


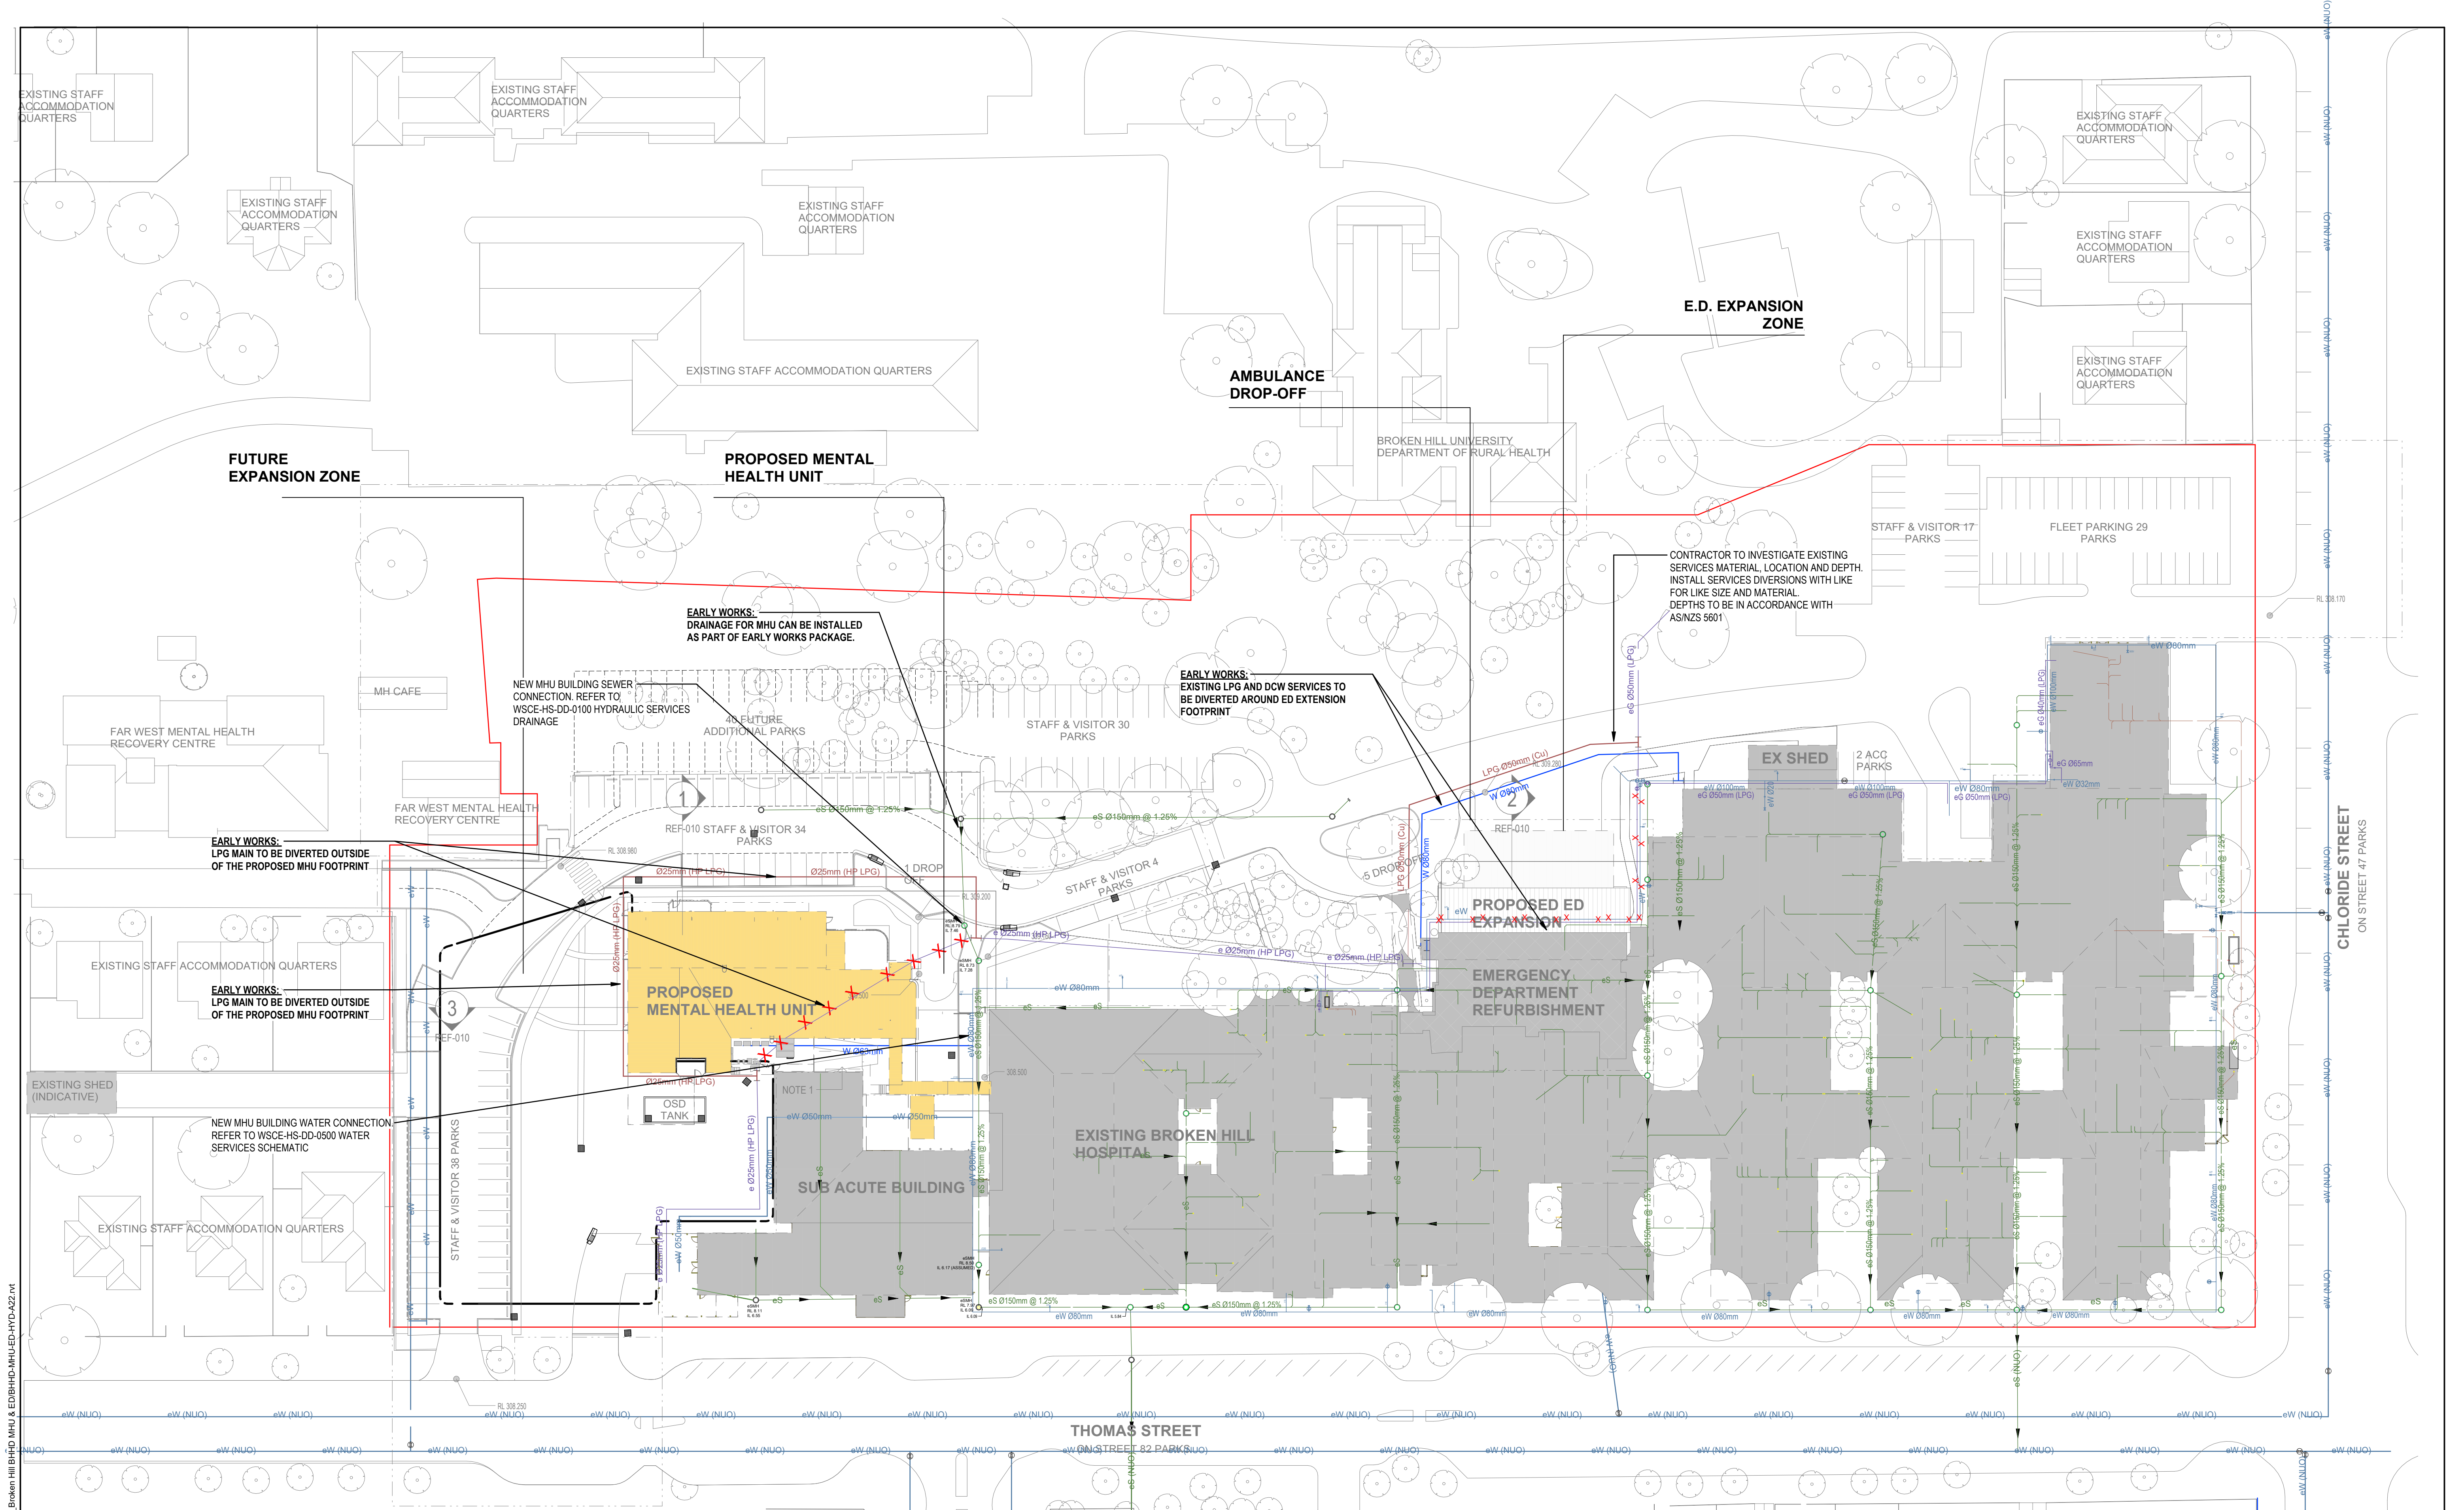

DO NOT SCALE FROM DRAWINGS. CHECK & VERIFY ALL DIMENSIONS & LEVELS BEFORE COMMENCEMENT OF ANY WORK.

THIS DRAWING IS REQUIRED TO BE PRINTED IN COLOUR. FAILURE TO DO SO MAY RESULT IN LOSS OF INFORMATION.

THIS DRAWING IS NOT TO BE COPIED IN PART OR WHOLE WITHOUT WRITTEN PERMISSION FROM WARREN SMITH CONSULTING ENGINEERS.

NORTH POINT

NOTES

REV	DESCRIPTION	DATE
01	SCHEMATIC DESIGN	04/05/2023
02	DESIGN DEVELOPMENT	25/08/2023

PROJECT

BROKEN HILL HOSPITAL REDEVELOPMENT

176 Thomas St
Broken Hill NSW 2880

CLIENT

Health Infrastructure

WARREN SMITH CONSULTING ENGINEERS
SINCE 1981.

NSW
20/66 Goulburn St,
Sydney 2000 NSW Australia
PH +61 (2) 9299 1312
wsp@warrensmith.com.au
www.warrensmith.com.au
ACN 002 197 088 ABN 36 300 430 126

VIC
Suite 7 03, 365 Little Collins St
Melbourne 3000 VIC Australia
PH +61 (3) 8648 9942
wsp@warrensmith.com.au
www.warrensmith.com.au
ACN 002 197 088 ABN 36 300 430 126

LEGEND

- Hydraulic
- Fire
- Civil
- Utilities Infrastructure

TITLE

HYDRAULIC SERVICES SITE PLAN

SCALE	DRAWN	DESIGNED	CHECKED	APPROVED
1:500	RB	LB		

DATE	DRAWING No.	REV
25/08/2023	WSCE-HS-DD-0001	02

JOB No. 7763000