


DO NOT SCALE FROM DRAWINGS. CHECK & VERIFY ALL DIMENSIONS & LEVELS BEFORE COMMENCEMENT OF ANY WORK.

THIS DRAWING IS REQUIRED TO BE PRINTED IN COLOUR. FAILURE TO DO SO MAY RESULT IN LOSS OF INFORMATION.

THIS DRAWING IS NOT TO BE COPIED IN PART OR WHOLE WITHOUT WRITTEN PERMISSION FROM WARREN SMITH CONSULTING ENGINEERS.

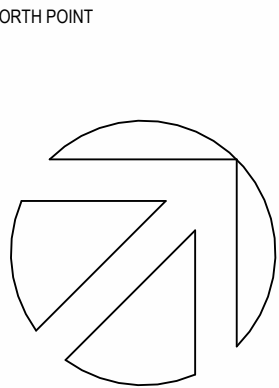

NOTES


10 20 30 40 50 60 70 80 90 100 110 120 130 140 150 SHEET SIZE: A0

REV	SCHEMATIC DESIGN	DESCRIPTION	DATE	PROJECT
1			03/07/2024	WORLD CLASS END OF LIFE PROGRAM HAWKESBURY RD, WESTMEAD, NSW, 2145



LEVEL 5 PLAN - DRAINAGE SERVICES					
SCALE	1:100	DRAWN	SZ	DESIGNED	VG
DATE	03/07/2024	CHECKED	TW	APPROVED	DP
JOB NO.	8120000	DRAWING NO.	WSCE-HY-DD-0200	REV	1




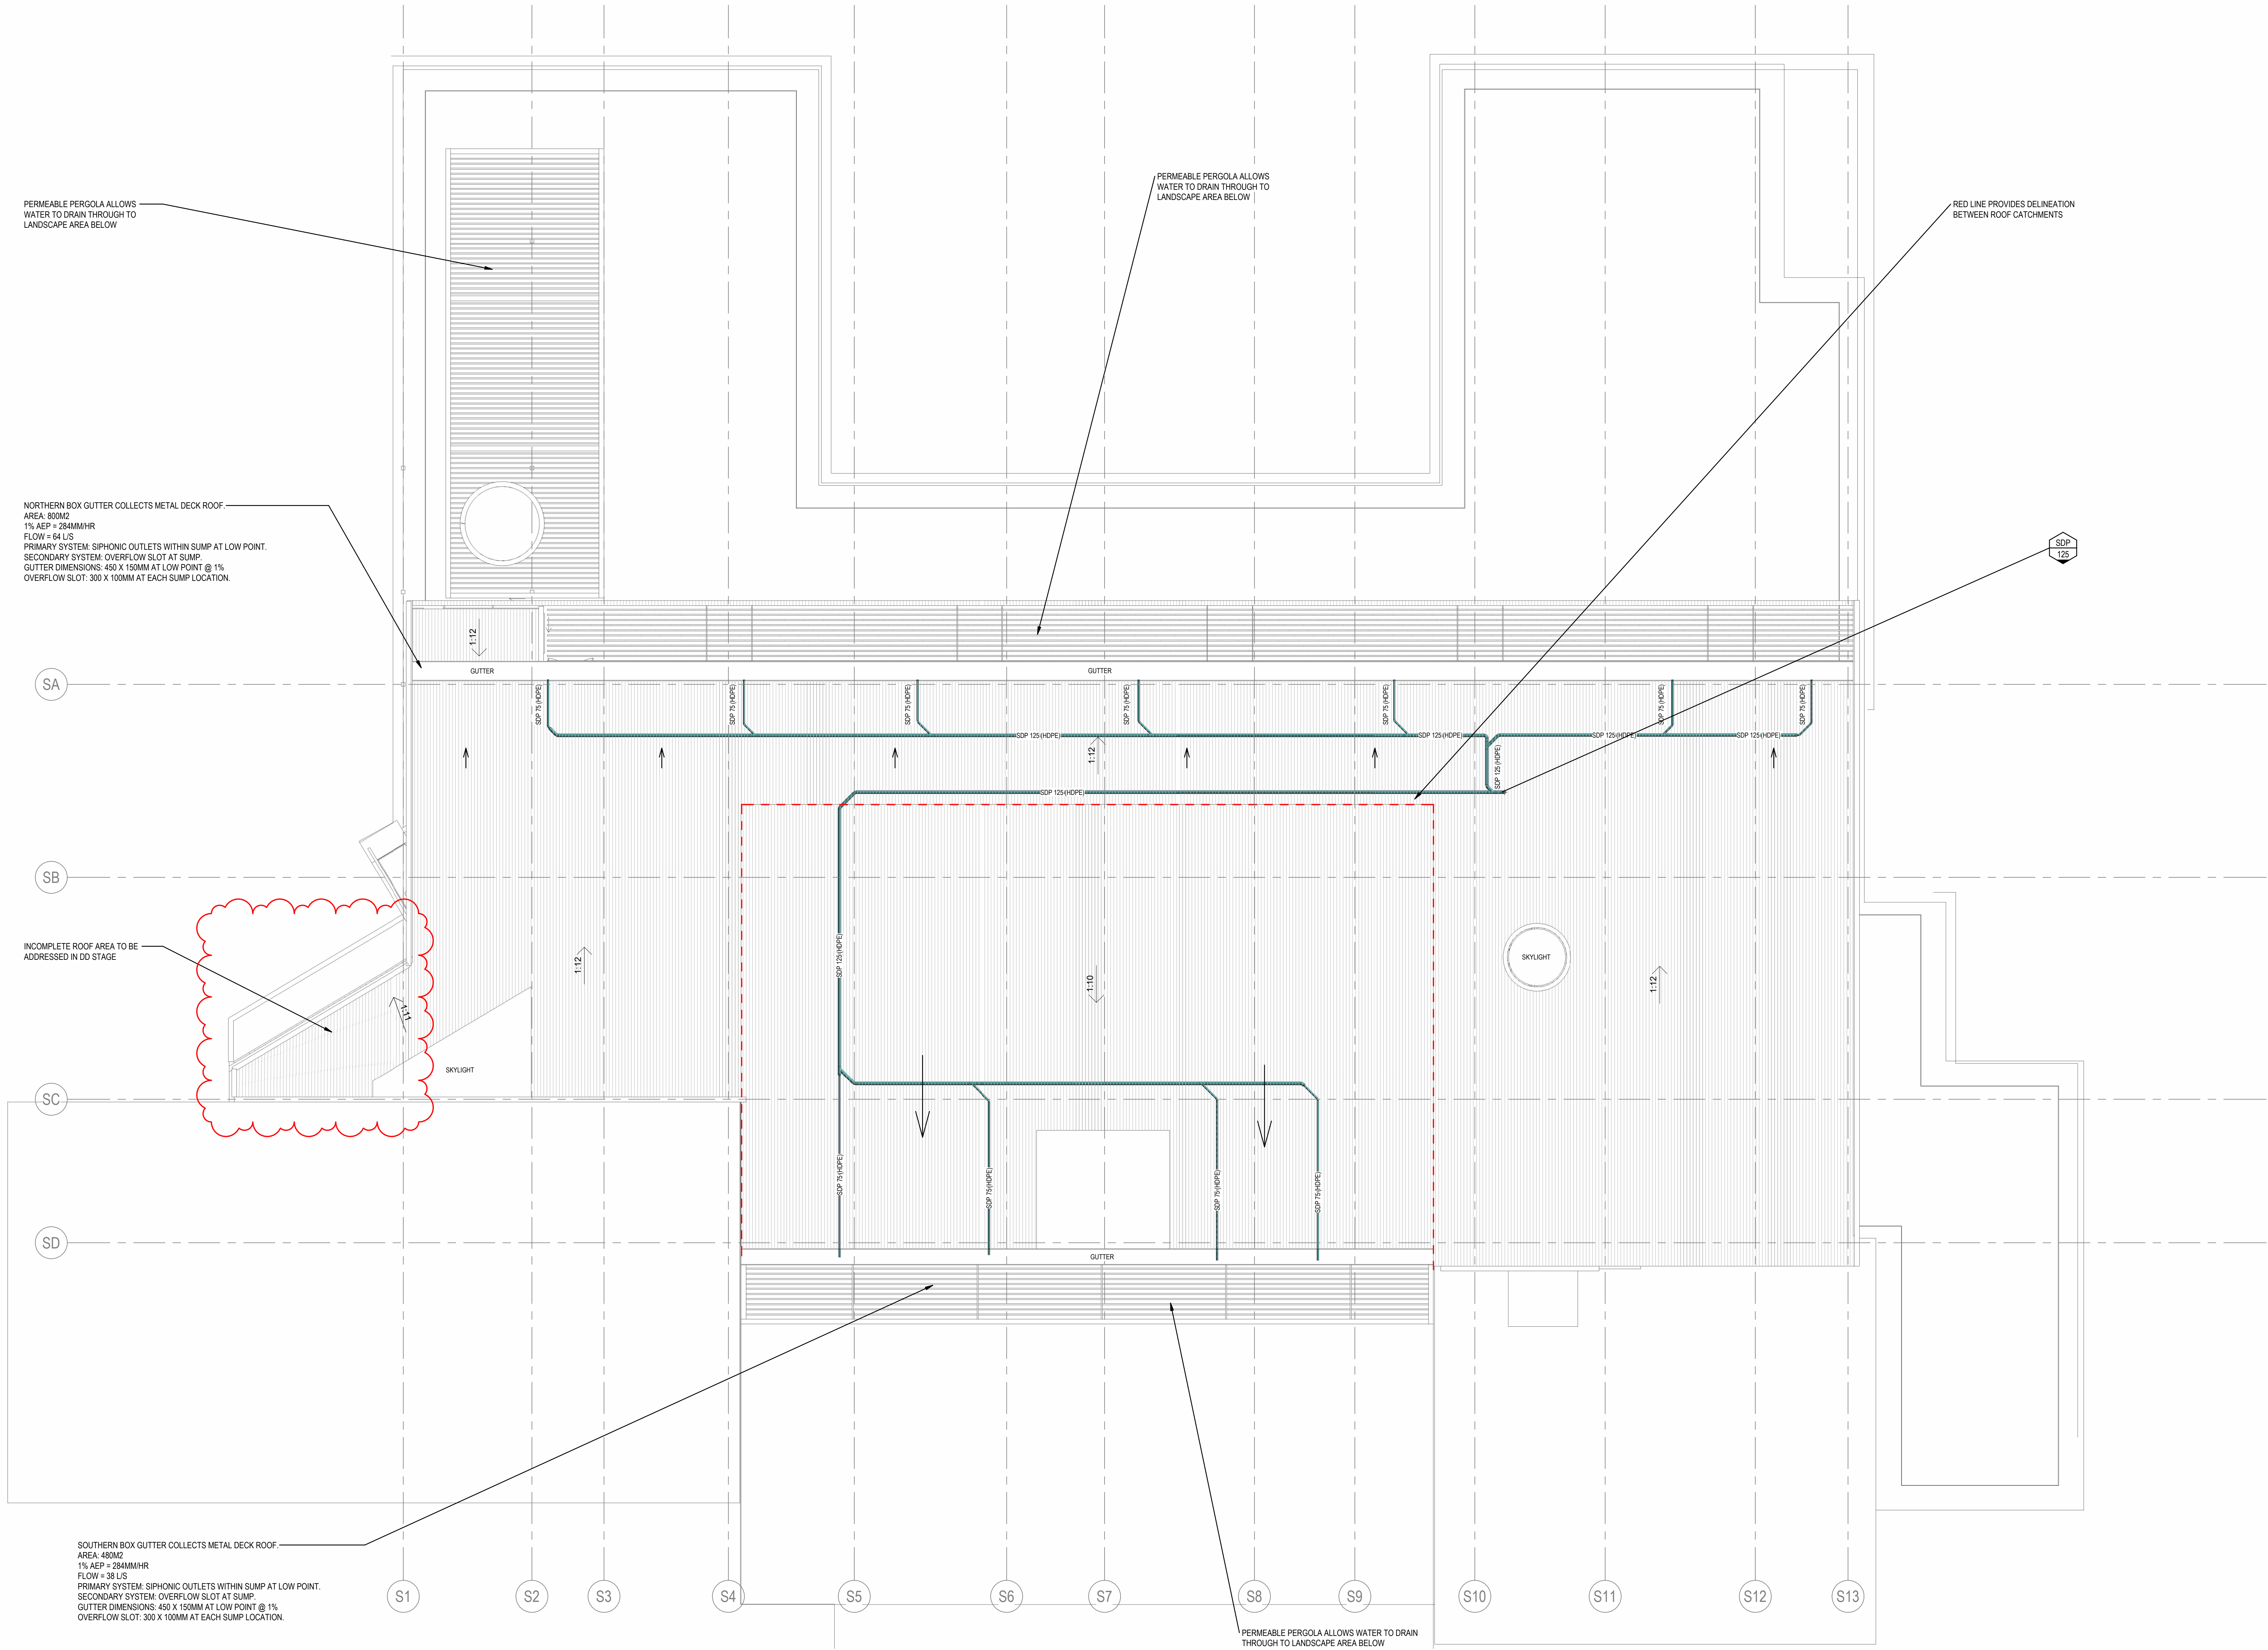

DO NOT SCALE FROM DRAWINGS. CHECK & VERIFY ALL DIMENSIONS & LEVELS BEFORE COMMENCEMENT OF ANY WORK.

THIS DRAWING IS REQUIRED TO BE PRINTED IN COLOUR. FAILURE TO DO SO MAY RESULT IN LOSS OF INFORMATION.

THIS DRAWING IS NOT TO BE COPIED IN PART OR WHOLE WITHOUT WRITTEN PERMISSION FROM WARREN SMITH CONSULTING ENGINEERS.

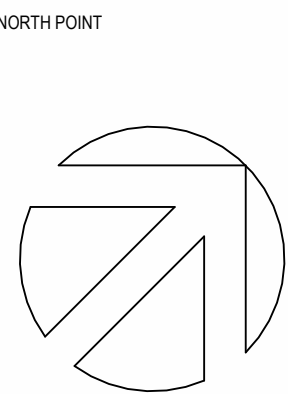

NOTES

NORTHERN BOX GUTTER COLLECTS METAL DECK ROOF.  
AREA: 800M2  
1% ACP = 28MM/MH  
FLOW = 64 L/S  
PRIMARY SYSTEM: SIPHONIC OUTLETS WITHIN SUMP AT LOW POINT.  
SECONDARY SYSTEM: OVERFLOW SLOT AT SUMP.  
GUTTER DIMENSIONS: 450 X 150MM AT LOW POINT @ 1%  
OVERFLOW SLOT: 300 X 100MM AT EACH SUMP LOCATION.

SOUTHERN BOX GUTTER COLLECTS METAL DECK ROOF.  
AREA: 480M2  
1% ACP = 26MM/MH  
FLOW = 38 L/S  
PRIMARY SYSTEM: SIPHONIC OUTLETS WITHIN SUMP AT LOW POINT.  
SECONDARY SYSTEM: OVERFLOW SLOT AT SUMP.  
GUTTER DIMENSIONS: 450 X 150MM AT LOW POINT @ 1%  
OVERFLOW SLOT: 300 X 100MM AT EACH SUMP LOCATION.

REV

SCHEMATIC DESIGN

DESCRIPTION

DATE

03/07/2024

PROJECT

WORLD CLASS END OF LIFE PROGRAM  
HAWKESBURY RD, WESTMEAD, NSW, 2145


CLIENT



ARCHITECT



WSCE Pty Ltd  
ACN 648 656 141  
ABN 78 648 656 141  
info@wsce.com.au  
www.wsce.com.au

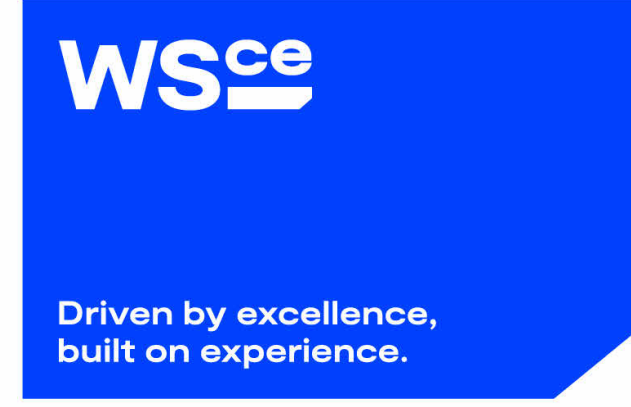


TITLE  
ROOF PLAN - DRAINAGE SERVICES


SCALE 1:100	DRAWN SZ	DESIGNED VG	CHECKED TW	APPROVED DP
DATE 03/07/2024	DRAWING NO. 8120000	JOB NO. WSCE-HY-DD-0201		REV 1

SHEET SIZE  
A0




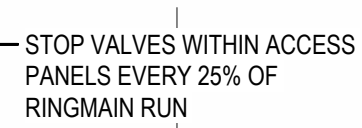



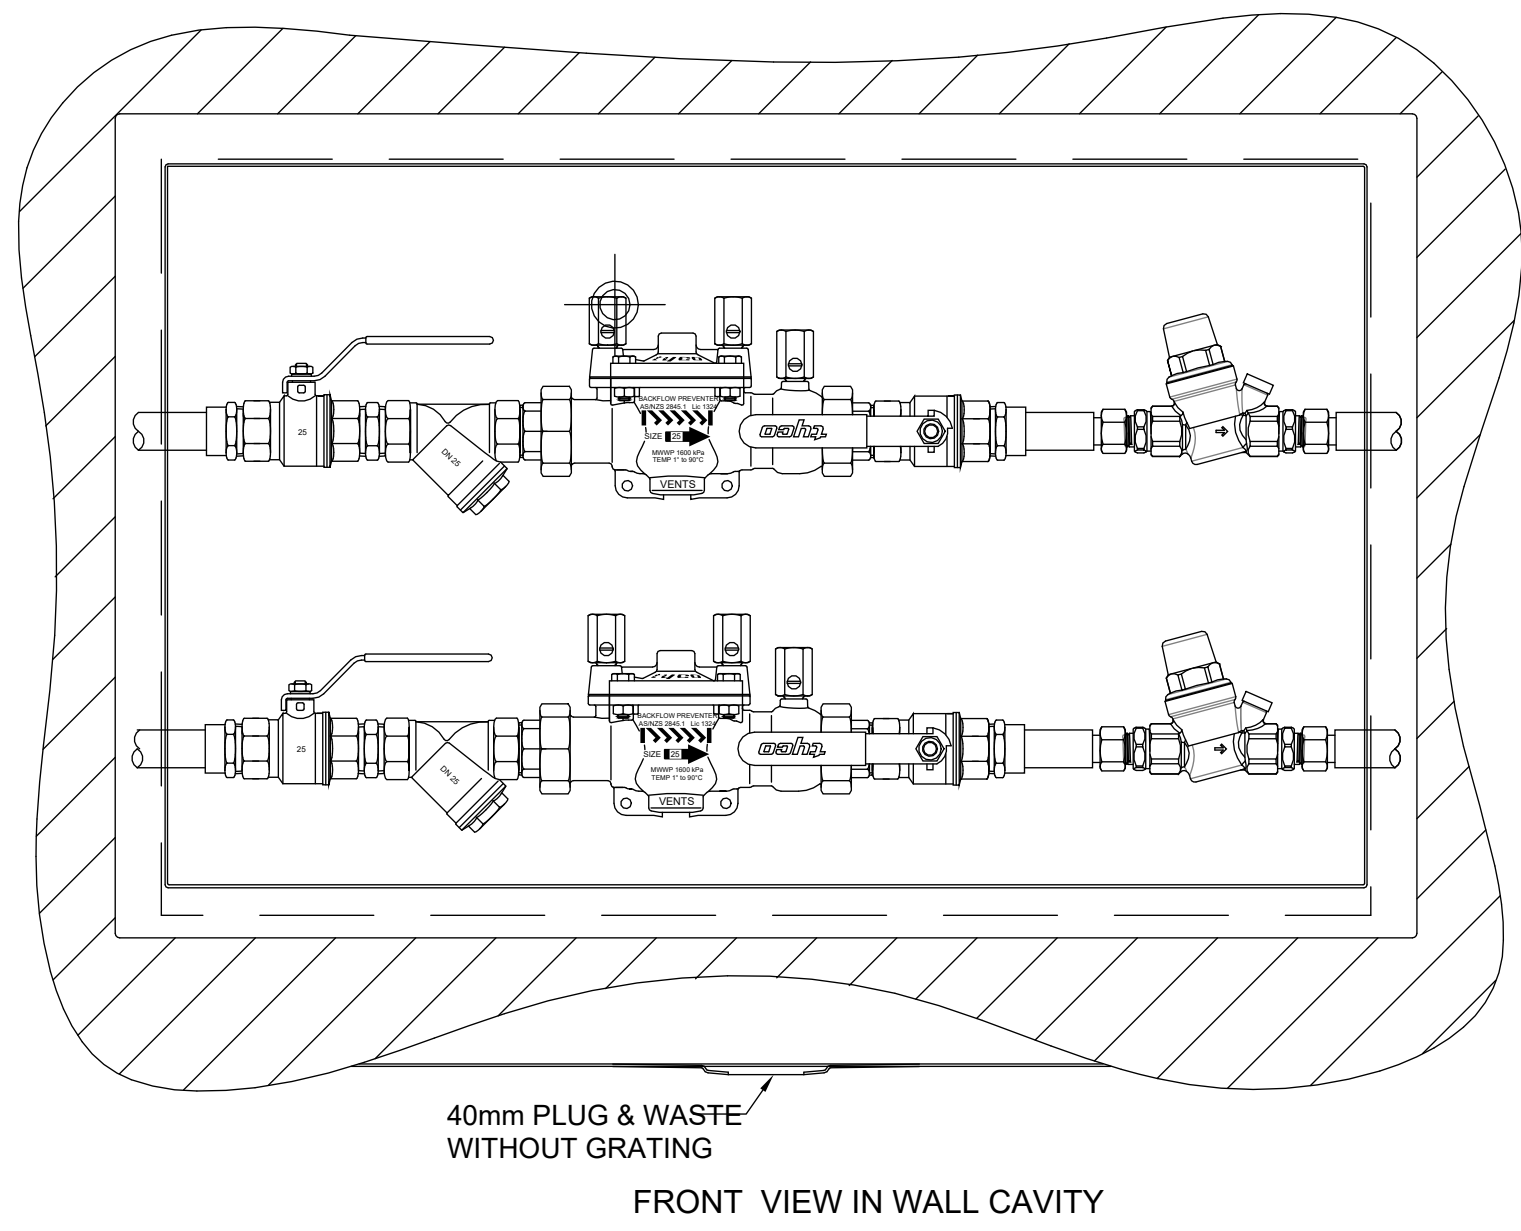

1 RPZD DETAIL  
1:5

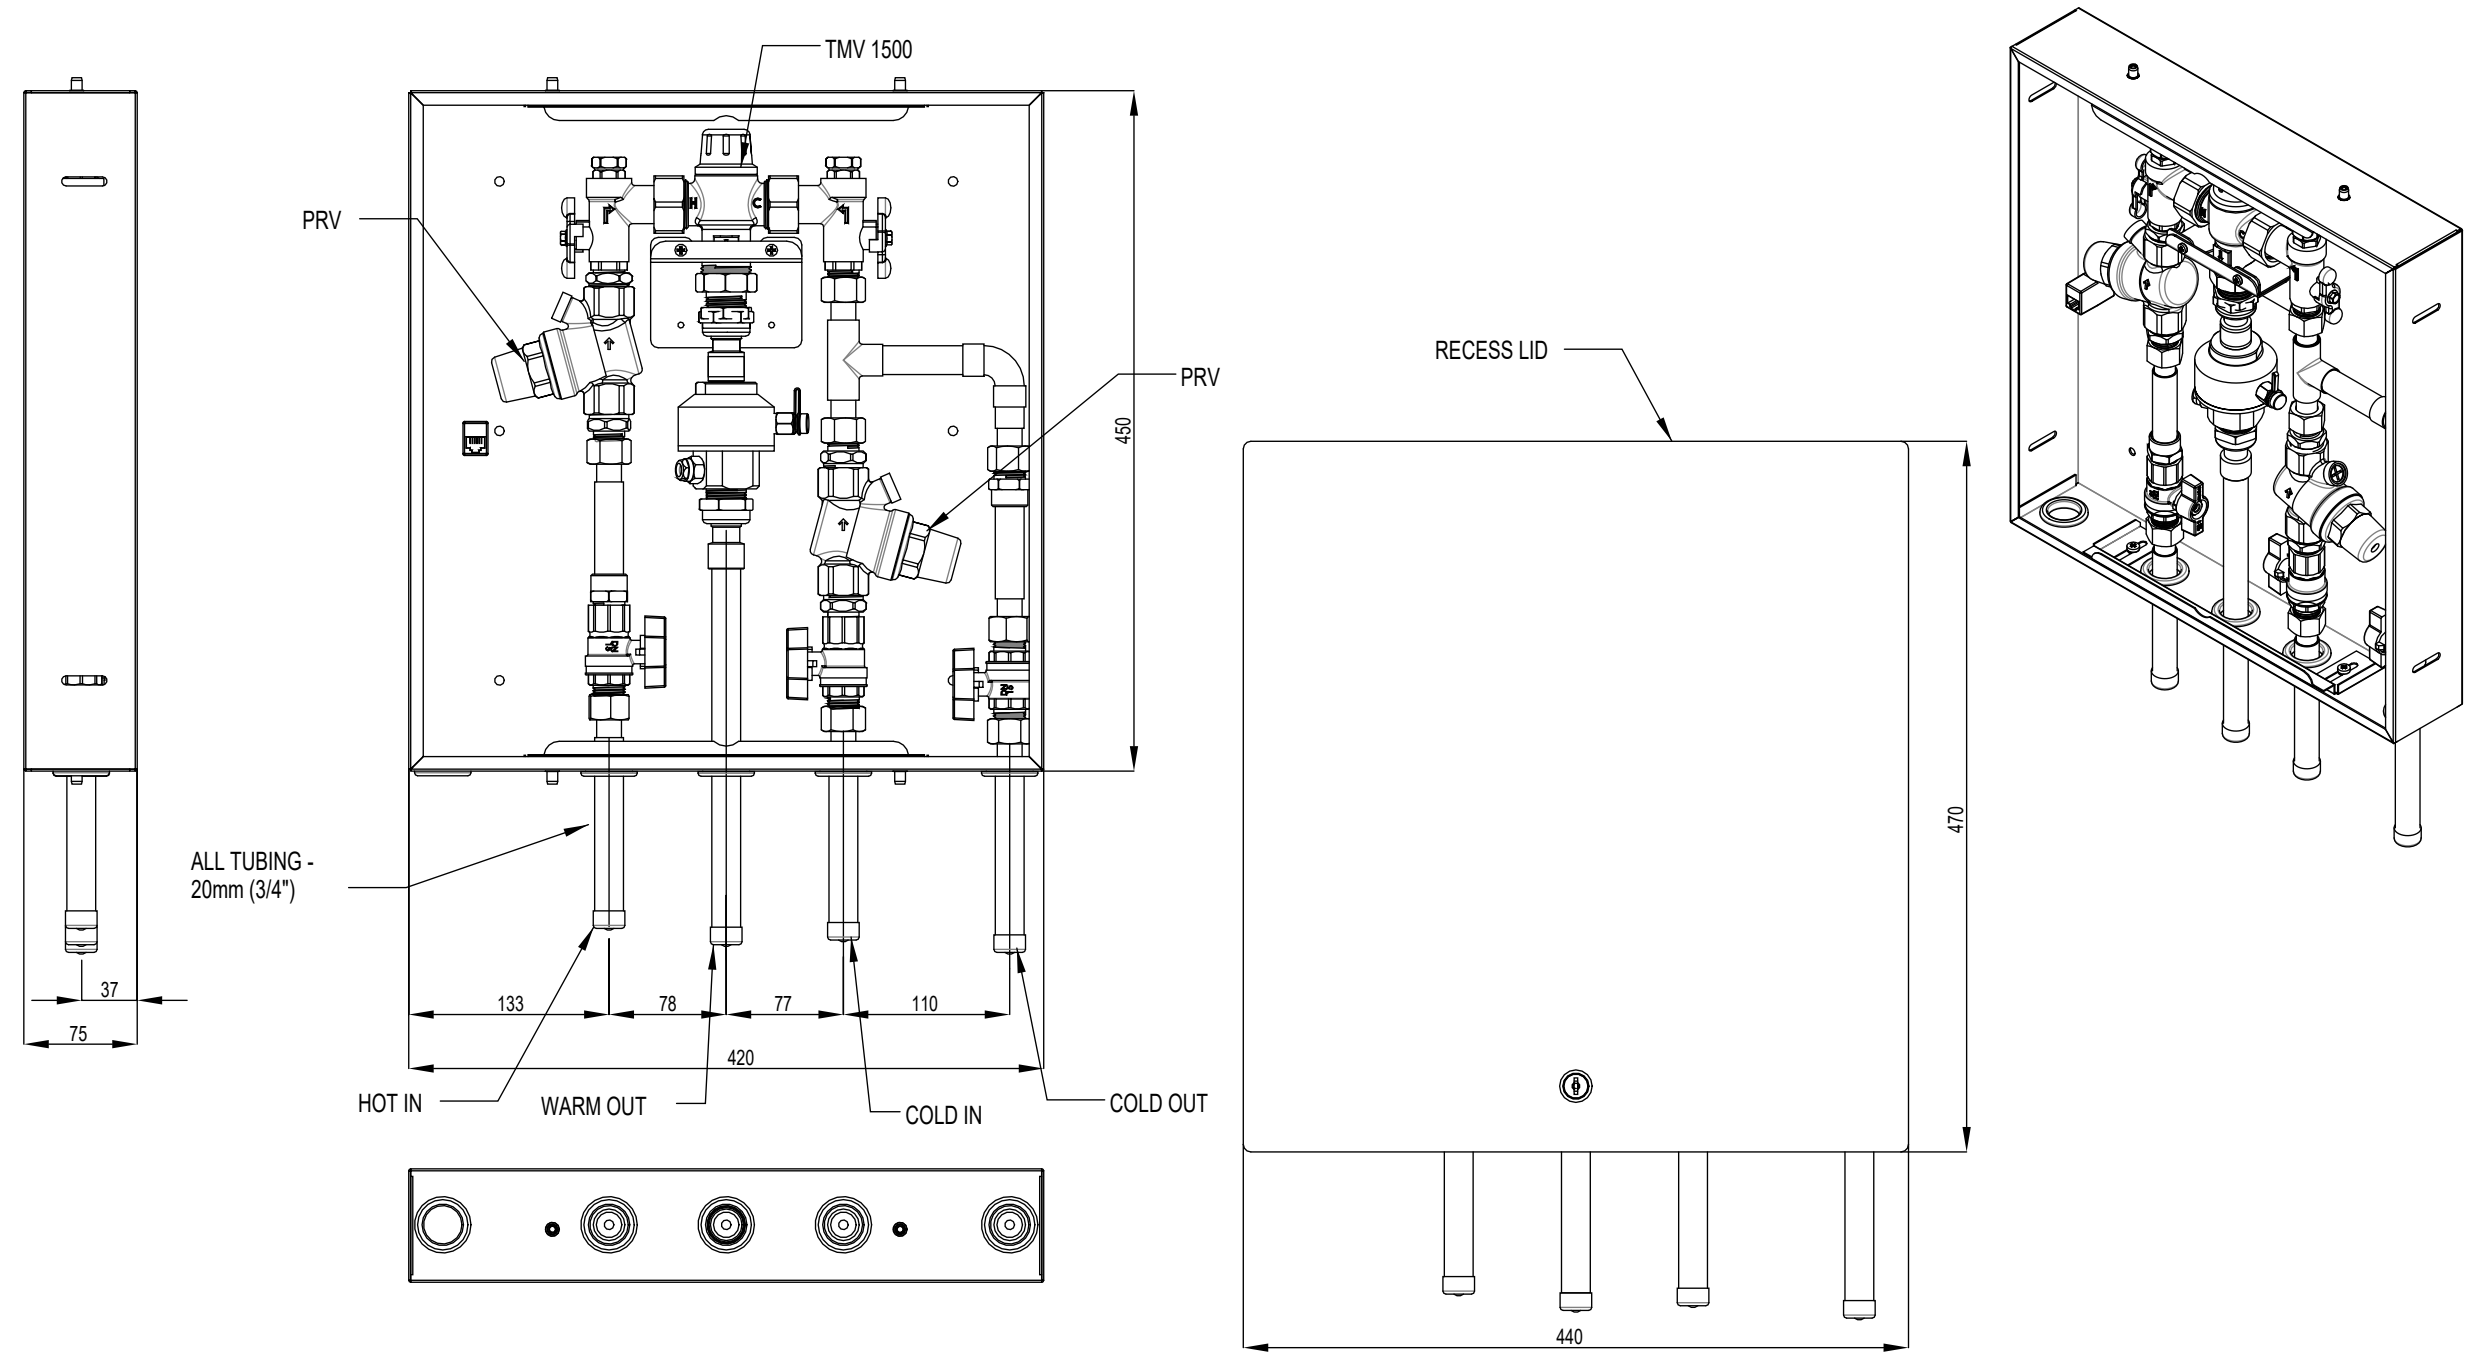


2 TMV DETAIL  
1:5

DO NOT SCALE FROM DRAWINGS.  
CHECK & VERIFY ALL  
DIMENSIONS & LEVELS BEFORE  
COMMENCEMENT OF ANY WORK.

THIS DRAWING IS REQUIRED TO  
BE PRINTED IN COLOUR. FAILURE  
TO DO SO MAY RESULT IN LOSS  
OF INFORMATION.

THIS DRAWING IS NOT TO BE  
COPIED IN PART OR WHOLE  
WITHOUT WRITTEN PERMISSION  
FROM WARREN SMITH  
CONSULTING ENGINEERS.

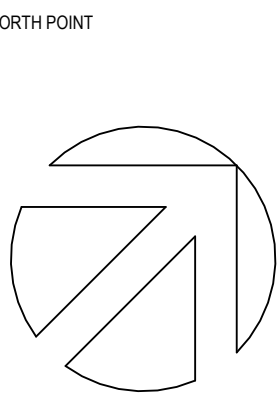

NOTES

SHEET SIZE: A0

REV	DESCRIPTION	DATE	PROJECT
1	SCHEMATIC DESIGN	03/07/2024	WORLD CLASS END OF LIFE PROGRAM HAWKESBURY RD, WESTMEAD, NSW, 2145



TITLE					
DETAIL SHEET					
SCALE	DRAWN	DESIGNED	CHECKED	APPROVED	
1:5	SZ	VG	TW	DP	
DATE	DRAWING NO.		REV		
03/07/2024	WSCE-HY-DD-0400		1		