
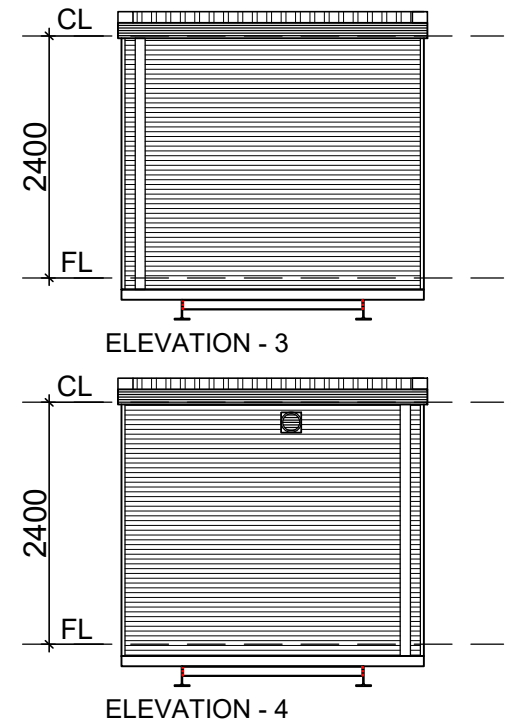
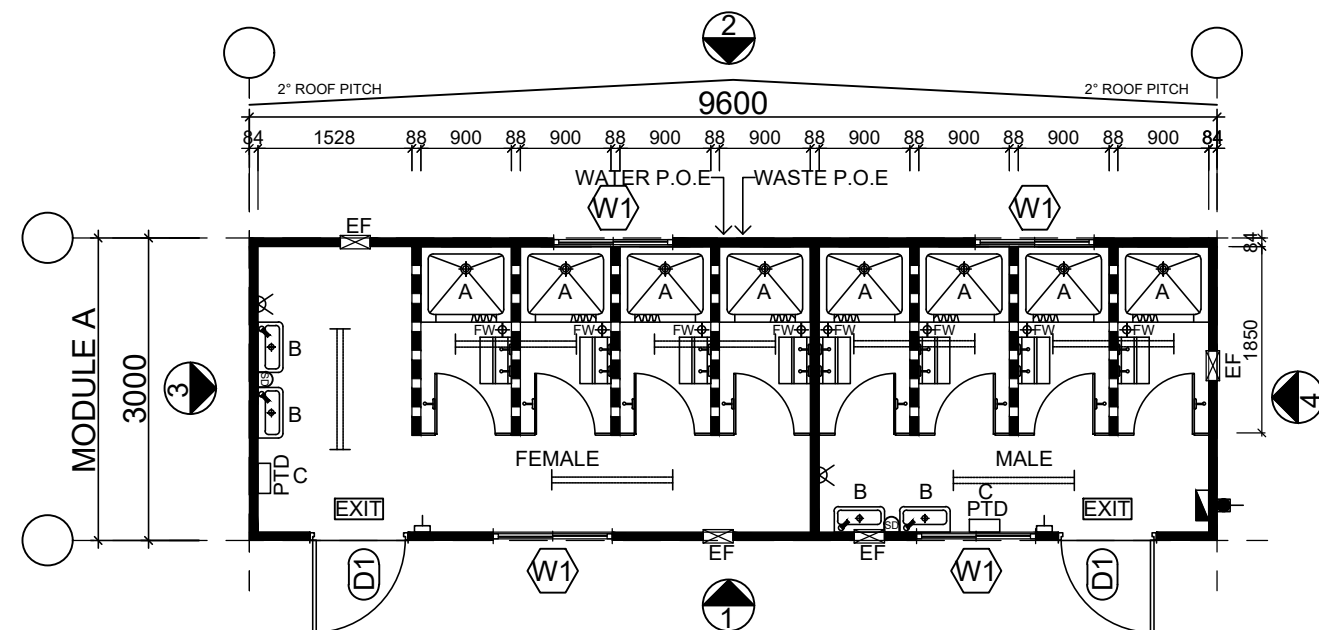


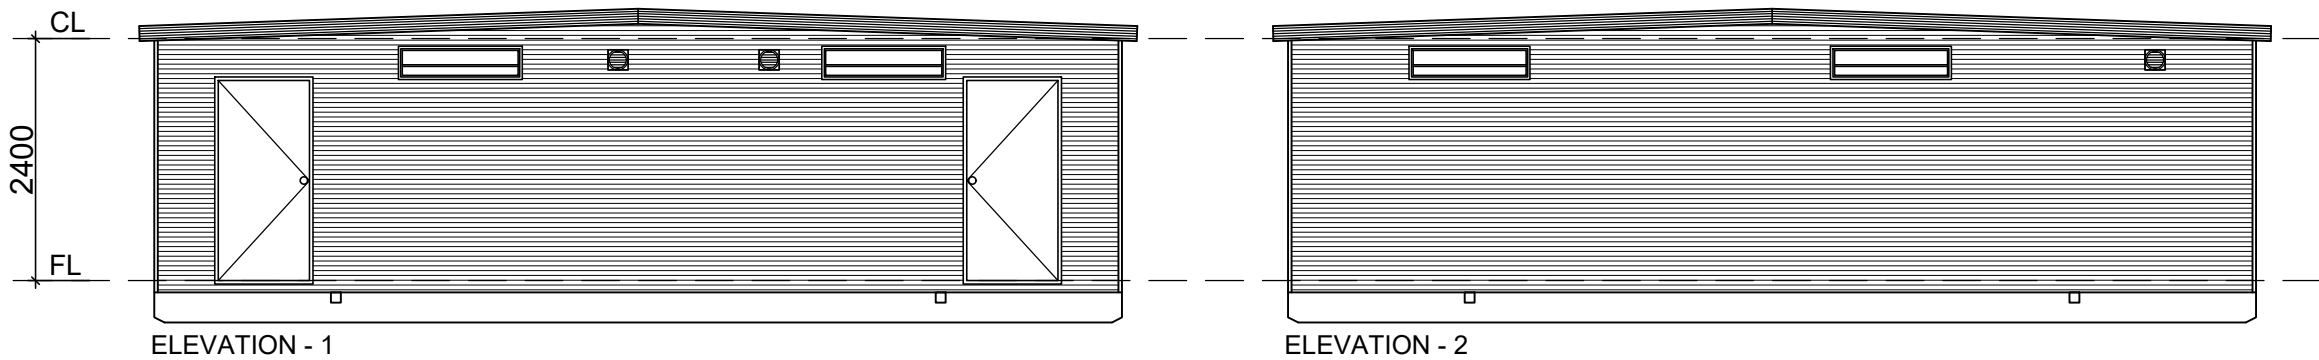

DOOR & WINDOW SCHEDULE		
ITEM	DESCRIPTION	QTY
D1	920 x 2040mm COLORBOND EXT. DOOR - (PAPERBARK)	2
W1	280 x 1190mm HALF VENTED WINDOW - (PAPERBARK)	4

ELECTRICAL LEGEND			
ITEM	DESCRIPTION	HEIGHT	QTY
	ELECTRICAL DISTRIBUTION BOARD	1800AFL	1
	POINT OF ENTRY	2200AFL	1
	1200mm LED FLURO LIGHT	C/MNTD	7
	LIGHT SWITCH	1300AFL	2
	DOUBLE GPO - 10 AMP	1475 AFL	2
	EMERGENCY LIGHT	C/MNTD	2
	EXHAUST FAN	W/MNTD	4

TOILET ITEM SCHEDULE		
ITEM	DESCRIPTION	QTY
A	900 x 760mm FIBREGLASS SHOWER CUBICLE	8
B	S/S MINI BASIN WITH PUSH BUTTON TAPS	4
C	PAPER TOWEL DISPENSER	2
SD	SOAP DISPENSER	2

NOTES:

PRELIMINARY ISSUE

Build 4 Me Pty Ltd Blue Sky Modular Buildings
174 Hartley Rd
Smeaton Grange NSW 2567
Phone: 0409 228 535 Email: ben@blueskymodular.com.au

PROJECT: LAKE COWAL		DATE: 22/03/2021		TITLE: 9.6 x 3m SHOWER BLOCK PLAN & ELEVATIONS		CLIENT APPROVAL	
DRAWN BY: TW		CHECKED BY: BS					
SCALE: 1:75		DRAWING NUMBER: -		BUILDING NUMBER: B01		SIGNATURE: _____	
QUOTATION NUMBER: -		REV: 2		SHEET A3		NAME: _____	
						DATE: _____	

2	REVISED PLAN LAYOUT & ELEVATIONS	TW	24.03.2021
1	PRELIMINARY ISSUE	TW	22.03.2021
ISSUE	AMENDMENT	BY	DATE

c:\users\tony\dropbox\bluesky teena drawings\drawings teena\68 - lake cowal\61 lake cowal - 9.6 x 3m shower block (2).dwg