
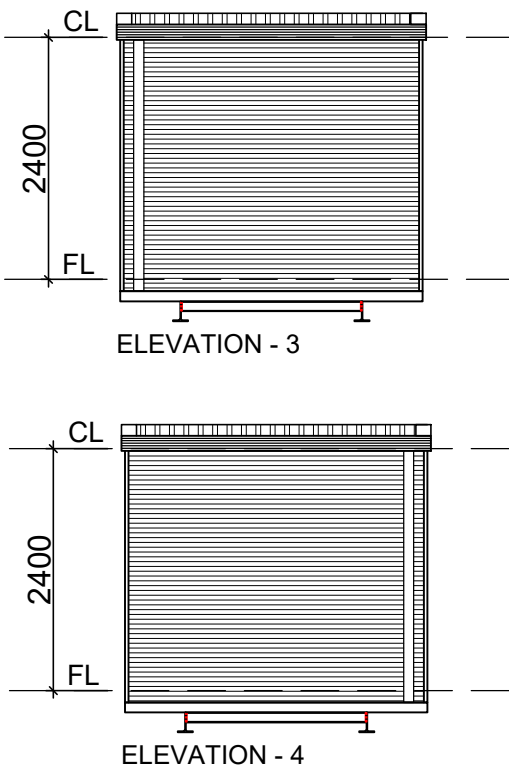
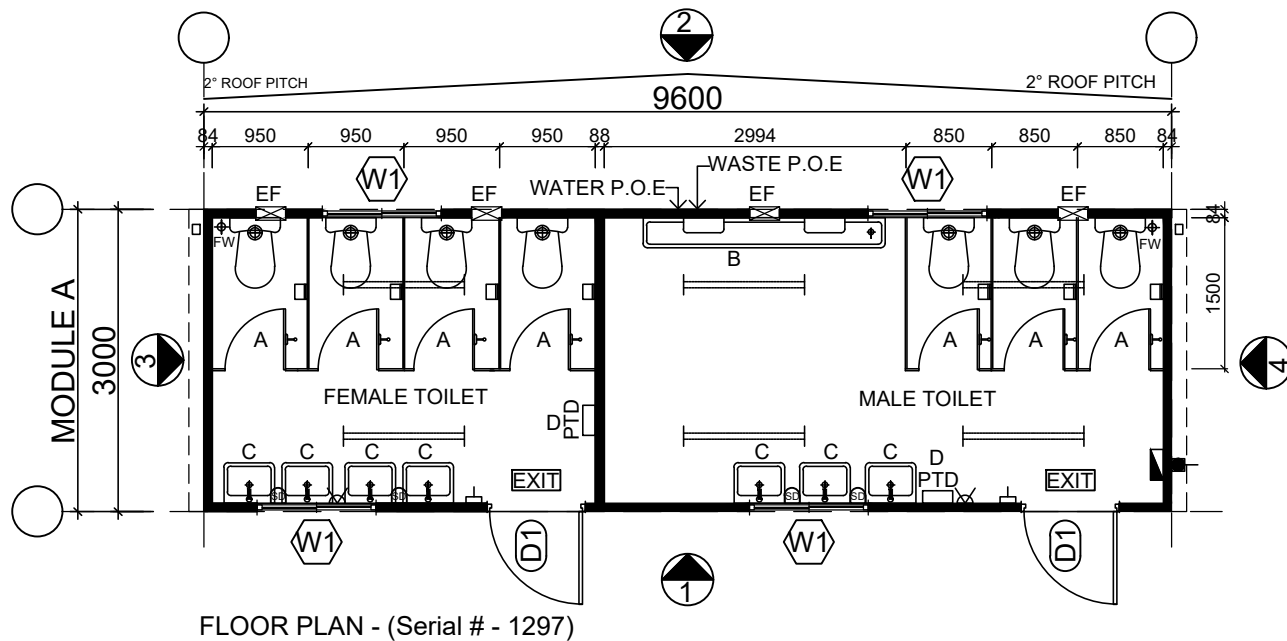


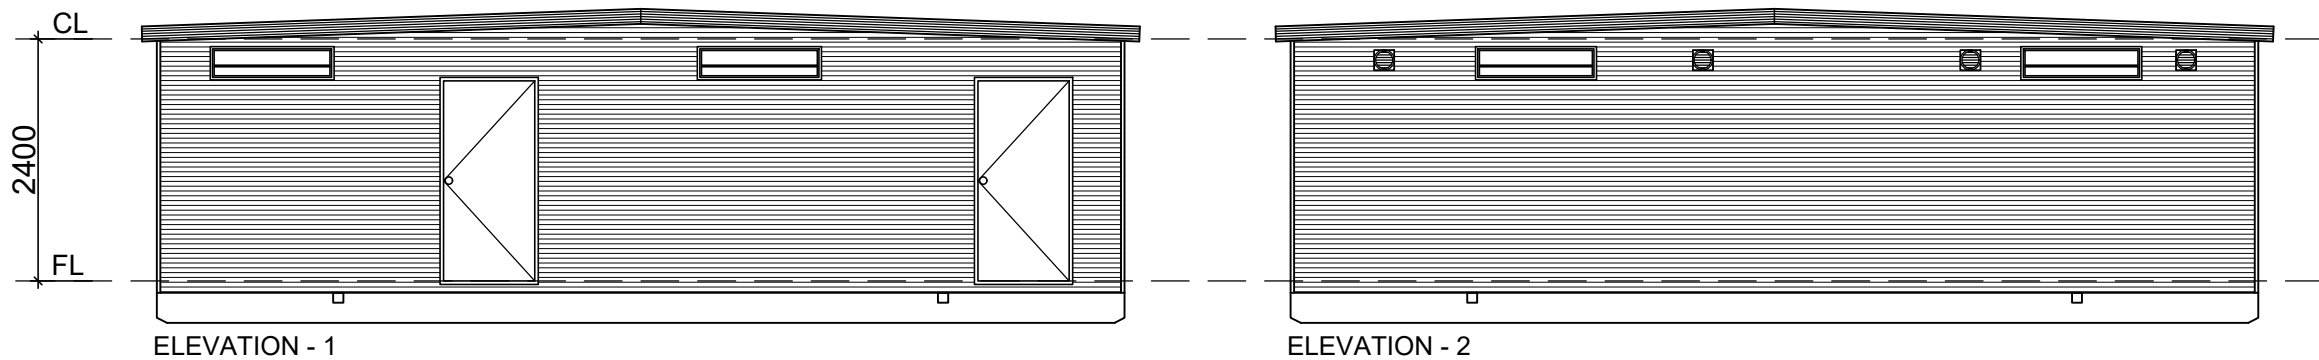

DOOR & WINDOW SCHEDULE		
ITEM	DESCRIPTION	QTY
D1	920 x 2040mm COLORBOND EXT. DOOR - (PAPERBARK)	2
W1	280 x 1190mm HALF VENTED WINDOW - (PAPERBARK)	4

ELECTRICAL LEGEND			
ITEM	DESCRIPTION	HEIGHT	QTY
	ELECTRICAL DISTRIBUTION BOARD	1800AFL	1
	POINT OF ENTRY	2200AFL	1
	1200mm LED FLURO LIGHT	C/MNTD	6
	LIGHT SWITCH	1300AFL	2
	DOUBLE GPO - 10 AMP	1475 AFL	2
	EMERGENCY LIGHT	C/MNTD	2
	EXHAUST FAN	W/MNTD	4

TOILET ITEM SCHEDULE		
ITEM	DESCRIPTION	QTY
A	DUAL FLUSH TOILET & MELAMINE TOILET CUBICLE	7
B	2400mm S/S WALL HUNG URINAL	1
C	S/S BASIN WITH PUSH BUTTON TAPS	7
D	PAPER TOWEL DISPENSER	2
SD	SOAP DISPENSER	4

NOTES:

PRELIMINARY ISSUE



Build 4 Me Pty Ltd Blue Sky Modular Buildings
174 Hartley Rd
Smeaton Grange NSW 2567
Phone: 0409 228 535 Email: ben@blueskymodular.com.au

PROJECT:

LAKE COWAL

© COPYRIGHT.
This drawing remains the property of Build 4 Me Pty Ltd T/A BlueSky Modular Buildings.
It may NOT be reproduced or copied whole or in part without written authority.

DATE:
22/03/2021

DRAWN BY:
TW

CHECKED BY:
BS

SCALE: 1:75

TITLE:
9.6 x 3m M/F TOILET BLOCK
PLAN & ELEVATIONS

DRAWING NUMBER:
-

QUOTATION NUMBER: -

BUILDING NUMBER:
B02

REV: 1

SHEET A3

CLIENT APPROVAL

SIGNATURE:

NAME:

DATE:

1	PRELIMINARY ISSUE	TW	22.03.2021
ISSUE	AMENDMENT	BY	DATE