




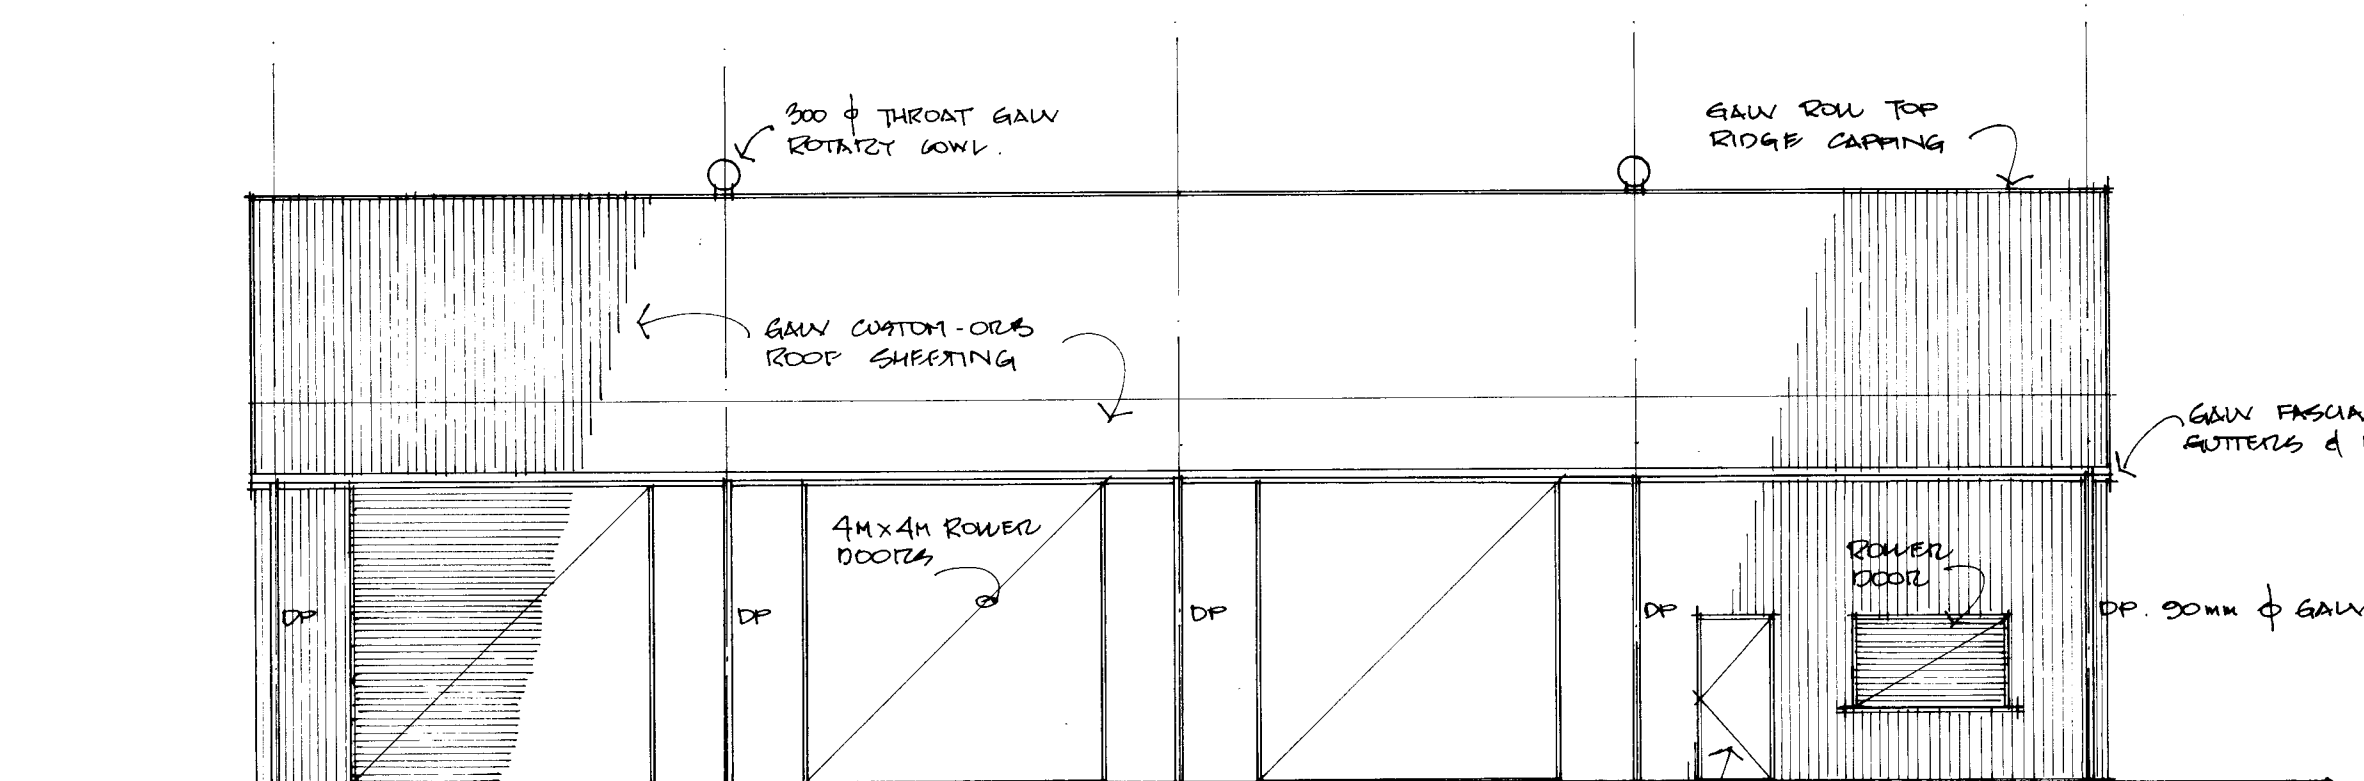


NORTH ELEVATION

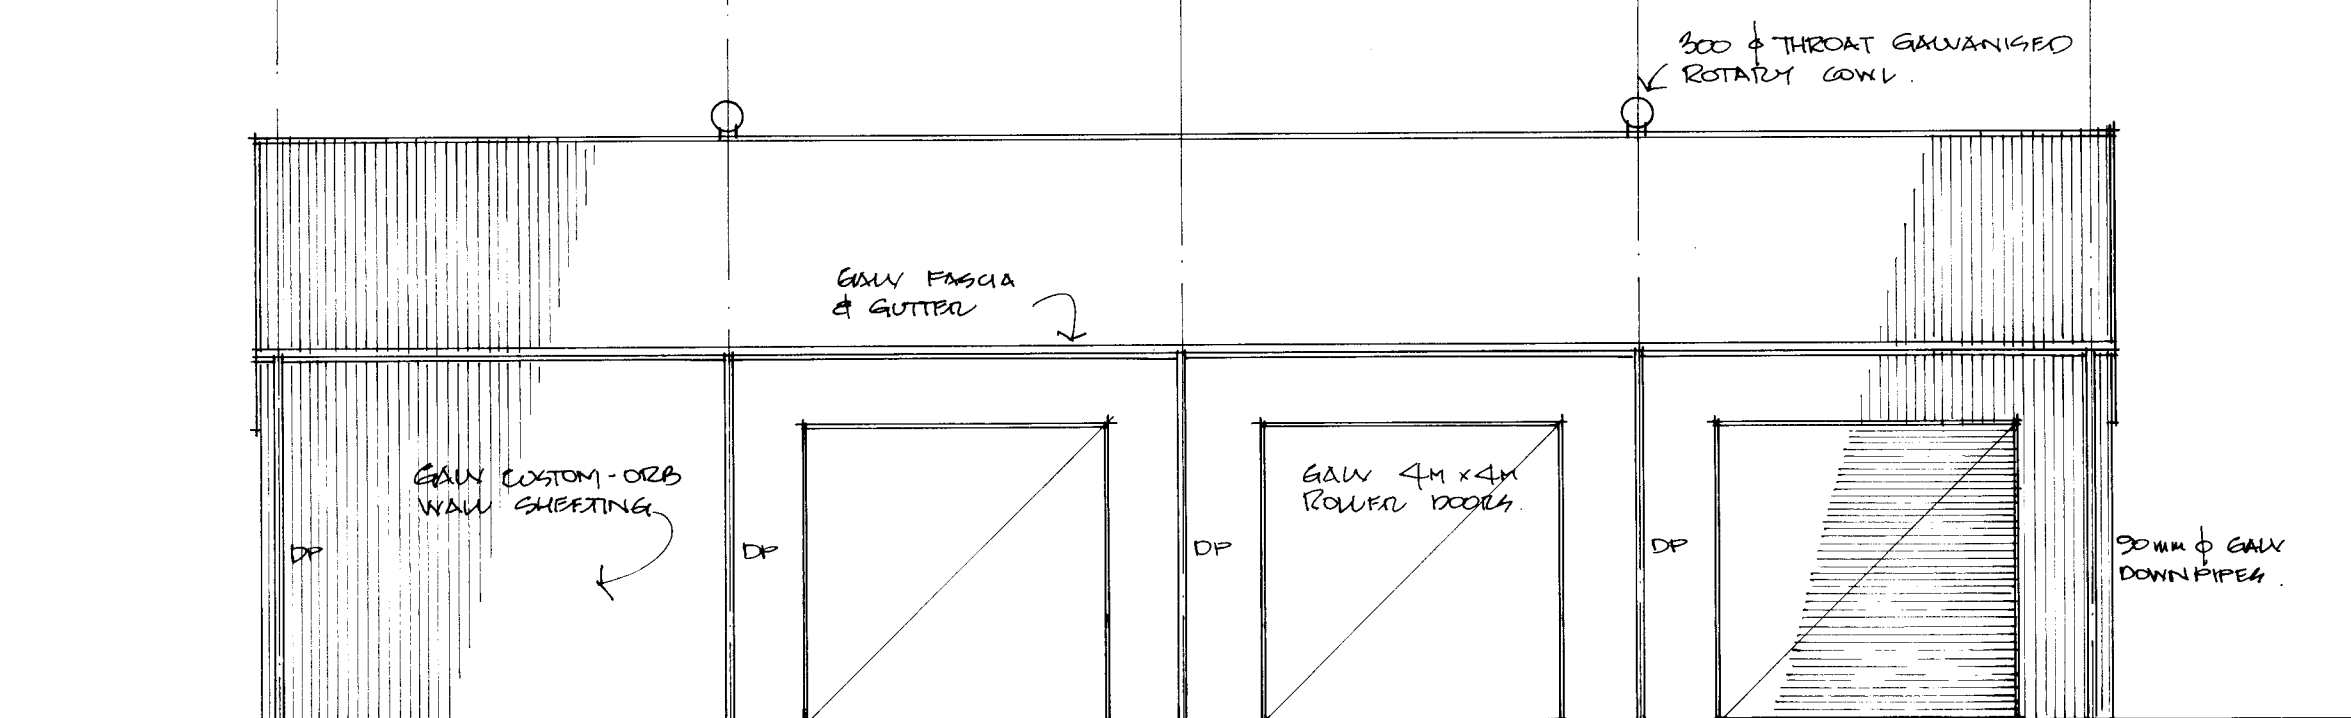


SOUTH ELEVATION

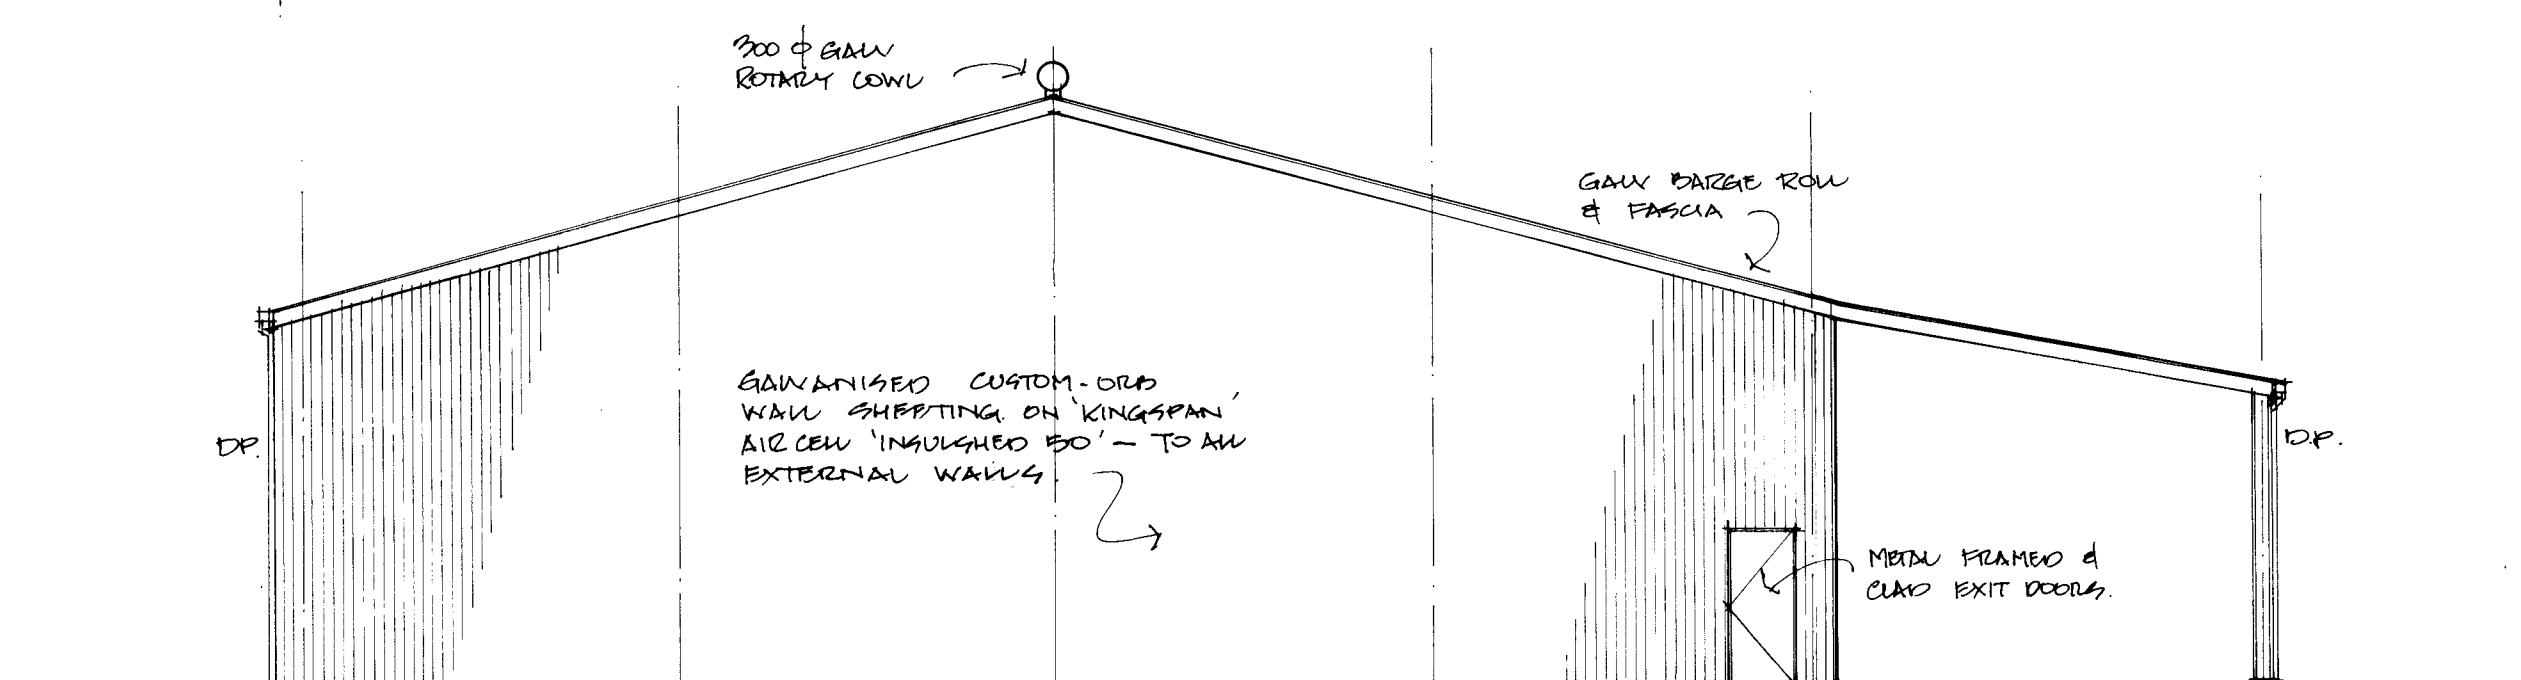


EAST ELEVATION - WEST ELEVATION MIRROR REVERSE.

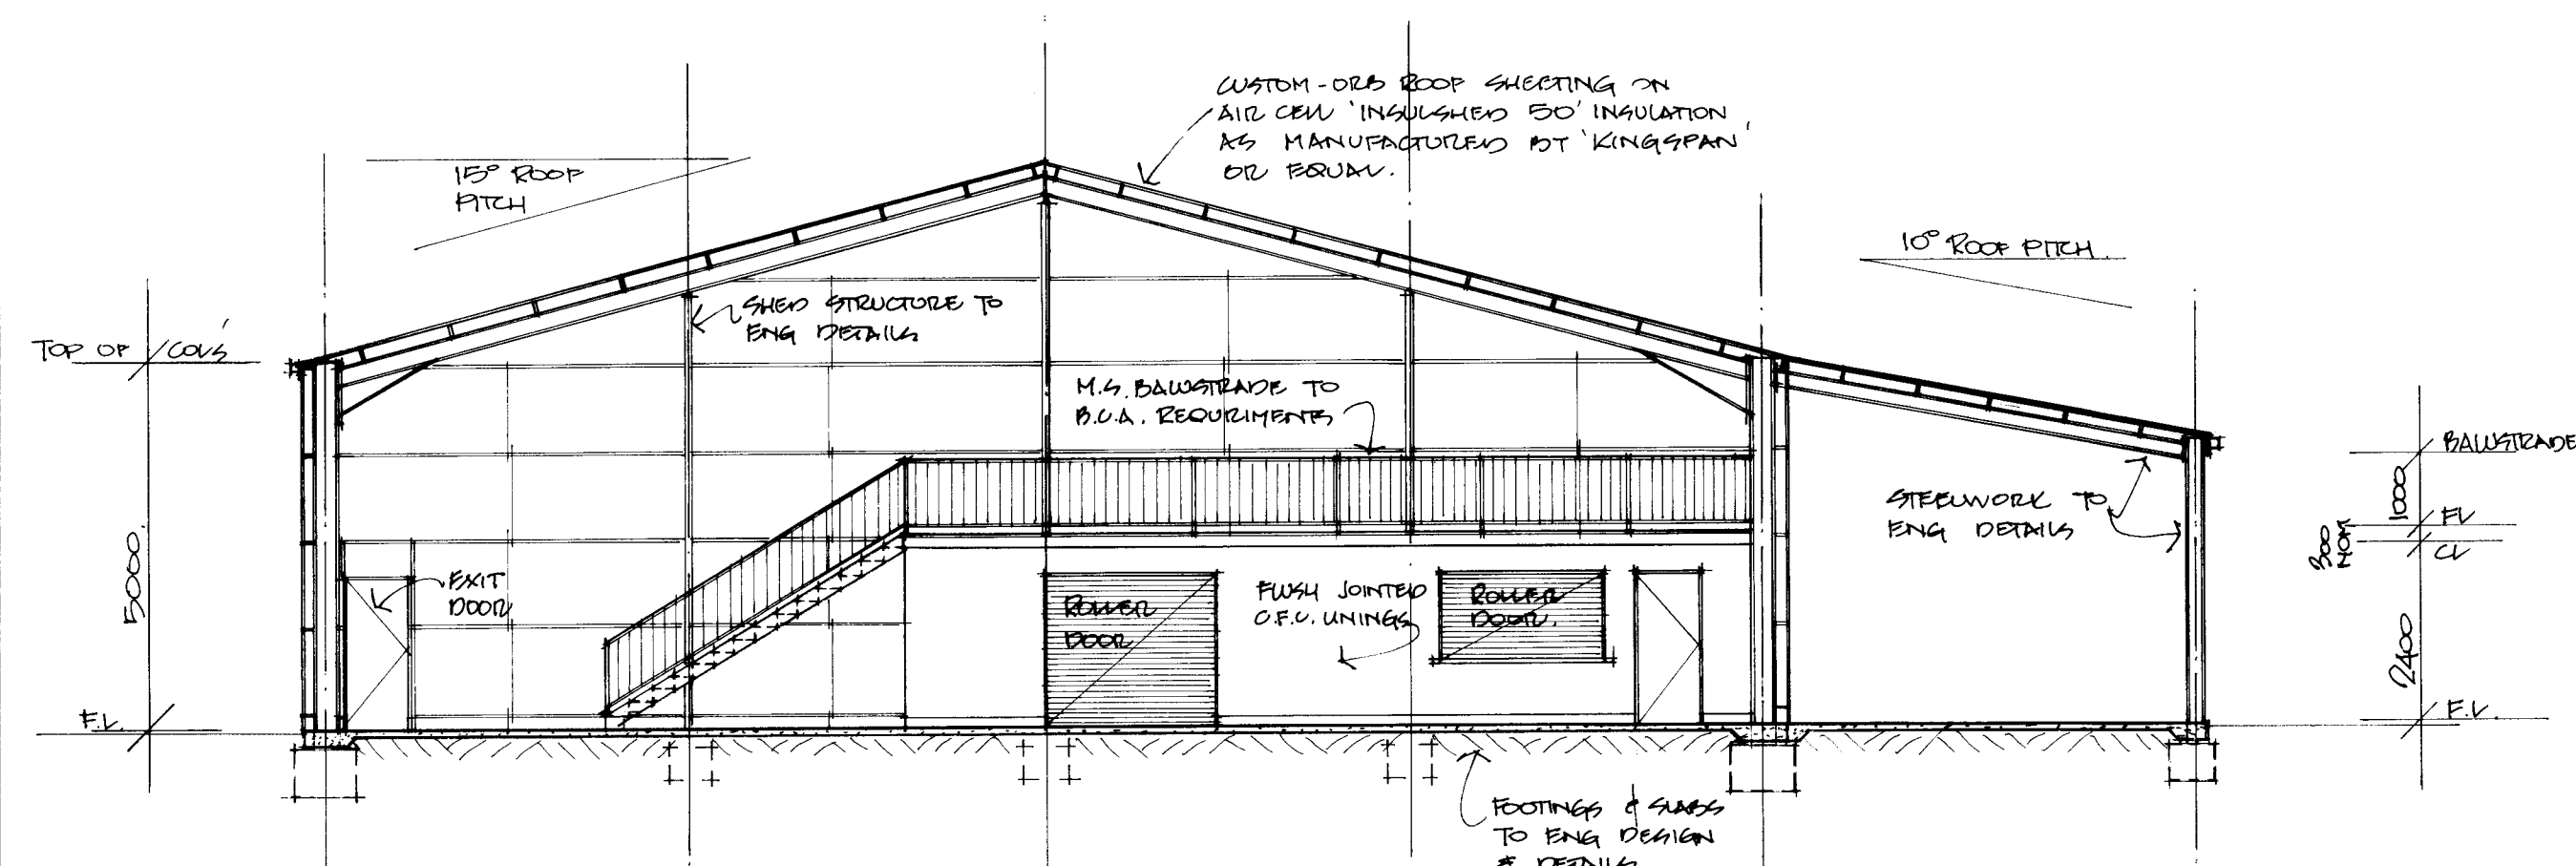

SECTION A - A.

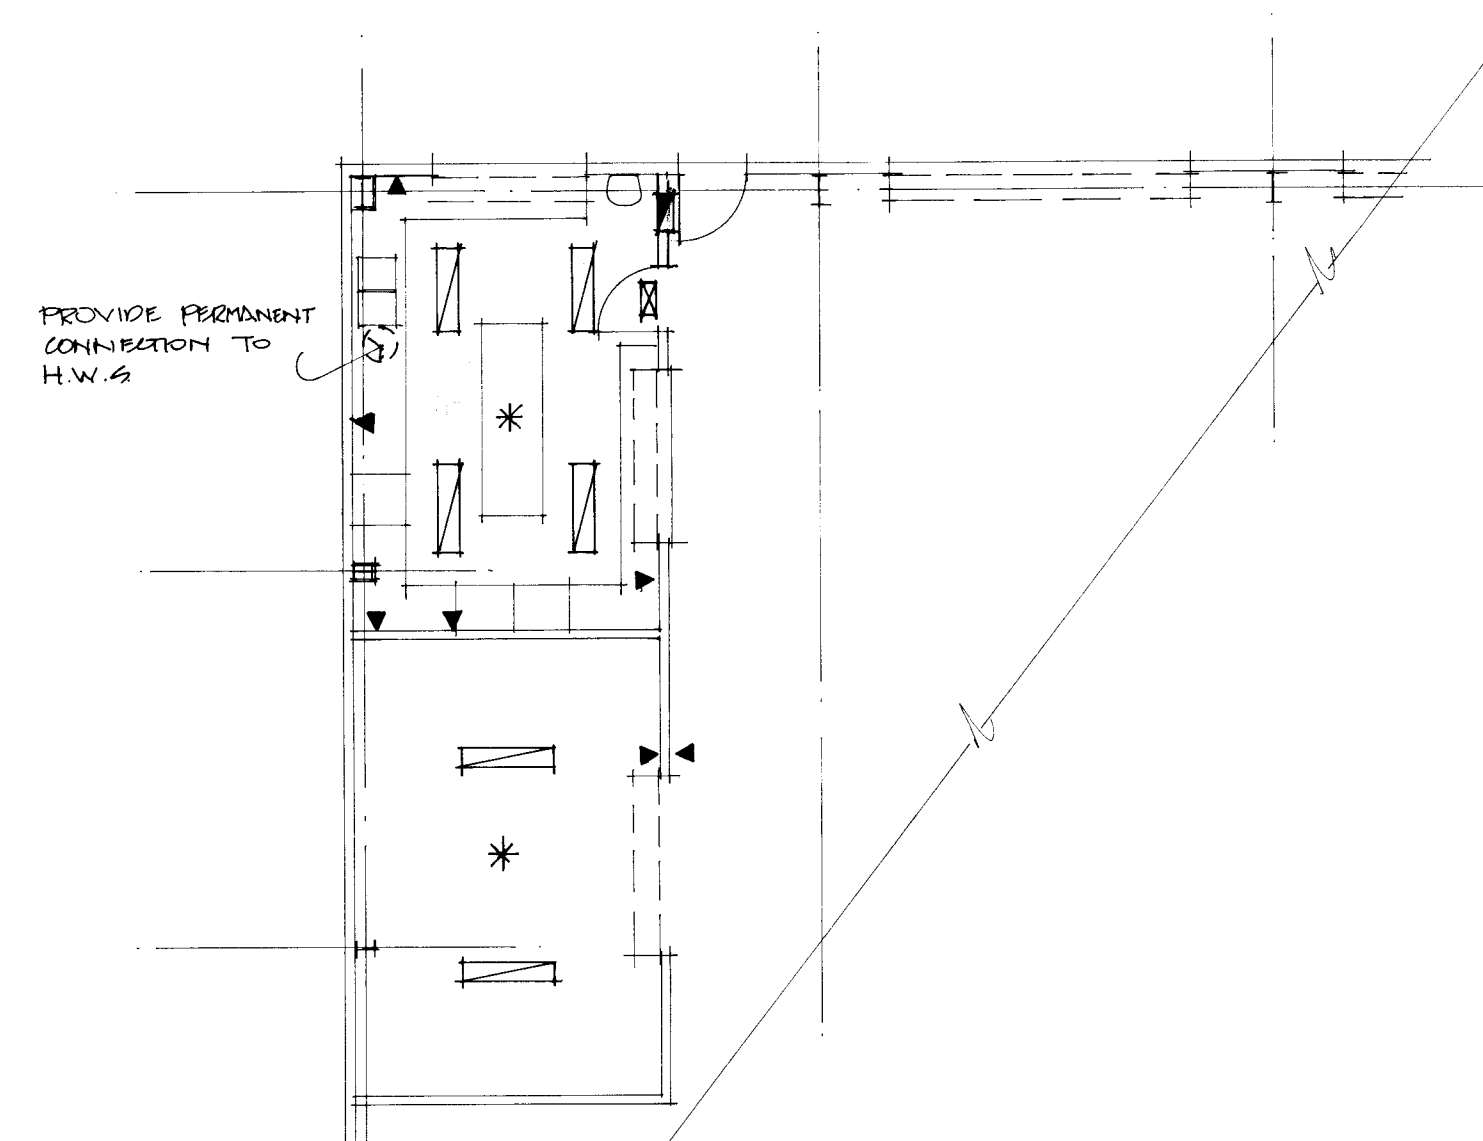

UNDER MEZZANINE  
REFLECTED CEILING PLAN  
SHOWING ELECTRICAL LAYOUT.

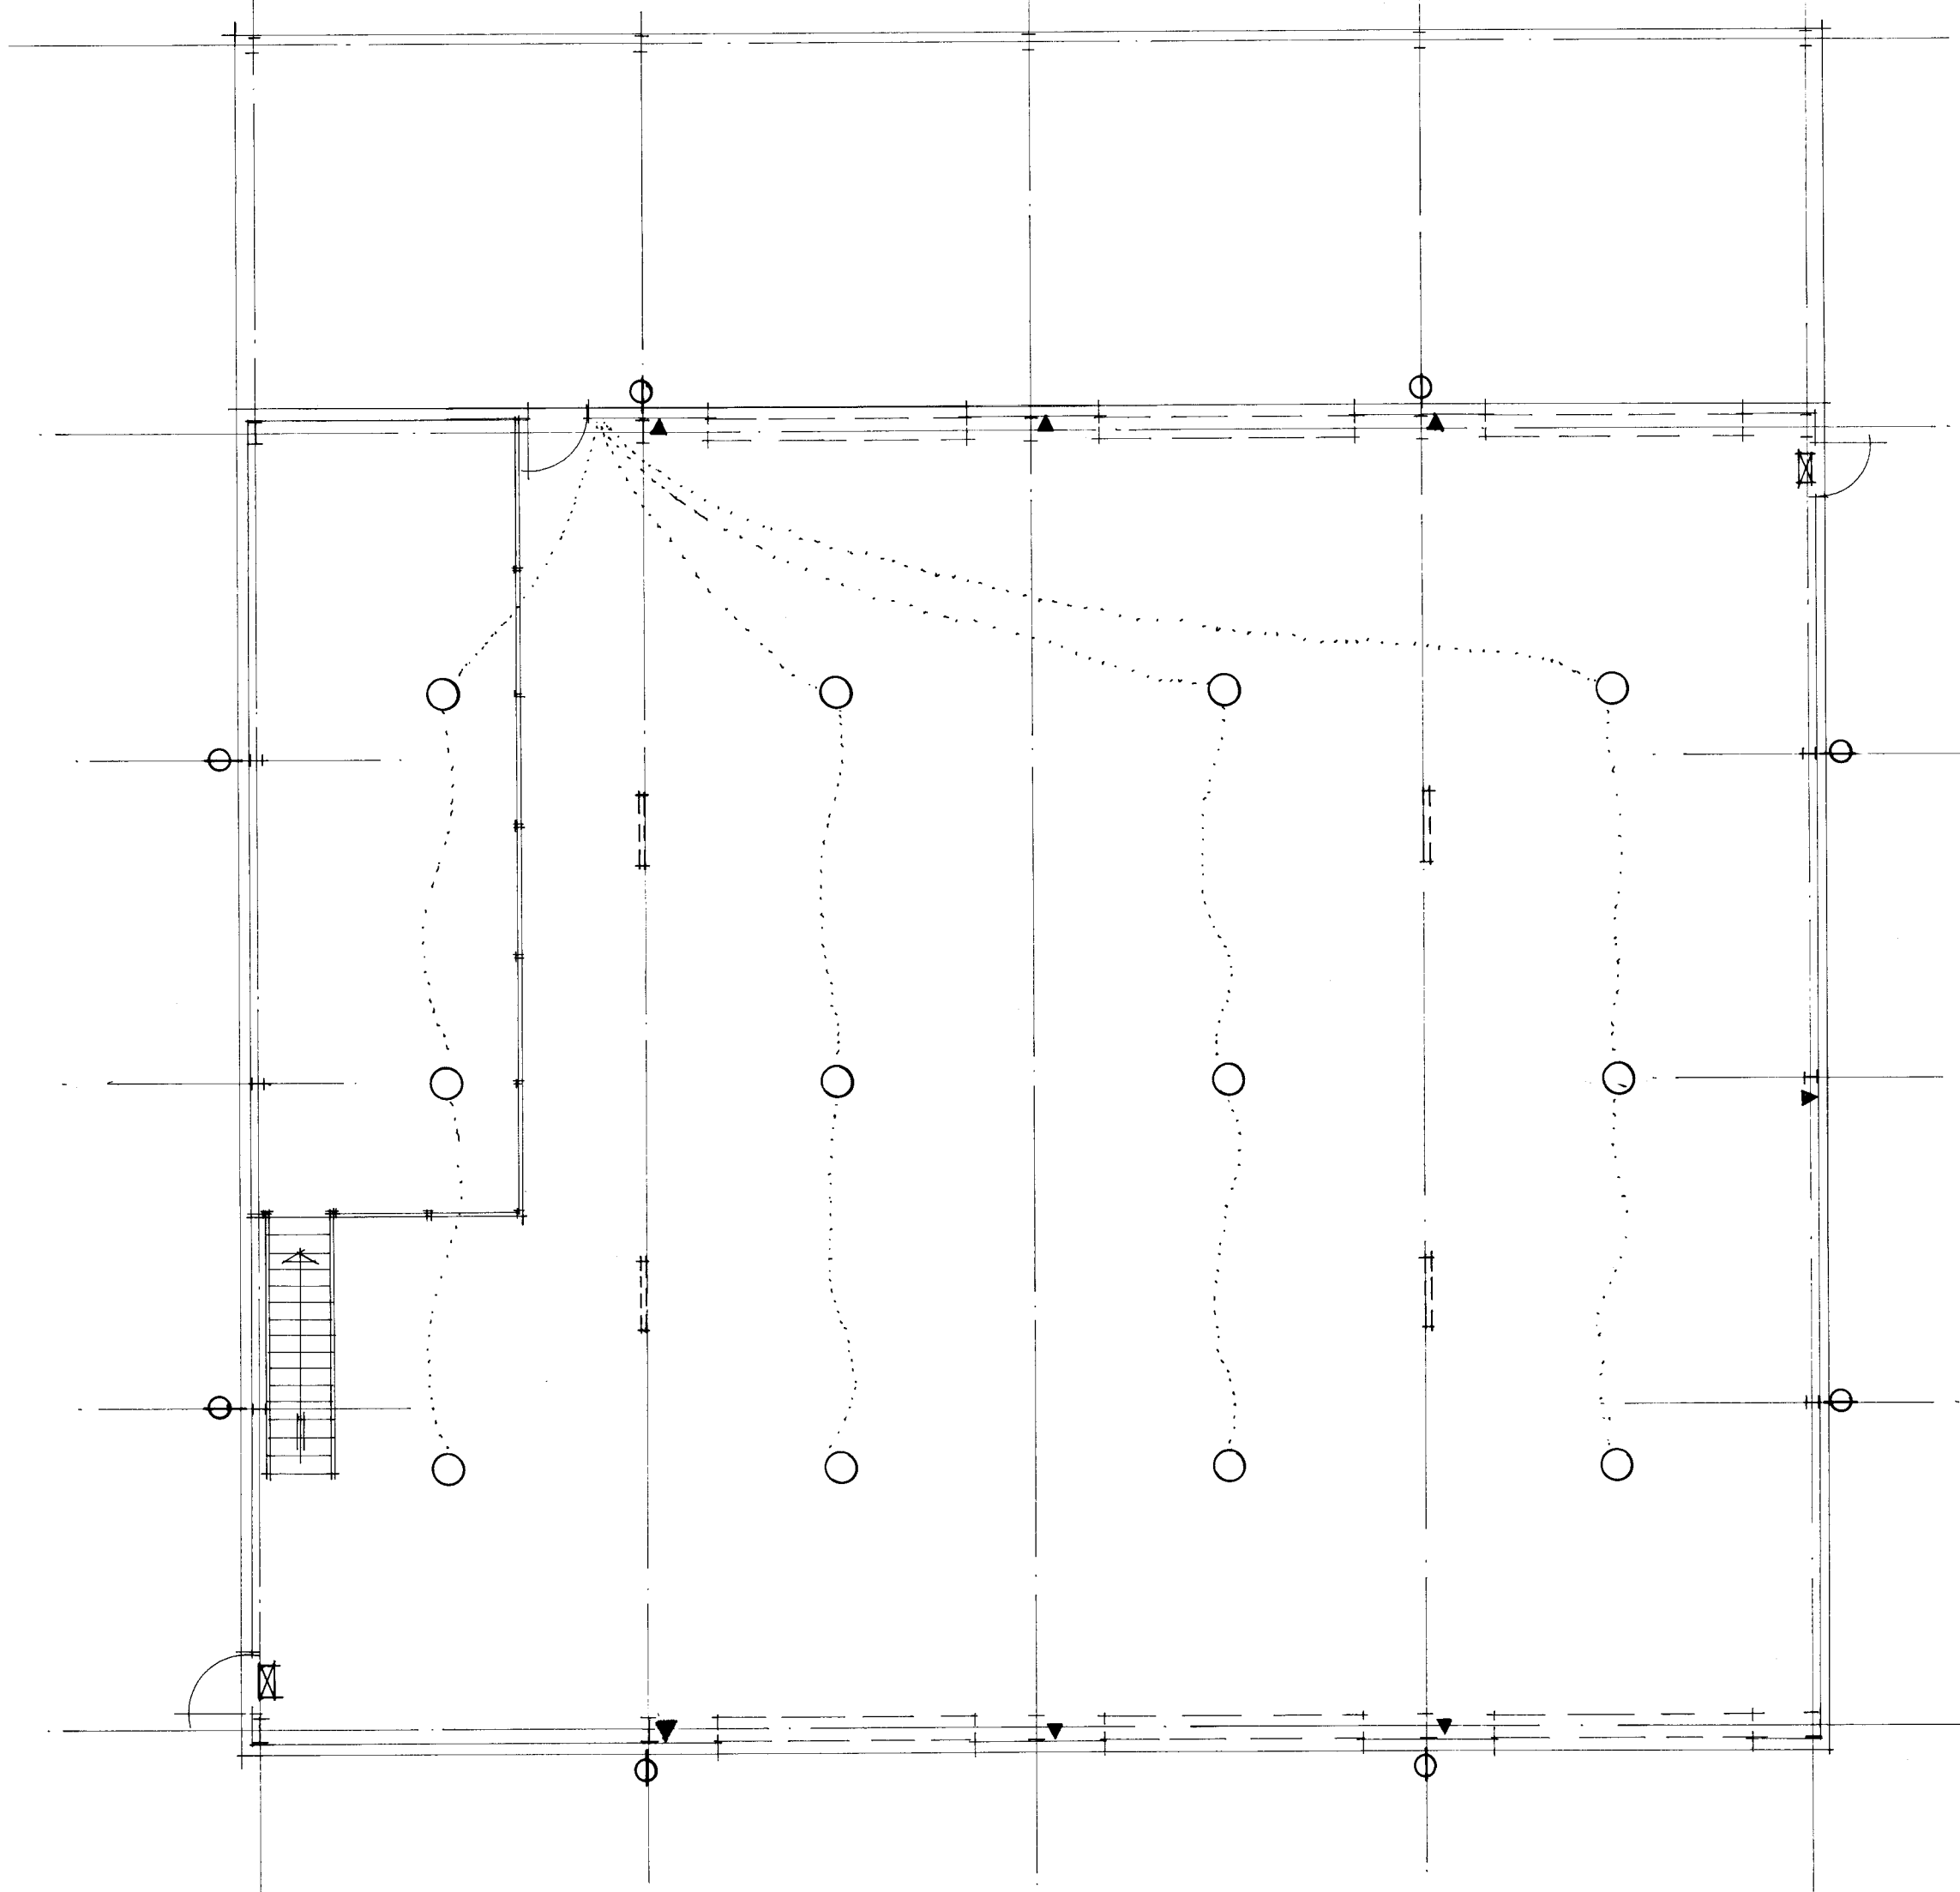


REFLECTED CEILING PLAN  
SHOWING ELECTRICAL LAYOUT.

# LEGEND :

- NON DIMMABLE 40W L.E.D. 1200 x 300 LIGHT PANEL FLUSH MOUNTED ON CEILING SWITCHED VIA MOTION SENSOR.
- 100W L.E.D. LOW BAY FITTING CHAIN SUSPENDED AT 5M ABOVE F.F.L. SWITCHED AS SHOWN.
- 10W L.E.D. BULKHEAD FITTING - SUPERLUX - 1W 6001-54 OR EQUAL. TO BE SWITCHED VIA MOTION SENSOR.
- L.E.D. BATTERY EMERGENCY LIGHT FITTING. FIXED TO U/S OF STEEL PORTAL FRAME.
- L.E.D. "SPITFIRE" EMERGENCY LIGHT FITTING CEILING MOUNTED.
- SELF ILLUMINATED EXIT SIGN.
- SUN BOARD
- DOUBLE G.P.O.
- INDICATES SWITCHING POINTS & GROUPING.

## NOTES:

- \* ELECTRICAL LAYOUT IS INTENDED AS A GUIDE ONLY. CONTRACTOR MUST VISIT SITE TO DETERMINE FULL EXTENT OF WORK ENTAILLED.
- \* ALL FITTINGS, SWITCHES, MOUNTING HEIGHTS, ETC. ARE TO BE APPROVED BY JOB SUPERINTENDANT.
- \* ALL WORK IS TO COMPLY WITH LOCAL SUPPLY AUTHORITIES REQUIREMENTS & CURRENT AUSTRALIAN STANDARDS.

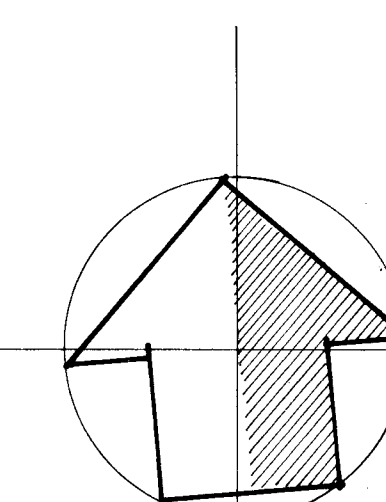

NORTH

Job:  
PROPOSED STAGED UPGRADE  
AT COOLAMON SHOWGROUND  
WILDMAN STREET COOLAMON  
FOR COOLAMON SHIRE COUNCIL

Dwg:  
**WORKING DRAWING**  
**ALLEN C. THOMPSON**

**BUILDING DESIGNER**

2 BEAUTY POINT AVENUE  
WAGGA WAGGA 2650  
PHONE (02) 9225 2028  
EMAIL ac@thompsonsgroup.com.au

SCALE: 1:100  
check all dimensions  
figured dimensions to be  
taken in preference to scale

Date:  
Nov 2021.

2138-6A

THIS PLAN IS SUBJECT  
TO COPYRIGHT LAW &  
MUST NOT BE REPRODUCED  
WITHOUT WRITTEN  
AUTHORITY