


GENERAL NOTS

1. ALL WORK SHALL BE IN ACCORDANCE WITH THE BUILDING CODE OF AUSTRALIA AND AS3500.3, COUNCILS STANDARD SPECIFICATIONS CODES.
2. THIS PLAN IS TO BE READ IN CONJUNCTION WITH THE ARCHITECTURAL, LANDSCAPE AND STRUCTURAL PLANS AS AVAILABLE.
3. MINIMUM GRADES FOR ALL PIPE SHOULD BE 1%.
4. DIRECT SURFACE FLOW TO ALL GRATED SURFACE INLET PITS.
5. ALL DESIGN LEVELS SHOWN ON PLAN SHALL BE VERIFIED ON SITE PRIOR TO THE COMMENCEMENT OF ANY WORK.
6. ANY DISCREPANCIES OR OMISSIONS SHALL BE REFERRED TO THE DESIGN ENGINEER FOR RESOLUTION.
7. ALL DOWN PIPES AND PIPE JOINTING SHALL BE FULLY SEALED AND SOLVENT WOKLED.
8. GUTTER / LEAF GUARDS ARE TO BE INSTALLED IN ALL GUTTERS.
9. CLEANING INSPECTION EYES SHALL BE INSTALLED AT THE LOWEST POINT IN ALL CHARGED LINES IF REQUIRED

TRUE NORTH
M.C.A. NORTH

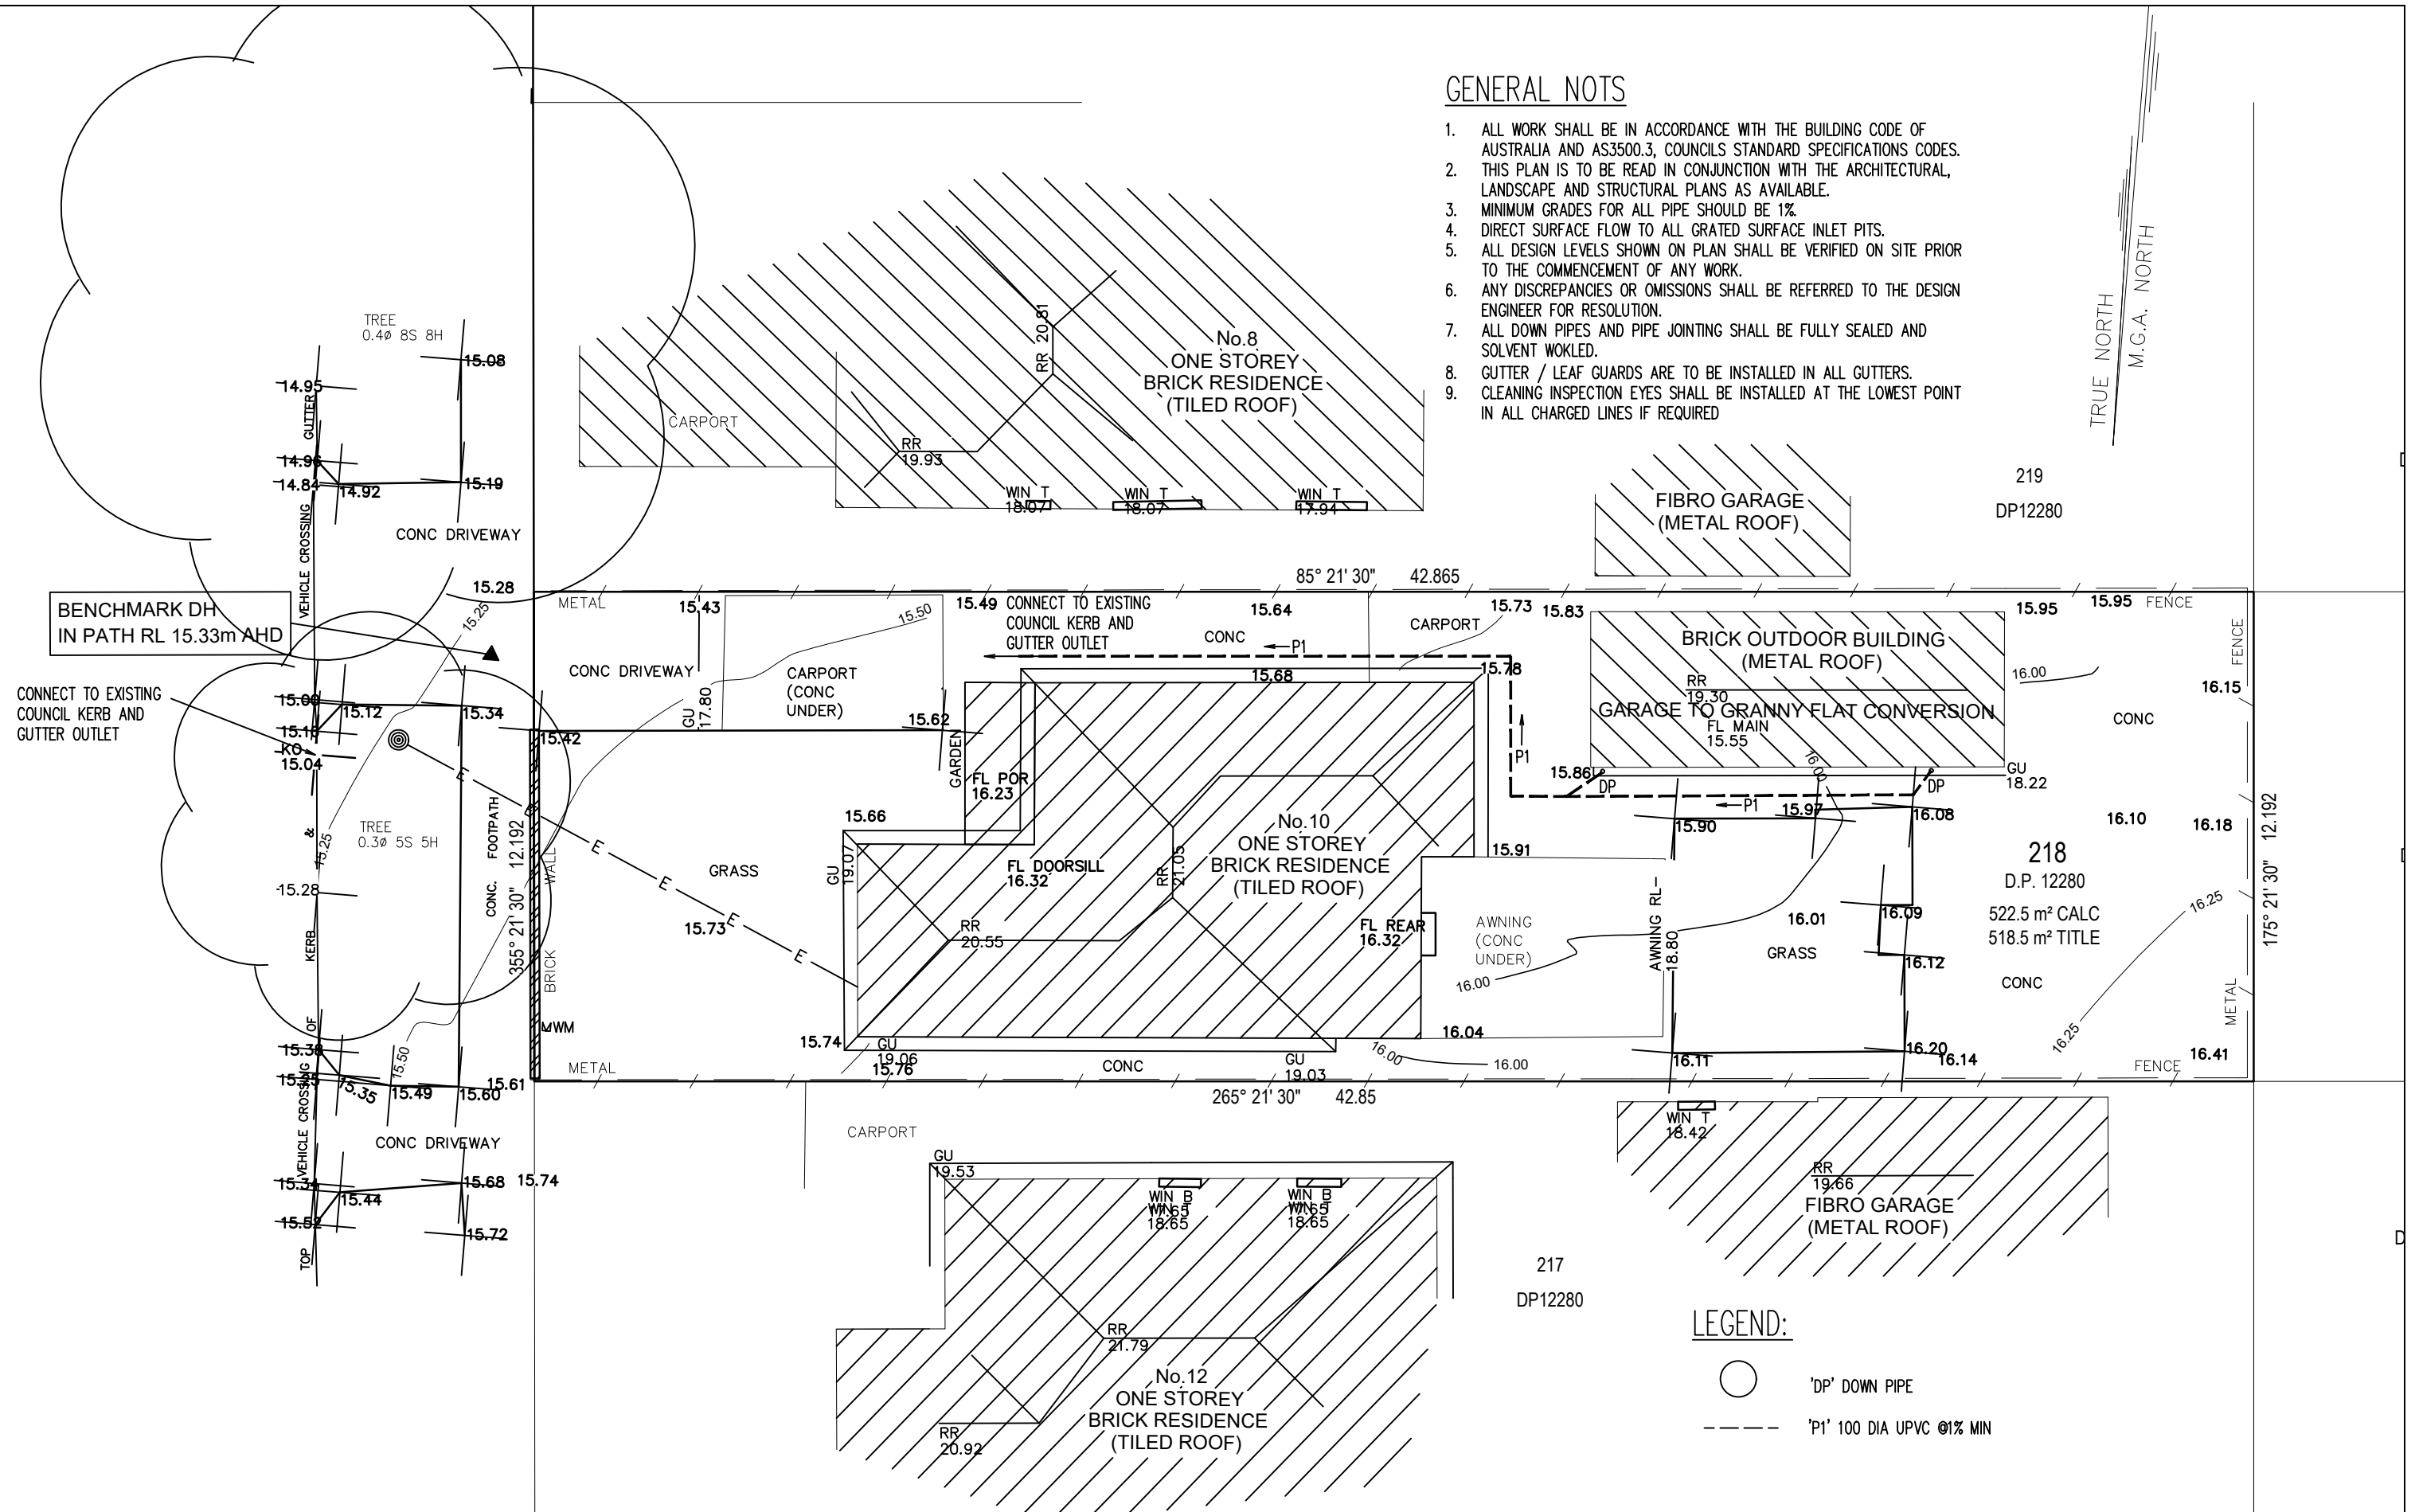

LEGEND:

- 'DP' DOWN PIPE
 --- 'P1' 100 DIA UPVC @1% MIN

Designed by:	E.C.	ERTAZ H, CHOWDHURY MIEAust, CPEng. NPER, Reg. No. 2214897 	Australiawide Consulting Services P/L Civil & Structural Engineering and Project Management 1369b Canterbury Road, Punchbowl, NSW 2196 Mobile: 0420710548 Email: ertaz1@hotmail.com 	Architect: -	Client: MR CONG QUANG LE	Project North: 	Project: BUILDING INFORMATION CERTIFICATION FOR EXISTING GARAGE TO GRANNY FLAT CONVERSION AT 10 BLENMAN AVENUE, PUNCHBOWL, NSW 2196	Job: STORMWATER DRAINAGE PLAN	Date: 02-09-2022
Drawn by:	A.A.							Title: STORMWATER DRAINAGE PLAN	Scale @A3: 1:150
Revision:	00								Drg No. SW02-A