


LEP Height of Buildings



Planning Proposal

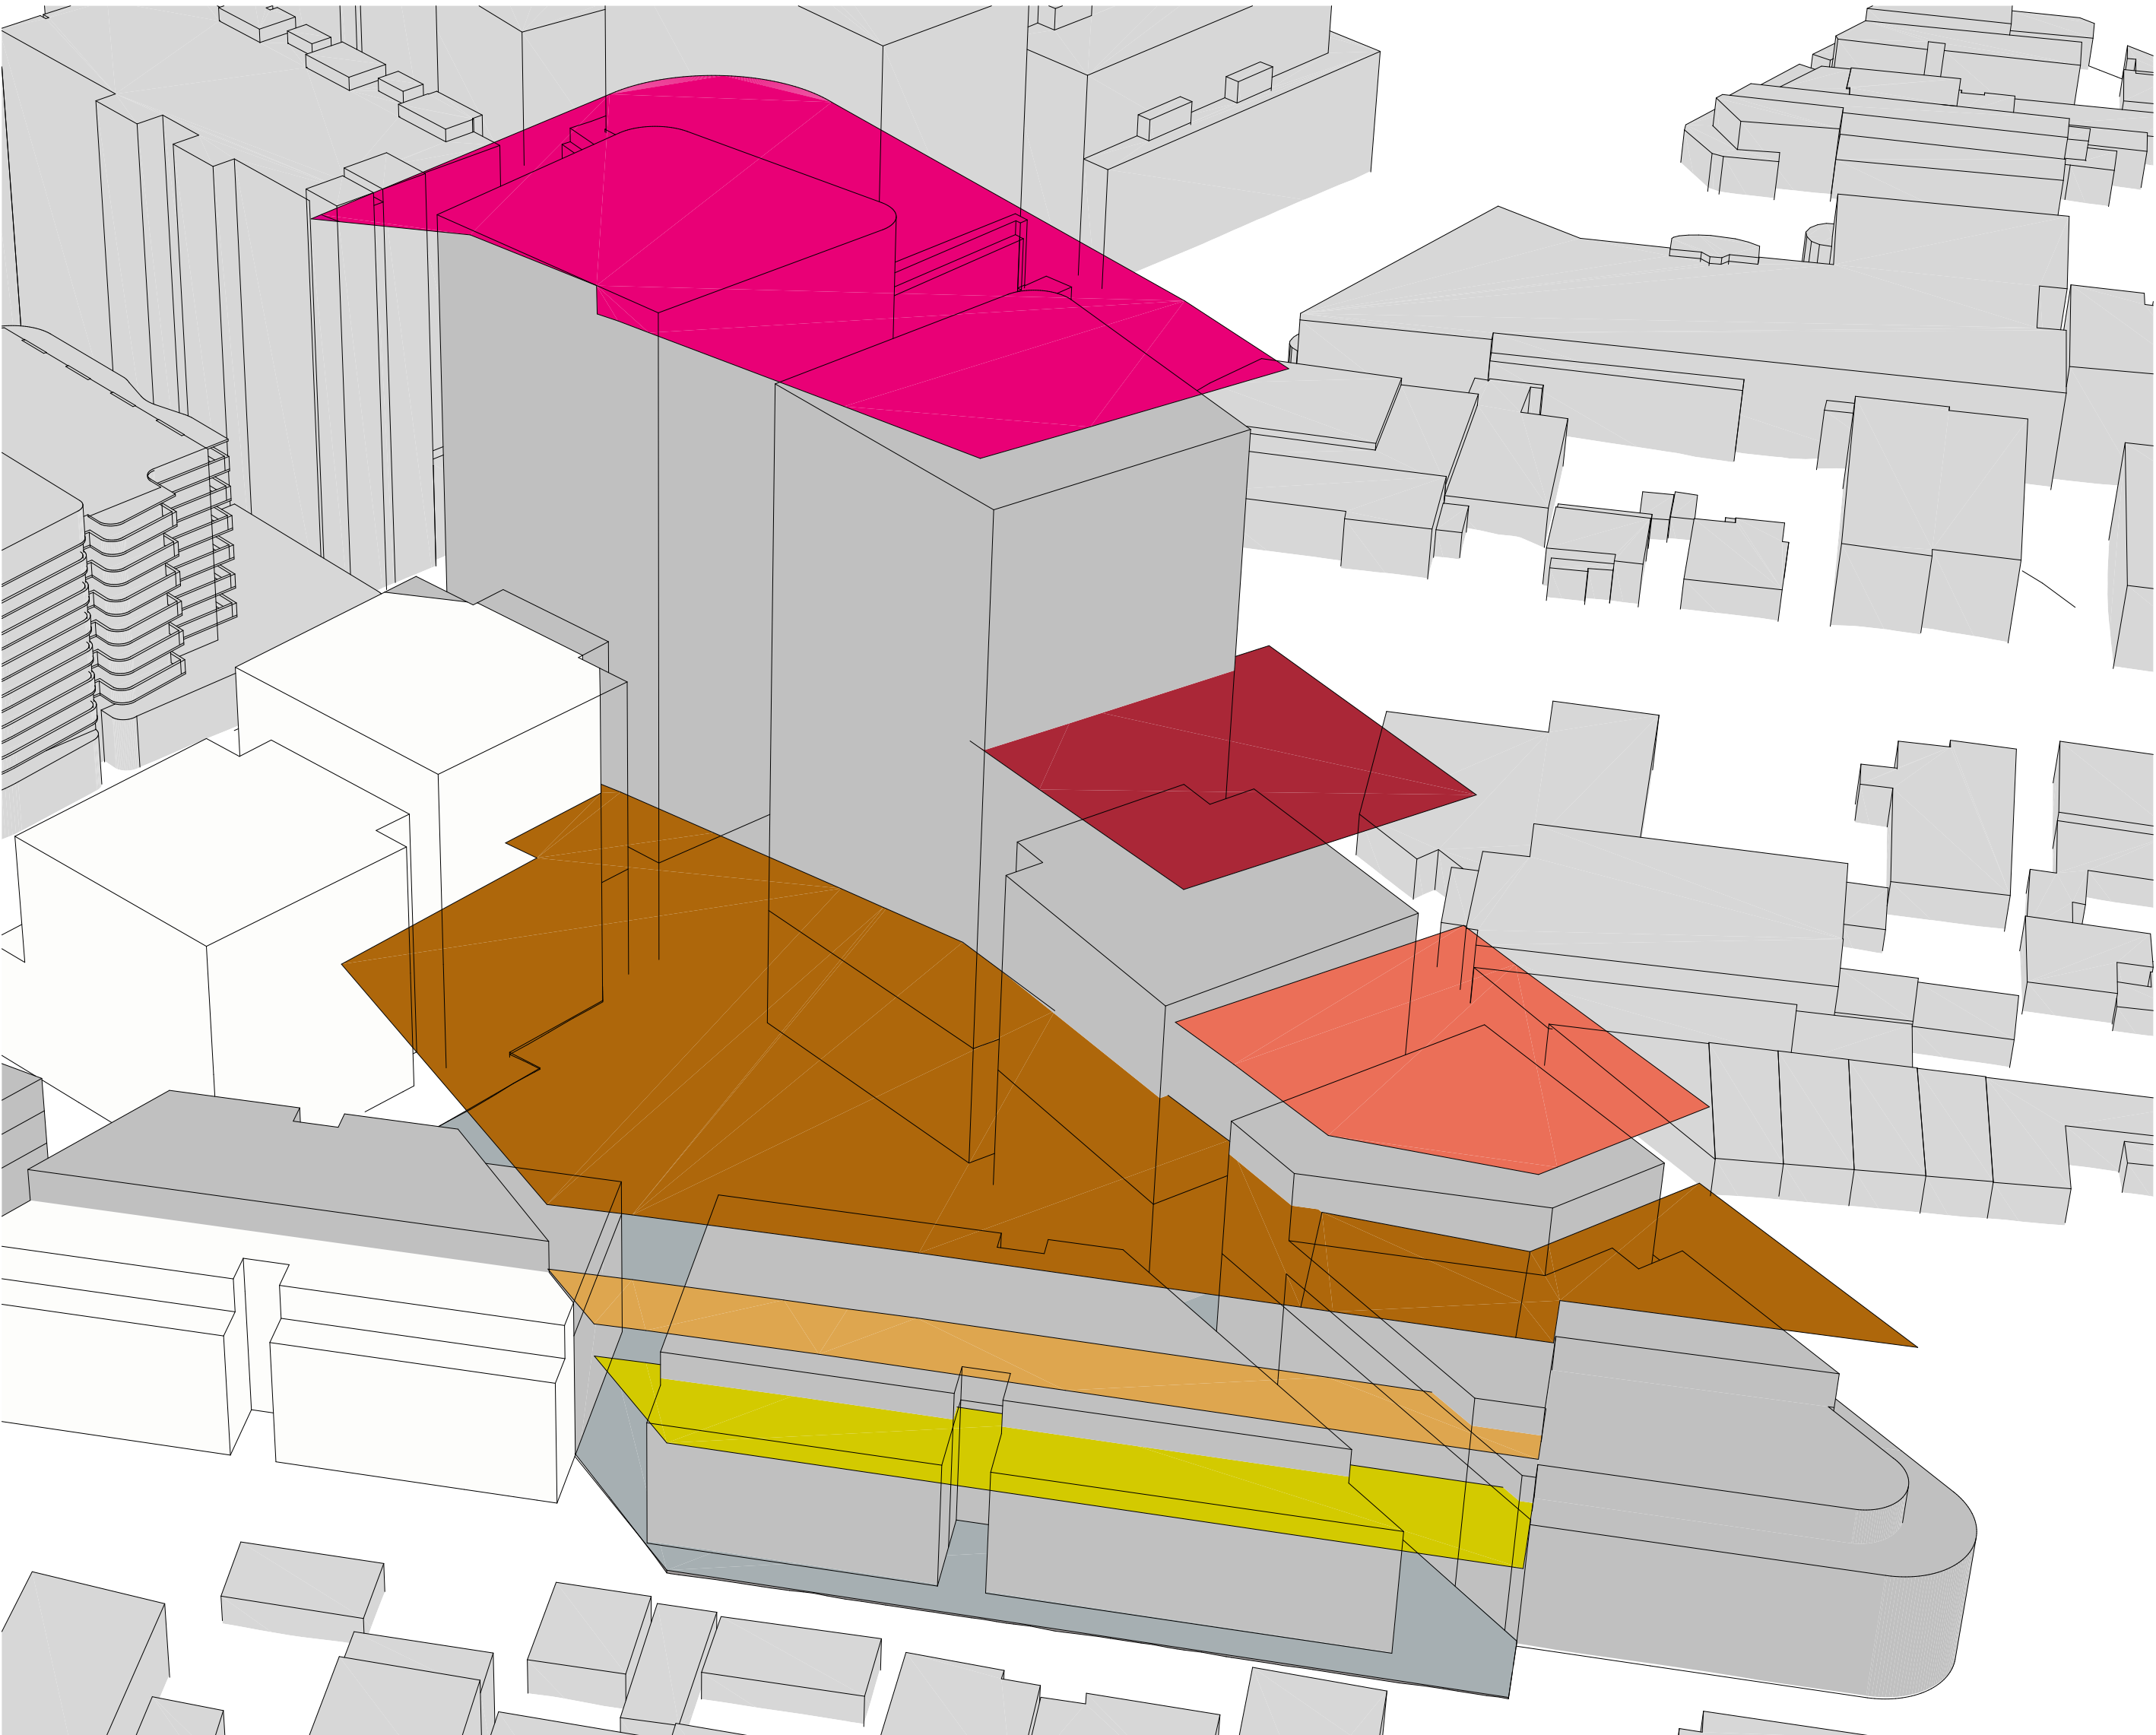

Development Application

NOTES  
THIS DRAWING IS COPYRIGHT © OF TURNER. NO REPRODUCTION WITHOUT PERMISSION. UNLESS NOTED OTHERWISE THIS DRAWING IS NOT FOR CONSTRUCTION. ALL DIMENSIONS AND LEVELS ARE TO BE CHECKED ON SITE PRIOR TO THE COMMENCEMENT OF WORK. INFORM TURNER OF ANY DISCREPANCIES FOR CLARIFICATION BEFORE PROCEEDING WITH WORK. DRAWINGS ARE NOT TO BE SCALED. USE ONLY FIGURED DIMENSIONS. REFER TO CONSULTANT DOCUMENTATION FOR FURTHER INFORMATION (DWG, PC AND BIM) FILES AND UNCONTROLLED DOCUMENTS AND ARE ISSUED FOR INFORMATION ONLY.

CLIENT  
**Aoyuan International**  
Suite 30.02, Lvl 30, 420 George Street  
Sydney NSW 2000

DLCS Quality Endorsed Company ISO 9001:2015, Registration Number 20476  
Notified Architect Nicholas Turner 6885, ABN 98 594 394 871

Project Title  
**Landmark Square**  
61-75 Forest Road & 126 Durham Street Hurstville NSW

Drawing Title  
**Control Diagrams**  
**Proposed Height of Buildings Comparison**

E	18.03.21	AM	Development Application Amendment
D	19.08.20	AM	Development Application
A	13.08.20	AM	Development Application
Rev	Date	Approved by	Revision Notes

Scale	Project No.	20035	Drawn by	North
Status	Dwg No.	DA-710-020	Rev	E
Development Application				

**TURNER**

Level 7 ONE Oxford Street  
Darlinghurst NSW 2010  
AUSTRALIA  
T +61 2 8668 0000  
F +61 2 8668 0088  
turnerstudio.com.au