



DP NOTES:

ALL SEALED DOWNPIPES TO BE 90 Ø PVC
PAINT SINGLE PIPE RUNS BEFORE INSTALATION
USE METAL, ROUND BENDS TO CONNECT SDPs to GUTTERS
USE 100 mm WIDE and 60 mm HIGH GUTTERS

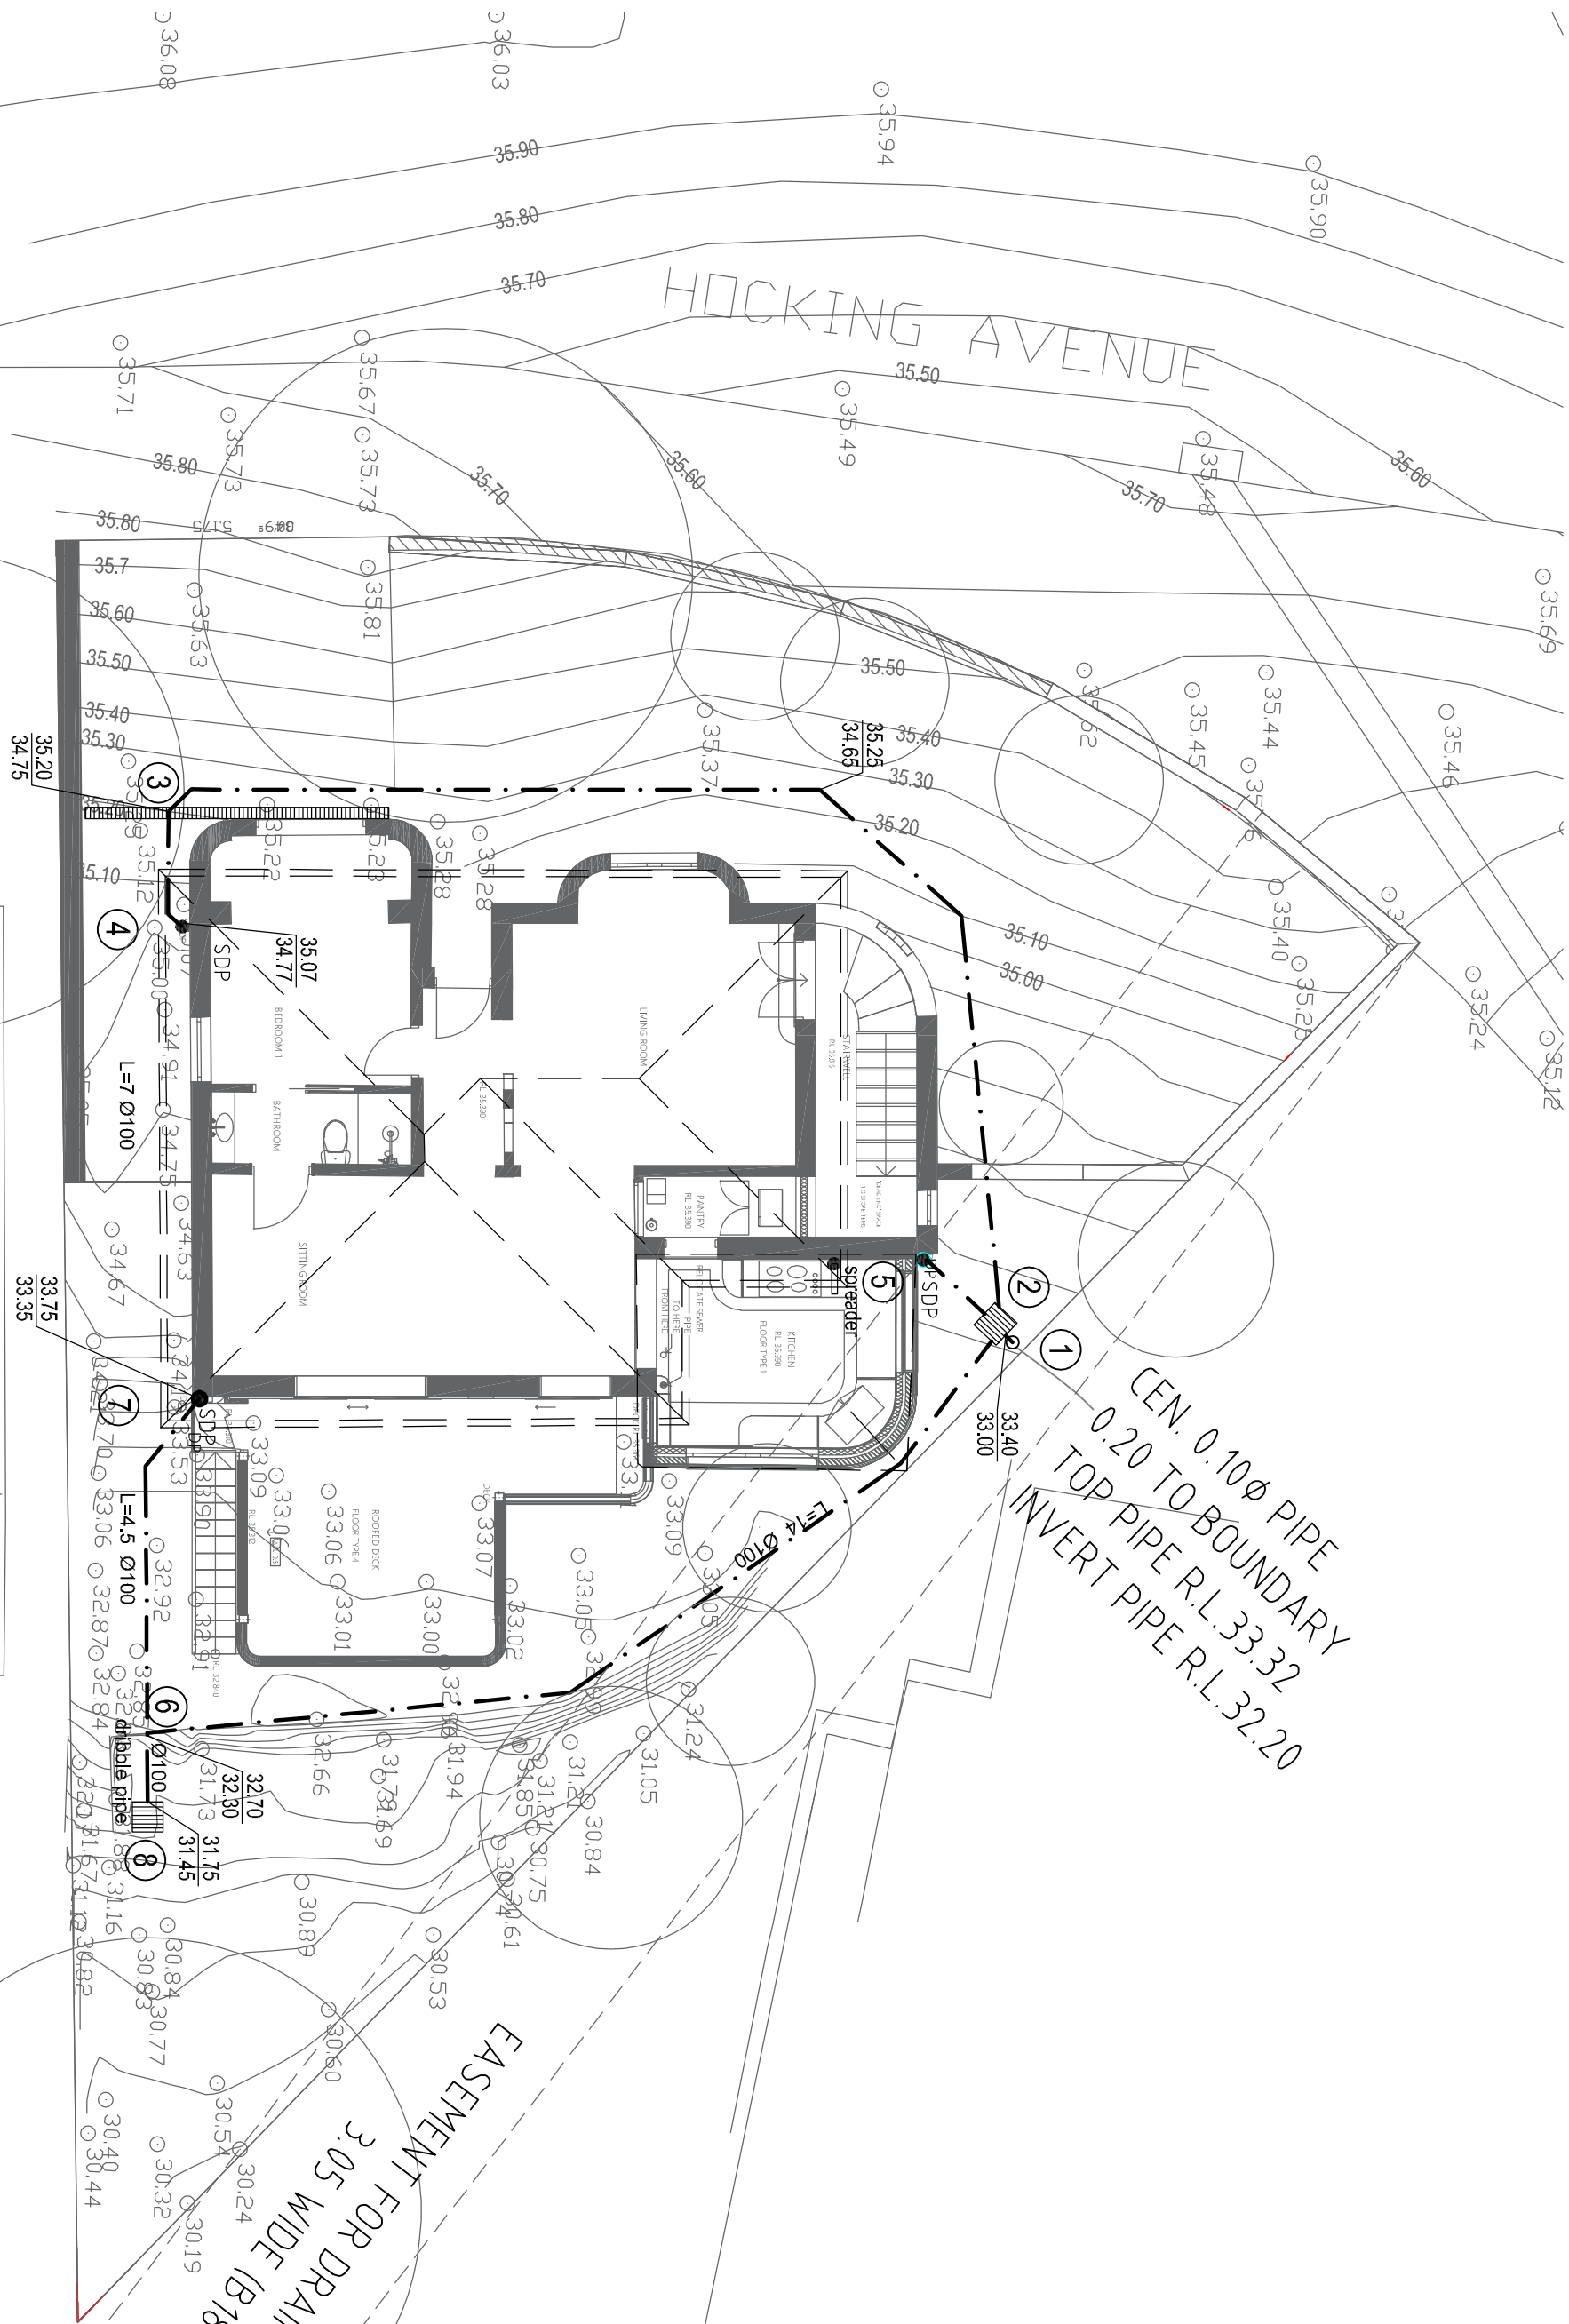


CEN. 0.10ø PIPE
0.20 TO BOUNDARY
TOP PIPE R.L.33.32
INVERT PIPE R.L.32.20


EASEMENT FOR DRAINAGE OF WATERS
3.05 WIDE (B184/832)

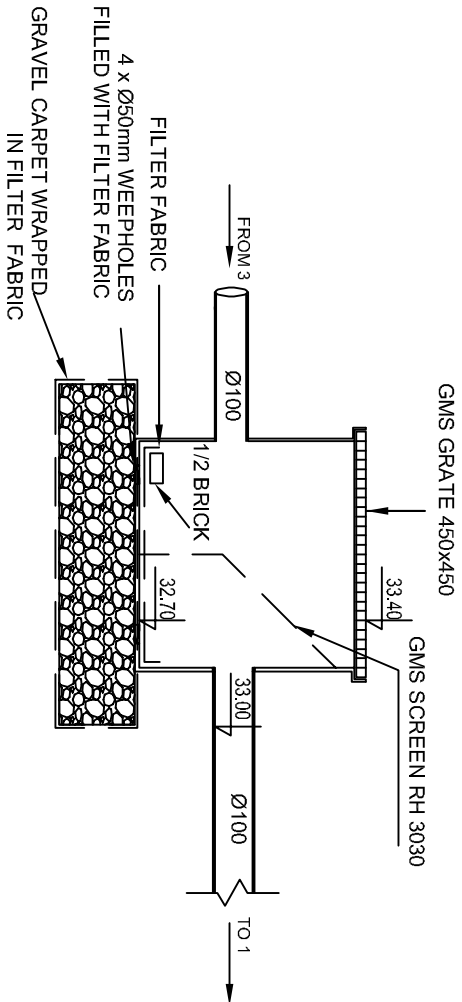


PIT No. 2 SECTION NTS

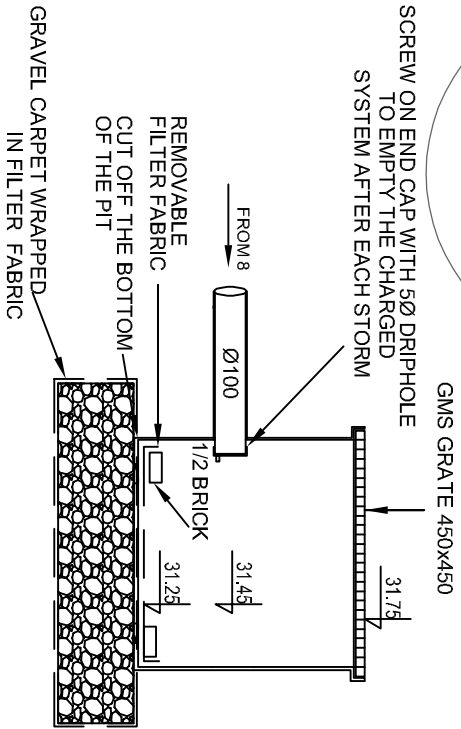

PIT No. 8 SECTION NTS

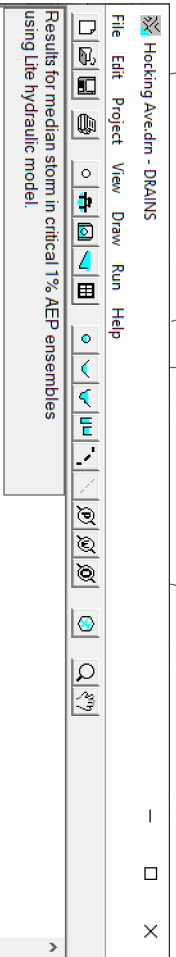

DRAINS SHEMATIC, 1% AEP, EXISTING

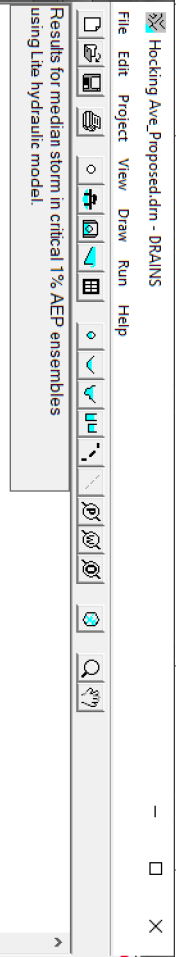

DRAINS SHEMATIC, 1% AEP, PROPOSED

Amendments

Issue	Date	Comments
1	2/11/20	for comments
2	14/12/20	for DA
3	10/08/22	Draft for CC
4	28/09/22	for CC
5	6/07/24	FWT removed, connect to existing discharge point
6	-	-
7	-	-
8	-	-

STORMWATER DRAINAGE PLAN FOR PROPOSED ALTERATIONS/ADDITIONS AT No.4 HOCKING AVENUE, EARLWOOD		DRAWN BY: P.K.
SCALE: 1:100 on A2, 1:200 on A4		DRAWING No.C-3564-01
DESIGNED BY: PAVEL KOZAROVSKI, MIEAus, CPEng, NER		Kozarovski & Partners 14/52-54 KINGSWAY, CRONULLA NSW 2230 (02) 9544 8720 Mobile: 04-12 997 767 pavelk@cplustrat.com.au