


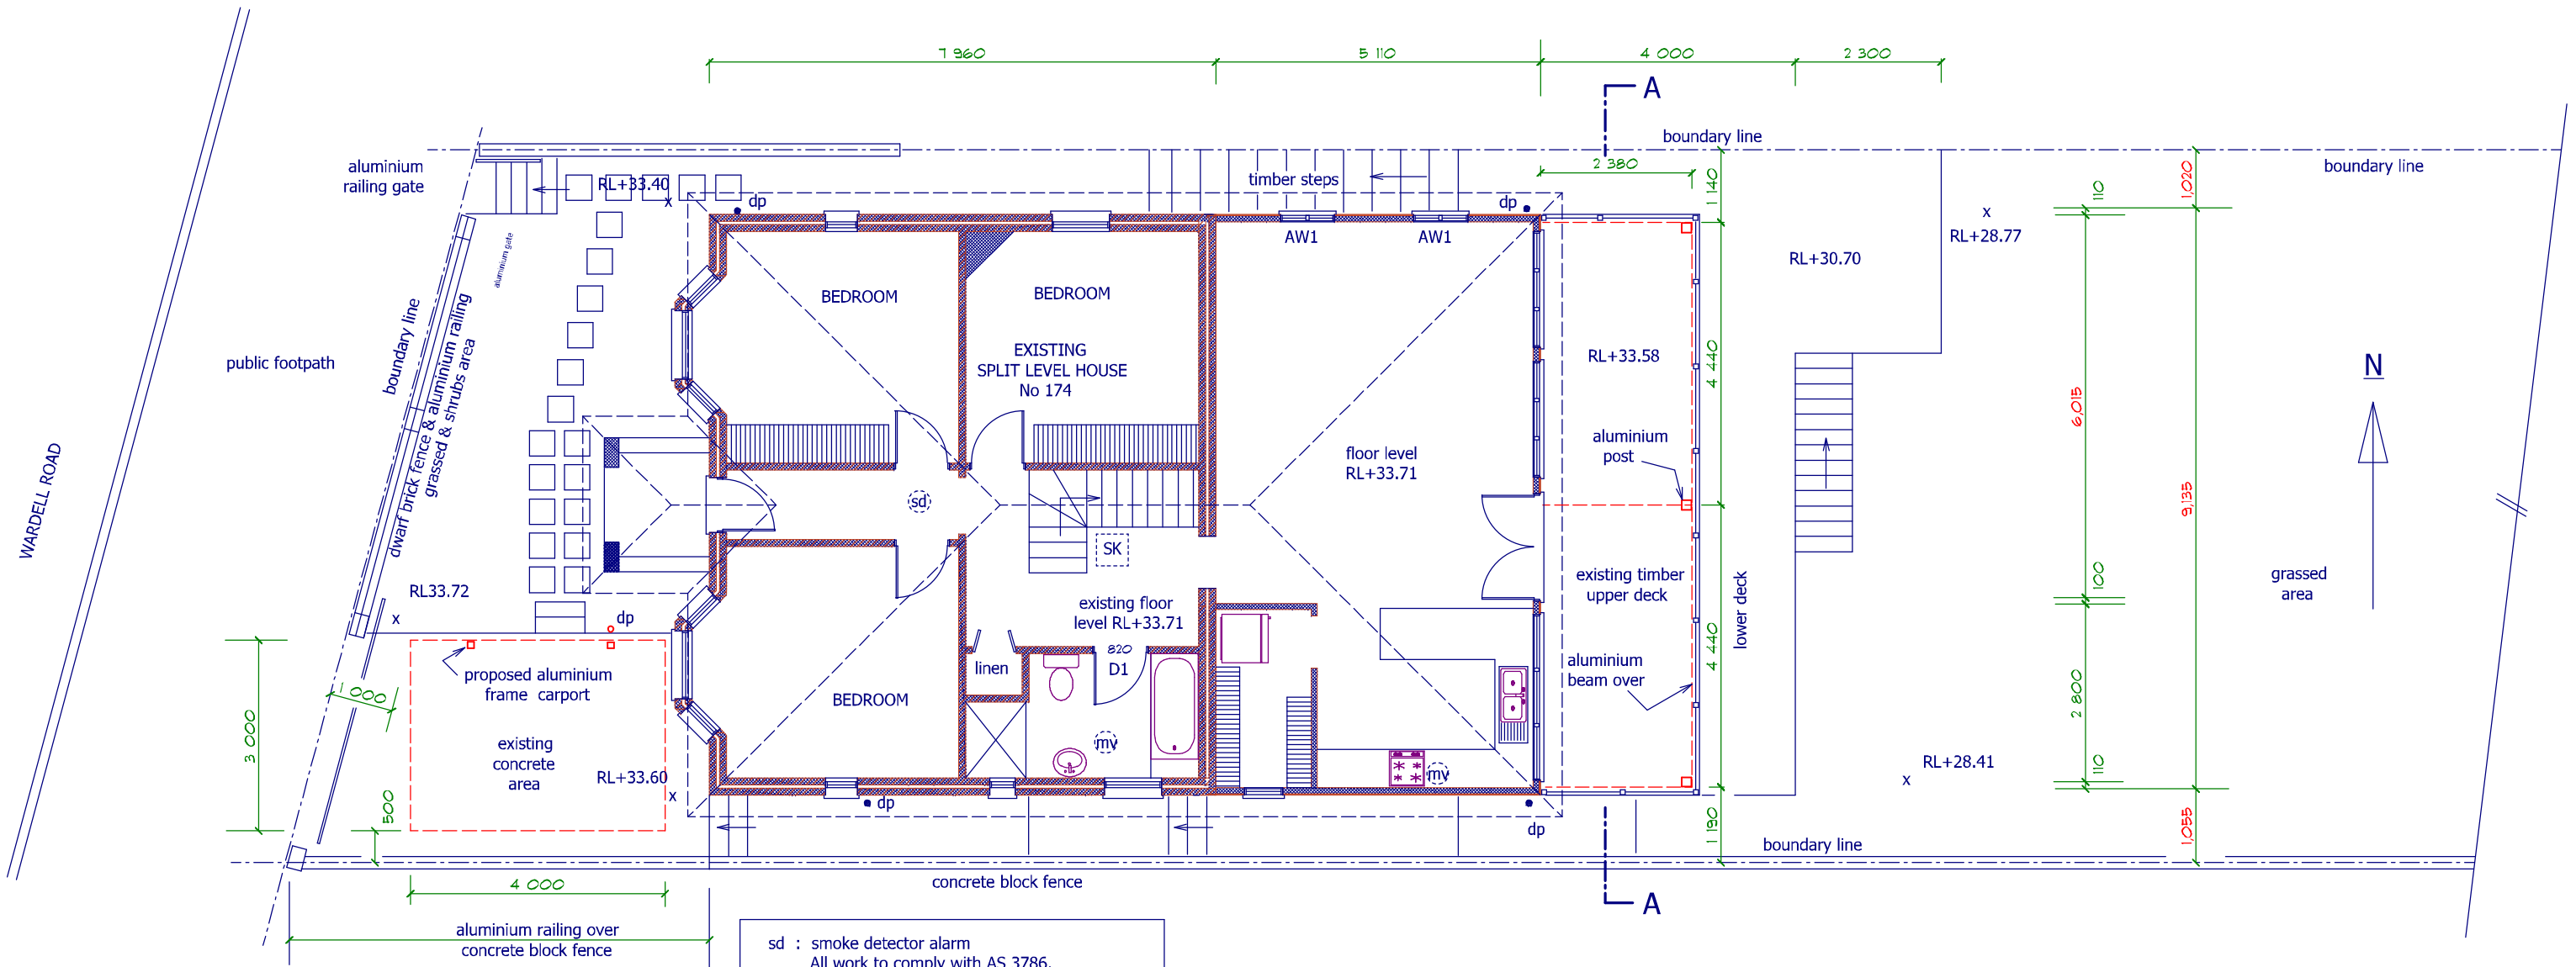


MAIN LEVEL FLOOR PLAN

sd : smoke detector alarm
All work to comply with AS 3786.
Smoke alarms must be connected to the
consumer mains power and be battery-backed.
mv : mechanical ventilation



NOTE: ALL DIMENSIONS AND LEVELS TO BE CHECKED ON SITE

 DPM Design and Plans Pty Ltd ABN 27 743 583 732 T (02) 9558 5885 M 0413 143 982 E dpm@outlook.com.au	REVISION	DESCRIPTION	ISSUED	PROPOSED VERGOLA & CARPORT ADDITION		AT 174 WARDELL ROAD, EARLWOOD NSW		
				FOR MARIA & GREGORIO GARRIGO		TITLE CONCEPT DRAWINGS		
				DATE APRIL / 2025	DRAWN BY GG	SCALE : 1 : 100	SHEET : 4 OF 6	SIZE : A3

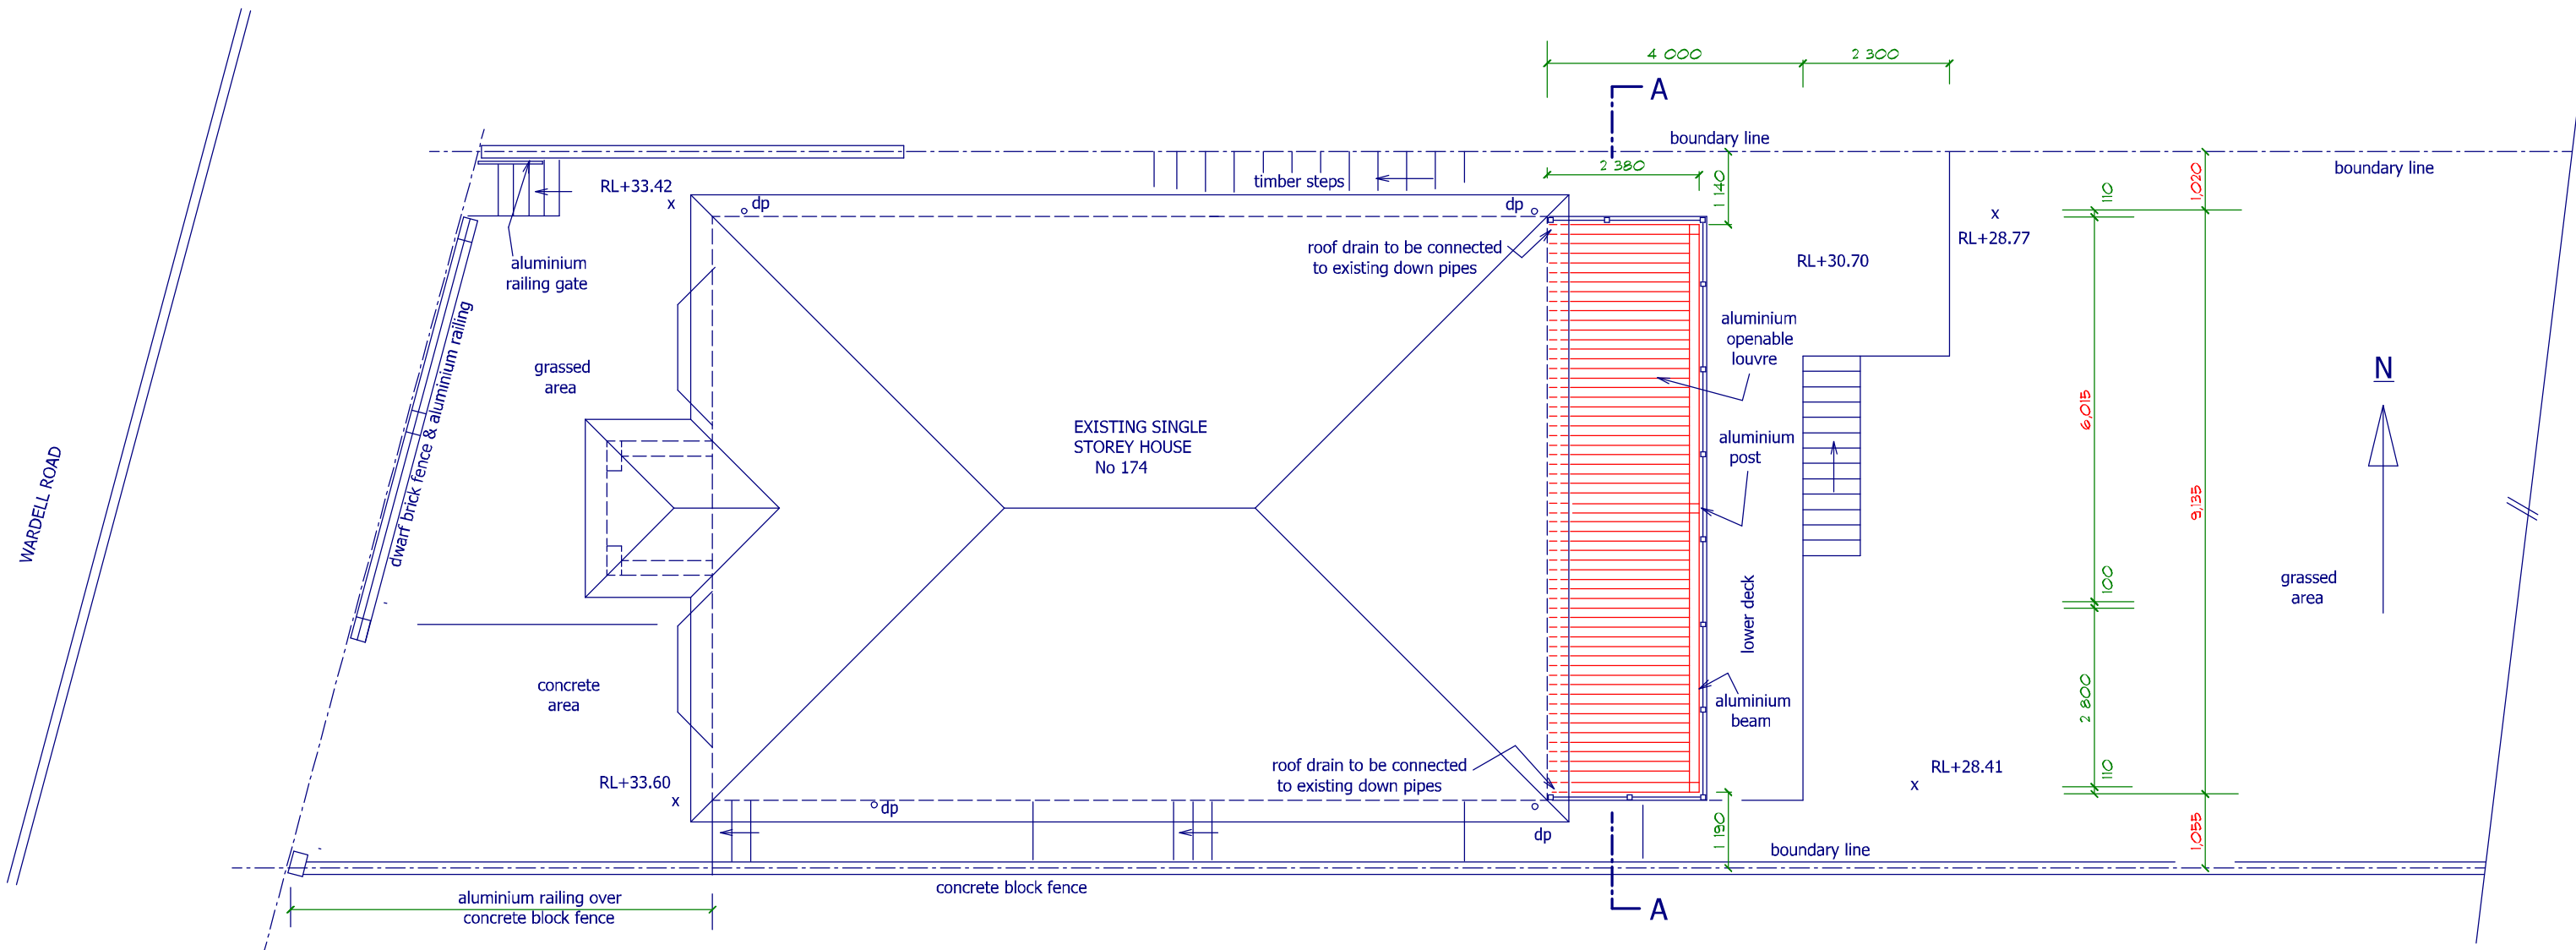

ROOF PLAN



NOTE: ALL DIMENSIONS AND LEVELS TO BE CHECKED ON SITE

 DPM Design and Plans Pty Ltd ABN 27 743 583 732 T (02) 9558 5885 M 0413 143 982 E dpm@outlook.com.au	REVISION	DESCRIPTION	ISSUED	PROPOSED VERGOLA & CARPORT ADDITION		AT 174 WARDELL ROAD, EARLWOOD NSW		
				FOR MARIA & GREGORIO GARRIGO		TITLE CONCEPT DRAWINGS		
				DATE APRIL / 2025	DRAWN BY GG	SCALE : 1 : 100	SHEET : 6 OF 6	SIZE : A3