


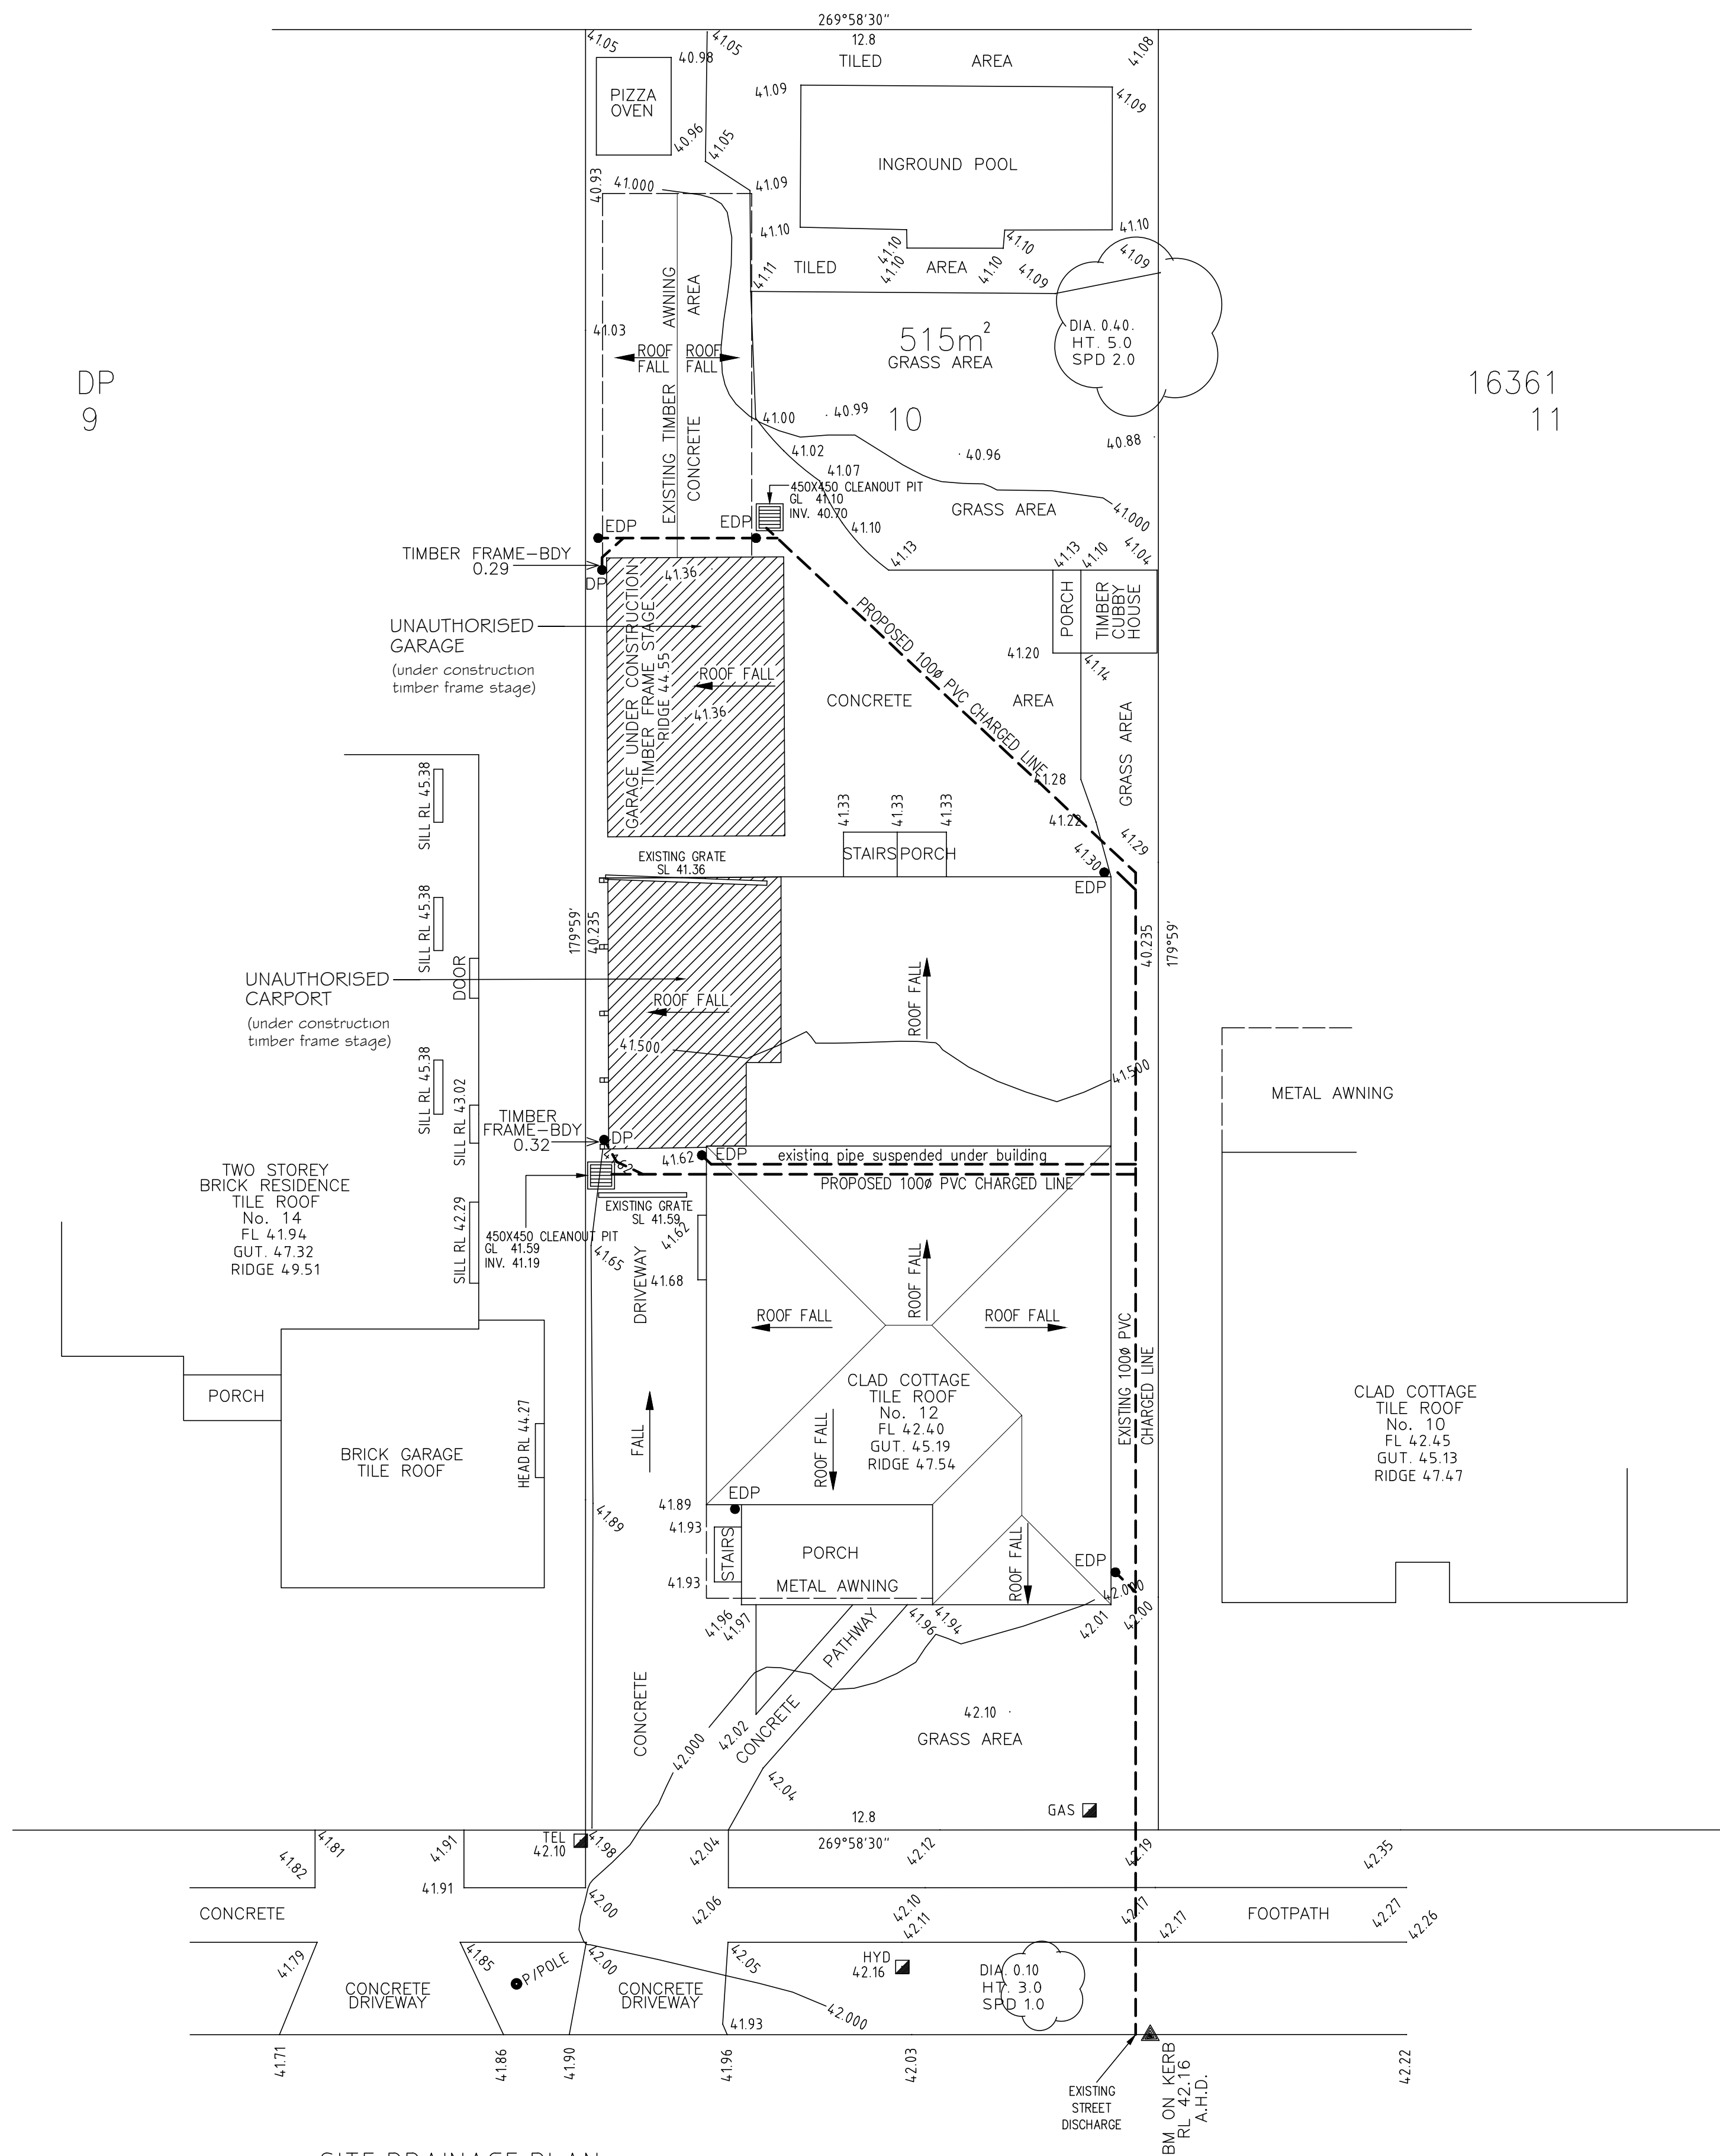

SITE DRAINAGE PLAN
SCALE 1: 100

- | | |
|-----|---------------------------|
| RL | DENOTES PROPOSED LEVEL |
| + | DENOTES EXISTING LEVEL |
| DP | DENOTES DOWNPIPE |
| EDP | DENOTES EXISTING DOWNPIPE |

100mm Ø UPVC PIPE FROM CHARGED LINE SYSTEM (provide screw cap to pipe end)

GRATED PIT

N12 - 300 EACH WAY

1/2 BRICK KEEPER

REPLACEABLE GEOTEXTILE FILTER FABRIC

PERMANENT GEOTEXTILE FILTER FABRIC SURROUNDING 14mm AGGREGATE.

200


200

200

100

4x30 DIA PIPE (WEAPHOLES)

CHARGED LINE CLEANOUT PIT

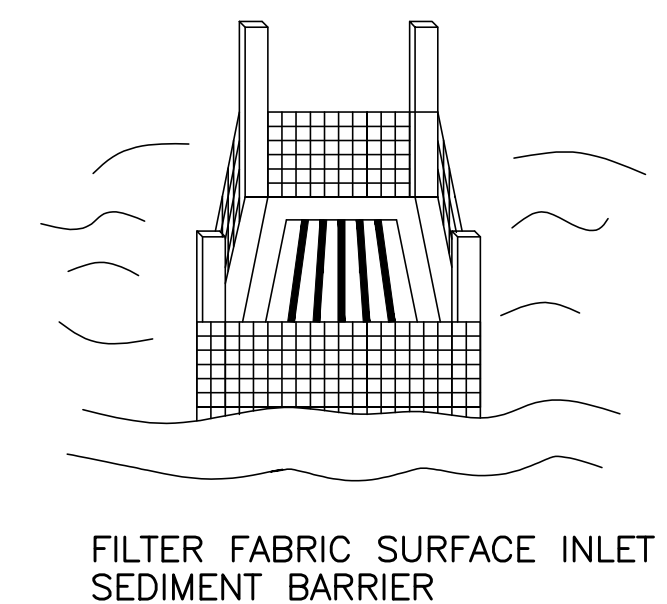

13/05/2025	THE GARAGE AND CARPORT AS SEPARATE STRUCTURES	REV. A
PROJECT UNAUTHORISED GARAGE WITH BATHROOM AND STORAGE AREA AT: 12 WENTWORTH STREET BIRRONG FOR MR CEMEL & MRS AHMET		
DRAWING TITLE STORMWATER DRAINAGE PLAN		
DESIGNED – B. HAYKAL No. 25 LANGTRY AVE, AUBURN 2144 Ph: (02) 9702 3400		CHECKED – B. HAYKAL B.E, MIEAust CPEng, NPFR ACCREDITED CERTIFIER, STRUCTURE & CIVIL M/N 761897
DRAWN B.H. SCALES 1:100 SHEET 1/1		JOB NUMBER 24021/D
DATE 30/12/2024		