


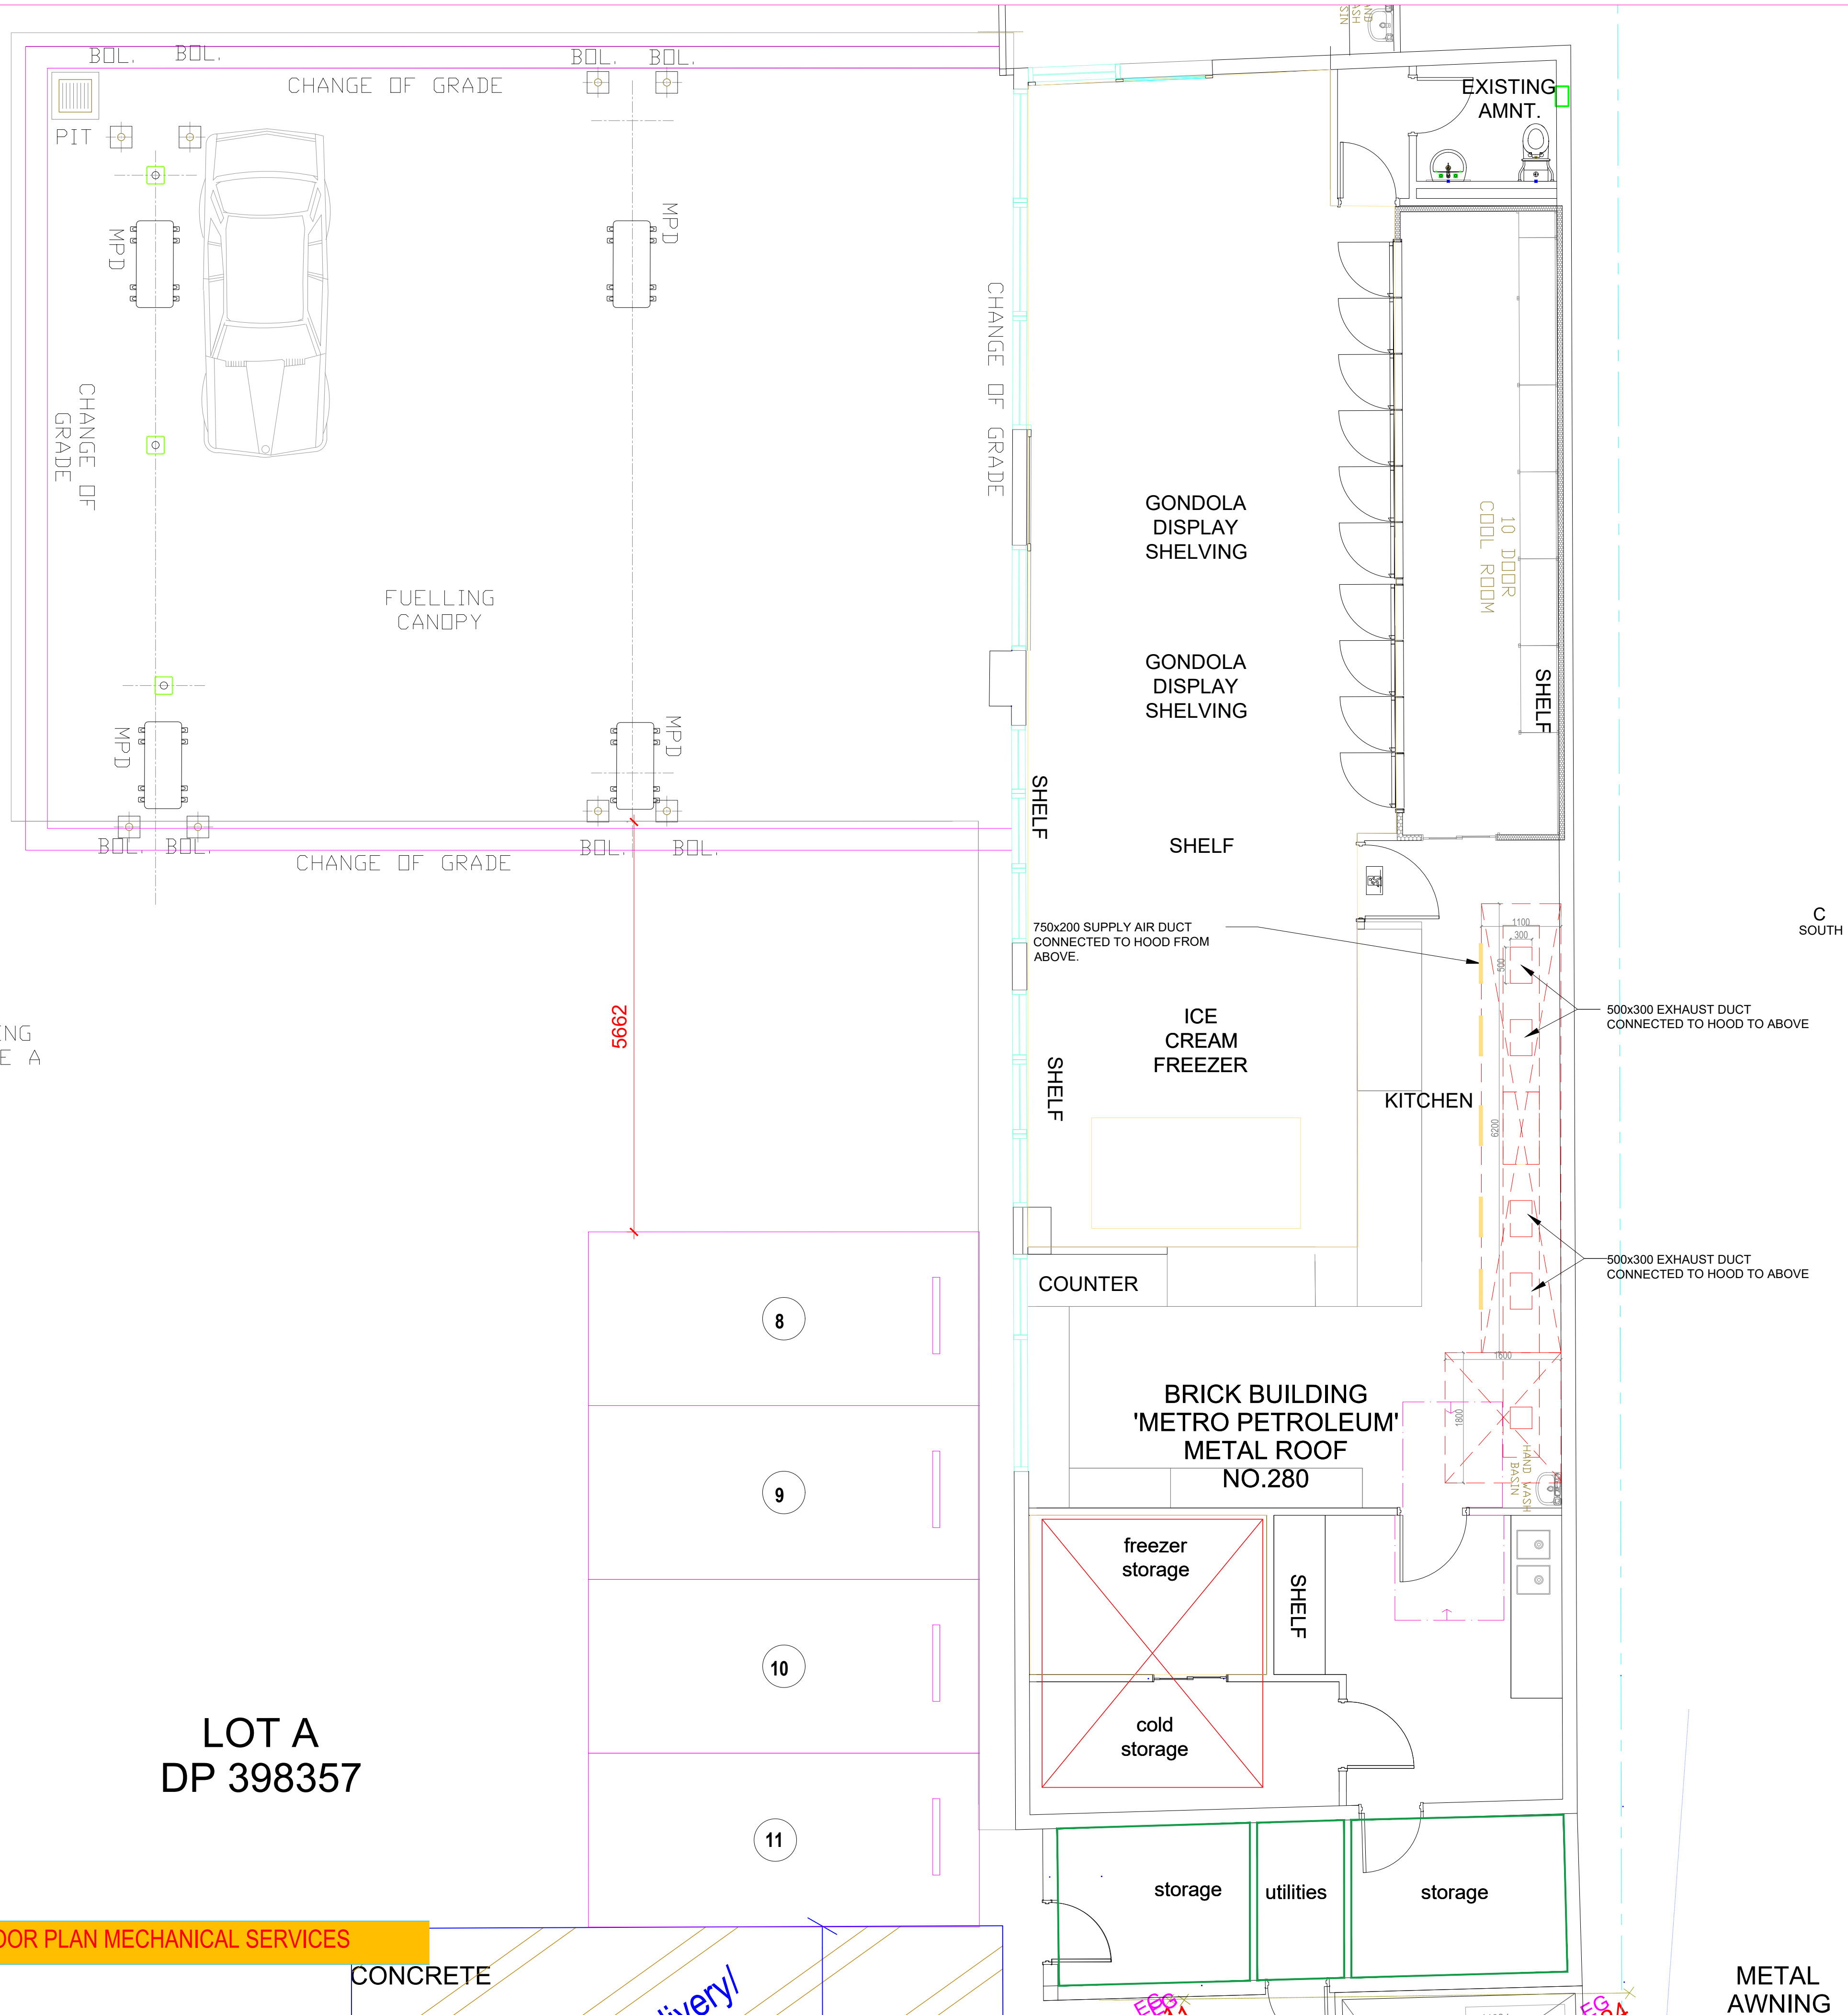

LOT B
DP 398357

METAL
AWNING

REVISIONS				
1	ISSUED FOR DA APPROVAL	M.W.	A.K.	09.06.26
No	AMENDMENT	ENG	DRAFT	DATE

COPYRIGHT ©
THIS DRAWING IS COPYRIGHT AND THE PROPERTY OF ABSOLUTE
COMMERCIAL KITCHENS. IT MUST NOT BE RETAINED, COPIED OR USED
WITHOUT THE AUTHORITY OF CUBTIC CONSULTING PTY LTD.

DISCLAIMER
THIS DRAWING AND ITS CONTENTS ARE ELECTRONICALLY GENERATED,
ARE CONFIDENTIAL AND MAY ONLY BE USED FOR THE PURPOSE FOR
WHICH THEY WERE INTENDED. ABSOLUTE COMMERCIAL KITCHENS PTY
LTD. WILL NOT ACCEPT RESPONSIBILITY FOR ANY CONSEQUENCES
ARISING FROM THE USE OF THE DRAWING FOR OTHER THAN ITS INTENDED
PURPOSE OR WHERE THE DRAWING HAS BEEN ALTERED, ADDED OR
CHANGED EITHER MANUALLY OR ELECTRONICALLY BY ANY THIRD PARTY.



BSOLUTE
COMMERCIAL
KITCHENS

4/170 ELDRIDGE RD CONDELL PARK NSW 2200
Office - 0423 834 649
Email - absolutecommercialkitchens@gmail.com

CLIENT
CLIENT ADDRESS

DESIGN

BSOLUTE COMMERCIAL KITCHENS
4/170 ELDRIDGE RD CONDELL PARK NSW 2200

PROJECT TITLE
CHANGE OF USE KITCHEN AND COOL
ROOM AREA

TO FOOD AND DRINK PREMISES AT
284 CANTERBURY RD, CANTERBURY,
NSW 2193

DRAWING TITLE

FLOOR PLAN MECHANICAL SERVICES

DESIGNER -----	DRAFTSPERSON	APPROVED BY	
SCALE @ A1 1:50	DATE	SHEET SIZE A1	REVISION
JOB No 240194	DRAWING No. A0165		1

FLOOR PLAN MECHANICAL SERVICES

SCALE 1:50

CONCRETE

1	ISSUED FOR DA APPROVAL	M.W.	A.K.	09.06.26
No	AMENDMENT	ENG	DRAFT	DATE

DISCLAIMER
THIS DRAWING AND ITS CONTENTS ARE ELECTRONICALLY GENERATED,
ARE CONFIDENTIAL, AND MAY ONLY BE USED FOR THE PURPOSE, FOR
WHICH THEY WERE INTENDED. ABSOLUTE COMMERCIAL KITCHENS PTY
LTD. WILL NOT ACCEPT RESPONSIBILITY FOR ANY CONSEQUENCES
ARISING FROM THE USE OF THE DRAWING FOR OTHER THAN ITS INTENDED
PURPOSE OR WHERE THE DRAWING HAS BEEN ALTERED, AMENDED OR
CHANGED EITHER MANUALLY OR ELECTRONICALLY BY ANY THIRD PARTY.



4/170 ELDRIDGE RD CONDELL PARK NSW 2200
Office - 0423 834 649
Email - absolutecommercialkitchens@gmail.com

CLIENT ADDRESS

4/170 ELDRIDGE RD CONDELL PARK NSW 2200

JOB No	DRAWING No.	1
240194	A0166	

EXISTING
SIGNAGE A

LOT A
DP 398357

CONCRETE

5662

8

(9)

10

11

NCV-710

MUC
560

710 x 710


600x600 INTAKE AIR
DUCT FITTED WITH
INSECT SCREEN MESH


710 x 710

EXHAUST

METAL
AWNING

LOT B
DP 398357

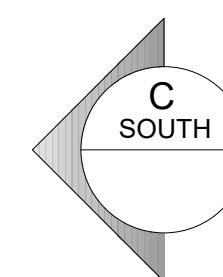

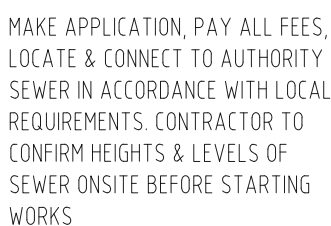

SYMBOLS


ABBREVIATIONS

PENETRATION THROUGH

	COLD WATER
	HOT WATER FLOW
	HOT WATER RETURN
	GAS SERVICE
	SEWER DRAINAGE/SANITARY PLUMBING
	VENT PIPE
	GREASE DRAIN
	FIRE HYDRANT
	SUCTION LINE
	WARM WATER
	WARM WATER RETURN
	NON POTABLE COLD WATER
	SEWER RISING MAIN
	STORMWATER RISING MAIN
	TRADE WASTE
	RAINWATER
	RISING MAIN
	STORMWATER
	ROOF DOWN PIPE
	SUBSOIL
	IRRIGATION
	EXISTING WATER MAIN
	EXISTING GAS MAIN
	EXISTING SEWER MAIN
	PIPE - DELETE
	PIPE - EXISTING
	PIPE - REDUNDANT

COPYRIGHT ©
THIS DRAWING IS COPYRIGHT AND THE PROPERTY OF ABSOLUTE
COMMERCIAL KITCHENS. IT MUST NOT BE RETAINED, COPIED OR USED
WITHOUT THE AUTHORITY OF CLUSTIC CONSULTING PTY LTD.

DISCLAIMER
THIS DRAWING AND ITS CONTENTS ARE ELECTRONICALLY GENERATED,
ARE CONFIDENTIAL AND **MAY ONLY** BE USED FOR THE PURPOSE FOR
WHICH THEY WERE INTENDED. ABSOLUTE COMMERCIAL KITCHENS PTY LTD. WILL NOT ACCEPT RESPONSIBILITY FOR ANY CONSEQUENCES
ARISING FROM THE USE OF THE DRAWING FOR OTHER THAN ITS INTENDED
PURPOSE OR WHERE THE DRAWING HAS BEEN ALTERED, MODIFIED OR
CHANGED EITHER MANUALLY OR ELECTRONICALLY BY ANY THIRD PARTY.

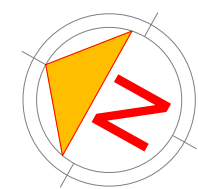

SCALE 1:50



SYMBOLS	MISCELLANEOUS
	PIPE RISER
	TEE DROPPER
	PIPE DROPPER
	PIPE BREAK
	FLOW DIRECTION
	PIPE CAP
	SINGLE RIGHT ANGLE ISOLATION VALVE
	DOUBLE RIGHT ANGLE ISOLATION VALVE
	HOT & COLD WATER POINT
	COLD WATER POINT
	HOT WATER POINT
	HOSE TAP
	THERMOSTATIC MIXING VALVE
	TEMPERING VALVE
	ISOLATION VALVE
	BALANCING VALVE
	CHECK VALVE / REFLUX VALVE
	VALVE IN PATH BOX
	UNION
	NON RETURN VALVE
	REDUCED PRESSURE ZONE DEVICE
	PRESSURE LIMITING VALVE
	GAS REGULATOR VALVE
	AIR ADMITTANCE VALVE
	HOSE TAP / STOP VALVE
	WATER METER
	GAS METER
	FIRE HYDRANT
	FIRE HOSE REEL
	BUCKET TRAP FLOOR WASTE
	OVERFLOW GULLY
	FLOOR WASTE TUNDISH
	BOUNDARY TRAP
	CLEAR OUT
	PLANTER DRAIN
	EXTERNAL GULLY
	SEWER MANHOLE
	PENETRATION THROUGH
	CAST IN CONCRETE
	CONCRETE ENCASE
	CONTINUATION SERVICES
	OVERLAND FLOW PATH
	SERVICE TYPE IDENTIFICATION
	SIZE/NUMERICAL/ ALPHABETICAL IDENTIFICATION
	FLOW DIRECTION
	LINE CONTINUATION WITH DRAWING REFERENCE
	PUMP ASSEMBLY
	FIRE HYDRANT BOOSTER VALVE
	HOT WATER UNIT
	HOT WATER UNIT WITH FLUE
LINETYPES	
	COLD WATER
	HOT WATER FLOW
	HOT WATER RETURN
	GAS SERVICE
	SEWER DRAINAGE/SANITARY PLUMBING
	VENT PIPE
	GREASE DRAIN
	FIRE HYDRANT
	SUCTION LINE
	WARM WATER
	WARM WATER RETURN
	NON POTABLE COLD WATER
	SEWER RISING MAIN
	STORMWATER RISING MAIN
	TRADE WASTE
	RAINWATER
	RISING MAIN
	STORMWATER
	ROOF DOWN PIPE
	SUBSOIL
	IRRIGATION
	EXISTING WATER MAIN
	EXISTING GAS MAIN
	EXISTING SEWER MAIN
	PIPE - DELETE
	PIPE - EXISTING
	PIPE - REDUNDANT

AAV	AIR ADMITTANCE VALVE	GR	GAS RISER	S	SEWER
ASL	ABOVE SLAB LEVEL	GST	GREASE STACK	SAC	SEWER ACCESS CHAMBER
B	BASIN / VANITY BASIN / HANDBASIN	GVF	GREASE VENT PIPE	SCV	SEWER CHAMBER VENT
BD	BALCONY DRAIN	HB	HAND BASIN	SDV	SOLENOID VALVE
BT	BOUNDARY TRAP	HDPE	HIGH DENSITY POLYETHYLENE PIPE	SFW	SEALED FLOOR WASTE
BTWF	BASKET TRAP FLOOR WASTE	HT	HOSE TAP	SHR	SHOWER
BTH	BATH	HW	HOT WATER	SK	SINK
BVP	BRANCH VENT PIPE	HWF	HOT WATER FLOW	SL	SURFACE LEVEL
CI	CAST IRON	HWU	HOT WATER UNIT	SMH	SEWER MANHOLE
CIB	CAST IN BEAM	IL	INVERT LEVEL	SP	SANITARY PLUMBING
CO	CLEAR OUT	IO	INSPECTION OPENING	S/S	STAINLESS STEEL
CSK	CLEANER'S SINK	IPMF	INDUCT PIPE MICA FLAP	ST	STACK
CU	COOKTOP	KPA	KILOPASCALS	SV	STOP VALVE
CT	COPPER PIPE	KW	KILOWATTS	ST	STUB
CV	CHECK VALVE	L	LITRES	TD	TUNDISH
CW	COLD WATER	L/L	LOW LEVEL	TG	TEMPERATURE GAUGE
ø	DIAMETER	L/S	LITRES PER SECOND	TMV	THERMOSTATIC MIXING VALVE
D	DIESEL EXHAUST	LT	LAUNDRY TUB	TV	TEMPERING VALVE
DICL	DUCTILE IRON CEMENT LINED PIPE	NG	NATURAL GAS	TW	TRADE WASTE
FD	FLOOR DRAIN	O/F	OVERFLOW	uPVC	UNPLASTICIZED POLYVINYL CHLORIDE PIPE
FFL	FINISHED FLOOR LEVEL	OFG	OVERFLOW GULLY	UR	URINAL
FH	FIRE HYDRANT	PVC	UNPLASTICIZED POLYVINYL CHLORIDE	U/S	UNDERSIDE
FHBV	FIRE HYDRANT BOOSTER VALVE	RC	REINFORCED CONCRETE PIPE	V	VENT PIPE
FHR	FIRE HOSE REEL	RM	RIISING MAIN	VC	VITRIFIED CLAY PIPE
FW	FLOOR WASTE	RO	REVERSE OSMOSIS	WC	WATER CLOSET
G	GAS	RPZD	REDUCED PRESSURE ZONE DEVICE	WM	WATER METER
GM	GAS METER	RRV	RATIO REDUCTION VALVE		
GMS	GALVANIZED MILD STEEL PIPE	RVP	RELIEF VENT PIPE		

1	ISSUED FOR DA APPROVAL	M.W.	A.K.	09.06.26
No	AMENDMENT	ENG	DRAFT	DATE

DISCLAIMER
THIS DRAWING AND ITS CONTENTS ARE ELECTRONICALLY GENERATED, ARE CONFIDENTIAL AND MAY ONLY BE USED FOR THE PURPOSE FOR WHICH THEY WERE INTENDED. ABSOLUTE COMMERCIAL KITCHENS PTY LTD. WILL NOT ACCEPT RESPONSIBILITY FOR ANY CONSEQUENCES ARISING FROM THE USE OF THE DRAWING FOR OTHER THAN ITS INTENDED PURPOSE OR WHERE THE DRAWING HAS BEEN ALTERED, AMENDED OR CHANGED EITHER MANUALLY OR ELECTRONICALLY BY ANY THIRD PARTY.



BSOLUTE
COMMERCIAL
KITCHENS

4/170 ELDRIDGE RD CONDELL PARK NSW 2200
Office - 0423 834 649
Email - absolutecommercialkitchens@gmail.com

CLIENT ADDRESS

BSOLUTE COMMERCIAL KITCHENS
4/170 ELDRIDGE RD CONDELL PARK NSW 2200

TO FOOD AND DRINK PREMISES AT
284 CANTERBURY RD, CANTERBURY,
NSW 2193

DRAWING TITLE

HYDRAULIC SERVICES PLAN
SHEET - 02

DESIGNER -----		DRAFTSPERSON		APPROVED BY	
SCALE @ A1 1:50		DATE		SHEET SIZE A1	
JOB No 240194		DRAWING No. A0168			REVISION 1