





**DIAL BEFORE
YOU DIG**
www.1100.com.au

20MPa CONCRETE
TO PIERS


SITE CLASSIFICATION
"P/M"

SEE S5/6 FOR
DRIVEWAY PROFILE

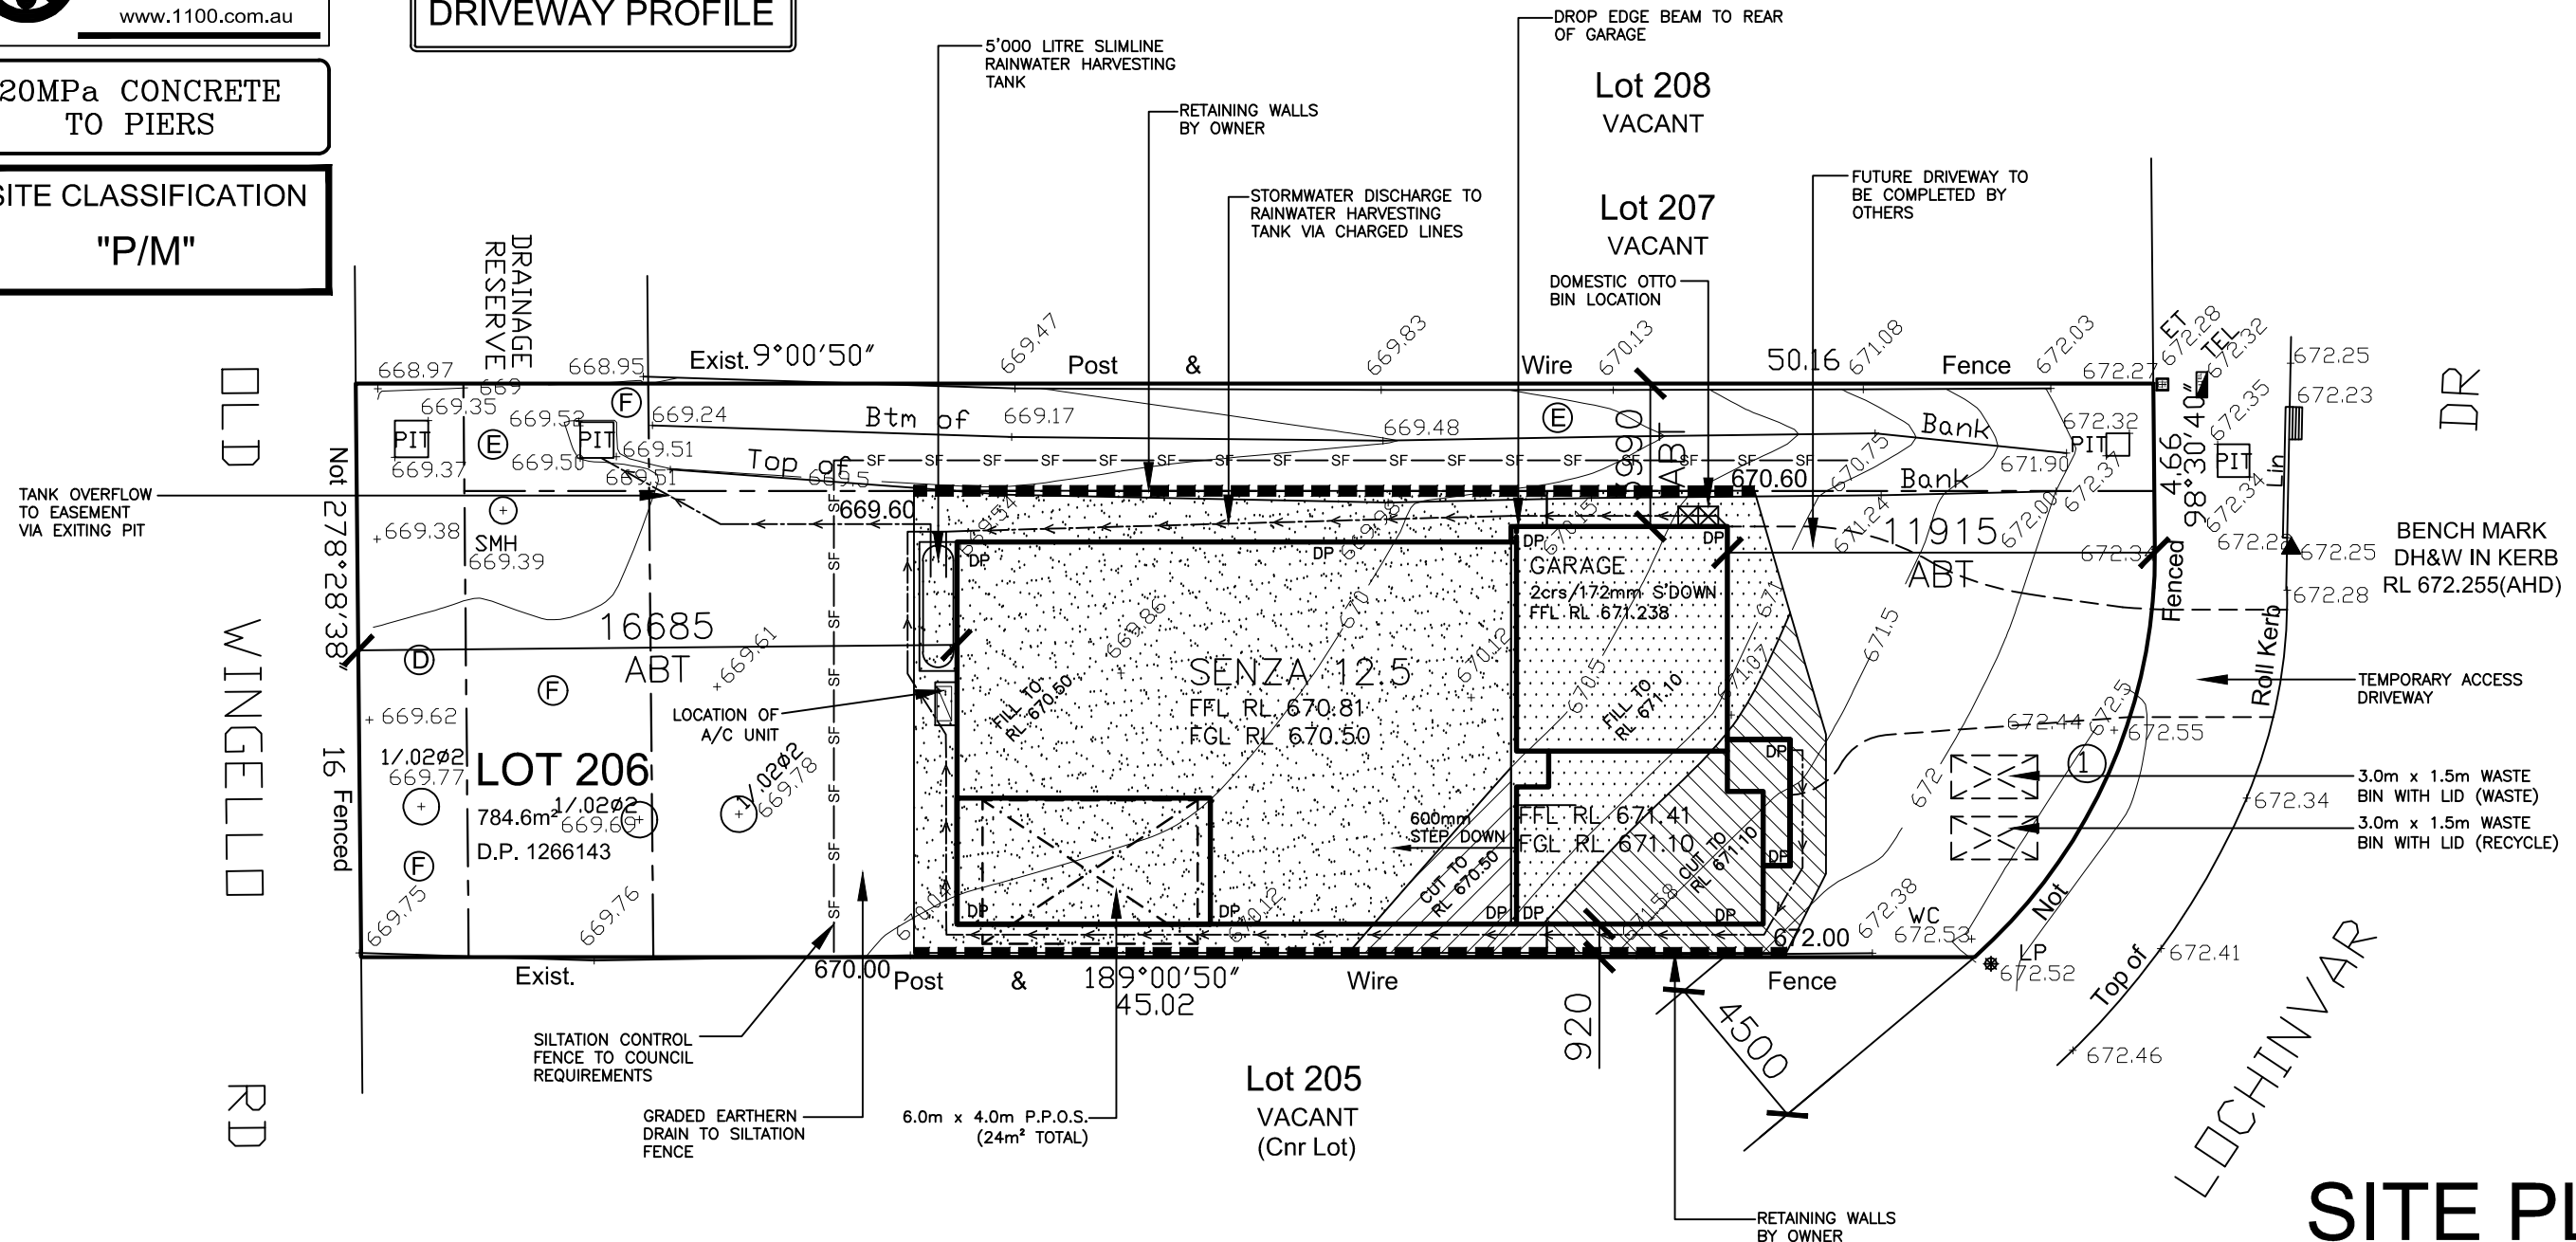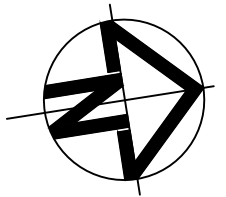

SITE PLAN

SCALE 1:200

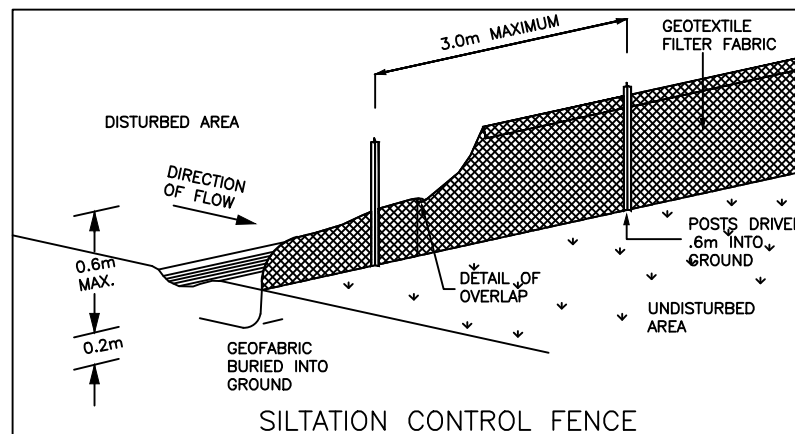

KEY

ET : Electric Turret	ET	LIN : Lintel	
LP : Light Pole	LP	KO : Kerb Outlet	+
PP : Power Pole	PP	SIP : Sewer Insp Point	o
GM : Gas Meter	GM	SMS : Sewer Maint. Shaft	o
HYD : Hydrant	HYD	SMH : Sewer Manhole	o
SV : Stop Valve	SV	TEL : Telecom Pit	■
WC : Water Connection	WC	PC : Pram Crossing	
WM : Water Meter	WM	VC : Vehicle Crossing	
SWP : Stormwater Pit	PIT	DH&W:Drillhole & Wing	▲

NOTES:

- * AS REQUIRED, ALL RETAINING & SURFACE DRAINAGE WORK TO BE COMPLETED BY OWNER TO COUNCIL SPECIFICATIONS.
- * STORMWATER DISCHARGE TO TANK VIA CHARGED LINES WITH OVERFLOW TO EASEMENT VIA EXISTING PIT
- * FIXED INDOOR AND OUTDOOR CLOTHES LINE TO BE PROVIDED, POSITIONED AND INSTALLED BY OWNER
- * NO TREES TO BE REMOVED

SCHEDULE of CURVED BOUNDARIES

No.	BEARING	CHORD	ARC	RADIUS
1	122°56'00"	12.405	12.79	15

- Ⓓ EASEMENT TO DRAIN WATER 3 WIDE
- Ⓔ EASEMENT TO DRAIN WATER 3 WIDE
- Ⓕ POSITIVE COVENANT



ALLWORTH CONSTRUCTIONS PTY LTD

9A/9-11 SOUTH STREET, RYDALMERE NSW 2116
ABN 78 002 565 353 LIC No. 34459 PH: 1300 769 988

COPYRIGHT:
THIS PLAN IS THE PROPERTY OF
THE COMPANY AND MAY NOT BE
COPIED IN WHOLE OR PART
WITHOUT THE EXPRESS WRITTEN
PERMISSION ON THE COMPANY

PROPOSED BRICK VENEER RESIDENCE

FOR: MR F. HICKLING & MISS S. ATTREED
AT: LOT 206 (No.3) LOCHINVAR DR, BUNDANOON
COUNCIL: WINGECARRIBEE

S1/6

DRAWN: DJ/MK
JOB No.: 14284
SCALE: 1:200

HOUSE DESIGN

SENZA 12.5
PRICELEADER

4 BED MEDIA ACTIVITIES ALFRESCO
PROMO COTTAGE LH

Issue	By	Date	Notes
A	MK	09.04.21	FIRST ISSUE
B	DO	28.04.21	COUNCIL ISSUE

ISSUE

B