
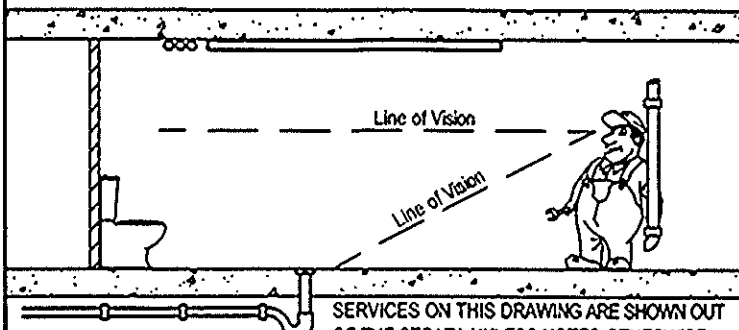


NOTE:
THIS DRAWING IS DIAGRAMMATIC ONLY AND HAS BEEN PREPARED FOR THE PURPOSE OF INDICATING THE DESIGN INTENT AND SCOPE OF WORKS OF THE HYDRAULIC AND FIRE PROTECTION SERVICES INSTALLATION AND SHOULD NOT BE INTERPRETED AS BEING DEFINITIVE.
IT IS THE RESPONSIBILITY OF THE BUILDING AND/OR PLANNING SUBCONTRACTOR TO INVESTIGATE AND COORDINATE BEFORE AND DURING THE CONSTRUCTION PHASE ALL EXISTING SERVICES AND STRUCTURE WHICH WILL AFFECT THE INSTALLATION OF THESE SERVICES. THIS DRAWING IS TO BE READ IN CONJUNCTION WITH THE HYDRAULIC AND FIRE SERVICES SPECIFICATION. ALL WORKS TO BE CARRIED OUT IN ACCORDANCE WITH THE RELEVANT CODES AND STANDARDS.
POSITION AND LEVELS OF EXISTING MAINS AND/OR EXISTING SERVICES ARE INDICATIVE ONLY AND ARE TO BE CHECKED PRIOR TO COMMENCING ANY WORK. DO NOT SCALE FROM THIS DRAWING. REFER TO ARCHITECTURAL DRAWINGS FOR DIMENSION SETOUT. THIS DRAWING IS TO BE READ IN CONJUNCTION WITH RELEVANT ARCHITECTURAL, ELECTRICAL AND MECHANICAL DRAWINGS.
ALL RIGHTS RESERVED. THIS WORK IS COPYRIGHT AND CANNOT BE REPRODUCED OR COPIED IN ANY FORM OR BY ANY MEANS WITHOUT THE WRITTEN PERMISSION OF WHIPPS-WOOD CONSULTING PTY LTD. ANY LICENSE, EXPRESSED OR IMPLIED, TO USE THIS DOCUMENT FOR ANY PURPOSE WHATSOEVER IS RESTRICTED TO THE TERMS OF AGREEMENT BETWEEN WHIPPS-WOOD CONSULTING PTY LTD AND THE INSTRUCTING PARTY.

THIS DRAWING HAS BEEN PREPARED IN CONJUNCTION WITH THE FOLLOWING DRAWINGS:				
Discipline	Dwg. No.	Date	Revisions	
ARCHITECTURAL	DA10	09.08.10	P01	P01
STRUCTURAL				
MECHANICAL				
ELECTRICAL				
CIVIL				
LANDSCAPE				
OTHER				

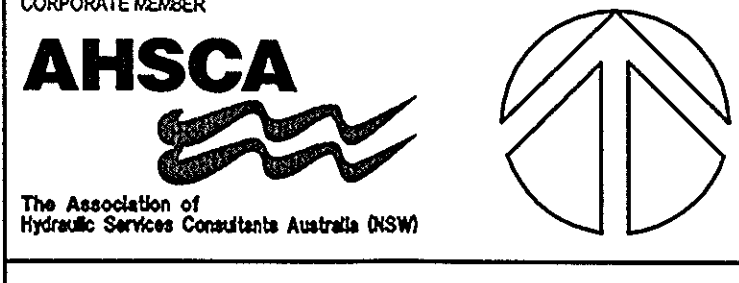

No.	Date	Details
P4	09.09.10	DEVELOPMENT APPLICATION
P3	30.08.10	PRELIMINARY ISSUE
P2	14.07.10	PRELIMINARY ISSUE
P1	14.05.10	PRELIMINARY ISSUE

No.	Date	Details
P4	09.09.10	DEVELOPMENT APPLICATION
P3	30.08.10	PRELIMINARY ISSUE
P2	14.07.10	PRELIMINARY ISSUE
P1	14.05.10	PRELIMINARY ISSUE

Architect	
Client	

HORNSBY BAPTIST CHURCH
2 College Crescent, Hornsby

whipps-wood CONSULTING
Engineers in Hydraulic, Civil & Fire Protection Design
Lower Ground, 48 Alfred Street
Miltons Point NSW 2061
PO Box 558, Miltons Point
NSW 1565
T +61 02 8923 8444
F +61 02 8923 8484
sydney@www.net.au
www.wvc.net.au


Project
**HORNSBY BAPTIST CHURCH
PROPOSED NEW CHURCH &
RESIDENTIAL DEVELOPMENT**

Drawing
**HYDRAULIC SERVICES
EXISTING SITE PLAN & LEGEND**

Status
PRELIMINARY ISSUE: NOT FOR CONSTRUCTION

Project No.	Drawing No.
2009-0268	HDA01/ P4
Drawn: WP	Date: 18.01.10
Design: NS	Scale: 1:200
Verified: -	No in set: 4



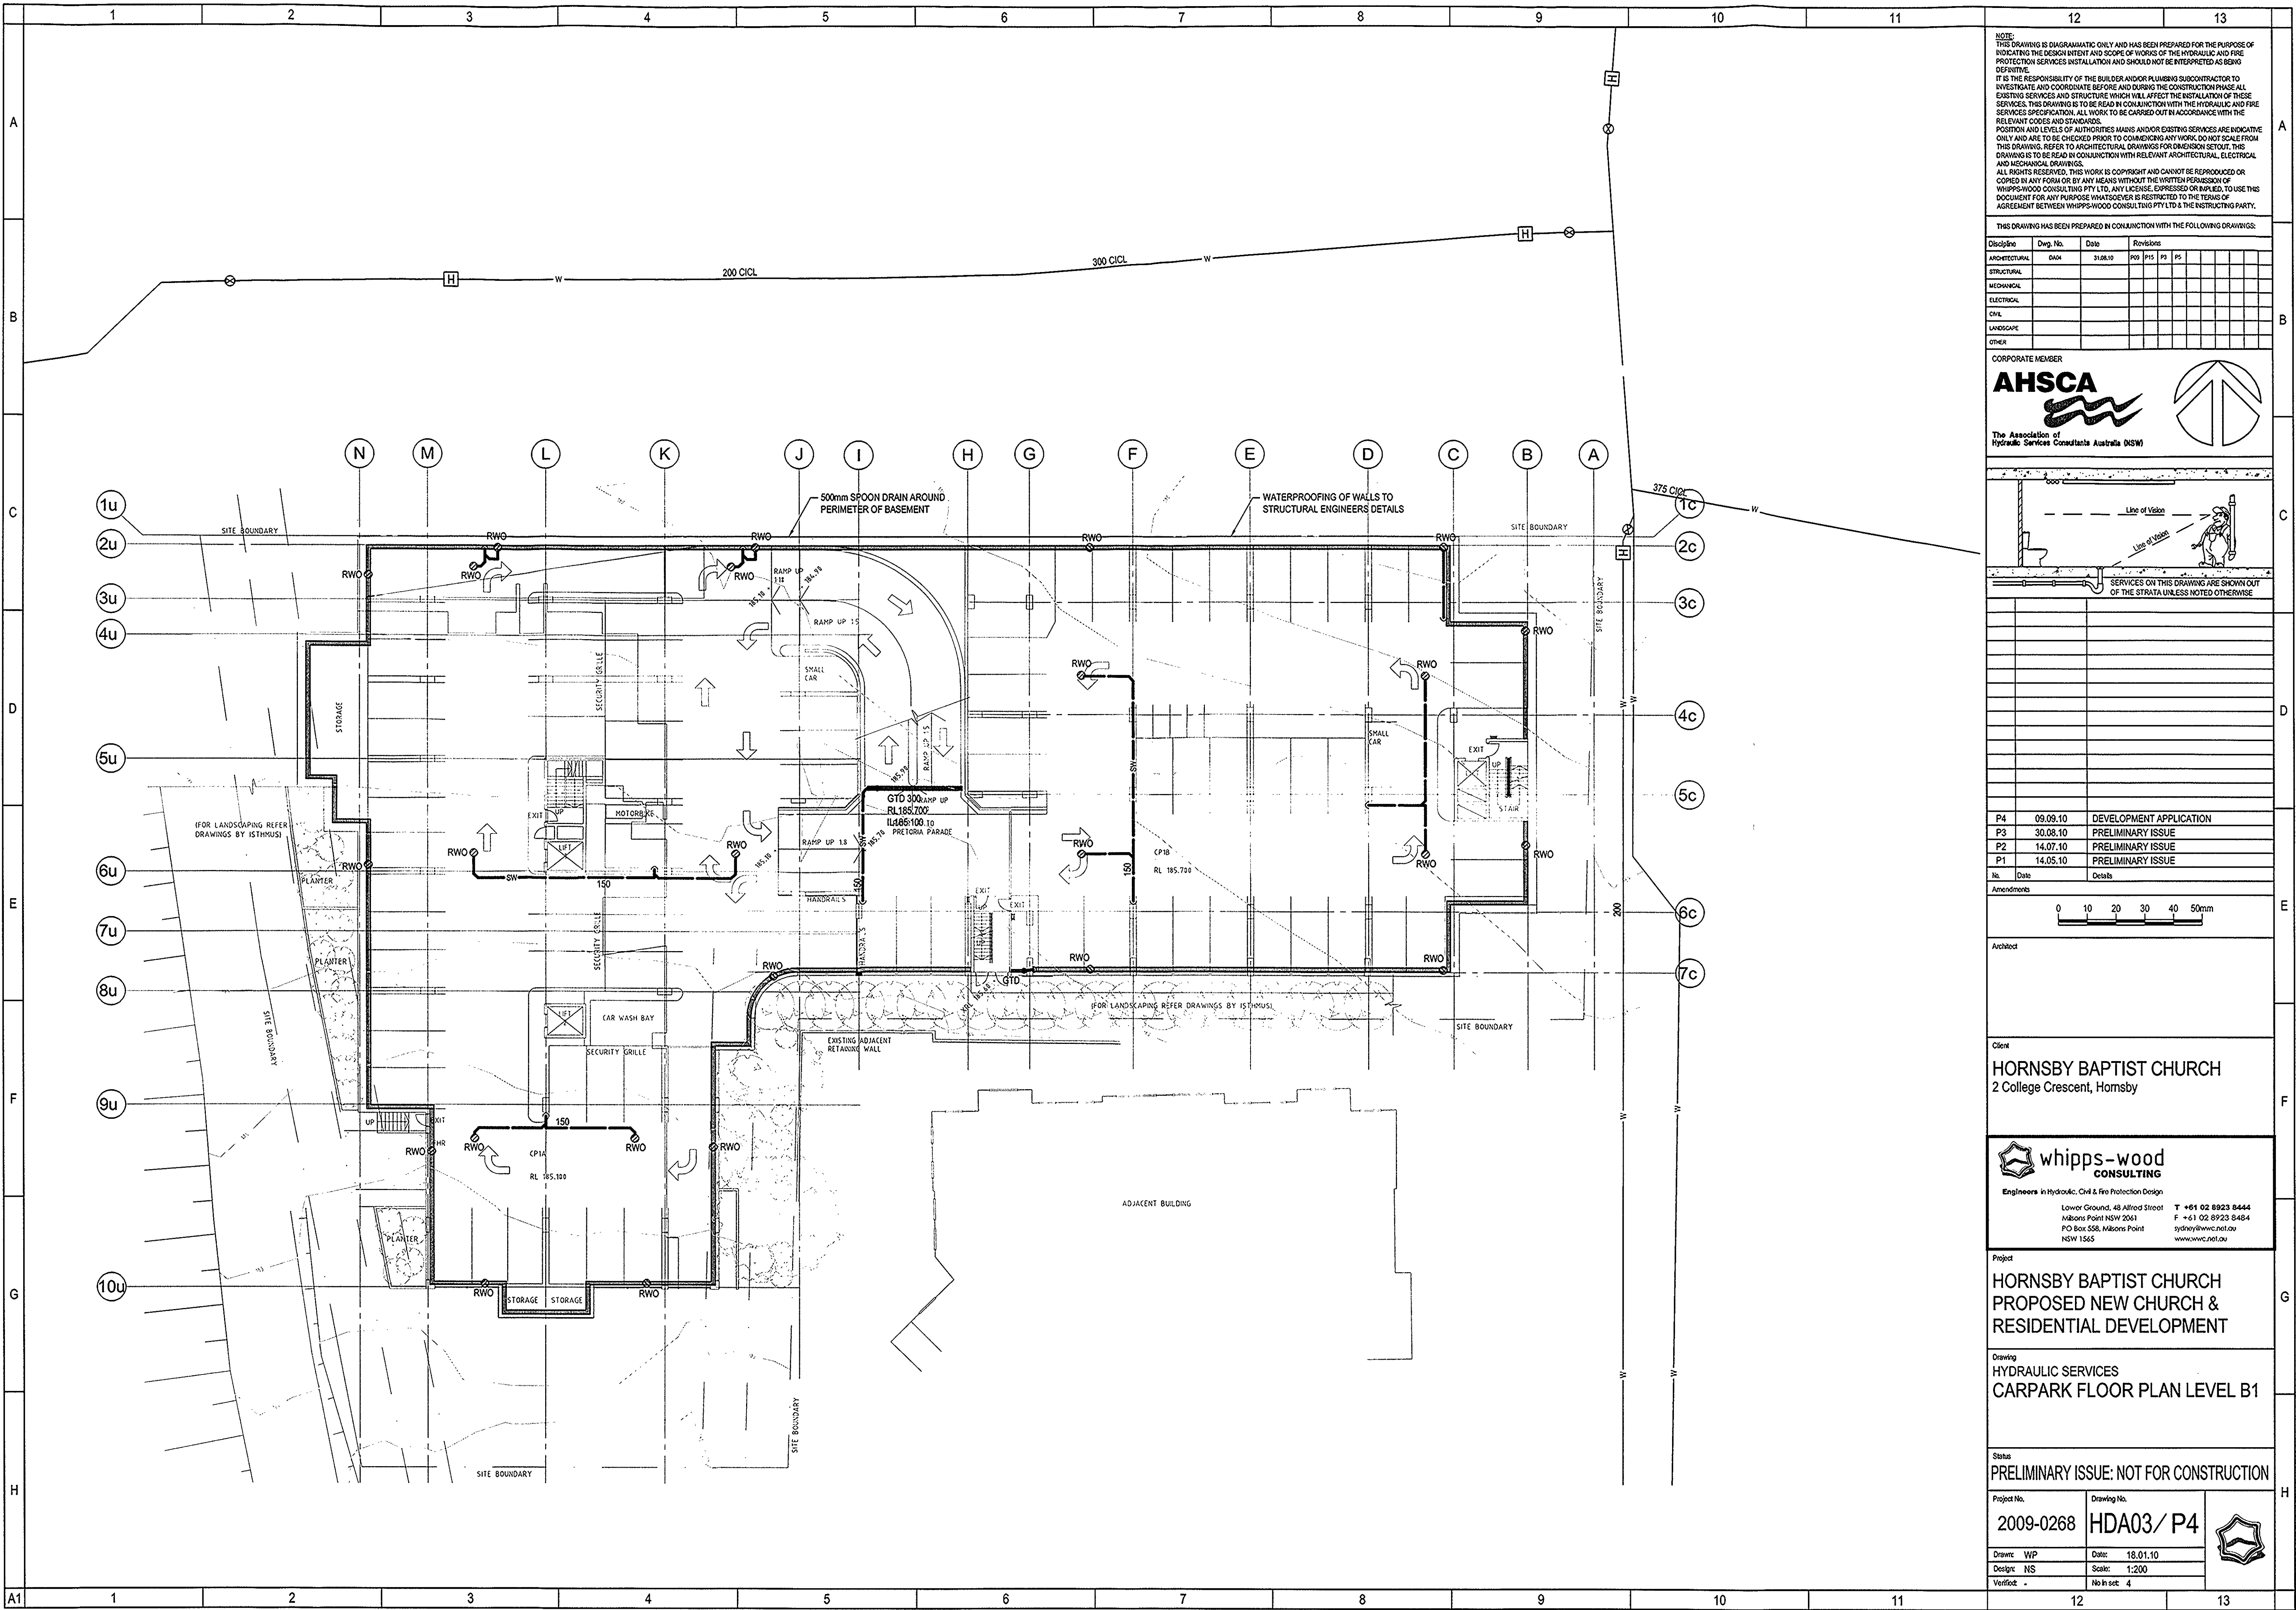


NOTE:
THIS DRAWING IS DIAGNOSTIC ONLY AND HAS BEEN PREPARED FOR THE PURPOSE OF INDICATING THE DESIGN INTENT AND SCOPE OF WORKS OF THE HYDRAULIC AND FIRE PROTECTION SERVICES INSTALLATION AND SHOULD NOT BE INTERPRETED AS BEING DEFINITIVE.
IT IS THE RESPONSIBILITY OF THE BUILDER AND/OR PLUMBING SUBCONTRACTOR TO INVESTIGATE AND COORDINATE BEFORE AND DURING THE CONSTRUCTION PHASE ALL EXISTING SERVICES AND STRUCTURE WHICH MAY AFFECT THE INSTALLATION OF THESE SERVICES. THIS DRAWING IS TO BE READ IN CONJUNCTION WITH THE HYDRAULIC AND FIRE SERVICES SPECIFICATION. ALL WORK TO BE CARRIED OUT IN ACCORDANCE WITH THE RELEVANT CODES AND STANDARDS.
POSITION AND LEVELS OF AUTHORITIES MAINS AND/OR EXISTING SERVICES ARE INDICATIVE ONLY AND ARE TO BE CHECKED PRIOR TO COMMENCING ANY WORK. DO NOT SCALE FROM THIS DRAWING. REFER TO ARCHITECTURAL DRAWINGS FOR DIMENSION SETOUT. THIS DRAWING IS TO BE READ IN CONJUNCTION WITH RELEVANT ARCHITECTURAL, ELECTRICAL AND MECHANICAL DRAWINGS.
ALL RIGHTS RESERVED. THIS WORK IS COPYRIGHT AND CANNOT BE REPRODUCED OR COPIED IN ANY FORM OR BY ANY MEANS WITHOUT THE WRITTEN PERMISSION OF WHIPPS-WOOD CONSULTING PTY LTD. ANY LICENSE, EXPRESSED OR IMPLIED, TO USE THIS DOCUMENT FOR ANY PURPOSE WHATSOEVER IS RESTRICTED TO THE TERMS OF AGREEMENT BETWEEN WHIPPS-WOOD CONSULTING PTY LTD & THE INSTRUCTING PARTY.


THIS DRAWING HAS BEEN PREPARED IN CONJUNCTION WITH THE FOLLOWING DRAWINGS:

Discipline	Dwg. No.	Date	Revises
ARCHITECTURAL	DAH	30.08.10	P3 P15 P3 P5
STRUCTURAL			
MECHANICAL			
ELECTRICAL			
CIVIL			
LANDSCAPE			
OTHER			

CORPORATE MEMBER

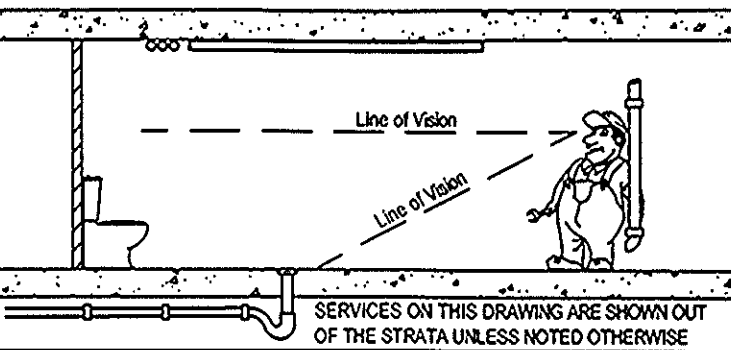

P4	09.09.10	DEVELOPMENT APPLICATION
P3	30.08.10	PRELIMINARY ISSUE
P2	14.07.10	PRELIMINARY ISSUE
P1	14.05.10	PRELIMINARY ISSUE
No.	Date	Details

 

Architect

Client
HORNSBY BAPTIST CHURCH
2 College Crescent, Hornsby



Project
HORNSBY BAPTIST CHURCH
PROPOSED NEW CHURCH & RESIDENTIAL DEVELOPMENT

Drawing
HYDRAULIC SERVICES
CARPARK FLOOR PLAN LEVEL B1

Status
PRELIMINARY ISSUE: NOT FOR CONSTRUCTION

Project No.	Drawing No.
2009-0268	HDA03/P4
Drawn: WP	Date: 18.01.10
Design: NS	Scale: 1:200
Verified: -	No in set: 4



