

[illegible]

notes

- REFER TO SURVEY PLANS PREPARED BY CBD SURVEYING SERVICES FOR EXISTING SITE INFORMATION;
- REFER TO CIVIL DOCUMENTATION PREPARED BY TAYLOR THOMSON WHITTING FOR STORMWATER AND CIVIL WORKS DESIGN;
- REFER TO LANDSCAPE DRAWINGS PREPARED BY DEM (AUST) FOR LANDSCAPE DESIGN & EXTERNAL DETAILS;
- REFER TO APPENDIXES IN THE STATEMENT OF ENVIRONMENTAL EFFECTS FOR OTHER RELEVANT REPORTS & INFORMATION, INCLUDING ACOUSTIC REQUIREMENTS, BCA REPORT, GEOTECHNICAL INFORMATION, FLORA & FAUNA REPORT, WASTE MANAGEMENT REPORT, TRAFFIC REPORT ETC.

W	
W	WEDDING
WS	WATER-SHED
WC	WATER CLOSET (TOILET) CLOUSE
WD	WASTE DISPOSAL UNIT
WE	WATER(SOFT) PRESS
WL	WATER LEVEL
WM	WASHING MACHINE
WMR	WATER METER
WP	WASTE PIPE
WPM	WATERPROOF MEMBRANE
WP	WAPORBIE
WS	WORKSTATION (FFM)
y	
YG	YARD GULLY

amendments				verified	
no.	date	amendment	by	chk'd	chk'd
-01	05/09/11	INITIAL ISSUE	DE	DE	
-02	21/09/11	CLIENT REVIEW FOR DA ISSUE	DE	DE	Rv
A01	22/09/11	04 ISSUE	DE	DE	Rv

_____ north point



dem

planning, urban design, architecture,
landscape architecture, interior design
level 8 15 help street chatswood nsw 2067
p: po box 5036 west chatswood nsw 1515
t: (02) 8966 6000 f: (02) 8966 6111
e: svdnev@dem.com.au

**FOOD MANUFACTURING
PREMISES
PICKTON ROAD
MALDON**


ALLIED MILLS
LEVEL 4
BUILDING G
1 HOMEBUSH BAY DRIVE
RHODES NSW 2138

drawing title
COVER SHEET

da issue

original	scale	dropen	project no.
b1	NA	de	4177-00

drawing no. **arcv0001** rev no. **A01**

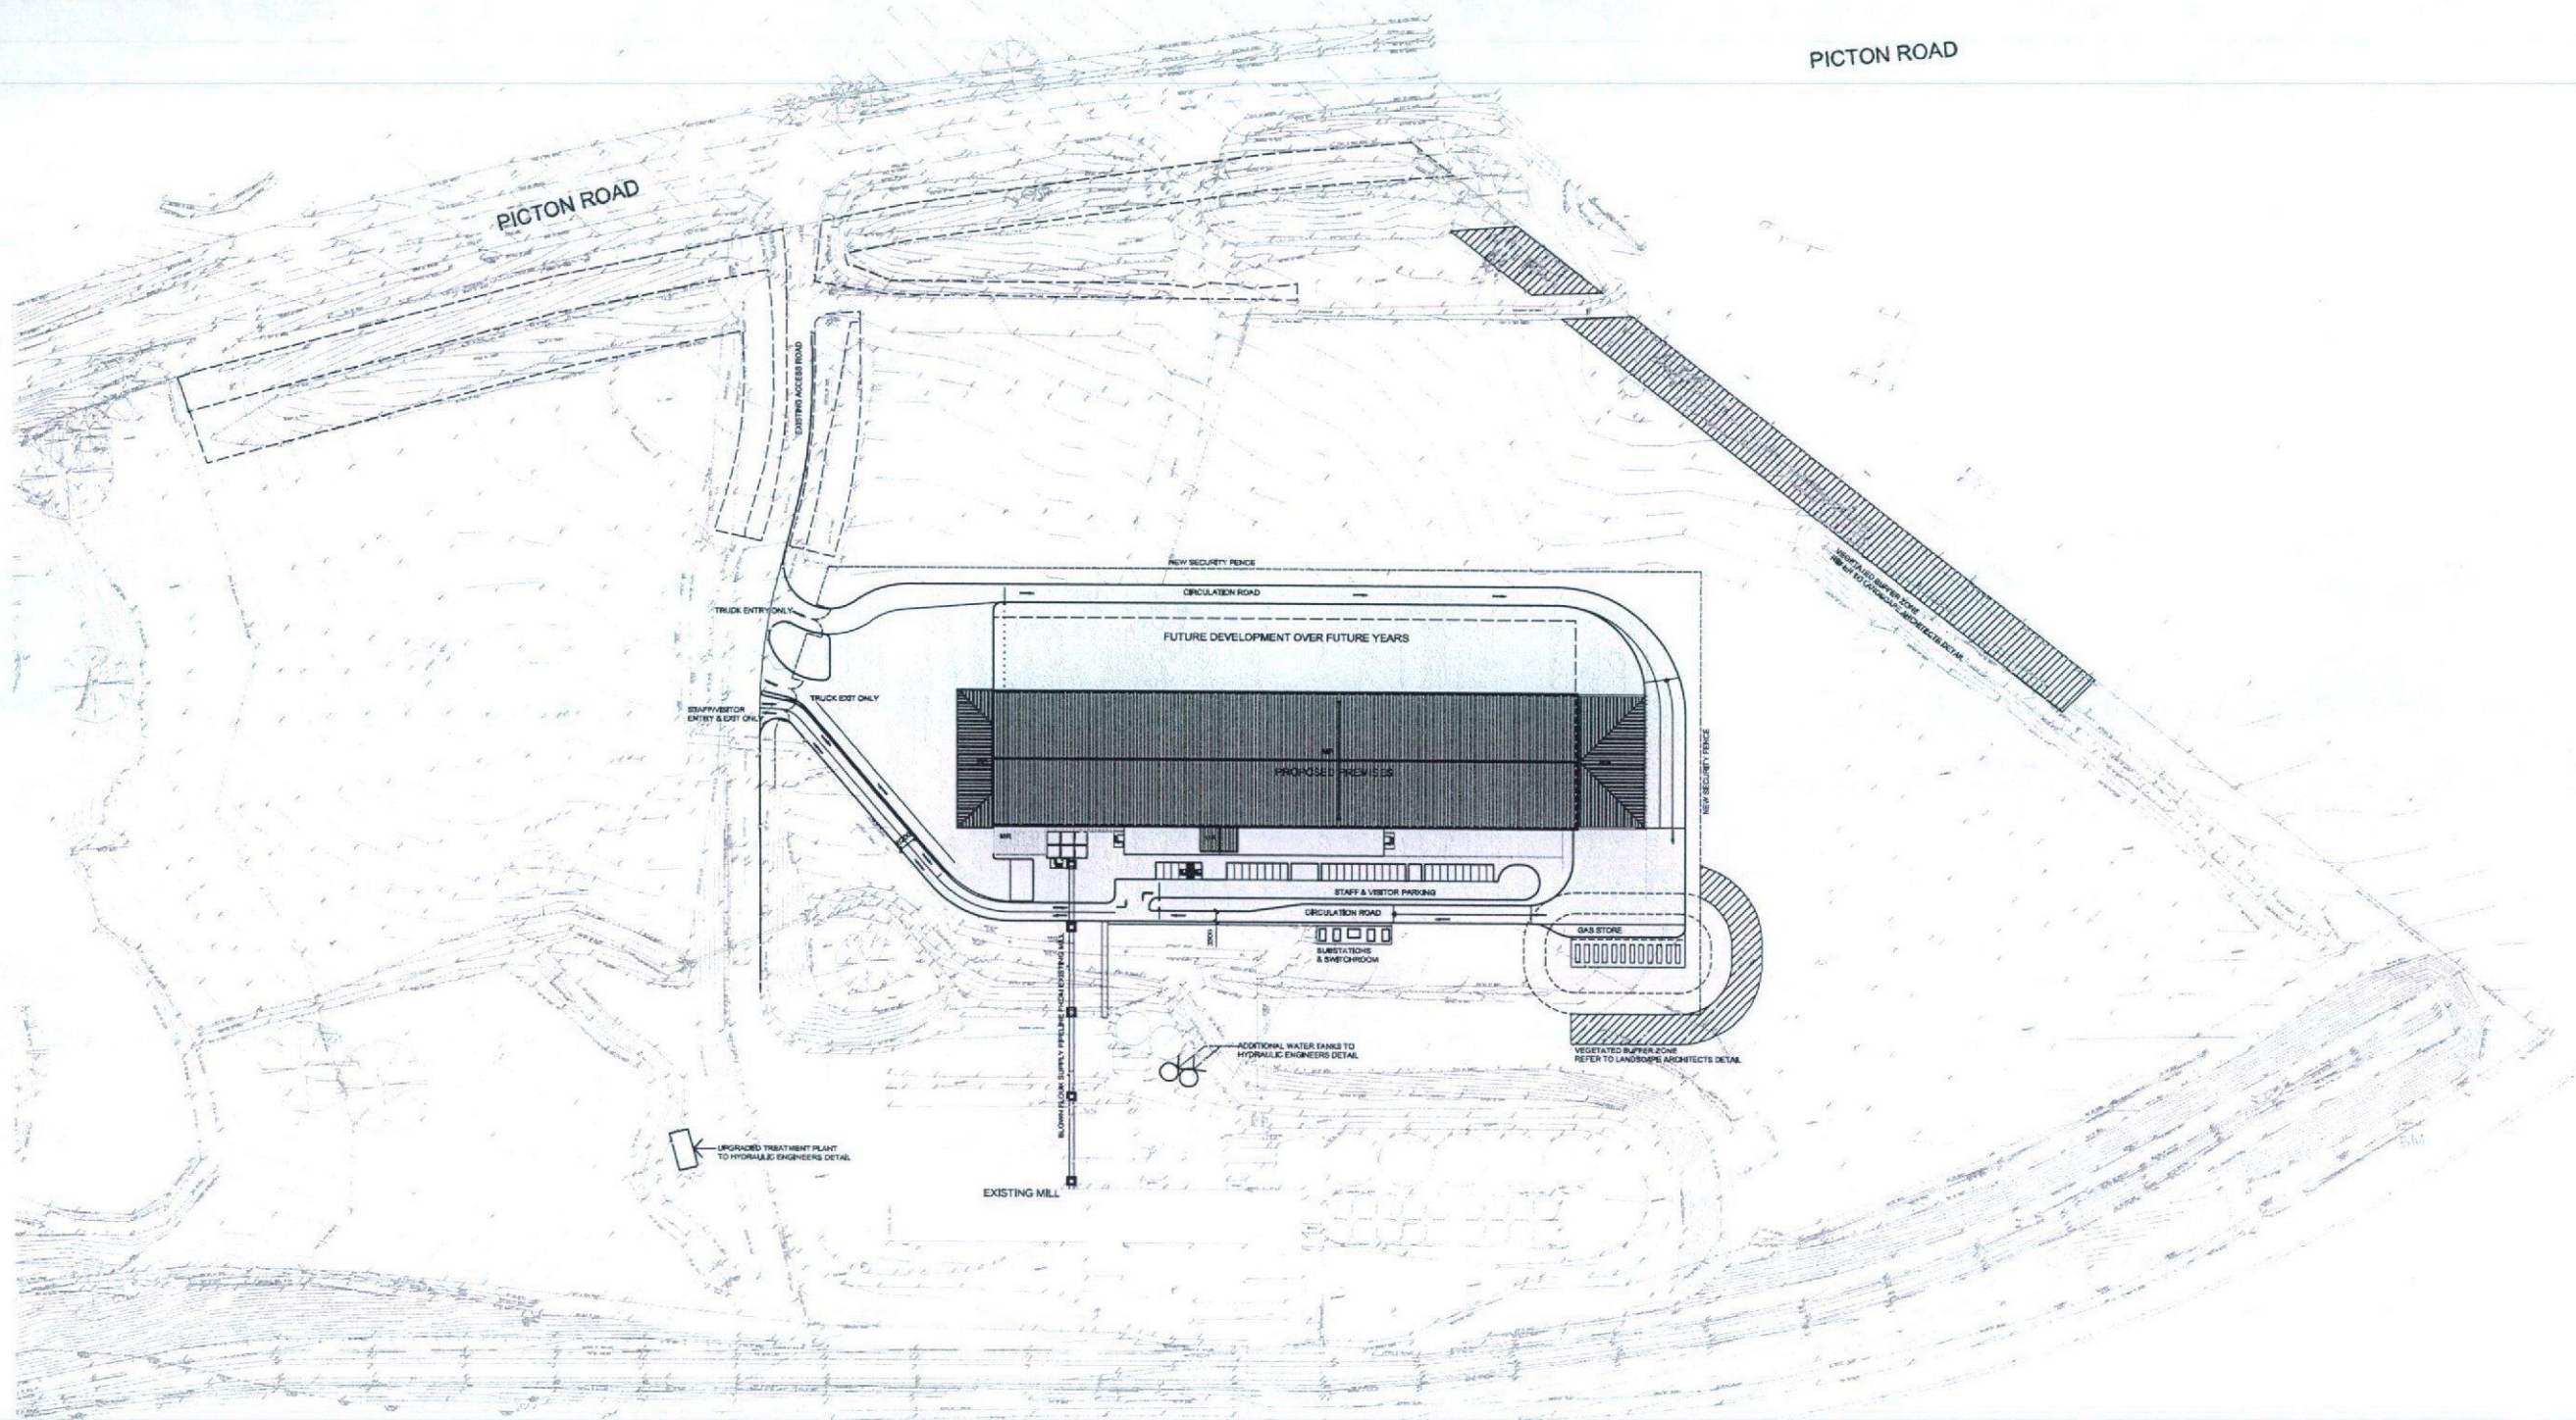

NOTE:

- REFER TO SURVEY DRAWING FOR FULL SURVEY DETAIL. SURVEY INFORMATION SHOWN ON THIS DRAWING IS INDICATIVE ONLY.
- REFER TO LANDSCAPE DRAWINGS FOR FULL LANDSCAPE DETAIL. LANDSCAPE INFORMATION SHOWN ON THIS DRAWING IS INDICATIVE ONLY.
- REFER TO CIVIL DRAWINGS FOR FULL CIVIL DETAIL. CIVIL INFORMATION SHOWN ON THIS DRAWING IS INDICATIVE ONLY.

LEGEND

PROPOSED NEW WORKS
ASSOCIATED WORKS TO ENHANCE THE COMPLETION
OF THE PROPOSED WORKS MAY EXTEND BEYOND
THE EXTENT SHOWN

0 10 20 30 40 50 60 70 80 90 100

© copyright of dem (austr) Pty Limited 2011. All rights reserved. Any unauthorised use or distribution of information contained on this document without dem (austr) Pty Limited prior consent is prohibited.

Any reports, drawings, advice or information included or referenced that is prepared and/or provided by any other party, including the client, is the sole responsibility of the party who prepared the report, drawing, advice or information and does not constitute a representation by dem (austr) Pty Limited. dem (austr) Pty Limited accepts no responsibility for any documents, advice or other material prepared by any other party.

Figured dimensions to be taken in preference to scaled dimensions. Verify all dimensions on the job before proceeding with design or construction work. Dimensions shown are computer generated and the contractor is to apply standard building tolerances.

Notified suitable for the use stipulated by the relevant code of practice only if indicated and checked by an authorised dem (austr) Pty Limited representative.

amendment			revised		
no.	date	description	by	chkd	chkd
1	20/11/11	1st ISSUE	DE	DE	DE
2	20/11/11	CLIENT REVIEW FOR DABBLE	DE	DE	DE
3	20/11/11	DABBLE	DE	DE	DE



dem

planning, urban design, architecture,
landscape architecture, interior design
level 6 15 help street chelmsford nsw 2067
p: po box 5036 west chelmsford nsw 1515
t: (02) 8966 6000 f: (02) 8966 6111
e: sydney@dem.com.au

FOOD MANUFACTURING PREMISES PICTON ROAD MALDON

ALLIED MILLS
LEVEL 4
BUILDING G
1 HOMEBUSH BAY DRIVE
RHODES NSW 2138

consultant

SITE & ROOF PLAN

da issue

original	scale	drawn	project no.
b1	1:1000	de	4177-00
drawing no.			rev no.

ar-0201

A01

DISTRIBUTION		DATE		REFERENCE		PAGE		TOTAL	
NO.	DATE	REFERENCE	DATE	PAGE	TOTAL	NO.	DATE	PAGE	TOTAL
ADP	SEP 1971	ADP THE ISSUE DA BRUL		26	26				
				28	28				

 


planning, urban design, architecture,
landscape architecture, interior design
level 8 15 help street chiswood nsw 2057
a: po box 5036 west chiswood nsw 1515
t: (02) 8966 6000 f: (02) 8966 6111
e: sydney@dem.com.au

ALLIED MILLS
LEVEL 4
BUILDING G
1 HOMEBUSH BAY DRIVE
RHODES NSW 2138

ar-0301 A01


plotted by: dmad



© copyright of dem (austr) Pty Limited and its subsidiaries. All rights reserved. No part of this document may be reproduced, stored in a retrieval system, or transmitted, in any form or by any means, electronic, mechanical, photocopying, recording, or by any information storage or retrieval system, without prior written permission from dem (austr) Pty Limited. This document is the property of dem (austr) Pty Limited and is loaned to you for your use only. It is not to be distributed, copied, or otherwise used for any purpose other than that for which it was loaned to you. If you are not an authorized user, you are notified that you are in breach of the copyright laws of Australia and may be liable to prosecution. The information contained herein is for general information only and does not constitute a representation by dem (austr) Pty Limited. The information is provided as a guide only and is not to be relied upon for any specific purpose. The information is provided as a guide only and is not to be relied upon for any specific purpose. The information is provided as a guide only and is not to be relied upon for any specific purpose.

amendment	no.	date	description	by	checked	approved
1	15/01/11	15/01/11	INITIAL ISSUE	DE	DE	DE
2	16/01/11	16/01/11	CLIENT REVIEW/CR/ISSUE	DE	DE	DE
3	17/01/11	17/01/11	COORDINATION ISSUE	DE	DE	DE
4	17/01/11	17/01/11	ISSUE	DE	DE	DE

amendment	no.	date	description	by	checked	approved
1	15/01/11	15/01/11	INITIAL ISSUE	DE	DE	DE
2	16/01/11	16/01/11	CLIENT REVIEW/CR/ISSUE	DE	DE	DE
3	17/01/11	17/01/11	COORDINATION ISSUE	DE	DE	DE
4	17/01/11	17/01/11	ISSUE	DE	DE	DE

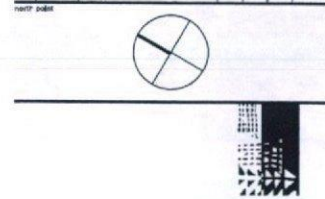

dem

planning, urban design, architecture,
landscape architecture, interior design
level 6 15 help street chelmsford nsw 2067
p: pc box 5036 west chelmsford nsw 1515
t: (02) 8966 6000 f: (02) 8966 6111
e: sydney@dem.com.au

FOOD MANUFACTURING PREMISES PICKTON ROAD MALDON


ALLIED MILLS
LEVEL 4
BUILDING G
1 HOMEBUSH BAY DRIVE
RHODES NSW 2138

drawing title
GROUND FLOOR PLAN
STAGE 1, 2 & 3

for coordination


original	scale	drawn	project no.
b1	1:500	de	4177-00
drawing no.		rev no.	

ar-1201 A01

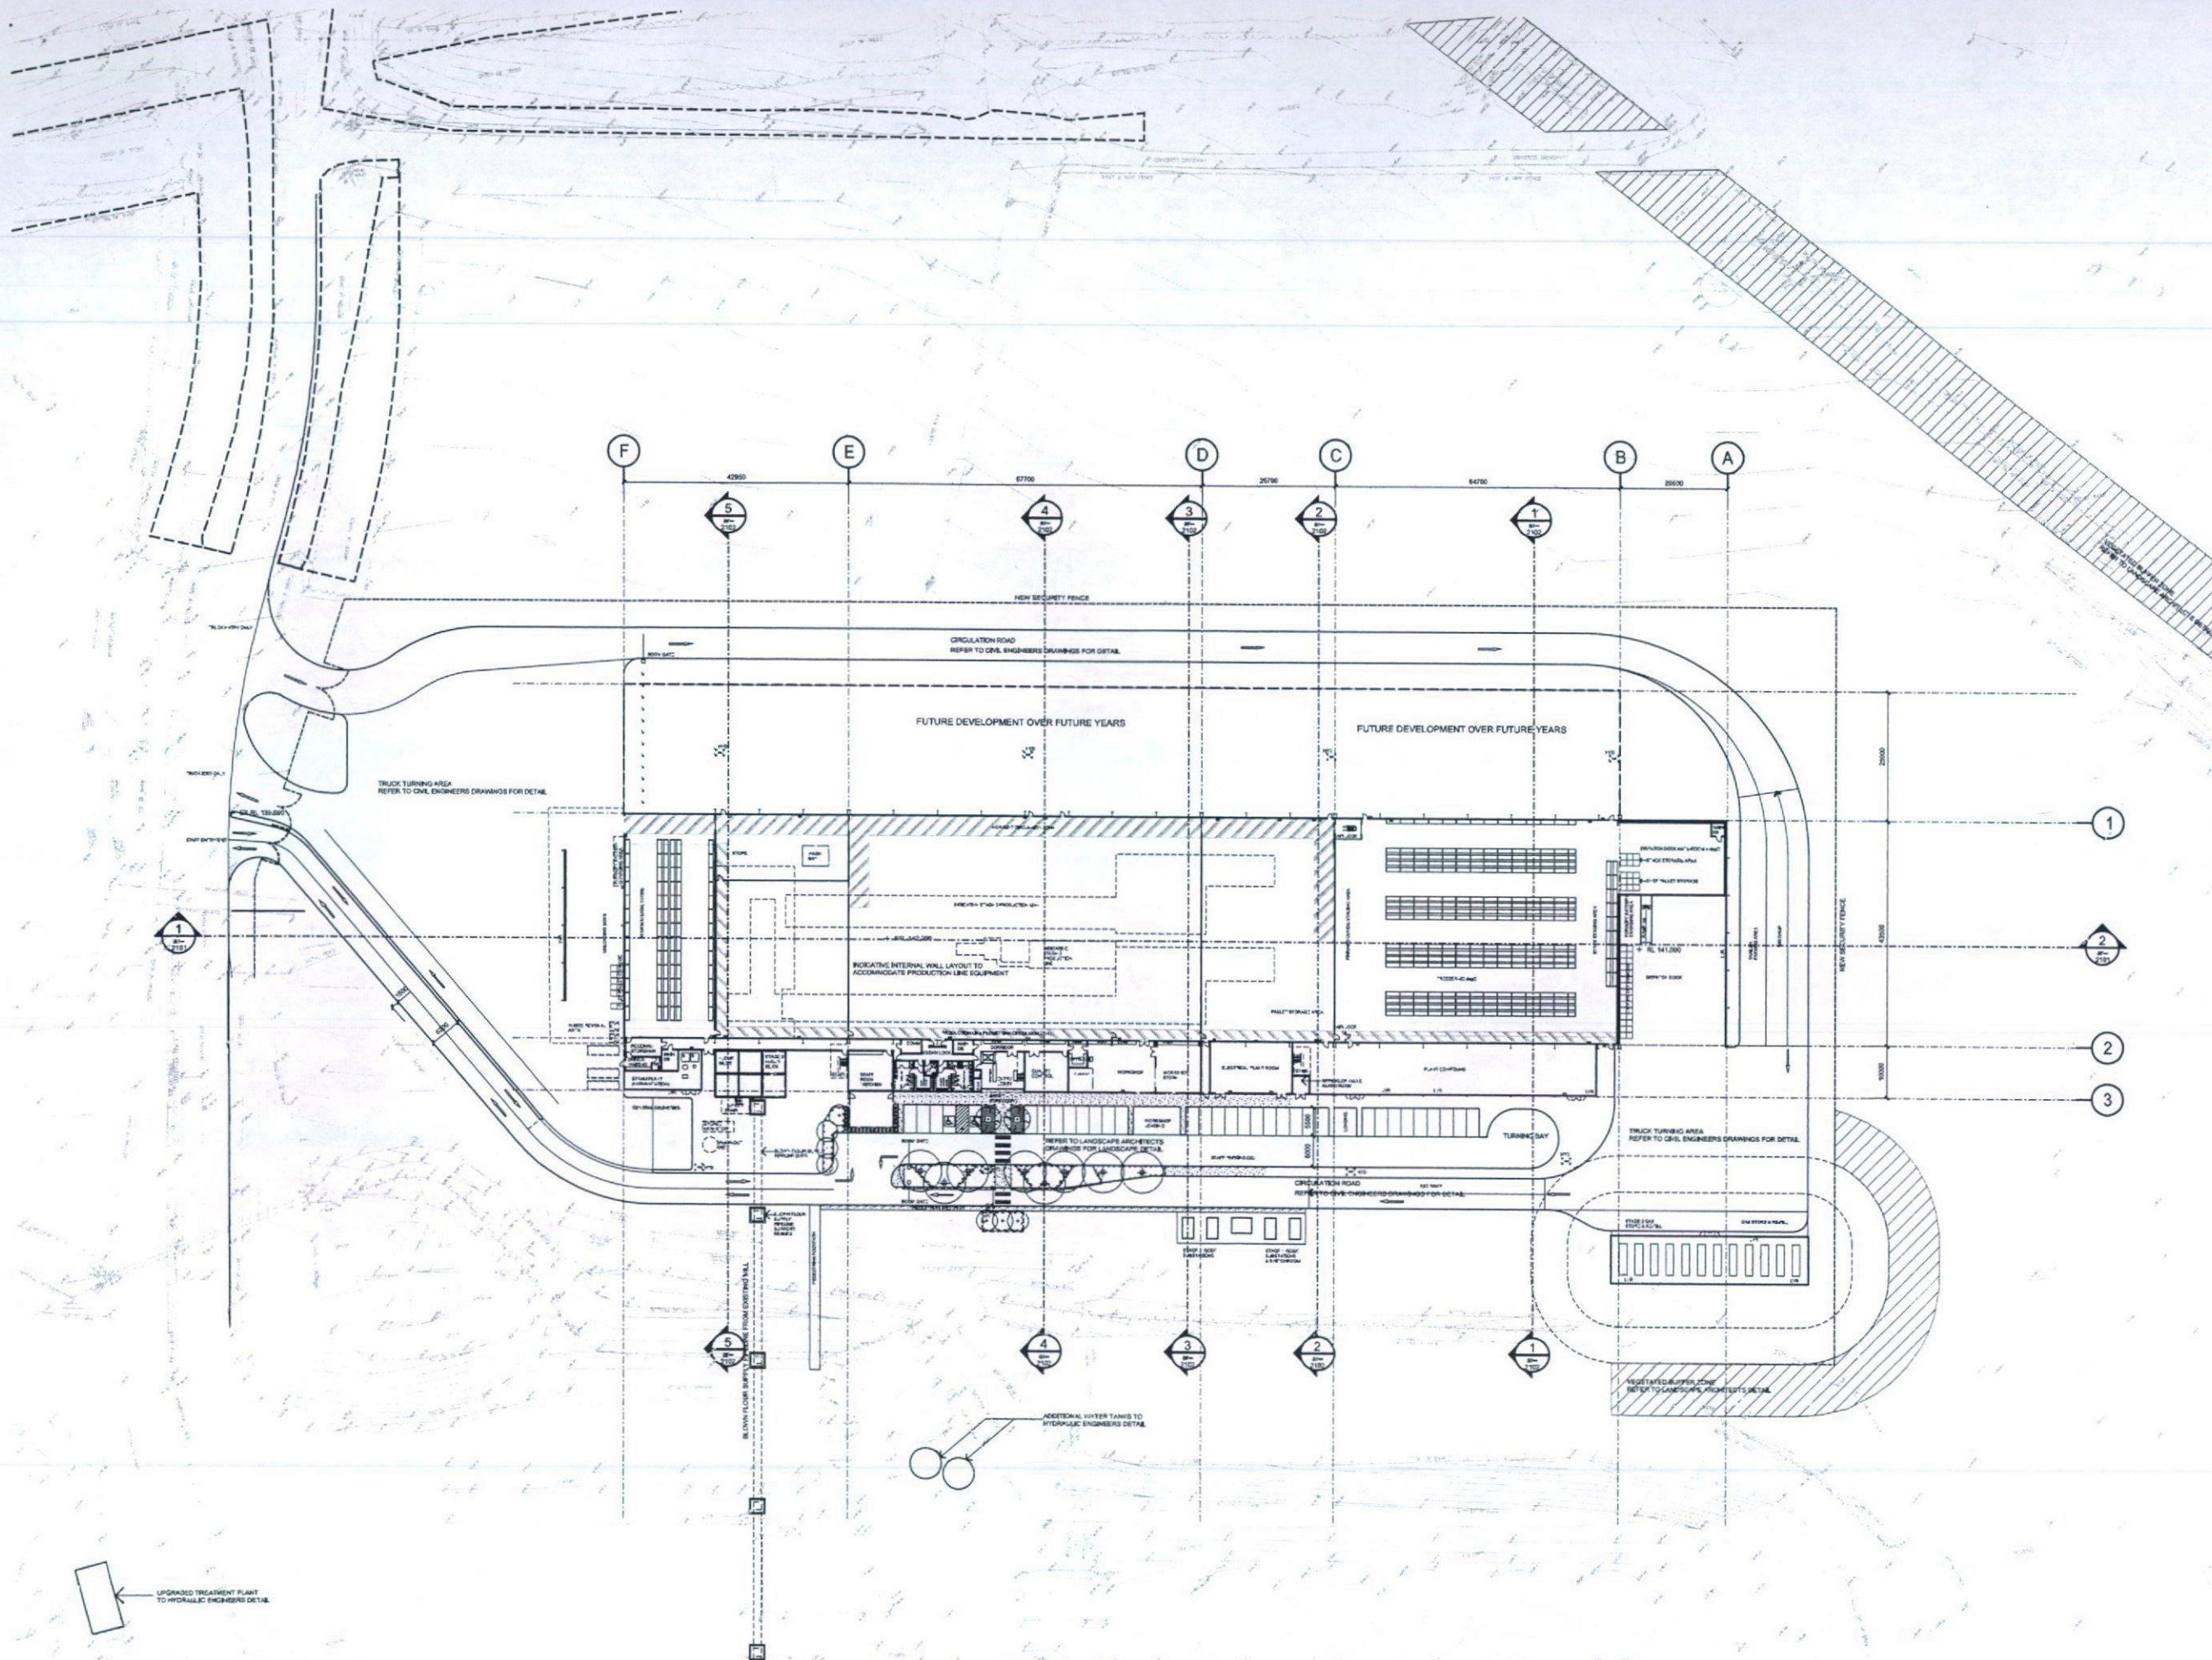

NOTE:
- REFER TO SURVEY DRAWING FOR FULL SURVEY DETAIL.
- SURVEY INFORMATION SHOWN ON THIS DRAWING IS INDICATIVE ONLY.
- REFER TO LANDSCAPE DRAWINGS FOR FULL LANDSCAPE DETAIL.
- LANDSCAPE INFORMATION SHOWN ON THIS DRAWING IS INDICATIVE ONLY.
- REFER TO CIVIL DRAWINGS FOR FULL CIVIL DETAIL.
- CIVIL INFORMATION SHOWN ON THIS DRAWING IS INDICATIVE ONLY.

amendments				verified		
no.	date	amendment	by	chk'd	init	chk'd
401	05/09/11	INITIAL ISSUE	DE	DE		
402	23/09/11	CLIENT REVIEW FOR QA ISSUE	DE	DE	RV	RV
404	23/11/11	QA ISSUE	DE	DE	RV	RV

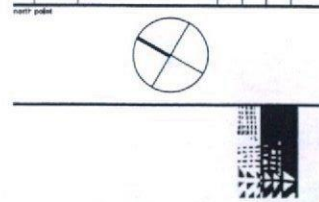

planning, urban design, architecture,
landscape architecture, interior design
level 8 15 help street chatswood nsw 2067
p: po box 5036 west chatswood nsw 1515
t: (02) 8966 6000 f: (02) 8966 6111
e: sydney@dem.com.au

**FOOD MANUFACTURING
PREMISES
PICKTON ROAD
MALDON**

ALLIED MILLS
LEVEL 4
BUILDING G
1 HOMEBUSH BAY DRIVE
RHODES NSW 2138

FIRST FLOOR PLAN
STAGE 1, 2 & 3

original	scale	drawn	project no.
b1	1:500	de	4177-00
drawing no.			rev. no.
ar-1202			A01



NOTE:

- REFER TO SURVEY DRAWING FOR FULL SURVEY DETAIL.
- SURVEY INFORMATION SHOWN ON THIS DRAWING IS INDICATIVE ONLY.
- REFER TO LANDSCAPE DRAWINGS FOR FULL LANDSCAPE DETAIL.
- LANDSCAPE INFORMATION SHOWN ON THIS DRAWING IS INDICATIVE ONLY.
- REFER TO CIVIL DRAWINGS FOR FULL CIVIL DETAIL.
- CIVIL INFORMATION SHOWN ON THIS DRAWING IS INDICATIVE ONLY.

© copyright of dem (nsw) Pty Limited 2011. All rights reserved. No part of this document may be reproduced or transmitted in any form or by any means electronic or mechanical, including photocopying, recording, or by any information storage or retrieval system, without prior written permission from dem (nsw) Pty Limited. This document is the property of dem (nsw) Pty Limited and is loaned to you for your use only. It is not to be distributed, copied, or otherwise used for any other purpose without the prior written permission of dem (nsw) Pty Limited. The information contained herein is for your information only and does not constitute a contract. The information is provided as a guide only and is not to be used as a basis for any decision. The information is provided as a guide only and is not to be used as a basis for any decision. The information is provided as a guide only and is not to be used as a basis for any decision.

dem (nsw) Pty Limited is not responsible for the use of the information contained herein for any purpose other than that for which it was provided. The information is provided as a guide only and is not to be used as a basis for any decision. The information is provided as a guide only and is not to be used as a basis for any decision. The information is provided as a guide only and is not to be used as a basis for any decision.

no.	date	description	by	chkd	rev
1	10/01/11	REVISED	DE	DE	1
2	10/01/11	REVISED	DE	DE	2
3	10/01/11	REVISED	DE	DE	3

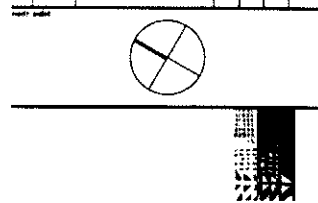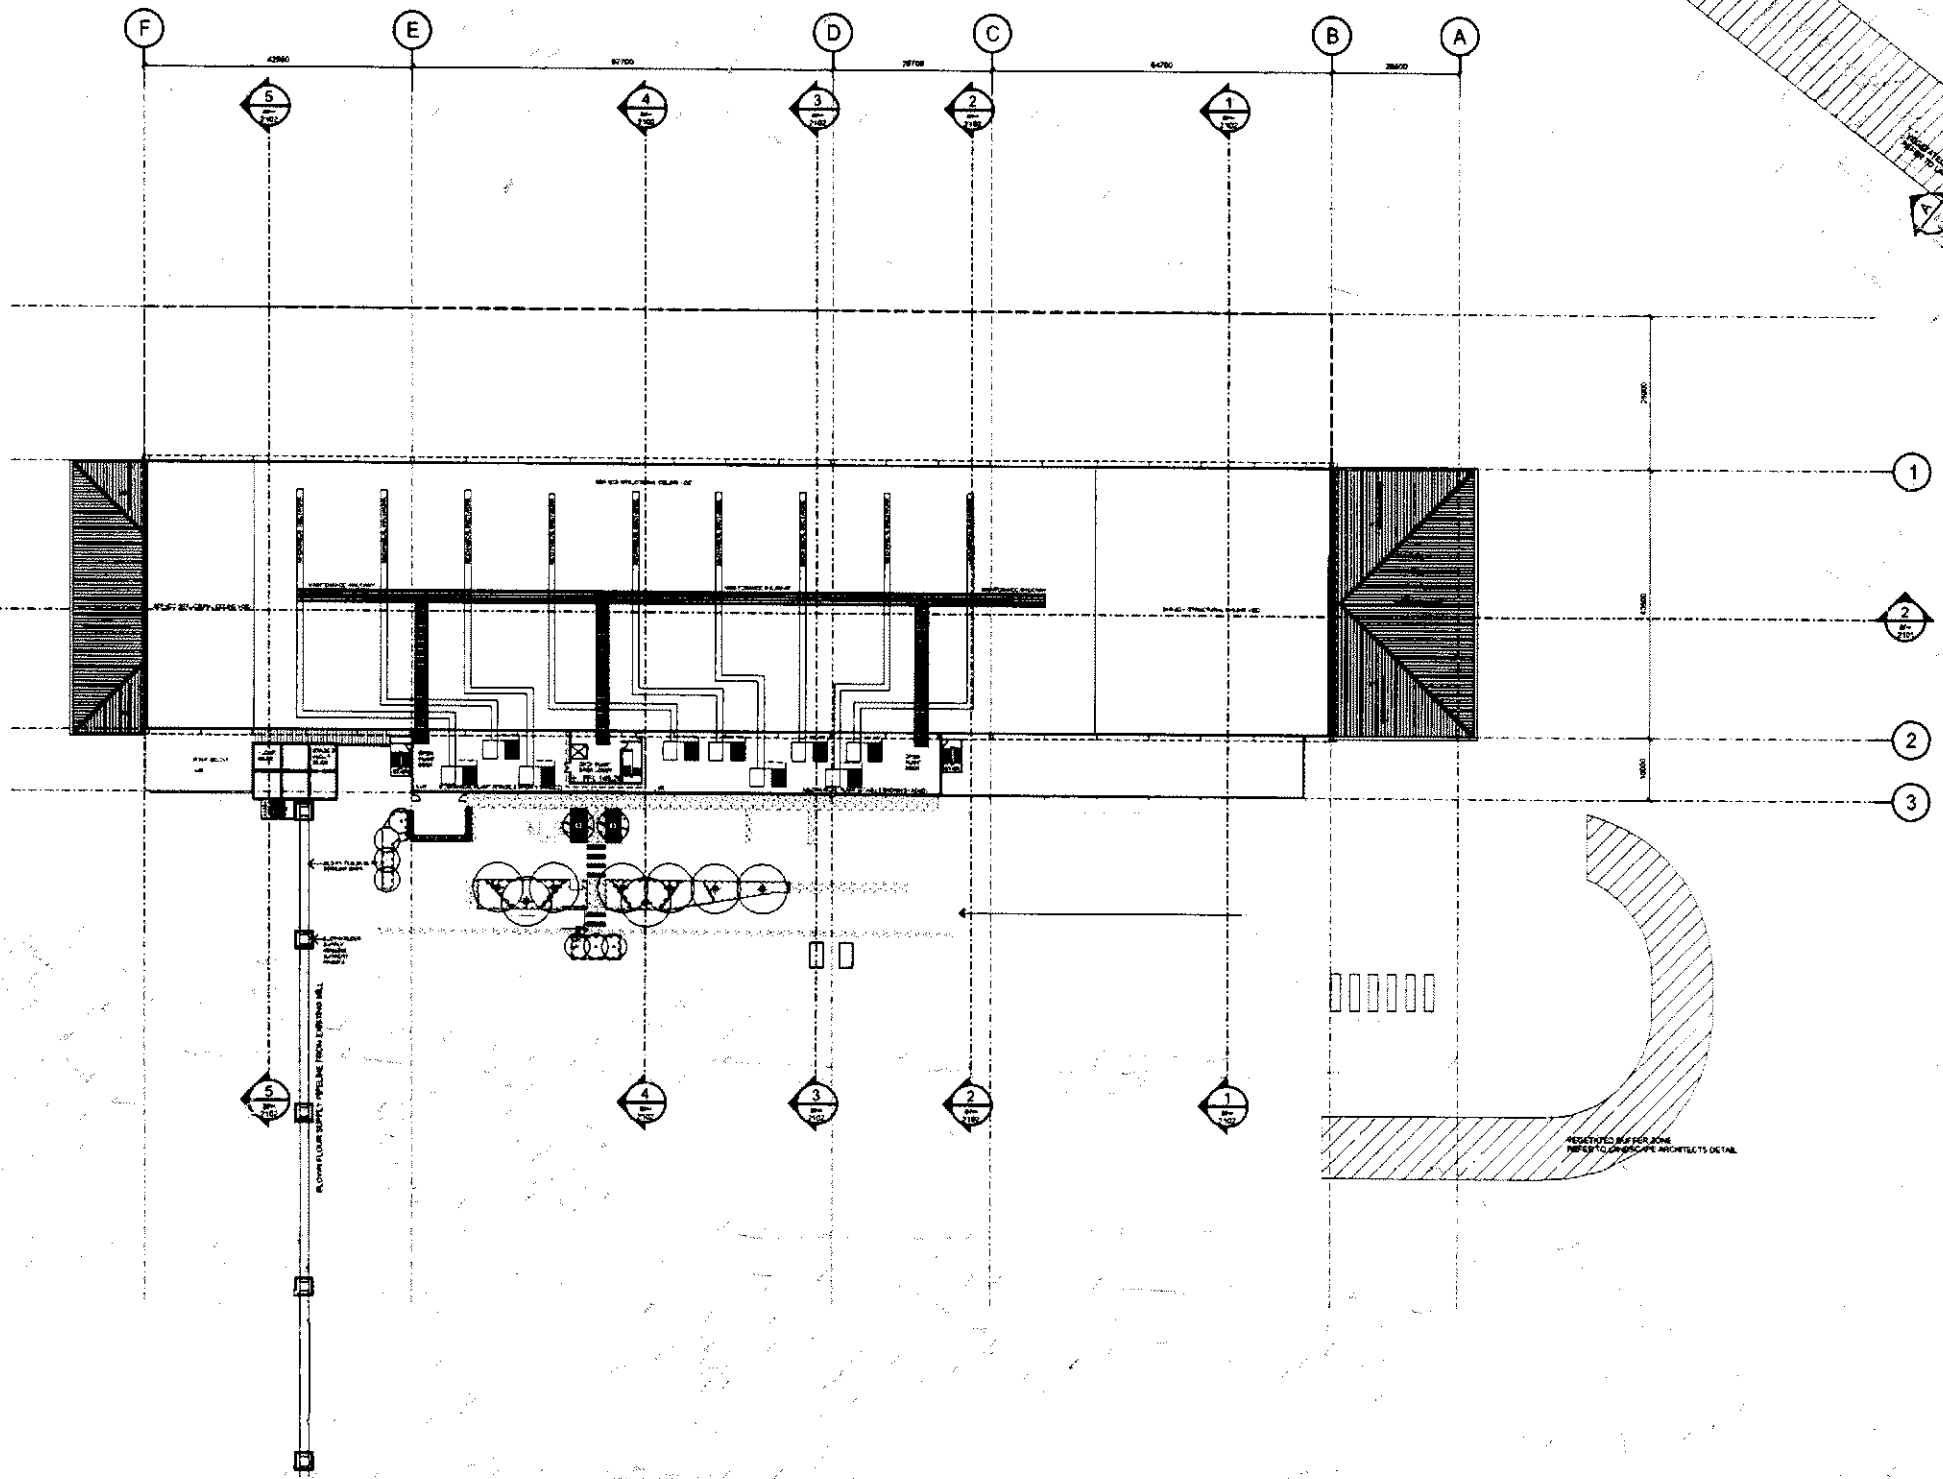

dem
planning, urban design, architecture,
landscape architecture, interior design
level 8 15 help street chelsea nsw 2067
p: 02 9566 6000 f: 02 9566 6111
e: sydney@dem.com.au

FOOD MANUFACTURING PREMISES PICTON ROAD MALDON


ALLIED MILLS
LEVEL 4
BUILDING G
1 HOMEBUSH BAY DRIVE
RHODES NSW 2138


PLANT LEVEL PLAN STAGE 1, 2 & 3

sheet	scale	drawn	checked
b1	1:500	de	4177-00
drawing no.		rev	

ar-1203 A01

  NOTE:
- REFER TO SURVEY DRAWING FOR FULL SURVEY DETAIL.
- SURVEY INFORMATION SHOWN ON THIS DRAWING IS INDICATIVE ONLY.
- REFER TO LANDSCAPE DRAWINGS FOR FULL LANDSCAPE DETAIL.
- LANDSCAPE INFORMATION SHOWN ON THIS DRAWING IS INDICATIVE ONLY.
- REFER TO CIVIL DRAWINGS FOR FULL CIVIL DETAIL.
- CIVIL INFORMATION SHOWN ON THIS DRAWING IS INDICATIVE ONLY.





**FOOD MANUFACTURING
PREMISES
PICKTON ROAD
MALDON**

consultant

da issue

original	scale	design	project no.
b1	1:500	de	4177-00
drawing no.		rev. no.	
ar-1401		A01	

plotted: 21/11/2011 plotted by: deard file: P:\4177-00-PictMP100Cad\Sheetlar-1401.dgn


STAGE 2 INDICATIVE PRODUCTION LINE AND ASSOCIATED FITOUT, EXPANSION OF SITE SERVICES AND STORAGE REQUIREMENTS

STAGE 3 INDICATIVE PRODUCTION LINE AND ASSOCIATED FITOUT, EXPANSION OF SITE SERVICES AND STORAGE REQUIREMENTS


Time (min)	Control (cm)	100 mg/L (cm)	200 mg/L (cm)
0	0.0	0.0	0.0
5	1.5	1.0	0.8
10	3.0	2.0	1.5
15	4.5	3.0	2.2
20	6.0	4.0	3.0
25	8.5	6.5	5.5

© Copyright of dem (austr) Pty Ltd 2011. All rights reserved. No part of this document may be reproduced, stored in a retrieval system, or transmitted in any form or by any means, electronic, mechanical, photocopying, recording, or by any information storage or retrieval system, without prior written permission from dem (austr) Pty Ltd. This document is the property of dem (austr) Pty Ltd and is loaned to you for your use only. It is not to be distributed, copied, or otherwise used for any purpose other than that for which it was loaned to you. If you are not the intended recipient of this document, you should not disseminate, distribute or copy this document. If you have received this document by mistake, please notify dem (austr) Pty Ltd immediately. This document is the property of dem (austr) Pty Ltd and is loaned to you for your use only. It is not to be distributed, copied, or otherwise used for any purpose other than that for which it was loaned to you. If you are not the intended recipient of this document, you should not disseminate, distribute or copy this document. If you have received this document by mistake, please notify dem (austr) Pty Ltd immediately.

REV	DATE	BY	CHK	APP	DESCRIPTION
1	10/10/11	DEM	DEM	DEM	INITIAL ISSUE
2	10/10/11	DEM	DEM	DEM	CLIENT REVIEW ON DASH
3	10/10/11	DEM	DEM	DEM	DASH

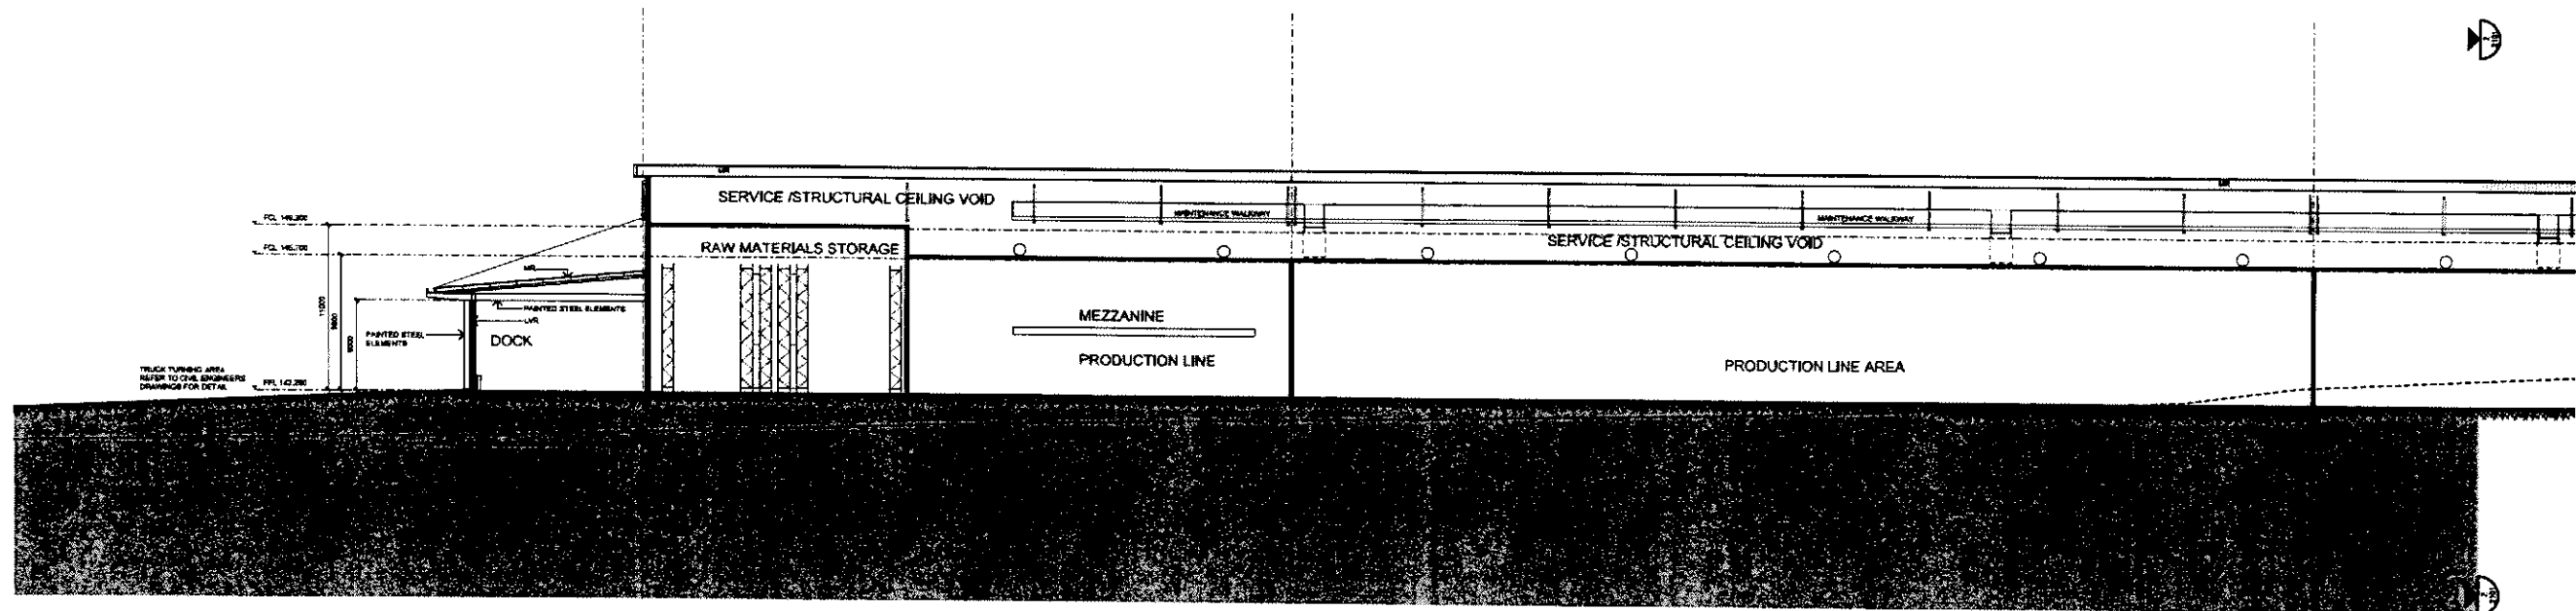

1 NORTHERN END
SECTION 1

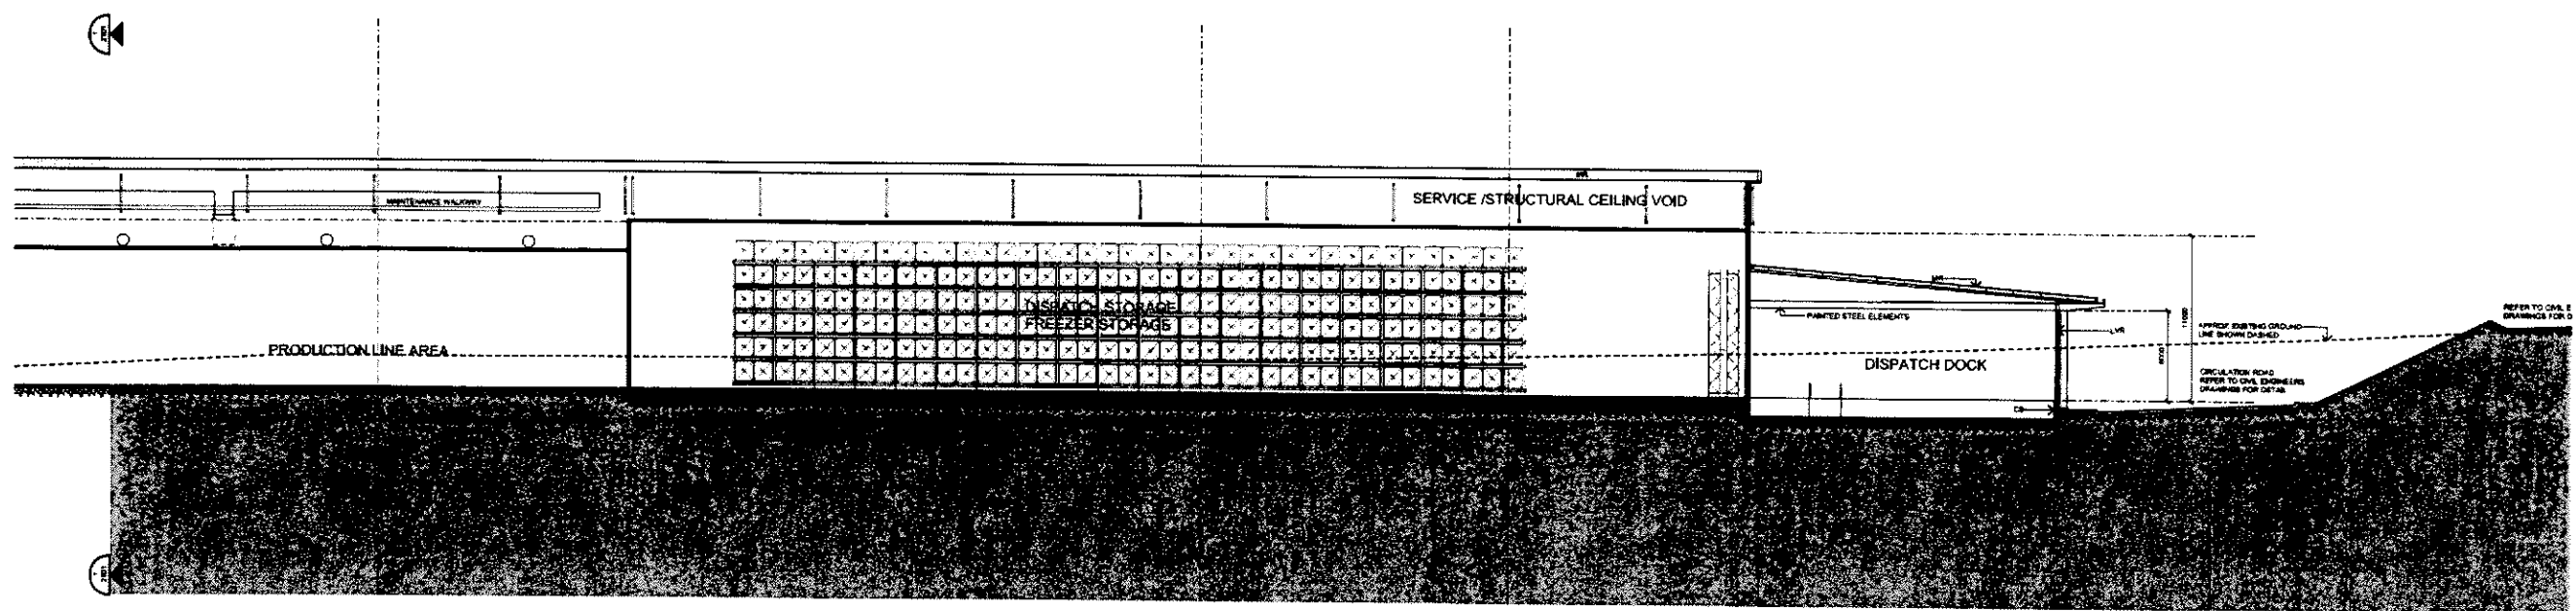

2 SOUTHERN END
SECTION 1

planning, urban design, architecture,
landscape architecture, interior design
level 8 15 hamp street chelsea nsw 2067
p: po box 5036 west chelsea nsw 1615
t: (02) 8966 6000 f: (02) 8966 6111
e: sydney@dem.com.au

**FOOD MANUFACTURING
PREMISES
PICKTON ROAD
MALDON**

ALLIED MILLS
LEVEL 4
BUILDING G
1 HOMEBUSH BAY DRIVE
RHODES NSW 2138

drawing title
SITE SECTIONS 1

da issue

original	scale	drawn	project no
b1	1:200	de	4177-00
drawing no.		per no.	

ar-2101

A01

any reports, drawings, advice or information included or referenced that is prepared and/or provided by any other party, including the client/principal, to the sole representation of the party who prepared the report/drawings, advice or information and does not constitute a representation by ~~them~~ (s/s) sly limited. ~~them~~ (s/s) sly limited expressly takes no responsibility for any documents, advice or other material prepared by any other party.

verified suitable for the use stipulated by the relevant reclassification
only if initiated and checked by an authorized ~~user~~ (not) by United
representative.

[illegible]

dem

project/learn

constant

original	scale	drawn	project no.
----------	-------	-------	-------------

drawing no. rev no.

plotted: 2/1/1/2011 plotted by: dward file: P:\4177-00-P\MP100CadSheet1a-2102.dgn



 




Figure 4 illustrates the use of preference to attain dimensions, only all dimensions of the job better preparing shop drawings or processing work dimensions phone are accurate; generate and the contractor is to apply standard building tolerances.



planning, urban design, architecture,
landscape architecture interior design
level 8 15 help street chatawood nsw 2067
p: po box 3036 west chatawood nsw 1515
t: (02) 8966 6000 f: (02) 8966 6111
e: sydney@dem.com.au

ALLIED MILLS
LEVEL 4
BUILDING G
1 HOMEBUSH BAY DRIVE
RHODES NSW 2138

ar-2502 A01

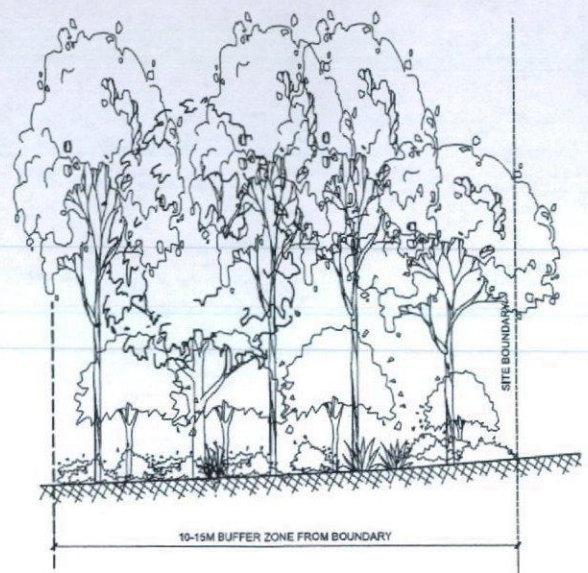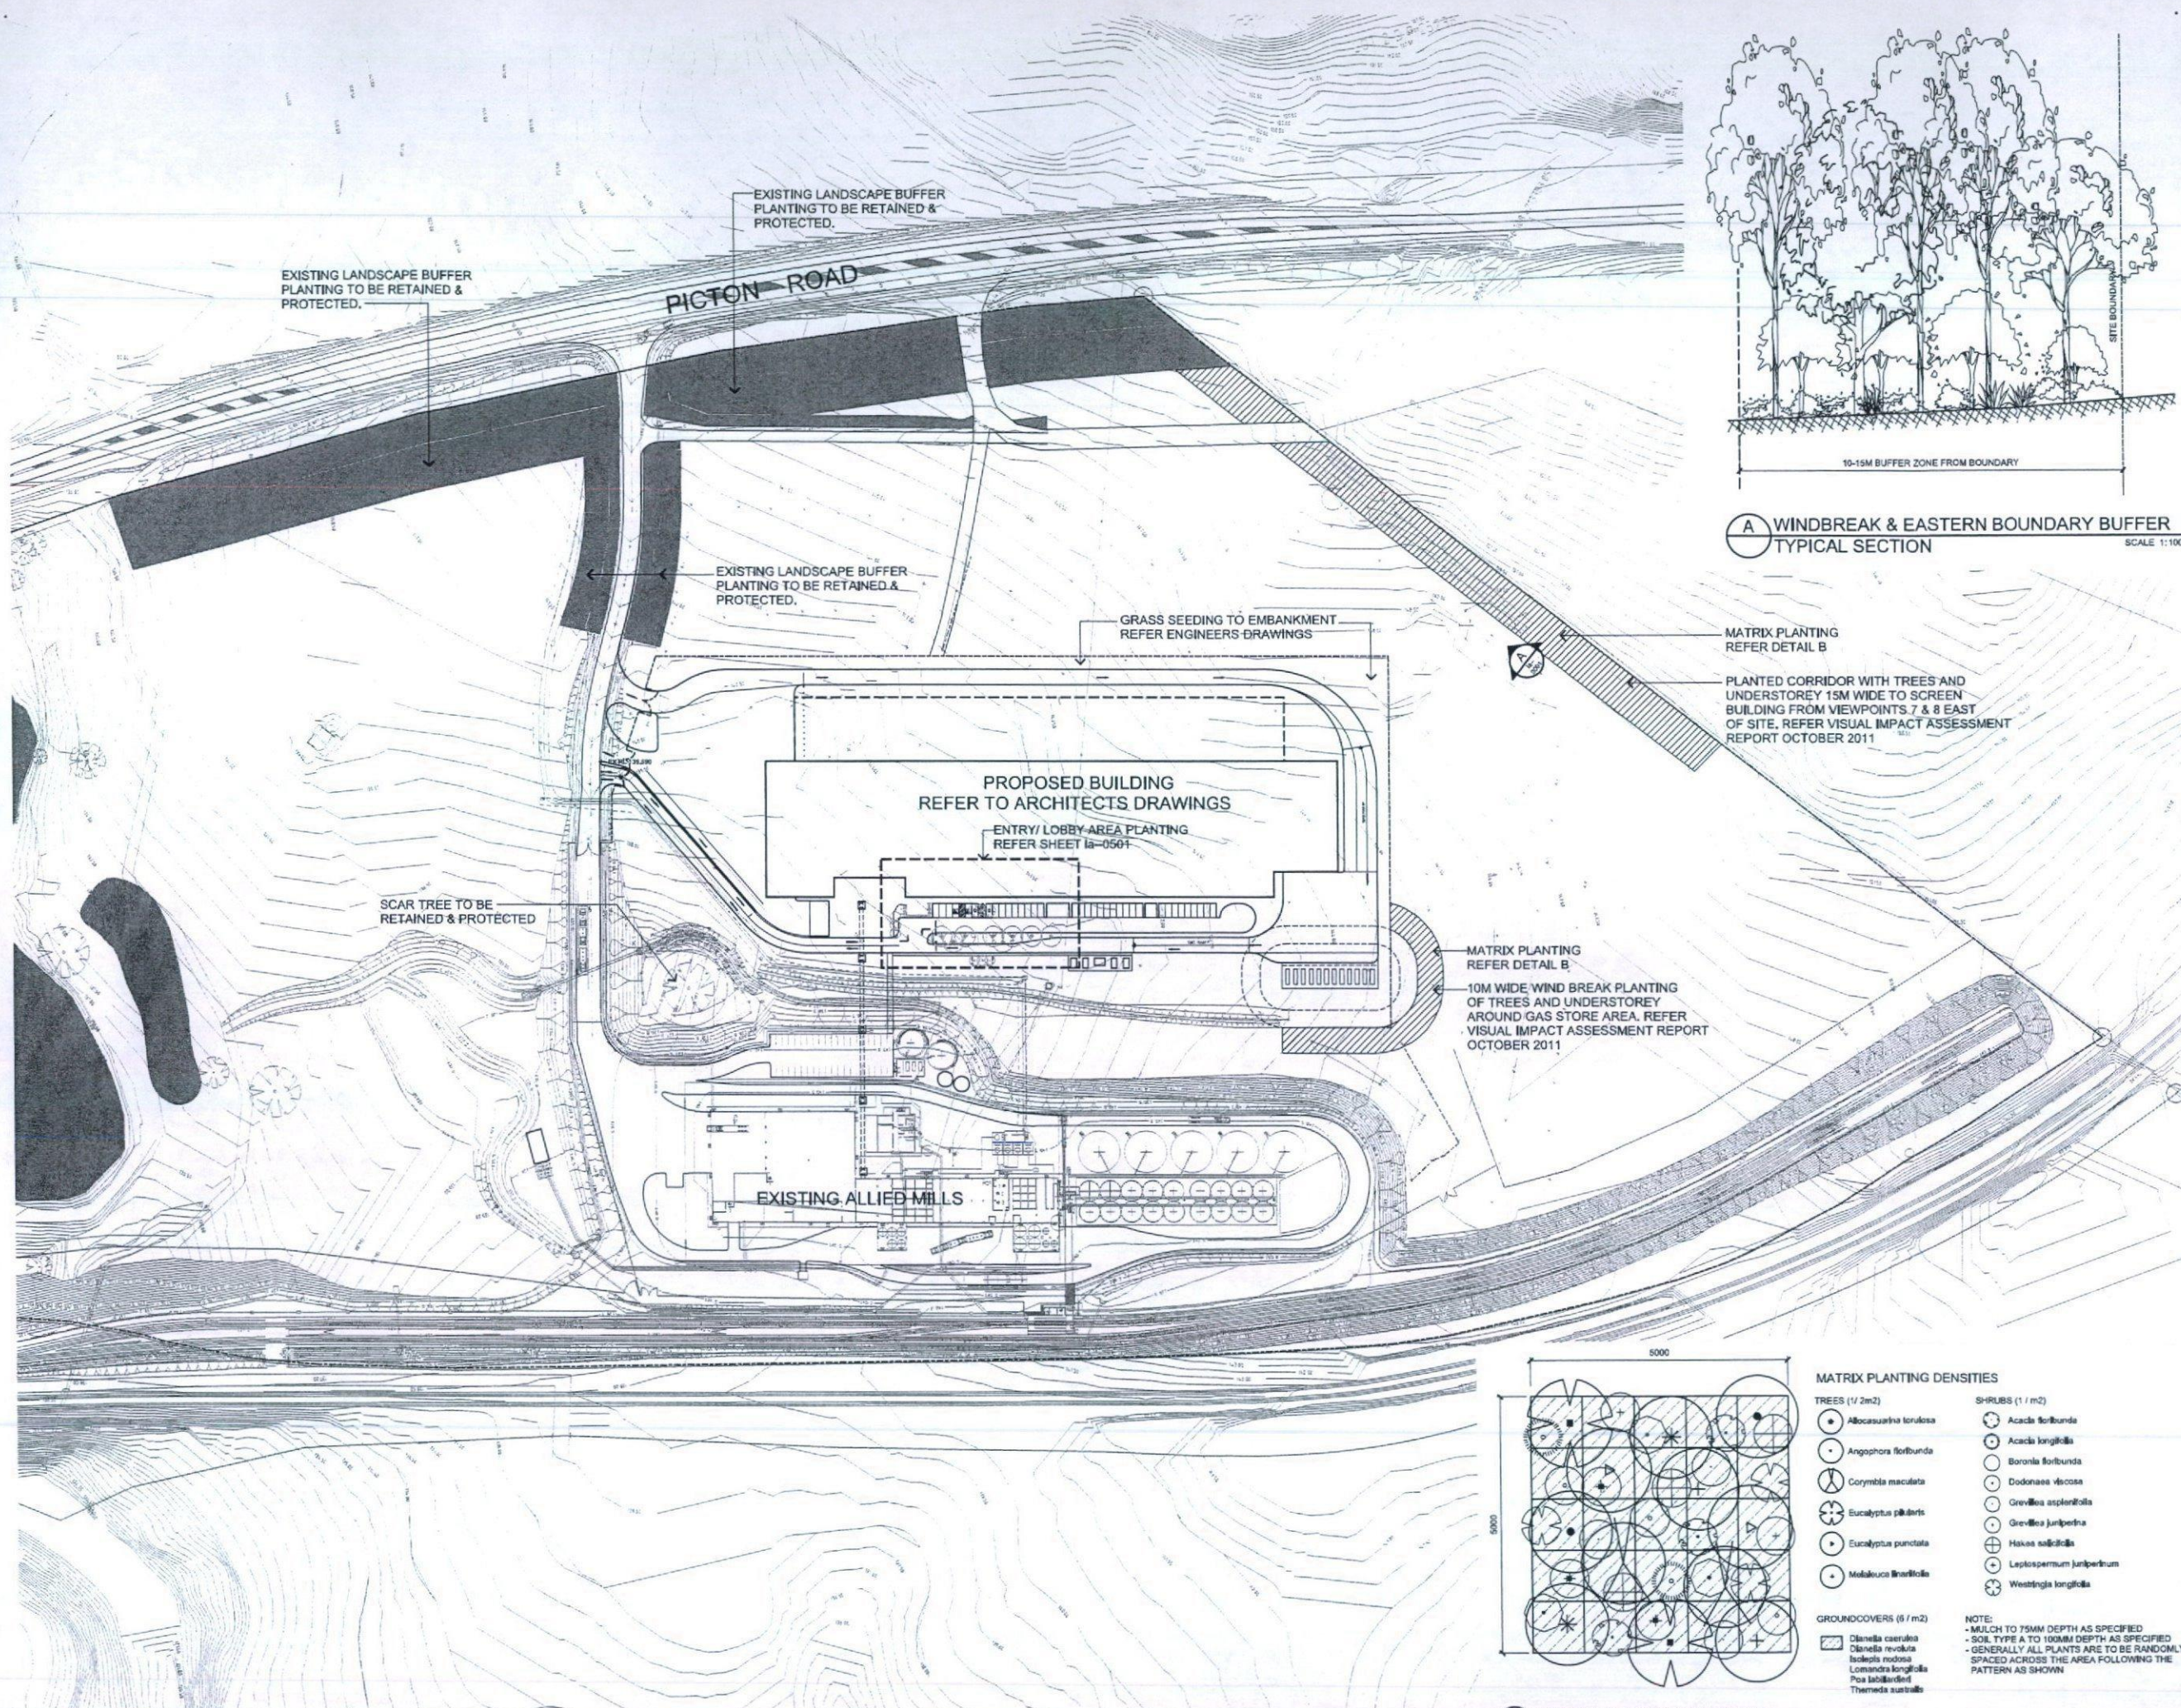


A WINDBREAK & EASTERN BOUNDARY BUFFER
TYPICAL SECTION
SCALE 1:100

MATRIX PLANTING
REFER DETAIL B

PLANTED CORRIDOR WITH TREES AND
UNDERSTOREY 15M WIDE TO SCREEN
BUILDING FROM VIEWPOINTS 7 & 8 EAST
OF SITE. REFER VISUAL IMPACT ASSESSMENT
REPORT OCTOBER 2011

MATRIX PLANTING
REFER DETAIL B

10M WIDE WIND BREAK PLANTING
OF TREES AND UNDERSTOREY
AROUND GAS STORE AREA. REFER
VISUAL IMPACT ASSESSMENT REPORT
OCTOBER 2011

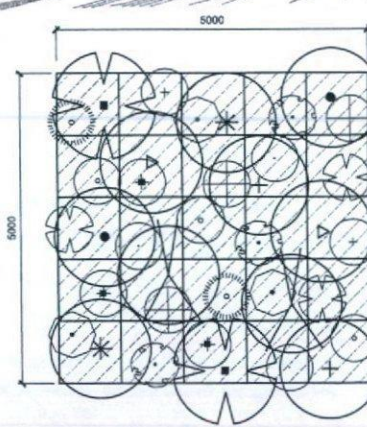

B MATRIX PLANTING ARRANGEMENT
TYPICAL LAYOUT
SCALE 1:500

MATRIX PLANTING DENSITIES

TREES (1/2m2)	SHRUBS (1/1m2)
Albocaulis torulosa	Acacia floribunda
Acacia longifolia	Acacia longifolia
Angophora floribunda	Boronia floribunda
Corymbia maculata	Dodonaea viscosa
Eucalyptus ptilaris	Grevillea asplenifolia
Eucalyptus punctata	Grevillea juniperina
Melaleuca linariifolia	Hakea salicifolia
	Lepidospermum juniperinum
	Westringia longifolia

GROUNDCOVERS (5/1m2)

Dianella caerulea
Dianella revoluta
Lomandra longifolia
Poa labillardieri
Themeda australis

NOTE:
- MULCH TO 75MM DEPTH AS SPECIFIED
- SOIL TYPE A TO 100MM DEPTH AS SPECIFIED
- GENERALLY ALL PLANTS ARE TO BE RANDOMLY
SPACED ACROSS THE AREA FOLLOWING THE
PATTERN AS SHOWN

copyright of dem (austr) Pty Ltd. All rights reserved. No part of this document may be reproduced or transmitted in any form or by any means electronic or mechanical, including photocopying, recording, or by any information storage or retrieval system, without prior written permission from dem (austr) Pty Ltd. All rights reserved.

any reports, drawings, or information included or referenced in this document are the property of dem (austr) Pty Ltd. and are not to be used for any other purpose without prior written permission from dem (austr) Pty Ltd. All rights reserved.

dem (austr) Pty Ltd. is not responsible for any errors or omissions in this document. The user of this document is advised to verify all information and to consult the relevant authorities for any other information.

dem (austr) Pty Ltd. is not responsible for any damage or loss of any kind, including but not limited to, direct, indirect, or consequential damage, arising from the use of this document.

amendment	date	description	by	checked	approved
01	25.10.11	DATE ISSUE	PN	PN	AB
02	17.11.11	DATE ISSUE	PN	PN	AB

dem

planning, urban design, architecture,
landscape architecture, interior design

level 8 15 help street chatswood nsw 2067
p: po box 5036 west chatswood nsw 1515
t: (02) 8966 6000 f: (02) 8966 6111
e: sydney@dem.com.au

**FOOD MANUFACTURING
PREMISES
No.330 PICTON ROAD
MALDON NSW**

Allied Mills Pty Ltd.
Level 4 Building G
1 Homebush Bay Drive
Rhodes NSW 2138

overall plan

da issue

original	scale	drawn	project no.
b1	1:1000	PN	4177-01

la-0001 A02


PLANT SCHEDULE

Code	Botanic Name	Common Name	Container Size at planting	Rate	Approx Size at Maturity (H x S)	Total Quantity
Trees						
Cs	Callistemon salignus	Pink tipped bottlebrush	75L	N/A	9m x 4m	4
Cm	Corymbia maculata	Spotted Gum	75L	N/A	30m x 8m	6
TTL	Tristanopsis laurina 'Luscious'	Water Gum	75L	N/A	10m x 8m	2
Shrubs						
Bs	Banksia serrata	Old Man Banksia	SL	N/A	6m x 4m	3
Wf	Westringia fruticosa	Coastal Rosemary	SL	1000mm	2m x 2m	25
Groundcovers						
Dc'LJ	Dianella caerulea 'Little Jess'	Little Jess	Tubestock	400mm	0.4m x 0.4m	337
In	Isoplepis nodosa	Knobby Clubbrush	Tubestock	400mm	1m x 0.5m	609
L/K	Lomandra longifolia 'Katinus'	Spiry Headed Rush	Tubestock	400mm	1m x 0.5m	462
L/T	Lomandra longifolia 'Tanika'	Tanika	Tubestock	400mm	0.6m x 0.6m	529

GENERAL NOTES

1. DIMENSIONS SHOWN ARE IN MILLIMETRES. DO NOT SCALE FROM THESE DRAWINGS.
2. LEVELS SHOWN ARE IN METRES.
3. FOR ARCHITECTURAL DETAILS REFER ARCHITECTURAL DRAWINGS.
4. FOR CIVIL, STRUCTURAL, TRAFFIC OR ELECTRICAL DETAILS REFER ENGINEERS DRAWINGS.
5. SURVEY INFORMATION TAKEN FROM CBD SURVEYING SERVICES PTY. LTD. BEVERLY HILLS NSW 2209. PLAN NO. 1129013 DATED 26.05.11 & 18.10.11 AND ALLIED MILLS AUSTRALIA PTY. LTD. PICTON NSW SITEPLAN DATED 05.03.08

LEGEND

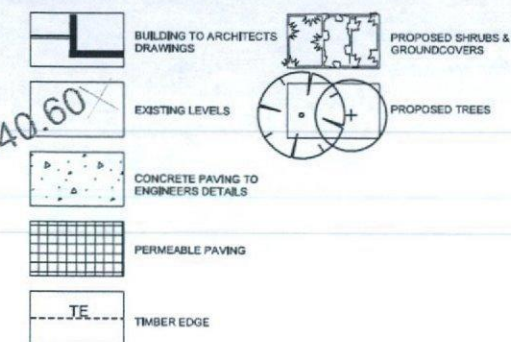


Copyright of dem (sue) Pty. Limited 2011. All rights reserved. No part of this publication may be reproduced, stored in a retrieval system, or transmitted, in any form or by any means, electronic, mechanical, photocopying, recording, or by any information storage or retrieval system, without prior written permission from dem (sue) Pty. Limited. Any person who infringes the copyright in this publication may be liable to criminal sanctions (including fines and imprisonment) and/or civil sanctions (including damages and costs).

dem (sue) Pty. Limited is not responsible for any errors or omissions in this publication, or for any consequences arising from the use of the information contained herein. dem (sue) Pty. Limited is not responsible for any loss or damage, whether direct or indirect, arising from the use of the information contained herein.

dem (sue) Pty. Limited is not responsible for any loss or damage, whether direct or indirect, arising from the use of the information contained herein.

amendment	no.	date	description	by	checked	approved
AD	01	15.11.11	ISSUE	PN	PN	AD
AD	02	15.11.11	ISSUE	PN	PN	AD

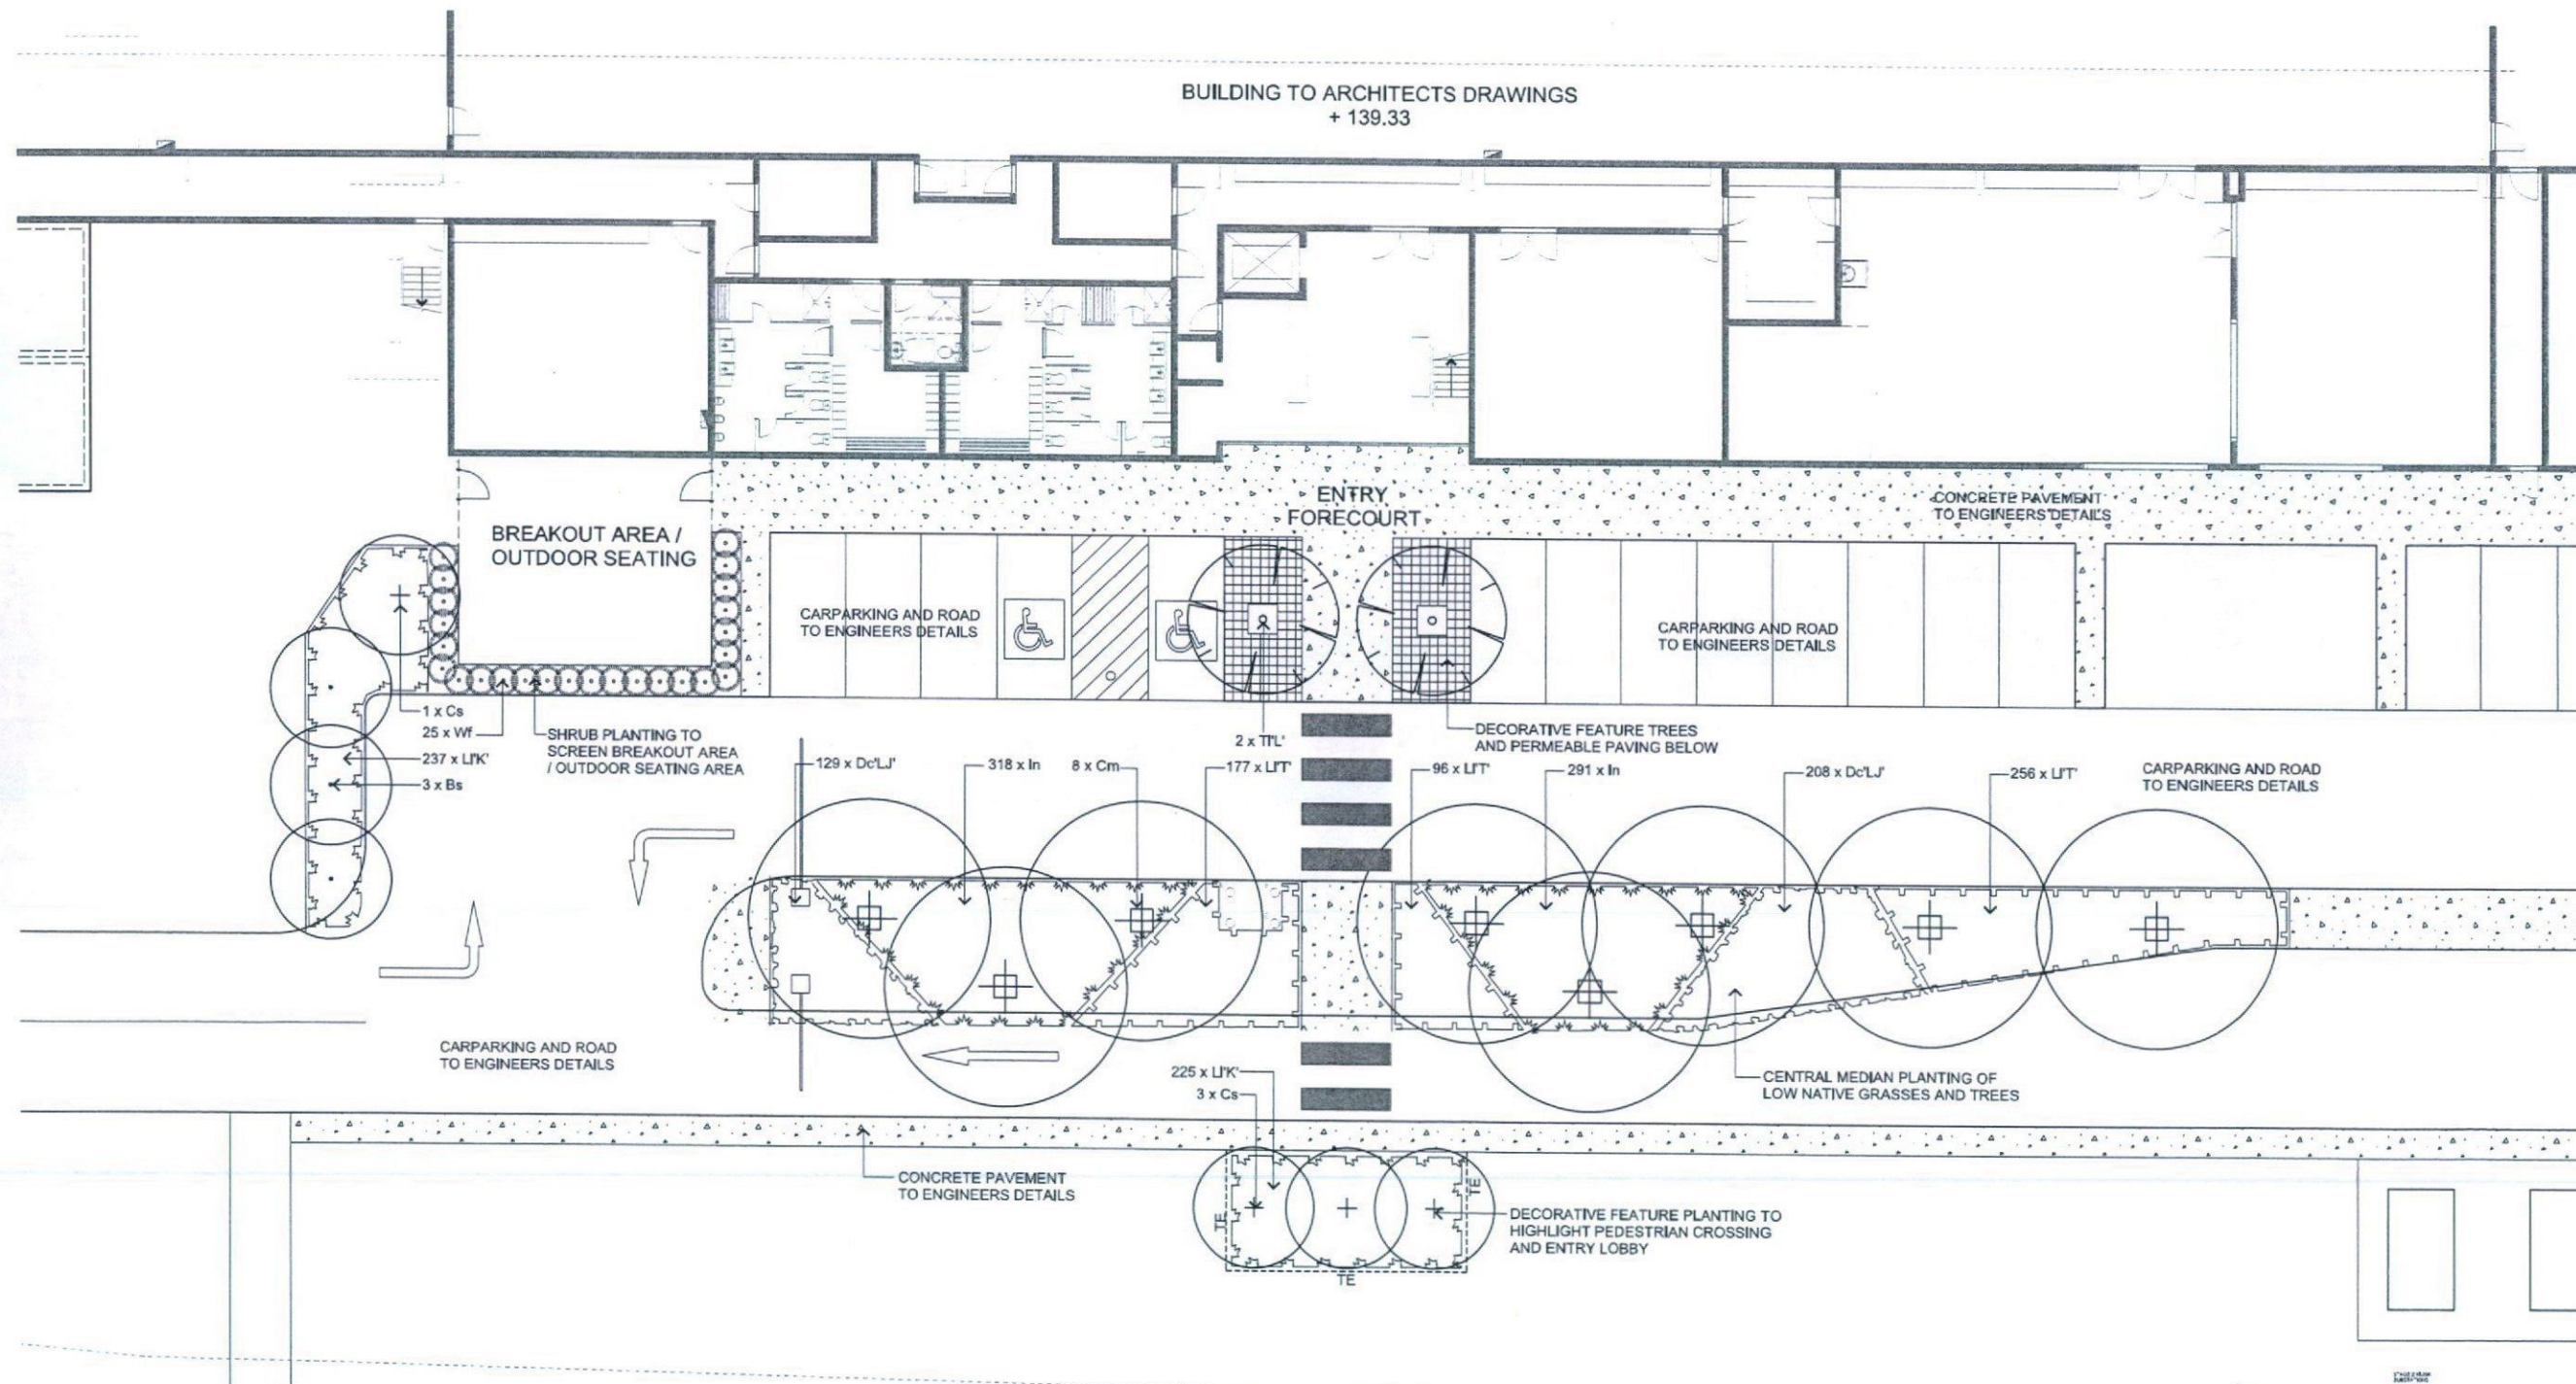

dem

planning, urban design, architecture, landscape architecture, interior design

level & 15 help street, chadsworth nsw 2067

po box 5036 west chadsworth nsw 1515

t: (02) 8966 6000 f: (02) 8966 6111

e: sydney@dem.com.au

proposed

FOOD MANUFACTURING PREMISES

No.330 PICTON ROAD

MALDON NSW

Allied Mills Pty Ltd.
Level 4 Building G
1 Homebush Bay Drive
Rhodes NSW 2138

drawing title

landscape plan

entry lobby area

da issue

original	scale	date	project no.
b1	1:100	PN	4177-01
drawing no.			

la-0501 A02