


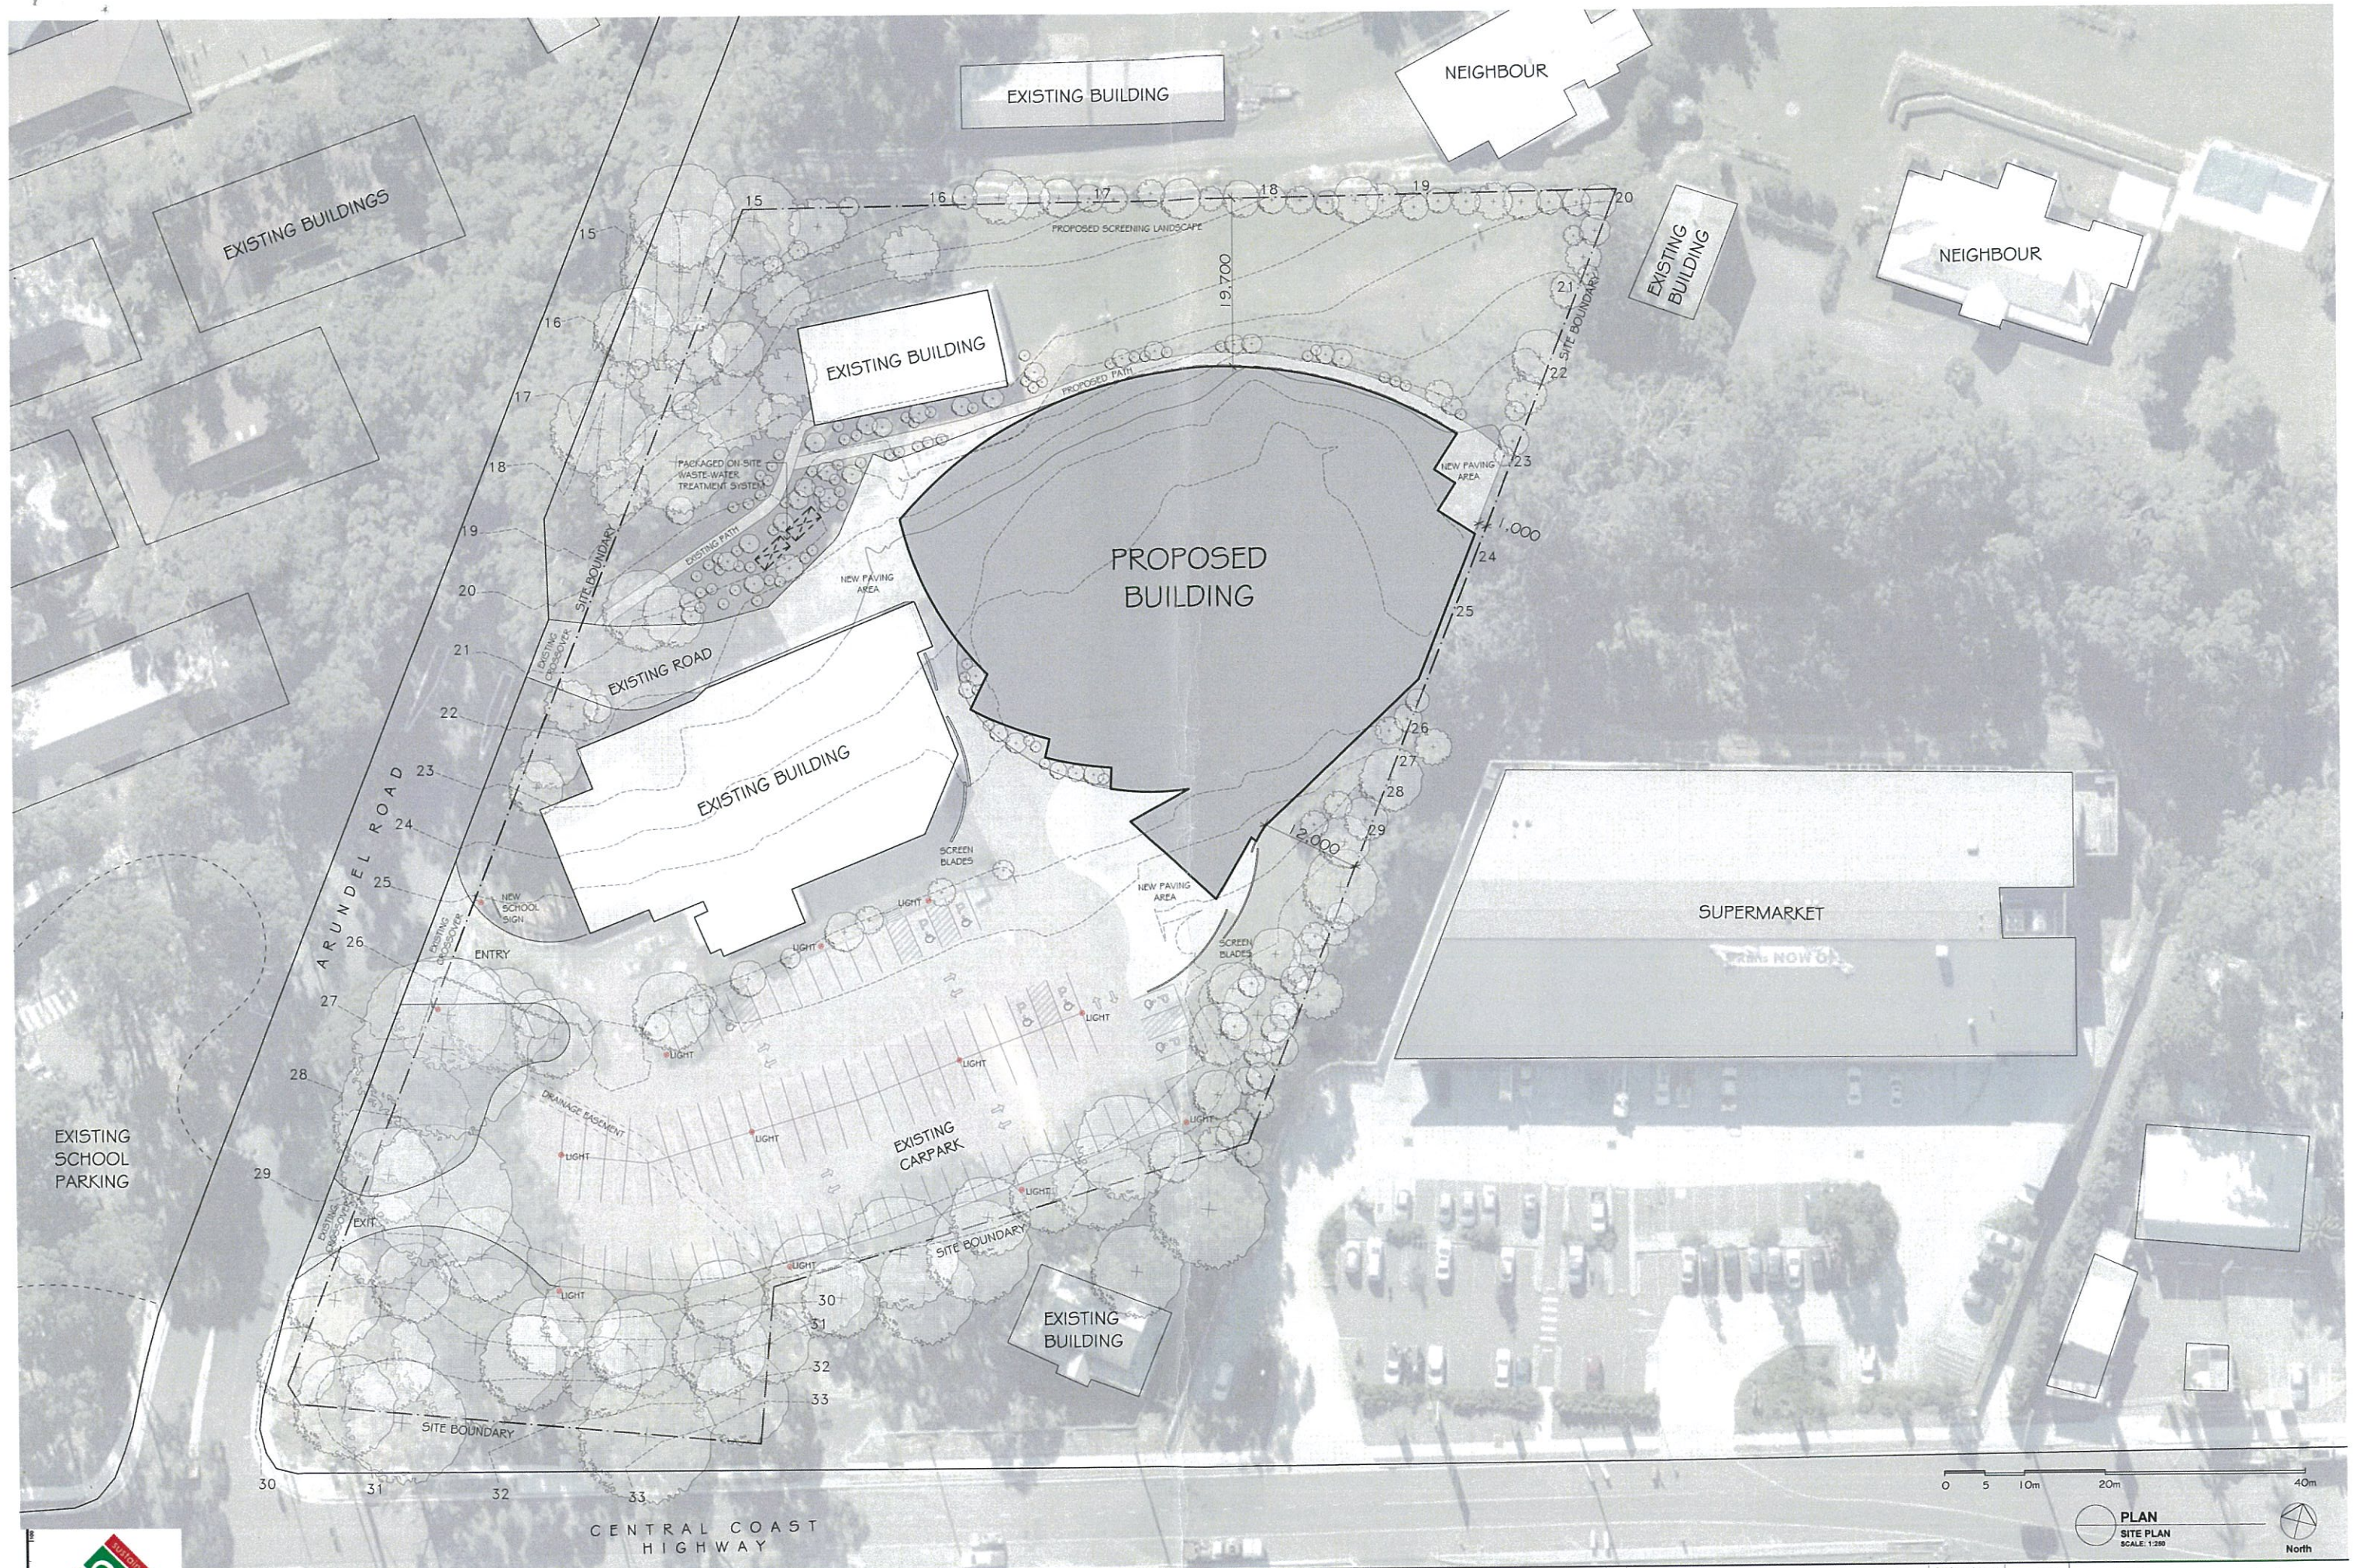

CBM Sustainable Design
 8 Broadland Dr, PO Box 1971, Launceston TAS 7250
 Ph: 03 6332 6988 Fax: 03 6331 8300 www.cbmgroupp.com.au

Job No: **25191P**
 Project: **CENTRAL COAST GRAMMAR SCHOOL
 MULTI PURPOSE CENTRE (MPC)**

Designed: CBM	Scale: 1:250	Dwg No: A101	Rev: A
Drawn: CBM	Size: A0	Dwg: PROPOSED SITE PLAN	
Checked: CBM			
Date: 1 Rev			

Drawings to be read in conjunction with written specifications. Written dimensions take precedence over scaled dimensions. All dimensions in millimetres.

Copyright 2012



5



6



7



8



4



3



2



1



9



10



11



12



CBM Sustainable Design
8 Broadland Dr, PO Box 1971, Launceston TAS 7250
Ph: 03 6332 6988 Fx: 03 6331 8300 www.cbmgroupp.com.au

Job No: 25191P
Project: CENTRAL COAST GRAMMAR
MULTI PURPOSE CENTRE (MPC)


Designed: CBM
Drawn: CBM
Checked: CBM
Scale: NTS
Size: A0


Dwg No: A102
Dwg: SITE PHOTOS

Rev: A
Copyright 2012



 Copyright 2011



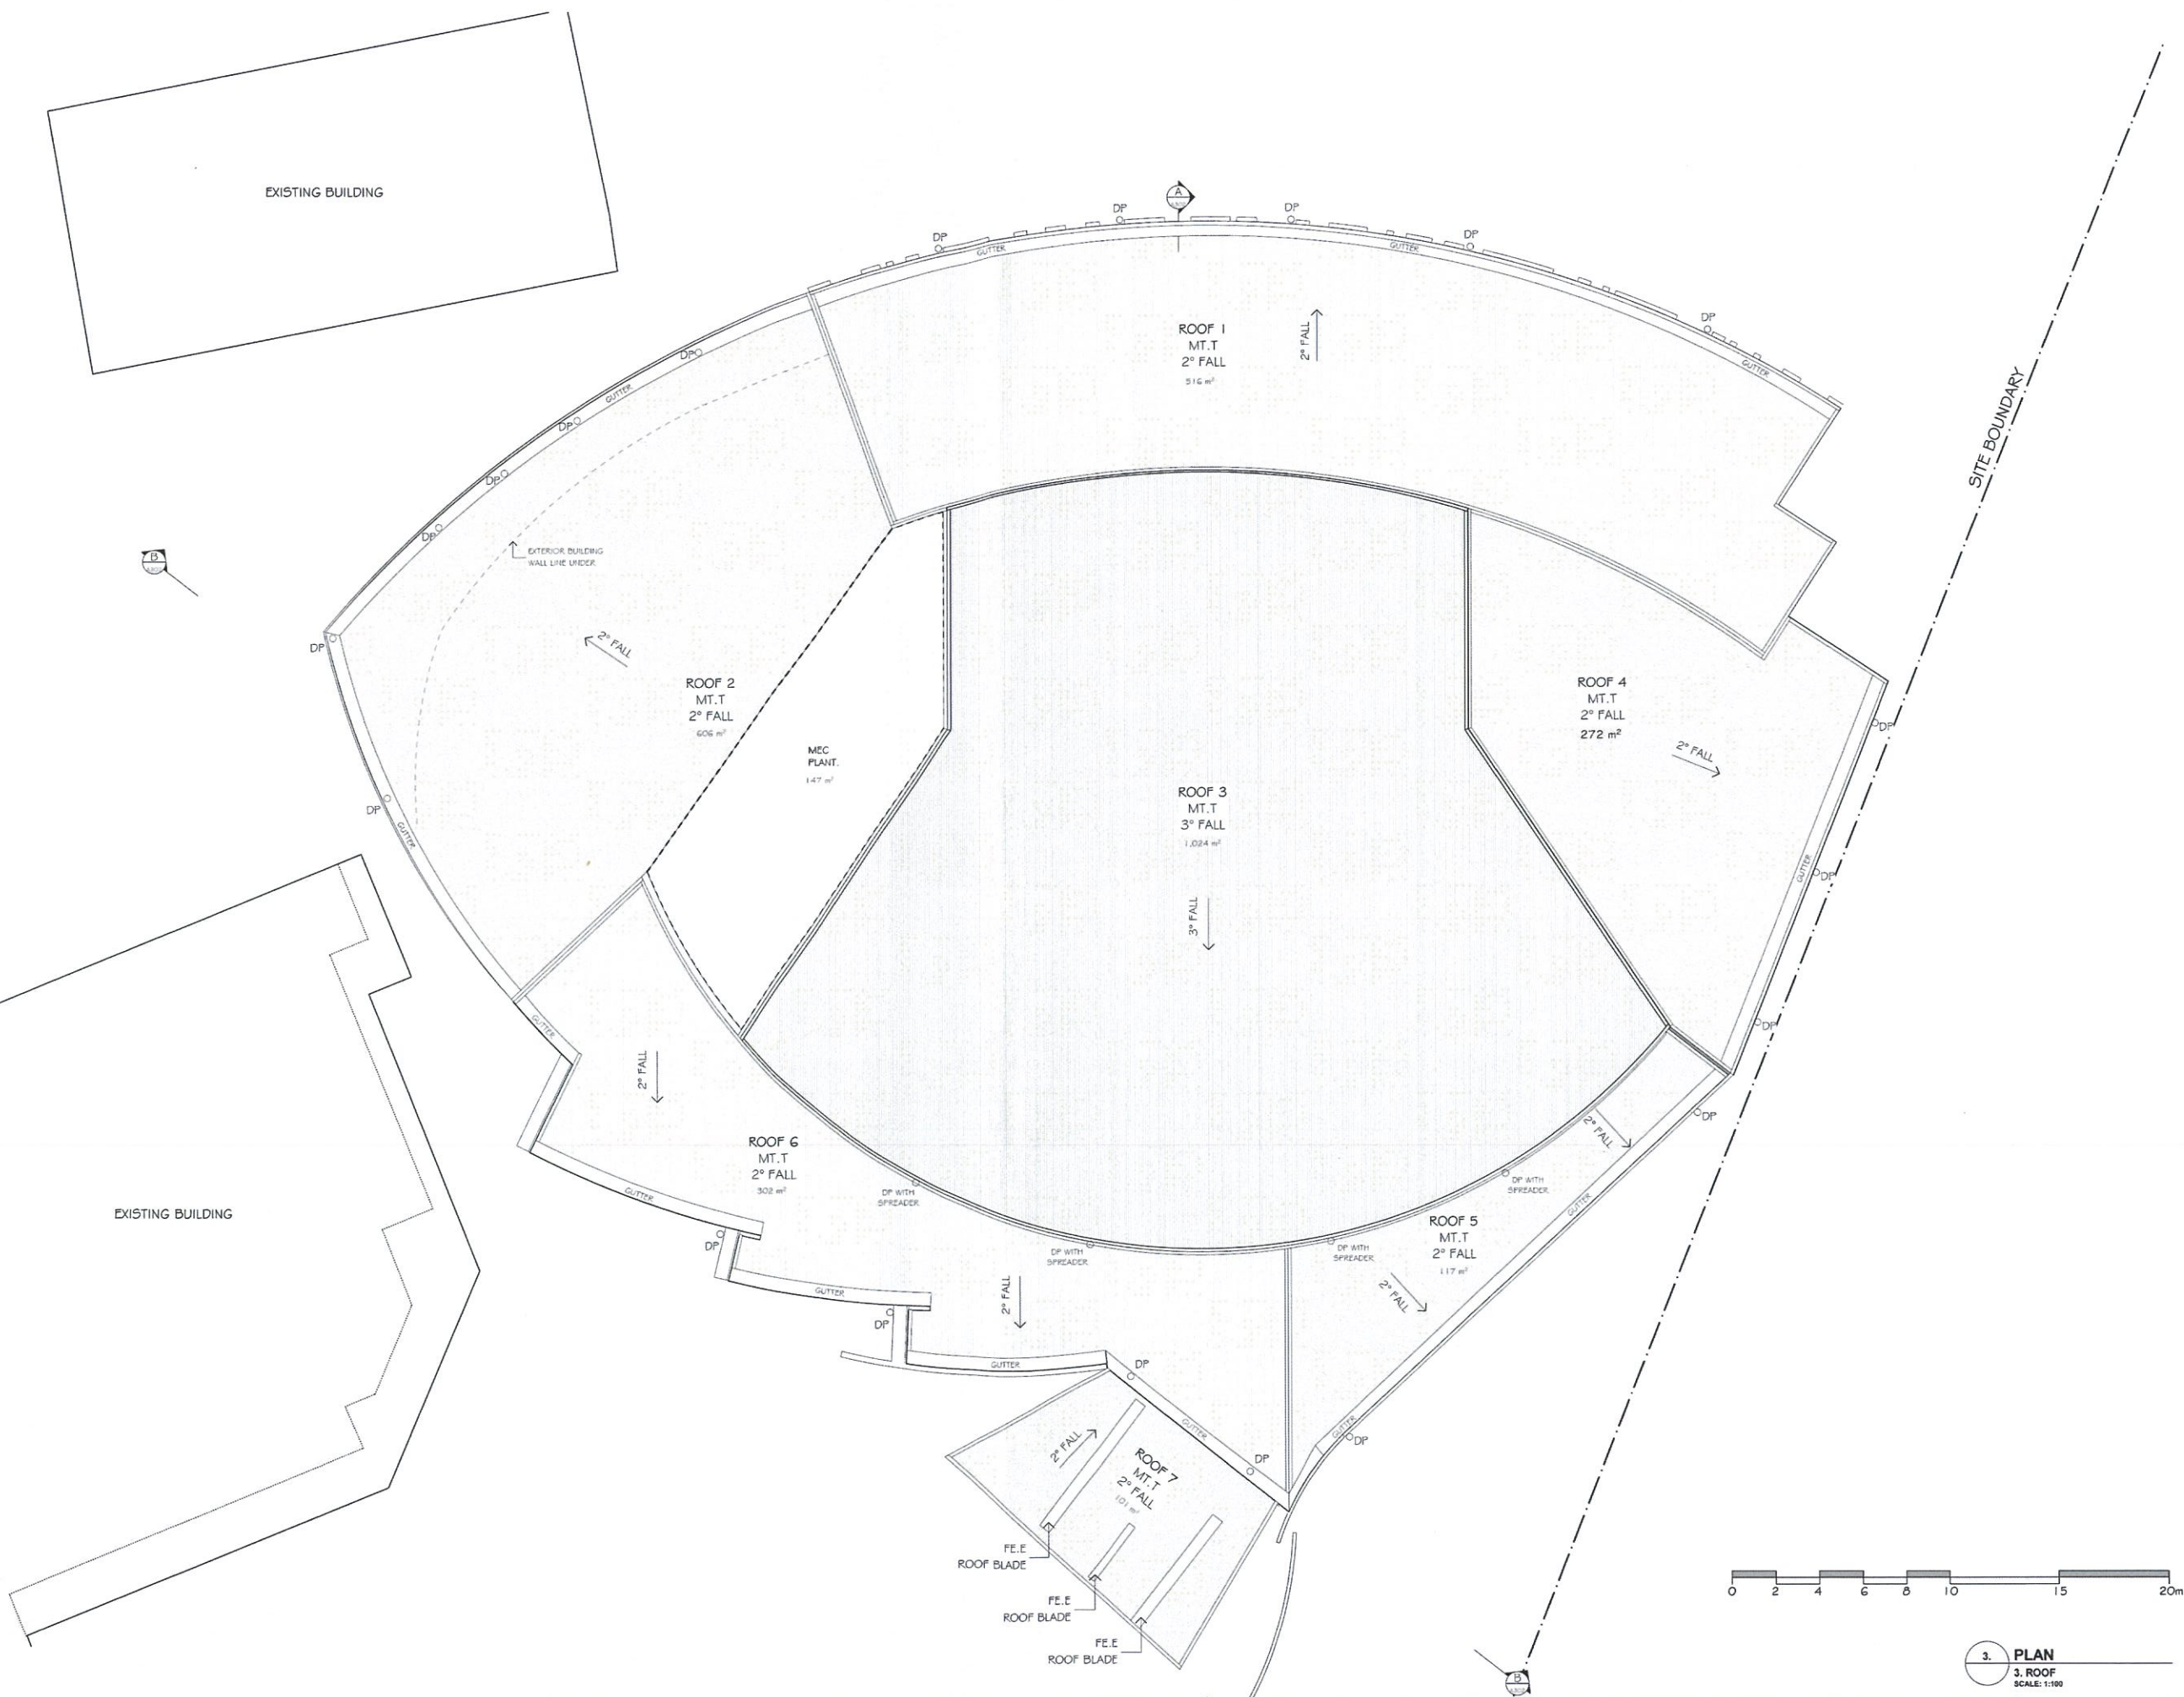

3. PLAN
3. ROOF
SCALE: 1:100



CBM Sustainable Design
8 Broadland Dr, PO Box 1971, Launceston TAS 7250
Ph: 03 6332 6988 Fax: 03 6331 8300 www.cbmgroupp.com.au


Job No: **25191P**
Project: **CENTRAL COAST GRAMMAR SCHOOL
MULTI PURPOSE CENTRE (MPC)**

1302 2013	A	FOR DEVELOPMENT APPLICATION
1302 2013	1809	130161


Designed: CBM	Scale: 1:100	Dwg No: A206	Rev: A
Drawn: CBM			
Checked: CBM	Size: A0	Dwg: ROOF PLAN	

Drawings to be read in conjunction with written specifications. Written dimensions take precedence over scaled dimensions. All dimensions in millimetres.

Copyright 2012

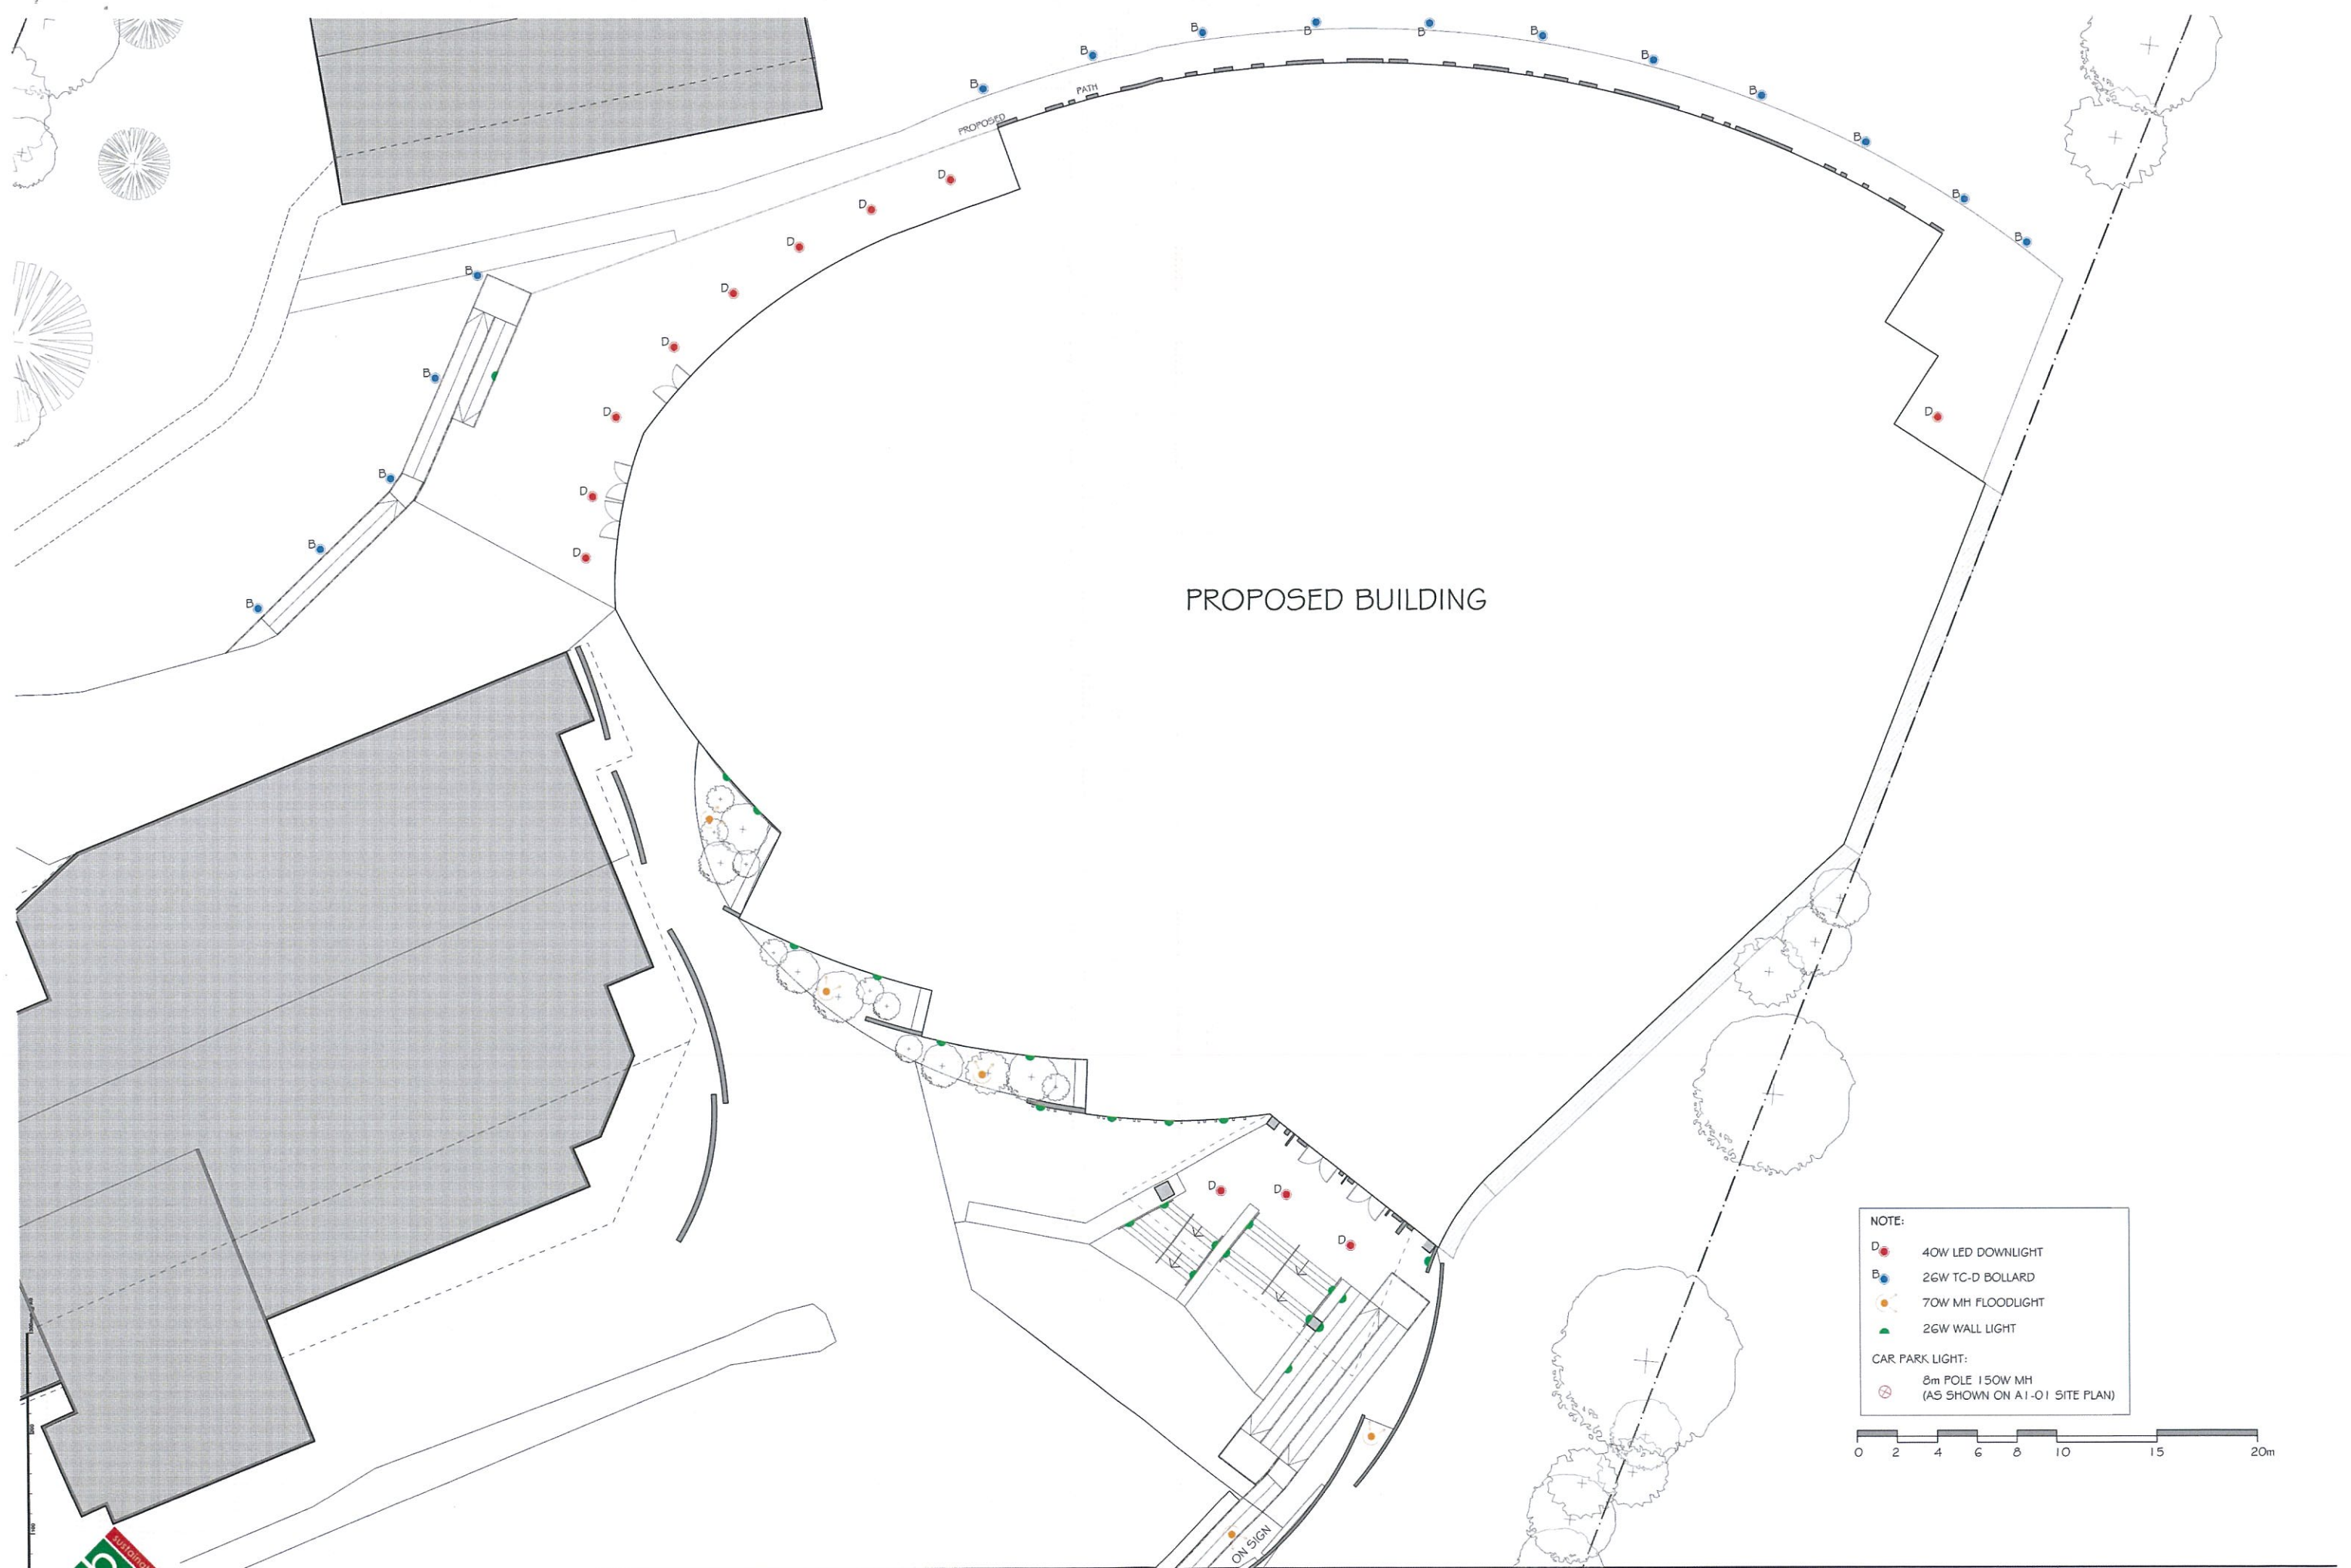

 - NOTE:
- D 40W LED DOWNLIGHT
 - B 26W TC-D BOLLARD
 - 70W MH FLOODLIGHT
 - 26W WALL LIGHT
- CAR PARK LIGHT:
- 8m POLE 150W MH (AS SHOWN ON A1-01 SITE PLAN)



CBM Sustainable Design
8 Broadland Dr, PO Box 1971, Launceston TAS 7250
Ph: 03 6332 6988 Fx: 03 6331 8300 www.cbmgroupp.com.au

Job No: 25191P
Project: CENTRAL COAST GRAMMAR
MULTI PURPOSE CENTRE (MPC)

13.07.2012	A	FOR DEVELOPMENT APPLICATION
13.07.2012	A	FOR DEVELOPMENT APPLICATION


Designed: CBM	Scale: 1:100	Dwg No: A207	Rev: A
Drawn: CBM	Size: A0	Dwg: LIGHTING PLAN	Copyright 2012
Checked: CBM			



FOYER PERSPECTIVE



NORTHERN PERSPECTIVE

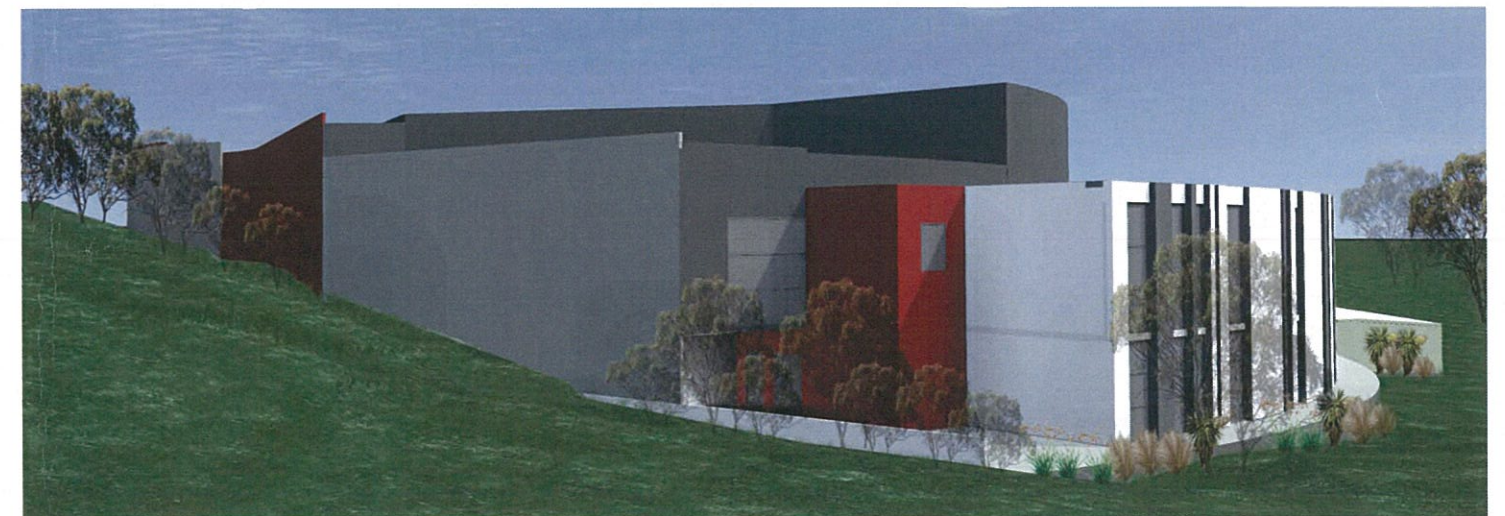

EASTERN BOUNDARY PERSPECTIVE



CBM Sustainable Design
 8 Broadland Dr, PO Box 1971, Louneston TAS 7250
 Ph: 03 6332 6988 Fax: 03 6331 8300 www.cbmgroupp.com.au

Job No: **25191P**
 Project: **CENTRAL COAST GRAMMAR
 MULTI PURPOSE CENTRE (MPC)**

Designed: CBM	Scale:
Drawn: CBM	
Checked: CBM	Size: A0
FOR DEVELOPMENT APPLICATION	
18.07.2012 A	
18.07.2012 A	

Dwg No: **A208** Rev: **A**
 Dwg: **EXTERNAL PERSPECTIVES** Copyright 2012




NOTES:

- FC.E HARDIE EASYLAP FIBRE CEMENT SHEET
- MT.T LYSAGHT TRIMDEK METAL SHEET
- CON TILT-UP CONCRETE PANELS
- BL.K CONCRETE BLOCK-WORK
- ALU ALUCOBOND ALUMINIUM COMPOSITE SHEET

ALL EXTERIOR GLAZING TO BE DOUBLE GLAZING AND POWDERCOATED ALUMINIUM FRAMES.

ALL MATERIALS TO BE INSTALLED TO MANUFACTURER'S SPECIFICATIONS.

ALL WORK TO COMPLY WITH BCA + RELEVANT AUSTRALIAN STANDARDS.

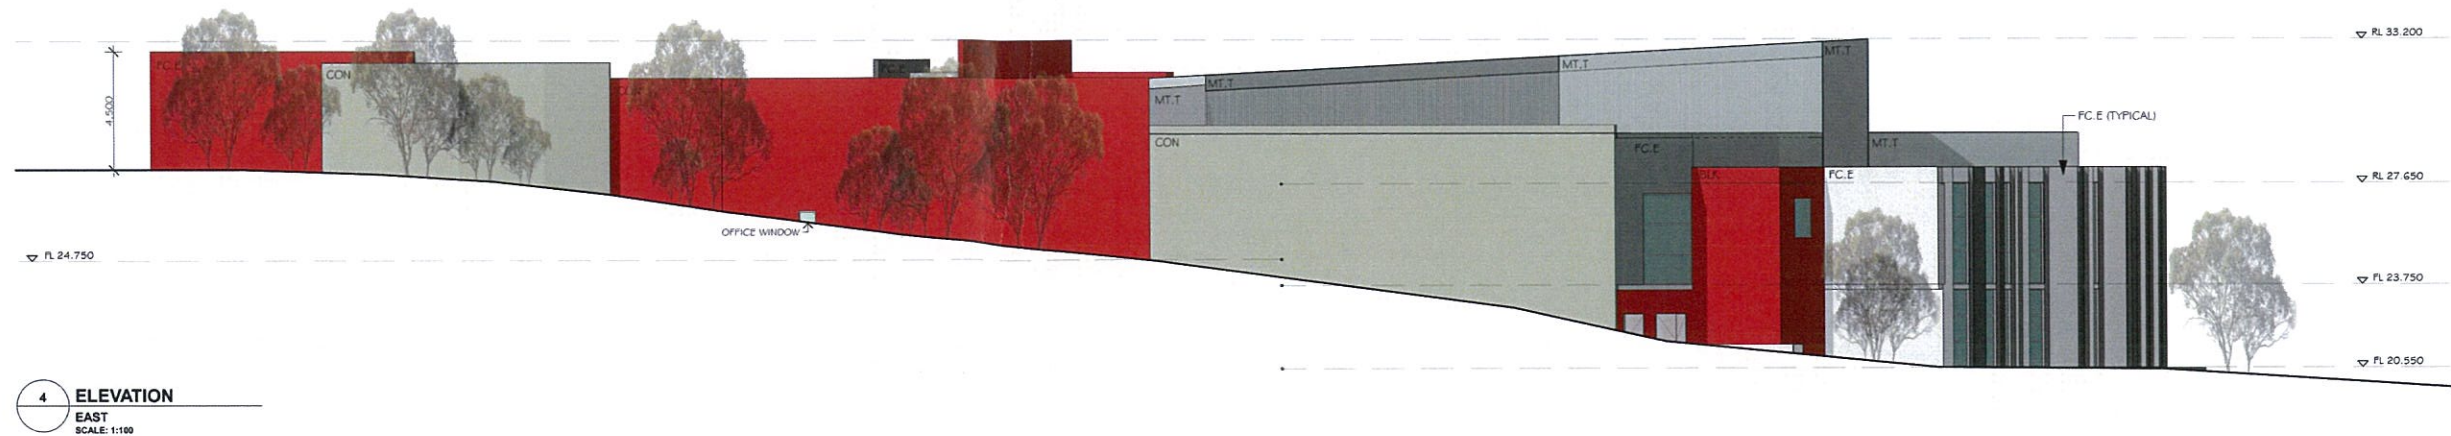


CBM Sustainable Design
8 Broadland Dr, PO Box 1971, Launceston TAS 7250
Ph: 03 6332 6988 Fax: 03 6331 8300 www.cbmgroupp.com.au


Job No: **25191P**
Project: **CENTRAL COAST GRAMMAR
MULTI PURPOSE CENTRE (MPC)**

Designed: CBM	Scale: 1:100	Dwg No: A301	Rev: A
Drawn: CBM	Size: A0	Dwg: ELEVATIONS 1	Copyright 2012
Checked: CBM	FOR DEVELOPMENT APPLICATION		

Drawings to be read in conjunction with written specifications. Written dimensions take precedence over scaled dimensions. All dimensions in millimetres.

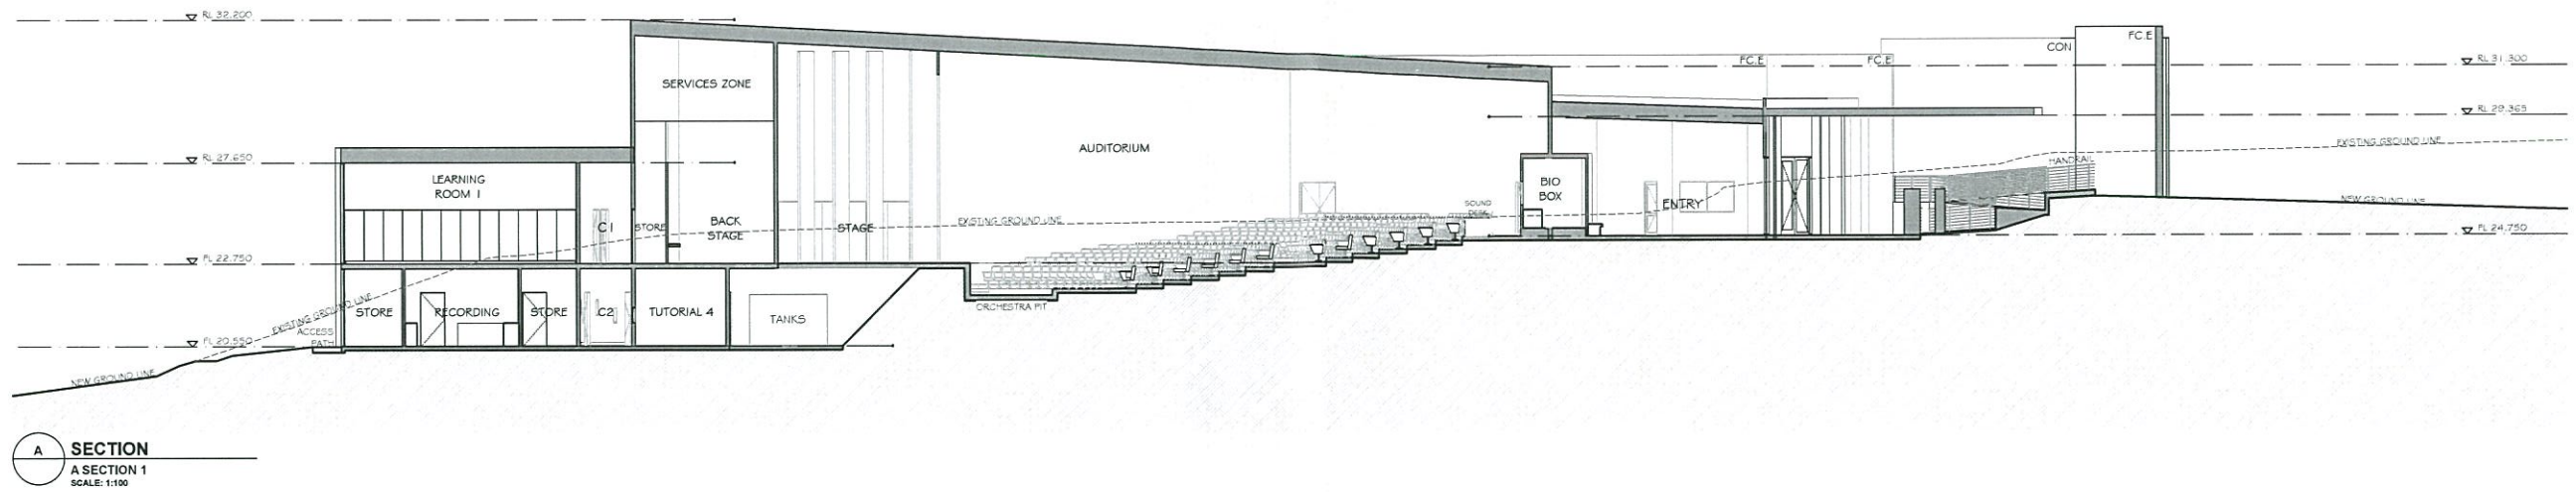

A SECTION
A SECTION 1
SCALE: 1:100

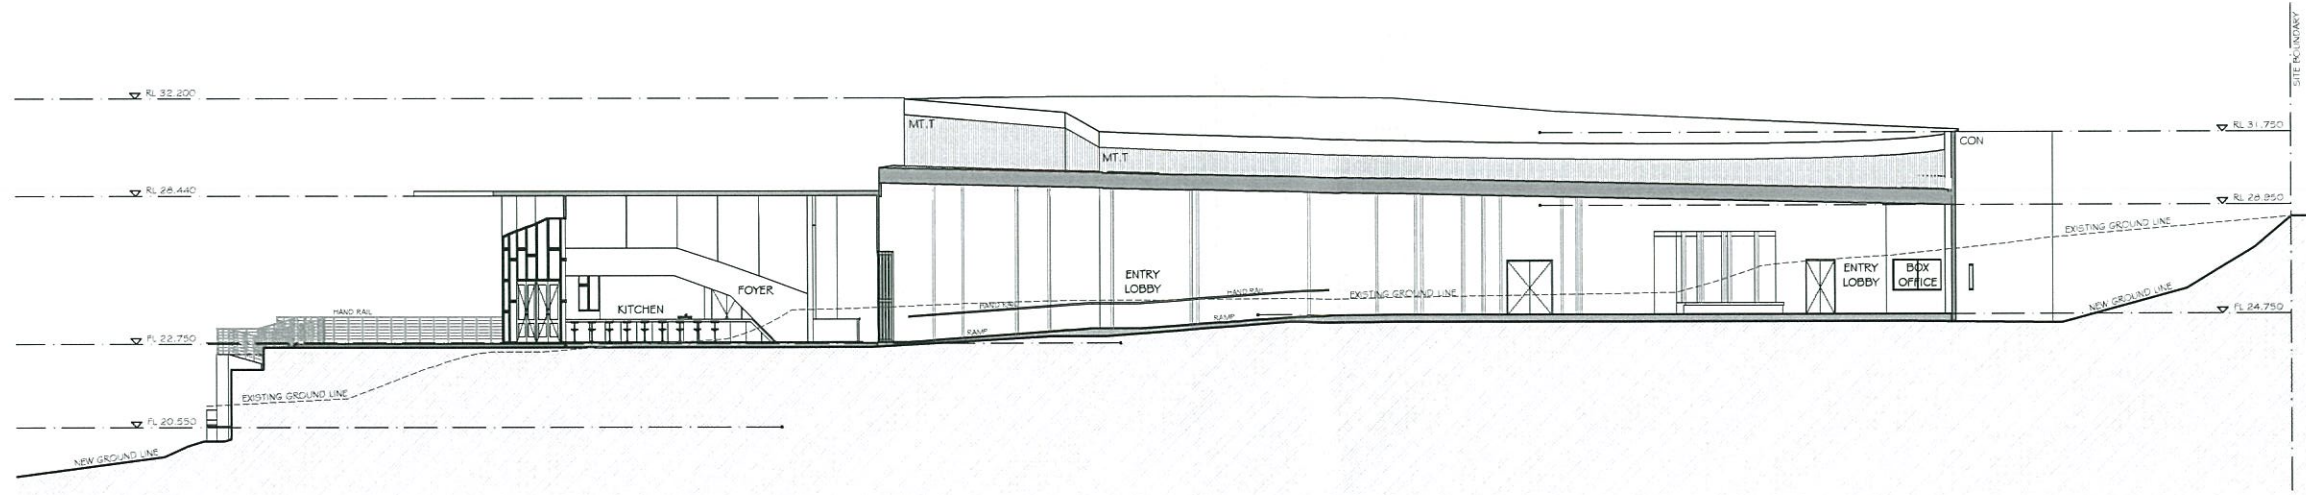

B SECTION
B SECTION 2
SCALE: 1:100

NOTES:

FC.E HARDIE EASYLAP FIBRE CEMENT SHEET
MT.T LYSAGHT TRIMDEK METAL SHEET
CON TILT-UP CONCRETE PANELS
RL REFERENCE LEVEL
FL FLOOR LEVEL
C CIRCULATION

ALL MATERIALS TO BE INSTALLED TO MANUFACTURER'S SPECIFICATIONS.



ALL WORK TO COMPLY WITH BCA + RELEVANT AUSTRALIAN STANDARDS.



CBM Sustainable Design
8 Broadland Dr, PO Box 1971, Launceston TAS 7250
Ph: 03 6332 6988 Fx: 03 6331 8300 www.cbmgroupp.com.au

Job No: **25191P**
Project: **CENTRAL COAST GRAMMAR
MULTI PURPOSE CENTRE (MPC)**

Designed: CBM	Scale: 1:100	Dwg No: A302	Rev: A
Drawn: CBM	Size: A0	Dwg: SECTIONS 1	Copyright 2012
Checked: CBM			

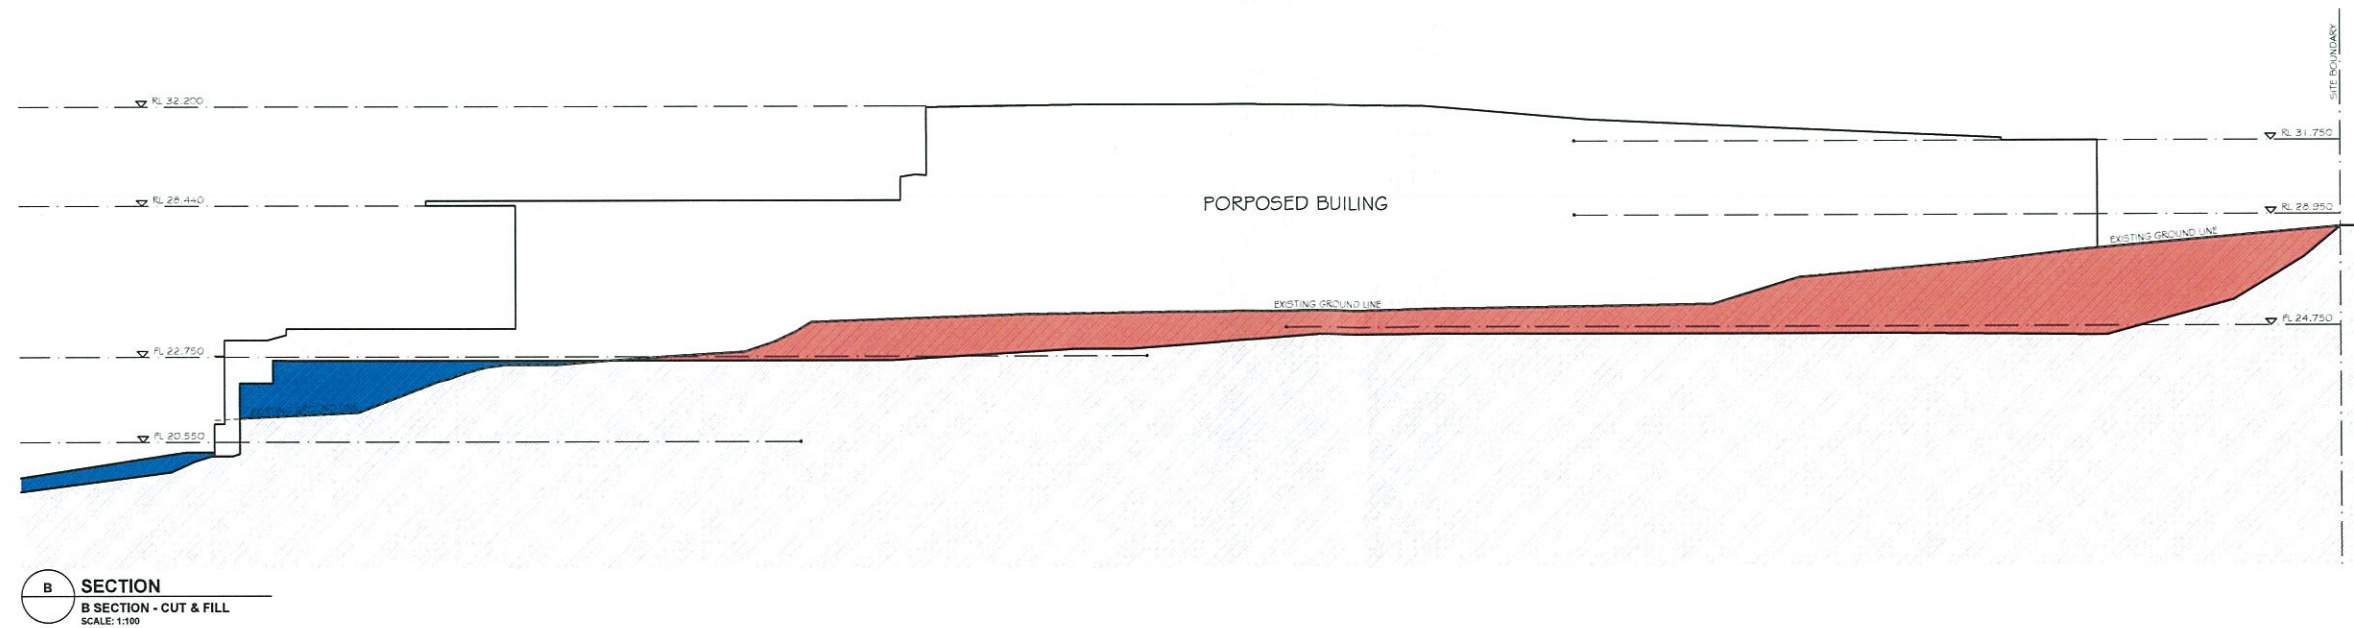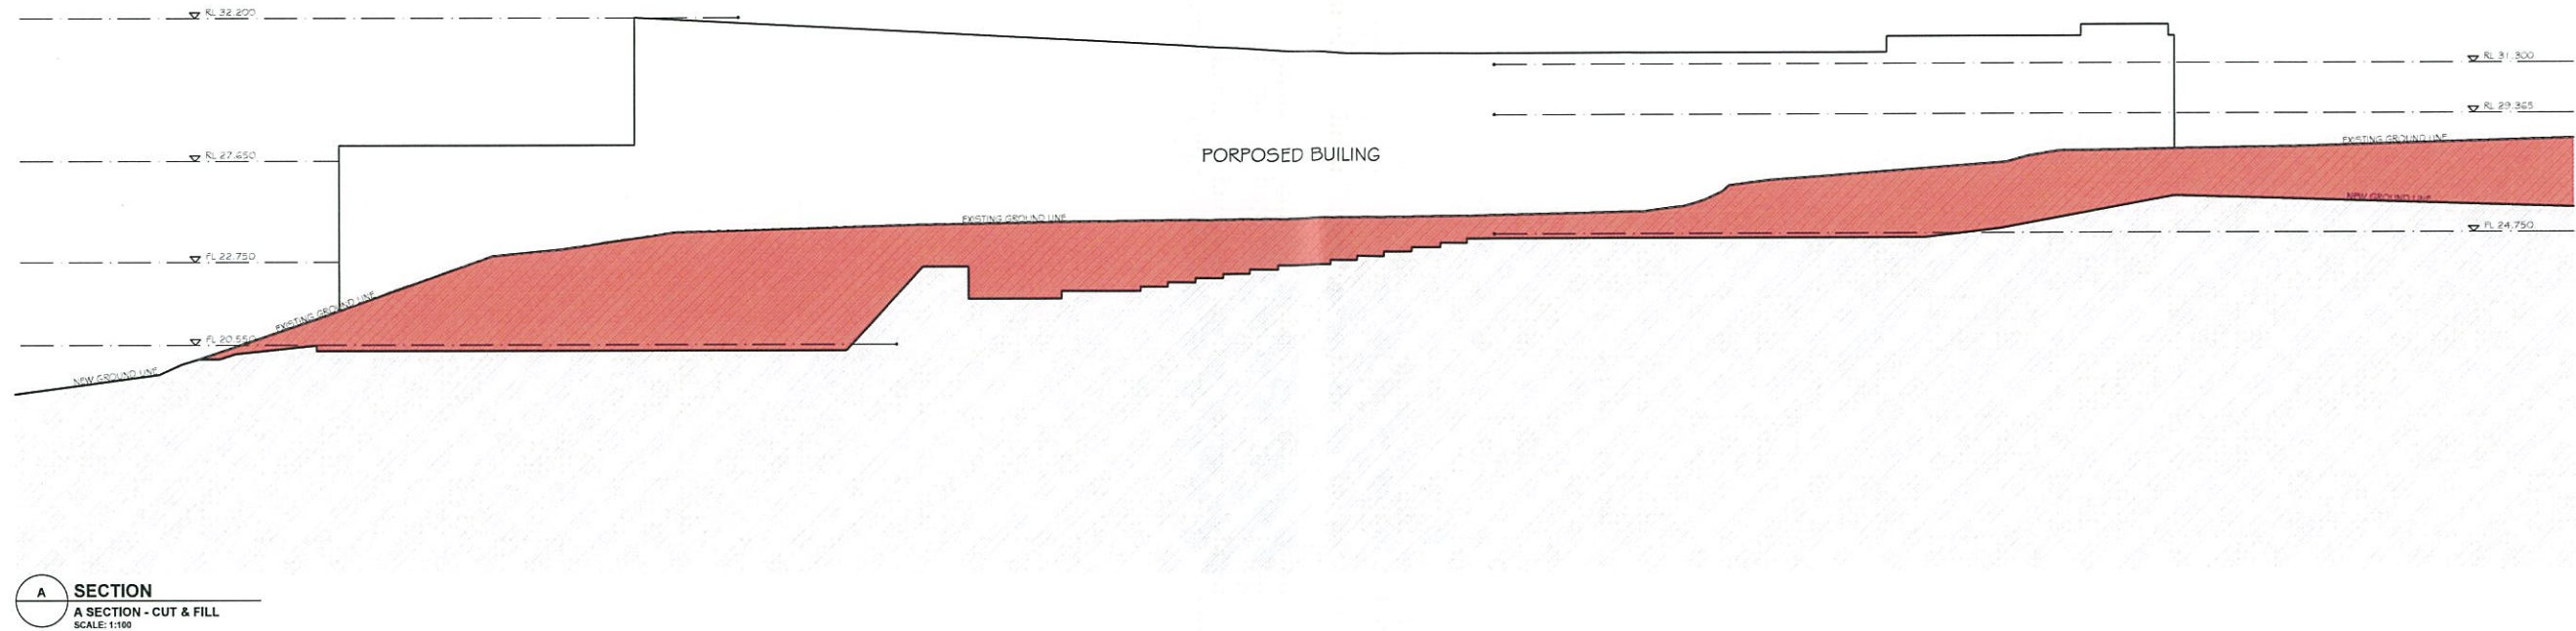

LEGEND

CUT
FILL



LEGEND

- TREES REMOVED
- TREES RETAINED
- TREES RETAINED IF POSSIBLE

1. PLAN
1. TREE LOCATIONS SCHEDULE
SCALE: 1:600



CBM Sustainable Design
8 Broadland Dr, PO Box 1971, Launceston TAS 7250
Ph: 03 6332 6988 Fx: 03 6331 8300 www.cbmgroupp.com.au

Job No: 25191P
Project: CENTRAL COAST GRAMMAR
MULTI PURPOSE CENTRE (MPC)

13.07.2012	A	FOR DEVELOPMENT APPLICATION
Date	Rev	Notes

Designed: CBM	Scale: 1:600	Dwg No: A202	Rev: A
Drawn: CBM	Size: A3	Dwg: TREE SCHEDULE	
Checked: CBM			

Drawings to be read in conjunction with written specifications. Written dimensions take precedence over scaled dimensions. All dimensions in millimetres.

Copyright 2012

