


ABBREVIATIONS

ACP	ALUMINIUM COMPOSITE PANEL
AP	ACCESS PANEL
AWN	AWNING RETRACTABLE
BAL	BALUSTRADE
BG	BOX GUTTER
BK	BLOCKWORK
CC	CONCRETE COLUMN
CL	CEILING TYPE
CJ	CONSTRUCTION JOINT
COW	CONCRETE
COS	CHECK ON SITE
EDB	ELECTRICAL DISTRIBUTION BOARD
ELEC	ELECTRICAL RISER
EP#	EXTERNAL PAINT FINISH
EX	EXISTING
FAC	METAL FASCIA
FC	FIBRE CEMENT SHEET
FCL	FINISHED CEILING LEVEL (ABOVE FFL)
FCU	FAN COIL UNIT
FE	FIRE EXTINGUISHER
FFL	FINISH FLOOR LEVEL
FG	FIXED GLAZING
FHR	FIRE HOSE REEL
FIP	FIRE INSPECTION PANEL
FU	FURRING CHANNEL
G	GLASS TYPES
GD	GRATED DRAIN
GF	GLAZED FACADE
HR	HAND RAIL
HYD	HYDRAULIC RISER
HWU	HOT WATER UNIT
INS	INSULATION
KE	KITCHEN EXHAUST
LV	LOUVRES
MS	METAL SHEET SOFFIT
MSB	MAIN SWITCHBOARD
MC	MECHANICAL SERVICES
MDF	MEDIUM DENSITY FIBRE BOARD
MH	MANHOLE
MS	METAL STUD/METAL FRAME
OF	OVERALL
OG	OPERABLE GLAZING
PB	PLASTERBOARD
PB/FR	PLASTERBOARD / FIRE RATED
PCP	PRECAST CONCRETE PANELS
PV	PHOTOVOLTAIC PANELS
RA	RETURN AIR
RGL	ROOF GLAZING
RL	RELATIVE LEVEL
RMS	ROOF METAL SHEETING
RWO	RAIN WATER OUTLET
SA	SUPPLY AIR
SD	SLIDING DOOR
SE	SMOKE EXHAUST
SFS	SURFACE FINISHER SEALER
SS	STAINLESS STEEL
SSL	STRUCTURAL SLAB LEVEL
SVP	SEWER VENT PIPE
TBC	TO BE CONFIRMED
TCP	TIMBER CLADDING PANELS
TE	TOILET EXHAUST
TGSI	TACTILE GROUND SURFACE INDICATORS
TS	TIMBER BATTEN PRIVACY SCREEN
UIS	UNDER SIDE
WPM	WATERPROOFING MEMBRANE

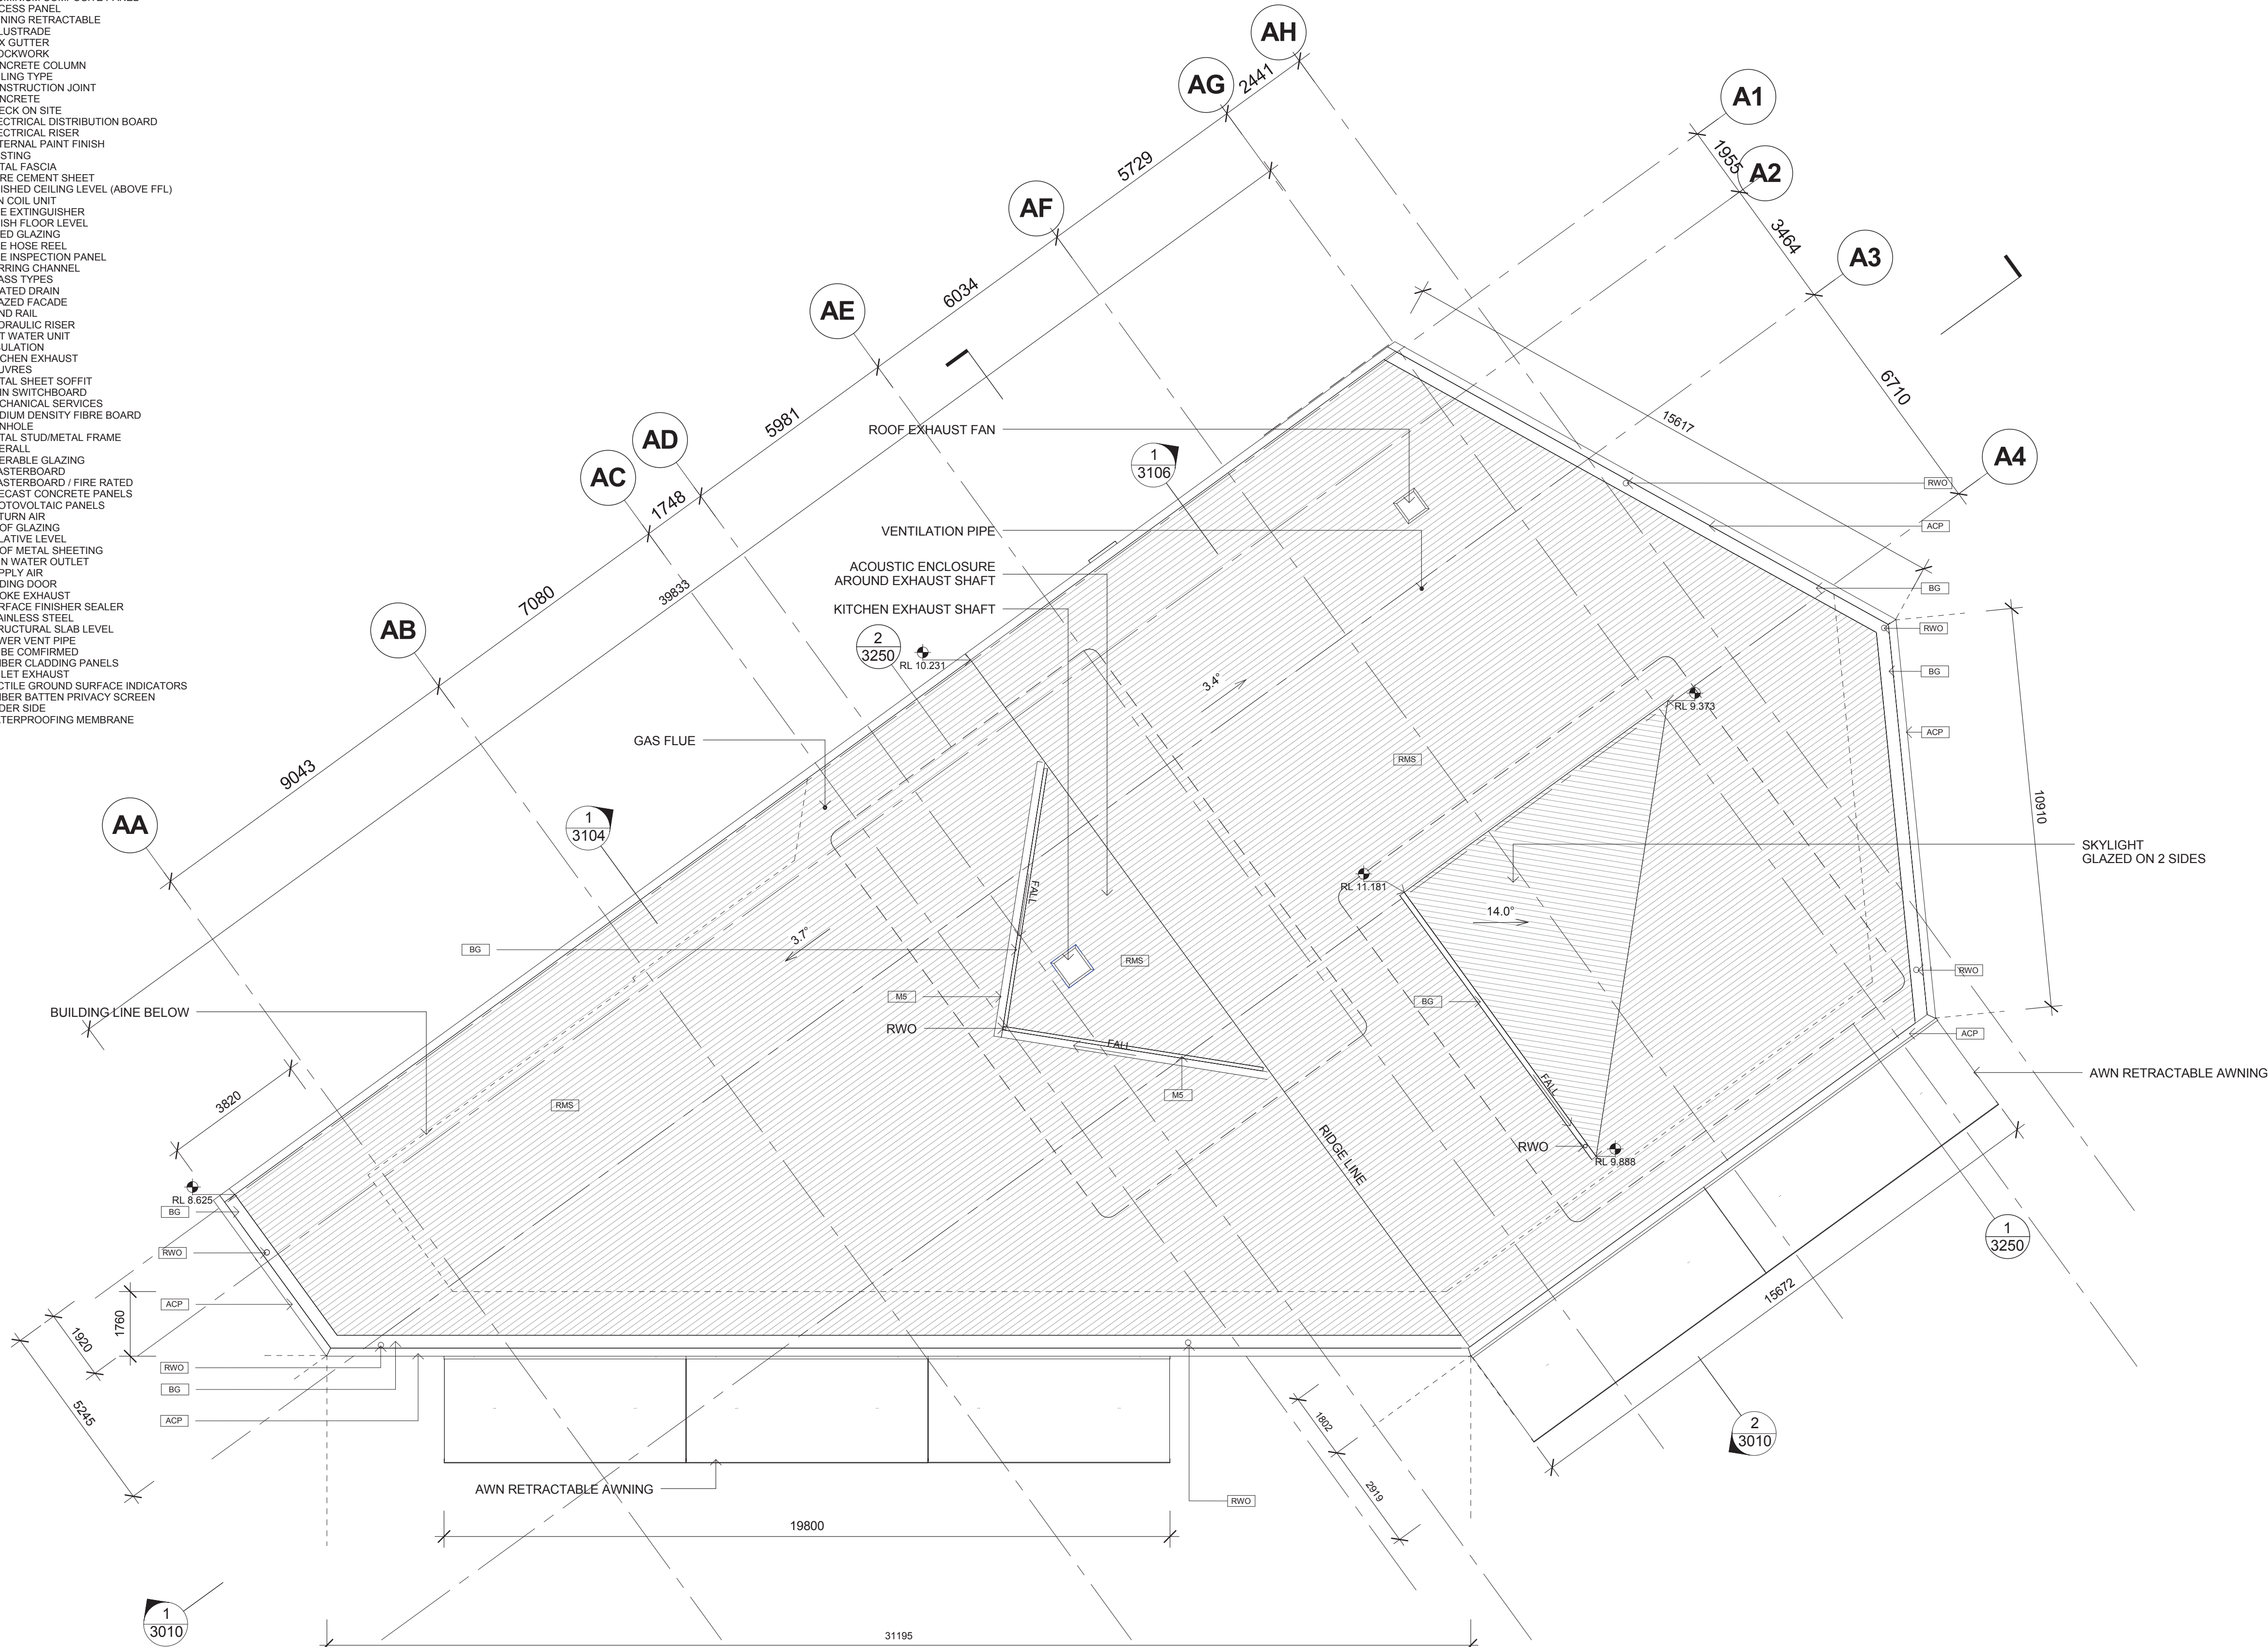

Notes

All dimensions and setbacks to be verified prior to commencement, omissions or discrepancies to be notified to the architect.

Copyright

The copyright of this drawing together with any other documents prepared by crone partners architecture studios. ply ltd (cp) remains the property of cp. crone partners grants licence for the use of this document for the purpose for which they are intended. The licence is not transferable without the permission of cp.

Quality Assurance System

Authorised By: AD Date: 16.06.14

KEY

C	DEVELOPMENT APPLICATION REVISION	AVH	27.11.14
B	DEVELOPMENT APPLICATION REVISION	AVH	16.06.14
A	DEVELOPMENT APPLICATION REVISION	AVH	06.05.14

Client

<p>Structural Engineer TAYLOR THOMSON WHITTING Level 3, 48 Chandos Street, St Leonards NSW 2065 Ph: (+612) 94397288</p>	<p>Service Consultant WOOD AND GRIEVE ENGINEERS L6, Building B, 207 Pacific Highway, St Leonards, New South Wales, 2065 Ph: (+612) 94697288</p>
<p>ESD Consultant CRONE PARTNERS Level 2, 364 Kent Street Sydney, NSW 2000 Ph: (+612) 8295 5300</p>	<p>Landscape Architect URBIS Tower 2, Level 23, Darling Park, 201 Sussex St. Sydney, NSW 2000 Ph: (+612) 8233 9900</p>
<p>Civil Engineer TAYLOR THOMSON WHITTING Level 3, 48 Chandos Street, St Leonards NSW 2065 Ph: (+612) 94397288</p>	<p>BCA Consultant CITY PLAN SERVICES Level 1, 384 Kent Street, Sydney, NSW 2000 Ph: (+612) 8270 3500</p>
<p>Cost Consultant MITCHELL BRANDTMAN Unit 10, 15-23 Kumulla Rd Miranda, NSW 2226 Ph: (+612) 95418000</p>	<p>Planning Consultant URBIS Tower 2, Level 23, Darling Park, 201 Sussex St. Sydney, NSW 2000 Ph: (+612) 8233 9900</p>

Architect

cronepartners

Crone Partners
level 2, 364 kent street,
sydney, nsw 2000, australia
Ph: +61 2 8295 5300
Fax: +61 2 8295 5301

Project

RHODES COMMUNITY FACILITIES AND RESTAURANT

30 Shoreline Drive, Rhodes 2138


Drawn: AH Checked: AD Date: 27/11/14 Scale As indicated

Drawing Title
ROOF PLAN - BUILDING A

Scale Bar: 0 1000 2000 3000 4000 5000 mm
SCALE 1:100 AT ORIGINAL SIZE

DEVELOPMENT APPLICATION

CA 3138 Project no.	DA Drawing Phase.	1007 Drawing No.	C Rev
-------------------------------	-----------------------------	----------------------------	-----------------

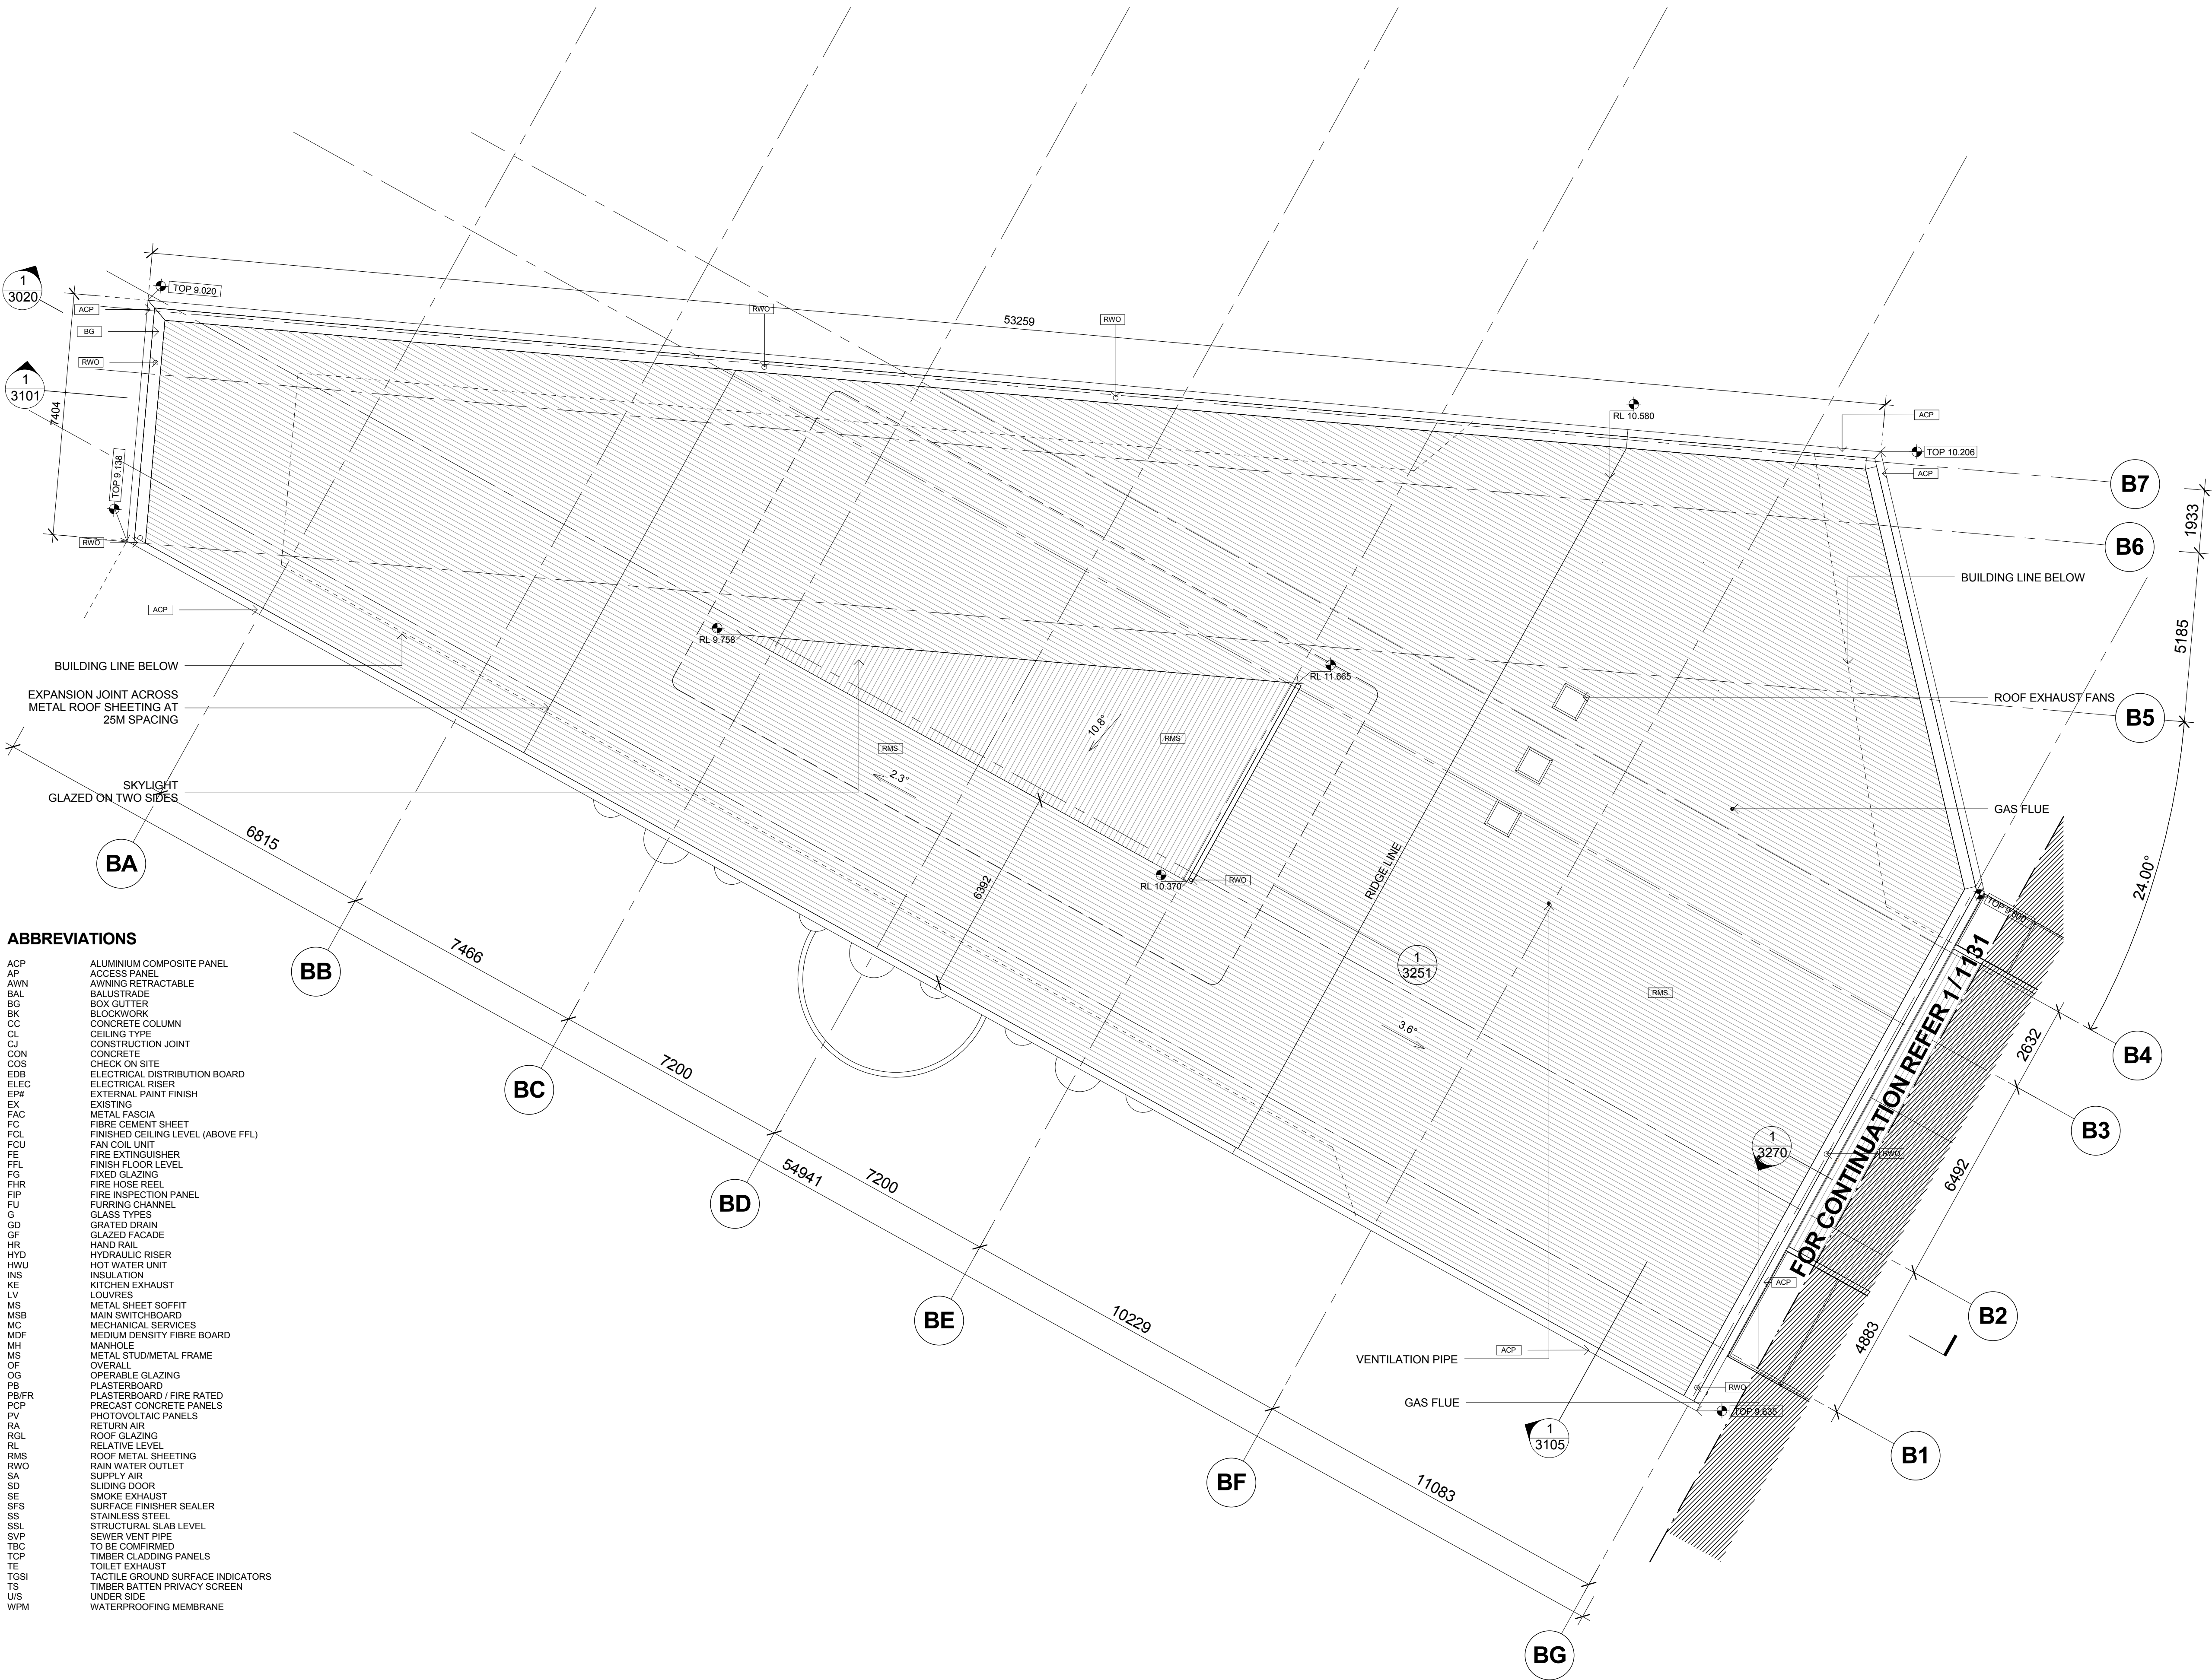

ABBREVIATIONS	
ACP	ALUMINIUM COMPOSITE PANEL
AP	ACCESS PANEL
AWN	AWNING RETRACTABLE
BAL	BALUSTRADE
BG	BOX GUTTER
BK	BLOCKWORK
CC	CONCRETE COLUMN
CL	CEILING TYPE
CJ	CONSTRUCTION JOINT
CON	CONCRETE
COS	CHECK ON SITE
EDB	ELECTRICAL DISTRIBUTION BOARD
ELEC	ELECTRICAL RISER
EPF	EXTERNAL PAINT FINISH
EX	EXISTING
FAC	METAL FASCIA
FC	FIBRE CEMENT SHEET
FCL	FINISHED CEILING LEVEL (ABOVE FFL)
FCU	FAN COIL UNIT
FE	FIRE EXTINGUISHER
FFL	FINISH FLOOR LEVEL
FG	FIXED GLAZING
FHR	FIRE HOSE REEL
FIP	FIRE INSPECTION PANEL
FU	FURRING CHANNEL
G	GLASS TYPES
GD	GRATED DRAIN
GF	GLAZED FACADE
HYD	HYDRAULIC RISER
HWU	HOT WATER UNIT
INS	INSULATION
KE	KITCHEN EXHAUST
LV	LOUVRES
MS	METAL SHEET SOFFIT
MSB	MAIN SWITCHBOARD
MC	MECHANICAL SERVICES
MDF	MEDIUM DENSITY FIBRE BOARD
MH	MANHOLE
MS	METAL STUD/METAL FRAME
OF	OVERALL
OG	OPERABLE GLAZING
PB	PLASTERBOARD
PB/FR	PLASTERBOARD / FIRE RATED
PCP	PRECAST CONCRETE PANELS
PV	PHOTOVOLTAIC PANELS
RA	RETURN AIR
RGL	ROOF GLAZING
RL	RELATIVE LEVEL
RMS	ROOF METAL SHEETING
RWO	RAIN WATER OUTLET
SA	SUPPLY AIR
SD	SLIDING DOOR
SE	SMOKE EXHAUST
SFS	SURFACE FINISHER SEALER
SS	STAINLESS STEEL
SSL	STRUCTURAL SLAB LEVEL
SVIP	SEWER VENT PIPE
TBC	TO BE CONFIRMED
TCP	TIMBER CLADDING PANELS
TE	TOILET EXHAUST
TGSI	TACTILE GROUND SURFACE INDICATORS
US	TIMBER BATTEN PRIVACY SCREEN
WPM	UNDER SIDE
	WATERPROOFING MEMBRANE

Notes

All dimensions and setbacks to be verified prior to commencement, omissions or discrepancies to be notified to the architect.

Copyright

The copyright of this drawing together with any other documents prepared by crone partners architecture studios. ply ltd (cp) remains the property of cp. crone partners grants licence for the use of this document for the purpose for which they are intended. The licence is not transferable without the permission of cp.

Quality Assurance System

Authorised By: ADDate: 03.12.14

KEY

C	DEVELOPMENT APPLICATION REVISION	AVH	03.12.14
B	DEVELOPMENT APPLICATION REVISION	AVH	16.06.14
A	DEVELOPMENT APPLICATION REVISION	AVH	06.05.14

Client

Structural Engineer TAYLOR THOMSON WHITTING Level 3, 48 Chandos Street, St Leonards NSW 2065 Ph: (+612) 94397288	Service Consultant WOOD AND GRIEVE ENGINEERS L6, Building B, 207 Pacific Highway, St Leonards, New South Wales, 2065 Ph: (+612) 94687000
ESD Consultant CRONE PARTNERS Level 2, 364 Kent Street Sydney, NSW 2000 Ph: (+612) 8295 5300	Landscape Architect URBIS Tower 2, Level 23, Darling Park, 201 Sussex St. Sydney, NSW 2000 Ph: (+612) 8233 9900
Civil Engineer TAYLOR THOMSON WHITTING Level 3, 48 Chandos Street, St Leonards NSW 2065 Ph: (+612) 94397288	BCA Consultant CITY PLAN SERVICES Level 1, 384 Kent Street, Sydney, NSW 2000 Ph: (+612) 8270 3500
Cost Consultant MITCHELL BRANDTMAN Unit 10, 15 - 23 Kumulla Rd Miranda, NSW 2228 Ph: (+612) 95418000	Planning Consultant URBIS Tower 2, Level 23, Darling Park, 201 Sussex St. Sydney, NSW 2000 Ph: (+612) 8233 9900

Architect

cronepartners

Crone Partners
level 2, 364 kent street,
sydney, nsw 2000, australia
Ph: +61 2 8295 5300
Fax: +61 2 8295 5301

Project

RHODES COMMUNITY FACILITIES AND RESTAURANT

30 Shoreline Drive, Rhodes 2138

Drawn: AHChecked: ADDate: 03/12/14Scale As indicated

Drawing Title

ROOF PLAN - BUILDING B


Scale Bar:

0 1000 2000 3000 4000 5000 mm

SCALE 1:100 AT ORIGINAL SIZE

DEVELOPMENT APPLICATION

CA 3138	DA	1008	C
Project no.	Drawing Phase.	Drawing No.	Rev

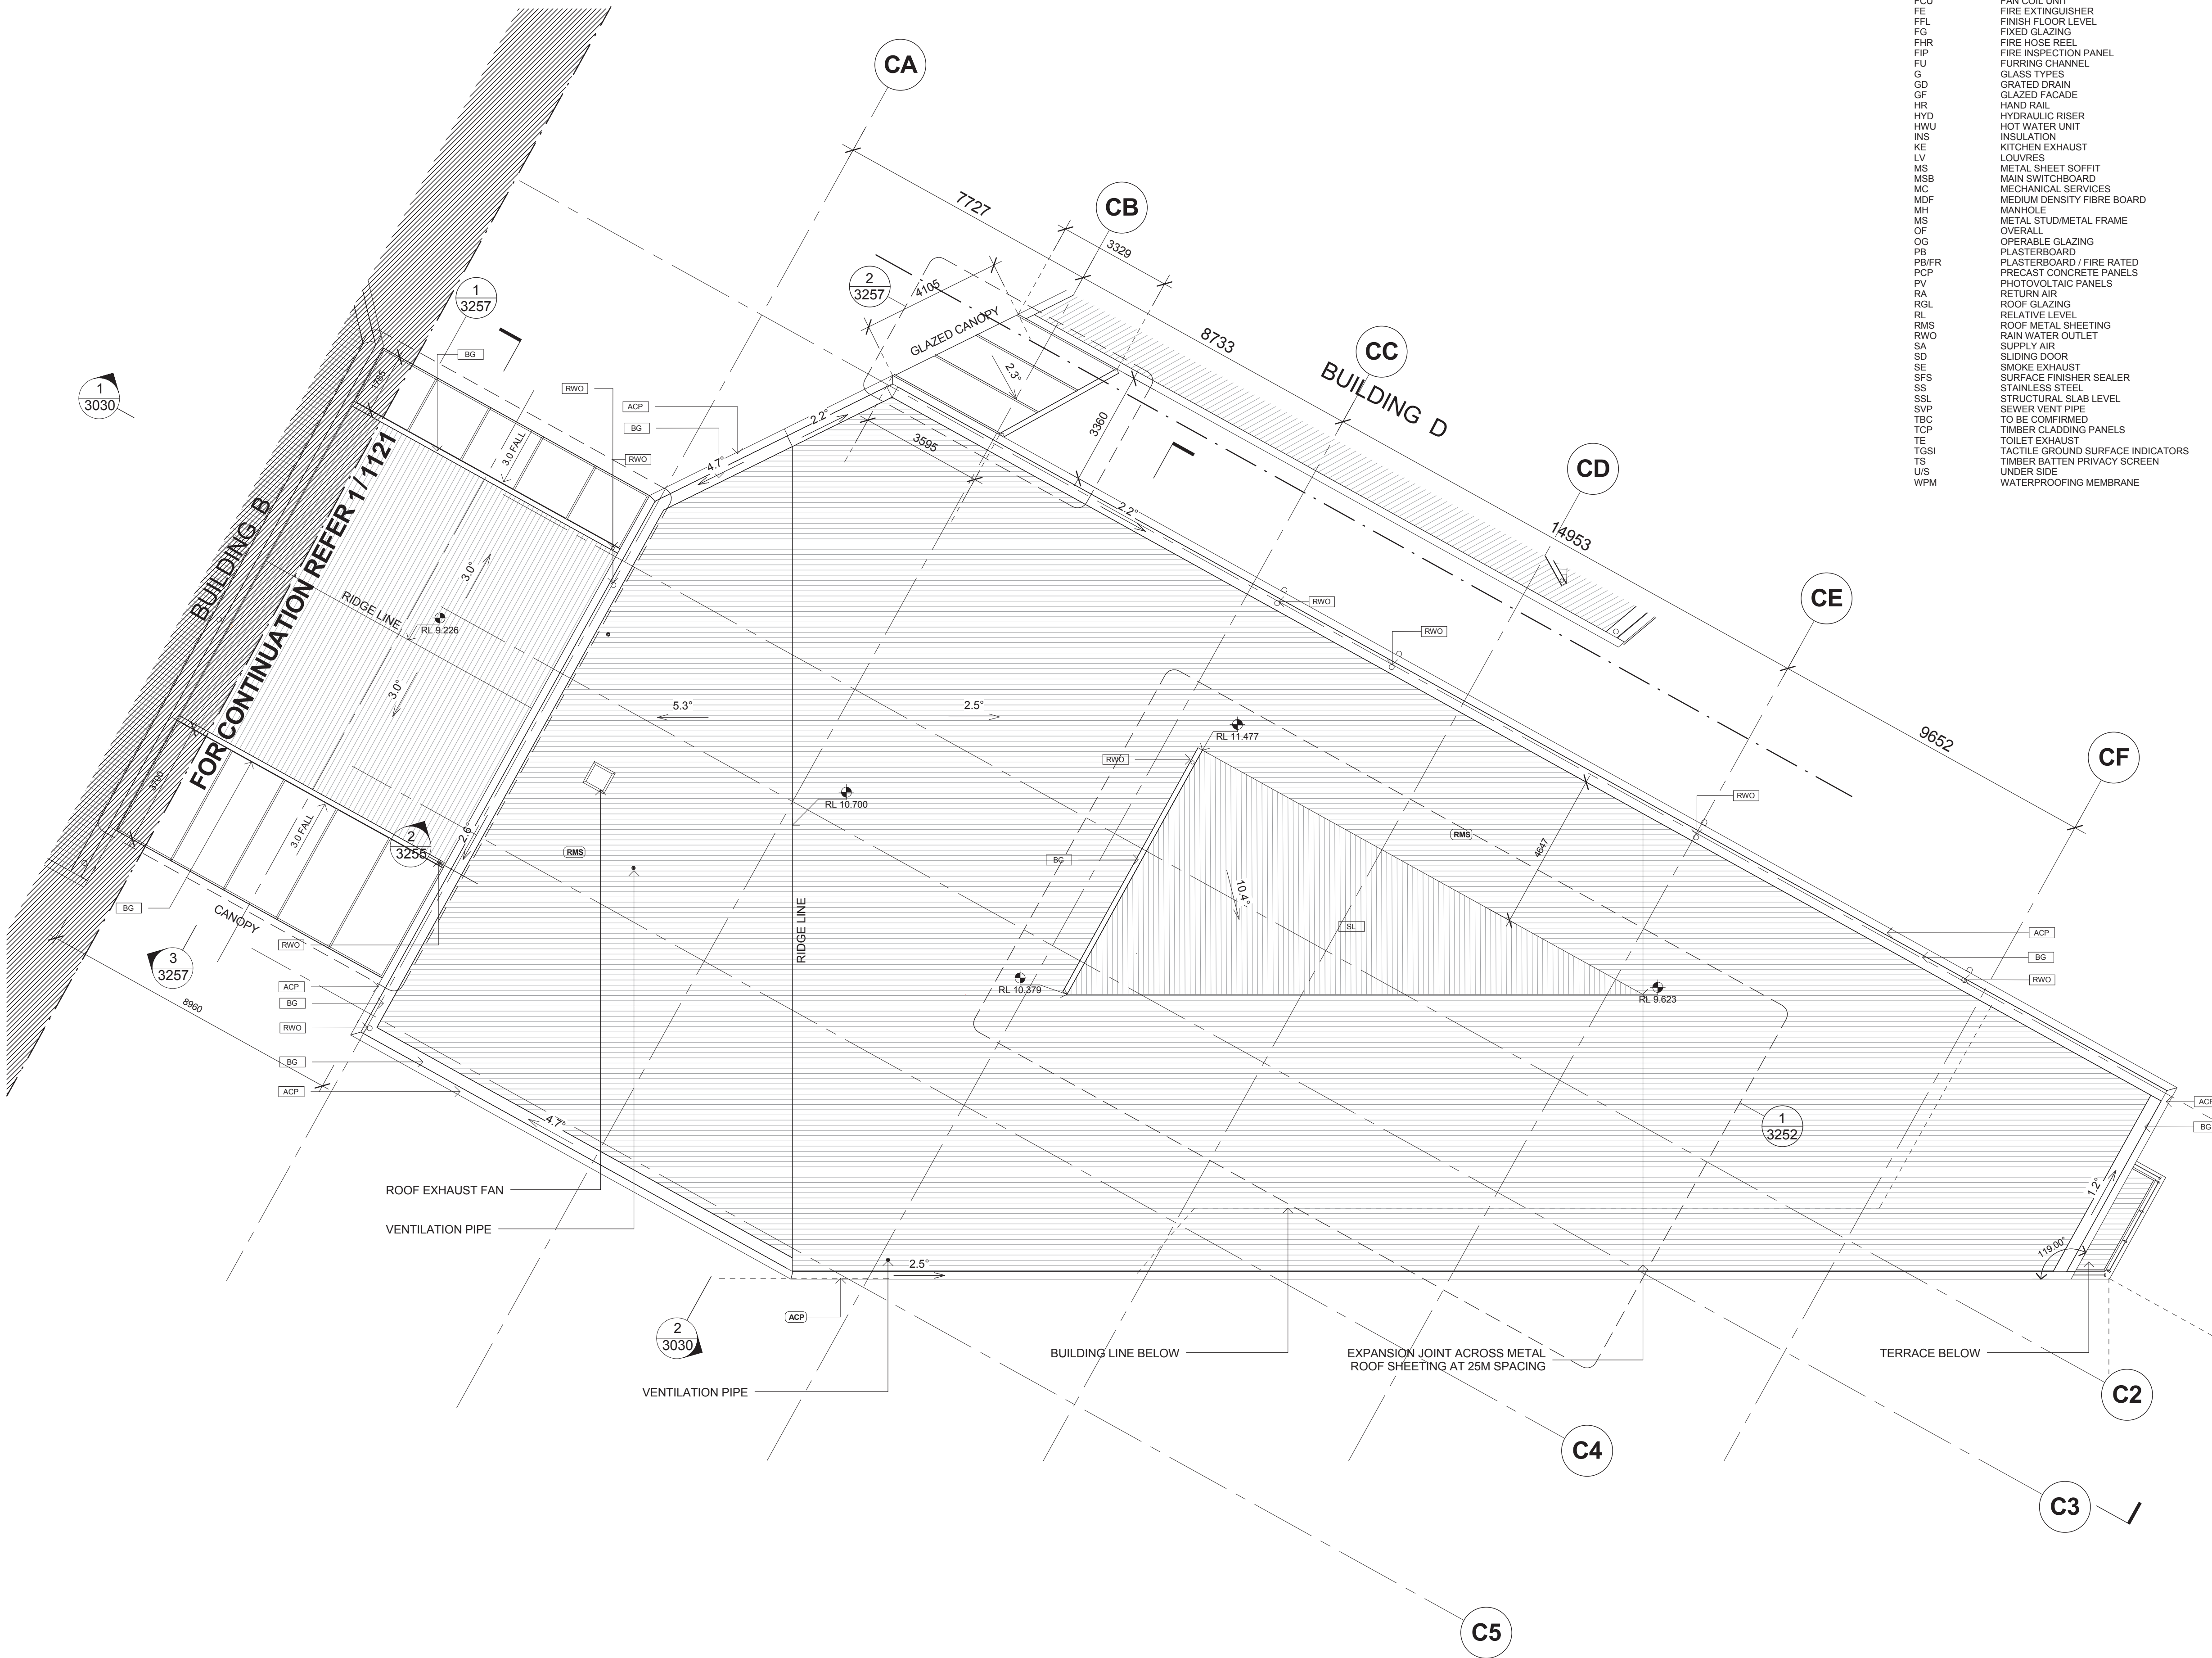

ABBREVIATIONS

ACP	ALUMINIUM COMPOSITE PANEL
AP	ACCESS PANEL
AWN	AWNING RETRACTABLE
BAL	BALUSTRADE
BG	BOX GUTTER
BK	BLOCKWORK
CC	CONCRETE COLUMN
CL	CEILING TYPE
CJ	CONSTRUCTION JOINT
CON	CONCRETE
COS	CHECK ON SITE
EDB	ELECTRICAL DISTRIBUTION BOARD
ELEC	ELECTRICAL RISER
EP#	EXTERNAL PAINT FINISH
EX	EXISTING
FAC	METAL FASCIA
FC	FIBRE CEMENT SHEET
FCFL	FINISHED CEILING LEVEL (ABOVE FFL)
FCU	FAN COIL UNIT
FE	FIRE EXTINGUISHER
FFL	FINISH FLOOR LEVEL
FG	FIXED GLAZING
FHR	FIRE HOSE REEL
FIP	FIRE INSPECTION PANEL
FU	FURRING CHANNEL
G	GLASS TYPES
GD	GRATED DRAIN
GF	GLAZED FACADE
HR	HAND RAIL
HYD	HYDRAULIC RISER
HWU	HOT WATER UNIT
INS	INSULATION
KE	KITCHEN EXHAUST
LV	LOUVRES
MS	METAL SHEET SOFFIT
MSB	MAIN SWITCHBOARD
MC	MECHANICAL SERVICES
MDF	MEDIUM DENSITY FIBRE BOARD
MH	MANHOLE
MS	METAL STUD/METAL FRAME
OF	OVERALL
OG	OPERABLE GLAZING
PB	PLASTERBOARD
PB/FR	PLASTERBOARD / FIRE RATED
PCP	PRECAST CONCRETE PANELS
PV	PHOTOVOLTAIC PANELS
RA	RETURN AIR
RGL	ROOF GLAZING
RL	RELATIVE LEVEL
RMS	ROOF METAL SHEETING
RWO	RAIN WATER OUTLET
SA	SUPPLY AIR
SD	SLIDING DOOR
SE	SMOKE EXHAUST
SFS	SURFACE FINISHER SEALER
SS	STAINLESS STEEL
SSL	STRUCTURAL SLAB LEVEL
SVP	SEWER VENT PIPE
TBC	TO BE CONFIRMED
TCP	TIMBER CLADDING PANELS
TE	TOILET EXHAUST
TGSI	TACTILE GROUND SURFACE INDICATORS
TS	TIMBER BATTEN PRIVACY SCREEN
U/S	UNDER SIDE
WPM	WATERPROOFING MEMBRANE

Notes

All dimensions and setbacks to be verified prior to commencement, omissions or discrepancies to be notified to the architect.

Copyright


The copyright of this drawing together with any other documents prepared by crone partners architecture studios. ply ltd (cp) remains the property of cp. crone partners grants licence for the use of this document for the purpose for which they are intended. The licence is not transferable without the permission of cp.

Quality Assurance System

Authorised By: AD

Date: 27.11.14

KEY

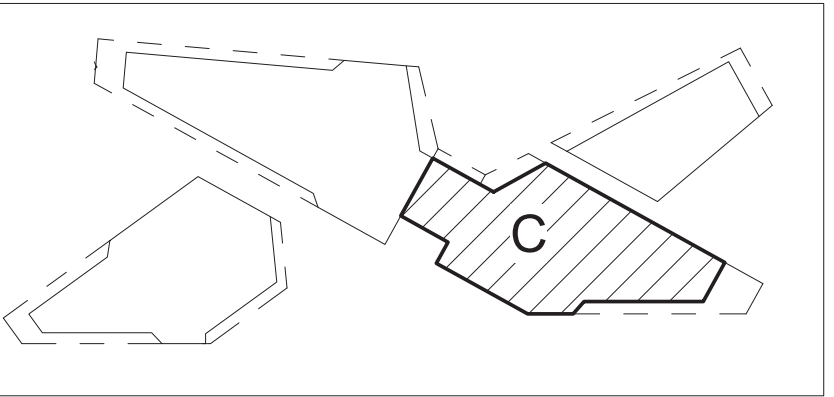

C	DEVELOPMENT APPLICATION REVISION	AVH	27.11.14
B	DEVELOPMENT APPLICATION REVISION	AVH	16.06.14
A	DEVELOPMENT APPLICATION REVISION	AVH	06.05.14

Client



Structural Engineer TAYLOR THOMSON WHITTING Level 3, 48 Chandos Street, St Leonards NSW 2065 Ph: (+612) 94397288	Service Consultant WOOD AND GRIEVE ENGINEERS L6, Building B, 207 Pacific Highway, St Leonards, New South Wales, 2065 Ph: (+612) 94647000
---	---

ESD Consultant CRONE PARTNERS Level 2, 364 Kent Street Sydney, NSW 2000 Ph: (+612) 8295 5300	Landscape Architect URBIS Tower 2, Level 23, Darling Park, 201 Sussex St. Sydney, NSW 2000 Ph: (+612) 8233 9900
---	--

Civil Engineer TAYLOR THOMSON WHITTING Level 3, 48 Chandos Street, St Leonards NSW 2065 Ph: (+612) 94397288	BCA Consultant CITY PLAN SERVICES Sydney, NSW 2000 Ph: (+612) 8270 3500
--	---

Cost Consultant MITCHELL BRANDTMAN Unit 10, 15-23 Kumulla Rd Miranda, NSW 2226 Ph: (+612) 95418000	Planning Consultant URBIS Tower 2, Level 23, Darling Park, 201 Sussex St. Sydney, NSW 2000 Ph: (+612) 8233 9900
---	--

Architect

cronepartners

Crone Partners
level 2, 364 kent street,
sydney, nsw 2000, australia
Ph: +61 2 8295 5300
Fax: +61 2 8295 5301

Project
RHODES COMMUNITY FACILITIES AND RESTAURANT

30 Shoreline Drive, Rhodes 2138

Drawn: AH Checked: AD Date: 27/11/14 Scale As indicated

Drawing Title
ROOF PLAN - BUILDING C


Scale Bar: 0 1000 2000 3000 4000 5000 mm
SCALE 1:100 AT ORIGINAL SIZE

DEVELOPMENT APPLICATION

CA 3138	DA	1009	C
Project no.	Drawing Phase.	Drawing No.	Rev

ABBREVIATIONS

ACP	ALUMINIUM COMPOSITE PANEL
AP	ACCESS PANEL
AWN	AWNING RETRACTABLE
BAL	BALUSTRADE
BG	BOX GUTTER
BK	BLOCKWORK
CC	CONCRETE COLUMN
CL	CEILING TYPE
CJ	CONSTRUCTION JOINT
CON	CONCRETE
COS	CHECK ON SITE
EDB	ELECTRICAL DISTRIBUTION BOARD
ELEC	ELECTRICAL RISER
EP#	EXTERNAL PAINT FINISH
EX	EXISTING
FAC	METAL FASCIA
FC	FIBRE CEMENT SHEET
FCL	FINISHED CEILING LEVEL (ABOVE FFL)
FCU	FAN COIL UNIT
FE	FIRE EXTINGUISHER
FFL	FINISH FLOOR LEVEL
FG	FIXED GLAZING
FHR	FIRE HOSE REEL
FIP	FIRE INSPECTION PANEL
FU	FURRING CHANNEL
G	GLASS TYPES
GD	GRADED DRAIN
GF	GLAZED FACADE
HR	HAND RAIL
HYD	HYDRAULIC RISER
HWU	HOT WATER UNIT
INS	INSULATION
KE	KITCHEN EXHAUST
LV	LOUVRES
MS	METAL SHEET SOFFIT
MSB	MAIN SWITCHBOARD
MC	MECHANICAL SERVICES
MDF	MEDIUM DENSITY FIBRE BOARD
MH	MANHOLE
MS	METAL STUD/METAL FRAME
OF	OVERALL
OG	OPERABLE GLAZING
PB	PLASTERBOARD
PB/FR	PLASTERBOARD / FIRE RATED
PCP	PRECAST CONCRETE PANELS
PV	PHOTOVOLTAIC PANELS
RA	RETURN AIR
RGL	ROOF GLAZING
RL	RELATIVE LEVEL
RMS	ROOF METAL SHEETING
RWO	RAIN WATER OUTLET
SA	SUPPLY AIR
SD	SLIDING DOOR
SE	SMOKE EXHAUST
SFS	SURFACE FINISHER SEALER
SS	STAINLESS STEEL
SSL	STRUCTURAL SLAB LEVEL
SVP	SEWER VENT PIPE
TBC	TO BE CONFIRMED
TOP	TIMBER CLADDING PANELS
TE	TOILET EXHAUST
TGSI	TACTILE GROUND SURFACE INDICATORS
TS	TIMBER BATTEN PRIVACY SCREEN
US	UNDER SIDE
WPM	WATERPROOFING MEMBRANE

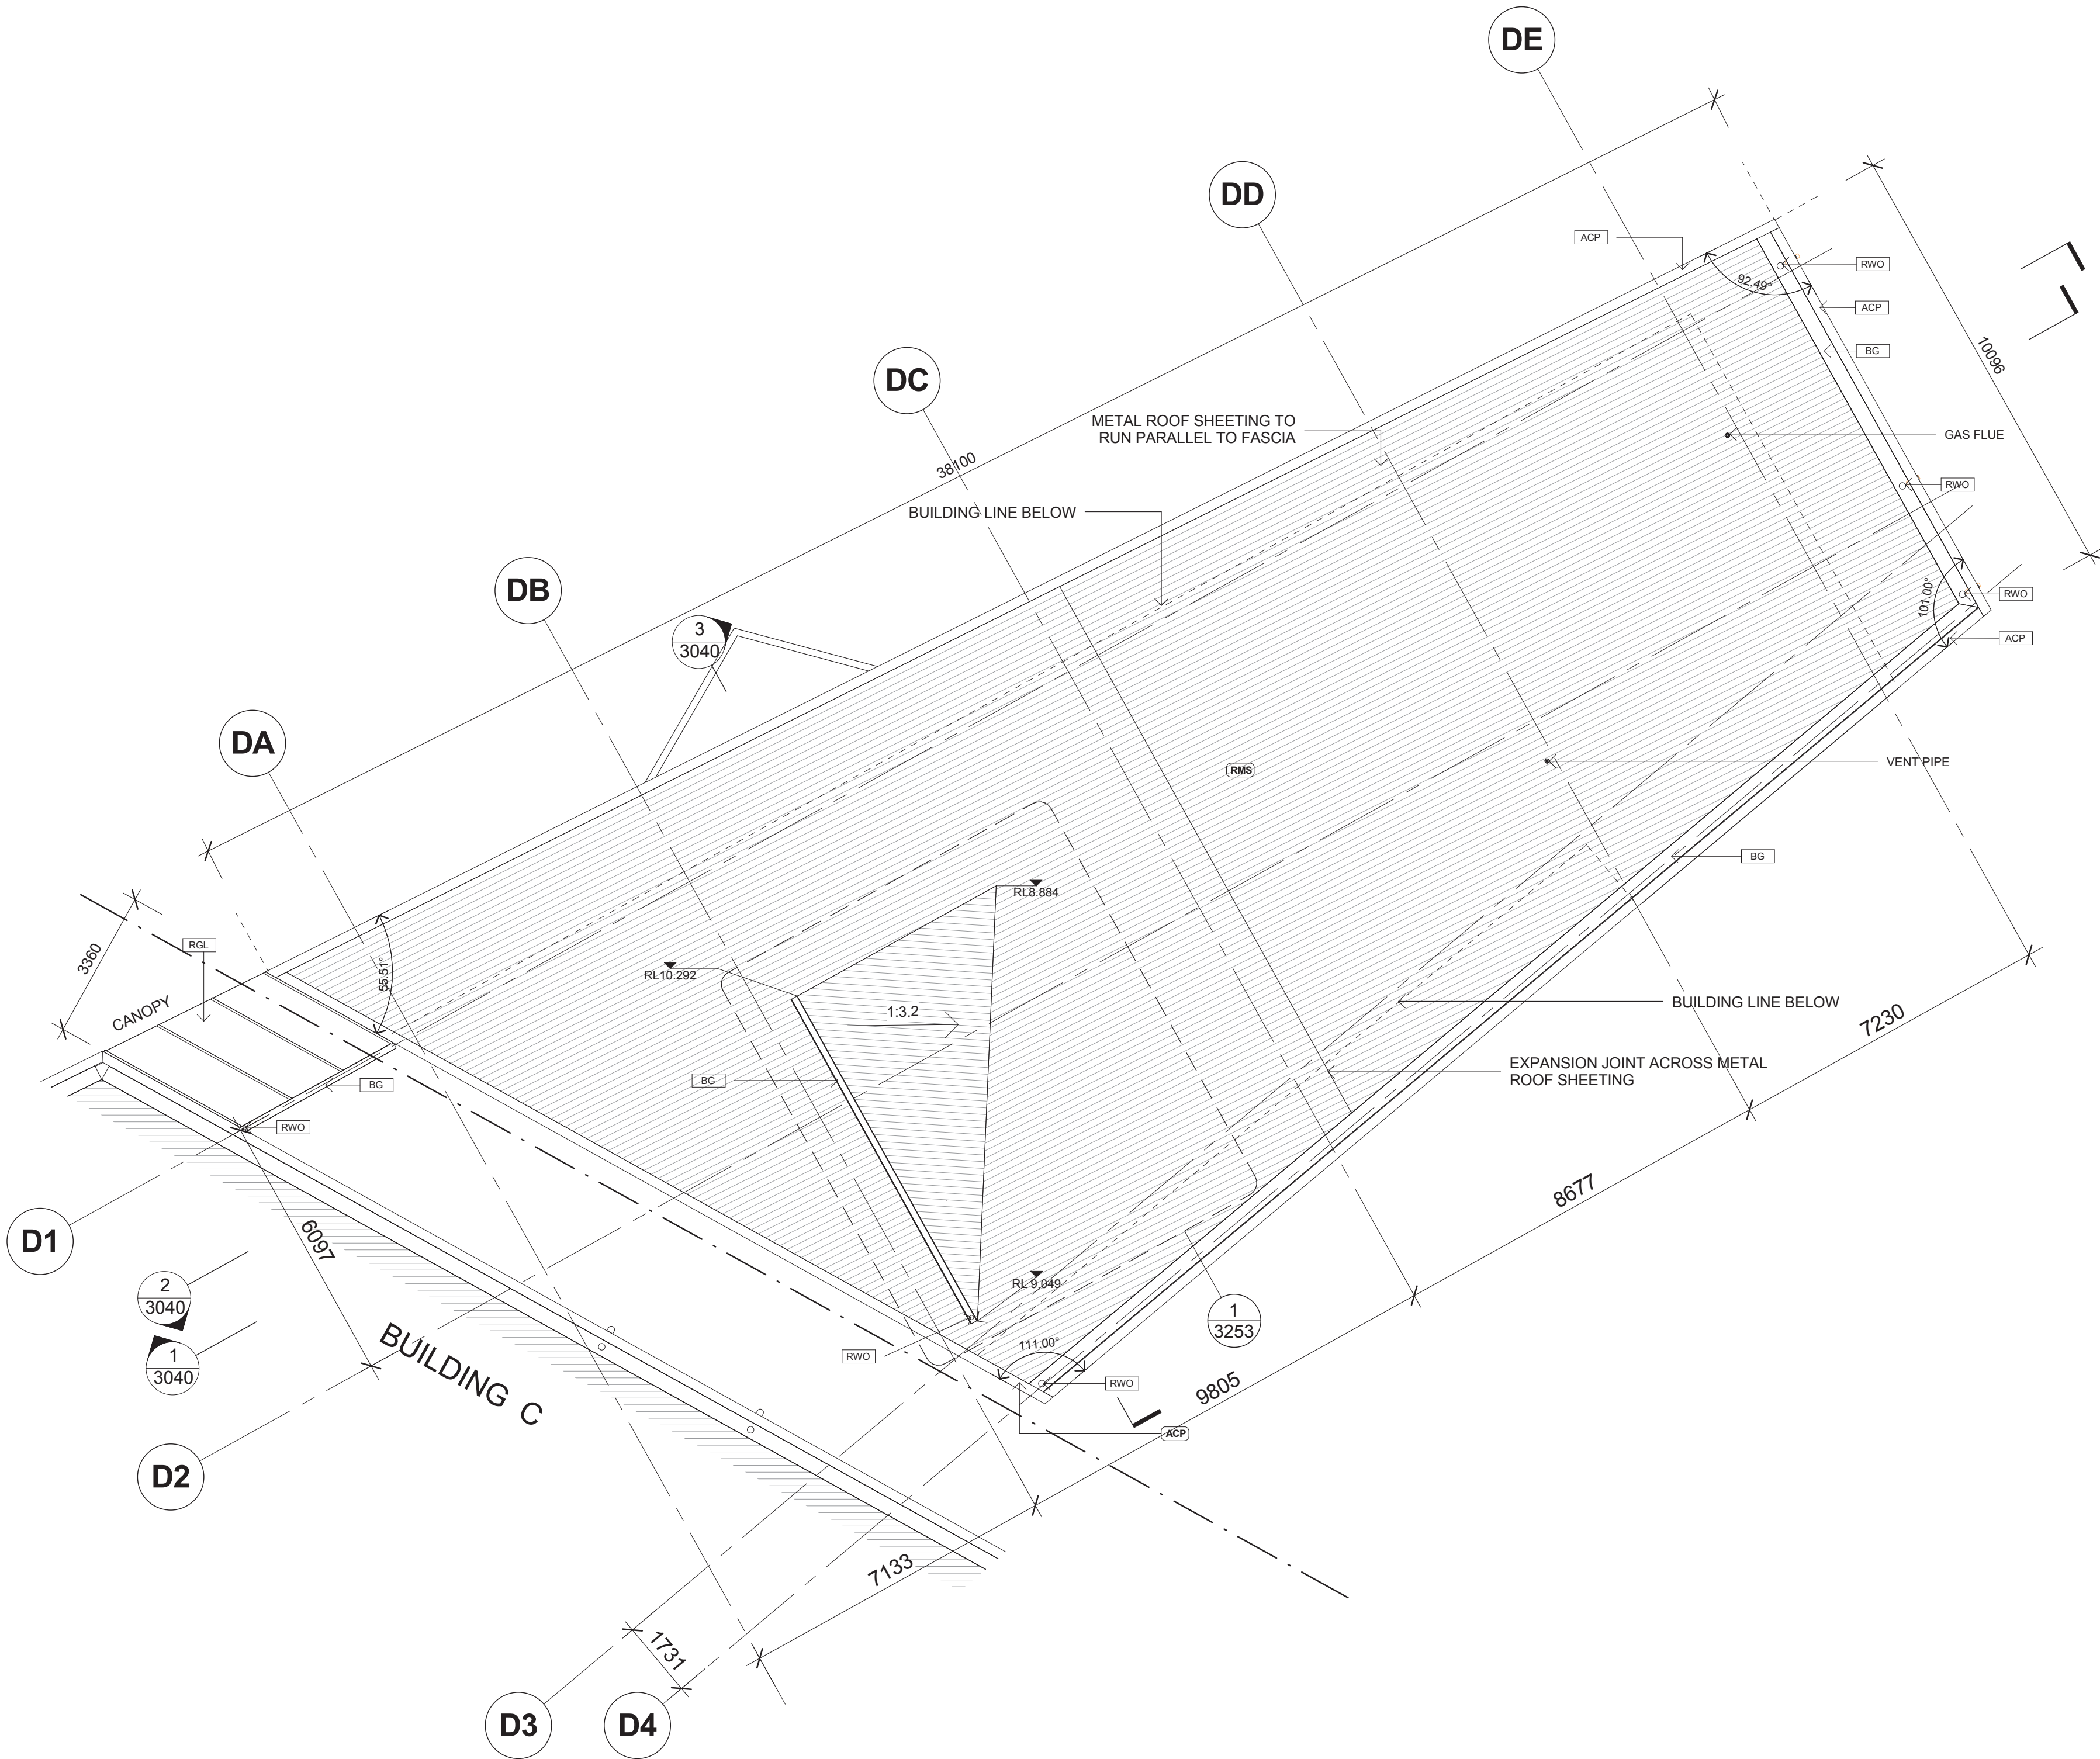

Notes

All dimensions and setouts to be verified prior to commencement, omissions or discrepancies to be notified to the architect.

Copyright

The copyright of this drawing together with any other documents prepared by crone partners architecture studios. ply ltd (cp) remains the property of cp. crone partners grants licence for the use of this document for the purpose for which they are intended. The licence is not transferable without the permission of cp.

Quality Assurance System

Authorised By: AD Date: 27.11.14

KEY

C	DEVELOPMENT APPLICATION REVISION	AVH	27.11.14
B	DEVELOPMENT APPLICATION REVISION	AVH	16.06.14
A	DEVELOPMENT APPLICATION REVISION	AVH	06.05.14

Client

<p>Structural Engineer</p> <p>TAYLOR THOMSON WHITTING</p> <p>Level 3, 48 Chandos Street, St Leonards NSW 2065 Ph: (+612) 94397288</p>	<p>Service Consultant</p> <p>WOOD AND GRIEVE ENGINEERS</p> <p>L6, Building B, 207 Pacific Highway, St Leonards, New South Wales, 2065 Ph: (+612) 94647000</p>
<p>ESD Consultant</p> <p>CRONE PARTNERS</p> <p>Level 2, 364 Kent Street Sydney, NSW 2000 Ph: (+612) 8295 5300</p>	<p>Landscape Architect</p> <p>URBIS</p> <p>Tower 2, Level 23, Darling Park, 201 Sussex St. Sydney, NSW 2000 Ph: (+612) 8233 9900</p>
<p>Civil Engineer</p> <p>TAYLOR THOMSON WHITTING</p> <p>Level 3, 48 Chandos Street, St Leonards NSW 2065 Ph: (+612) 94397288</p>	<p>BCA Consultant</p> <p>CITY PLAN SERVICES</p> <p>Level 1, 384 Kent Street, Sydney, NSW 2000 Ph: (+612) 8270 3500</p>
<p>Cost Consultant</p> <p>MITCHELL BRANDTMAN</p> <p>Unit 10, 15-23 Kumulla Rd Miranda, NSW 2226 Ph: (+612) 95418000</p>	<p>Planning Consultant</p> <p>URBIS</p> <p>Tower 2, Level 23, Darling Park, 201 Sussex St. Sydney, NSW 2000 Ph: (+612) 8233 9900</p>

Architect

cronepartners

Crone Partners
level 2, 364 kent street,
sydney, nsw 2000, australia
Ph: +61 2 8295 5300
Fax: +61 2 8295 5301

Project

RHODES COMMUNITY FACILITIES AND RESTAURANT

30 Shoreline Drive, Rhodes 2138

Drawn: AH Checked: AD Date: 27/11/14 Scale As indicated

Drawing Title

ROOF PLAN - BUILDING D

Scale Bar:

0 1000 2000 3000 4000 5000 mm

SCALE 1:100 AT ORIGINAL SIZE

DEVELOPMENT APPLICATION

CA 3138	DA	1010	C
Project no.	Drawing Phase.	Drawing No.	Rev