

APPENDIX F

Plans of proposed development



Rev.	Description	Date	Des.	App.	Chk.

Project Title
Whytes Lane
Proposed Waste Transfer Station

Client
Ballina Pumping Service

Designed APP/CH	Drawn CH	Approved JR	Checked JR	Date 03/12/14
--------------------	-------------	----------------	---------------	------------------


XREFs
Scale 1:1000 @ A1 0 10 20 30 40 50

Drawing Title
Site Layout

File name: 034-009 Ballina Pumping Service - Whytes Lane.dwg

Drawing Number
034-001

Revision

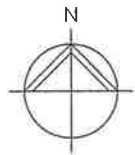

Vegetative Screening Plants List

Groundcovers native to Ballina Shire


<i>Actinotus helianthi</i>	Sydney Flannel Flower
<i>Alocasia brisbanensis</i>	Cunjevoi
<i>Alpinia coerulea</i>	Native Ginger
<i>Austromyrtus dulcis</i>	Midgenberry
<i>Brachyscome multifida</i>	Native Daisy
<i>Carpobrotus glaucescens</i>	Pigface
<i>Correa alba</i>	White Correa
<i>Dendrobium sp.</i>	Orchids
<i>Dianella caerulea</i>	Blue Flax Lily
<i>Dianella revolute</i>	Black Anther Flax Lily
<i>Enoslaemon myoporoides</i>	Wax Flower
<i>Helichrysum rupicola</i>	Paper daisy
<i>Hibbertia scandens</i>	Twining Guinea Flower
<i>Lobelia trigonocaulis</i>	Forest Lobelia
<i>Lomandra hy strix</i>	Small Mat Rush
<i>Lomandra longifolia</i>	Longleaf Mat Rush
<i>Viola hederacea</i>	Native Violet

Shrubs native to Ballina Shire

<i>Acacia longifolia</i>	Sydney Golden Wattle
<i>Baeckea linifolia</i>	Swamp Baeckea
<i>Banksia ericifolia</i>	Heath Leaved Banksia
<i>Banksia robur</i>	Swamp Banksia
<i>Bauera rubioides</i>	River Dog Rose
<i>Boronia species</i>	Boronia
<i>Callicarpa pedunculata</i>	Velvet Leaf
<i>Callistemon 'Little John'</i>	Callistemon
<i>Coprosma hirtella</i>	Looking Glass Plant
<i>Darwinia citriodora</i>	Lemon-scented Darwinia
<i>Dillwynia retorta</i>	Egg and Bacon
<i>Dodonaea triquetra</i>	Hopbush
<i>Doryanthes palmeri</i>	Spear Lily
<i>Eremophila species</i>	Emu Bush
<i>Enoslaemon australasius</i>	Pink Wax Flower
<i>Eupomatia laurina</i>	Native Bolwarra or Guava
<i>Gompholobium virgatum</i>	Yellow Wedge Pea
<i>Graptophyllum excelsum</i>	Scarlet Fuchsia
<i>Grevillea species</i>	Grevillea
<i>Hakea species</i>	Hakea
<i>Hibiscus heterophyllus</i>	Native Rosella
<i>Hibiscus splendens</i>	Native Hibiscus
<i>Isopogon anemonifolius</i>	Drumstick
<i>Kunzea capitata</i>	Pink Kunzea
<i>Lepidospermum petersonii</i>	Lemon-scented Tea Tree
<i>Lepidospermum species</i>	Tea Trees
<i>Melastoma affine</i>	Blue Tongue
<i>Oxylobium robustum</i>	Golden Shaggy Pea
<i>Ozothamnus diosmifolius</i>	Rice, Sago or Pill Flower
<i>Pittosporum revolutum</i>	Hairy Pittosporum
<i>Ricinocarpus pinifolius</i>	Wedding Bush
<i>Thryptomene paynei</i>	Thryptomene
<i>Westringea fruticosa</i>	Coastal Rosemary

Trees native to Ballina Shire

<i>Acacia elata</i>	Cedar Wattle
<i>Acmena smithii</i>	Lilly Pilly
<i>Acronychia imperforata</i>	Coastal Apple
<i>Alectryon coriaceus</i>	Beach Alectryon
<i>Allocasuarina littoralis</i>	Black She Oak
<i>Archirodon myrtus beckeri</i>	Rose Myrtle
<i>Austromyrtus bidwillii</i>	Pythion Tree
<i>Backhousia citriodora</i>	Lemon Scented Ironwood
<i>Banksia serrata</i>	Old Man Banksia
<i>Brachychiton acenifolius</i>	(Illawarra) Flame Tree
<i>Brachychiton discolor</i>	Lace Bark Tree
<i>Callicoma serratifolia</i>	Callicoma
<i>Callistemon salignus</i>	Weeping Bottle brush
<i>Cassine australis</i>	Red Olive Plum
<i>Cryptocarya laevigata</i>	Glossy Laurel
<i>Cupaniopsis anacardioides</i>	Coastal Tuckeroo
<i>Elaeocarpus reticulatus</i>	Blueberry Ash
<i>Euodia elleryana</i>	Pink Euodia
<i>Euodia micrococci</i>	White Euodia
<i>Ficus fraseri</i>	Sandpaper Fig
<i>Glochidion sumatranum</i>	Umbrella Cheese Tree
<i>Hakea salicifolia</i>	Willow Hakea
<i>Harpullia pendula</i>	Tulipwood
<i>Hymenosporum flavum</i>	Native Frangipani
<i>Lophostemon confertus</i>	Brush Box
<i>Macaranga tanarius</i>	Macaranga
<i>Melaleuca leucadendra</i>	Broad-leaved Paperbark
<i>Melaleuca quinquenervia</i>	Pandanus, Screw Pine
<i>Pandanus tectorius</i>	Geebung
<i>Persoonia species</i>	Satinwood
<i>Phebalium squameum</i>	Hollywood/Coastal Daphne
<i>Pittosporum rhombifolium</i>	Celerywood
<i>Polyscias elegans</i>	Native Gardenia
<i>Randia benthamiana</i>	Scrub Turpentine
<i>Rhodamnia rubescens</i>	Steelwood
<i>Sarcopteryx stipata</i>	Fire-wheel tree
<i>Stenocarpus sinuatus</i>	Peanut Tree
<i>Sterculia quadrifida</i>	Scentless Rosewood
<i>Synoum glandulosum</i>	Brush Cherry
<i>Syzygium austral</i>	Blue Lilly Pilly
<i>Syzygium olesum</i>	Magenta Lilly Pilly
<i>Syzygium paniculatum</i>	Water Gum
<i>Tristanopsis laurina</i>	Tree Heath
<i>Trochocarpa laurina</i>	Weeping Lilly Pilly
<i>Waterhousea floribunda</i>	

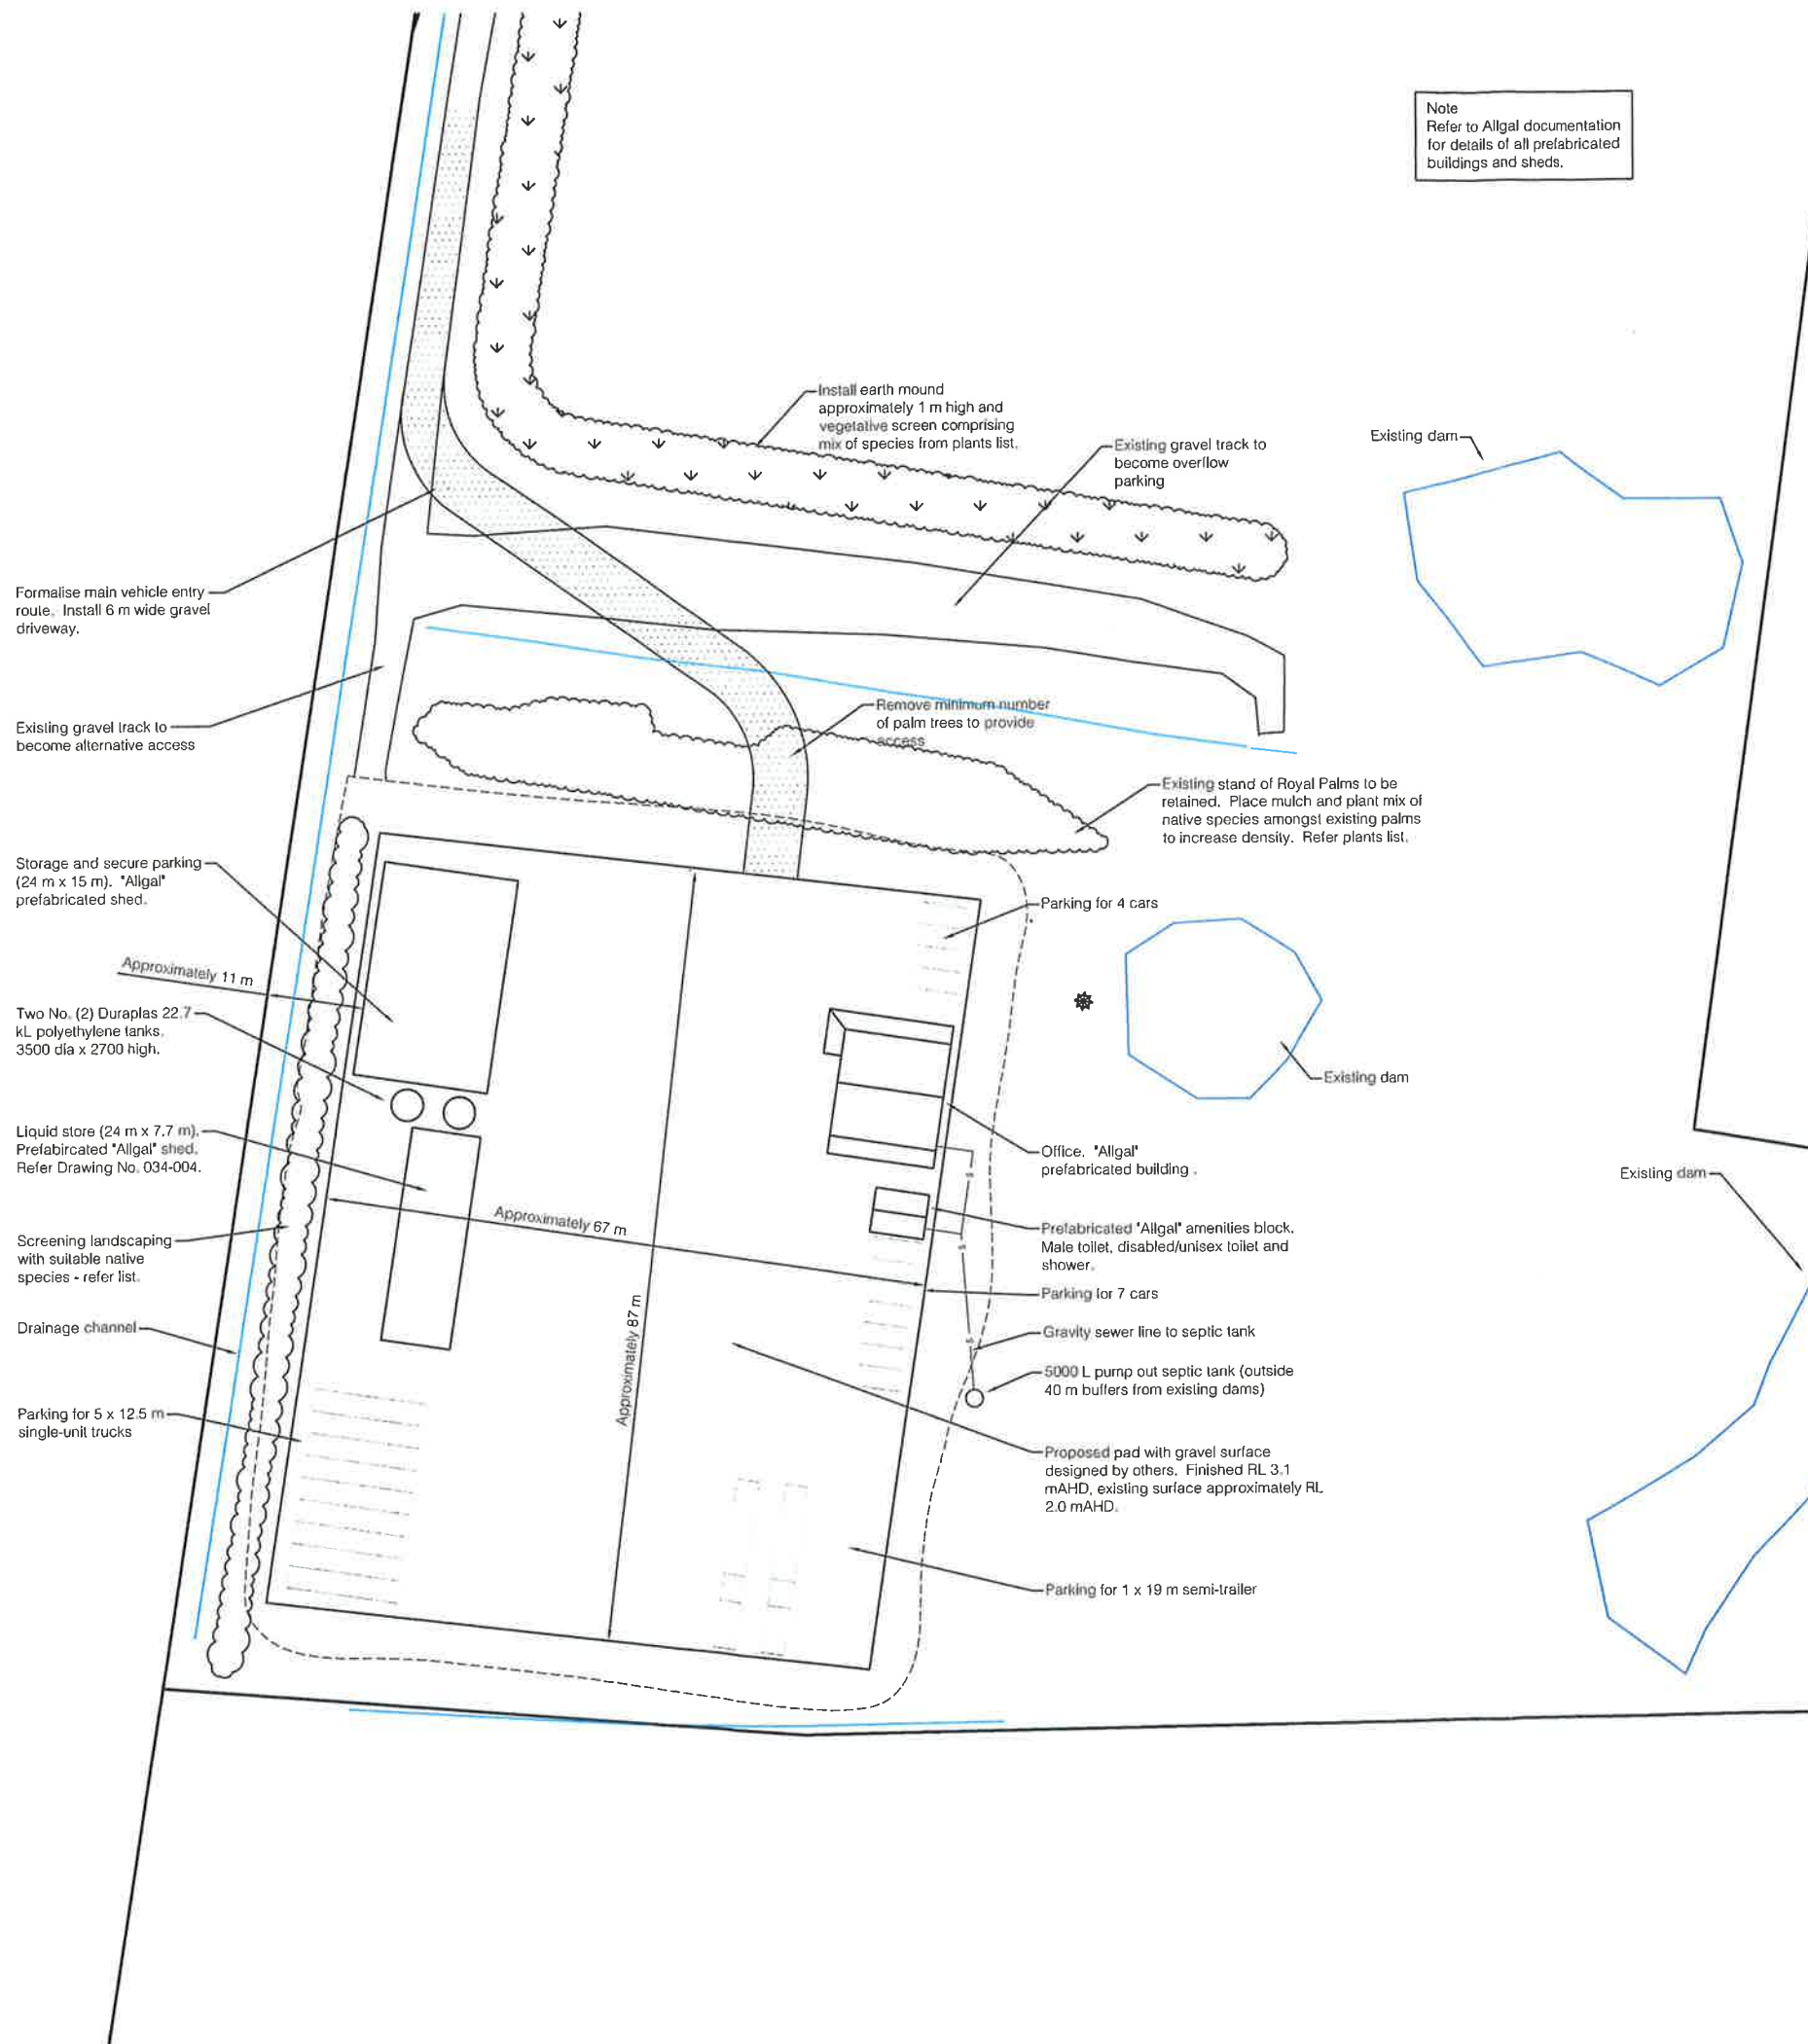

CHARLIE HEWITT ENGINEERING DESIGN

0421 098 267
charlie@charliehewitt.com.au
www.charliehewitt.com.au

PO Box 442
Lennox Head 2478
ABN 31 592 939 151

This drawing must not be relied upon for any purpose other than that for which it was prepared or by any person or corporation other than the referred client.

Rev	Description	Date	Des	App	Chk
Amendments					

Project Title
Whytes Lane
Proposed Waste Transfer Station

Client
Ballina Pumping Service

Designed APP/CH
Drawn CH
Approved JR
Checked JR
Date 08/12/14


XREFs
Scale 1:400 @ A1
0 4 8 12 16 20

Drawing Title
Layout

File name: 034-002 Ballina Pumping Service - Whytes Lane.dwg


Drawing Number
034-002

Revision

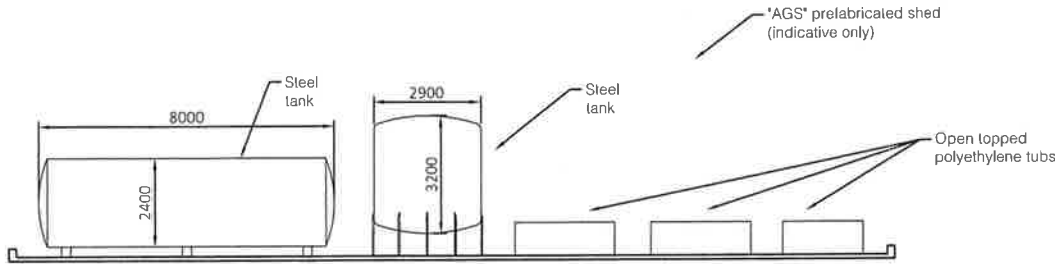


Section A-A
(Scale A)


Note
Refer to 'AGS All Steel Garages'
documentation for details of all
prefabricated buildings and sheds.

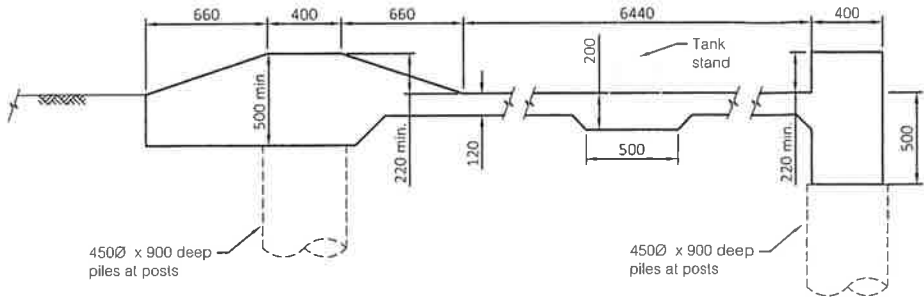

Section B-B
(Scale B)

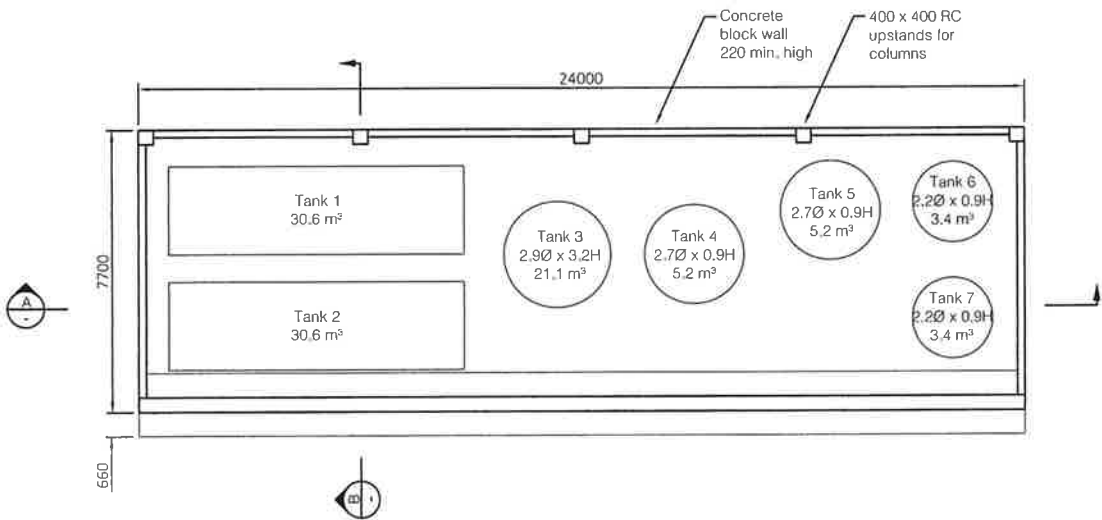

Liquid Store
Layout
(Scale A)

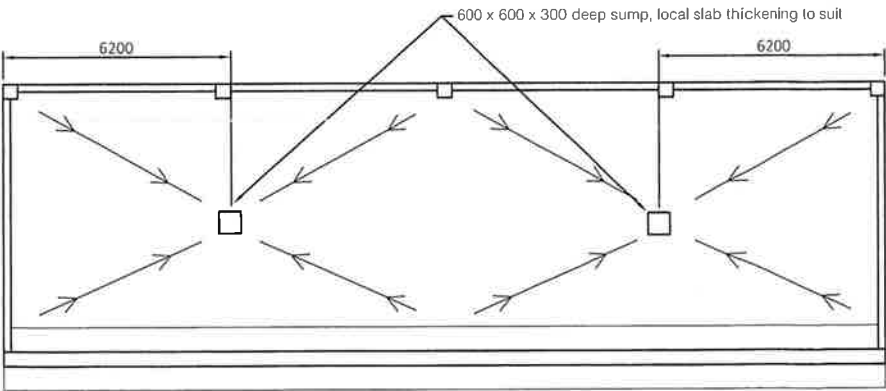

Liquid Store
Drainage Layout
(Scale A)

Rev	Description	Date	Des.	App.	Chk.
Amendments					

Project Title
Whytes Lane
Proposed Waste Transfer Station


Client
Ballina Pumping Service

Designed	Drawn	Approved	Checked	Date
APP/CH	CH	JR	JR	08/12/14

XREFs

Scale A	1:500 @ A1	0	1	2	3	4	5
Scale B	1:20 @ A1	0	0.2	0.4	0.6	0.8	1

Drawing Title
Details

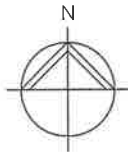

Rev	Description	Date	Des	App	Chk
Amendments					

Project Title
Whytes Lane
Proposed Waste Transfer Station

Client
Ballina Pumping Service


Designed	Drawn	Approved	Checked	Date
APP/CH	CH	JR	JR	08/12/14

XREFs
Scale 1:200 @ A1 0 2 4 6 8 10

Drawing Title
Swept Paths

HIGHWAY

PACIFIC

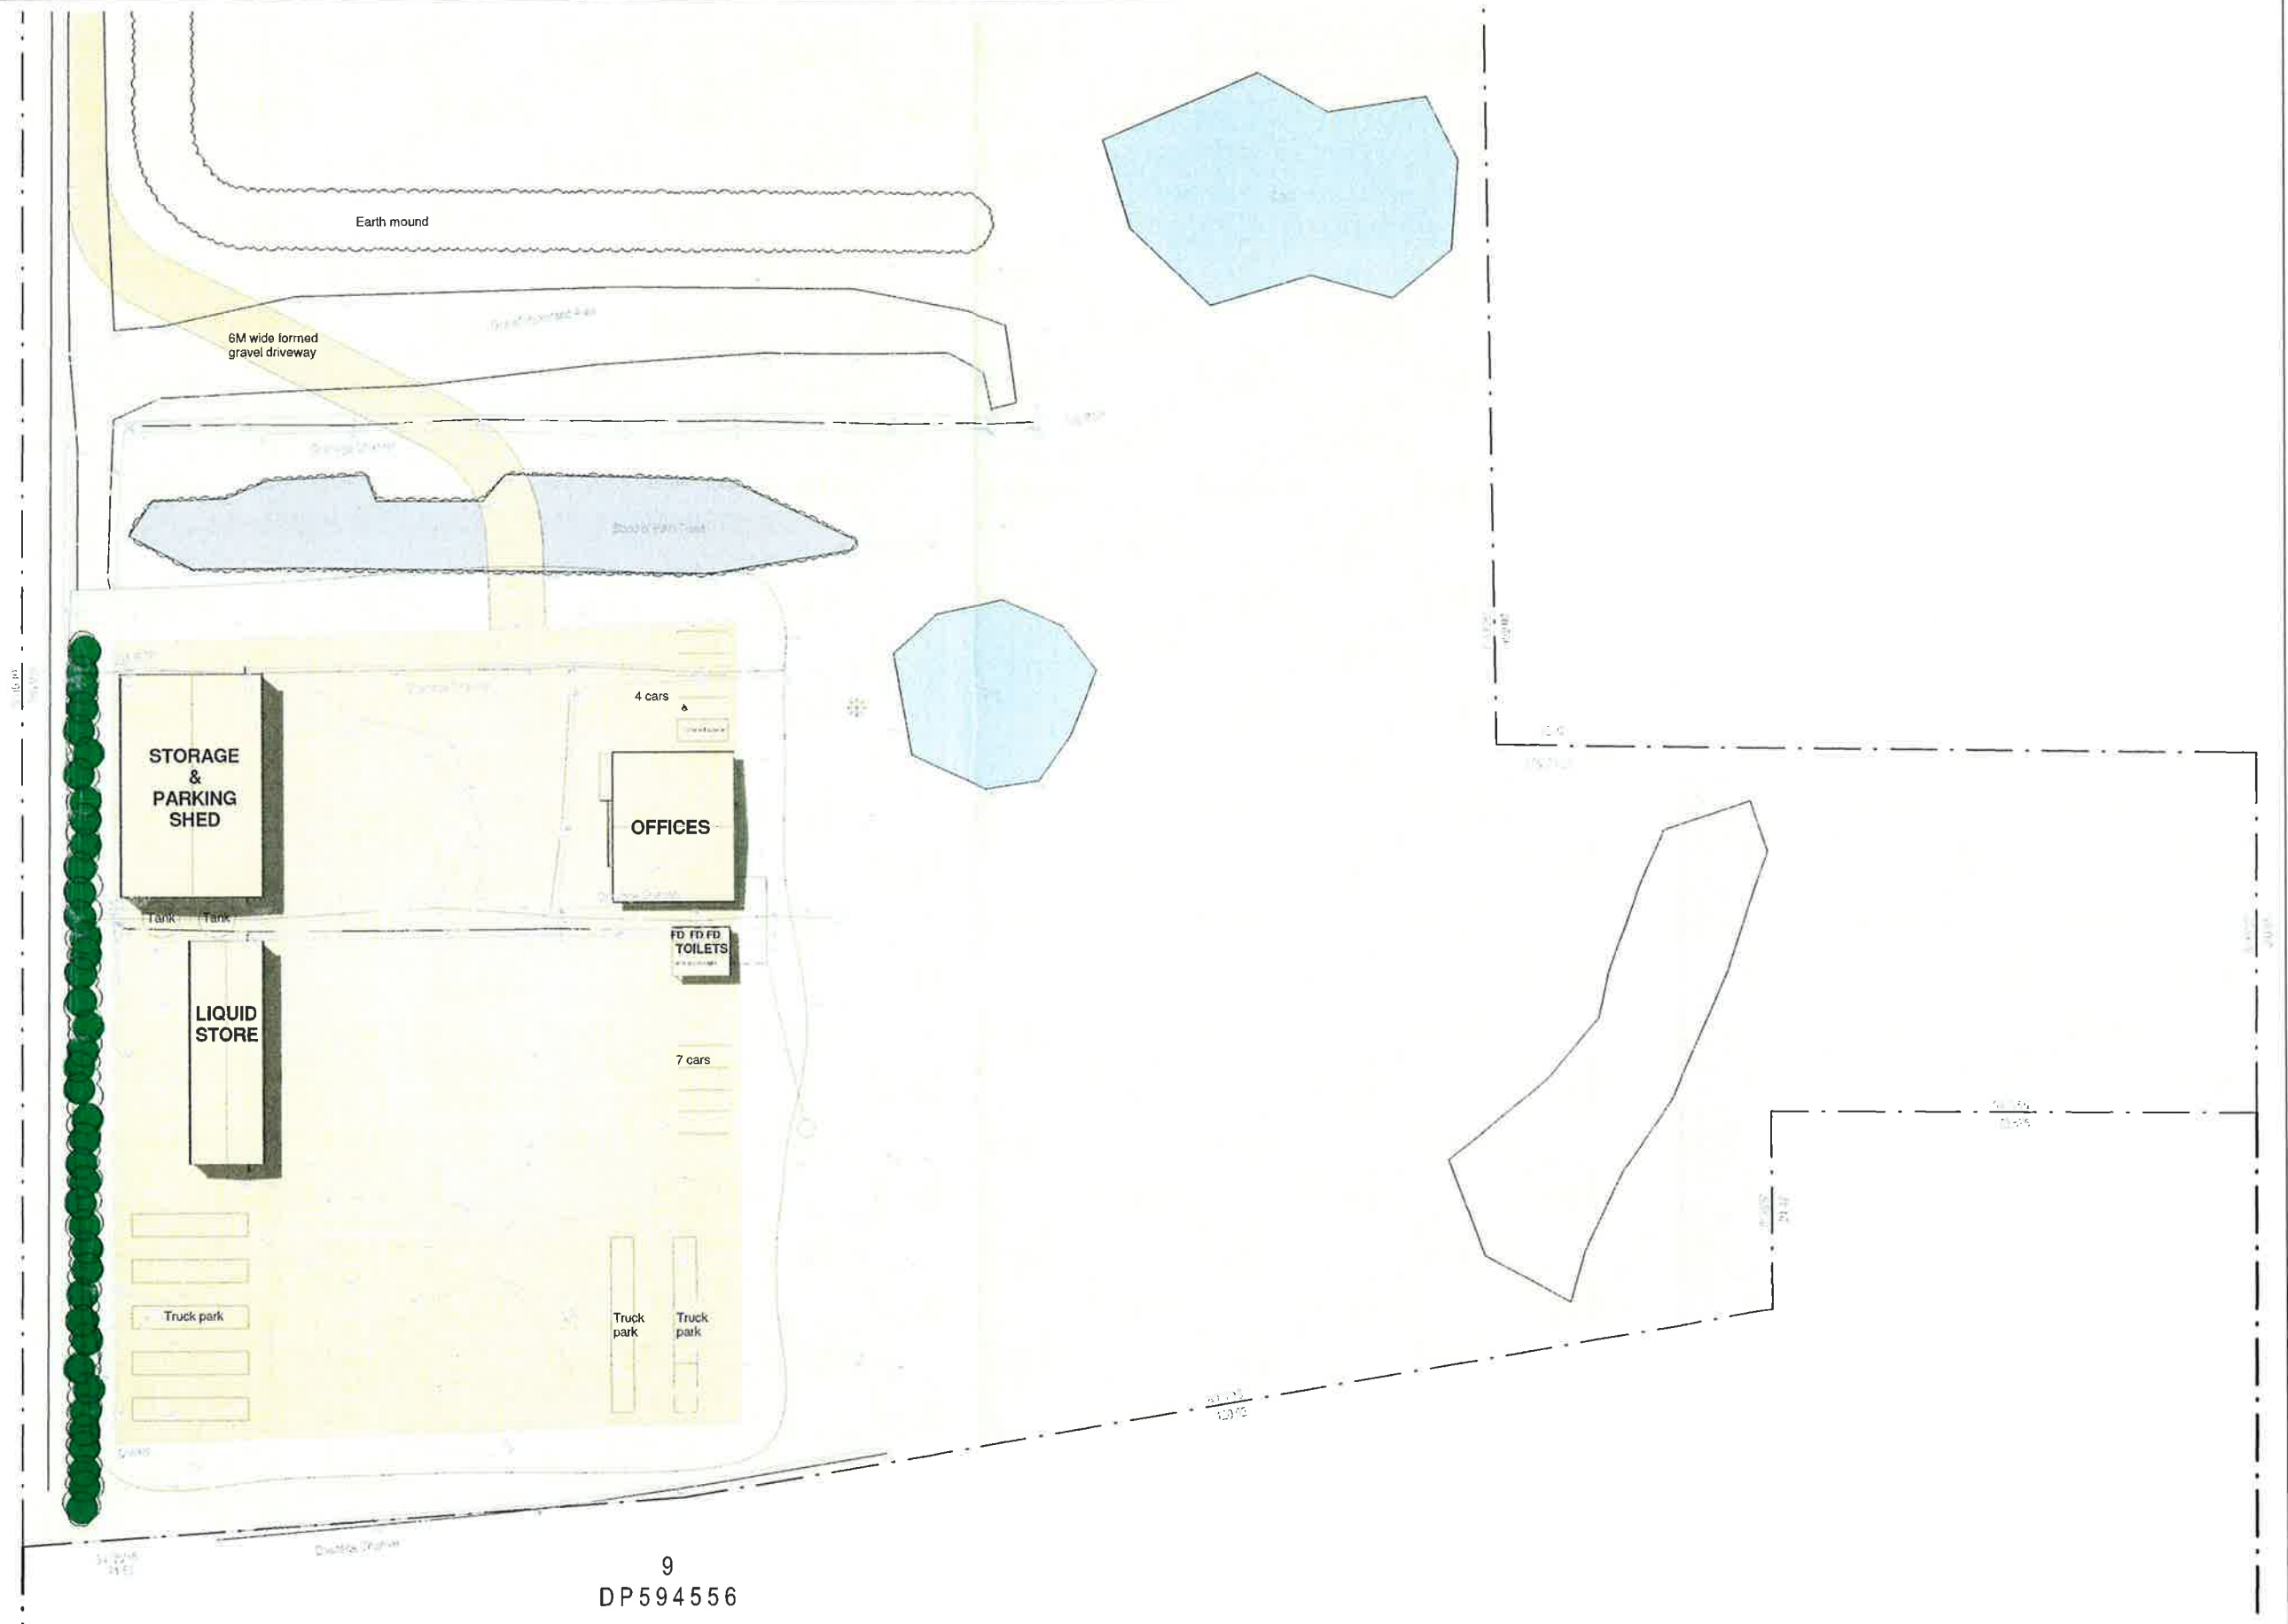

9
DP594556



All Steel Garages & Sheds Pty Ltd

10 Irving Drive, Casino
PO Box 230 Casino NSW 2470
phone 02 66628661
fax 02 66628570

www.allsteelgarages.com.au
RICHMOND VALLEY BUILDING DESIGN

No	Description	Date
	Project Status	07/12/14
a	amended position for liquid store	20/01/15

No	Description	Date


Proposed Industrial Sheds

Ballina Pumping
Whites Lane Ballina


Site Plan

Project number	AGSbalpump	SK01d
Date	Nov14	
Drawn by	CW	
Checked by	SB	
Scale	1 : 500	© Copyright


04/02/2015 14:22:09

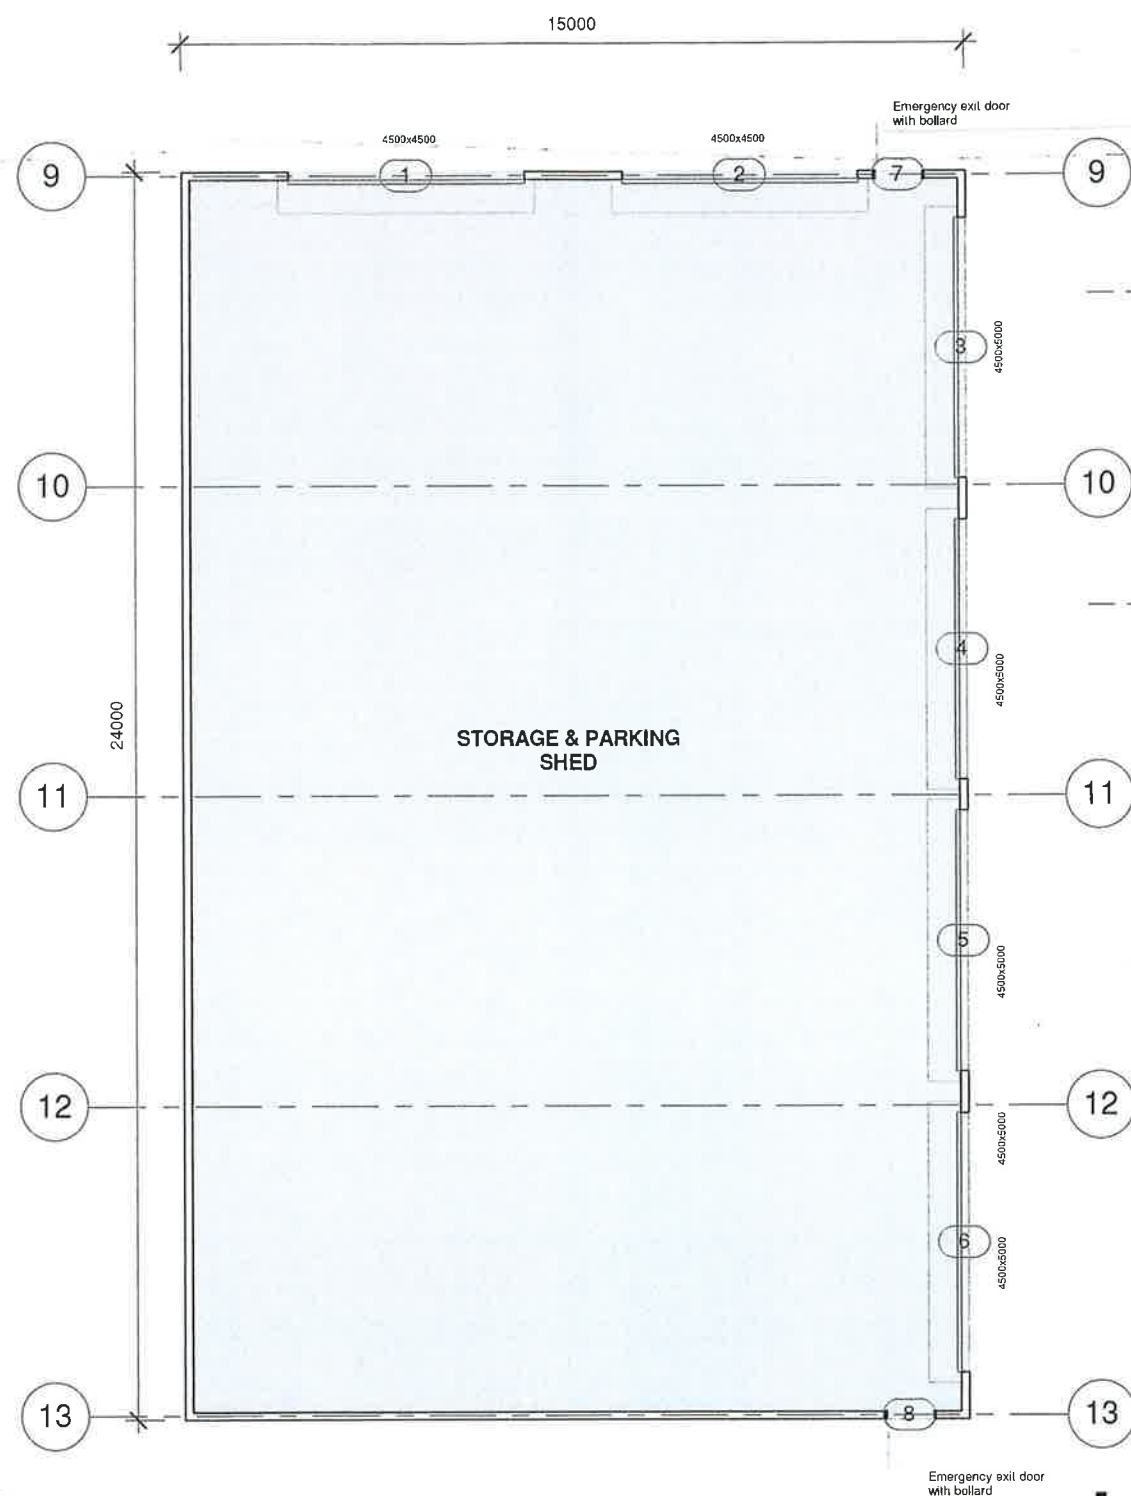

3
SK02a
STORAGE & PARKING FL
1 : 100

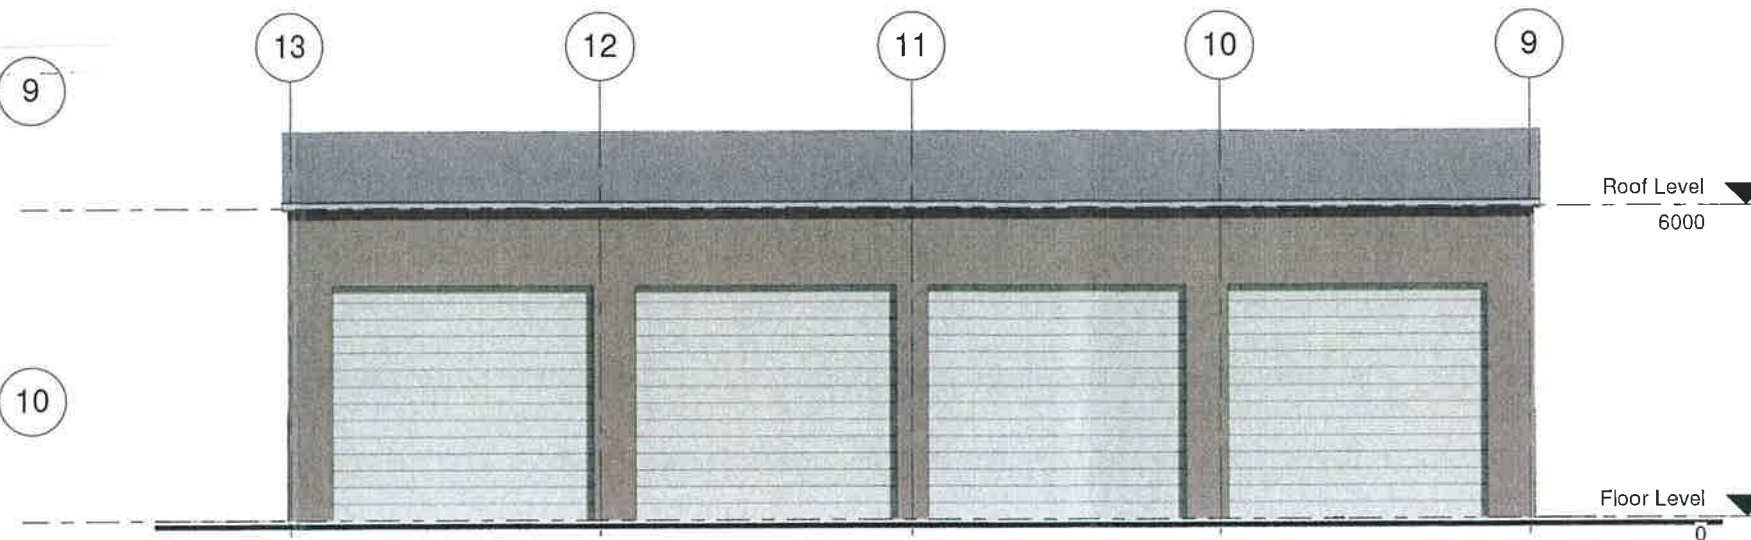

2
Elevation Storage Shed
1 : 100

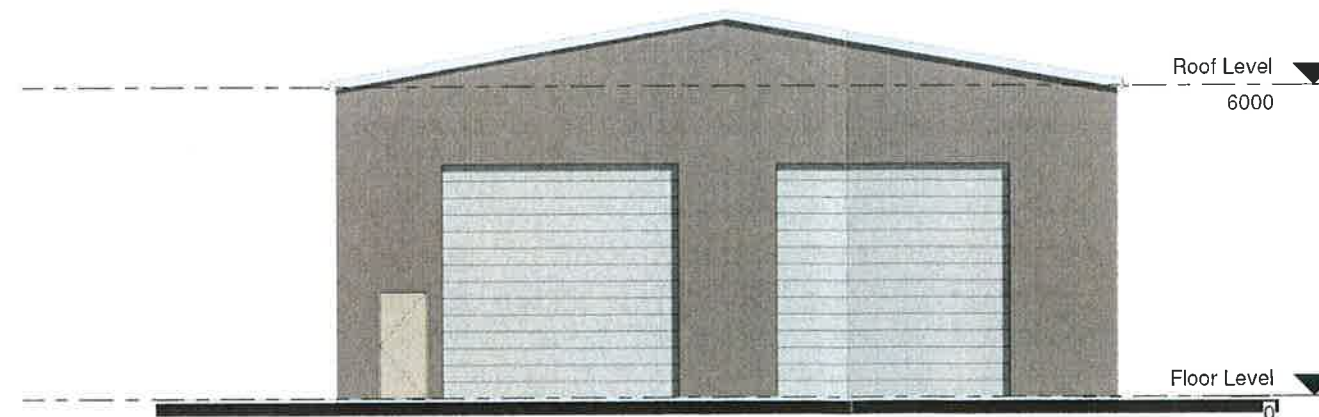

3
End Elevation
1 : 100



All Steel Garages & Sheds Pty Ltd

10 Irving Drive, Casino
PO Box 230 Casino NSW 2470
phone 02 66628661
fax 02 66628570
www.allsteelgarages.com.au
RICHMOND VALLEY BUILDING DESIGN

No	Description	Date
	Project Status	07/02/14


No	Description	Date

Proposed Industrial Sheds


Ballina Pumping
Whytes Lane Ballina

Storage & Parking Shed

Project number	AGSbalpump	SK02a
Date	Nov14	
Drawn by	CW	
Checked by	SB	
Scale	1 : 100	© Copyright

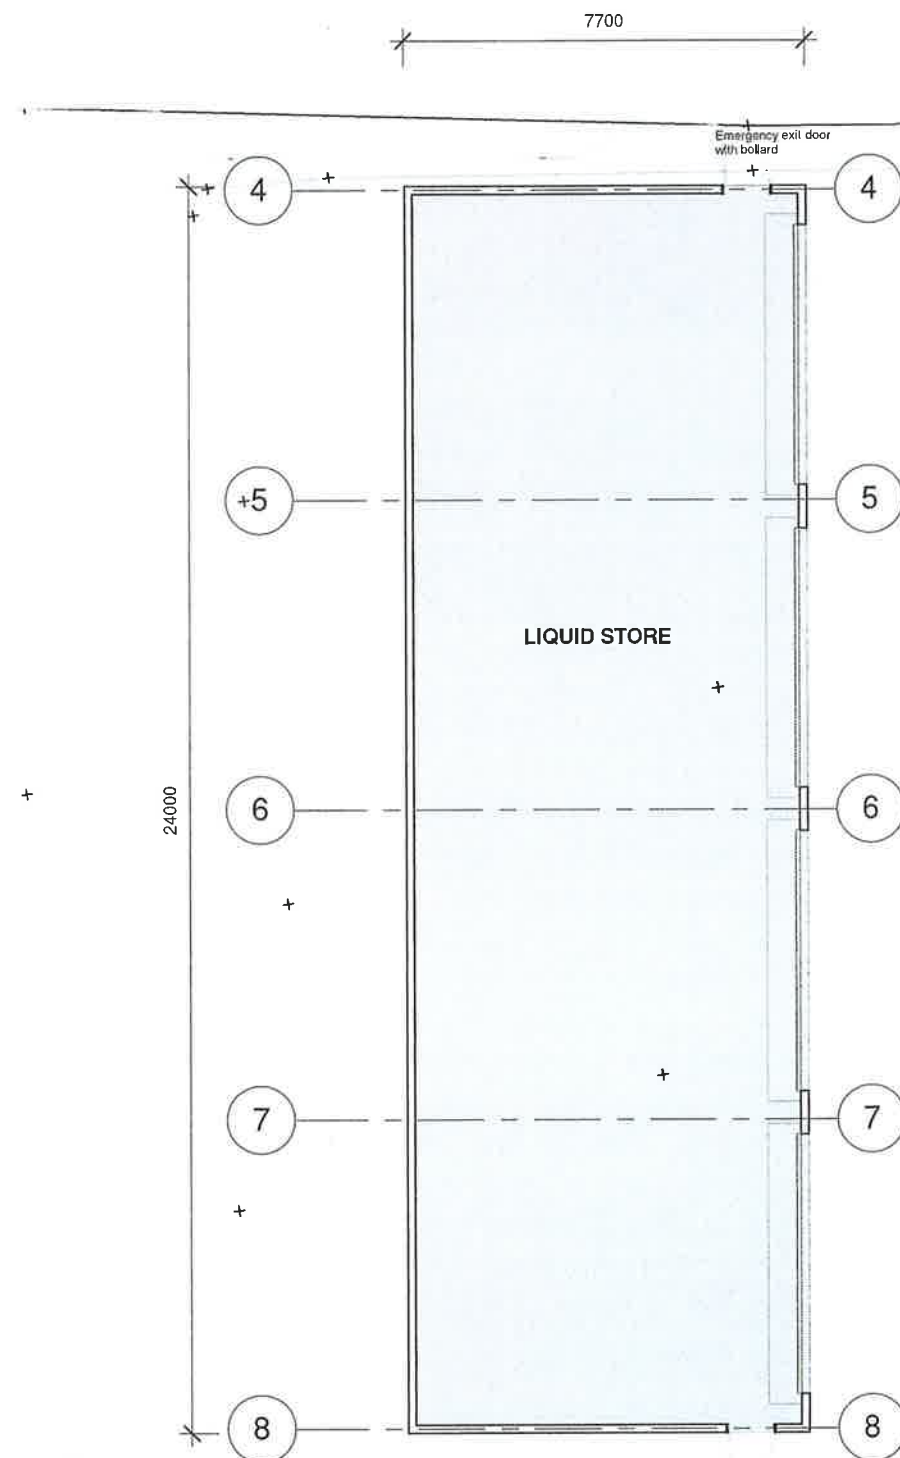

1 LIQUID STORE
1 : 100

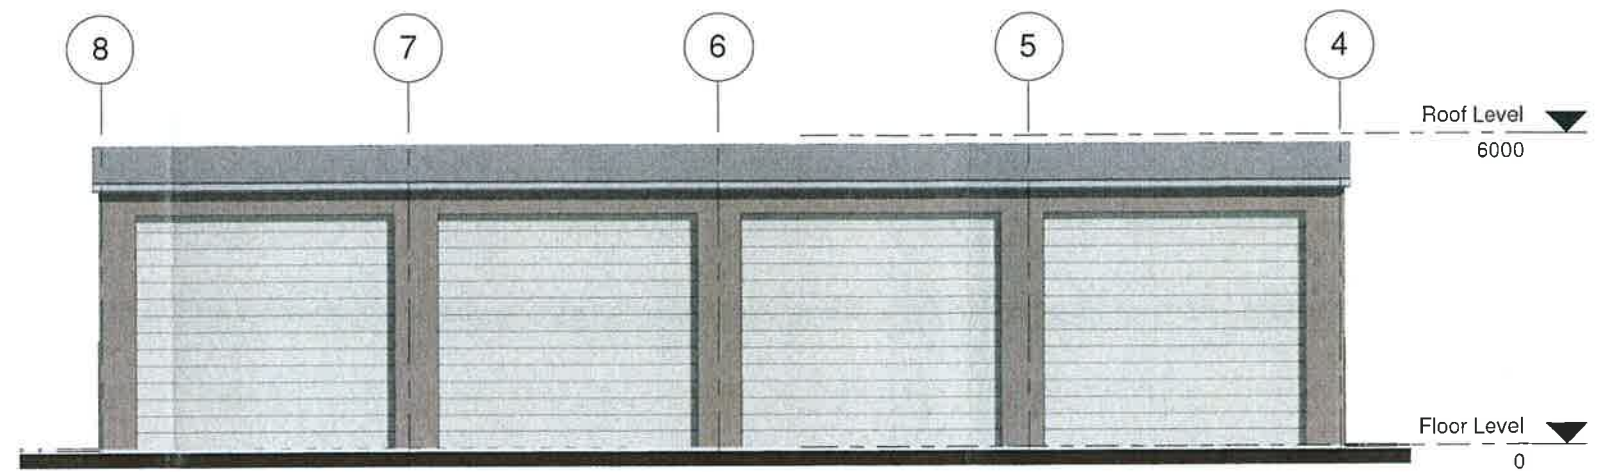

2 Liquid Store Front Elevation
1 : 100



3 Liquid Store End Elevation
1 : 200



All Steel Garages & Sheds Pty Ltd

10 Irving Drive, Casino
PO Box 230 Casino NSW 2470
phone 02 66628661
fax 02 66628570

www.allsteelgarages.com.au
RICHMOND VALLEY BUILDING DESIGN

No	Description	Date
	Project Status	07/02/14

No	Description	Date

Proposed Industrial Sheds


Ballina Pumping
Whytes Lane Ballina

Liquid Store

Project number AGSbalpump
Date Nov14
Drawn by CW
Checked by CW

SK03a

Scale As indicated © Copyright

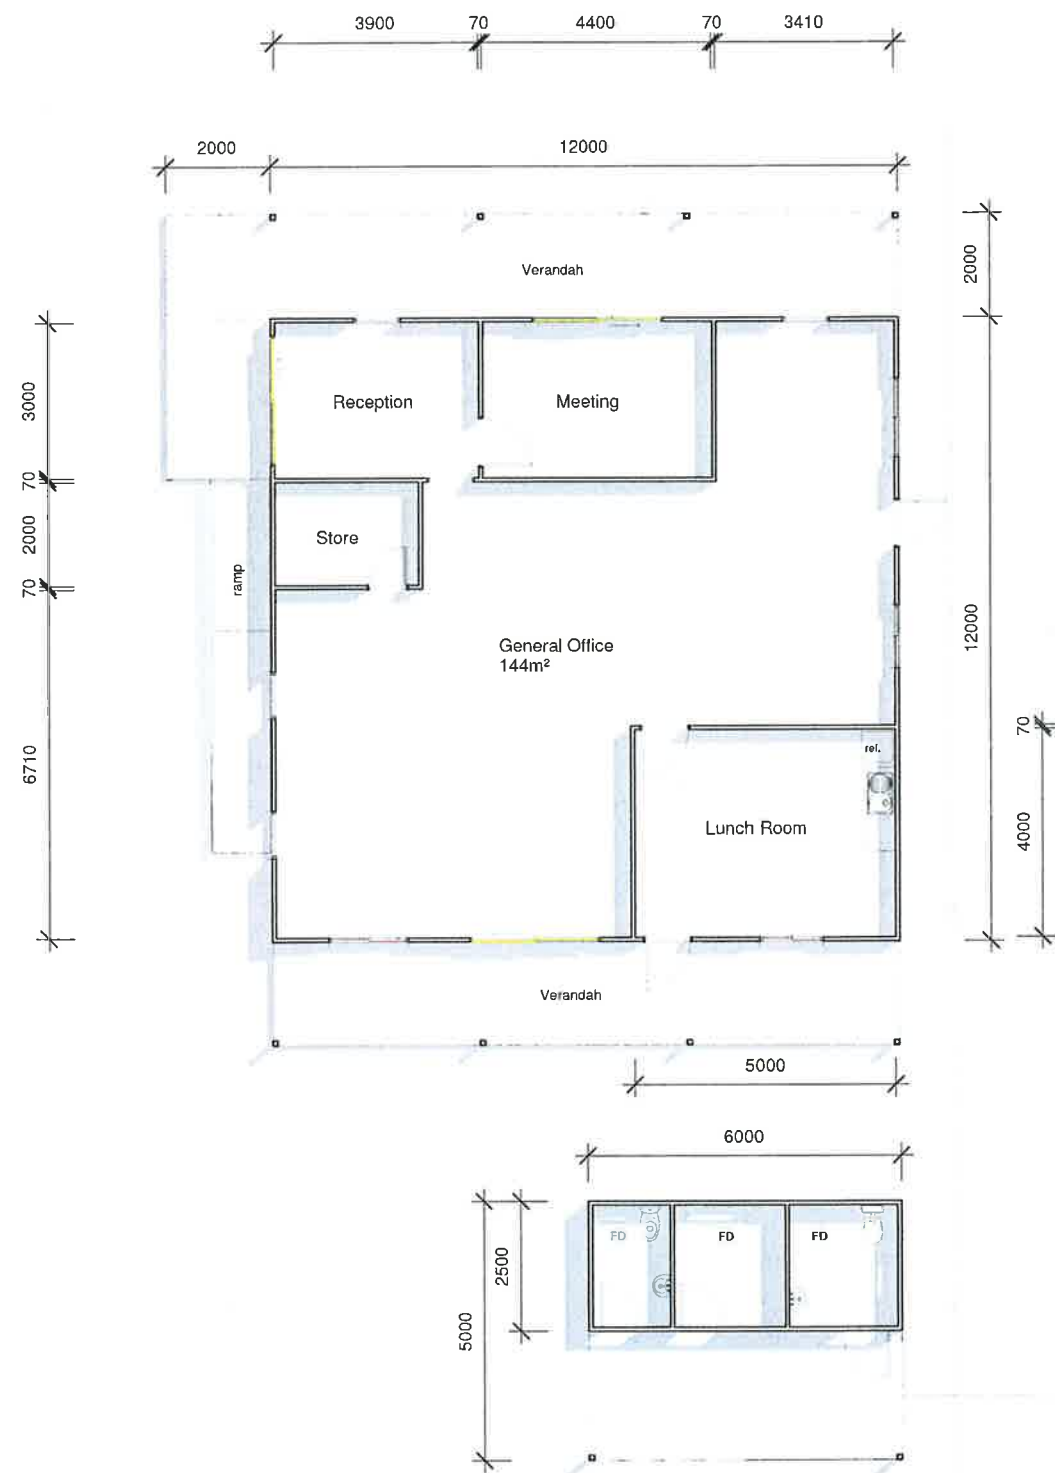


1 OFFICE
1 : 100



3 3D View 2



4 3D View 3

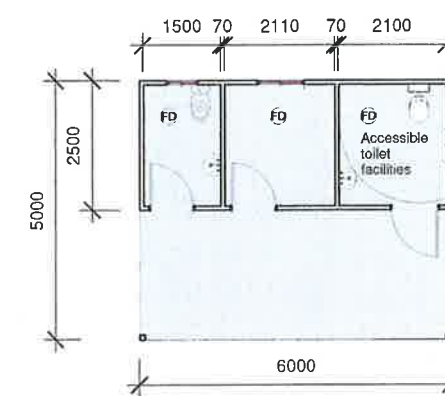

2 TOILETS
1 : 100

All Steel Garages & Sheds Pty Ltd

10 Irving Drive, Casino
PO Box 230 Casino NSW 2470
phone 02 66628661
fax 02 66628570
www.allsteelgarages.com.au
RICHMOND VALLEY BUILDING DESIGN

No	Description	Date
	Project Status	02/12/14

No	Description	Date

Proposed Industrial Sheds

Ballina Pumping
Whytes Lane Ballina

Office Building & Toilet Facilities

Project number	AGSbalpump	SK04
Date	Nov14	
Drawn by	CW	
Checked by	SB	

Scale 1 : 100 © Copyright