

BIGGE PARK - LIVERPOOL

95% LANDSCAPE CONSTRUCTION DOCUMENTATION PACKAGE

DRAWING REGISTER

DWG NO.	DRAWING NAME	SCALE	SIZE	ISSUE
BP-000-CS	COVER SHEET & DRAWING REGISTER	NTS	A1	D
BP-001-CS	COVER SHEET: LEGENDS	NTS	A1	D
BP-002-CS	COVER SHEET: PROJECT HOLD POINTS	NTS	A1	D
BP-150-DE	DEMOLITION PLAN COVER SHEET	1:400	A1	D
BP-151-DE	DEMOLITION PLAN	1:200	A1	D
BP-152-DE	DEMOLITION PLAN	1:200	A1	D
BP-153-DE	DEMOLITION PLAN	1:200	A1	D
BP-154-DE	DEMOLITION PLAN	1:200	A1	D
BP-200-FI	FINISHES PLAN COVER SHEET	1:400	A1	D
BP-201-FI	FINISHES PLAN	1:200	A1	D
BP-202-FI	FINISHES PLAN	1:200	A1	D
BP-203-FI	FINISHES PLAN	1:200	A1	D
BP-204-FI	FINISHES PLAN	1:200	A1	D
BP-250-JO	JOINTING PLAN COVER SHEET	1:400	A1	B
BP-251-JO	JOINTING PLAN	1:200	A1	B
BP-252-JO	JOINTING PLAN	1:200	A1	B
BP-253-JO	JOINTING PLAN	1:200	A1	B
BP-254-JO	JOINTING PLAN	1:200	A1	B
BP-300-SO	SET-OUT PLAN COVER SHEET	1:400	A1	B
BP-301-SO	SET-OUT PLAN	1:200	A1	B
BP-302-SO	SET-OUT PLAN	1:200	A1	B
BP-303-SO	SET-OUT PLAN	1:200	A1	B
BP-304-SO	SET-OUT PLAN	1:200	A1	B
BP-305-SO	DETAILED SET-OUT PLAN	1:100	A1	A
BP-400-GR	GRADING + DRAINAGE COVER SHEET	1:400	A1	E
BP-401-GR	GRADING + DRAINAGE PLAN	1:200	A1	D
BP-402-GR	GRADING + DRAINAGE PLAN	1:200	A1	D
BP-403-GR	GRADING + DRAINAGE PLAN	1:200	A1	D
BP-404-GR	GRADING + DRAINAGE PLAN	1:200	A1	D
BP-500-PP	PLANTING COVER SHEET	1:400	A1	D
BP-501-PP	PLANTING PLAN	1:200	A1	D
BP-502-PP	PLANTING PLAN	1:200	A1	D
BP-503-PP	PLANTING PLAN	1:200	A1	D
BP-504-PP	PLANTING PLAN	1:200	A1	D

DWG NO.	DRAWING NAME	SCALE	SIZE	ISSUE
BP-600-FU	FURNITURE & PLAYGROUND PLAN COVER SHEET	1:400	A1	D
BP-601-FU	FURNITURE & PLAYGROUND PLAN	1:200	A1	D
BP-602-FU	FURNITURE & PLAYGROUND PLAN	1:200	A1	D
BP-603-FU	FURNITURE & PLAYGROUND PLAN	1:200	A1	D
BP-604-FU	FURNITURE & PLAYGROUND PLAN	1:200	A1	D
BP-700-LI	LIGHTING PLAN COVER SHEET	1:400	A1	D
BP-701-LI	LIGHTING PLAN	1:200	A1	D
BP-702-LI	LIGHTING PLAN	1:200	A1	D
BP-703-LI	LIGHTING PLAN	1:200	A1	D
BP-704-LI	LIGHTING PLAN	1:200	A1	D
BP-800-SE	SECTIONS	AS SHOWN	A1	B
BP-801-SE	SECTIONS	AS SHOWN	A1	B
BP-802-SE	ELEVATIONS	AS SHOWN	A1	B
BP-900-DT	CAFE DETAIL PLAN	1:100	A1	D
BP-901-DT	HERITAGE COURTYARD DETAIL PLAN	1:100	A1	D
BP-902-DT	ACCESS RAMP & STAIR DETAIL PLANS	AS SHOWN	A1	D
BP-903-DT	FURNITURE ARRANGEMENT DETAIL PLANS	AS SHOWN	A1	D
BP-904-DT	CLOCK TOWER DETAIL PLAN	AS SHOWN	A1	B
BP-905-DT	HARDWORKS DETAILS	AS SHOWN	A1	D
BP-906-DT	HARDWORKS DETAILS	AS SHOWN	A1	D
BP-907-DT	HARDWORKS DETAILS	AS SHOWN	A1	D
BP-908-DT	HARDWORKS DETAILS	AS SHOWN	A1	D
BP-909-DT	HARDWORKS DETAILS	AS SHOWN	A1	D
BP-910-DT	HARDWORKS DETAILS	AS SHOWN	A1	D
BP-911-DT	HARDWORKS DETAILS	AS SHOWN	A1	B
BP-915-DT	SOFTWORKS DETAILS	AS SHOWN	A1	D

 


KEY PLAN / SHEET LAYOUT
SCALE 1:1000@A1


LEGENDS

GENERAL


GENERAL




EXTENT OF WORKS

 


JOINLINE



 
EXISTING BUILDING/ STRUCTURE
RETAINED



PROPOSED TREE
REFER PLANTING PLAN




EXISTING TREE
TO BE RETAINED




EXISTING TREE
TO BE REMOVED


DEMOLITION PLAN

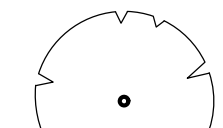


PROPOSED TREE
REFER PLANTING PLAN




EXISTING TREE
TO BE RETAINED

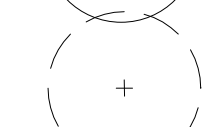


EXISTING TREE
TO BE REMOVED

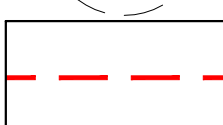


AREAS TO BE
DEMOLISHED

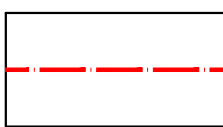


AREAS TO BE
RETAINED & PROTECTED

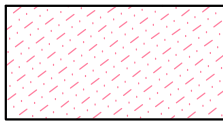


EXISTING PAVEMENT
TO BE REMOVED

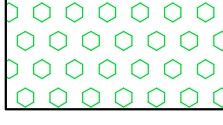


EXISTING PLANTING & SOIL
TO BE RETAINED

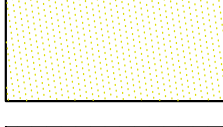


EXISTING TURF
TO BE RETAINED

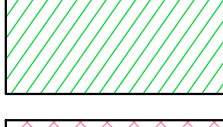

EXISTING PLANTING & SOIL
TO BE REMOVED




 EXISTING PLANTING
TO BE REMOVED




EXISTING MEMORIALS
REFER MEMORIAL SCHEDULE


FINISHES PLAN

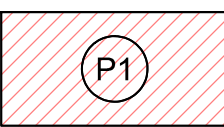


P1 : PAVEMENT PROFILE 1
REFER SCHEDULE OF LANDSCAPE WORKS
INSITU CONCRETE - RUBY

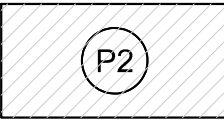


P2 : PAVEMENT PROFILE 2
REFER SCHEDULE OF LANDSCAPE WORKS
INSITU CONCRETE - PEWTER

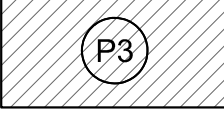


P3 : PAVEMENT PROFILE 3
REFER SCHEDULE OF LANDSCAPE WORKS
INSITU CONCRETE - MORPHEUS

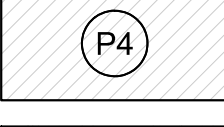


P4 : PAVEMENT PROFILE 4
REFER SCHEDULE OF LANDSCAPE WORKS
800x400x50mm PAVERS - REGENT GREY




P4a : PAVEMENT PROFILE 4a
REFER SCHEDULE OF LANDSCAPE WORKS
800x100x50mm PAVERS - REGENT GREY

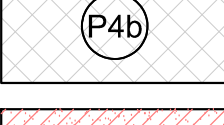


P4b : PAVEMENT PROFILE 4b
REFER SCHEDULE OF LANDSCAPE WORKS
200 X 100 X 50 REGENT GREY INTERLOCKING GRANITE SETS

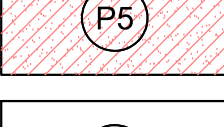


P5 - PAVEMENT PROFILE 5
REFER SCHEDULE OF LANDSCAPE WORKS
POROUS PAVEMENT - UNDER TREE CANOPIES

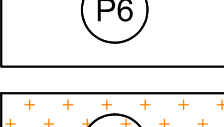


P6 - PAVEMENT PROFILE 6
REFER SCHEDULE OF LANDSCAPE WORKS
400x400x50mm - REGENT GREY




SF : PLAY/FITNESS EQUIPMENT SOFTFALL
REFER SCHEDULE OF LANDSCAPE WORKS




TAC - WARNING TACTILE INDICATORS
REFER SCHEDULE OF LANDSCAPE WORKS

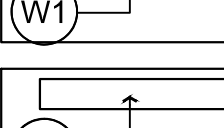


W1 : WALL TYPE 1
REFER SCHEDULE OF LANDSCAPE WORKS
REFER DETAIL 02/911-DT (TO BE CONFIRMED)




W2 : WALL TYPE 2 - PERIMETER RETAINING WALL
REFER SCHEDULE OF LANDSCAPE WORKS
REFER DETAIL 01/911-DT (TO BE CONFIRMED)

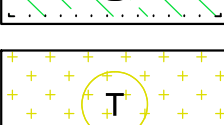


G1 : GARDEN PROFILE 1
REFER SCHEDULE OF LANDSCAPE WORKS

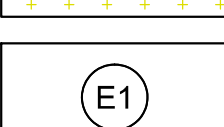


T1 : TURF PROFILE 1
REFER SCHEDULE OF LANDSCAPE WORKS

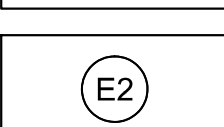


E1: EDGE TYPE 1
REFER SCHEDULE OF LANDSCAPE WORKS
REFER DETAIL 06/905-DT

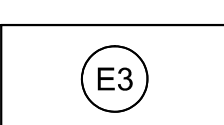


E2: EDGE TYPE 2
REFER SCHEDULE OF LANDSCAPE WORKS
REFER DETAIL 02/905-DT

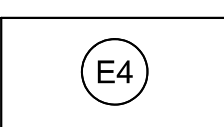


E3: EDGE TYPE 3
REFER SCHEDULE OF LANDSCAPE WORKS
REFER DETAIL 05/905-DT

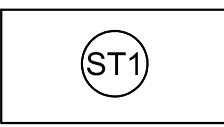


E4: EDGE TYPE 4
EXTRUDED CONCRETE
REFER SCHEDULE OF WORKS

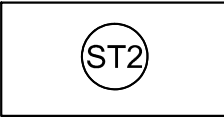


ST1: STAIR TYPE 1
REFER DETAIL 02/910-DT

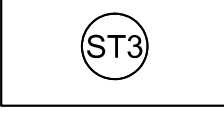


ST2: STAIR TYPE 2
REFER DETAIL 03/910-DT

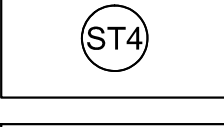


ST3: STAIR TYPE 3
REFER DETAIL 04/910-DT

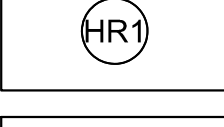


ST4: STAIR TYPE 4
REFER DETAIL 05/910-DT



HR1: HANDRAIL TYPE 1 - STAIRS
REFER DETAIL 02/910-DT




HR2: HANDRAIL TYPE 2 - RAMPS
REFER DETAIL 02/911-DT




DG
REFER DETAIL 05/905-DT


SET-OUT PLAN

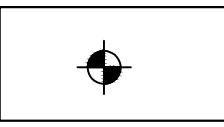

SETOUT POINT

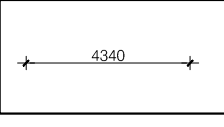


TYPICAL DIMENSION

 


NORTHING & EASTING
COORDINATES

JOINTING PLAN

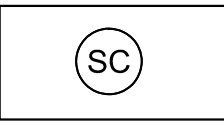


SC: SAW CUT JOINT




EJ: EXPANSION JOINT
REFER ENGINEERS SPECIFICATION

NOTE: REFER LIVERPOOL COUNCIL (LCC) DETAILS FOR ALL JOINTING REQUIREMENTS


DRAINAGE & GRADING PLAN




EXISTING LEVEL

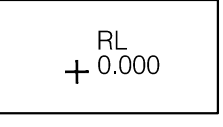


PROPOSED FINISHED SURFACE LEVEL
(e.g. TOP OF MULCH OR PAVEMENT SURFACE)

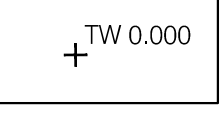


TOP OF WALL LEVEL

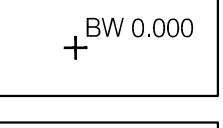


BOTTOM OF WALL LEVEL

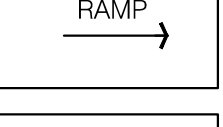


RAMP
(ARROW INDICATES UP)

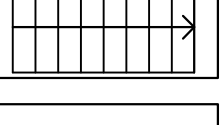

STAIR
(ARROW INDICATES UP)

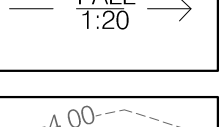

 
DIRECTION AND GRADIENT
OF SURFACE FALL
(ARROW INDICATES DOWN)




PROPOSED CONTOURS
REFER ENGINEERS DRAWINGS

NOTE: REFER LIVERPOOL COUNCIL (LCC)DRAWINGS FOR DETAILED DRAINAGE & GRADING DESIGN


PLANTING PLAN

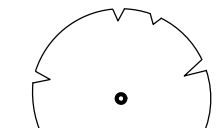


PROPOSED TREE
REFER SCHEDULE OF LANDSCAPE WORKS

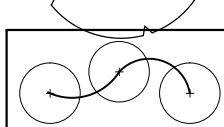


SHRUBS




XX x EUC mic

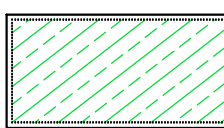


PLANTING AREA 1

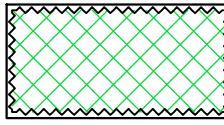


PLANTING AREA 2

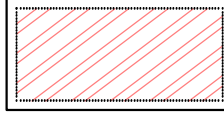


PLANTING AREA 3

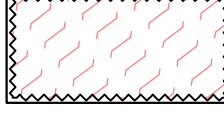

PLANTING AREA 4

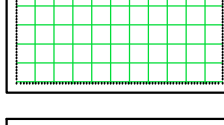


PLANTING AREA 5

 


PLANTING AREA 6

NOTE: REFER SCHEDULE OF WORKS FOR PLANT SCHEDULE, INCLUDING: SPECIES NAME, QUANTITIES, POT SIZES & SPACINGS


FURNITURE & PLAYGROUND PLAN

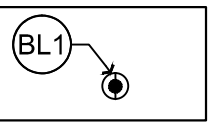


B1: BOLLARD TYPE 1
REFER SCHEDULE OF LANDSCAPE WORKS

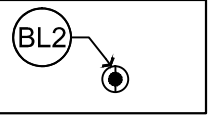


B2: BOLLARD TYPE 2
REFER SCHEDULE OF LANDSCAPE WORKS

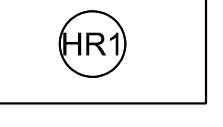


HR1: HANDRAIL TYPE 1 - STAIRS
REFER DETAIL 02/910-DT

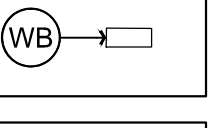


WB →
WATER BUBBLER
REFER SCHEDULE OF LANDSCAPE WORKS

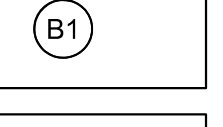


B1
RUBBISH BIN TYPE 1
REFER SCHEDULE OF LANDSCAPE WORKS

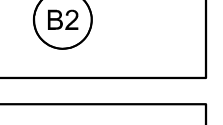


B2
RUBBISH BIN TYPE 2
REFER SCHEDULE OF LANDSCAPE WORKS

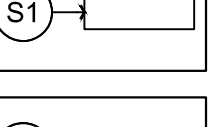


S1 →
BENCH SEAT TYPE 1
REFER SCHEDULE OF LANDSCAPE WORKS
REFER DETAIL 01/906-DT

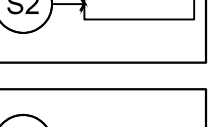


S2 →
BENCH SEAT TYPE 2
REFER SCHEDULE OF LANDSCAPE WORKS
REFER DETAIL 01/907-DT

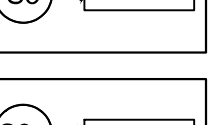


S3 →
BENCH SEAT TYPE 3
REFER SCHEDULE OF LANDSCAPE WORKS
REFER DETAIL 01/908-DT



S3a →
BENCH SEAT TYPE 3a
REFER SCHEDULE OF LANDSCAPE WORKS
REFER DETAIL 01/909-DT

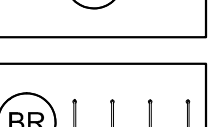


S4
BENCH SEAT TYPE 4
REFER SCHEDULE OF LANDSCAPE WORKS

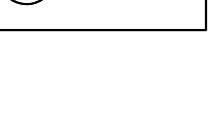


BR || || ||
BIKE RACKS
REFER SCHEDULE OF LANDSCAPE WORKS


LIGHTING PLAN

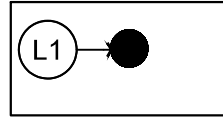


L1 - LIGHT TYPE 1
POLE TOP LIGHT
REFER SCHEDULE OF LANDSCAPE WORS

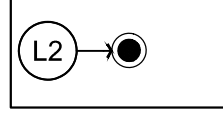


L2 - LIGHT TYPE 2
FLOOD LIGHTS
REFER SCHEDULE OF LANDSCAPE WORS

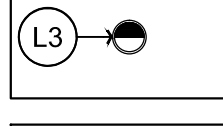


L3- LIGHT TYPE 3
UPLIGHTS
REFER SCHEDULE OF LANDSCAPE WORS

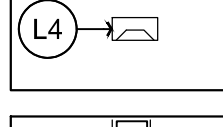


L4 - LIGHT TYPE 4
WALL MOUNTED LIGHTS
REFER SCHEDULE OF LANDSCAPE WORS

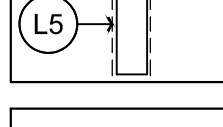


L5 - LIGHT TYPE 5
SEATING DOWN LIGHT
REFER SCHEDULE OF LANDSCAPE WORS

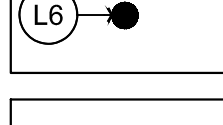


L6 - LIGHT TYPE 6
UPLIGHTS TO SOUNDSCAPE ART
REFER SCHEDULE OF LANDSCAPE WORS

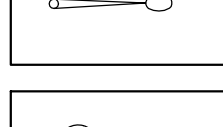

EXISTING LIGHTPOLE
TO BE RETAINED

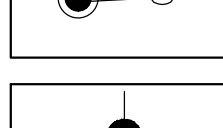


EXISTING FLOODLIGHT
TO BE RETAINED

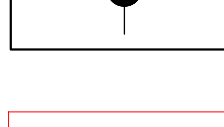

3 PHASE POWER SUPPLY
REFER WEBB AUSTRALIA GROUP DRAWINGS

NOTE: REFER WEBB AUSTRALIA GROUP DRAWINGS FOR ALL DETAILED LIGHTING & ELECTRICAL DRAWINGS

KEY PLAN

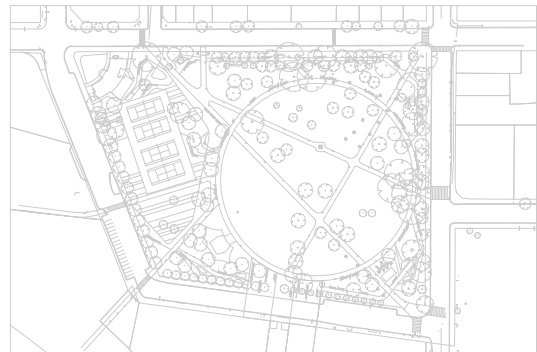

DRAFT

CLIENT
LIVERPOOL CITY COUNCIL



PROJECT DIRECTOR: X.X.

REV	NO	DESCRIPTION	DWN	CHK	DATE
-	-	-	-	-	-
-	-	-	-	-	-
D	04	95% CONSTRUCTION DOCUMENTATION	CG	MK	06.03.15
C	03	50% CONSTRUCTION DOCUMENTATION	CG	MK	23.01.15
B	02	100% DESIGN DEVELOPMENT	CG	MK	28.11.14
A	01	75% DESIGN DEVELOPMENT	CG	MK	07.11.14

PROJECT
BIGGE PARK - LIVERPOOL
CNR OF MOORE STREET & BIGGE ST, LIVERPOOL, NSW

DRAWING TITLE
COVER SHEET
LEGENDS

ISSUE
NOT FOR CONSTRUCTION

SCALE

NA

DRAWING NO.


BP-001-CS

PROJECT NO.
ND1075



REVISION

D

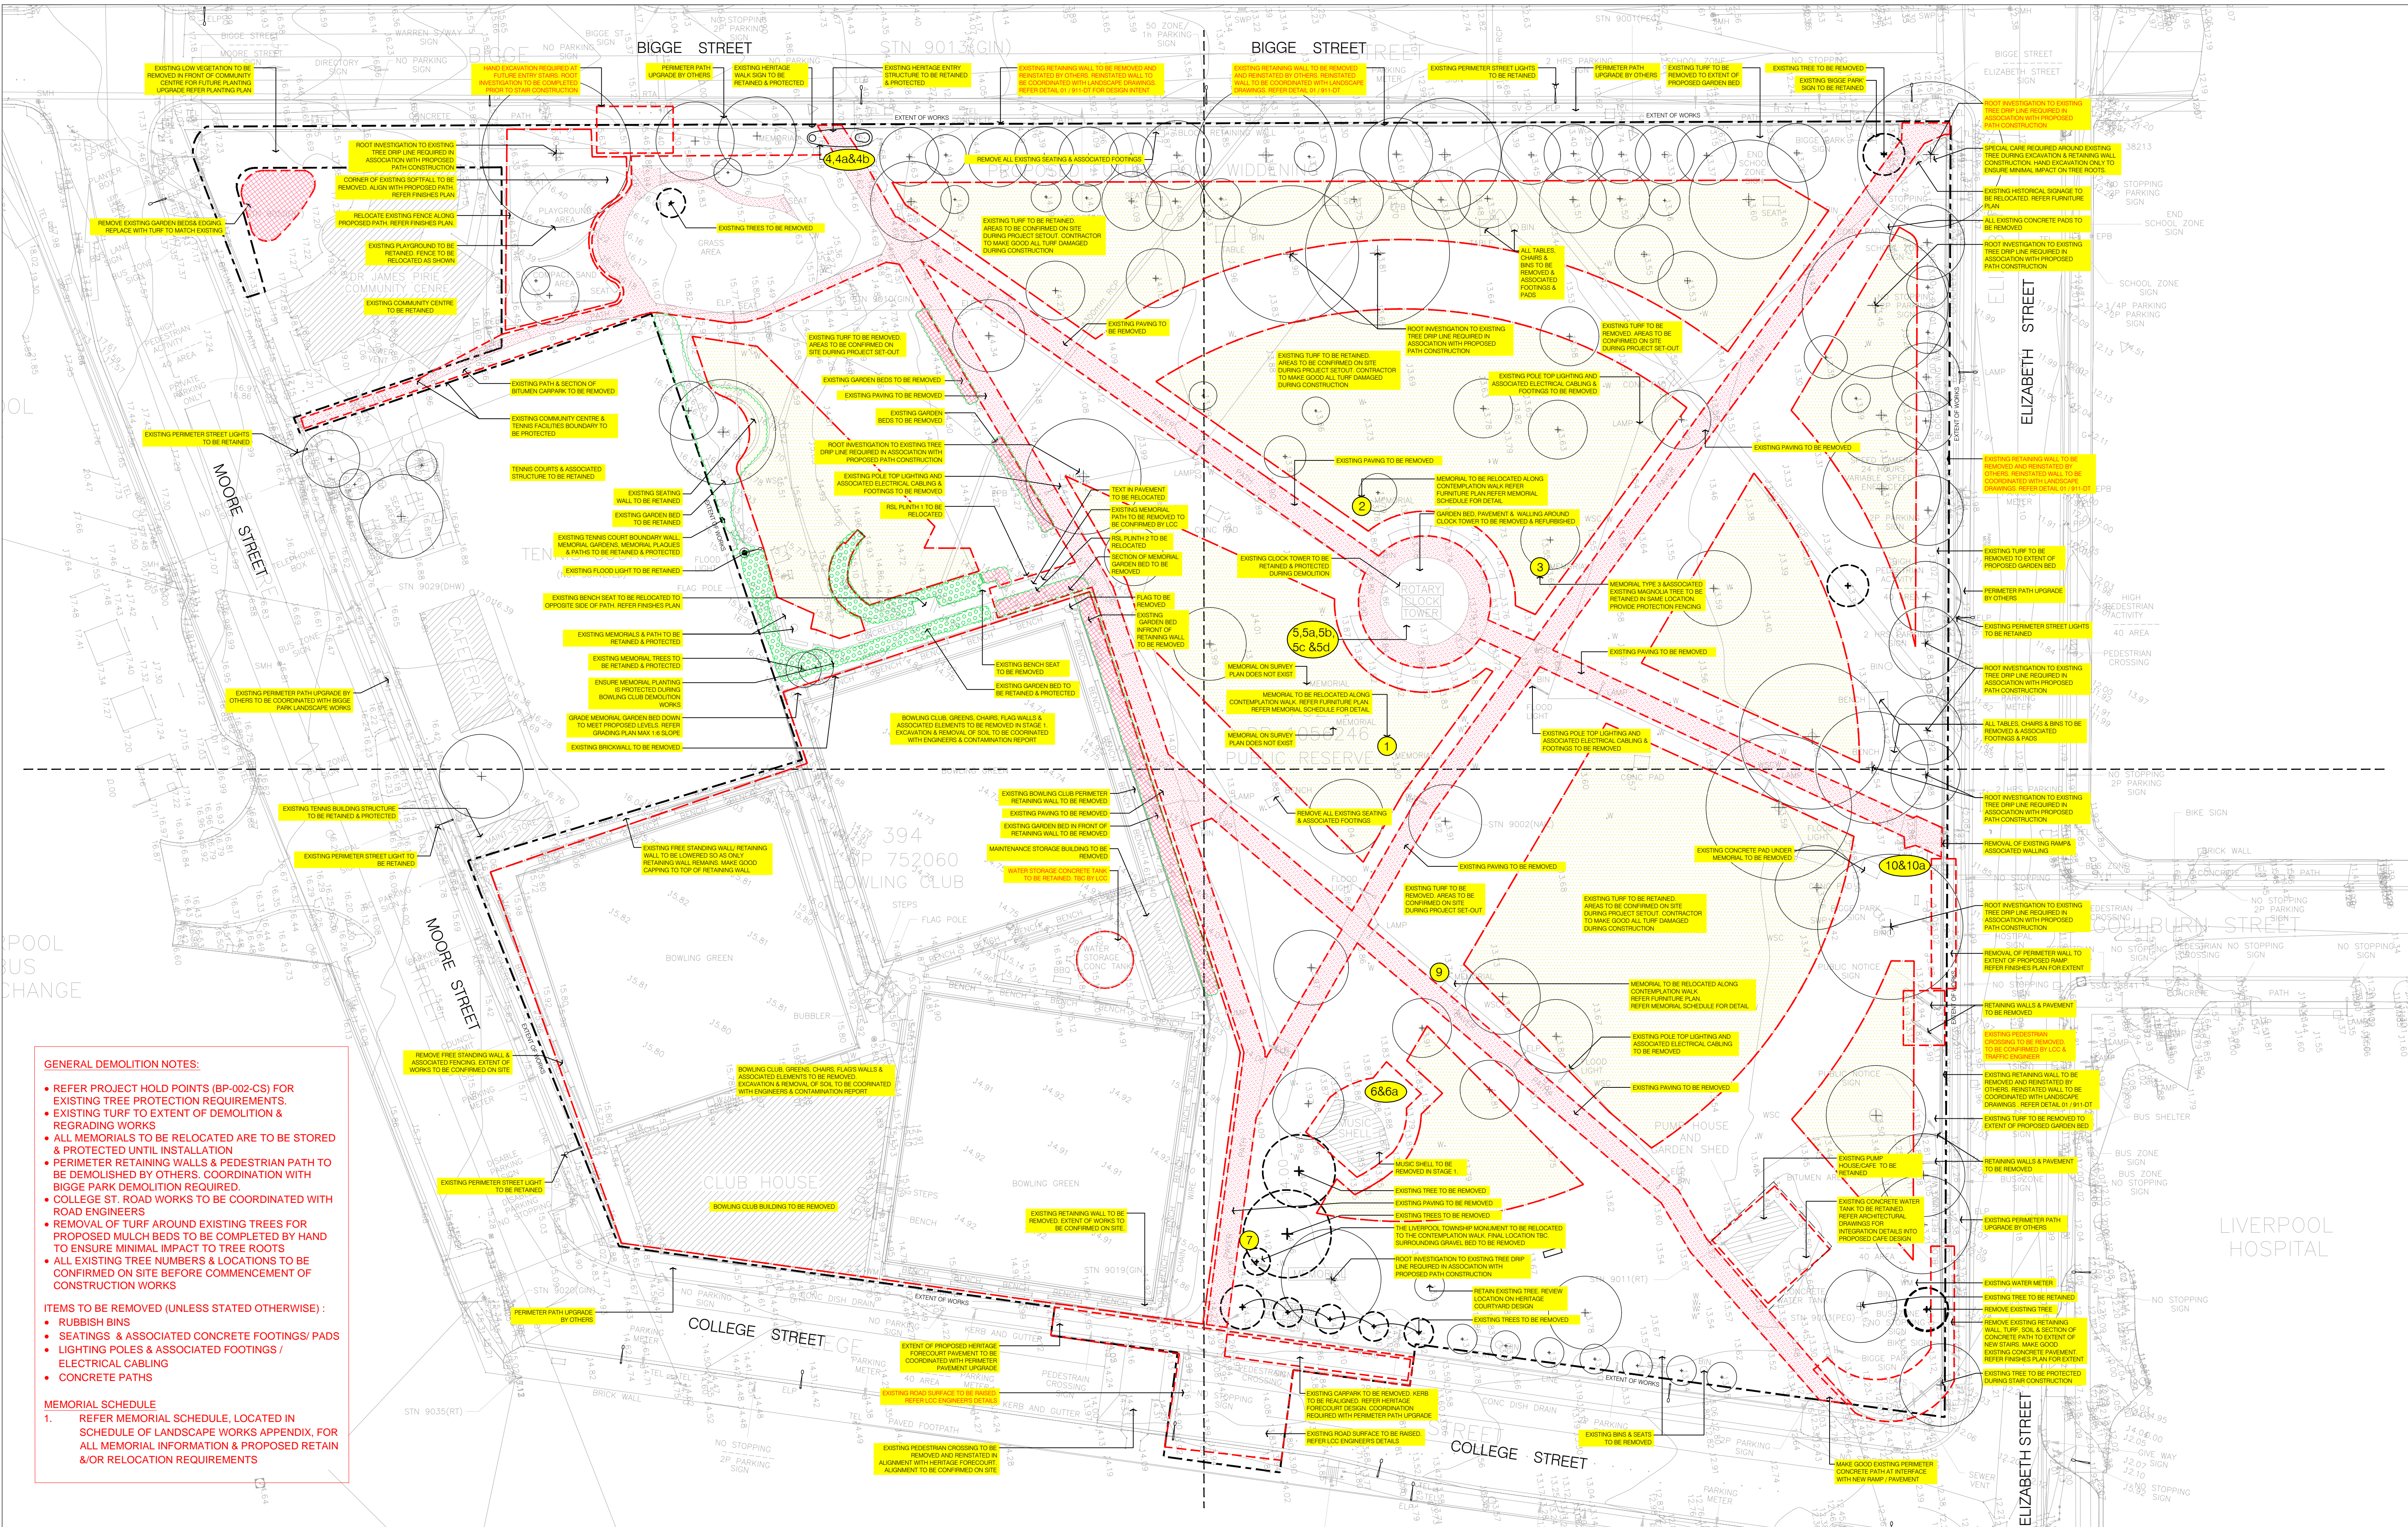


- GENERAL DEMOLITION NOTES:**
- REFER PROJECT HOLD POINTS (BP-002-CS) FOR EXISTING TREE PROTECTION REQUIREMENTS.
 - EXISTING TURF TO EXTENT OF DEMOLITION & REGRADING WORKS
 - ALL MEMORIALS TO BE RELOCATED ARE TO BE STORED & PROTECTED UNTIL INSTALLATION
 - PERIMETER RETAINING WALLS & PEDESTRIAN PATH TO BE DEMOLISHED BY OTHERS. COORDINATION WITH BIGGE PARK DEMOLITION REQUIRED.
 - COLLEGE ST. ROAD WORKS TO BE COORDINATED WITH ROAD ENGINEERS
 - REMOVAL OF TURF AROUND EXISTING TREES FOR PROPOSED MULCH BEDS TO BE COMPLETED BY HAND TO ENSURE MINIMAL IMPACT TO TREE ROOTS
 - ALL EXISTING TREE NUMBERS & LOCATIONS TO BE CONFIRMED ON SITE BEFORE COMMENCEMENT OF CONSTRUCTION WORKS
- ITEMS TO BE REMOVED (UNLESS STATED OTHERWISE) :**
- RUBBISH BINS
 - SEATINGS & ASSOCIATED CONCRETE FOOTINGS/ PADS
 - LIGHTING POLES & ASSOCIATED FOOTINGS / ELECTRICAL CABLING
 - CONCRETE PATHS
- MEMORIAL SCHEDULE**
- REFER MEMORIAL SCHEDULE, LOCATED IN SCHEDULE OF LANDSCAPE WORKS APPENDIX, FOR ALL MEMORIAL INFORMATION & PROPOSED RETAIN &/OR RELOCATION REQUIREMENTS




REV	NO	DESCRIPTION	DWN	CHK	DATE
D	04	95% CONSTRUCTION DOCUMENTATION	CG	MK	06.03.15
C	03	50% CONSTRUCTION DOCUMENTATION	CG	MK	23.01.15
B	02	100% DESIGN DEVELOPMENT	CG	MK	28.11.14
A	01	75% DESIGN DEVELOPMENT	CG	MK	07.11.14

REFER BP-151-DE

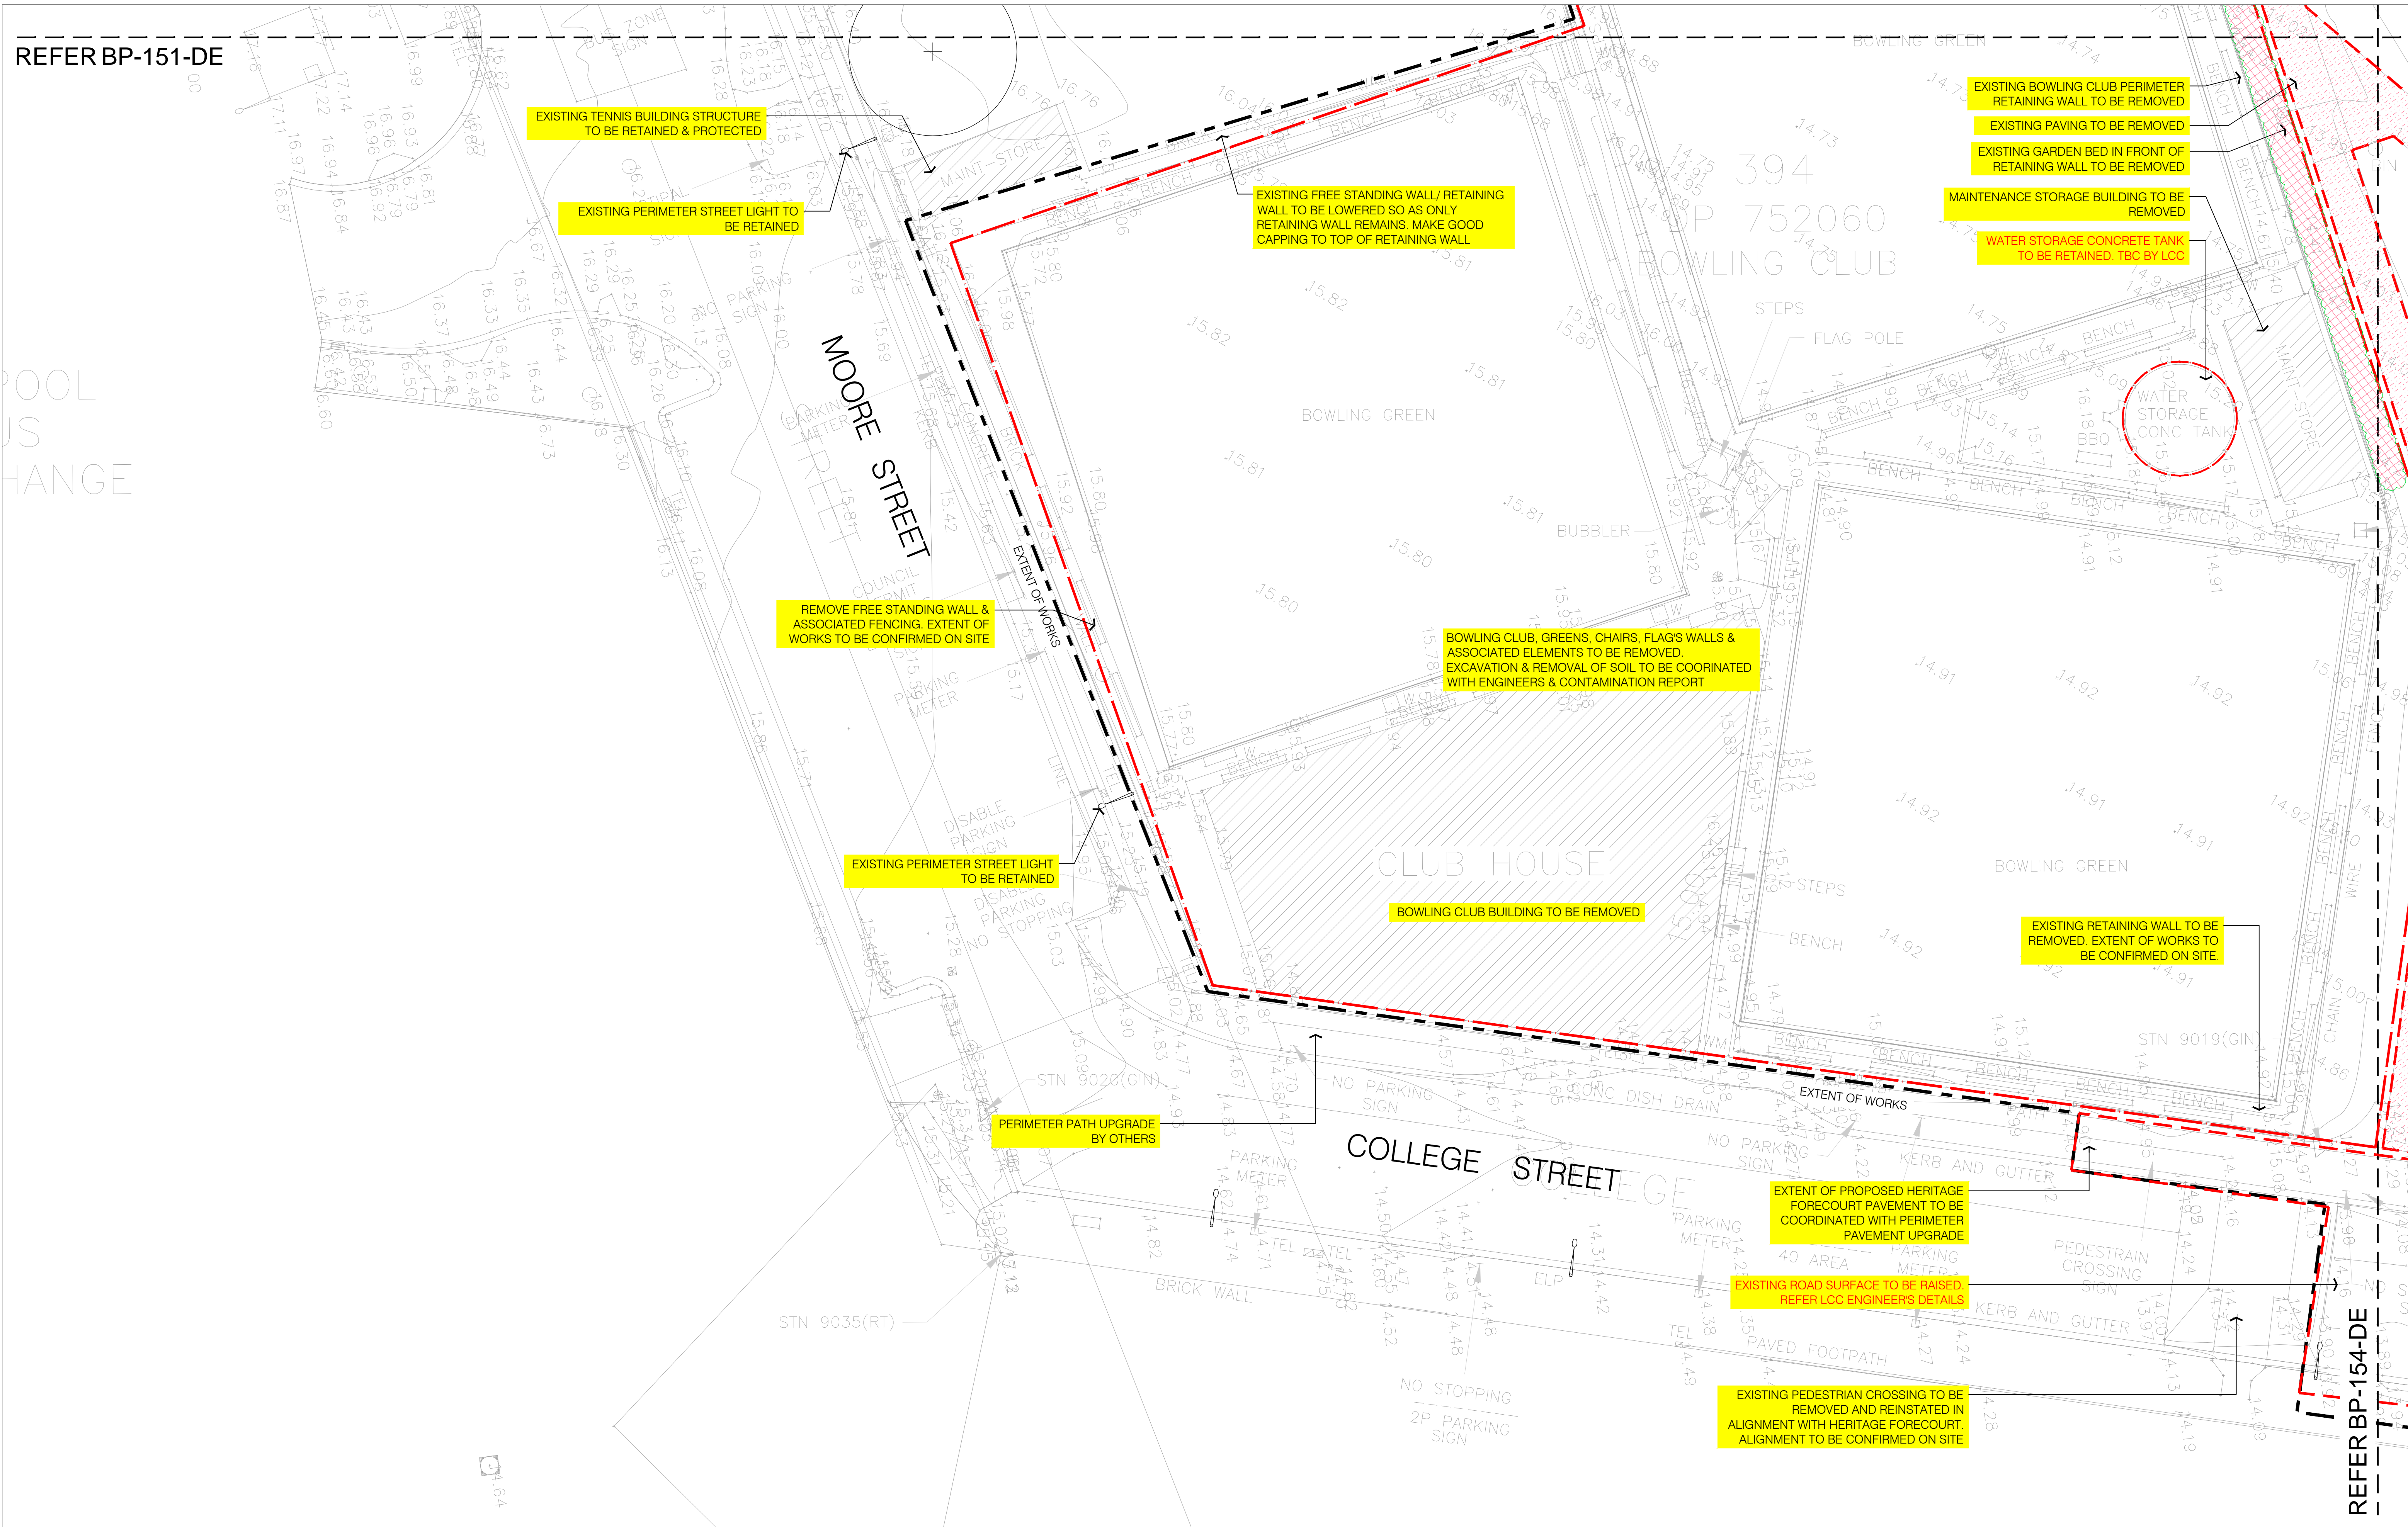


REFER BP-154-DE

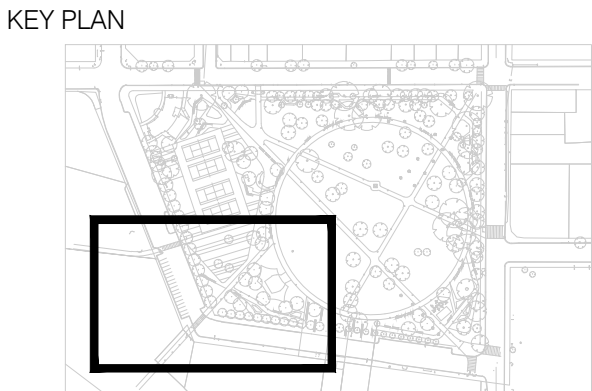

DRAFT

REV/NO	DESCRIPTION	DWN	CHK	DATE
D 04	95% CONSTRUCTION DOCUMENTATION	CG	MK	06.03.15
C 03	50% CONSTRUCTION DOCUMENTATION	CG	MK	23.01.15
B 02	100% DESIGN DEVELOPMENT	CG	MK	28.11.14
A 01	75% DESIGN DEVELOPMENT	CG	MK	07.11.14

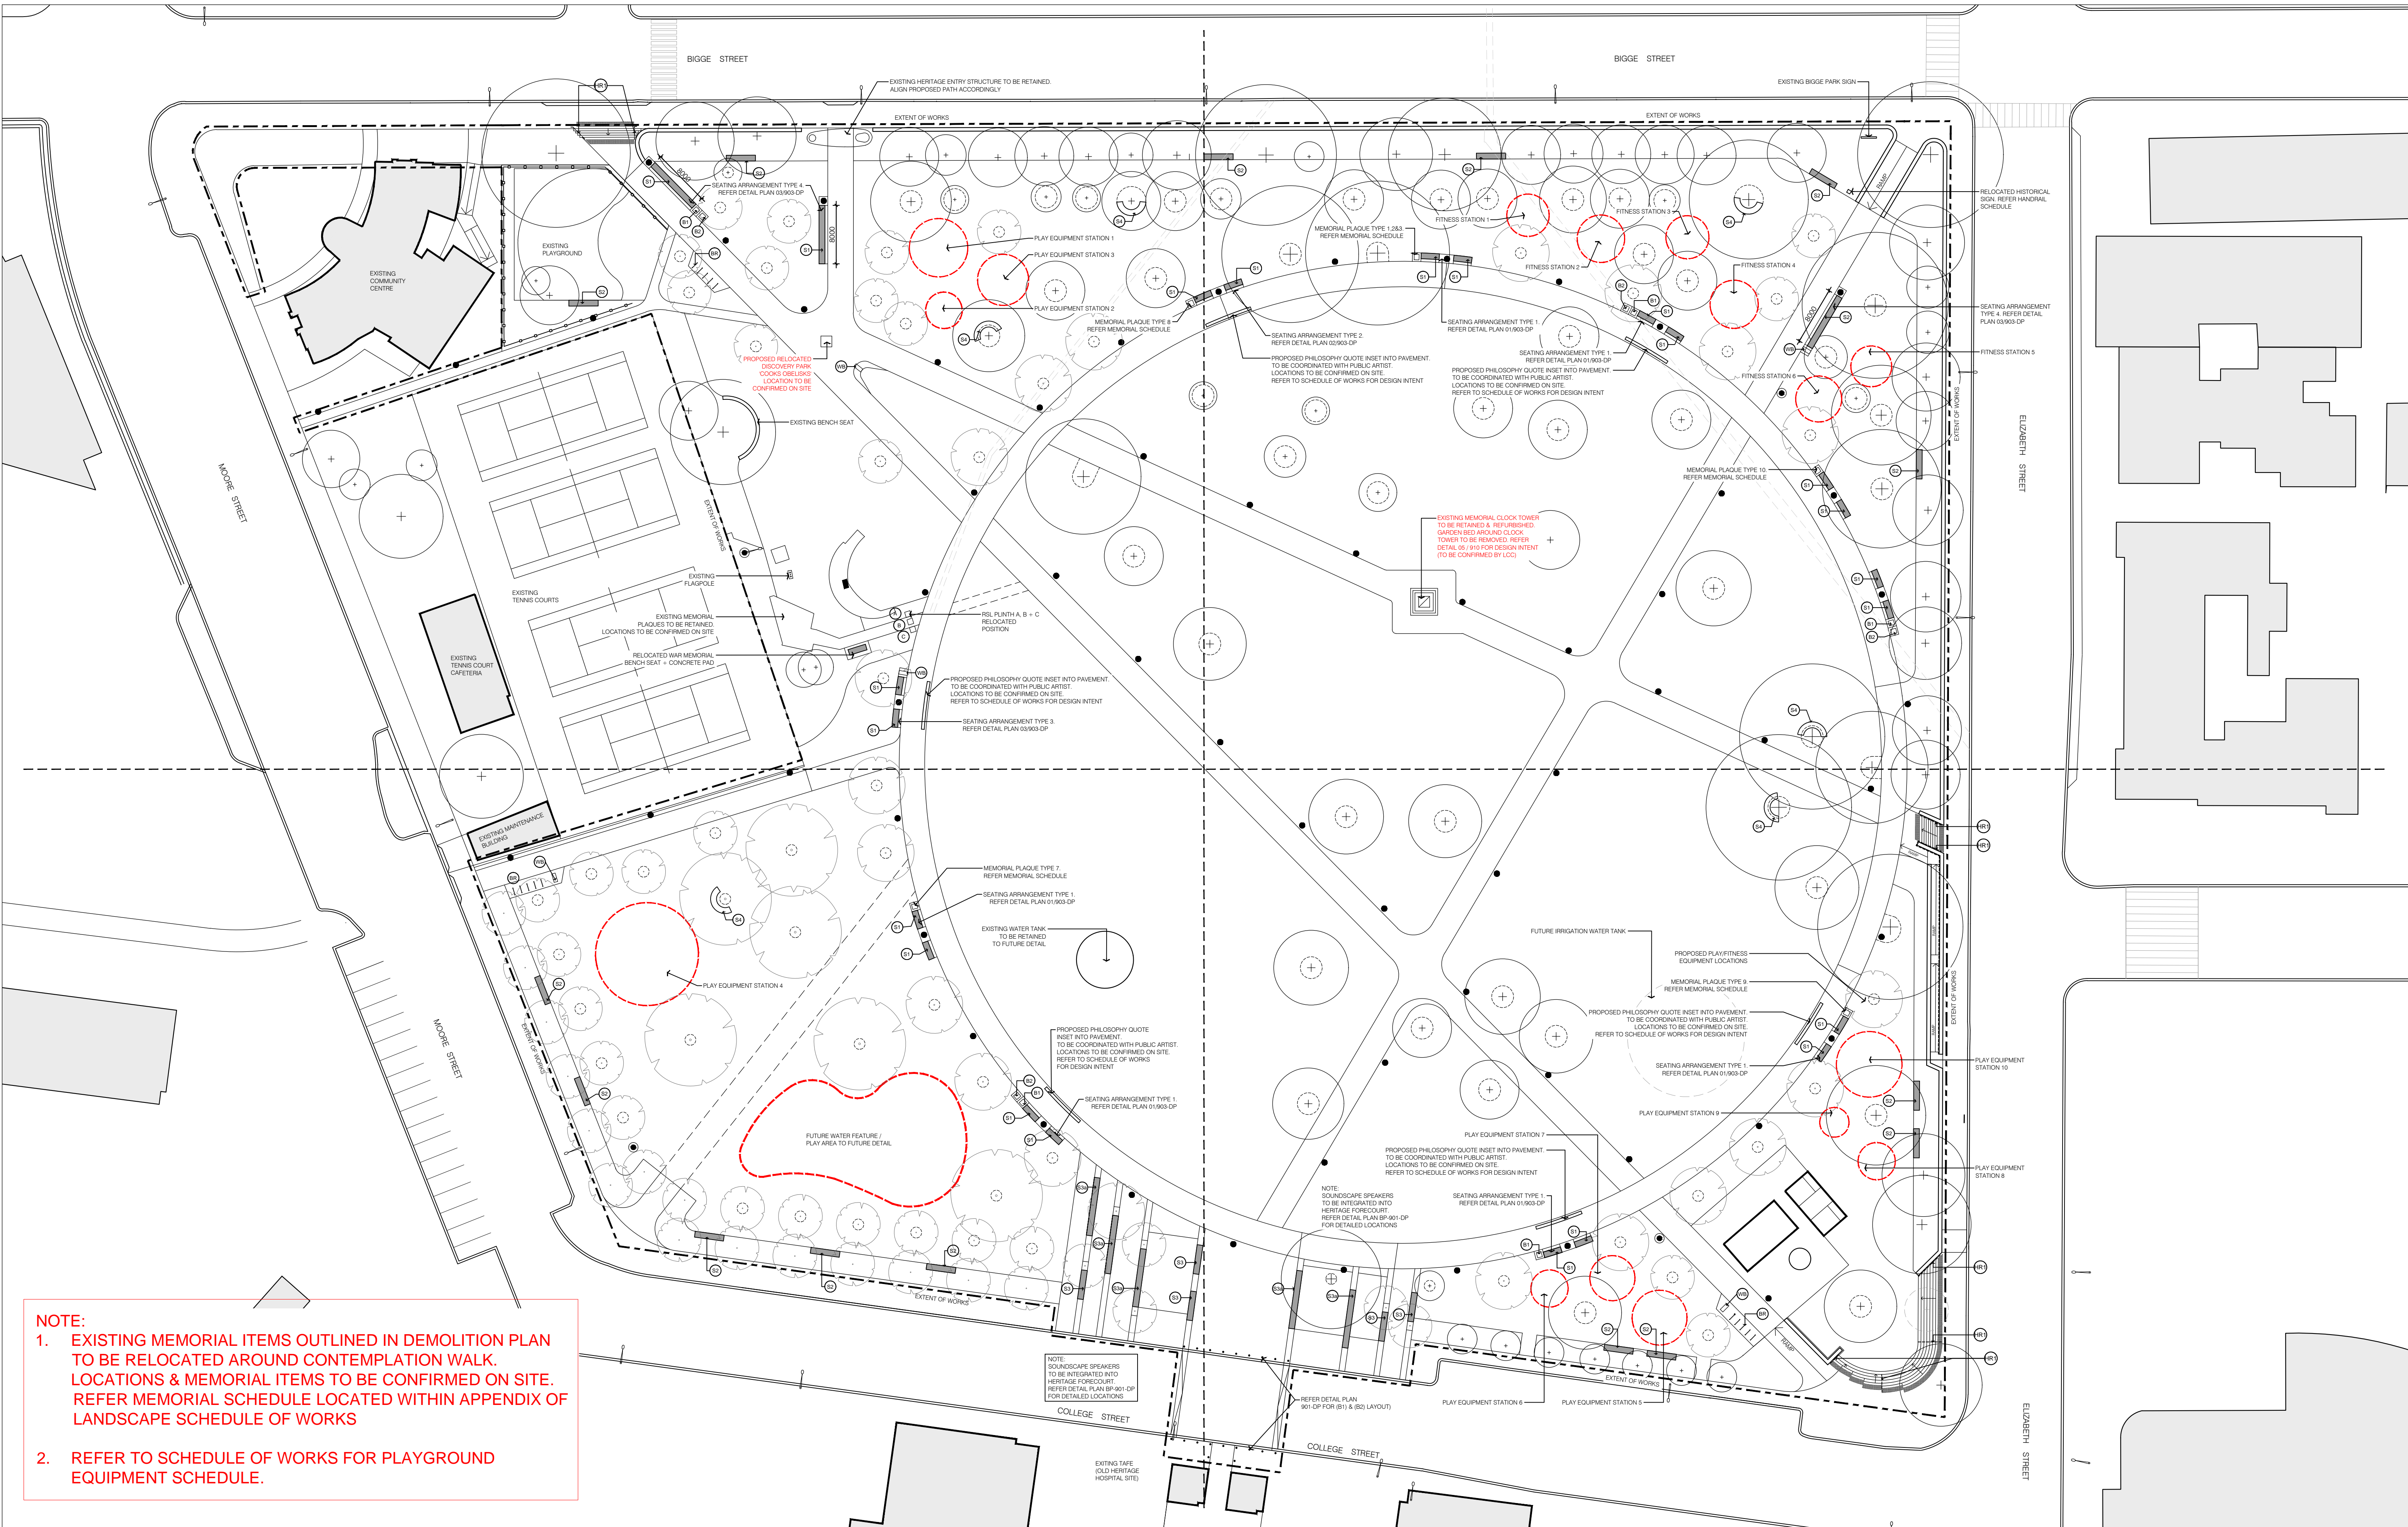

NOTE:

- EXISTING MEMORIAL ITEMS OUTLINED IN DEMOLITION PLAN TO BE RELOCATED AROUND CONTEMPLATION WALK. LOCATIONS & MEMORIAL ITEMS TO BE CONFIRMED ON SITE. REFER MEMORIAL SCHEDULE LOCATED WITHIN APPENDIX OF LANDSCAPE SCHEDULE OF WORKS
- REFER TO SCHEDULE OF WORKS FOR PLAYGROUND EQUIPMENT SCHEDULE.



Tower 2, Level 23, Darling Park
201 Sussex Street
Sydney NSW 2000 Australia
TEL +612 8233 9900
FAX +612 8233 9966
www.urbis.com.au

Urbis Pty Ltd ABN 50 105 256 228
Australia, Asia, Middle East

KEY PLAN



CLIENT
LIVERPOOL CITY COUNCIL



PROJECT DIRECTOR: X.X.

DRAFT

REV/NO	DESCRIPTION	DWN/CHK	DATE
D 04	95% CONSTRUCTION DOCUMENTATION	CG MK	06.03.15
C 03	50% CONSTRUCTION DOCUMENTATION	CG MK	23.01.15
B 02	100% DESIGN DEVELOPMENT	CG MK	28.11.14
A 01	75% DESIGN DEVELOPMENT	CG MK	07.11.14

PROJECT
BIGGE PARK - LIVERPOOL
CNR OF MOORE STREET & BIGGE ST, LIVERPOOL, NSW

DRAWING TITLE
**LANDSCAPE FURNITURE
& PLAYGROUND PLAN**


ISSUE
NOT FOR CONSTRUCTION

SCALE
1:400 @ A1 1:800 @ A3


DRAWING NO.
BP-600-FU

PROJECT NO.
ND1075

REVISION
D

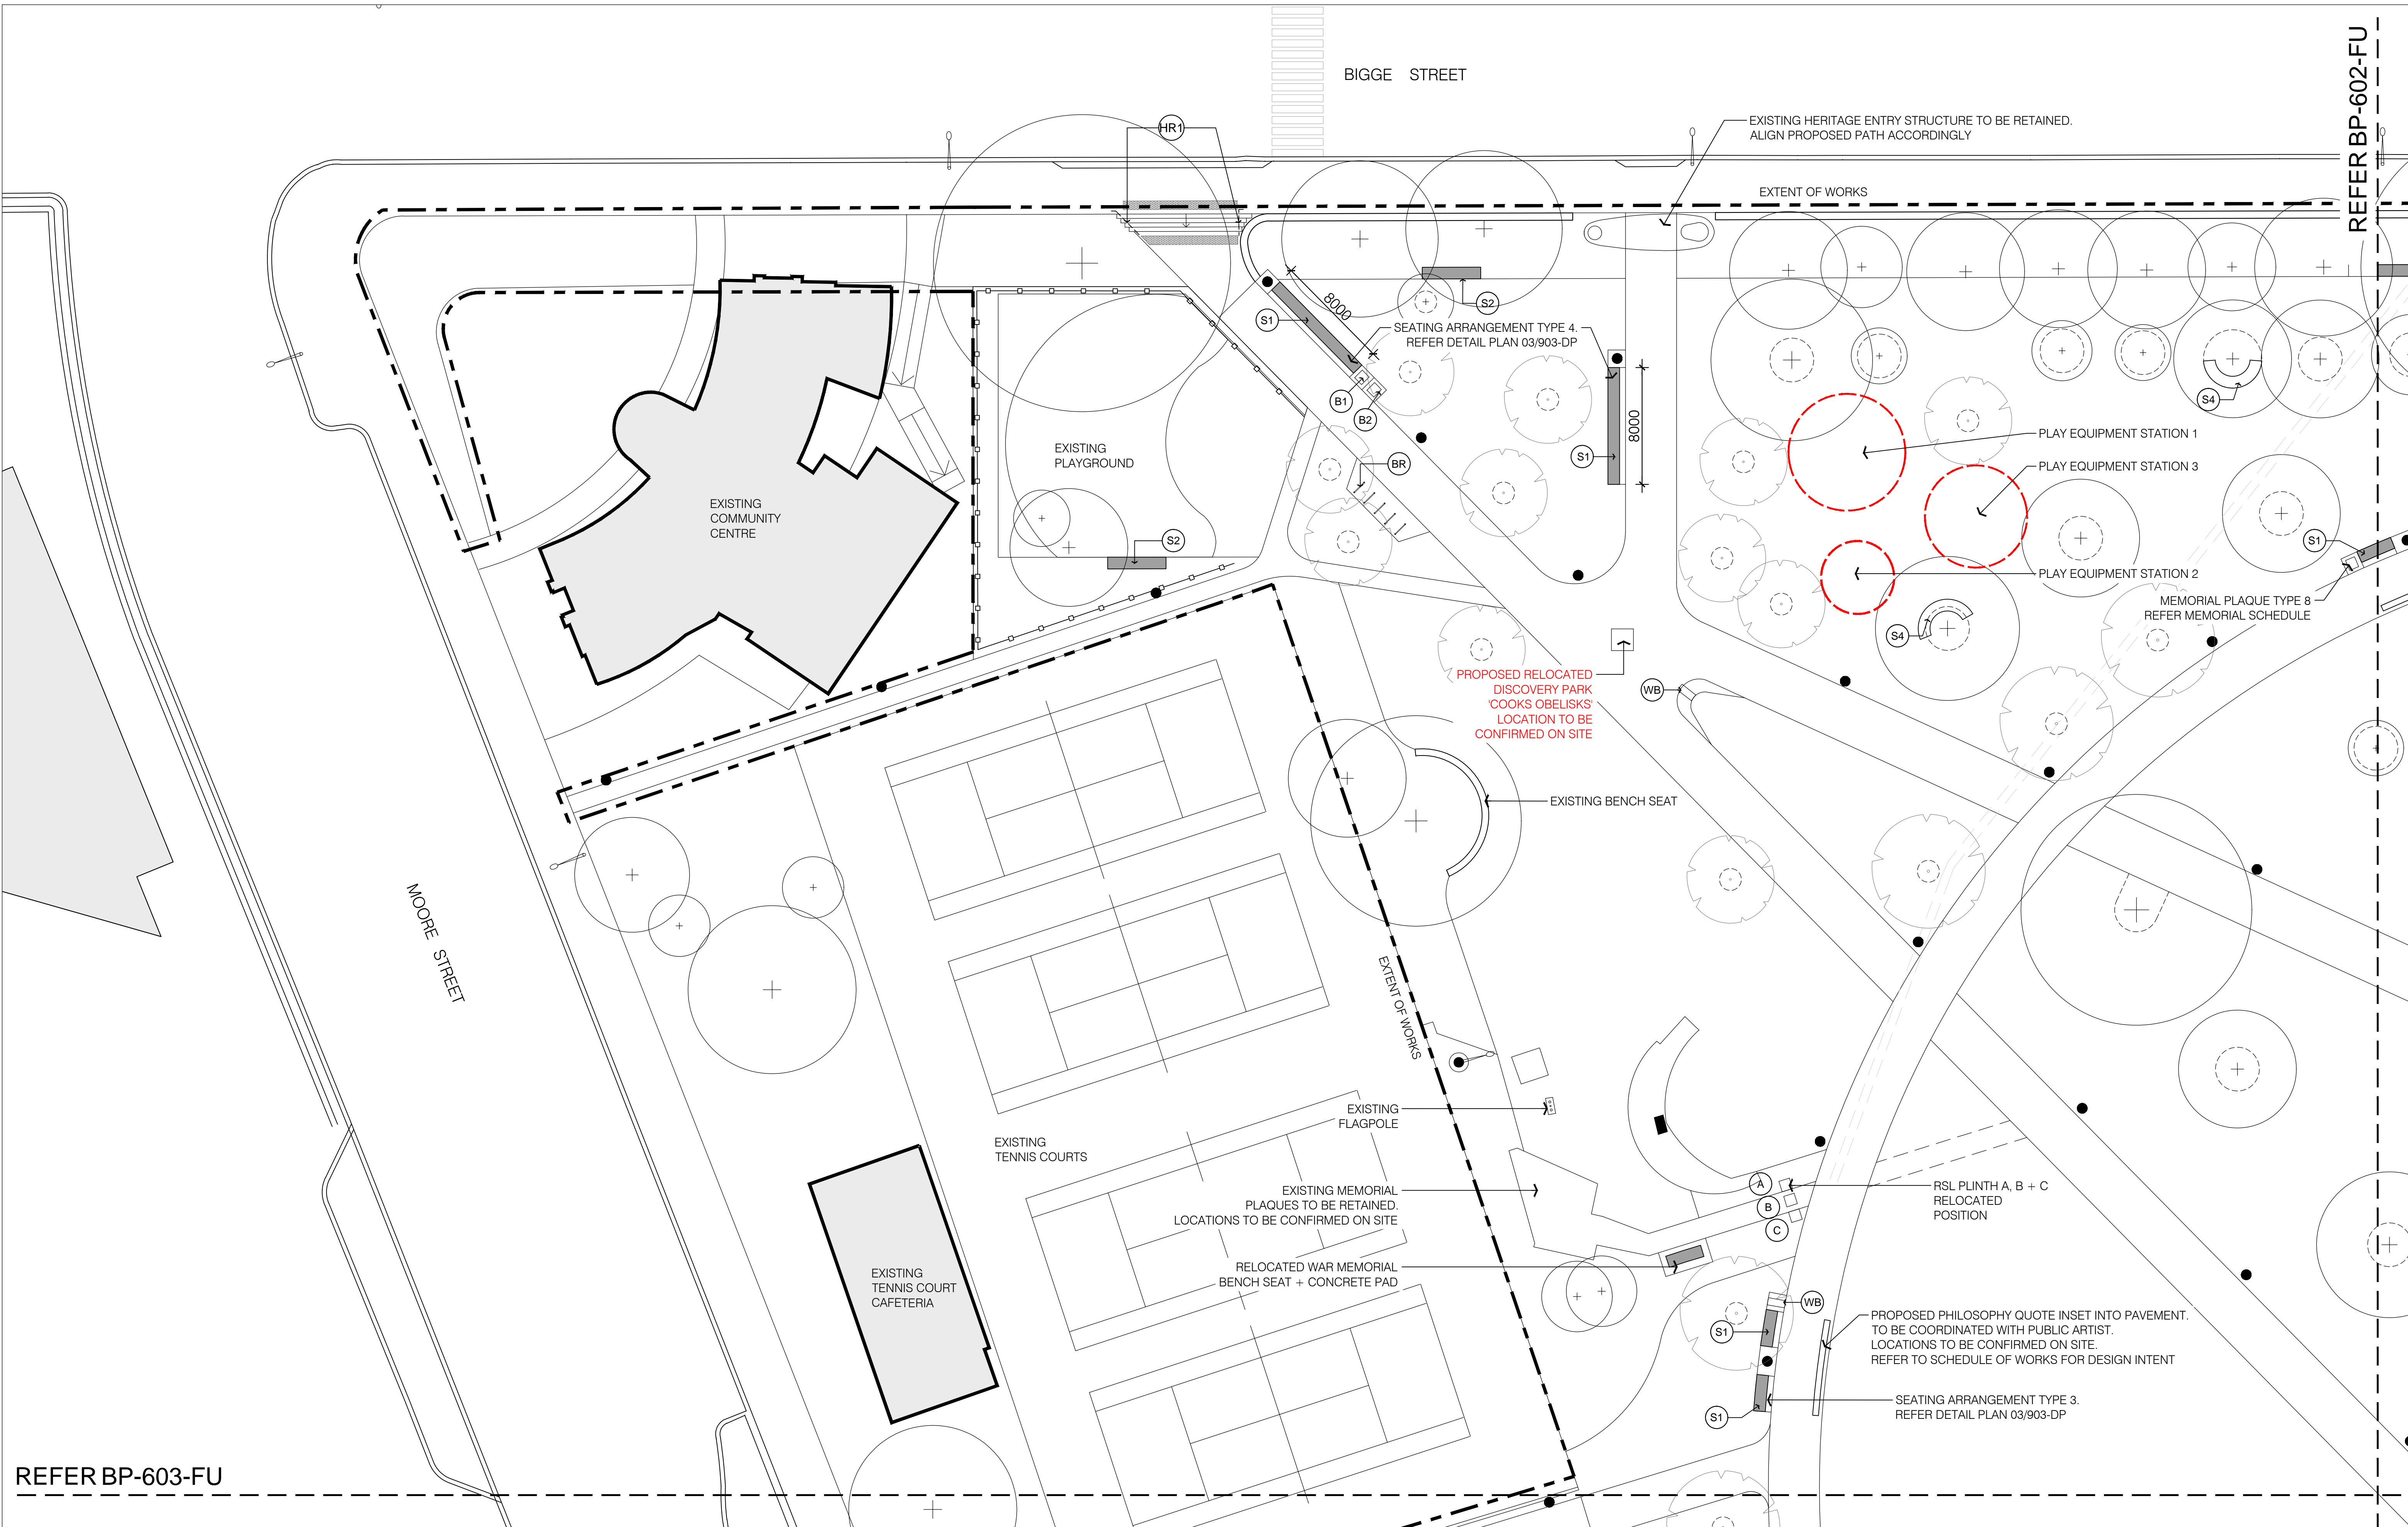


REFER BP-603-FU


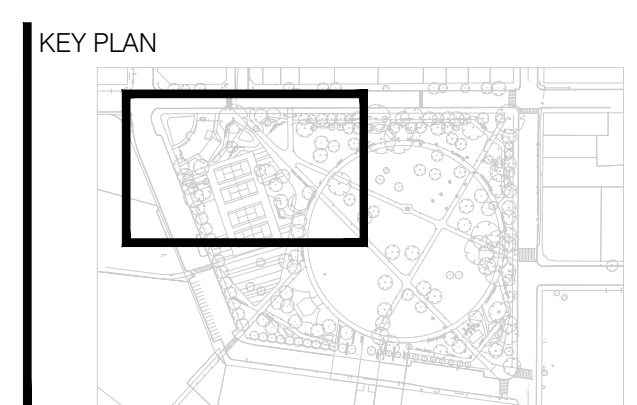


DRAFT

REV/NO	DESCRIPTION	DWN/CHK	DATE
D 04	95% CONSTRUCTION DOCUMENTATION	CG MK	06.03.15
C 03	50% CONSTRUCTION DOCUMENTATION	CG MK	23.01.15
B 02	100% DESIGN DEVELOPMENT	CG MK	28.11.14
A 01	75% DESIGN DEVELOPMENT	CG MK	07.11.14


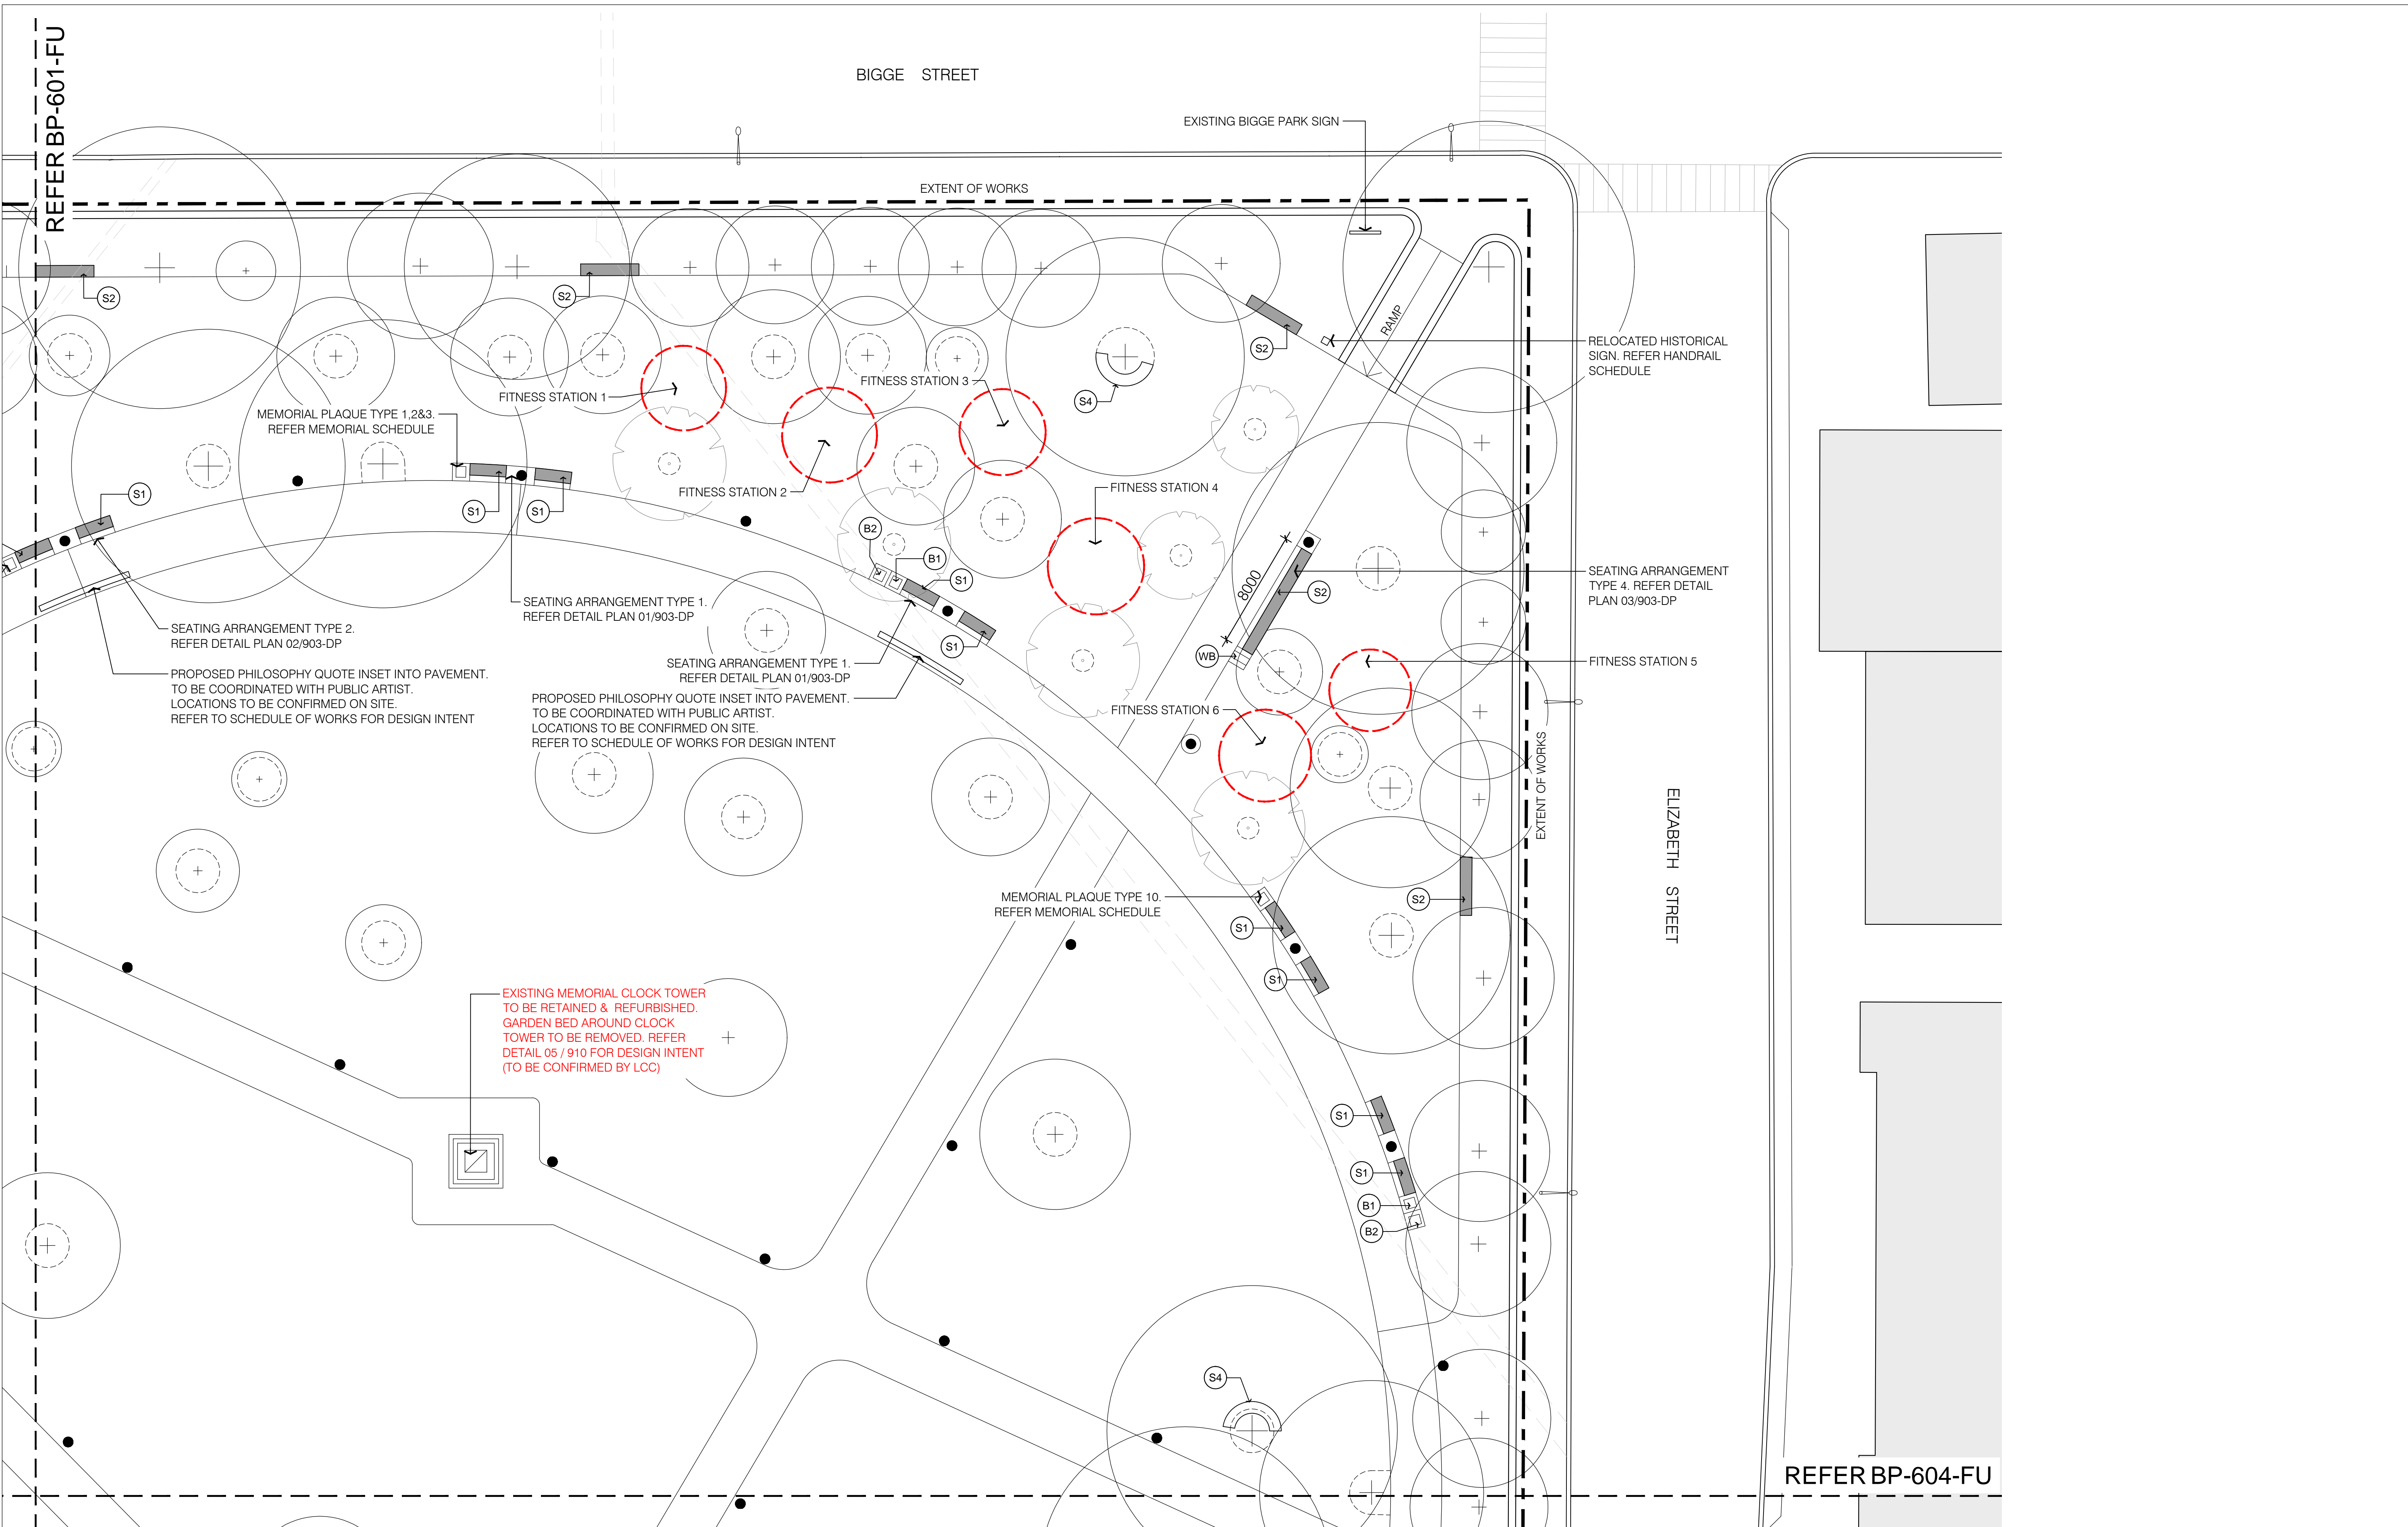


REFER BP-601-FU

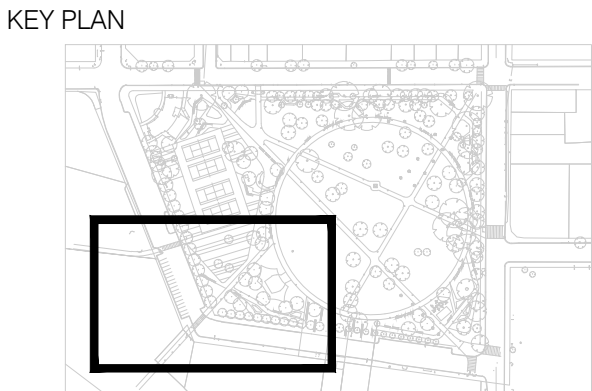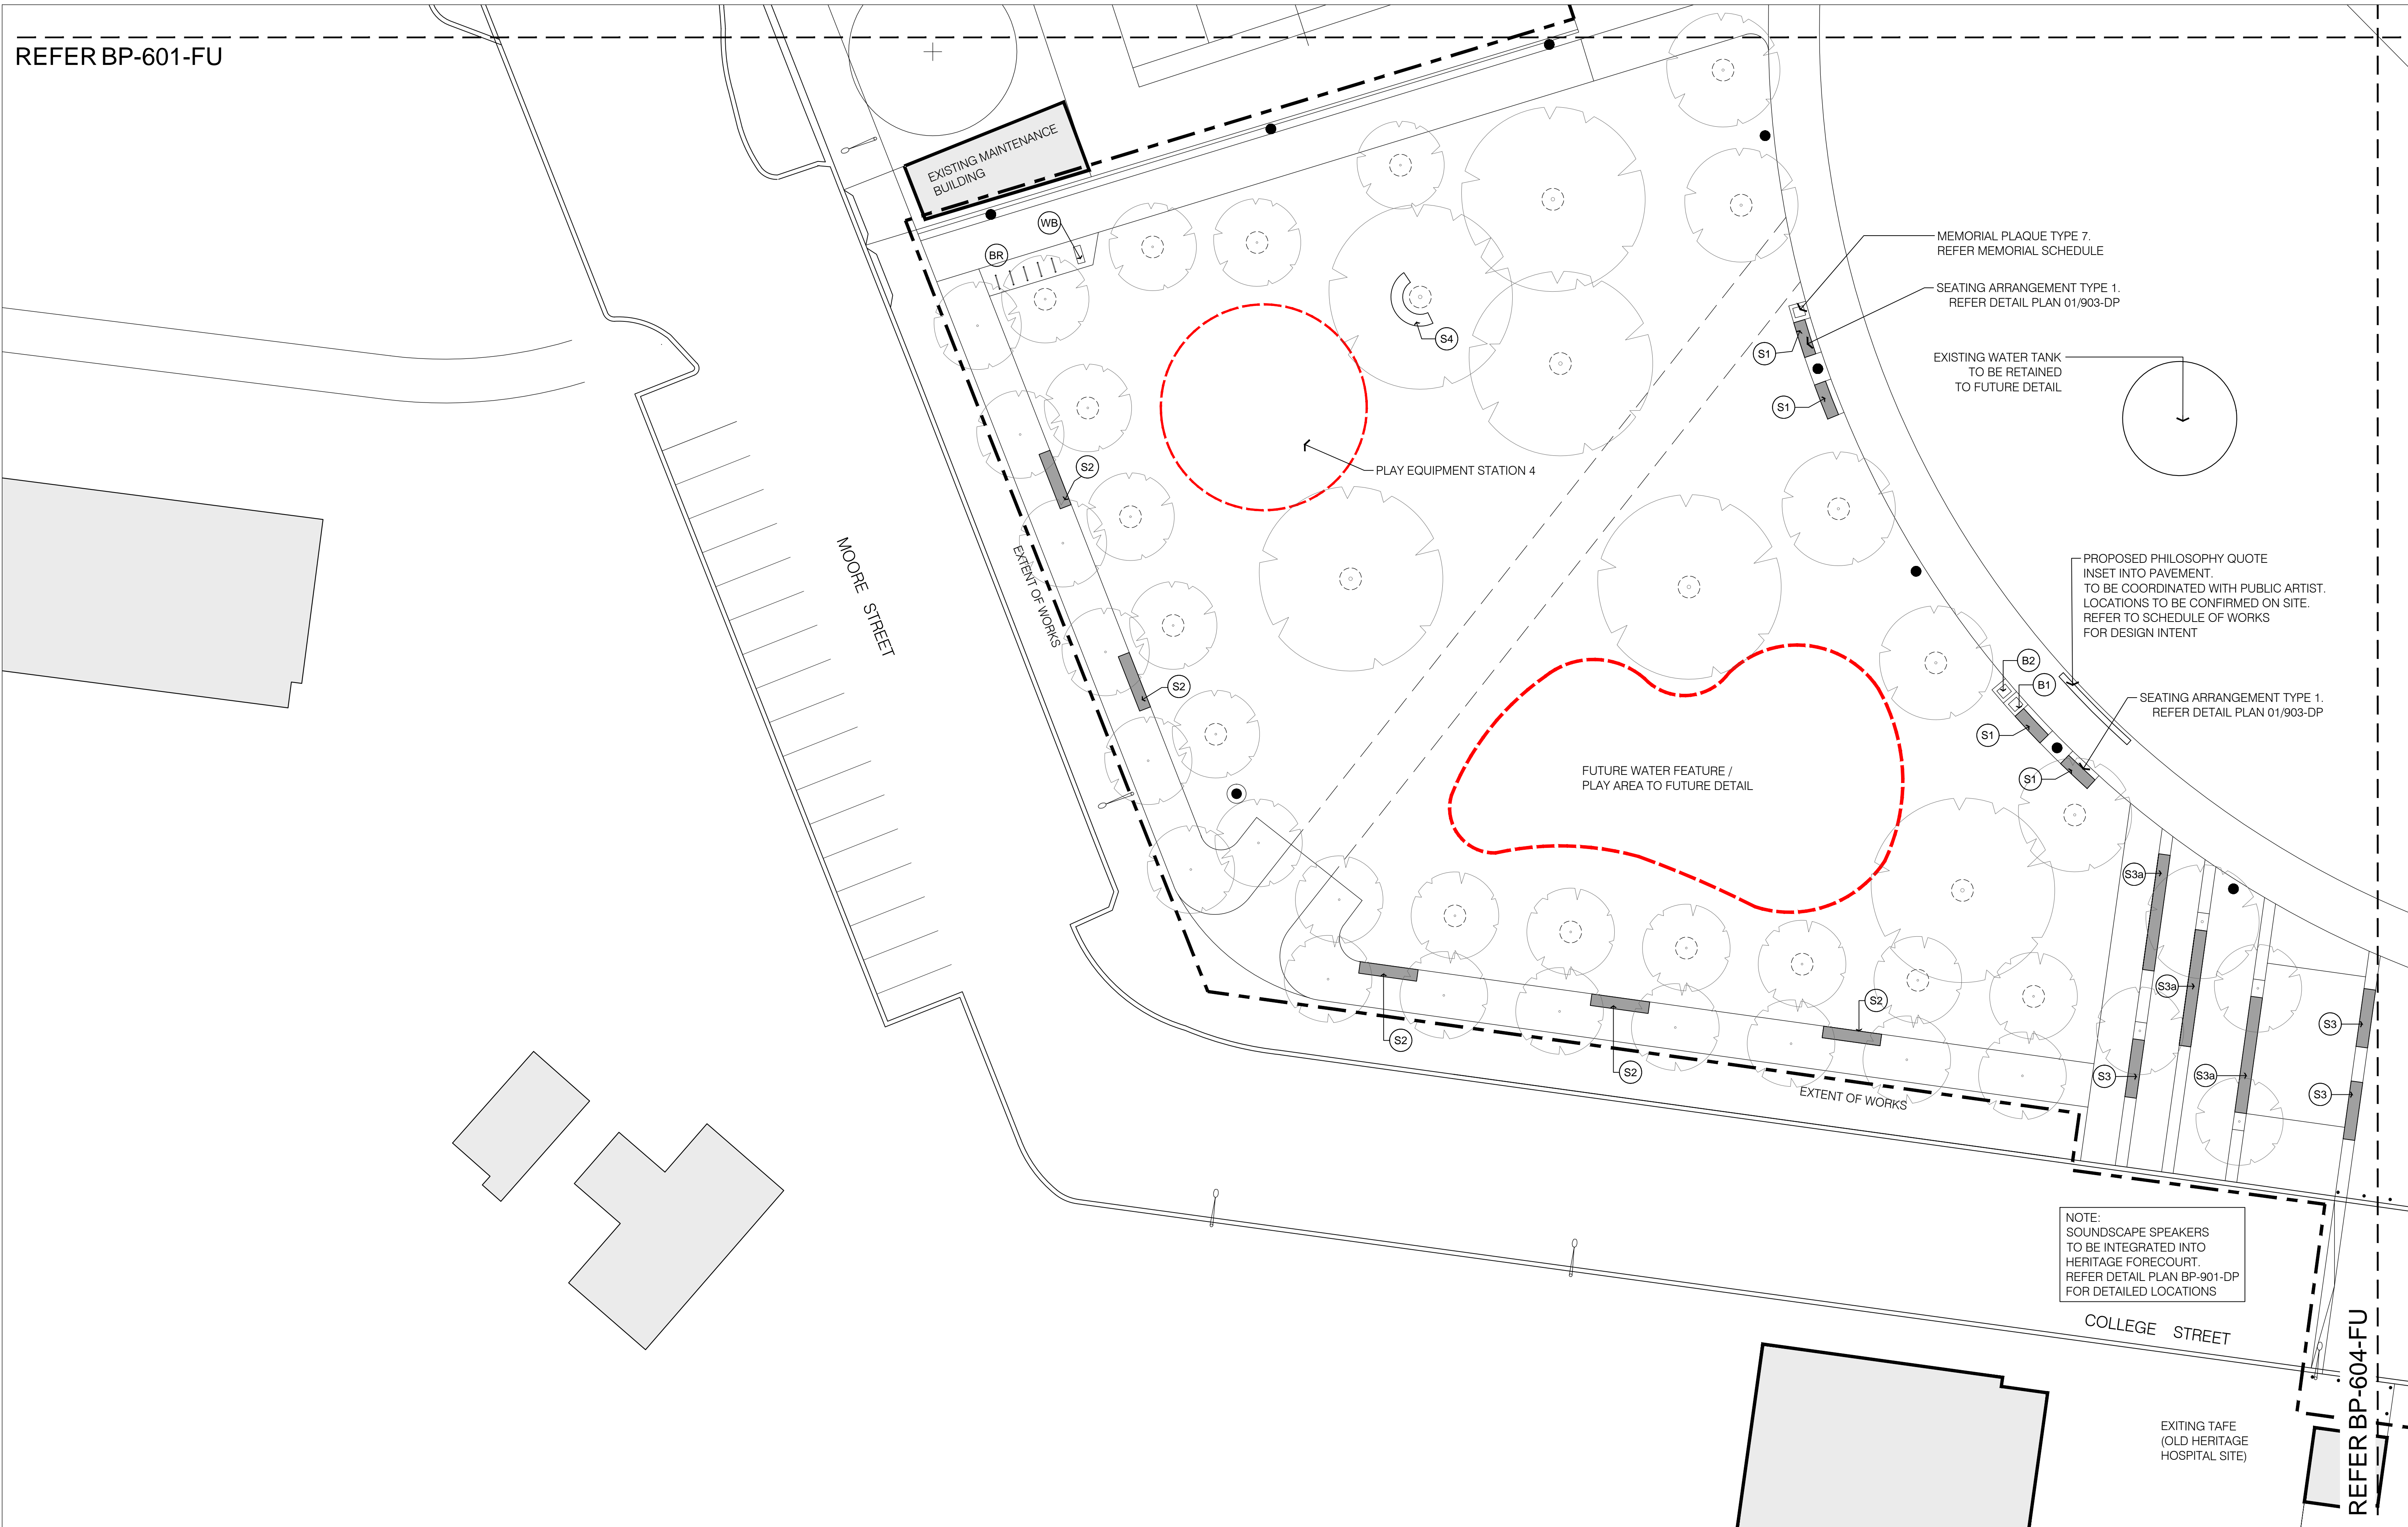

DRAFT

REV	NO	DESCRIPTION	DWN	CHK	DATE
D	04	95% CONSTRUCTION DOCUMENTATION	CG	MK	06.03.15
C	03	50% CONSTRUCTION DOCUMENTATION	CG	MK	23.01.15
B	02	100% DESIGN DEVELOPMENT	CG	MK	28.11.14
A	01	75% DESIGN DEVELOPMENT	CG	MK	07.11.14

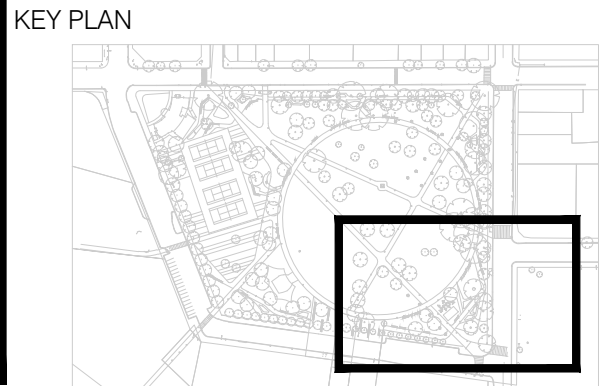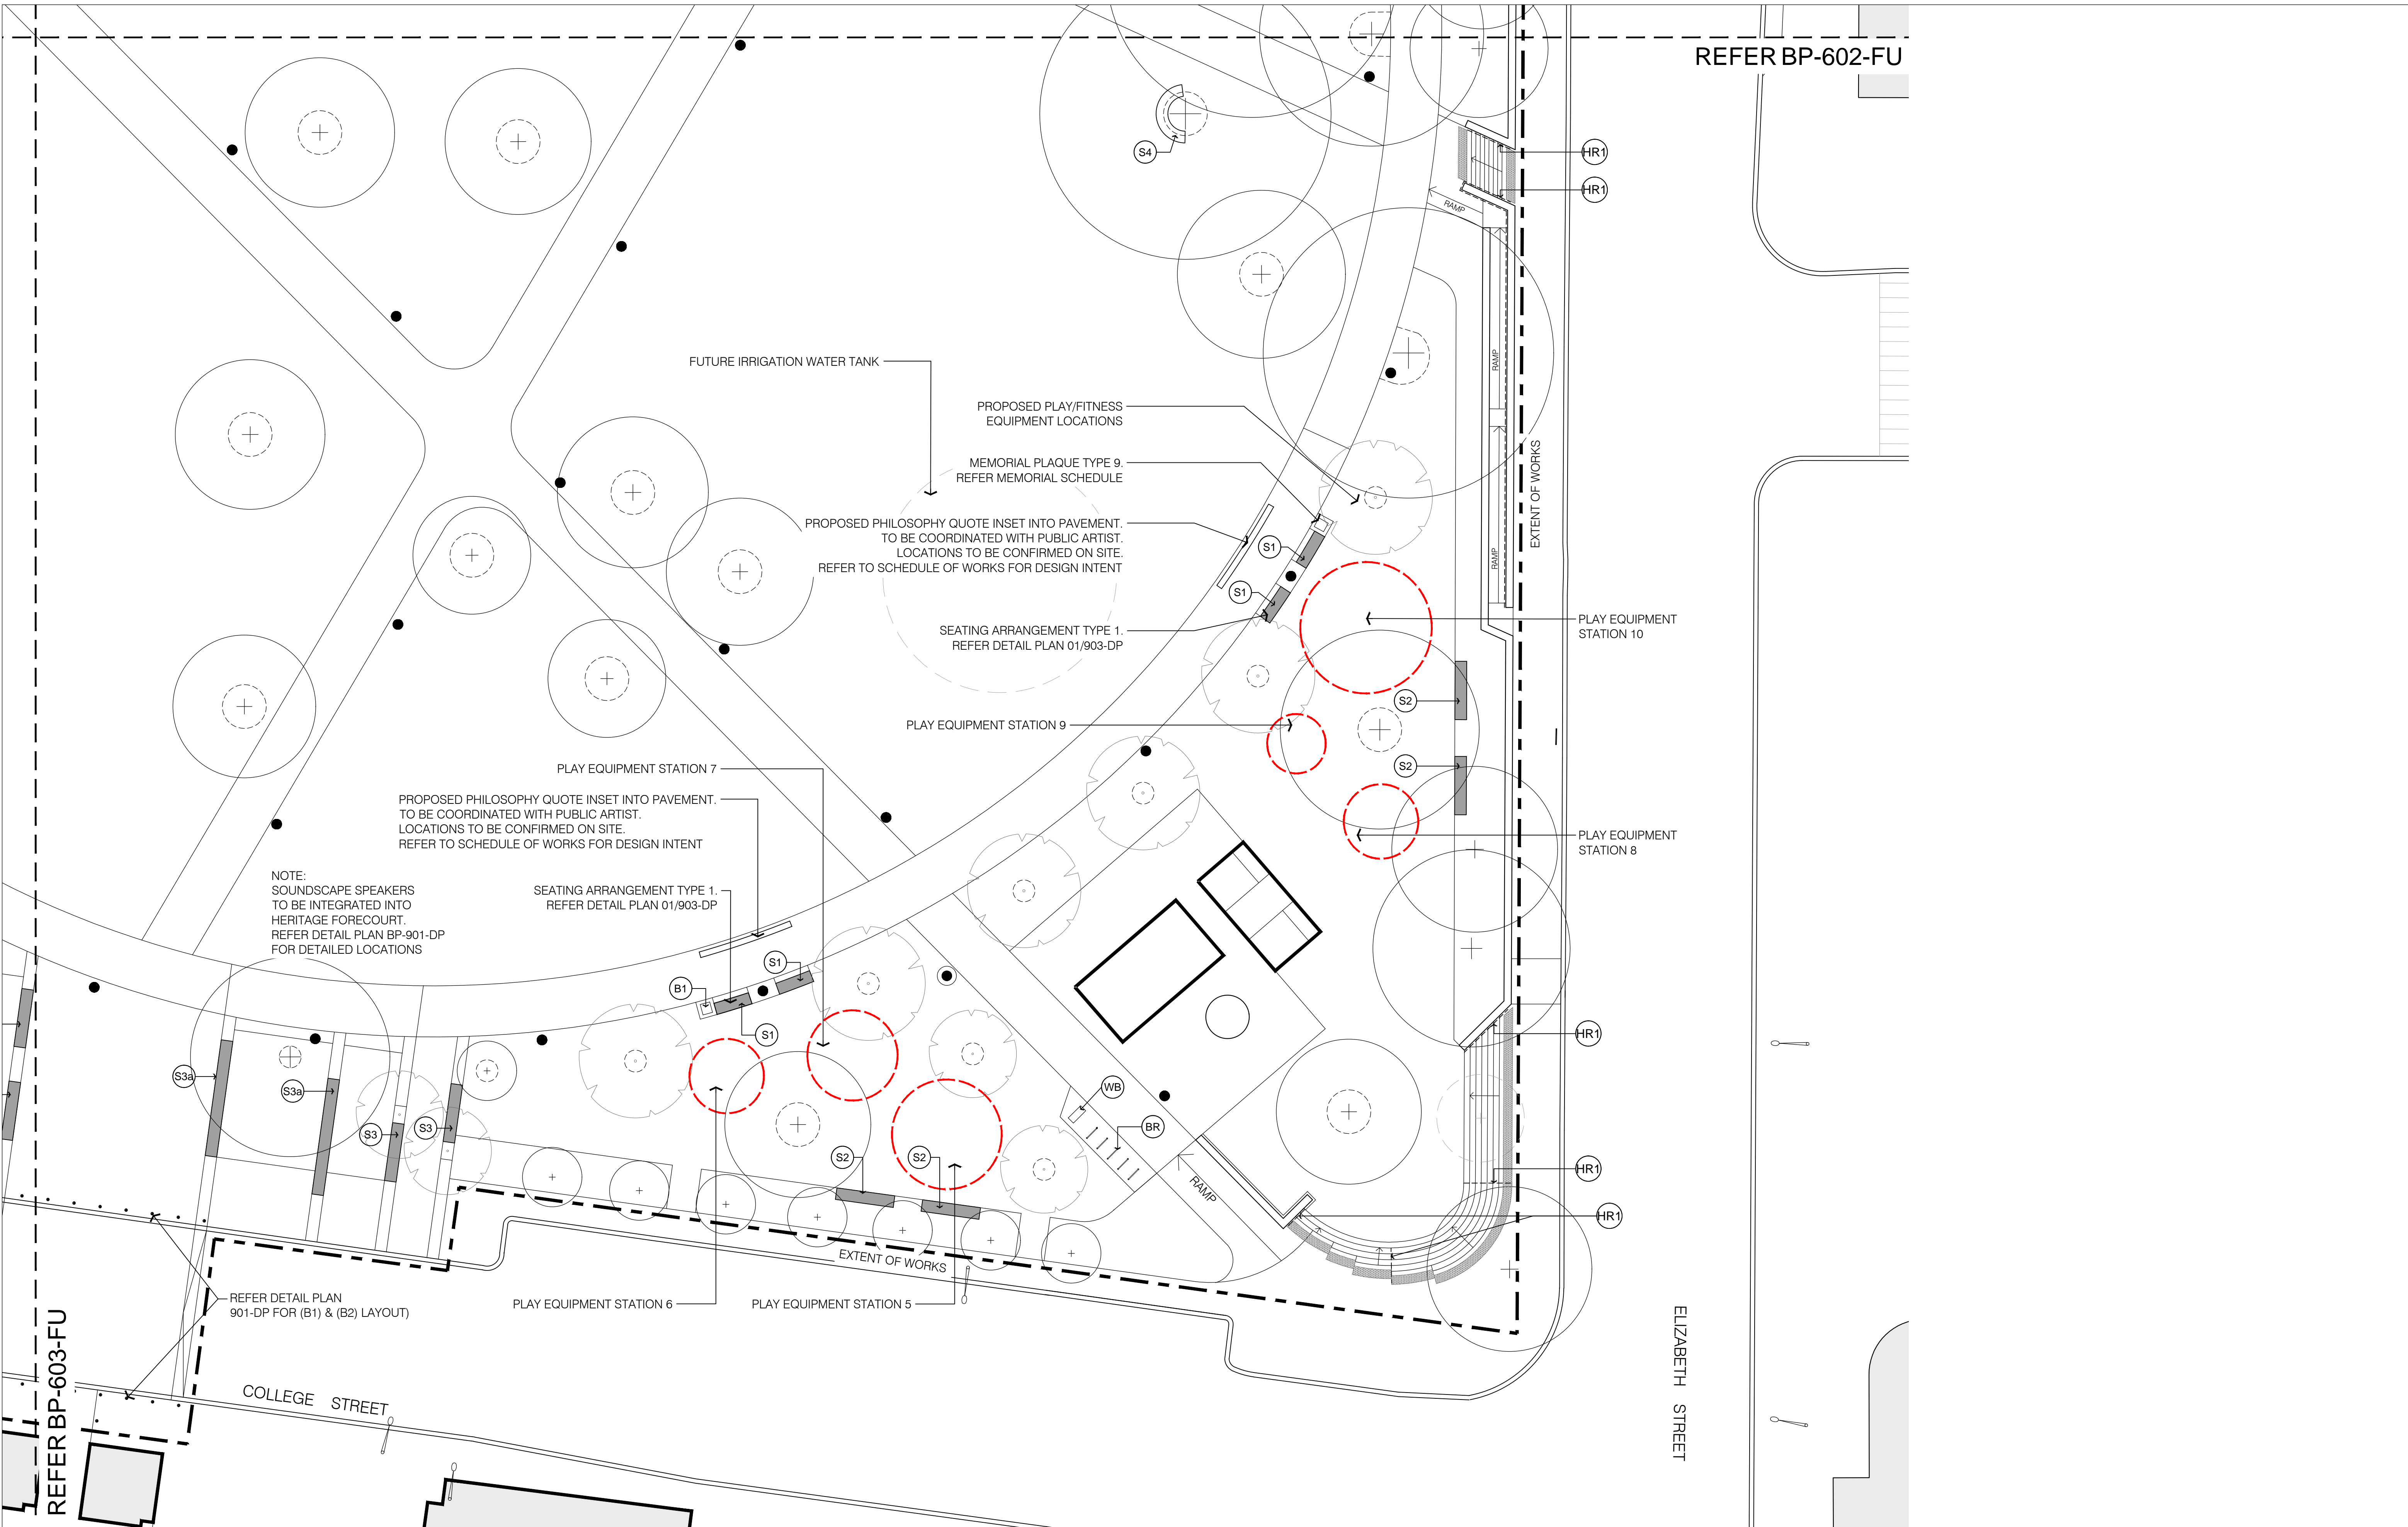

DRAFT

REV	NO	DESCRIPTION	DWN	CHK	DATE
D	04	95% CONSTRUCTION DOCUMENTATION	CG	MK	06.03.15
C	03	50% CONSTRUCTION DOCUMENTATION	CG	MK	23.01.15
B	02	100% DESIGN DEVELOPMENT	CG	MK	28.11.14
A	01	75% DESIGN DEVELOPMENT	CG	MK	07.11.14