


34-44 HILL STREET GOSFORD APARTMENTS

SHEET LIST

SITE PLANS		
DA000	SITE ANALYSIS	1:200 @ A3
DA001	EXISTING SITE SURVEY	1:200 @ A3
DA002	LANDSCAPE CALCULATION PLAN	1:200 @ A3
DA003	CUT AND FILL PLAN	1:200 @ A3
DA004	UNIT SCHEDULE	1:200 @ A3
FLOOR PLANS		
DA100	BASEMENT LOWER PLAN	1:200 @ A3
DA101	BASEMENT UPPER PLAN	1:200 @ A3
DA102	GROUND FLOOR / SITE PLAN	1:200 @ A3
DA103	LEVEL 1 PLAN	1:200 @ A3
DA104	LEVEL 2 PLAN	1:200 @ A3
DA105	LEVEL 3 PLAN	1:200 @ A3
DA106	LEVEL 4 PLAN	1:200 @ A3
DA107	LEVEL 5 PLAN	1:200 @ A3
DA108	LEVEL 6 PLAN	1:200 @ A3
DA109	LEVEL 7 PLAN	1:200 @ A3
DA110	LEVEL 8 PLAN	1:200 @ A3
DA111	ROOF PLAN	1:200 @ A3
ELEVATIONS		
DA200	EAST ELEVATIONS	1:200 @ A3
DA201	SOUTH ELEVATIONS	1:200 @ A3
DA202	WEST ELEVATIONS	1:200 @ A3
DA203	NORTH ELEVATIONS	1:200 @ A3
SECTIONS		
DA300	SECTION A-A [LONGITUDINAL]	1:200 @ A3
DA301	SECTION B-B [TRANSVERSE]	1:200 @ A3
DA302	SECTION C-C & D-D [BUILDING A - PARKING RAMP]	1:200 @ A3
DA303	SECTION E-E [BUILDING B - PARKING RAMP]	1:200 @ A3
DA304	SECTION F-F & G-G [TRANSVERSE]	1:200 @ A3
3D PERSPECTIVE / MONTAGE		
DA400	3D VIEWS 1	1:200 @ A3
DA401	3D VIEWS 2	1:200 @ A3
DA402	3D VIEWS 3	1:200 @ A3
DA403	SHADOW DIAGRAMS 1	1:200 @ A3
ADAPTABLE UNIT LAYOUT PLANS		
DA501	TYPICAL ADAPTABLE LAYOUTS	1:200 @ A3
DA502	LEVEL 1 - 3 ADAPTABLE PLANS	1:200 @ A3
DA503	LEVEL 4 - 7 ADAPTABLE PLANS	1:200 @ A3
FSR PLANS		
DA600	GROUND - LEVEL 1 FSR PLANS	1:200 @ A3
DA601	LEVEL 2 - 5 FSR PLANS	1:200 @ A3
DA602	LEVEL 6 - 8 FSR PLANS	1:200 @ A3
SOLAR & VENTILATION ACCESS PLANS		
DA700	GROUND - LEVEL 1 SOLAR & VENTILATION PLANS	1:200 @ A3
DA701	LEVEL 2 - 5 SOLAR & VENTILATION PLANS	1:200 @ A3
DA702	LEVEL 6 - 8 SOLAR & VENTILATION PLANS	1:200 @ A3
NOTIFICATION DRAWINGS		
ND100	NOTIFICATION DRAWING 1	AS SHOWN
ND101	NOTIFICATION DRAWING 2	AS SHOWN
ND102	NOTIFICATION DRAWING 3	AS SHOWN
ND103	NOTIFICATION DRAWING 4	AS SHOWN
ND104	NOTIFICATION DRAWING 5	AS SHOWN


AERIAL PHOTOGRAPH

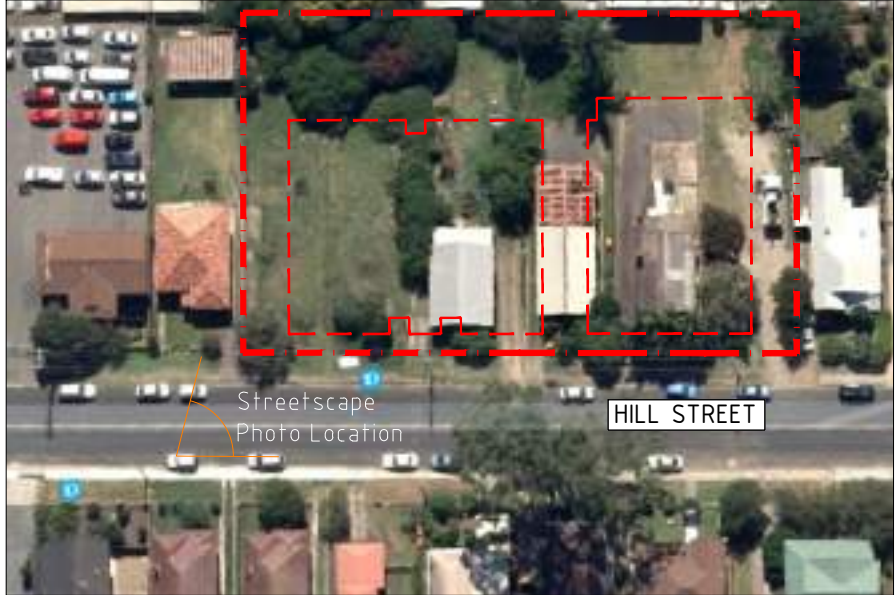


STREETSCAPE PHOTO





PROPOSED DEVELOPMENT

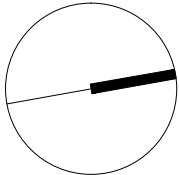


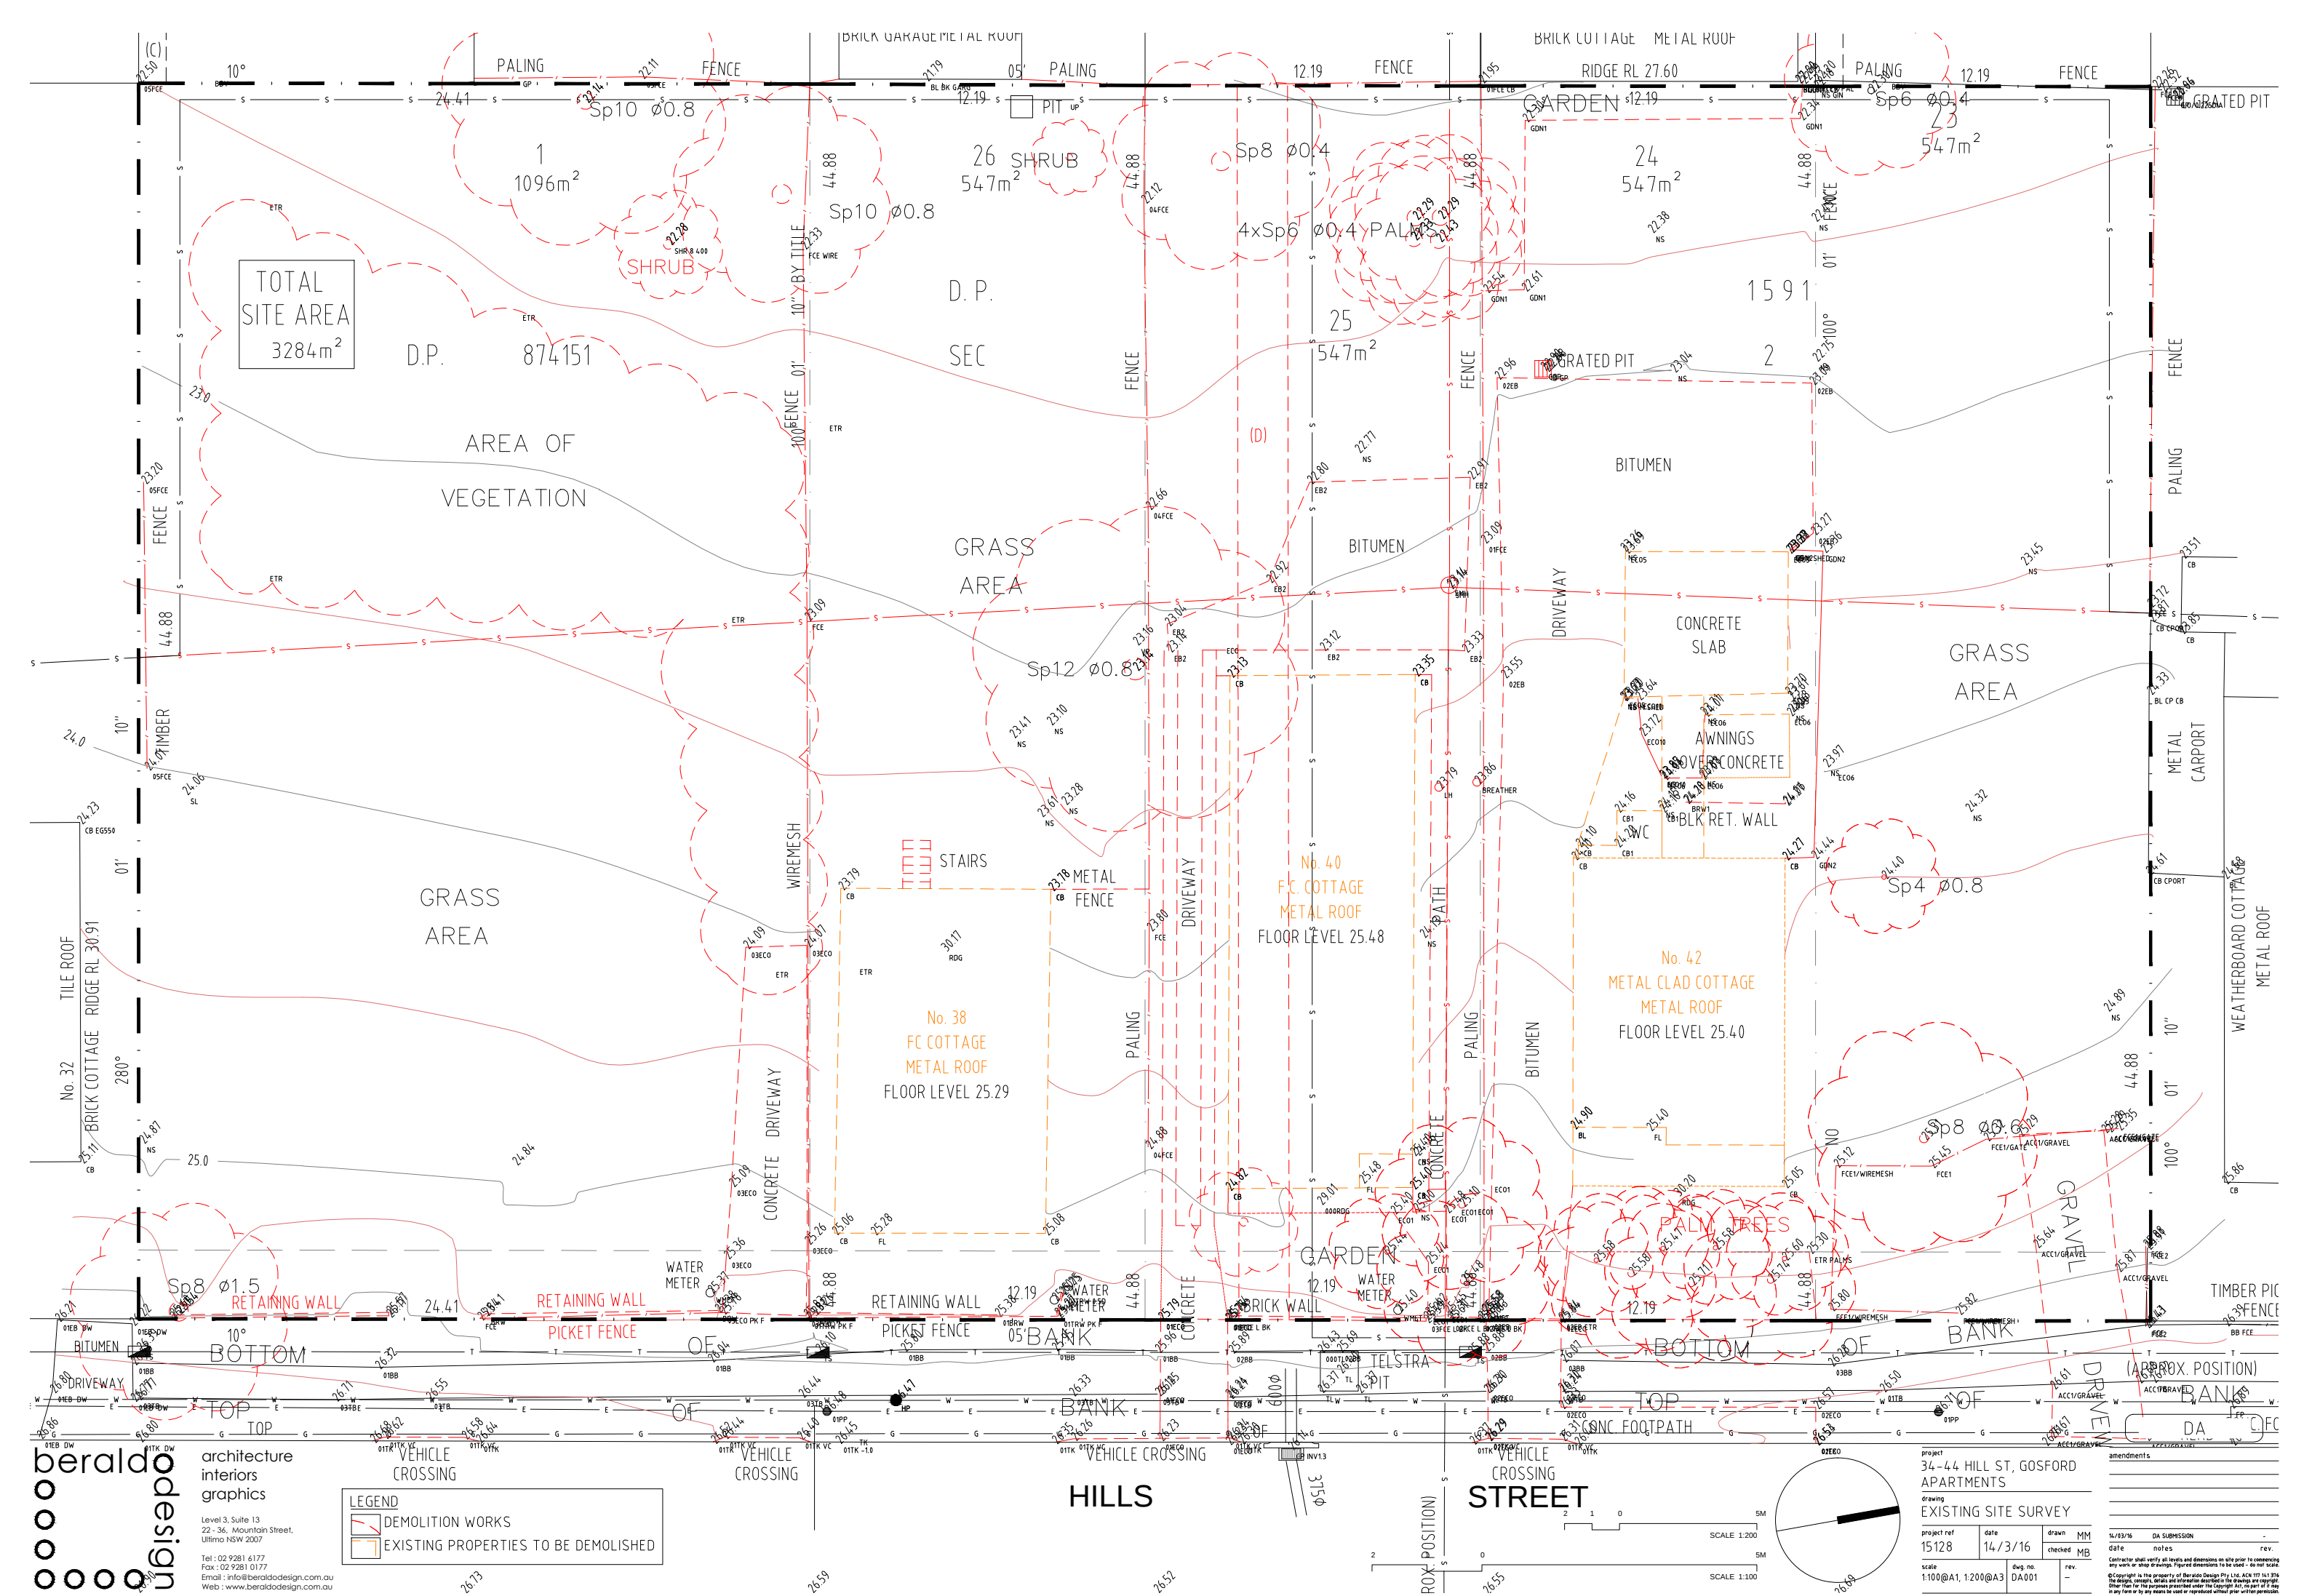

LANDSCAPE KEY

 - DEEP SOIL
- ADDITIONAL PLANTING AREA
- SITE COVER

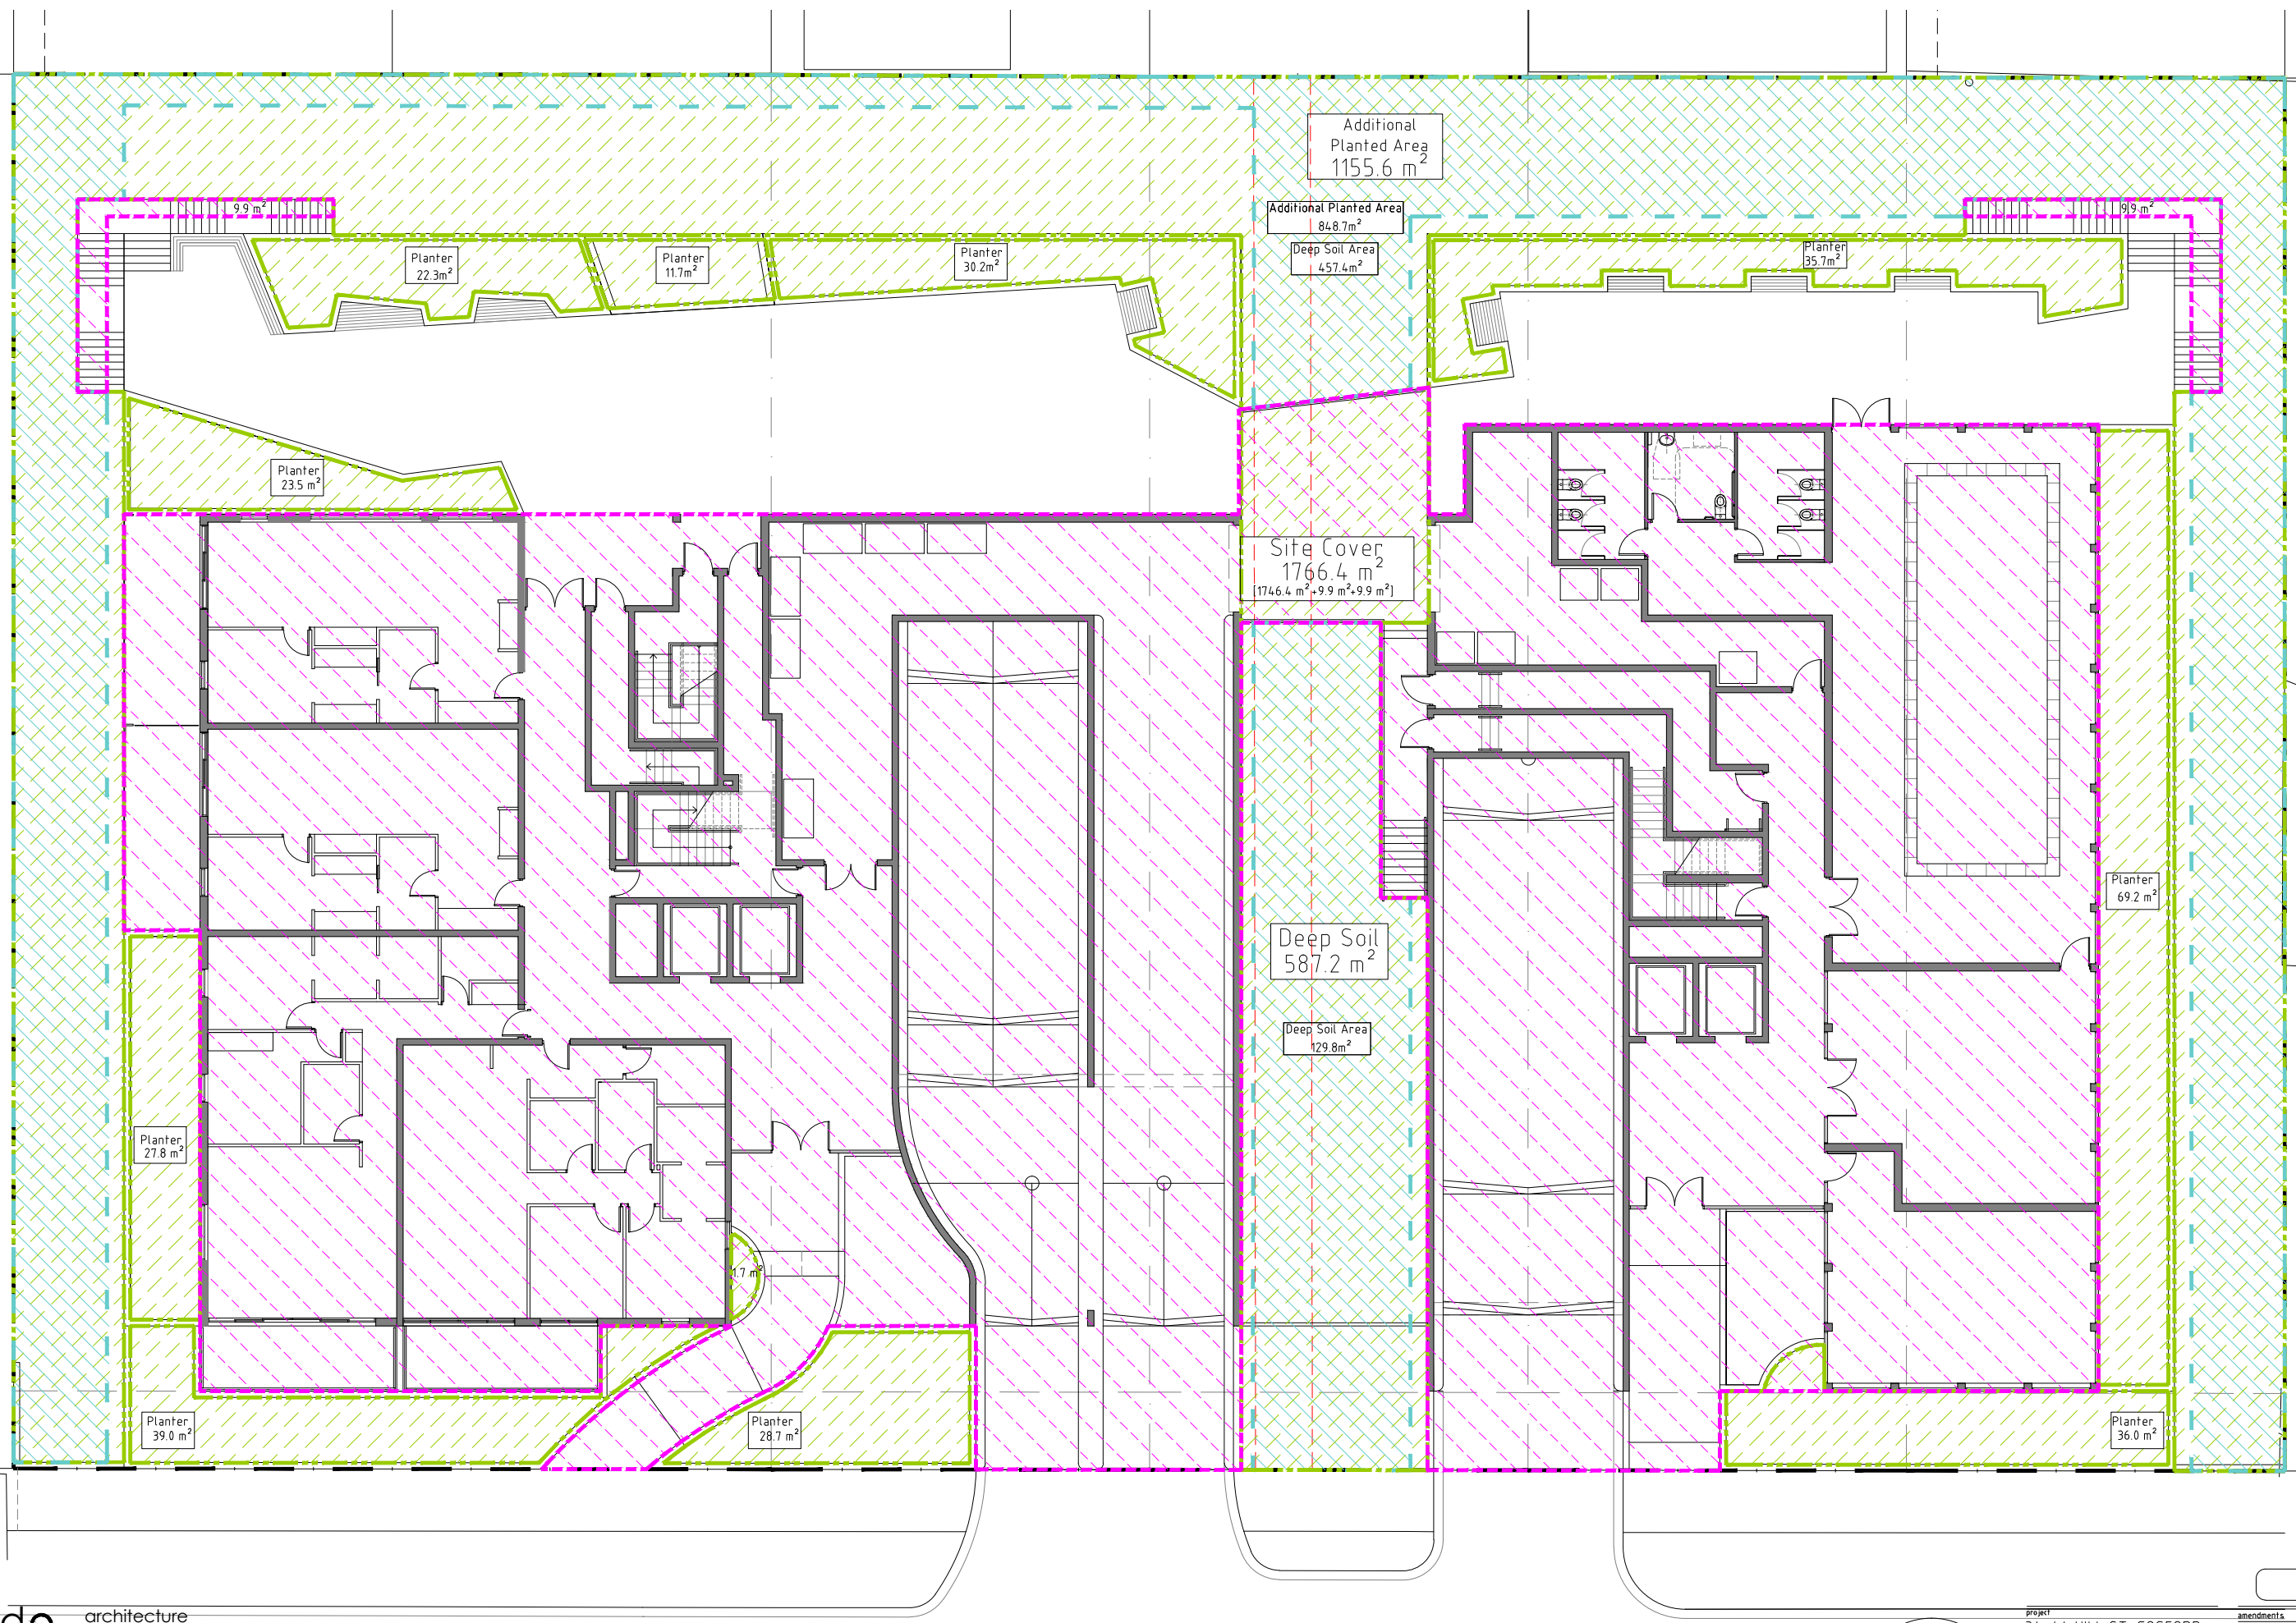

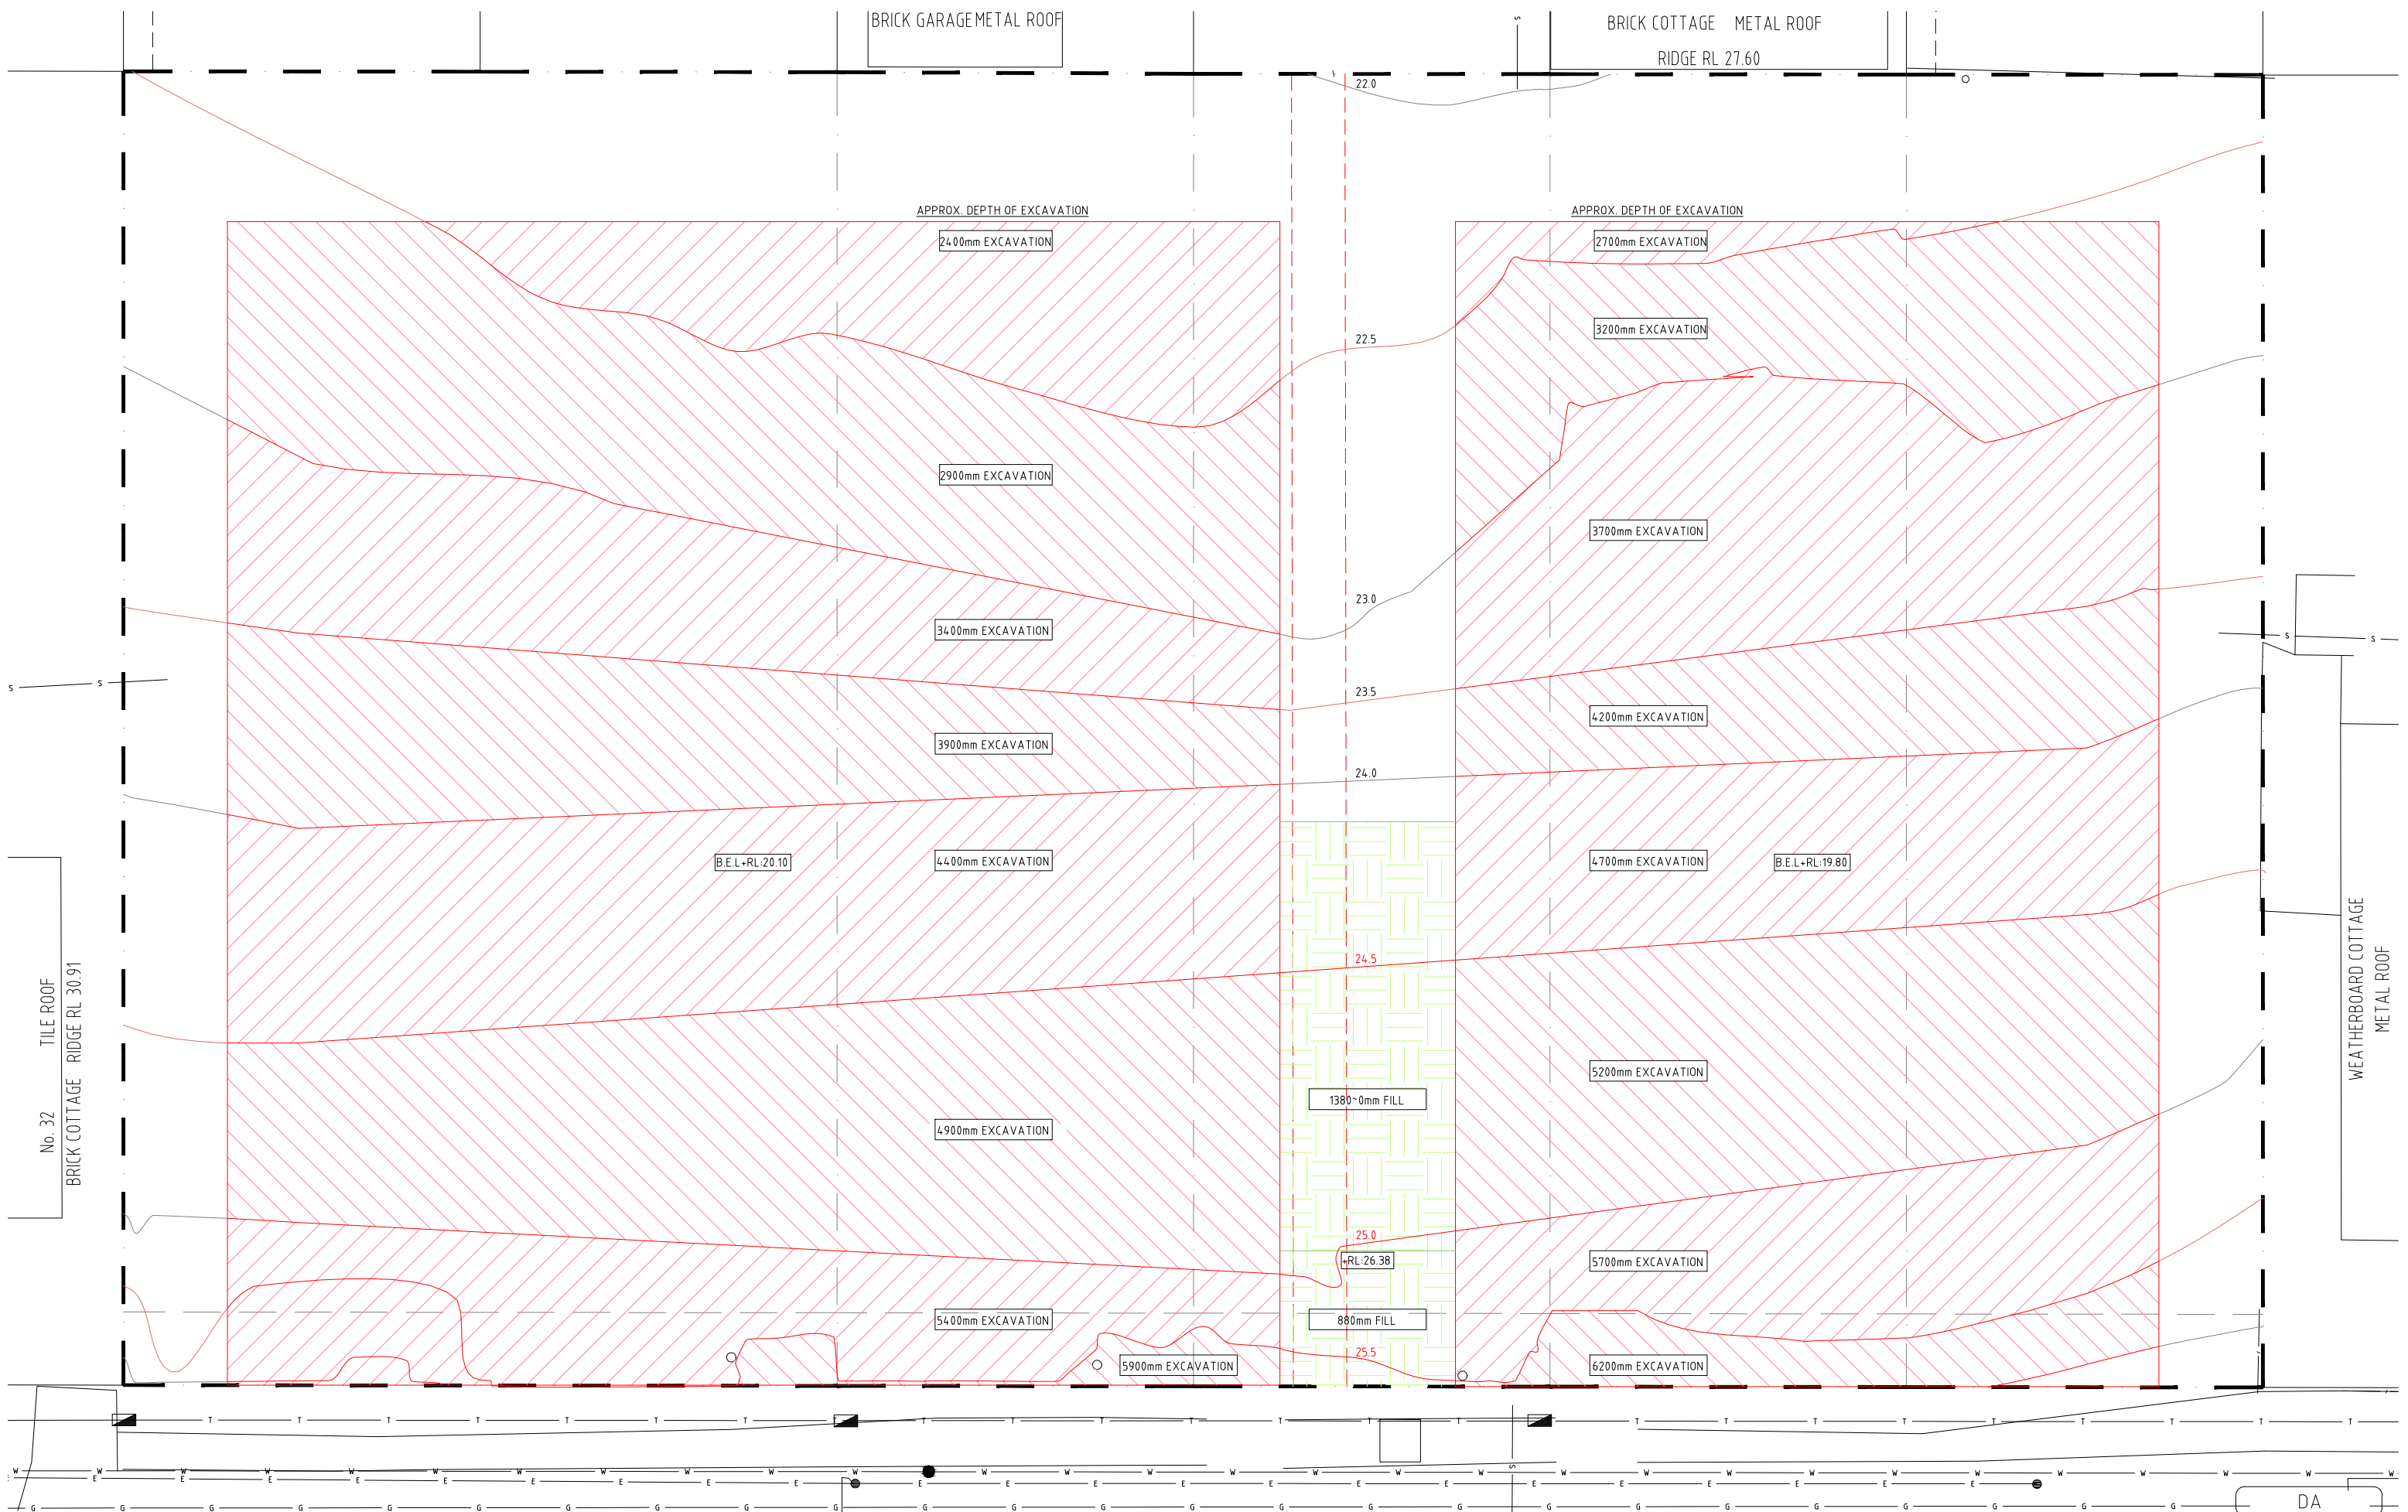

beraldodesign

architecture
interiors
graphics

Level 3, Suite 13
22 - 36, Mountain Street,
Ultimo NSW 2007

Tel : 02 9281 6177
Fax : 02 9281 0177
Email : info@beraldodesign.com.au
Web : www.beraldodesign.com.au

CUT & FILL KEY

EXCAVATION

EXCAVATION

FILL

project 34-44 HILL ST, GOSFORD APARTMENTS

drawing CUT & FILL PLAN

project ref 15128	date 14/3/16	drawn MM	checked MB
scale 1:100@A1, 1:200@A3	DA003	rev. -	

1:100@A1, 1:200@A3

SCALE 1:200

SCALE 1:100

DA

amendments

date	notes	rev.
14/03/16	DA SUBMISSION	-

Contractor shall verify all levels and dimensions on site prior to commencing any work or shop drawings. Figure dimensions to be used - do not scale.


© Copyright is the property of Beraldo Design Pty Ltd. All rights reserved. No part of this drawing may be reproduced without the written permission of Beraldo Design Pty Ltd.


UNIT SCHEDULE									
Building A		Unit Type		Building B		Unit Type			
Level	3 Bed	2 Bed	1 Bed	Level	3 Bed	2 Bed	1 Bed		
Ground	-	2	2	Ground	0	0	0		
L1	1	3	3	L1	1	3	2		
L2		6	3	L2	1	3	2		
L3		6	3	L3	1	3	2		
L4	1	3	4	L4		3	1		
L5	1	3	4	L5	-	3	1		
L6	1	3	4	L6	-	3	1		
L7	1	3	4	L7	-	3	1		
L8	2	4	-						
Sub-Total		1	33	21	Sub-Total		3	21	10
Total Building A		61		Total Building B				34	
Total Building A+B				Total Building A+B				101	
ADAPTABLE UNIT REQUIREMENTS [@ 15%]									


OPEN SPACE CALCULATION		
Site Area	3284.00	m ²
Site Cover	2499.40	m ²
Lawn Area	328.60	m ²
Deep Soil	619.90	m ²
Communal Open Space	1175.00	m ²
Deep Soil / Open Space Ratio	55.50	%


UNIT RATIO		
Unit Type	No	Ratio
1 bed	97	95.6 %
2 bed	54	53.5 %
3 bed	10	9.9 %
	101	100 %


STORAGE REQUIREMENTS (m ³)							
Building A			Building B				
Unit Type			Unit Type				
Level	3 Bed	2 Bed	1 Bed	Level	3 Bed	2 Bed	1 Bed
Ground	-	8	6	Ground	0	0	0
L1	5	12	9	L1	5	12	6
L2		24	9	L2	5	12	6
L3	-	24	9	L3	5	12	6
L4	5	12	12	L4	-	12	3
L5	5	12	12	L5	-	12	3
L6	5	12	12	L6	-	12	3
L7	5	12	12	L7	-	12	3
L8	10	10	-				
Sub-Total			81	Sub-Total			30
Total			248	Total			129

 

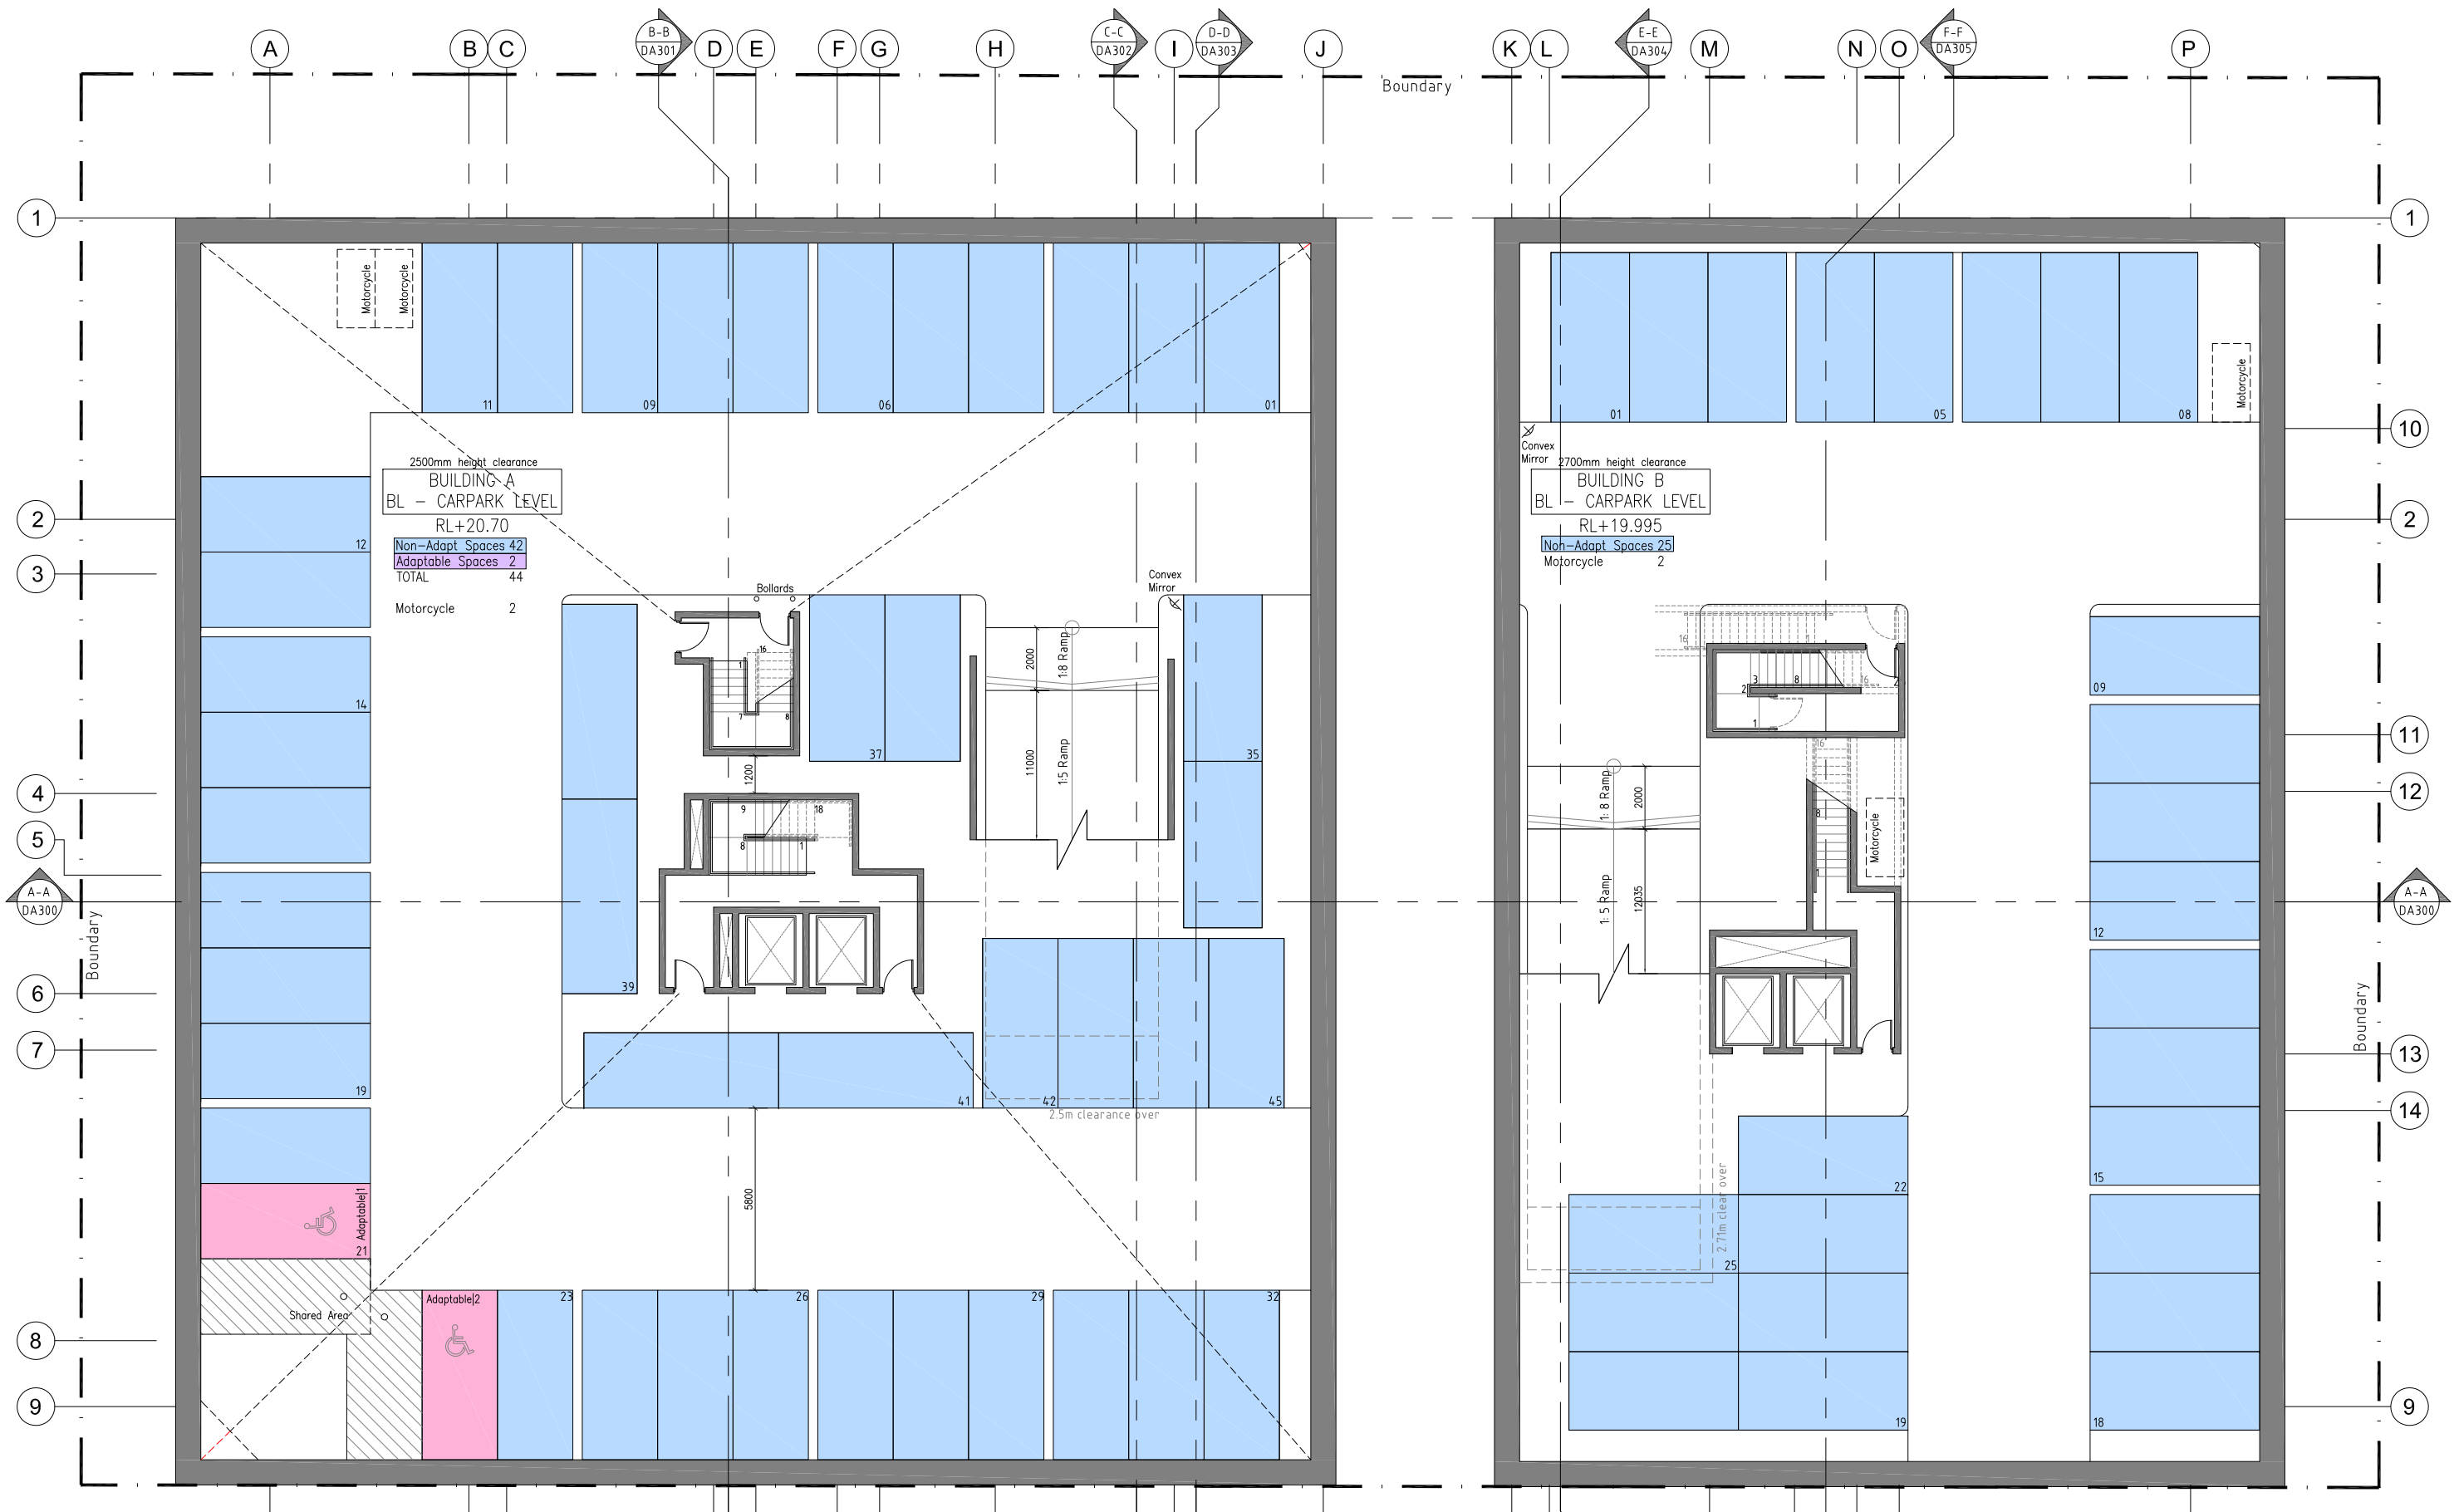

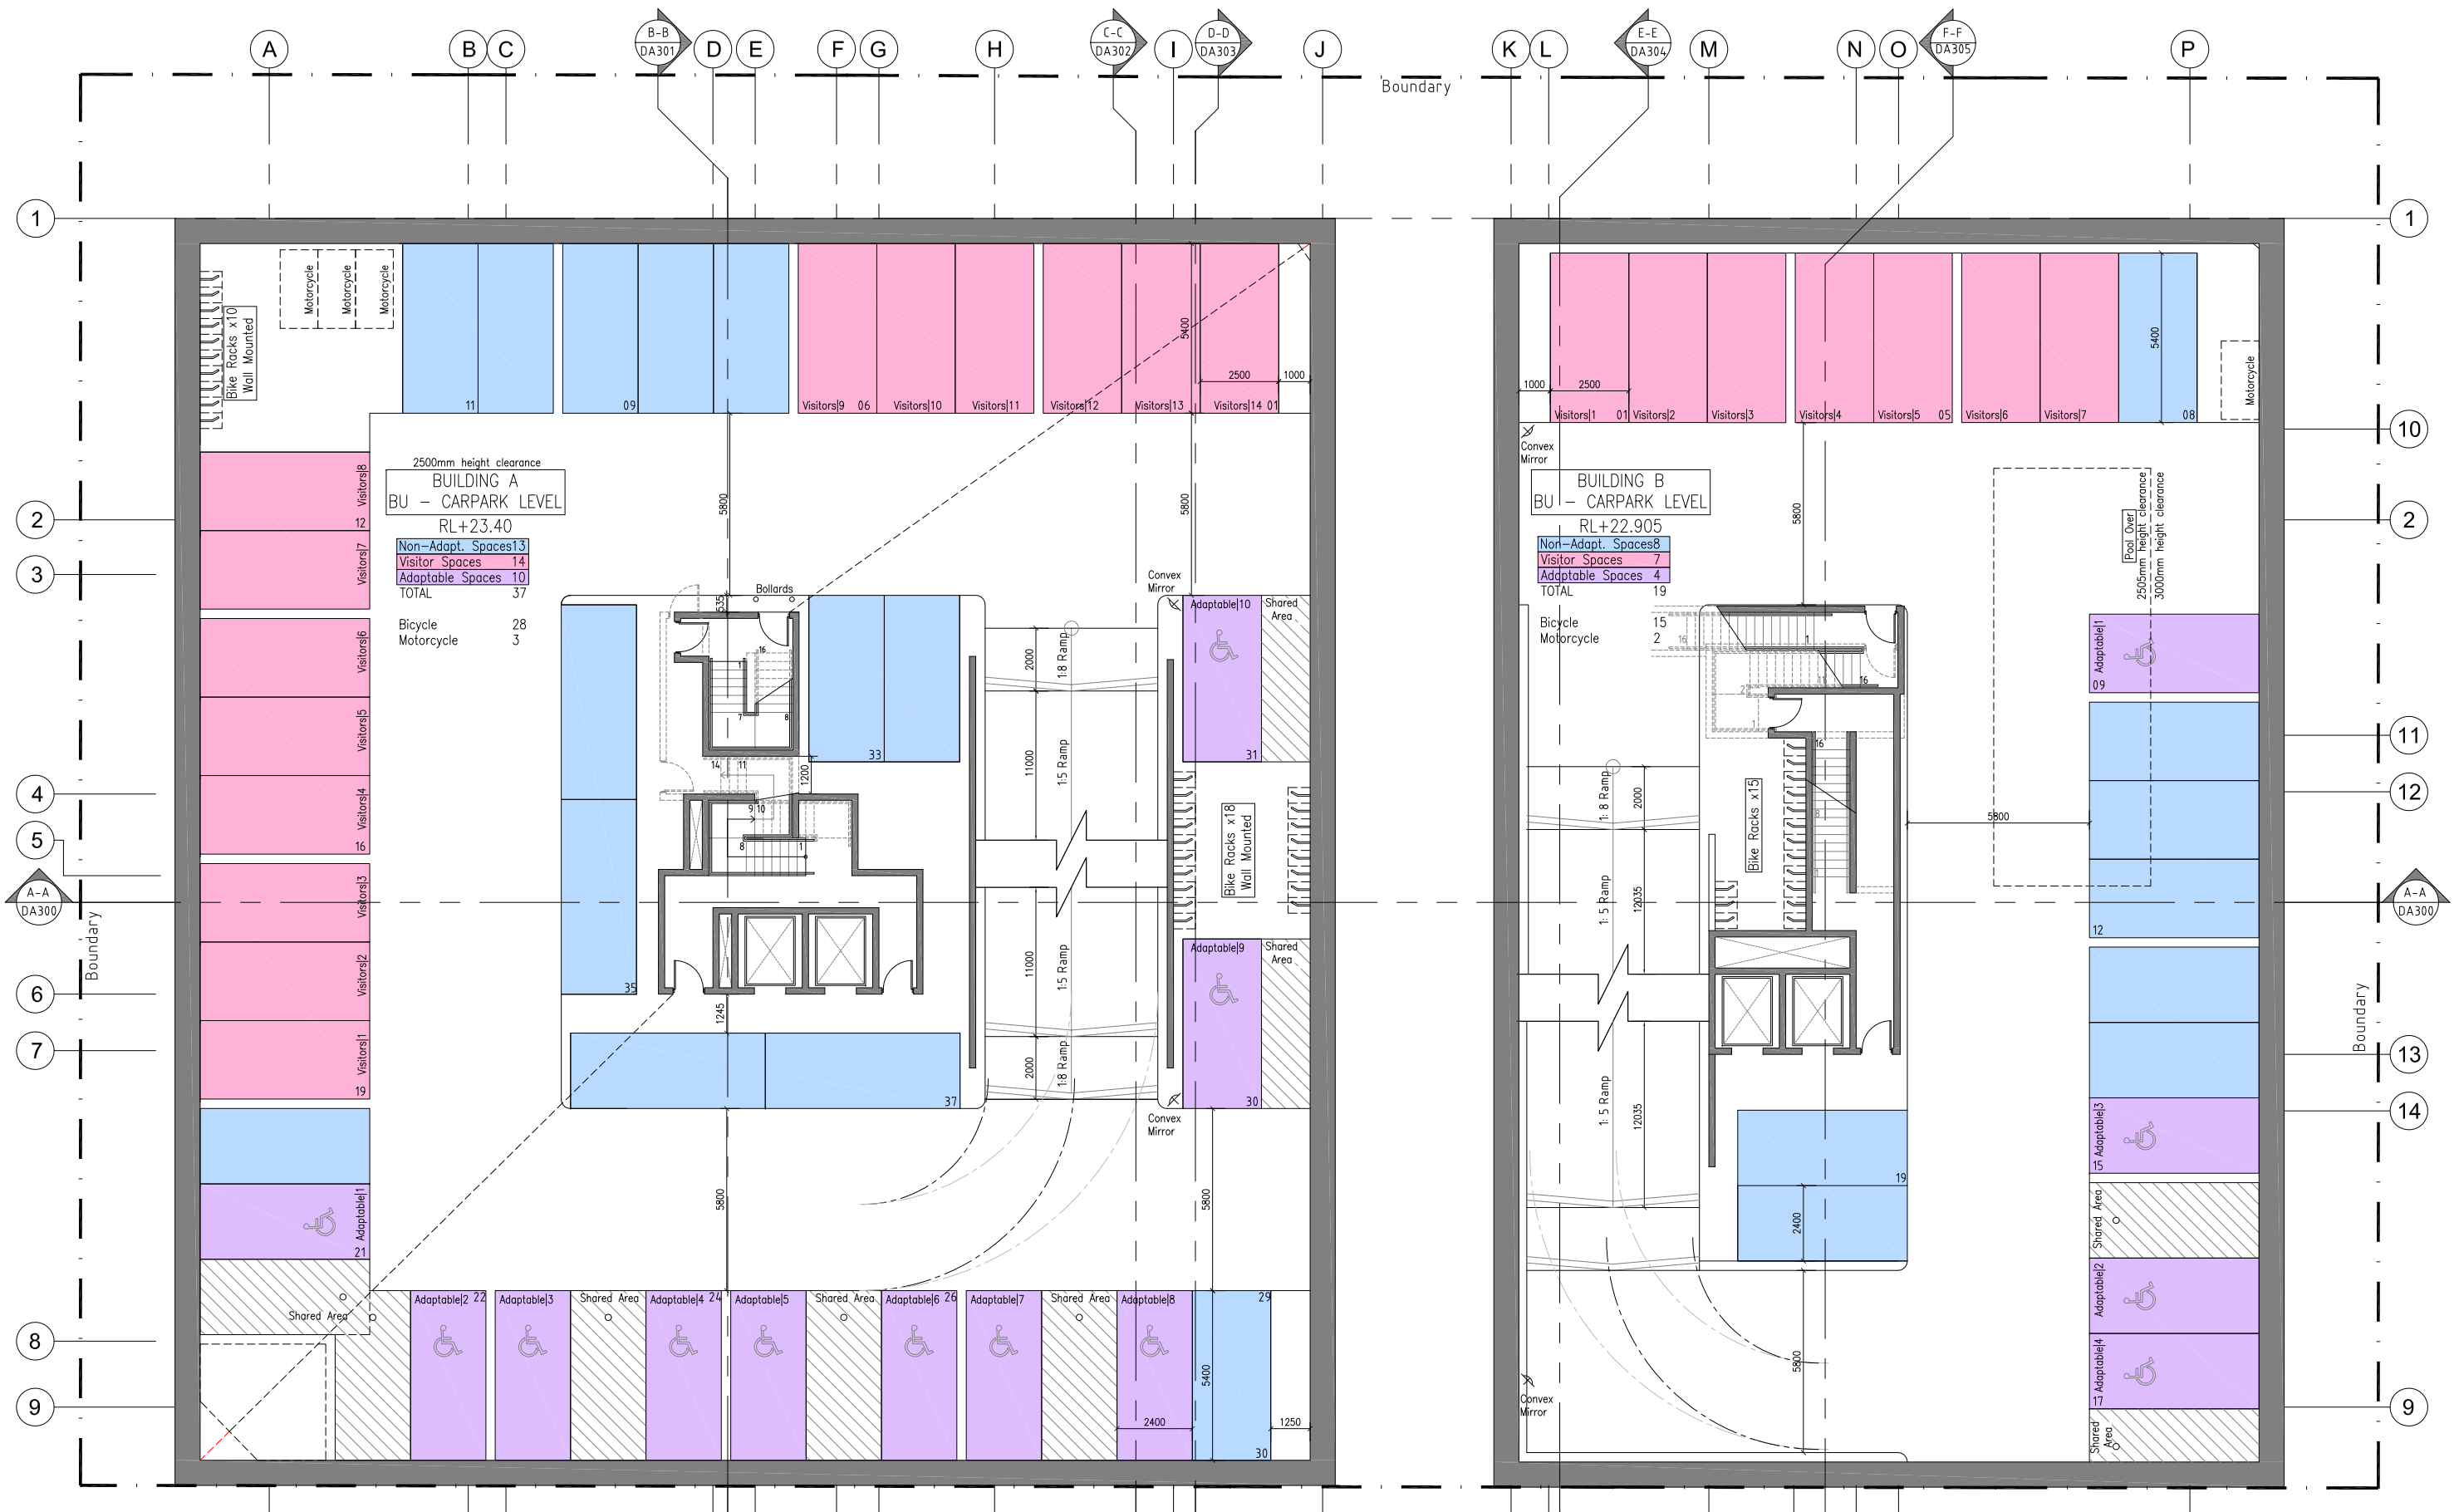

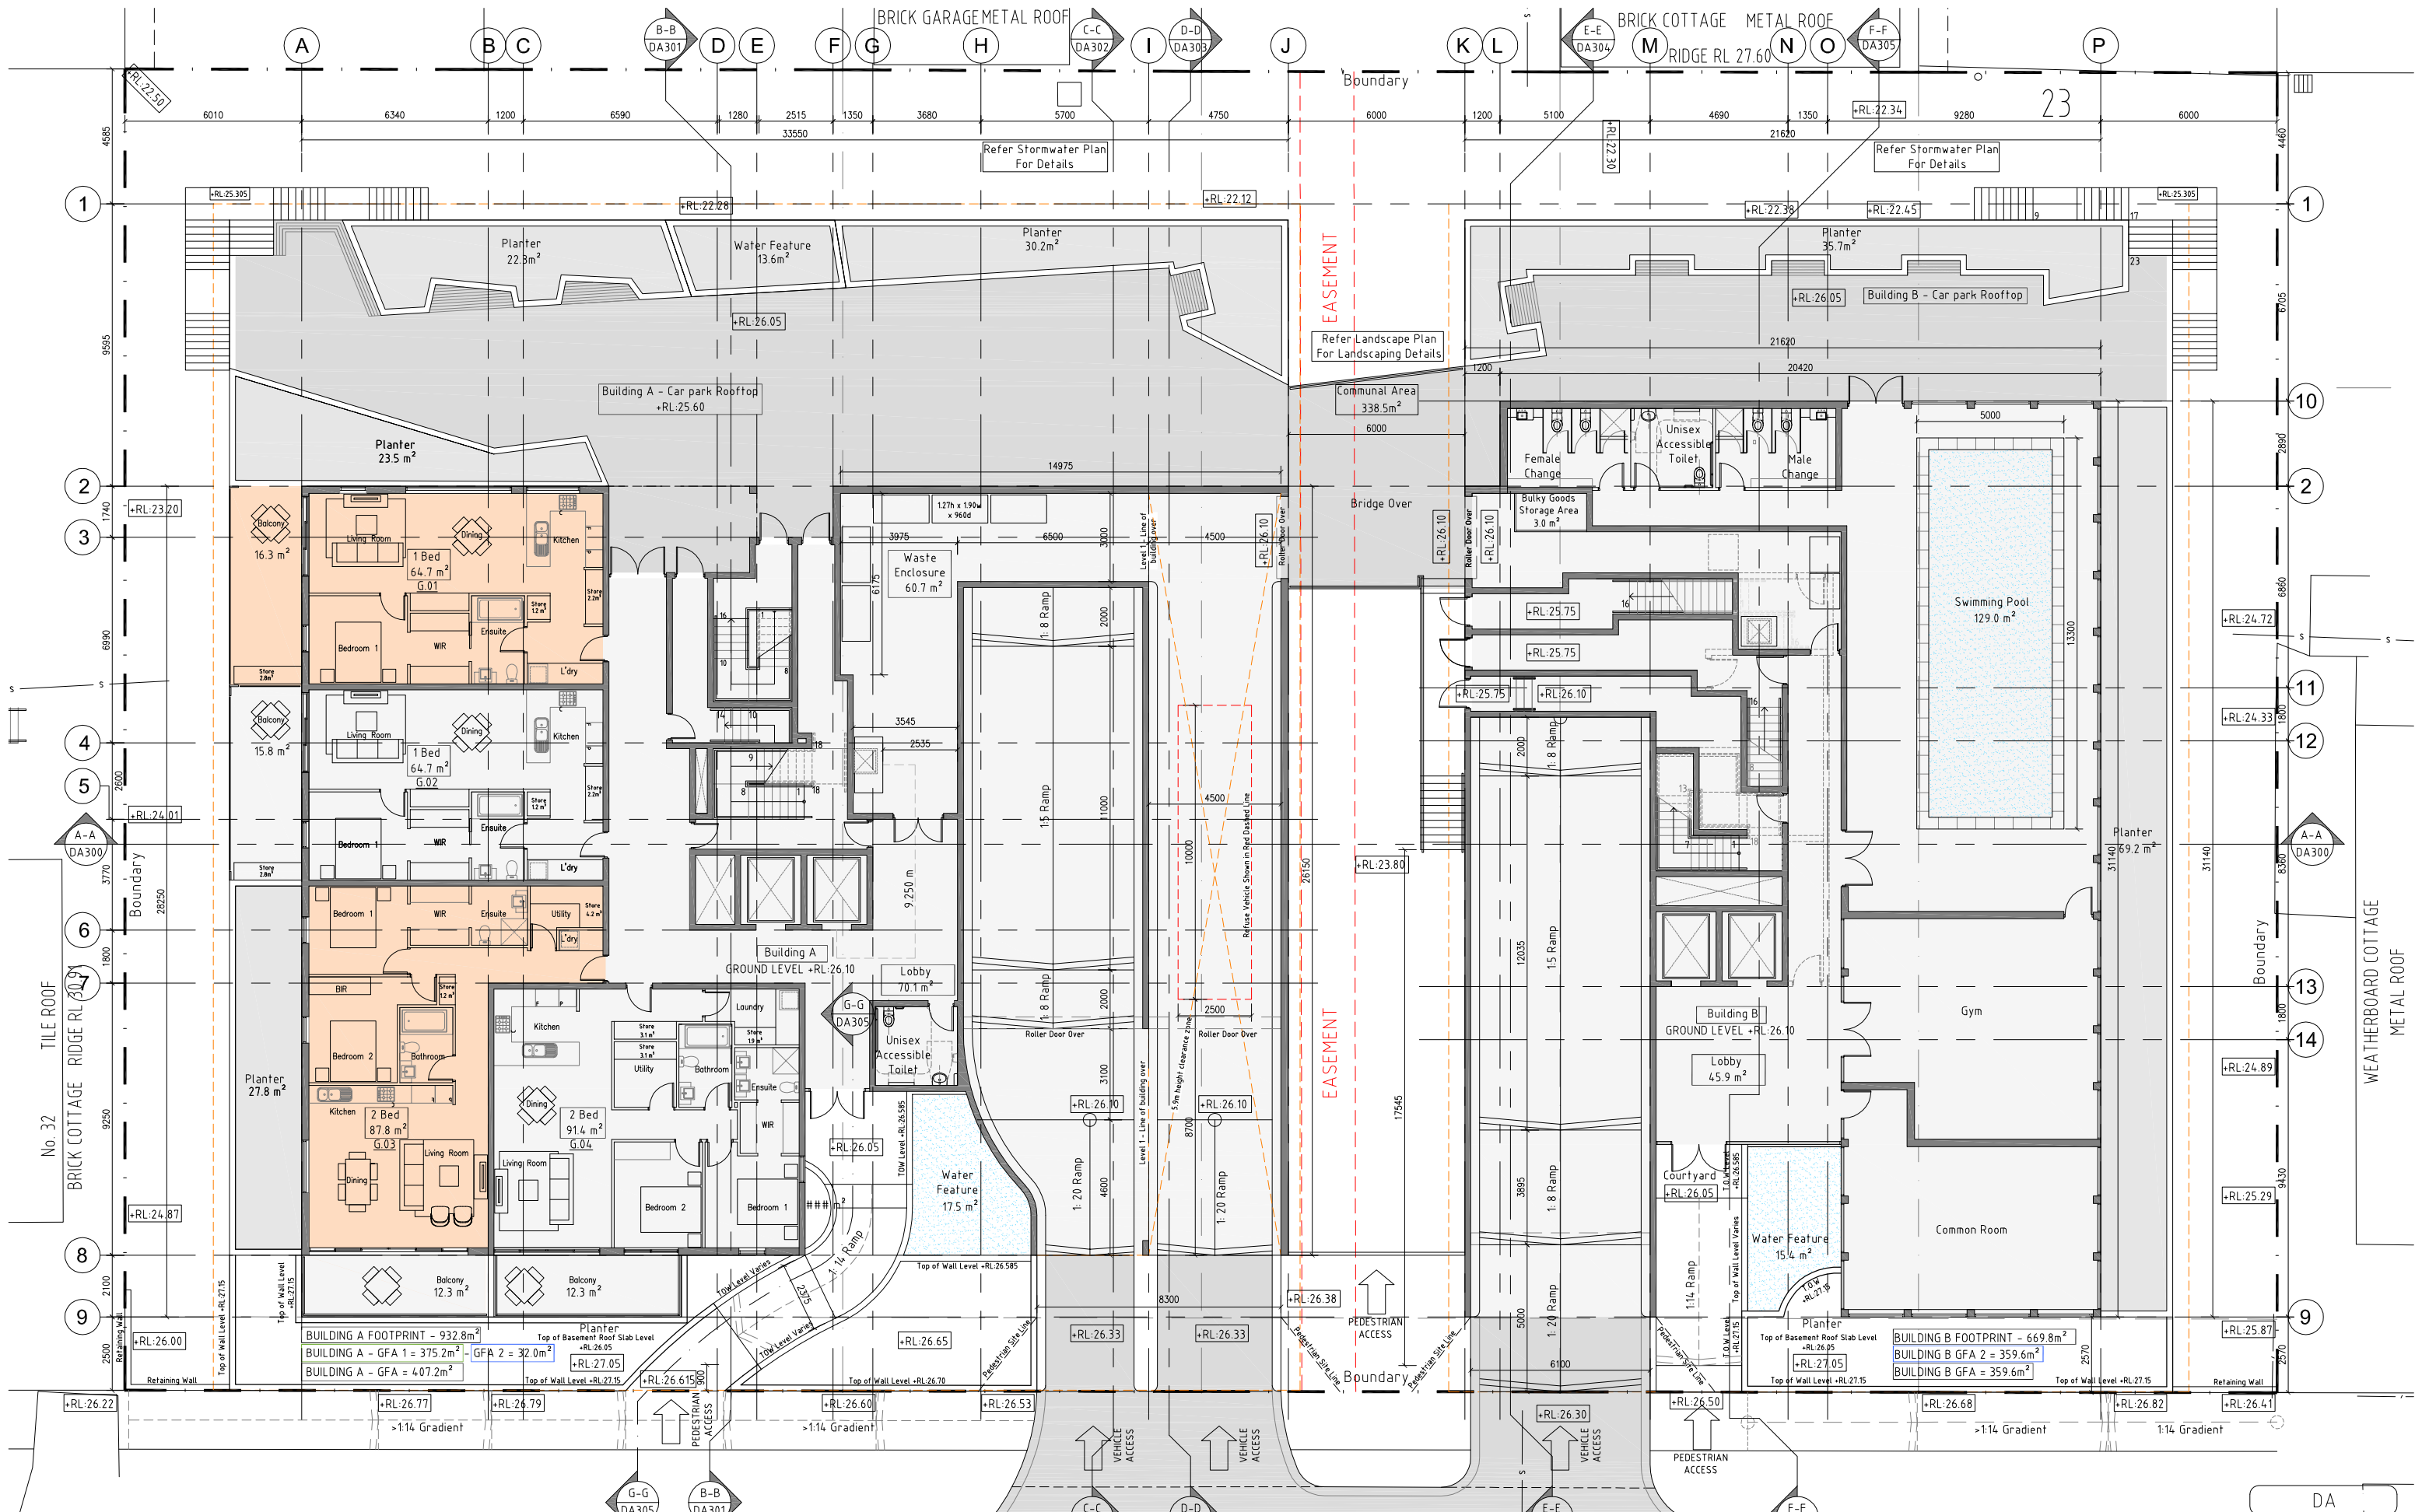

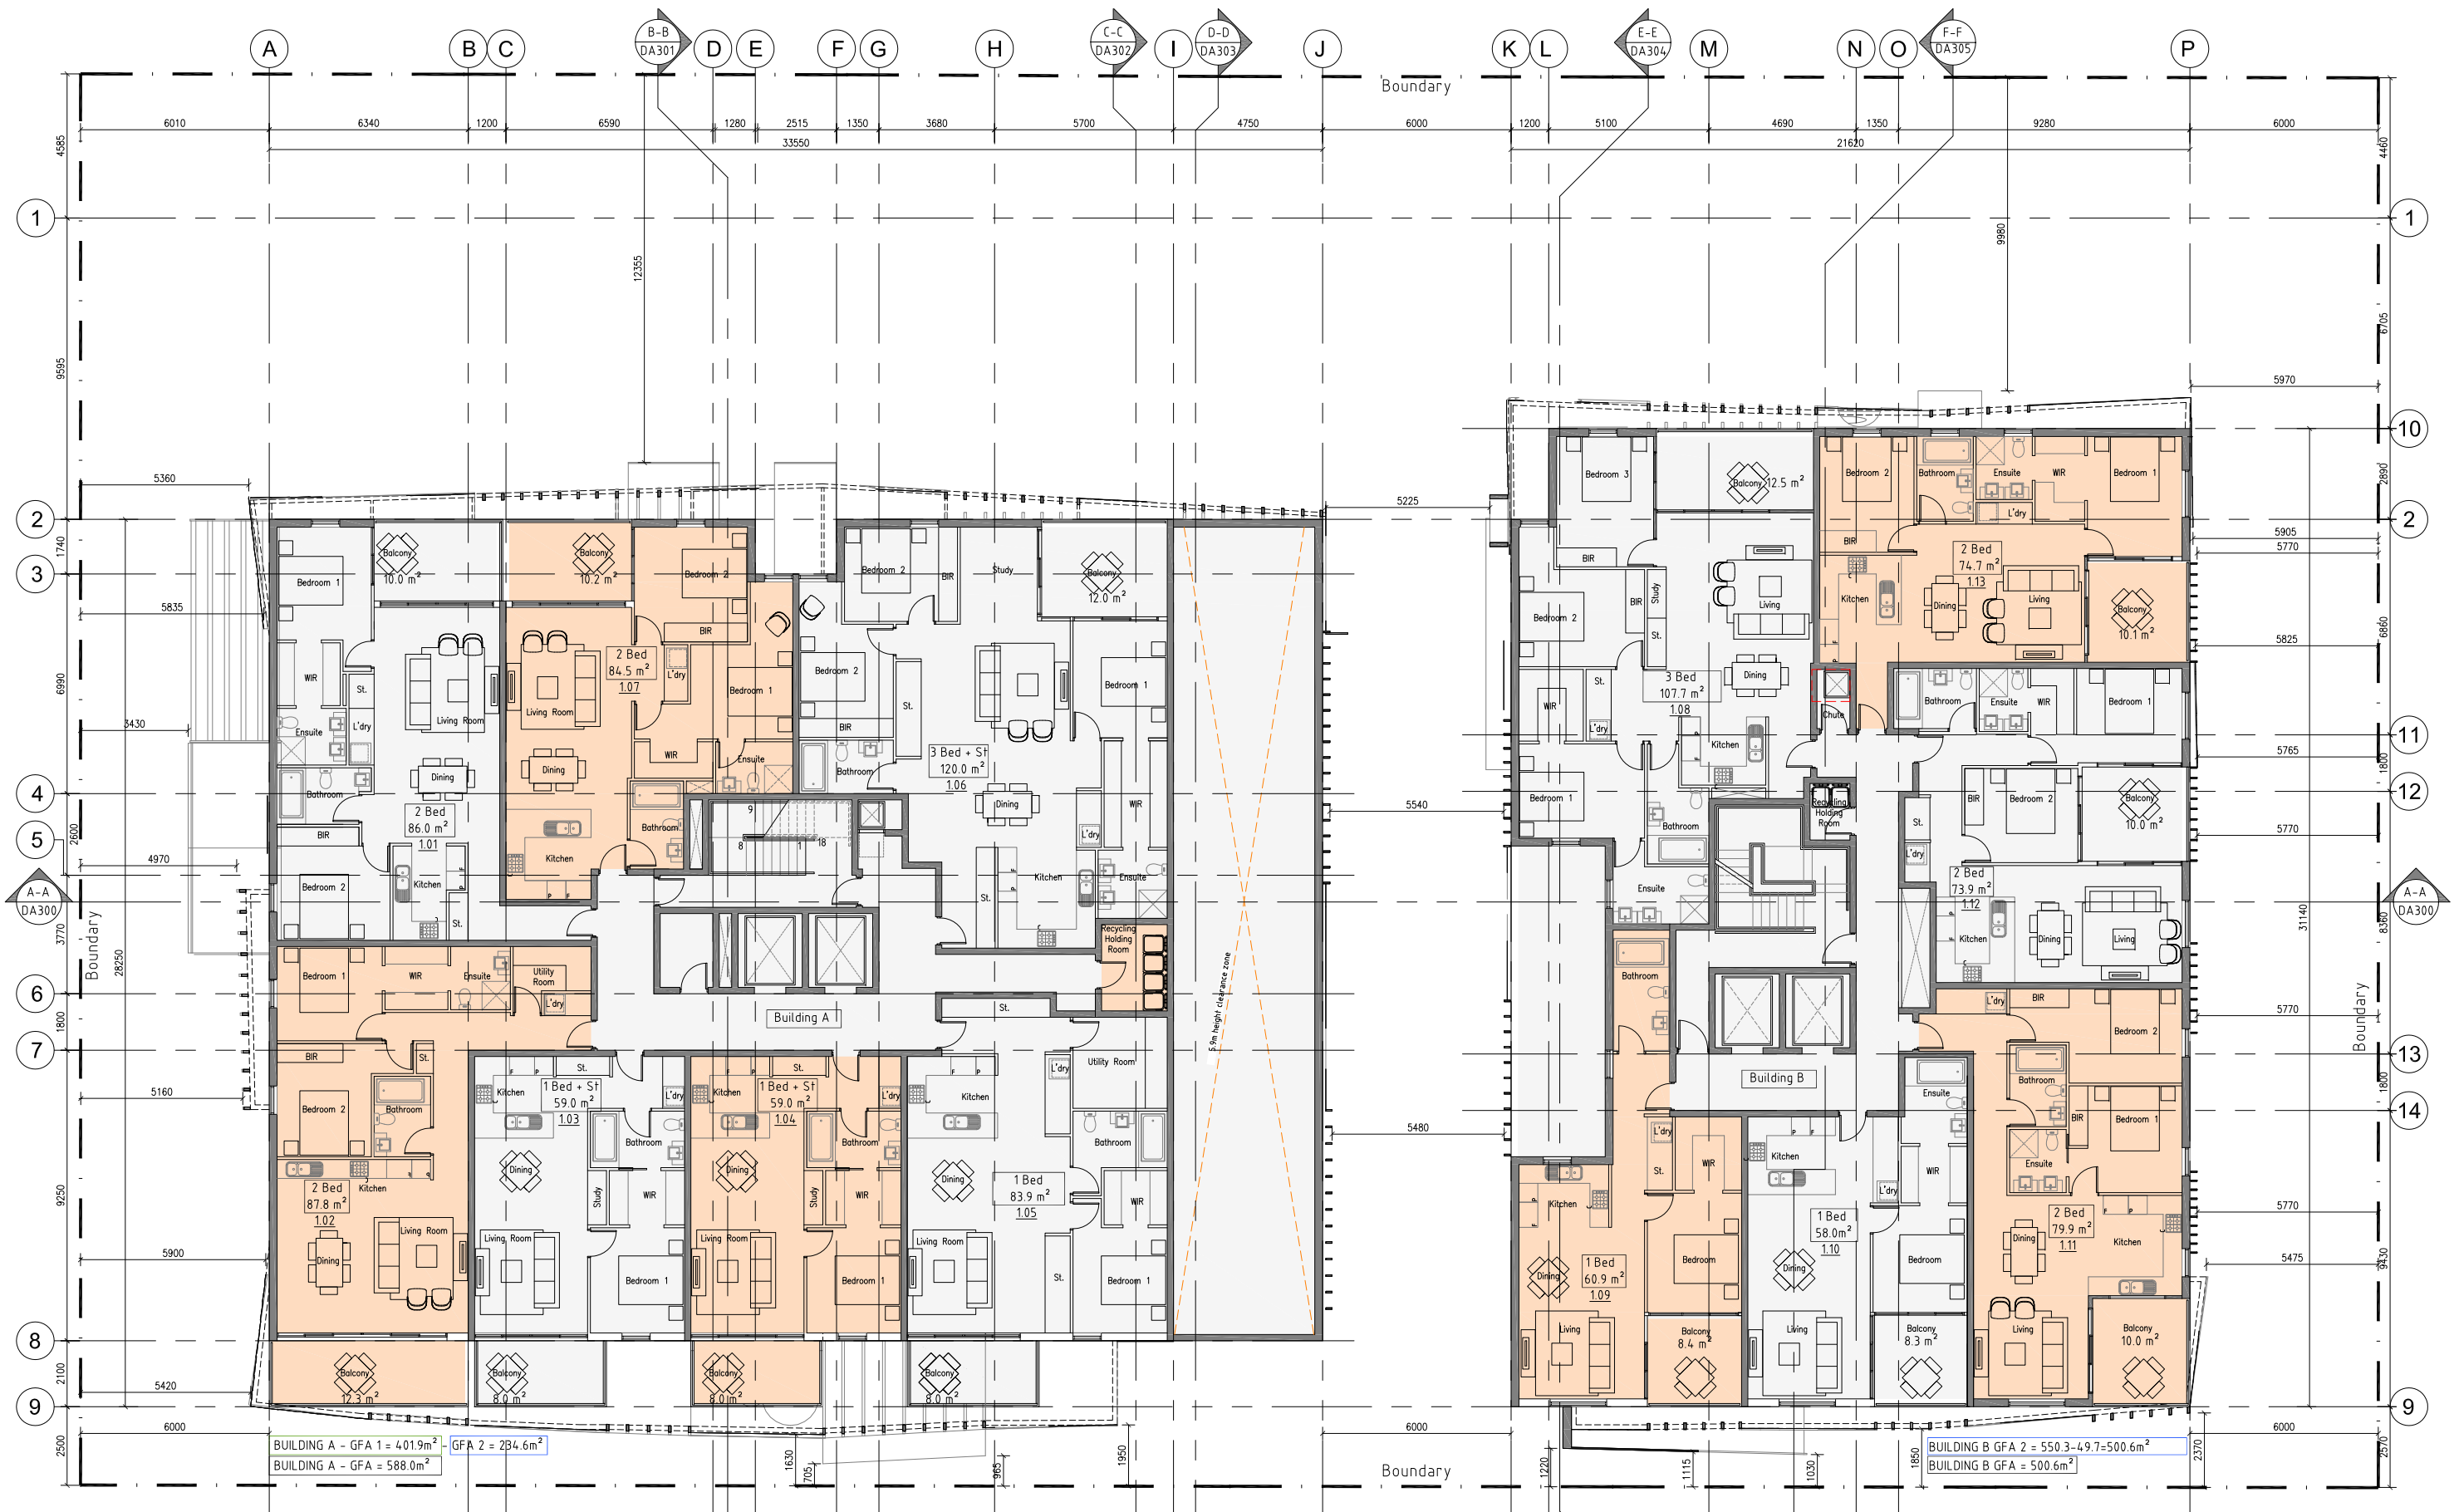

1 LEVEL 1 PLAN
1:100






Level 3, Suite 13
22 - 36, Mountain Street,
Ultimo NSW 2007

Tel : 02 9281 6177
Fax : 02 9281 0177
Email : info@beraldodesign.com.au
Web : www.beraldodesign.com.au


in any form or by any means

1997, 1998, 1999, 2678, 26



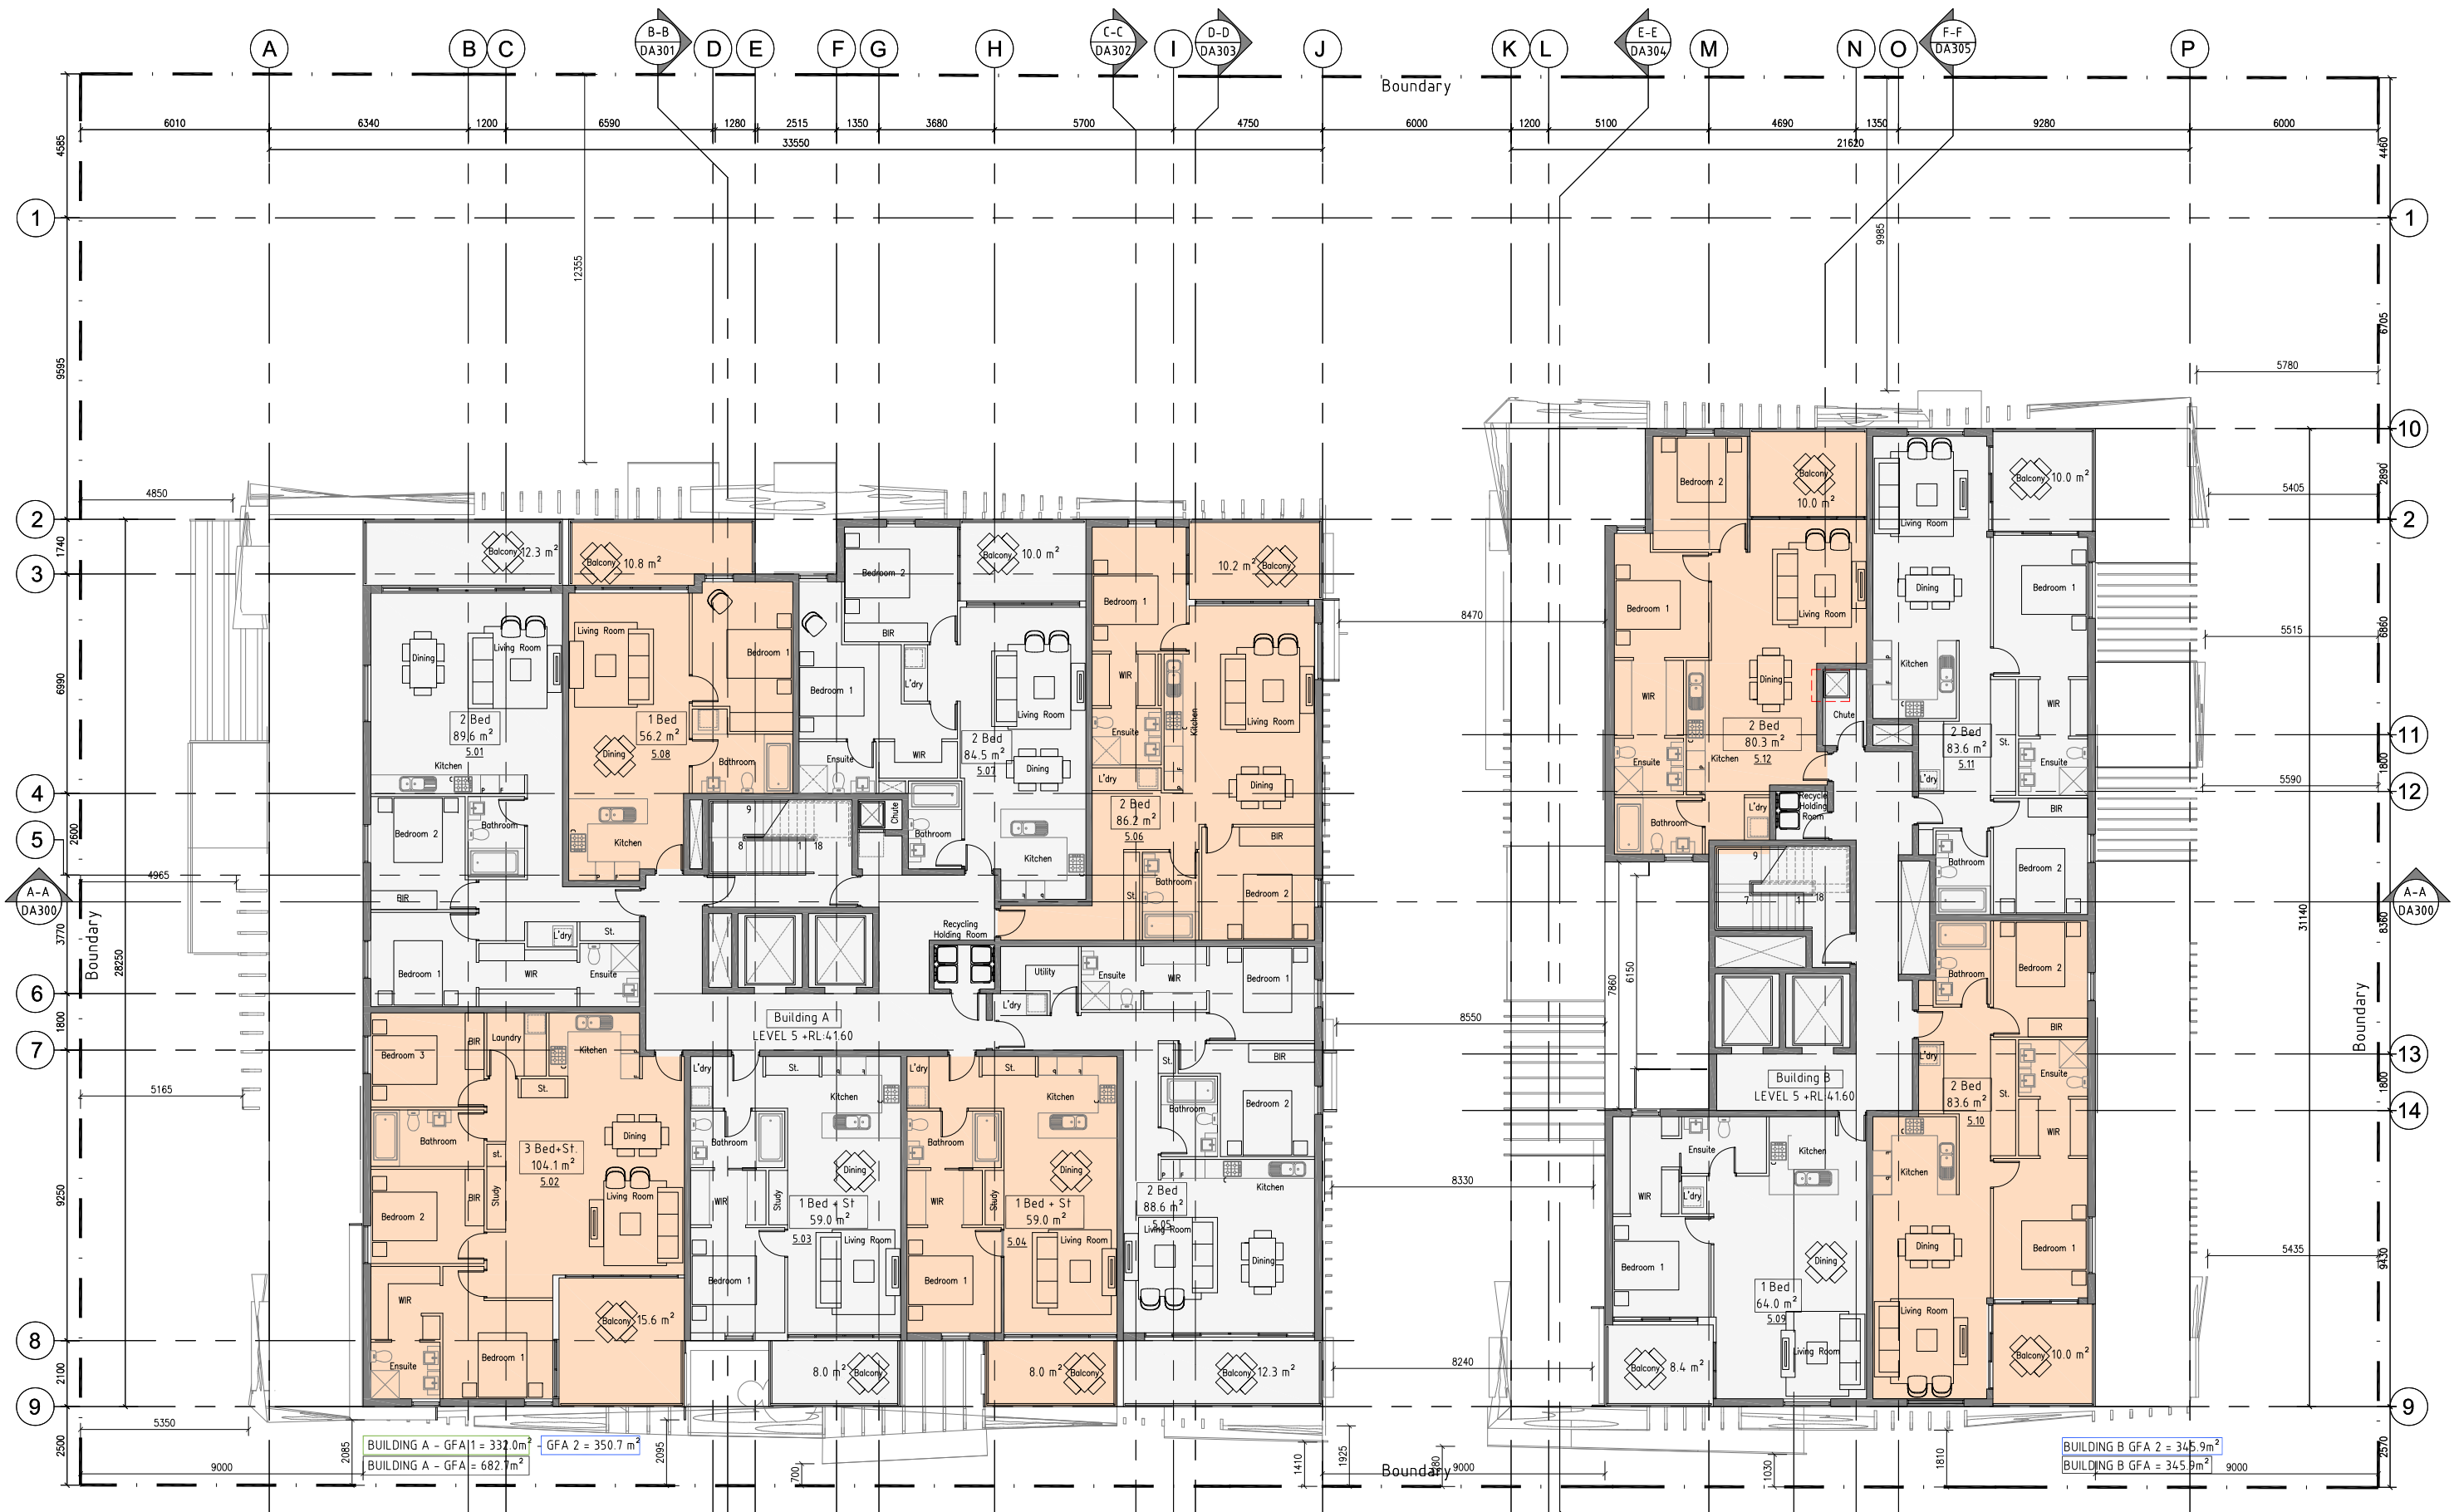


1 LEVEL 5 PLAN
1:100

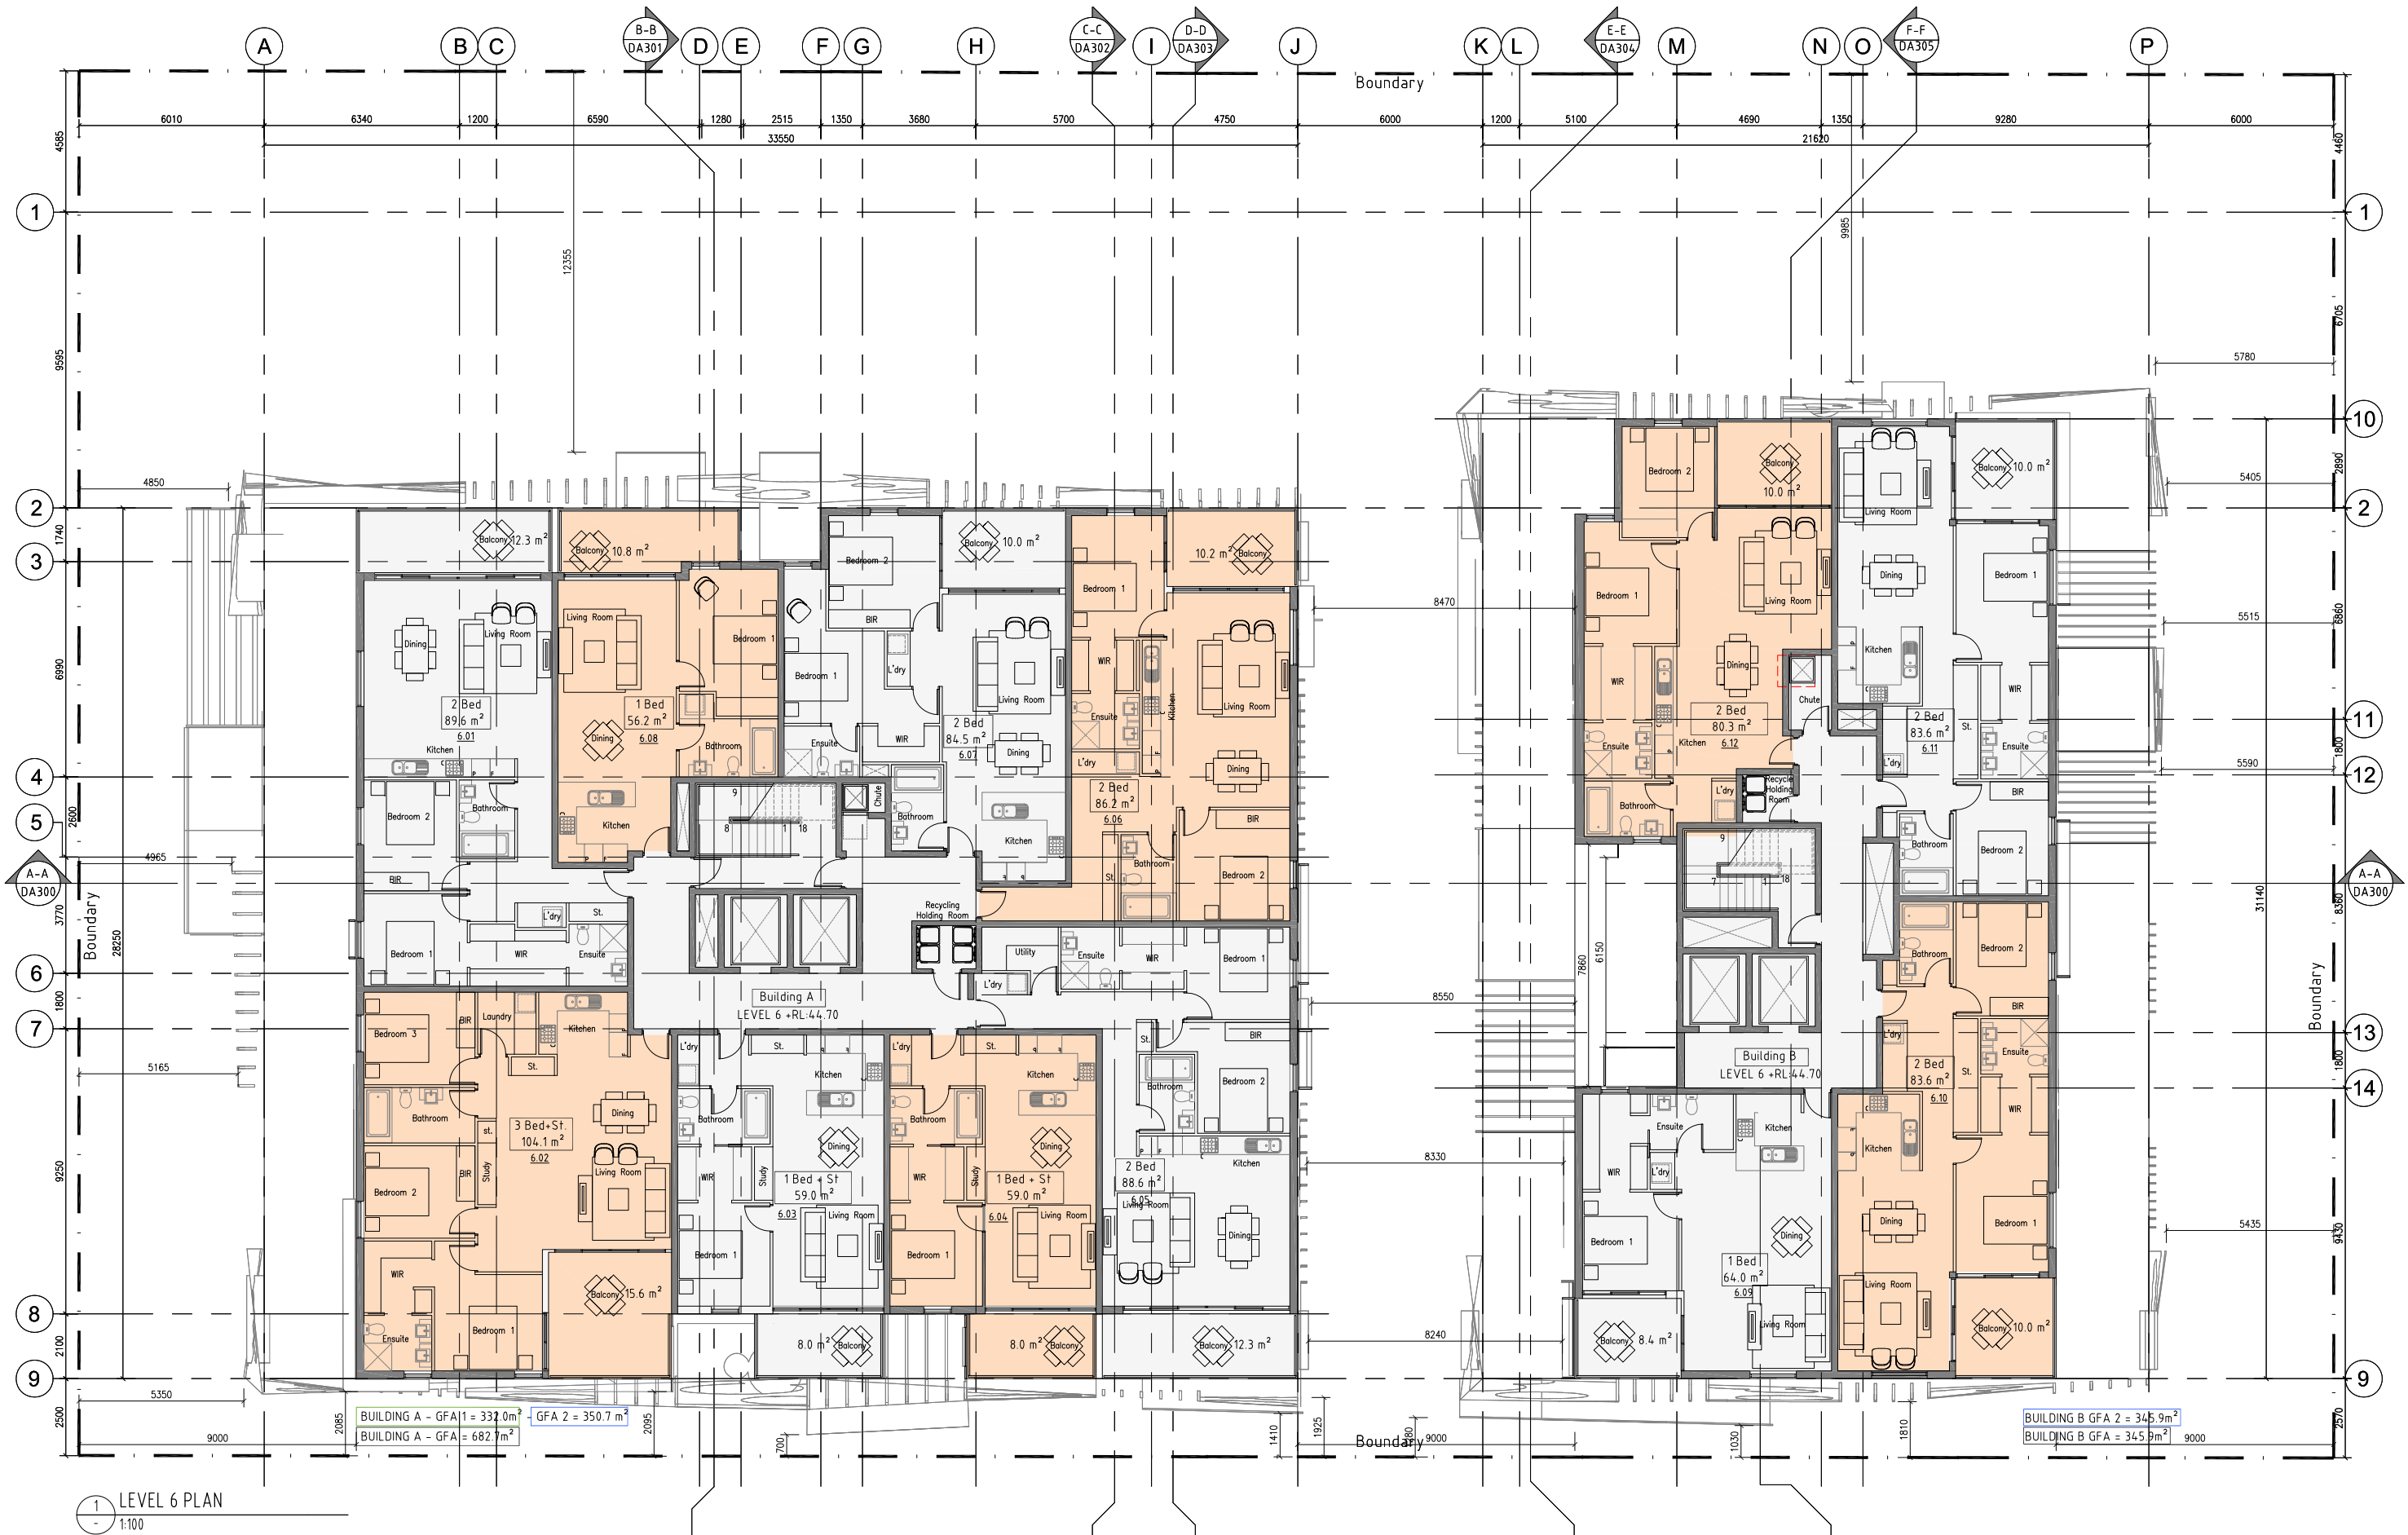






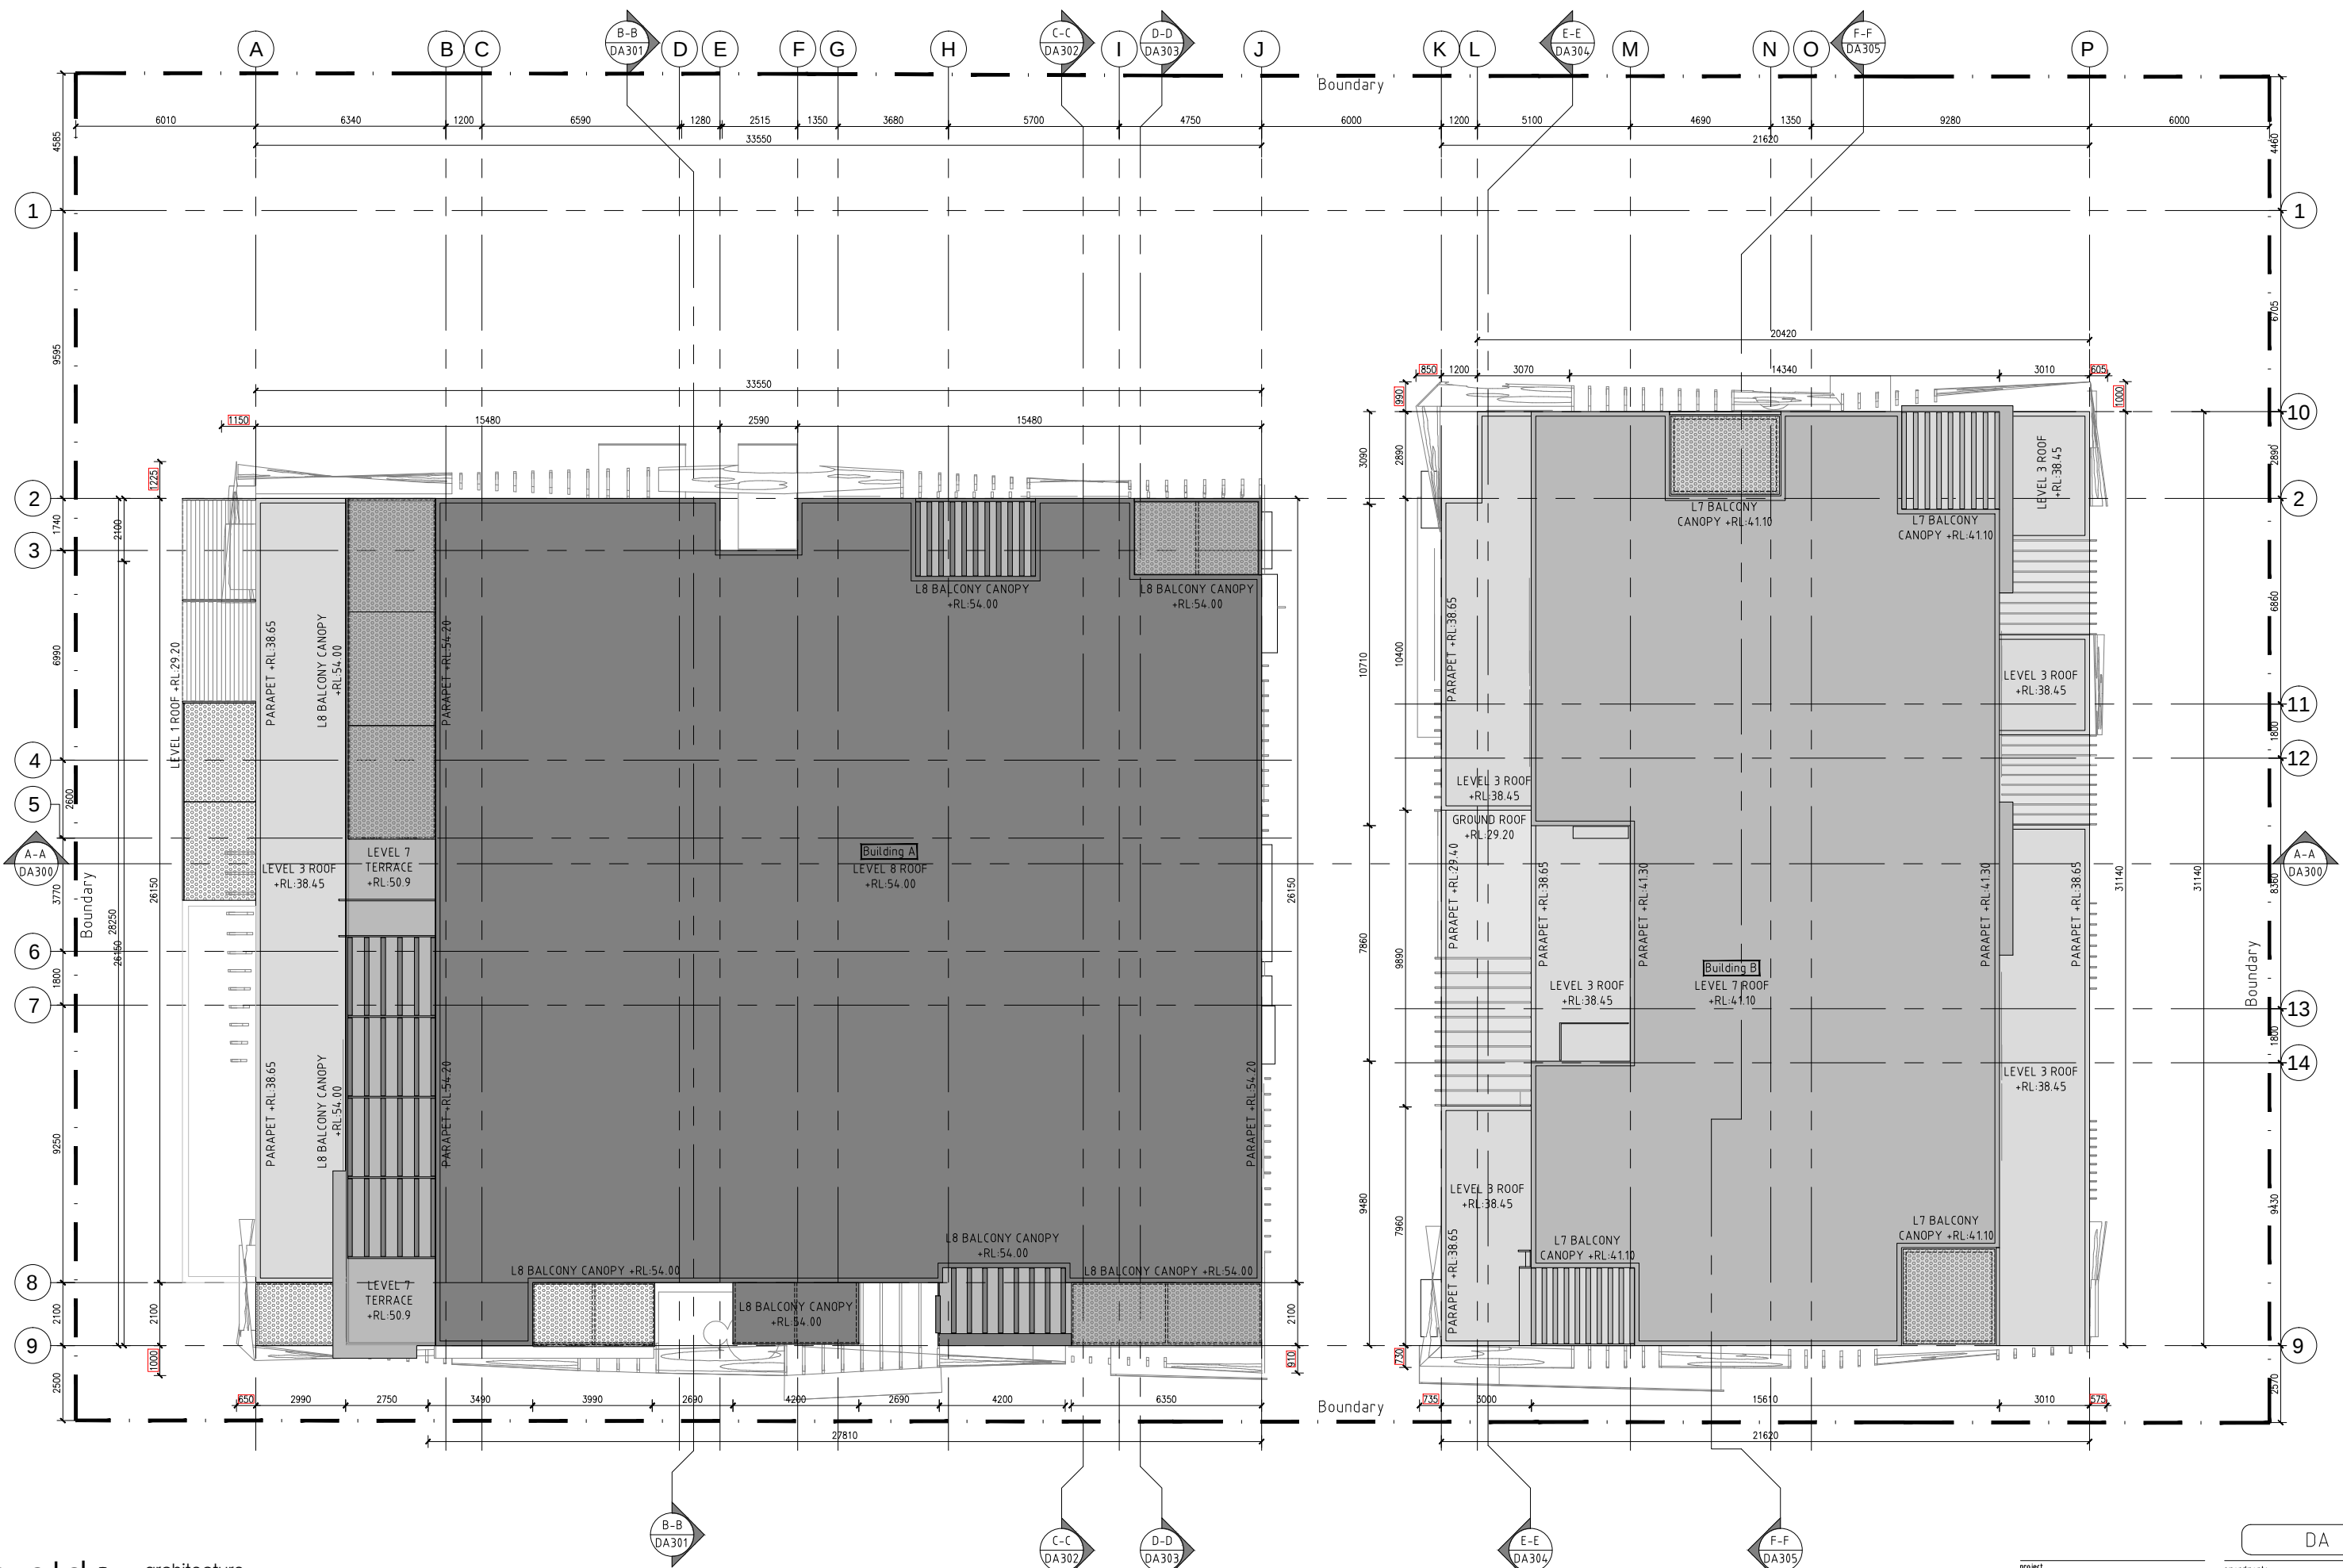



FINISHES KEY			
LS	LOUVRE SCREEN	SB	SOLID BALUSTRADE
ZC	ZINC CLADDING	OG	OBSCURE GLASS
CP	COPPER PANNELLING	RD	ROLLER DOOR
AB	ALUMINIUM BLADE	GC	GLASS CANOPY
RF	RENDER FINISH	CF	CONCRETE FINISH
GB	GLASS BALUSTRADE	EC	ENTRANCE CANOPY
PM	PERFORATED METAL	LC	LOUVRE CANOPY
TG	TECHNO GREEN		

 

project			
34-44 HILL ST, GOSFORD APARTMENTS			
drawing			
WEST ELEVATION			
project ref	date	drawn	checked
15128	14/3/16	MM	MB
scale	scale	date	rev.
1:100@A1, 1:200@A3	DA202		

DA

amendments


date	notes	rev.

Contractor shall verify all levels and dimensions on site prior to commencing any work or shop drawings. Figure dimensions to be used - do not scale.


Copyright is the property of Beraldo Design Pty Ltd. All rights reserved. No part of this drawing may be reproduced or transmitted in any form or by any means, electronic or mechanical, including photocopying, recording, or by any information storage and retrieval system, without permission in writing from Beraldo Design Pty Ltd.




FINISHES KEY			
LS	: LOUVRE SCREEN	SB	: SOLID BALUSTRADE
ZC	: ZINC CLADDING	OG	: OBSCURE GLASS
CP	: COPPER PANELLING	RD	: ROLLER DOOR
AB	: ALUMINIUM BLADE	GC	: GLASS CANOPY
RF	: RENDER FINISH	CF	: CONCRETE FINISH
GB	: GLASS BALUSTRADE	EC	: ENTRANCE CANOPY
PM	: PERFORATED METAL	LC	: LOUVRE CANOPY
TG	: TECHNO GREEN		

 




project			
34-44 HILL ST, GOSFORD APARTMENTS			
drawing			
NORTH ELEVATION			
project ref	date	drawn	MM
15128	14/3/16	checked	MB
scale	dwg. no.	rev.	
1:100@A1, 1:200@A3	DA203	-	
amendments			
DA			
14/03/16 DA SUBMISSION			
DATE notes			
Contractor shall verify all levels and dimensions on site prior to commencing any work or shop drawings. Figure dimensions to be used - do not scale.			
© Copyright is the property of Beraldo Design Pty Ltd. All rights reserved. No part of this drawing may be reproduced without prior written permission.			

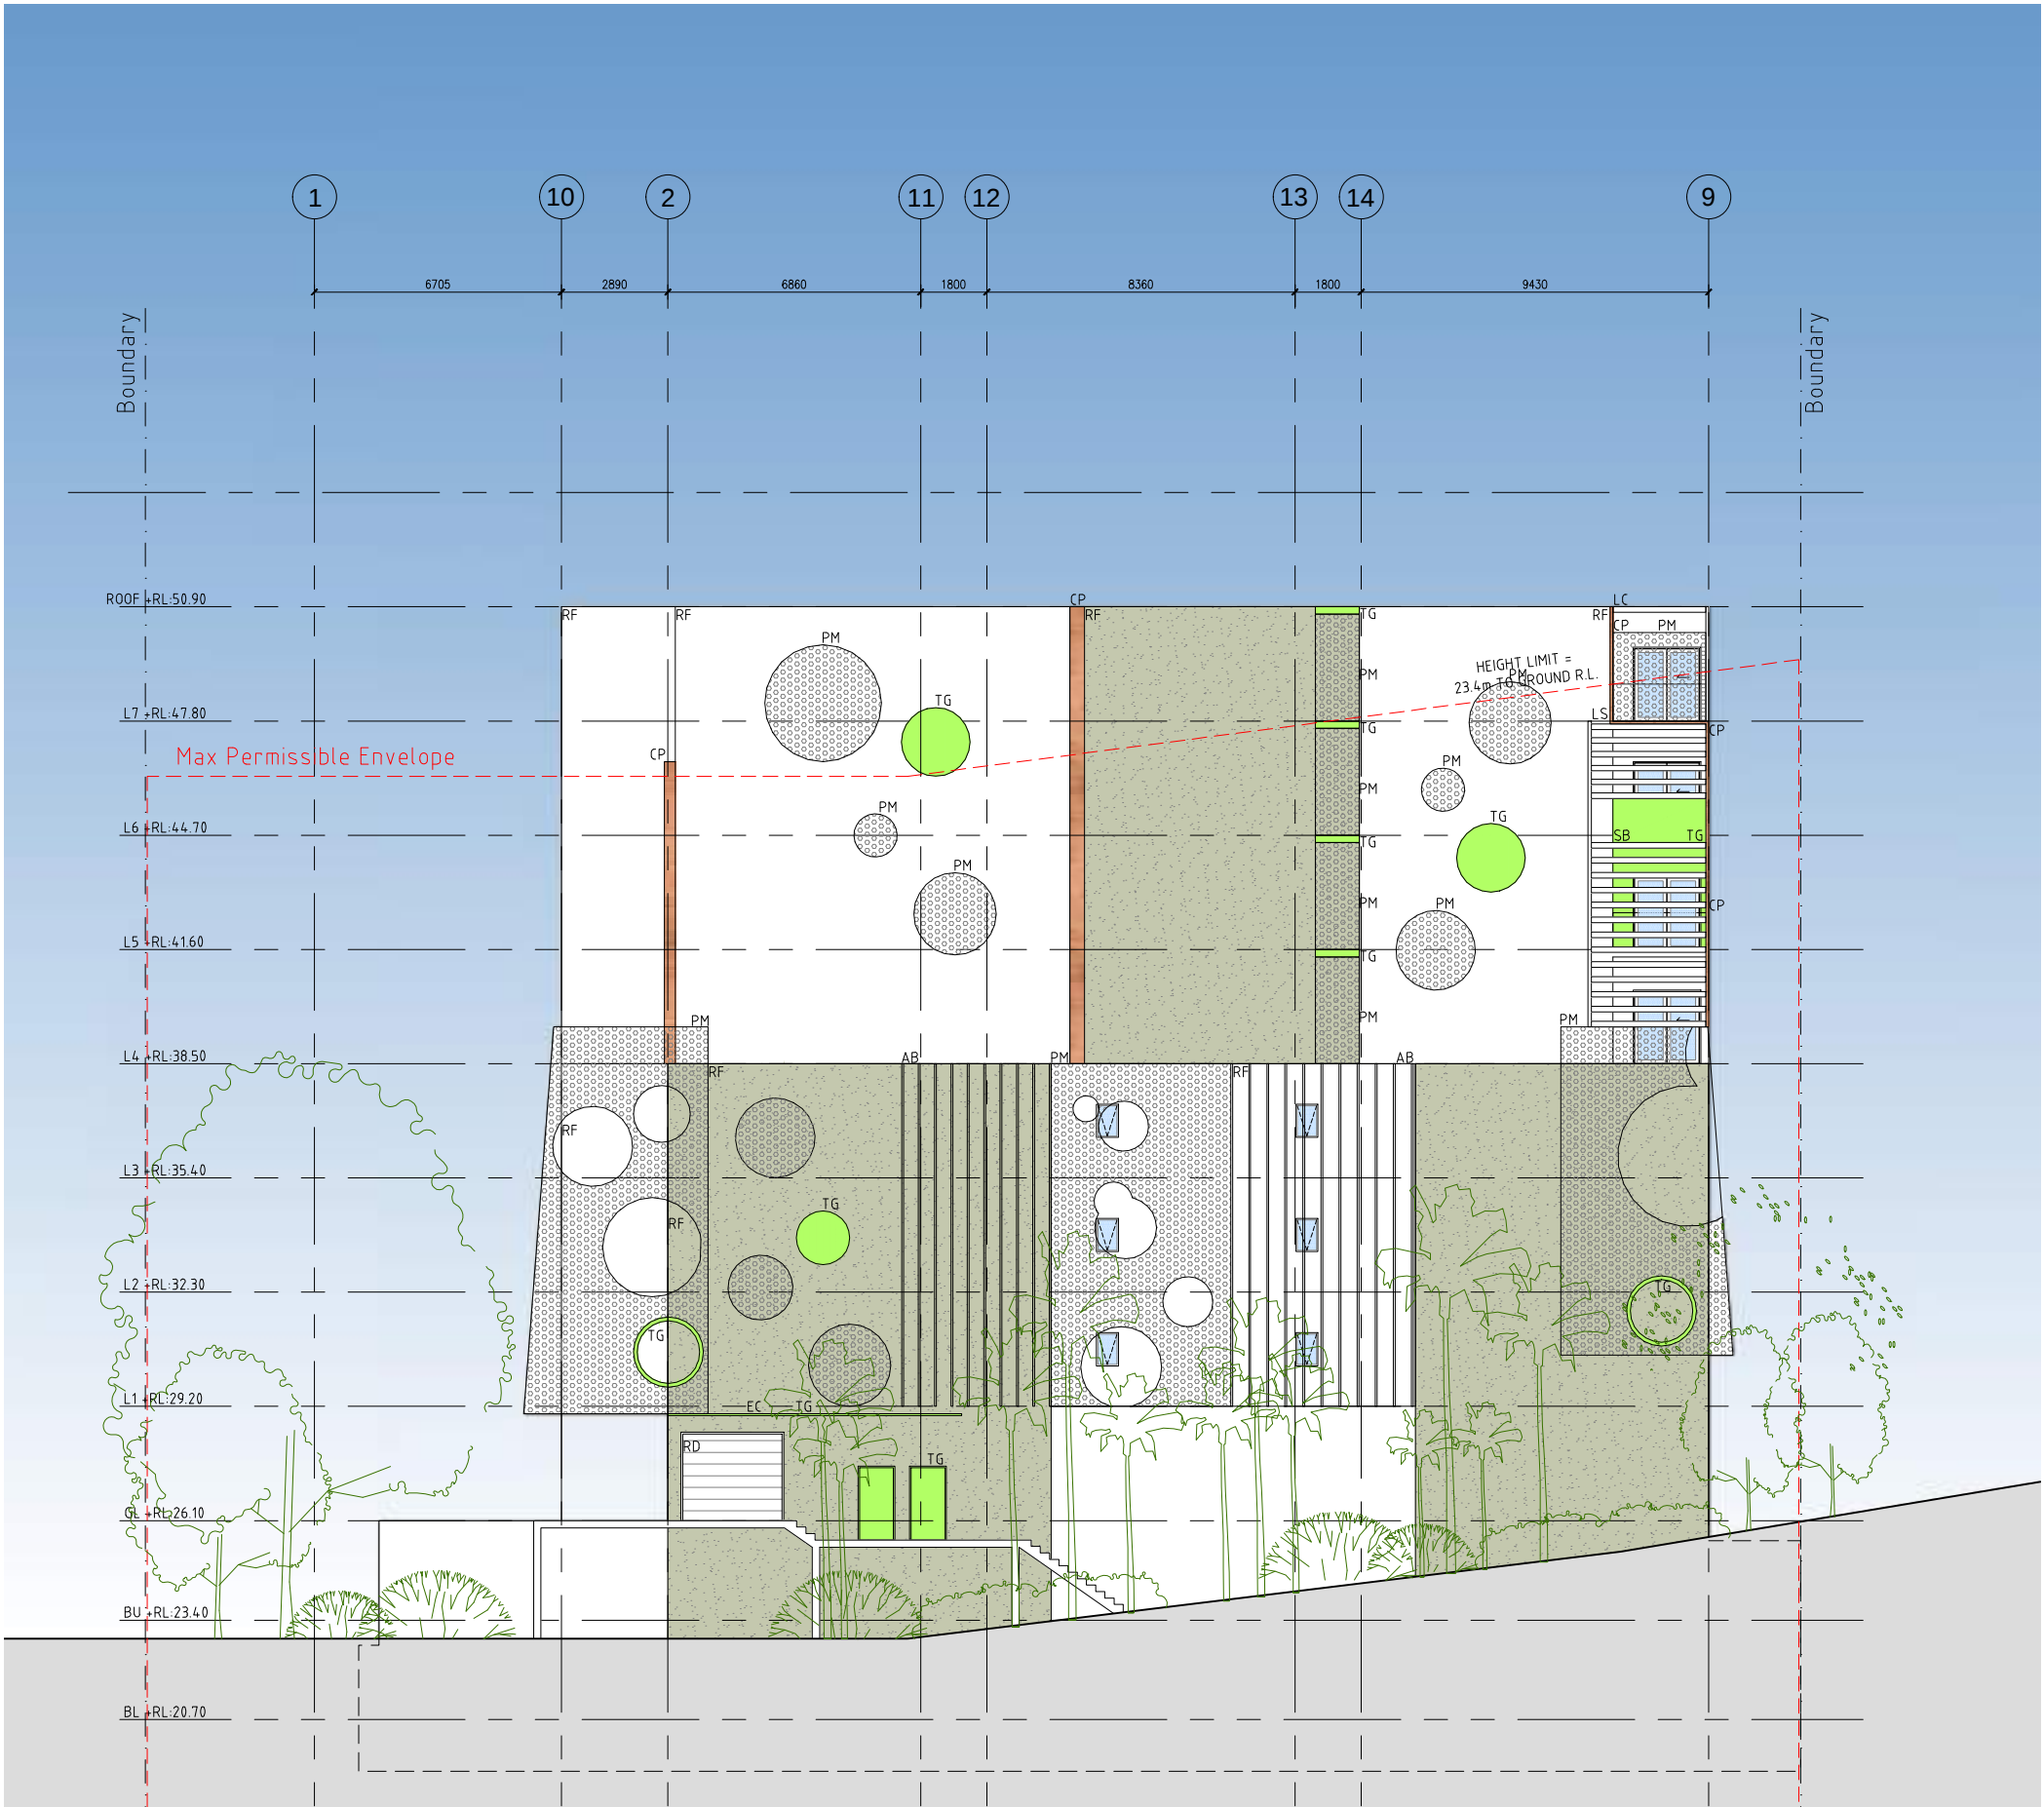

FINISHES KEY			
CS	LOUVRE SCREEN	SB	SOLID BALUSTRADE
ZO	ZINC CLADDING	OG	OBSCURE GLASS
CP	COPPER PANELLING	RD	ROLLER DOOR
AB	ALUMINIUM BLADE	GO	GLASS CANOPY
RF	RENDER FINISH	CF	CONCRETE FINISH
GB	GLASS BALUSTRADE	EC	ENTRANCE CANOPY
PM	PERFORATED METAL	LC	LOUVRE CANOPY
TG	TECHNO GREEN		

 

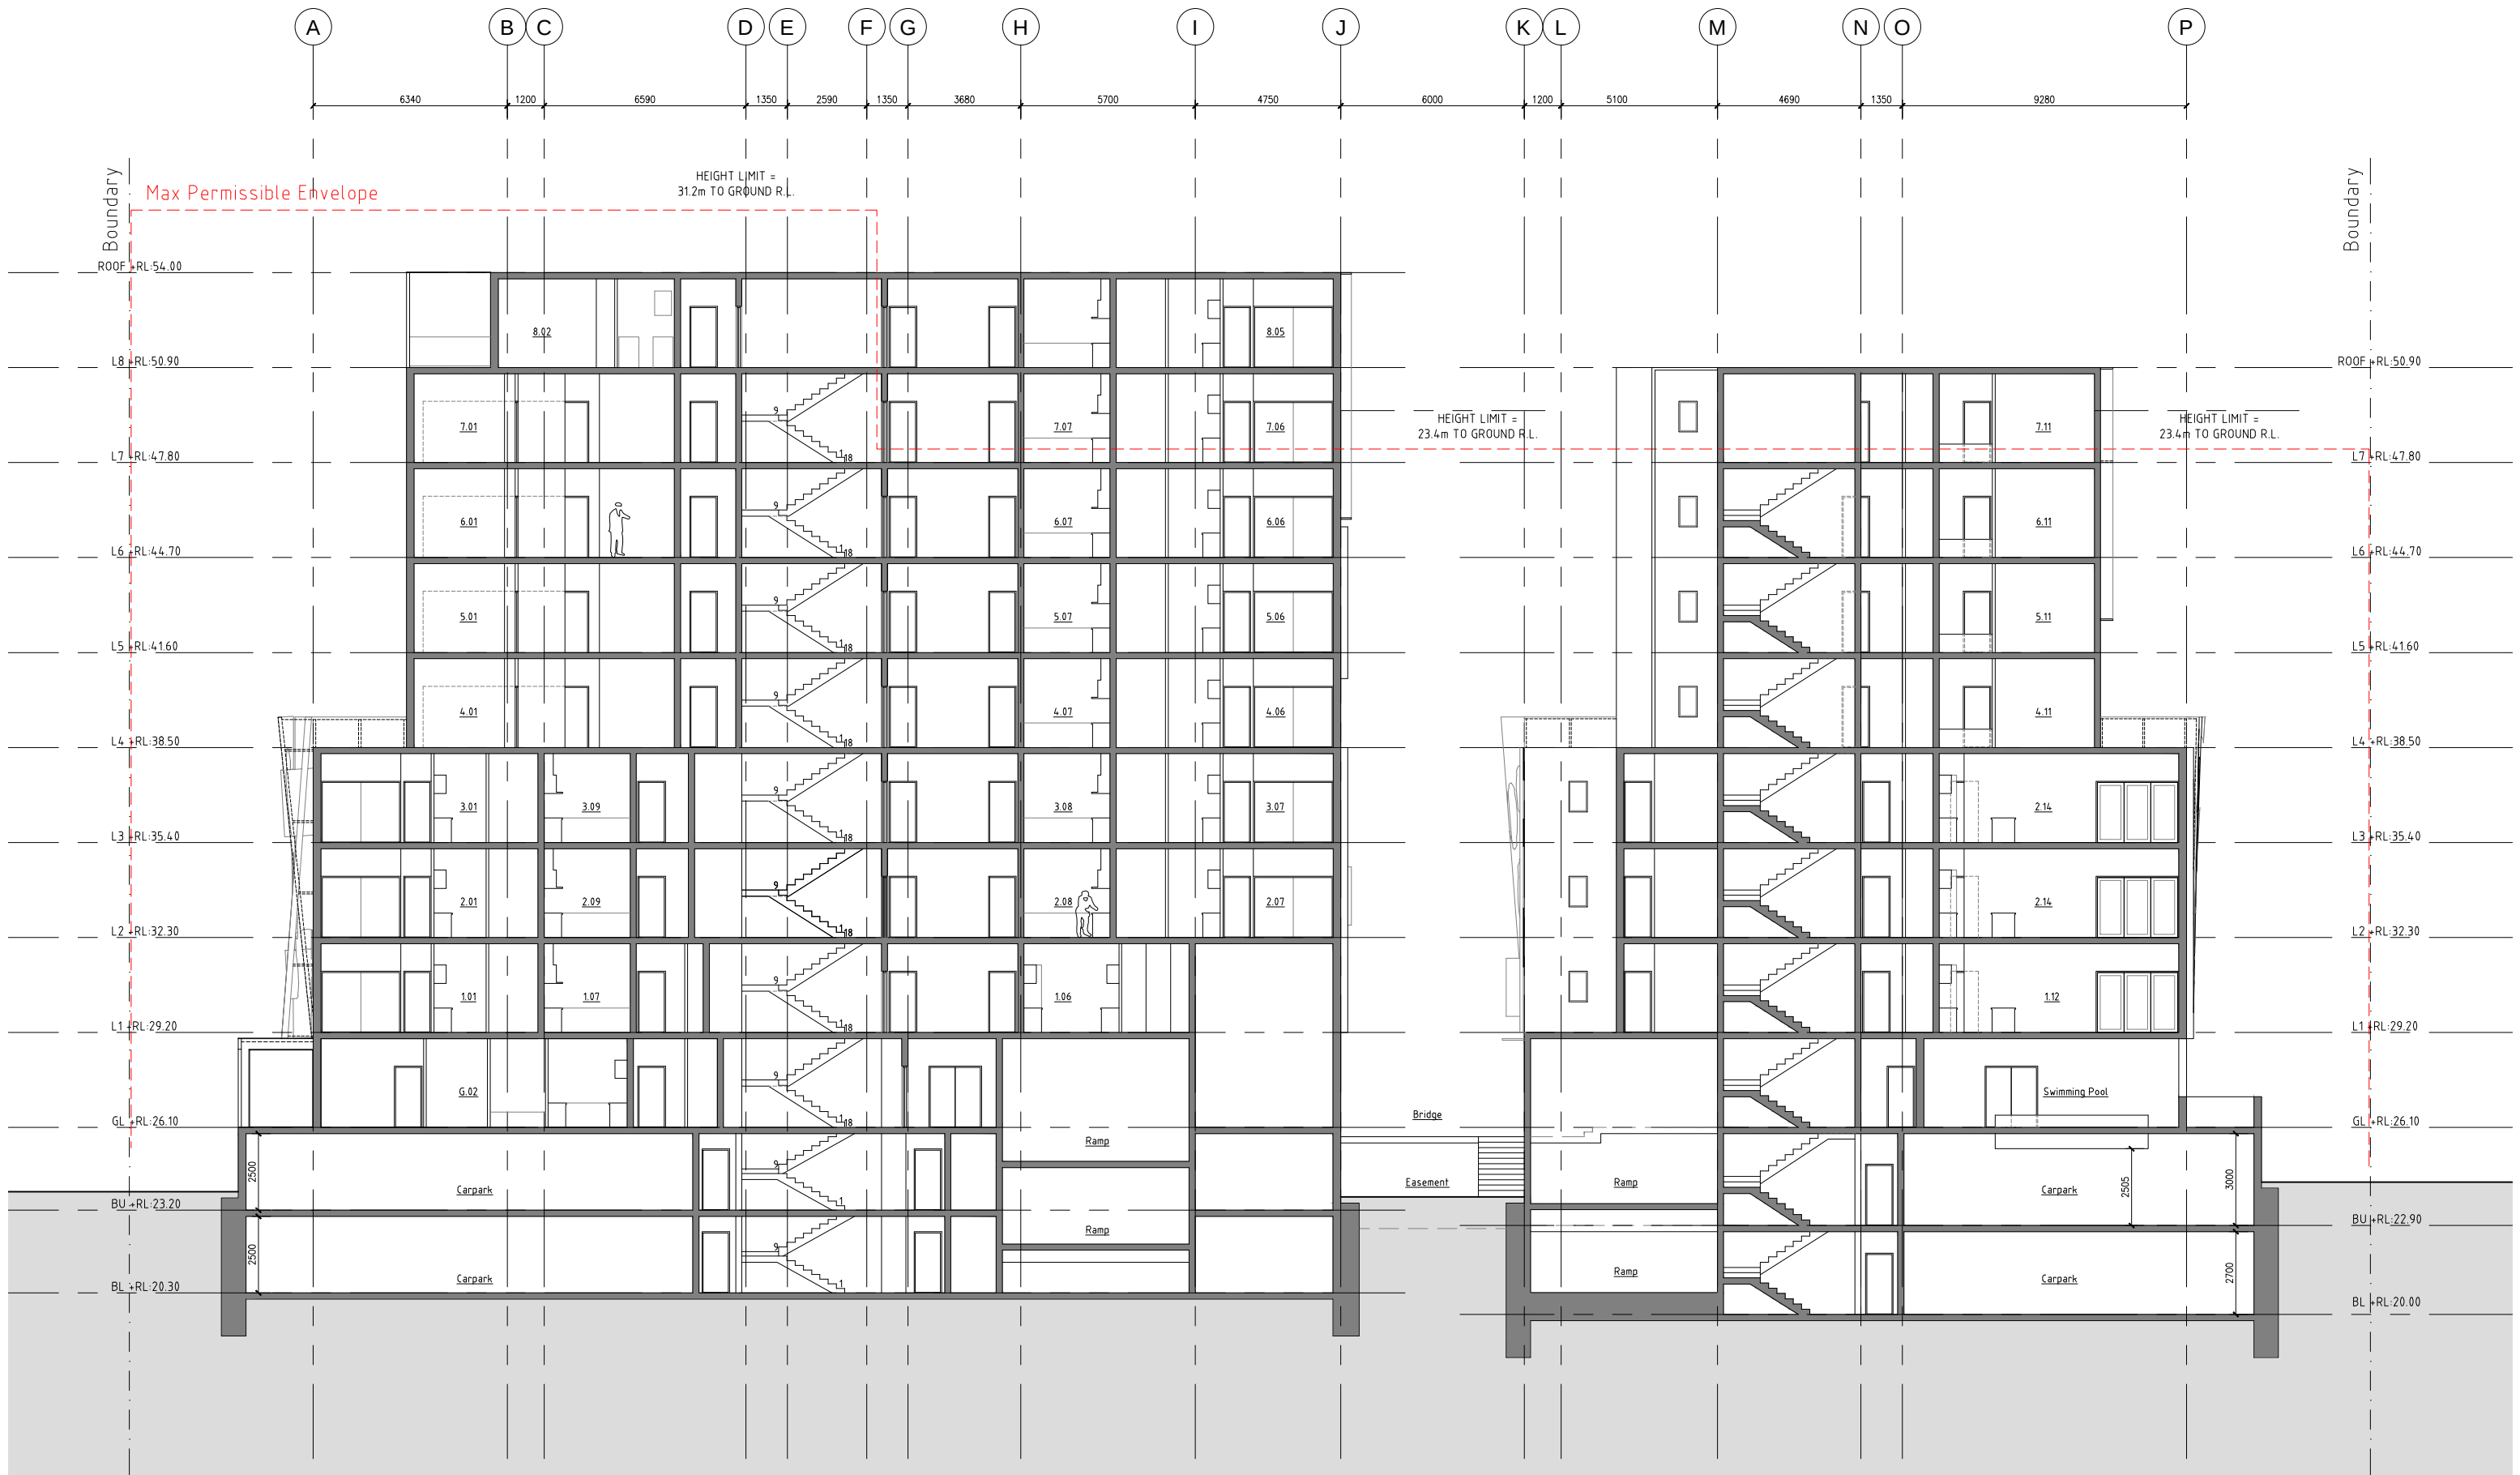

 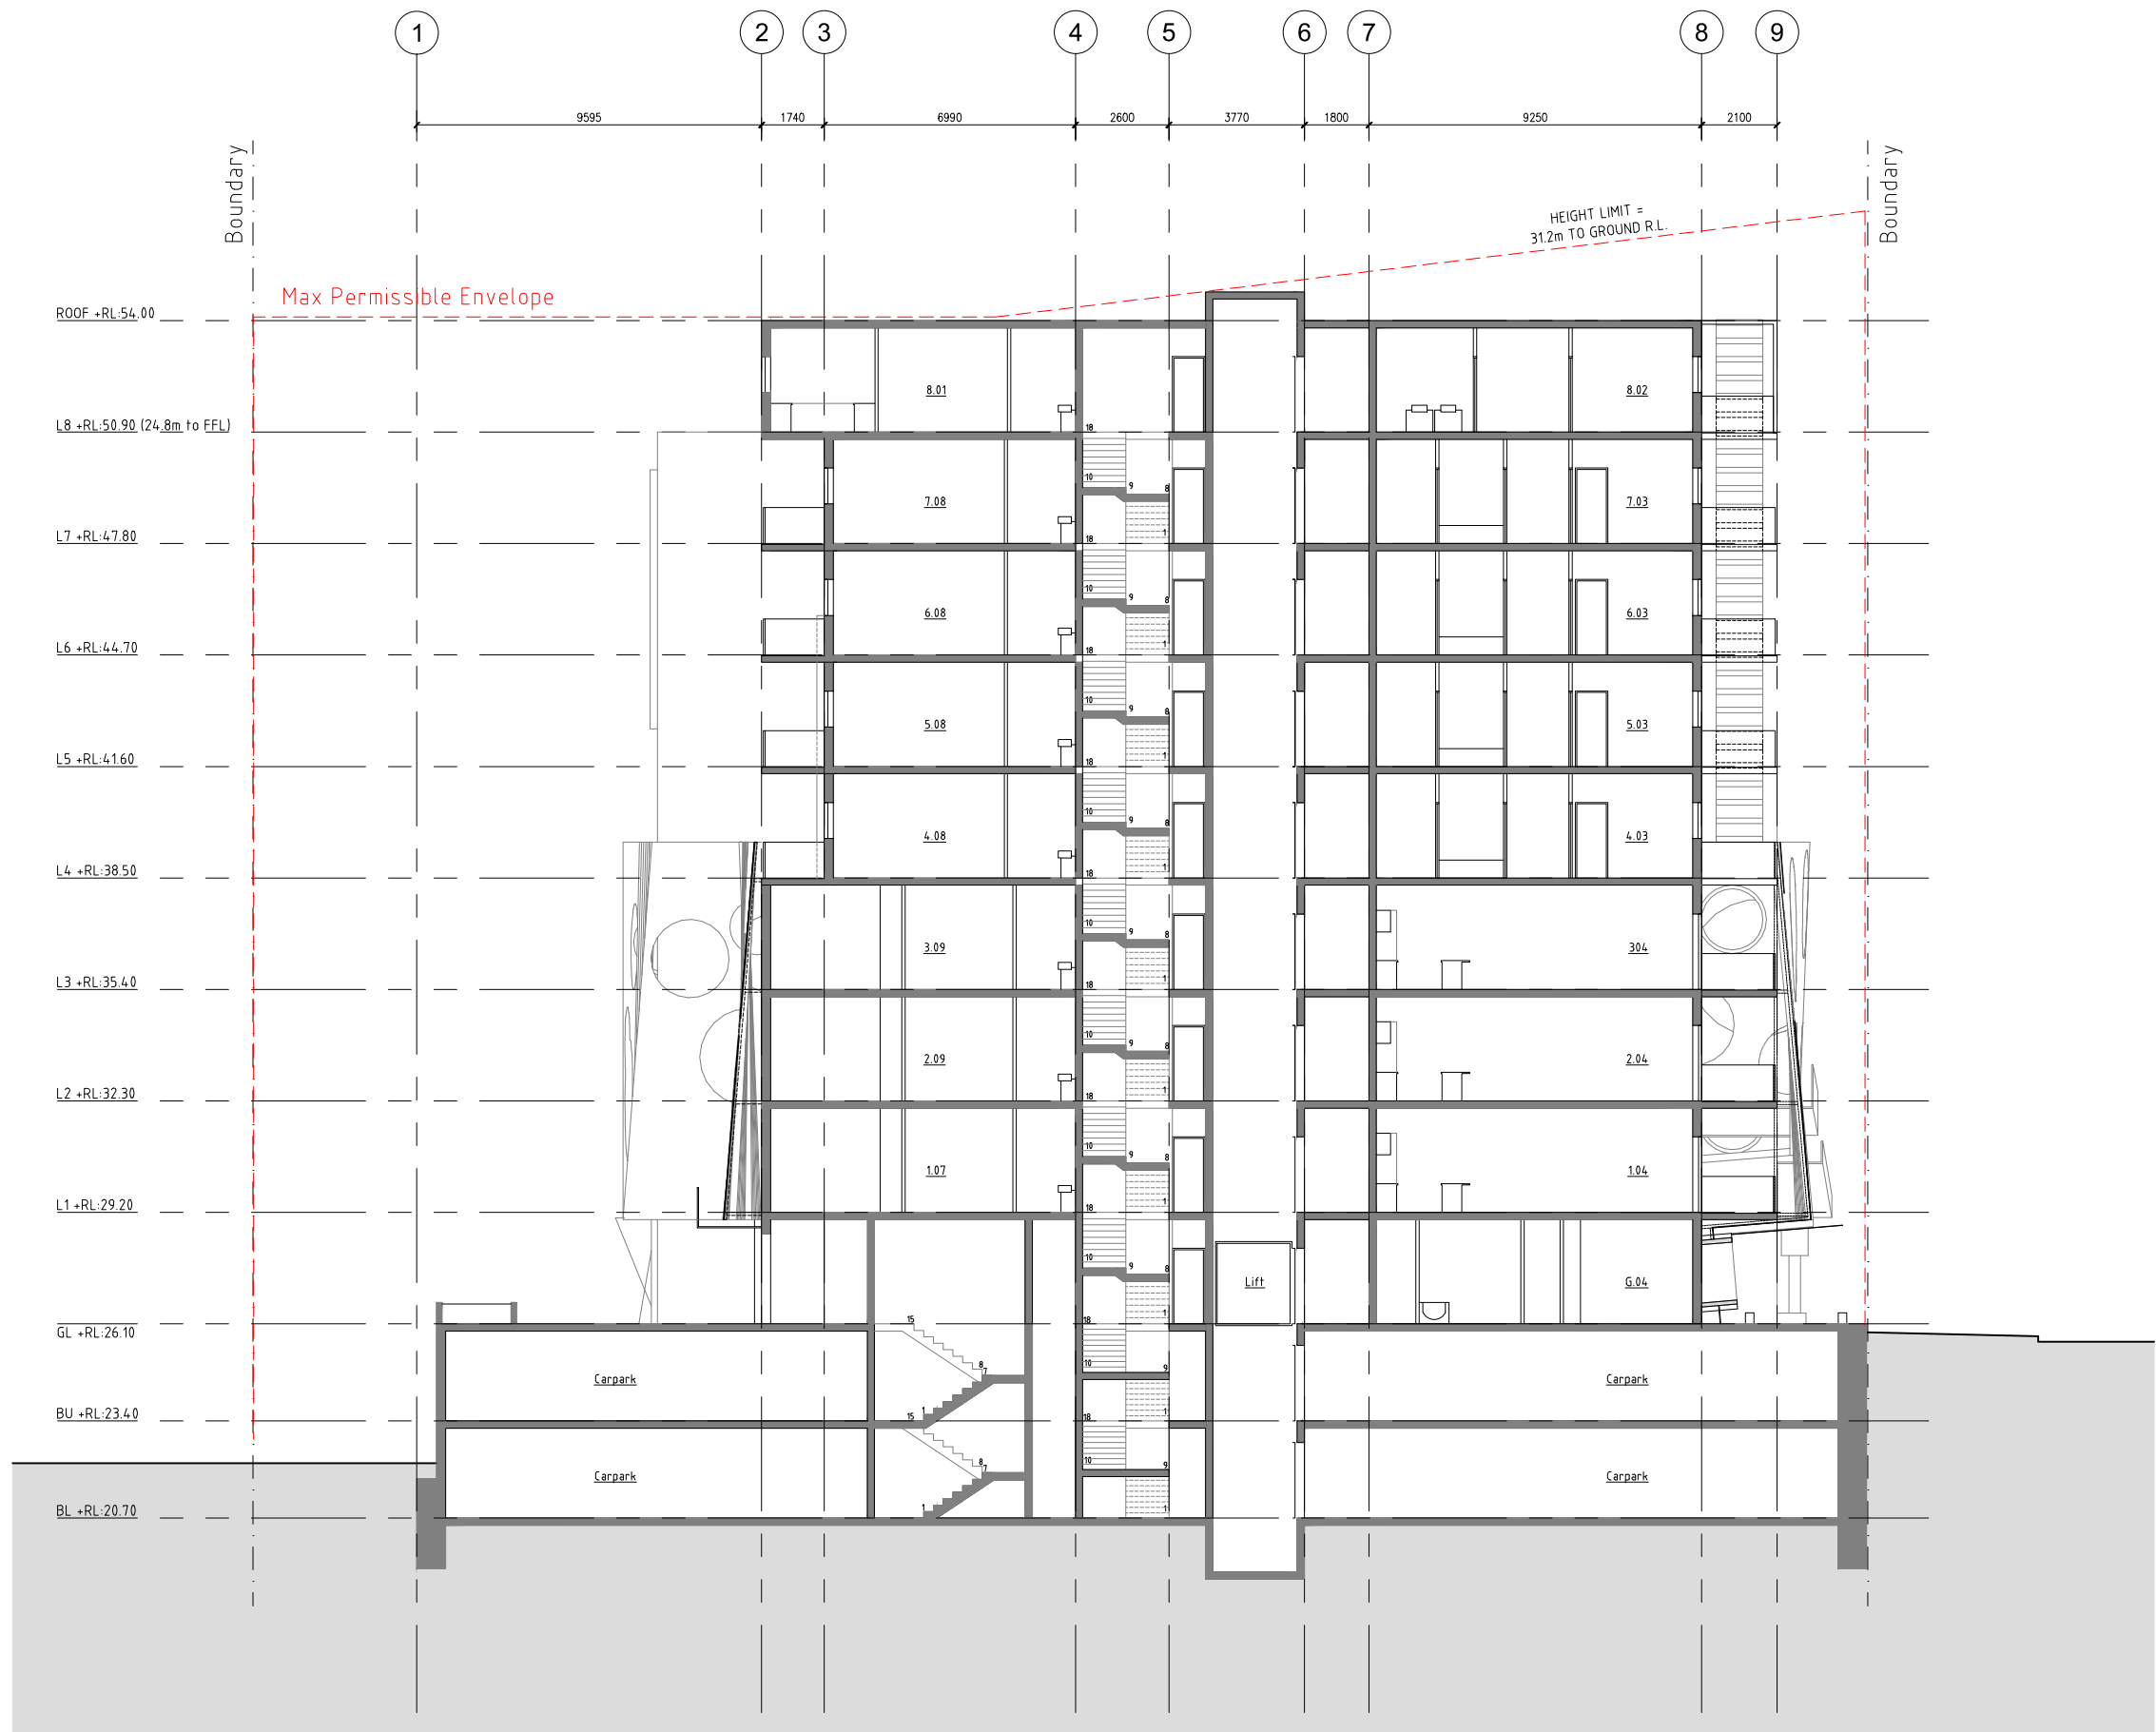


project		34-44 HILL ST, GOSFORD	
drawing		APARTMENTS	
drawing		SECTION B-B	
project ref	date	drawn	MM
15128	14/3/16	checked	MB
scale	dwg. no.	rev.	
1:100@A1, 1:200@A3	DA100	-	


amendments	
14/03/16	DA SUBMISSION
date	notes
rev.	

Contractor shall verify all levels and dimensions on site prior to commencing any work on shop drawings. Tolerances to be used - do not scale.
©Copyright is the property of Beraldo Design Pty Ltd. ACN 117 161 376. No design, copyright, patent or other intellectual property rights are reserved. Other than for the purposes prescribed under the Copyright Act, no part of it may in any form or by any means be used or reproduced without prior written permission.



DA

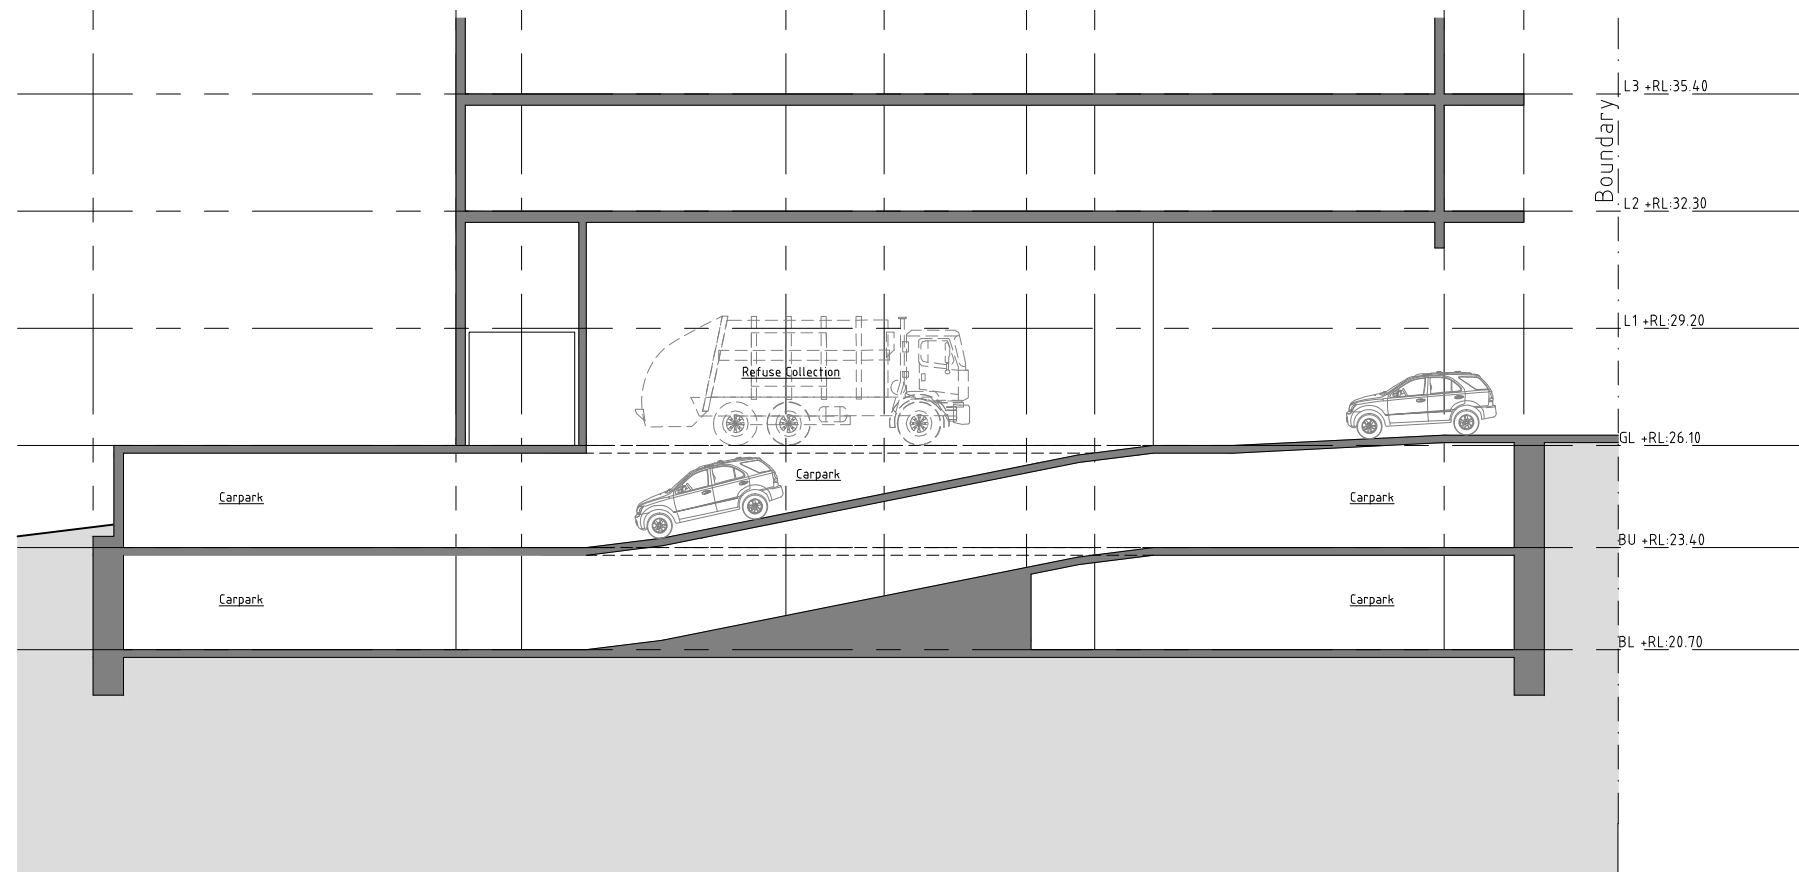


1 SECTION C-C
DA102 1:100


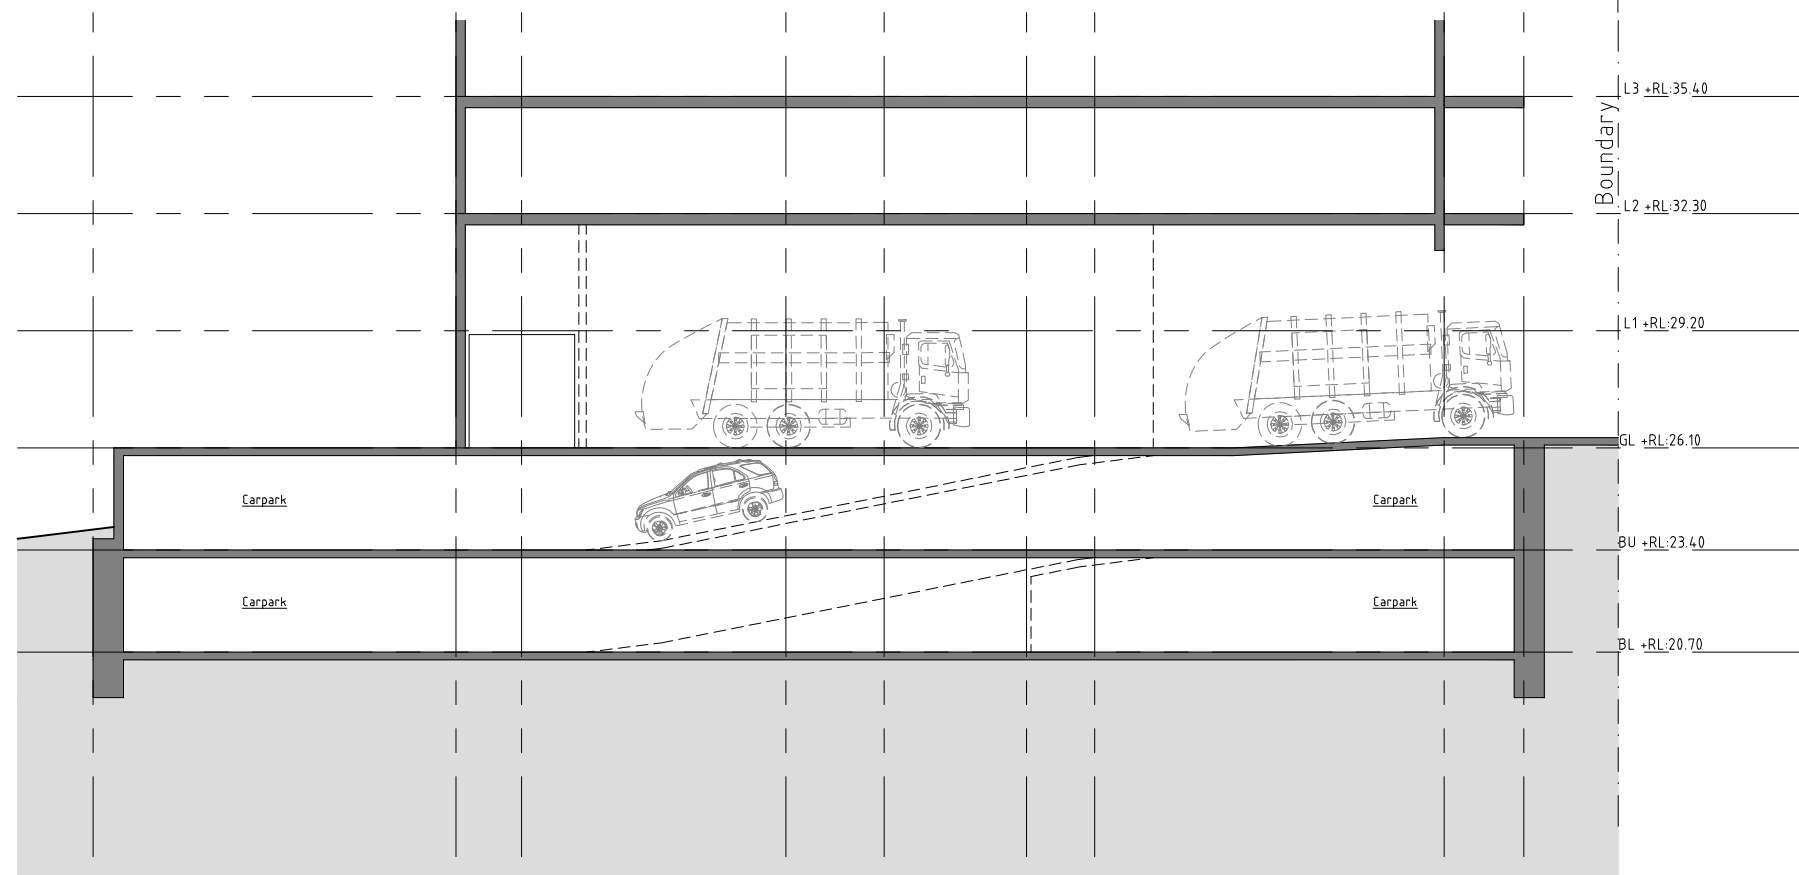


2 SECTION D-D
DA102 1:100

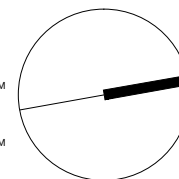 

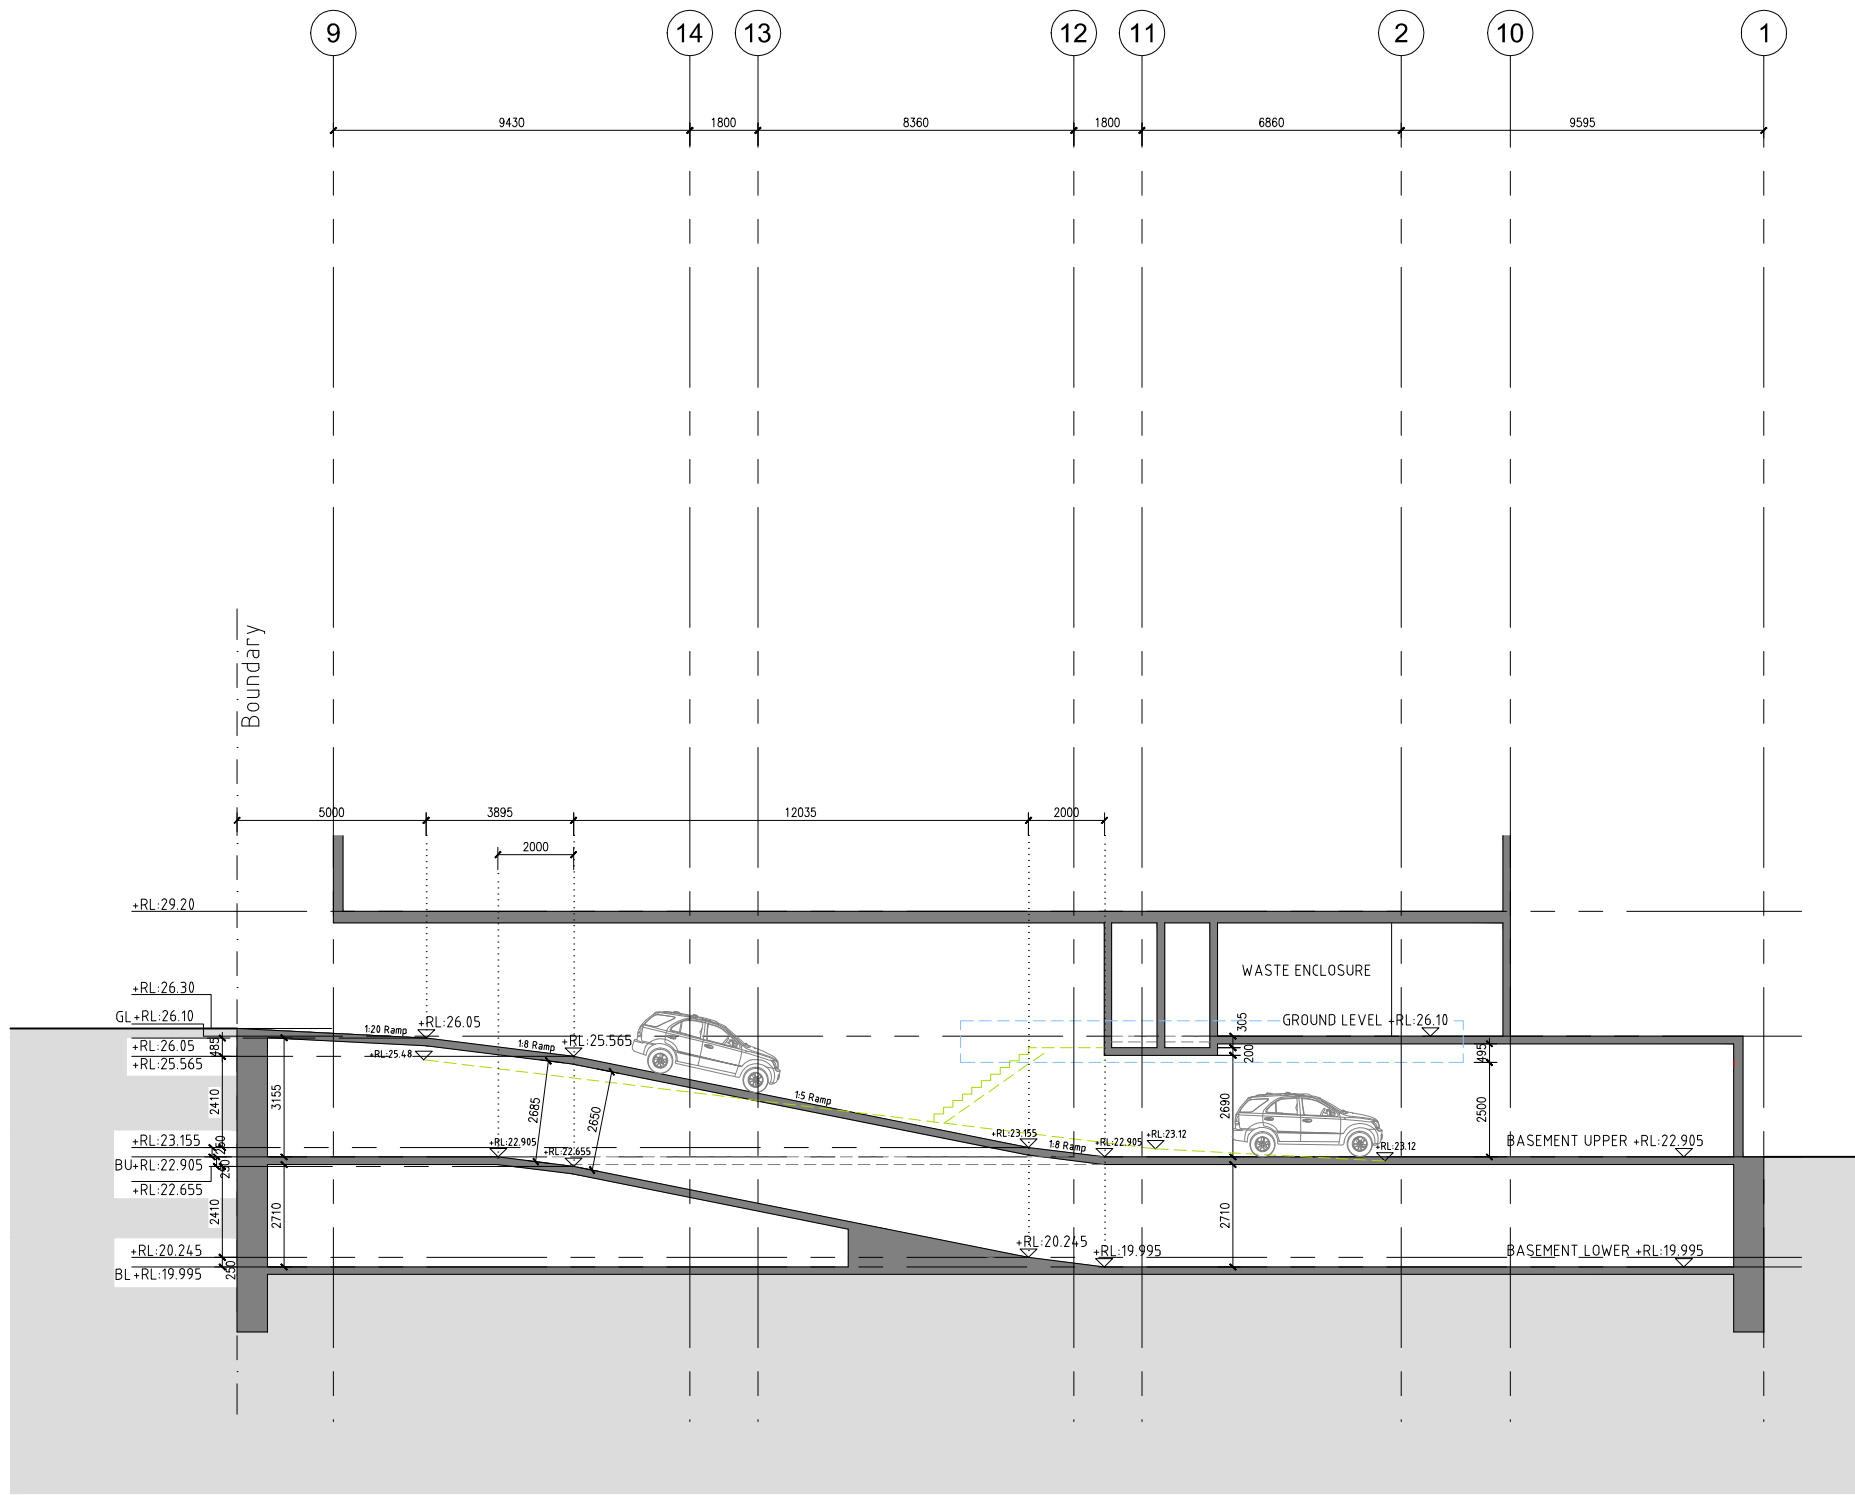


1 SECTION E-E
DA102 1:100

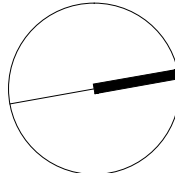 


project		34-44 HILL ST, GOSFORD APARTMENTS	
drawing		SECTION E-E	
project ref 15128	date 14/3/16	drawn	MM
		checked	MB
scale 1:100@A1, 1:200@A3	dwg. no. DA303	rev.	
		-	



DA	
amendments	
14/03/16	DA SUBMISSION
date	notes
©Copyright is the property of Beraldo Design Pty Ltd. All rights reserved. No part of this drawing may be reproduced without prior written permission.	

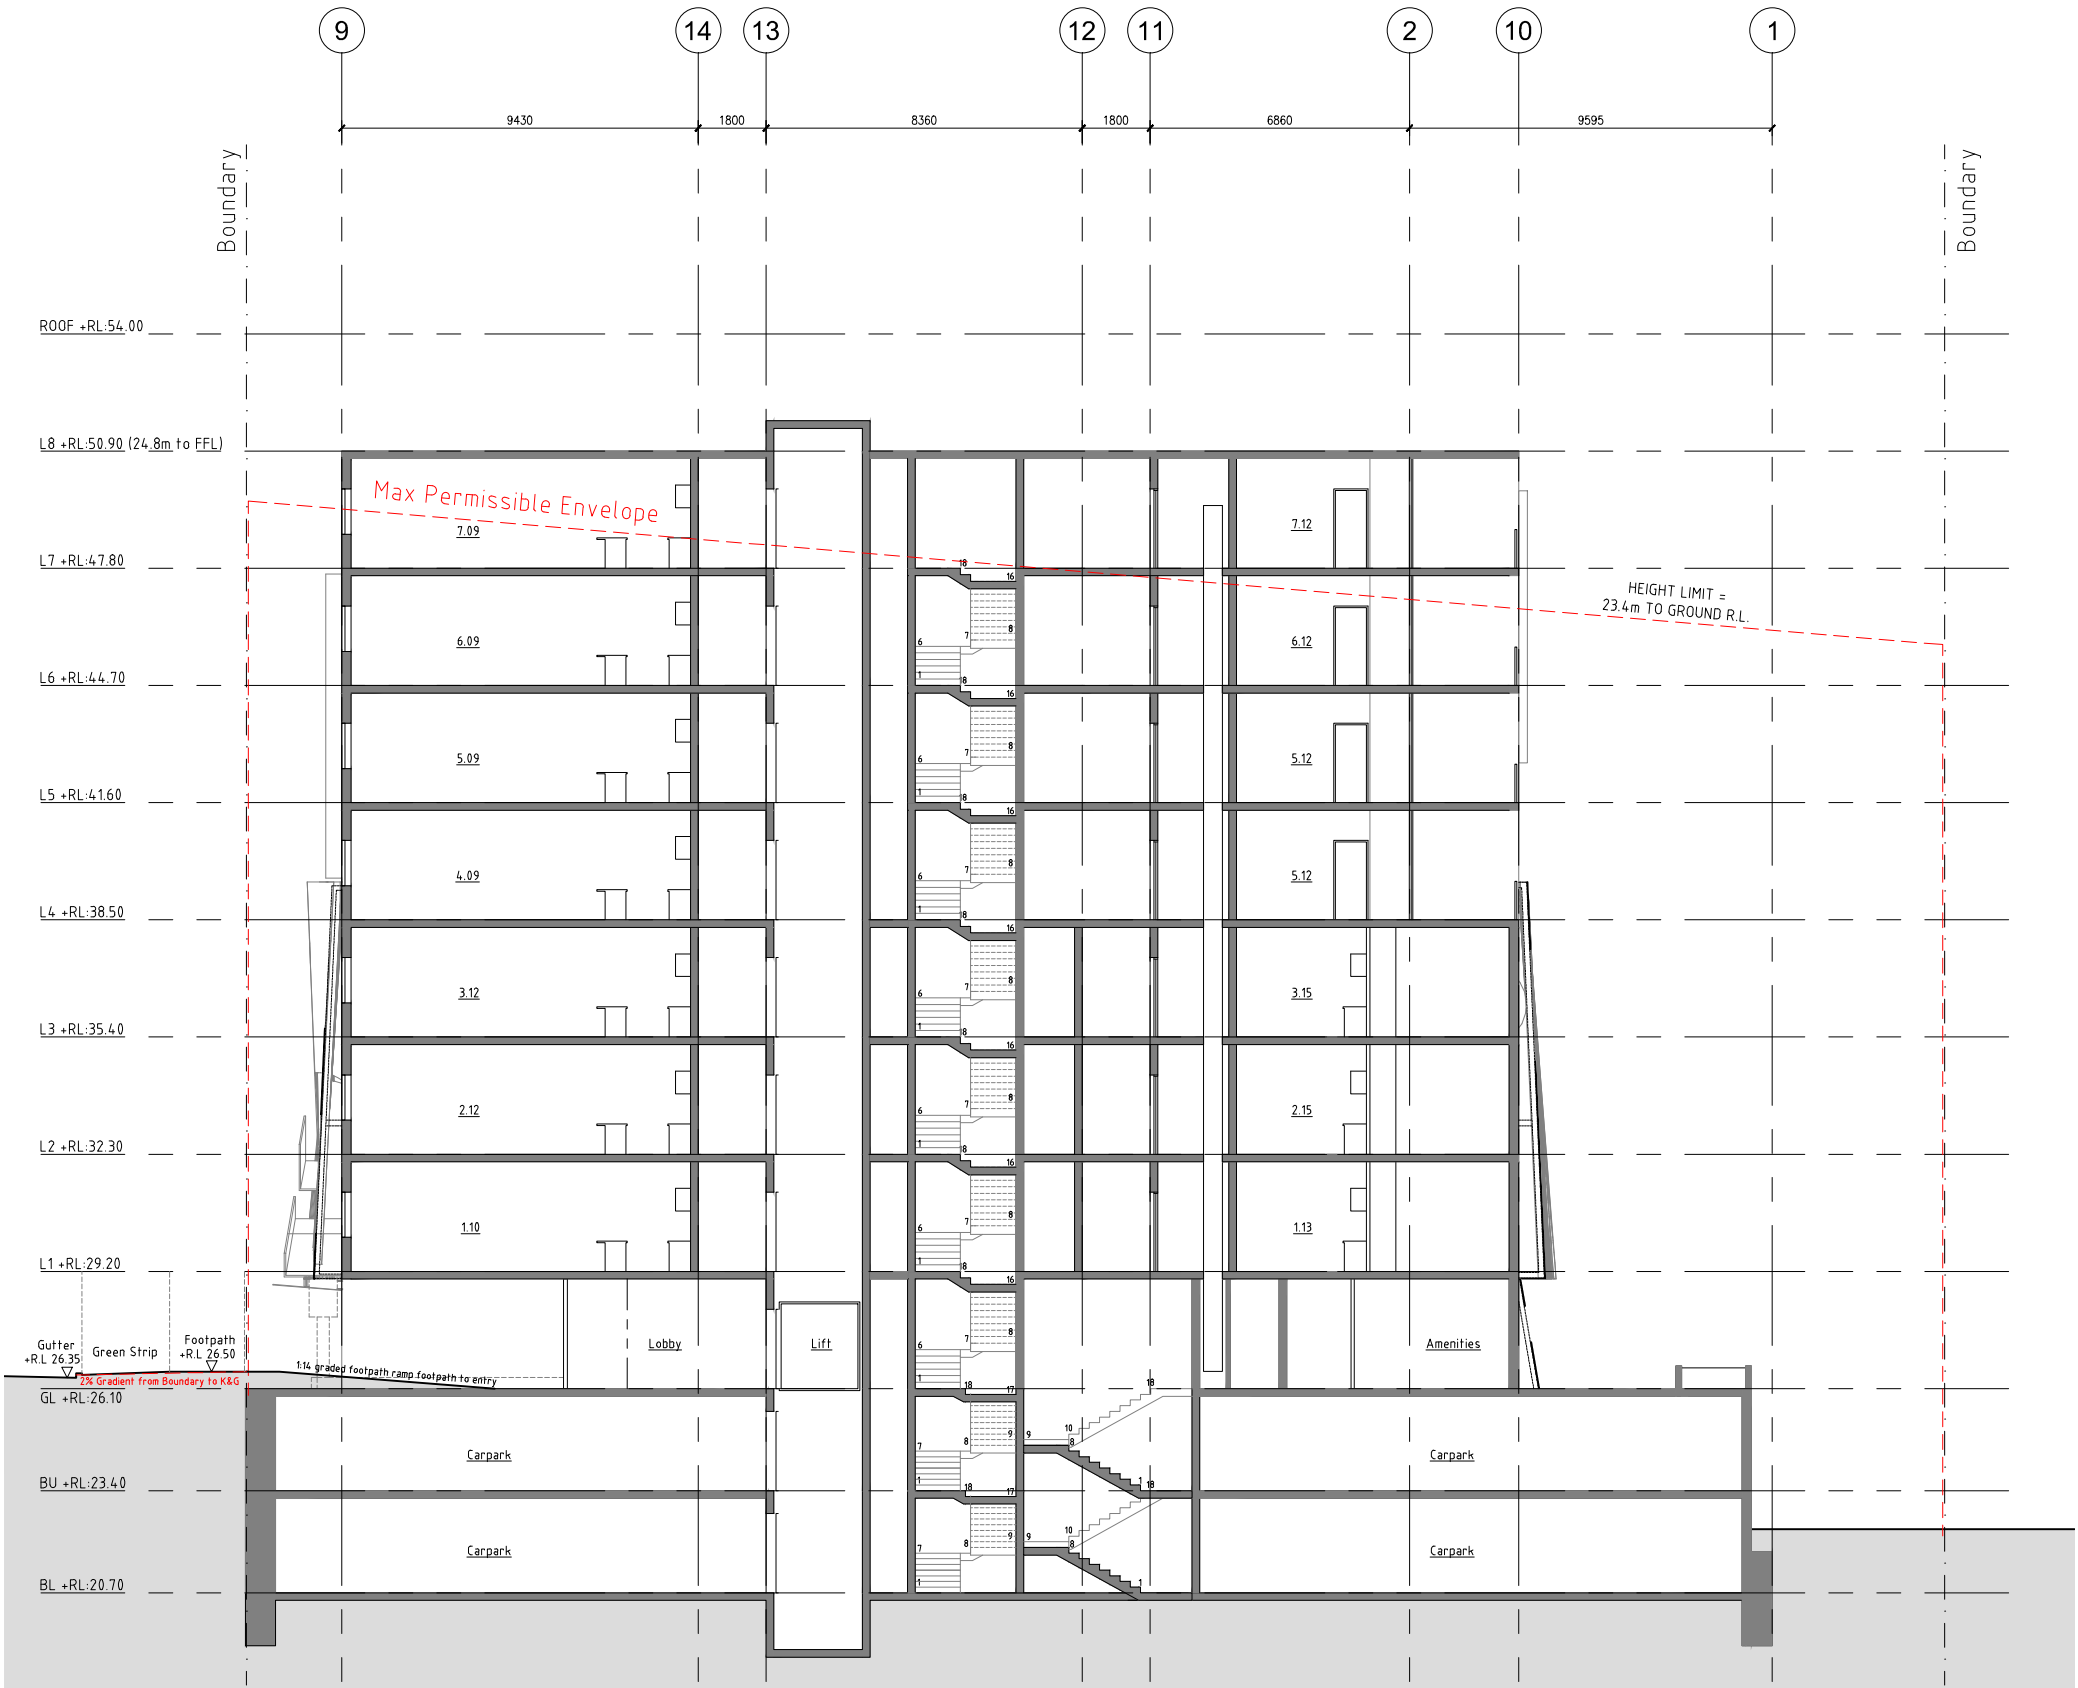

1 SECTION F-F
1:100@A1, 1:200@A3

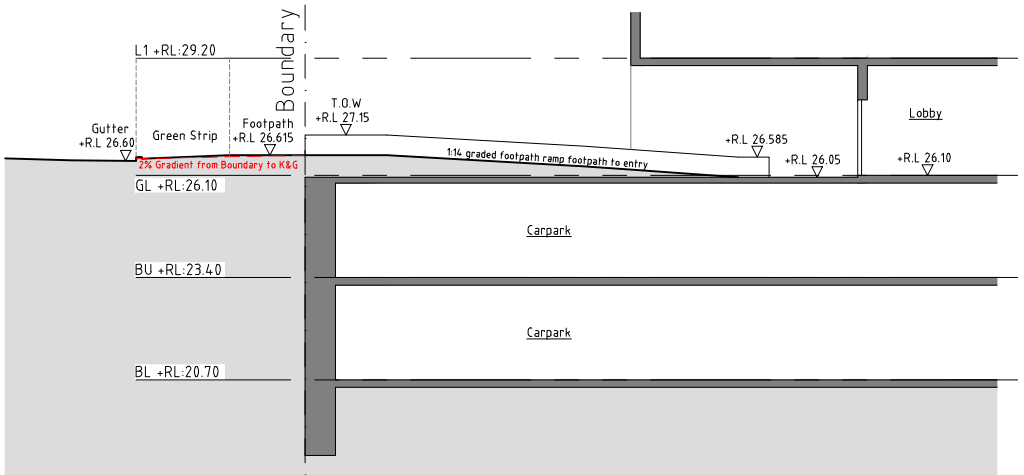

2 SECTION G-G
1:100@A1, 1:200@A3

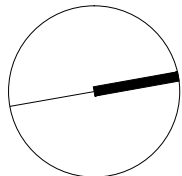 

project	34-44 HILL ST, GOSFORD APARTMENTS
drawing	SECTIONS F-F & G-G
project ref	15128
date	14/3/16
drawn	MM
checked	MB
scale	1:100@A1, 1:200@A3
dwg no	DA304
rev.	-

amendments	DA
1	
2	
3	
100	

HILL ST VIEW - FROM SOUTH END



HILL ST VIEW - FROM NORTH END

