

**2016SYW047 - Liverpool City Council,
DA-180/2016 - Residential flat building
- Consolidation of five existing lots,
demolition of five existing structures,
construction of two Residential Flat
Buildings, comprising of 233 dwellings,
with three levels of basement parking
and associated landscaping,
17-25 Bigge Street, Liverpool**


Architectural Plans


No.	Title.
1	1. The first part of the book is a history of the city of New York, from its first settlement in 1624 to the present time. It is a very interesting and well-written history, and is well illustrated with many fine engravings.
2	2. The second part of the book is a history of the city of New York, from its first settlement in 1624 to the present time. It is a very interesting and well-written history, and is well illustrated with many fine engravings.
3	3. The third part of the book is a history of the city of New York, from its first settlement in 1624 to the present time. It is a very interesting and well-written history, and is well illustrated with many fine engravings.
4	4. The fourth part of the book is a history of the city of New York, from its first settlement in 1624 to the present time. It is a very interesting and well-written history, and is well illustrated with many fine engravings.
5	5. The fifth part of the book is a history of the city of New York, from its first settlement in 1624 to the present time. It is a very interesting and well-written history, and is well illustrated with many fine engravings.
6	6. The sixth part of the book is a history of the city of New York, from its first settlement in 1624 to the present time. It is a very interesting and well-written history, and is well illustrated with many fine engravings.
7	7. The seventh part of the book is a history of the city of New York, from its first settlement in 1624 to the present time. It is a very interesting and well-written history, and is well illustrated with many fine engravings.
8	8. The eighth part of the book is a history of the city of New York, from its first settlement in 1624 to the present time. It is a very interesting and well-written history, and is well illustrated with many fine engravings.
9	9. The ninth part of the book is a history of the city of New York, from its first settlement in 1624 to the present time. It is a very interesting and well-written history, and is well illustrated with many fine engravings.
10	10. The tenth part of the book is a history of the city of New York, from its first settlement in 1624 to the present time. It is a very interesting and well-written history, and is well illustrated with many fine engravings.

No.	Title
TR62-1	THE SHIRT
TR62-2	THE SHIRT
TR62-3	THE SHIRT
TR62-100	THE SHIRT

GENERAL NOTES

[illegible]

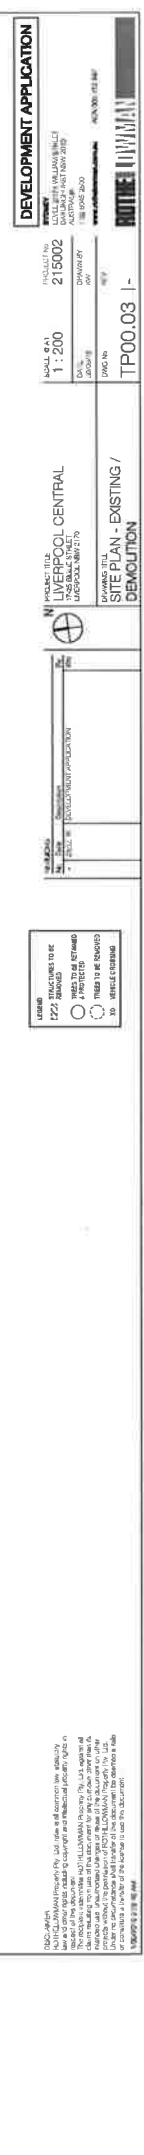

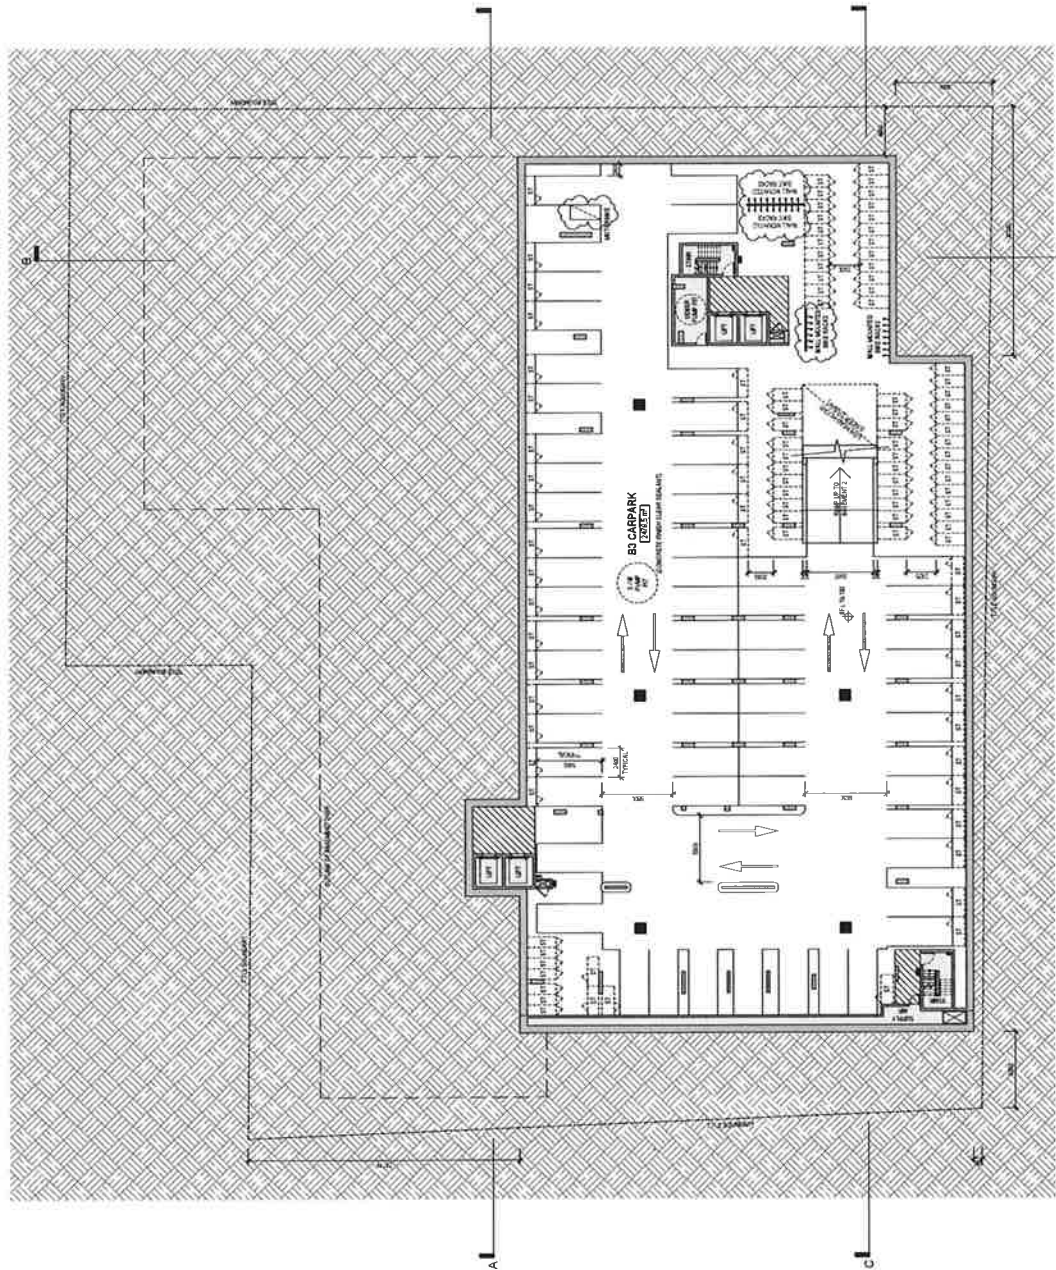

DEVELOPMENT APPLICATION

PROJECT NO: 215002
 PROJECT NAME: LIVERPOOL CENTRAL
 SCALE: 1:200
 DATE: 10/01/2023
 DRAWN BY: [Name]
 CHECKED BY: [Name]
 PROJECT NO: 215002
 PROJECT NAME: LIVERPOOL CENTRAL
 SCALE: 1:200
 DATE: 10/01/2023
 DRAWN BY: [Name]
 CHECKED BY: [Name]

LIVERPOOL CENTRAL

PROJECT NO: 215002
 PROJECT NAME: LIVERPOOL CENTRAL
 SCALE: 1:200
 DATE: 10/01/2023
 DRAWN BY: [Name]
 CHECKED BY: [Name]

BASEMENT 3

PROJECT NO: 215002
 PROJECT NAME: LIVERPOOL CENTRAL
 SCALE: 1:200
 DATE: 10/01/2023
 DRAWN BY: [Name]
 CHECKED BY: [Name]

Level	Area	Total
BASEMENT 1	186	186
BASEMENT 2	115	115
BASEMENT 3	63	63
TOTAL	364	364

ABBREVIATIONS

PT: PARKING TRAIL
 PL: PARKING LOT
 PL: PARKING LOT

NOTES

1. ALL DIMENSIONS ARE IN METERS UNLESS OTHERWISE SPECIFIED.

2. ALL DIMENSIONS ARE TO FACE UNLESS OTHERWISE SPECIFIED.

3. ALL DIMENSIONS ARE TO FACE UNLESS OTHERWISE SPECIFIED.

4. ALL DIMENSIONS ARE TO FACE UNLESS OTHERWISE SPECIFIED.

5. ALL DIMENSIONS ARE TO FACE UNLESS OTHERWISE SPECIFIED.

6. ALL DIMENSIONS ARE TO FACE UNLESS OTHERWISE SPECIFIED.

7. ALL DIMENSIONS ARE TO FACE UNLESS OTHERWISE SPECIFIED.

8. ALL DIMENSIONS ARE TO FACE UNLESS OTHERWISE SPECIFIED.

9. ALL DIMENSIONS ARE TO FACE UNLESS OTHERWISE SPECIFIED.

10. ALL DIMENSIONS ARE TO FACE UNLESS OTHERWISE SPECIFIED.



Level	Total
BASEMENT 1	68
BASEMENT 2	116
BASEMENT 3	63
	247

PROJECT TEAM
LIVERPOOL CENTRAL
15-21 DECEMBER 2007
10.00 AM - 5.00 PM

SCALE GAT		STORY	
1 : 200	215002	LVL 2/7 WILLAMSHILL DUP-IMP-HS NEW 2010	
DATE	DRAWN BY	AUTHOR	
6/10/08	SJ-MW	TCL DWS ADON	
ENG No	Qty		



DEVELOPMENT APPLICATION

PROJECT NO: 2150002
 SCALE: 1:200
 DATE: 10/01/2023
 DRAWN BY: J. DUNN
 CHECKED BY: J. DUNN
 APPROVED BY: J. DUNN

PROJECT TITLE: LIVERPOOL CENTRAL

LEVELS 1-2

TP01.05 A

LEGEND

RESIDENTIAL
 COMMERCIAL
 PUBLIC SPACE
 PARKING
 BUS STOP
 PUBLIC SQUARE

ABBREVIATIONS

RES: RESIDENTIAL
 COM: COMMERCIAL
 PUB: PUBLIC SPACE
 PAR: PARKING
 BUS: BUS STOP
 PUBS: PUBLIC SQUARE

NOTES: 1. ALL DIMENSIONS ARE IN METERS. 2. ALL DIMENSIONS ARE TO FACE UNLESS OTHERWISE STATED. 3. ALL DIMENSIONS ARE TO BE TAKEN FROM THE CENTERLINE OF THE ROAD. 4. ALL DIMENSIONS ARE TO BE TAKEN FROM THE CENTERLINE OF THE ROAD. 5. ALL DIMENSIONS ARE TO BE TAKEN FROM THE CENTERLINE OF THE ROAD. 6. ALL DIMENSIONS ARE TO BE TAKEN FROM THE CENTERLINE OF THE ROAD. 7. ALL DIMENSIONS ARE TO BE TAKEN FROM THE CENTERLINE OF THE ROAD. 8. ALL DIMENSIONS ARE TO BE TAKEN FROM THE CENTERLINE OF THE ROAD. 9. ALL DIMENSIONS ARE TO BE TAKEN FROM THE CENTERLINE OF THE ROAD. 10. ALL DIMENSIONS ARE TO BE TAKEN FROM THE CENTERLINE OF THE ROAD.



PROJECT TITLE
LIVERPOOL CENTRAL
17-25 MAR 2014


NAME	DATE	TIME
Mr. Smith	10/10/10	10:00

LEGEND

 BLANK/VOIDSPACE

ABBREVIATIONS

[illegible]

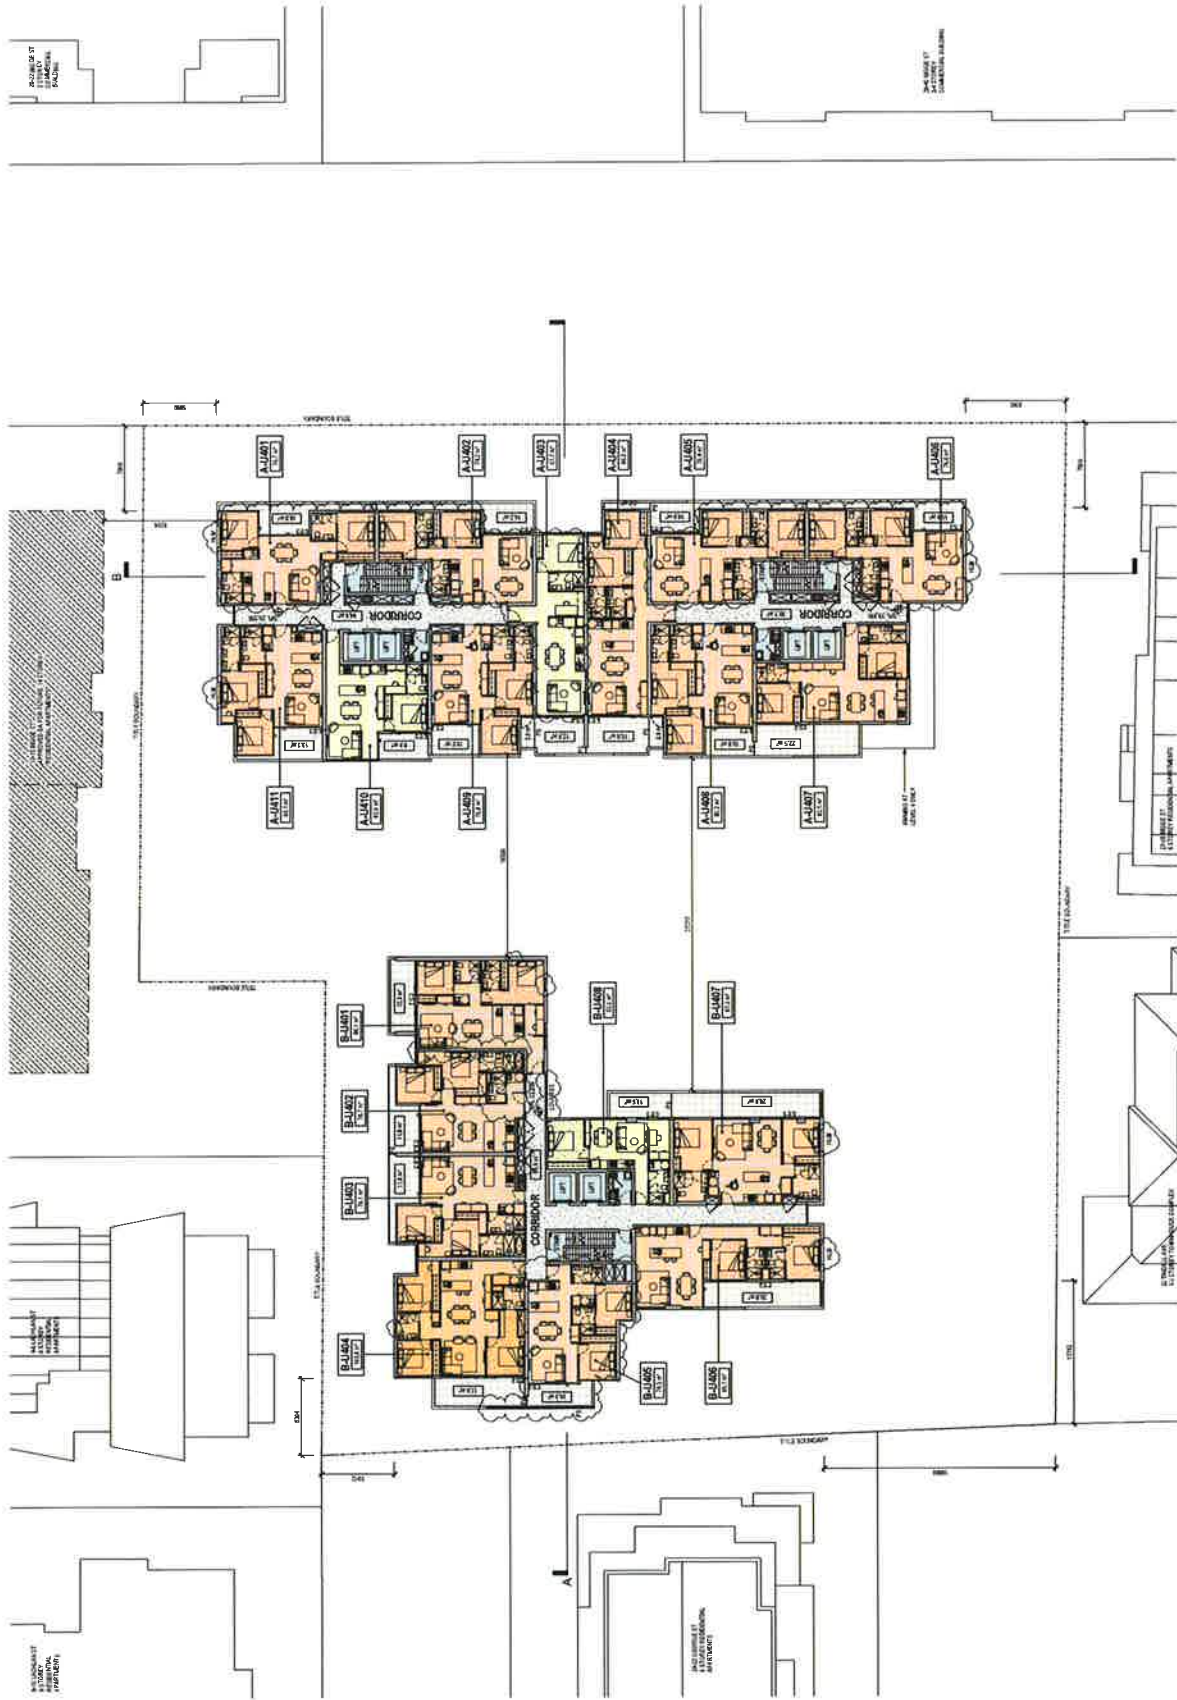

DEVELOPMENT APPLICATION

PROJECT NO: 2150002
 SCALE: 1:200
 DATE: 10/05/2017
 DRAWN BY: S. BOY
 CHECKED BY: S. BOY
 PROJECT: LIVERPOOL CENTRAL
 ADDRESS: 100-110 LIVERPOOL STREET, LIVERPOOL, L3 5AB


LEGEND

ABBREVIATIONS

PT: PUBLIC TOILET
 ST: STORE
 CL: CLOSET
 SH: SHOWER
 WC: W.C.
 UR: URINAL
 BI: BATH
 SI: SINK
 CU: CUPBOARD
 STOVE: STOVE
 REFR: REFRIGERATOR
 DISH: DISHWASHER
 FREEZ: FREEZER
 ICE: ICE BOX
 Fridge: FRIDGE
 WASH: WASHING MACHINE
 DRY: DRYER
 TV: TELEVISION
 RFR: REFRIGERATOR
 STOVE: STOVE
 DISH: DISHWASHER
 FREEZ: FREEZER
 ICE: ICE BOX
 Fridge: FRIDGE
 WASH: WASHING MACHINE
 DRY: DRYER
 TV: TELEVISION

NOTES

1. ALL ROOMS TO BE FINISHED TO THE STANDARD OF THE LIVERPOOL CENTRAL PROJECT.
 2. ALL ROOMS TO BE FINISHED TO THE STANDARD OF THE LIVERPOOL CENTRAL PROJECT.
 3. ALL ROOMS TO BE FINISHED TO THE STANDARD OF THE LIVERPOOL CENTRAL PROJECT.
 4. ALL ROOMS TO BE FINISHED TO THE STANDARD OF THE LIVERPOOL CENTRAL PROJECT.
 5. ALL ROOMS TO BE FINISHED TO THE STANDARD OF THE LIVERPOOL CENTRAL PROJECT.
 6. ALL ROOMS TO BE FINISHED TO THE STANDARD OF THE LIVERPOOL CENTRAL PROJECT.
 7. ALL ROOMS TO BE FINISHED TO THE STANDARD OF THE LIVERPOOL CENTRAL PROJECT.
 8. ALL ROOMS TO BE FINISHED TO THE STANDARD OF THE LIVERPOOL CENTRAL PROJECT.
 9. ALL ROOMS TO BE FINISHED TO THE STANDARD OF THE LIVERPOOL CENTRAL PROJECT.
 10. ALL ROOMS TO BE FINISHED TO THE STANDARD OF THE LIVERPOOL CENTRAL PROJECT.

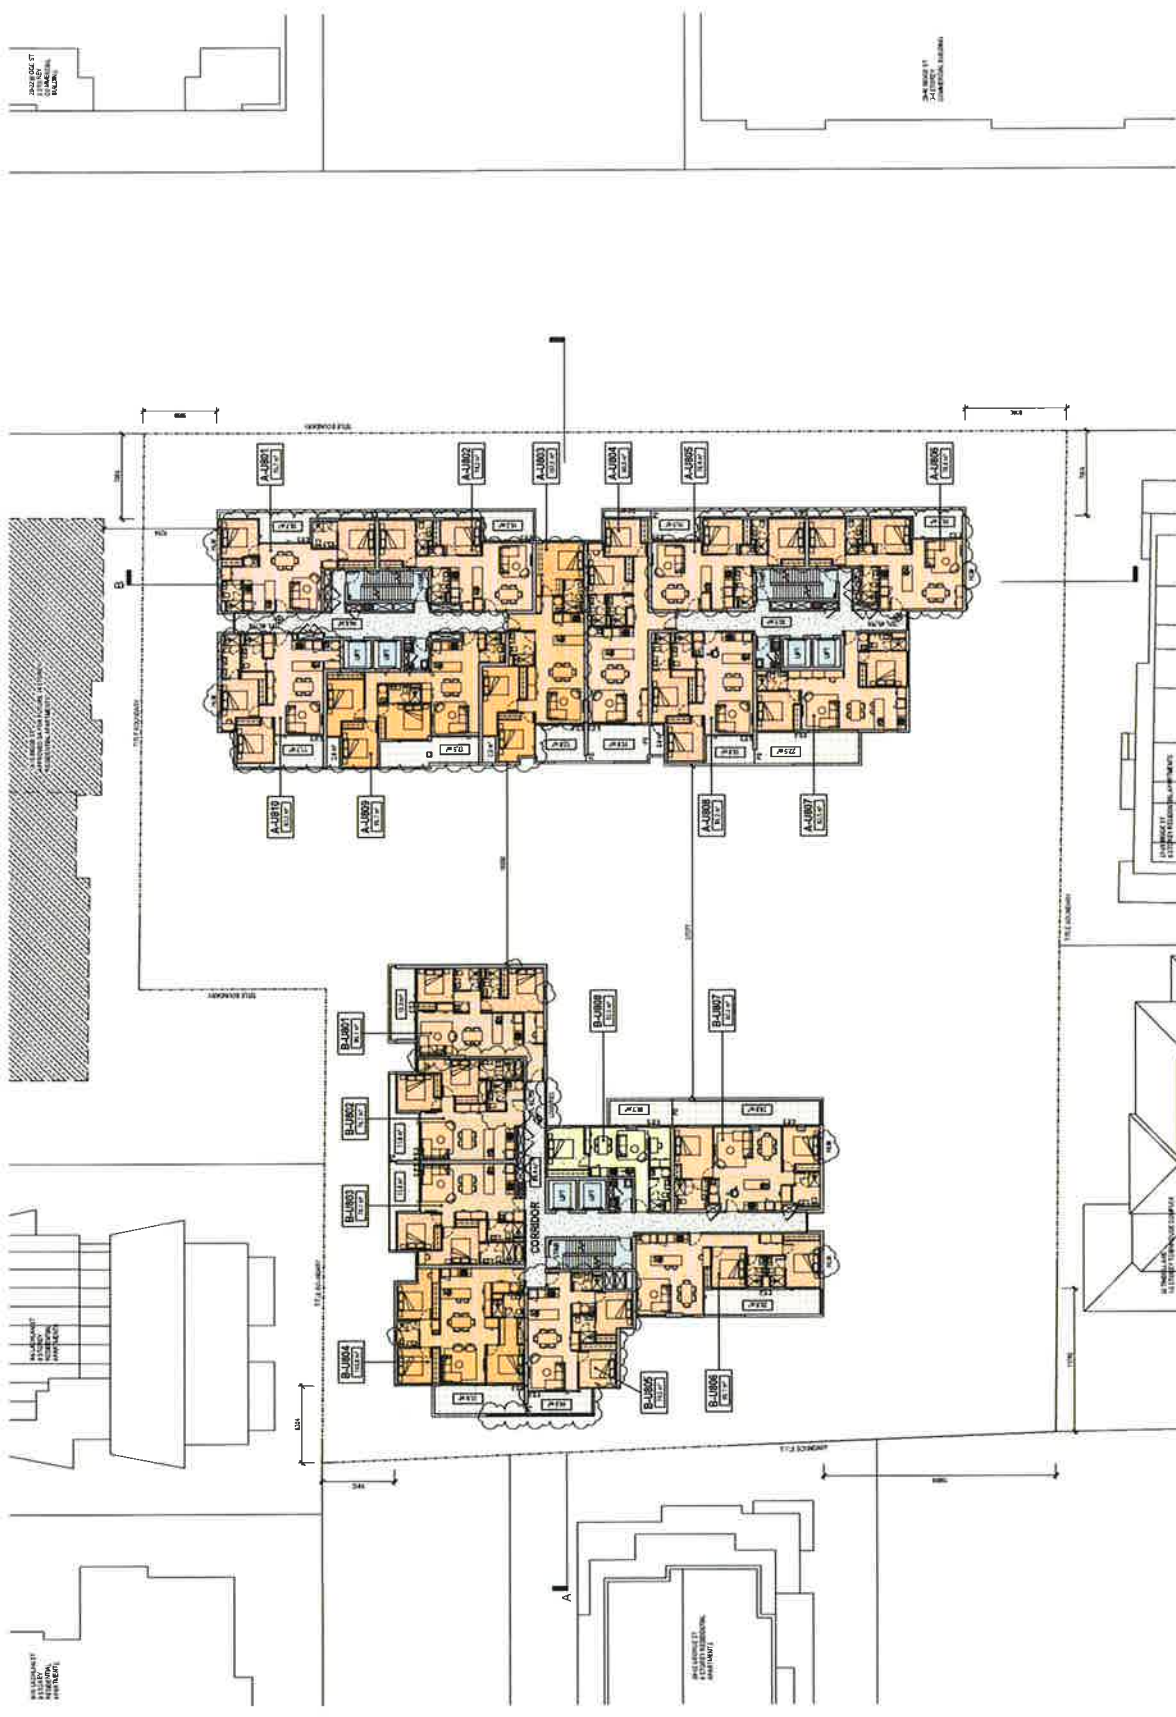

ACQUAINTANCE
ACQUAINTANCE PROPERTY LTD. 100% OF THE DEVELOPMENT

PROJECT TITLE
LIVERPOOL CENTRAL
UNIVERSITY OF LIVERPOOL

PROJECT NO.
2150002

SCALE
1 : 200

DATE
10/01/2023

DWG NO.
TP01.11

DEVELOPMENT APPLICATION


PROJECT NO.
2150002

SCALE
1 : 200

DATE
10/01/2023

DWG NO.
TP01.11

LEVELS 8-9

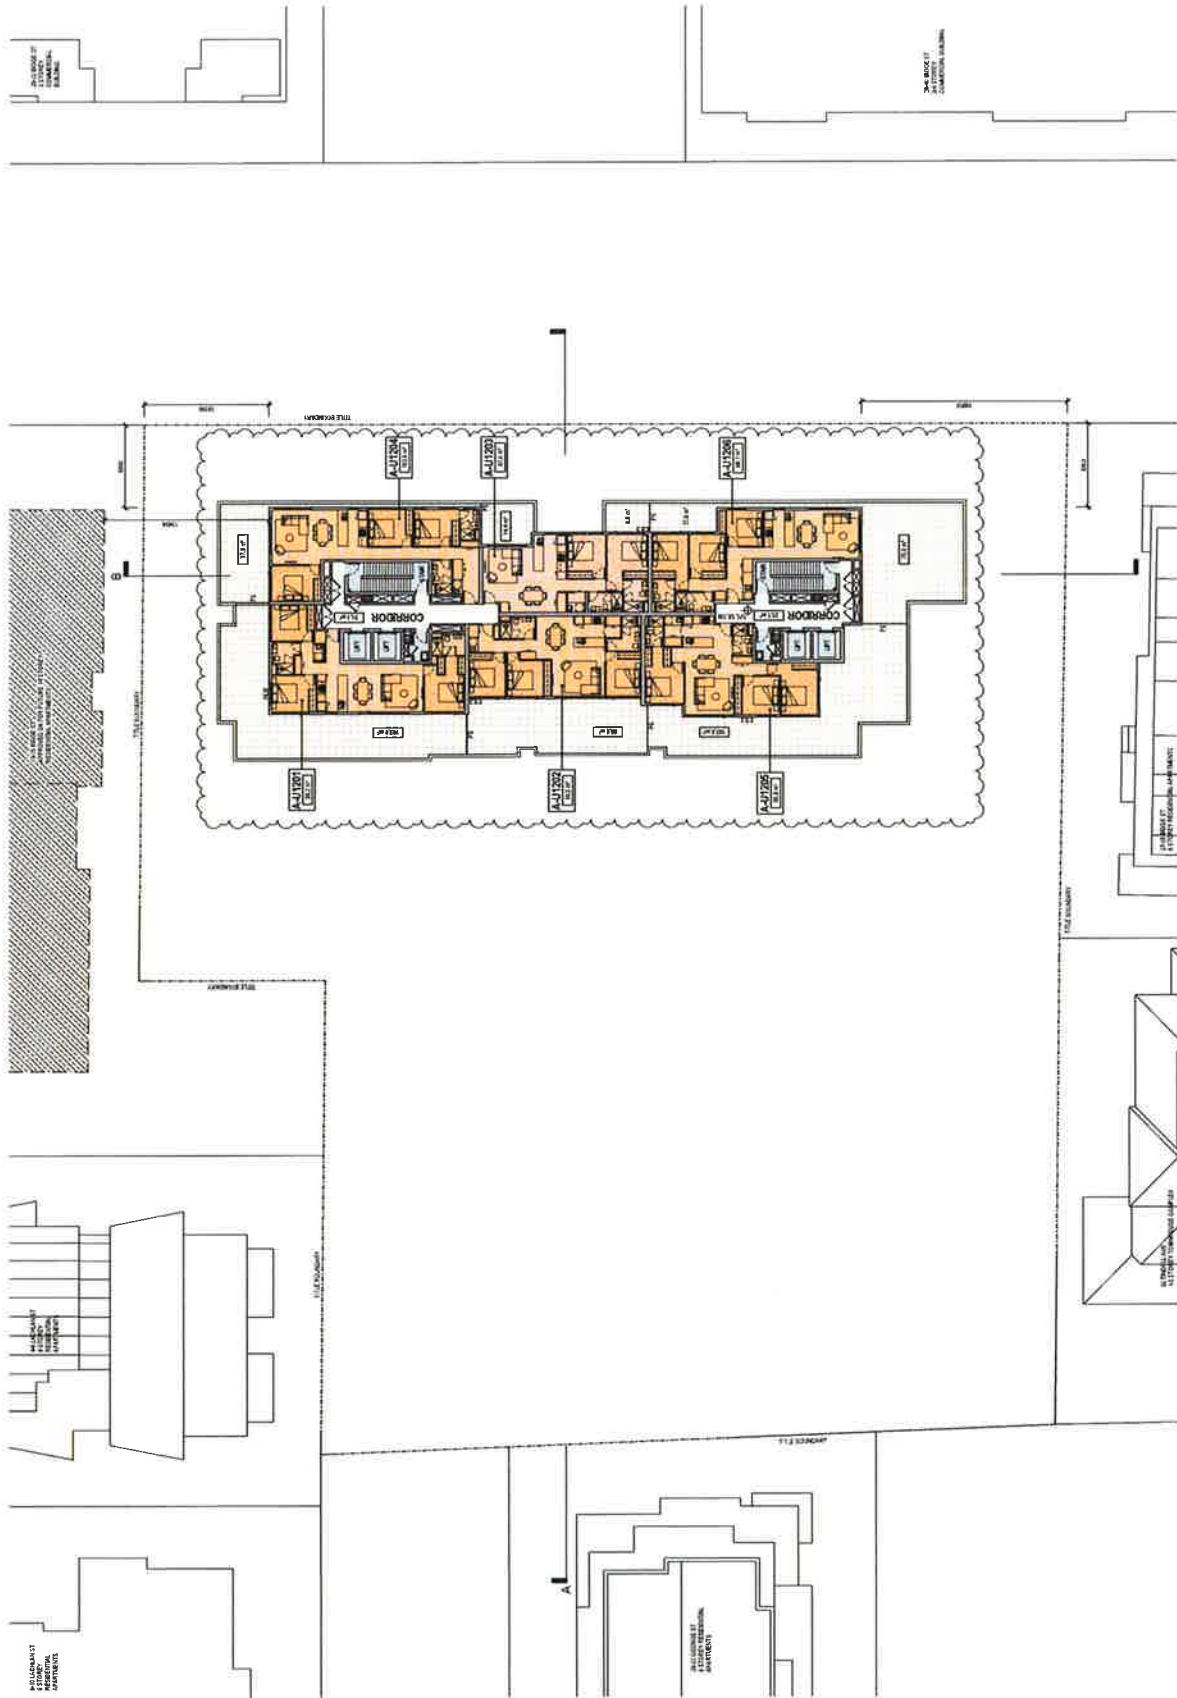

DEVELOPMENT APPLICATION

PROJECT NO: 215002
 SCALE: 1:200
 DATE: 1/07/16
 DRAWN BY: [Name]
 CHECKED BY: [Name]
 APPROVED BY: [Name]

PROJECT TITLE: LIVERPOOL CENTRAL

LEVEL 12


TP01.15

LEGEND

■ EXISTING WALLS
 ■ EXISTING DOORS
 ■ EXISTING WINDOWS
 ■ EXISTING FLOORS
 ■ EXISTING ROOFS
 ■ EXISTING LANDSCAPE
 ■ EXISTING UTILITIES
 ■ EXISTING SERVICES
 ■ EXISTING STRUCTURE
 ■ EXISTING MATERIALS
 ■ EXISTING FINISHES
 ■ EXISTING EQUIPMENT
 ■ EXISTING FURNITURE
 ■ EXISTING PLANT
 ■ EXISTING LIGHTING
 ■ EXISTING HEATING
 ■ EXISTING COOLING
 ■ EXISTING VENTILATION
 ■ EXISTING SOUNDING
 ■ EXISTING SECURITY
 ■ EXISTING ACCESSIBILITY
 ■ EXISTING SUSTAINABILITY
 ■ EXISTING RESILIENCE
 ■ EXISTING INCLUSIVITY
 ■ EXISTING WELLBEING
 ■ EXISTING COMMUNITY
 ■ EXISTING CULTURE
 ■ EXISTING HERITAGE
 ■ EXISTING IDENTITY
 ■ EXISTING CHARACTER
 ■ EXISTING QUALITY
 ■ EXISTING BEAUTY
 ■ EXISTING ENJOYMENT
 ■ EXISTING MEANING
 ■ EXISTING CONNECTION
 ■ EXISTING BELONGING
 ■ EXISTING HOPE
 ■ EXISTING DREAMS
 ■ EXISTING VISIONS
 ■ EXISTING ASPIRATIONS
 ■ EXISTING POTENTIAL
 ■ EXISTING OPPORTUNITIES
 ■ EXISTING CHALLENGES
 ■ EXISTING RISKS
 ■ EXISTING THREATS
 ■ EXISTING OPPORTUNITIES
 ■ EXISTING CHALLENGES
 ■ EXISTING RISKS
 ■ EXISTING THREATS

ABBREVIATIONS

■ EXISTING WALLS
 ■ EXISTING DOORS
 ■ EXISTING WINDOWS
 ■ EXISTING FLOORS
 ■ EXISTING ROOFS
 ■ EXISTING LANDSCAPE
 ■ EXISTING UTILITIES
 ■ EXISTING SERVICES
 ■ EXISTING STRUCTURE
 ■ EXISTING MATERIALS
 ■ EXISTING FINISHES
 ■ EXISTING EQUIPMENT
 ■ EXISTING FURNITURE
 ■ EXISTING PLANT
 ■ EXISTING LIGHTING
 ■ EXISTING HEATING
 ■ EXISTING COOLING
 ■ EXISTING VENTILATION
 ■ EXISTING SOUNDING
 ■ EXISTING SECURITY
 ■ EXISTING ACCESSIBILITY
 ■ EXISTING SUSTAINABILITY
 ■ EXISTING RESILIENCE
 ■ EXISTING INCLUSIVITY
 ■ EXISTING WELLBEING
 ■ EXISTING COMMUNITY
 ■ EXISTING CULTURE
 ■ EXISTING HERITAGE
 ■ EXISTING IDENTITY
 ■ EXISTING CHARACTER
 ■ EXISTING QUALITY
 ■ EXISTING BEAUTY
 ■ EXISTING ENJOYMENT
 ■ EXISTING MEANING
 ■ EXISTING CONNECTION
 ■ EXISTING BELONGING
 ■ EXISTING HOPE
 ■ EXISTING DREAMS
 ■ EXISTING VISIONS
 ■ EXISTING ASPIRATIONS
 ■ EXISTING POTENTIAL
 ■ EXISTING OPPORTUNITIES
 ■ EXISTING CHALLENGES
 ■ EXISTING RISKS
 ■ EXISTING THREATS
 ■ EXISTING OPPORTUNITIES
 ■ EXISTING CHALLENGES
 ■ EXISTING RISKS
 ■ EXISTING THREATS

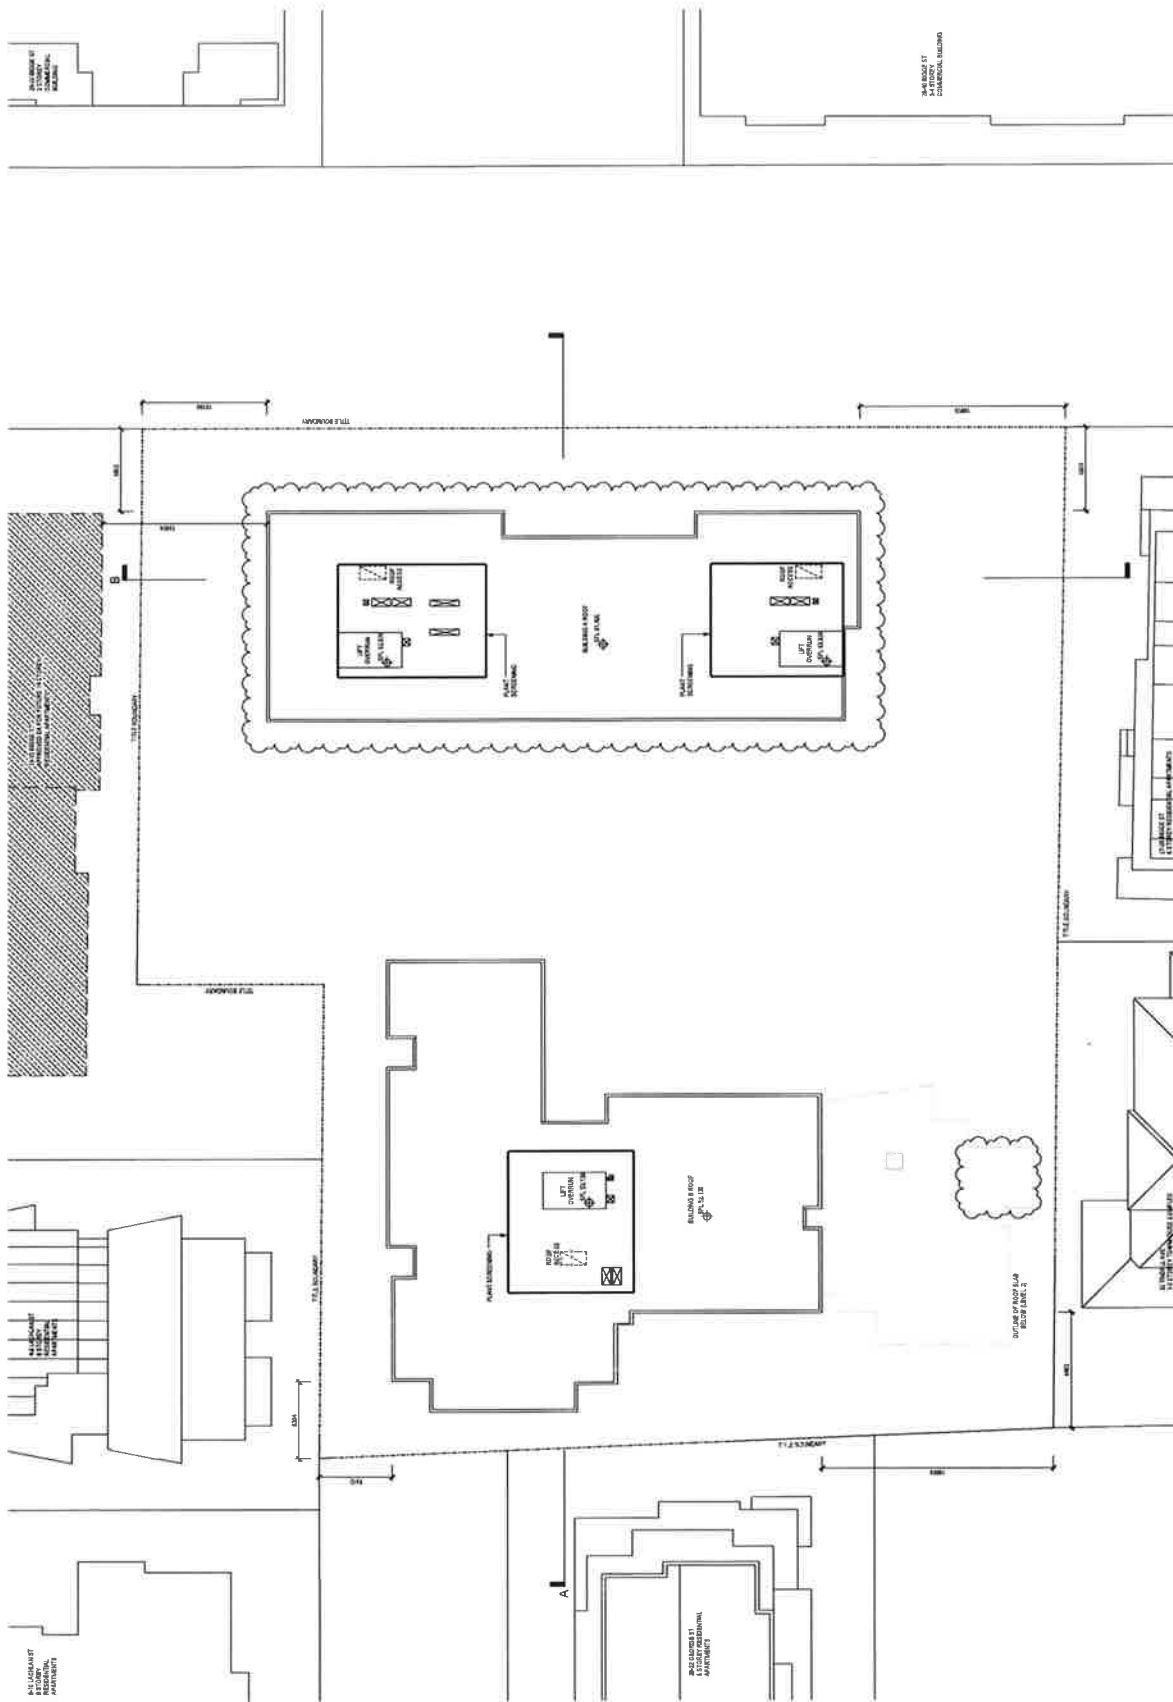

DEVELOPMENT APPLICATION

PROJECT

PROJECT NO. 215002

PROJECT NAME LIVERPOOL CENTRAL

PROJECT ADDRESS 100-102, 104-106, 108-110, 4648-4650, 4652-465



DEVELOPMENT APPLICATION

PROJECT No. 215002
 DATE: 21/01/2021
 DRAWN BY: [Name]
 CHECKED BY: [Name]
 SCALE: 1:100
 SHEET No. 1/1

PROJECT INFO

PROJECT No. 215002
 DATE: 21/01/2021
 DRAWN BY: [Name]
 CHECKED BY: [Name]
 SCALE: 1:100
 SHEET No. 1/1

PROJECT INFO

PROJECT No. 215002
 DATE: 21/01/2021
 DRAWN BY: [Name]
 CHECKED BY: [Name]
 SCALE: 1:100
 SHEET No. 1/1

PROJECT INFO

PROJECT No. 215002
 DATE: 21/01/2021
 DRAWN BY: [Name]
 CHECKED BY: [Name]
 SCALE: 1:100
 SHEET No. 1/1

PROJECT INFO

PROJECT No. 215002
 DATE: 21/01/2021
 DRAWN BY: [Name]
 CHECKED BY: [Name]
 SCALE: 1:100
 SHEET No. 1/1

PROJECT INFO

PROJECT No. 215002
 DATE: 21/01/2021
 DRAWN BY: [Name]
 CHECKED BY: [Name]
 SCALE: 1:100
 SHEET No. 1/1



FINISHES LEGEND
APPLY TO MATERIALS SELECTIONS FOR COLOURS

(LPI)	APPLIED FINISH TYPE 1
(PI)	INTERIOR PLANT TYPE 1
(OTD)	GLASSING TYPE 1
(MD)	METAL FINISH TYPE 1

No.	Date	Page no.	Pr.
1	22/11/16		100
2	23/11/16		100

PROJECT TITLE
LIVERPOOL CENTRAL
17-25 BLAKE STREET
LIVERPOOL, NEW ZEALAND

DRAWING TITLE

ELEVATION - SOUTH BUILDING A


SCALE: A1
1:100

LEVEL 2/171 WILLIAM STREET
SYDNEY NSW 2010
AUSTRALIA

DEVELOPMENT APPLICATION

TP02.02 | A



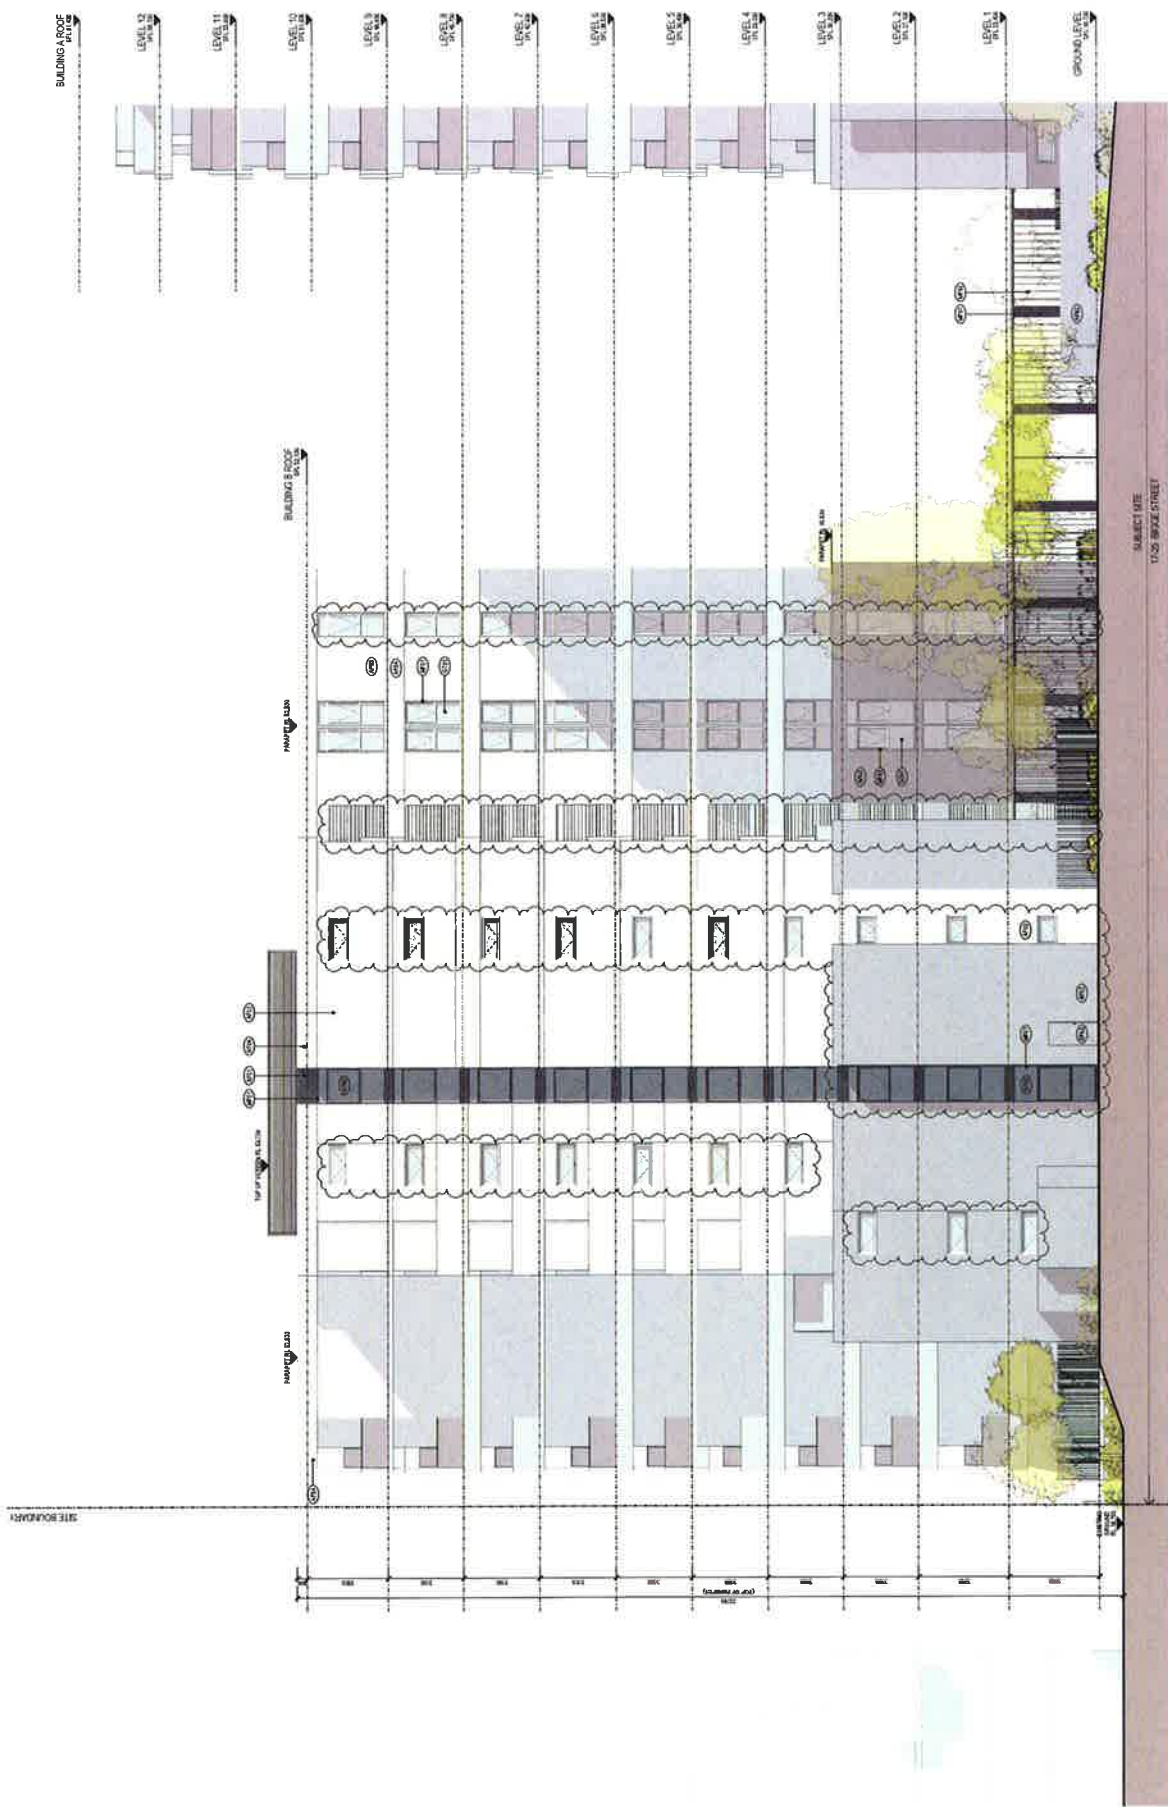

DEVELOPMENT APPLICATION

PROJECT No: 215002
 SCALE: 1:100
 DATE: 10/01/2023
 DRAWN BY: [Name]
 CHECKED BY: [Name]
 APPROVED BY: [Name]

PROJECT TITLE
 LIVERPOOL CENTRAL
 LIVERPOOL CENTRAL
 LIVERPOOL CENTRAL

ENVIRONMENTAL TITLE
 ELEVATION - SOUTH BUILDING B
 TP02.03.1A

PROJECT LOCATION
 100 BOXER STREET, LIVERPOOL
 LIVERPOOL, NSW 2150
 PROJECT NO: 215002

PROJECT TYPE
 RECONSTRUCTION
 RECONSTRUCTION
 RECONSTRUCTION


PROJECT DESCRIPTION
 RECONSTRUCTION OF SOUTH BUILDING B
 RECONSTRUCTION OF SOUTH BUILDING B
 RECONSTRUCTION OF SOUTH BUILDING B

PROJECT TYPE
 RECONSTRUCTION
 RECONSTRUCTION
 RECONSTRUCTION

PROJECT LOCATION
 100 BOXER STREET, LIVERPOOL
 LIVERPOOL, NSW 2150
 PROJECT NO: 215002

PROJECT TYPE
 RECONSTRUCTION
 RECONSTRUCTION
 RECONSTRUCTION

NOTES:
 1. THIS DOCUMENT IS THE PROPERTY OF [FIRM NAME] AND IS NOT TO BE REPRODUCED OR TRANSMITTED IN ANY FORM OR BY ANY MEANS, ELECTRONIC OR MECHANICAL, INCLUDING PHOTOCOPYING, RECORDING, OR BY ANY INFORMATION STORAGE AND RETRIEVAL SYSTEM, WITHOUT THE WRITTEN PERMISSION OF [FIRM NAME].
 2. THE INFORMATION CONTAINED HEREIN IS FOR INFORMATION ONLY AND DOES NOT CONSTITUTE A CONTRACT OR A GUARANTEE OF ANY KIND.
 3. THE INFORMATION CONTAINED HEREIN IS FOR INFORMATION ONLY AND DOES NOT CONSTITUTE A CONTRACT OR A GUARANTEE OF ANY KIND.
 4. THE INFORMATION CONTAINED HEREIN IS FOR INFORMATION ONLY AND DOES NOT CONSTITUTE A CONTRACT OR A GUARANTEE OF ANY KIND.
 5. THE INFORMATION CONTAINED HEREIN IS FOR INFORMATION ONLY AND DOES NOT CONSTITUTE A CONTRACT OR A GUARANTEE OF ANY KIND.

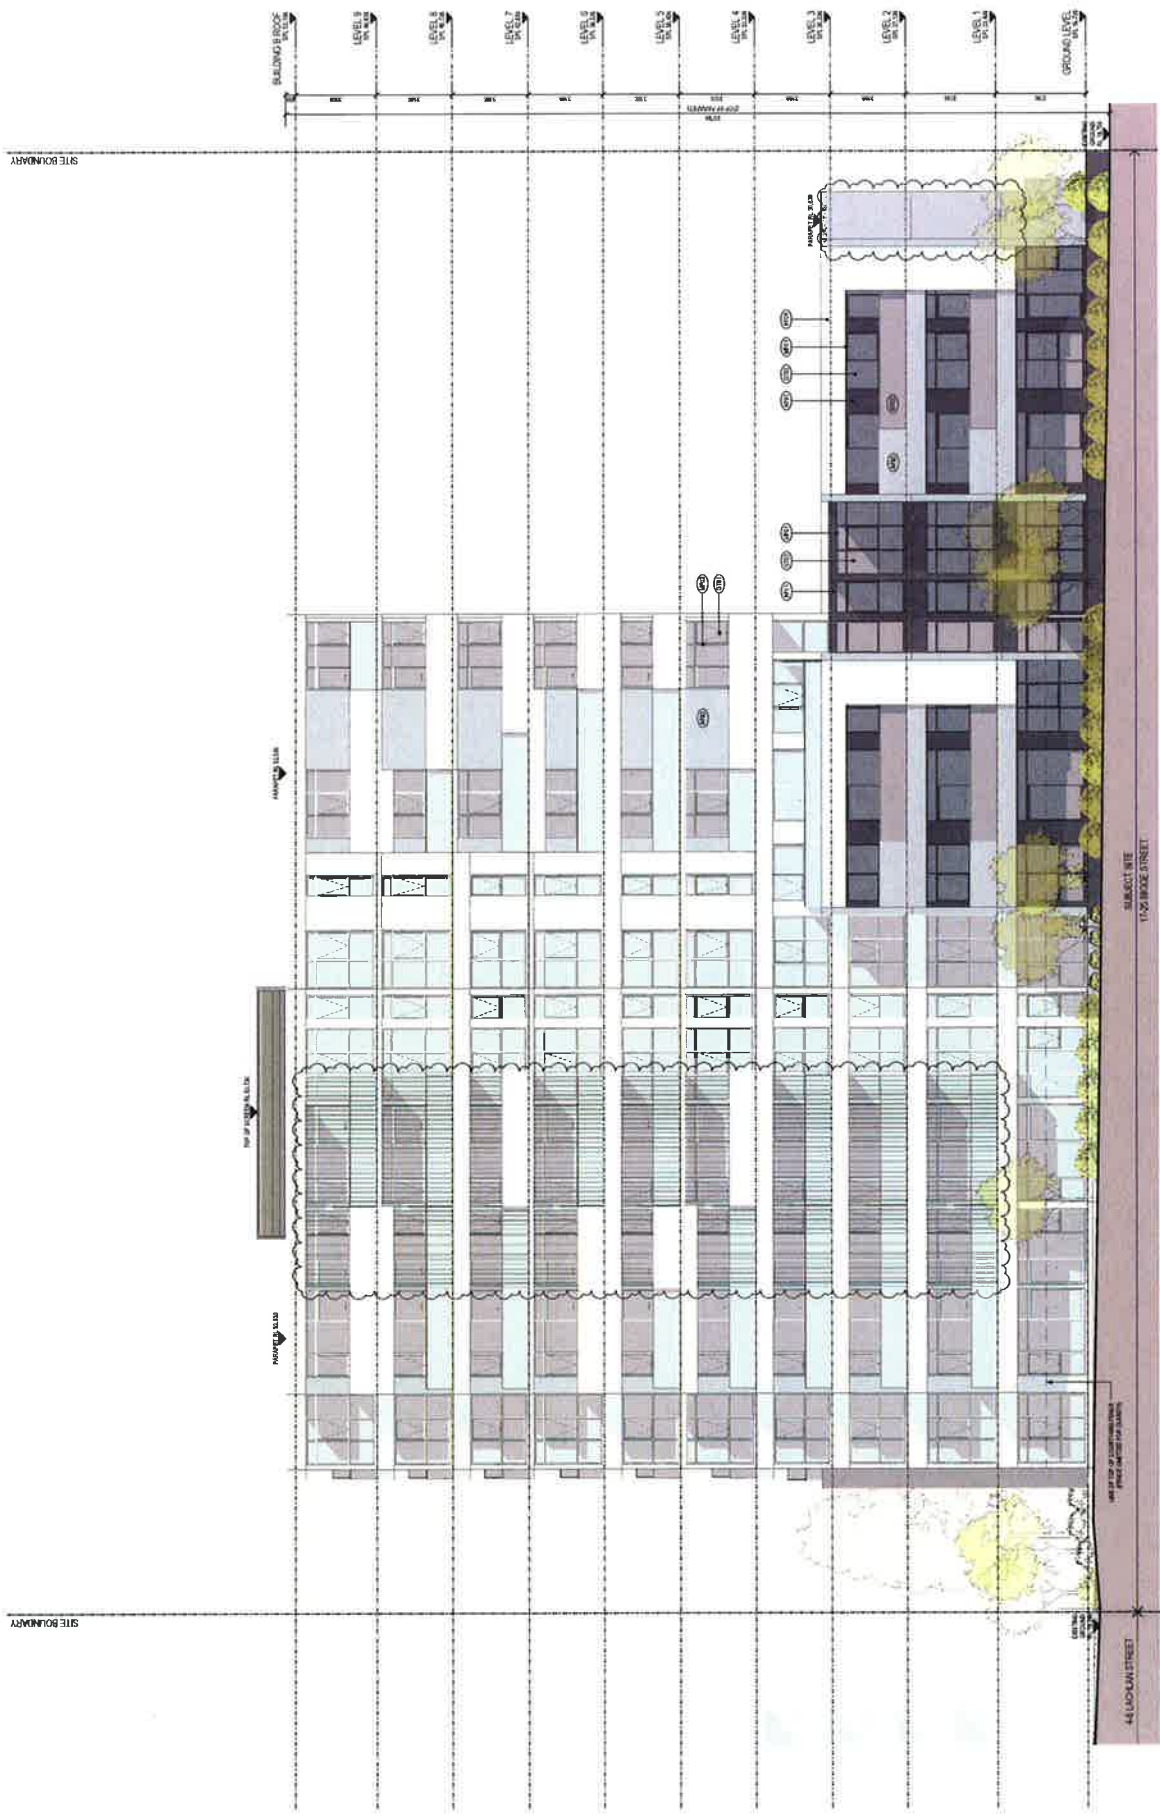

DEVELOPMENT APPLICATION

PROJECT TITLE: **LIVERPOOL CENTRAL**
 PROJECT NO: **2150002**
 DRAWING TITLE: **ELEVATION - WEST**

SCALE: **1:100**

DATE: **10/10/2021**

DRAWN BY: **TP02.04 / A**

PROJECT NO: **2150002**

PROJECT TITLE: **LIVERPOOL CENTRAL**

PROJECT NO: **2150002**

PROJECT TITLE: **LIVERPOOL CENTRAL**

NOTES:

1. ALL DIMENSIONS ARE IN METERS.

2. ALL DIMENSIONS ARE TO FACE UNLESS OTHERWISE SPECIFIED.

3. ALL DIMENSIONS ARE TO FACE UNLESS OTHERWISE SPECIFIED.

4. ALL DIMENSIONS ARE TO FACE UNLESS OTHERWISE SPECIFIED.

5. ALL DIMENSIONS ARE TO FACE UNLESS OTHERWISE SPECIFIED.

LEGEND:

W1: WINDOW TYPE 1

W2: WINDOW TYPE 2

W3: WINDOW TYPE 3

W100: WINDOW TYPE 100

REVISIONS:

 
1. ALL DIMENSIONS ARE IN METERS.

2. ALL DIMENSIONS ARE TO FACE UNLESS OTHERWISE SPECIFIED.

3. ALL DIMENSIONS ARE TO FACE UNLESS OTHERWISE SPECIFIED.

4. ALL DIMENSIONS ARE TO FACE UNLESS OTHERWISE SPECIFIED.

5. ALL DIMENSIONS ARE TO FACE UNLESS OTHERWISE SPECIFIED.



Page No.	Date	Page No.
1	20/05/20	1
2	21/05/20	2
3	22/05/20	3
4	23/05/20	4
5	24/05/20	5
6	25/05/20	6
7	26/05/20	7
8	27/05/20	8
9	28/05/20	9
10	29/05/20	10
11	30/05/20	11
12	31/05/20	12
13	01/06/20	13
14	02/06/20	14
15	03/06/20	15
16	04/06/20	16
17	05/06/20	17
18	06/06/20	18
19	07/06/20	19
20	08/06/20	20
21	09/06/20	21
22	10/06/20	22
23	11/06/20	23
24	12/06/20	24
25	13/06/20	25
26	14/06/20	26
27	15/06/20	27
28	16/06/20	28
29	17/06/20	29
30	18/06/20	30
31	19/06/20	31
32	20/06/20	32
33	21/06/20	33
34	22/06/20	34
35	23/06/20	35
36	24/06/20	36
37	25/06/20	37
38	26/06/20	38
39	27/06/20	39
40	28/06/20	40
41	29/06/20	41
42	30/06/20	42
43	01/07/20	43
44	02/07/20	44
45	03/07/20	45
46	04/07/20	46
47	05/07/20	47
48	06/07/20	48
49	07/07/20	49
50	08/07/20	50
51	09/07/20	51
52	10/07/20	52
53	11/07/20	53
54	12/07/20	54
55	13/07/20	55
56	14/07/20	56
57	15/07/20	57
58	16/07/20	58
59	17/07/20	59
60	18/07/20	60
61	19/07/20	61
62	20/07/20	62
63	21/07/20	63
64	22/07/20	64
65	23/07/20	65
66	24/07/20	66
67	25/07/20	67
68	26/07/20	68
69	27/07/20	69
70	28/07/20	70
71	29/07/20	71
72	30/07/20	72
73	31/07/20	73
74	01/08/20	74
75	02/08/20	75
76	03/08/20	76
77	04/08/20	77
78	05/08/20	78
79	06/08/20	79
80	07/08/20	80
81	08/08/20	81
82	09/08/20	82
83	10/08/20	83
84	11/08/20	84
85	12/08/20	85
86	13/08/20	86
87	14/08/20	87
88	15/08/20	88
89	16/08/20	89
90	17/08/20	90
91	18/08/20	91
92	19/08/20	92
93	20/08/20	93
94	21/08/20	94
95	22/08/20	95
96	23/08/20	96
97	24/08/20	97
98	25/08/20	98
99	26/08/20	99
100	27/08/20	100
101	28/08/20	101
102	29/08/20	102
103	30/08/20	103
104	31/08/20	104
105	01/09/20	105
106	02/09/20	106
107	03/09/20	107
108	04/09/20	108
109	05/09/20	109
110	06	

SCALE: 1:100
DATE: 6/20/18
DRAWN BY: KRW
DWG NO.: 18-001
PROJECT NO.: 215002
TP02.05 1A

DEVELOPMENT APPLICATION



DEVELOPMENT APPLICATION

PROJECT: LIVERPOOL CENTRAL
 11-25 BRIDGE STREET
 LIVERPOOL, L3 1 2R

SCALE: 1:100

DWG NO: TP02.06 1A

DATE: 10/10/2023

DESIGNER: ROUTE LIVERMAN

PROJECT TITLE: LIVERPOOL CENTRAL
 11-25 BRIDGE STREET
 LIVERPOOL, L3 1 2R

SCALE: 1:100

DWG NO: TP02.06 1A

DATE: 10/10/2023

DESIGNER: ROUTE LIVERMAN

REVISIONS:

NO.	DATE	DESCRIPTION
1	10/10/2023	ISSUED FOR PERMIT

NOTES:

1. ALL MATERIALS SHALL BE AS SHOWN ON THE DRAWINGS.

2. ALL WORK SHALL BE IN ACCORDANCE WITH THE BUILDING REGULATIONS.

3. ALL WORK SHALL BE IN ACCORDANCE WITH THE PLANNING ACT.

4. ALL WORK SHALL BE IN ACCORDANCE WITH THE ENVIRONMENTAL ACT.

5. ALL WORK SHALL BE IN ACCORDANCE WITH THE WASTE MANAGEMENT ACT.

6. ALL WORK SHALL BE IN ACCORDANCE WITH THE WATER ACT.

7. ALL WORK SHALL BE IN ACCORDANCE WITH THE AIR ACT.

8. ALL WORK SHALL BE IN ACCORDANCE WITH THE CLIMATE ACT.

9. ALL WORK SHALL BE IN ACCORDANCE WITH THE ENERGY ACT.

10. ALL WORK SHALL BE IN ACCORDANCE WITH THE TRANSPORT ACT.

11. ALL WORK SHALL BE IN ACCORDANCE WITH THE COMMUNICATIONS ACT.

12. ALL WORK SHALL BE IN ACCORDANCE WITH THE DEFENCE ACT.

13. ALL WORK SHALL BE IN ACCORDANCE WITH THE EDUCATION ACT.

14. ALL WORK SHALL BE IN ACCORDANCE WITH THE HEALTH ACT.

15. ALL WORK SHALL BE IN ACCORDANCE WITH THE JUSTICE ACT.

16. ALL WORK SHALL BE IN ACCORDANCE WITH THE LABOUR ACT.

17. ALL WORK SHALL BE IN ACCORDANCE WITH THE LEISURE ACT.

18. ALL WORK SHALL BE IN ACCORDANCE WITH THE LOCAL GOVERNMENT ACT.

19. ALL WORK SHALL BE IN ACCORDANCE WITH THE NATIONAL GOVERNMENT ACT.

20. ALL WORK SHALL BE IN ACCORDANCE WITH THE REGIONAL GOVERNMENT ACT.

21. ALL WORK SHALL BE IN ACCORDANCE WITH THE UNITED KINGDOM ACT.

TOP OF FINISH FLOOR

TOP OF FINISH FLOOR




DEVELOPMENT APPLICATION			
PROJECT No.	2150002	SCALE	1 : 100
PROJECT NAME	LIVERPOOL CENTRAL	DATE	11/05/2021
PROJECT ADDRESS	100-110 QUEEN STREET, SYDNEY NSW 2000	DRAWN BY	GP
PROJECT TYPE	RENOVATION - COURTYARD BUILDING A	CHECKED BY	GP
PROJECT NO.	TP02.07 1A	DATE	11/05/2021

REVISIONS	
NO.	DESCRIPTION
1	ISSUED FOR PERMIT
2	ISSUED FOR PERMIT
3	ISSUED FOR PERMIT
4	ISSUED FOR PERMIT

LEGEND	
(S)	APPLIED FINISH TYPE 1
(D)	APPLIED FINISH TYPE 2
(G)	APPLIED FINISH TYPE 3
(B)	APPLIED FINISH TYPE 4
(P)	APPLIED FINISH TYPE 5

NOTES:
1. ALL DIMENSIONS ARE IN METRES.
2. ALL DIMENSIONS ARE TO FACE UNLESS OTHERWISE SPECIFIED.
3. ALL DIMENSIONS ARE TO FACE UNLESS OTHERWISE SPECIFIED.
4. ALL DIMENSIONS ARE TO FACE UNLESS OTHERWISE SPECIFIED.
5. ALL DIMENSIONS ARE TO FACE UNLESS OTHERWISE SPECIFIED.
6. ALL DIMENSIONS ARE TO FACE UNLESS OTHERWISE SPECIFIED.
7. ALL DIMENSIONS ARE TO FACE UNLESS OTHERWISE SPECIFIED.
8. ALL DIMENSIONS ARE TO FACE UNLESS OTHERWISE SPECIFIED.
9. ALL DIMENSIONS ARE TO FACE UNLESS OTHERWISE SPECIFIED.
10. ALL DIMENSIONS ARE TO FACE UNLESS OTHERWISE SPECIFIED.

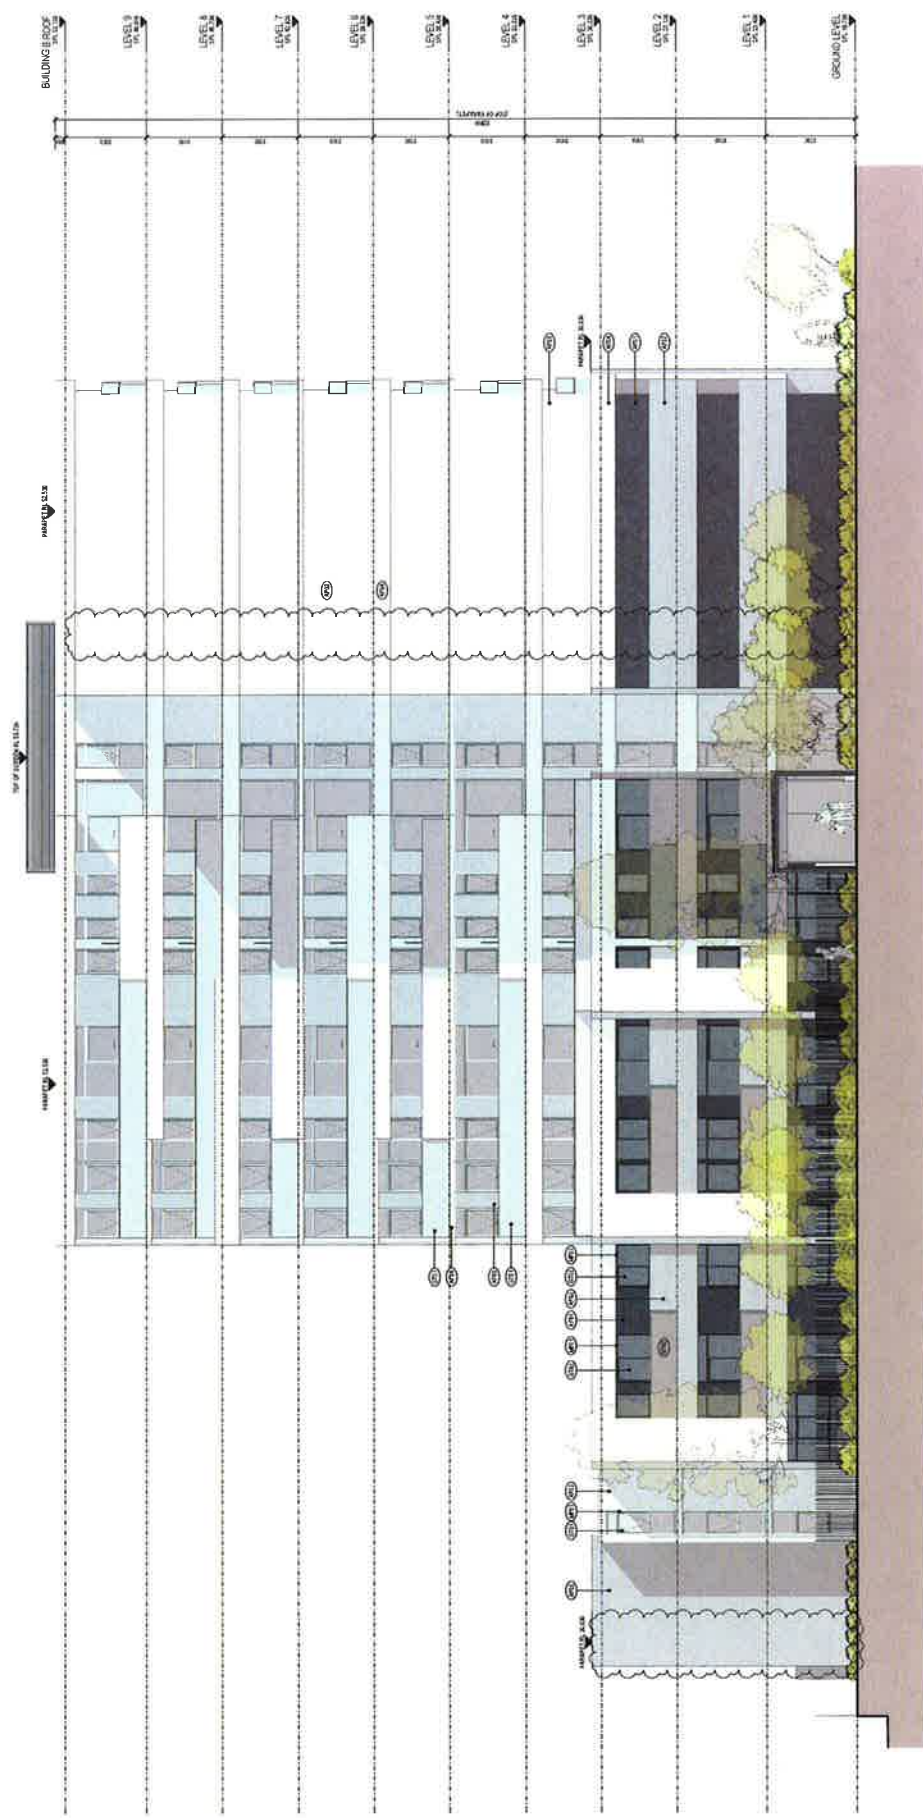

DEVELOPMENT APPLICATION

PROJECT: LIVERPOOL CENTRAL
 PROJECT NO: 215002
 DRAWING: ELEVATION - COURTYARD
 BUILDING B

SCALE: 1:100

DATE: 10/01/2023

TP02.08.1A

PROJECT TEAM


ARCHITECT: [Faint text]
 ENGINEER: [Faint text]
 LANDSCAPE ARCHITECT: [Faint text]





LEGEND

1. REFLECTIVE GLASS
 2. GLAZED BALCONY
 3. GLAZED BALCONY
 4. GLAZED BALCONY
 5. GLAZED BALCONY
 6. GLAZED BALCONY
 7. GLAZED BALCONY
 8. GLAZED BALCONY
 9. GLAZED BALCONY
 10. GLAZED BALCONY

NOTES

1. REFLECTIVE GLASS
 2. GLAZED BALCONY
 3. GLAZED BALCONY
 4. GLAZED BALCONY
 5. GLAZED BALCONY
 6. GLAZED BALCONY
 7. GLAZED BALCONY
 8. GLAZED BALCONY
 9. GLAZED BALCONY
 10. GLAZED BALCONY

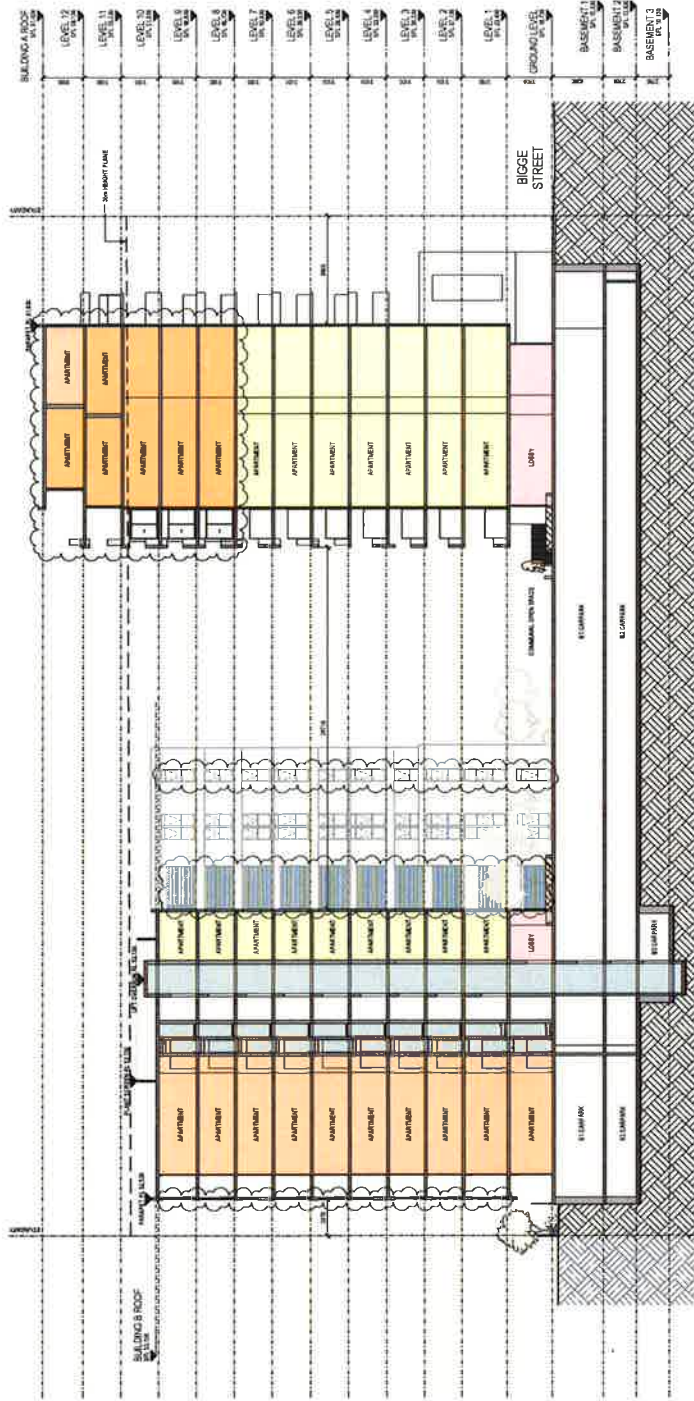

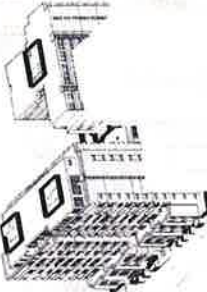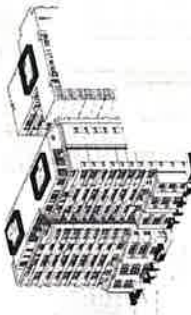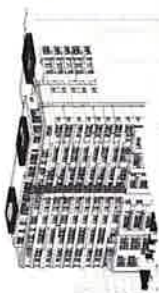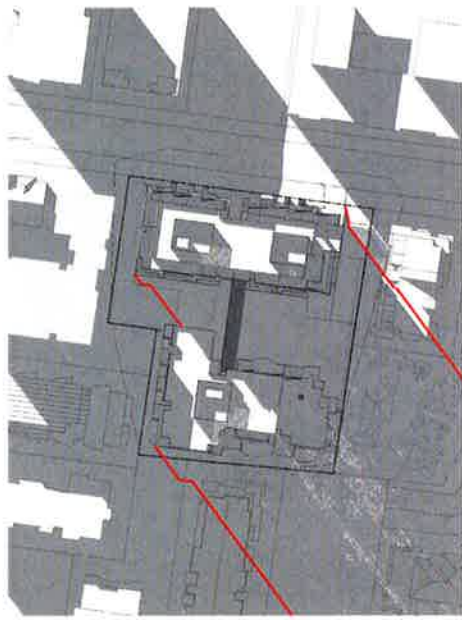






1 SUN VIEW - SHADOW 0800
SCALE

2 SUN VIEW - SHADOW 0900
SCALE

3 SUN VIEW - SHADOW 1000
SCALE

NOTES:
1. SHADOWS ARE CAST FROM THE SUN'S POSITION AT THE TIME OF THE PHOTOGRAPH.
2. SHADOWS ARE CAST FROM THE SUN'S POSITION AT THE TIME OF THE PHOTOGRAPH.
3. SHADOWS ARE CAST FROM THE SUN'S POSITION AT THE TIME OF THE PHOTOGRAPH.
4. SHADOWS ARE CAST FROM THE SUN'S POSITION AT THE TIME OF THE PHOTOGRAPH.
5. SHADOWS ARE CAST FROM THE SUN'S POSITION AT THE TIME OF THE PHOTOGRAPH.
6. SHADOWS ARE CAST FROM THE SUN'S POSITION AT THE TIME OF THE PHOTOGRAPH.
7. SHADOWS ARE CAST FROM THE SUN'S POSITION AT THE TIME OF THE PHOTOGRAPH.
8. SHADOWS ARE CAST FROM THE SUN'S POSITION AT THE TIME OF THE PHOTOGRAPH.
9. SHADOWS ARE CAST FROM THE SUN'S POSITION AT THE TIME OF THE PHOTOGRAPH.
10. SHADOWS ARE CAST FROM THE SUN'S POSITION AT THE TIME OF THE PHOTOGRAPH.

DEVELOPMENT APPLICATION	
PROJECT No	215002
PROJECT TITLE	LIVERPOOL CENTRAL
PROJECT ADDRESS	100-110, 112-114, 116-118, 120-122, 4412-4414, 441

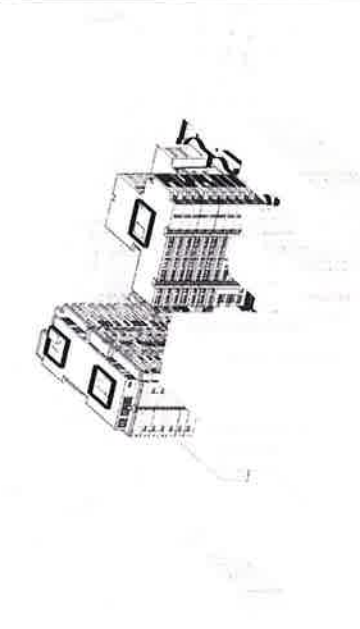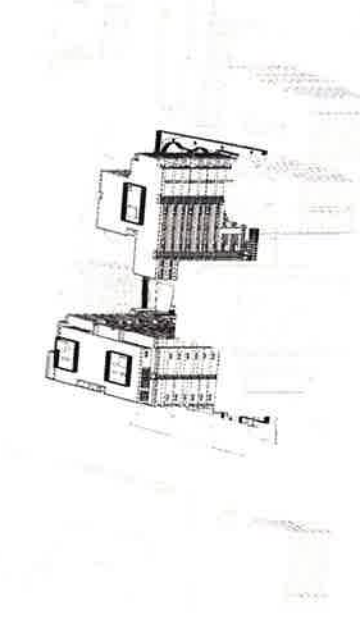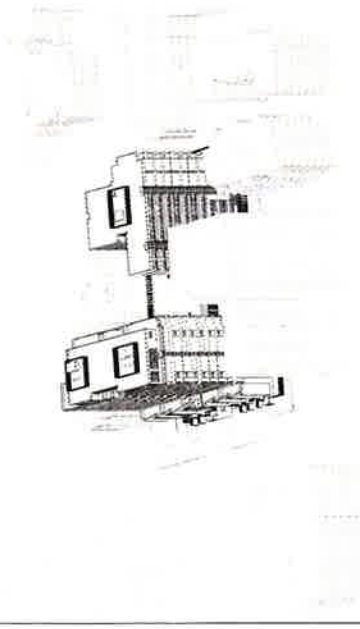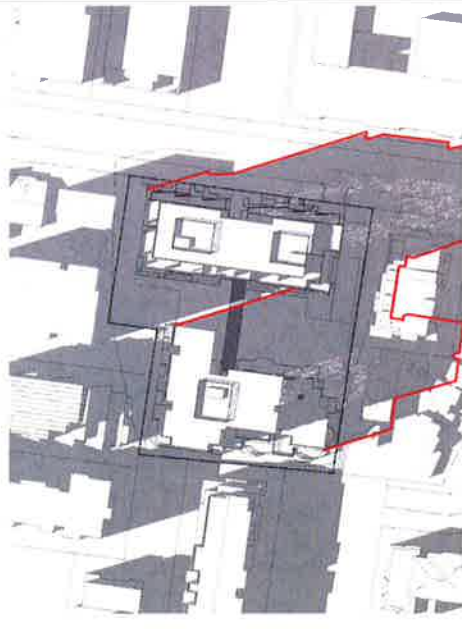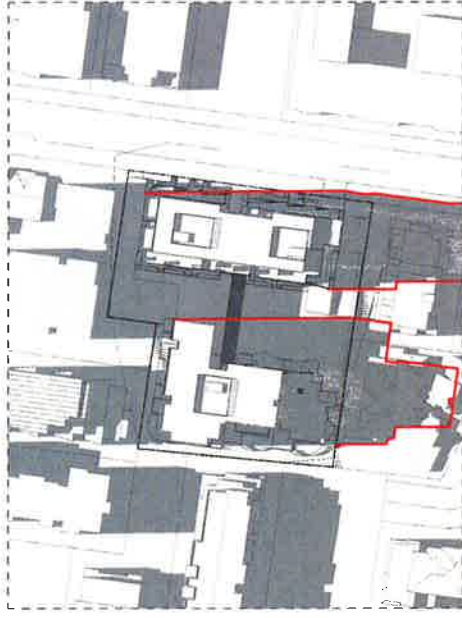


1 SUN VIEW - SHADOW 1100
SCALE

2 SUN VIEW - SHADOW 1200
SCALE

3 SUN VIEW - SHADOW 1300
SCALE

NOTES:
1. ALL DIMENSIONS ARE IN METERS.
2. ALL DIMENSIONS ARE TO FACE UNLESS OTHERWISE SPECIFIED.
3. ALL DIMENSIONS ARE TO FACE UNLESS OTHERWISE SPECIFIED.
4. ALL DIMENSIONS ARE TO FACE UNLESS OTHERWISE SPECIFIED.
5. ALL DIMENSIONS ARE TO FACE UNLESS OTHERWISE SPECIFIED.
6. ALL DIMENSIONS ARE TO FACE UNLESS OTHERWISE SPECIFIED.
7. ALL DIMENSIONS ARE TO FACE UNLESS OTHERWISE SPECIFIED.
8. ALL DIMENSIONS ARE TO FACE UNLESS OTHERWISE SPECIFIED.
9. ALL DIMENSIONS ARE TO FACE UNLESS OTHERWISE SPECIFIED.
10. ALL DIMENSIONS ARE TO FACE UNLESS OTHERWISE SPECIFIED.


DEVELOPMENT APPLICATION PROJECT NO: 215002 DATE: 20/11/2019 PROJECT: LIVERPOOL CENTRAL ADDRESS: LIVERPOOL CENTRAL LIVERPOOL, MERseyside L69 3GB		SCALE: 1:750 DATE: 20/11/2019 PROJECT: LIVERPOOL CENTRAL ADDRESS: LIVERPOOL CENTRAL LIVERPOOL, MERseyside L69 3GB	PROJECT NO: 215002 DATE: 20/11/2019 PROJECT: LIVERPOOL CENTRAL ADDRESS: LIVERPOOL CENTRAL LIVERPOOL, MERseyside L69 3GB
SHADOW DIAGRAMS - 21 JUNE TP04.02 IA		SHADOW DIAGRAMS - 21 JUNE TP04.02 IA	

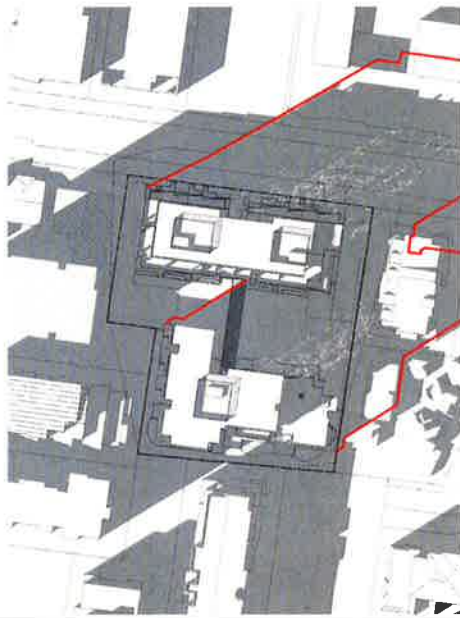




1 SUN VIEW - SHADOW 1400
SCALE



1 SUN VIEW - SHADOW 1500
SCALE

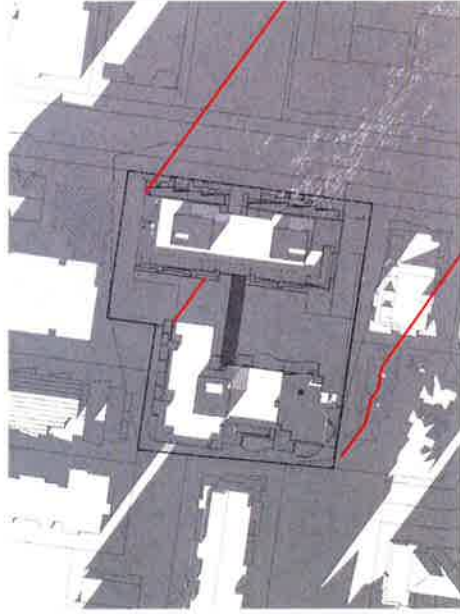

1 SUN VIEW - SHADOW 1600
SCALE

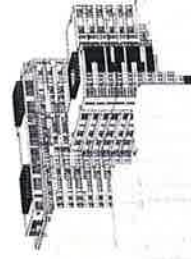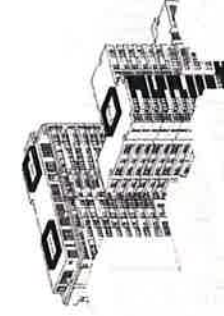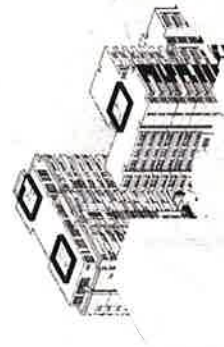

NOTES:
1. The proposed development is shown in grey.
2. The surrounding buildings are shown in white.
3. The shadows are cast from the proposed development onto the surrounding buildings.
4. The scale of the shadows is 1:1000.
5. The shadows are cast from the proposed development onto the surrounding buildings.
6. The scale of the shadows is 1:1000.
7. The shadows are cast from the proposed development onto the surrounding buildings.
8. The scale of the shadows is 1:1000.
9. The shadows are cast from the proposed development onto the surrounding buildings.
10. The scale of the shadows is 1:1000.

DATE	BY	FOR
21/06/2021	TP04.03	SHADOW DIAGRAMS
21/06/2021	TP04.03	SHADOW DIAGRAMS
PROJECT TITLE
LIVERPOOL CENTRAL
LIVERPOOL, MERseyside

PROJECT NO
215002
DATE
21/06/2021
SCALE
1:1600

DEVELOPMENT APPLICATION
PROJECT NO
215002
DATE
21/06/2021
SCALE
1:1600
PROJECT NO
215002
DATE
21/06/2021
SCALE
1:1600

TP04.03 | A
SHADOW DIAGRAMS - 21 JUNE

27-29 BIGGE SREET

3 TINDALL AVENUE



27-29 BIGGE ST - N ELEV - 0900

SCALE

27-29 BIGGE SREET

3 TINDALL AVENUE



27-29 BIGGE ST - N ELEV - 0930

SCALE

27-29 BIGGE SREET

3 TINDALL AVENUE



27-29 BIGGE ST - N ELEV - 1000

SCALE

27-29 BIGGE SREET

3 TINDALL AVENUE




27-29 BIGGE ST - N ELEV - 1030

SCALE

27-29 BIGGE SREET

3 TINDALL AVENUE

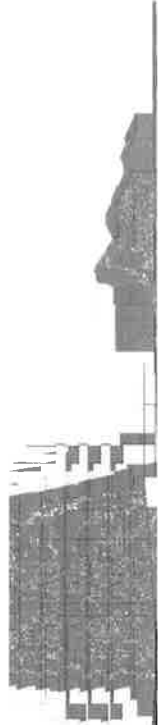

27-29 BIGGE ST - N ELEV - 1100

SCALE

27-29 BIGGE SREET

3 TINDALL AVENUE



27-29 BIGGE ST - N ELEV - 1125

SCALE

27-29 BIGGE SREET

3 TINDALL AVENUE



27-29 BIGGE ST - N ELEV - 1200

SCALE

27-29 BIGGE SREET

3 TINDALL AVENUE



27-29 BIGGE ST - N ELEV - 1230

SCALE

NOTES:
1. ALL DIMENSIONS ARE IN METERS.
2. THE ELEVATIONS ARE SHOWN FOR THE NORTH SIDE OF THE STREET.
3. THE ELEVATIONS ARE SHOWN FOR THE NORTH SIDE OF THE STREET.
4. THE ELEVATIONS ARE SHOWN FOR THE NORTH SIDE OF THE STREET.
5. THE ELEVATIONS ARE SHOWN FOR THE NORTH SIDE OF THE STREET.


NO.	DATE	REVISION
1	10/10/11	ISSUED FOR TENDERS

LIVERPOOL CENTRAL
SHADOW DIAGRAMS - 27-29
BIGGE ST

DEVELOPMENT APPLICATION
PROJECT NO: 215002
DATE: 10/10/11
DRAWN BY: [Name]
CHECKED BY: [Name]
APPROVED BY: [Name]


TP04.11 IA

27-29 BIGGE SREET 3 TINDALL AVENUE

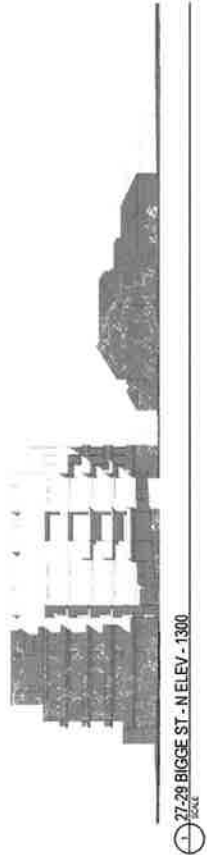


1 27-29 BIGGE ST - N ELEV - 1300
SCALE

27-29 BIGGE SREET 3 TINDALL AVENUE

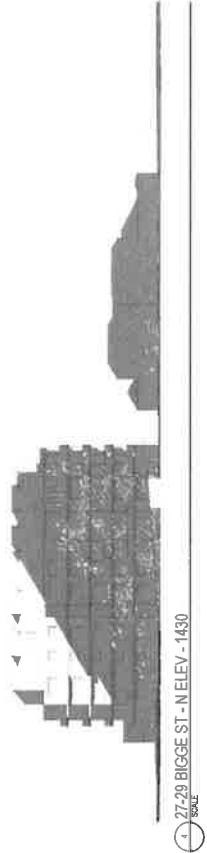


1 27-29 BIGGE ST - N ELEV - 1430
SCALE

27-29 BIGGE SREET 3 TINDALL AVENUE

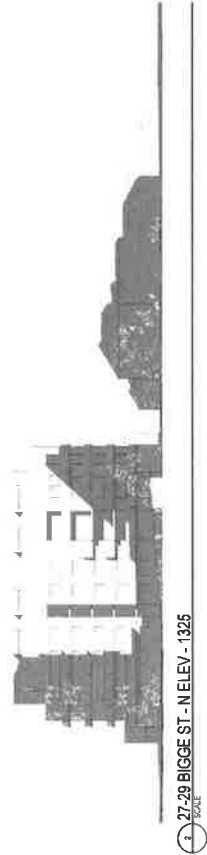


2 27-29 BIGGE ST - N ELEV - 1325
SCALE

27-29 BIGGE SREET 3 TINDALL AVENUE

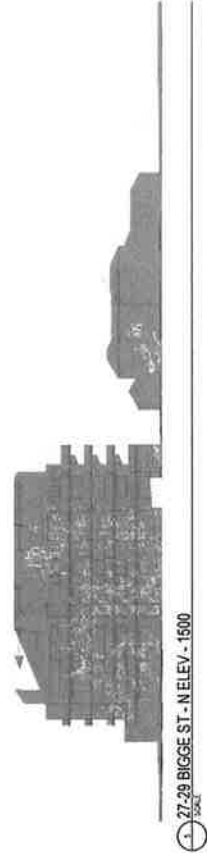

2 27-29 BIGGE ST - N ELEV - 1500
SCALE

27-29 BIGGE SREET 3 TINDALL AVENUE

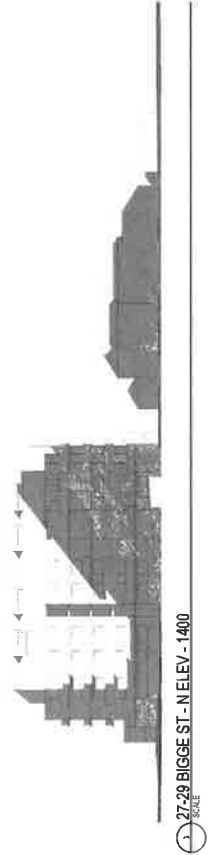

1 27-29 BIGGE ST - N ELEV - 1400
SCALE

NOTES:
1. THE DRAWING IS THE PROPERTY OF THE ARCHITECT AND IS NOT TO BE REPRODUCED OR TRANSMITTED IN ANY FORM OR BY ANY MEANS, ELECTRONIC OR MECHANICAL, INCLUDING PHOTOCOPYING, RECORDING, OR BY ANY INFORMATION STORAGE AND RETRIEVAL SYSTEM, WITHOUT THE WRITTEN PERMISSION OF THE ARCHITECT.
2. THE ARCHITECT IS NOT RESPONSIBLE FOR THE ACCURACY OF THE INFORMATION PROVIDED BY THE CLIENT OR FOR THE CONSEQUENCES OF ANY ACTION OR INACTION BASED ON THIS INFORMATION.
3. THE ARCHITECT IS NOT RESPONSIBLE FOR THE CONSTRUCTION OF THE BUILDING OR FOR THE MAINTENANCE OF THE BUILDING.
4. THE ARCHITECT IS NOT RESPONSIBLE FOR THE DESIGN OF THE BUILDING OR FOR THE CONSTRUCTION OF THE BUILDING.
5. THE ARCHITECT IS NOT RESPONSIBLE FOR THE DESIGN OF THE BUILDING OR FOR THE CONSTRUCTION OF THE BUILDING.

NO.	DESCRIPTION	DATE
1	REVISION TO DRAWING	10/10/2010
2	REVISION TO DRAWING	10/10/2010
3	REVISION TO DRAWING	10/10/2010



PROJECT TITLE
LIVERPOOL CENTRAL
ARCHITECT
LIVERPOOL CITY COUNCIL
LIVERPOOL CITY COUNCIL
LIVERPOOL CITY COUNCIL

PROJECT NO.
215002
SCALE
1:100
DATE
10/10/2010
DRAWN BY
RJS
CHECKED BY
RJS
DATE
10/10/2010

DEVELOPMENT APPLICATION
PROJECT NO.
215002
SCALE
1:100
DATE
10/10/2010
DRAWN BY
RJS
CHECKED BY
RJS
DATE
10/10/2010

TP04.12 1A

SHADOW DIAGRAMS - 27-29
BIGGE ST

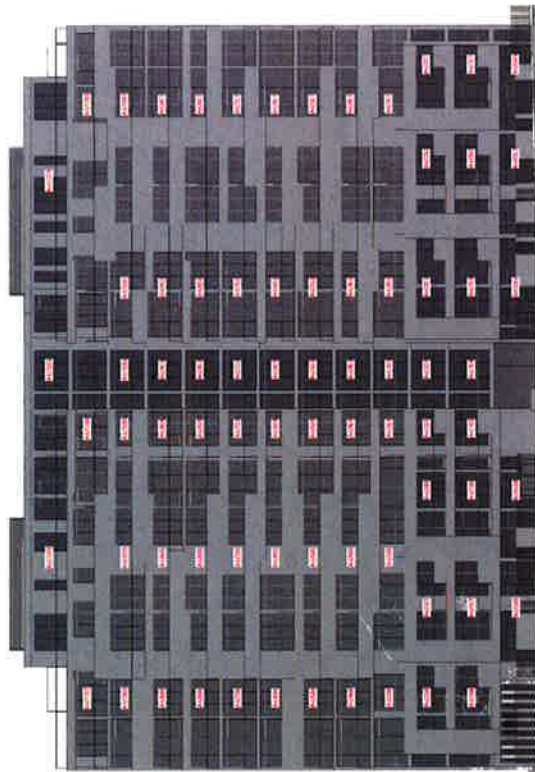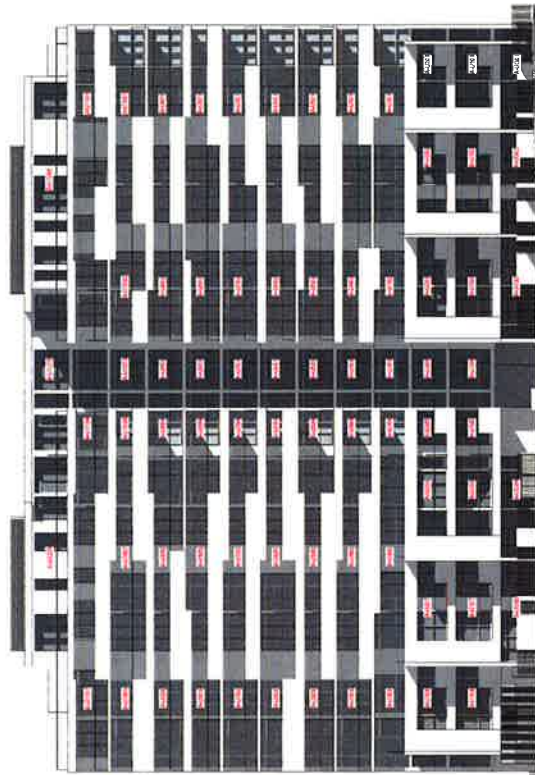[illegible]



Id	Date	Description	De	Cr
1	11.02.00	RESPONSE TO COUNCIL		800


PROJECT TITLE
LIVERPOOL CENTRAL
17-25 BRICK LANE
LIVERPOOL, NEW 2170

DATE	19/07/15	DATE	19/07/15
TIME	14:00	TIME	14:00
PROJECT NO.	215002	PROJECT NO.	215002
ISSUED BY	FOR	ISSUED BY	FOR
CHKD BY	REV	CHKD BY	REV

TP04.21 | -

[illegible]

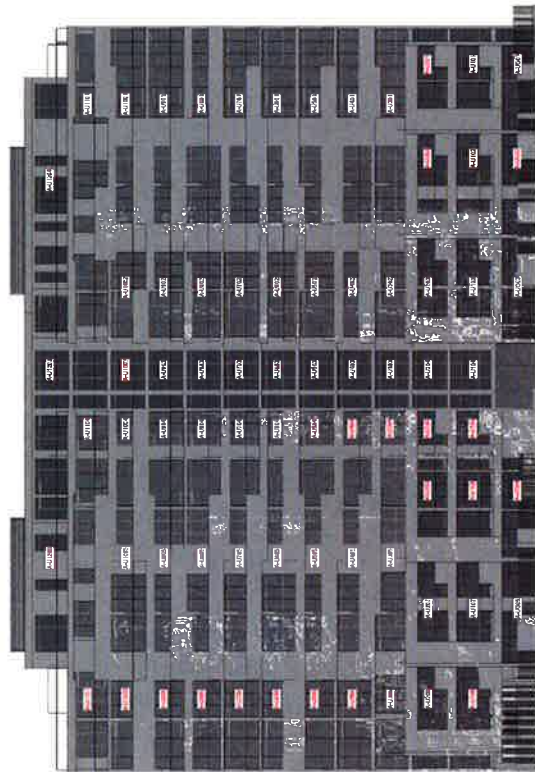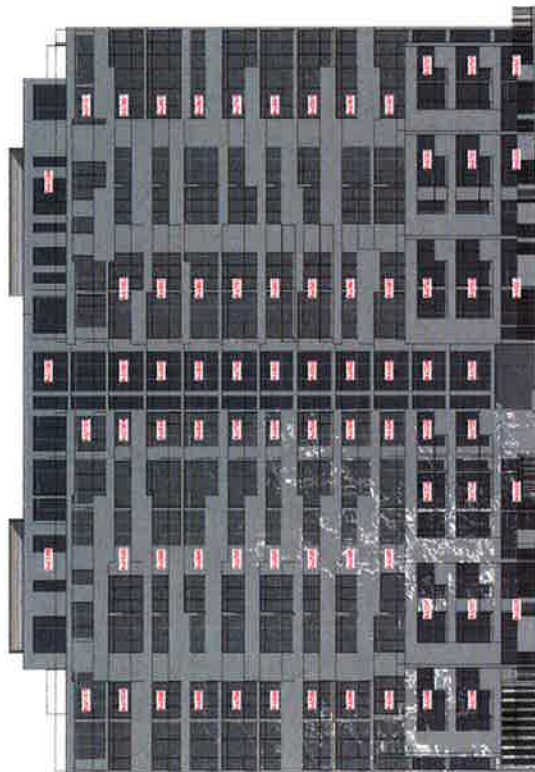


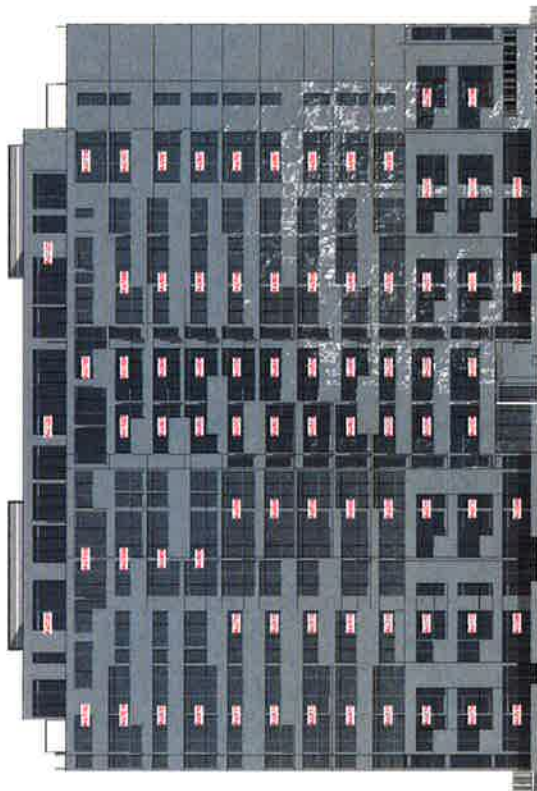

Building A West 10 am



Building A West 11 am

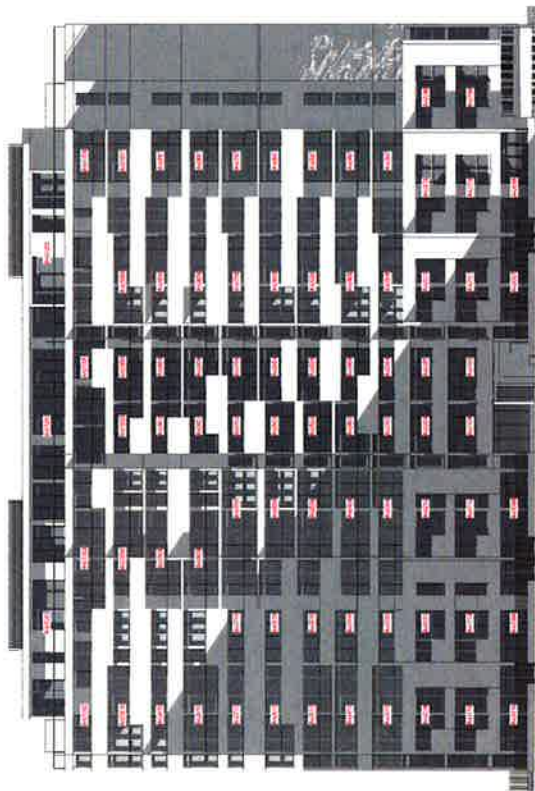

Building A West 12 pm

NOTES:
1. This rendering is for informational purposes only and is not intended to represent a final design or construction. The design is subject to change without notice.
2. The rendering is based on the information provided in the project brief and is not intended to represent a final design or construction. The design is subject to change without notice.
3. The rendering is based on the information provided in the project brief and is not intended to represent a final design or construction. The design is subject to change without notice.

DATE	DESCRIPTION	BY	APP.
11/11/2020	REVISION 1	ARCHITECT	ARCHITECT
11/11/2020	REVISION 2	ARCHITECT	ARCHITECT
11/11/2020	REVISION 3	ARCHITECT	ARCHITECT

PROJECT TITLE
LIVERPOOL CENTRAL
LIVERPOOL, ENGLAND


PROJECT NO.
215002
DATE
20/06/2020
SCALE
1:500

DEVELOPMENT APPLICATION
PROJECT NO.
215002
DATE
20/06/2020
SCALE
1:500
DRAWN BY
ARCHITECT
CHECKED BY
ARCHITECT
DATE
20/06/2020


TP04.23

SHADOW DIAGRAMS - 21 JUNE -
BUILDING A WEST - SHEET 1


NOTES:
1. This rendering is for informational purposes only and is not intended to represent a final design or construction. The design is subject to change without notice.
2. The rendering is based on the information provided in the project brief and is not intended to represent a final design or construction. The design is subject to change without notice.
3. The rendering is based on the information provided in the project brief and is not intended to represent a final design or construction. The design is subject to change without notice.

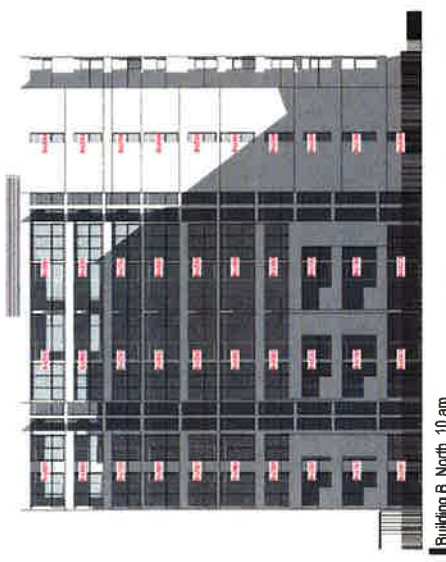


Building B North_10 am

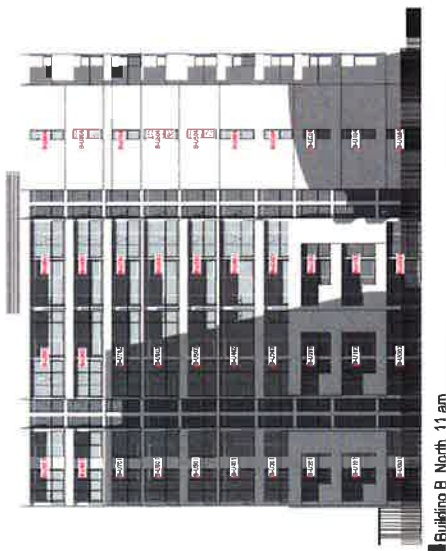


Building B North_11 am

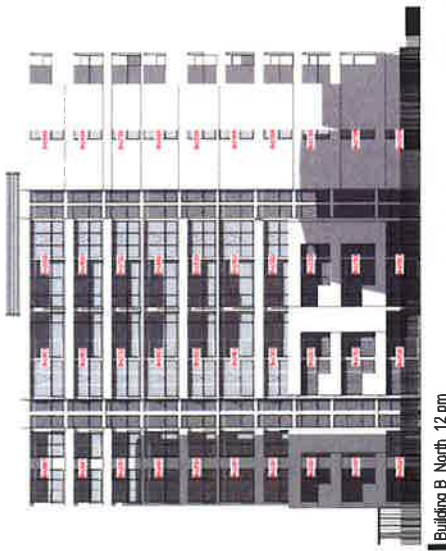


Building B North_12 pm

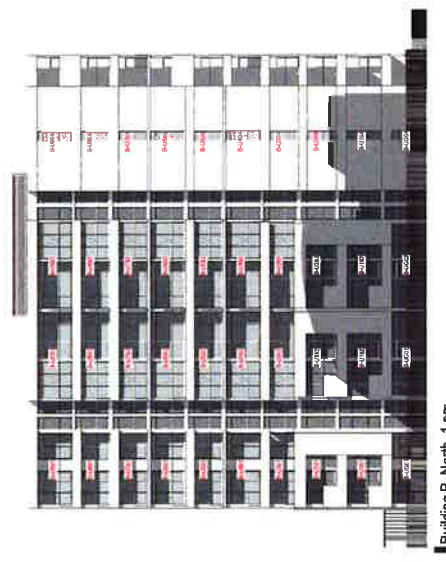

Building B North_1 pm

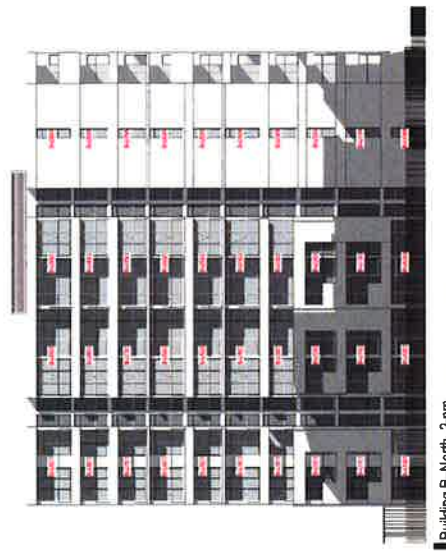

Building B North_2 pm

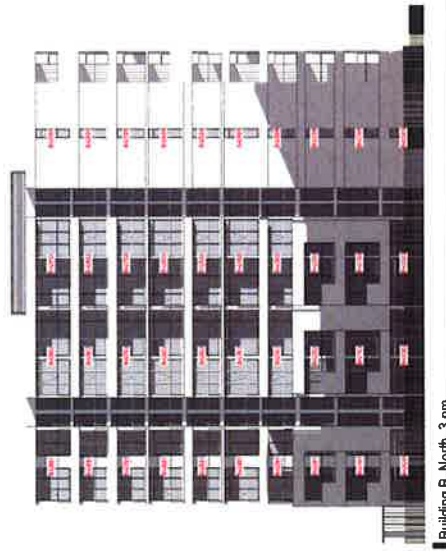







Building B North_3 pm

DISCLAIMER: The information contained herein is for informational purposes only and does not constitute an offer or recommendation of any financial product or service. The information is provided for general informational purposes only and should not be relied upon for investment decisions. The information is provided for general informational purposes only and should not be relied upon for investment decisions.

DATE	REVISION
1	1.0
2	2.0
3	3.0
100	100.0

PROJECT: LIVERPOOL CENTRAL
 SHADOW DIAGRAMS - 21 JUNE -
 BUILDING B NORTH

SCALE: 1:100
 DATE: 20/06/2024
 DRAWN BY: [Name]
 CHECKED BY: [Name]
 PROJECT NO: 215002
 PROJECT NAME: LIVERPOOL CENTRAL
 PROJECT ADDRESS: 100, 102, 104, 3326,

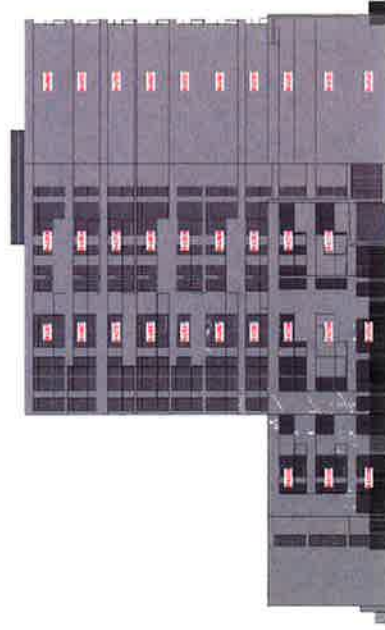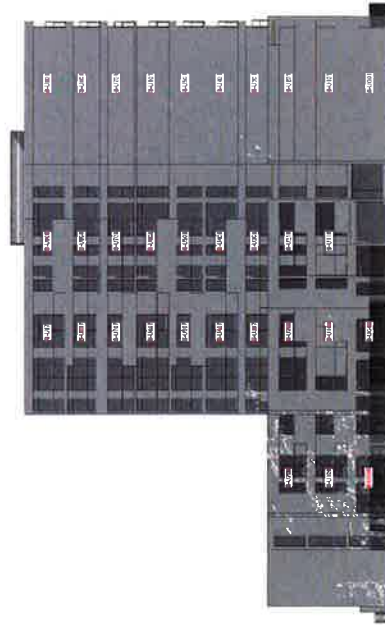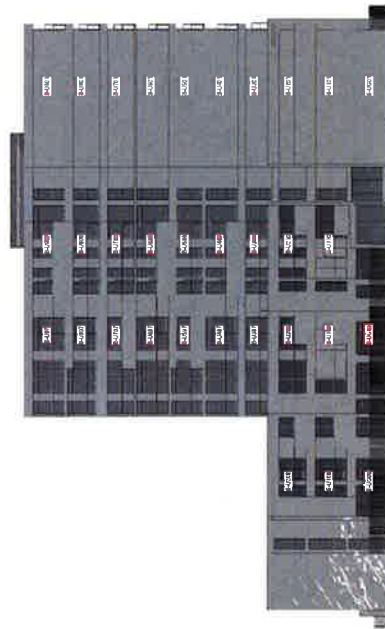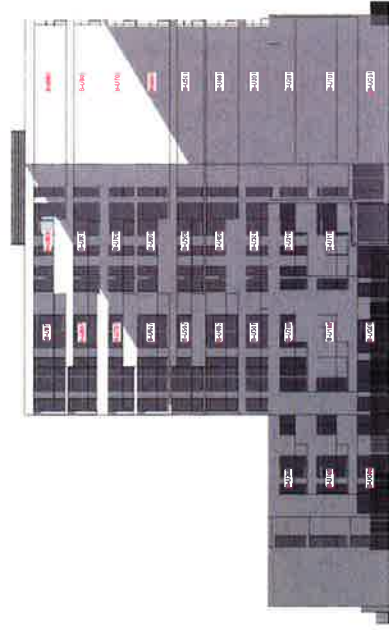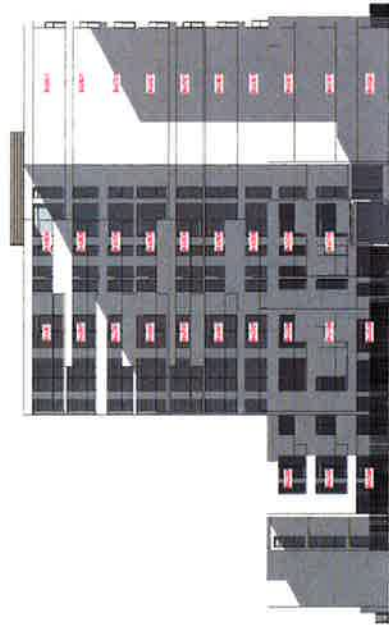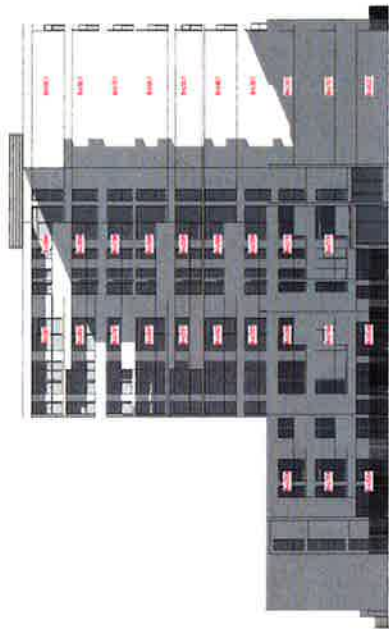

DISCLOSURE: The authors of this manuscript have nothing to disclose.

File Name	File Size	File Type
11-11-11	11-11-11	11-11-11


PHOTO: ITEL
LIVERPOOL CENTRAL
17-25 BLAISDEL
LIVERPOOL NW 2170

SCALE	PROJECT NO
DATE	215002
DATE	DATE BY
DATE	REV
DATE	FILE
DATE	TP04 26


BYRONY
LALITA & VIKI WILKINSON & DAUGHTERS
1000-1001 MOUNT STREET
MELBOURNE
AUSTRALIA
TEL: 03 9346 2970

(Net Saleable Area - Residential) has been calculated in per the Property Council of Australia Method of Measurement Guidelines - Residential


and the fact that the company's stock price has risen 10% since the announcement, the company's stock price is a good indicator of its financial health. The company's stock price is a good indicator of its financial health.

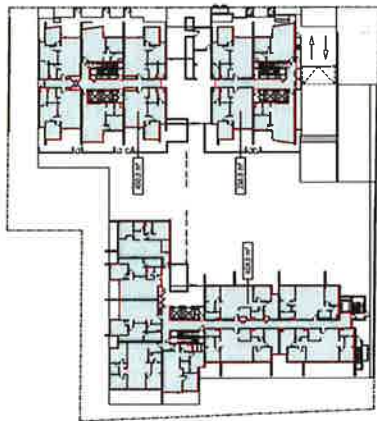


GROUND LEVEL

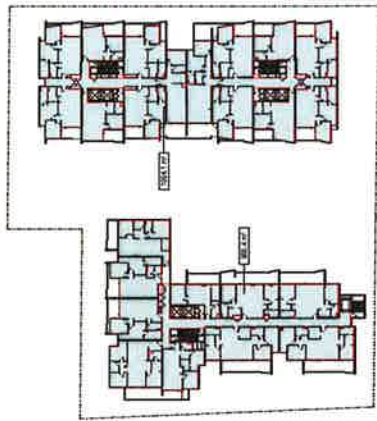


LEVELS 1-2

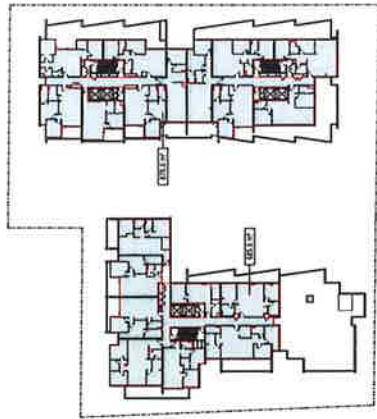


LEVEL 3

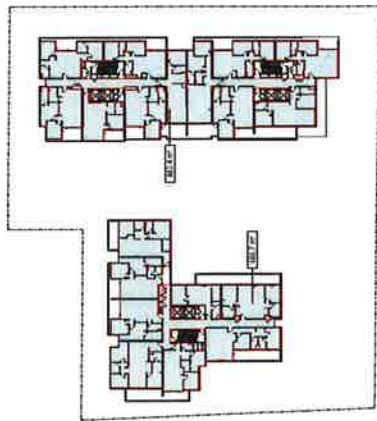


LEVELS 4-7

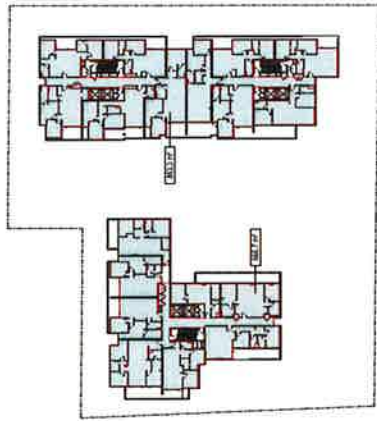


LEVELS 8-9

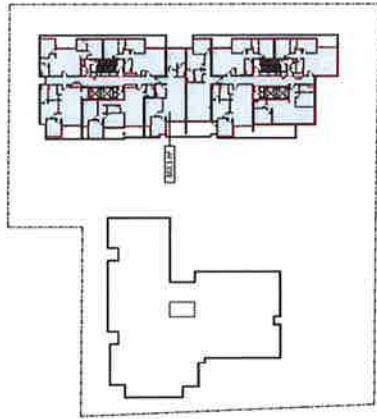

LEVEL 10

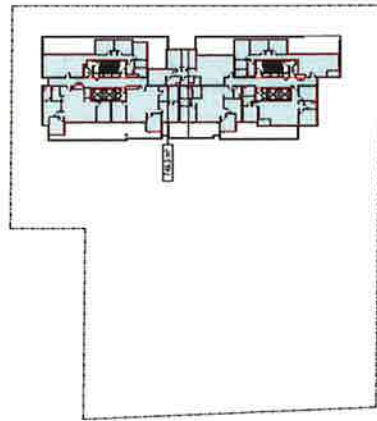

LEVEL 11

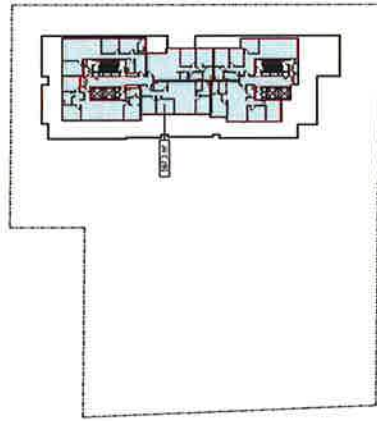

LEVEL 12

NOTES:
1. ALL DIMENSIONS ARE IN METERS.
2. ALL DIMENSIONS ARE TO FACE UNLESS OTHERWISE SPECIFIED.
3. ALL DIMENSIONS ARE TO FACE UNLESS OTHERWISE SPECIFIED.
4. ALL DIMENSIONS ARE TO FACE UNLESS OTHERWISE SPECIFIED.
5. ALL DIMENSIONS ARE TO FACE UNLESS OTHERWISE SPECIFIED.
6. ALL DIMENSIONS ARE TO FACE UNLESS OTHERWISE SPECIFIED.
7. ALL DIMENSIONS ARE TO FACE UNLESS OTHERWISE SPECIFIED.
8. ALL DIMENSIONS ARE TO FACE UNLESS OTHERWISE SPECIFIED.
9. ALL DIMENSIONS ARE TO FACE UNLESS OTHERWISE SPECIFIED.
10. ALL DIMENSIONS ARE TO FACE UNLESS OTHERWISE SPECIFIED.

NO.	REVISION	DATE	BY	CHKD.
1	ISSUED FOR PERMIT	10/10/2019	ARCHITECT	ENGINEER
2	ISSUED FOR PERMIT	10/10/2019	ARCHITECT	ENGINEER
3	ISSUED FOR PERMIT	10/10/2019	ARCHITECT	ENGINEER

PROJECT TITLE
LIVERPOOL CENTRAL
700 MARK STREET
LIVERPOOL L3 5QY

SCALE
1:500
DATE
10/10/2019
DRAWN BY
ARCHITECT
CHECKED BY
ENGINEER

DEVELOPMENT APPLICATION
PROJECT NO.
215002
SUBJECT
LIVERPOOL CENTRAL
700 MARK STREET
LIVERPOOL L3 5QY
DATE
10/10/2019
DRAWN BY
ARCHITECT
CHECKED BY
ENGINEER

TP05.02 | A

GROSS FLOOR AREA PLANS



GROUND LEVEL
SCALE: 1:50




LEVEL 1
SCALE: 1:50




LEVEL 2
SCALE: 1:50




LEVEL 3
SCALE: 1:50

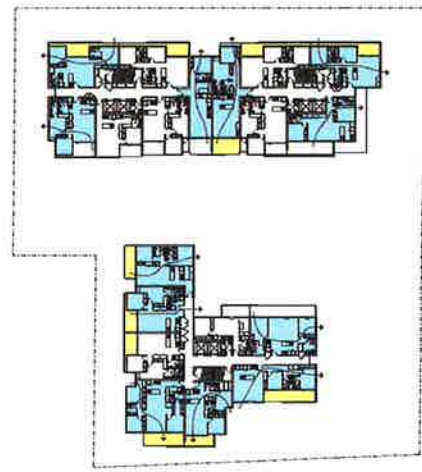


LEVEL 4
SCALE: 1:50

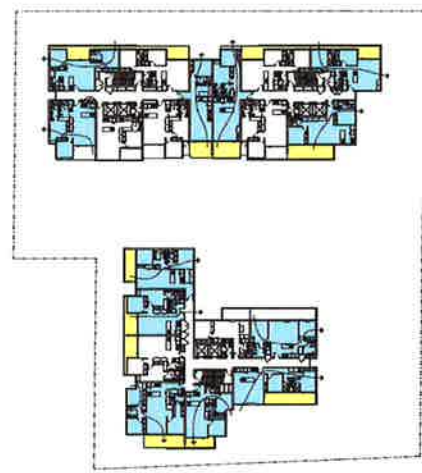

LEVEL 5
SCALE: 1:50

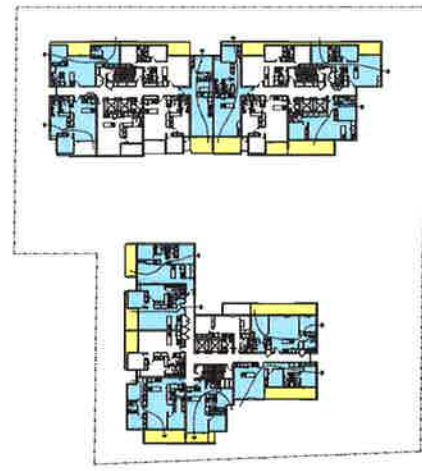

LEVEL 6
SCALE: 1:50

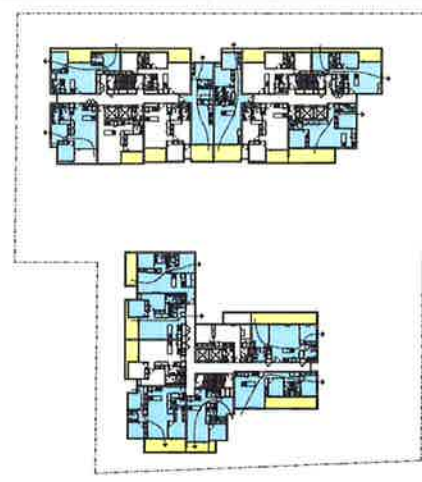

LEVEL 7
SCALE: 1:50

LEGEND

- ACHIEVES 24 SOLAR
- ACHIEVES CROSS VENTILATION
- ACHIEVES CROSS VENTILATION
- CROSS VENTILATION AIR FLOW

THIS DOCUMENT IS THE PROPERTY OF THE ARCHITECT AND SHOULD NOT BE REPRODUCED OR TRANSMITTED IN ANY FORM OR BY ANY MEANS, ELECTRONIC OR MECHANICAL, INCLUDING PHOTOCOPYING, RECORDING, OR BY ANY INFORMATION STORAGE AND RETRIEVAL SYSTEM, WITHOUT THE WRITTEN PERMISSION OF THE ARCHITECT. THE ARCHITECT'S LIABILITY IS LIMITED TO THE DESIGN AND CONSTRUCTION OF THE BUILDING AND DOES NOT EXTEND TO ANY OTHER MATTER. THE ARCHITECT'S LIABILITY IS LIMITED TO THE DESIGN AND CONSTRUCTION OF THE BUILDING AND DOES NOT EXTEND TO ANY OTHER MATTER. THE ARCHITECT'S LIABILITY IS LIMITED TO THE DESIGN AND CONSTRUCTION OF THE BUILDING AND DOES NOT EXTEND TO ANY OTHER MATTER.

DEVELOPMENT APPLICATION

PROJECT NO: 215002
 PROJECT NAME: LIVERPOOL CENTRAL
 PROJECT TYPE: SOLAR ACCESS & CROSS VENTILATION PLANS - SHEET 1
 SCALE: 1:50
 DATE: 20/01/2021
 DRAWN BY: J. L. J.
 CHECKED BY: J. L. J.
 PROJECT NO: 215002


TP05.11 IA

Schedule of Silver Level LHA			Schedule of Silver Level LHA		
Level	Apd. Number	Compliant Appointments	Level	Apd. Number	Compliant Appointments
LEVEL 6	AJ-0098		GROUND LEVEL	AJ-0033	
LEVEL 6	AJ-0099		GROUND LEVEL	AJ-0034	
LEVEL 6	AJ-0100		GROUND LEVEL	AJ-0035	
LEVEL 6	AJ-0165		GROUND LEVEL	AJ-0100	

Schedule of Stated Level LHA Complaints/ Apartments		Appt. Number
Level		
GROUND LEVEL	A-UG03	
GROUND LEVEL	A-UG04	
GROUND LEVEL	A-UG05	
GROUND LEVEL	A-UG06	
GROUND LEVEL	A-UG07	
LEVEL 1	A-U111	
LEVEL 1	A-U112	
LEVEL 1	A-U114	
LEVEL 2	A-U111	
LEVEL 2	A-U212	
LEVEL 2	A-U214	
LEVEL 3	A-U309	
LEVEL 3	A-U311	
LEVEL 3	A-U327	
LEVEL 4	A-U408	
LEVEL 4	A-U409	
LEVEL 4	A-U411	
LEVEL 4	B-A607	
LEVEL 5	B-A608	
LEVEL 5	A-U509	
LEVEL 5	A-U511	
LEVEL 5	B-A507	

Schedule of Future Level 1A Complete Apartments	
Level	Apt. Number
LEVEL 5	AU1008
LEVEL 5	AU1009
LEVEL 5	AU1011
LEVEL 5	AU1027
LEVEL 7	AU1008
LEVEL 7	AU1009
LEVEL 7	AU1011
LEVEL 7	AU1027
LEVEL 8	AU1008
LEVEL 8	AU1010
LEVEL 8	AU1027
LEVEL 9	AU1008
LEVEL 9	AU1010
LEVEL 9	AU1027
LEVEL 11	AU1100
LEVEL 11	AU1103
LEVEL 11	AU1106
LEVEL 12	AU1202
LEVEL 12	AU1203
LEVEL 12	AU1206



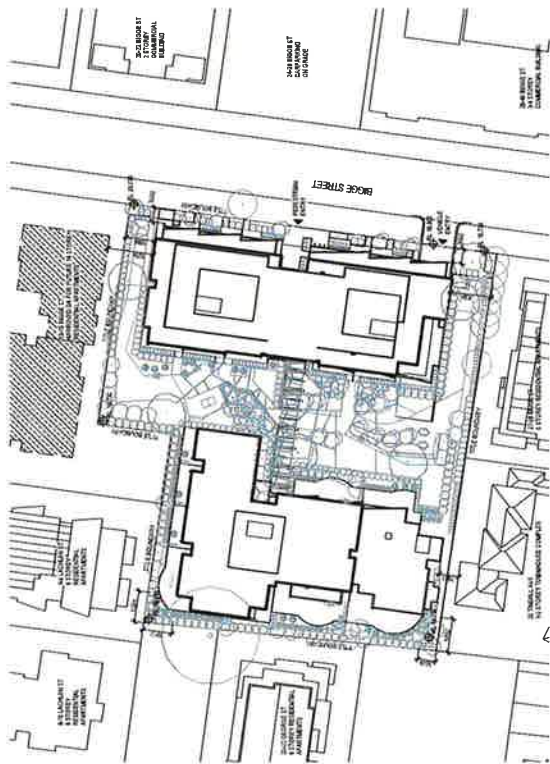

SITE PLAN
 SCALE: 1/8" = 1'-0"






SHADOWS, JUNE 21, 1500
 SCALE: 1/8" = 1'-0"

SHADOWS, JUNE 21, 1200
 SCALE: 1/8" = 1'-0"

SHADOWS, JUNE 21, 0900
 SCALE: 1/8" = 1'-0"

DEVELOPMENT APPLICATION PROJECT: LIVERPOOL CENTRAL 1700 BROADWAY LIVERPOOL, NEW YORK 10004 DATE: 06/21/2019		SCALE: As indicated PROJECT: 215002 SHEET: 001 DATE: 06/21/2019	PROJECT: LIVERPOOL CENTRAL 1700 BROADWAY LIVERPOOL, NEW YORK 10004 DATE: 06/21/2019
NOTIFICATION PLAN SHEET 1 TP07.01 IA		PROJECT: LIVERPOOL CENTRAL 1700 BROADWAY LIVERPOOL, NEW YORK 10004 DATE: 06/21/2019	

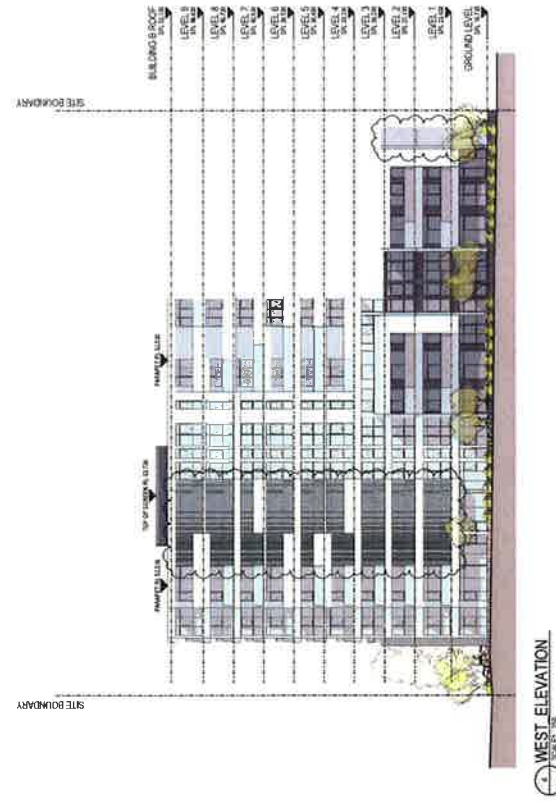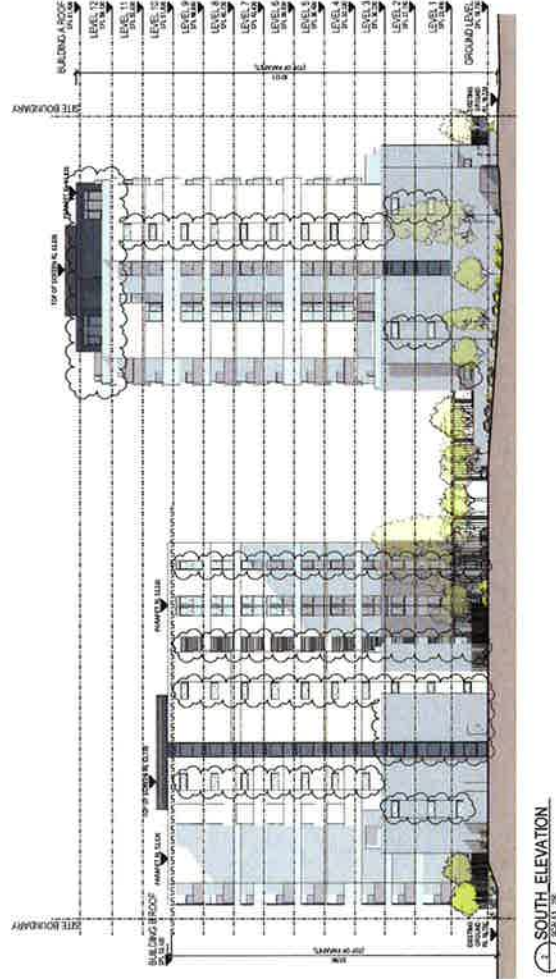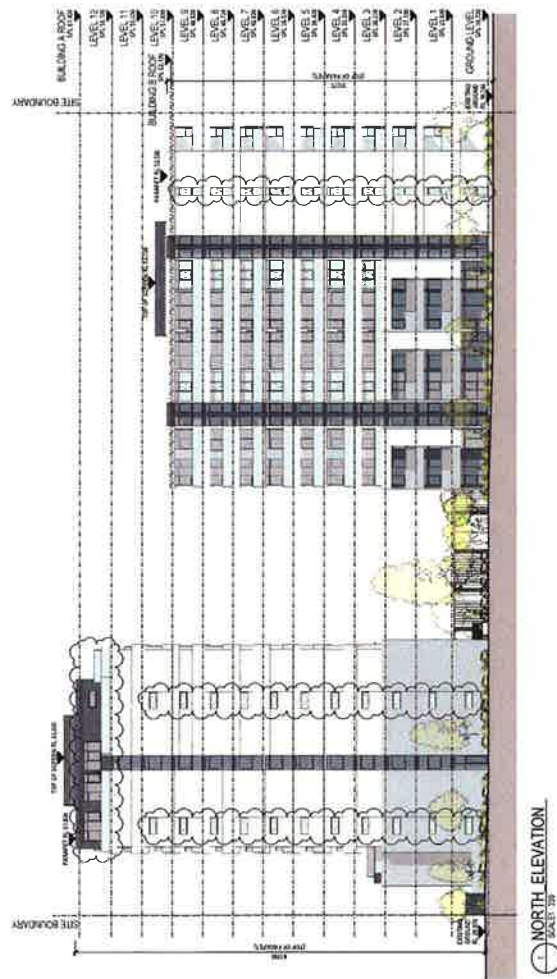

David Moore
1-877-337-4
COMMERCIAL
REAL ESTATE

1992, 1993, 1994, 2673, 26

PROPOSED RESIDENTIAL BUILDING
11-25 BROAD STREET

BIGGE STREET

22-43 MOORE ST
24 STOREY
COMMERCIAL BUILDING

RETRAIL ARE
24 MONTH

SECURITY: HOTEL/CLUB/STATION PROPERTY AND INFLUENCE OF COLLECTIVE AND INDIVIDUAL

second of the document. The medication is identified as HCL/DLAMMAN Hydroxy PIV. The label on all other packaging from each of the documents for this medication states that its function was to "neutralize changes or control the activity of the virus in other respects, without the participation of HCL/DLAMMAN Hydroxy PIV. Ltd. Under this circumstances and the use of the document, be observed a copy of certificate of transfer of the license to use this document."

PROJECT TITLE
LIVERPOOL CENTRAL


BUILDING SEPARATION@12M

1:200 215002

TP05.05 | A

DEVELOPMENT APPLICATION

THE EDMAN

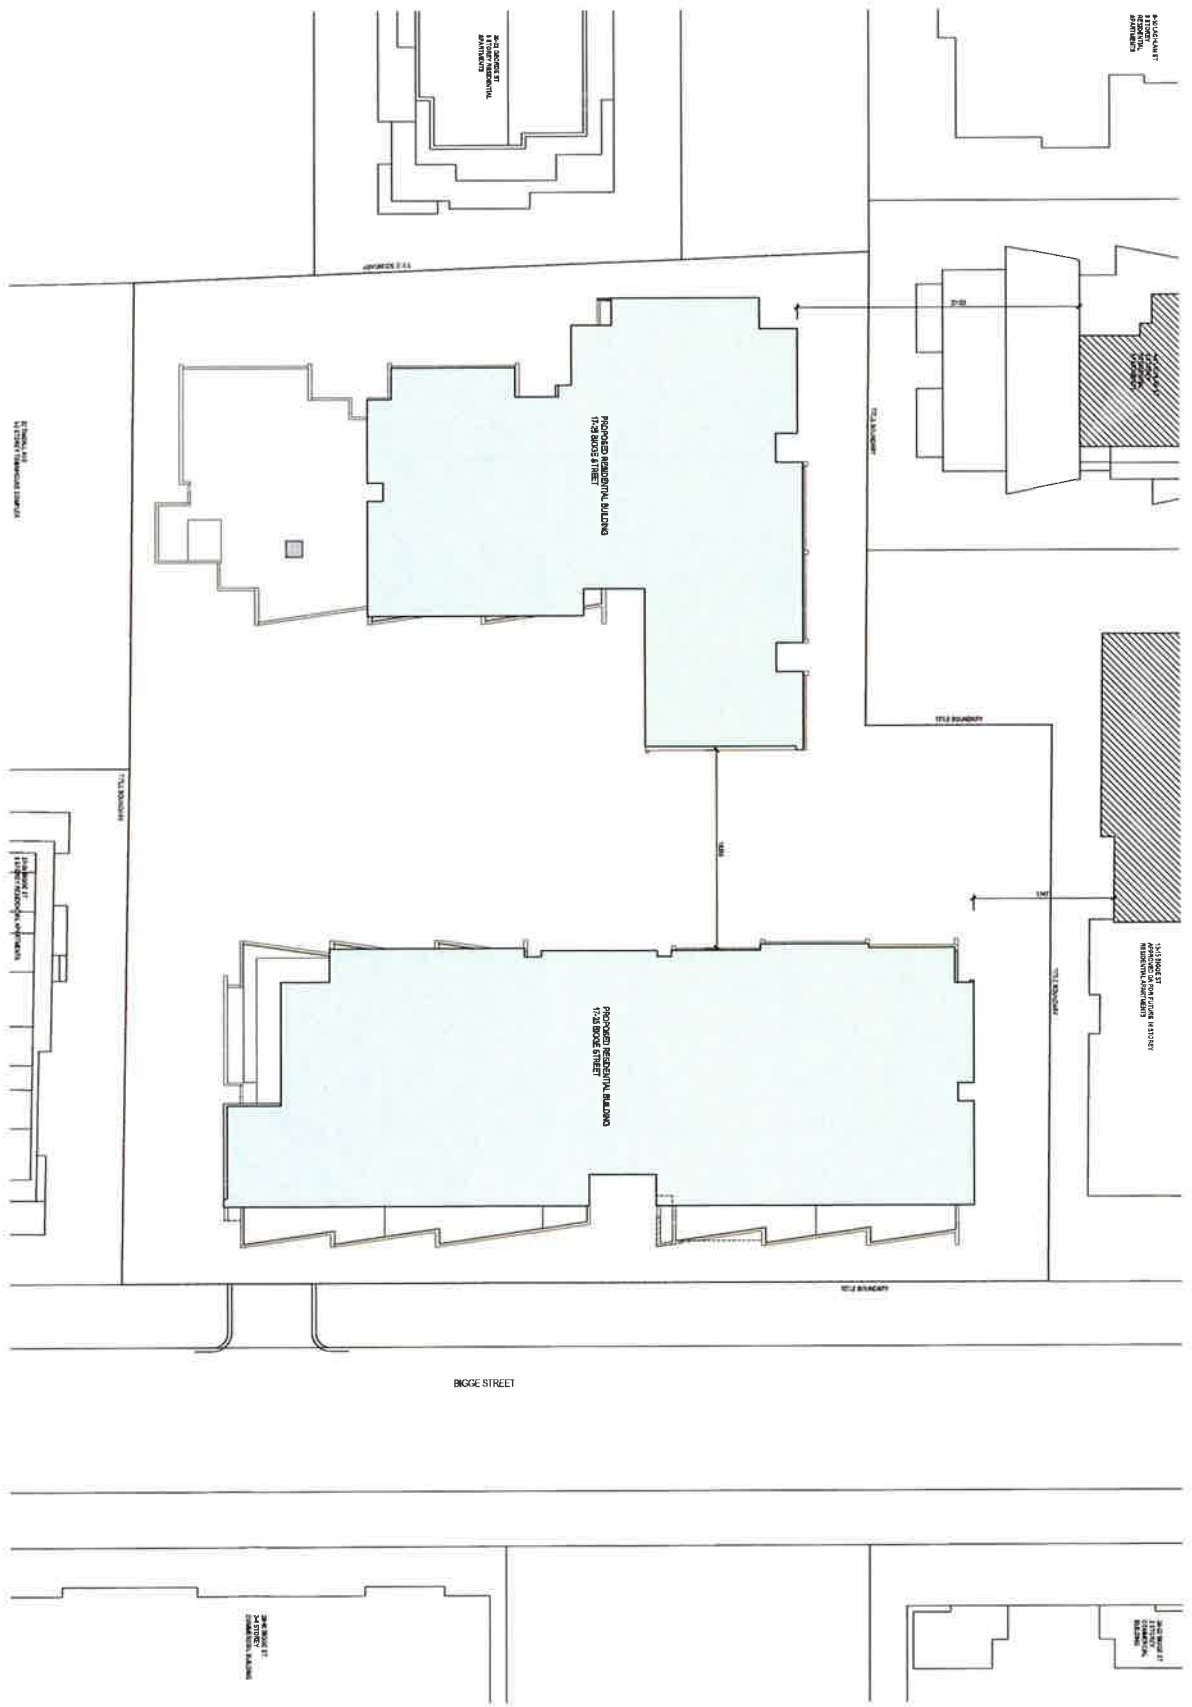[illegible]

NAME	MR	DATE	TIME	BY
* ASAC	0	11/20/00	10:00 AM	10/20/00
A	01/20/00	10:00 AM	10/20/00	10/20/00

PROJECT TITLE
LIVERPOOL CENTRAL
17-23 BAILE STREET
LIVERPOOL, NW4 2TQ

ARCHITECT
BUILDING SEPARATION@25M

SCALE 0.1	PRODUCT No
1 : 200	215002
DATE	DRAWN BY
2/11/04	As
THICK 1mm	REV
TP05.06	1A

DEVELOPMENT APPLICATION

STRATEGY


ANALYSE THE MARKET
ANALYSE THE COMPETITION
ANALYSE THE CUSTOMER
ANALYSE THE PRODUCT

Tel: 020 200 2000

www.development.com.au

ACN 200 972 346

POTENTIAL

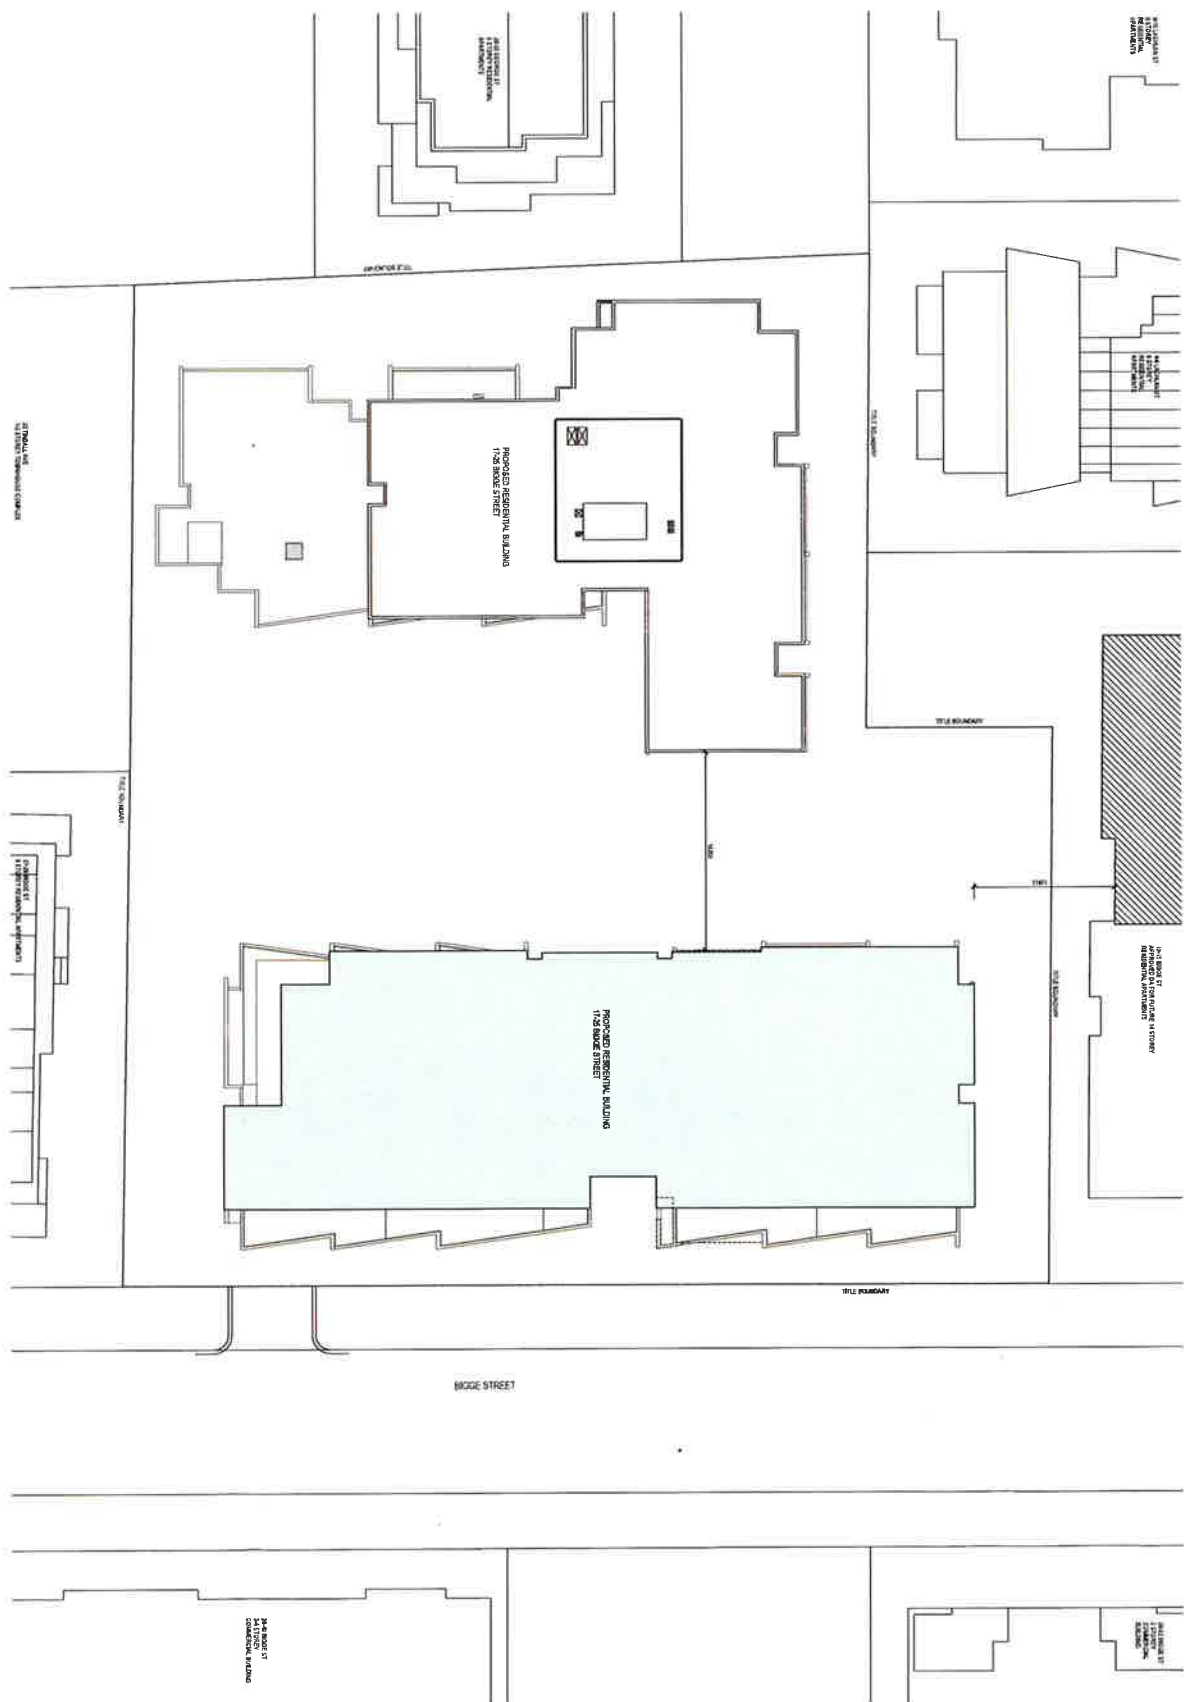[illegible]

ITEMS		
Item	Description	Qty
1	2018-19	1
2	2019-20	1
3	2020-21	1
81	2098-99	1
82	2099-00	1
83	2100-01	1
84	2101-02	1
85	2102-03	1
86	2103-04	1
87	2104-05	1
88	2105-06	1
89	2106-07	1
90	2107-08	1
91	2108-09	1
92	2109-10	1
93	2110	1

PROJECT TITLE
LIVERPOOL CENTRAL
1742 BOLD STREET
LIVERPOOL, NSW 2170

DATE	DATE
TIME	TIME
DATA NO	DATA NO
TP05.07	TP05.07

DEVELOPMENT APPLICATION

ATTENTION:
12/026, ST'79, HALLWAY & 3RD LT
COURT BUILDING 1000 NORTH 20TH
AUSTRALIA
TEL 800-805 8000
www.austlii.edu.au/au/other/australia-lii/

AUSTLII TEL 753 3447