


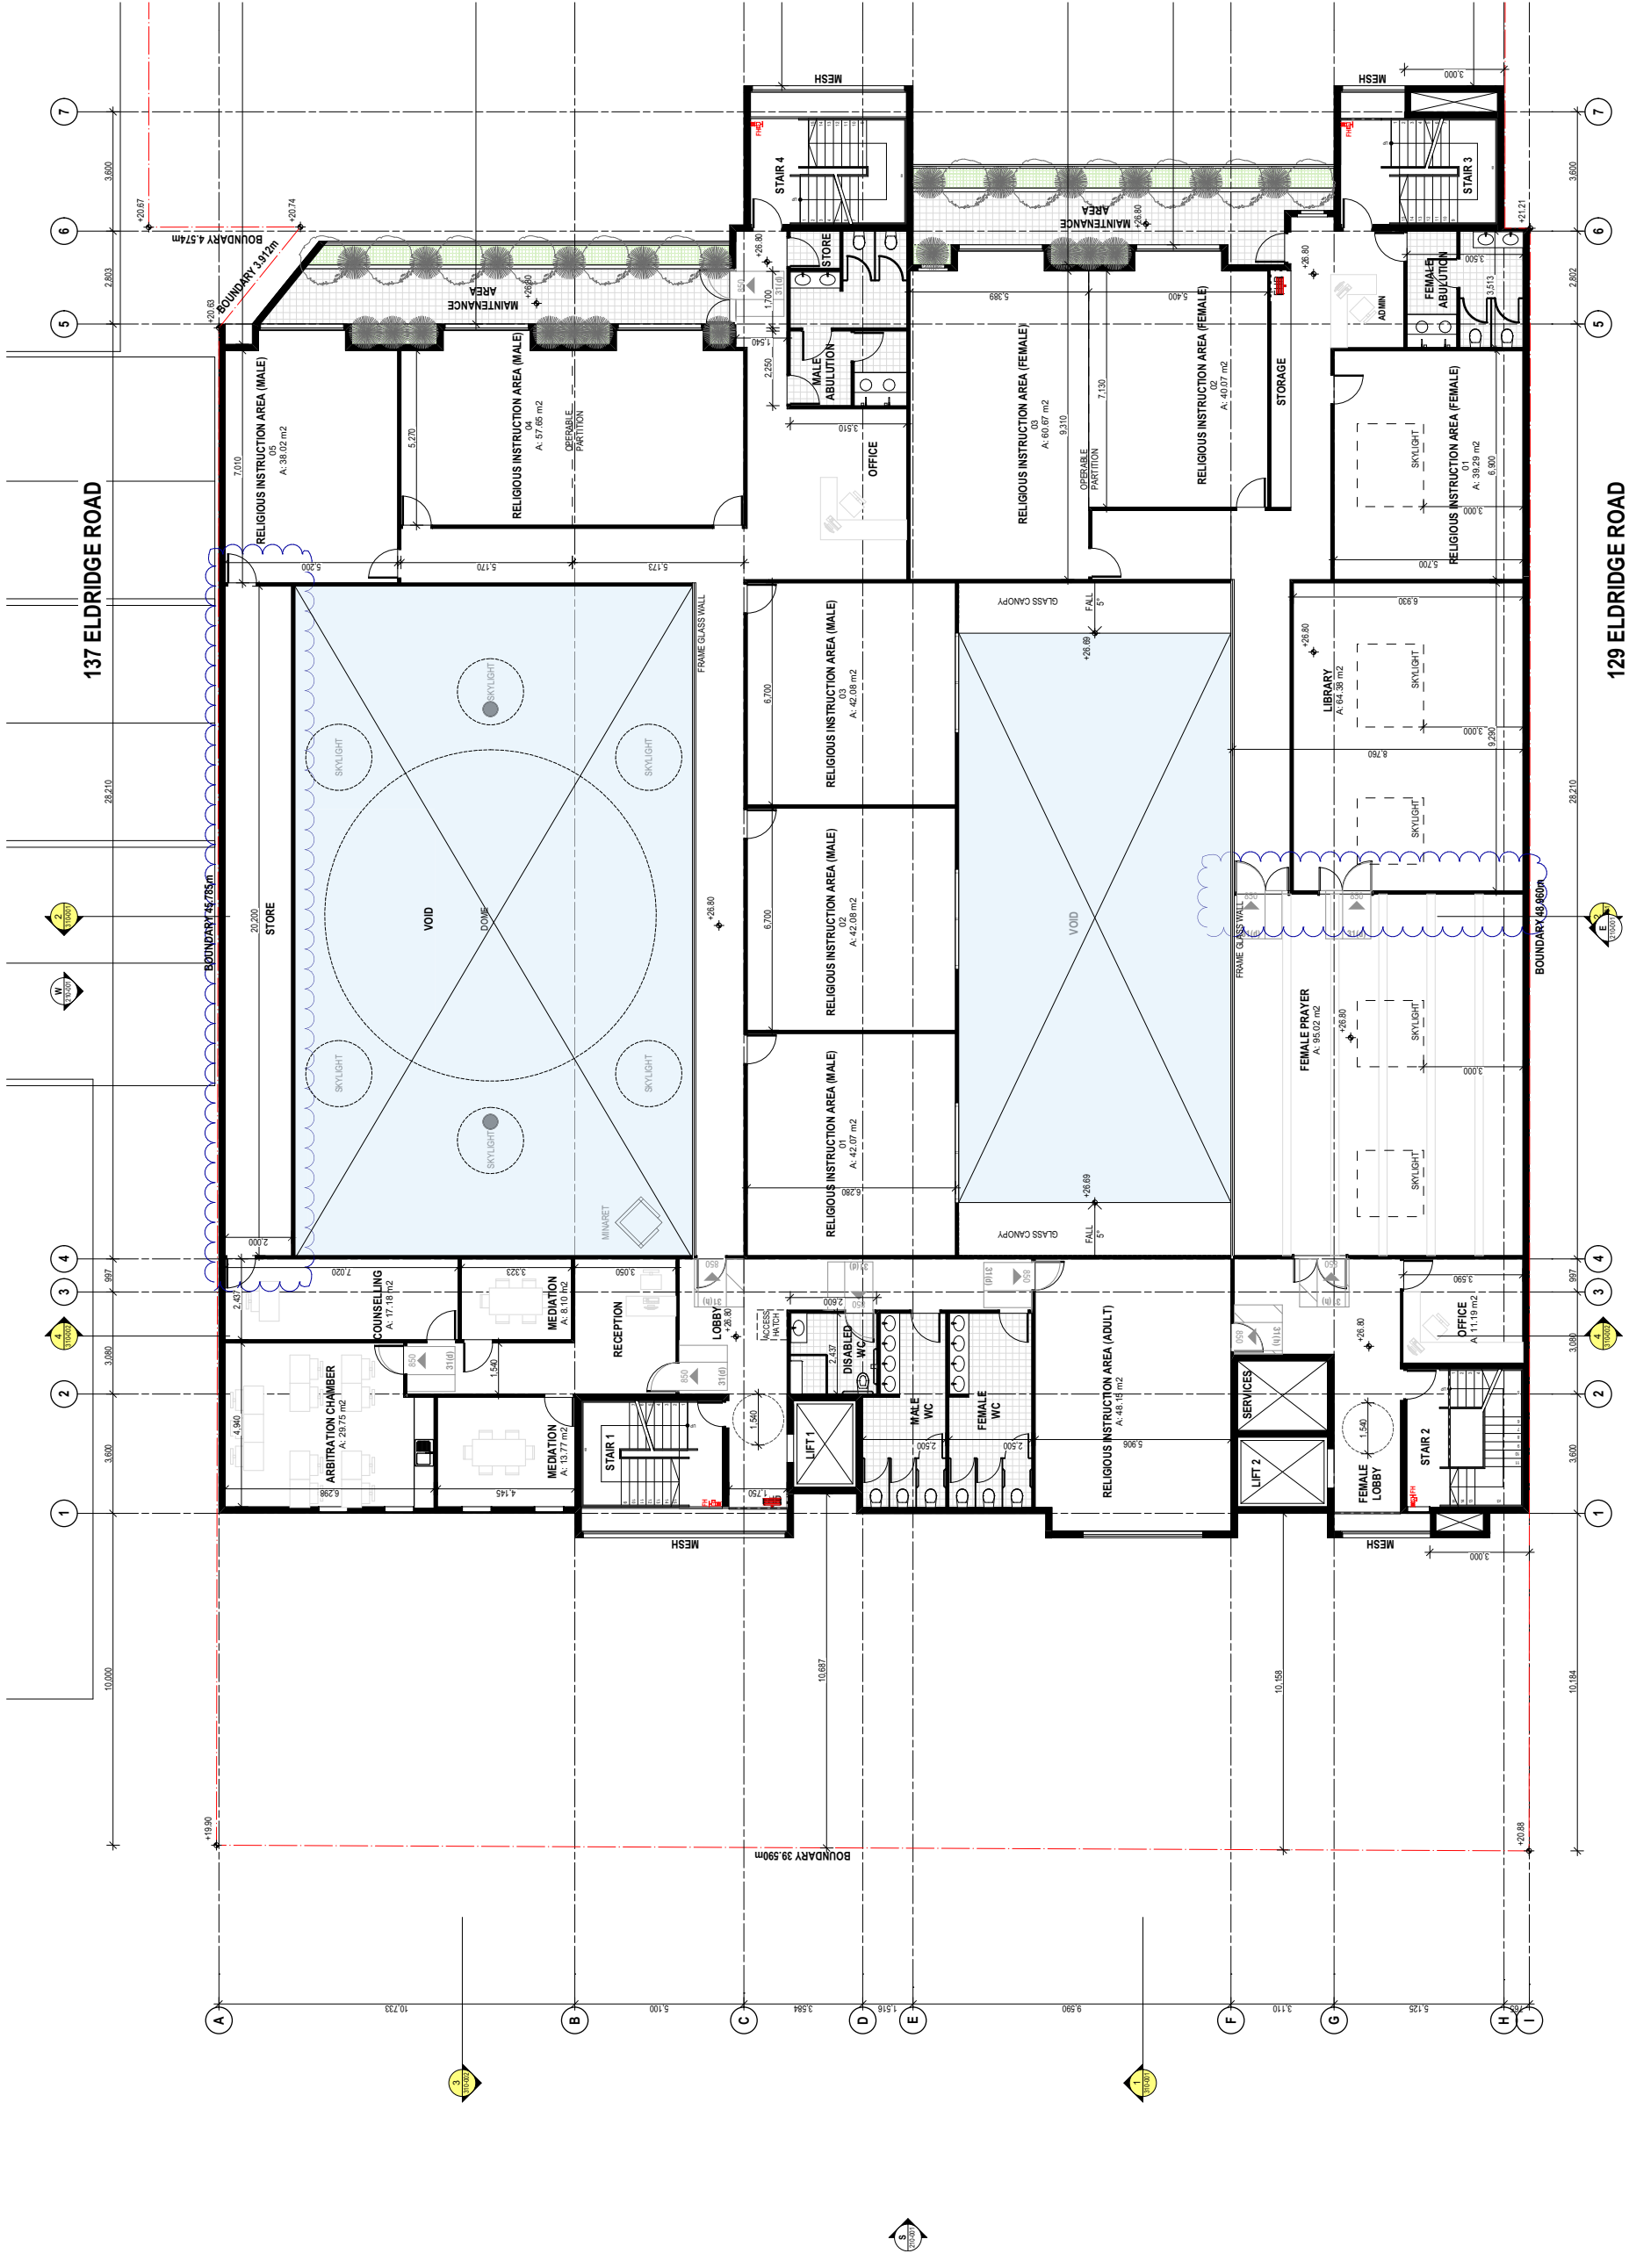

RELIGIOUS INSTRUCT. AREA - GFA		
NO.	ZONE	AREA
	RELIGIOUS INSTRUCTION AREA (ADULT)	48.15
01	RELIGIOUS INSTRUCTION AREA (FEMALE)	39.29
01	RELIGIOUS INSTRUCTION AREA (MALE)	42.07
02	RELIGIOUS INSTRUCTION AREA (FEMALE)	40.07
02	RELIGIOUS INSTRUCTION AREA (MALE)	42.08
03	RELIGIOUS INSTRUCTION AREA (FEMALE)	60.67
03	RELIGIOUS INSTRUCTION AREA (MALE)	42.08
04	RELIGIOUS INSTRUCTION AREA (MALE)	57.65
05	RELIGIOUS INSTRUCTION AREA (MALE)	38.02
		410.08 m ²

LEGEND	
	EASMENT
	EXISTING BUILDING OUTLINE
	SECURITY CAMERA
	FIRE HOSE REEL
	FIRE HYDRANT VALVE
	TACTILE STRIP
	MOTION BASED SENSOR LIGHTING AND VIDEO SURVEILLANCE SYSTEMS.
	EXIT SIGNAGE
	WHEEL CHAR OUTLINE

CONSULTANT LIST	
	Alliance Project Group 3111 121 Underwood Rd, Homebush NSW 2140 (02) 8746 0122 info@allianceprojectgroup.com.au
	Wilana Associates 103/155-161 Aveca St, Randwick NSW 2031 (02) 9399 6500 wilana@wilana.com.au
	BCA Logo 1, 7-75 Archer St, Chatswood NSW 2087 (02) 9411 5360 info@calogic.com.au
	Traffic Suite 208, 50 Hst St, Surry Hills NSW 2010 (02) 8324 5700 info@traffic.com.au
	Late Consulting 10/101 Church St, Parramatta NSW 2150 (02) 8712 524 info@lateconsulting.com
	MYD Consulting Engineers Level 2, 230 Victoria Road, Gadesville, NSW 2111 (02) 9671 2611 info@mydconsulting.com
	Concept Landscape Architect Suite 101, 508 Miller Street, Cammeray NSW 2062 (02) 9622 8312 enquiries@conceptlnd.com.au
	Ousource Ideas 1564 Princes Hwy, Rockdale NSW 2216 (02) 9597 9809 wed@ousourceideas.net
	Acoustic Logic Consultancy 9 Smith St, Mascot NSW 2020 (02) 8338 8000 enquiries@acousticlogic.com.au

3 SECOND FLOOR FFL
1:100


Rev	Date	By	For	Assessment
1	09/03/2018	PKM	PKM	PKM
2	09/03/2018	PKM	PKM	PKM
3	09/03/2018	PKM	PKM	PKM
100	09/03/2018	PKM	PKM	PKM

GENERAL NOTES:
1. ALL DIMENSIONS AND SIZES ARE IN MILLIMETRES.
2. ALL DIMENSIONS ARE TO FACE UNLESS NOTED OTHERWISE.
3. ALL WALL THICKNESSES DIMENSIONED OR NOTED ARE 100MM.
4. INFORMATION INDICATED IN THIS DOCUMENT MAY BE CRUCIAL TO THE SAFE AND PROPER FUNCTIONING OF THE PROJECT. DO NOT TAKE OVERSIZED MEASUREMENTS.
5. READ THE DRAWING IN CONJUNCTION WITH RELEVANT CONSULTANT PROPRIETOR TO THE WATERBANK FOR APPROVAL.
6. INFORM THE ARCHITECT OF ANY DISCREPANCIES.

ARCHITECTURE DESIGN STUDIO PTY LTD
ABN: 43 159 401 420
4/38 Avenue Of The Americas
Newington, NSW 2127
Phone: 02 9546 6666
email: info@ads.com.au



 Member
Australian
Architects



This drawing is protected by copyright. It may only be used for the purpose for which it is issued.
AT Scale: 1:100
AS Scale: 1:100
10m

Client: Alliance Project Group
Project: CONNELL PARK COMMUNITY & PARTNERSHIP
131-155 ELDRIDGE RD CONNELL PARK NSW 2062
206 ASPTG

Drawing No: Pn_0607
Second Floor Plan
Date: 09/03/17
Drawn By: F
Checked By: F
Reviewed By: F
A-110-102

ISSUE FOR DA