


Solar Access Schedule		
Unit Number	Unit Type	Solar Compliance
Lower Ground		
LG-U1	2B	YES
LG-U2	3B	YES
LG-U3	2B	YES
Ground Floor (Retail)		
G-U1	2B	YES
G-U2	1B + ST	YES
G-U3	2B	YES
G-U4	2B	YES
Level 1		
L1-U1	2B	YES
L1-U2	1B + ST	YES
L1-U3	2B	YES
L1-U4	2B	YES
L1-U7	2B	YES
L1-U8	1B	YES
Level 2		
L2-U1	2B	YES
L2-U2	1B + ST	YES
L2-U3	2B	YES
L2-U4	2B	YES
L2-U7	2B	YES
L2-U8	1B	YES
L2-U9	1B	YES
Level 3		
L3-U1	2B	YES
L3-U2	1B + ST	YES
L3-U3	2B	YES
L3-U4	2B	YES
L3-U7	2B	YES
L3-U8	1B	YES
L3-U9	1B	YES
L3-U10	2B	YES
Level 4		
L4-U1	2B	YES
L4-U2	1B + ST	YES
L4-U3	2B	YES
L4-U4	2B	YES
L4-U5	2B	YES
L4-U6	2B	YES
L4-U7	2B	YES
L4-U8	1B	YES
L4-U9	1B	YES
L4-U10	2B	YES
Level 5		
L5-U1	3B	YES
L5-U2	3B	YES
Total: 40 units		

Natural Ventilation Schedule		
Unit Number	Unit Type	Ventilation Compliance
Lower Ground		
LG-U1	2B	YES
LG-U2	3B	YES
LG-U3	2B	YES
LG-U5	2B	YES
Ground Floor (Retail)		
G-U1	2B	YES
G-U2	1B + ST	YES
G-U3	2B	YES
G-U4	2B	YES
G-U6	2B	YES
Level 1		
L1-U1	2B	YES
L1-U2	1B + ST	YES
L1-U3	2B	YES
L1-U4	2B	YES
L1-U6	2B	YES
L1-U7	2B	YES
L1-U11	2B	YES
Level 2		
L2-U1	2B	YES
L2-U2	1B + ST	YES
L2-U3	2B	YES
L2-U4	2B	YES
L2-U6	2B	YES
L2-U7	2B	YES
L2-U11	2B	YES
Level 3		
L3-U1	2B	YES
L3-U2	1B + ST	YES
L3-U3	2B	YES
L3-U4	2B	YES
L3-U6	2B	YES
L3-U7	2B	YES
L3-U11	2B	YES
Level 4		
L4-U1	2B	YES
L4-U2	1B + ST	YES
L4-U3	2B	YES
L4-U4	2B	YES
L4-U5	2B	YES
L4-U6	2B	YES
L4-U7	2B	YES
L4-U11	2B	YES
Level 5		
L5-U1	3B	YES
L5-U2	3B	YES
Total: 40 units		

Solar Access & Natural Ventilation Summary		
Total Units: 57		
	Control	Provided
Solar Access	70% of units (40 units)	70% of units (40 units)
Natural Cross Ventilation	60% of units (34 units)	70% of units (40 units)

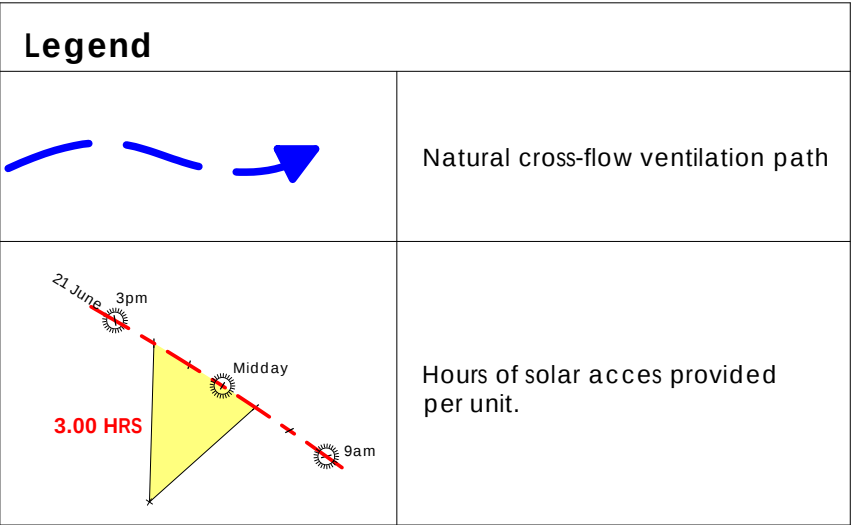


Solar Access & Natural Ventilation

Rev. #	Description	Date	 The Architect retains copyright. Authority should be requested for any reproductions	Client	Consultants	 alec pappas architects Pty Ltd	 ABN: 60 050 064 045 Level 1, 12 Mashman Avenue Kingsgrove NSW 2208 ph: (02) 9554 8233 fx: (02) 9554 8244 em: info@alecpappas.com.au web: www.alecpappas.com.au nominated Architect: Alec Pappas (Registration No: 4713)	 Project Proposed Mixed Use Development 850-858 King Georges Rd South Hurstville	Date	
A	Council Amendments	Oct'17		Gaidra Pty Ltd	GSA Planning (Urban Planner) Structural Design Solutions (Structural) LAM Consulting Engineers (Stormwater) Building & Energy Consultants Australia (BASIX)				Mar' 17	
									Scale	Job No.
									1 : 200	J09-16

The floor plan illustrates the fire spread from a porch into five upper-level flats (LG-U1 to LG-U5). The fire starts in a porch area, with a 3.00 HRS spread time to LG-U1 and 5.00 HRS to LG-U2. From there, it spreads to LG-U3 (3.00 HRS), LG-U4 (0.00 HRS), and LG-U5 (0.00 HRS). The plan also shows the fire front's progression at 9am, Midday, and 3pm on 21 June. The building is located next to 'SHORT LANE'.

 1:200


Rev. #	Description	Date		Client Gaidra Pty Ltd	Consultants GSA Planning (Urban Planner) Structural Design Solutions (Structural) LAM Consulting Engineers (Stormwater) Building & Energy Consultants Australia (BASIX)	 alec pappas architects Pty Ltd	ABN: 60 050 064 045 Level 1, 12 Mashman Avenue Kingsgrove NSW 2208 ph: (02) 9554 8233 fx: (02) 9554 8244 em: info@alecpappas.com.au web: www.alecpappas.com.au nominated Architect: Alec Pappas (Registration No: 4713)	 Member Australian Institute of Architects	Project Proposed Mixed Use Development 850-858 King Georges Rd South Hurstville	Date Mar '17
A	Council Amendments	Oct '17							Scale 1 : 200	Job No. J09-16
©	The Architect retains copyright. Authority should be requested for any reproductions	DESIGN INTENT FOR COUNCIL (DA)			Alec Pappas Architects Pty Ltd			Title Solar & Natural Ventilation	Dwg No. SV-02	Revision A



ALLEN STREET


SHORT LANE

KINGS GEORGES ROAD

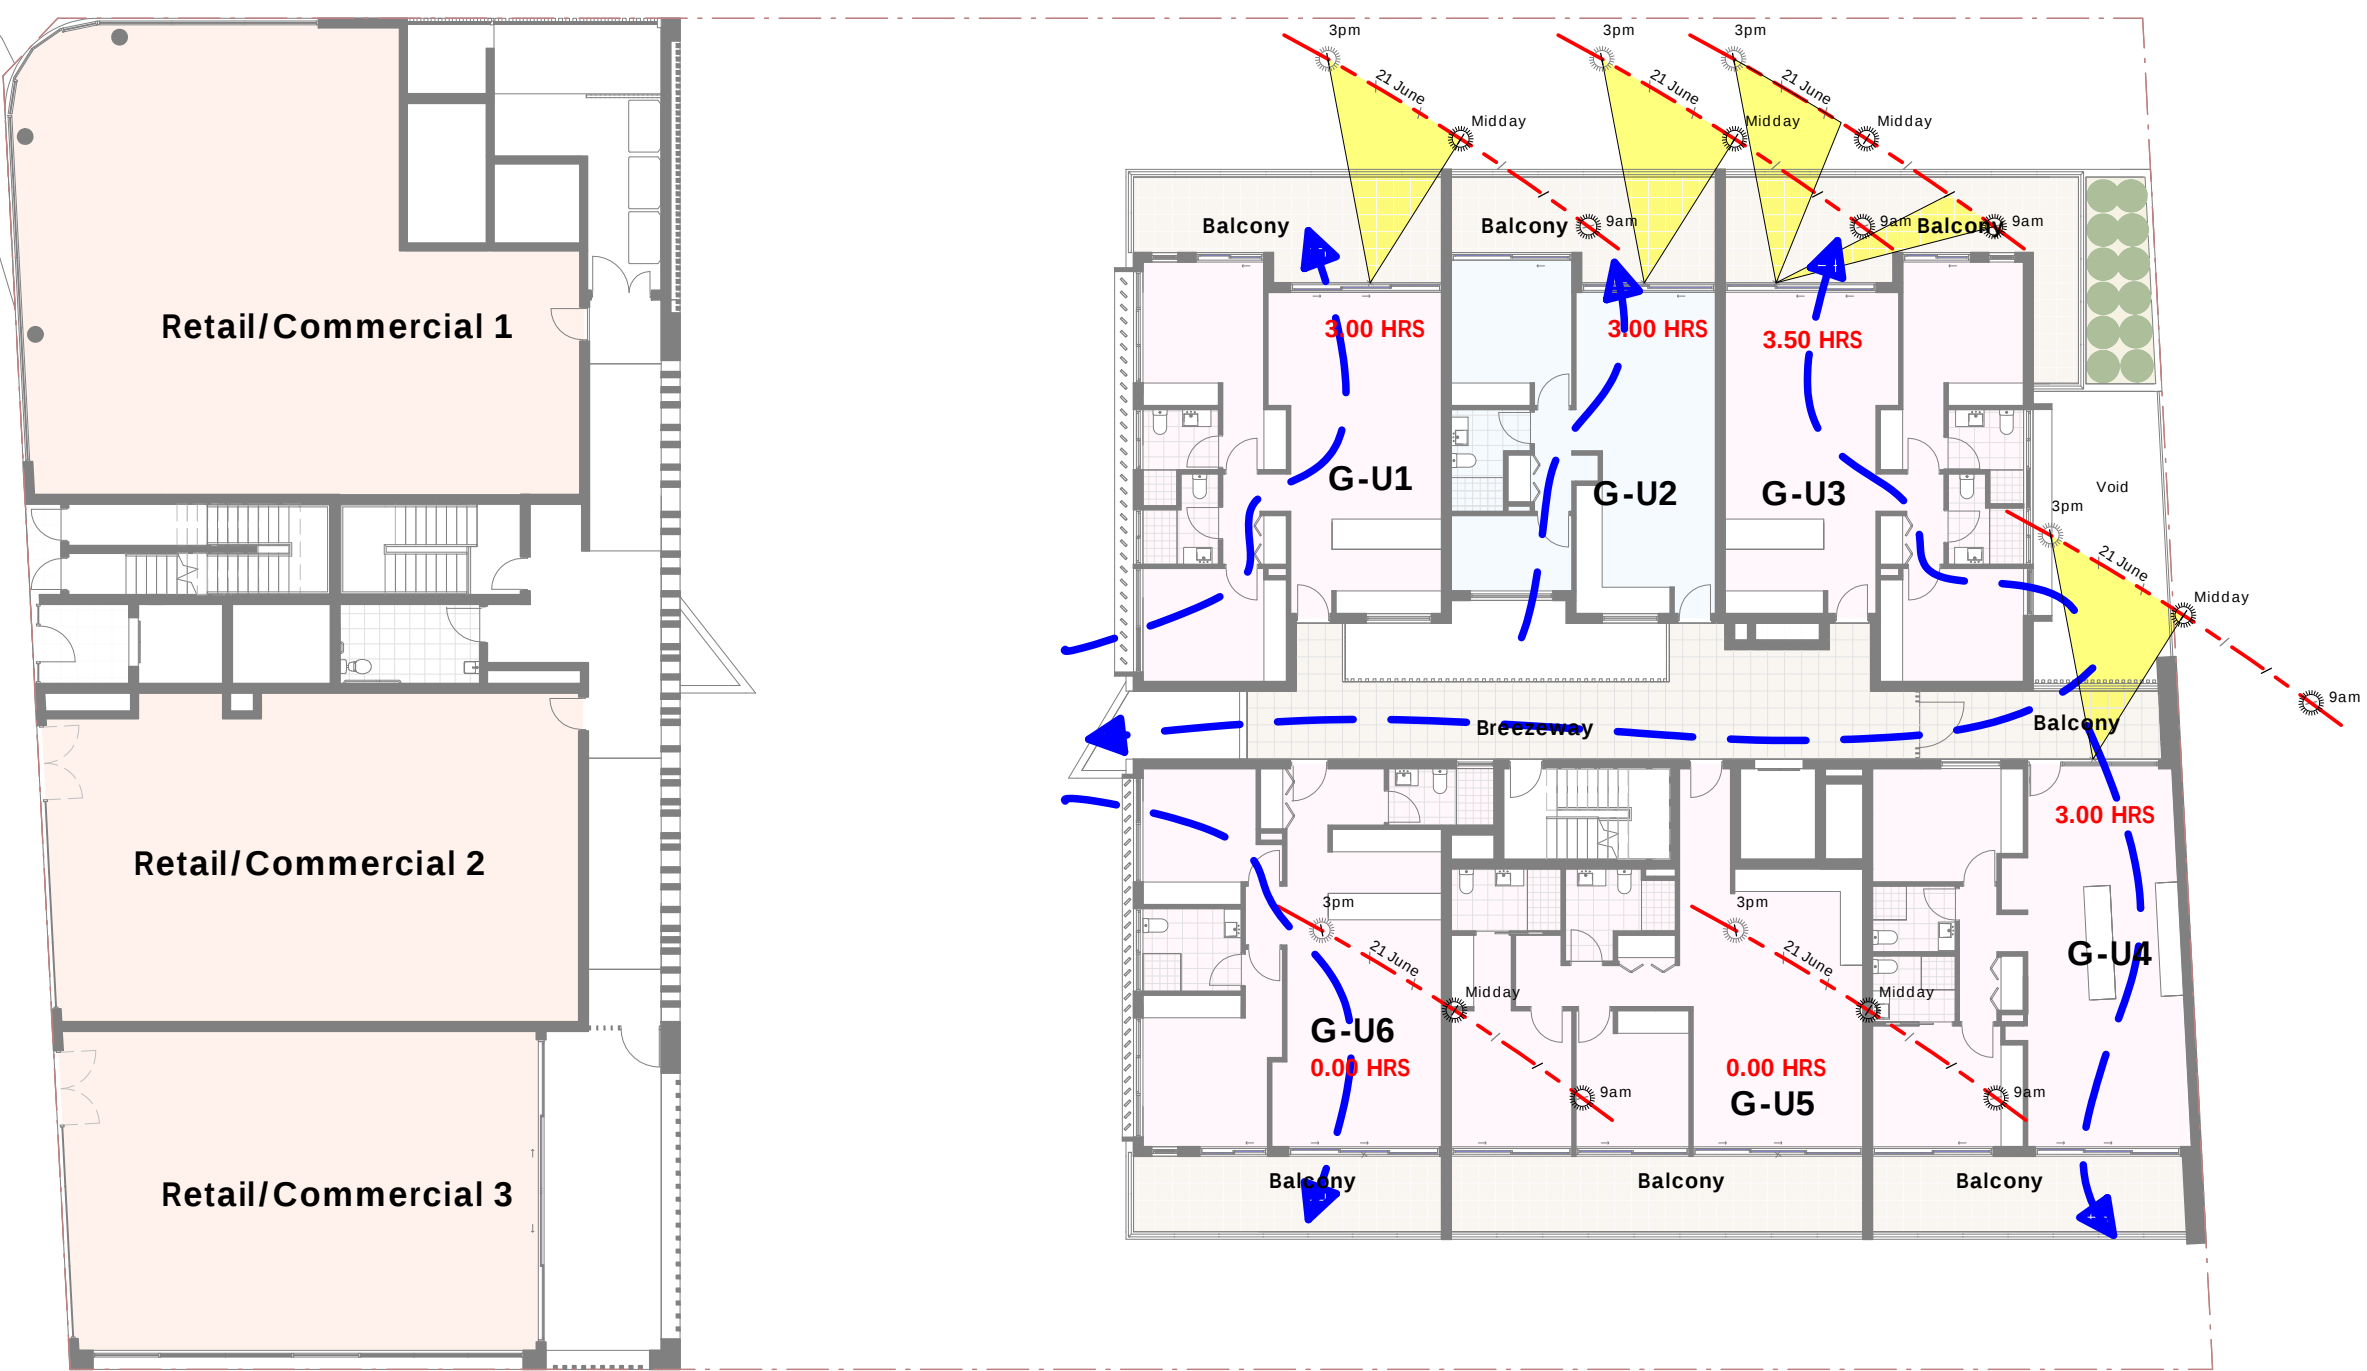


Solar Access & Natural Ventilation (Ground Floor Plan)
1:200

Rev. #	Description	Date		Client Gaidra Pty Ltd	Consultants GSA Planning (Urban Planner) Structural Design Solutions (Structural) LAM Consulting Engineers (Stormwater) Building & Energy Consultants Australia (BASIX)	 alec pappas architects Pty Ltd ABN: 60 050 064 045 Level 1, 12 Mashman Avenue Kingsgrove NSW 2208 ph: (02) 9554 8233 fx: (02) 9554 8244 em: info@alecpappas.com.au web: www.alecpappas.com.au nominated Architect: Alec Pappas (Registration No: 4713)	 Member Australian Institute of Architects	Project	Date	
A	Council Amendments	Oct '17						Proposed Mixed Use Development	Mar' 17	
								850-858 King Georges Rd	Scale	Job No.
								South Hurstville	1 : 200	J09-16

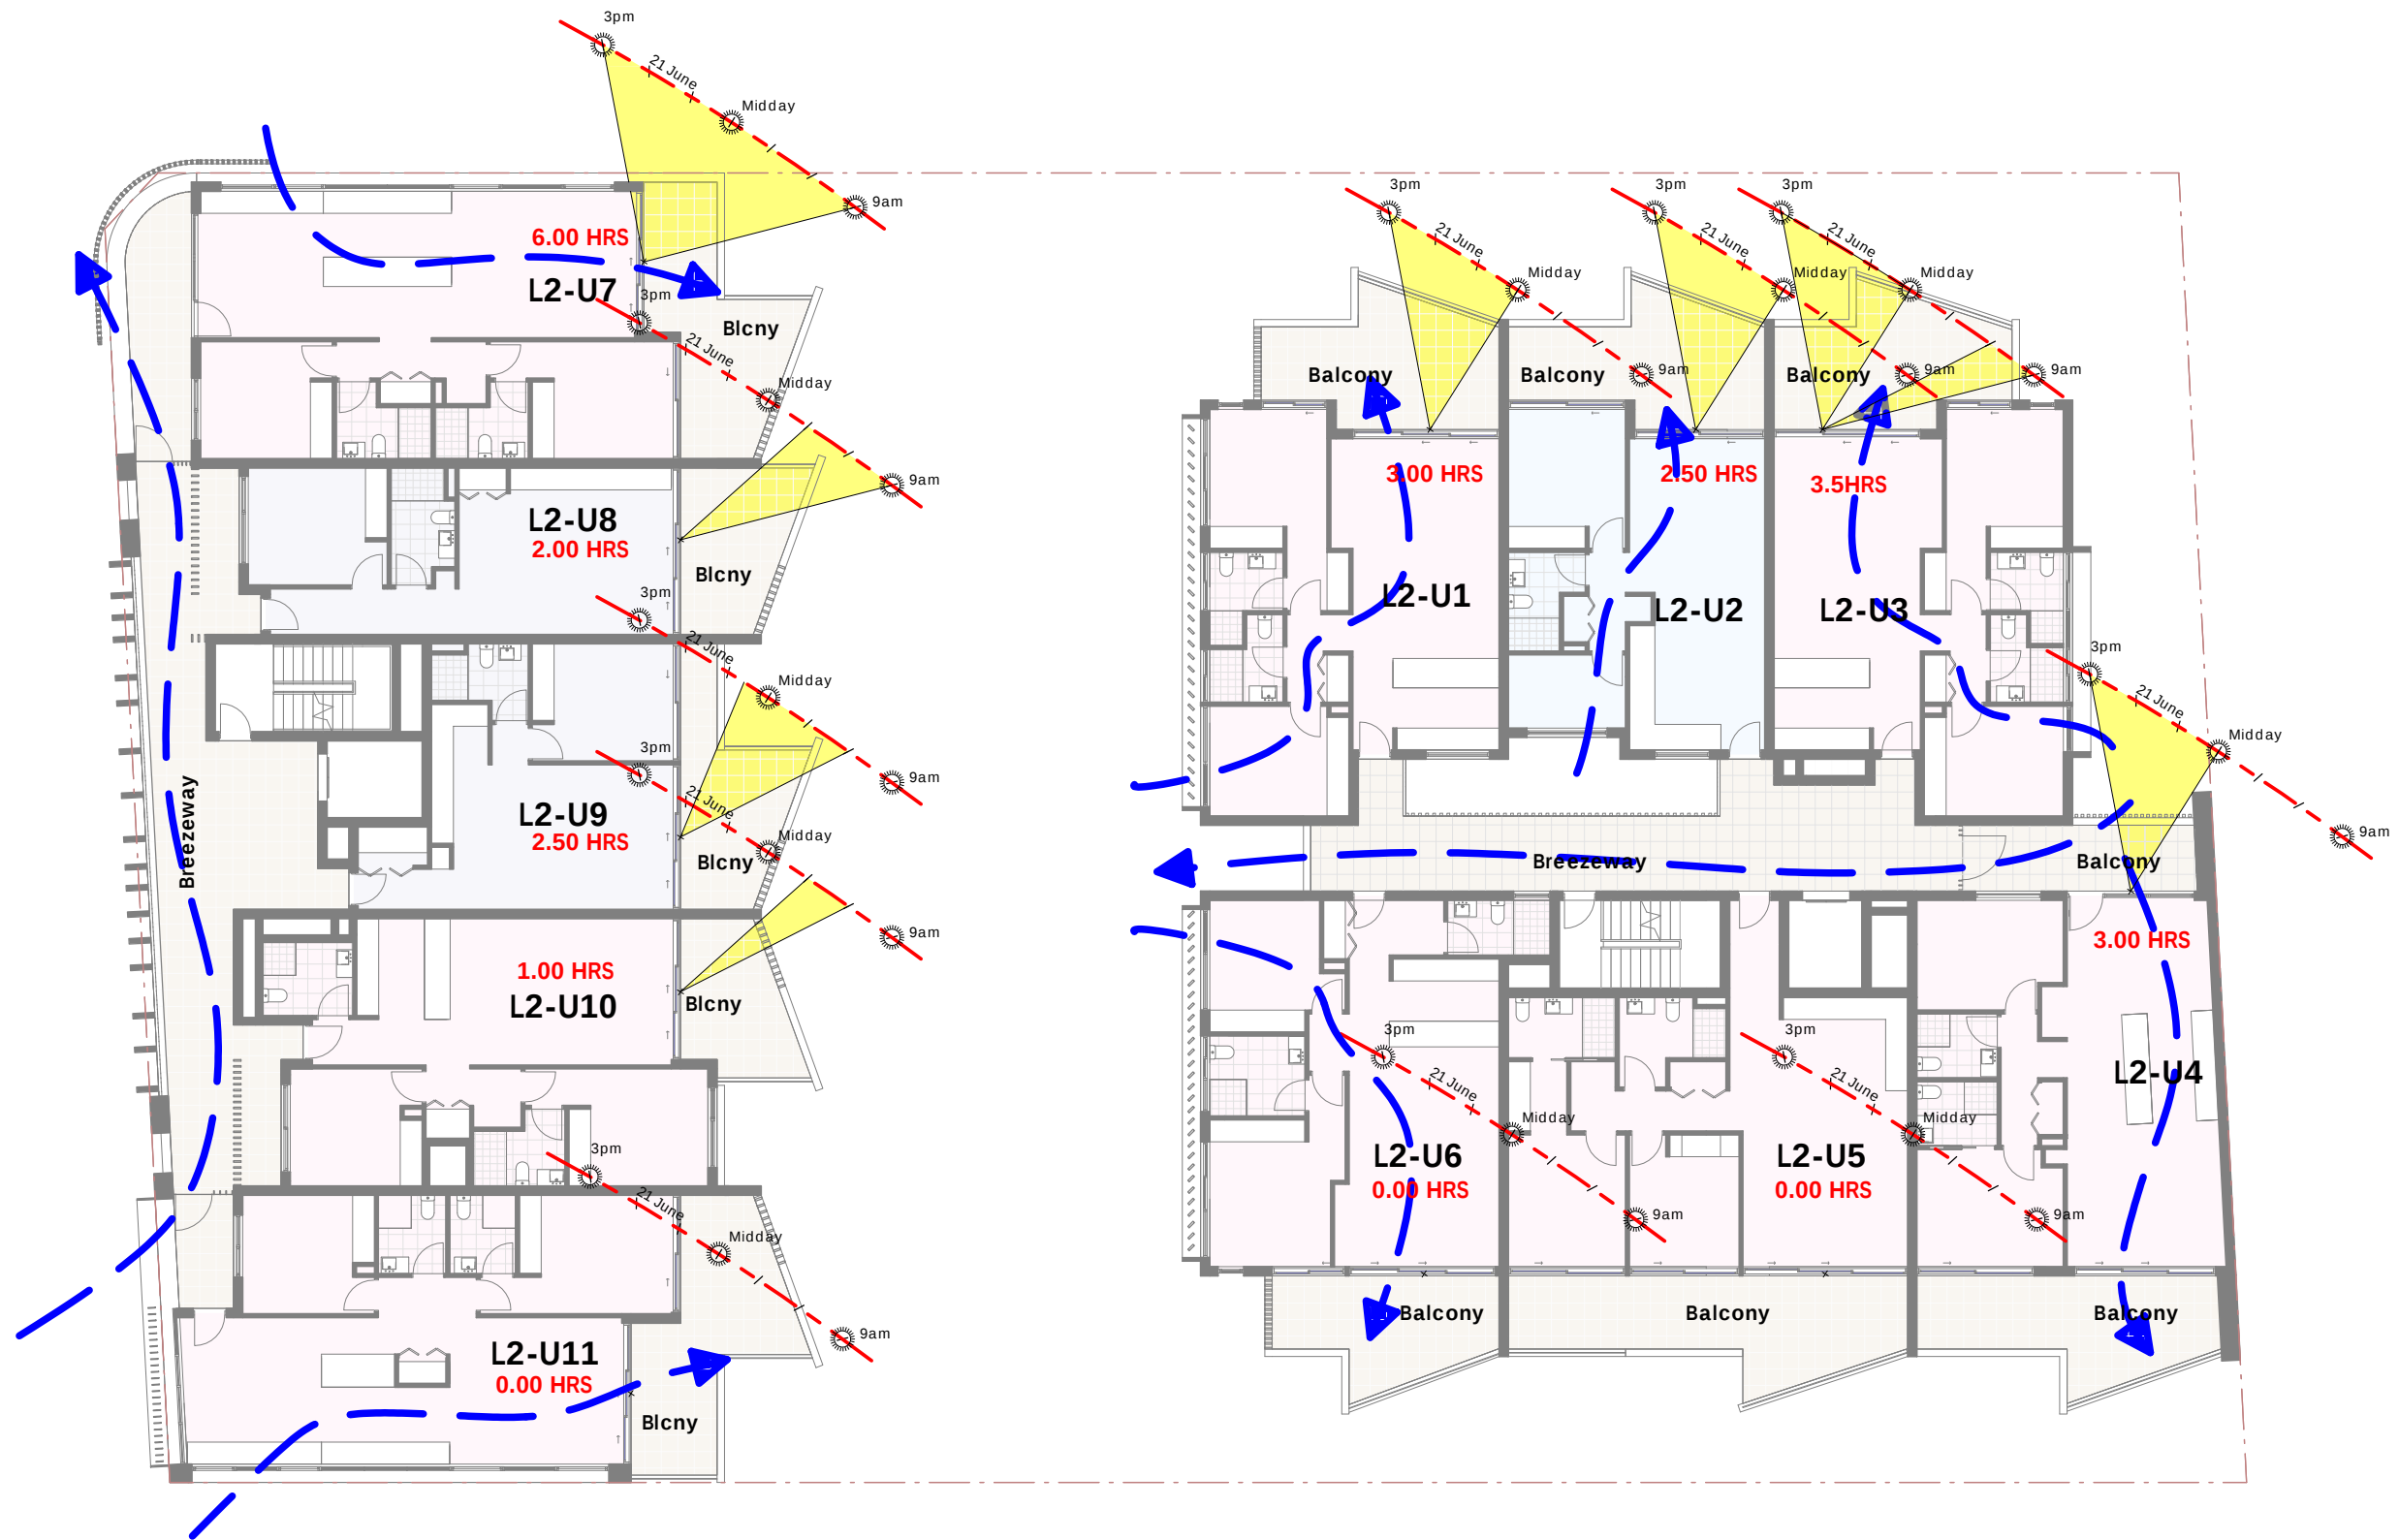



Solar Access & Natural Ventilation (Level 2 Floor Plan)
1:200

Rev. #	Description	Date		 The Architect retains copyright. Authority should be requested for any reproductions	Client	Consultants	 alec pappas architects Pty Ltd	ABN: 60 050 064 045 Level 1, 12 Mashman Avenue Kingsgrove NSW 2208 ph: (02) 9554 8233 fx: (02) 9554 8244 em: info@alecpappas.com.au web: www.alecpappas.com.au nominated Architect: Alec Pappas (Registration No: 4713) 	Project	Date			
A	Council Amendments	Oct '17			Gaidra Pty Ltd	GSA Planning (Urban Planner) Structural Design Solutions (Structural) LAM Consulting Engineers (Stormwater) Building & Energy Consultants Australia (BASIX)			Proposed Mixed Use Development 850-858 King Georges Rd South Hurstville	Mar' 17			
					DESIGN INTENT FOR COUNCIL (DA)		Alec Pappas Architects Pty Ltd		Solar & Natural Ventilation		Scale Job No. 1 : 200 J09-16		
									Title SV-05		Dwg No. Revision A		

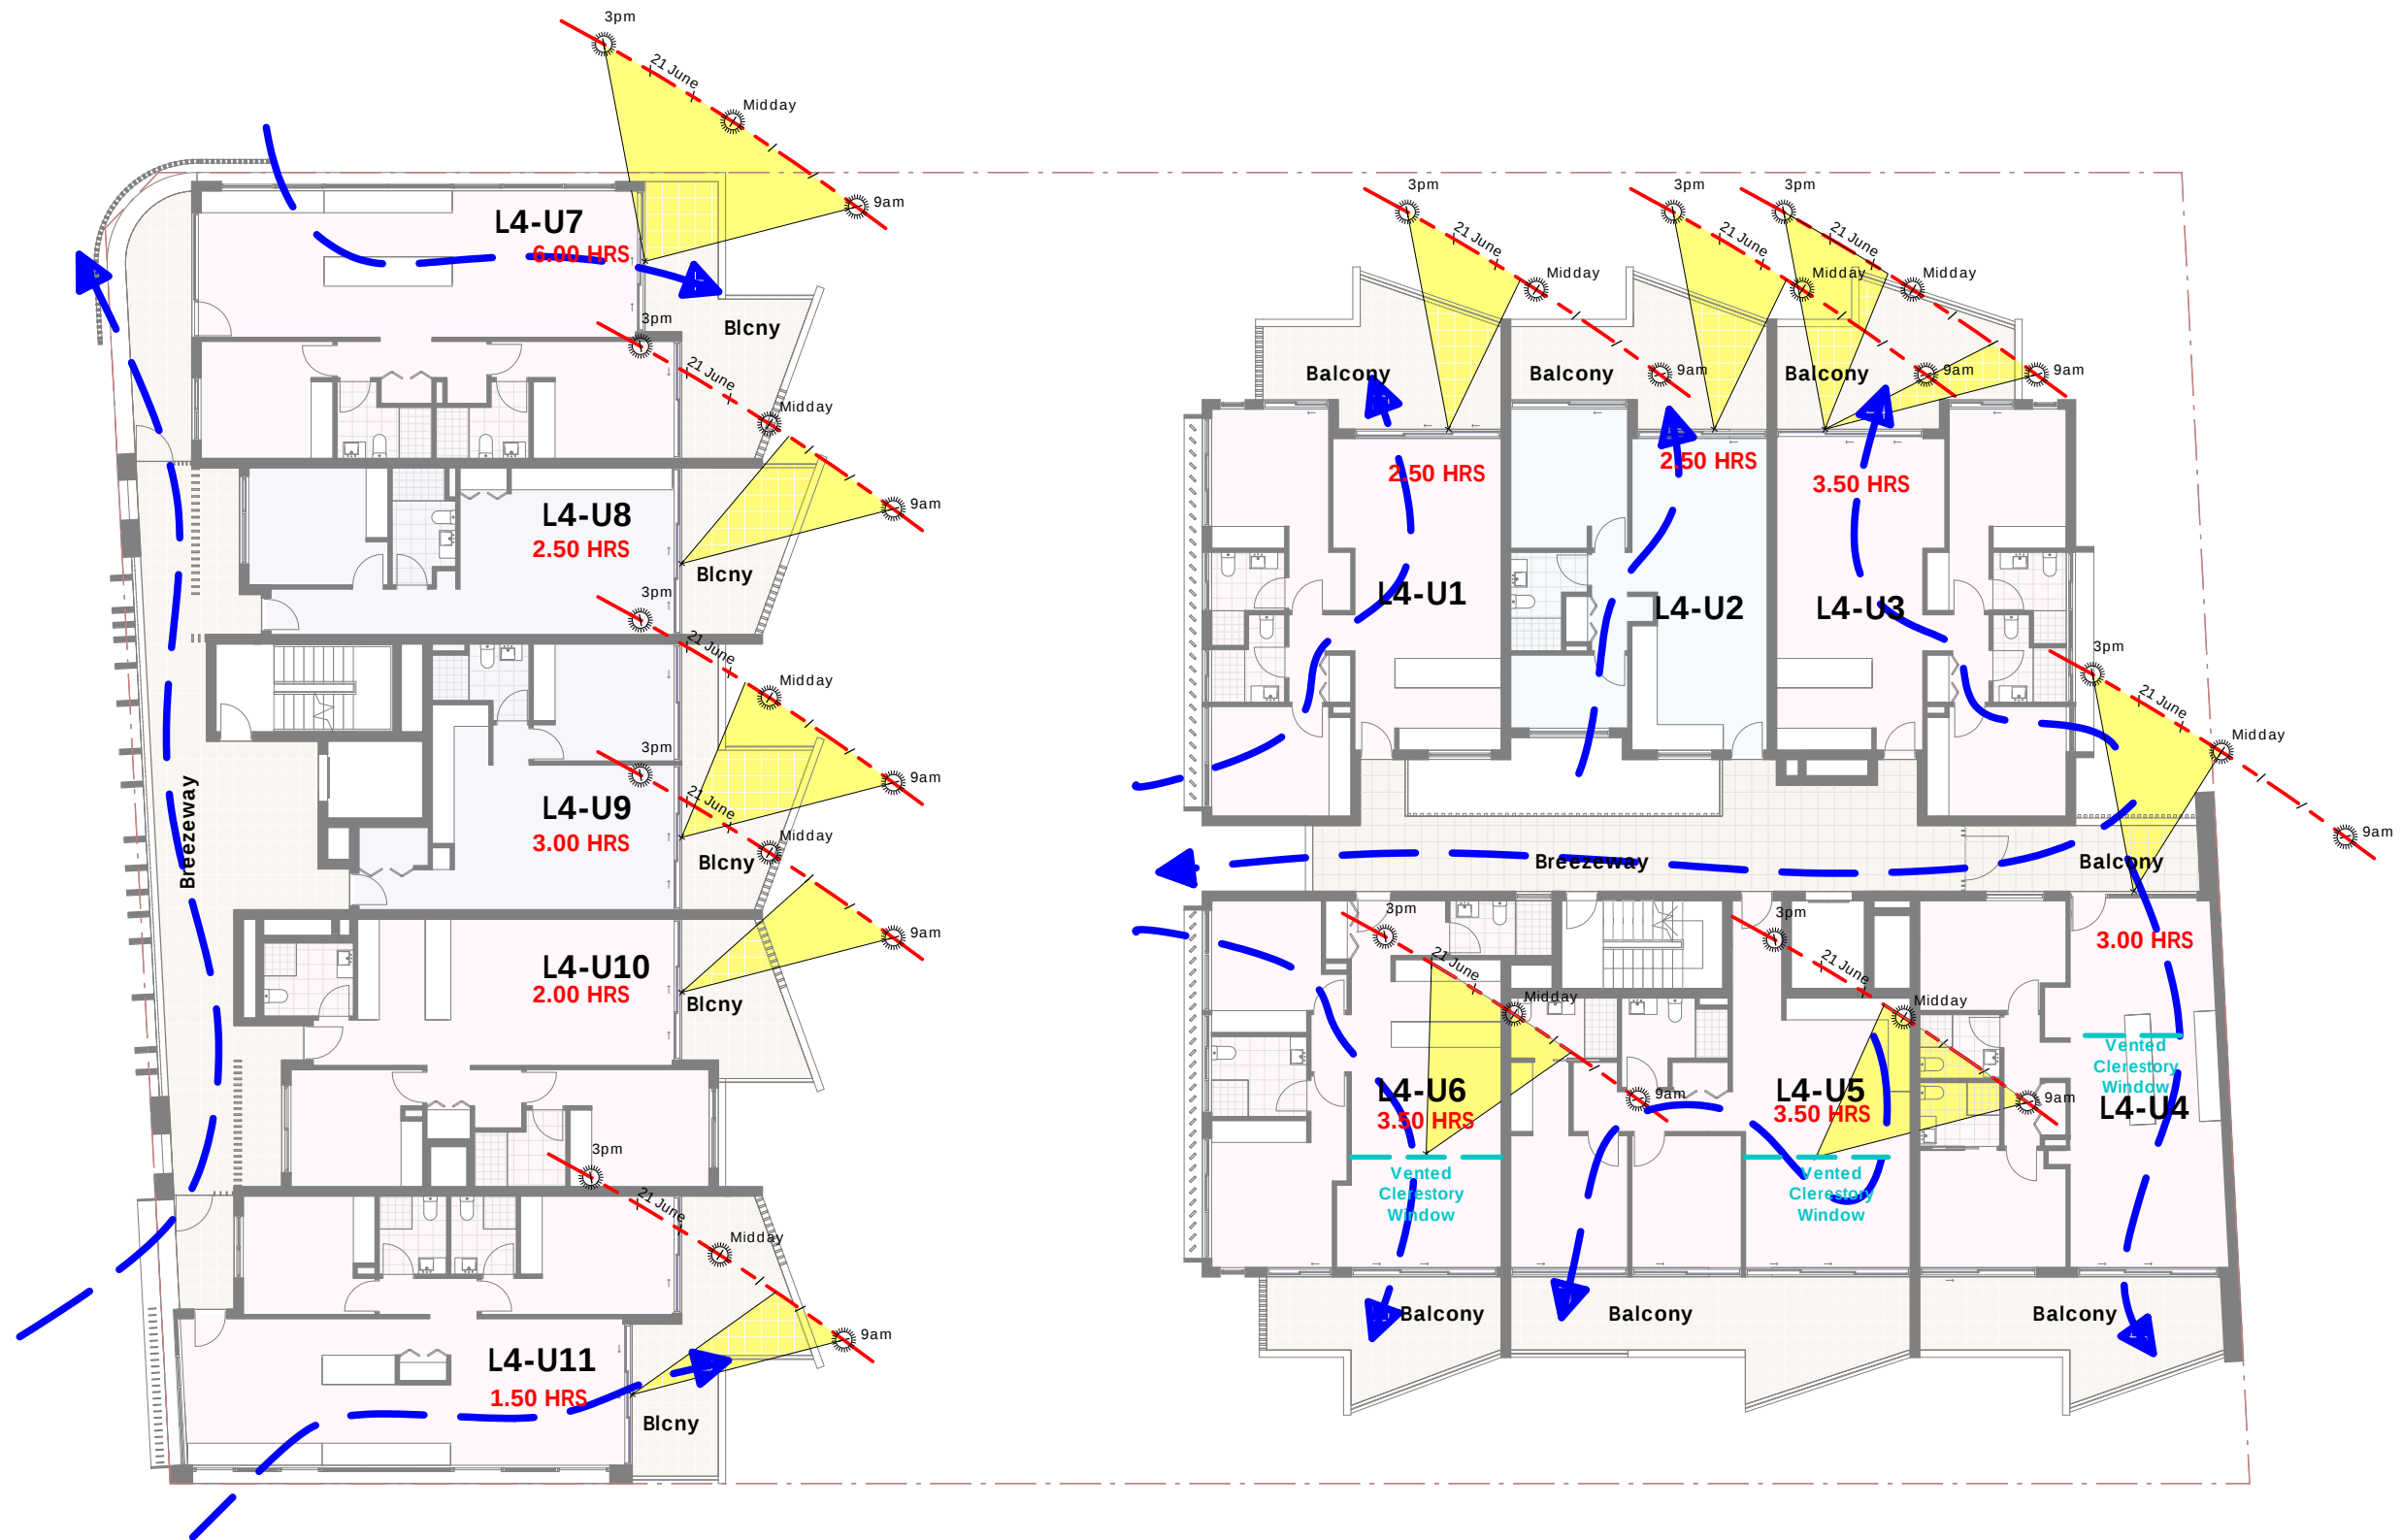


Solar Access & Natural Ventilation (Level 4 Floor Plan)
1:200

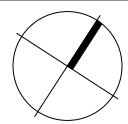Rev. #	Description	Date		Client Gaidra Pty Ltd	Consultants GSA Planning (Urban Planner) Structural Design Solutions (Structural) LAM Consulting Engineers (Stormwater) Building & Energy Consultants Australia (BASIX)	 alec pappas architects Pty Ltd ABN: 60 050 064 045 Level 1, 12 Mashman Avenue Kingsgrove NSW 2208 ph: (02) 9554 8233 fx: (02) 9554 8244 em: info@alecpappas.com.au web: www.alecpappas.com.au nominated Architect: Alec Pappas (Registration No: 4713)  Member Australian Institute of Architects	Project Proposed Mixed Use Development 850-858 King Georges Rd South Hurstville	Title Solar & Natural Ventilation	Date Mar' 17	Scale Job No. 1 : 200 J09-16
A	Council Amendments	Oct '17								
© The Architect retains copyright. Authority should be requested for any reproductions			DESIGN INTENT FOR COUNCIL (DA)		Alec Pappas Architects Pty Ltd					

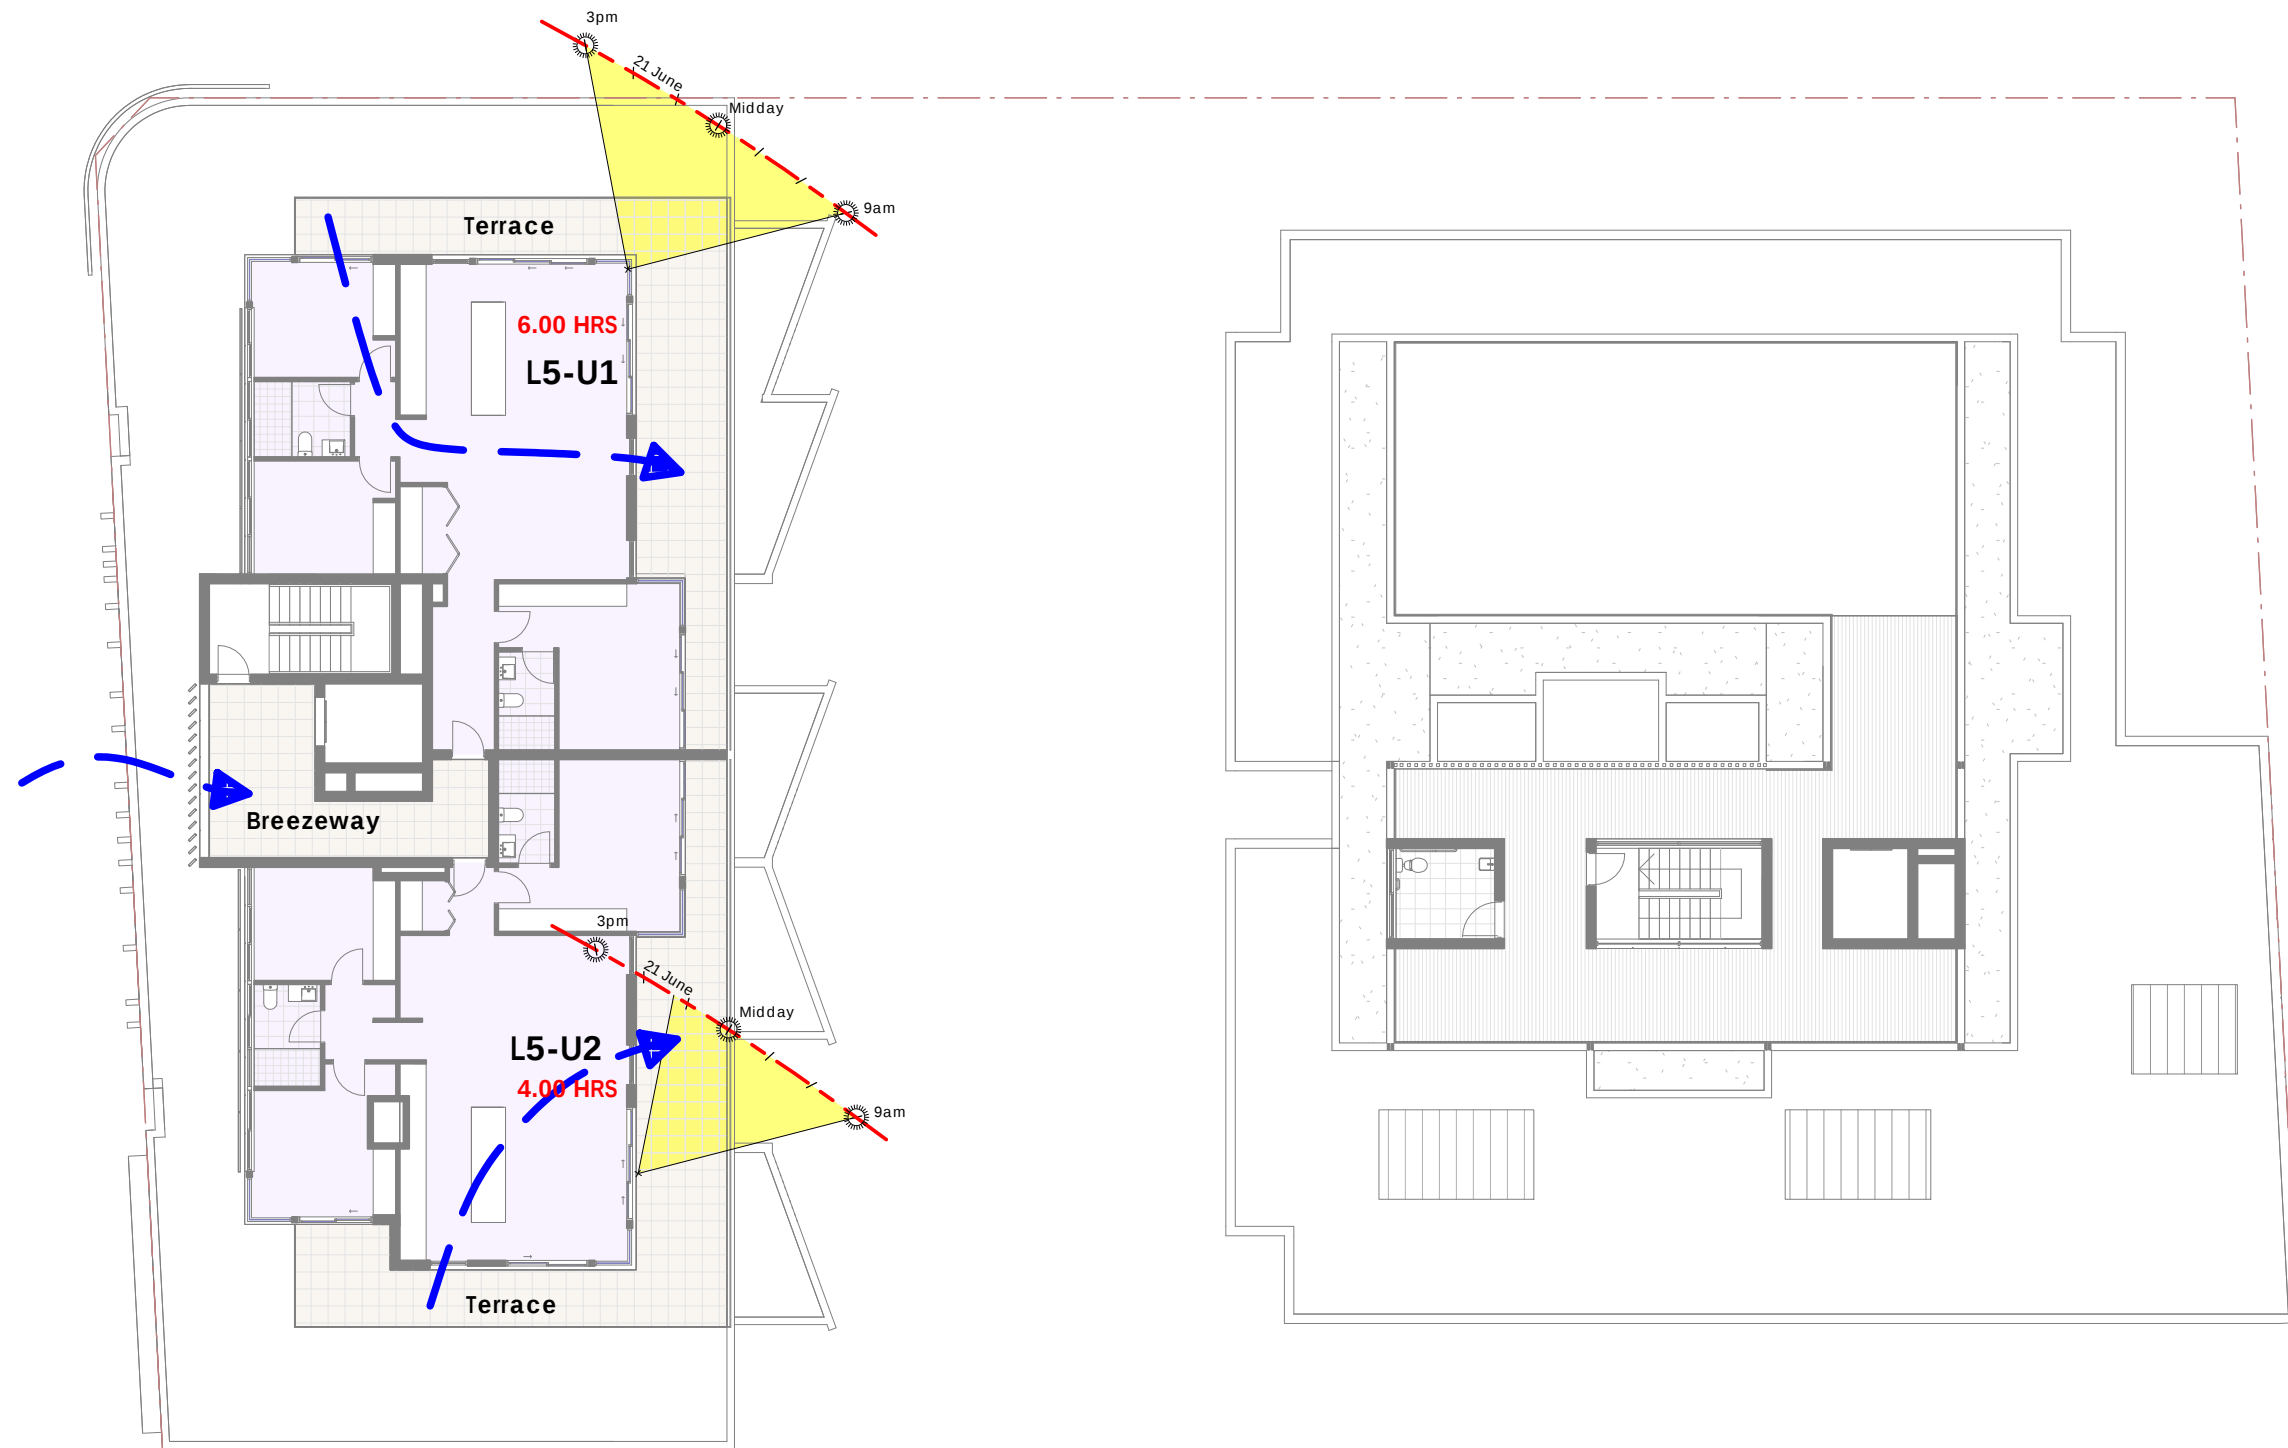

Solar Access & Natural Ventilation (Level 5 Floor Plan)

 1:200

Rev. #	Description	Date		Client Gaidra Pty Ltd	Consultants GSA Planning (Urban Planner) Structural Design Solutions (Structural) LAM Consulting Engineers (Stormwater) Building & Energy Consultants Australia (BASIX)	 alec pappas architects Pty Ltd ABN: 60 050 064 045 Level 1, 12 Mashman Avenue Kingsgrove NSW 2208 ph: (02) 9554 8233 fx: (02) 9554 8244 em: info@alecpappas.com.au web: www.alecpappas.com.au nominated Architect: Alec Pappas (Registration No: 4713)	 Member Australian Institute of Architects	Project Proposed Mixed Use Development 850-858 King Georges Rd South Hurstville	Date Mar' 17 Scale 1 : 200 Job No. J09-16
A	Council Amendments	Oct '17							
© The Architect retains copyright. Authority should be requested for any reproductions			DESIGN INTENT FOR COUNCIL (DA)			Alec Pappas Architects Pty Ltd		Title Solar & Natural Ventilation	Dwg No. SV-08 Revision A