


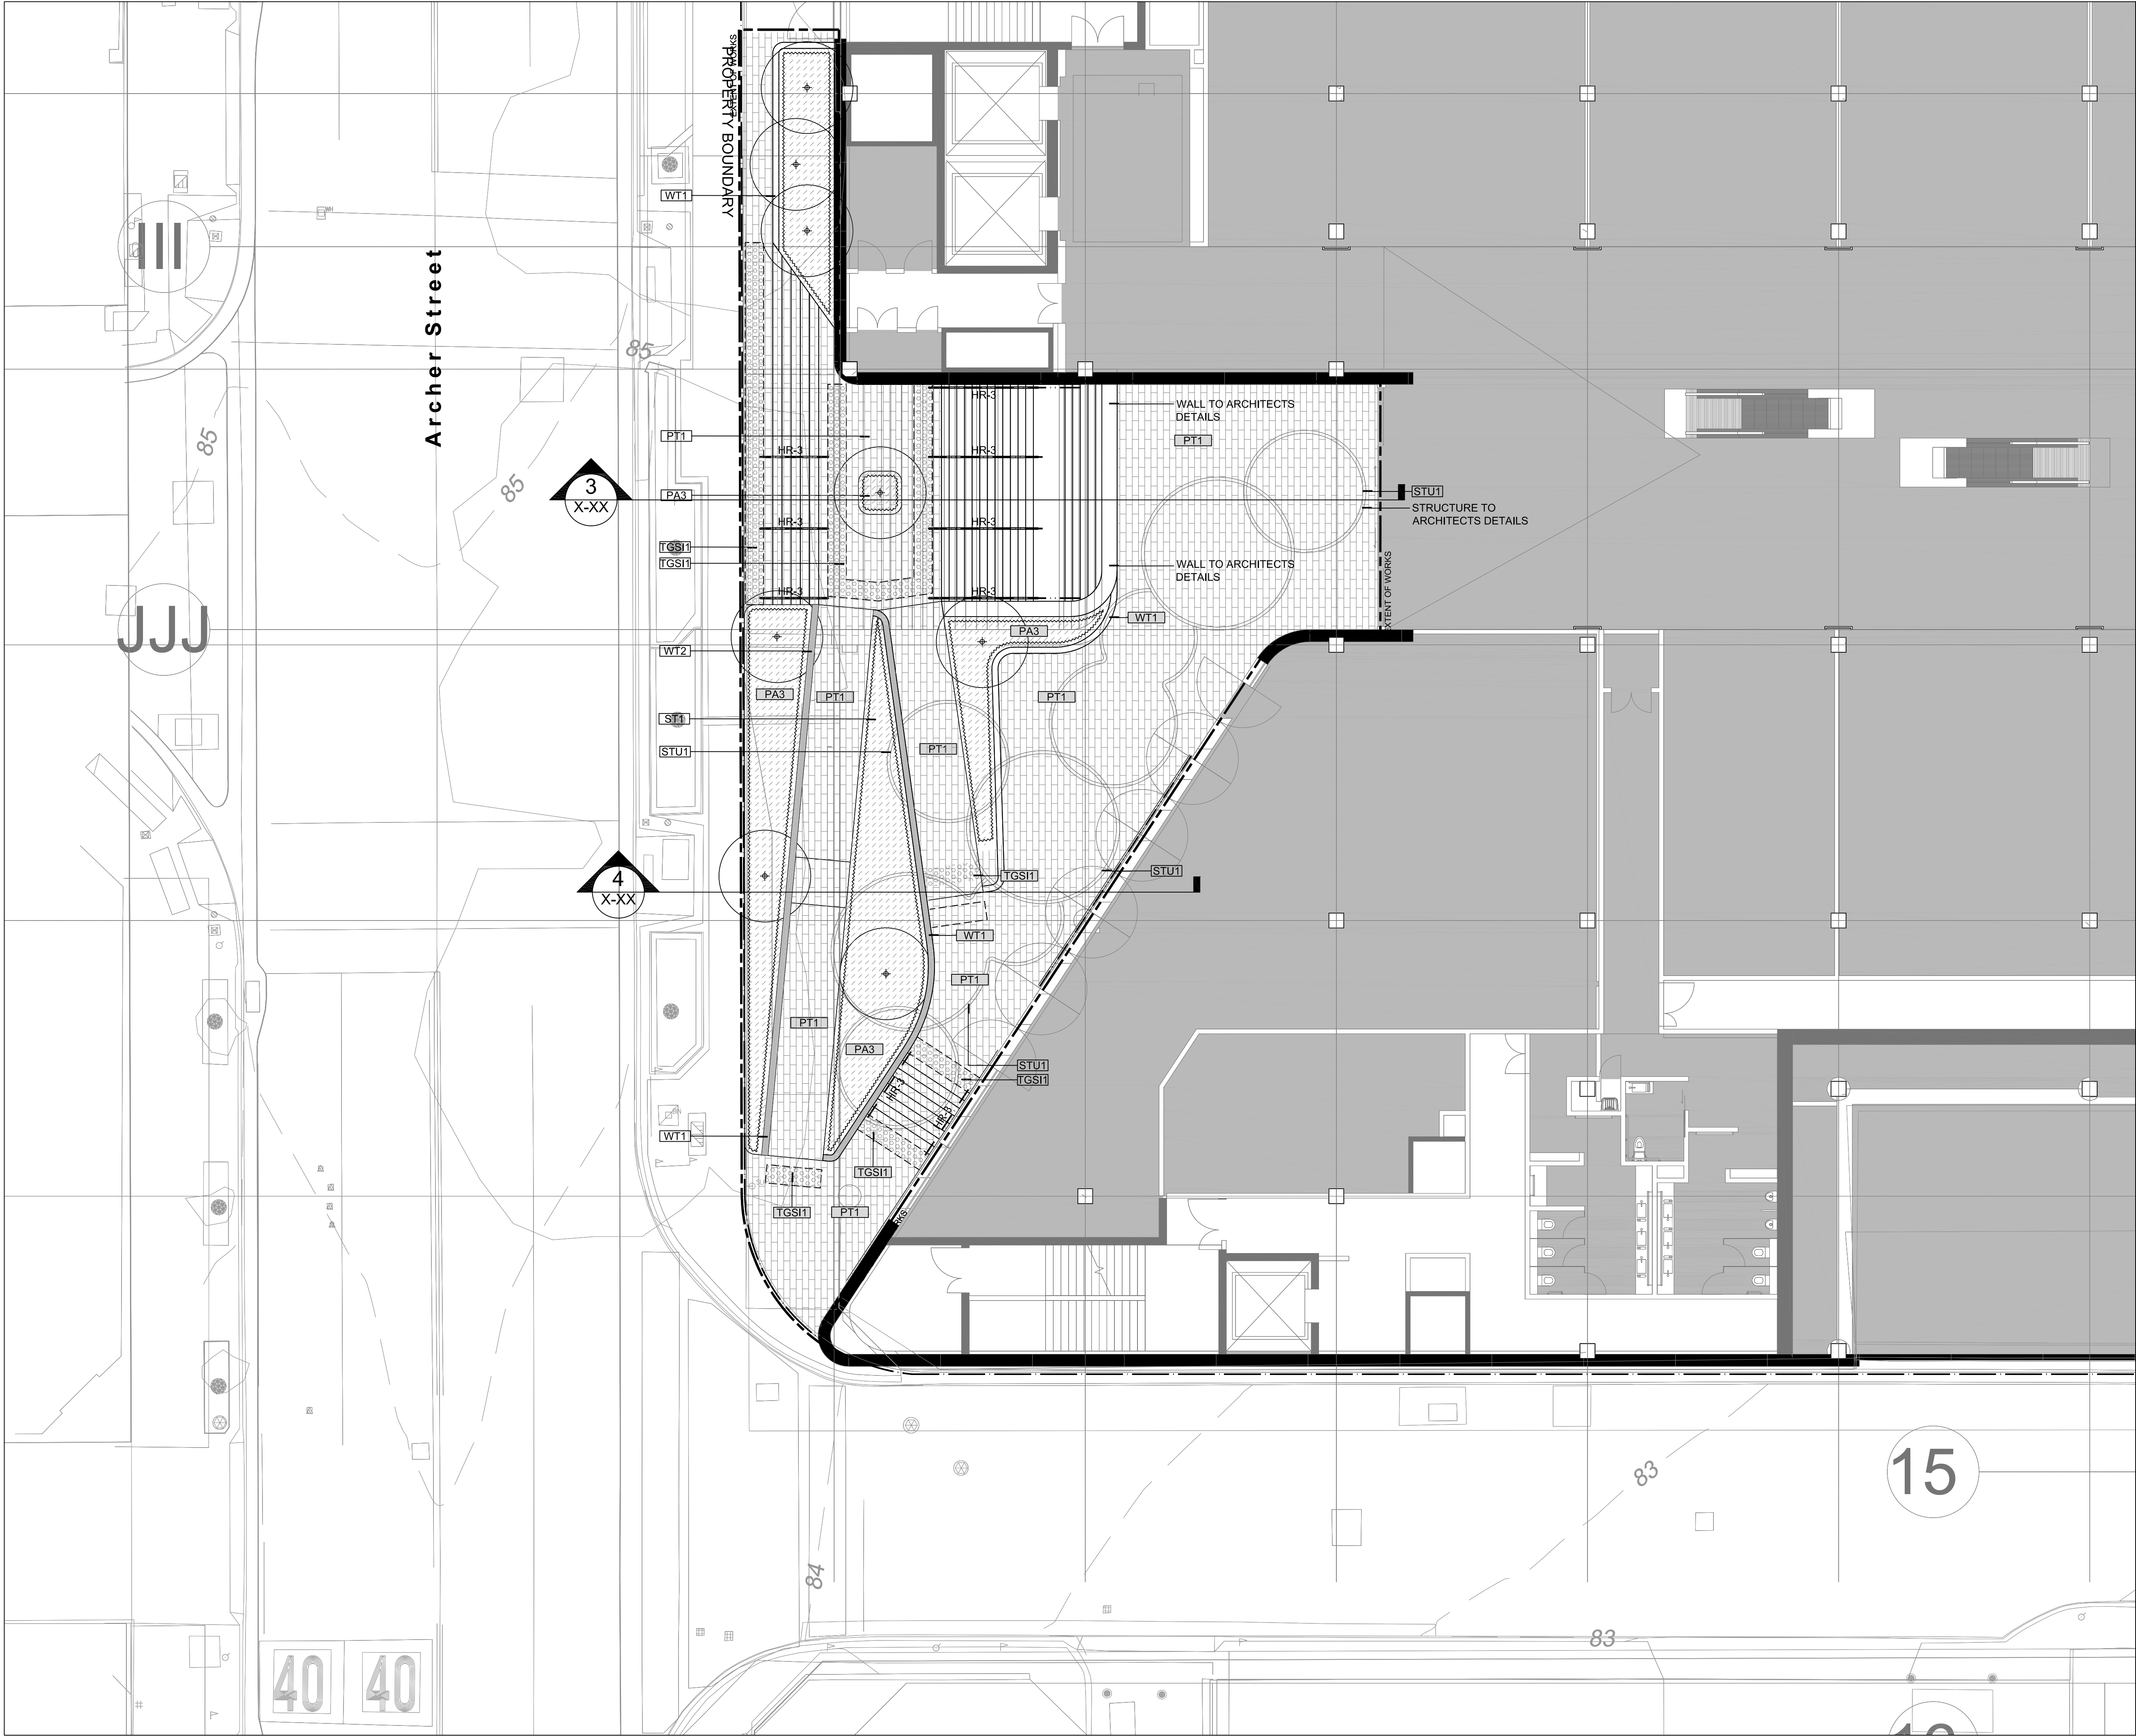

REV	DESCRIPTION	DATE
01	DRAFT 50% DOC	02.11.18
02	UPDATED DA	13.05.19
THIS DRAWING IS TO BE READ IN CONJUNCTION WITH DETAILS AND SPECIFICATIONS PREPARED BY LAT27 PTY LTD. PRIOR TO UNDERTAKING ANY CONSTRUCTION, ANY CONFLICTS THAT EXIST ON THIS DRAWING, OR ADVICE AND DIRECTION REQUIRED SHOULD BE SOUGHT FROM LAT27 PTY LTD.		
1. ALL STRUCTURAL, CIVIL, HYDRAULIC AND ELECTRICAL INFORMATION INDICATED ON THIS DRAWING IS OUTSIDE THE DEFINED SCOPE OF LAT27. ALL CONSULTANT INFORMATION SHOWN IS FOR COORDINATION PURPOSES ONLY AND REFERENCE IS TO BE MADE TO THE RELEVANT CONSULTANTS DRAWINGS AND SPECIFICATIONS ACCORDINGLY FOR CONSTRUCTION.		
2. FIGURED DIMENSIONS TAKE PRECEDENCE OVER SCALED.		
3. CHECK ALL DIMENSIONS ON SITE PRIOR TO COMMENCEMENT OF WORK.		
© COPYRIGHT LAT27 PTY LTD ALL RIGHTS RESERVED. THIS DRAWING MAY NOT BE PRODUCED OR TRANSMITTED IN ANY FORM OR BY ANY MEANS IN PART OR IN WHOLE WITHOUT THE WRITTEN PERMISSION OF LAT27 PTY LTD		

NOT FOR CONSTRUCTION


07 3236 1086
Level 5, 300 Ann Street
Brisbane, Qld 4000
www.lat27.com.au

lat²⁷

CLIENT

VICINITY CENTRES

PROJECT TITLE CHATSWOOD CHASE		
DRAWING TITLE GROUND - C1 FINISHES PLAN - SHEET 1		
SCALE BAR SCALE 1:100 @ A1 0m 1.0 2.0 3.0 4.0 5.0 SCALE 1:200 @ A3		
PROJECT No. 17140.01	SCALE 1:100	
DRAWN BY ST	VERIFIER NW	
DRAWING No. LA-LAT-DRG-00-C1-0101	REVISION 02	

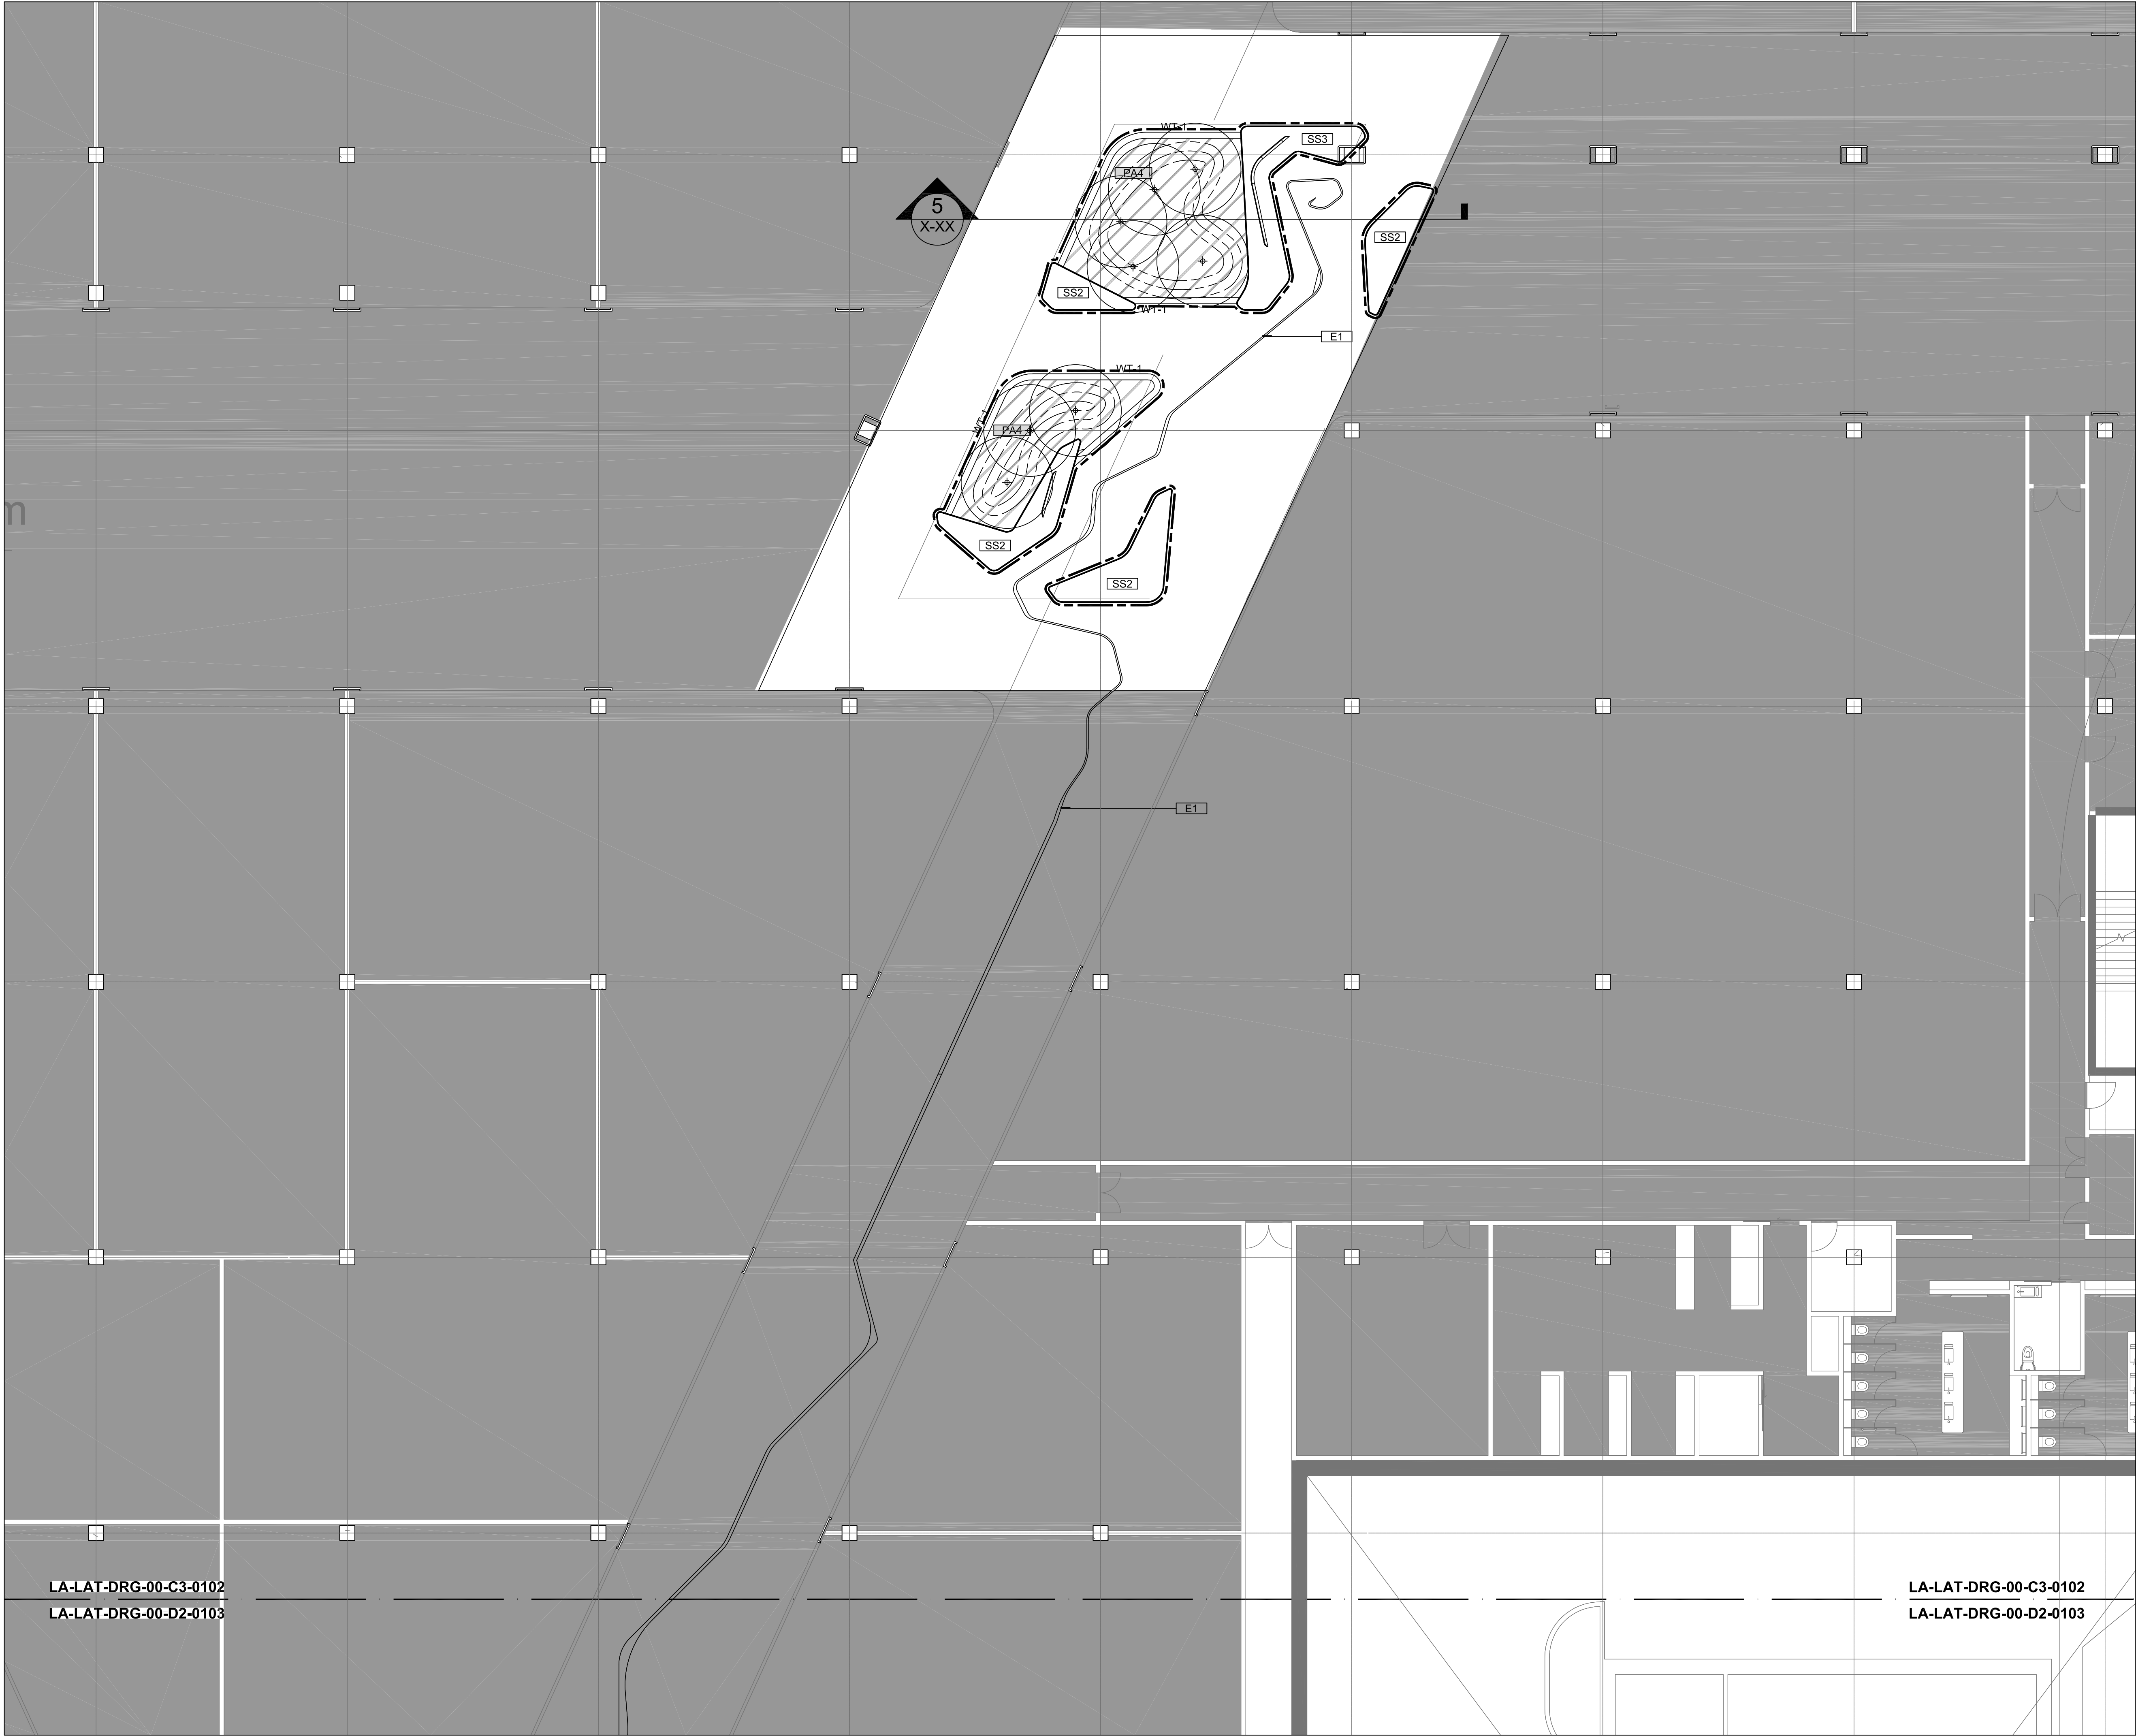

REV	DESCRIPTION	DATE
01	DRAFT 50% DOC	02.11.18
02	UPDATED DA	13.05.19

THIS DRAWING IS TO BE READ IN CONJUNCTION WITH DETAILS AND SPECIFICATIONS PREPARED BY LAT27 PTY LTD. PRIOR TO UNDERTAKING ANY CONSTRUCTION, ANY CONFLICTS THAT EXIST ON THIS DRAWING, OR ADVICE AND DIRECTION REQUIRED SHOULD BE SOUGHT FROM LAT27 PTY LTD.

1. ALL STRUCTURAL, CIVIL, HYDRAULIC AND ELECTRICAL INFORMATION INDICATED ON THIS DRAWING IS OUTSIDE THE DEFINED SCOPE OF LAT27. ALL CONSULTANT INFORMATION SHOWN IS FOR COORDINATION PURPOSES ONLY AND REFERENCE IS TO BE MADE TO THE RELEVANT CONSULTANTS DRAWINGS AND SPECIFICATIONS ACCORDINGLY FOR CONSTRUCTION.

2. FIGURED DIMENSIONS TAKE PRECEDENCE OVER SCALED.

3. CHECK ALL DIMENSIONS ON SITE PRIOR TO COMMENCEMENT OF WORK.

© COPYRIGHT LAT27 PTY LTD ALL RIGHTS RESERVED. THIS DRAWING MAY NOT BE PRODUCED OR TRANSMITTED IN ANY FORM OR BY ANY MEANS IN PART OR IN WHOLE WITHOUT THE WRITTEN PERMISSION OF LAT27 PTY LTD

NOT FOR CONSTRUCTION

07 3236 1086
Level 5, 300 Ann Street
Brisbane, Qld 4000
www.lat27.com.au



CLIENT
VICINITY CENTRES



PROJECT TITLE
CHATSWOOD CHASE


DRAWING TITLE
GROUND - C3
FINISHES PLAN - SHEET 2

SCALE BAR
SCALE 1:100 @ A1
0m 1.0 2.0 3.0 4.0 5.0
SCALE 1:200 @ A3

PROJECT No. 17140.01	SCALE 1:100	
DRAWN BY ST	VERIFIER NW	
DRAWING No. LA-LAT-DRG-00-C3-0102	REVISION 02	

LA-LAT-DRG-00-C3-0102
LA-LAT-DRG-00-D2-0103

LA-LAT-DRG-00-C3-0102
LA-LAT-DRG-00-D2-0103

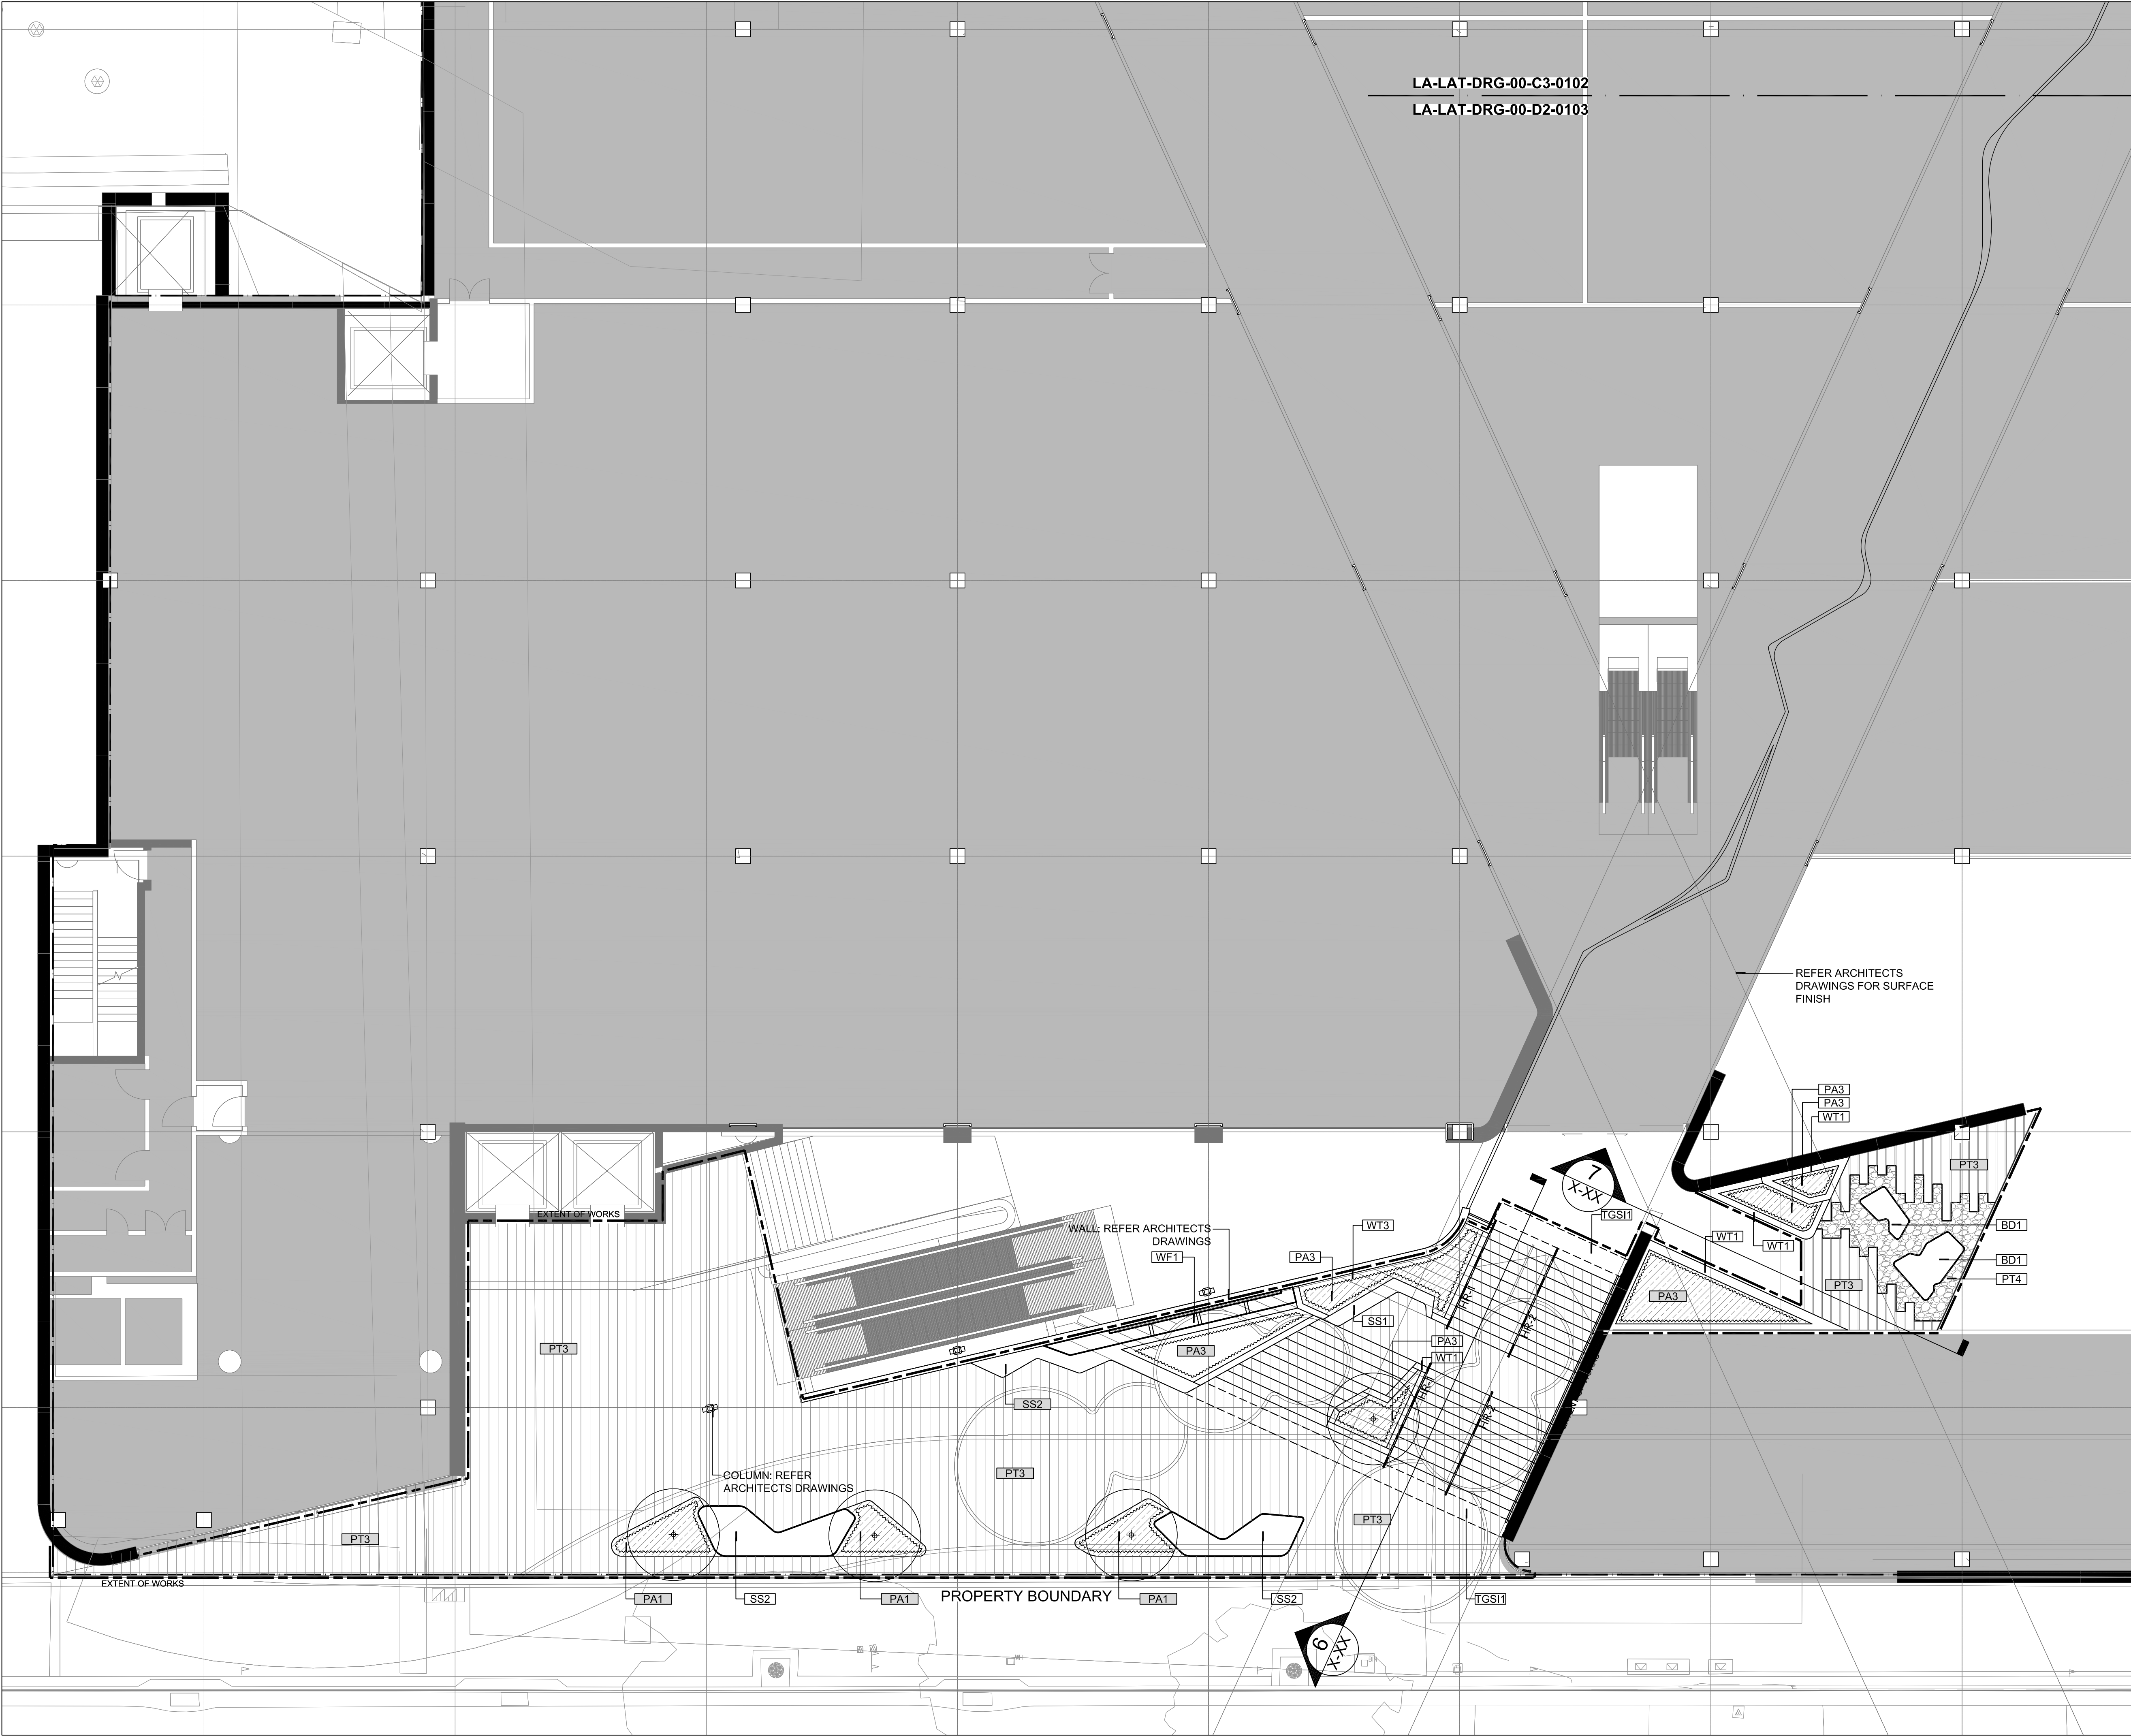

REV	DESCRIPTION	DATE
01	DRAFT 50% DOC	02.11.18
02	UPDATED DA	13.05.19

THIS DRAWING IS TO BE READ IN CONJUNCTION WITH DETAILS AND SPECIFICATIONS PREPARED BY LAT27 PTY LTD. PRIOR TO UNDERTAKING ANY CONSTRUCTION, ANY CONFLICTS THAT EXIST ON THIS DRAWING, OR ADVICE AND DIRECTION REQUIRED SHOULD BE SOUGHT FROM LAT27 PTY LTD.

1. ALL STRUCTURAL, CIVIL, HYDRAULIC AND ELECTRICAL INFORMATION INDICATED ON THIS DRAWING IS OUTSIDE THE DEFINED SCOPE OF LAT27. ALL CONSULTANT INFORMATION SHOWN IS FOR COORDINATION PURPOSES ONLY AND REFERENCE IS TO BE MADE TO THE RELEVANT CONSULTANTS DRAWINGS AND SPECIFICATIONS ACCORDINGLY FOR CONSTRUCTION.

2. FIGURED DIMENSIONS TAKE PRECEDENCE OVER SCALED.

3. CHECK ALL DIMENSIONS ON SITE PRIOR TO COMMENCEMENT OF WORK.

© COPYRIGHT LAT27 PTY LTD ALL RIGHTS RESERVED. THIS DRAWING MAY NOT BE PRODUCED OR TRANSMITTED IN ANY FORM OR BY ANY MEANS IN PART OR IN WHOLE WITHOUT THE WRITTEN PERMISSION OF LAT27 PTY LTD

NOT FOR CONSTRUCTION

07 3236 1086
Level 5, 300 Ann Street
Brisbane, Qld 4000
www.lat27.com.au

lat^{27°}

VICINITY CENTRES

PROJECT TITLE
CHATSWOOD CHASE

DRAWING TITLE
GROUND - D2
FINISHES PLAN - SHEET 3

SCALE BAR
SCALE 1:100 @ A1
0m 1.0 2.0 3.0 4.0 5.0
SCALE 1:200 @ A3

PROJECT No.
17140.01


SCALE
1:100

DRAWN BY
ST

VERIFIER
NW

DRAWING No.
LA-LAT-DRG-00-D2-0103

REVISION
02

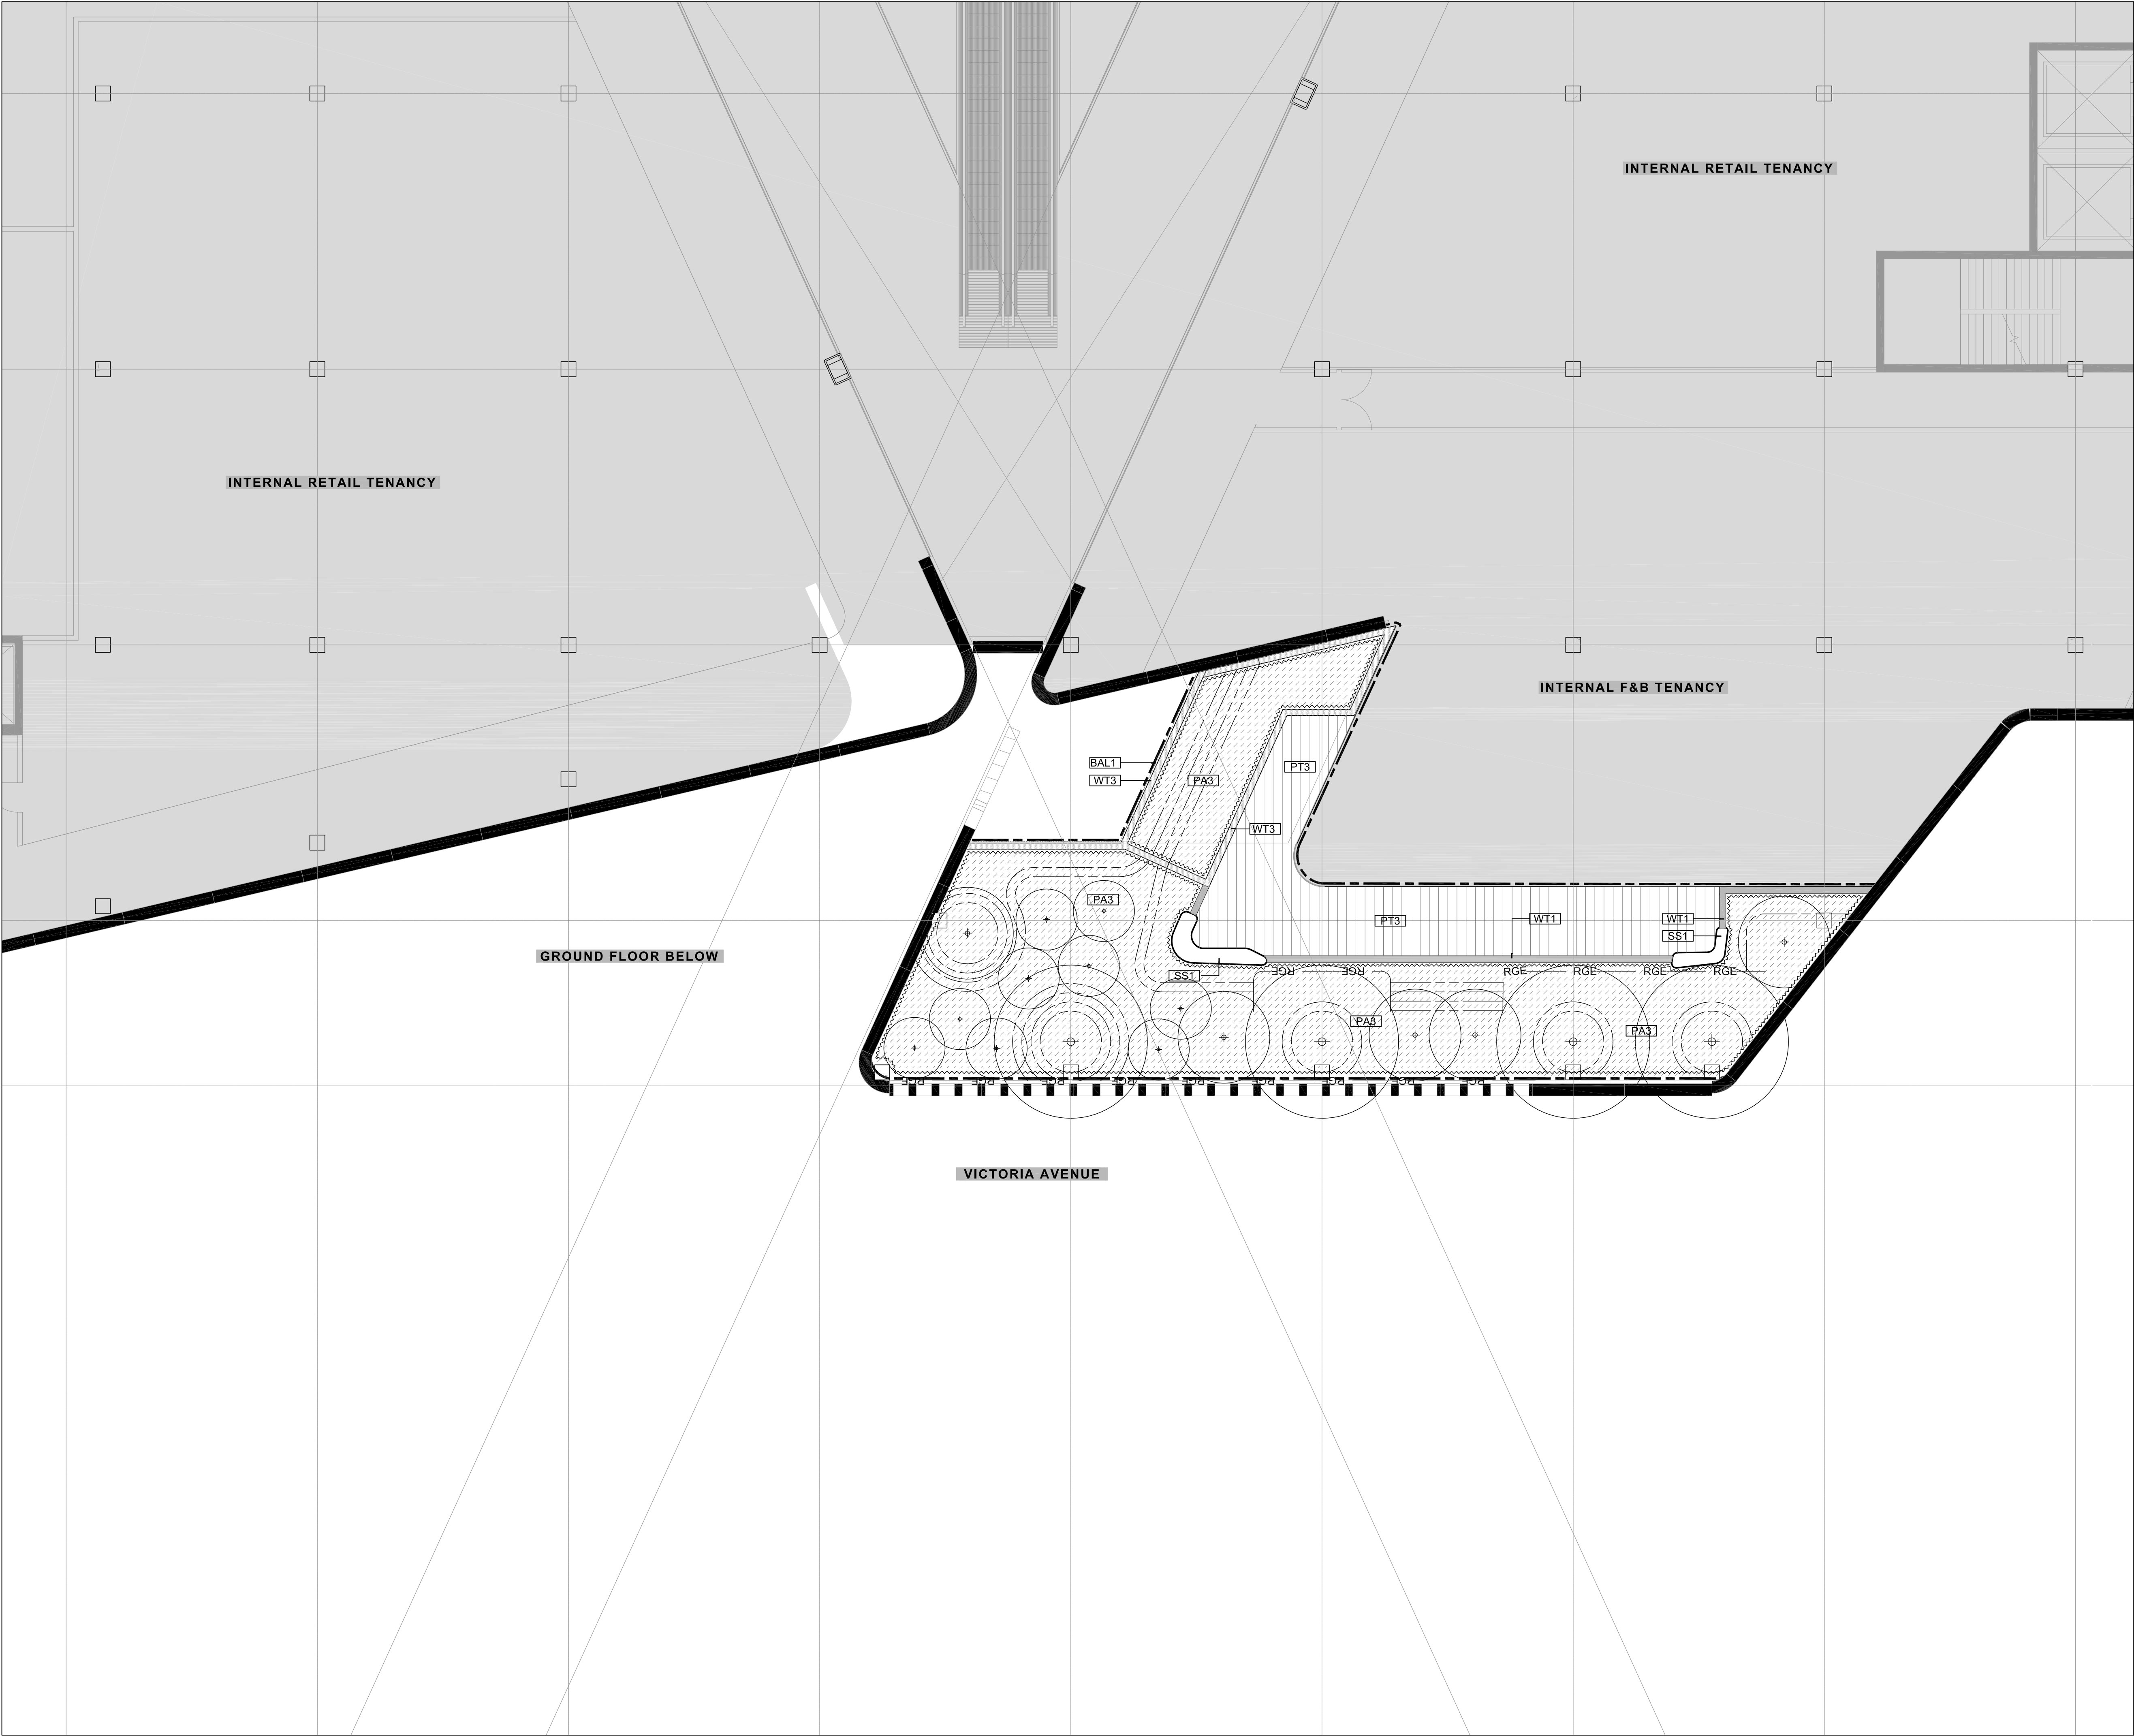

REV	DESCRIPTION	DATE
01	DRAFT 50% DOC	02.11.18
02	UPDATED DA	13.05.19
THIS DRAWING IS TO BE READ IN CONJUNCTION WITH DETAILS AND SPECIFICATIONS PREPARED BY LAT27 PTY LTD. PRIOR TO UNDERTAKING ANY CONSTRUCTION, ANY CONFLICTS THAT EXIST ON THIS DRAWING, OR ADVICE AND DIRECTION REQUIRED SHOULD BE SOUGHT FROM LAT27 PTY LTD.		
1. ALL STRUCTURAL, CIVIL, HYDRAULIC AND ELECTRICAL INFORMATION INDICATED ON THIS DRAWING IS OUTSIDE THE DEFINED SCOPE OF LAT27. ALL CONSULTANT INFORMATION SHOWN IS FOR COORDINATION PURPOSES ONLY AND REFERENCE IS TO BE MADE TO THE RELEVANT CONSULTANTS DRAWINGS AND SPECIFICATIONS ACCORDINGLY FOR CONSTRUCTION.		
2. FIGURED DIMENSIONS TAKE PRECEDENCE OVER SCALED.		
3. CHECK ALL DIMENSIONS ON SITE PRIOR TO COMMENCEMENT OF WORK.		
© COPYRIGHT LAT27 PTY LTD ALL RIGHTS RESERVED. THIS DRAWING MAY NOT BE PRODUCED OR TRANSMITTED IN ANY FORM OR BY ANY MEANS IN PART OR IN WHOLE WITHOUT THE WRITTEN PERMISSION OF LAT27 PTY LTD		

NOT FOR CONSTRUCTION

07 3236 1086
Level 5, 300 Ann Street
Brisbane, Qld 4000
www.lat27.com.au



CLIENT

VICINITY CENTRES



PROJECT TITLE


CHATSWOOD CHASE


DRAWING TITLE

LEVEL 1 - D2
FINISHES PLAN - SHEET 1

SCALE BAR

SCALE 1:100 @ A1
0m 1.0 2.0 3.0 4.0 5.0
SCALE 1:200 @ A3

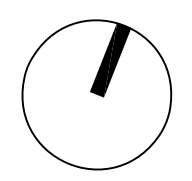PROJECT No. 17140.01	SCALE 1:100	
DRAWN BY ST	VERIFIER NW	
DRAWING No. LA-LAT-DRG-01-D2-0101	REVISION 02	

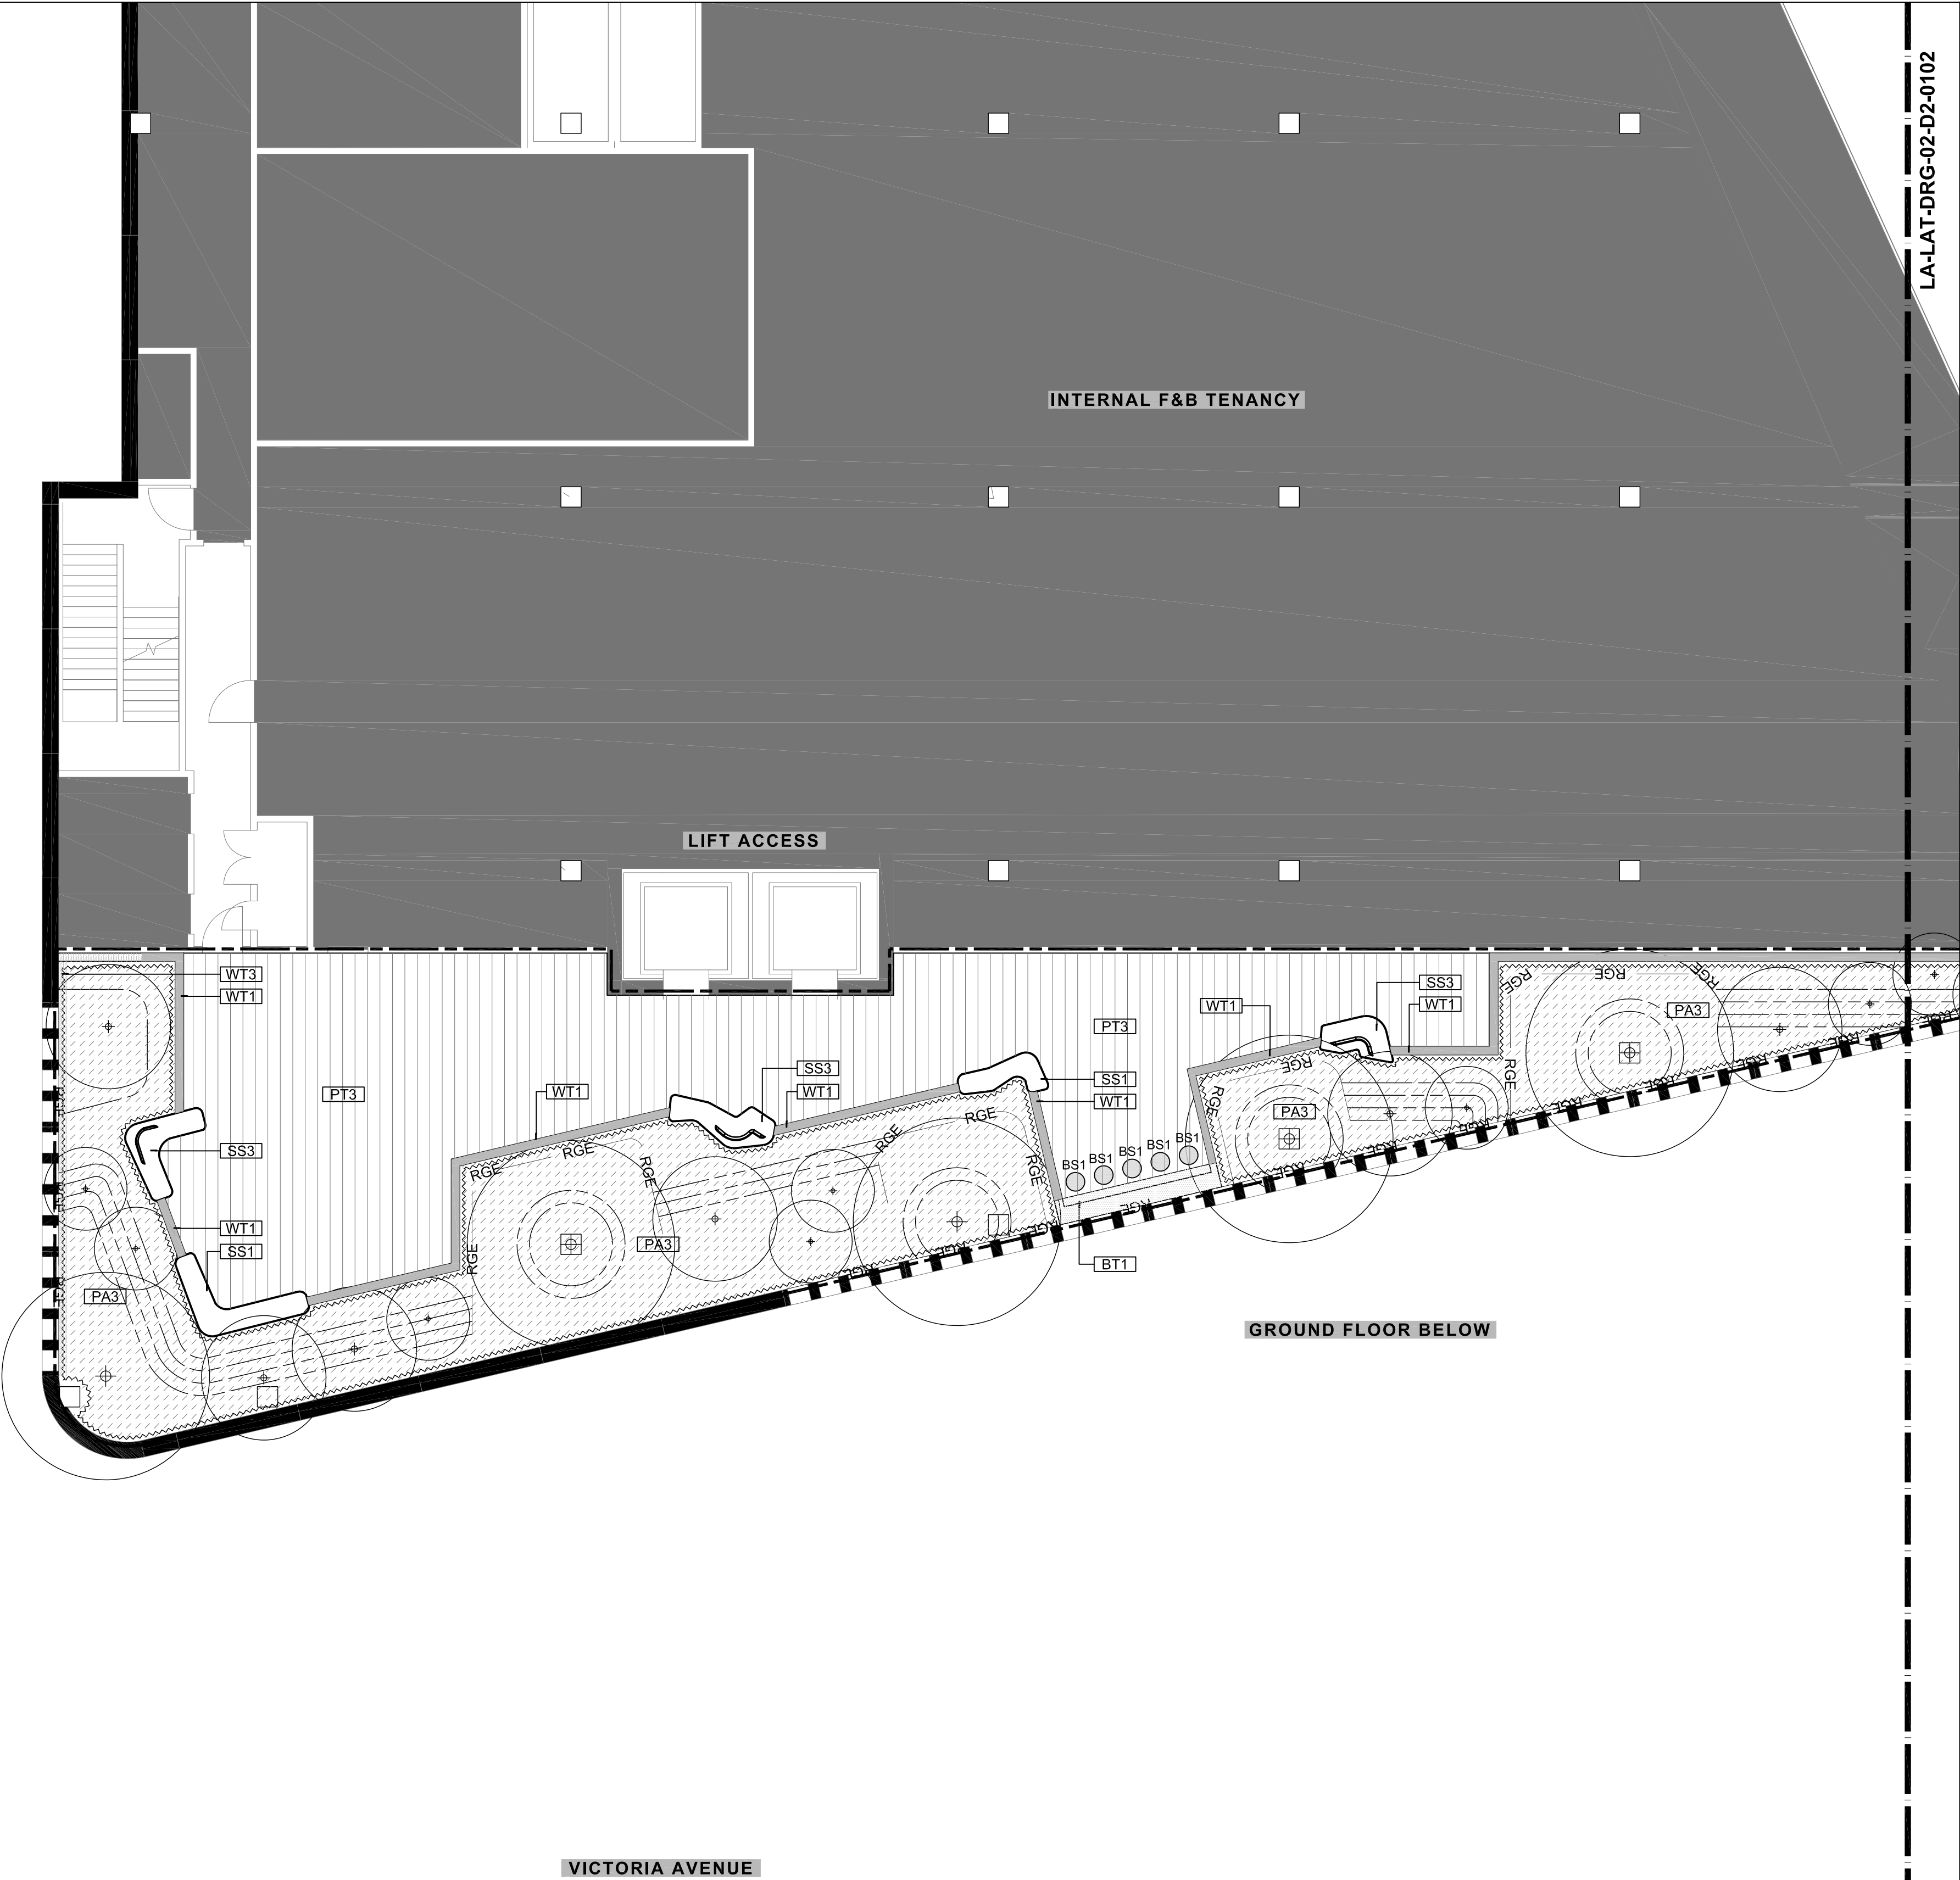

REV	DESCRIPTION	DATE
01	DRAFT 50% DOC	02.11.18
02	UPDATED DA	13.05.19
THIS DRAWING IS TO BE READ IN CONJUNCTION WITH DETAILS AND SPECIFICATIONS PREPARED BY LAT27 PTY LTD. PRIOR TO UNDERTAKING ANY CONSTRUCTION. ANY CONFLICTS THAT EXIST ON THIS DRAWING, OR ADVICE AND DIRECTION REQUIRED SHOULD BE SOUGHT FROM LAT27 PTY LTD.		
1. ALL STRUCTURAL, CIVIL, HYDRAULIC AND ELECTRICAL INFORMATION INDICATED ON THIS DRAWING IS OUTSIDE THE DEFINED SCOPE OF LAT27. ALL CONSULTANT INFORMATION SHOWN IS FOR COORDINATION PURPOSES ONLY AND REFERENCE IS TO BE MADE TO THE RELEVANT CONSULTANTS DRAWINGS AND SPECIFICATIONS ACCORDINGLY FOR CONSTRUCTION.		
2. FIGURED DIMENSIONS TAKE PRECEDENCE OVER SCALED.		
3. CHECK ALL DIMENSIONS ON SITE PRIOR TO COMMENCEMENT OF WORK.		
© COPYRIGHT LAT27 PTY LTD ALL RIGHTS RESERVED. THIS DRAWING MAY NOT BE PRODUCED OR TRANSMITTED IN ANY FORM OR BY ANY MEANS IN PART OR IN WHOLE WITHOUT THE WRITTEN PERMISSION OF LAT27 PTY LTD		

NOT FOR CONSTRUCTION

07 3236 1086
Level 5, 300 Ann Street
Brisbane, Qld 4000
www.lat27.com.au



CLIENT
VICINITY CENTRES




PROJECT TITLE
CHATSWOOD CHASE

DRAWING TITLE
LEVEL 2 - D2
FINISHES PLAN - SHEET 1

SCALE BAR
SCALE 1:100 @ A1
0m 1.0 2.0 3.0 4.0 5.0
SCALE 1:200 @ A3

PROJECT No. 17140.01	SCALE 1:100	
DRAWN BY ST	VERIFIER NW	
DRAWING No. LA-LAT-DRG-02-D2-0101	REVISION 02	

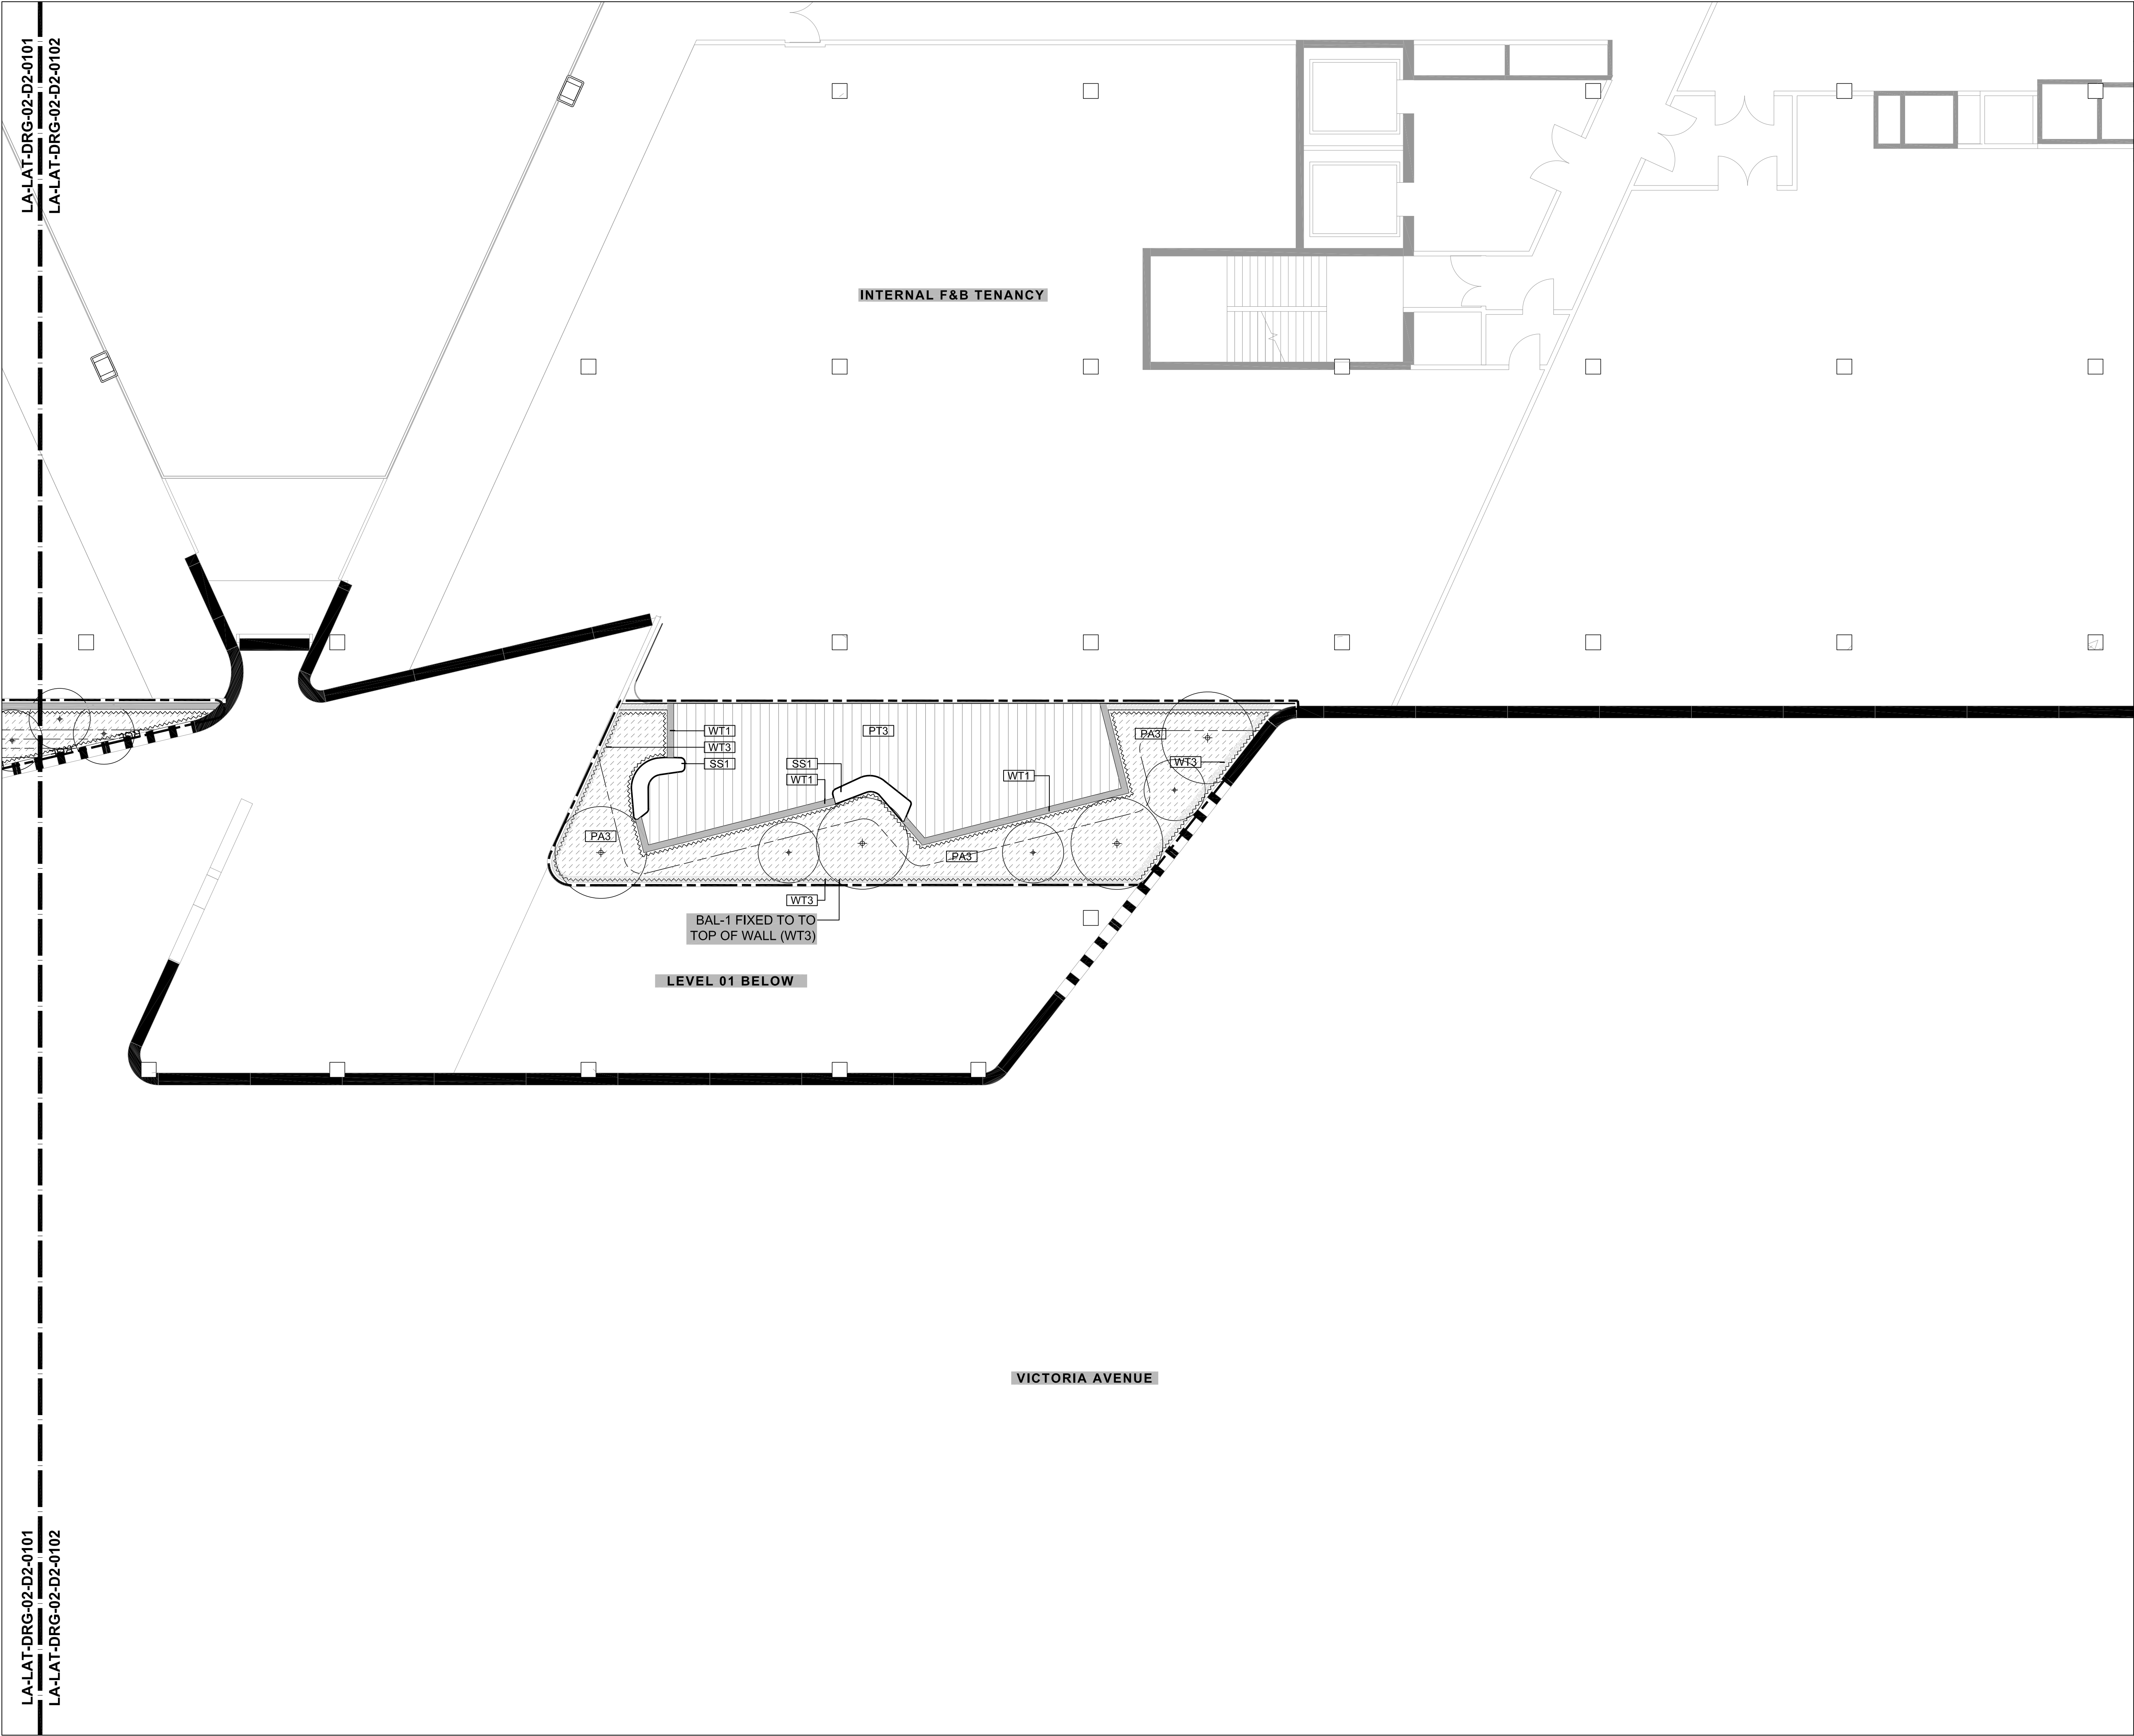

REV	DESCRIPTION	DATE
01	DRAFT 50% DOC	02.11.18
02	UPDATED DA	13.05.19

THIS DRAWING IS TO BE READ IN CONJUNCTION WITH DETAILS AND SPECIFICATIONS PREPARED BY LAT27 PTY LTD. PRIOR TO UNDERTAKING ANY CONSTRUCTION, ANY CONFLICTS THAT EXIST ON THIS DRAWING, OR ADVICE AND DIRECTION REQUIRED SHOULD BE SOUGHT FROM LAT27 PTY LTD.

1. ALL STRUCTURAL, CIVIL, HYDRAULIC AND ELECTRICAL INFORMATION INDICATED ON THIS DRAWING IS OUTSIDE THE DEFINED SCOPE OF LAT27. ALL CONSULTANT INFORMATION SHOWN IS FOR COORDINATION PURPOSES ONLY AND REFERENCE IS TO BE MADE TO THE RELEVANT CONSULTANTS DRAWINGS AND SPECIFICATIONS ACCORDINGLY FOR CONSTRUCTION.

2. FIGURED DIMENSIONS TAKE PRECEDENCE OVER SCALED.

3. CHECK ALL DIMENSIONS ON SITE PRIOR TO COMMENCEMENT OF WORK.

© COPYRIGHT LAT27 PTY LTD ALL RIGHTS RESERVED. THIS DRAWING MAY NOT BE PRODUCED OR TRANSMITTED IN ANY FORM OR BY ANY MEANS IN PART OR IN WHOLE WITHOUT THE WRITTEN PERMISSION OF LAT27 PTY LTD

NOT FOR CONSTRUCTION

07 3236 1086
Level 5, 300 Ann Street
Brisbane, Qld 4000
www.lat27.com.au

lat^{27°}

CLIENT

VICINITY CENTRES



VICINITY
CENTRES

PROJECT TITLE

CHATSWOOD CHASE


DRAWING TITLE


LEVEL 2 - D2
FINISHES PLAN - SHEET 2

SCALE BAR

SCALE 1:100 @ A1
0m 1.0 2.0 3.0 4.0 5.0

SCALE 1:200 @ A3

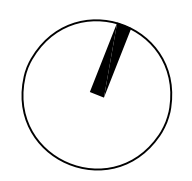PROJECT No. 17140.01	SCALE 1:100	
DRAWN BY ST	VERIFIER NW	
DRAWING No. LA-LAT-DRG-02-D2-0102		REVISION 02

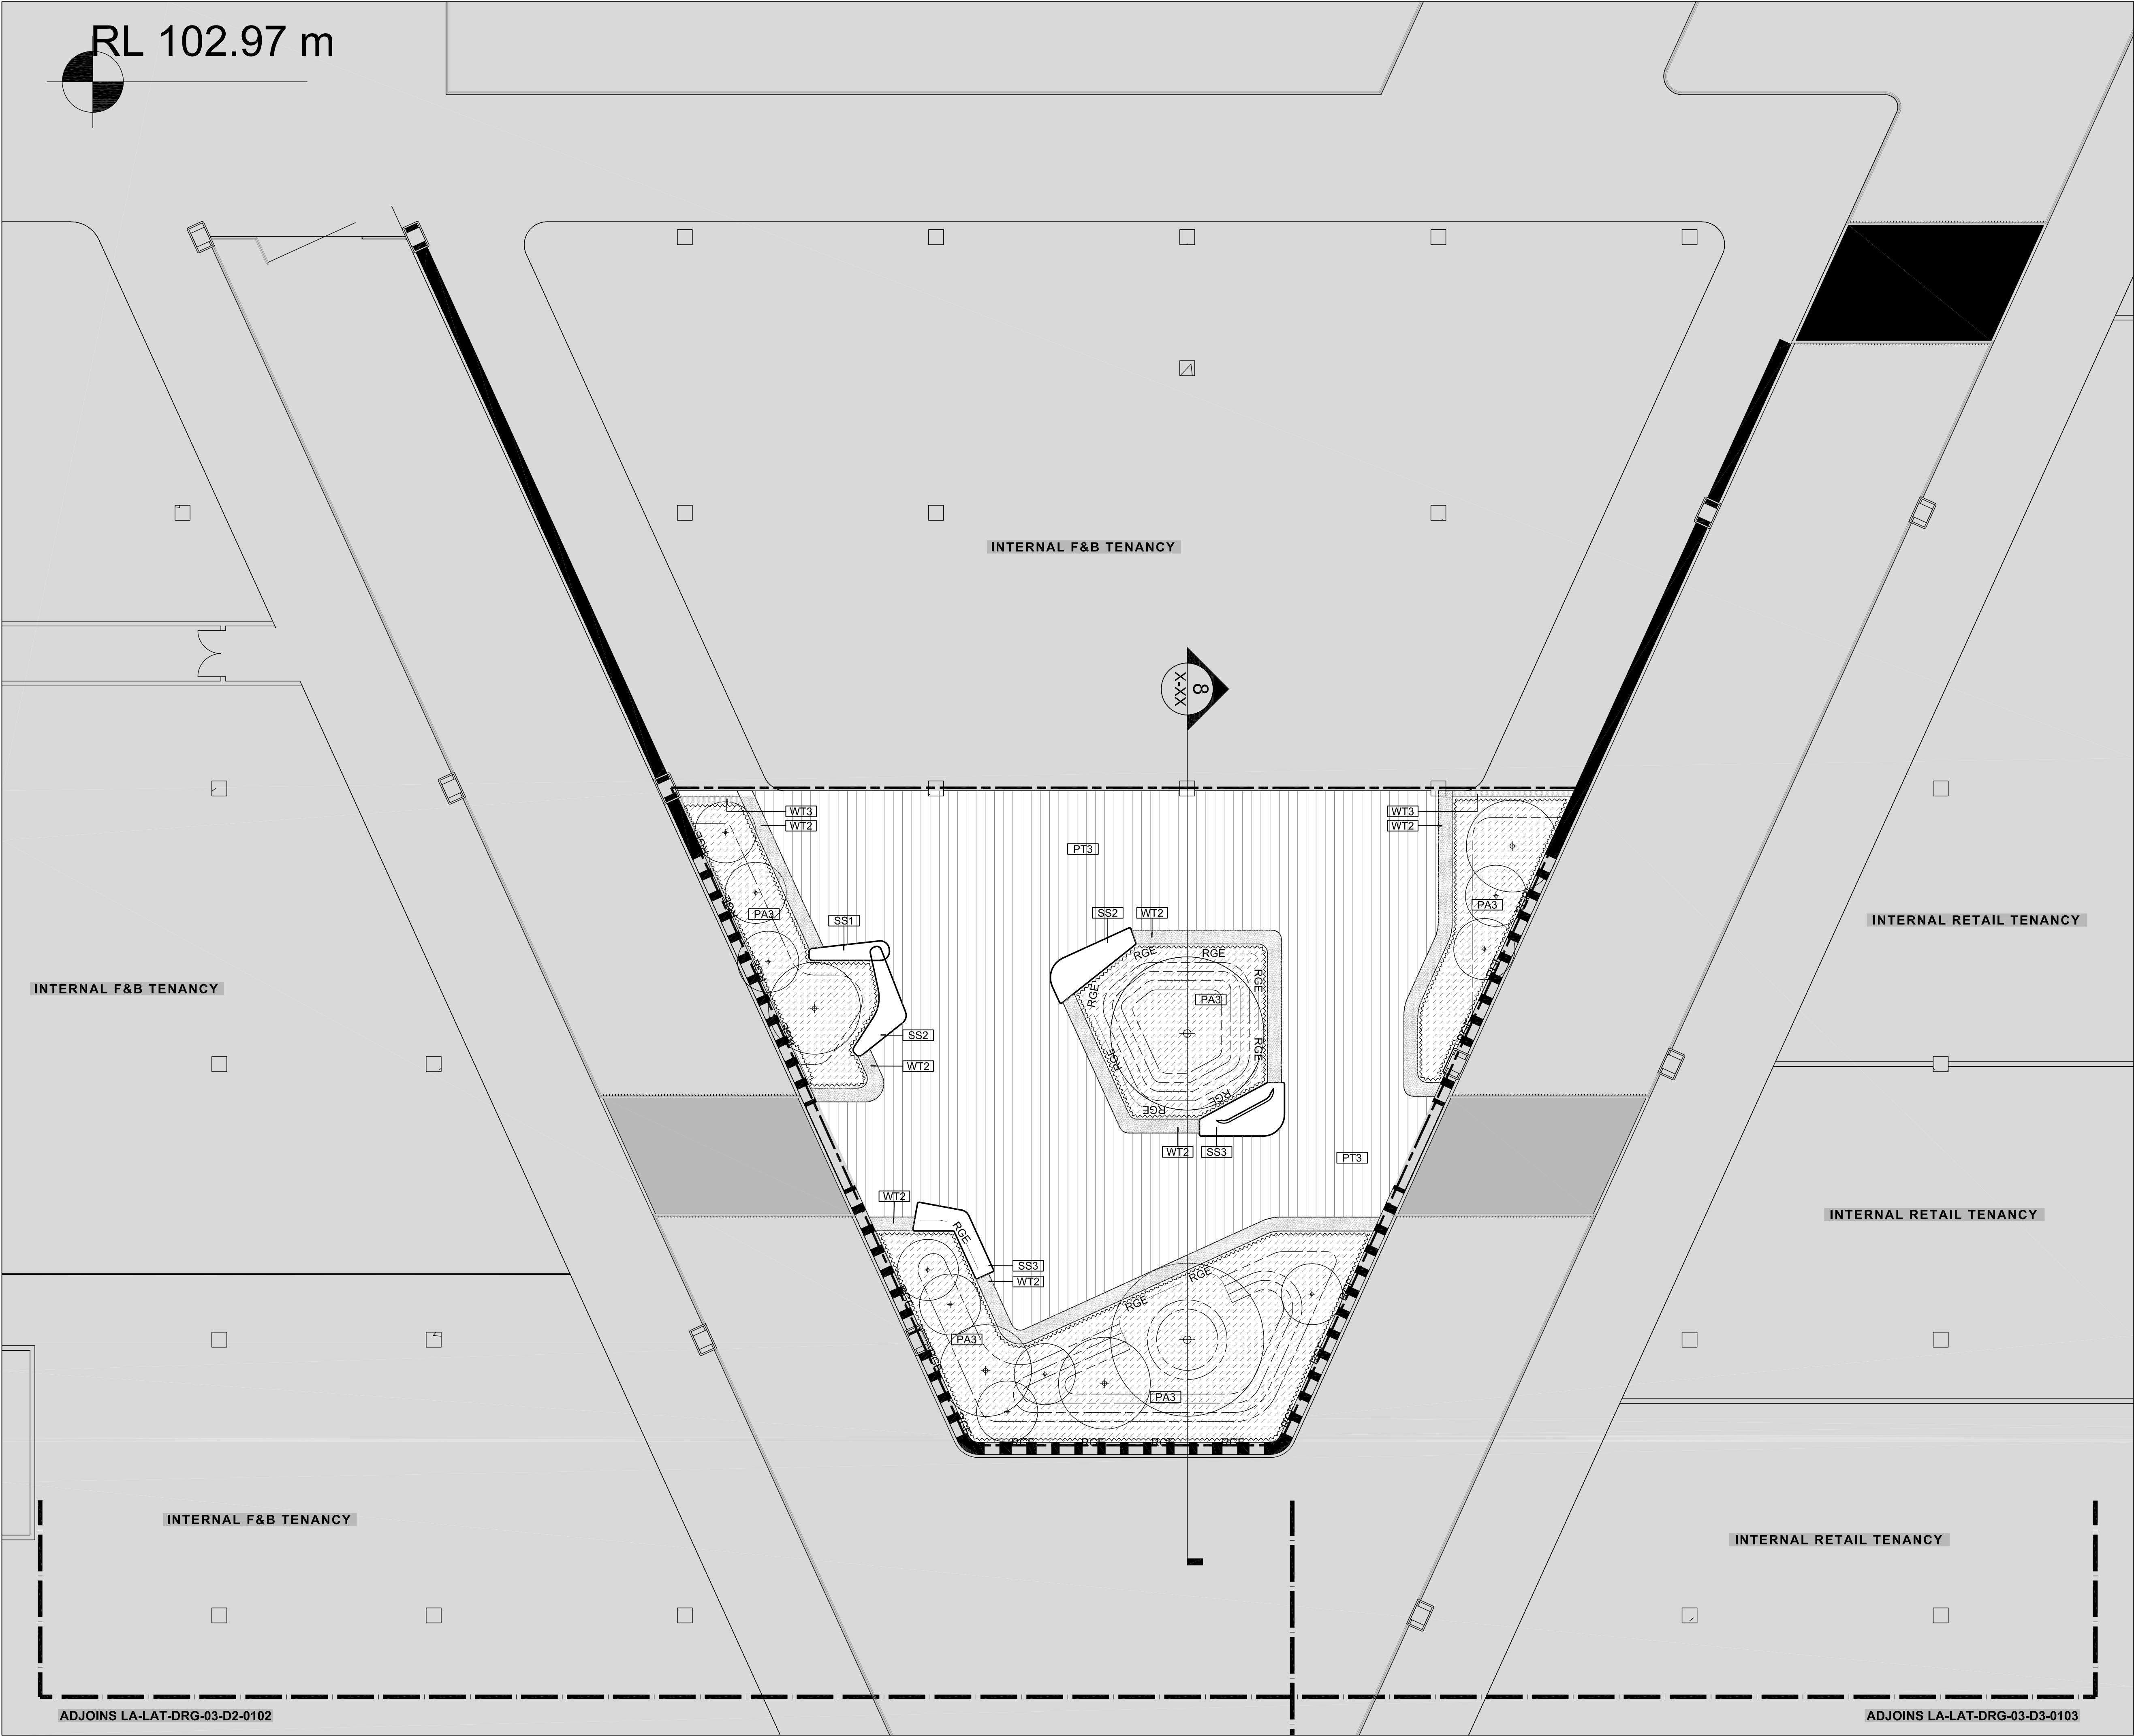

ADJOINS LA-LAT-DRG-03-D2-0102

ADJOINS LA-LAT-DRG-03-D3-0103

REV	DESCRIPTION	DATE
01	DRAFT 50% DOC	02.11.18
02	UPDATED DA	13.05.19

THIS DRAWING IS TO BE READ IN CONJUNCTION WITH DETAILS AND SPECIFICATIONS PREPARED BY LAT27 PTY LTD. PRIOR TO UNDERTAKING ANY CONSTRUCTION, ANY CONFLICTS THAT EXIST ON THIS DRAWING, OR ADVICE AND DIRECTION REQUIRED SHOULD BE SOUGHT FROM LAT27 PTY LTD.

1. ALL STRUCTURAL, CIVIL, HYDRAULIC AND ELECTRICAL INFORMATION INDICATED ON THIS DRAWING IS OUTSIDE THE DEFINED SCOPE OF LAT27. ALL CONSULTANT INFORMATION SHOWN IS FOR COORDINATION PURPOSES ONLY AND REFERENCE IS TO BE MADE TO THE RELEVANT CONSULTANTS DRAWINGS AND SPECIFICATIONS ACCORDINGLY FOR CONSTRUCTION.

2. FIGURED DIMENSIONS TAKE PRECEDENCE OVER SCALED.

3. CHECK ALL DIMENSIONS ON SITE PRIOR TO COMMENCEMENT OF WORK.

© COPYRIGHT LAT27 PTY LTD ALL RIGHTS RESERVED. THIS DRAWING MAY NOT BE PRODUCED OR TRANSMITTED IN ANY FORM OR BY ANY MEANS IN PART OR IN WHOLE WITHOUT THE WRITTEN PERMISSION OF LAT27 PTY LTD

NOT FOR CONSTRUCTION

07 3236 1086
Level 5, 300 Ann Street
Brisbane, Qld 4000
www.lat27.com.au



CLIENT
VICINITY CENTRES




PROJECT TITLE
CHATSWOOD CHASE

DRAWING TITLE
LEVEL 3 - D2
FINISHES PLAN - SHEET 1

SCALE BAR
SCALE 1:100 @ A1
0m 1.0 2.0 3.0 4.0 5.0
SCALE 1:200 @ A3

PROJECT No. 17140.01	SCALE 1:100	
DRAWN BY ST	VERIFIER NW	
DRAWING No. LA-LAT-DRG-03-D2-0101		REVISION 02

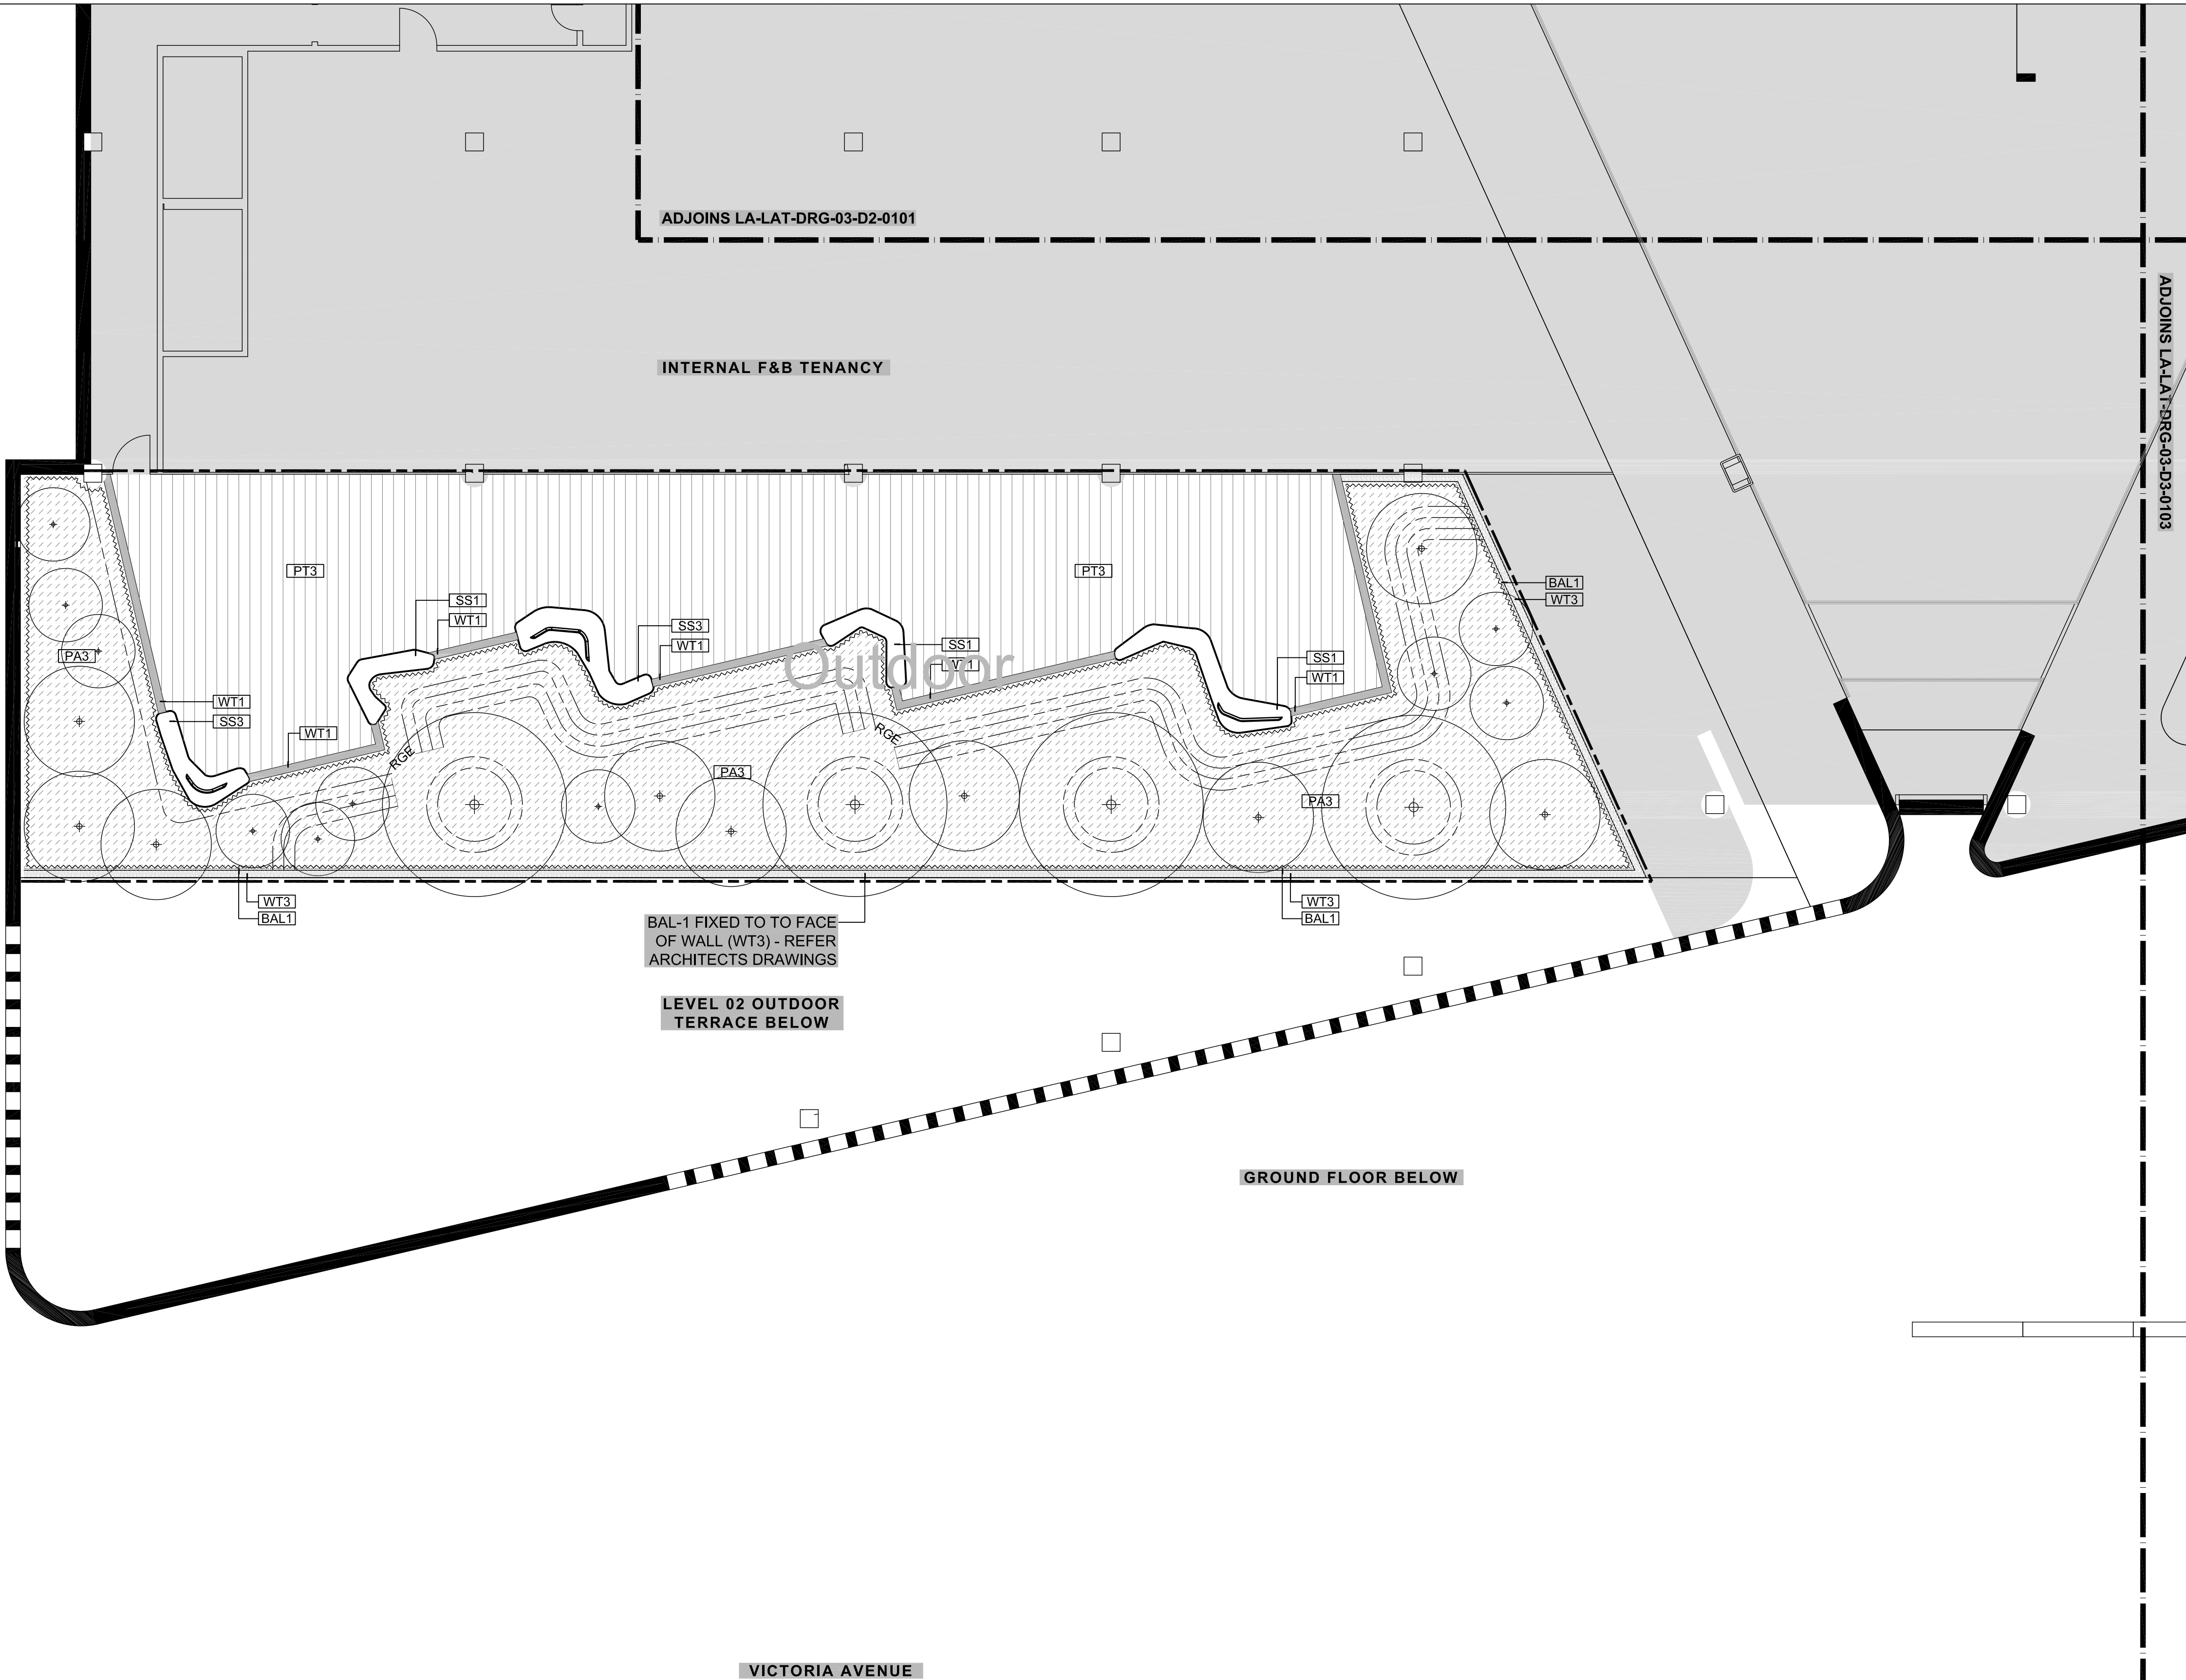

REV	DESCRIPTION	DATE
01	DRAFT 50% DOC	02.11.18
02	UPDATED DA	13.05.19

THIS DRAWING IS TO BE READ IN CONJUNCTION WITH DETAILS AND SPECIFICATIONS PREPARED BY LAT27 PTY LTD. PRIOR TO UNDERTAKING ANY CONSTRUCTION, ANY CONFLICTS THAT EXIST ON THIS DRAWING, OR ADVICE AND DIRECTION REQUIRED SHOULD BE SOUGHT FROM LAT27 PTY LTD.

1. ALL STRUCTURAL, CIVIL, HYDRAULIC AND ELECTRICAL INFORMATION INDICATED ON THIS DRAWING IS OUTSIDE THE DEFINED SCOPE OF LAT27. ALL CONSULTANT INFORMATION SHOWN IS FOR COORDINATION PURPOSES ONLY AND REFERENCE IS TO BE MADE TO THE RELEVANT CONSULTANTS DRAWINGS AND SPECIFICATIONS ACCORDINGLY FOR CONSTRUCTION.

2. FIGURED DIMENSIONS TAKE PRECEDENCE OVER SCALED.

3. CHECK ALL DIMENSIONS ON SITE PRIOR TO COMMENCEMENT OF WORK.

© COPYRIGHT LAT27 PTY LTD ALL RIGHTS RESERVED. THIS DRAWING MAY NOT BE PRODUCED OR TRANSMITTED IN ANY FORM OR BY ANY MEANS IN PART OR IN WHOLE WITHOUT THE WRITTEN PERMISSION OF LAT27 PTY LTD

NOT FOR CONSTRUCTION

07 3236 1086
Level 5, 300 Ann Street
Brisbane, Qld 4000
www.lat27.com.au



CLIENT
VICINITY CENTRES




PROJECT TITLE
CHATSWOOD CHASE

DRAWING TITLE
LEVEL 3 - D2
FINISHES PLAN - SHEET 2

SCALE BAR
SCALE 1:100 @ A1
0m 1.0 2.0 3.0 4.0 5.0
SCALE 1:200 @ A3

PROJECT No. 17140.01	SCALE 1:100	
DRAWN BY ST	VERIFIER NW	
DRAWING No. LA-LAT-DRG-03-D2-0102	REVISION 02	

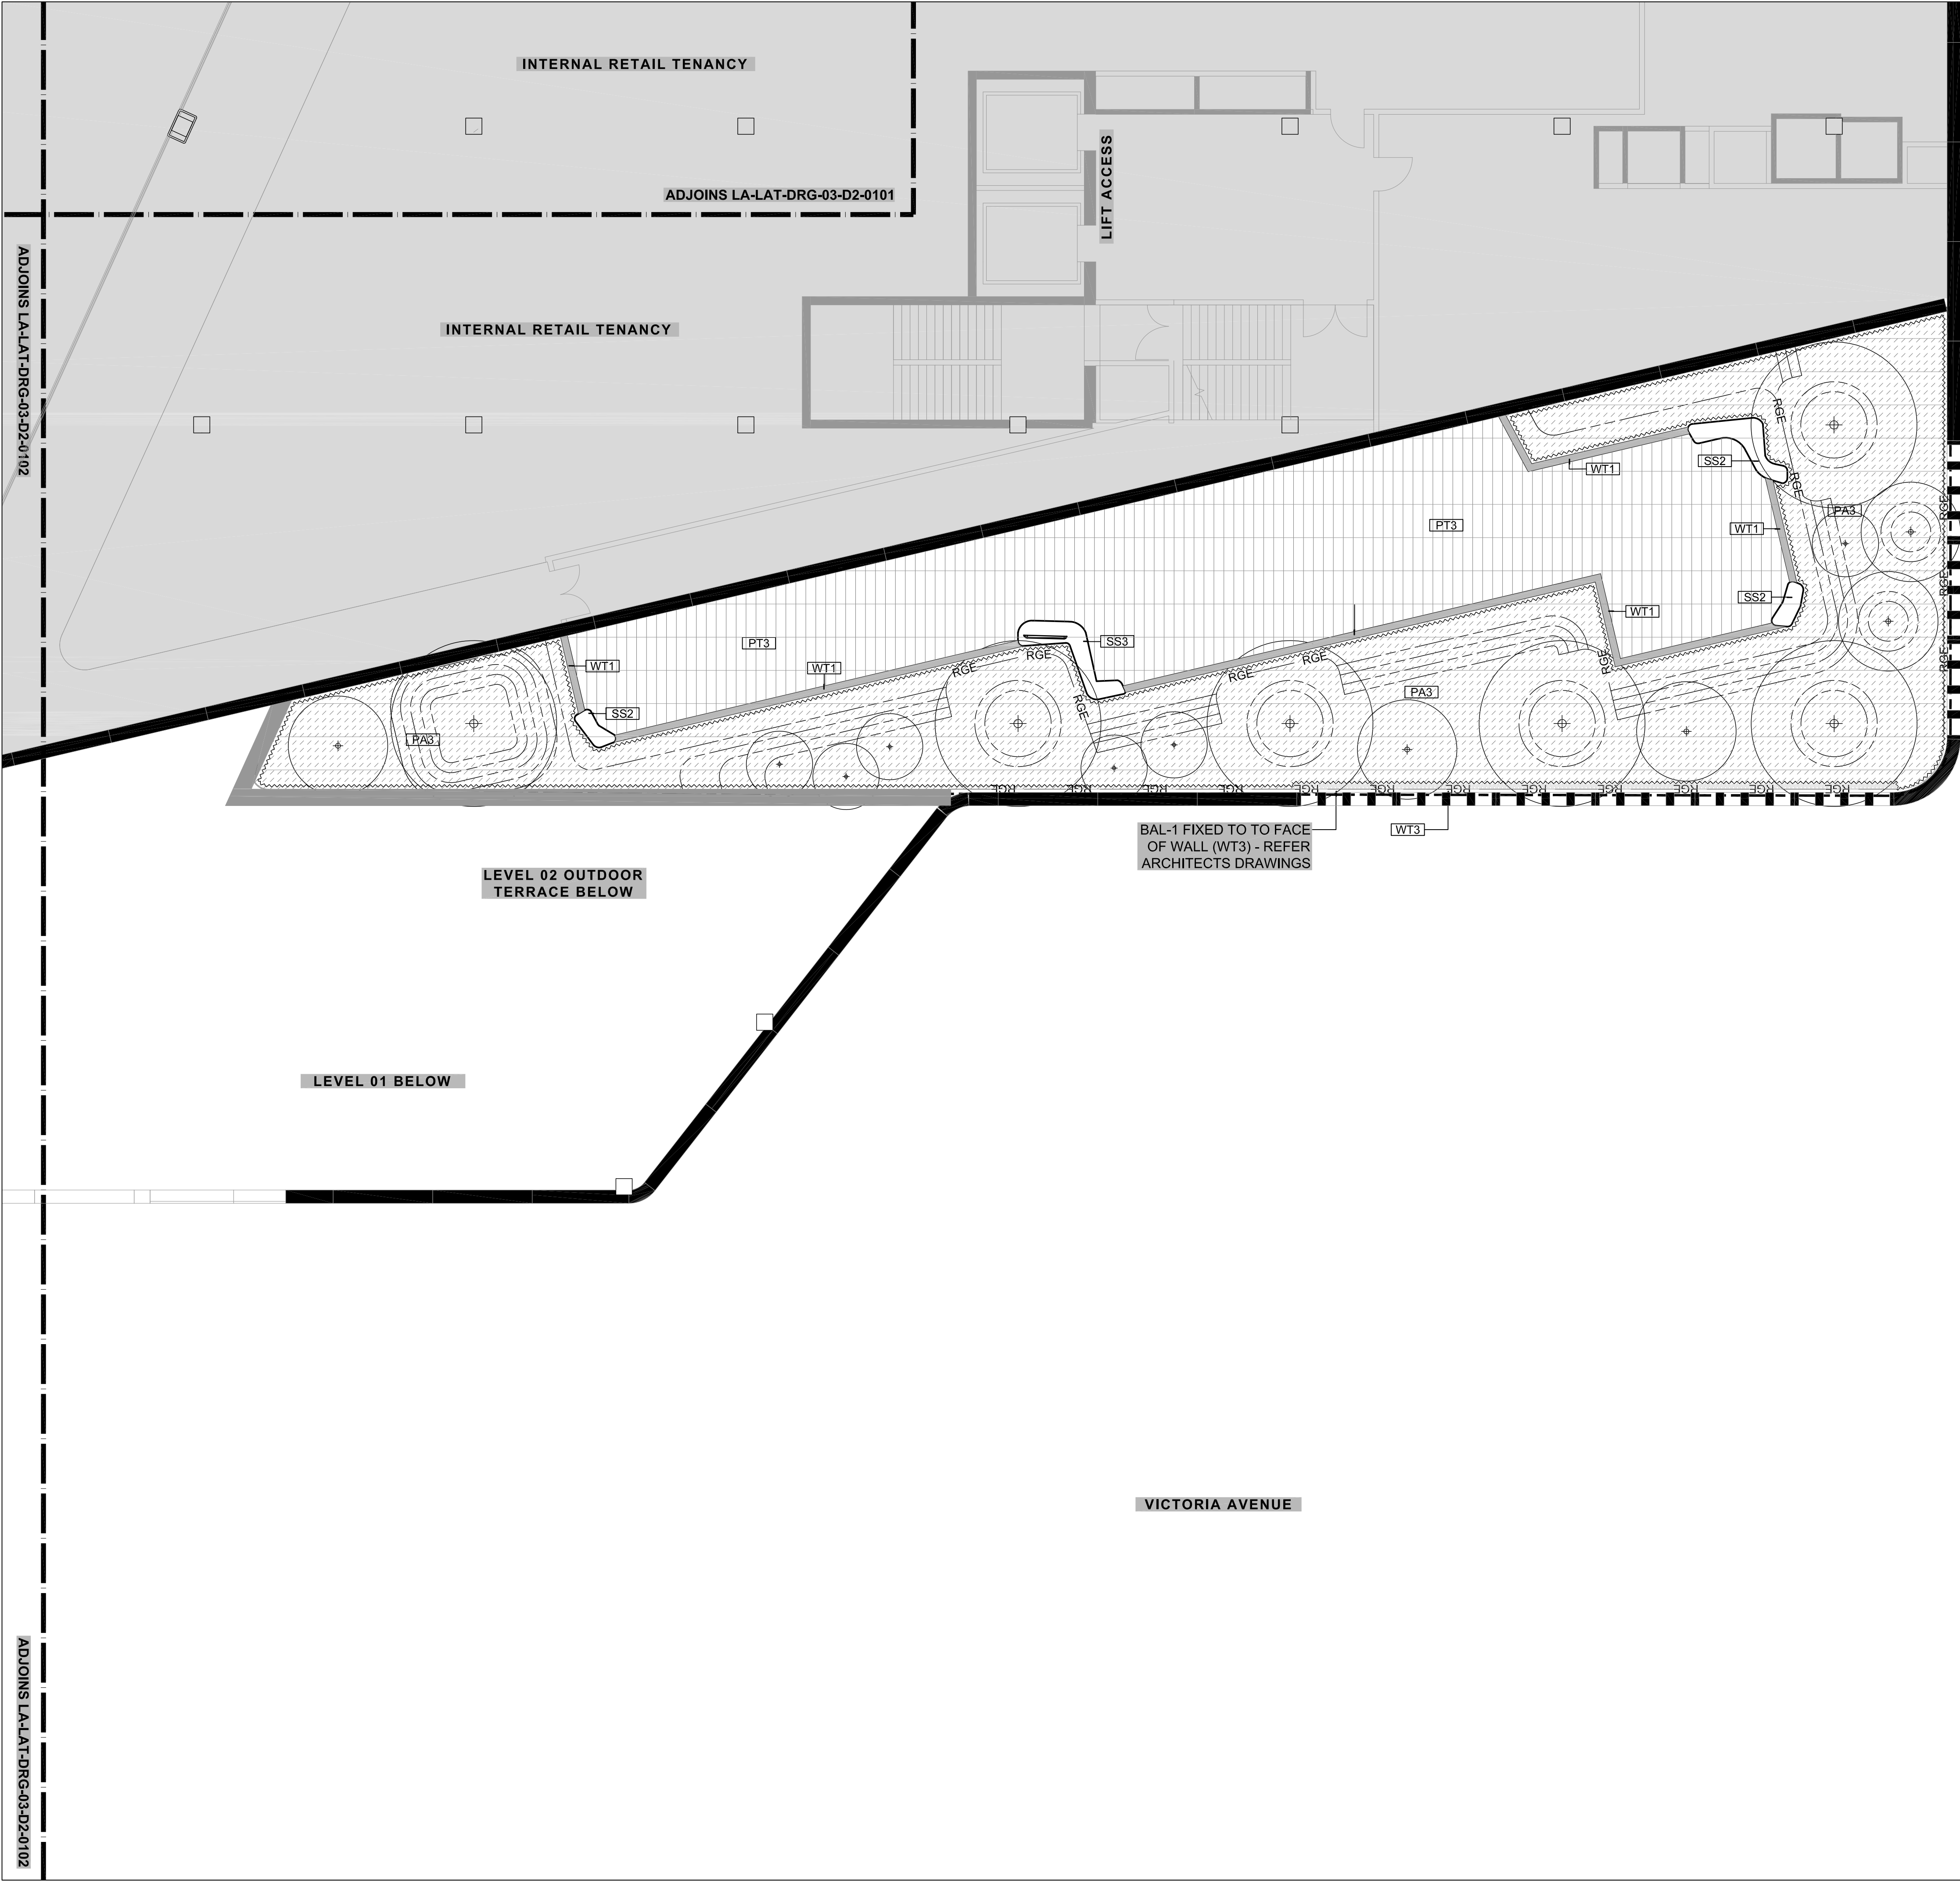

REV	DESCRIPTION	DATE
01	DRAFT 50% DOC	02.11.18
02	UPDATED DA	13.05.19

THIS DRAWING IS TO BE READ IN CONJUNCTION WITH DETAILS AND SPECIFICATIONS PREPARED BY LAT27 PTY LTD. PRIOR TO UNDERTAKING ANY CONSTRUCTION, ANY CONFLICTS THAT EXIST ON THIS DRAWING, OR ADVICE AND DIRECTION REQUIRED SHOULD BE SOUGHT FROM LAT27 PTY LTD.

1. ALL STRUCTURAL, CIVIL, HYDRAULIC AND ELECTRICAL INFORMATION INDICATED ON THIS DRAWING IS OUTSIDE THE DEFINED SCOPE OF LAT27. ALL CONSULTANT INFORMATION SHOWN IS FOR COORDINATION PURPOSES ONLY AND REFERENCE IS TO BE MADE TO THE RELEVANT CONSULTANTS DRAWINGS AND SPECIFICATIONS ACCORDINGLY FOR CONSTRUCTION.
2. FIGURED DIMENSIONS TAKE PRECEDENCE OVER SCALED.
3. CHECK ALL DIMENSIONS ON SITE PRIOR TO COMMENCEMENT OF WORK.

© COPYRIGHT LAT27 PTY LTD ALL RIGHTS RESERVED. THIS DRAWING MAY NOT BE PRODUCED OR TRANSMITTED IN ANY FORM OR BY ANY MEANS IN PART OR IN WHOLE WITHOUT THE WRITTEN PERMISSION OF LAT27 PTY LTD

NOT FOR CONSTRUCTION

07 3236 1086
Level 5, 300 Ann Street
Brisbane, Qld 4000
www.lat27.com.au



CLIENT
VICINITY CENTRES




PROJECT TITLE
CHATSWOOD CHASE

DRAWING TITLE
LEVEL 3 - A3
FINISHES PLAN - SHEET 1

SCALE BAR
SCALE 1:100 @ A1
0m 1.0 2.0 3.0 4.0 5.0
SCALE 1:200 @ A3

PROJECT No. 17140.01	SCALE 1:100	
DRAWN BY ST	VERIFIER NW	
DRAWING No. LA-LAT-DRG-03-D3-0103		REVISION 02

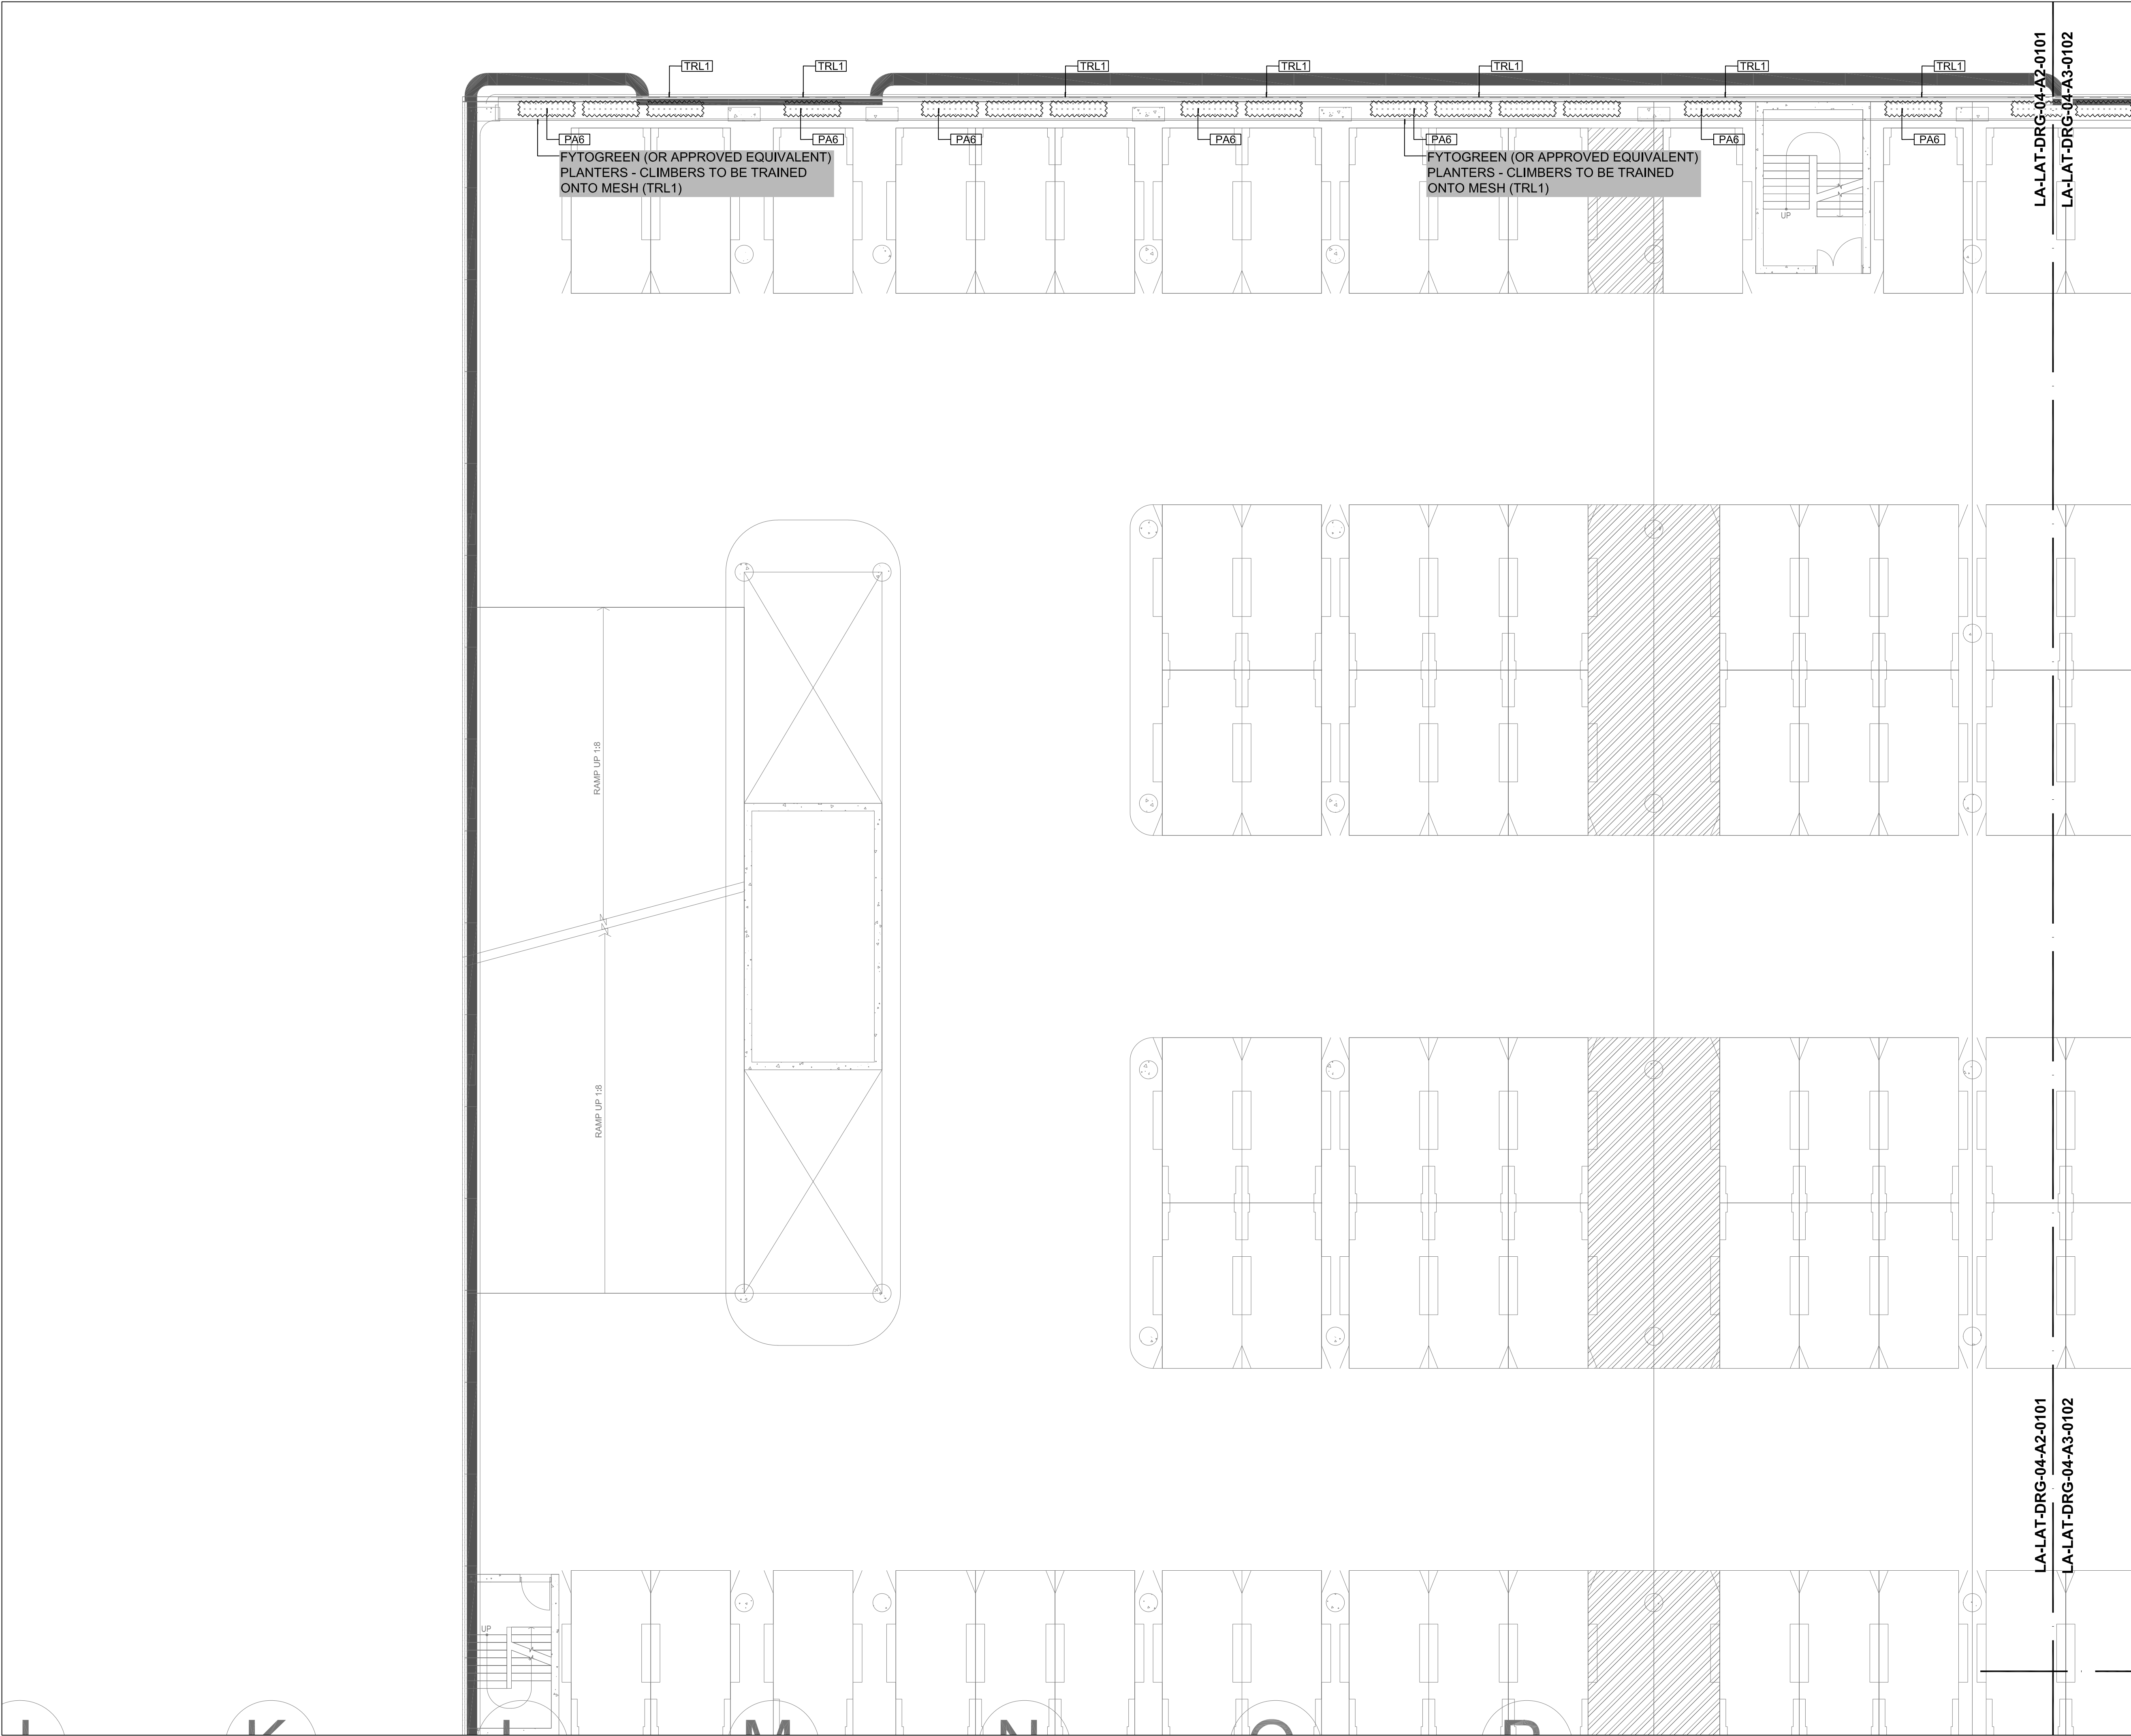

REV	DESCRIPTION	DATE
01	DRAFT 50% DOC	02.11.18
02	UPDATED DA	13.05.19
THIS DRAWING IS TO BE READ IN CONJUNCTION WITH DETAILS AND SPECIFICATIONS PREPARED BY LAT27 PTY LTD. PRIOR TO UNDERTAKING ANY CONSTRUCTION, ANY CONFLICTS THAT EXIST ON THIS DRAWING, OR ADVICE AND DIRECTION REQUIRED SHOULD BE SOUGHT FROM LAT27 PTY LTD.		
1. ALL STRUCTURAL, CIVIL, HYDRAULIC AND ELECTRICAL INFORMATION INDICATED ON THIS DRAWING IS OUTSIDE THE DEFINED SCOPE OF LAT27. ALL CONSULTANT INFORMATION SHOWN IS FOR COORDINATION PURPOSES ONLY AND REFERENCE IS TO BE MADE TO THE RELEVANT CONSULTANTS DRAWINGS AND SPECIFICATIONS ACCORDINGLY FOR CONSTRUCTION.		
2. FIGURED DIMENSIONS TAKE PRECEDENCE OVER SCALED.		
3. CHECK ALL DIMENSIONS ON SITE PRIOR TO COMMENCEMENT OF WORK.		
© COPYRIGHT LAT27 PTY LTD ALL RIGHTS RESERVED. THIS DRAWING MAY NOT BE PRODUCED OR TRANSMITTED IN ANY FORM OR BY ANY MEANS IN PART OR IN WHOLE WITHOUT THE WRITTEN PERMISSION OF LAT27 PTY LTD		

NOT FOR CONSTRUCTION

07 3236 1086
Level 5, 300 Ann Street
Brisbane, Qld 4000
www.lat27.com.au


lat²⁷

CLIENT

VICINITY CENTRES


VICINITY
CENTRES

PROJECT TITLE

CHATSWOOD CHASE

DRAWING TITLE

LEVEL 4 - A2
FINISHES PLAN - SHEET 1

SCALE BAR

SCALE 1:100 @ A1
0m 1.0 2.0 3.0 4.0 5.0
SCALE 1:200 @ A3

PROJECT No.
17140.01


SCALE
1:100

DRAWN BY
ST

VERIFIER
NW

DRAWING No.
LA-LAT-DRG-04-A2-0101

REVISION
02

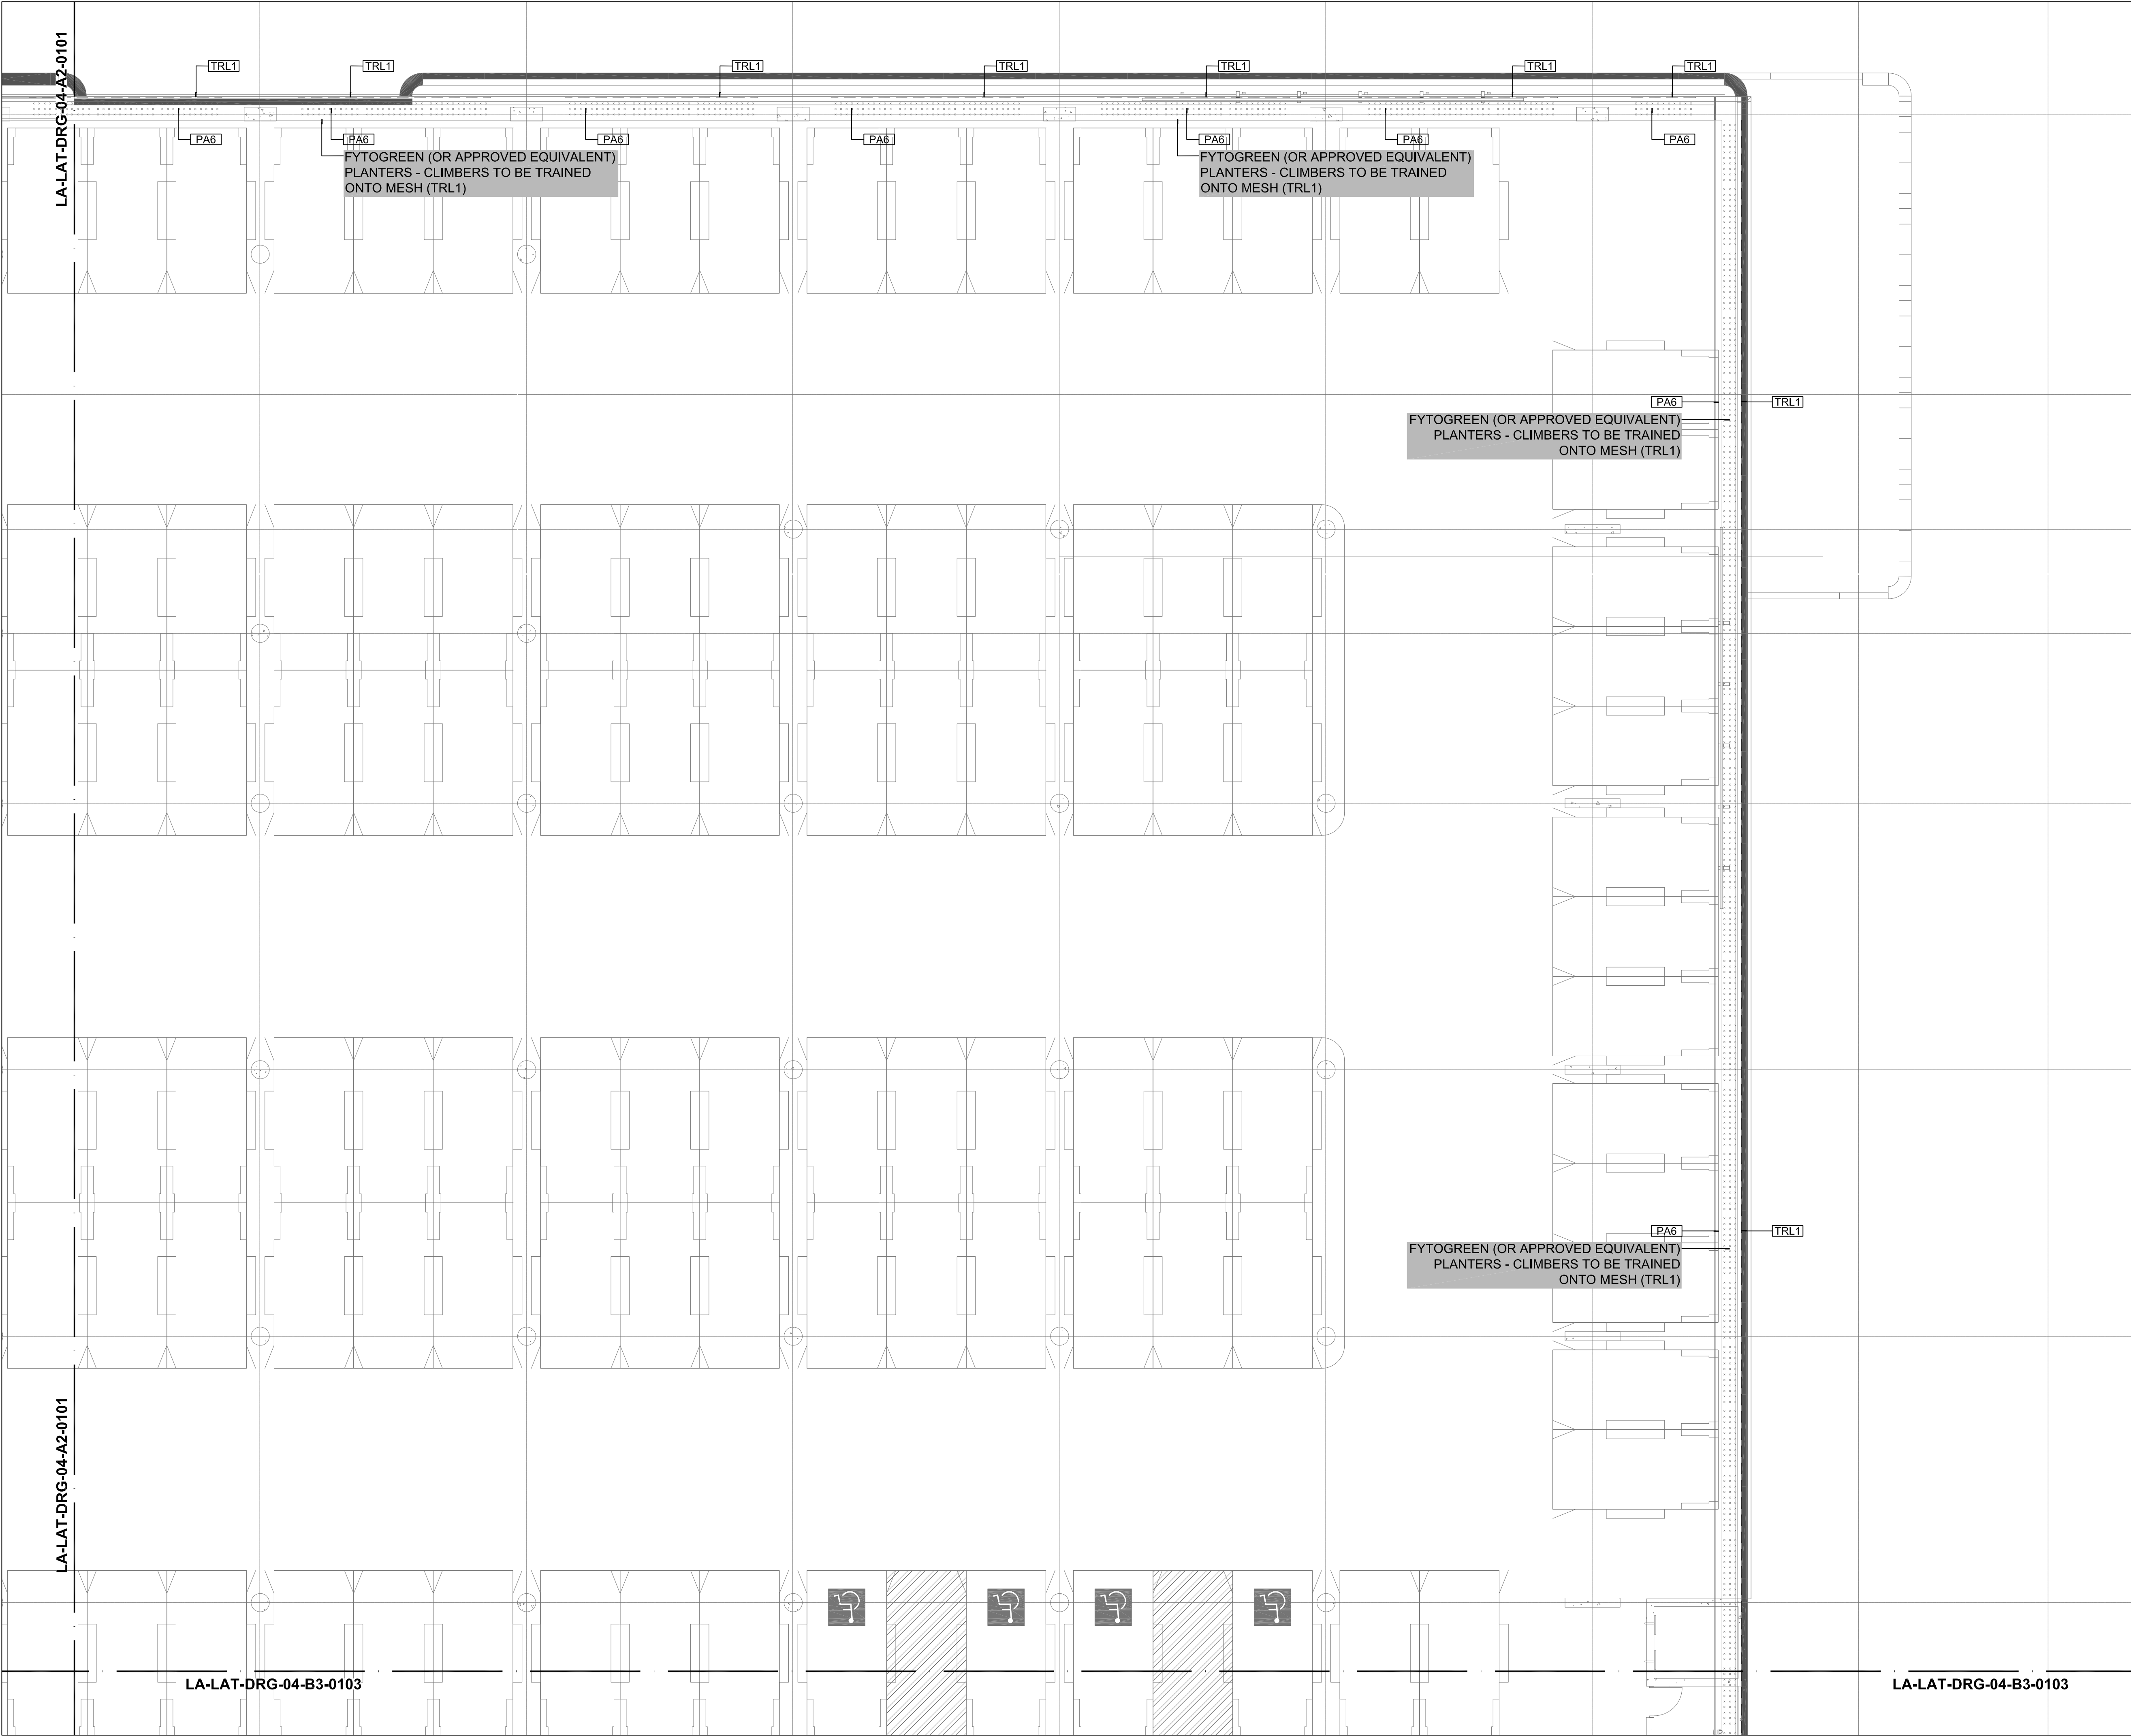

REV	DESCRIPTION	DATE
01	DRAFT 50% DOC	02.11.18
02	UPDATED DA	13.05.19

THIS DRAWING IS TO BE READ IN CONJUNCTION WITH DETAILS AND SPECIFICATIONS PREPARED BY LAT27 PTY LTD. PRIOR TO UNDERTAKING ANY CONSTRUCTION, ANY CONFLICTS THAT EXIST ON THIS DRAWING, OR ADVICE AND DIRECTION REQUIRED SHOULD BE SOUGHT FROM LAT27 PTY LTD.

1. ALL STRUCTURAL, CIVIL, HYDRAULIC AND ELECTRICAL INFORMATION INDICATED ON THIS DRAWING IS OUTSIDE THE DEFINED SCOPE OF LAT27. ALL CONSULTANT INFORMATION SHOWN IS FOR COORDINATION PURPOSES ONLY AND REFERENCE IS TO BE MADE TO THE RELEVANT CONSULTANTS DRAWINGS AND SPECIFICATIONS ACCORDINGLY FOR CONSTRUCTION.

2. FIGURED DIMENSIONS TAKE PRECEDENCE OVER SCALED.

3. CHECK ALL DIMENSIONS ON SITE PRIOR TO COMMENCEMENT OF WORK.

© COPYRIGHT LAT27 PTY LTD ALL RIGHTS RESERVED. THIS DRAWING MAY NOT BE PRODUCED OR TRANSMITTED IN ANY FORM OR BY ANY MEANS IN PART OR IN WHOLE WITHOUT THE WRITTEN PERMISSION OF LAT27 PTY LTD

NOT FOR CONSTRUCTION

07 3236 1086
Level 5, 300 Ann Street
Brisbane, Qld 4000
www.lat27.com.au

lat²⁷

CLIENT

VICINITY CENTRES



PROJECT TITLE

CHATSWOOD CHASE

DRAWING TITLE

LEVEL 4 - A3
FINISHES PLAN - SHEET 2

SCALE BAR

SCALE 1:100 @ A1
0m 1.0 2.0 3.0 4.0 5.0

SCALE 1:200 @ A3

PROJECT No.
17140.01


SCALE
1:100

DRAWN BY
ST


VERIFIER
NW

DRAWING No.
LA-LAT-DRG-04-A3-0102

REVISION
02

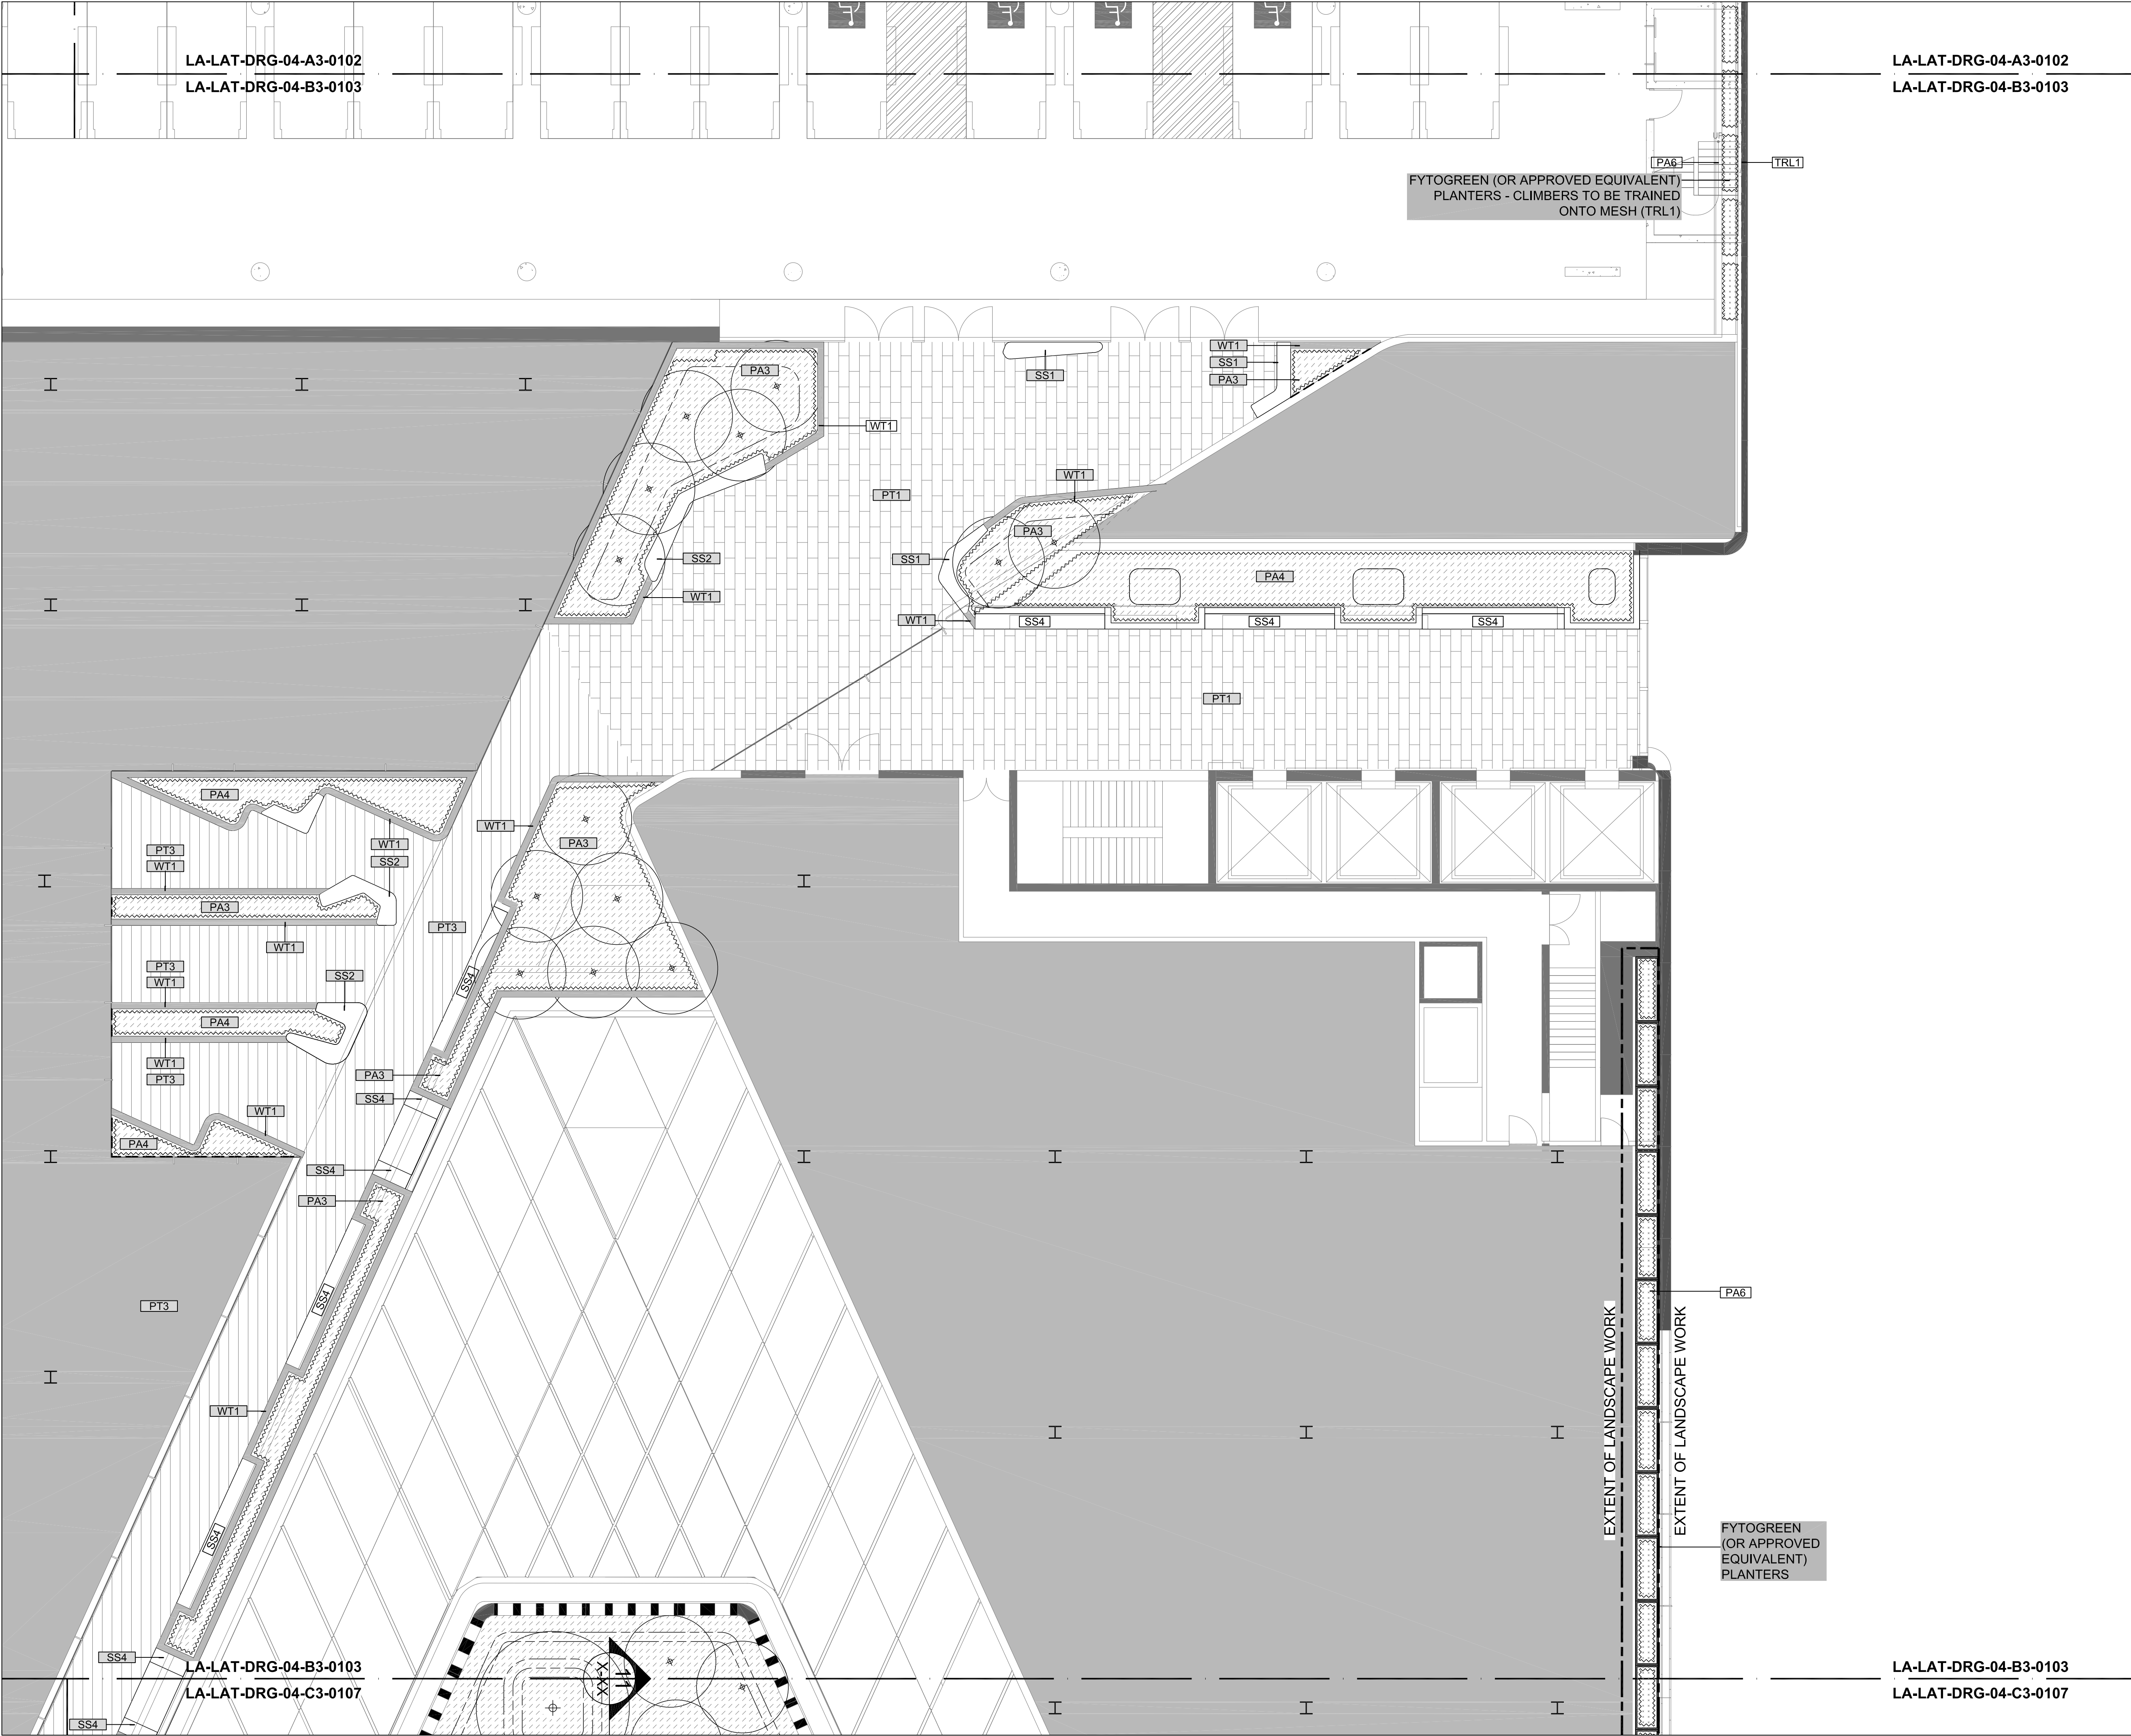

REV	DESCRIPTION	DATE
01	DRAFT 50% DOC	02.11.18
02	UPDATED DA	13.05.19
THIS DRAWING IS TO BE READ IN CONJUNCTION WITH DETAILS AND SPECIFICATIONS PREPARED BY LAT27 PTY LTD. PRIOR TO UNDERTAKING ANY CONSTRUCTION, ANY CONFLICTS THAT EXIST ON THIS DRAWING, OR ADVICE AND DIRECTION REQUIRED SHOULD BE SOUGHT FROM LAT27 PTY LTD.		
1. ALL STRUCTURAL, CIVIL, HYDRAULIC AND ELECTRICAL INFORMATION INDICATED ON THIS DRAWING IS OUTSIDE THE DEFINED SCOPE OF LAT27. ALL CONSULTANT INFORMATION SHOWN IS FOR COORDINATION PURPOSES ONLY AND REFERENCE IS TO BE MADE TO THE RELEVANT CONSULTANTS DRAWINGS AND SPECIFICATIONS ACCORDINGLY FOR CONSTRUCTION.		
2. FIGURED DIMENSIONS TAKE PRECEDENCE OVER SCALED.		
3. CHECK ALL DIMENSIONS ON SITE PRIOR TO COMMENCEMENT OF WORK.		
© COPYRIGHT LAT27 PTY LTD ALL RIGHTS RESERVED. THIS DRAWING MAY NOT BE PRODUCED OR TRANSMITTED IN ANY FORM OR BY ANY MEANS IN PART OR IN WHOLE WITHOUT THE WRITTEN PERMISSION OF LAT27 PTY LTD		
NOT FOR CONSTRUCTION		
07 3236 1086 Level 5, 300 Ann Street Brisbane, Qld 4000 www.lat27.com.au		
lat ²⁷		
CLIENT VICINITY CENTRES		
PROJECT TITLE CHATSWOOD CHASE		
DRAWING TITLE LEVEL 4 - A3 FINISHES PLAN - SHEET 3		
SCALE BAR SCALE 1:100 @ A1 0m 1.0 2.0 3.0 4.0 5.0 SCALE 1:200 @ A3		
PROJECT No. 17140.01	SCALE 1:100	
DRAWN BY ST	VERIFIER NW	
DRAWING No. LA-LAT-DRG-04-A3-0103	REVISION 02	

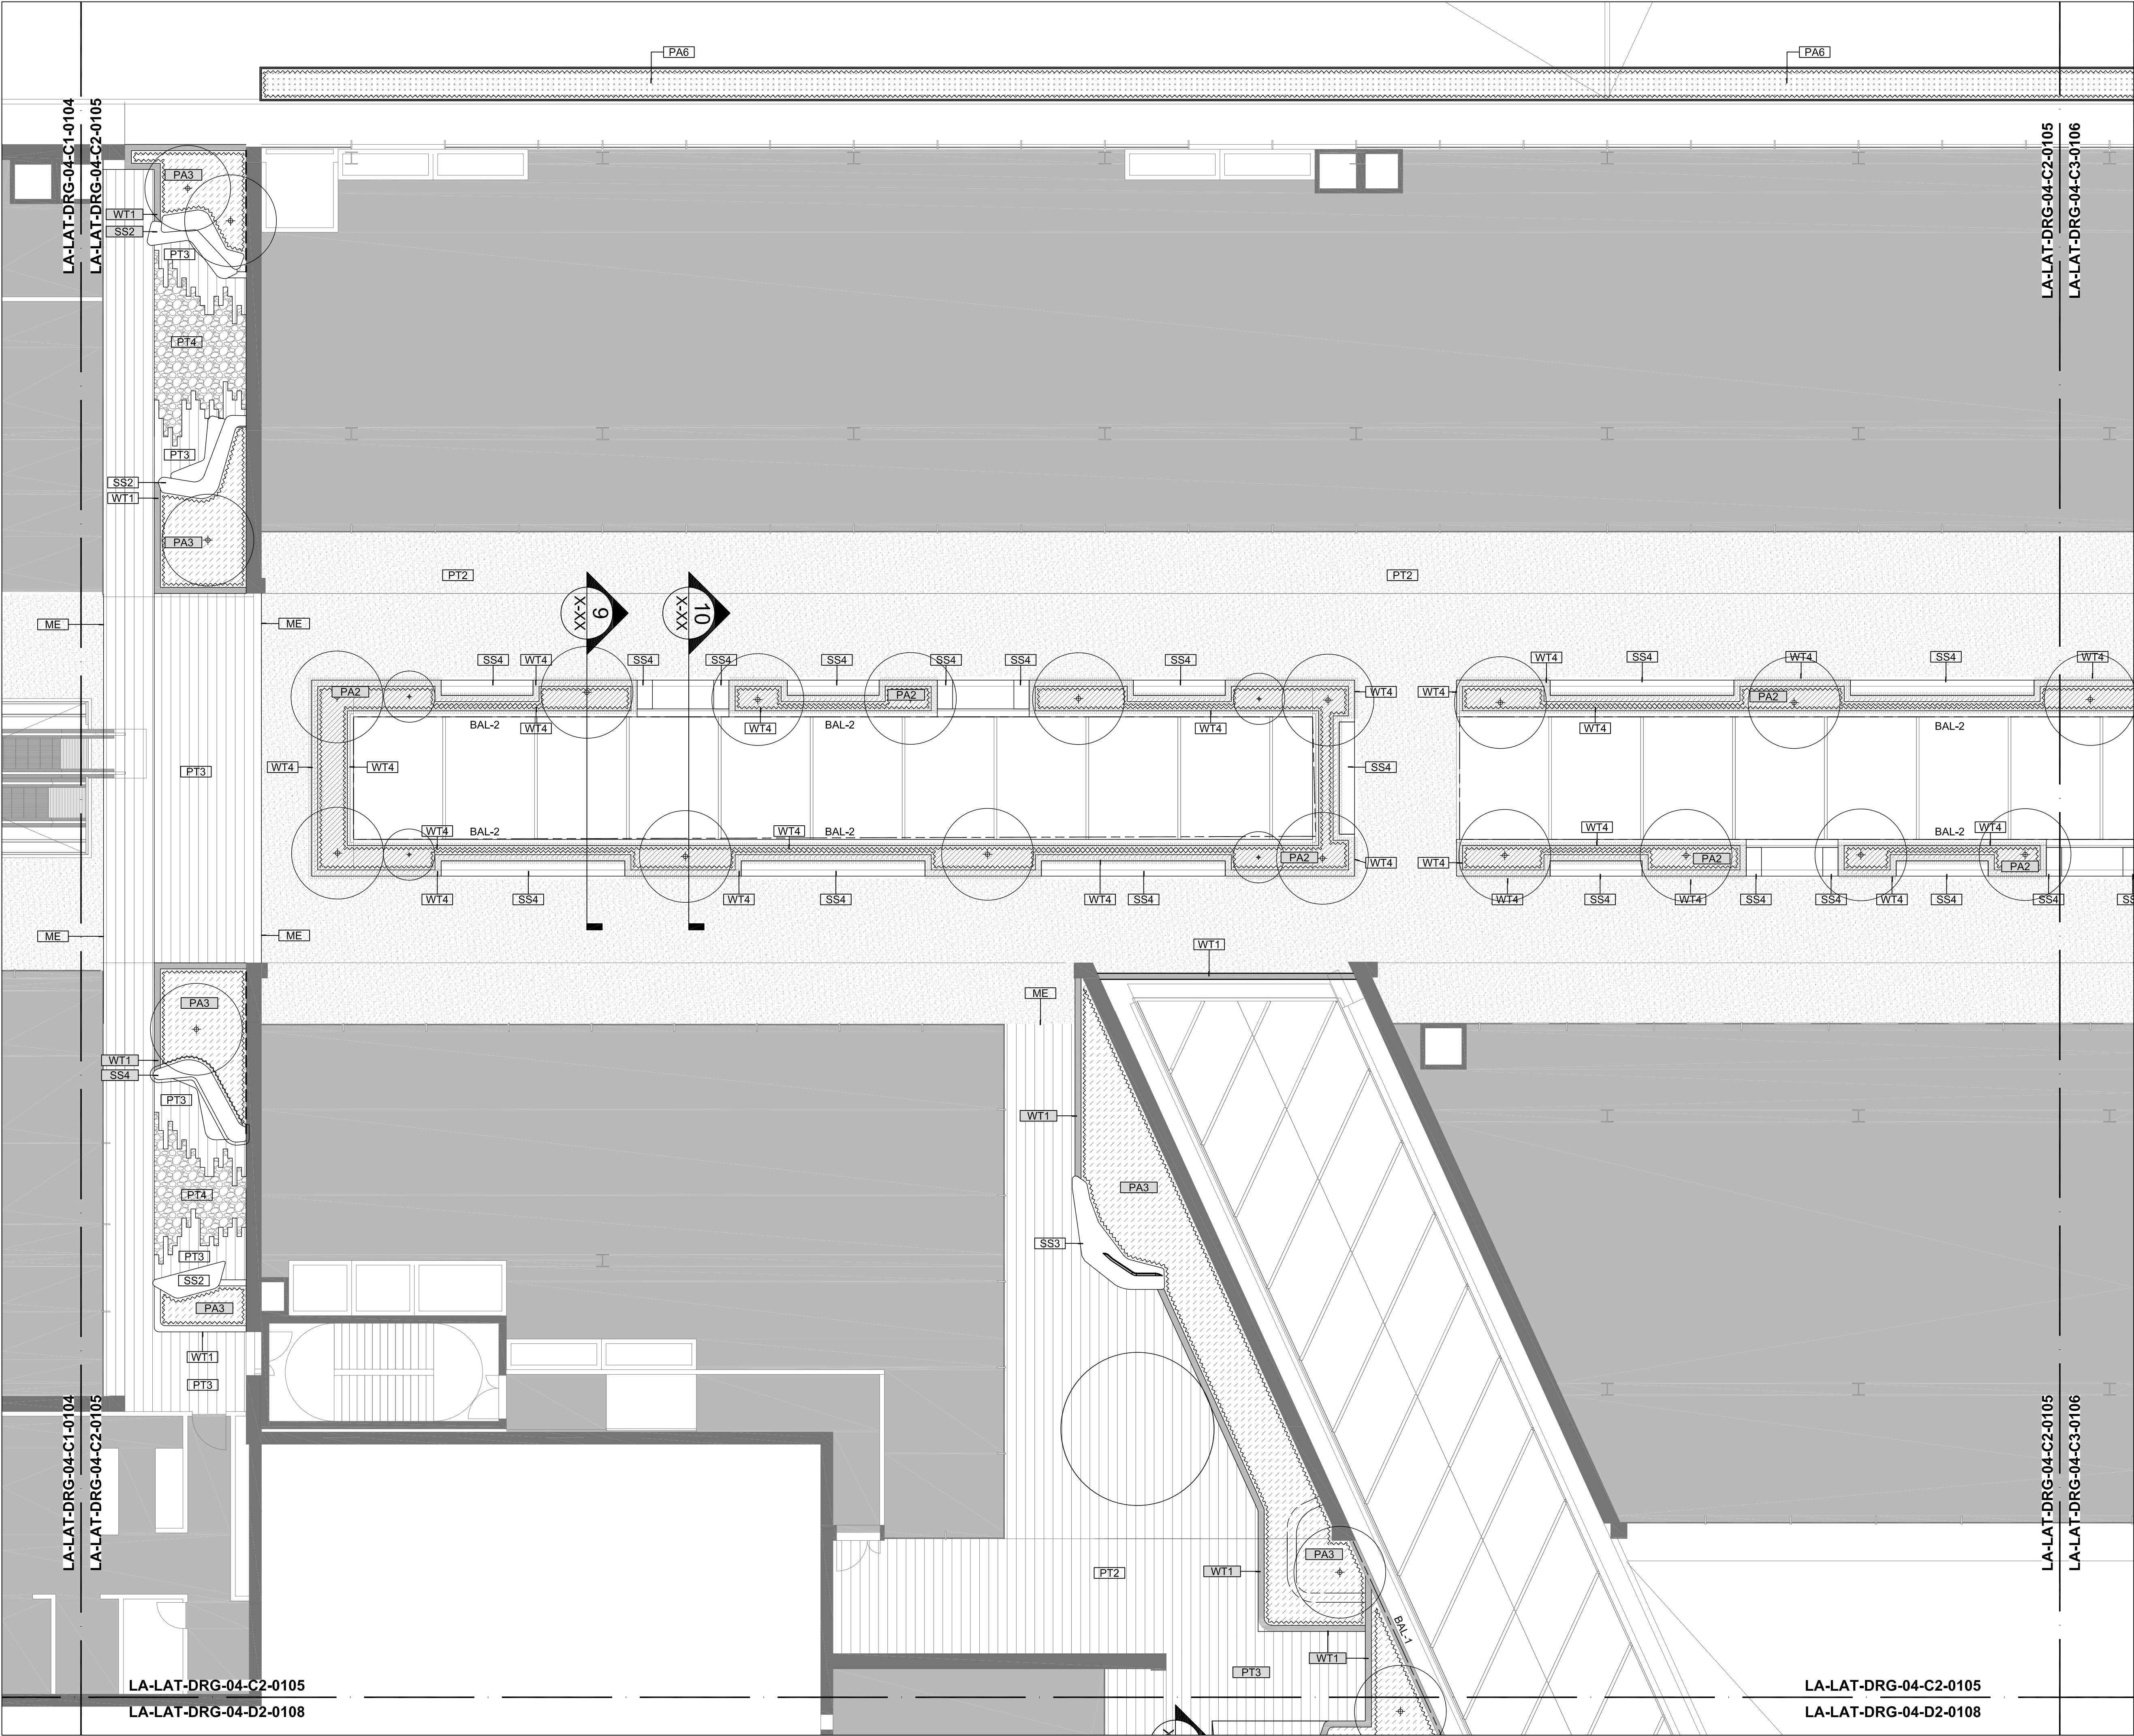

REV	DESCRIPTION	DATE
01	DRAFT 50% DOC	02.11.18
02	UPDATED DA	13.05.19

THIS DRAWING IS TO BE READ IN CONJUNCTION WITH DETAILS AND SPECIFICATIONS PREPARED BY LAT27 PTY LTD. PRIOR TO UNDERTAKING ANY CONSTRUCTION, ANY CONFLICTS THAT EXIST ON THIS DRAWING, OR ADVICE AND DIRECTION REQUIRED SHOULD BE SOUGHT FROM LAT27 PTY LTD.

1. ALL STRUCTURAL, CIVIL, HYDRAULIC AND ELECTRICAL INFORMATION INDICATED ON THIS DRAWING IS OUTSIDE THE DEFINED SCOPE OF LAT27. ALL CONSULTANT INFORMATION SHOWN IS FOR COORDINATION PURPOSES ONLY AND REFERENCE IS TO BE MADE TO THE RELEVANT CONSULTANTS DRAWINGS AND SPECIFICATIONS ACCORDINGLY FOR CONSTRUCTION.

2. FIGURED DIMENSIONS TAKE PRECEDENCE OVER SCALED.

3. CHECK ALL DIMENSIONS ON SITE PRIOR TO COMMENCEMENT OF WORK.

© COPYRIGHT LAT27 PTY LTD ALL RIGHTS RESERVED. THIS DRAWING MAY NOT BE PRODUCED OR TRANSMITTED IN ANY FORM OR BY ANY MEANS IN PART OR IN WHOLE WITHOUT THE WRITTEN PERMISSION OF LAT27 PTY LTD

NOT FOR CONSTRUCTION

07 3236 1086
Level 5, 300 Ann Street
Brisbane, Qld 4000
www.lat27.com.au



CLIENT
VICINITY CENTRES




PROJECT TITLE
CHATSWOOD CHASE

DRAWING TITLE
**LEVEL 4 - C2
FINISHES PLAN - SHEET 5**

SCALE BAR
SCALE 1:100 @ A1
0m 1.0 2.0 3.0 4.0 5.0
SCALE 1:200 @ A3

PROJECT No. 17140.01	SCALE 1:100	
DRAWN BY ST	VERIFIER NW	
DRAWING No. LA-LAT-DRG-04-C2-0105	REVISION 02	

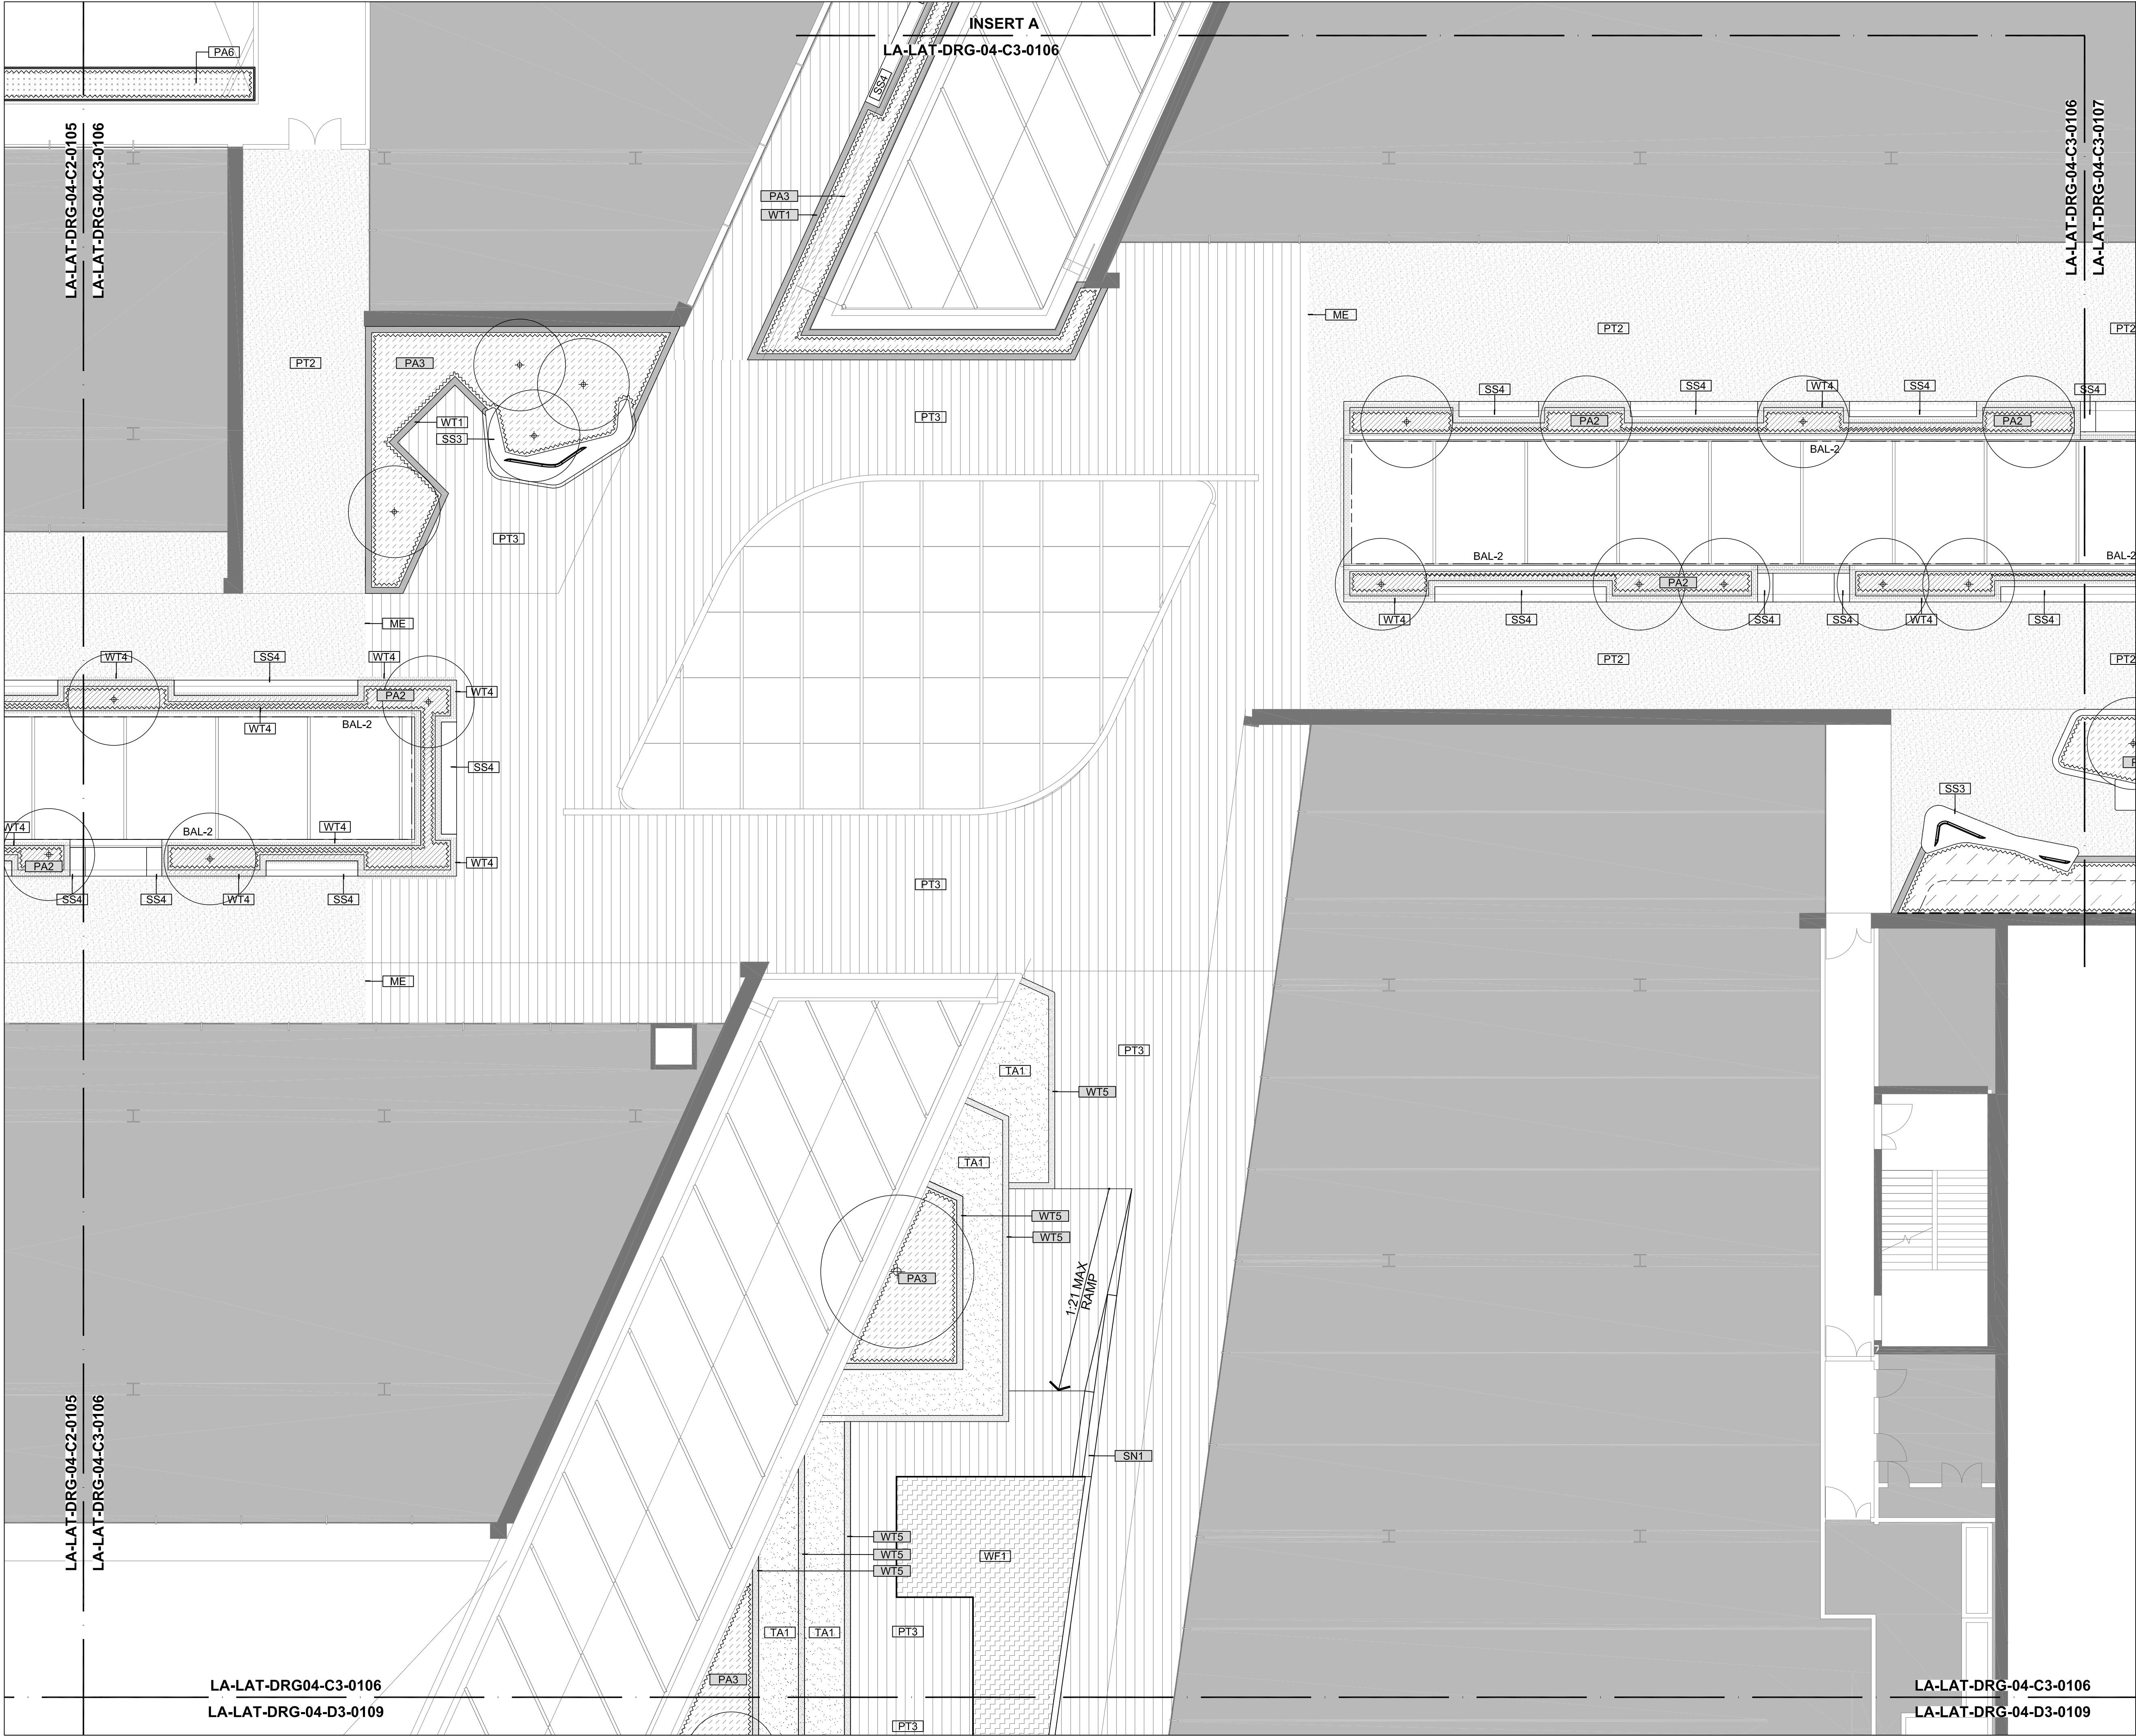

REV	DESCRIPTION	DATE
01	DRAFT 50% DOC	02.11.18
02	UPDATED DA	13.05.19

THIS DRAWING IS TO BE READ IN CONJUNCTION WITH DETAILS AND SPECIFICATIONS PREPARED BY LAT27 PTY LTD. PRIOR TO UNDERTAKING ANY CONSTRUCTION, ANY CONFLICTS THAT EXIST ON THIS DRAWING, OR ADVICE AND DIRECTION REQUIRED SHOULD BE SOUGHT FROM LAT27 PTY LTD.

1. ALL STRUCTURAL, CIVIL, HYDRAULIC AND ELECTRICAL INFORMATION INDICATED ON THIS DRAWING IS OUTSIDE THE DEFINED SCOPE OF LAT27. ALL CONSULTANT INFORMATION SHOWN IS FOR COORDINATION PURPOSES ONLY AND REFERENCE IS TO BE MADE TO THE RELEVANT CONSULTANTS DRAWINGS AND SPECIFICATIONS ACCORDINGLY FOR CONSTRUCTION.

2. FIGURED DIMENSIONS TAKE PRECEDENCE OVER SCALED.

3. CHECK ALL DIMENSIONS ON SITE PRIOR TO COMMENCEMENT OF WORK.

© COPYRIGHT LAT27 PTY LTD ALL RIGHTS RESERVED. THIS DRAWING MAY NOT BE PRODUCED OR TRANSMITTED IN ANY FORM OR BY ANY MEANS IN PART OR IN WHOLE WITHOUT THE WRITTEN PERMISSION OF LAT27 PTY LTD

NOT FOR CONSTRUCTION

07 3236 1086
Level 5, 300 Ann Street
Brisbane, Qld 4000
www.lat27.com.au



CLIENT
VICINITY CENTRES



PROJECT TITLE
CHATSWOOD CHASE

DRAWING TITLE
LEVEL 4 - C3
FINISHES PLAN - SHEET 6

SCALE BAR
SCALE 1:100 @ A1
0m 1.0 2.0 3.0 4.0 5.0
SCALE 1:200 @ A3

PROJECT No. 17140.01	SCALE 1:100	
DRAWN BY ST	VERIFIER NW	
DRAWING No. LA-LAT-DRG-04-C3-0106	REVISION 02	

REV	DESCRIPTION	DATE
01	DRAFT 50% DOC	02.11.18
02	UPDATED DA	13.05.19

THIS DRAWING IS TO BE READ IN CONJUNCTION WITH DETAILS AND SPECIFICATIONS PREPARED BY LAT27 PTY LTD. PRIOR TO UNDERTAKING ANY CONSTRUCTION, ANY CONFLICTS THAT EXIST ON THIS DRAWING, OR ADVICE AND DIRECTION REQUIRED SHOULD BE SOUGHT FROM LAT27 PTY LTD.

1. ALL STRUCTURAL, CIVIL, HYDRAULIC AND ELECTRICAL INFORMATION INDICATED ON THIS DRAWING IS OUTSIDE THE DEFINED SCOPE OF LAT27. ALL CONSULTANT INFORMATION SHOWN IS FOR COORDINATION PURPOSES ONLY AND REFERENCE IS TO BE MADE TO THE RELEVANT CONSULTANTS DRAWINGS AND SPECIFICATIONS ACCORDINGLY FOR CONSTRUCTION.

2. FIGURED DIMENSIONS TAKE PRECEDENCE OVER SCALED.

3. CHECK ALL DIMENSIONS ON SITE PRIOR TO COMMENCEMENT OF WORK.

© COPYRIGHT LAT27 PTY LTD ALL RIGHTS RESERVED. THIS DRAWING MAY NOT BE PRODUCED OR TRANSMITTED IN ANY FORM OR BY ANY MEANS IN PART OR IN WHOLE WITHOUT THE WRITTEN PERMISSION OF LAT27 PTY LTD

LA-LAT-DRG-04-D2-0108

LA-LAT-DRG-04-D3-0109

NOT FOR CONSTRUCTION

07 3236 1086
Level 5, 300 Ann Street
Brisbane, Qld 4000
www.lat27.com.au

lat^{27°}

CLIENT

VICINITY CENTRES



VICINITY
CENTRES

PROJECT TITLE

CHATSWOOD CHASE

DRAWING TITLE

LEVEL 4 - D2
FINISHES PLAN - SHEET 8

SCALE BAR

SCALE 1:100 @ A1

0m

1.0

2.0

3.0

4.0

5.0

SCALE 1:200 @ A3

PROJECT No.
17140.01


DRAWN BY
ST


DRAWING No.
LA-LAT-DRG-04-D2-0108


SCALE
1:100

VERIFIER
NW

REVISION
02

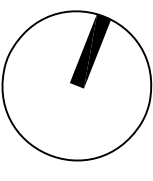

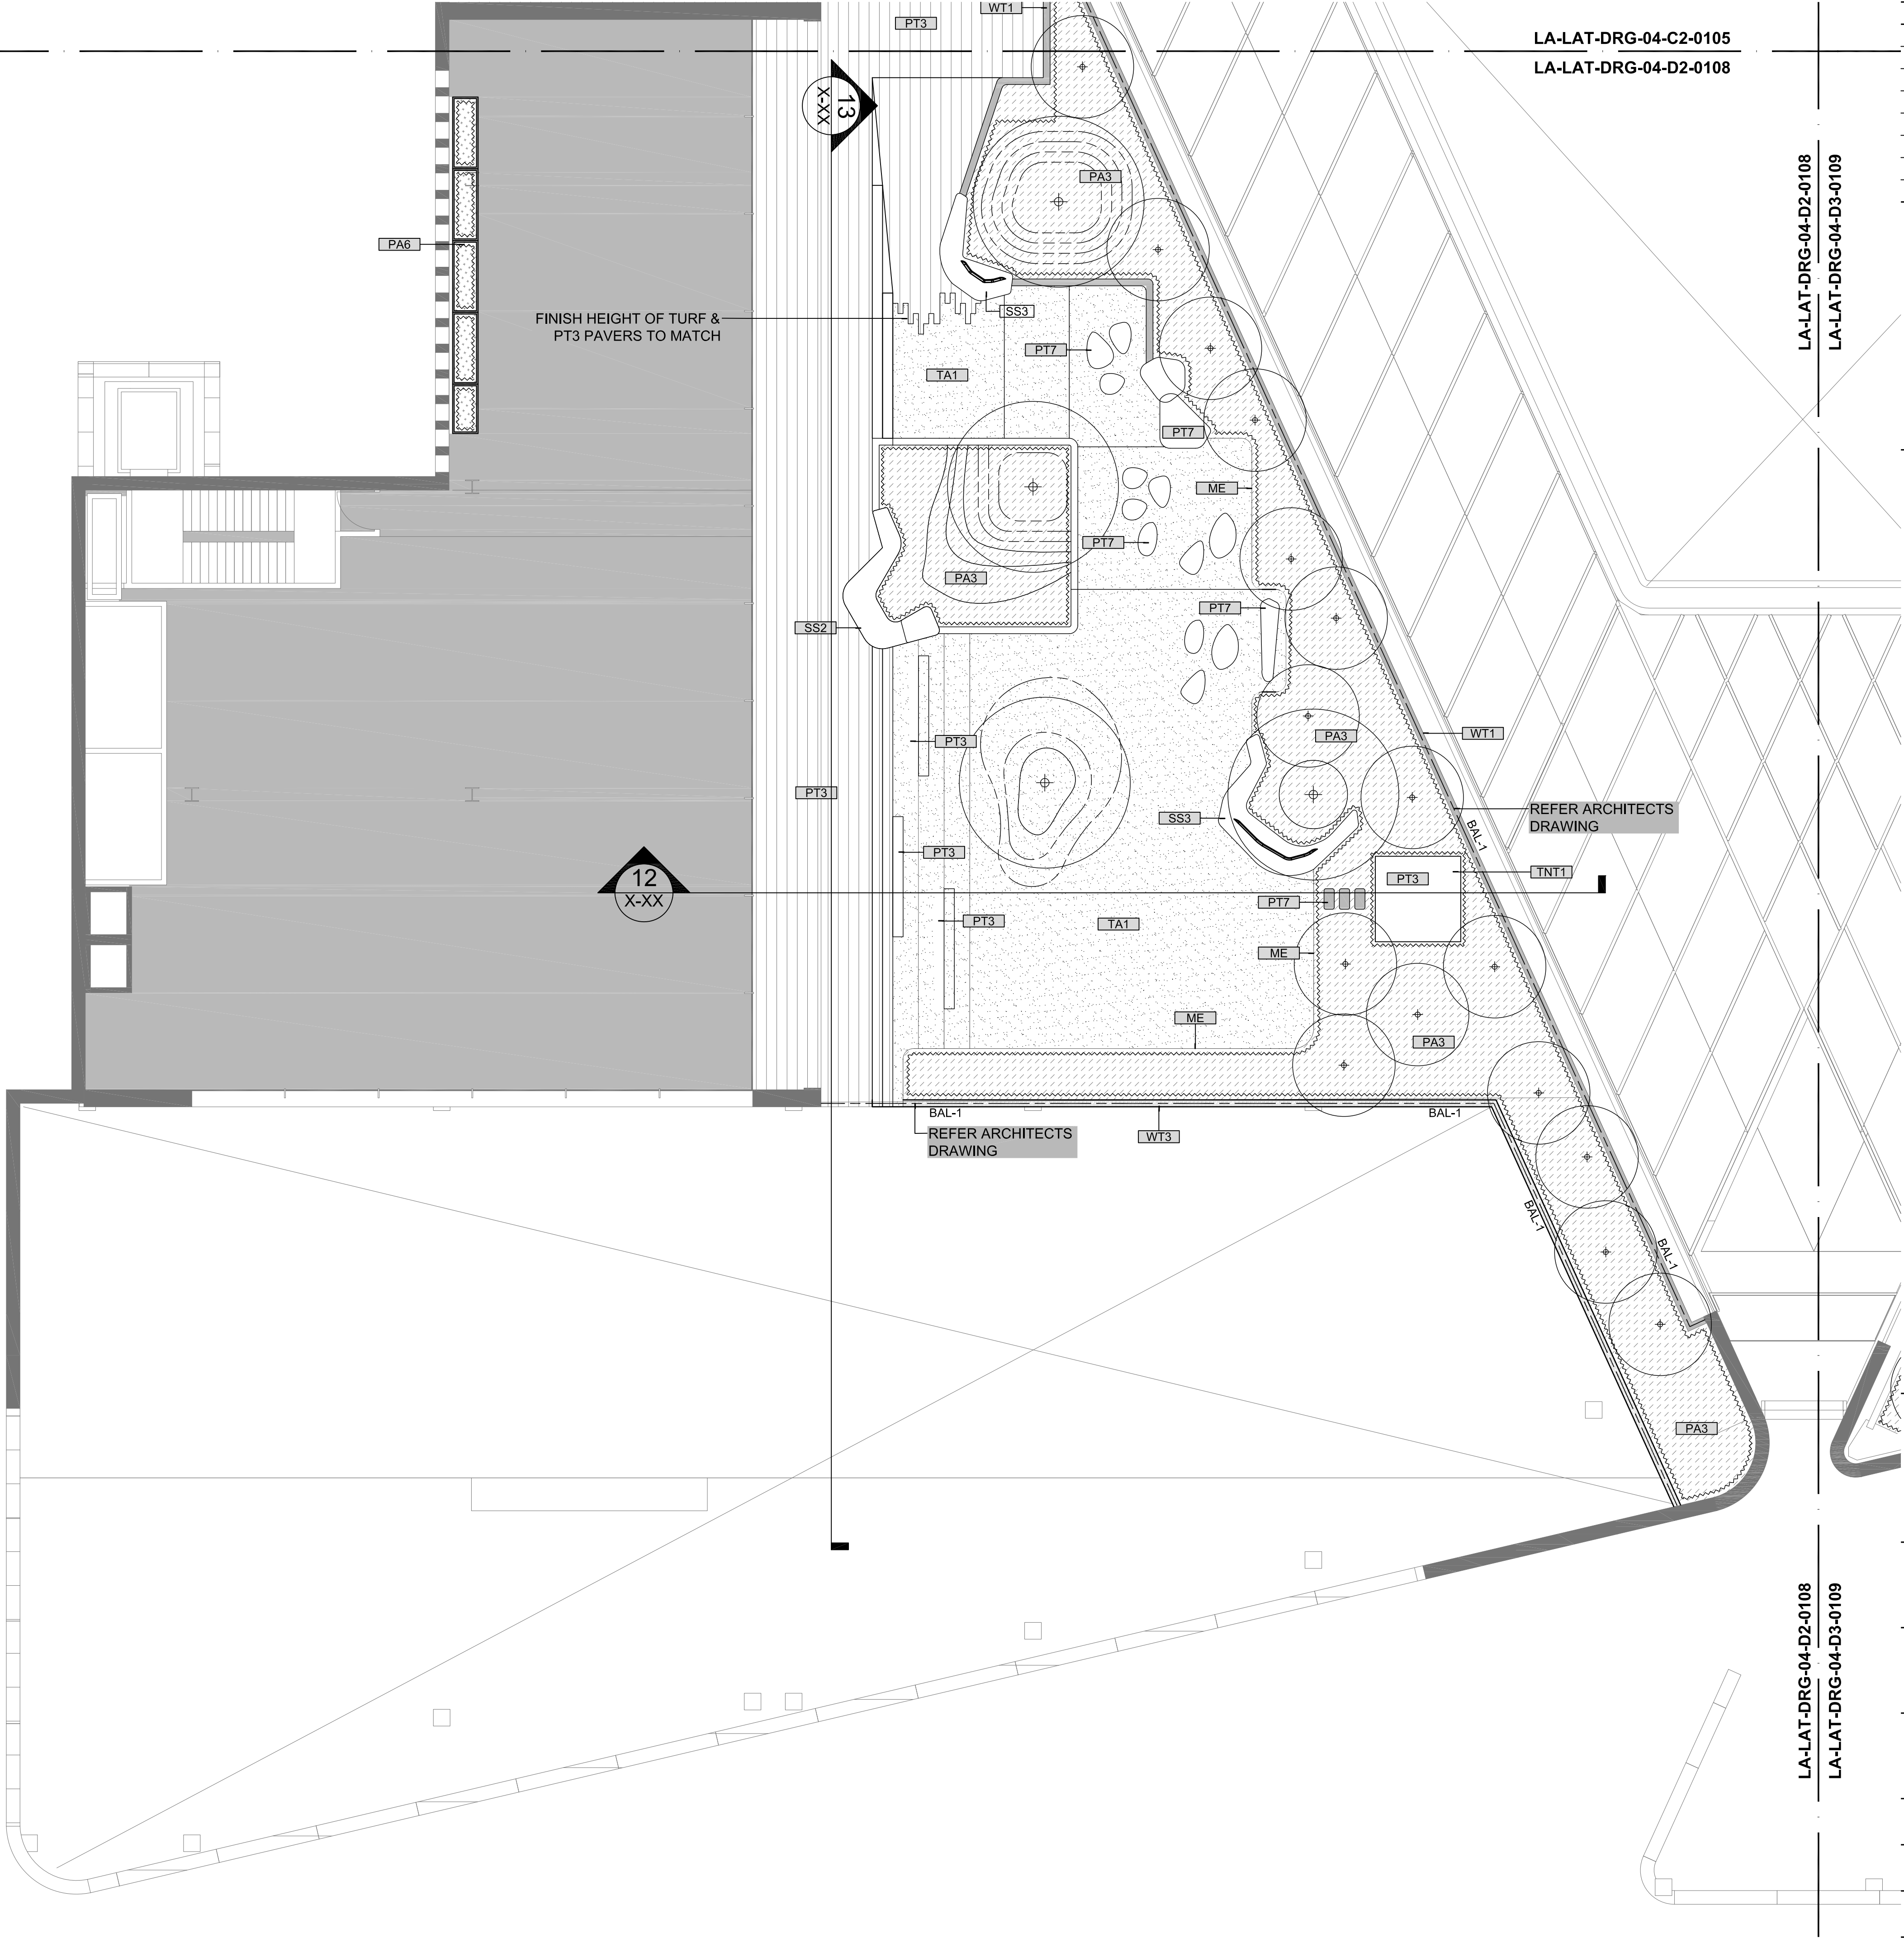

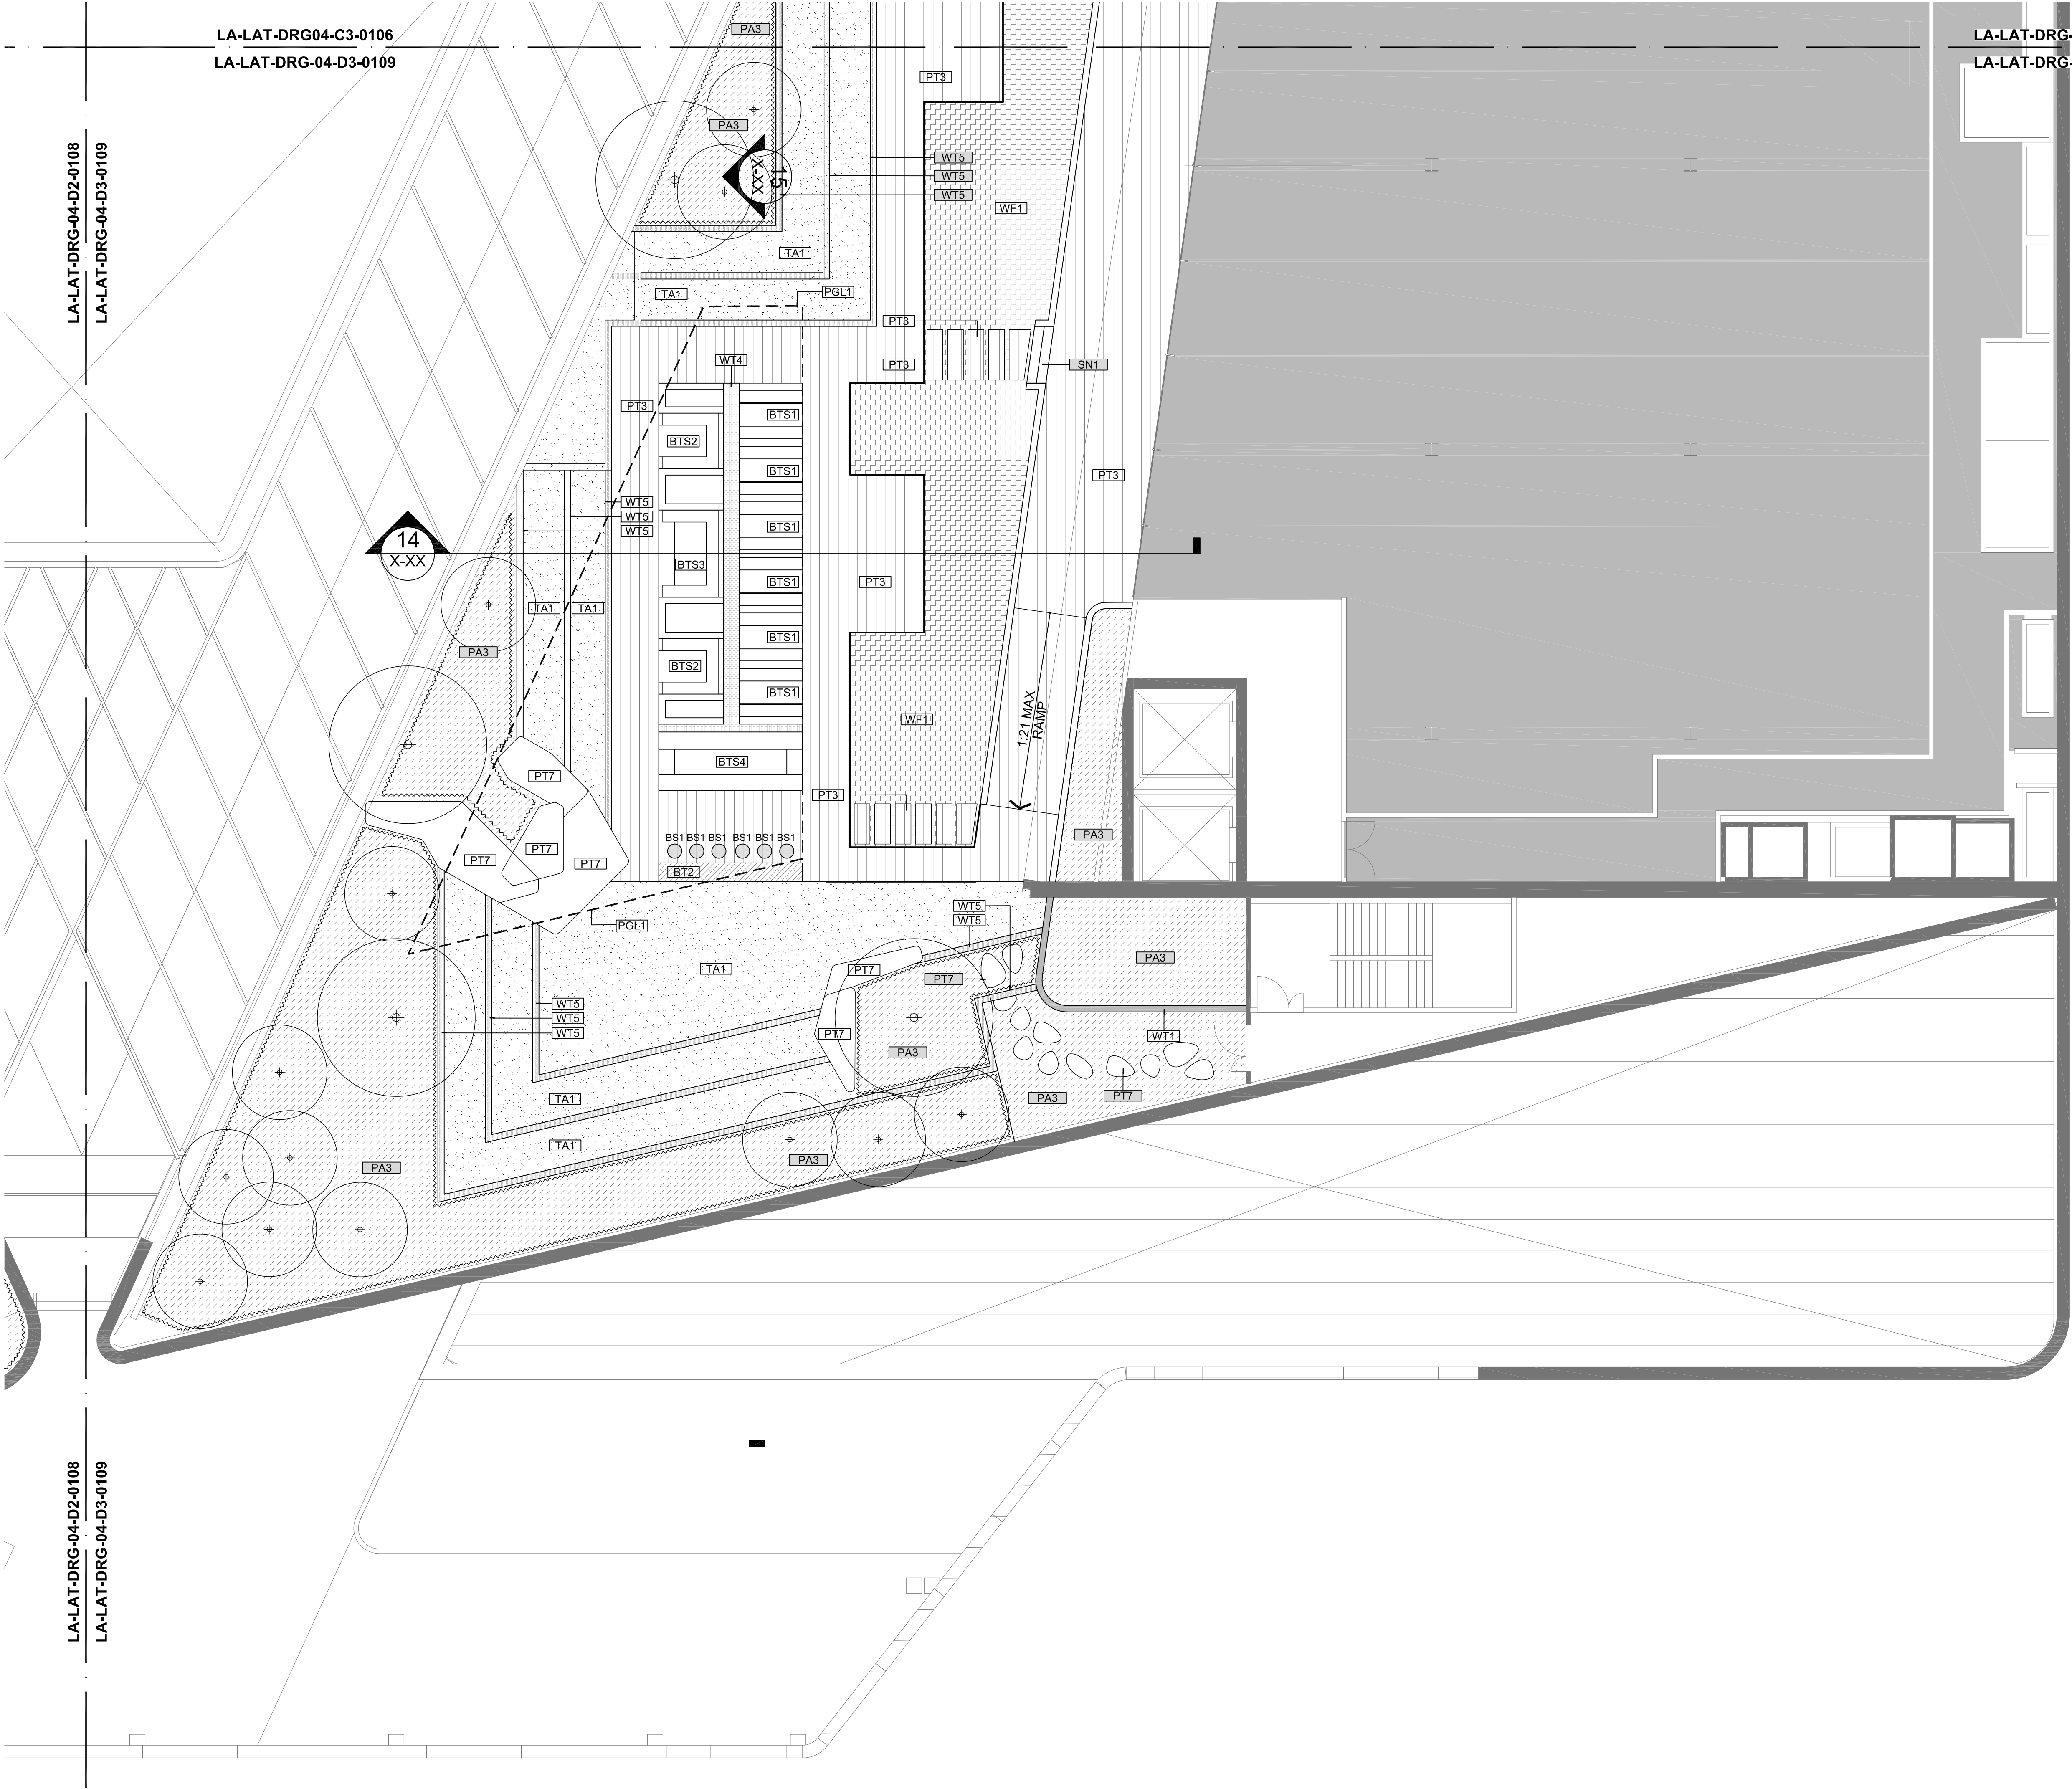

LA-LAT-DRG04-C3-0106
LA-LAT-DRG-04-D3-0109

LA-LAT-DRG-04-D2-0108
LA-LAT-DRG-04-D3-0109

LA-LAT-DRG-04-D2-0108
LA-LAT-DRG-04-D3-0109

LA-LAT-DRG-04-C3-0106
LA-LAT-DRG-04-D3-0109

REV	DESCRIPTION	DATE
01	DRAFT 50% DOC	02.11.18
02	UPDATED DA	13.05.19

THIS DRAWING IS TO BE READ IN CONJUNCTION WITH DETAILS AND SPECIFICATIONS PREPARED BY LAT27 PTY LTD. PRIOR TO UNDERTAKING ANY CONSTRUCTION, ANY CONFLICTS THAT EXIST ON THIS DRAWING, OR ADVICE AND DIRECTION REQUIRED SHOULD BE SOUGHT FROM LAT27 PTY LTD.

1. ALL STRUCTURAL, CIVIL, HYDRAULIC AND ELECTRICAL INFORMATION INDICATED ON THIS DRAWING IS OUTSIDE THE DEFINED SCOPE OF LAT27. ALL CONSULTANT INFORMATION SHOWN IS FOR COORDINATION PURPOSES ONLY AND REFERENCE IS TO BE MADE TO THE RELEVANT CONSULTANTS DRAWINGS AND SPECIFICATIONS ACCORDINGLY FOR CONSTRUCTION.

2. FIGURED DIMENSIONS TAKE PRECEDENCE OVER SCALED.

3. CHECK ALL DIMENSIONS ON SITE PRIOR TO COMMENCEMENT OF WORK.

© COPYRIGHT LAT27 PTY LTD ALL RIGHTS RESERVED. THIS DRAWING MAY NOT BE PRODUCED OR TRANSMITTED IN ANY FORM OR BY ANY MEANS IN PART OR IN WHOLE WITHOUT THE WRITTEN PERMISSION OF LAT27 PTY LTD

NOT FOR CONSTRUCTION


07 3236 1086
Level 5, 300 Ann Street
Brisbane, Qld 4000
www.lat27.com.au

lat²⁷

CLIENT
VICINITY CENTRES


VICINITY
CENTRES

PROJECT TITLE		
CHATSWOOD CHASE		
DRAWING TITLE		
LEVEL 4 - D3		
FINISHES PLAN - SHEET 9		
SCALE BAR		
SCALE 1:100 @ A1		

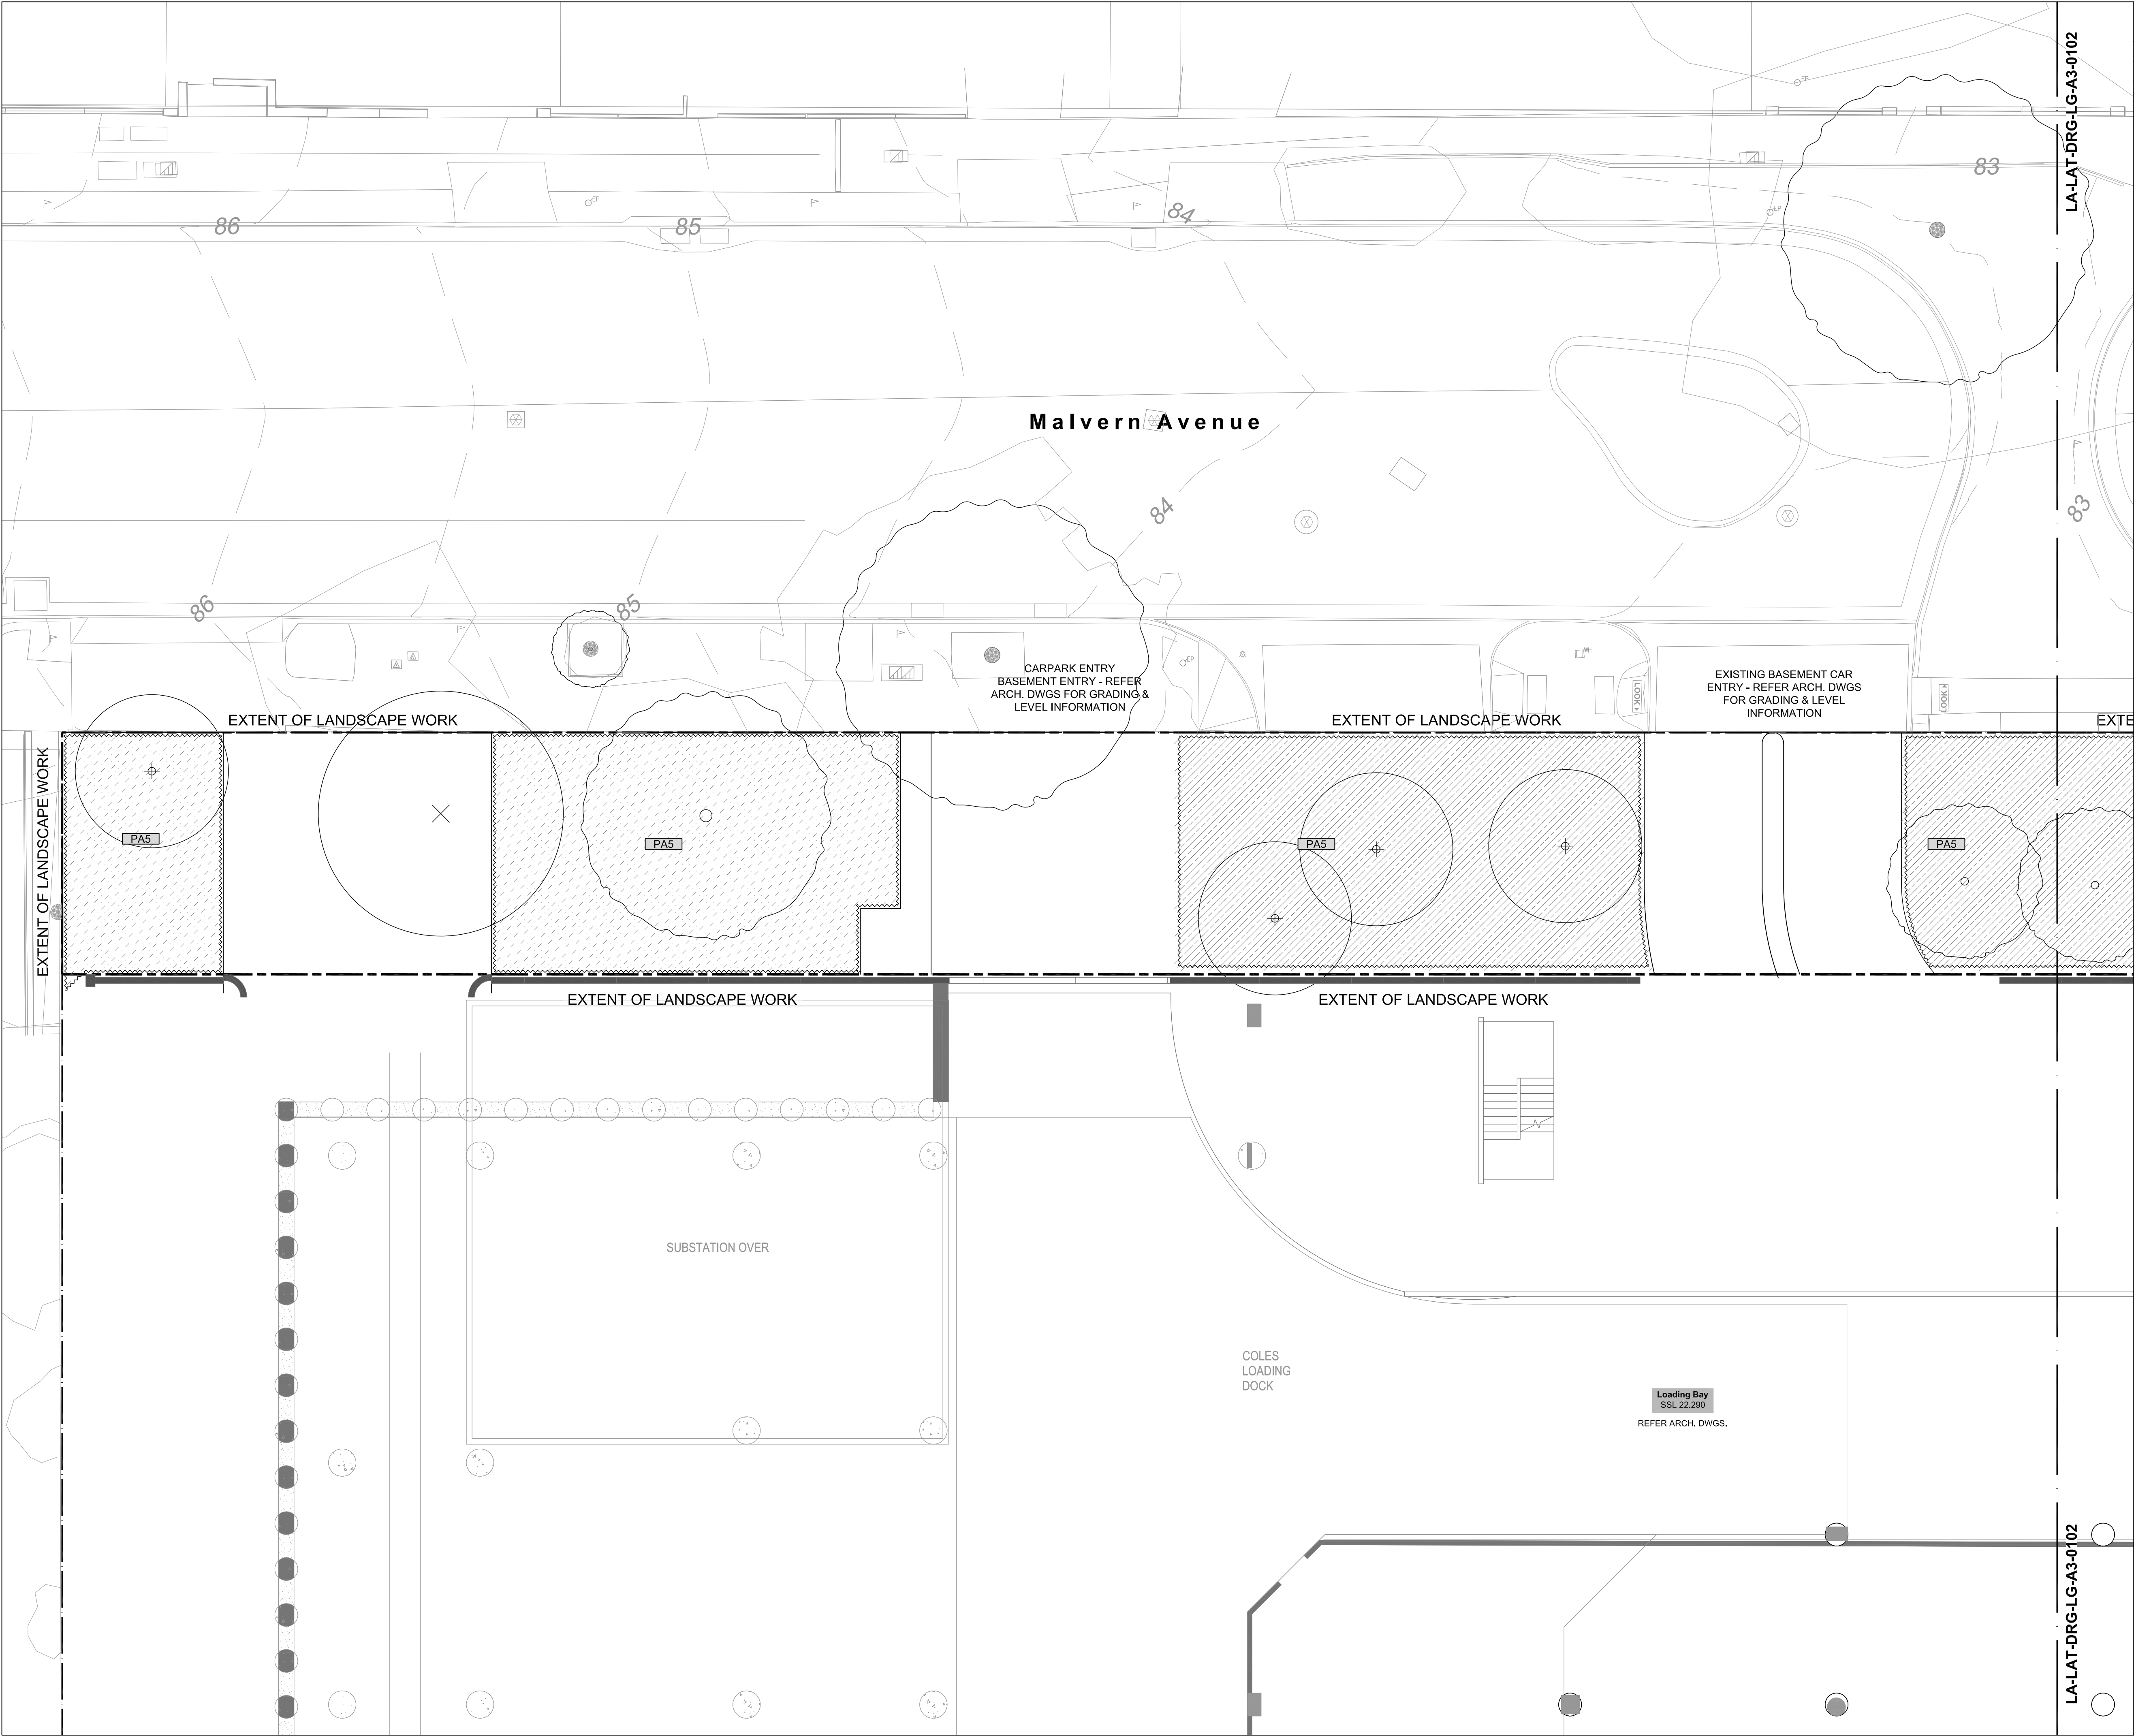

REV	DESCRIPTION	DATE
01	DRAFT 50% DOC	02.11.18
02	UPDATED DA	13.05.19
THIS DRAWING IS TO BE READ IN CONJUNCTION WITH DETAILS AND SPECIFICATIONS PREPARED BY LAT27 PTY LTD. PRIOR TO UNDERTAKING ANY CONSTRUCTION, ANY CONFLICTS THAT EXIST ON THIS DRAWING, OR ADVICE AND DIRECTION REQUIRED SHOULD BE SOUGHT FROM LAT27 PTY LTD.		
1. ALL STRUCTURAL, CIVIL, HYDRAULIC AND ELECTRICAL INFORMATION INDICATED ON THIS DRAWING IS OUTSIDE THE DEFINED SCOPE OF LAT27. ALL CONSULTANT INFORMATION SHOWN IS FOR COORDINATION PURPOSES ONLY AND REFERENCE IS TO BE MADE TO THE RELEVANT CONSULTANTS DRAWINGS AND SPECIFICATIONS ACCORDINGLY FOR CONSTRUCTION.		
2. FIGURED DIMENSIONS TAKE PRECEDENCE OVER SCALED.		
3. CHECK ALL DIMENSIONS ON SITE PRIOR TO COMMENCEMENT OF WORK.		
© COPYRIGHT LAT27 PTY LTD ALL RIGHTS RESERVED. THIS DRAWING MAY NOT BE PRODUCED OR TRANSMITTED IN ANY FORM OR BY ANY MEANS IN PART OR IN WHOLE WITHOUT THE WRITTEN PERMISSION OF LAT27 PTY LTD		

NOT FOR CONSTRUCTION

07 3236 1086
Level 5, 300 Ann Street
Brisbane, Qld 4000
www.lat27.com.au

CLIENT

VICINITY CENTRES

PROJECT TITLE
CHATSWOOD CHASE


DRAWING TITLE
LOWER GROUND - A2
FINISHES PLAN - SHEET 1

SCALE BAR

SCALE 1:100 @ A1
0m 1.0 2.0 3.0 4.0 5.0

SCALE 1:200 @ A3

PROJECT No. 17140.01	SCALE 1:100	
DRAWN BY ST	VERIFIER NW	
DRAWING No. LA-LAT-DRG-LG-A2-0101	REVISION 02	

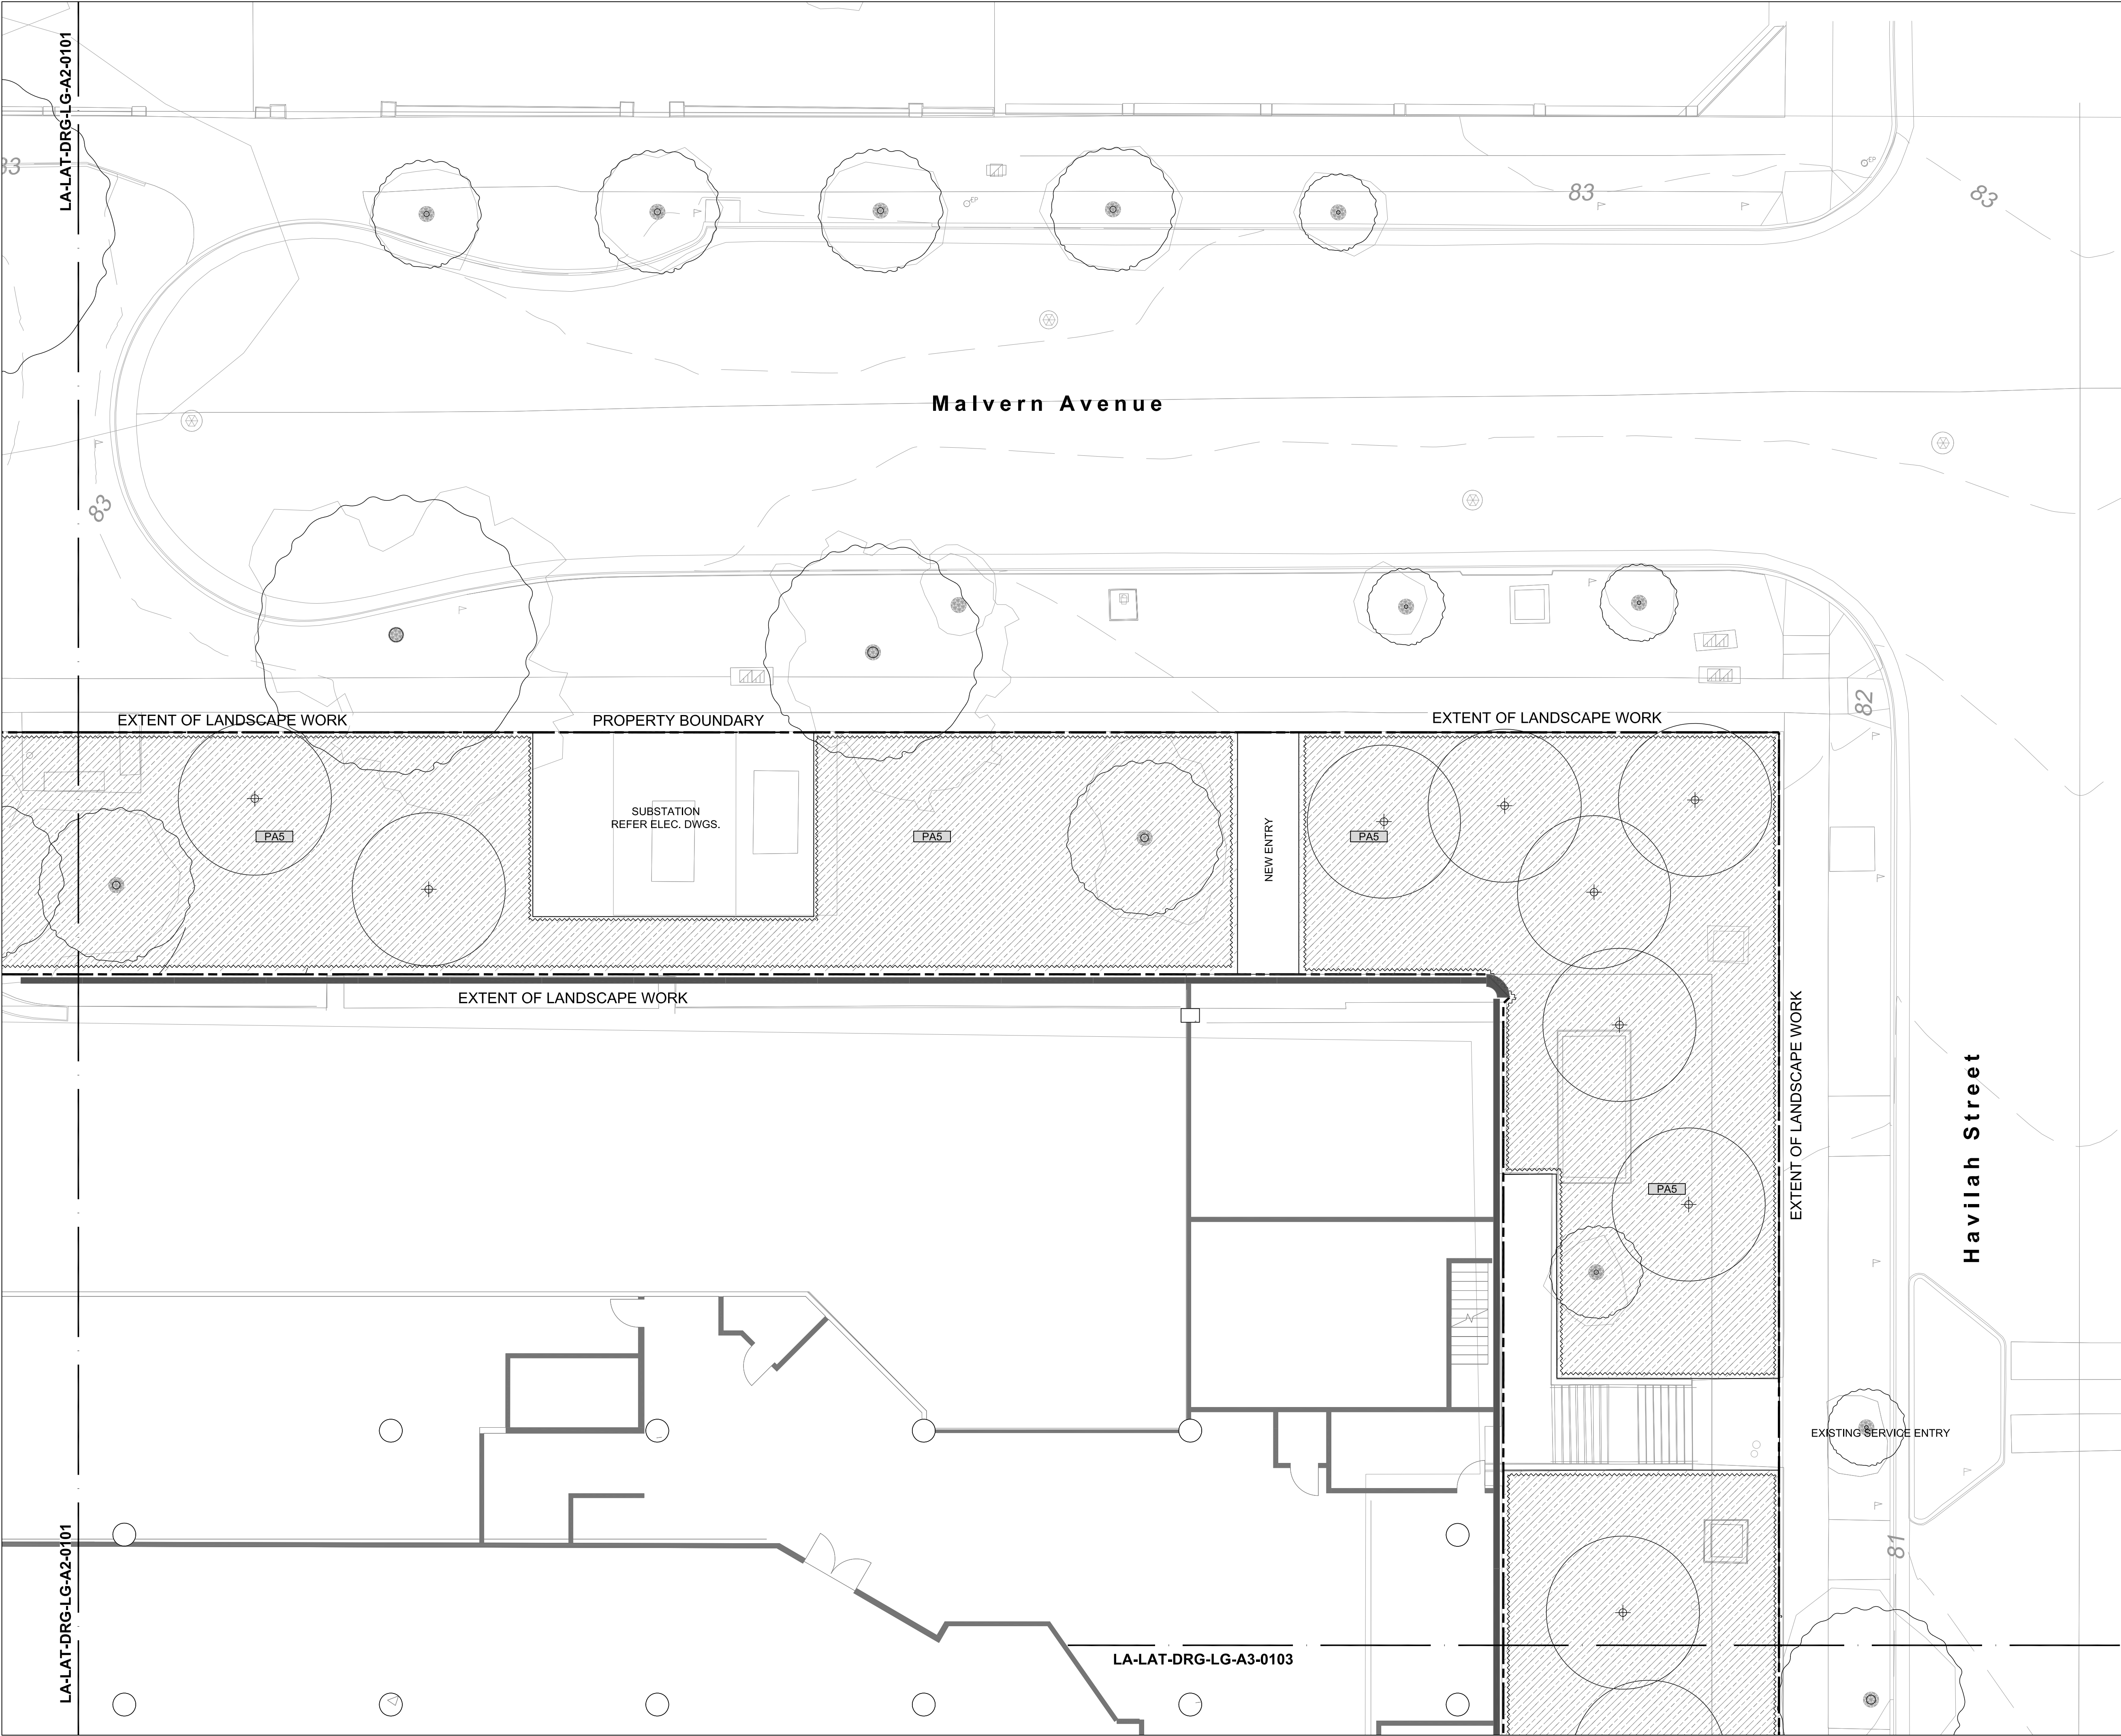

REV	DESCRIPTION	DATE
01	DRAFT 50% DOC	02.11.18
02	UPDATED DA	13.05.19

THIS DRAWING IS TO BE READ IN CONJUNCTION WITH DETAILS AND SPECIFICATIONS PREPARED BY LAT27 PTY LTD. PRIOR TO UNDERTAKING ANY CONSTRUCTION, ANY CONFLICTS THAT EXIST ON THIS DRAWING, OR ADVICE AND DIRECTION REQUIRED SHOULD BE SOUGHT FROM LAT27 PTY LTD.

1. ALL STRUCTURAL, CIVIL, HYDRAULIC AND ELECTRICAL INFORMATION INDICATED ON THIS DRAWING IS OUTSIDE THE DEFINED SCOPE OF LAT27. ALL CONSULTANT INFORMATION SHOWN IS FOR COORDINATION PURPOSES ONLY AND REFERENCE IS TO BE MADE TO THE RELEVANT CONSULTANTS DRAWINGS AND SPECIFICATIONS ACCORDINGLY FOR CONSTRUCTION.

2. FIGURED DIMENSIONS TAKE PRECEDENCE OVER SCALED.

3. CHECK ALL DIMENSIONS ON SITE PRIOR TO COMMENCEMENT OF WORK.

© COPYRIGHT LAT27 PTY LTD ALL RIGHTS RESERVED. THIS DRAWING MAY NOT BE PRODUCED OR TRANSMITTED IN ANY FORM OR BY ANY MEANS IN PART OR IN WHOLE WITHOUT THE WRITTEN PERMISSION OF LAT27 PTY LTD

NOT FOR CONSTRUCTION

07 3236 1086
Level 5, 300 Ann Street
Brisbane, Qld 4000
www.lat27.com.au

lat^{27°}

CLIENT

VICINITY CENTRES




VICINITY
CENTRES


PROJECT TITLE
CHATSWOOD CHASE

DRAWING TITLE
LOWER GROUND - A3
FINISHES PLAN - SHEET 2

SCALE BAR	
SCALE 1:100 @ A1 0m 1.0 2.0 3.0 4.0 5.0	
SCALE 1:200 @ A3	
PROJECT No. 17140.01	SCALE 1:100
DRAWN BY ST	VERIFIER NW
DRAWING No. LA-LAT-DRG-LG-A3-0102	REVISION 02

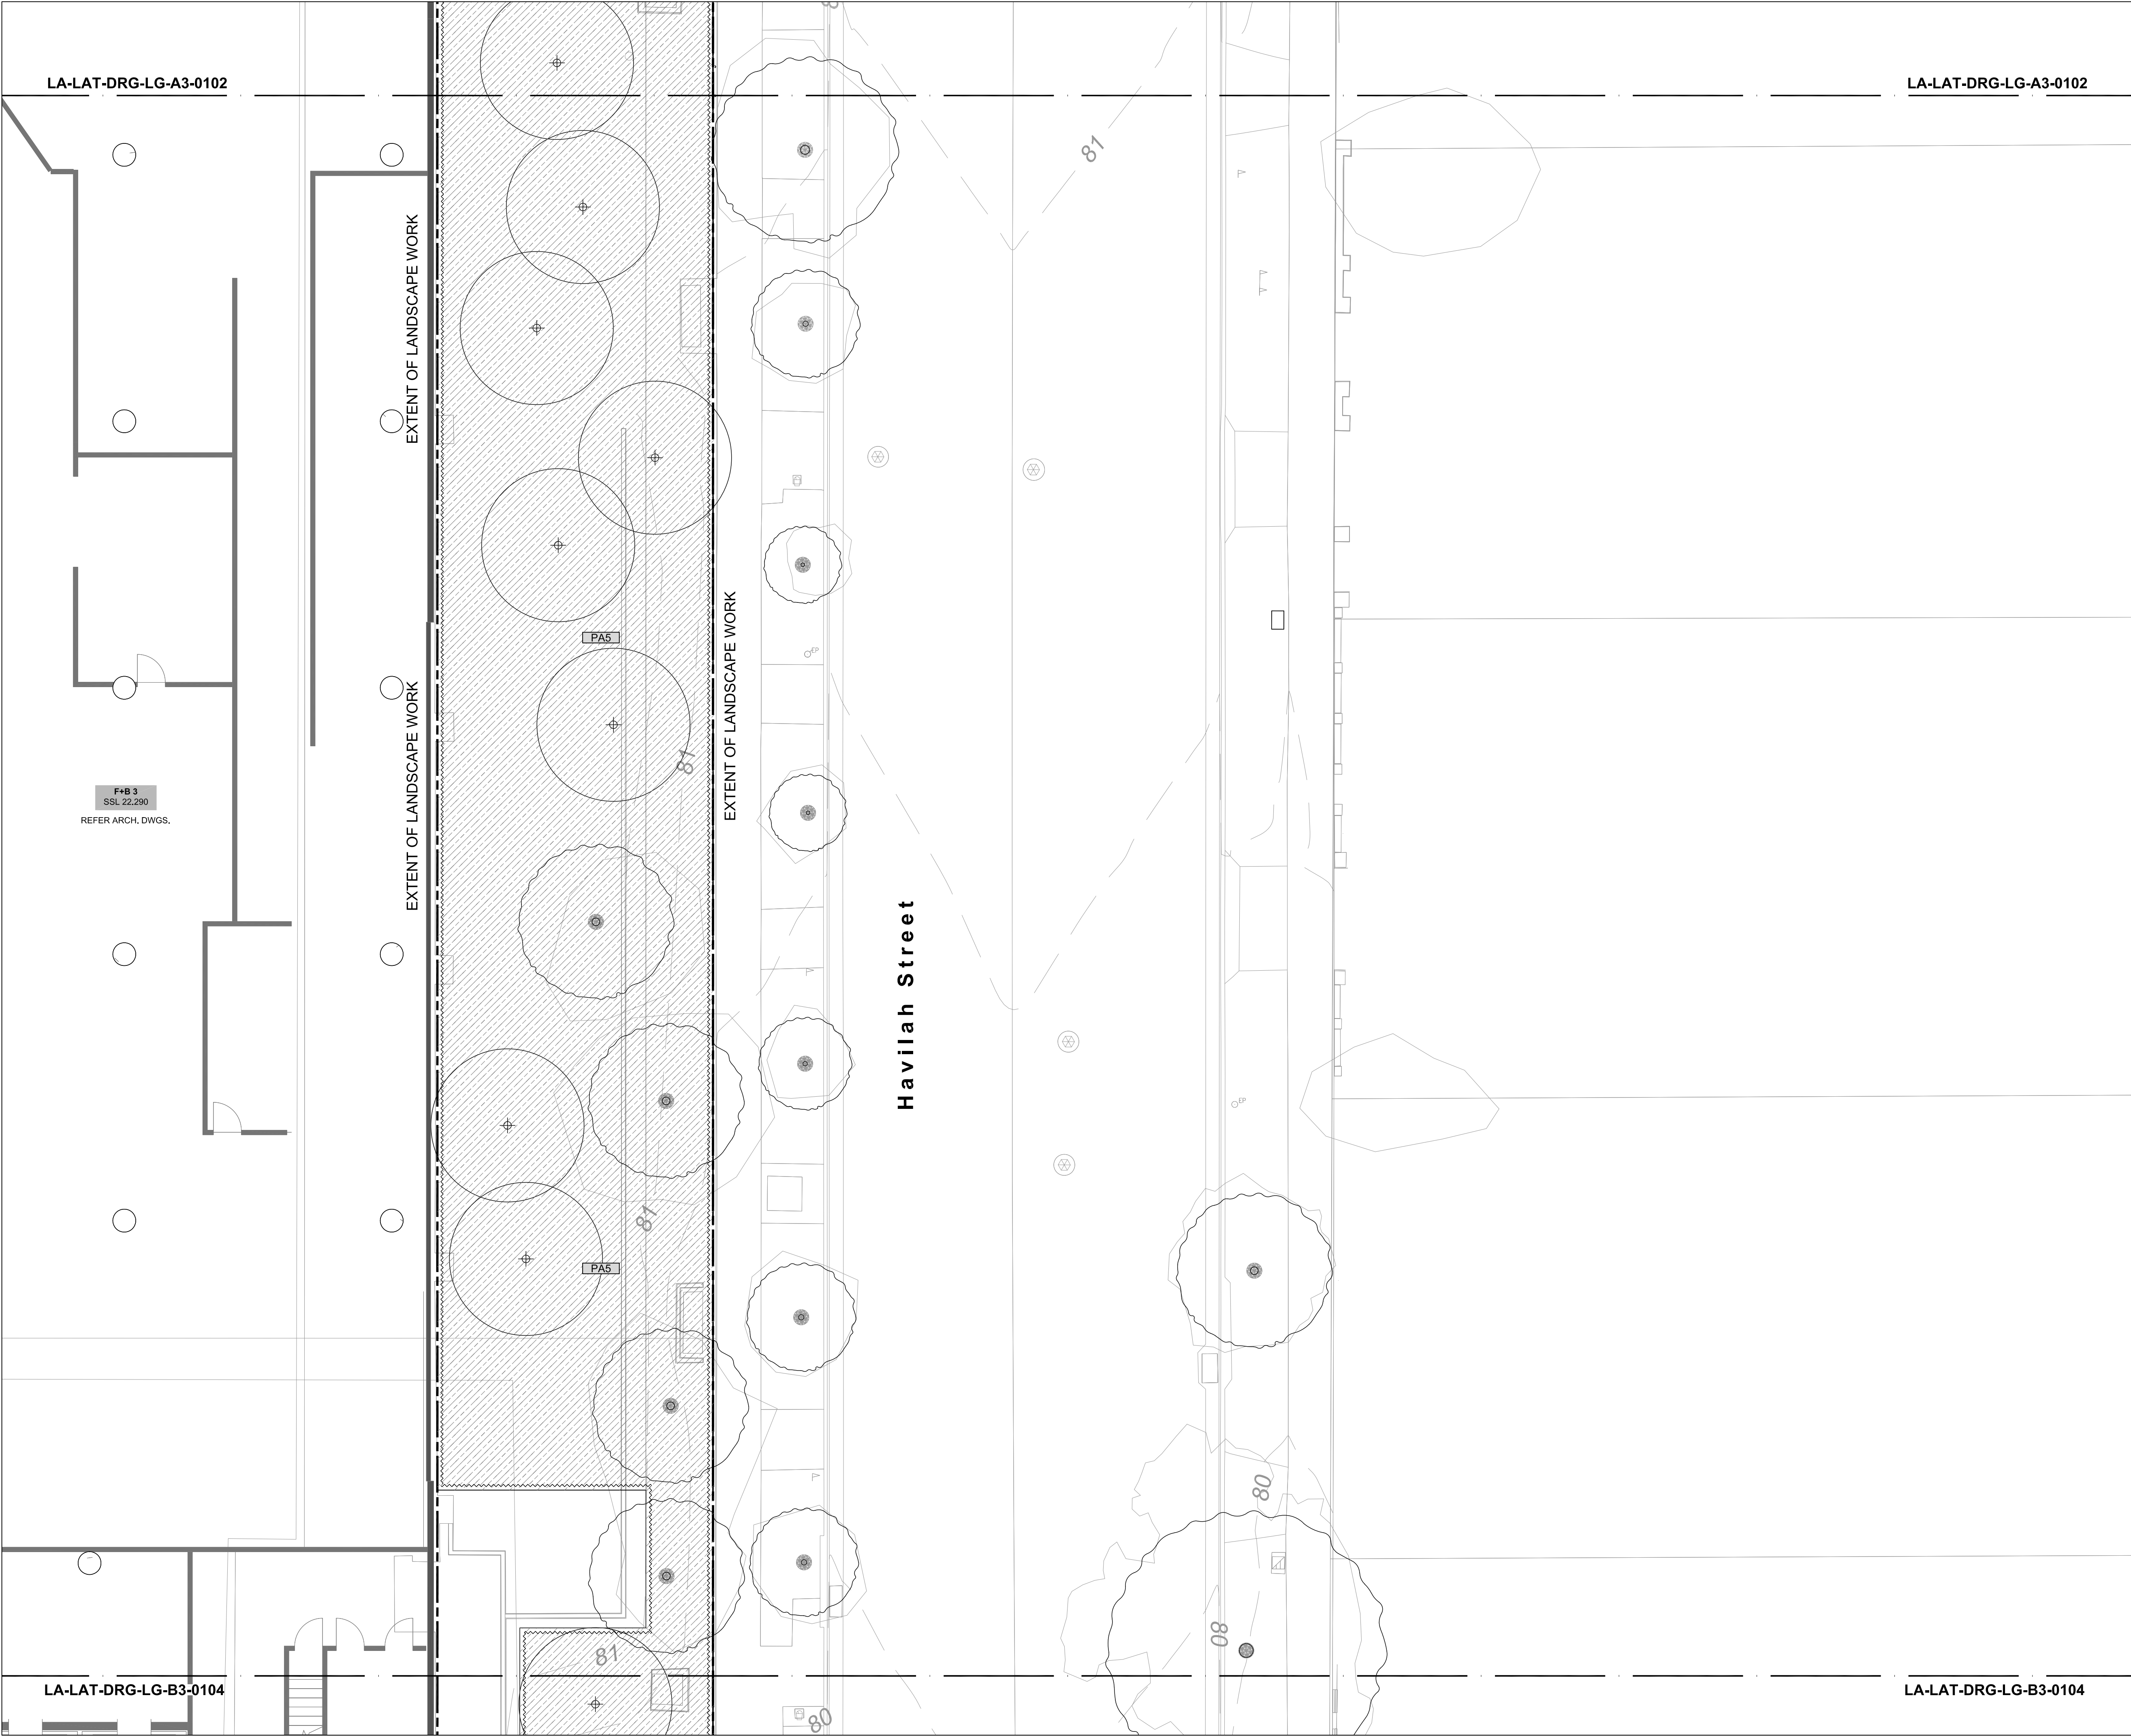

REV	DESCRIPTION	DATE
01	DRAFT 50% DOC	02.11.18
02	UPDATED DA	13.05.19
THIS DRAWING IS TO BE READ IN CONJUNCTION WITH DETAILS AND SPECIFICATIONS PREPARED BY LAT27 PTY LTD. PRIOR TO UNDERTAKING ANY CONSTRUCTION, ANY CONFLICTS THAT EXIST ON THIS DRAWING, OR ADVICE AND DIRECTION REQUIRED SHOULD BE SOUGHT FROM LAT27 PTY LTD.		
1. ALL STRUCTURAL, CIVIL, HYDRAULIC AND ELECTRICAL INFORMATION INDICATED ON THIS DRAWING IS OUTSIDE THE DEFINED SCOPE OF LAT27. ALL CONSULTANT INFORMATION SHOWN IS FOR COORDINATION PURPOSES ONLY AND REFERENCE IS TO BE MADE TO THE RELEVANT CONSULTANTS DRAWINGS AND SPECIFICATIONS ACCORDINGLY FOR CONSTRUCTION.		
2. FIGURED DIMENSIONS TAKE PRECEDENCE OVER SCALED.		
3. CHECK ALL DIMENSIONS ON SITE PRIOR TO COMMENCEMENT OF WORK.		
© COPYRIGHT LAT27 PTY LTD ALL RIGHTS RESERVED. THIS DRAWING MAY NOT BE PRODUCED OR TRANSMITTED IN ANY FORM OR BY ANY MEANS IN PART OR IN WHOLE WITHOUT THE WRITTEN PERMISSION OF LAT27 PTY LTD		
NOT FOR CONSTRUCTION		
07 3236 1086 Level 5, 300 Ann Street Brisbane, Qld 4000 www.lat27.com.au		
lat ²⁷		
CLIENT VICINITY CENTRES		
PROJECT TITLE CHATSWOOD CHASE		
DRAWING TITLE LOWER GROUND - A3 FINISHES PLAN - SHEET 3		
SCALE BAR SCALE 1:100 @ A1 0m 1.0 2.0 3.0 4.0 5.0 SCALE 1:200 @ A3		
PROJECT No. 17140.01	SCALE 1:100	
DRAWN BY ST	VERIFIER NW	
DRAWING No. LA-LAT-DRG-LG-A3-0103	REVISION 02	

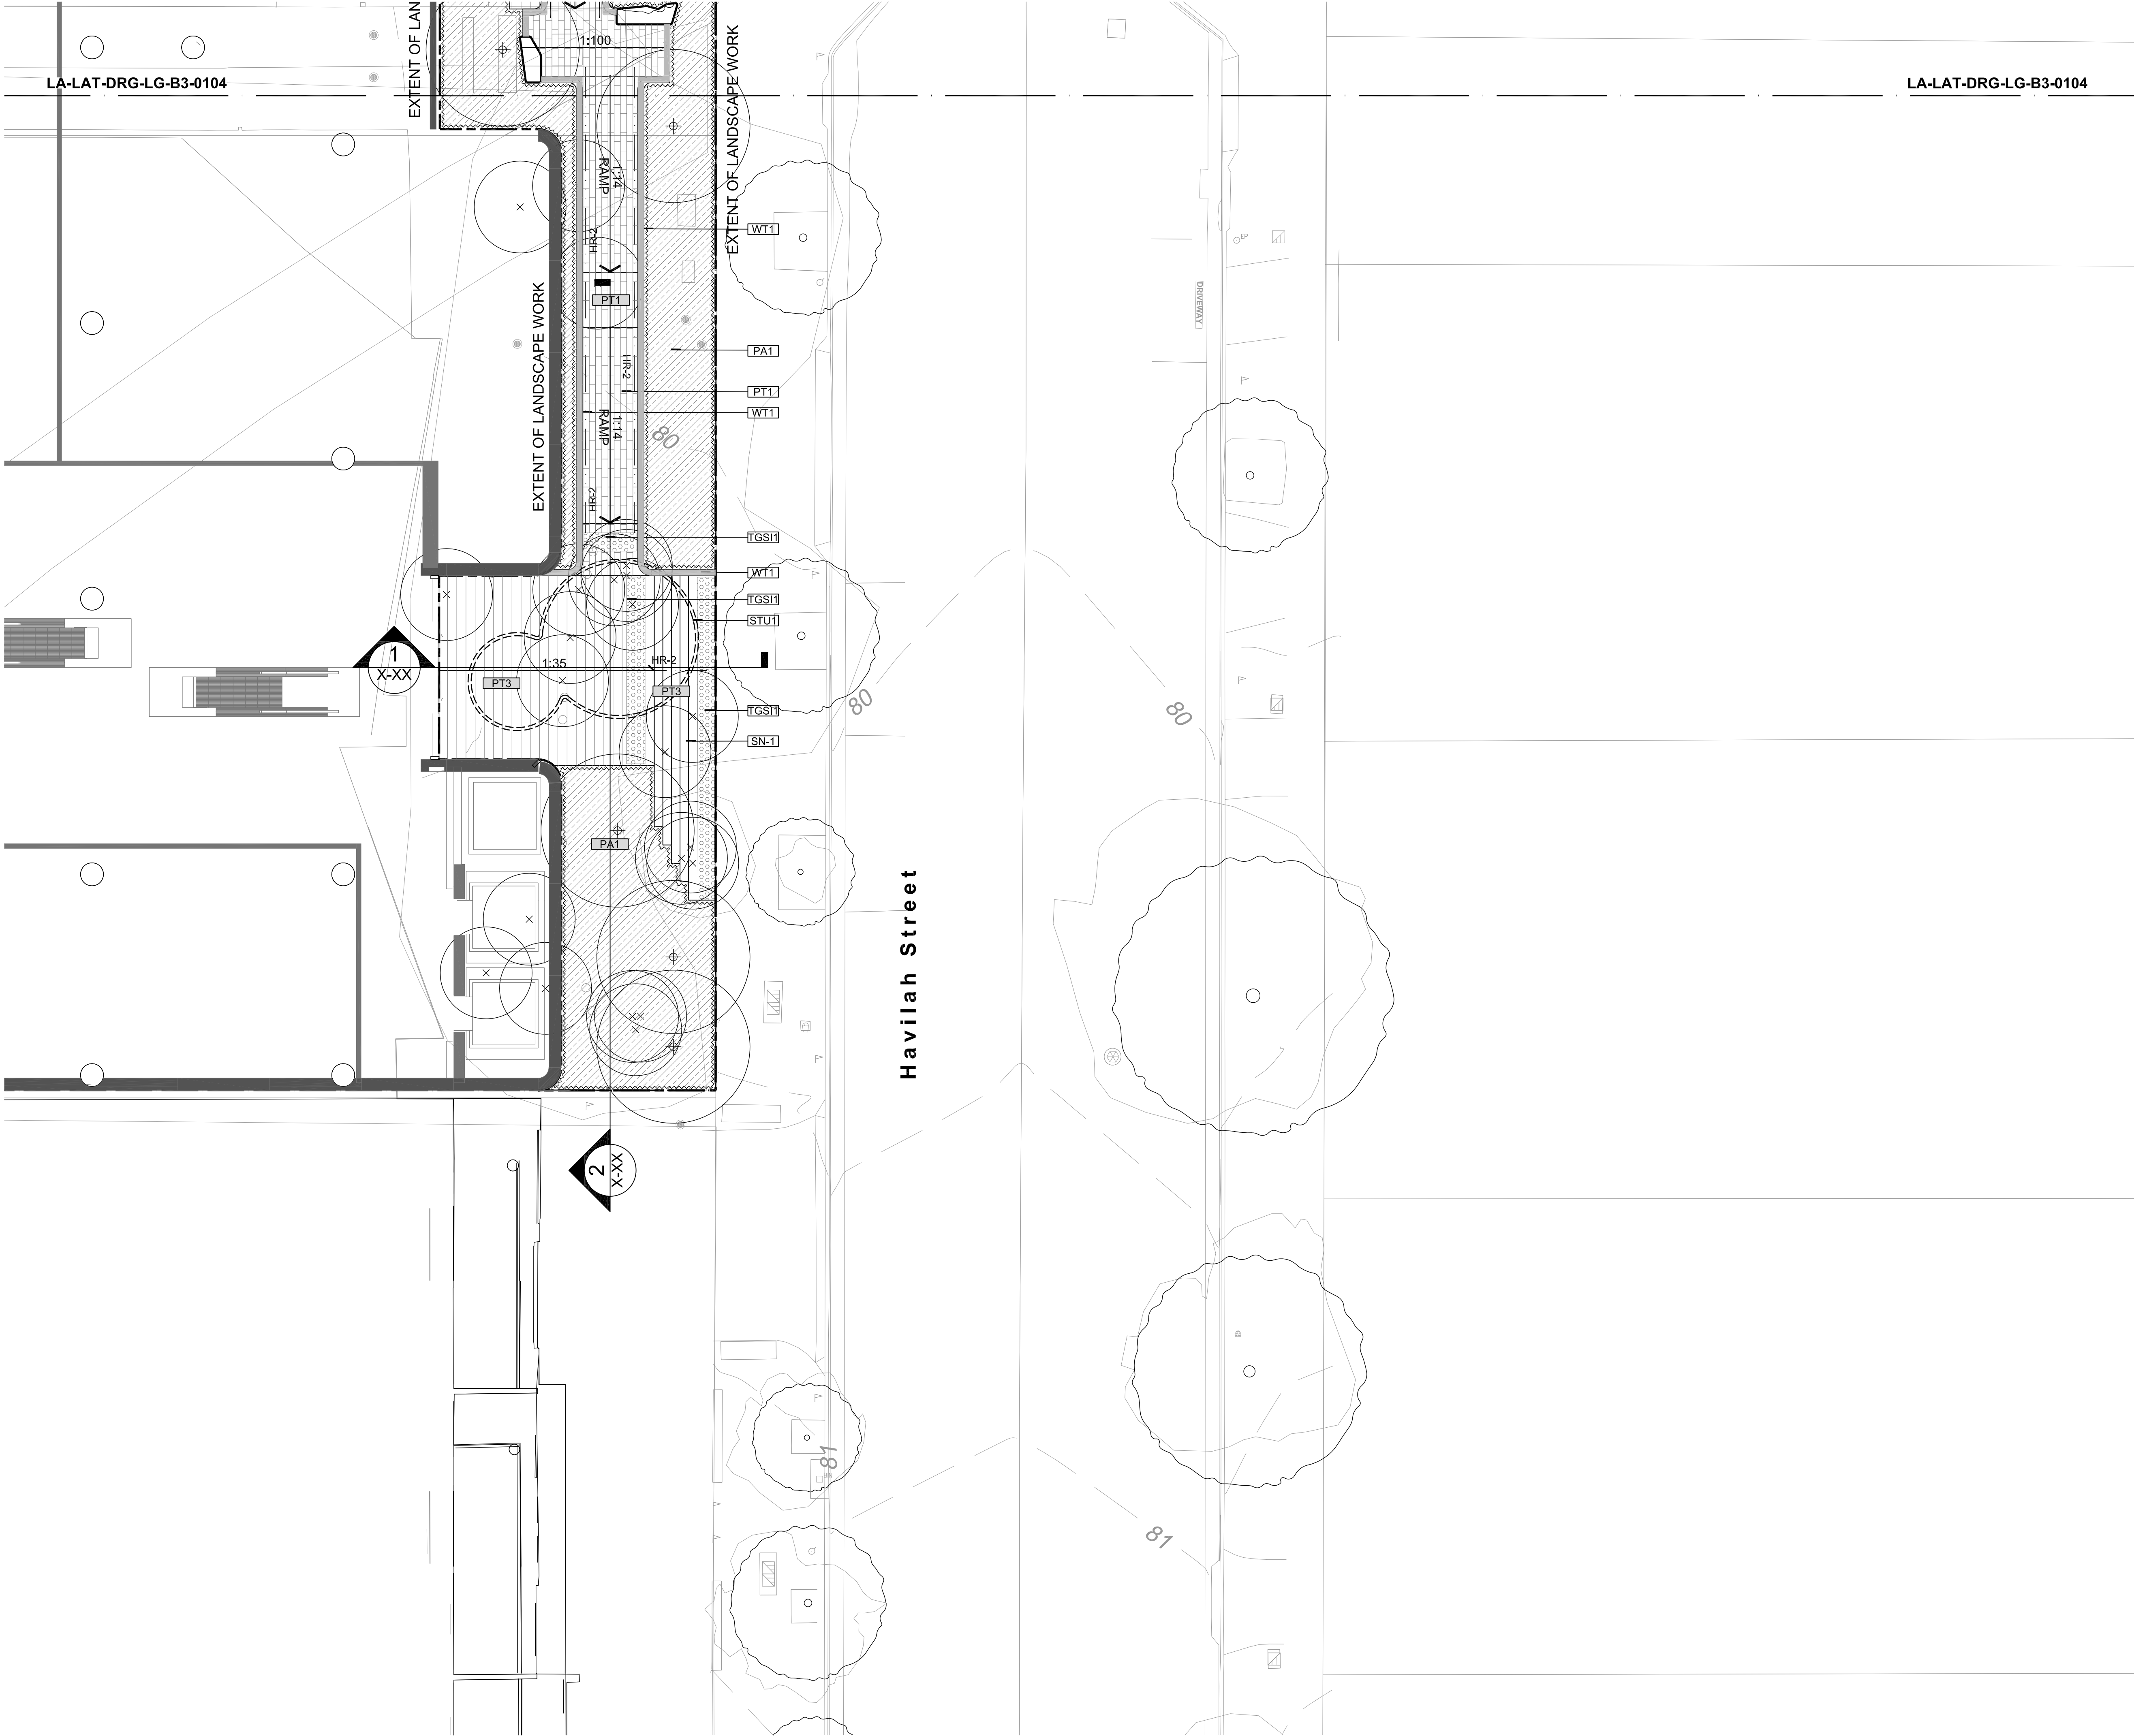

REV	DESCRIPTION	DATE
01	DRAFT 50% DOC	02.11.18
02	UPDATED DA	13.05.19
THIS DRAWING IS TO BE READ IN CONJUNCTION WITH DETAILS AND SPECIFICATIONS PREPARED BY LAT27 PTY LTD. PRIOR TO UNDERTAKING ANY CONSTRUCTION. ANY CONFLICTS THAT EXIST ON THIS DRAWING, OR ADVICE AND DIRECTION REQUIRED SHOULD BE SOUGHT FROM LAT27 PTY LTD.		
1. ALL STRUCTURAL, CIVIL, HYDRAULIC AND ELECTRICAL INFORMATION INDICATED ON THIS DRAWING IS OUTSIDE THE DEFINED SCOPE OF LAT27. ALL CONSULTANT INFORMATION SHOWN IS FOR COORDINATION PURPOSES ONLY AND REFERENCE IS TO BE MADE TO THE RELEVANT CONSULTANTS DRAWINGS AND SPECIFICATIONS ACCORDINGLY FOR CONSTRUCTION.		
2. FIGURED DIMENSIONS TAKE PRECEDENCE OVER SCALED.		
3. CHECK ALL DIMENSIONS ON SITE PRIOR TO COMMENCEMENT OF WORK.		
© COPYRIGHT LAT27 PTY LTD ALL RIGHTS RESERVED. THIS DRAWING MAY NOT BE PRODUCED OR TRANSMITTED IN ANY FORM OR BY ANY MEANS IN PART OR IN WHOLE WITHOUT THE WRITTEN PERMISSION OF LAT27 PTY LTD		

NOT FOR CONSTRUCTION

07 3236 1086
Level 5, 300 Ann Street
Brisbane, Qld 4000
www.lat27.com.au

lat^{27°}

lat27

CLIENT

VICINITY CENTRES

VICINITY CENTRES

PROJECT TITLE

CHATSWOOD CHASE

DRAWING TITLE

LOWER GROUND - C3
FINISHES PLAN - SHEET 5

SCALE BAR

SCALE 1:100 @ A1
0m 1.0 2.0 3.0 4.0 5.0
SCALE 1:200 @ A3

PROJECT No.
17140.01

SCALE
1:100

DRAWN BY
ST

VERIFIER
NW

DRAWING No.
LA-LAT-DRG-LG-C3-0105

REVISION
02

GENERAL

	EXTENT OF LANDSCAPE WORKS/STAGE BOUNDARY
	PAGE ADJOINS
	PROPERTY BOUNDARY
	PROPOSED CONTOURS + MOUNDING WITHIN ON-GROUND AND PODIUM LANDSCAPE
	EXISTING CONTOURS
	BUILDING EXTENT OVER
	OVERLAND FLOW PATH

LEVELS AND SET OUT

	EXISTING LEVELS REFER LEVELS & DRAINAGE PLANS - 05 SERIES
	UNBONDED REINFORCED TOPPING SLAB LEVEL REFER LEVELS & DRAINAGE PLANS - 05 SERIES
	FINISHED SURFACE LEVEL REFER LEVELS & DRAINAGE PLANS - 05 SERIES
	INVERT LEVEL REFER LEVELS & DRAINAGE PLANS - 05 SERIES
	HIGH POINT OF LOCALISED MOUNDING REFER LEVELS & DRAINAGE PLANS - 05 SERIES
	TOP OF WALL REFER LEVELS & DRAINAGE PLANS - 05 SERIES
	TOP OF KERB REFER LEVELS & DRAINAGE PLANS - 05 SERIES
	TOP OF EDGE REFER LEVELS & DRAINAGE PLANS - 05 SERIES
	WATER LEVEL REFER LEVELS & DRAINAGE PLANS - 05 SERIES
	FLUSH SURFACE FINISHES REFER LEVELS & DRAINAGE PLANS - 05 SERIES
	FALL DIRECTION REFER LEVELS & DRAINAGE PLANS - 05 SERIES
	WALKWAYS & RAMPS GREATER 1:33

TREE WORKS

	- PROPOSED TREE - EX-GROUND / 1000L - REFER TO PLANTING PLANS 02 SERIES FOR ARRANGEMENT & DISTRIBUTION OF SIZING - REFERENCES: - REFER LANDSCAPE DETAILS XXX AND LANDSCAPE SPECIFICATION
	EXISTING TREE - TO BE RETAINED & PROTECTED - TREE PROTECTION ZONE - NOM. 1-2.0M BEYOND DRIP LINE - SUBJECT TO ARBORIST ADVICE - EXISTING LEVELS TO CANOPY DRIP LINE TO BE UNDISTURBED.
	EXISTING TREE TO BE REMOVED - REFER VEGETATION MANAGEMENT PLANS - REFERENCES: - REFER LANDSCAPE SPECIFICATION
	EXISTING STREET TREE - TO BE RETAINED & PROTECTED - BEYOND CURRENT SCOPE OF WORKS
	EXISTING STREET TREE - TO BE RETAINED & PROTECTED - WITHIN CURRENT SCOPE OF WORKS
	NEW TREE TRENCH 1200MM DEEP TREE TRENCH - STRATAVAULT OR APPROVED EQUIVALENT - CONNECTED TO OVERALL STORMWATER SYSTEM
	ROOT BARRIER - NYLEX OR APPROVED EQUIVALENT - REFER DETAILS

GROWING & DRAINAGE MEDIA PODIUM DEPTHS

	200MM OF SOIL ABOVE SSL (DRAINAGE + TOPPING SLAB IN ADDITION TO THIS DIMENSION)
	450MM OF SOIL ABOVE SSL (DRAINAGE + TOPPING SLAB IN ADDITION TO THIS DIMENSION)
	700MM OF SOIL ABOVE SSL (DRAINAGE + TOPPING SLAB IN ADDITION TO THIS DIMENSION)
	800 - 1000MM OF SOIL ABOVE SSL (DRAINAGE + TOPPING SLAB IN ADDITION TO THIS DIMENSION)

IRRIGATION WORKS

REFER HYDRO PLAN DRAWING PACKAGE FOR DETAILS AND SPECIFICATION NOTES ON THE PROPOSED IRRIGATION SCOPE OF WORKS

SOFTSCAPE FINISHES

	PROPOSED PLANTING AREA TYPE 1 - PLANTING INTO NATURAL GROUND - RIP, CULTIVATE SUBGRADE TO A DEPTH OF 150mm 300mm OF IMPORTED TOPSOIL 100mm 1"HOOP PINE MULCH - PLANT STOCK PLANTED IN ACCORDANCE WITH THE LANDSCAPE PLANTING PLANS - 02 SERIES (FUTURE) - REFERENCES: - REFER DETAIL XXXX AND LANDSCAPE SPECIFICATION
	PROPOSED PLANTING AREA TYPE 2 - PLANTING ON PODIUM - IMPORTED PODIUM SOILS OVER FILTRATION LAYER AND DRAINAGE CELL SUB BASE- DEPTH & SOIL PROPERTIES VARY 100mm GRAVEL MULCH (GM1) - DRAINAGE LAYER TO HYD. ENG. SPEC. - PLANT STOCK PLANTED IN ACCORDANCE WITH THE LANDSCAPE PLANTING PLANS - 02 SERIES (FUTURE) - REFERENCES: - REFER DETAIL XXXX AND LANDSCAPE SPECIFICATION
	PROPOSED PLANTING AREA TYPE 3 - FULL SUN / PARTIAL SHADE PLANTING ON PODIUM - IMPORTED PODIUM SOILS OVER FILTRATION LAYER AND DRAINAGE CELL SUB BASE- DEPTH & SOIL PROPERTIES VARY 100mm GRAVEL MULCH (GM1) - DRAINAGE LAYER TO HYD. ENG. SPEC. - PLANT STOCK PLANTED IN ACCORDANCE WITH THE LANDSCAPE PLANTING PLANS - 02 SERIES (FUTURE) - REFERENCES: - REFER DETAIL XXXX AND LANDSCAPE SPECIFICATION
	PROPOSED PLANTING AREA TYPE 4 - SHADED PLANTING ON PODIUM - IMPORTED PODIUM SOILS OVER FILTRATION LAYER AND DRAINAGE CELL SUB BASE- DEPTH & SOIL PROPERTIES VARY 100mm GRAVEL MULCH (GM1) - DRAINAGE LAYER TO HYD. ENG. SPEC. - PLANT STOCK PLANTED IN ACCORDANCE WITH THE LANDSCAPE PLANTING PLANS - 02 SERIES (FUTURE) - REFERENCES: - REFER DETAIL XXXX AND LANDSCAPE SPECIFICATION
	PROPOSED PLANTING AREA TYPE 05 - SUPPLEMENTARY PLANTING TO EXISTING GARDEN AREA 100mm OF IMPORTED TOPSOIL 100mm 1"HOOP PINE MULCH - PLANT STOCK PLANTED IN ACCORDANCE WITH THE LANDSCAPE PLANTING PLANS - 02 SERIES (FUTURE) - REFERENCES: - REFER DETAIL XXXX AND LANDSCAPE SPECIFICATION
	PROPOSED PLANTING AREA TYPE 06 - CARPARK FACADE RAISED PLANTERS 700mm OF IMPORTED SPECIALIST FYTOGREEN OR APPROVED EQUIVALENT PODIUM MIX 100mm 1"HOOP PINE MULCH - PLANT STOCK PLANTED IN ACCORDANCE WITH THE LANDSCAPE PLANTING PLANS - 02 SERIES (FUTURE) - REFERENCES: - REFER DETAIL XXXX AND LANDSCAPE SPECIFICATION
	TURF AREA TYPE 1 (ON PODIUM) - REFERENCES: - REFER LANDSCAPE DETAILS XXXX AND LANDSCAPE SPECIFICATION.
	GRAVEL MULCH TYPE 1 - PRODUCT TYPE: MT WHITE WHITE RANGE SANDSTONE - RUMBLD SANDSTONE PEBBLE LAID OVER GEOFABRIC - SIZE: NOM. 25mm-50mm DIA.Ø - COLOUR: WHITE & TANS - THICKNESS: NOM. 100mm - SUPPLIER: GOSFORD QUARRIES OR APPROVED EQUIVALENT - REFERENCES: - REFER DETAIL XXXX - LANDSCAPE SPECIFICATION

DRAINAGE

	PODIUM DRAINAGE OUTLET FLOOR DRAIN, BRASS WHEN IN PAVEMENT & HEELSAFE GARDEN DRAIN, GALVANISED STEEL WHEN IN GARDEN BED - TO INCLUDE SOLID RISER PIPE & CONNECTION TO PODIUM SW SYSTEM - REFERENCES: - REFER TO XXXX AND LANDSCAPE SPECIFICATION. - REFER TO HYDRAULIC ENGINEER'S DRAWINGS
	GROUND FLOOR SURFACE DRAINS FLOOR DRAIN, BRASS WHEN IN PAVEMENT & HEELSAFE GARDEN DRAIN, GALVANISED STEEL WHEN IN GARDEN BED TO INCLUDE SOLID RISER PIPE & CONNECTION TO SW SYSTEM - REFERENCES: - REFER LANDSCAPE SPECIFICATION. - REFER TO HYDRAULIC ENGINEER'S DRAWINGS
	STRIP DRAIN TYPE 1 - FINISH: SANDSTONE TILE INLAY TO MATCH PT2 OR BRASS 'HEELGUARD' - CONNECTED TO SW SYSTEM - REFER HYDRAULIC ENG. DWGS FOR DETAILS.

HARDSCAPE FINISHES

	PAVING TYPE 1 NATURAL STONE ON CONCRETE SLAB - TRAFFICABLE - PRODUCT: LINEAR SANDSTONE PAVING - SUPPLIER: GOSFORD QUARRY - COLOUR: MT WHITE WHITE RANGE SANDSTONE - SIZE & PATTERN: LARGE LINEAR FORMAT - MIX HONED, BUSH HAMMERED & GANGSAWN - ALLOW FOR PENETRATIVE SEALANT, APPLIED TO MANUFACTURER'S SPECIFICATION - ENSURE 300MM FEATHERED EDGE ADJACENT VERTICAL FACE ACHIEVING A 30% LUMINANCE CONTRAST - REFERENCES: - REFER ENGINEER DWGS. FOR DETAIL - LANDSCAPE DETAIL XXXX & SPECIFICATION
	PAVING TYPE 2 NATURAL STONE ON CONCRETE SLAB - TRAFFICABLE - PRODUCT: LINEAR SANDSTONE PAVING - SUPPLIER: GOSFORD QUARRY - COLOUR: MT WHITE WHITE RANGE SANDSTONE - SIZE & PATTERN: SMALL LINEAR FORMAT - HONED - ALLOW FOR PENETRATIVE SEALANT, APPLIED TO MANUFACTURER'S SPECIFICATION - ENSURE 300MM FEATHERED EDGE ADJACENT VERTICAL FACE ACHIEVING A 30% LUMINANCE CONTRAST - REFERENCES: - REFER LANDSCAPE DETAIL XXXX & SPEC.
	PAVING TYPE 3 NATURAL STONE ON CONCRETE SLAB - TRAFFICABLE - PRODUCT: LINEAR SANDSTONE PAVING - SUPPLIER: GOSFORD QUARRY - COLOUR: MT WHITE WHITE RANGE SANDSTONE - SIZE & PATTERN: SMALL LINEAR FORMAT - HONED, BUSH HAMMERED & GANGSAWN - ALLOW FOR PENETRATIVE SEALANT, APPLIED TO MANUFACTURER'S SPECIFICATION - REFERENCES: - REFER LANDSCAPE DETAIL XXXX & SPEC.
	PAVING TYPE 4 SANDSTONE GRAVEL ON CONCRETE SLAB - TRAFFICABLE - PRODUCT: PEA GRAVEL - SUPPLIER: GOSFORD QUARRY - COLOUR: MT WHITE WHITE RANGE SANDSTONE - SIZE: 5-10mm - ALLOW FOR PENETRATIVE SEALANT, APPLIED TO MANUFACTURER'S SPECIFICATION - REFERENCES: - REFER LANDSCAPE DETAIL XXXX & SPEC.
	PAVING TYPE 5 NATURAL STONE PAVER ON CONCRETE SLAB - PRODUCT: LINEAR STEPPING STONE PAVER - SUPPLIER: GOSFORD QUARRY - COLOUR: MT WHITE WHITE RANGE SANDSTONE - SIZE & PATTERN: VARIES - ENSURE 300MM FEATHERED EDGE ADJACENT VERTICAL FACE ACHIEVING A 30% LUMINANCE CONTRAST - REFERENCES: - REFER LANDSCAPE DETAIL XXXX & SPEC.
	PAVING TYPE 6 NATURAL STONE ON CONCRETE SLAB - TRAFFICABLE - PRODUCT: LINEAR SANDSTONE PAVING - SUPPLIER: GOSFORD QUARRY - COLOUR: MT WHITE WHITE RANGE SANDSTONE - SIZE & PATTERN: LARGE FORMAT - HONED - ALLOW FOR PENETRATIVE SEALANT, APPLIED TO MANUFACTURER'S SPECIFICATION - ENSURE 300MM FEATHERED EDGE ADJACENT VERTICAL FACE ACHIEVING A 30% LUMINANCE CONTRAST - REFERENCES: - REFER LANDSCAPE DETAIL XXXX & SPEC.
	PAVING TYPE 8 INSITU CONCRETE - SUPPLIER: CONTRACTOR TO SOURCE - COLOUR: DRIFTWOOD - FINISH: HONED - ALLOW FOR PENETRATIVE SEALANT, APPLIED TO MANUFACTURER'S SPECIFICATION - REFERENCES: - REFER LANDSCAPE DETAIL XXXX & SPEC.
	PAVING TYPE 9 PERMEABLE PAVEMENT - SUPPLIER: CONTRACTOR TO SOURCE - COLOUR: TBA - APPLIED TO MANUFACTURER'S SPECIFICATION - REFERENCES: - REFER LANDSCAPE DETAIL XXXX & SPEC.
	PT7 STONE STEPPER TO MATCH PT1 & PT2 - REFERENCES: - REFER LANDSCAPE DETAIL XXXX & SPECIFICATION
	WALL TYPE 1 SANDSTONE WALL - COLOUR: MT WHITE WHITE RANGE SANDSTONE - FINISH: - HORIZONTAL FACES: HONED - VERTICAL FACES: HYDRA SPLIT - MANUFACTURER'S SPECIFICATION) - WIDTH: 200 - HEIGHT: VARIES - REFER LEVELS PLAN - REFERENCES: - LANDSCAPE DETAIL XXXX & LANDSCAPE SPECIFICATION *SHOP DRAWINGS TO BE SUPPLIED FOR APPROVAL
	WALL TYPE 2 SANDSTONE SEATING WALL - COLOUR: MT WHITE WHITE RANGE SANDSTONE - FINISH: - HORIZONTAL FACES: HONED - VERTICAL FACES: HYDRA SPLIT - WIDTH: 450 - HEIGHT: 450 - REFERENCES: - LANDSCAPE DETAIL XXXX & LANDSCAPE SPECIFICATION *SHOP DRAWINGS TO BE SUPPLIED FOR APPROVAL

HARDSCAPE FINISHES CONT.

	WALL TYPE 3 PRECAST CONCRETE SEATING WALL - COLOUR: OFF WHITE - WHERE ADJACENT PERFORATED FACADE - FINISH: OFF FORM CONCRETE - WIDTH: 200 - HEIGHT: 900 - REFERENCES: - LANDSCAPE DETAIL XXXX & LANDSCAPE SPECIFICATION *SHOP DRAWINGS TO BE SUPPLIED FOR APPROVAL
	WALL TYPE 4 SANDSTONE WALL UNDER PERGOLA - COLOUR: MT WHITE WHITE RANGE - FINISH: - HORIZONTAL FACES: HONED - VERTICAL FACES: HYDRA SPLIT - WIDTH: 500MM - HEIGHT: 2.0M - REFERENCES: - LANDSCAPE DETAIL XXXX & LANDSCAPE SPECIFICATION *SHOP DRAWINGS TO BE SUPPLIED FOR APPROVAL
	WALL TYPE 5 SANDSTONE WALL ON LAWN TERRACE - COLOUR: WHITE RANGE - FINISH: - HORIZONTAL FACES: HONED - VERTICAL FACES: HYDRA SPLIT - WIDTH: 300 - HEIGHT: VARIOUS - REFERENCES: - LANDSCAPE DETAIL XXXX & LANDSCAPE SPECIFICATION *SHOP DRAWINGS TO BE SUPPLIED FOR APPROVAL
	WALL TYPE 6 STONE WALL SURROUNDS TO EAST/WEST LIGHT WELL - COLOUR: WHITE RANGE - FINISH: - HORIZONTAL FACES: HONED - VERTICAL FACES: HYDRA SPLIT - WIDTH: 300 - HEIGHT: VARIOUS - REFERENCES: - LANDSCAPE DETAIL XXXX & LANDSCAPE SPECIFICATION *SHOP DRAWINGS TO BE SUPPLIED FOR APPROVAL

EDGES

	METAL EDGE - ON PODIUM - ALUMINIUM PLATE PAINTED - COLOUR: NICKEL COLOUR 150MM PROFILE - REFERENCES: - REFER LANDSCAPE DETAIL XXXX - MANUFACTURERS INSTRUCTIONS
	SAW CUT JOINT REFER STRUCTURAL DETAIL & DRAWING PACK (NOTE: SHOWN INDICATIVELY ON DRAWINGS)
	EDGE TYPE 1 METAL INLAY 3MM BRASS ANGLE - COLOUR: BRASS - REFERENCES: - LANDSCAPE DETAIL XXXX & LANDSCAPE SPECIFICATION
	RETAINING METAL GARDEN EDGE - PROFILE: VARIES - REFER LEVELS PLANS - RANGE FROM 450mm TO 1000mm 2.5MM ALUMINIUM PLATE PAINTED - COLOUR: NICKEL COLOUR - REFERENCES: - LANDSCAPE DETAIL XXXX & LANDSCAPE SPECIFICATION
	TRELLIS TYPE 01 - SS MESH TO FUTURE DETAIL - SUPPLIER: INNOVATIVE RIGGING OR APPROVED EQUIVALENT. - REFERENCES: - REFER DETAILS ON XX AND LANDSCAPE SPECIFICATION.
	TRELLIS TYPE 02 - SS CABLE STRUCTURE FIXED TO PERGOLA POSTS REFER FUTURE DETAILS FOR FIXING. - S/S CABLES AND FIXINGS: IRS30-CST CUSTOM COLUMN SYSTEM. - REFERENCES: - REFER DETAILS ON XX AND LANDSCAPE SPECIFICATION.

FENCES

	- FENCE TYPE 1 - 1800mm TIMBER PAILING FENCE - REFERENCES: - TIMBER AUSTRALIAN STANDARDS
--	---

BALUSTRADES & HANDRAILS

	HANDRAIL RECESSED INTO WALL TO STAIRS HANDRAIL; REFER ARCH. DRAWINGS AND DETAILS
	SINGLE OR DOUBLE HANDRAIL TO STAIRS / RAMPS HANDRAIL; REFER ARCH DRAWINGS AND DETAILS
	BALUSTRADE TYPE 105 - VERTICAL RODS AND FLAT METAL TOP AND BOTTOM PLATES - HEIGHT: 1400mm - REFER ARCH. DRAWINGS AND DETAILS
	BALUSTRADE TYPE 106 - TO SKYLIGHT EDGE - FLAT METAL PLATE FIXED TO CONCRETE PARAPET - HEIGHT: 1400mm - REFER ARCH. DRAWINGS AND DETAILS
	BALUSTRADE TYPE 107 - TO EAST WEST SKYLIGHT EDGE - FLAT METAL PLATE - HEIGHT: 1400mm - REFER ARCH. DRAWINGS AND DETAILS
	BALUSTRADE TYPE 108 - TO HAVILAH STREET FACADE OPENING - GROUND FLOOR - HEIGHT: 1400mm - REFER ARCH. DRAWINGS AND DETAILS
	BALUSTRADE TYPE 109 - CURVED METAL SHEET TO OCULUS LIGHT WELL - HEIGHT: 2000mm - REFER ARCH. DRAWINGS AND DETAILS

STAIRS

- NOTE THE STAIRS ARE INDICATED ON THE SURFACE FINISH PLANS HOWEVER THE FOLLOWING APPLIES TO THE TREADS AND RISERS TO MIMIC THE LANGUAGE OF THE WALLS:
 - TREADS: HONED
 - RISERS: HYDRA SPLIT

	SN1 - STAIR NOSING - TYPE: 10mm SANDSTONE TILE - FINISH: PINK RANGE - TO ACHIEVE 30% COLOUR CONTRAST TO SURROUNDING PAVING - METAL INLAY AS PER DETAIL
	TGS1 - TACTILE GROUND SURFACE INDICATORS - TACTILE PAVERS IN STONE PAVING - SUPPLIER: 'CHELMSTONE', 'URBANSTONE' OR APPROVED EQUIVALENT. - COLOUR: TO ACHIEVE 30% COLOUR CONTRAST - REFERENCES: - REFER AS1428 - LANDSCAPE LANDSCAPE DETAIL XXXX AND SPECIFICATION.

LIGHTING

	HANDRAIL STRIP LED LIGHTING - STRIP LIGHTING RECESSED INTO UNDERSIDE OF HANDRAIL - REFER ARCH. DETAILS - REFERENCES: - REFER ELECTRICAL ENG. DWGS FOR DETAILS - LANDSCAPE DETAIL SHEET
	STRIP LED LIGHTING - IN-GROUND - STRIP LIGHTING RECESSED INTO PAVEMENT - REFERENCES: - REFER ELECTRICAL ENG. DWGS FOR DETAILS - LANDSCAPE DETAIL SHEET
	- UPLIGHTS - INGROUND - REFER ELECTRICAL ENG. DWGS FOR DETAILS
	UP-LIGHT - TO FEATURE TREES IN PLANTING AREA REFER ELECTRICAL ENG. DWGS FOR DETAILS
	BUD LIGHTING TO FEATURE TREES - REFER ELECTRICAL ENG. DWGS FOR DETAILS
	RECESSED STAIR LIGHTS - REFER ELECTRICAL ENG. DWGS FOR DETAILS
	MOUNTED DIRECTIONAL WALL LIGHT - REFER ELECTRICAL ENG. DWGS FOR DETAILS
	STRUCTURE LIGHTING - ASSOCIATED WITH PERGOLA (PGL-1) AND TIPI (TNT1) - REFER ELECTRICAL ENG. DWGS FOR DETAILS

REV	DESCRIPTION	DATE
01	DRAFT 50% DOC	02.11.18
02	UPDATED DA	13.05.19

THIS DRAWING IS TO BE READ IN CONJUNCTION WITH DETAILS AND SPECIFICATIONS PREPARED BY LAT27 PTY LTD. PRIOR TO UNDERTAKING ANY CONSTRUCTION, ANY CONFLICTS THAT EXIST ON THIS DRAWING, OR ADVICE AND DIRECTION REQUIRED SHOULD BE SOUGHT FROM LAT27 PTY LTD.

1. ALL STRUCTURAL, CIVIL, HYDRAULIC AND ELECTRICAL INFORMATION INDICATED ON THIS DRAWING IS OUTSIDE THE DEFINED SCOPE OF LAT27. ALL CONSULTANT INFORMATION SHOWN IS FOR COORDINATION PURPOSES ONLY AND REFERENCE IS TO BE MADE TO THE RELEVANT CONSULTANTS DRAWINGS AND SPECIFICATIONS ACCORDINGLY FOR CONSTRUCTION.

2. FIGURED DIMENSIONS TAKE PRECEDENCE OVER SCALED.

3. CHECK ALL DIMENSIONS ON SITE PRIOR TO COMMENCEMENT OF WORK.

© COPYRIGHT LAT27 PTY LTD ALL RIGHTS RESERVED. THIS DRAWING MAY NOT BE PRODUCED OR TRANSMITTED IN ANY FORM OR BY ANY MEANS IN PART OR IN WHOLE WITHOUT THE WRITTEN PERMISSION OF LAT27 PTY LTD

NOTE: LEGEND TO BE READ IN CONJUNCTION WITH THE ARCHITECTURAL MATERIAL SCHEDULE.

NOT FOR CONSTRUCTION

07 3236 1086
Level 5, 300 Ann Street
Brisbane, Qld 4000
www.lat27.com.au

lat^{27°}

CLIENT

VICINITY CENTRES

PROJECT TITLE

CHATSWOOD CHASE

DRAWING TITLE

LEGEND
SHEET 1

SCALE BAR

PROJECT No.	SCALE	
17140.01		
DRAWN BY	VERIFIER	
ST	NW	
DRAWING No.	REVISION	
LA-LAT-DRG-XX-00-0003	02	

ELECTRICAL



IN WALL POWER, DATA AND WATER OUTLET TYPE 01

- REFER TO DETAILS
- PRODUCT: CUSTOM CABINET
- FINISH: POWDERCOAT - NICKEL COLOUR OR EQUIVALENT
- SUPPLIER: CONTRACTOR TO SOURCE

CATENARY LIGHTING



CATENARY LUMINAIRE

- LUMINAIRE FIXED TO SS WIRE
- TURF TERRACES (WELLNESS OUTDOOR TERRACE)
- REFER ELECTRICAL ENG. DWGS FOR DETAILS



CATENARY LIGHTING CABLE

- REFER STRUCTURAL ENG. DWGS FOR DETAILS


NOTE: CATENARY SYSTEM TO BE UNDERTAKEN AS A D+C ELEMENT BY THE LANDSCAPE CONTRACTOR WITH NOMINATED CATENARY CONSULTANT

GROW LIGHTING

NOTE: GROW LIGHTING SYSTEM TO BE UNDERTAKEN AS A D+C ELEMENT BY THE LANDSCAPE CONTRACTOR WITH A SPECIALIST GROW LIGHTING CONSULTANT.


REFER INDICATIVE LIGHTING LAYOUTS ON SURFACE FINISHES PLANS SERIES 1000

FURNITURE

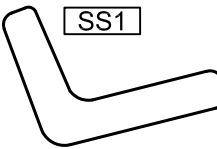


SEAT TYPE 1
CUSTOM SANDSTONE SEAT

- FINISH:
 - HORIZONTAL FACES: HONED
 - VERTICAL FACES: HYDRA SPLIT
- COLOUR: MT WHITE WHITE RANGE
- WIDTH: 450-550
- HEIGHT: 500
- REFERENCES:
 - LANDSCAPE DETAILS XXXX

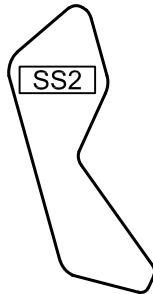


SEAT TYPE 2
CUSTOM SANDSTONE SEAT

- FINISH:
 - HORIZONTAL FACES: HONED
 - VERTICAL FACES: HYDRA SPLIT
- COLOUR: MT WHITE WHITE RANGE
- WIDTH: >550
- HEIGHT: 500
- REFERENCES:
 - LANDSCAPE DETAILS XXXX

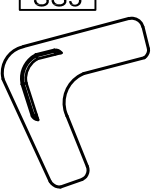

SEAT TYPE 3
CUSTOM SANDSTONE SEAT WITH STEEL BACK
STONE

 - FINISH:
 - HORIZONTAL FACES: HONED
 - VERTICAL FACES: HYDRA SPLIT
- STONE COLOUR: MT WHITE WHITE RANGE
- WIDTH: >550
- HEIGHT: 500
- STEEL SEAT BACK**
 - FINISH: PAINTED STEEL
 - COLOUR: NICKELT COLOUR
 - WIDTH: VARIES. REFER PLANS
 - HEIGHT: 400
 - REFERENCES:
 - LANDSCAPE DETAILS XXXX



SEAT TYPE 4

- CUSTOM SEAT
- STEEL FRAME WITH CUSHIONS
- FINISH: POWDERCOATED
- COLOUR: NICKEL COLOUR
- WIDTH: 450
- HEIGHT: 700
- REFERENCES:
 - LANDSCAPE DETAILS XXXX



INDIVIDUAL BOULDERS TYPE 1


- PRODUCT: 500 X 700MM NATURAL SANDSTONE BOULDER
- SIZE: MAX. 500 X 700MM DIA. FINISHED HEIGHT 400MM.
- ALL SHARP EDGES TO BE SMOOTHED
- REFER LANDSCAPE DETAIL XXXX

FURNITURE CONT.



BOOTH SEATING SET TYPE 1

- CUSTOM SEAT
- STEEL FRAME WITH CUSHIONS
- FINISH: POWDERCOATED
- COLOUR: NICKEL COLOUR
- WIDTH: 450
- HEIGHT: 700
- ACCESSORIES: CUSTOM LEATHER CUSHIONS TO SEAT AND BACK REST
- REFERENCES:
 - LANDSCAPE DETAILS XXXX

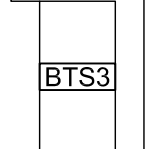


BOOTH SEATING TYPE 2

- CUSTOM SEAT
- STEEL FRAME WITH CUSHIONS
- FINISH: POWDERCOATED
- COLOUR: NICKEL COLOUR
- WIDTH: 450
- HEIGHT: 700
- ACCESSORIES: CUSTOM LEATHER CUSHIONS TO SEAT AND BACK REST
- REFERENCES:
 - LANDSCAPE DETAILS XXXX



BAR TABLE TYPE 1
CUSTOM SANDSTONE SEAT WITH STONE CAPPING

 - FINISH: TO MATCH ARCHITECTURAL INTERIOR FINISHES
- WIDTH: 450
- HEIGHT: 700
- REFERENCES:
 - LANDSCAPE DETAILS XXXX



BAR TABLE TYPE 2
CUSTOM SANDSTONE SEAT WITH STONE CAPPING

- FINISH: TO MATCH ARCHITECTURAL INTERIOR FINISHES
- WIDTH: 450
- HEIGHT: 700
- REFERENCES:
 - LANDSCAPE DETAILS XXXX



BAR STOOL TYPE 1

- EXTERNAL GRADE WIRE FRAME WITH LEATHER CUSHIONS
- WIDTH: 450
- HEIGHT: 700
- REFERENCES:
 - LANDSCAPE DETAILS XXXX



BICYCLE RACKS TYPE 1

- STAINLESS STEEL WITH BRASS OR NICKEL PATINA
- WIDTH: 100
- HEIGHT: 700
- LENGTH: 800
- REFERENCES:
 - LANDSCAPE DETAILS XXXX




DOUBLE VEHICLE GATE
ACRYLIC SHOP DRAWINGS TO BE PROVIDED FOR APPROVAL

DOUBLE VEHICLE GATE


- METAL FLATE PLATE FRAME
- VERTICAL FLAT PLATE MEMBERS WITH CROSS BRACING
- FINISH: POWDERCOATED
- COLOUR: BLACK
- SHOP DRAWINGS TO BE PROVIDED FOR APPROVAL

STRUCTURES

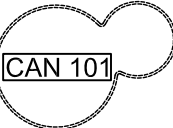

CANOPY STRUCTURE

- ACRYLIC SHADE STRUCTURE TO ARCH DETAILS
- SHOP DRAWINGS TO BE PROVIDED FOR APPROVAL

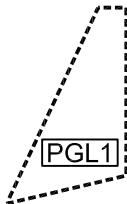


PERGOLA

- TIMBER STRUCTURE TO D+C CONTRACTOR
- REFER DETAIL XXXX
- SHOP DRAWINGS TO BE PROVIDED FOR APPROVAL



TIPI STRUCTURE - TENT TYPE 1

 - REFER DETAIL XXXX
- SHOP DRAWINGS TO BE PROVIDED FOR APPROVAL



Service pit lids

- (1) Service pit lids located within pavement ensure pit infill lids to match surrounding pavement type. Ensure 'Class B' specifications (suitable for occasional vehicle use), with slip resistance qualities as specified in AS/NZS 4586-2004 Slip resistance classification of new pedestrian surface materials and AS/NZS 4663-2004 Slip resistance measurement of existing pedestrian surfaces.
- (2) If service pit lids are located in the verge, they are of black cast iron construction, manufactured to AS 3996-2006 Access covers and grates 'Class B' specifications (suitable for occasional vehicle use), with slip resistance qualities as specified in AS/NZS 4586-2004 Slip resistance classification of new pedestrian surface materials and AS/NZS 4663-2004 Slip resistance measurement of existing pedestrian surfaces.
- (3) In relation to load rating, pit lids are manufactured to AS 3996-2006 Access covers and grates, Class C (suitable for driveways and roadway use)

REV	DESCRIPTION	DATE
01	DRAFT 50% DOC	02.11.18
02	UPDATED DA	13.05.19

THIS DRAWING IS TO BE READ IN CONJUNCTION WITH DETAILS AND SPECIFICATIONS PREPARED BY LAT27 PTY LTD. PRIOR TO UNDERTAKING ANY CONSTRUCTION, ANY CONFLICTS THAT EXIST ON THIS DRAWING, OR ADVICE AND DIRECTION REQUIRED SHOULD BE SOUGHT FROM LAT27 PTY LTD.

1. ALL STRUCTURAL, CIVIL, HYDRAULIC AND ELECTRICAL INFORMATION INDICATED ON THIS DRAWING IS OUTSIDE THE DEFINED SCOPE OF LAT27. ALL CONSULTANT INFORMATION SHOWN IS FOR COORDINATION PURPOSES ONLY AND REFERENCE IS TO BE MADE TO THE RELEVANT CONSULTANTS DRAWINGS AND SPECIFICATIONS ACCORDINGLY FOR CONSTRUCTION.

2. FIGURED DIMENSIONS TAKE PRECEDENCE OVER SCALED.

3. CHECK ALL DIMENSIONS ON SITE PRIOR TO COMMENCEMENT OF WORK.

© COPYRIGHT LAT27 PTY LTD ALL RIGHTS RESERVED. THIS DRAWING MAY NOT BE PRODUCED OR TRANSMITTED IN ANY FORM OR BY ANY MEANS IN PART OR IN WHOLE WITHOUT THE WRITTEN PERMISSION OF LAT27 PTY LTD

NOTE: LEGEND TO BE READ IN CONJUNCTION WITH THE ARCHITECTURAL MATERIAL SCHEDULE.

NOT FOR CONSTRUCTION

07 3236 1086
Level 5, 300 Ann Street
Brisbane, Qld 4000



www.lat27.com.au

VICINITY CENTRES



PROJECT TITLE		
CHATSWOOD CHASE		
DRAWING TITLE		
LEGEND SHEET 2		
SCALE BAR		
PROJECT No. 17140.01	SCALE	
DRAWN BY ST	VERIFIER NW	
DRAWING No. LA-LAT-DRG-XX-00-0004		REVISION 02

CHATSWOOD CHASE - PLANTING SCHEDULE

PROJECT NO.: 17140.01
DATE: 14.03.19
ISSUE: DRAFT DD 50%

The following species list is an indicative mix intended for Chatswood Chase. The Ground floor / Street level species reference the Willoughby Council Street Tree Master Plan. Species selected are a mix of readily available species, those native to the Chatswood region and a mix derived from native species found in the Kuringai Chase National Park and the Barangaroo Reserve

ITEM	CODE	BOTANICAL NAME	COMMON NAME	MATURE HEIGHT (m)	MATURE SPREAD (m)	CONTAINER SIZE	DENSITY	STAKE or GUY (Y/N)
	SYN glo	Syncarpia glomulifera	Turpentine	25m	10m	400L	As shown	G
	EUC res	Eucalyptus resinifera	Red mahogany	20m	12m	400L	As shown	G
	PLA ace	Palatanus x acerifolia	London Plane	20-25m	18-20m	400L	As shown	S

ITEM	CODE	BOTANICAL NAME	COMMON NAME	MATURE HEIGHT (m)	MATURE SPREAD (m)	CONTAINER SIZE	DENSITY	STAKE or GUY (Y/N)
	BAC myr	Backhousia myrtifolia	Grey Myrtle	3m	3m	400L	As shown	S
	ELA eum	Elaeocarpus eumundi	Eumundi Quandong	10m	3m	400L	As shown	S
	EUC pip	Eucalyptus piperita	Sydney Peppermint	20m	10m	400L	As shown	G
	TRI lau	Tristaniopsis laurina	Water Gum	12m	4m	400L	As shown	S
	PLA ace	Palatanus x acerifolia	London Plane	20-25m	18-20m	400L	As shown	S

* Ensure these species are procured with a suitable nursery. Ensure the Landscape Architect has approved nursery stock prior to confirming the procurement contract.

ITEM	CODE	BOTANICAL NAME	COMMON NAME	MATURE HEIGHT (m)	MATURE SPREAD (m)	CONTAINER SIZE	DENSITY	STAKE or GUY (Y/N)
	AGA rob	Agathis robusta	Kauri Pine	30m	6m	400L	As shown	G

* Ensure these species are procured with a suitable nursery. Ensure the Landscape Architect has approved nursery stock prior to confirming the procurement contract.

ITEM	CODE	BOTANICAL NAME	COMMON NAME	MATURE HEIGHT (m)	MATURE SPREAD (m)	CONTAINER SIZE	DENSITY	STAKE or GUY (Y/N)
	ASP bul	Asplenium bulbiferum	Mother Spleenwort	1.2m	1.2m	200mm	6/m ²	N
	BLE nud	Blechnum nudum	Fishbone Water Fern	1m	1m	200mm	2/m ²	N
	DOO asp	Doodia aspera	Prickly Rasp fern	0.4m	0.6m	200mm	6/m ²	N
	MIC div	Microsorium diversifolium	Kangaroo Paw Fern	0.3m	0.9m	200mm	6/m ²	N
	PTE esc	Pteridium esculentum	Bracken Fern	2m	1.5m	200mm	6/m ²	N

ITEM	CODE	BOTANICAL NAME	COMMON NAME	MATURE HEIGHT (m)	MATURE SPREAD (m)	CONTAINER SIZE	DENSITY	STAKE or GUY (Y/N)
	ALL tor	Allocasuarina torulosa	Rose She-oak	15m	4m	400L	As shown	G
	BAC myr	Backhousia myrtifolia	Grey Myrtle	3m	3m	400L	As shown	S
	ELA ret	Elaeocarpus reticulatus	Blueberry Ash	8m	3m	400L	As shown	G

* Ensure these species are procured with a suitable nursery. Ensure the Landscape Architect has approved nursery stock prior to confirming the procurement contract.

ITEM	CODE	BOTANICAL NAME	COMMON NAME	MATURE HEIGHT (m)	MATURE SPREAD (m)	CONTAINER SIZE	DENSITY	STAKE or GUY (Y/N)
	DOR pal	Doryanthes excelsa	Gymea Lily	3m	4m	300mm	1/2m ²	N
	LEP bra	Leptospermum brachyandrum	Weeping Tea Tree	5m	3m	45L	As shown	S
	WES fru	Westringia fruticosa	Coastal Rosemary	1.5m-2m	1.5-2m	200mm	1/2m ²	N
	XAN med	Xanthorrhoea media	Grass Tree	4m	1.5m	45L (CT 2m)	As shown	G

ITEM	CODE	BOTANICAL NAME	COMMON NAME	MATURE HEIGHT (m)	MATURE SPREAD (m)	CONTAINER SIZE	DENSITY	STAKE or GUY (Y/N)
	BLE nud	Blechnum nudum	Fishbone Water Fern	1m	1m	200mm	2/m ²	N
	CYA aus	Cyathe australis	Black Tree-fern	1-3m	2-3m	25L (CT 500mm)	As Shown	S
	MAC com	Macrozamia communis	Burrawang	1-2m	2-4m	25L (CT 500mm)	As Shown	S
	PTE esc	Pteridium esculentum	Bracken Fern	2m	1.5m	200mm	6/m ²	N




ITEM	CODE	BOTANICAL NAME	COMMON NAME	MATURE HEIGHT (m)	MATURE SPREAD (m)	CONTAINER SIZE	DENSITY	STAKE or GUY (Y/N)
	CIS hyp	Cissus hypoglauca	Native Grape	4m	2m	200mm	6/m ²	N
	HAR vio	Hardenbergia violacea	Purple Coral Pea	Up to 6m	Up to 6m	200mm	1/m ²	N
	LOM lon	Lomandra longifolia Tanika	Tanika	0.5-0.6m	0.5-0.6m	200mm	5/m ²	N
	PEN alo	Pennisetum alopecuroides	Nafray	1.2m	1m	200mm	5/m ²	N

ITEM	CODE	BOTANICAL NAME	COMMON NAME	MATURE HEIGHT (m)	MATURE SPREAD (m)	CONTAINER SIZE	DENSITY	STAKE or GUY (Y/N)
	CIS hyp	Cissus hypoglauca	Native Grape	4m	2m	200mm	6/m ²	N
	CUL dub	Culcita dubia	False Bracken	1.2m	1.5m	200mm	6/m ²	N
	DOO asp	Doodia aspera	Prickly Rasp fern	0.4m	0.6m	200mm	6/m ²	N
	LOM lon	Lomandra longifolia	Mat Rush	1-2m	1-2m	200mm	1/m ²	N

ITEM	CODE	BOTANICAL NAME	COMMON NAME	MATURE HEIGHT (m)	MATURE SPREAD (m)	CONTAINER SIZE	DENSITY	STAKE or GUY (Y/N)
	ASP ela	Aspidistra elatior	Cast Iron Plan	0.6m	0.9m	200mm	3/m ²	N
	CIS hyp	Cissus hypoglauca	Native Grape	9m	2.2m	200mm	3/m ²	N
	GEL sem	Gelsemium sempervirens	Confederate Jasmine	0.9m	1.2m	200mm	3/m ²	N
	PAN pan	Pandorea pandorana	Wonga wonga Vine	3-6m	3-8m	200mm	3/m ²	N
	TRA jas	Trachelospermum jasminoides	Star Jasmine	2m	1.5m	200mm	3/m ²	N

ITEM	CODE	BOTANICAL NAME	COMMON NAME	MATURE HEIGHT (m)	MATURE SPREAD (m)	CONTAINER SIZE	DENSITY	STAKE or GUY (Y/N)
	ALL tor	Allocasuarina torulosa	Rose She-Oak	15m	4m	200L	As shown	G
	ANG cos	Angophora costata	Smooth-barked Apple	15m	12m	200L	As shown	G
	BAC myr	Backhousia myrtifolia	Grey Myrtle	3m	3m	100L	As shown	S
	DOR pal	Doryanthes excelsa	Gymea Lily	3m	4m	300mm	1/2m ²	N
	EUC sal	Eucalyptus saligna	Blue Gum	30m	10m	200L	as shown	G
	EUC res	Eucalyptus resinifera	Red mahogany	20m	12m	200L	As shown	G
	ELA eum	Elaeocarpus eumundi	Eumundi Quandong	10m	3m	400L	As shown	S
	ELA ret	Elaeocarpus reticulatus	Blueberry Ash	8m	3m	200L	As shown	G
	PUL fle	Pultenaea flexilis	Graceful Pea Bush	4m	3m	200mm	2/m ²	N
	WES fru	Westringia fruticosa	Coastal Rosemary	1.5m-2m	1.5-2m	200mm	1/2m ²	N
	XAN med	Xanthorrhoea media	Grass Tree	4m	1.5m	45L (CT 2m)	As shown	G
	LOM lon	Lomandra longifolia	Mat Rush	1m	1-2m	200mm	1/m ²	N

EXTERNAL PLANT PALETTE

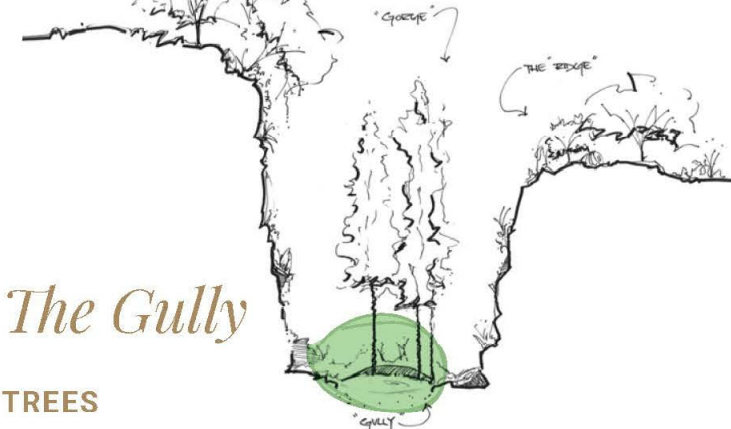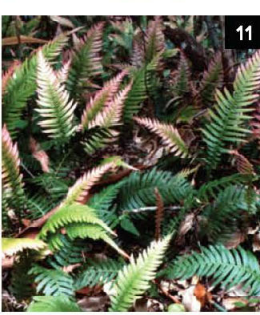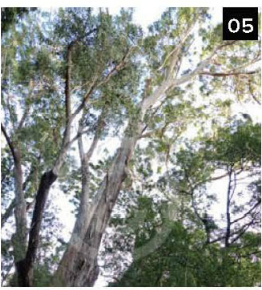




The Gully

TREES

01. *Agathis robusta* (Internal Garden)
02. *Backhousia myrtifolia* - Grey Myrtle
03. *Elaeocarpus eumundii* - Eumundii Quandong
04. *Eucalyptus resinifera* - Red mahogany
05. *Eucalyptus piperita* - Sydney Peppermint
06. *Syncarpia glomulifera* - Turpentine
07. *Palatanus x acerifolia* - London Plan
08. *Tristaniopsis laurina*

FERNS + CLIMBERS

09. *Asplenium bulbiferum* - Mother Spleenwort
10. *Blechnum nudum* - Fishbone Water Fern
11. *Doodia aspera* - Prickly Rasp fern
12. *Microsorium diversifolium* - Kangaroo Paw Fern
13. *Pteridium esculentum* - Bracken Fern

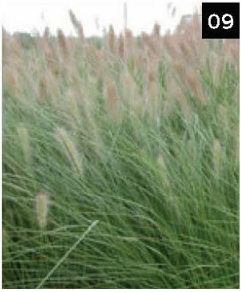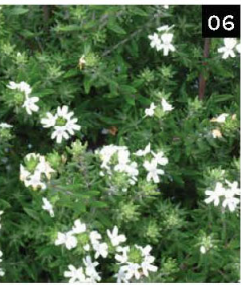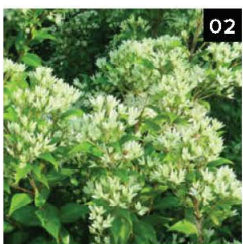

The Ridge

TREES

01. *Allocasuarina torulosa* - Rose She Oak
02. *Backhousia myrtifolia* - Grey Myrtle
03. *Elaeocarpus reticulatus* - Blueberry Ash

SHRUBS

04. *Leptospermum brachyandrum* - Weeping Tea Tree
05. *Doryanthes excelsa* - Gymea Lily
06. *Westringia fruticosa* - Coastal Rosemary
07. *Xanthorrhoea media* - Grass Tree

NATIVE GRASSES

08. *Lomandra longifolia* - Tanika
09. *Pennisetum alopecuroides* - Nafray

GROUND COVERS

10. *Cissus hypoglauca* - Water Vine
11. *Hardenbergia violacea* - Purple Coral Pea


SHADE TOLERANT SHRUBS + GROUND COVERS

12. *Blechnum nudum* - Fishbone Water Fern
13. *Cyathe australis* - Black Tree Fern
14. *Macrozamia communis* - Burrawong
15. *Cissus hypoglauca* -Native Grape
16. *Doodia aspera* - Prickly Rasp fern
17. *Culcita dubia*- False Bracken

* Note: Ridge/ Rooftop planting to have specialised podium mix to support growth of selected species

SCREEN PLANTING - HAVILAH AND MALVERN FACADES

01. *Allocasuarina torulosa* - Rose She-Oak
02. *Angophora costata* - Smooth-barked Apple
03. *Backhousia myrtifolia* - Grey Myrtle
04. *Doryanthes excelsa* - Gymea Lily
05. *Eucalyptus saligna* - Blue Gum
06. *Eucalyptus resinifera* - Red mahogany
07. *Elaeocarpus eumundi* - Eumundi Quandong
08. *Elaeocarpus reticulatus* - Blueberry Ash
09. *Pultenaea flexilis* - Graceful Pea Bush
10. *Westringia fruticosa* - Coastal Rosemary
11. *Xanthorrhoea media* - Grass Tree
12. *Lomandra longifolia* - Mat Rush

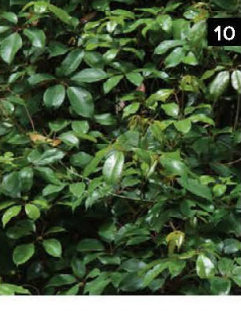

REV	DESCRIPTION	DATE
01	DRAFT 50% DOC	02.11.18
02	UPDATED DA	13.05.19

THIS DRAWING IS TO BE READ IN CONJUNCTION WITH DETAILS AND SPECIFICATIONS PREPARED BY LAT27 PTY LTD. PRIOR TO UNDERTAKING ANY CONSTRUCTION. ANY CONFLICTS THAT EXIST ON THIS DRAWING, OR ADVICE AND DIRECTION REQUIRED SHOULD BE SOUGHT FROM LAT27 PTY LTD.

1. ALL STRUCTURAL, CIVIL, HYDRAULIC AND ELECTRICAL INFORMATION INDICATED ON THIS DRAWING IS OUTSIDE THE DEFINED SCOPE OF LAT27. ALL CONSULTANT INFORMATION SHOWN IS FOR COORDINATION PURPOSES ONLY AND REFERENCE IS TO BE MADE TO THE RELEVANT CONSULTANTS DRAWINGS AND SPECIFICATIONS ACCORDINGLY FOR CONSTRUCTION.
2. FIGURED DIMENSIONS TAKE PRECEDENCE OVER SCALED.
3. CHECK ALL DIMENSIONS ON SITE PRIOR TO COMMENCEMENT OF WORK.

© COPYRIGHT LAT27 PTY LTD ALL RIGHTS RESERVED. THIS DRAWING MAY NOT BE PRODUCED OR TRANSMITTED IN ANY FORM OR BY ANY MEANS IN PART OR IN WHOLE WITHOUT THE WRITTEN PERMISSION OF LAT27 PTY LTD

NOT FOR CONSTRUCTION

07 3236 1086
Level 5, 300 Ann Street
Brisbane, Qld 4000
www.lat27.com.au

CLIENT
VICINITY CENTRES
VICINITY CENTRES

PROJECT TITLE
CHATSWOOD CHASE

DRAWING TITLE
PLANTING SCHEDULE
SHEET 1

SCALE BAR

PROJECT No. 17140.01	SCALE	
DRAWN BY ST	VERIFIER NW	
DRAWING No. LA-LAT-DRG-XX-00-0030	REVISION 02	