

DESIGN SPECIFICATION	
BASEFRAME / REFER BASEFRAME LAYOUTS FOR DETAILS	
BEARER	310 UB
OUTRIGGER/SPREADER	100 x 50mm PFC
BRACING ANGLE	50 x 50 x 5mm EQUAL ANGLE
END MEMBER	100 x 50mm PFC
LIFTING MECHANISMS	EXTENDABLE OUTRIGGERS
TOW LUG	10mm PLATE / Ø30mm HOLE
STEELWORK TREATMENT	PRIMED WITH RED OXIDE / FINISHED WITH BLACK ENAMEL
FLOOR FRAME / REFER BASEFRAME LAYOUTS FOR DETAILS	
JOISTS	C10015 @ 480 CENTRES
CAPPER	C10415
END JOIST	100 x 100 x 4mm SHS
FLOORING	
FLOOR SHEET	15mm TONGUE AND GROOVE PLYWOOD F11
FLOOR COVERING	2.0mm NON-SLIP VINYL - POLYSAFE HYDRO EVOLVE TIGRIS #4257
SKIRTING	100mm COVED VINYL
COMPLEXING	-
WATERPROOFING	NO
OTHER	DRY FLOOR WASTES
WALLS	
INTERNAL HEIGHT	2400mm
INTERNAL LINING	4mm POLYPLY PRE-FINISHED EMBOSSED PLYWOOD - GREY
INTERNAL TRIM	PVC D MOULD - WHITE (3 ROWS OF GREY SCREWS)
WALL INSULATION	-
EXTERNAL CLADDING	COLORBOND PANELRIB, LAID HORIZONTALLY - SURFMIST
EXTERNAL CORNER	HD 40x40x2.5mm D'GAL ANGLE
WALL FRAMES	
FRAMING	75 x 41 x 0.75mm G550 STEEL STUDS
STUD SPACING	400mm CTS
ROOF / CEILING	
CEILING TYPE	FLAT
CEILING LINING	4mm PRE-FINISHED PLYWOOD - MIRAGE PEARL
CEILING INSULATION	R 1.8 (75mm)
ROOF PITCH	2° CENTRE PITCH
ROOF CLADDING	TRIMDECK 0.42 BMT - ZINCALUME
ROOF INSULATION	-
UNDER BARGE FLASHING	ZINC
BARGE	WOODLAND GREY
GUTTER	-
DOWNPIPE	-
STEPCDOWN FLASHING	30 x 60 STEP DOWN - WOODLAND GREY
ROOF / CEILING FRAMES	
FRAMING	75 x 41 x 0.75mm G550 STEEL STUDS
STUD SPACING	400mm CTS
ELECTRICS	
SPECIFICATION	TO AS3000, 3001, 3012( TO COATES HIRE PURCHASE SPECIFICATIONS)
S/W BOARD	P.O.E. LOCATED BEHIND SWITCHBOARD, POLY PLASTIC INTERNALLY MOUNTED SWITCHBOARD, 1800mm AFFL(TO CTR)

## CLIENT APPROVAL

SIGNATURE:

NAME: .....

DATE: .....

PROJECT:

COATES - CAPEX  
3.0 x 6.0m M/F TOILET

© COPYRIGHT. THE INFORMATION IDEAS AND CONCEPTS CONTAINED IN THIS DOCUMENT ARE CONFIDENTIAL. THE RECIPIENT(S) OF THIS DOCUMENT IS/ARE PROHIBITED FROM DISCLOSING SUCH INFORMATION, IDEAS AND CONCEPTS TO ANY PERSON WITHOUT THE PRIOR WRITTEN CONSENT OF MODULAR BUILDING SYSTEMS Pty. Ltd

DATE:  
09.10.2015

DRAWN BY  
MI

CHECKED BY:  
DT

SCALE: SHOWN

TITLE:

## PLAN- GENERAL ARRANGEMENT

DRAWING NUMBER:  
MS-200305-B20-101






QUOTATION NUMBER: 200305

BUILDING NUMBER: #0000

REV: E SHEET A3


SHEET A3

## ELECTRICAL LEGEND


ITEM	DESCRIPTION	HEIGHT	QTY
EDB 	ELECTRICAL DISTRIBUTION BOARD	-	1
POE 	ELECTRICAL SUPPLY POINT OF ENTRY	1800 AFFL	1
	2x28W FLURO LIGHT DIFFUSED - SURFACE MOUNT	C/MNTD	3
	SINGLE LIGHT SWITCH	1300 AFFL	2
	SINGLE GPO - 10 AMP	1550 AFFL	2
EF	EXHAUST FAN	-	2

## ITEMS & EQUIPMENT SCHEDULE

TAG	QTY	DESCRIPTION
A	5	TOILET SUITE , DUAL FLUSH w/HASP & STAPLE
B	4	S/S HAND BASIN (H&C) PUSHBUTTON TYPE w/ MIRROR OVER
C	2	PAPER TOWEL DISPENSER (ROLL TYPE)
-		-
E	1	S/S URINAL - 1500
		<u>NOTES:</u>
		COATES SIGNS - 4 PER BUILDING @ TOP RIGHT CORNERS
		COATES ASSET TAGS - FIT BESIDE ENTRY DOOR @ LOCK
		WASTE OUTLET TO BE MIN. 70mm HIGHER THAN BOTTOM OF SKID
	5	TOILET CUBICLES IN WHITE

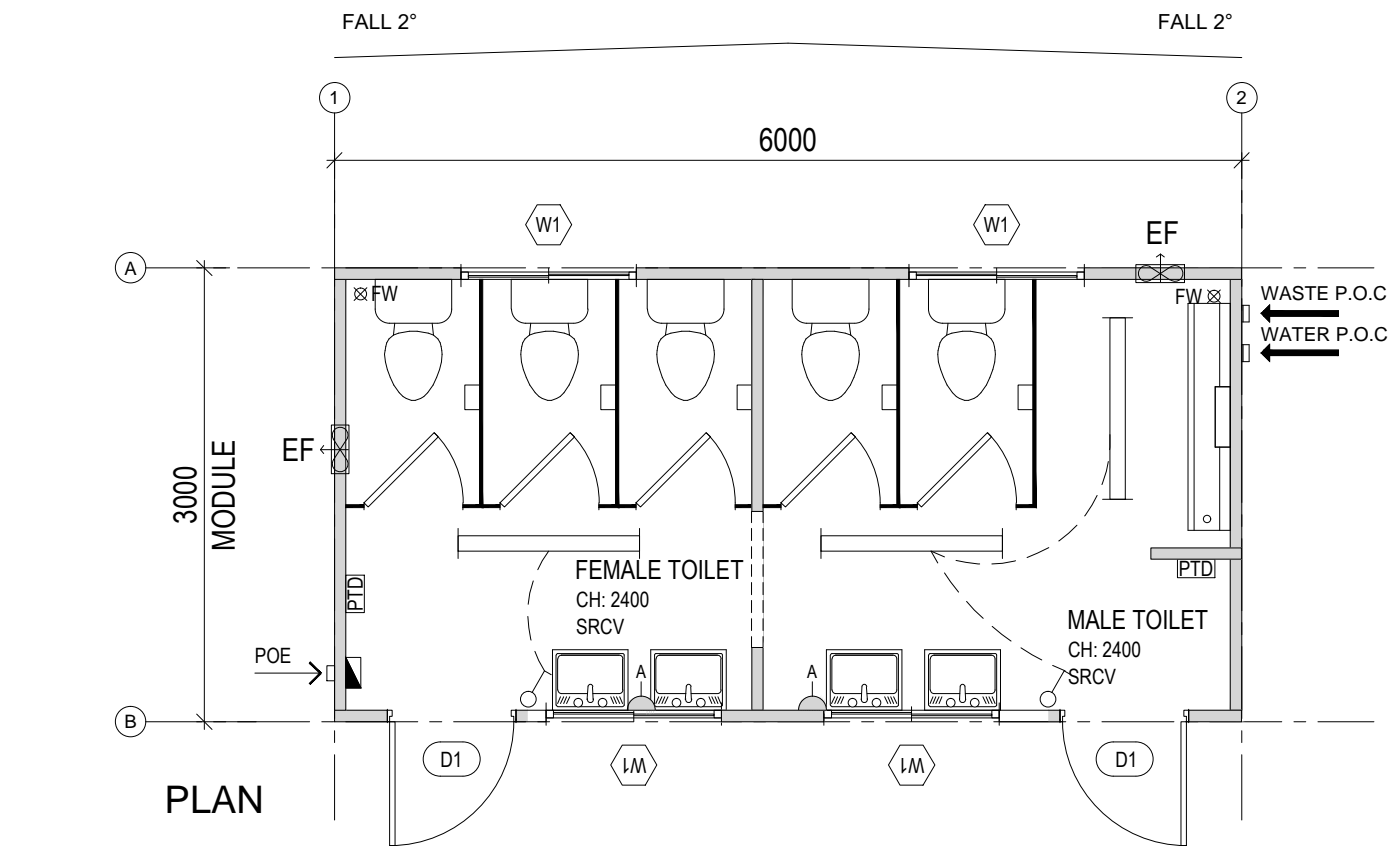

## PLAN

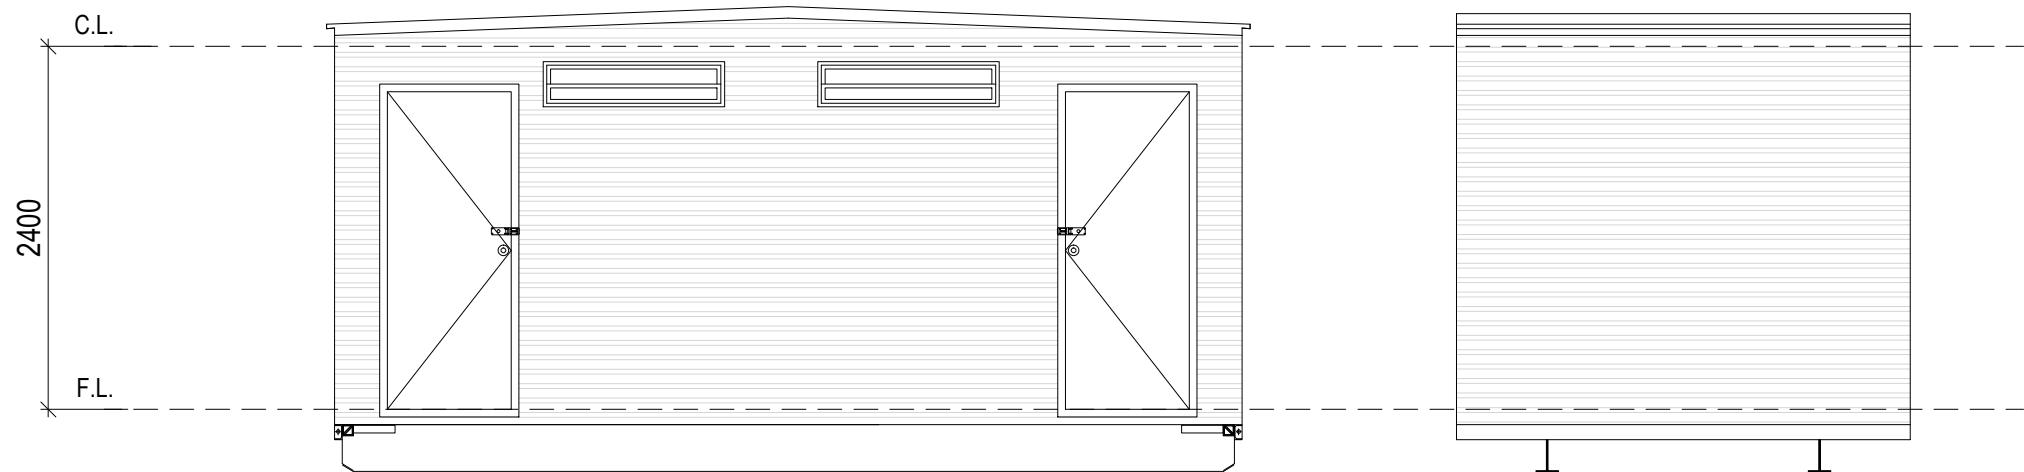

## TYPICAL FRONT ELEVATION

## TYPICAL END ELEVATION

## GENERAL ARRANGEMENT

SCALE: 1:50

## DOOR SCHEDULE

TAG	SIZE	QTY	LOCATION	COLOUR	FURNITURE	LOCKING	KEYING	ARCHITRAVE	GLASS	CLOSER	STOP	NOTES
D1	2040 x 920mm	2	EXTERNAL	WHITE	KNOB	PASSAGE	-	PVC	-	STD	YES	REBATED EDGE; SECURITY - ZINC PLATED HASP & STAPLE, CABIN HOOK

## WINDOW SCHEDULE

TAG	SIZE H x W	QTY	LOCATION	HEIGHT	OPENING	COLOUR	KEYING	ARCHITRAVE	GLASS	BLINDS	NOTES
W1	280 x 1175mm	4	EXTERNAL	2020 AFFL	290 x 1190mm CUT-OUT	PEARL WHITE	-	PVC	OBS& PERMANENT VENT	-	TAPE & SILICON SEAL TOP SIDES.

PRELIMINARY ISSUE

E	AS CLOUDED	ML	04.05.18
D	AS CLOUDED	ML	06.02.18
C	REVISED SPECIFICATIONS	TW	18.08.17
B	PRELIMINARY ISSUE	SN	27.07.16
A	PRELIMINARY ISSUE	ML	09.10.15
ISSUE	AMENDMENT	BY	DATE