

DRAWN: R. BOLAND
DESIGNED: R. BOLAND
JOB MANAGER: R. BOLAND
VERIFIER: S. LEE

General Notes:
- Fire hydrants and hose reels TBC
- Refer to civil plans for details of
stormwater drainage

modify existing dust suppression
sprinklers and stock troff water supplies
to be fed from stormwater reuse system

existing truck wash water supply to
remain, fed from stormwater reuse
system (no works)

Approx. location existing stormwater
reuse tank and pump. Allow to replace
pump with new duplex pump set sized
to suite dust suppression system
demand, c/w with particulate filtration to
suite the application

approx location of existing potable
water meter and backflow assembly

provide new dust suppression
sprinklers to outgoing yards, connected
to stormwater reuse system

modify existing water supply to existing
stock troffs to be fed from stormwater
reuse water system

modify existing water supply to existing
stock troffs to be fed from stormwater
reuse water system

SITE PLAN LEGEND

- EXISTING TREE TO BE RETAINED
- NEW VEHICLE PAVEMENT
- EXISTING YARD ACCESS SERVICE LANES

NOT FOR CONSTRUCTION

REV	DESCRIPTION	ISSUED	VER'D	APP'D	DATE
1	D&C TENDER	RB	SL	SL	30.01.23
2	D&C TENDER	RB	SL	SL	13.07.23

CLIENT

KEMPSEY
Shire Council

DRAWINGS NOT TO BE USED FOR CONSTRUCTION UNLESS
VERIFICATION SIGNATURE HAS BEEN ADDED

ARCHITECT

DRAARCHITECTS

PTY LTD

THE COPYRIGHT OF THIS DRAWING REMAINS WITH NORTHROP
CONSULTING ENGINEERS PTY LTD

ALL SETOUT TO ARCHITECT'S DRAWINGS.
DIMENSIONS TO BE VERIFIED WITH ARCHITECT AND
BUILDER BEFORE COMMENCING SHOP DRAWINGS OR
SITE WORK. NORTHROP ACCEPTS NO RESPONSIBILITY
FOR THE USABILITY, COMPLETENESS OR SCALE OF
DRAWINGS TRANSFERRED ELECTRONICALLY.

0 5000 10000 15000 20000 25000 1500 @ A1

NORTHROP

Newcastle

Level 1, 215 Pacific Highway, Charlestown N.S.W. 2290
Ph (02) 4943 1777 Email: newcastle@northrop.com.au
ABN 81 094 433 100

PROJECT

KEMPSEY REGIONAL SALEYARDS
42 SALEYARDS ROAD KEMPSEY
NSW 2440

DRAWING TITLE

HYDRAULIC SERVICES
SITE PLAN CONCEPT

JOB NUMBER

NL223940


DRAWING NUMBER

HSK01

REVISION

2

DRAWING SHEET SIZE = A1

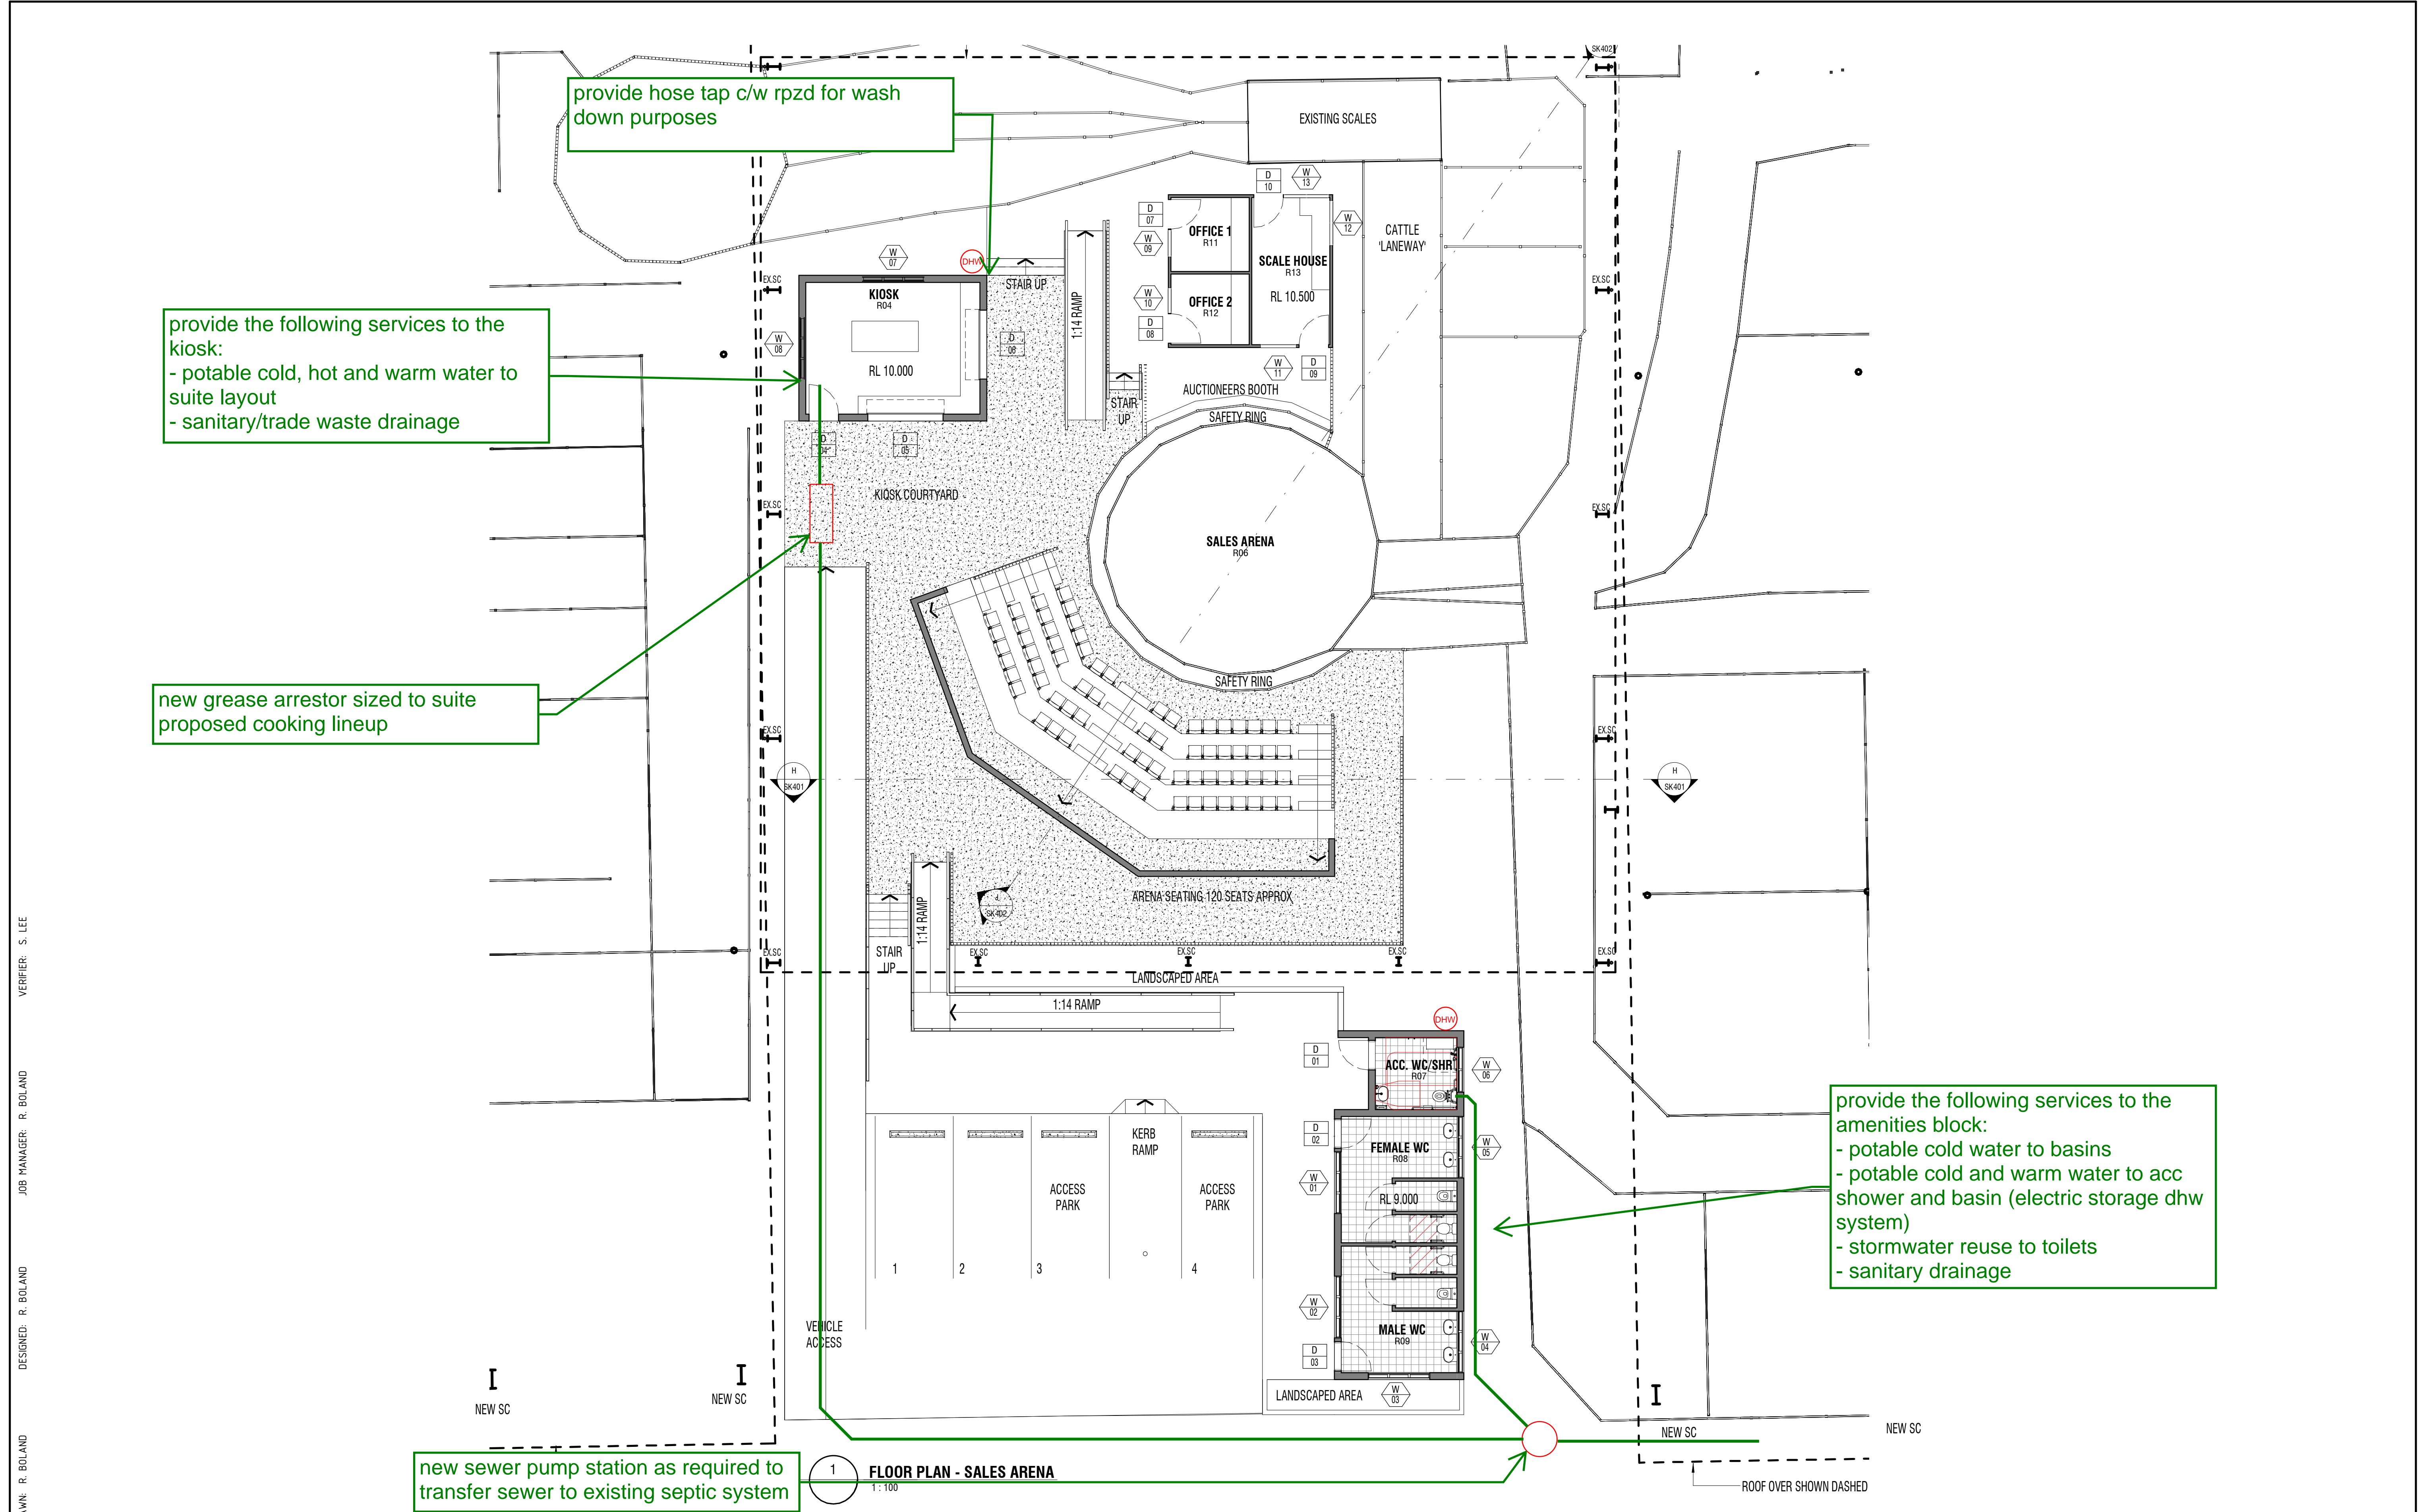


DRAWN: R. BOLAND
DESIGNED: R. BOLAND
JOB MANAGER: R. BOLAND
VERIFIER: S. LEE

REV	DESCRIPTION	ISSUED	VER'D	APP'D	DATE	CLIENT
1	D&C TENDER	RB	SL	SL	30.01.23	Kempsey Shire Council
2	D&C TENDER	RB	SL	SL	13.07.23	




30.01.23

new sewer pump station as required to transfer sewer to existing septic system



1 FLOOR PLAN - SALES ARENA
1:100

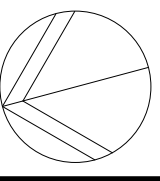

ALL SETOUT TO ARCHITECT'S DRAWINGS. DIMENSIONS TO BE VERIFIED WITH ARCHITECT AND BUILDER BEFORE COMMENCING SHOP DRAWINGS OR SITE WORK. NORTHROP ACCEPTS NO RESPONSIBILITY FOR THE USABILITY, COMPLETENESS OR SCALE OF DRAWINGS TRANSFERRED ELECTRONICALLY.

0 1000 2000 3000 4000 5000 1:100 @ A1



Newcastle
Level 1, 215 Pacific Highway, Charlestown N.S.W. 2290
Ph (02) 4943 1777 Email: newcastle@northrop.com.au
ABN 81 094 433 100

PROJECT

KEMPSEY REGIONAL SALEARYARDS
42 SALEYARDS ROAD KEMPSEY
NSW 2440

DRAWING TITLE

HYDRAULIC SERVICES
SALES ARENA CONCEPT

JOB NUMBER

NL223940

DRAWING NUMBER	REVISION
HSK02	2

DRAWING SHEET SIZE = A1

NOT FOR CONSTRUCTION