


DRAWING SCHEDULE				
DWG No.	DRAWING NAME	DWG ISSUE DATE	DWG REV	DWG REV DATE
A.000	COVER SHEET	07.08.2019		
A.010	SITE PLAN	07.08.2019		
A.011	SITE PLAN STAGES	07.08.2019		
A.050	EXISTING FLOOR PLAN	07.08.2019		
A.051	DEMOLITION PLAN	07.08.2019		
A.052	GFA - PLANS	07.08.2019		
A.053	ROOM SCHEDULE	07.08.2019		
A.056	PERSPECTIVES	17.07.2019		
A.100	PROPOSED GROUND FLOOR PLAN	07.08.2019		
A.101	PROPOSED LEVEL 01 PLAN	07.08.2019		
A.400	SECTIONS 1	07.08.2019		
A.401	SECTIONS 2	07.08.2019		
A.402	ELEVATIONS + SECTIONS	07.08.2019		
A.1010	EXTERNAL FINISHES	07.08.2019		

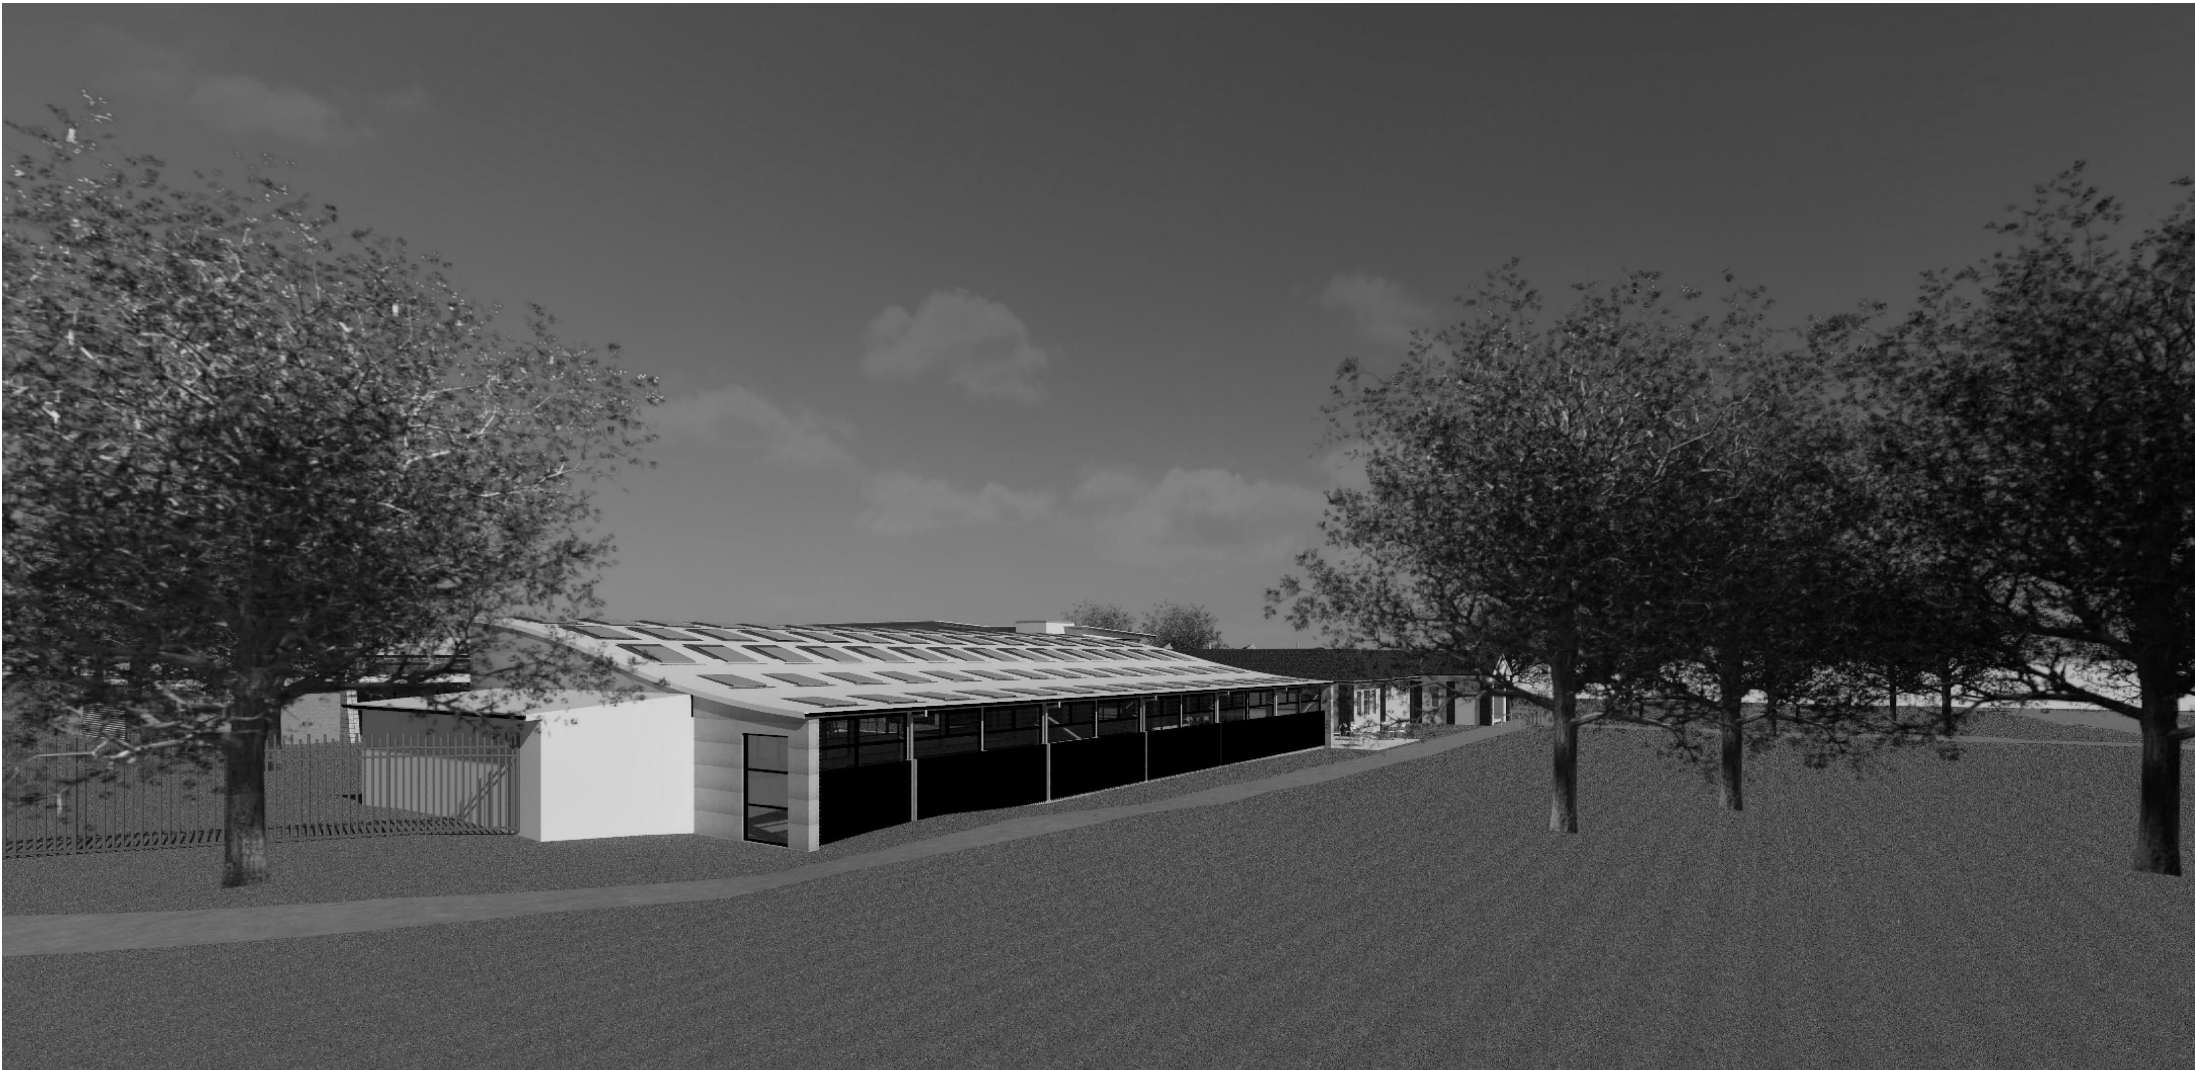


LOCATION PLAN
NOT TO SCALE

CONTRACTORS MUST VERIFY ALL DIMENSIONS ON SITE BEFORE COMMENCING ANY WORK OR PREPARING SHOP DRAWINGS

All Architectural drawing sheets to be cross-referenced with other relevant disciplines.

Rev	Description	Date
-----	-------------	------

 CONSULTANT 5:
SMS Pty Ltd
acn 80 158 133 110
po box 480
Milsport Point 1565
t 9438 1022 f 9438 2124
e reception@smscorp.com.au



CONSULTANT 4:
M.J. HARVEY & ASSOCIATES PTY. LTD.
HYDRAULIC & FIRE PROTECTION ENGINEERS
UNIT 7, 11-13 POTTER CLOSE
WEHERILL PARK 2164
Phone (02) 9756 5579
Fax (02) 9756 5641
Email: Michael@mhharvey.com.au

CONSULTANT 3:
COLARCI
A division of Collingridge & Associates Architects
39 Terry Street ROYELLE NSW 2039
T: +61 2 9555 8108


CONSULTANT 2:
SPECTRUM
ENGINEERING SOLUTIONS
1 Davis Place
Glenhaven NSW 2156
Phone: (02) 8850 6802
Mobile: 0419 294 533
Email: r.nah@specengsolutions.com.au

CONSULTANT 1:
ECLIPSE Consulting Engineers Pty Ltd
304/12 Century Cct - Norwest Central,
BAULKHAM HILLS NSW 2153
p: 02 9894 8500
m: 0419 64 8500 f: 02 8850 0212
e: info@eclipse.com.au
www.eclipse.com.au

DESIGN ARCHITECT:
FACILITY DESIGN GROUP
Architecture & Construction
AQUATIC ■ SPORTS ■ LEISURE ■ CIVIC ■ PROJECT MANAGEMENT
NSW Reg. No. 7168
ABN 75 083 999 624
info@fdg.com.au
www.fdg.com.au
02 4446 0777
PO Box 82,
Cronulla NSW 2230

CLIENT:
Municipality of Burwood
Burwood
heritage • progress • pride

PROJECT NAME:
Enfield Aquatic Centre Masterplan
FOR DA
PROJECT ADDRESS:
Lot 7305 DP1146569
Portland Street,
Enfield NSW 2136

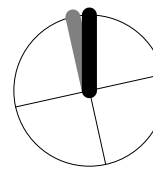

DRAWING TITLE:	
COVER SHEET	
B1 PRINT SIZE	
SHEET ISSUE DATE: 07.08.2019	DRAWING NO. REV.
REVISION DATE:	
SCALE: As indicated @ A1	A.000
JOB NO.: W221	

DRAWN BY: AT CHECKED BY: S. JOHANSSON

COPYRIGHT FACILITY DESIGN GROUP PTY. LIMITED. ALL RIGHTS RESERVED. DO NOT SCALE OFF DRAWINGS. WORK TO FIGURED DIMENSIONS ONLY. VERIFY DIMENSIONS ON SITE PRIOR TO COMMENCING WORK.

NOMINATED ARCHITECT: STEPHEN JOHANSSON - NSW REG No. 7168
24/08/2019 2:01:38 PM

CONTRACTORS MUST VERIFY ALL DIMENSIONS ON SITE BEFORE COMMENCING ANY WORK OR PREPARING SHOP DRAWINGS

All Architectural drawing sheets to be cross-referenced with other relevant disciplines.

Rev Description Date

CONSULTANT 5:
SMS
acn 80 158 133 110
po box 480
Milsport Point 1565
t: 9438 1022 f: 9438 2124
e: reception@smscorp.com.au

CONSULTANT 4:
M.J. HARVEY & ASSOCIATES PTY. LTD.
HYDRAULIC & FIRE PROTECTION ENGINEERS
UNIT 7, 11-13 POTTER CLOSE
WETHERILL PARK 2164
Phone (02) 9756 5579
Fax (02) 9756 5641
Email: Michael@mhjharvey.com.au

CONSULTANT 3:
COLARCI
A division of Collingridge & Associates Architects
39 Terry Street ROYELLE NSW 2039
ARCHITECTURE | APPLIED AQUATIC ENGINEERING
T: +61 2 9555 8108

CONSULTANT 2:
SPECTRUM
ENGINEERING SOLUTIONS
1 Davis Place
Glenhaven NSW 2156
Phone: (02) 8850 6802
Mobile: 0419 294 533
Email: r.nash@spectrumeng.com.au

CONSULTANT 1:
ECLIPSE Consulting Engineers Pty Ltd
304/12 Century Cct - Norwest Central,
BAULMORAH HILLS NSW 2153
p: 02 9894 8500
m: 0419 64 8500 f: 02 8850 0212
e: info@eclipse.com.au
ECLIPSE CONSULTING ENGINEERS

DESIGN ARCHITECT:
FACILITY DESIGN GROUP
Architecture & Construction
AQUATIC ■ SPORTS ■ LEISURE ■ CIVIC ■ PROJECT MANAGEMENT
NSW Reg. No. 7168
ABN: 75 083 999 624
e: info@fdg.com.au
w: www.fdg.com.au
p: 02 4446 0777
c: PO Box 62,
Cronulla NSW 2230

CLIENT:
Burwood
heritage • progress • pride

PROJECT NAME:
Enfield Aquatic Centre Masterplan

FOR DA
PROJECT ADDRESS:
Lot 7305 DP1146569
Portland Street,
Enfield NSW 2136


DRAWING TITLE:

SITE PLAN

B1 PRINT SIZE
SHEET ISSUE DATE: 07.08.2019
REVISION DATE:
SCALE: 1:250 @ A1
JOB NO.: W221
DRAWN BY: AT
CHECKED BY: S. JOHANSSON
DRAWING NO. REV.
A.010

COPYRIGHT FACILITY DESIGN GROUP PTY. LIMITED. ALL RIGHTS RESERVED. DO NOT SCALE OFF DRAWINGS. WORK TO FIGURED DIMENSIONS ONLY. VERIFY DIMENSIONS ON SITE PRIOR TO COMMENCING WORK.

NOMINATED ARCHITECT: STEPHEN JOHANSSON - NSW REG No. 7168
24/08/2019 2:01:46 PM

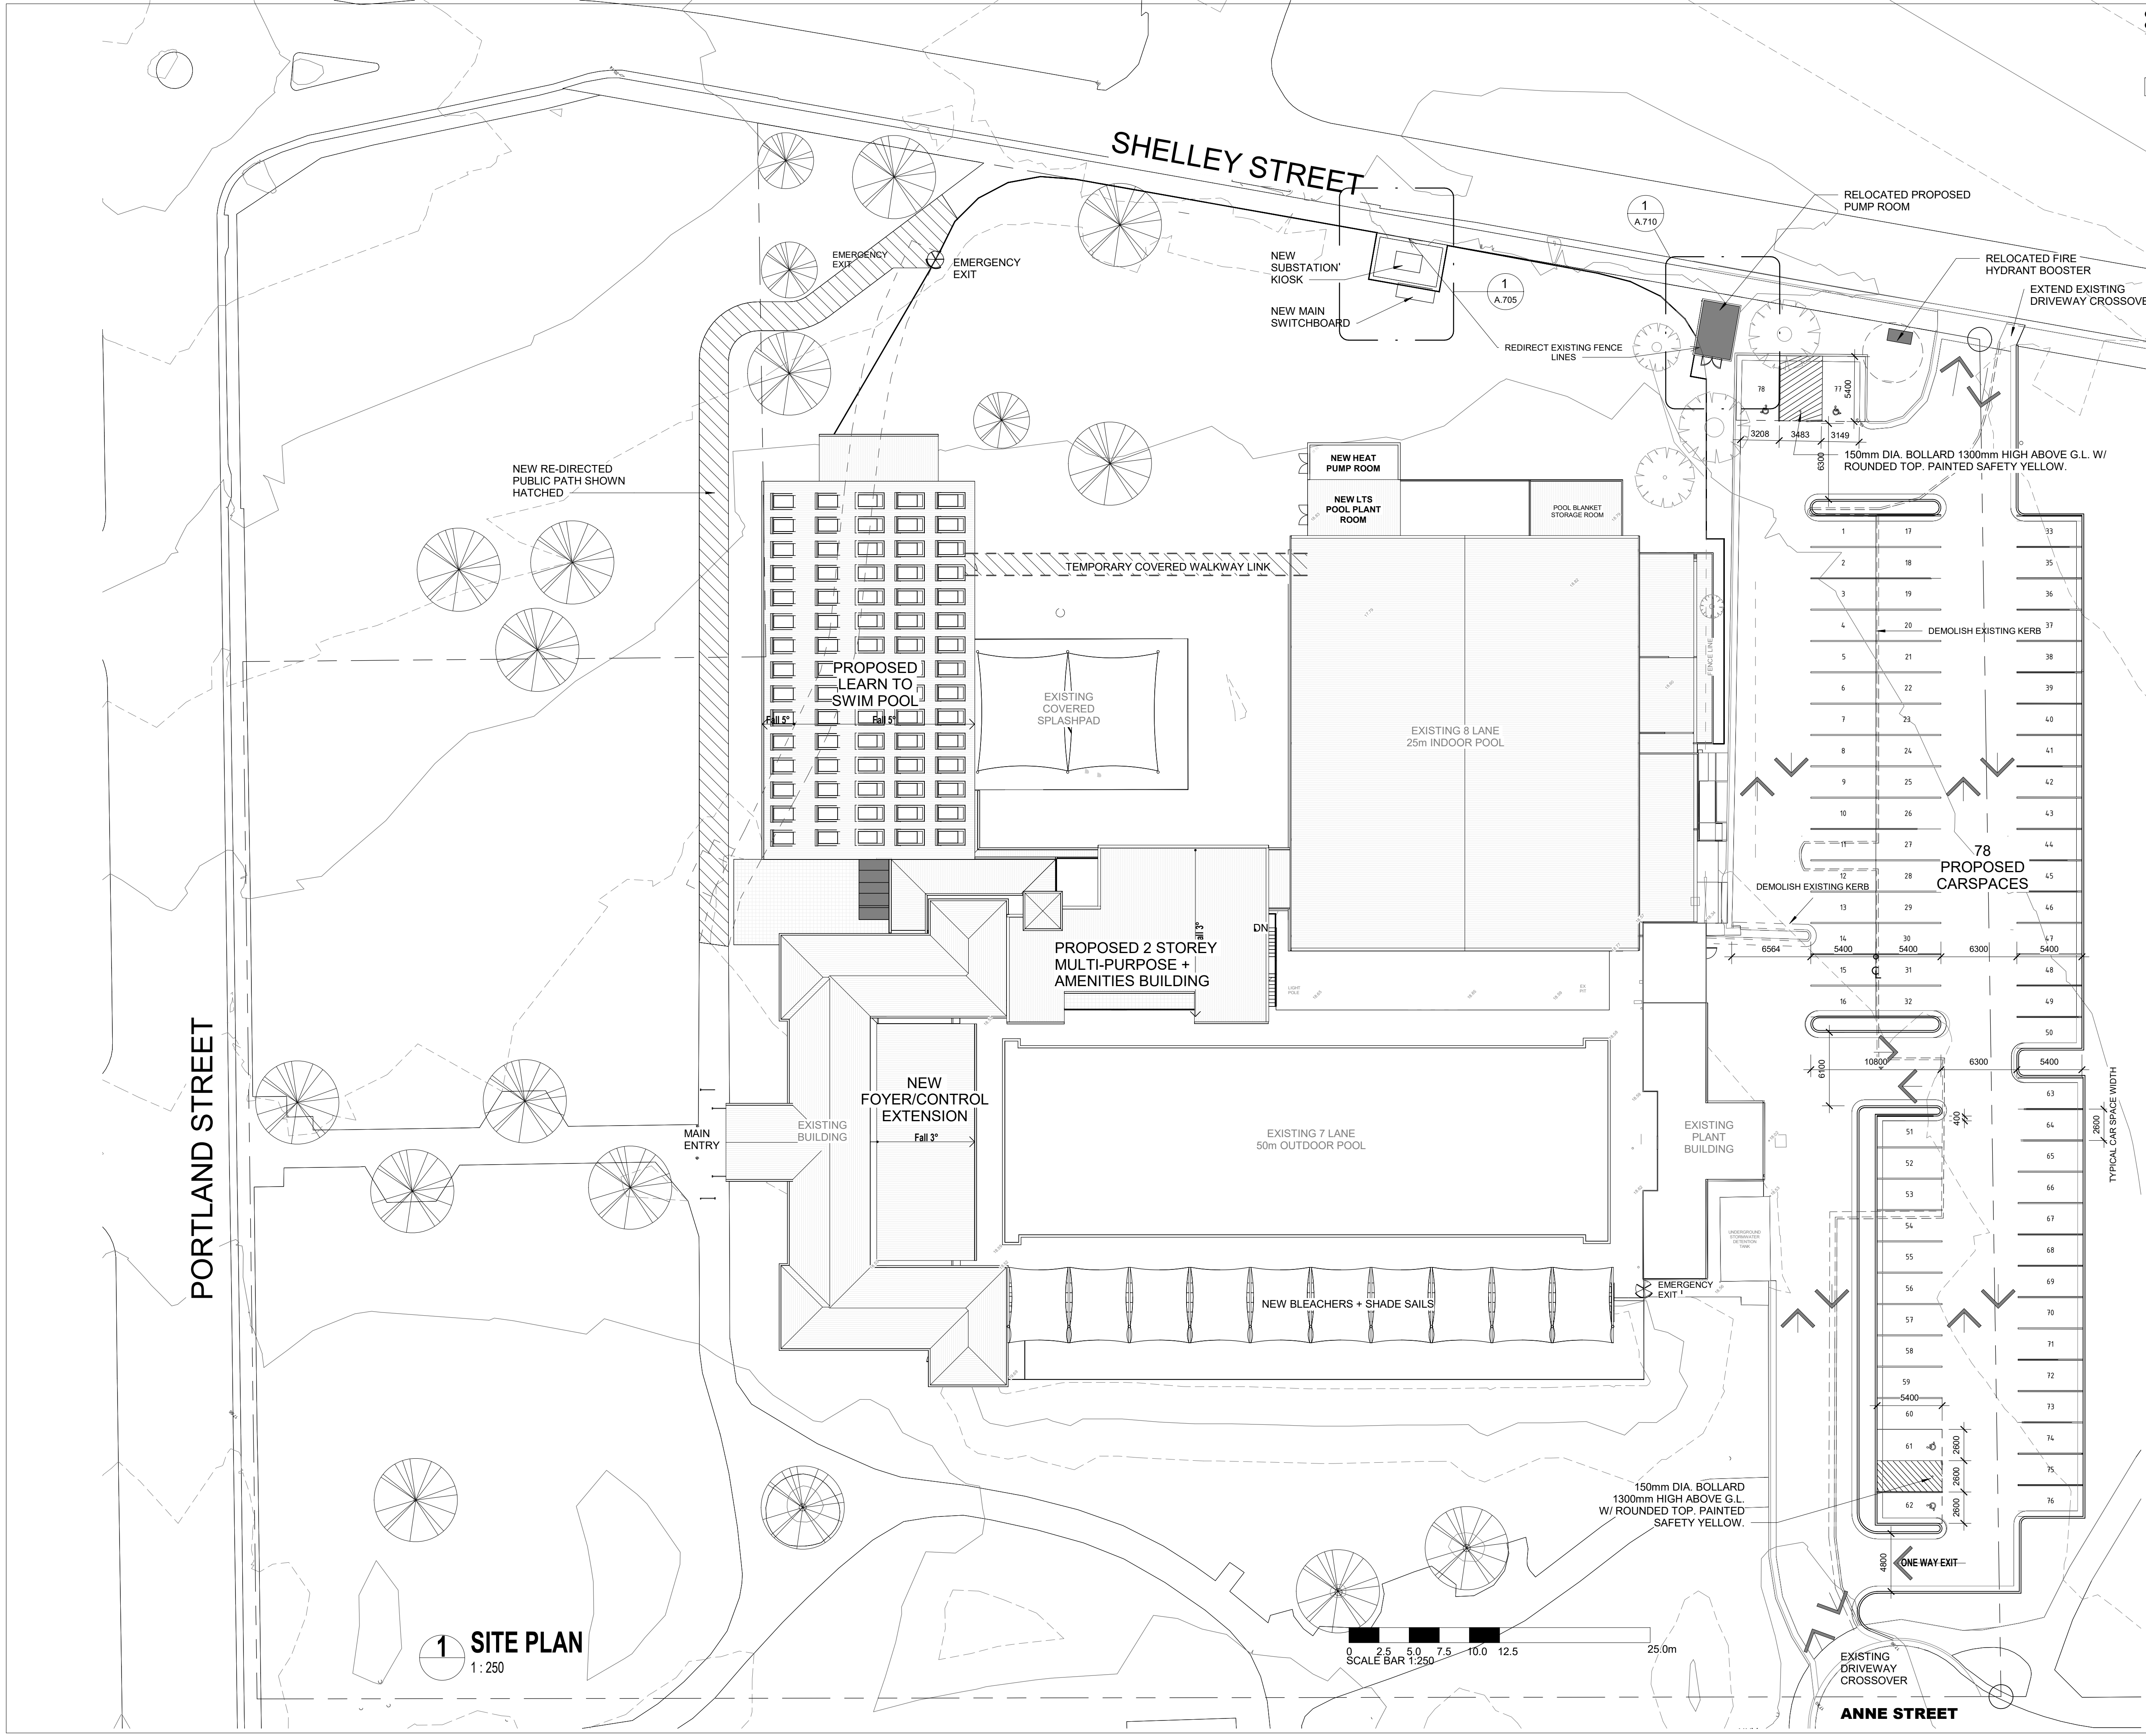


1 SITE PLAN
1:250

0 2.5 5.0 7.5 10.0 12.5 25.0m
SCALE BAR 1:250

CONTRACTORS MUST VERIFY ALL DIMENSIONS ON SITE BEFORE COMMENCING ANY WORK OR PREPARING SHOP DRAWINGS


All Architectural drawing sheets to be cross-referenced with other relevant disciplines.

Rev	Description	Date
-----	-------------	------

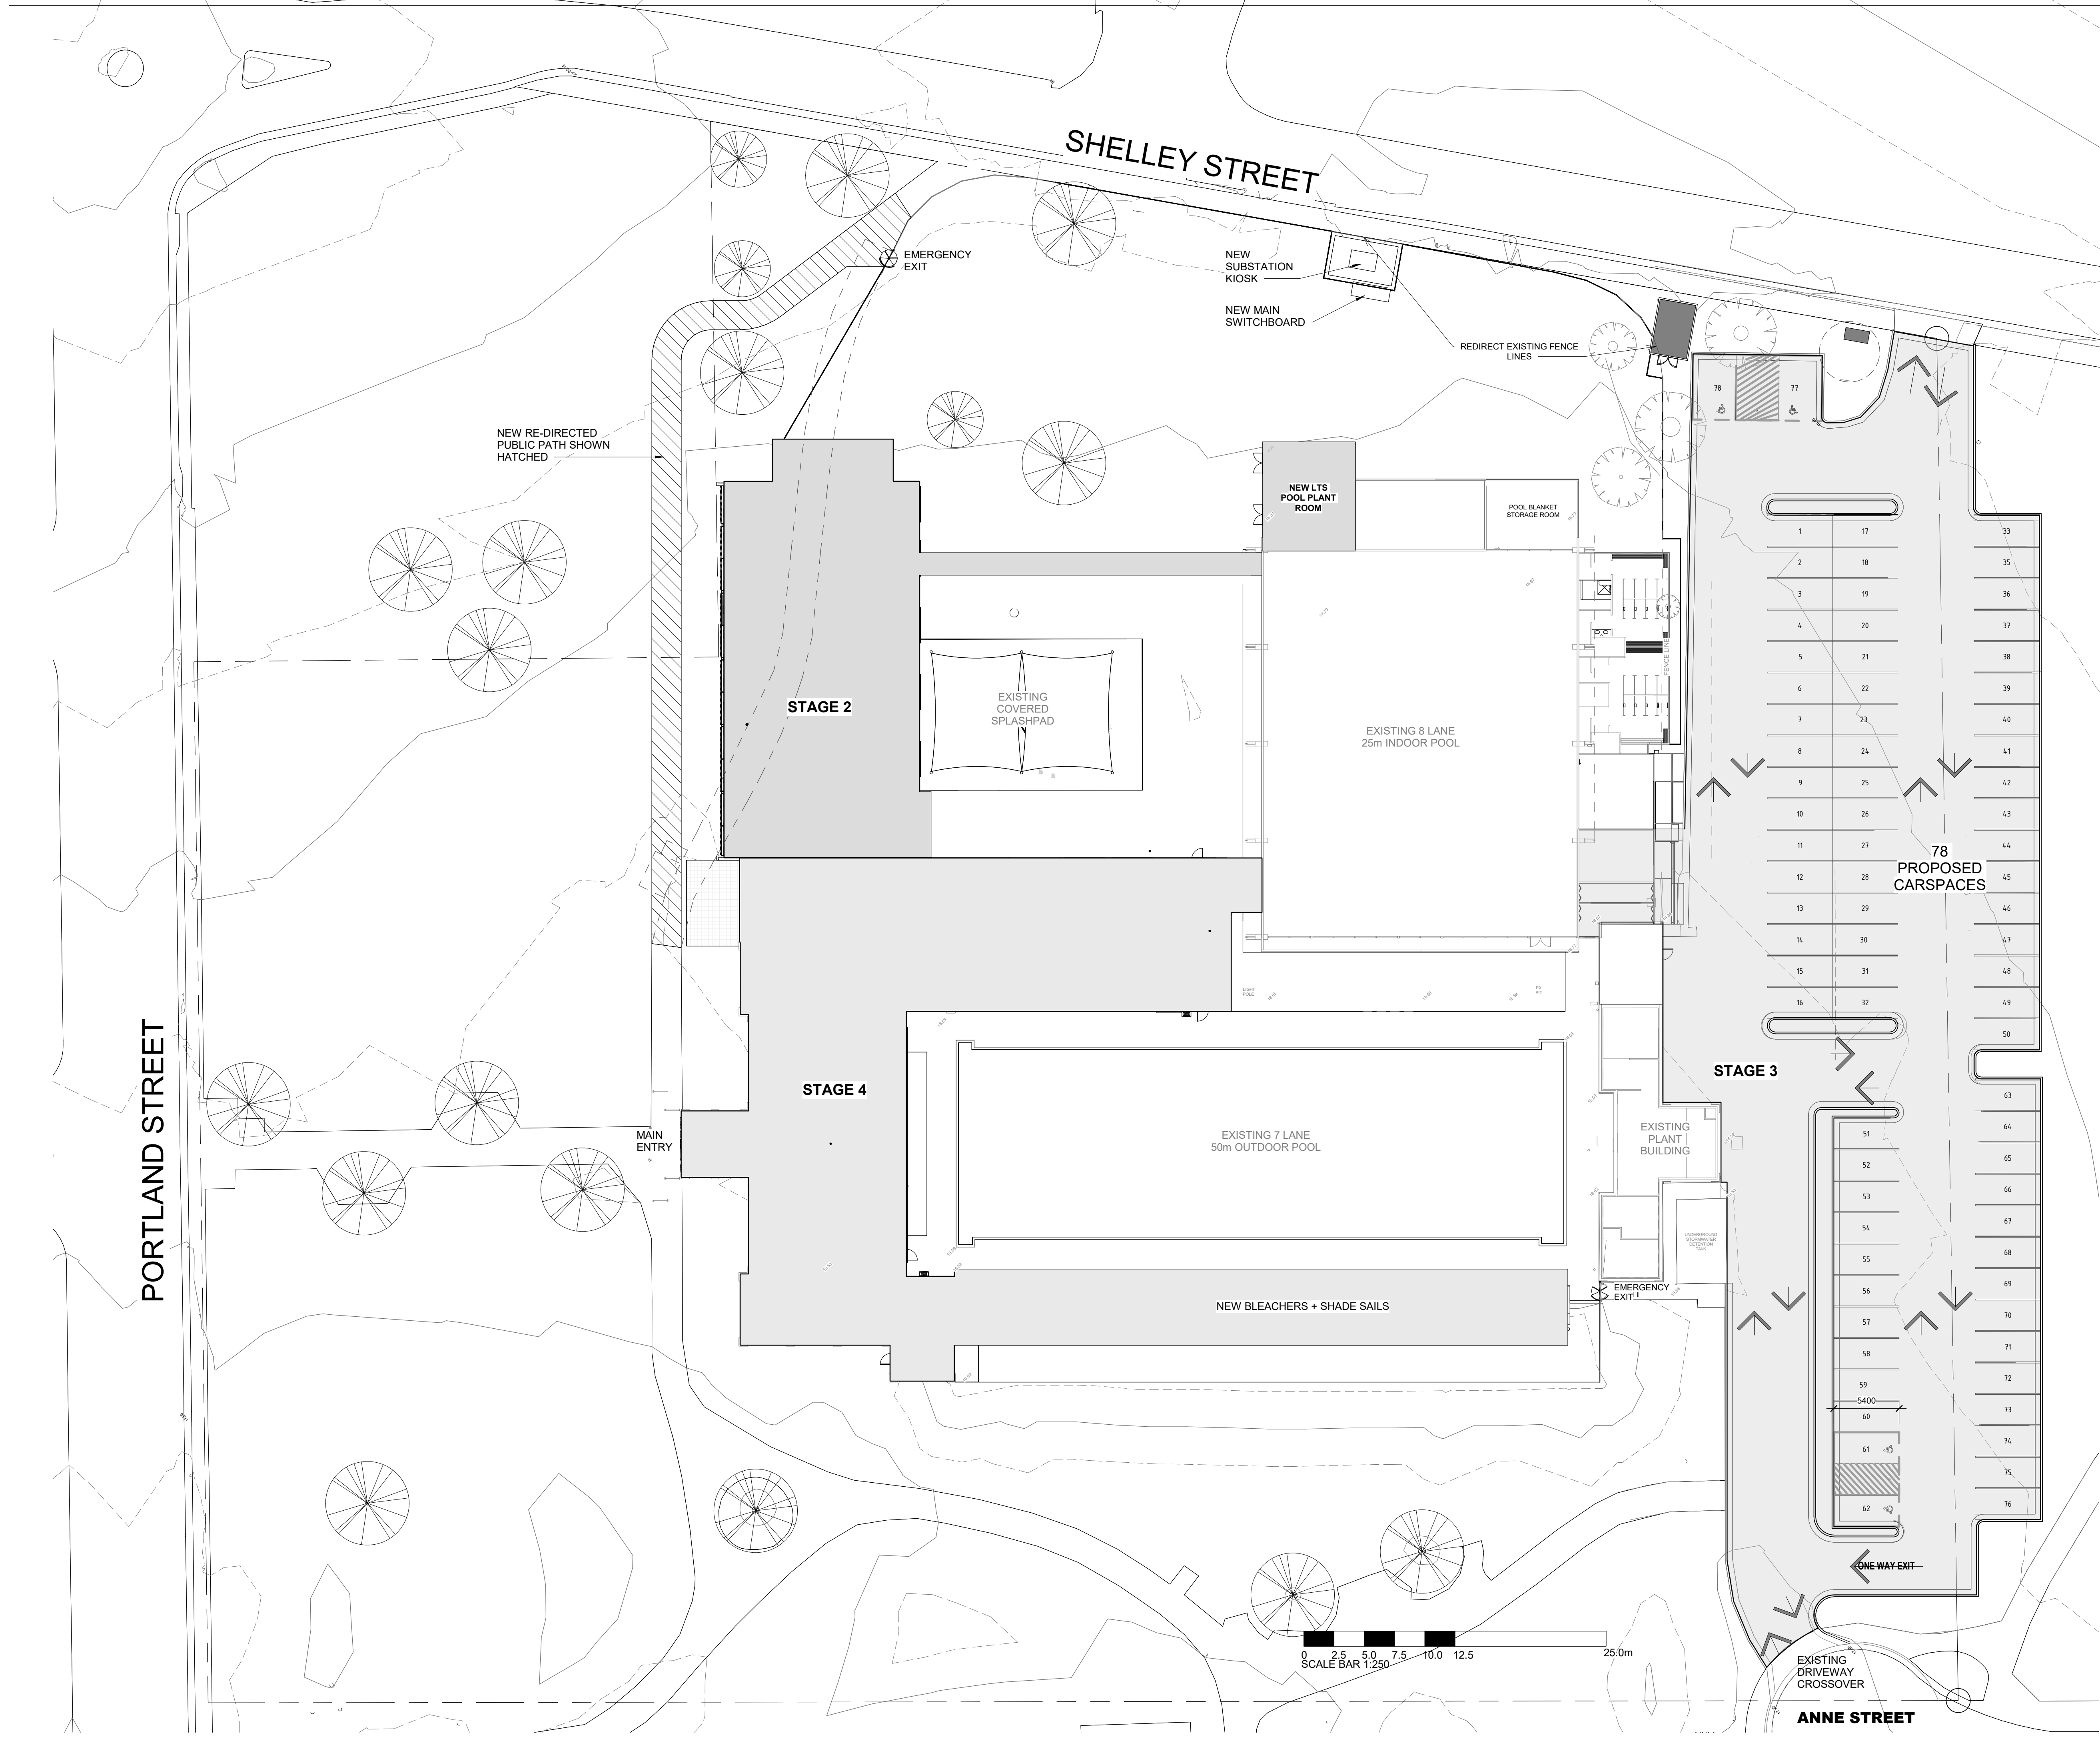

CONSULTANT 5:

 SMS
PO BOX 158 133 110
PO BOX 480
MILSONA POINT 1565
T: 9438 1022 F: 9438 2124
E: reception@smscorp.com.au



CONSULTANT 4:

MJH M.J. HARVEY & ASSOCIATES PTY. LTD.
HYDRAULIC & FIRE PROTECTION ENGINEERS
UNIT 7, 11-13 POTTER CLOSE
WETHERILL PARK 2164
Phone (02) 9756 5579
Fax (02) 9756 5641
Email: Michael@mjharvey.com.au

CONSULTANT 3:

COLARCI
A division of Collingridge & Associates Architects
39 Terry Street ROYELLE NSW 2039
ARCHITECTURE | APPLIED AQUATIC ENGINEERING
T: +61 2 9555 8108

CONSULTANT 2:

SPECTRUM
ENGINEERING SOLUTIONS
1 Davis Place
Glenhaven NSW 2156
Phone: (02) 8850 6802
Mobile: 0419 294 533
Email: r.nash@spectrum-solutions.com.au

CONSULTANT 1:

ECLIPSE CONSULTING ENGINEERS
ECLIPSE Consulting Engineers Pty Ltd
304/12 Century Cct - Norwest Central,
BAILLIAM HILLS NSW 2153
p: 02 9894 8500
m: 0419 64 8500 f: 02 8850 0212
e: info@eclipse.com.au

DESIGN ARCHITECT:

FACILITY DESIGN GROUP
Architecture & Construction
AQUATIC ■ SPORTS ■ LEISURE ■ CIVIC ■ PROJECT MANAGEMENT
NSW Reg. No. 7168
ABN: 75 083 999 624
e: info@fdg.com.au
w: www.fdg.com.au
p: 02 4446 0777
c: PO Box 82,
Cronulla NSW 2230

CLIENT:

Owner Burwood
heritage • progress • pride

PROJECT NAME:

Enfield Aquatic Centre Masterplan

FOR DA

PROJECT ADDRESS:
Lot 7305 DP1146569
Portland Street,
Enfield NSW 2136

DRAWING TITLE:

SITE PLAN STAGES

SHEET ISSUE DATE: 07.08.2019
REVISION DATE:

SCALE: 1:250 @ A1


JOB NO.: W221

DRAWN BY: Author CHECKED BY: S. JOHANSSON

COPYRIGHT FACILITY DESIGN GROUP PTY. LIMITED. ALL RIGHTS RESERVED. DO NOT SCALE OFF DRAWINGS. WORK TO FIGURED DIMENSIONS ONLY. VERIFY DIMENSIONS ON SITE PRIOR TO COMMENCING WORK.

NOMINATED ARCHITECT: STEPHEN JOHANSSON - NSW REG NO. 7168

24/08/2019 2:01:53 PM

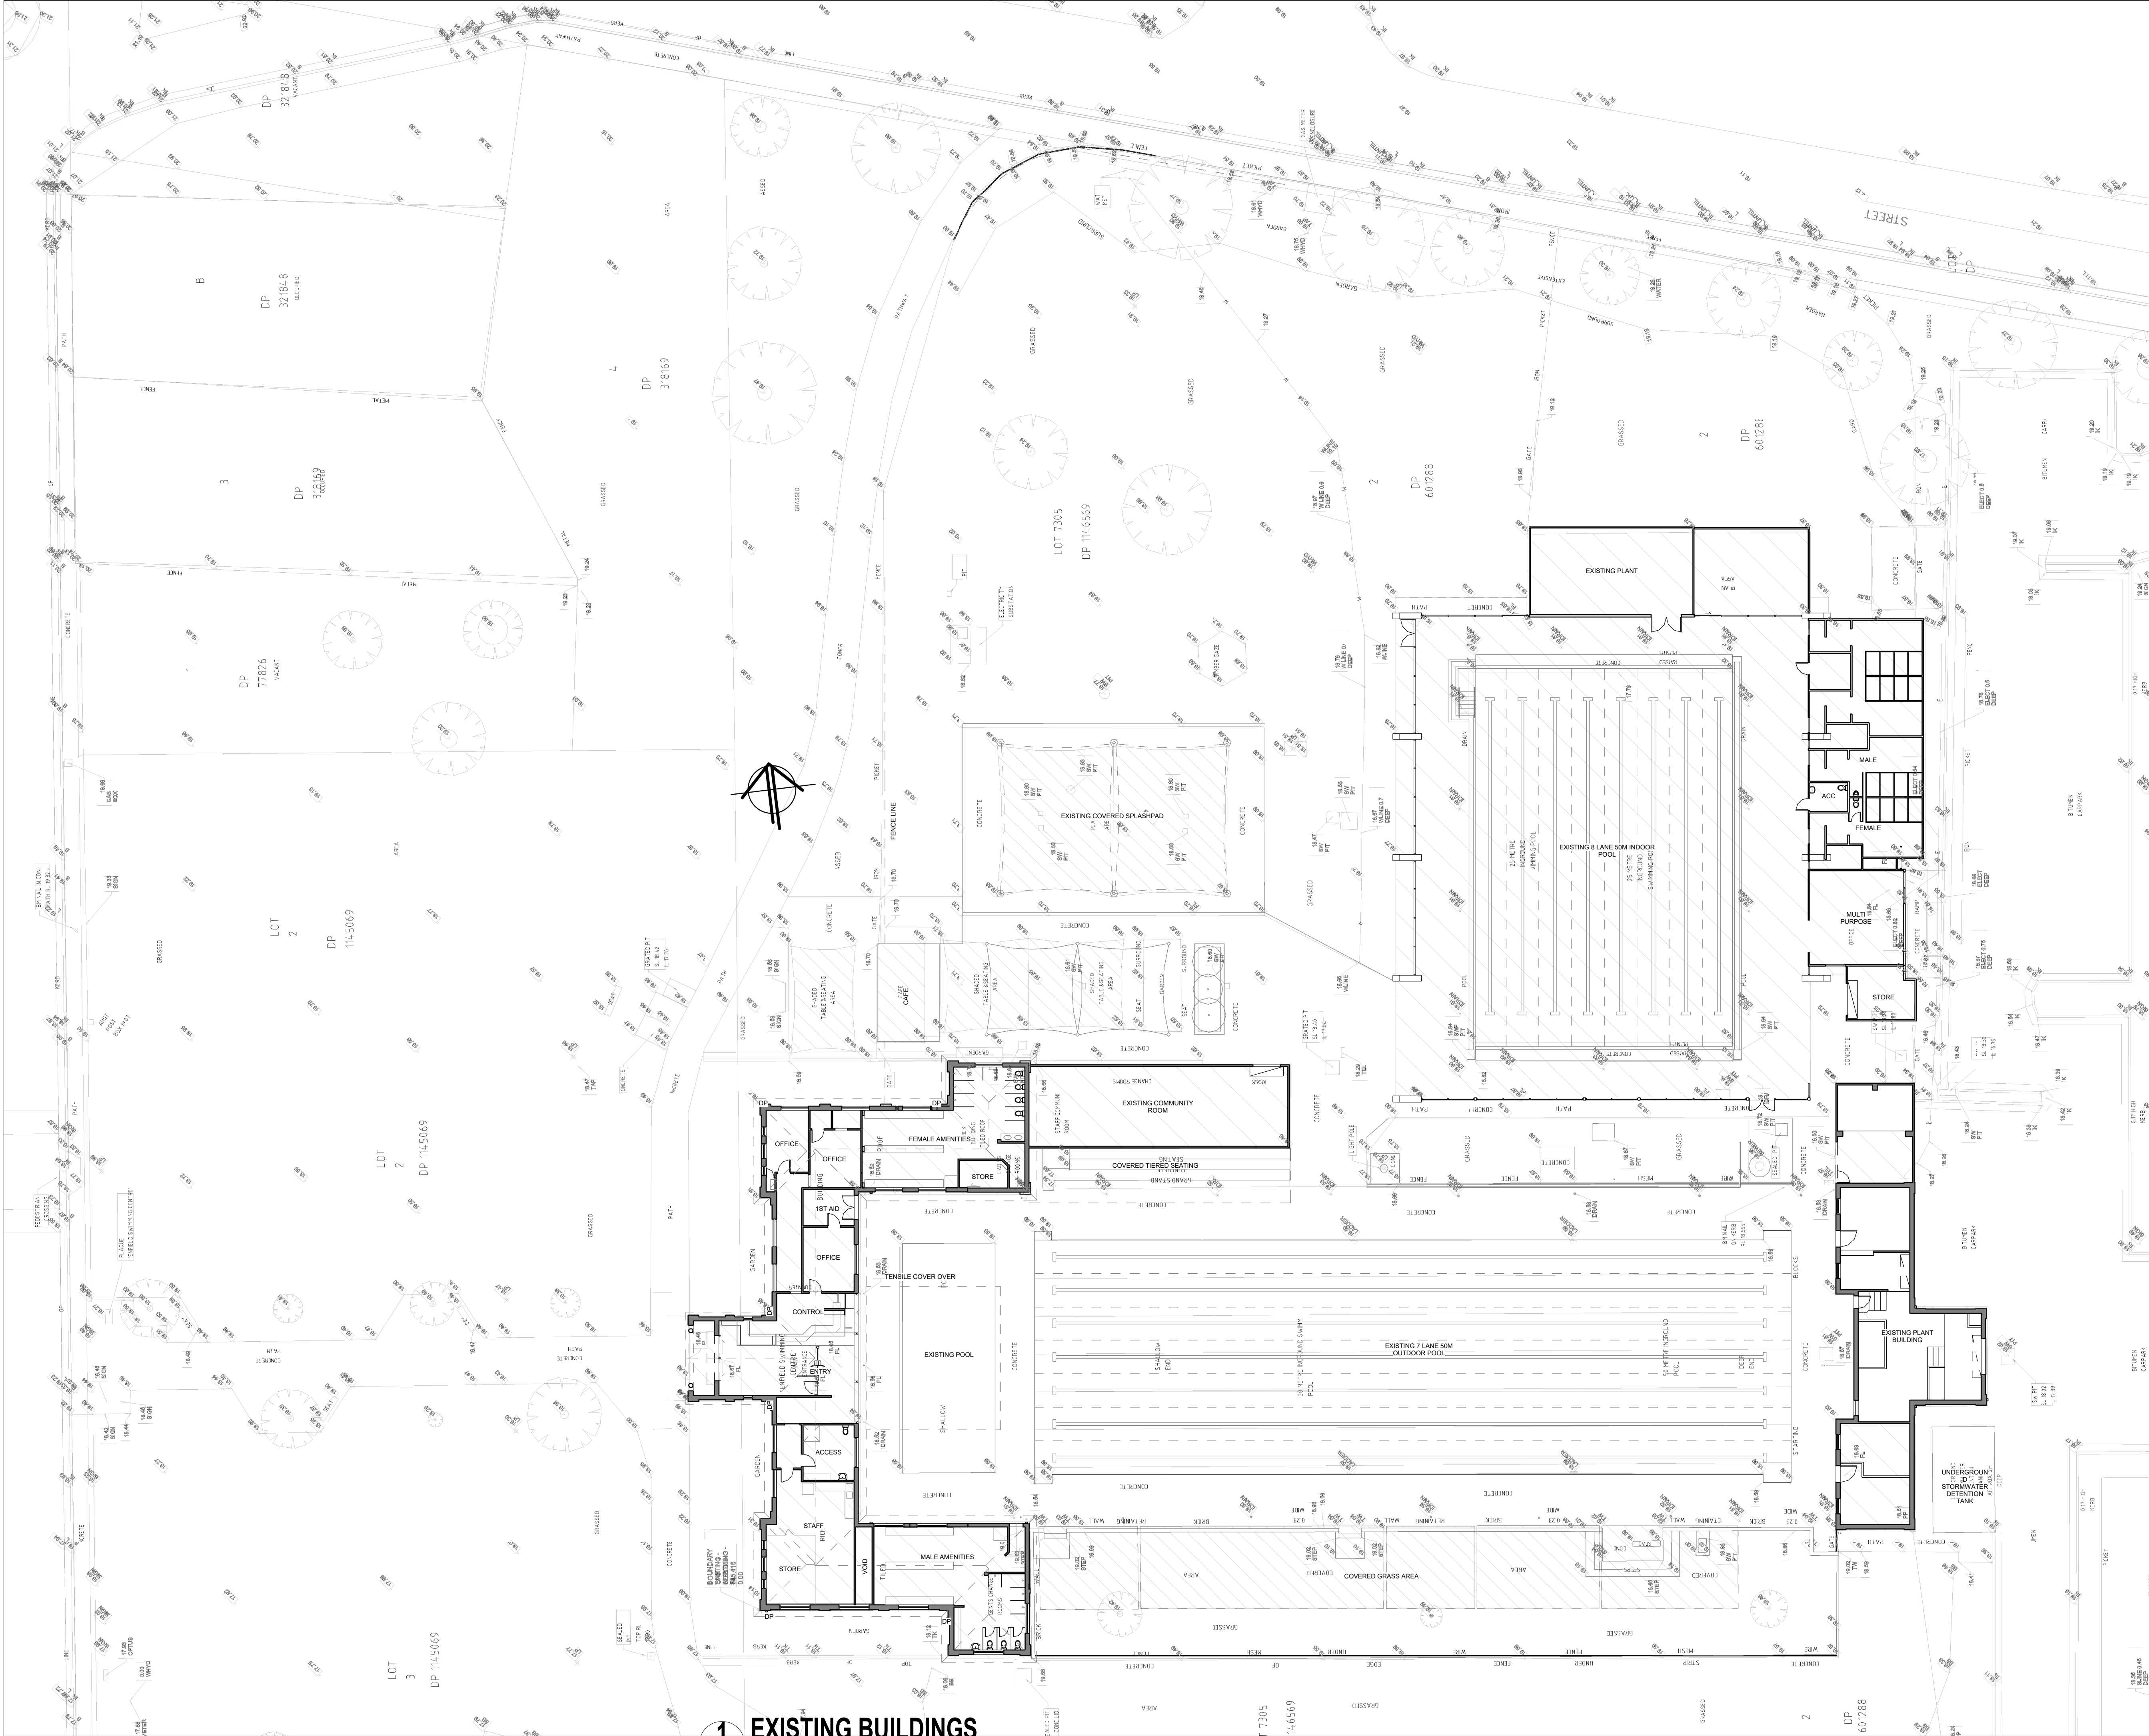

CONTRACTORS MUST VERIFY ALL DIMENSIONS ON SITE BEFORE COMMENCING ANY WORK OR PREPARING SHOP DRAWINGS

All Architectural drawing sheets to be cross-referenced with other relevant disciplines.

Rev	Description	Date
-----	-------------	------

CONSULTANT 5:
SMS
acn 80 158 133 110
po box 480
Milsom Point 1565
t: 0438 10022 f: 0438 2124
e: reception@smscorp.com.au

CONSULTANT 4:
M.J. HARVEY & ASSOCIATES PTY. LTD.
HYDRAULIC & FIRE PROTECTION ENGINEERS
UNIT 7, 11-13 POTTER CLOSE
WETHERILL PARK 2164
Phone (02) 9756 5579
Fax (02) 9756 5641
Email: Michael@mjharvey.com.au

CONSULTANT 3:
COLARCI
A division of Collingridge & Associates Architects
39 Terry Street ROYELLE NSW 2039
ARCHITECTURE | APPLIED AQUATIC ENGINEERING
T: +61 2 9555 8108

CONSULTANT 2:
SPECTRUM
ENGINEERING SOLUTIONS
1 Davis Place
Glenhaven NSW 2156
Phone: (02) 8850 6802
Mobile: 0419 294 533
Email: nash@spectrum-solutions.com.au

CONSULTANT 1:
ECLIPSE CONSULTING ENGINEERS
ECLIPSE Consulting Engineers Pty Ltd
304/12 Century Cct - Norwest Central,
BAULMORAH HILLS NSW 2153
p: 02 9894 6500
m: 0419 64 6500 f: 02 8850 0212
e: stephen@eclipse-consulting.com.au

DESIGN ARCHITECT:
FACILITY DESIGN GROUP
Architecture & Construction
AQUATIC ■ SPORTS ■ LEISURE ■ CIVIC ■ PROJECT MANAGEMENT
NSW Reg. No. 7168
ABN: 75 583 999 624
e: info@fdg.com.au
w: www.fdg.com.au
p: 02 4446 0777
PO Box 62,
Cronulla NSW 2240

CLIENT:
Burwood
heritage • progress • pride

PROJECT NAME:
Enfield Aquatic Centre
Masterplan
FOR DA
PROJECT ADDRESS:
Lot 7305 DP1146569
Portland Street,
Enfield NSW 2136


DRAWING TITLE:
EXISTING FLOOR PLAN

SHEET ISSUE DATE: 07.08.2019	DRAWING NO. REV.
REVISION DATE:	
SCALE: 1:200 @ A1	A.050
JOB NO.: W221	
DRAWN BY: AT	CHECKED BY: S. JOHANSSON

COPYRIGHT FACILITY DESIGN GROUP PTY. LIMITED. ALL RIGHTS RESERVED. DO NOT SCALE OFF DRAWINGS. WORK TO FIGURED DIMENSIONS ONLY. VERIFY DIMENSIONS ON SITE PRIOR TO COMMENCING WORK.

NOMINATED ARCHITECT: STEPHEN JOHANSSON - NSW REG NO. 7168

24/08/2019 2:02:24 PM

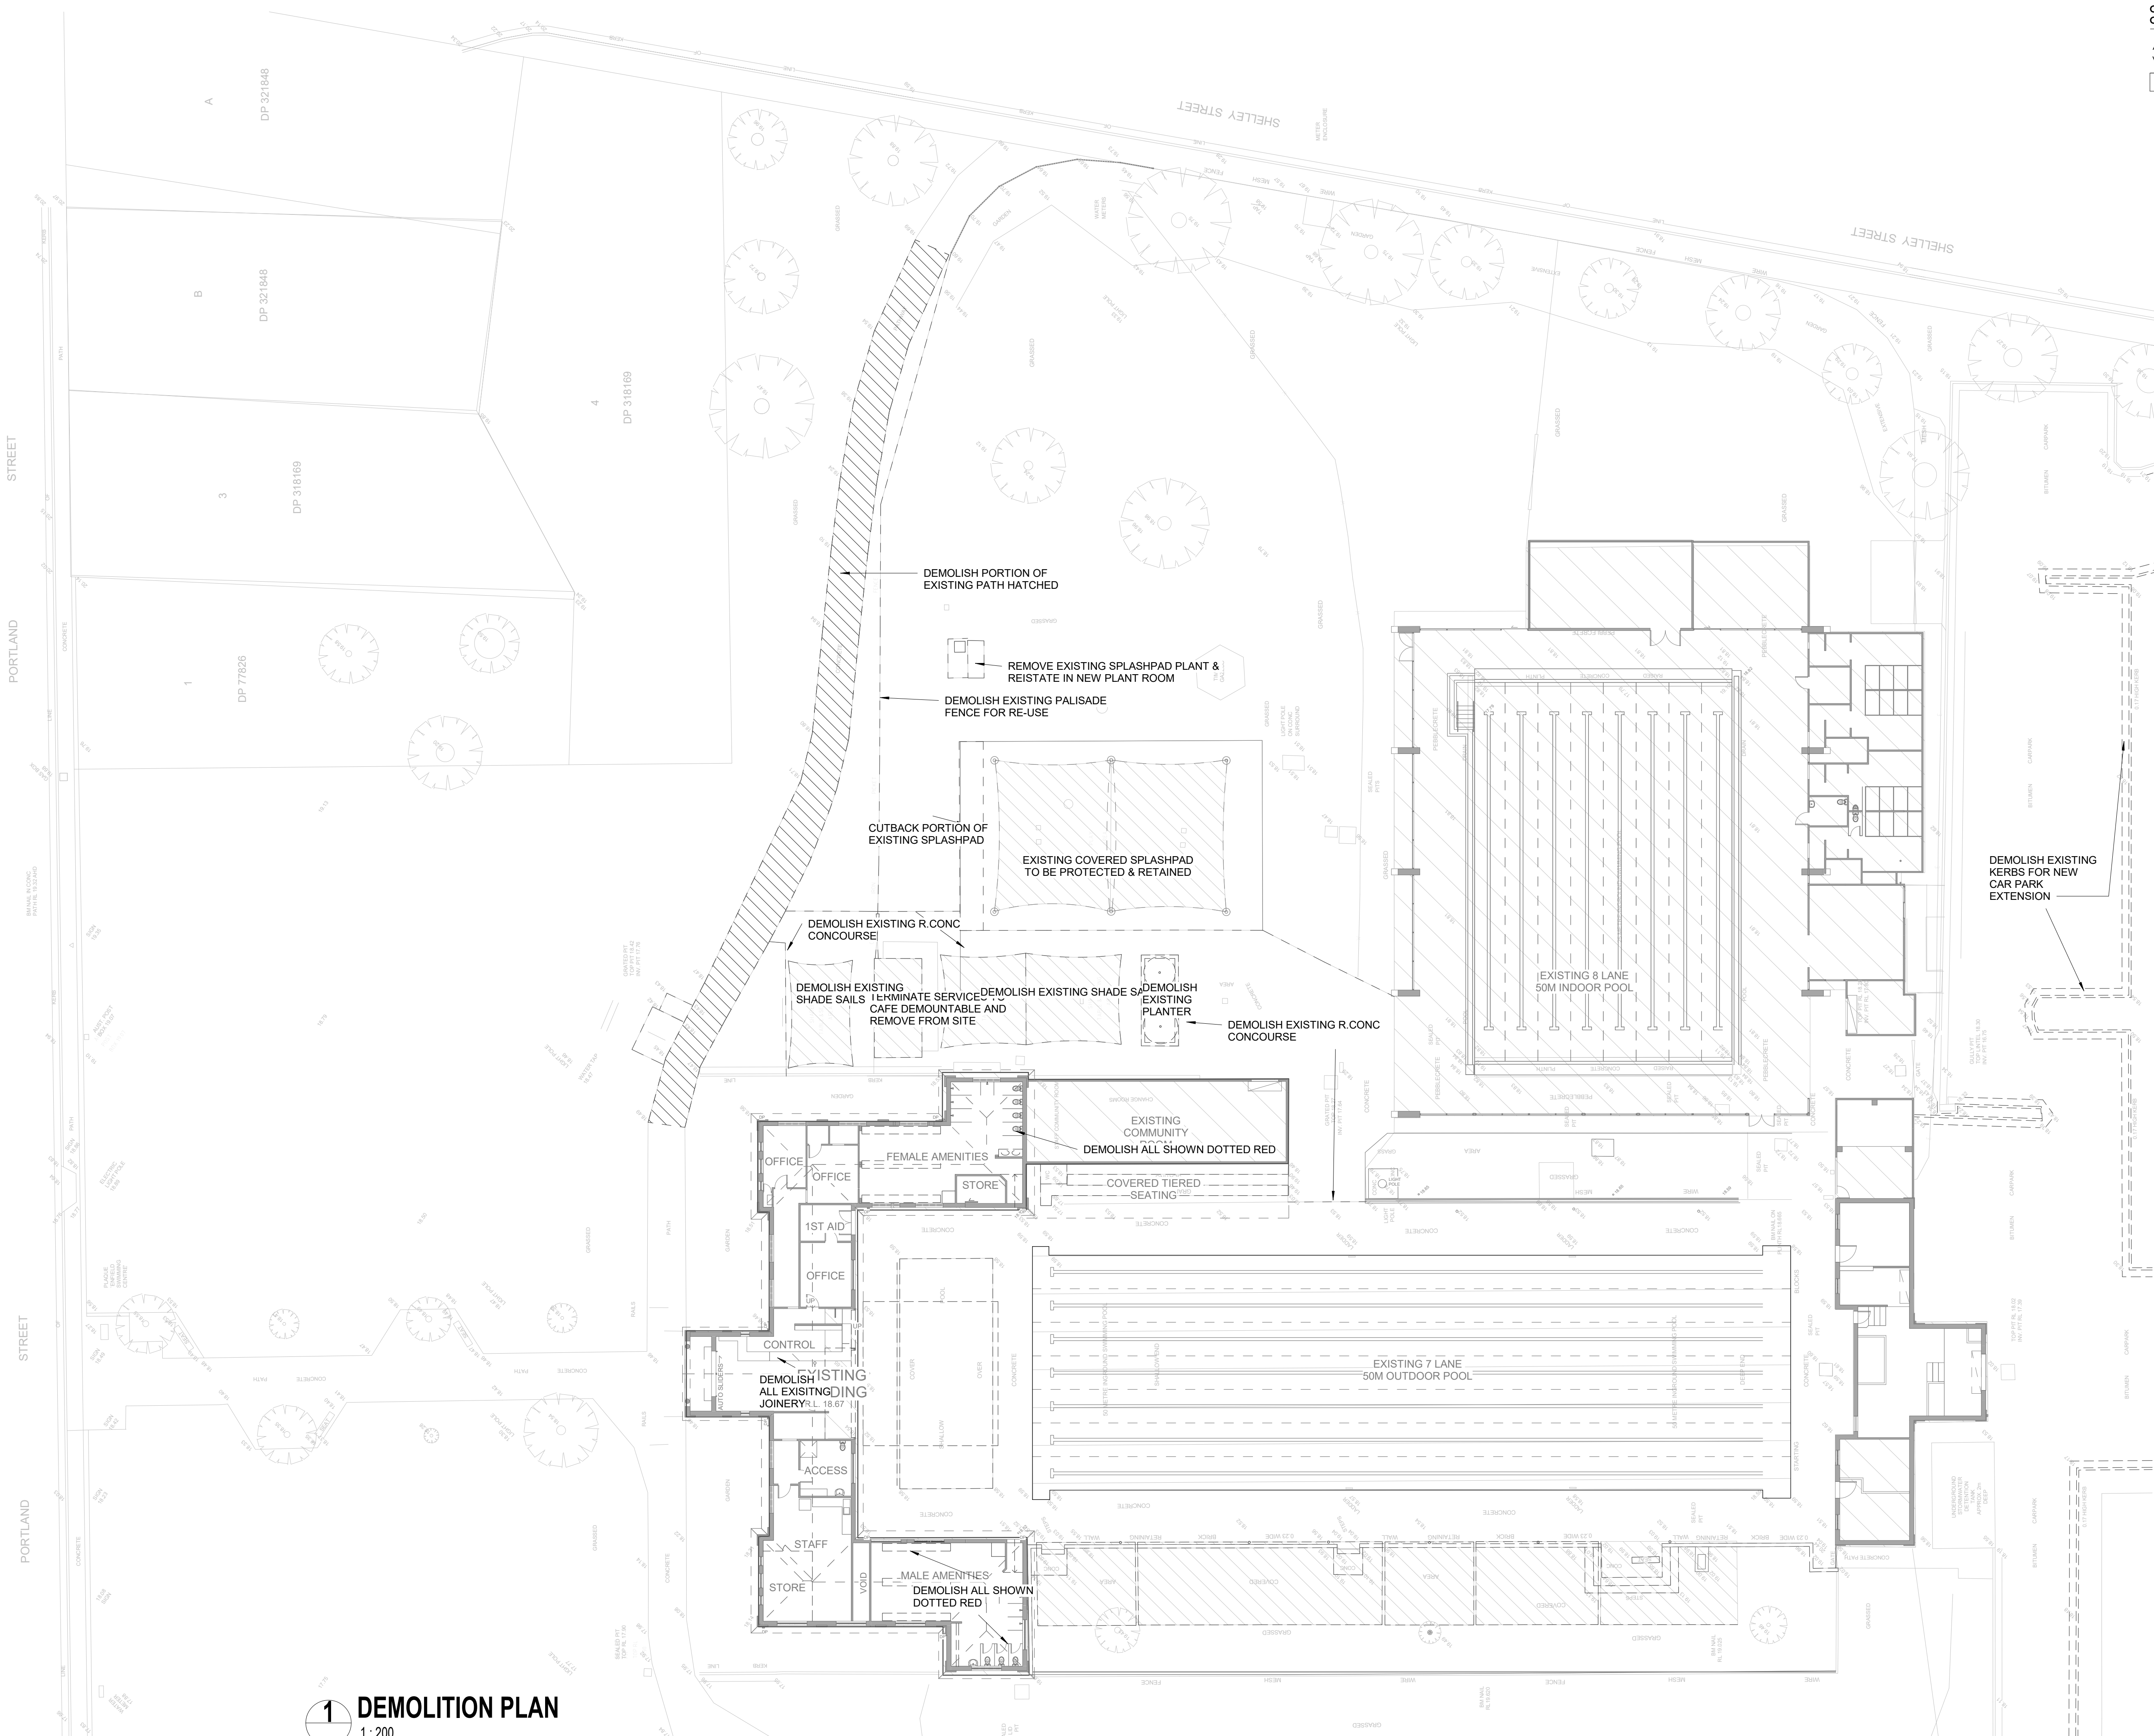

CONTRACTORS MUST VERIFY ALL DIMENSIONS ON SITE BEFORE COMMENCING ANY WORK OR PREPARING SHOP DRAWINGS

All Architectural drawing sheets to be cross-referenced with other relevant disciplines.

Rev	Description	Date
-----	-------------	------

CONSULTANT 5:
SMS
acn 80 158 133 110
po box 480
Morrison Point 1565
t: 0438 10022 f: 0438 2124
e: reception@smscorp.com.au

CONSULTANT 4:
M.J. HARVEY & ASSOCIATES PTY. LTD.
HYDRAULIC & FIRE PROTECTION ENGINEERS
UNIT 7, 11-13 POTTER CLOSE
WETHERILL PARK 2164
Phone (02) 9756 5579
Fax (02) 9756 5641
Email: Michael@mjharvey.com.au

CONSULTANT 3:
COLARCI
A division of Collingridge & Associates Architects
39 Terry Street ROYALE NSW 2039
ARCHITECTURE | APPLIED AQUATIC ENGINEERING
T: +61 2 9555 8108

CONSULTANT 2:
SPECTRUM
ENGINEERING SOLUTIONS
1 Davis Place
Glenhaven NSW 2156
Phone: (02) 8850 6802
Mobile: 0419 294 533
Email: info@spectrumengineering.com.au

CONSULTANT 1:
ECLIPSE Consulting Engineers Pty Ltd
304/12 Century Ctl - Norwest Central,
BAULKHAM HILLS NSW 2153
p: 02 9894 8500
m: 0419 64 8500 f: 02 8850 0212
e: info@eclipse-engineers.com.au

DESIGN ARCHITECT:
FACILITY DESIGN GROUP
Architecture & Construction
AQUATIC ■ SPORTS ■ LEISURE ■ CIVIC ■ PROJECT MANAGEMENT
NSW Reg. No. 7168
ABN: 75 583 999 424
e: info@fdg.com.au
w: www.fdg.com.au
p: 02 4446 0777
PO Box 82,
Cronulla NSW 2230

CLIENT:
Burwood
heritage • progress • pride


PROJECT NAME:
Enfield Aquatic Centre Masterplan
FOR DA
PROJECT ADDRESS:
Lot 7305 DP1146569
Portland Street,
Enfield NSW 2136

DRAWING TITLE: DEMOLITION PLAN		B1 PRINT SIZE	
SHEET ISSUE DATE: 07.08.2019		DRAWING NO. REV.	
REVISION DATE:			
SCALE: 1:200 @ A1		A.051	
JOB NO.: W221			
DRAWN BY: AT		CHECKED BY: S. JOHANSSON	
COPYRIGHT FACILITY DESIGN GROUP PTY. LIMITED. ALL RIGHTS RESERVED. DO NOT SCALE OFF DRAWINGS. WORK TO FIGURED DIMENSIONS ONLY. VERIFY DIMENSIONS ON SITE PRIOR TO COMMENCING WORK.			
NOMINATED ARCHITECT: STEPHEN JOHANSSON - NSW REG No. 7168			

24/08/2019 2:02:26 PM

All Architectural drawing sheets to be cross-referenced with other relevant disciplines.

Rev	Description	Date
-----	-------------	------

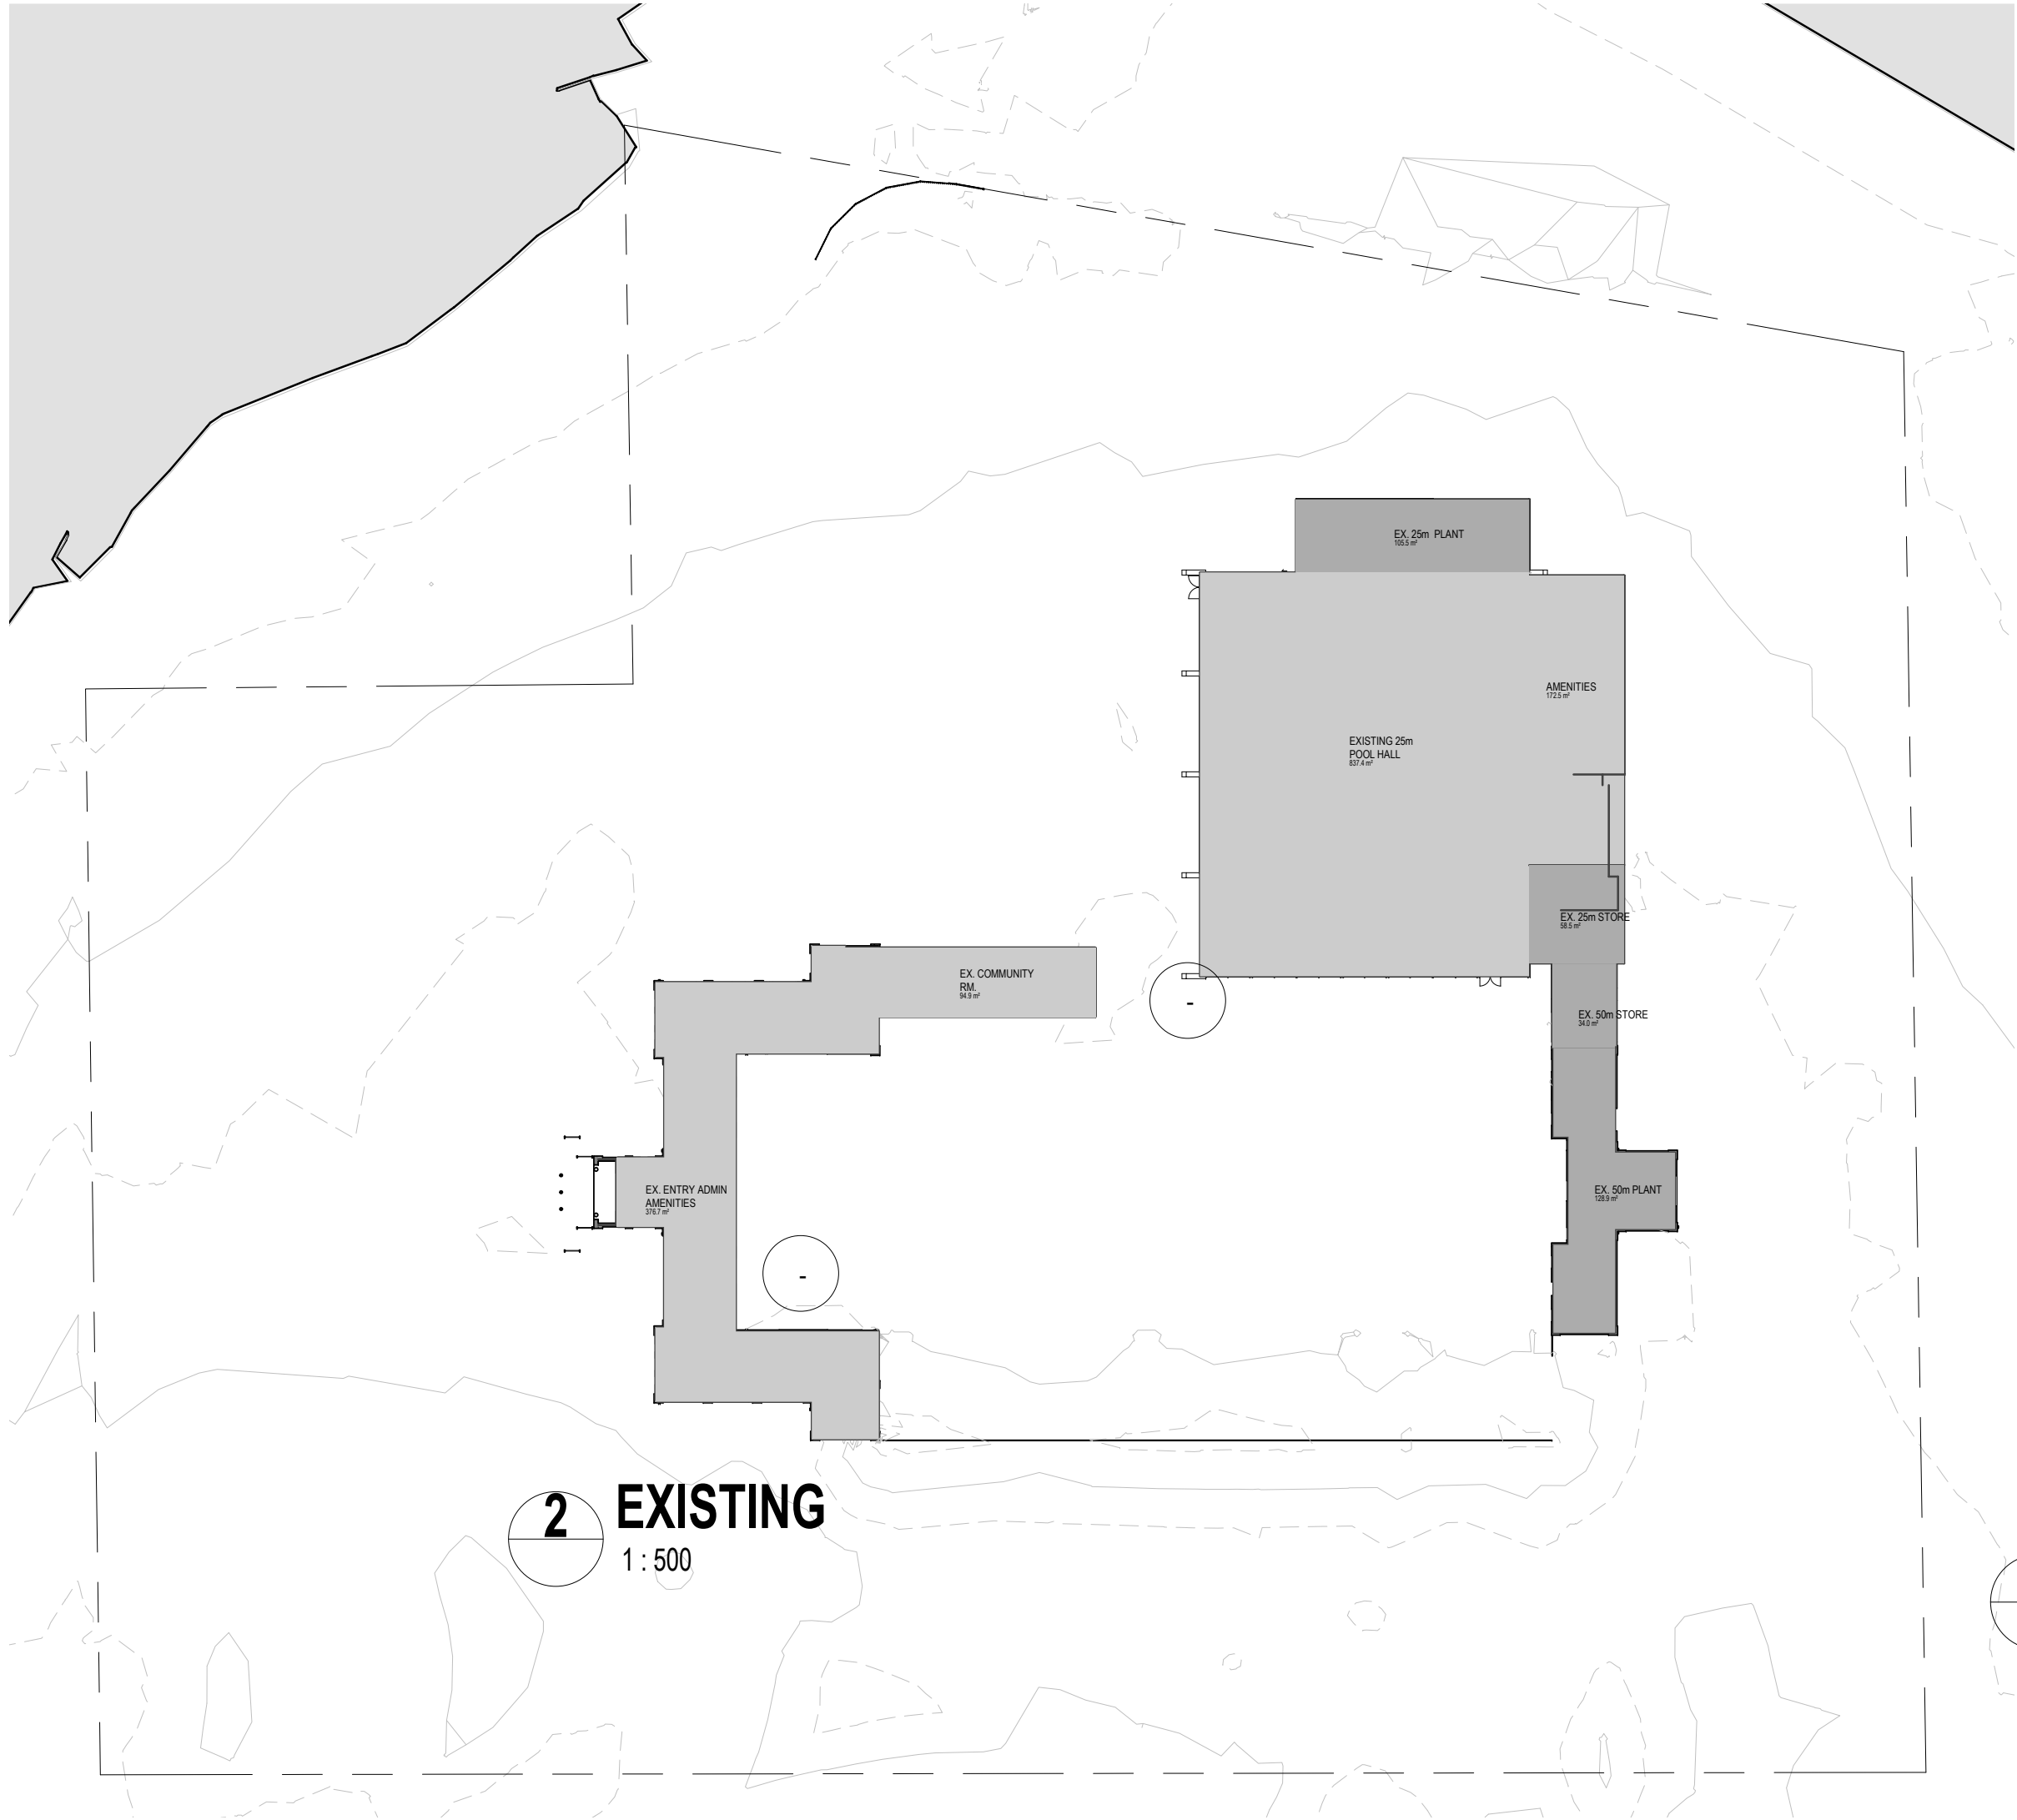


Area Schedule (Gross Building)		
Level	Name	Area


PROPOSED GROUND FLOOR PLAN		
PROPOSED GROUND FLOOR PLAN	CAFE	77 m ²
PROPOSED GROUND FLOOR PLAN	LTS PLANT	42 m ²
PROPOSED GROUND FLOOR PLAN	NEW COMMON, AMENITIES	249 m ²
PROPOSED GROUND FLOOR PLAN	NEW POOL HALL	509 m ²
PROPOSED GROUND FLOOR PLAN	NEW POOL HALL AMENITIES	35 m ²
PROPOSED GROUND FLOOR PLAN	VIEWING	160 m ²
PROPOSED GROUND FLOOR PLAN: 6		1073 m ²

EXISTING		
EXISTING	AMENITIES	173 m ²
EXISTING	EX. 25m PLANT	106 m ²
EXISTING	EX. 25m STORE	59 m ²
EXISTING	EX. 50m PLANT	129 m ²
EXISTING	EX. 50m STORE	34 m ²
EXISTING	EX. COMMUNITY RM.	95 m ²
EXISTING	EX. ENTRY ADMIN AMENITIES	377 m ²
EXISTING	EXISTING 25m POOL HALL	837 m ²
EXISTING: 8		1808 m ²

LEVEL 01		
LEVEL 01	MECH PLANT 1	21 m ²
LEVEL 01	NEW LIFT	7 m ²
LEVEL 01	NEW LOBBY	23 m ²
LEVEL 01	NEW STAFF TRAINING	162 m ²
LEVEL 01	NEW STAIR	10 m ²
LEVEL 01	NEW TERRACE	31 m ²
LEVEL 01: 6		252 m ²
Grand total: 20		3133 m ²

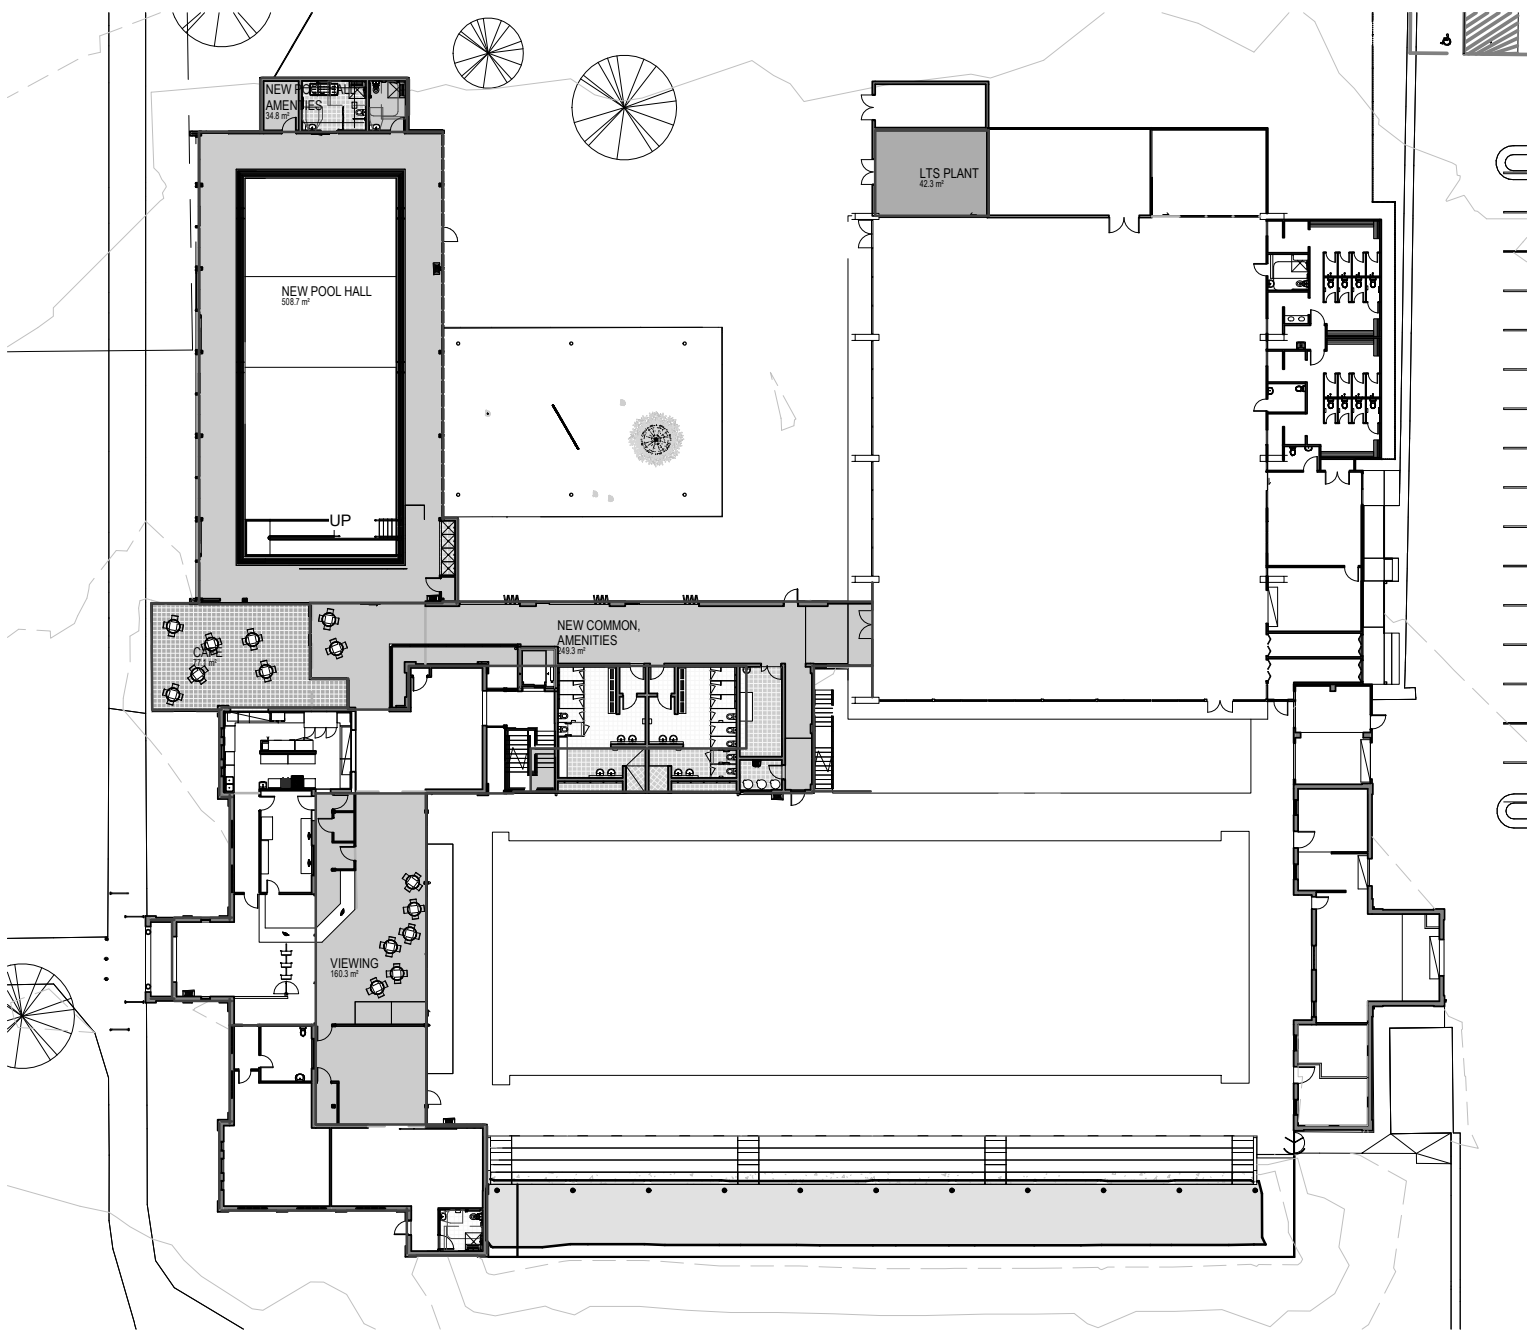


1 PROPOSED GROUND FLOOR
1:500

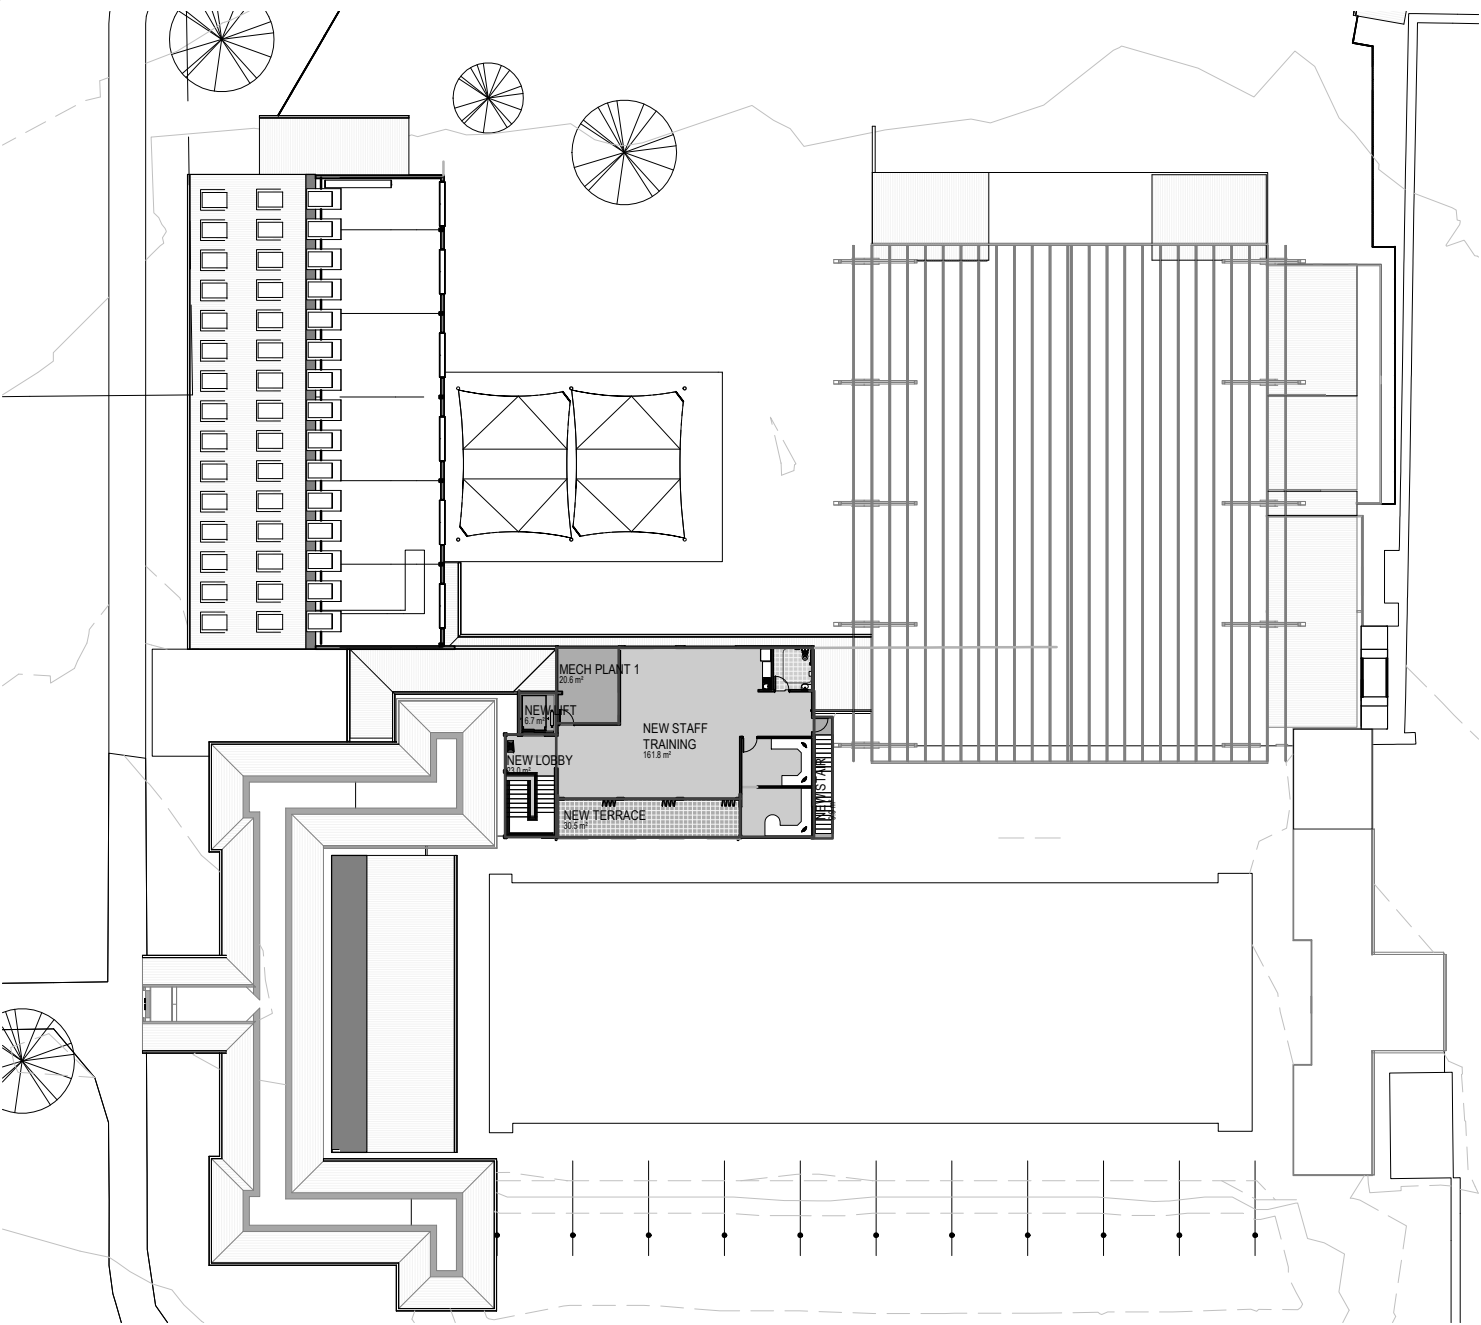

3 PROPOSED LEVEL 01
1:500

 CONSULTANT 5:
SMS
PO BOX 480
MILSONA POINT 1565
T: 9438 1022 F: 9438 2124
E: reception@smscorp.com.au



CONSULTANT 4:
M.J. HARVEY & ASSOCIATES PTY. LTD.
HYDRAULIC & FIRE PROTECTION ENGINEERS
UNIT 7, 11-13 POTTER CLOSE
WEHERILL PARK 2164
Phone (02) 9756 5579
Fax (02) 9756 5641
Email: Michael@mjharvey.com.au

CONSULTANT 3:
COLARCI
A division of Collingridge & Associates Architects
39 Terry Street ROYELLE NSW 2039
ARCHITECTURE | APPLIED AQUATIC ENGINEERING
T: +61 2 9555 8108

CONSULTANT 2:
SPECTRUM
ENGINEERING SOLUTIONS
1 Davis Place
Glenhaven NSW 2156
Phone: (02) 8850 6802
Mobile: 0419 294 533
Email: r.nash@spectrumeng.com.au

CONSULTANT 1:
ECLIPSE Consulting Engineers Pty Ltd
304/12 Century Cct - Norwest Central,
Baulkham Hills NSW 2153
p: 02 9894 8500
m: 0419 64 8500 f: 02 8850 0212
e: info@eclipse.com.au

DESIGN ARCHITECT:
FACILITY DESIGN GROUP
Architecture & Construction
AQUATIC ■ SPORTS ■ LEISURE ■ CIVIC ■ PROJECT MANAGEMENT
NSW Reg. No. 7168
ABN: 75 083 999 424
e: info@fdg.com.au
w: www.fdg.com.au
p: 02 4446 0777
a: PO Box 82,
Camden NSW 2540

CLIENT:
Burwood
heritage • progress • pride

PROJECT NAME:
Enfield Aquatic Centre Masterplan
FOR DA
PROJECT ADDRESS:
Lot 7305 DP1146569
Portland Street,
Enfield NSW 2136

DRAWING TITLE:
GFA - PLANS

SHEET ISSUE DATE: 07.08.2019
REVISION DATE:
SCALE: 1:500 @ A1
JOB NO.: W221
DRAWING NO. REV.
A.052

DRAWN BY: AT CHECKED BY: S. JOHANSSON

COPYRIGHT FACILITY DESIGN GROUP PTY. LIMITED. ALL RIGHTS RESERVED. DO NOT SCALE OFF DRAWINGS. WORK TO FIGURED DIMENSIONS ONLY. VERIFY DIMENSIONS ON SITE PRIOR TO COMMENCING WORK.

NOMINATED ARCHITECT: STEPHEN JOHANSSON - NSW REG No. 7168

24/08/2019 2:04:14 PM

Room Schedule			
Rm. No.	Name	Area	Volume

PROPOSED GROUND FLOOR PLAN

1	ENTRY FOYER	146 m ²	355.04 m ³
2	CONTROL	30 m ²	72.52 m ³
3	EX. STAFF CHANGE	12 m ²	29.99 m ³
4	STAFF ROOM	53 m ²	129.02 m ³
5	MULTI PURPOSE 1	43 m ²	104.73 m ³
6	MULTI-PURPOSE 2	57 m ²	139.99 m ³
7	ACCESS 1	8 m ²	18.45 m ³
8	STORE 1	4 m ²	9.53 m ³
9	ADMINISTRATION	23 m ²	55.01 m ³
10	CORRIDOR	11 m ²	26.43 m ³
11	KIOSK	42 m ²	102.74 m ³
12	DRY STORE	2 m ²	3.88 m ³
13	EDB 1	3 m ²	5.10 m ³
14	EXTERNAL CAFE SEATING	73 m ²	178.84 m ³
15	LOBBY 1	95 m ²	264.50 m ³
16	LOBBY 2	24 m ²	59.75 m ³
17	LIFT	6 m ²	13.92 m ³
18	ACCESS/VIEWING	117 m ²	303.09 m ³
19	MALE AMENITIES	42 m ²	101.84 m ³
20	OPEN SHOWERS 2	3 m ²	7.32 m ³
21	FEMALE AMENITIES	42 m ²	108.64 m ³
21	OPEN SHOWERS 1	3 m ²	8.13 m ³
22	CLEANER/HWS	5 m ²	13.29 m ³
23	FIRST AID + STAFF	16 m ²	40.19 m ³
24	EX. PLANT 1	118 m ²	286.79 m ³
25	EX. REAR ENTRANCE	32 m ²	77.67 m ³
27	EXISTING MULTI PURPOSE	39 m ²	90.15 m ³
30	EX. FAMILY CHANGE	5 m ²	10.95 m ³
34	EX. POOL BLANKET STORE ROOM	43 m ²	99.43 m ³
35	EX. PLANT 2	63 m ²	144.80 m ³
36	EXIST. 25m POOL HALL	834 m ²	1917.89 m ³
40	PROPOSED LEARN TO SWIM POOL	497 m ²	1192.05 m ³
41	ACCESS	8 m ²	18.92 m ³
42	ADULT CHANGE ROOM	14 m ²	33.61 m ³
43	LTS STORE	8 m ²	18.21 m ³
44	DECK SHOWERS 3	5 m ²	12.90 m ³
53	HEAT PUMP ENCLOSURE	21 m ²	48.19 m ³


EXISTING

26	EX. STORE 2	26 m ²	62.68 m ³
28	EX. WC	4 m ²	10.54 m ³
29	EX. FEMALE AMENITIES 2	47 m ²	113.32 m ³
31	EX. CLEANER	5 m ²	12.15 m ³
32	EX. MALE AMENITIES 2	47 m ²	111.87 m ³
33	EX. ACCESS 4	6 m ²	15.40 m ³
37	NEW LTS PLANT	42 m ²	102.06 m ³
38	NEW ENTRY	12 m ²	28.07 m ³
39	NEW EXIT	10 m ²	23.31 m ³

LEVEL 01

45	LOBBY 2	22 m ²	60.56 m ³
46	LIFT	6 m ²	13.99 m ³
47	MECH PLANT 1	20 m ²	53.59 m ³
48	STAFF TRAINING ROOM	118 m ²	318.80 m ³
49	TERRACE	30 m ²	57.87 m ³
50	OFFICE	15 m ²	39.48 m ³
51	MANAGER	15 m ²	32.46 m ³
52	ACCESS 3	7 m ²	19.08 m ³

1 PROPOSED BUILDING - ROOMS
1:250

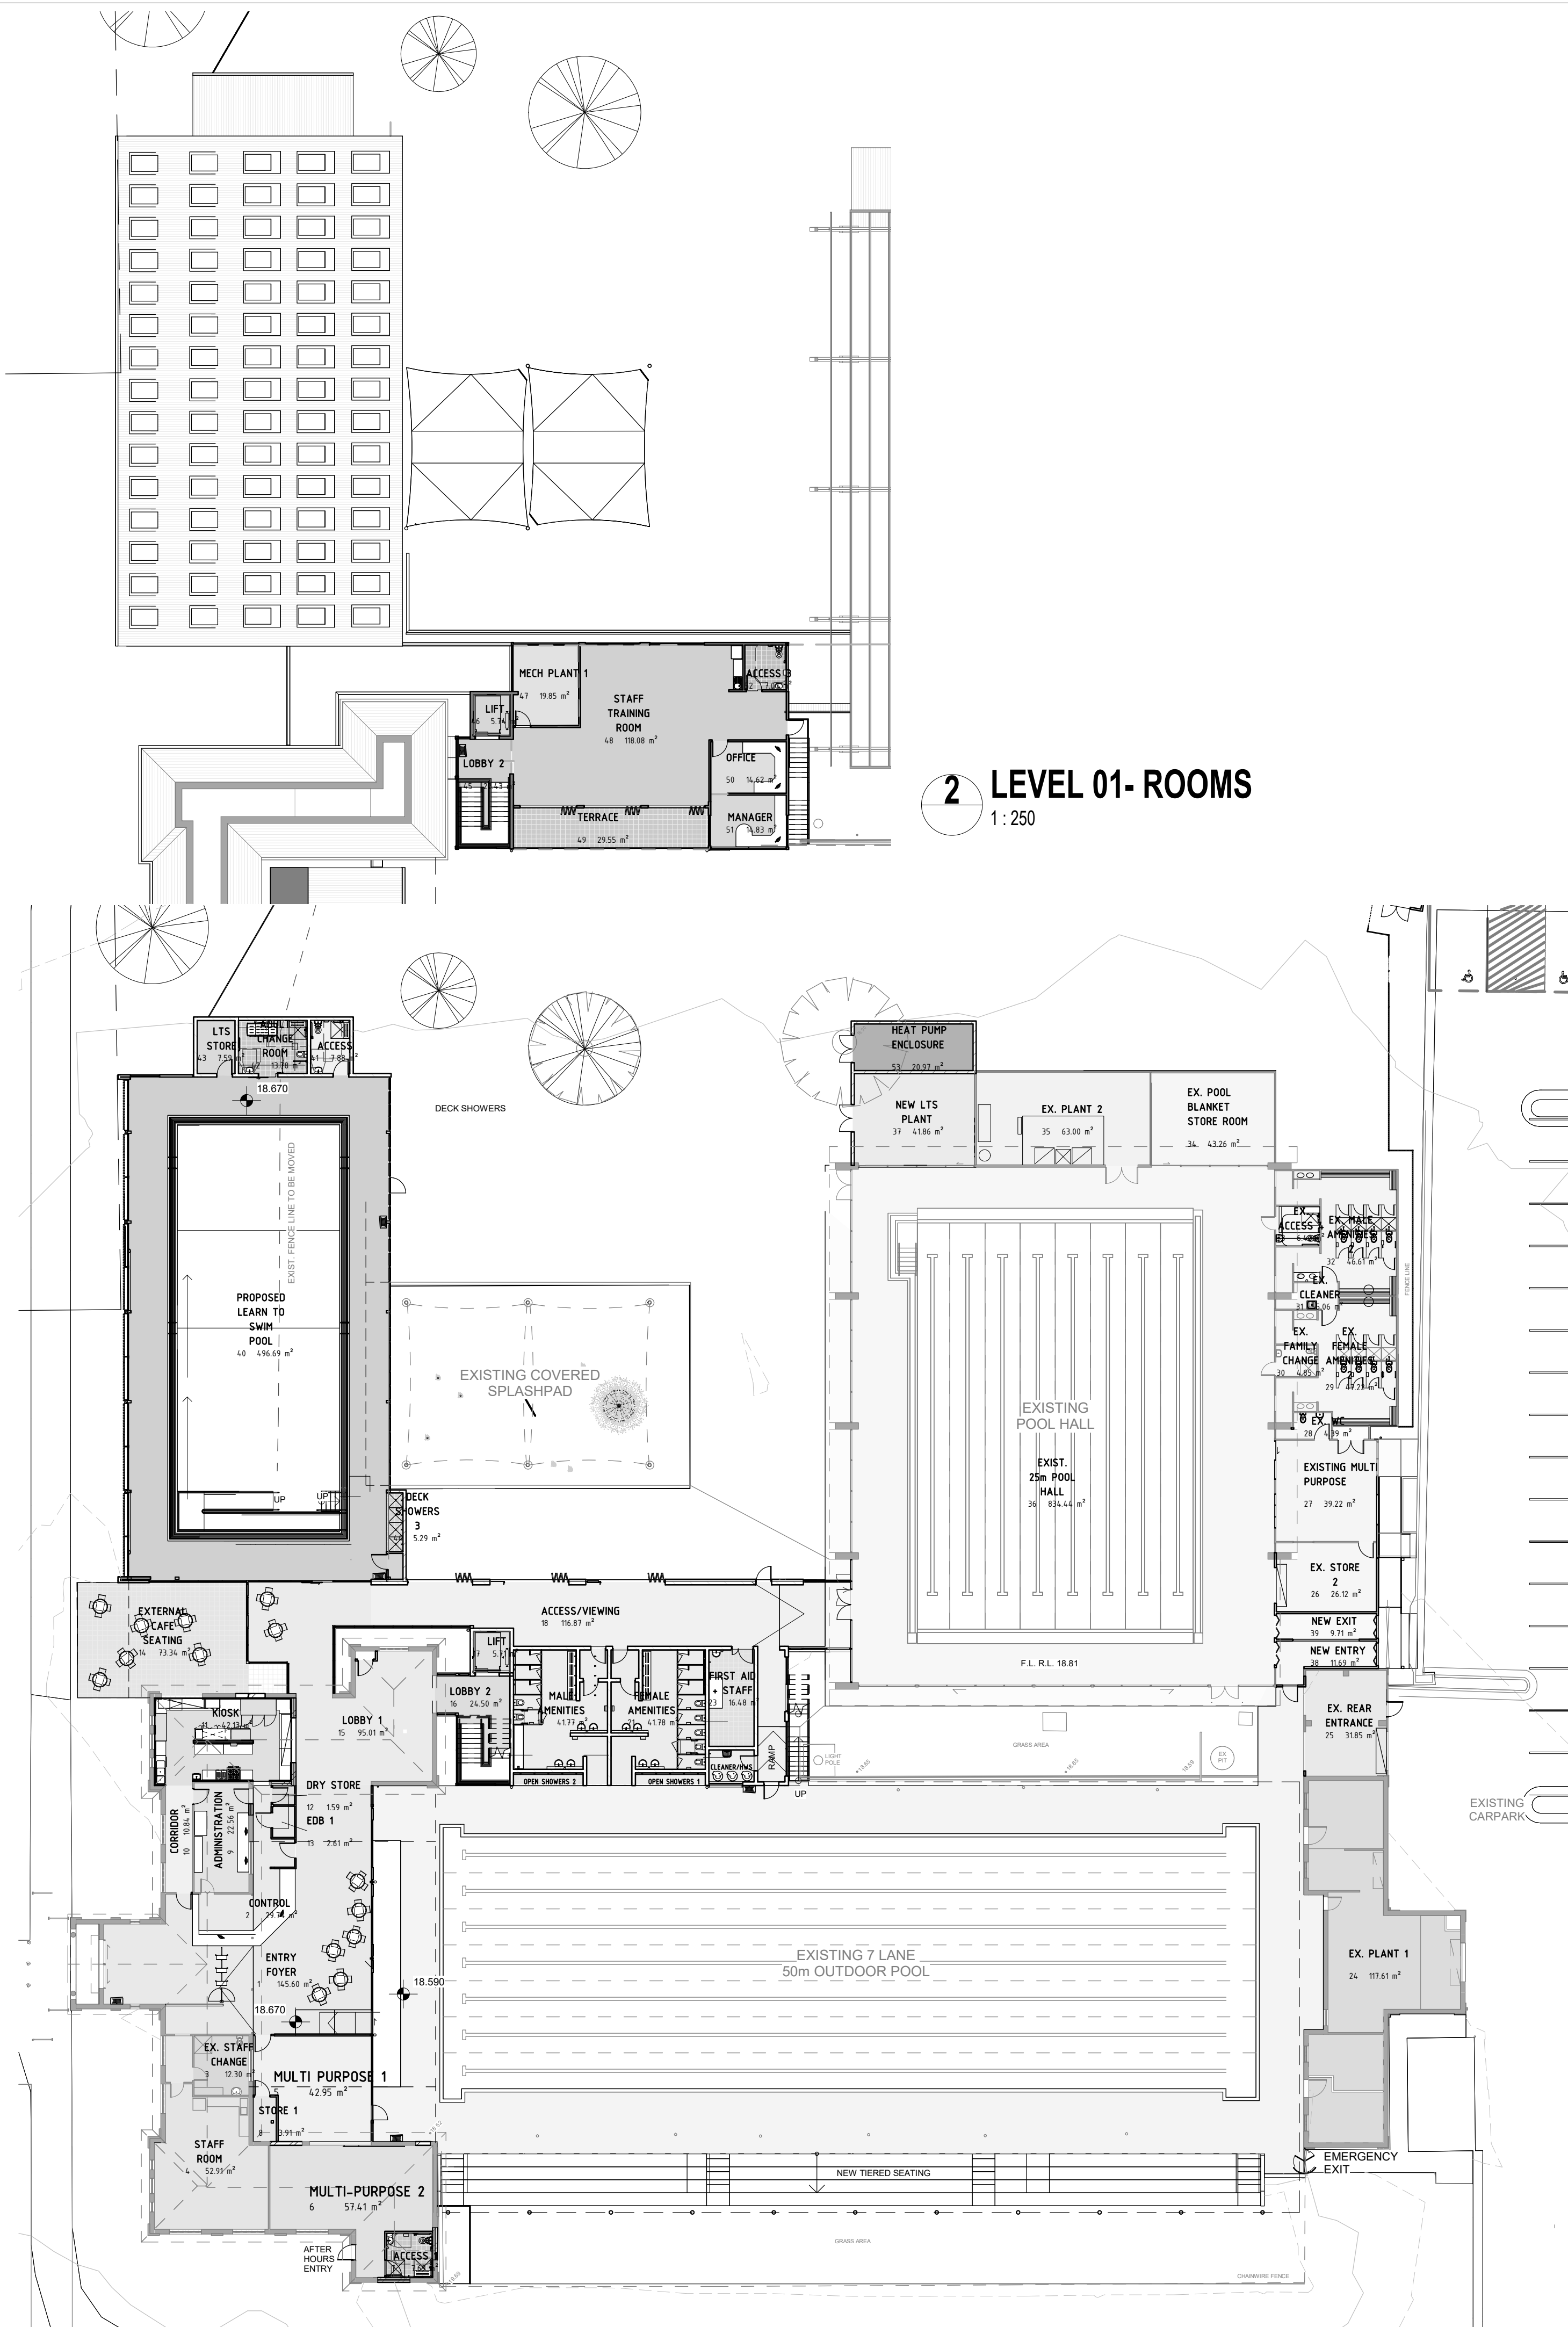


CONTRACTORS MUST VERIFY ALL DIMENSIONS ON SITE BEFORE COMMENCING ANY WORK OR PREPARING SHOP DRAWINGS

All Architectural drawing sheets to be cross-referenced with other relevant disciplines.

Rev	Description	Date
-----	-------------	------

CONSULTANT 5:

 30/04/12 Century Ccl., Norwest Central,
Baulkham Hills NSW 2153
p: 02 9894 8500 f: 02 8850 0212
e: info@fdg.com.au



CONSULTANT 4:

M.J. HARVEY & ASSOCIATES PTY. LTD.
HYDRAULIC & FIRE PROTECTION ENGINEERS
UNIT 7, 11-13 POTTER CLOSE
WETHERILL PARK 2164
Phone: (02) 9756 5579
Fax: (02) 9756 5641
Email: Michael@mhharvey.com.au

CONSULTANT 3:

COLARCI
A division of Collingridge &
Associates Architects
39 Terry Street ROYELLE NSW 2039
T: +61 2 9555 8108

CONSULTANT 2:

SPECTRUM
ENGINEERING SOLUTIONS
1 Davis Place
Glenhaven NSW 2156
Phone: (02) 8850 6802
Mobile: 0419 294 533
Email: r.nash@spectrumengineering.com.au

CONSULTANT 1:

ECLIPSE Consulting Engineers Pty Ltd
304/12 Century Ccl., Norwest Central,
Baulkham Hills NSW 2153
p: 02 9894 8500 f: 02 8850 0212
e: info@eclipse-engineers.com.au

DESIGN ARCHITECT:

FACILITY DESIGN GROUP
Architecture & Construction
NSW Reg. No. 7168
ABN: 75 083 999 424
e: info@fdg.com.au
w: www.fdg.com.au
p: 02 4446 0777
c: PO Box 62,
Camden NSW 2540

AQUATIC ■ SPORTS ■ LEISURE ■ CIVIC ■ PROJECT MANAGEMENT

CLIENT:



PROJECT NAME:

Enfield Aquatic Centre
Masterplan

FOR DA

PROJECT ADDRESS:
Lot 7305 DP1146569
Portland Street,
Enfield NSW 2136

DRAWING TITLE:

ROOM SCHEDULE

B1 PRINT SIZE

SHEET ISSUE DATE: 07.08.2019 DRAWING NO. REV.

REVISION DATE:

SCALE: 1:250 @ A1 A.053



JOB NO.: W221

DRAWN BY: Author CHECKED BY: S. JOHANSSON

COPYRIGHT FACILITY DESIGN GROUP PTY. LIMITED. ALL RIGHTS RESERVED. DO NOT SCALE OFF DRAWINGS. WORK TO FIGURED DIMENSIONS ONLY. VERIFY DIMENSIONS ON SITE PRIOR TO COMMENCING WORK.

NOMINATED ARCHITECT: STEPHEN JOHANSSON - NSW REG No. 7168

24/08/2019 2:07:12 PM

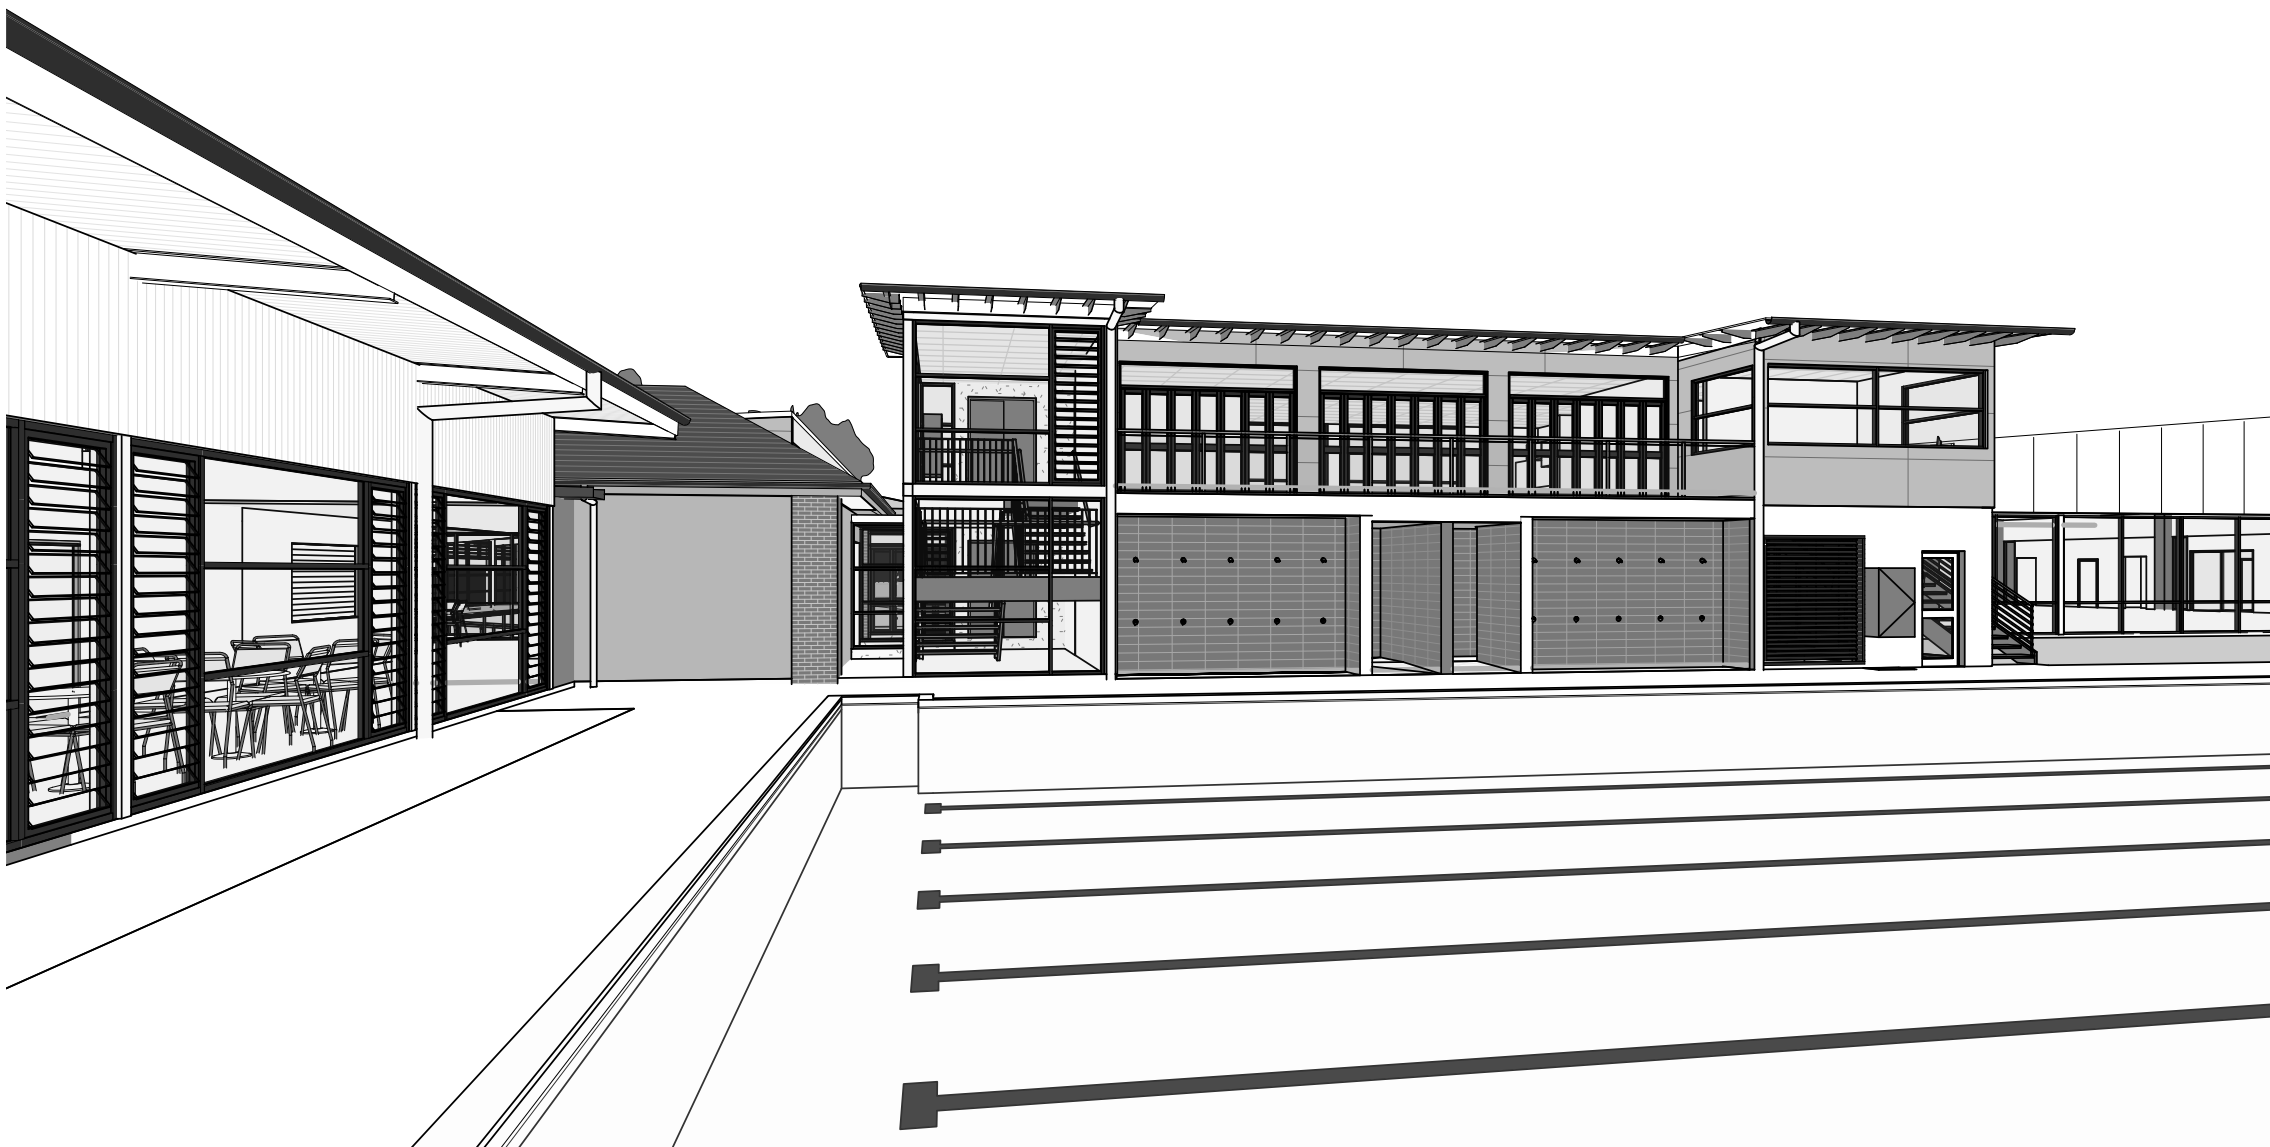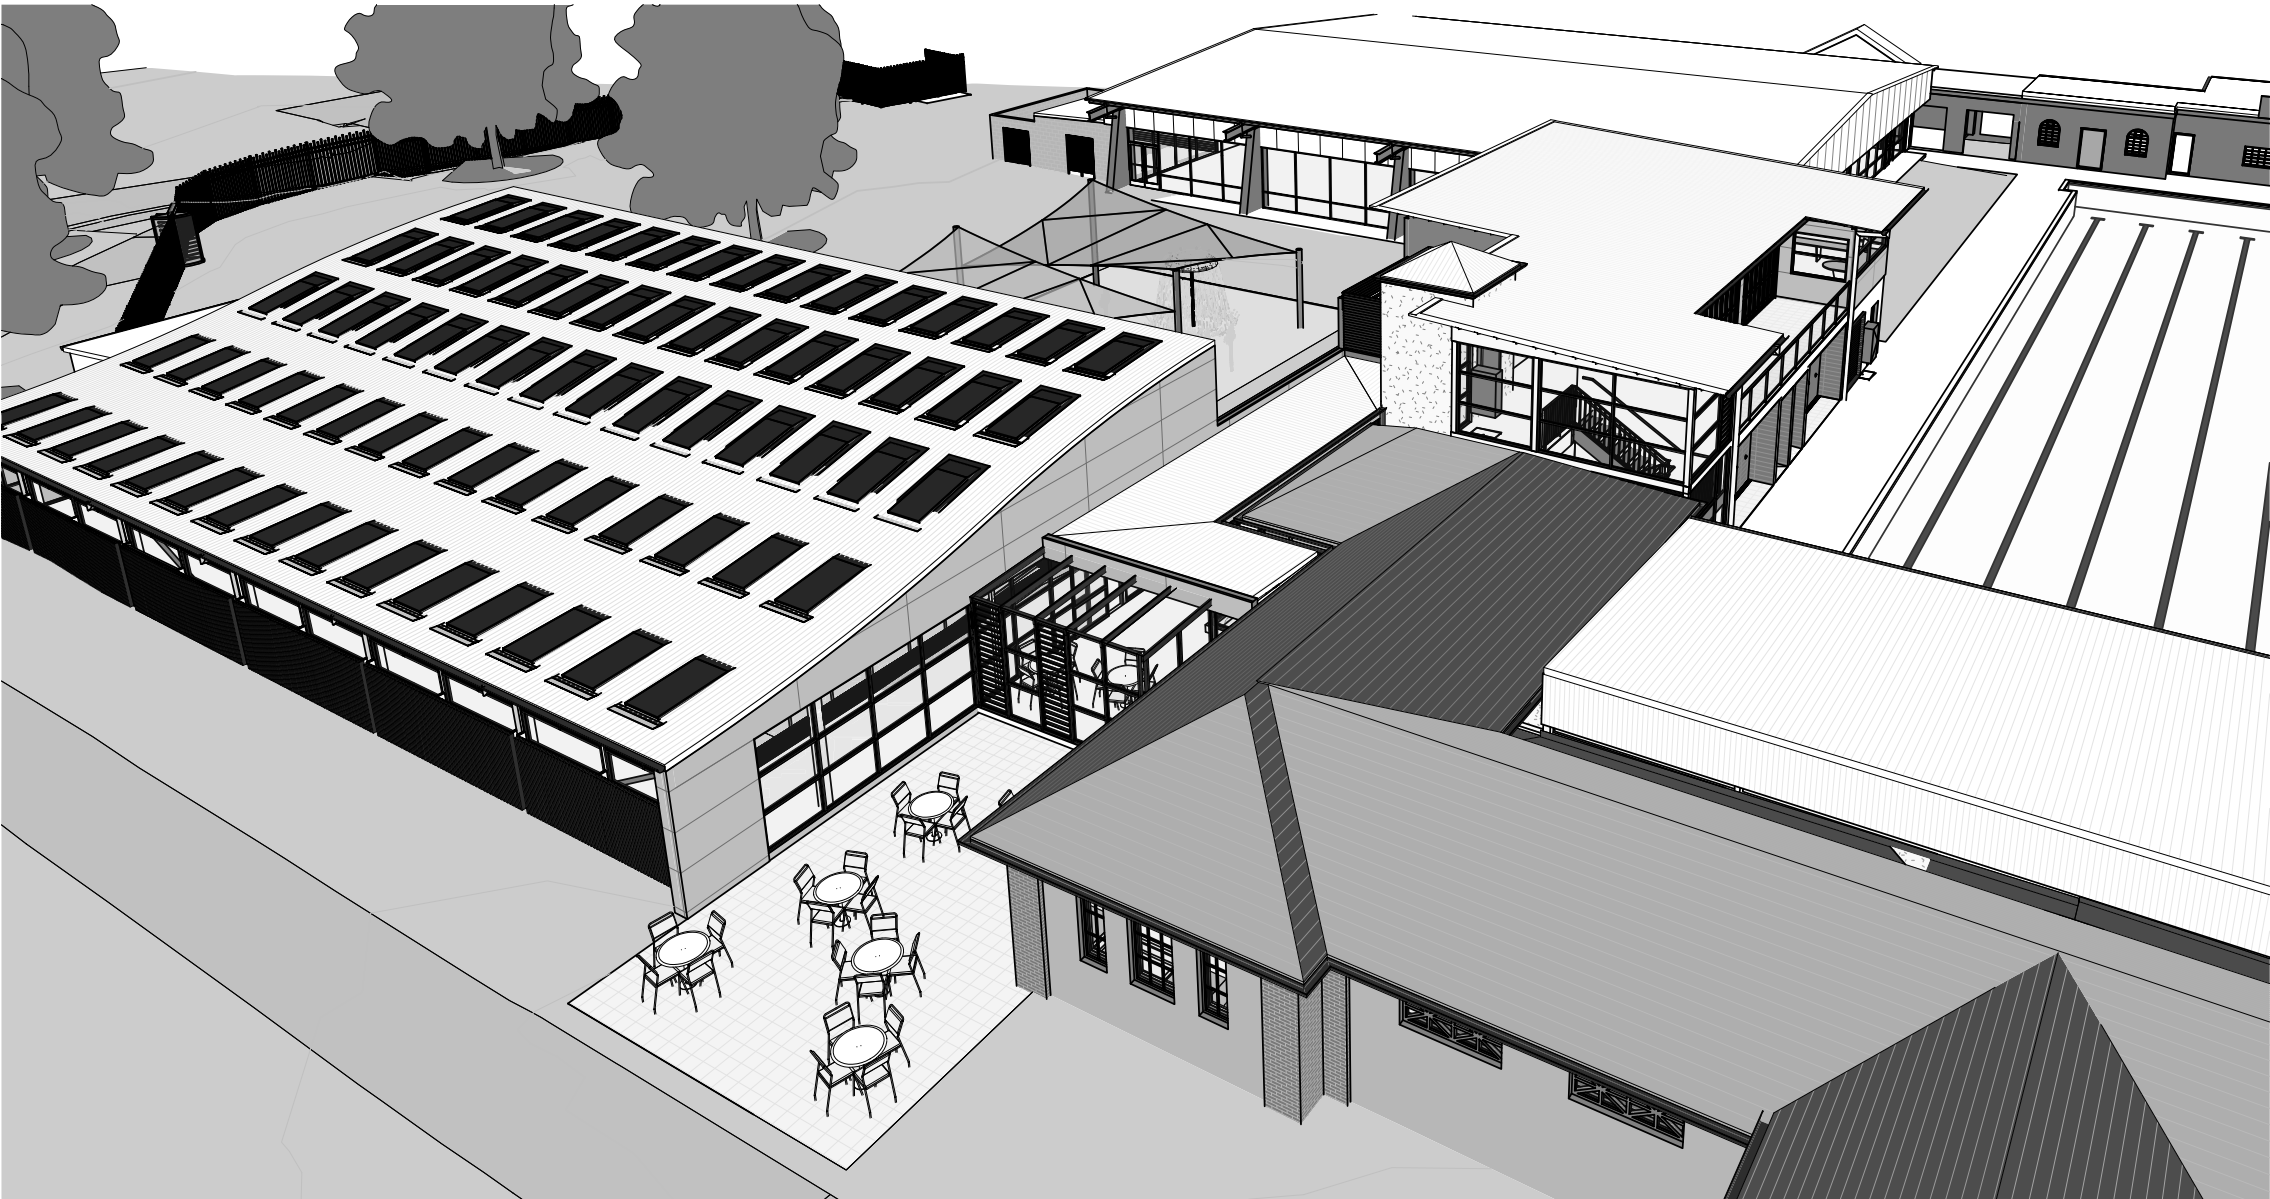


CONTRACTORS MUST VERIFY ALL DIMENSIONS ON SITE BEFORE COMMENCING ANY WORK OR PREPARING SHOP DRAWINGS

All Architectural drawing sheets to be cross-referenced with other relevant disciplines.

Rev	Description	Date
-----	-------------	------

 CONSULTANT 3:
SMS
acn 80 158 133 110
po box 480
Milsom Point 1565
t 9438 1022 f 9438 2124
e reception@smscorp.com.au



CONSULTANT 4:
M.J. HARVEY & ASSOCIATES PTY. LTD.
HYDRAULIC & FIRE PROTECTION ENGINEERS
UNIT 7, 11-13 POTTER CLOSE
WETHERILL PARK 2164
Phone (02) 9756 5579
Fax (02) 9756 5641
Email: Michael@mhharvey.com.au

CONSULTANT 3:
COLARCI
A division of Collingridge & Associates Architects
39 Terry Street ROYELLE NSW 2039
ARCHITECTURE | APPLIED AQUATIC ENGINEERING
T: +61 2 9555 8108

CONSULTANT 2:
SPECTRUM
ENGINEERING SOLUTIONS
1 Davis Place
Glenhaven NSW 2156
Phone: (02) 8850 6802
Mobile: 0419 294 533
Email: r.nah@specengsolutions.com.au

CONSULTANT 1:
ECLIPSE Consulting Engineers Pty Ltd
304/12 Century Cct - Norwest Central,
BAULKHAM HILLS NSW 2153
p: 02 9894 8500
m: 0419 64 8500 f: 02 8850 0212
e: info@eclipse.com.au
ECLIPSE CONSULTING ENGINEERS

DESIGN ARCHITECT:
FACILITY DESIGN GROUP
Architecture & Construction
AQUATIC ■ SPORTS ■ LEISURE ■ CIVIC ■ PROJECT MANAGEMENT
NSW Reg. No. 7168
ABN: 75 083 999 624
e: info@fdg.com.au
w: www.fdg.com.au
p: 02 4446 0777
a: PO Box 62,
Cronulla NSW 2240

CLIENT:
Owner
Burwood
heritage • progress • pride

PROJECT NAME:
Enfield Aquatic Centre Masterplan
FOR DA
PROJECT ADDRESS:
Lot 7305 DP1146569
Portland Street,
Enfield NSW 2136

DRAWING TITLE:		
PERSPECTIVES		
B1 PRINT SIZE		
SHEET ISSUE DATE: 17.07.2019	DRAWING NO.	REV.
REVISION DATE:		
SCALE: @ A1	A.056	
JOB NO.: W221		
DRAWN BY: Author CHECKED BY: S. JOHANSSON		

COPYRIGHT FACILITY DESIGN GROUP PTY. LIMITED. ALL RIGHTS RESERVED. DO NOT SCALE OFF DRAWINGS. WORK TO FIGURED DIMENSIONS ONLY. VERIFY DIMENSIONS ON SITE PRIOR TO COMMENCING WORK.

NOMINATED ARCHITECT: STEPHEN JOHANSSON - NSW REG No. 7168
24/08/2019 2:15:09 PM


PORTLAND STREET

SHELLEY STREET

CONTRACTORS MUST VERIFY ALL DIMENSIONS ON SITE BEFORE COMMENCING ANY WORK OR PREPARING SHOP DRAWINGS

All Architectural drawing sheets to be cross-referenced with other relevant disciplines.

Rev	Description	Date
-----	-------------	------

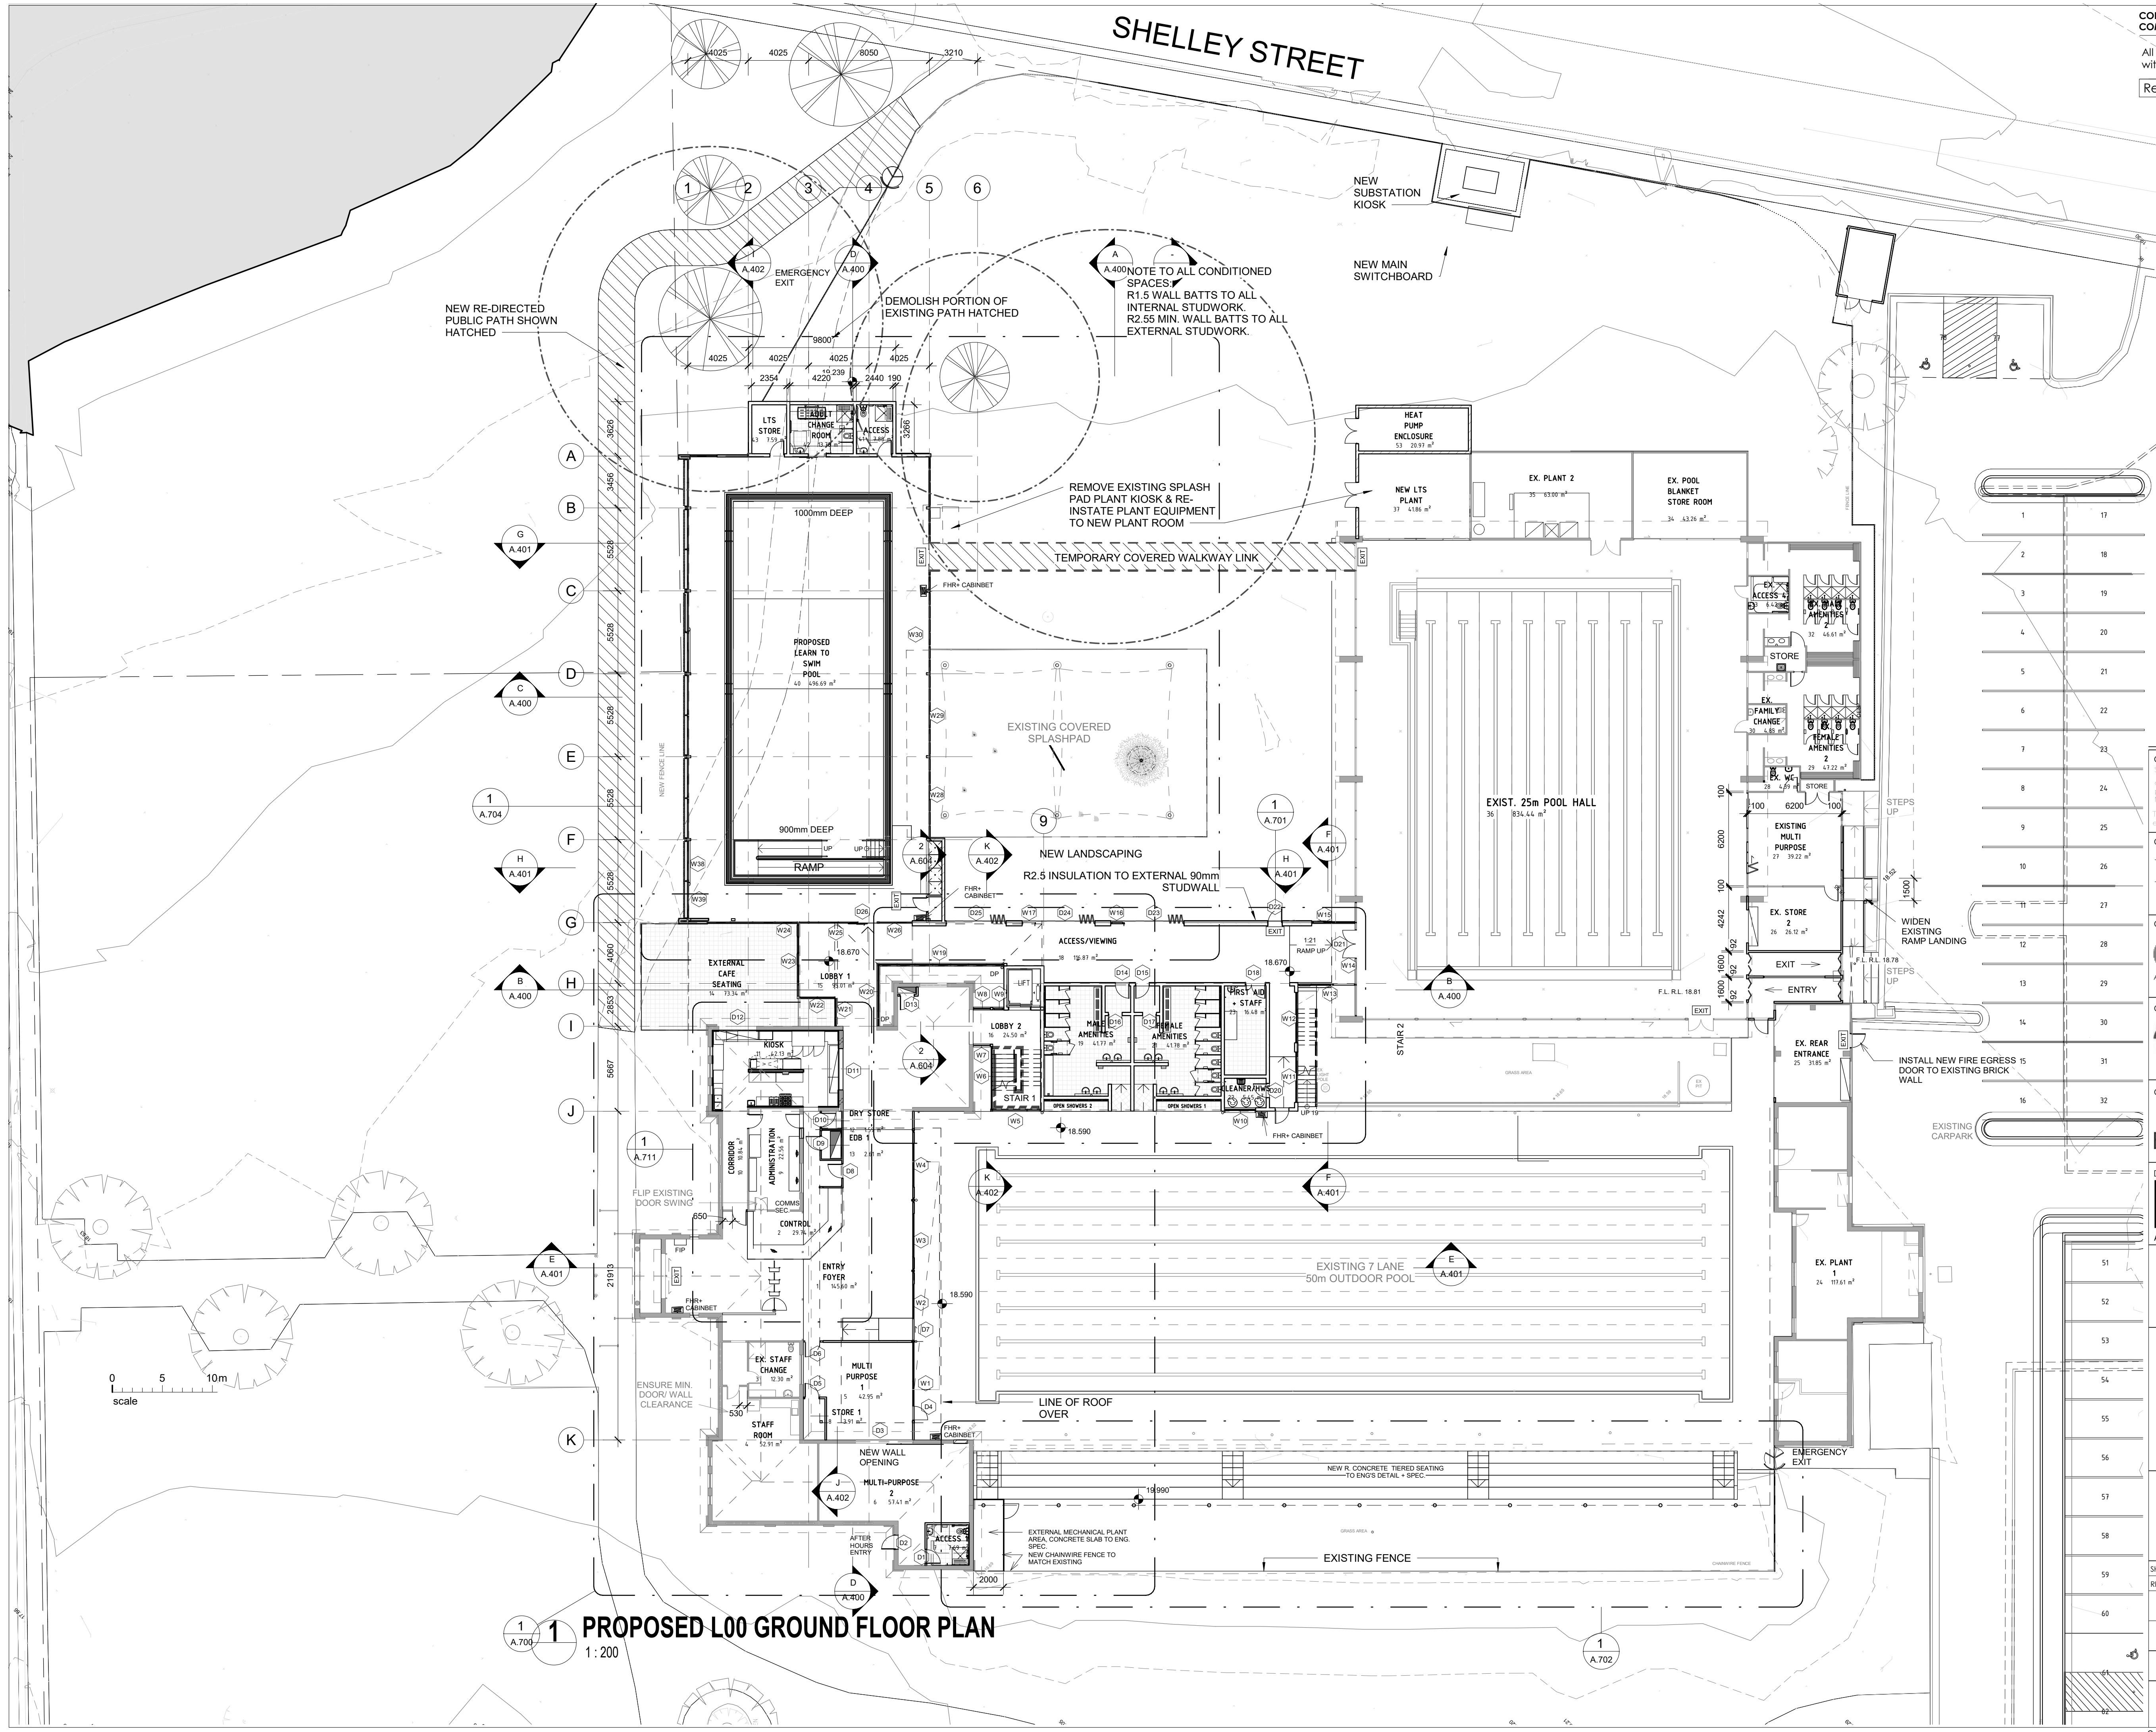

CONSULTANT 5:
SPECTRUM
Engineering Solutions
1 Davis Place
Glenhaven NSW 2156
Phone: (02) 8850 6802
Mobile: 0419 294 533
Email: info@spectrum-solutions.com.au

CONSULTANT 4:
M.J. HARVEY & ASSOCIATES PTY. LTD.
HYDRAULIC & FIRE PROTECTION ENGINEERS
UNIT 7, 11-13 POTTER CLOSE
WETHERILL PARK 2164
Phone: (02) 9756 5579
Fax: (02) 9756 5641
Email: Michael@mhjharvey.com.au

CONSULTANT 3:
COLARCI
A division of Collingridge & Associates Architects
39 Terry Street ROYELLE NSW 2039
ARCHITECTURE | APPLIED AQUATIC ENGINEERING
T: +61 2 9555 8108

CONSULTANT 2:
SPECTRUM
ENGINEERING SOLUTIONS
1 Davis Place
Glenhaven NSW 2156
Phone: (02) 8850 6802
Mobile: 0419 294 533
Email: info@spectrum-solutions.com.au

CONSULTANT 1:
ECLIPSE Consulting Engineers Pty Ltd
304/12 Century Cct. Norwest Central,
BAULKHAM HILLS NSW 2153
p: 02 9894 8500
m: 0419 64 8500 f: 02 8850 0212
e: info@eclipse-con.au or info@eclipse.com.au

DESIGN ARCHITECT:
FACILITY DESIGN GROUP
Architecture & Construction
AQUATIC ■ SPORTS ■ LEISURE ■ CIVIC ■ PROJECT MANAGEMENT
NSW Reg. No. 7168
ABN: 75 583 999 424
e: info@fdg.com.au
w: www.fdg.com.au
p: 02 4446 0777
PO Box 82,
Camden NSW 2540

CLIENT:
Burwood
heritage • progress • pride

PROJECT NAME:
Enfield Aquatic Centre
Masterplan
FOR DA
PROJECT ADDRESS:
Lot 7305 DP1146569
Portland Street,
Enfield NSW 2136

DRAWING TITLE:
PROPOSED GROUND FLOOR
PLAN
B1 PRINT SIZE

SHEET ISSUE DATE: 07.08.2019	DRAWING NO. REV.
REVISION DATE:	
SCALE: 1:200 @ A1	A.100
JOB NO.: W221	
DRAWN BY: AT	CHECKED BY: S. JOHANSSON

COPYRIGHT FACILITY DESIGN GROUP PTY. LIMITED. ALL RIGHTS RESERVED. DO NOT SCALE OFF DRAWINGS. WORK TO FIGURED DIMENSIONS ONLY. VERIFY DIMENSIONS ON SITE PRIOR TO COMMENCING WORK.
NOMINATED ARCHITECT: STEPHEN JOHANSSON - NSW REG NO. 7168
24/08/2019 2:15:24 PM


PORTLAND STREET

SHELLEY STREET


CONTRACTORS MUST VERIFY ALL DIMENSIONS ON SITE BEFORE COMMENCING ANY WORK OR PREPARING SHOP DRAWINGS

All Architectural drawing sheets to be cross-referenced with other relevant disciplines.

Rev	Description	Date
-----	-------------	------

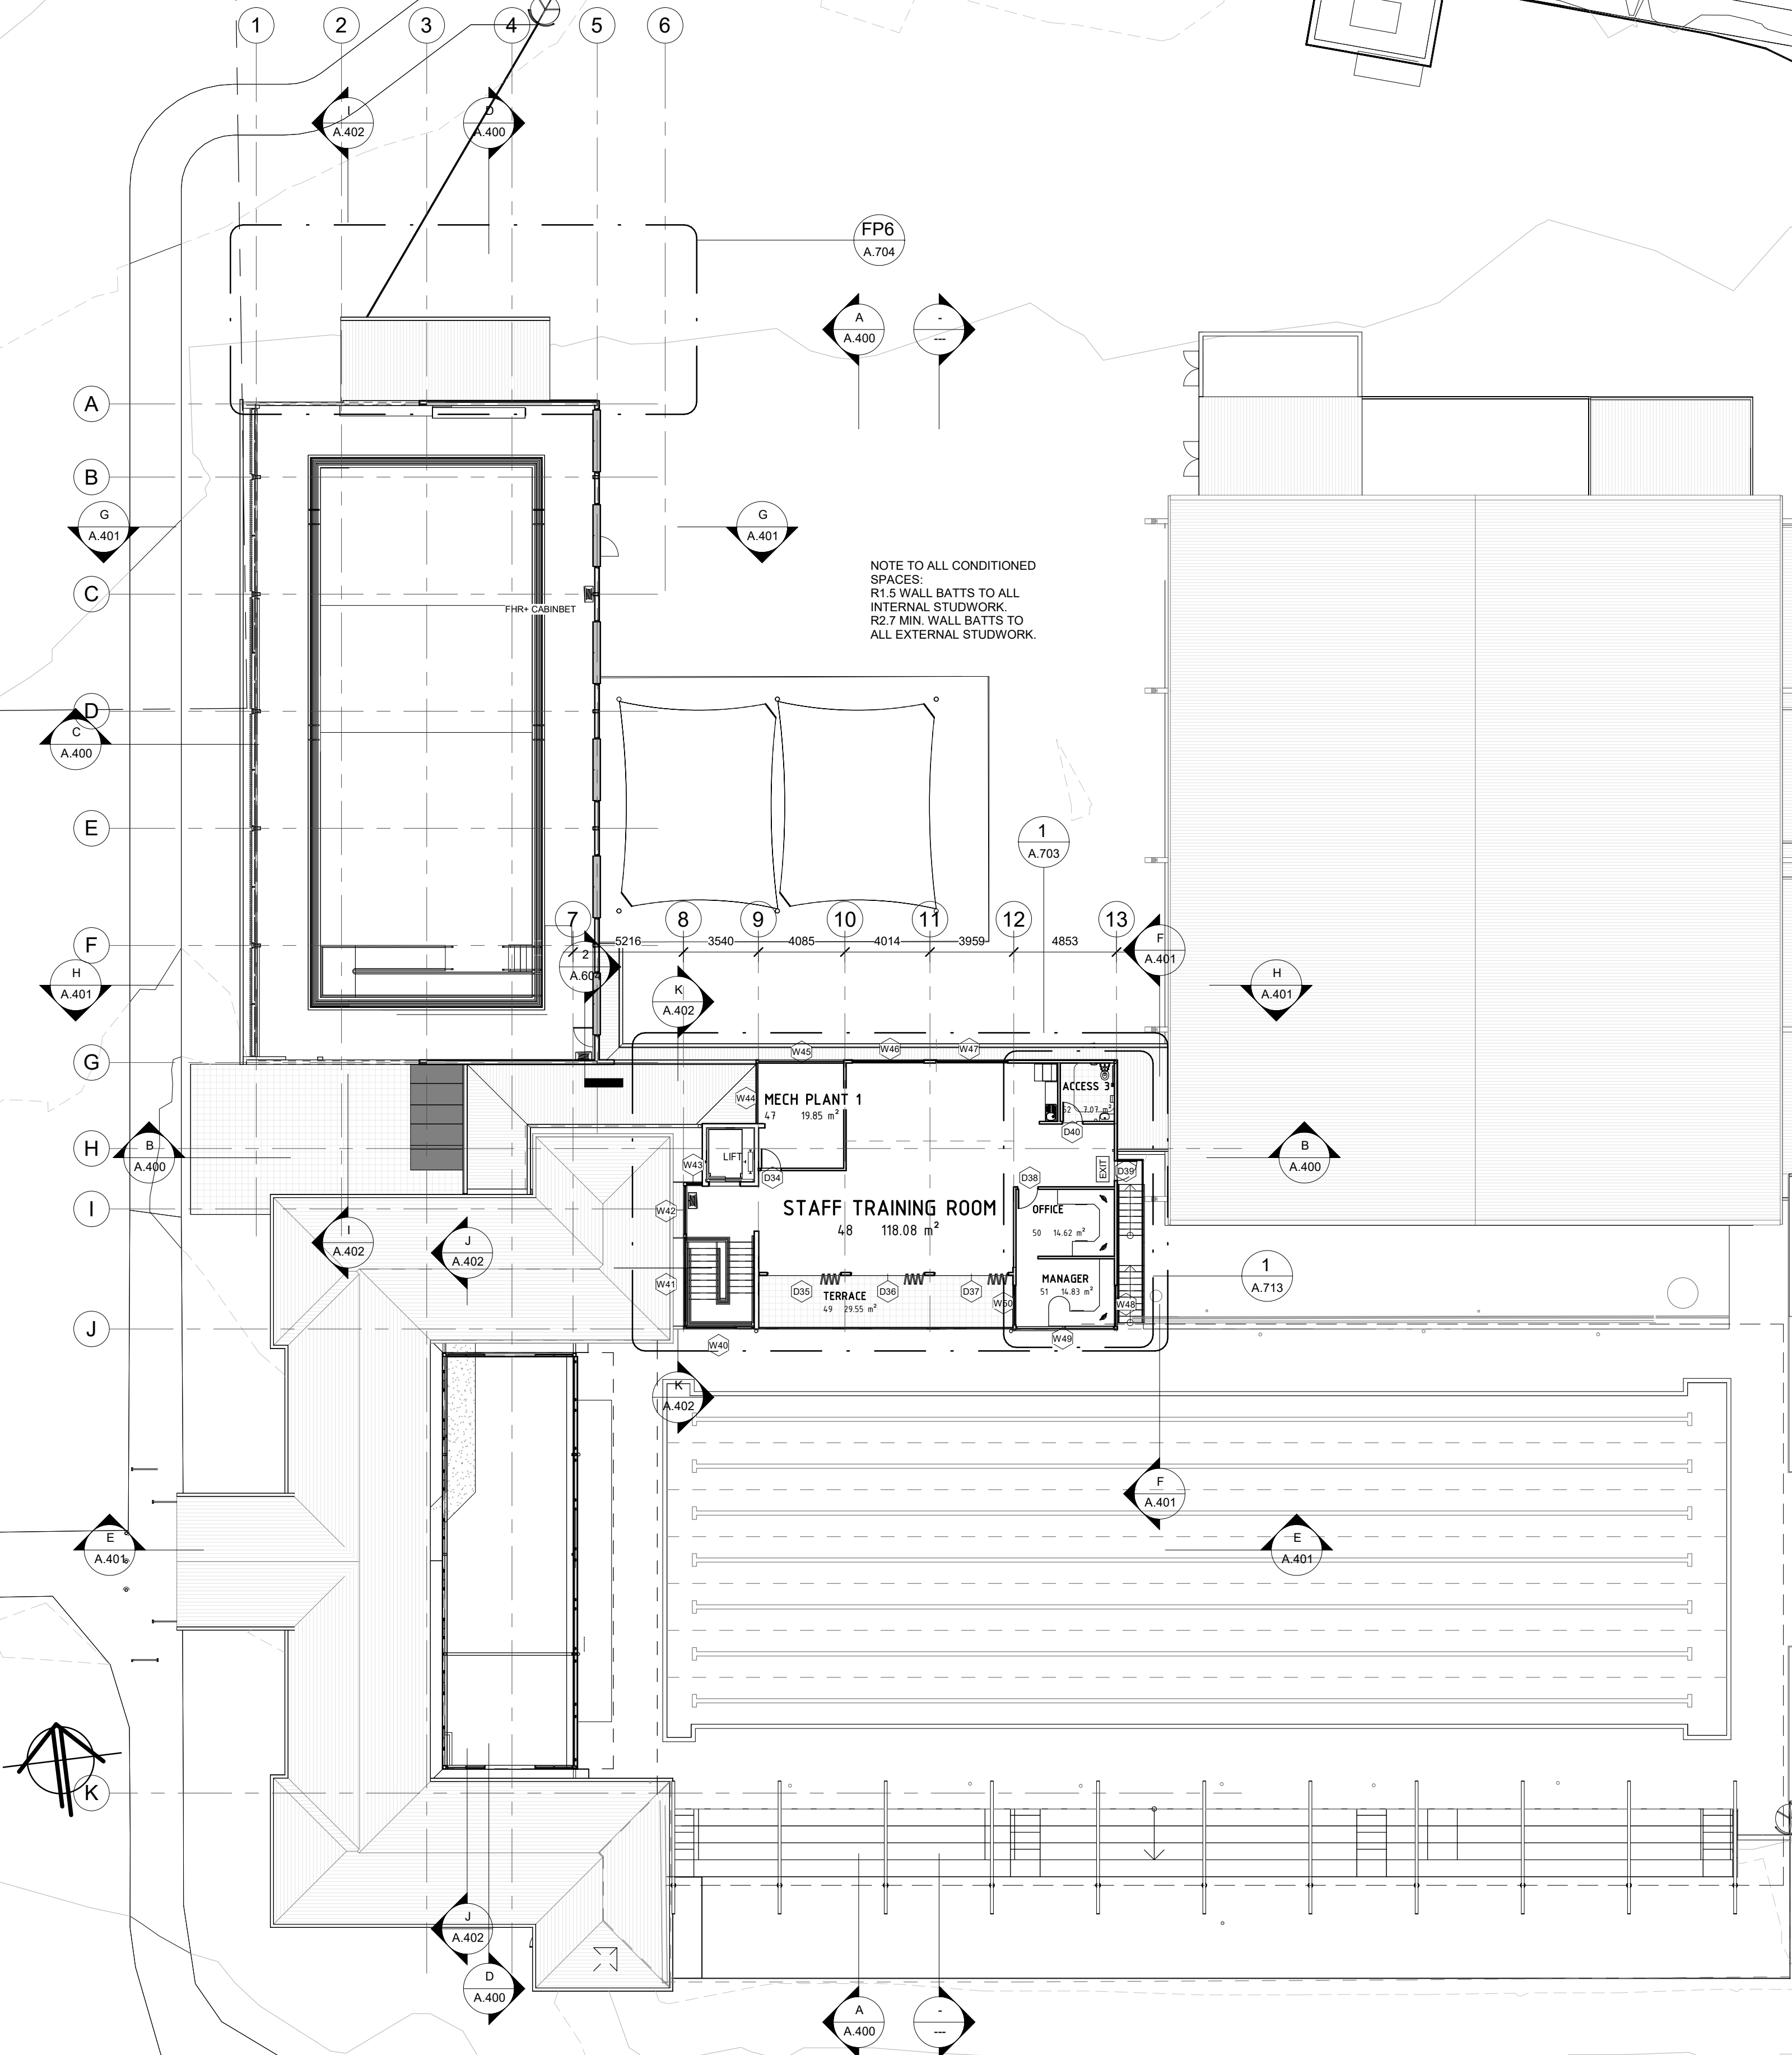

CONSULTANT 5:
SMS
acn 80 158 133 110
po box 480
Milsom Point 1565
t: 9438 1022 f: 9438 2124
e: reception@smscorp.com.au

 

CONSULTANT 4:
M.J. HARVEY & ASSOCIATES PTY. LTD.
HYDRAULIC & FIRE PROTECTION ENGINEERS
UNIT 7, 11-13 POTTER CLOSE
WETHERILL PARK 2164
Phone (02) 9756 5579
Fax (02) 9756 5641
Email: Michael@mhharvey.com.au

CONSULTANT 3:
COLARCI
A division of Collingridge & Associates Architects
39 Terry Street ROYELLE NSW 2039
ARCHITECTURE | APPLIED AQUATIC ENGINEERING
T: +61 2 9555 8108

CONSULTANT 2:
SPECTRUM
ENGINEERING SOLUTIONS
1 Davis Place
Glenhaven NSW 2156
Phone: (02) 8850 6802
Mobile: 0419 294 533
Email: r.nash@spectrumsolutions.com.au

CONSULTANT 1:
ECLIPSE Consulting Engineers Pty Ltd
304/12 Century Cct - Norwest Central,
Baulkham Hills NSW 2153
p: 02 9894 8500
m: 0419 64 8500 f: 02 8850 0212
e: info@eclipse-consu.com.au

DESIGN ARCHITECT:
FACILITY DESIGN GROUP
Architecture & Construction
AQUATIC ■ SPORTS ■ LEISURE ■ CIVIC ■ PROJECT MANAGEMENT
NSW Reg. No. 7168
ABN 75 083 999 624
e: info@fdg.com.au
w: www.fdg.com.au
p: 02 4446 0777
o: PO Box 82,
Cammerlang NSW 2540

CLIENT:
Burwood
heritage • progress • pride

PROJECT NAME:
Enfield Aquatic Centre
Masterplan

FOR DA
PROJECT ADDRESS:
Lot 7305 DP1146569
Portland Street,
Enfield NSW 2136

DRAWING TITLE:
PROPOSED LEVEL 01 PLAN

SHEET ISSUE DATE: 07.08.2019		DRAWING NO. REV.	
REVISION DATE:		A.101	
SCALE: 1:200 @ A1			
JOB NO.: W221			

DRAWN BY: AT CHECKED BY: S. JOHANSSON

COPYRIGHT FACILITY DESIGN GROUP PTY. LIMITED. ALL RIGHTS RESERVED. DO NOT SCALE OFF DRAWINGS. WORK TO FIGURED DIMENSIONS ONLY. VERIFY DIMENSIONS ON SITE PRIOR TO COMMENCING WORK.

NOMINATED ARCHITECT: STEPHEN JOHANSSON - NSW REG No. 7168
24/08/2019 2:15:31 PM

PORTLAND STREET

SHELLEY STREET


SHELLY STREET

CONTRACTORS MUST VERIFY ALL DIMENSIONS ON SITE BEFORE COMMENCING ANY WORK OR PREPARING SHOP DRAWINGS

All Architectural drawing sheets to be cross-referenced with other relevant disciplines.

Rev Description Date

 CONSULTANT 5:
SMS
acn 80 158 133 110
po box 480
Milsore Point 1565
t: 9438 1022 f: 9438 2124
e: reception@smscorp.com.au



CONSULTANT 4:
M.J. HARVEY & ASSOCIATES PTY. LTD.
HYDRAULIC & FIRE PROTECTION ENGINEERS
UNIT 7, 11-13 POTTER CLOSE
WETHERILL PARK 2164
Phone (02) 9756 5579
Fax (02) 9756 5641
Email: Michael@mhharvey.com.au

CONSULTANT 3:
COLARCI
A division of Collingridge & Associates Architects
39 Terry Street ROYELLE NSW 2039
ARCHITECTURE | APPLIED AQUATIC ENGINEERING
T: +61 2 9555 8108

CONSULTANT 2:
SPECTRUM
ENGINEERING SOLUTIONS
1 Davis Place
Glenhaven NSW 2156
Phone: (02) 8850 6802
Mobile: 0419 294 533
Email: r.nash@spectrum-solutions.com.au

CONSULTANT 1:
ECLIPSE Consulting Engineers Pty Ltd
304/12 Century Cct - Norwest Central,
Baulkham Hills NSW 2153
p: 02 9894 8500
m: 0419 64 8500 f: 02 8850 0212
e: info@eclipse-engineers.com.au

DESIGN ARCHITECT:
FACILITY DESIGN GROUP
Architecture & Construction
AQUATIC ■ SPORTS ■ LEISURE ■ CIVIC ■ PROJECT MANAGEMENT
NSW Reg. No. 7168
ABN: 75 083 999 624
e: info@fdg.com.au
w: www.fdg.com.au
p: 02 4446 0777
c: PO Box 82,
Camden NSW 2540


CLIENT:
Burwood
heritage • progress • pride

PROJECT NAME:
Enfield Aquatic Centre
Masterplan
FOR DA
PROJECT ADDRESS:
Lot 7305 DP1146569
Portland Street,
Enfield NSW 2136

DRAWING TITLE:
ROOF PLAN
B1 PRINT SIZE
SHEET ISSUE DATE: 17.07.2019
REVISION DATE:
SCALE: 1:200 @ A1
JOB NO.: W221
DRAWN BY: AT
CHECKED BY: S. JOHANSSON

COPYRIGHT FACILITY DESIGN GROUP PTY. LIMITED. ALL RIGHTS RESERVED. DO NOT SCALE OFF DRAWINGS. WORK TO FIGURED DIMENSIONS ONLY. VERIFY DIMENSIONS ON SITE PRIOR TO COMMENCING WORK.

NOMINATED ARCHITECT: STEPHEN JOHANSSON - NSW REG No. 7168
24/08/2019 2:15:40 PM

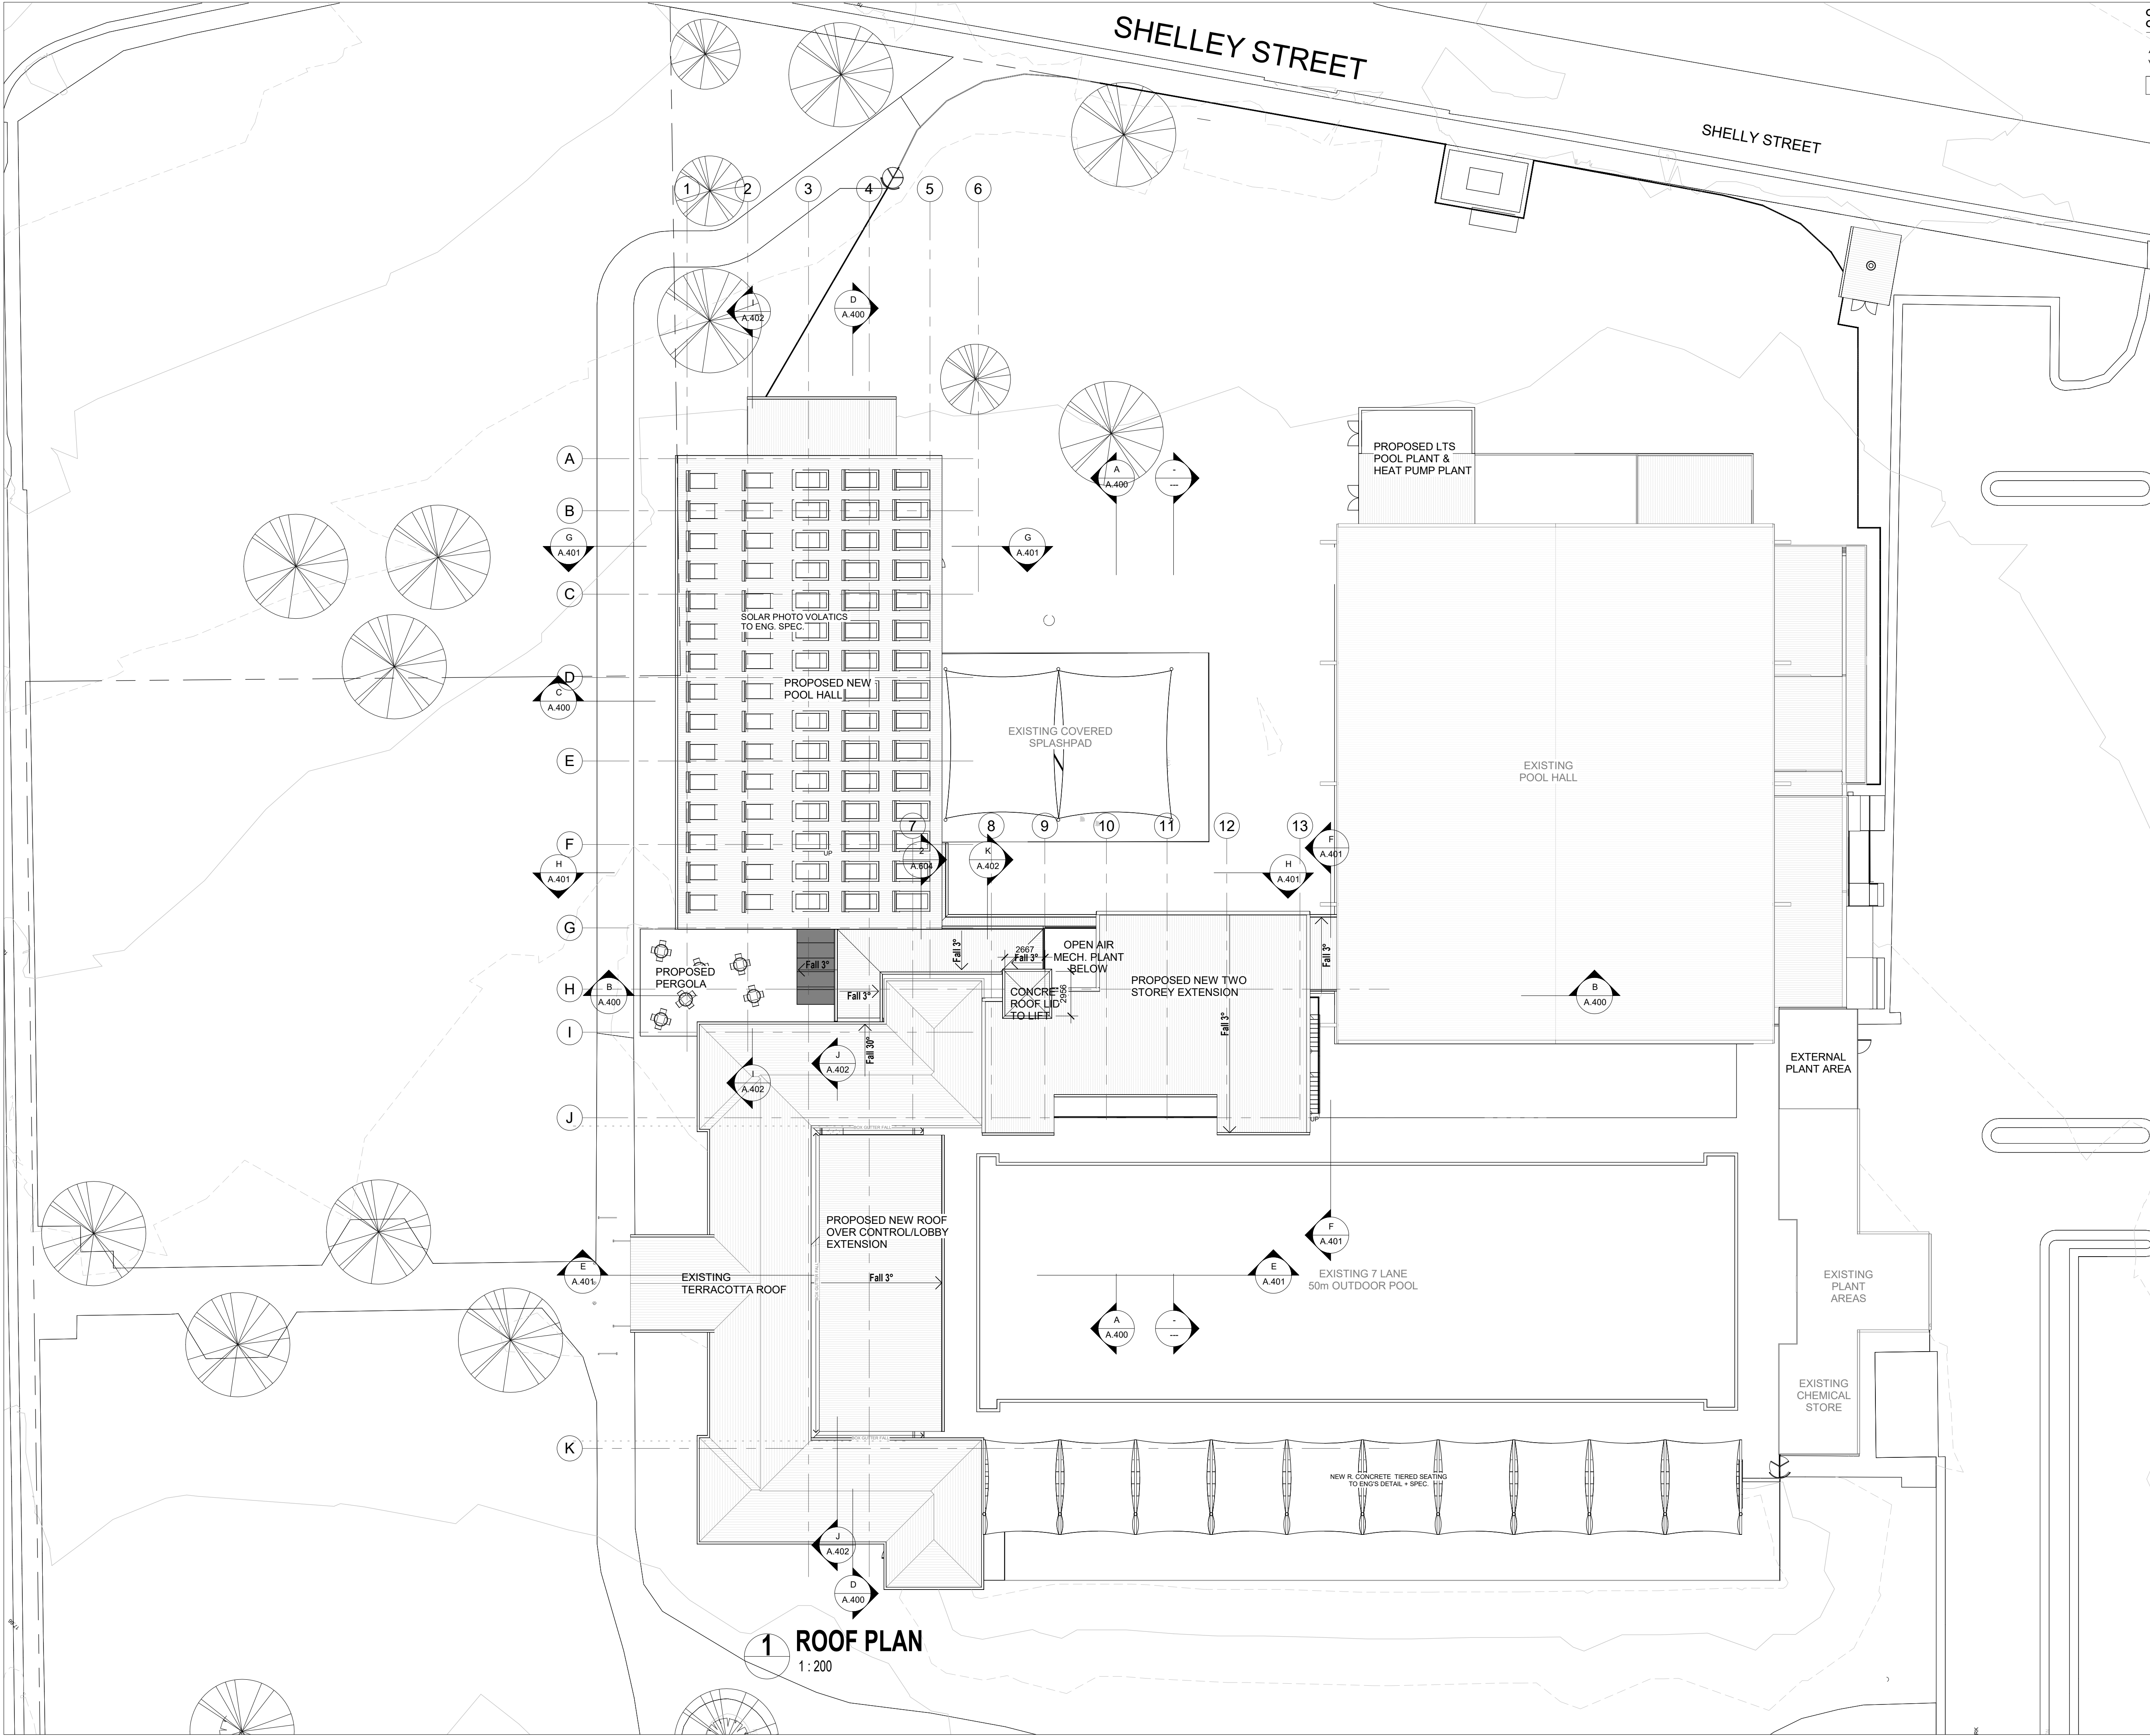


1 ROOF PLAN
1:200


CONTRACTORS MUST VERIFY ALL DIMENSIONS ON SITE BEFORE COMMENCING ANY WORK OR PREPARING SHOP DRAWINGS

All Architectural drawing sheets to be cross-referenced with other relevant disciplines.


Rev Description Date

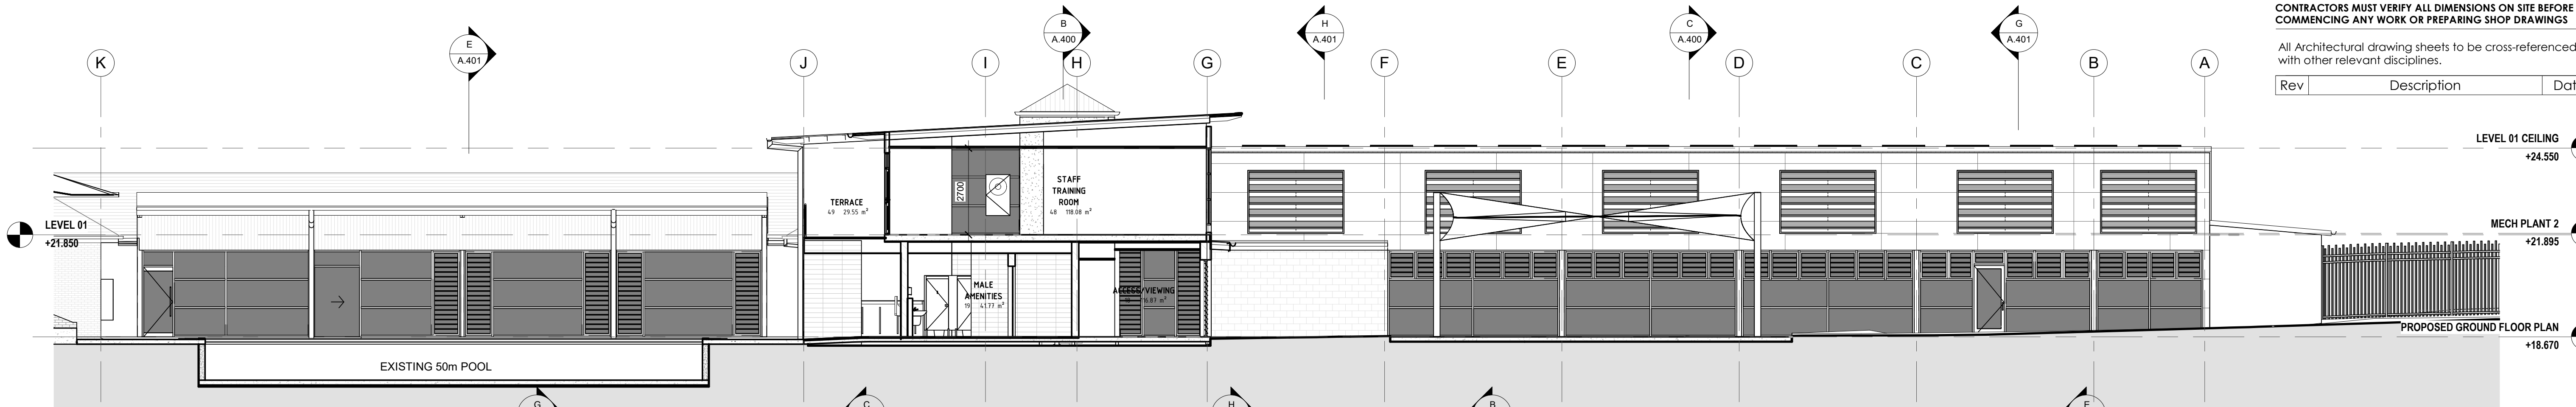


A SECTION A-A
1:100

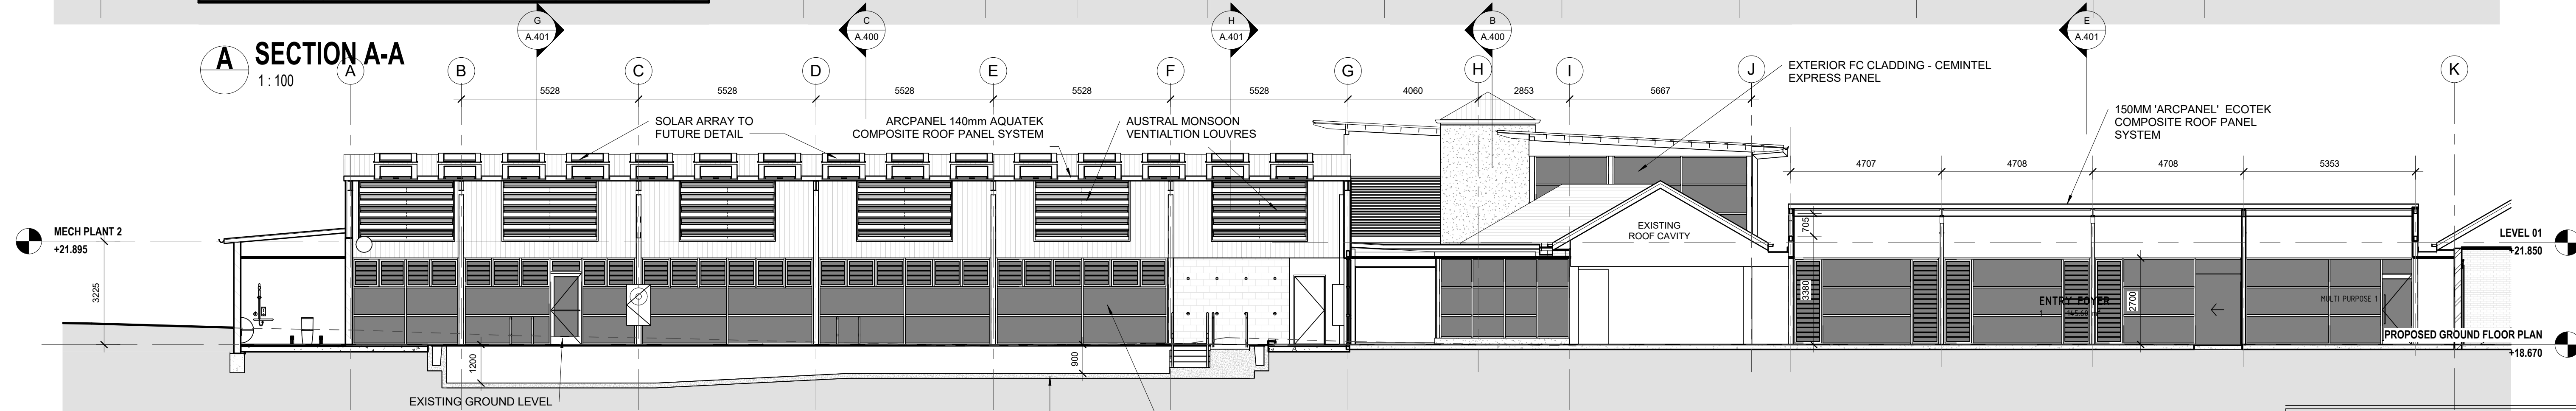

D Section B-B
1:100

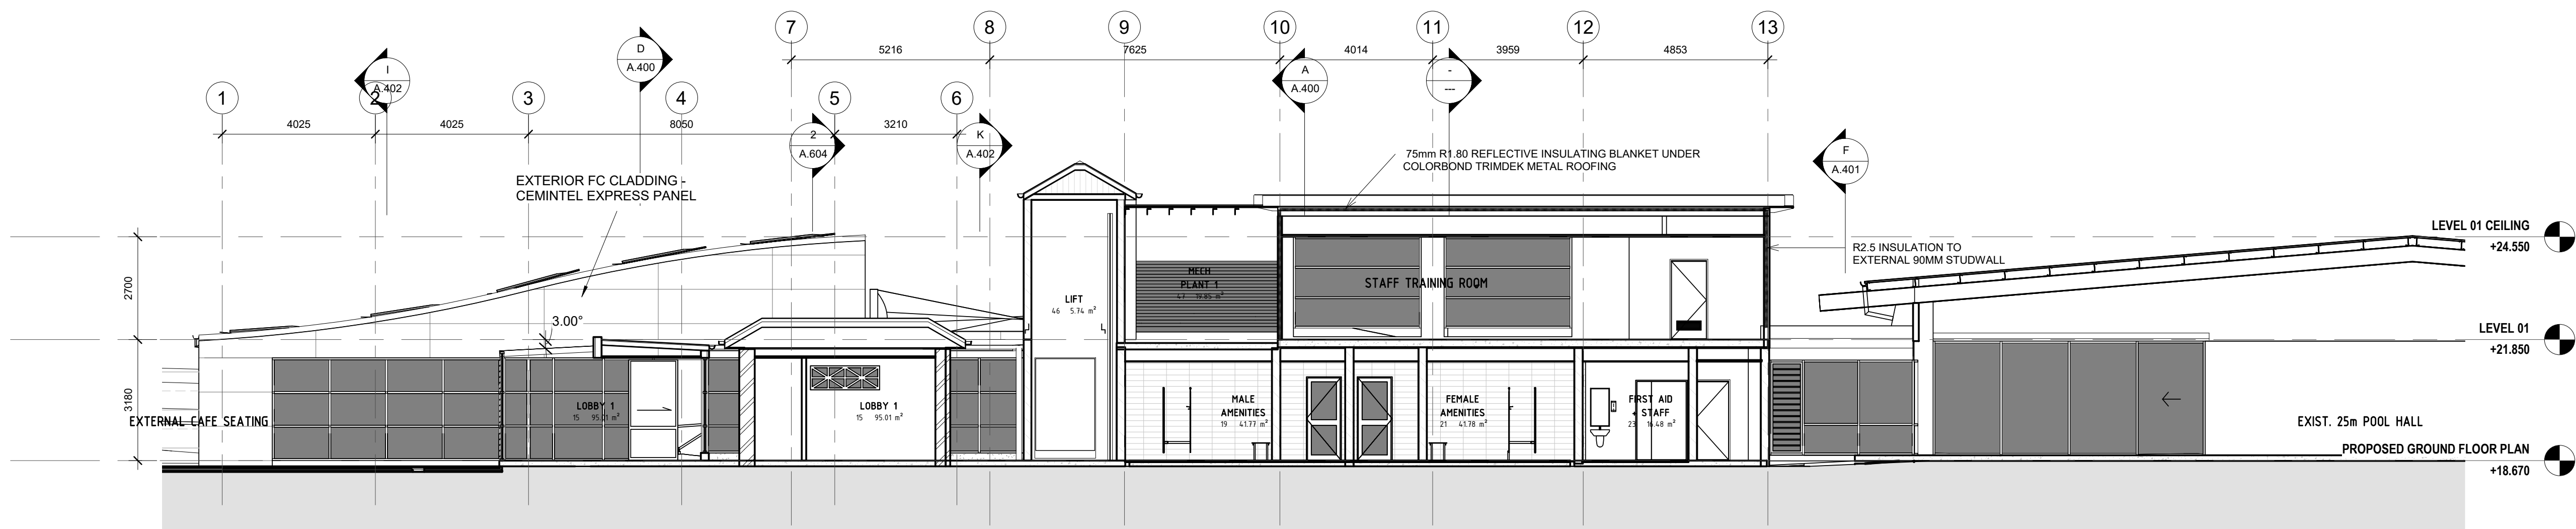


B Section C-C
1:100

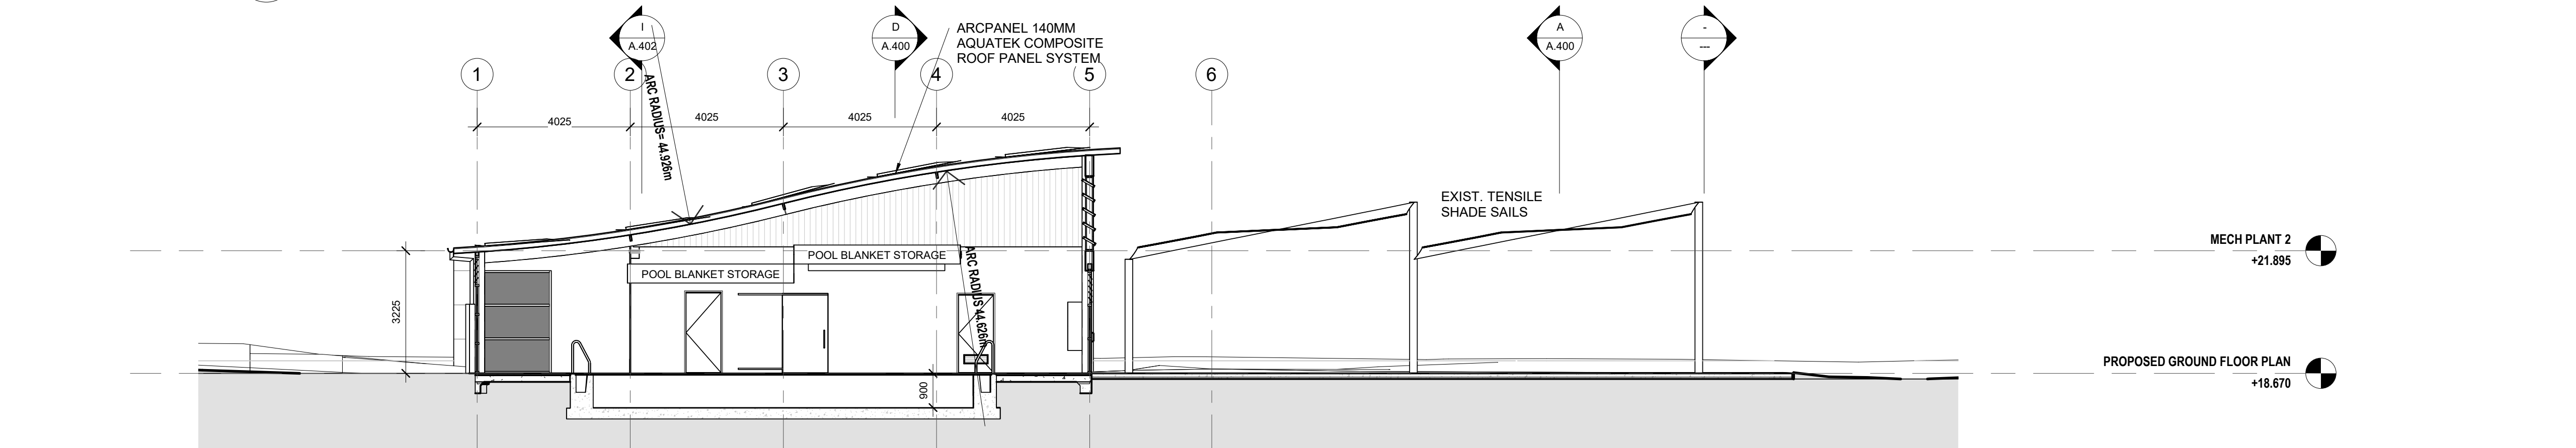

C Section D-D
1:100

 CONSULTANT 5:
SMS
PO BOX 158 133 110
MISORA POINT 1565
T: 9438 1022 F: 9438 2124
E: reception@smscorp.com.au



CONSULTANT 4:
MJH M.J. HARVEY & ASSOCIATES PTY. LTD.
HYDRAULIC & FIRE PROTECTION ENGINEERS
UNIT 7, 11-13 POTTER CLOSE
WETHERILL PARK 2164
Phone: (02) 9756 5579
Fax: (02) 9756 5641
Email: Michael@mjharvey.com.au

CONSULTANT 3:
COLARCI
A division of Collingridge & Associates Architects
39 Terry Street ROYELLE NSW 2039
ARCHITECTURE | APPLIED AQUATIC ENGINEERING
T: +61 2 9555 8108

CONSULTANT 2:
SPECTRUM
ENGINEERING SOLUTIONS
1 Davis Place
Glenhaven NSW 2156
Phone: (02) 8850 6802
Mobile: 0419 294 533
Email: r.nah@specengsolutions.com.au

CONSULTANT 1:
ECLIPSE Consulting Engineers Pty Ltd
304/12 Century Cct - Norwest Central,
BAULKLEIGH HILLS NSW 2153
p: 02 9894 8500
m: 0419 64 8500 f: 02 8850 0212
e: info@eclipse.com.au

DESIGN ARCHITECT:
FACILITY DESIGN GROUP
Architecture & Construction
AQUATIC ■ SPORTS ■ LEISURE ■ CIVIC ■ PROJECT MANAGEMENT
NSW Reg. No. 7168
ABN: 75 083 999 624
e: info@fdg.com.au
w: www.fdg.com.au
p: 02 4446 0777
c: PO Box 82,
Cronulla NSW 2230

CLIENT:
Owner **Burwood**
heritage • progress • pride

PROJECT NAME:
Enfield Aquatic Centre Masterplan

FOR DA
PROJECT ADDRESS:
Lot 7305 DP1146569
Portland Street,
Enfield NSW 2136

DRAWING TITLE:

SECTIONS 1

B1 PRINT SIZE
SHEET ISSUE DATE: 07.08.2019
REVISION DATE:
SCALE: 1:100 @ A1
JOB NO.: W221
DRAWN BY: Author
CHECKED BY: S. JOHANSSON


COPYRIGHT FACILITY DESIGN GROUP PTY. LIMITED. ALL RIGHTS RESERVED. DO NOT SCALE OFF DRAWINGS. WORK TO FIGURED DIMENSIONS ONLY. VERIFY DIMENSIONS ON SITE PRIOR TO COMMENCING WORK.

NOMINATED ARCHITECT: STEPHEN JOHANSSON - NSW REG NO. 7168
24/08/2019 2:15:47 PM


CONTRACTORS MUST VERIFY ALL DIMENSIONS ON SITE BEFORE COMMENCING ANY WORK OR PREPARING SHOP DRAWINGS

All Architectural drawing sheets to be cross-referenced with other relevant disciplines.


Rev	Description	Date
-----	-------------	------

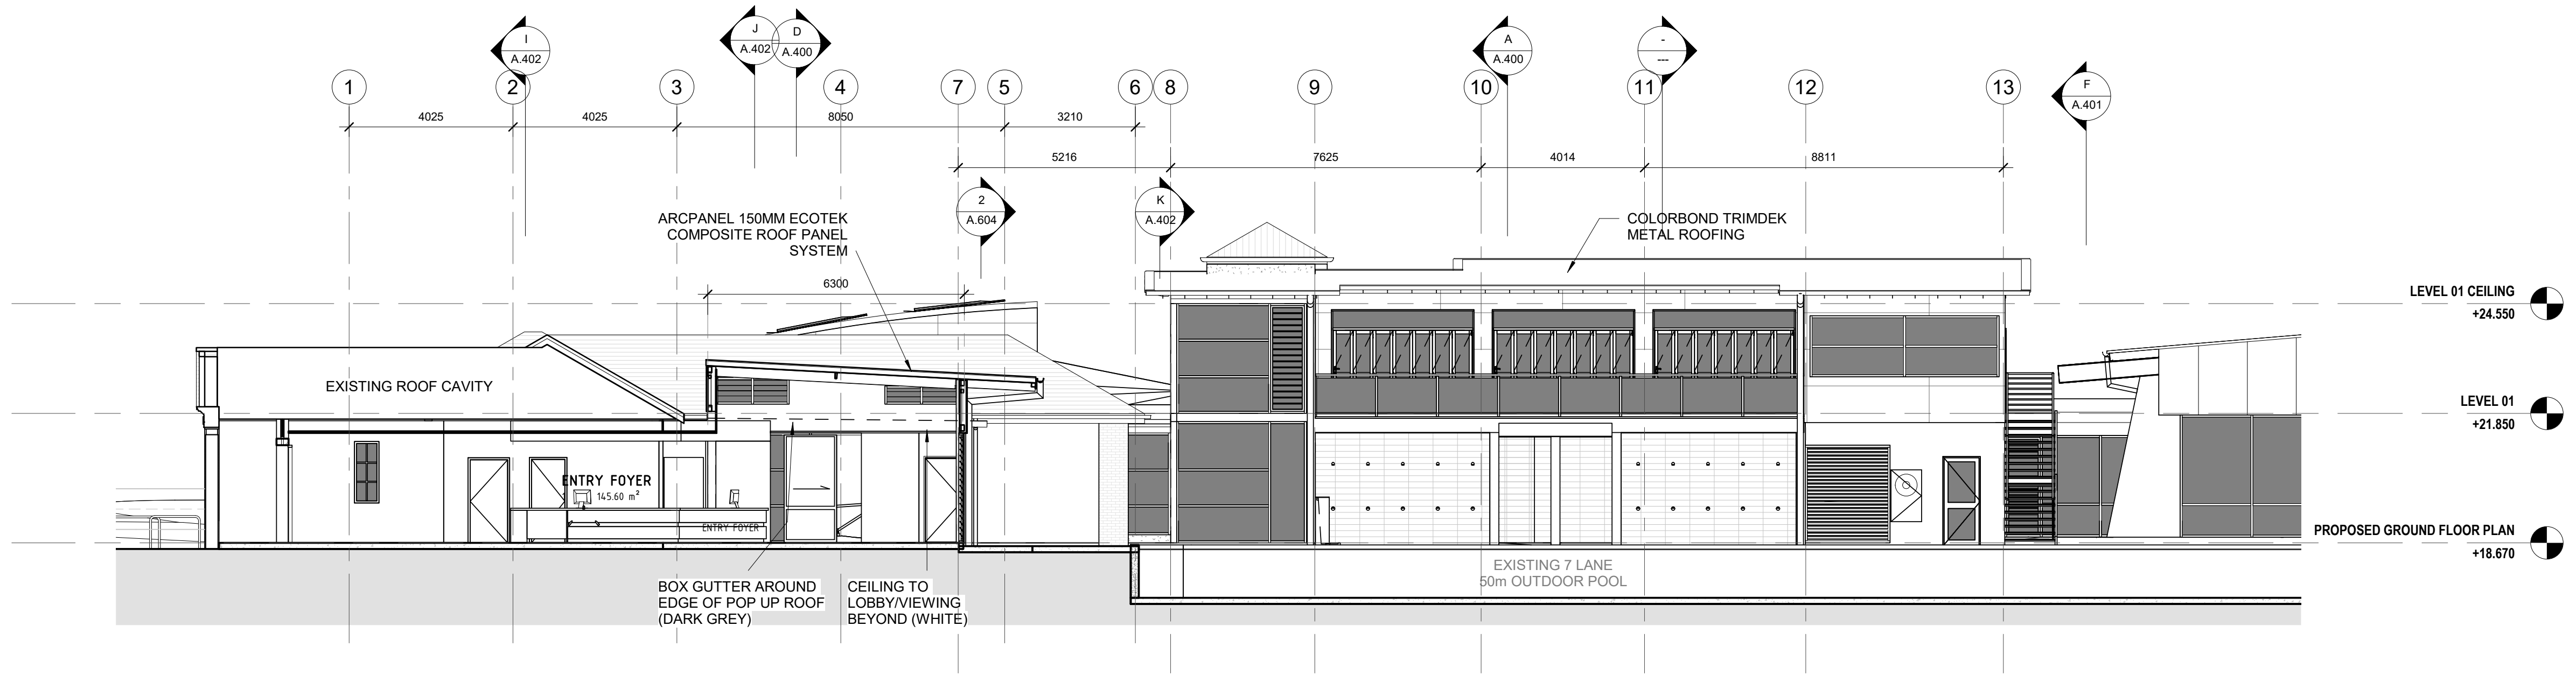


E SECTION E.E
1:100

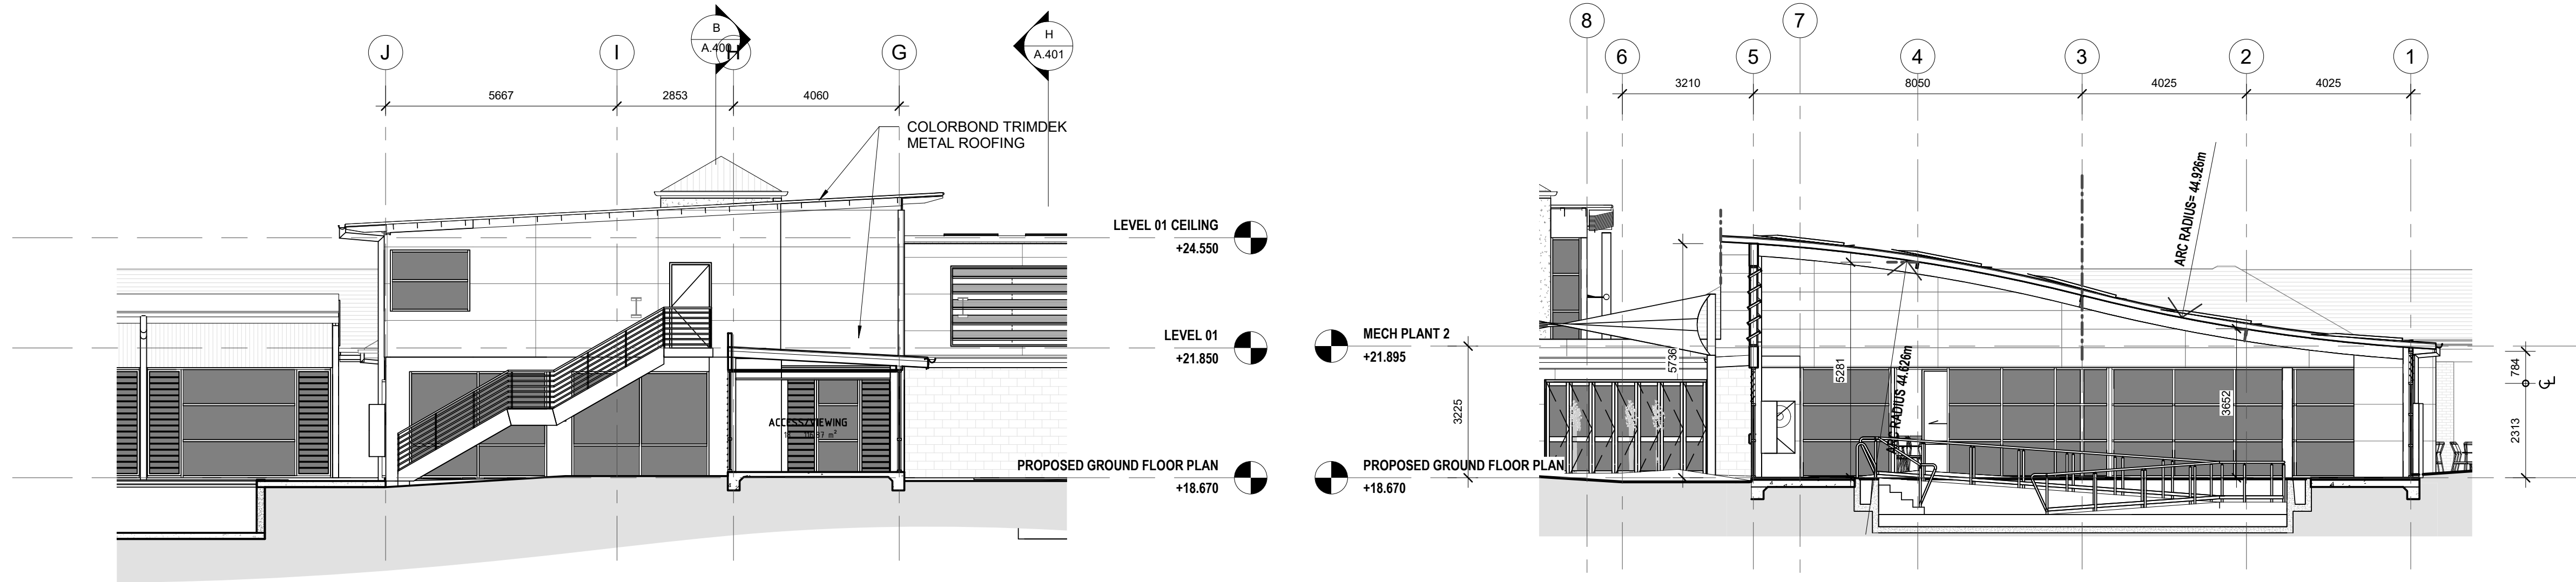

F SECTION F.F
1:100

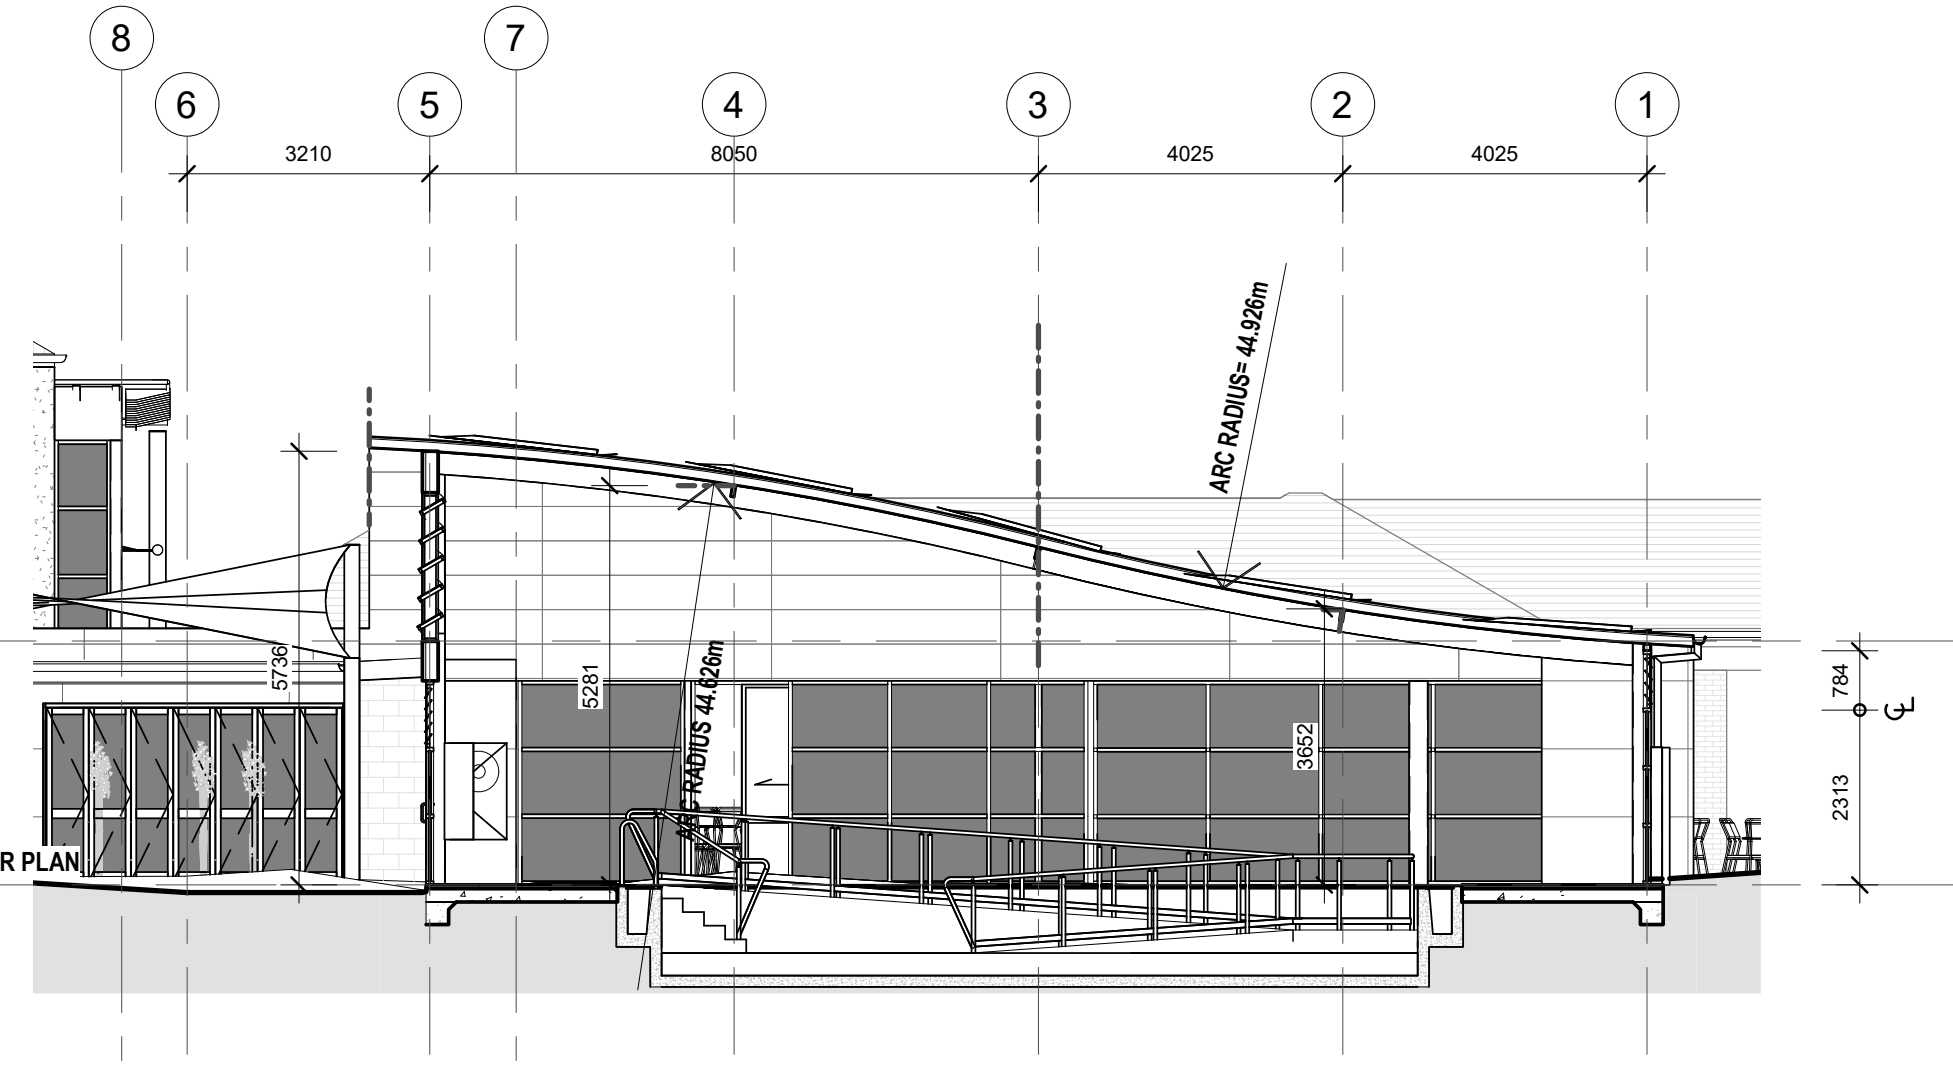


G SECTION G.G
1:100

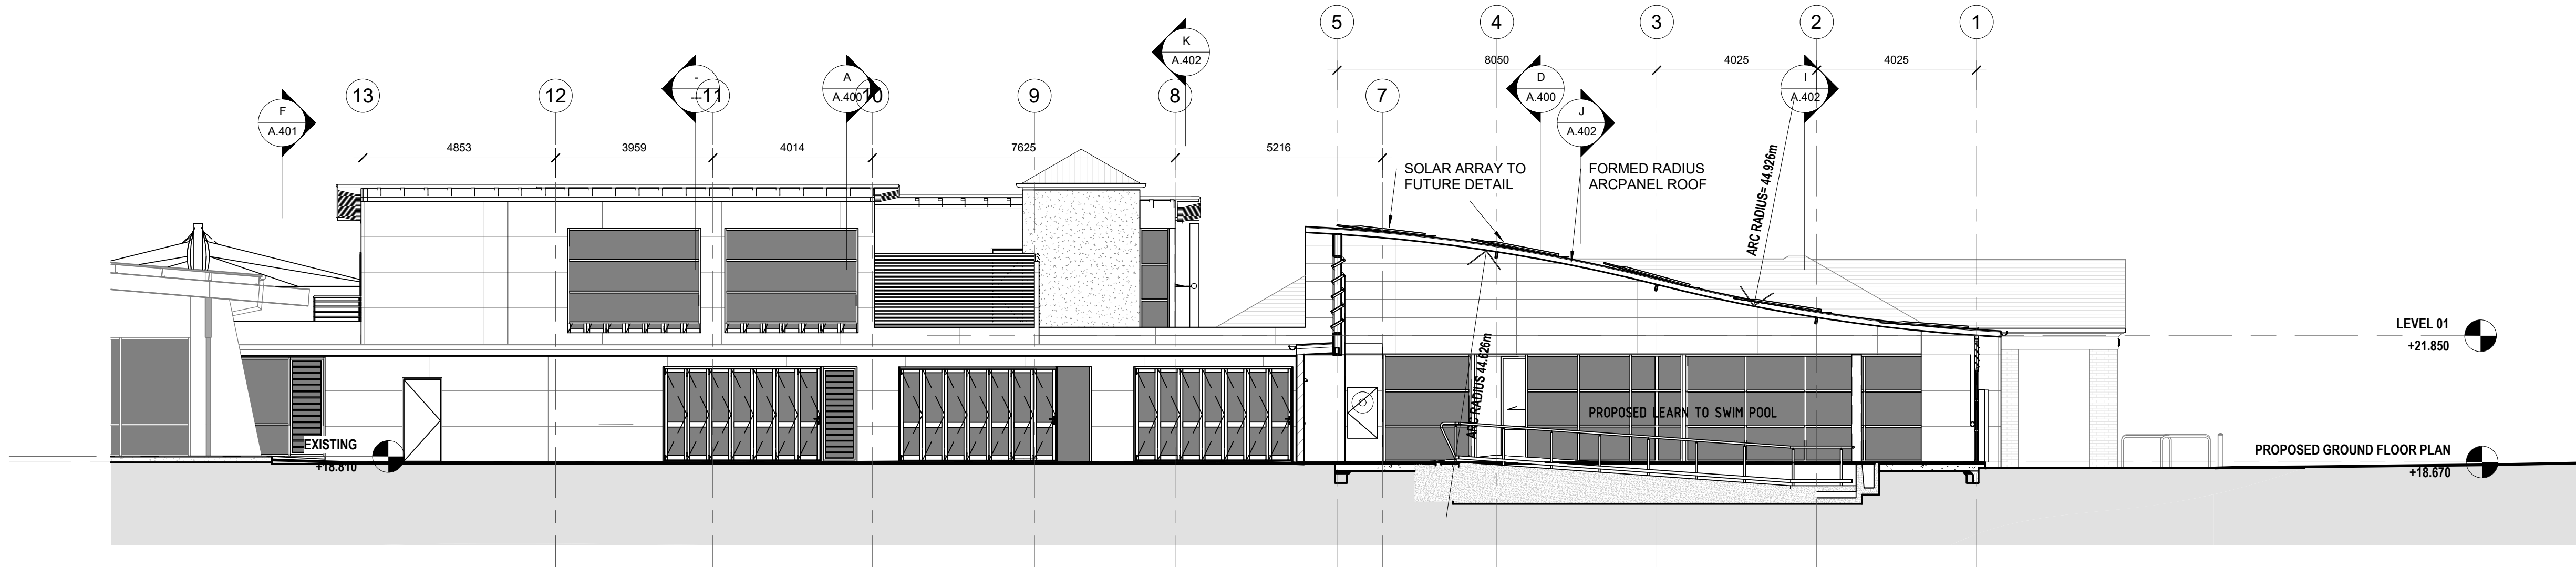

H SECTION H
1:100

 CONSULTANT 5:
SMS Pty. Ltd
acn 80 158 133 110
po box 480
Milsom Point 1565
t: 9438 1022 f: 9438 2124
e: reception@smscorp.com.au



CONSULTANT 4:
MJH M.J. HARVEY & ASSOCIATES PTY. LTD.
HYDRAULIC & FIRE PROTECTION ENGINEERS
UNIT 7, 11-13 POTTER CLOSE
WEHERRILL PARK 2164
Phone: (02) 9756 5579
Fax: (02) 9756 5641
Email: Michael@mharvey.com.au

CONSULTANT 3:
aquaticone
19/14 Ashlan Place,
Banyo QLD 4014
Phone: (07) 3267 7295
Mobile: 0477 208 020
Email: Luke.Bartlett@aquaticone.com

CONSULTANT 2:
SPECTRUM
ENGINEERING SOLUTIONS
1 Davis Place
Glenhaven NSW 2156
Phone: (02) 8850 6802
Mobile: 0419 294 533
Email: r.nah@specengsolutions.com.au

CONSULTANT 1:
ECLIPSE Consulting Engineers Pty Ltd
304/12 Century Cct - Norwest Central,
BAULKLEIGH HILLS NSW 2153
p: 02 9894 8500
m: 0419 64 8500 f: 02 8850 0212
e: info@eclipse-engineers.com.au

DESIGN ARCHITECT:
FACILITY DESIGN GROUP
Architecture & Construction
AQUATIC ■ SPORTS ■ LEISURE ■ CIVIC ■ PROJECT MANAGEMENT
NSW Reg. No. 7168
ABN: 75 083 999 624
e: info@fdg.com.au
w: www.fdg.com.au
p: 02 4446 0777
a: PO Box 82,
Camden NSW 2540

CLIENT:

Owner

PROJECT NAME:
Enfield Aquatic Centre Masterplan

FOR DA
PROJECT ADDRESS:
Lot 7305 DP1146569
Portland Street,
Enfield NSW 2136

DRAWING TITLE:

SECTIONS 2

SHEET ISSUE DATE: 07.08.2019	DRAWING NO. REV.
REVISION DATE:	
SCALE: 1:100 @ B1	A.401
JOB NO.: W221	

DRAWN BY: Author CHECKED BY: S. JOHANSSON

COPYRIGHT FACILITY DESIGN GROUP PTY. LIMITED. ALL RIGHTS RESERVED. DO NOT SCALE OFF DRAWINGS. WORK TO FIGURED DIMENSIONS ONLY. VERIFY DIMENSIONS ON SITE PRIOR TO COMMENCING WORK.


NOMINATED ARCHITECT: STEPHEN JOHANSSON - NSW REG No. 7168

24/08/2019 2:15:55 PM

CONTRACTORS MUST VERIFY ALL DIMENSIONS ON SITE BEFORE COMMENCING ANY WORK OR PREPARING SHOP DRAWINGS

All Architectural drawing sheets to be cross-referenced with other relevant disciplines.

Rev	Description	Date
-----	-------------	------

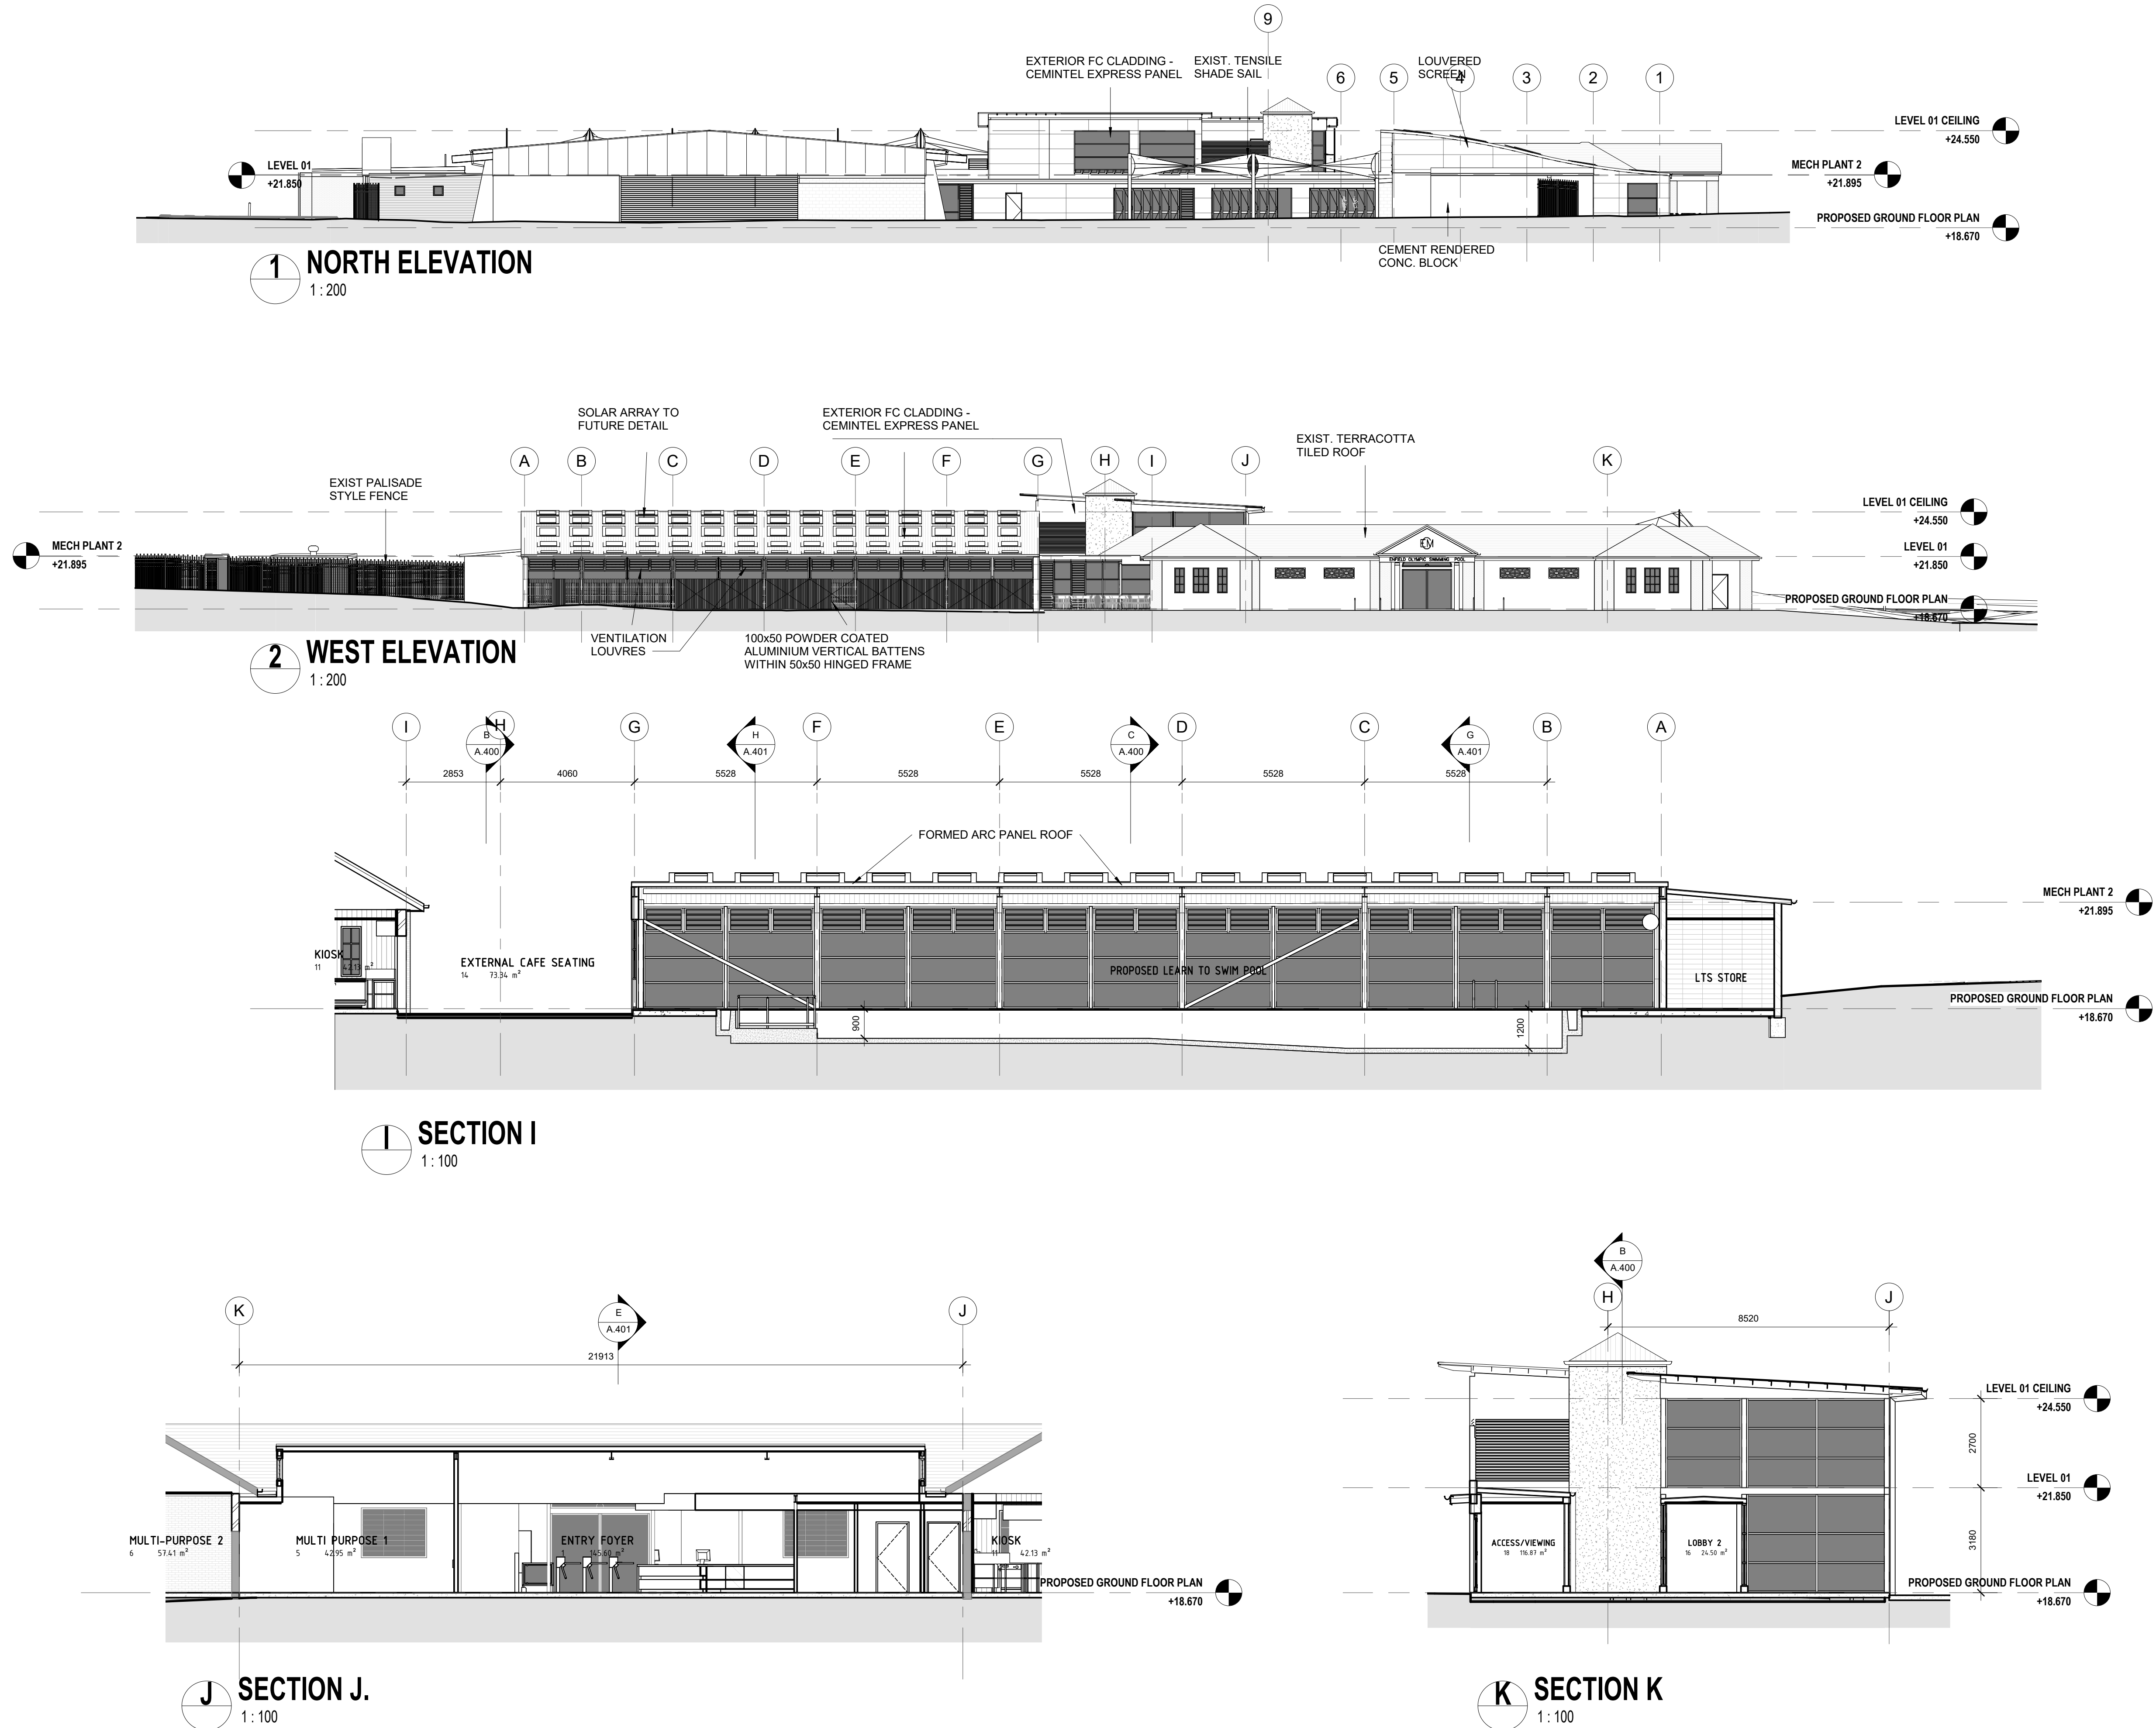

CONSULTANT 5:
SMS
acn 80 158 133 110
po box 480
Milsers Point 1565
t: 9438 1022 f: 9438 2124
e: reception@smscorp.com.au

CONSULTANT 4:
M.J. HARVEY & ASSOCIATES PTY. LTD.
HYDRAULIC & FIRE PROTECTION ENGINEERS
UNIT 7, 11-13 POTTER CLOSE
WETHERILL PARK 2164
Phone: (02) 9756 5579
Fax: (02) 9756 5641
Email: Michael@mhharvey.com.au

CONSULTANT 3:
COLARCI
A division of Collingridge & Associates Architects
39 Terry Street ROYELLE NSW 2039
ARCHITECTURE | APPLIED AQUATIC ENGINEERING
t: +61 2 9555 8108

CONSULTANT 2:
SPECTRUM
ENGINEERING SOLUTIONS
1 Davis Place
Glenhaven NSW 2156
Phone: (02) 8850 6802
Mobile: 0419 294 533
Email: i.nash@spectrumengsolutions.com.au

CONSULTANT 1:
ECLIPSE Consulting Engineers Pty Ltd
304/12 Century Cct - Norwest Central,
BAULKHAM HILLS NSW 2153
p: 02 9894 8500
m: 0419 64 8500 f: 02 8850 0212
e: info@eclipse-consu.com.au

DESIGN ARCHITECT:
FACILITY DESIGN GROUP
Architecture & Construction
AQUATIC ■ SPORTS ■ LEISURE ■ CIVIC ■ PROJECT MANAGEMENT
NSW Reg. No. 7168
ABN: 75 083 999 424
e: info@fdg.com.au
w: www.fdg.com.au
p: 02 4446 0777
a: PO Box 82,
Camden NSW 2540

CLIENT:
Burwood
heritage • progress • pride

PROJECT NAME:
Enfield Aquatic Centre Masterplan
FOR DA
PROJECT ADDRESS:
Lot 7305 DP1146569
Portland Street,
Enfield NSW 2136

DRAWING TITLE:
ELEVATIONS + SECTIONS
B1 PRINT SIZE

SHEET ISSUE DATE: 07.08.2019
REVISION DATE:
SCALE: As indicated @ A1
JOB NO.: W221
DRAWING NO. REV.
A.402


DRAWN BY: AT CHECKED BY: S. JOHANSSON

COPYRIGHT FACILITY DESIGN GROUP PTY. LIMITED. ALL RIGHTS RESERVED. DO NOT SCALE OFF DRAWINGS. WORK TO FIGURED DIMENSIONS ONLY. VERIFY DIMENSIONS ON SITE PRIOR TO COMMENCING WORK.


NOMINATED ARCHITECT: STEPHEN JOHANSSON - NSW REG No. 7168
24/08/2019 2:16:02 PM



EXTERNAL WALL CLADDING - CEMINTEL TERRITORY - QUARRY URBAN GREY

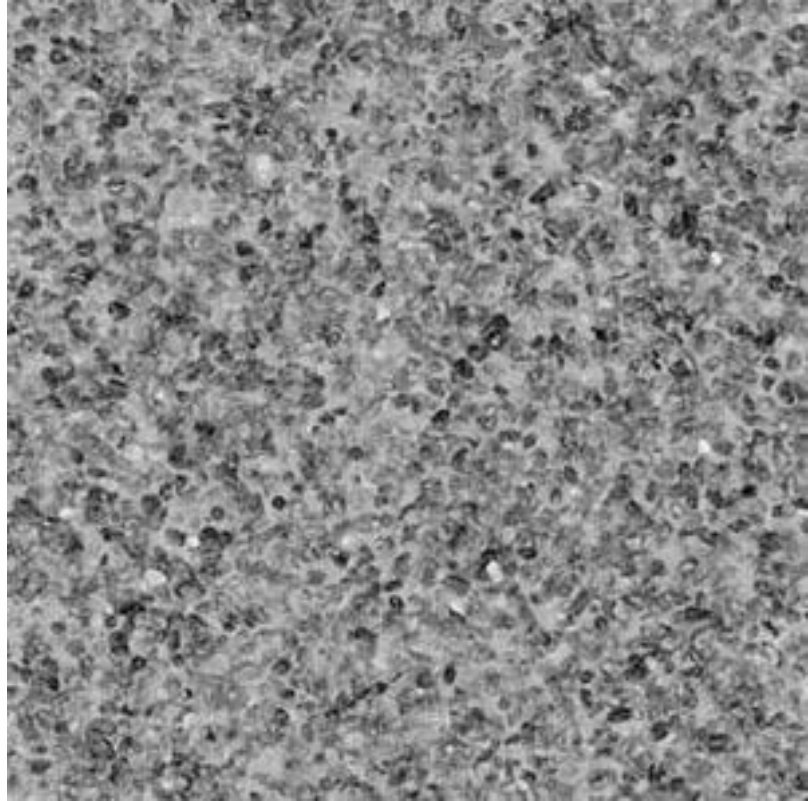

EXTERNAL WALL CEMENT RENDER - WATTYL-GRANOSITE PEWTER CUP KOONUNGA BLUE

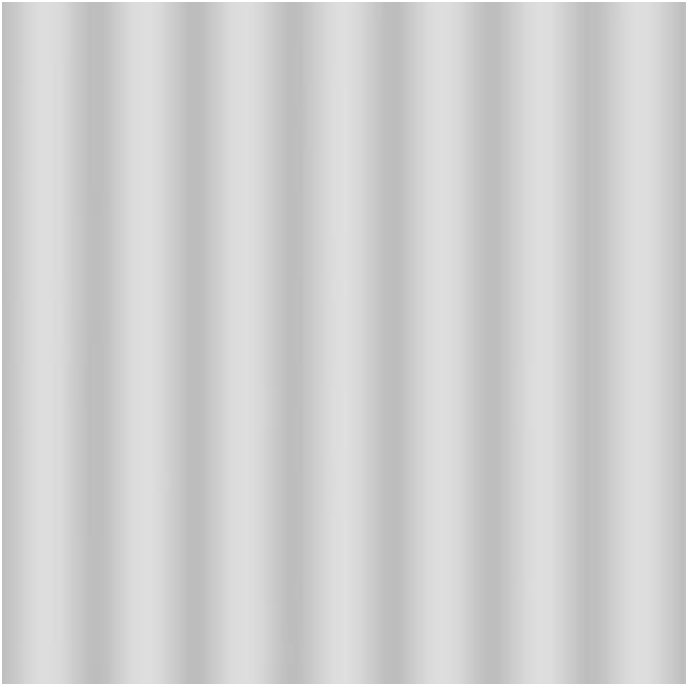


COLORBOND CUSTOM ORB ROOF SHEET - SURFMIST



BLACK POWDERCOATED ALUMINIUM FRAMED GLAZING



BLACK POWDERCOATED ALUMINIUM LOUVRE SCREEN

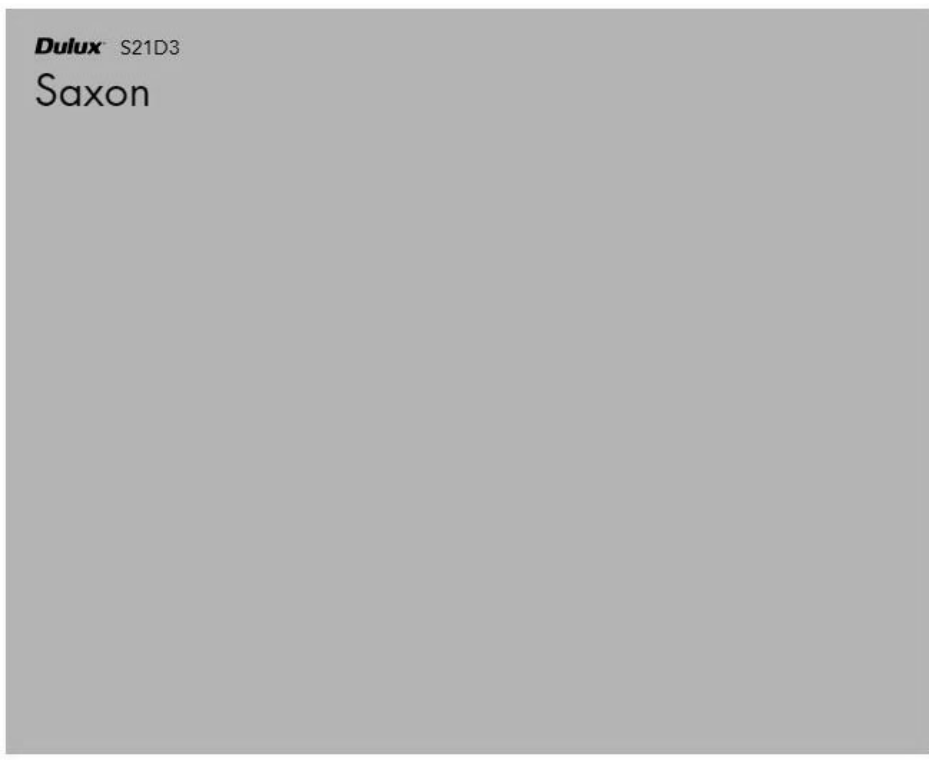

DULUX - SAXON - NEW WALL COLOUR TO EXISTING PAVILION



BLACK DURAGAL BATTEN SCREEN



STAINLESS STEEL GUTTERS + DOWNPIPES



BLACK PALISADE SECURITY FENCING

2 EXTERNAL FINISHES

1 : 20

CONTRACTORS MUST VERIFY ALL DIMENSIONS ON SITE BEFORE COMMENCING ANY WORK OR PREPARING SHOP DRAWINGS

All Architectural drawing sheets to be cross-referenced with other relevant disciplines.

Rev	Description	Date
-----	-------------	------

CONSULTANT 5:

SMS

acn 80 158 133 110
po box 480
Milsom Point 1565
t 9438 1022 f 9438 2124
e reception@smscorp.com.au

CONSULTANT 4:

MJH M.J. HARVEY & ASSOCIATES PTY. LTD.
HYDRAULIC & FIRE PROTECTION ENGINEERS
UNIT 7, 11-13 POTTER CLOSE
WEHERRILL PARK 2164
Phone (02) 9756 5579
Fax (02) 9756 5641
Email: Michael@mhharvey.com.au

CONSULTANT 3:

COLARCI
A division of Collingridge & Associates Architects
39 Terry Street ROYELLE NSW 2039
ARCHITECTURE | APPLIED AQUATIC ENGINEERING
t: +61 2 9555 8108

CONSULTANT 2:

SPECTRUM
ENGINEERING SOLUTIONS
1 Davis Place
Glenhaven NSW 2156
Phone: (02) 8850 6802
Mobile: 0419 294 533
Email: r.nah@specengsolutions.com.au

CONSULTANT 1:

ECLIPSE Consulting Engineers Pty Ltd
304/12 Century Cct - Norwest Central,
Baulkham Hills NSW 2153
p: 02 9894 8500
m: 0419 64 8500 f: 02 8850 0212
e: info@eclipse-consul.com.au

DESIGN ARCHITECT:

FACILITY DESIGN GROUP
Architecture & Construction
AQUATIC ■ SPORTS ■ LEISURE ■ CIVIC ■ PROJECT MANAGEMENT
NSW Reg. No. 7168
ABN 75 083 999 424
e: info@fdg.com.au
w: www.fdg.com.au
p: 02 4446 0777
c: PO Box 82,
Cronulla NSW 2230

CLIENT:

Owner **Burwood**
heritage • progress • pride

PROJECT NAME:

Enfield Aquatic Centre Masterplan

FOR DA

PROJECT ADDRESS:
Lot 7305 DP1146569
Portland Street,
Enfield NSW 2136

DRAWING TITLE:

EXTERNAL FINISHES

SHEET ISSUE DATE: 07.08.2019

REVISION DATE:

SCALE: As indicated @ A1

JOB NO.: W221

DRAWN BY: Author

CHECKED BY: S. JOHANSSON

COPYRIGHT FACILITY DESIGN GROUP PTY. LIMITED. ALL RIGHTS RESERVED. DO NOT SCALE OFF DRAWINGS. WORK TO FIGURED DIMENSIONS ONLY. VERIFY DIMENSIONS ON SITE PRIOR TO COMMENCING WORK.

NOMINATED ARCHITECT: STEPHEN JOHANSSON - NSW REG No. 7168

24/08/2019 2:16:05 PM