



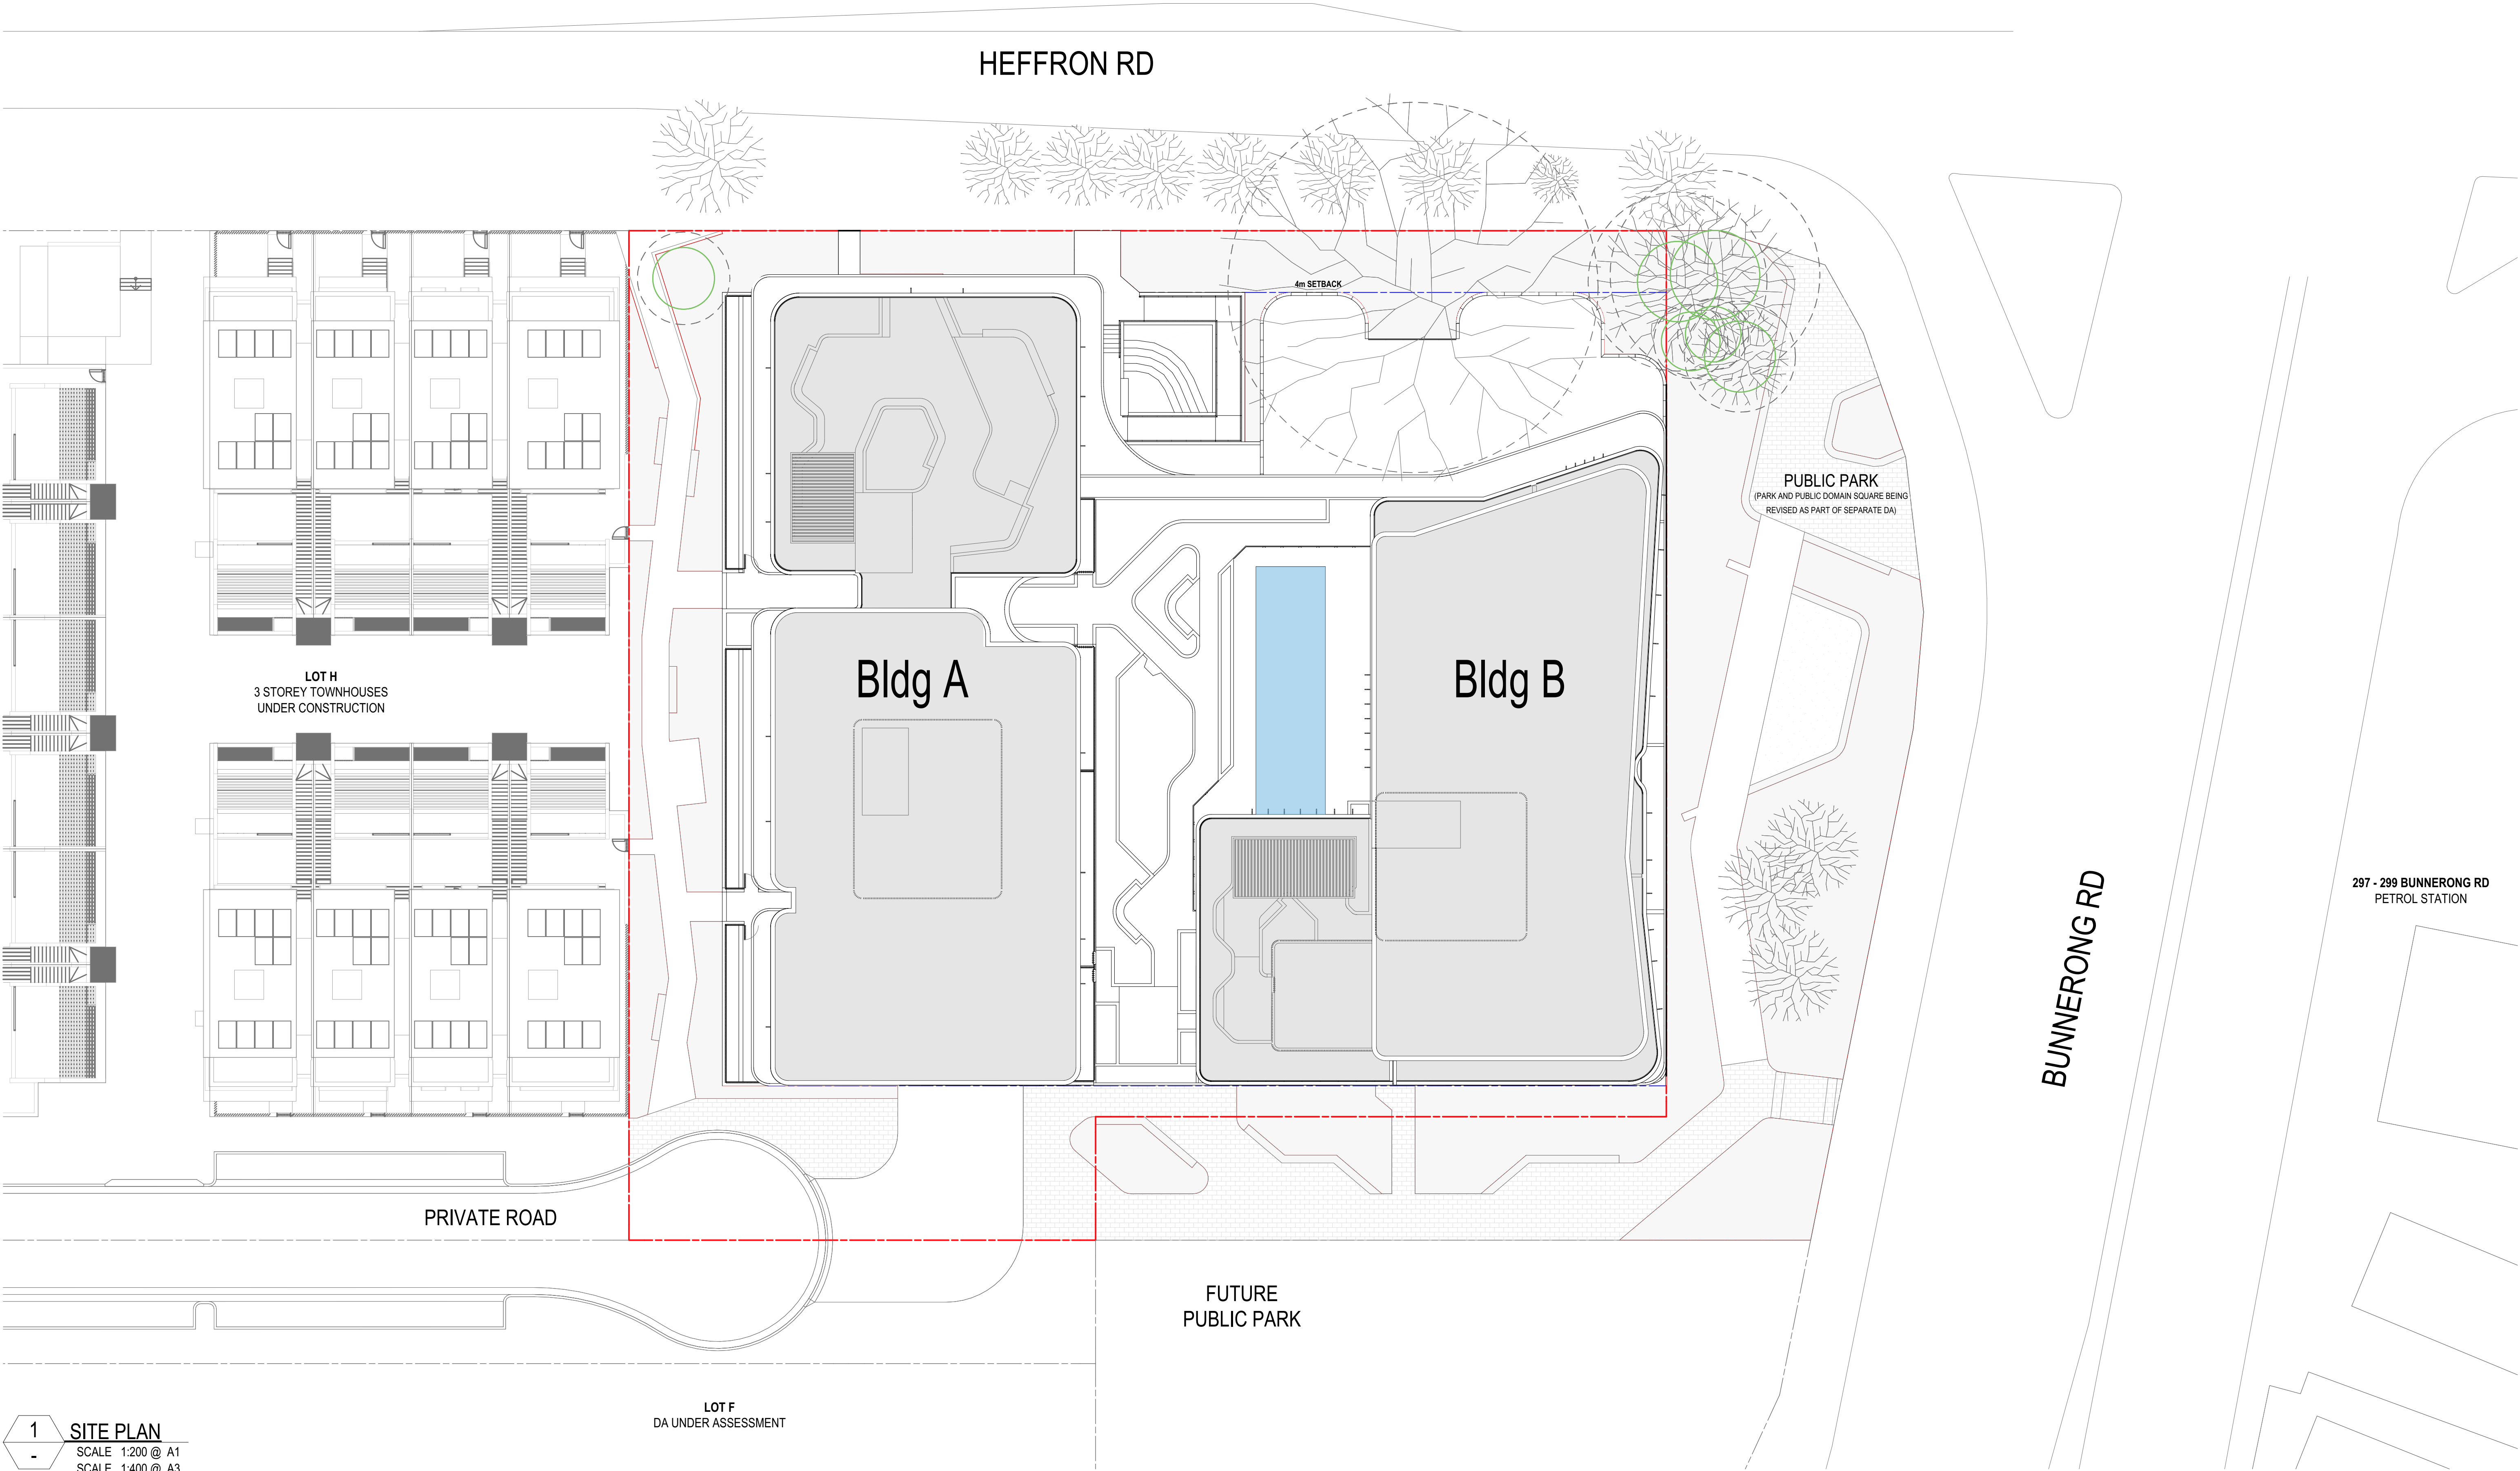

1 SITE PLAN
- SCALE 1:200 @ A1
SCALE 1:400 @ A3

COTTEEPARKER

Sydney
T 61 2 9366 1133
COTTEE PARKER ARCHITECTS PTY LTD
ABN 77 010 924 106
COTTEEPARKER.COM.AU

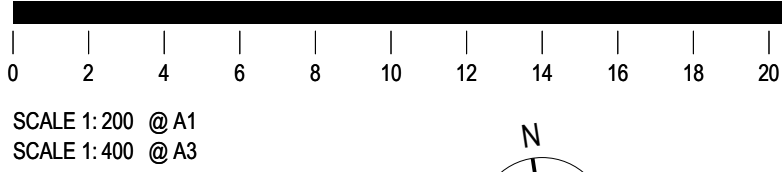

BIMcloud: CPACLBIM01 - BIMcloud/2200/6914 Pagewood Lot H & J 128 Bunnerong Rd Eastgardens DA Master: 22/01/2025: 4:41 PM

MINOR CHANGES TO FORM AND CONFIGURATION MAY BE REQUIRED WHEN DRAWINGS ARE SUBSEQUENTLY PREPARED FOR CONSTRUCTION PURPOSES AFTER THE GRANT OF DEVELOPMENT CONSENT.

D	PRELIMINARY ISSUE	22/01/2025	CPA	TM	AD
C	PRELIMINARY ISSUE	20/12/2024	CPA	TM	AD
B	ISSUE FOR DA	18/06/2024	LA	TJM	ADM
A	ISSUE FOR DA	06/06/2024	LA	TM	TM
DATE	D	C	A		

FOR INFORMATION

JOB No

6914

DRAWING No

SD1004

ISSUE

D

PAGEWOOD LOT J

8 HEFFRON ROAD, EASTGARDENS

CLIENT - Meriton

DRAWING TITLE


SITE PLAN

LEGEND:

RES = RESIDENTIAL
C/S = RESIDENTIAL CARSHARE
VIS = RESIDENTIAL VISITORS
CC PA = CHILDCARE PARENTS
CC ST = CHILDCARE STAFF
MC = MOTORCYCLE
ST = STORAGE

BUILDING A

BUILDING B

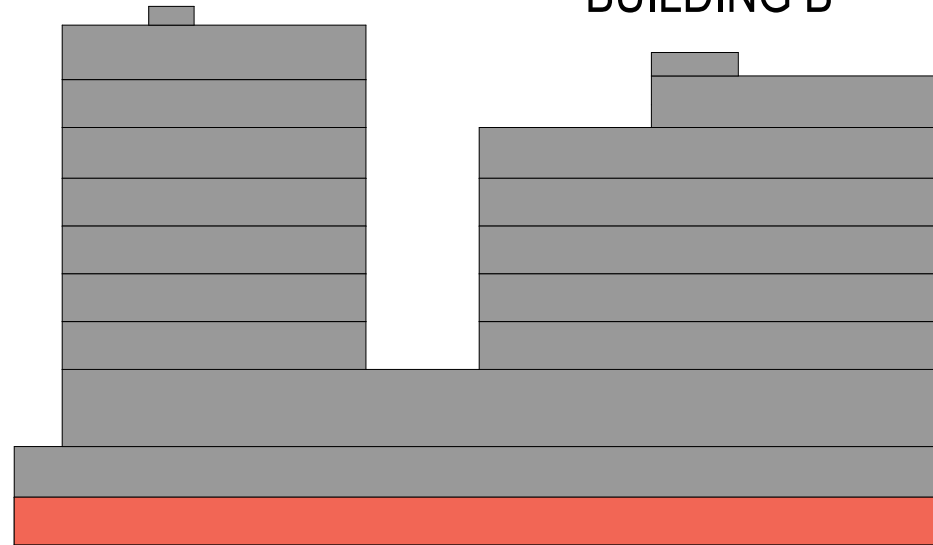


2 KEY SECTION

SCALE @ A1 1:500

1 FLOOR PLAN - BASEMENT 02

SCALE @ A1 1:200

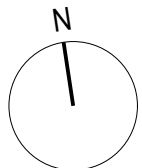


J	RESPONSE TO DRP COMMENTS	28/02/2025	CA	TJM	TJM
I	RESPONSE TO COUNCIL RF1	30/01/2025	BN	TJM	ADM
H	PRELIMINARY ISSUE	23/01/2025	BN	TJM	ADM
G	PRELIMINARY ISSUE	22/01/2025	CPA	TM	AD
F	PRELIMINARY ISSUE	20/01/2025	CPA	TM	AD
E	PRELIMINARY ISSUE	20/01/2025	CPA	TM	AD
D	PRELIMINARY ISSUE	20.12.2024	CPA	TM	AD
C	FOR COORDINATION	25/06/2024	JH	TJM	ADM
B	ISSUE FOR DA	18/06/2024	LA	TJM	ADM
A	ISSUE FOR DA	06/06/2024	LA	TM	TM
ISSUE PURPOSE		DATE	D	C	A


LEGEND:

RES = RESIDENTIAL
C/S = RESIDENTIAL CARSHARE
VIS = RESIDENTIAL VISITORS
CC PA = CHILDCARE PARENTS
CC ST = CHILDCARE STAFF
MC = MOTORCYCLE
ST = STORAGE

 BUILDING A



BUILDING B

 



2 KEY SECTION

SCALE @ A1 1:500

1 FLOOR PLAN - BASEMENT 01

SCALE @ A1 1:200

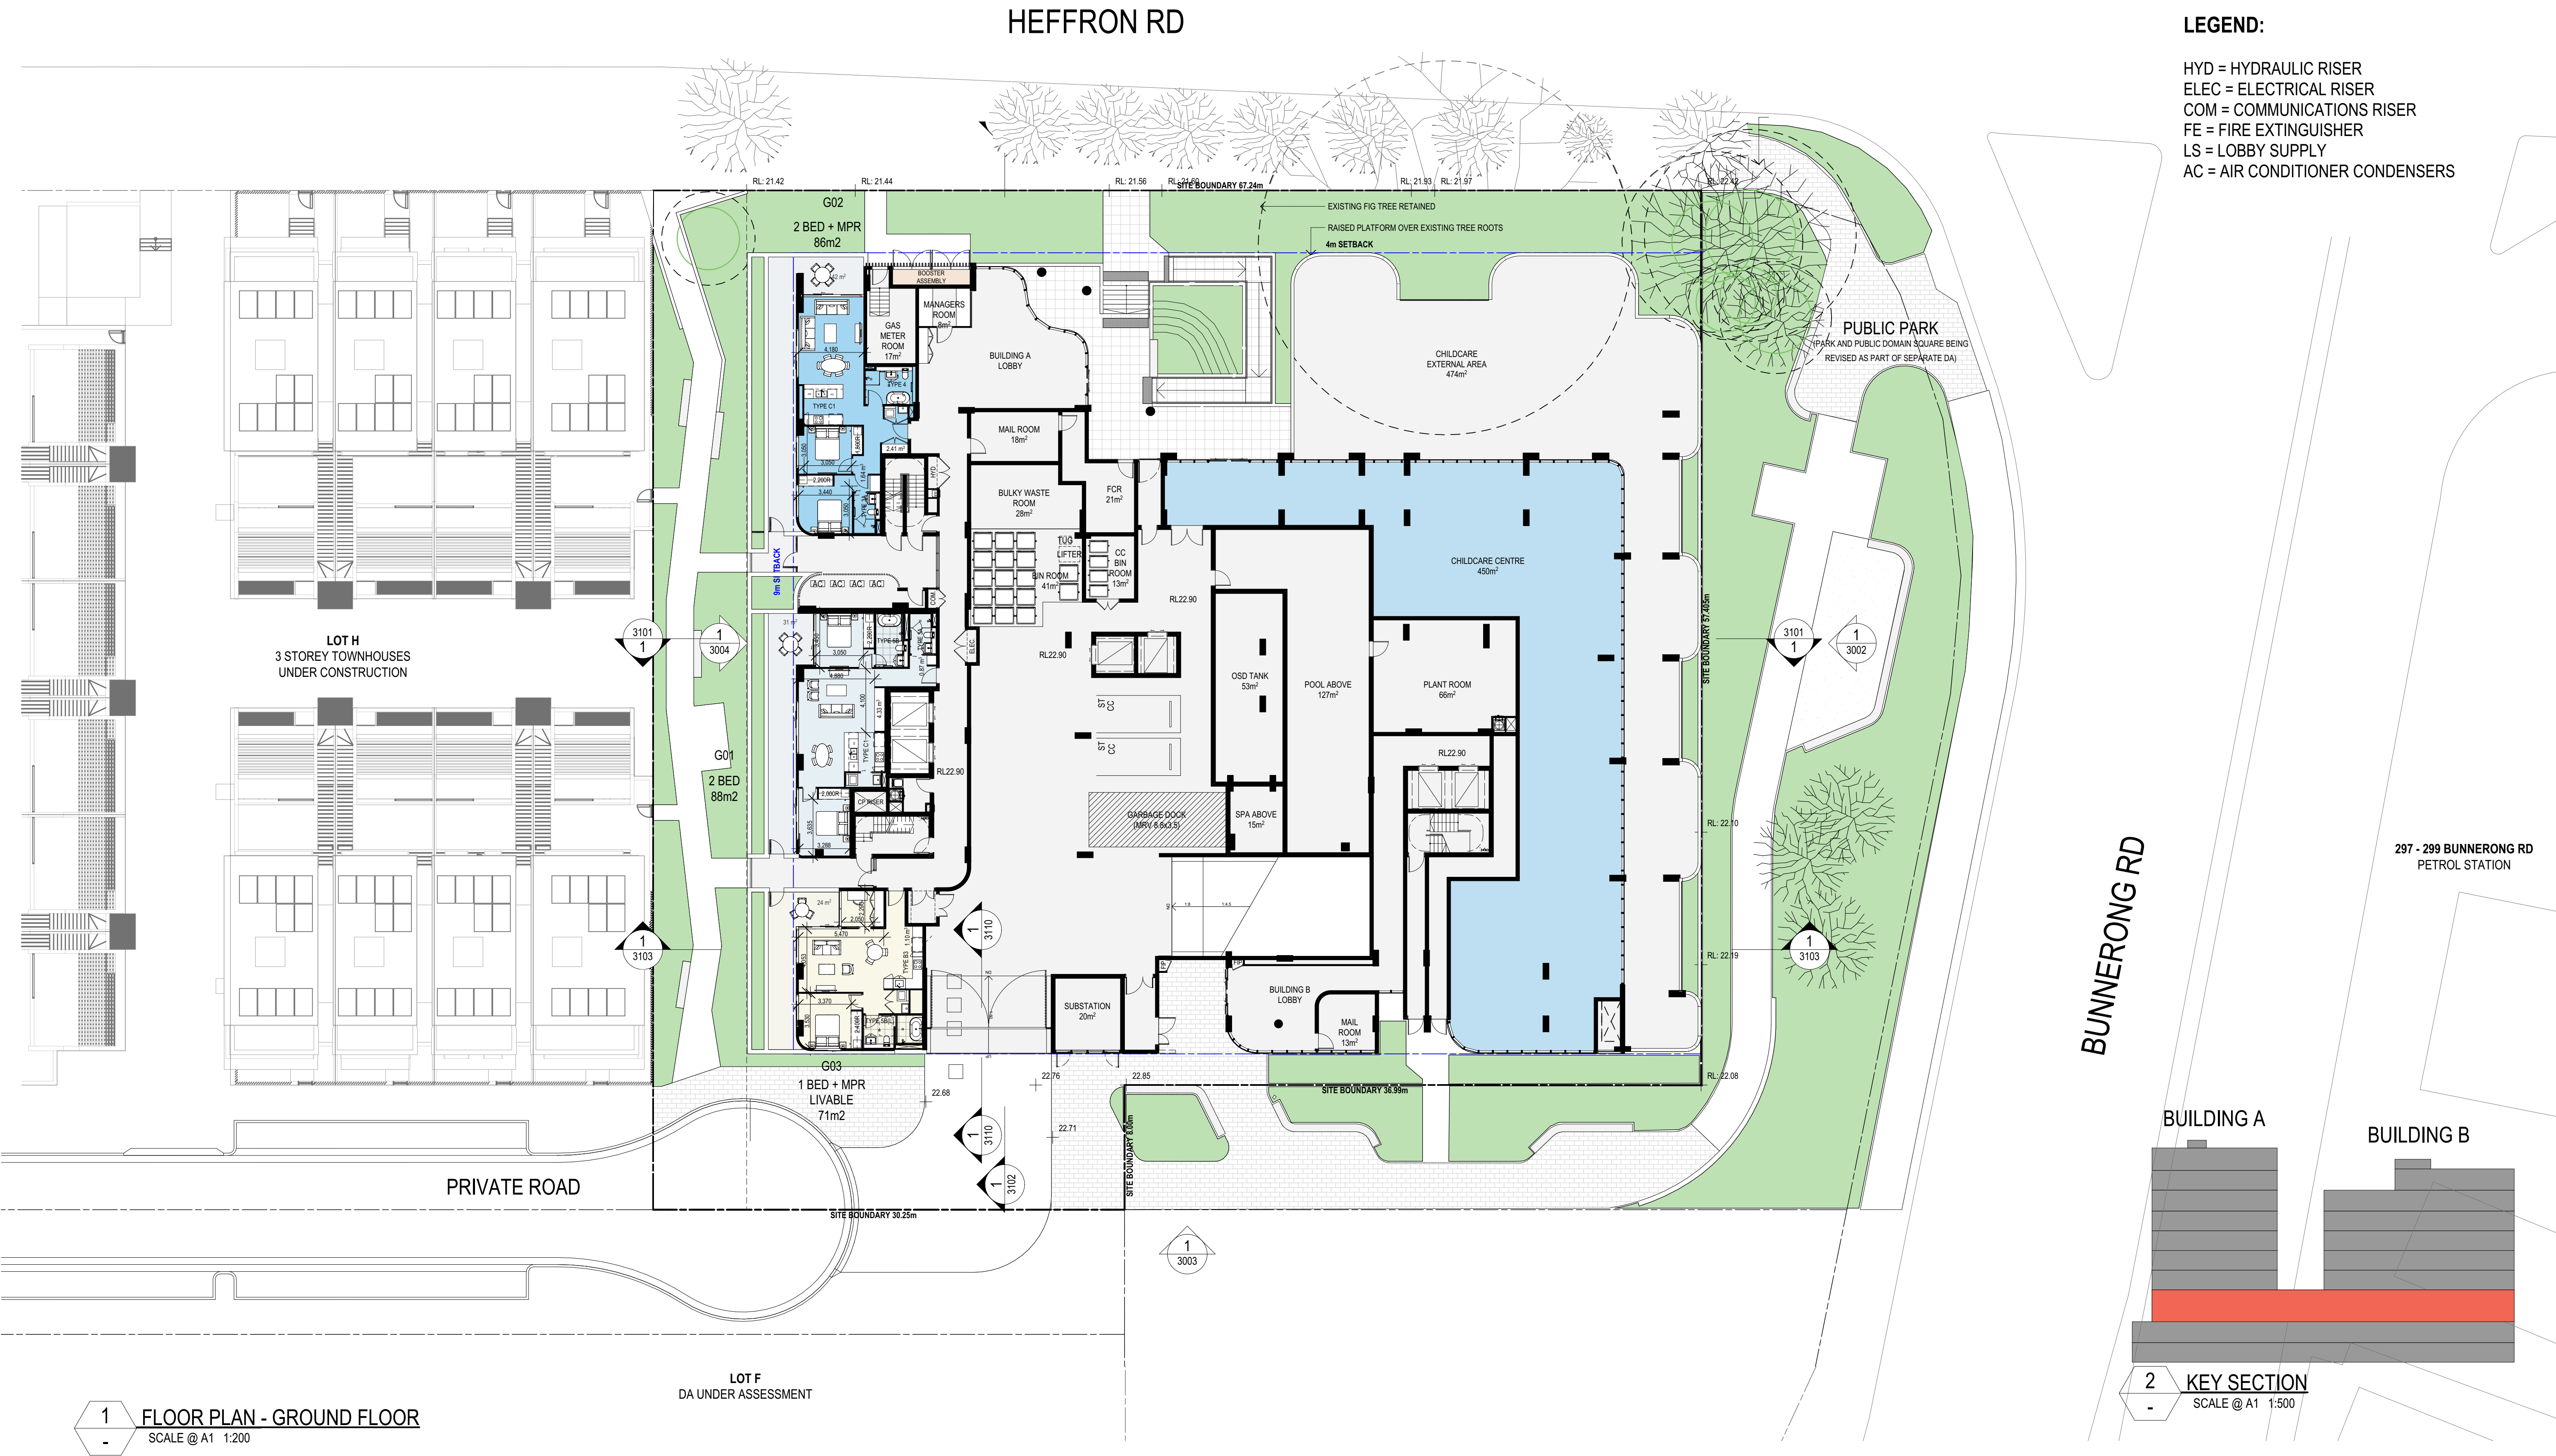


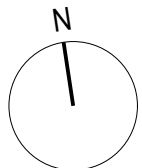


J	RESPONSE TO DRP COMMENTS	04/03/2025	BN	TJM	ADM
I	RESPONSE TO DRP COMMENTS	28/02/2025	CA	TJM	TJM
H	RESPONSE TO COUNCIL RFI	30/01/2025	BN	TJM	ADM
G	PRELIMINARY ISSUE	23/01/2025	BN	TJM	ADM
F	PRELIMINARY ISSUE	22/01/2025	CPA	TM	AD
E	PRELIMINARY ISSUE	17/01/2025	CPA	TM	AD
D	PRELIMINARY ISSUE	20/12/2024	CPA	TM	AD
C	FOR COORDINATION	25/06/2024	JH	TJM	ADM
B	ISSUE FOR DA	18/06/2024	LA	TJM	ADM
A	ISSUE FOR DA	06/06/2024	LA	TM	TM
ISSUE PURPOSE		DATE	D	C	A

LEGEND:

HYD = HYDRAULIC RISER
ELEC = ELECTRICAL RISER
COM = COMMUNICATIONS RISER
FE = FIRE EXTINGUISHER
LS = LOBBY SUPPLY
AC = AIR CONDITIONER CONDENSERS

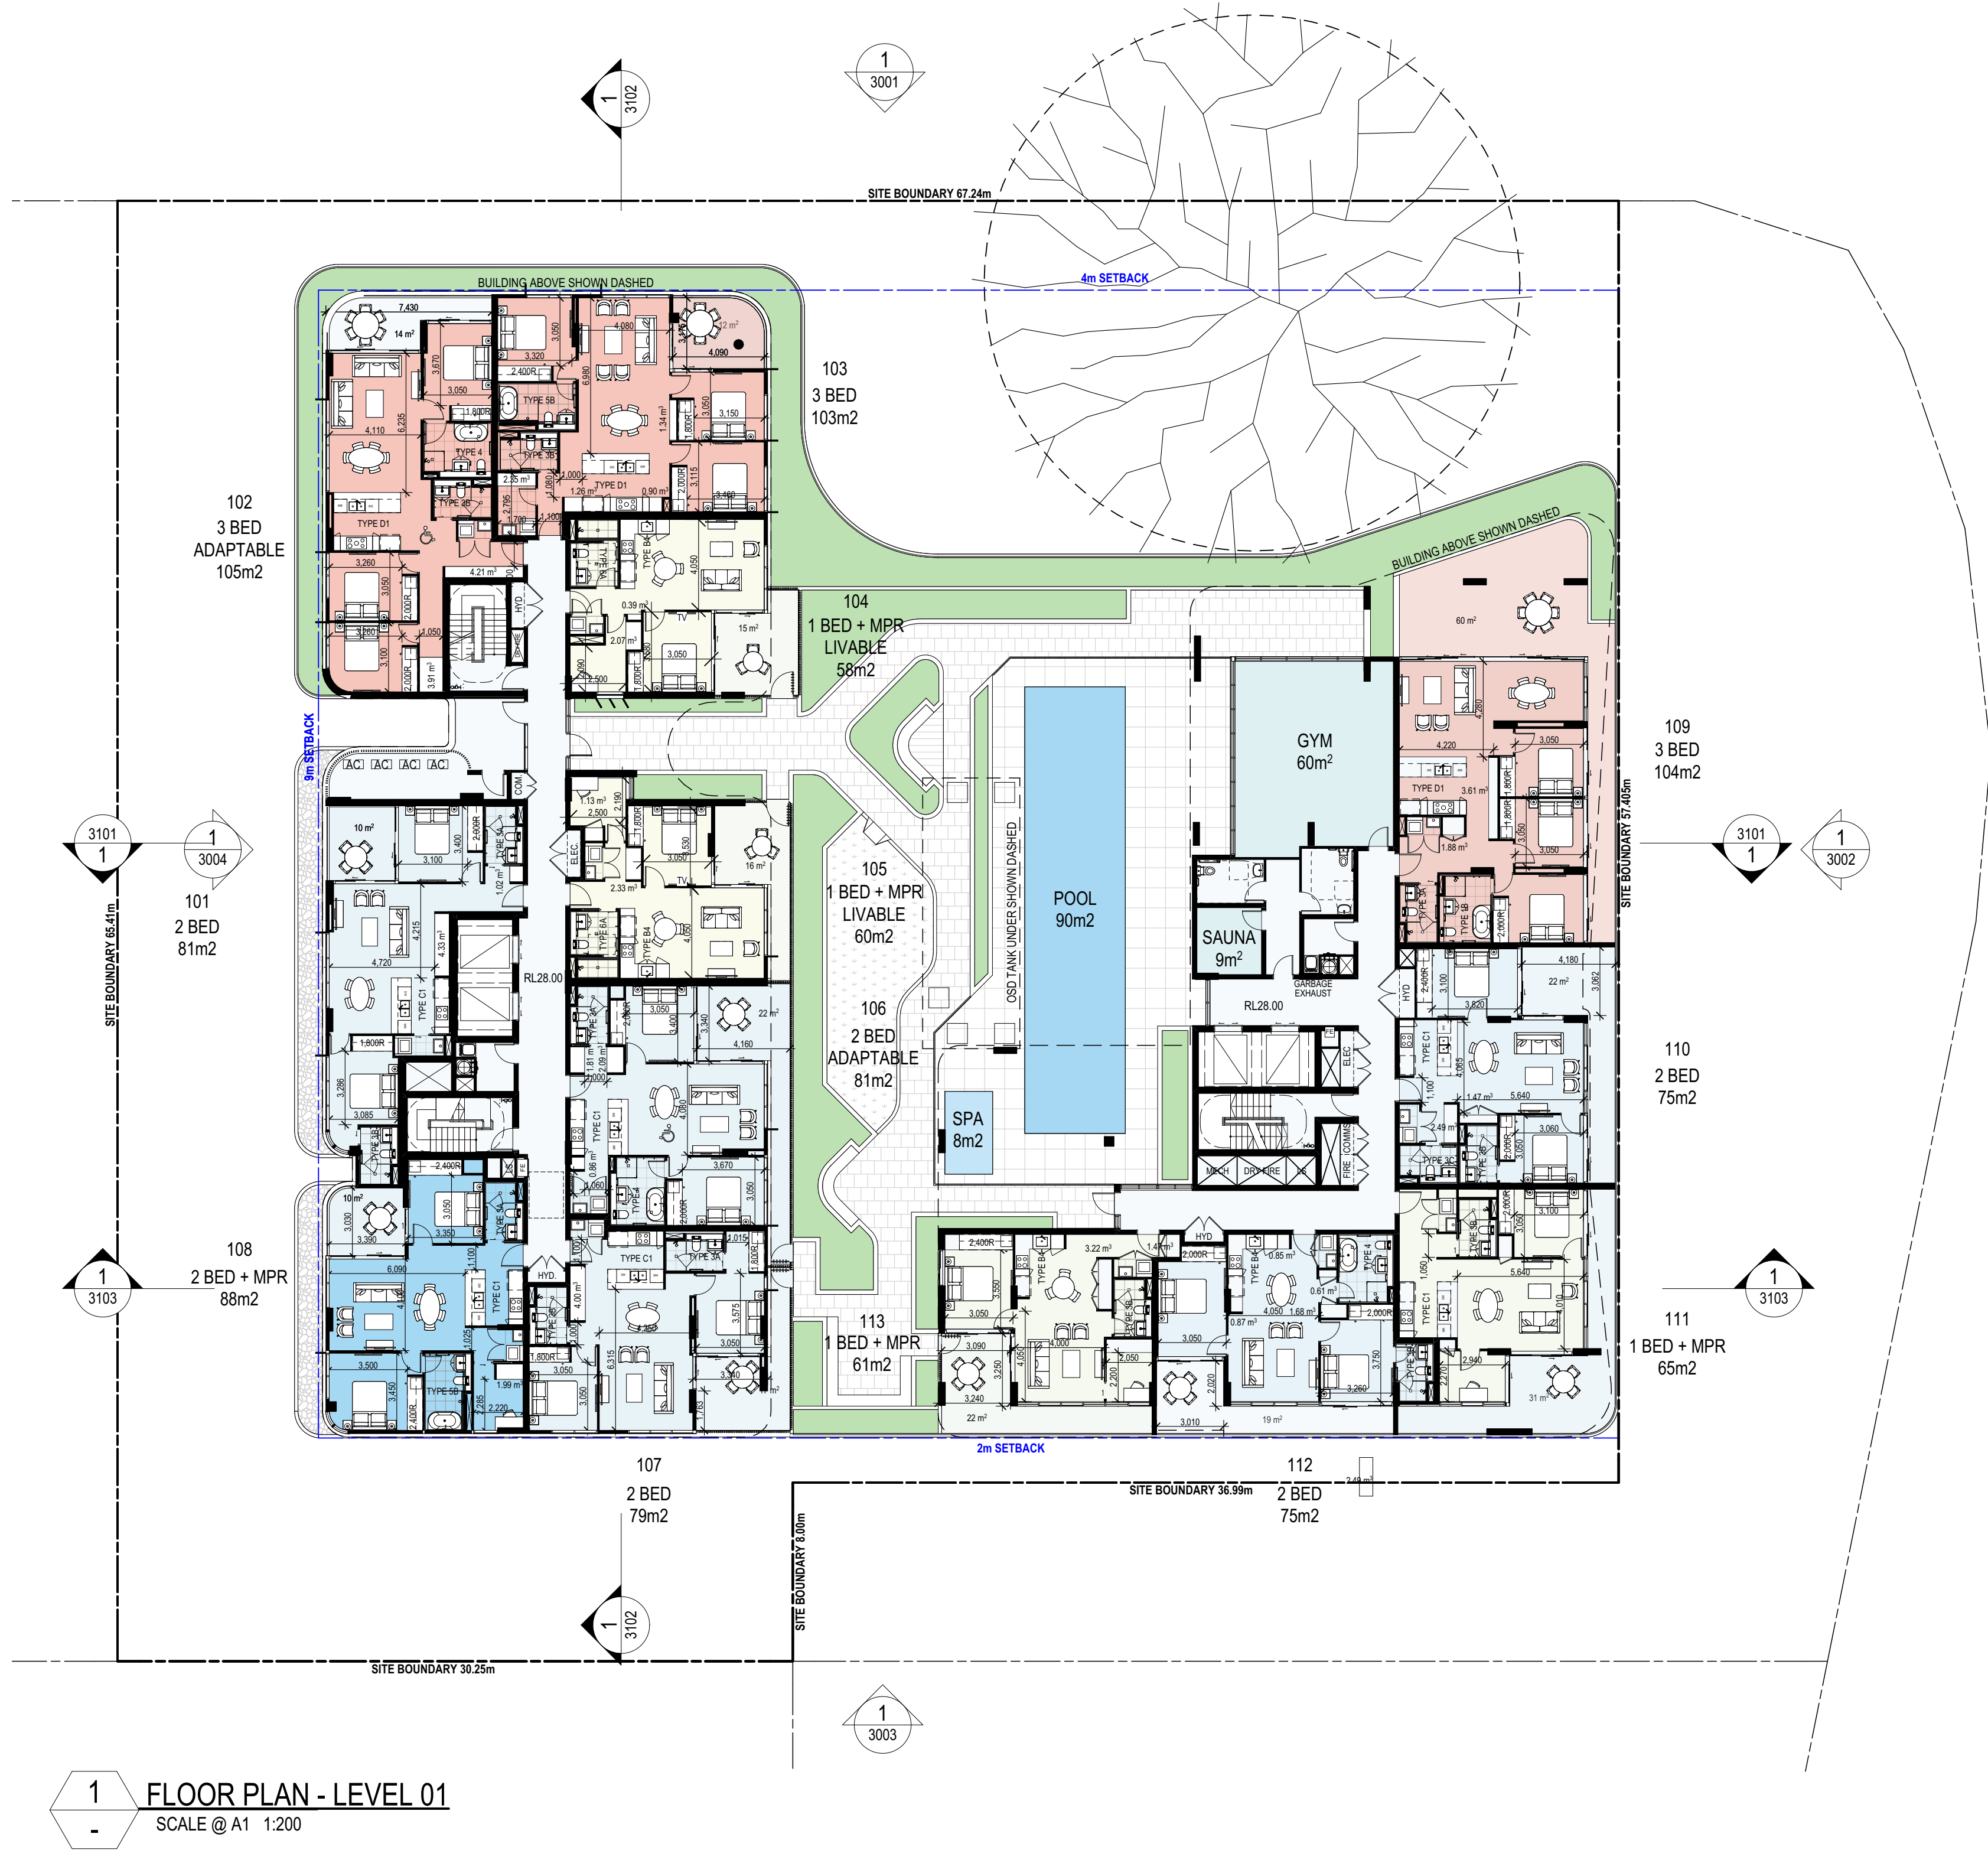


1 FLOOR PLAN - LEVEL 01
SCALE @ A1 1:200

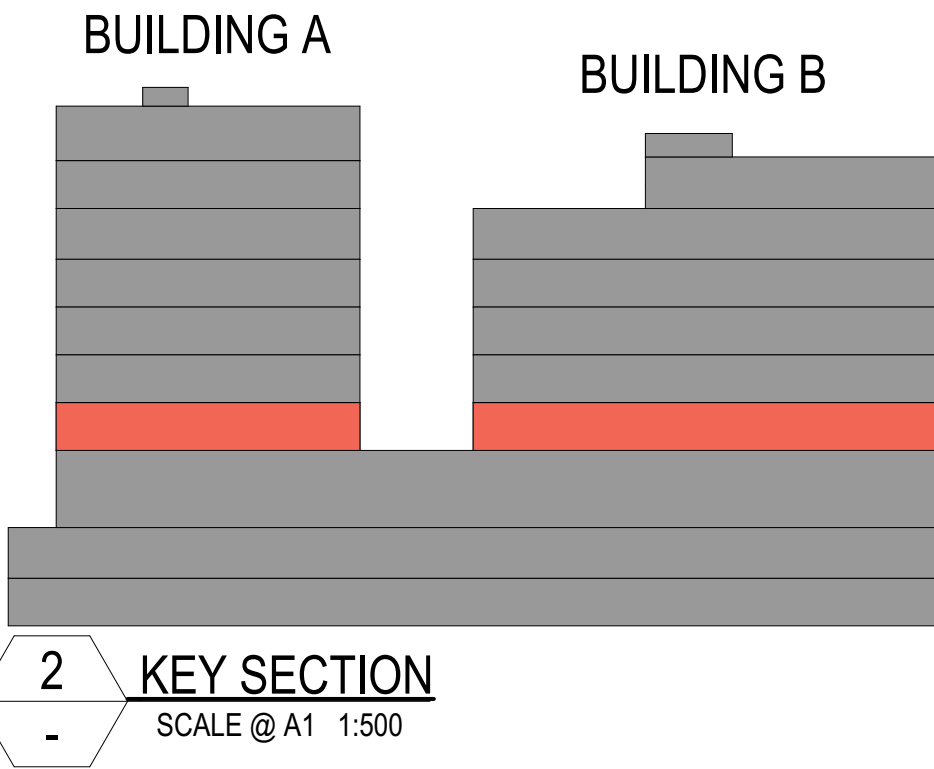

2 KEY SECTION
SCALE @ A1 1:500


LEGEND:

HYD = HYDRAULIC RISER
ELEC = ELECTRICAL RISER
COM = COMMUNICATIONS RISER
FE = FIRE EXTINGUISHER
LS = LOBBY SUPPLY
AC = AIR CONDITIONER CONDENSERS

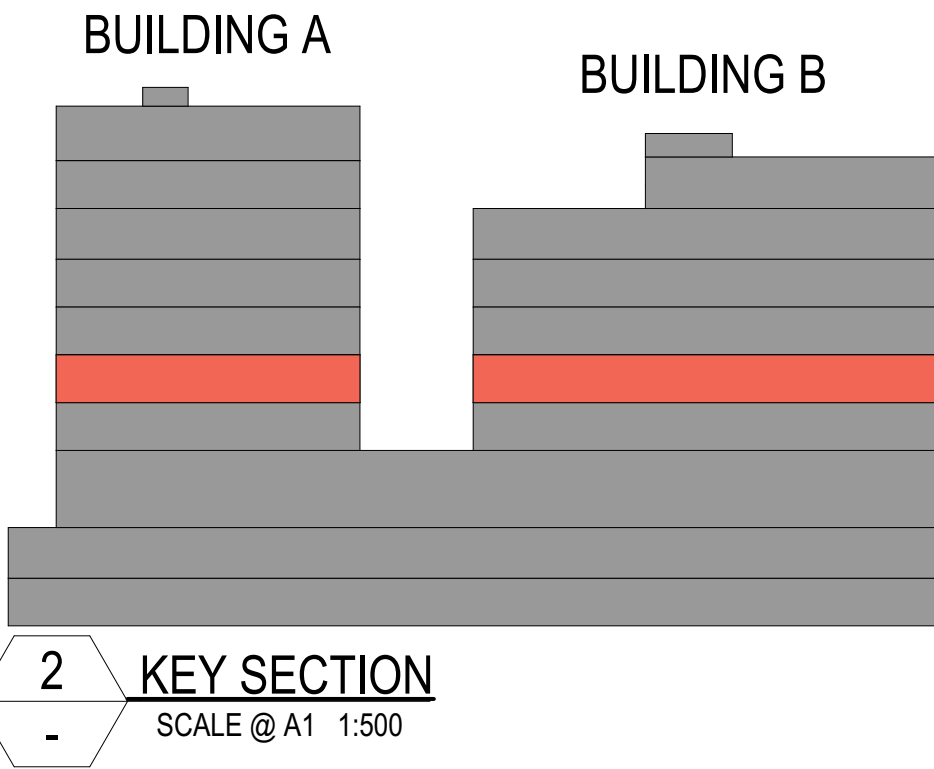

COTTEEPARKER

Sydney
T 61 2 9366 1133
COTTEE PARKER ARCHITECTS PTY LTD
ABN 77 010 924 106
COTTEEPARKER.COM.AU

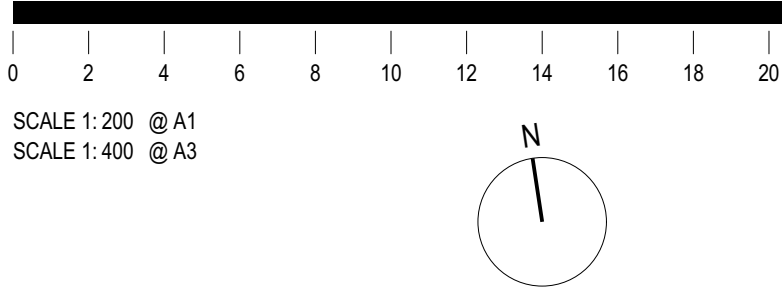

BIMcloud: CPACLBIMM01 - BIMcloud/2200/6914 Pagewood Lot H & J 128 Bunnerong Rd Eastgardens DA Master: 4/03/2025: 3:30 PM

MINOR CHANGES TO FORM AND CONFIGURATION MAY BE REQUIRED WHEN DRAWINGS ARE SUBSEQUENTLY PREPARED FOR CONSTRUCTION PURPOSES AFTER THE GRANT OF DEVELOPMENT CONSENT.

J	RESPONSE TO DRP COMMENTS	04/03/2025	BN	TJM	ADM
I	RESPONSE TO DRP COMMENTS	28/02/2025	CA	TJM	TJM
H	RESPONSE TO COUNCIL RFI	30/01/2025	BN	TJM	ADM
G	PRELIMINARY ISSUE	23/01/2025	BN	TJM	ADM
F	PRELIMINARY ISSUE	22/01/2025	CPA	TM	ADM
E	PRELIMINARY ISSUE	17/01/2025	CPA	TM	ADM
D	PRELIMINARY ISSUE	20/12/2024	CPA	TM	ADM
C	FOR COORDINATION	25/06/2024	JH	TJM	ADM
B	ISSUE FOR DA	18/06/2024	LA	TJM	ADM
A	ISSUE FOR DA	06/06/2024	LA	TM	TM
DATE	D	C	A		

FOR INFORMATION

PAGEWOOD LOT J

8 HEFFRON ROAD, EASTGARDENS

CLIENT - Meriton

DRAWING TITLE

FLOOR PLAN - LEVEL 02

JOB No

6914

DRAWING No



SD2106

ISSUE

J

LEGEND:


HYD = HYDRAULIC RISER
ELEC = ELECTRICAL RISER
COM = COMMUNICATIONS RISER
FE = FIRE EXTINGUISHER
LS = LOBBY SUPPLY
AC = AIR CONDITIONER CONDENSERS

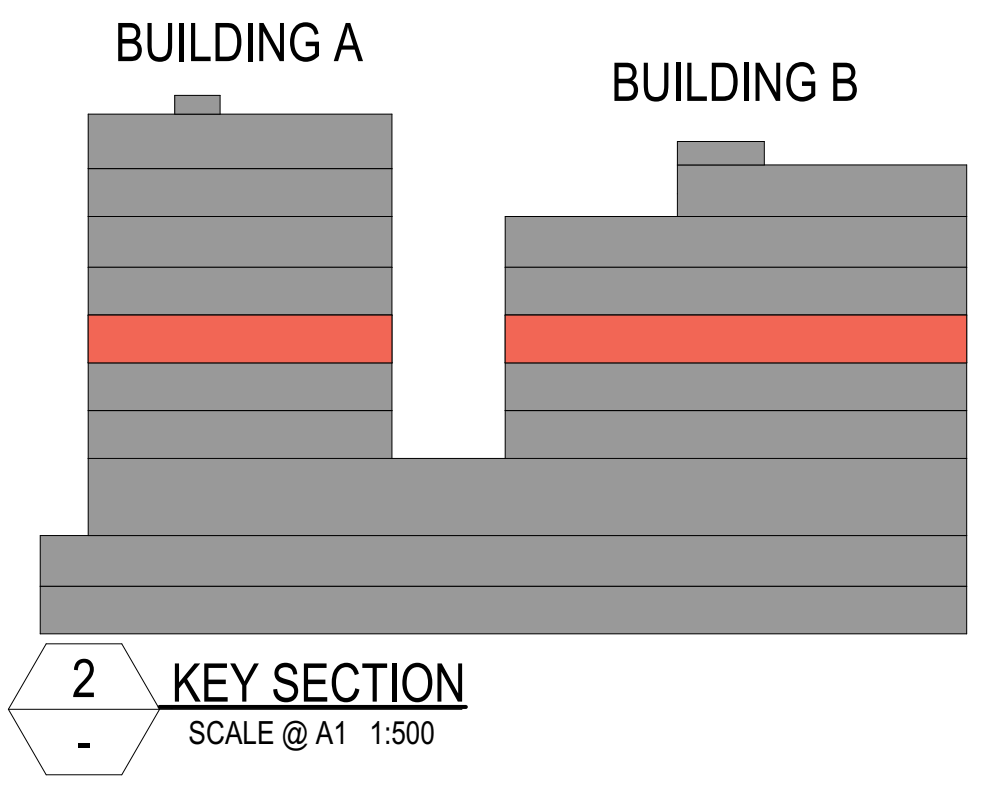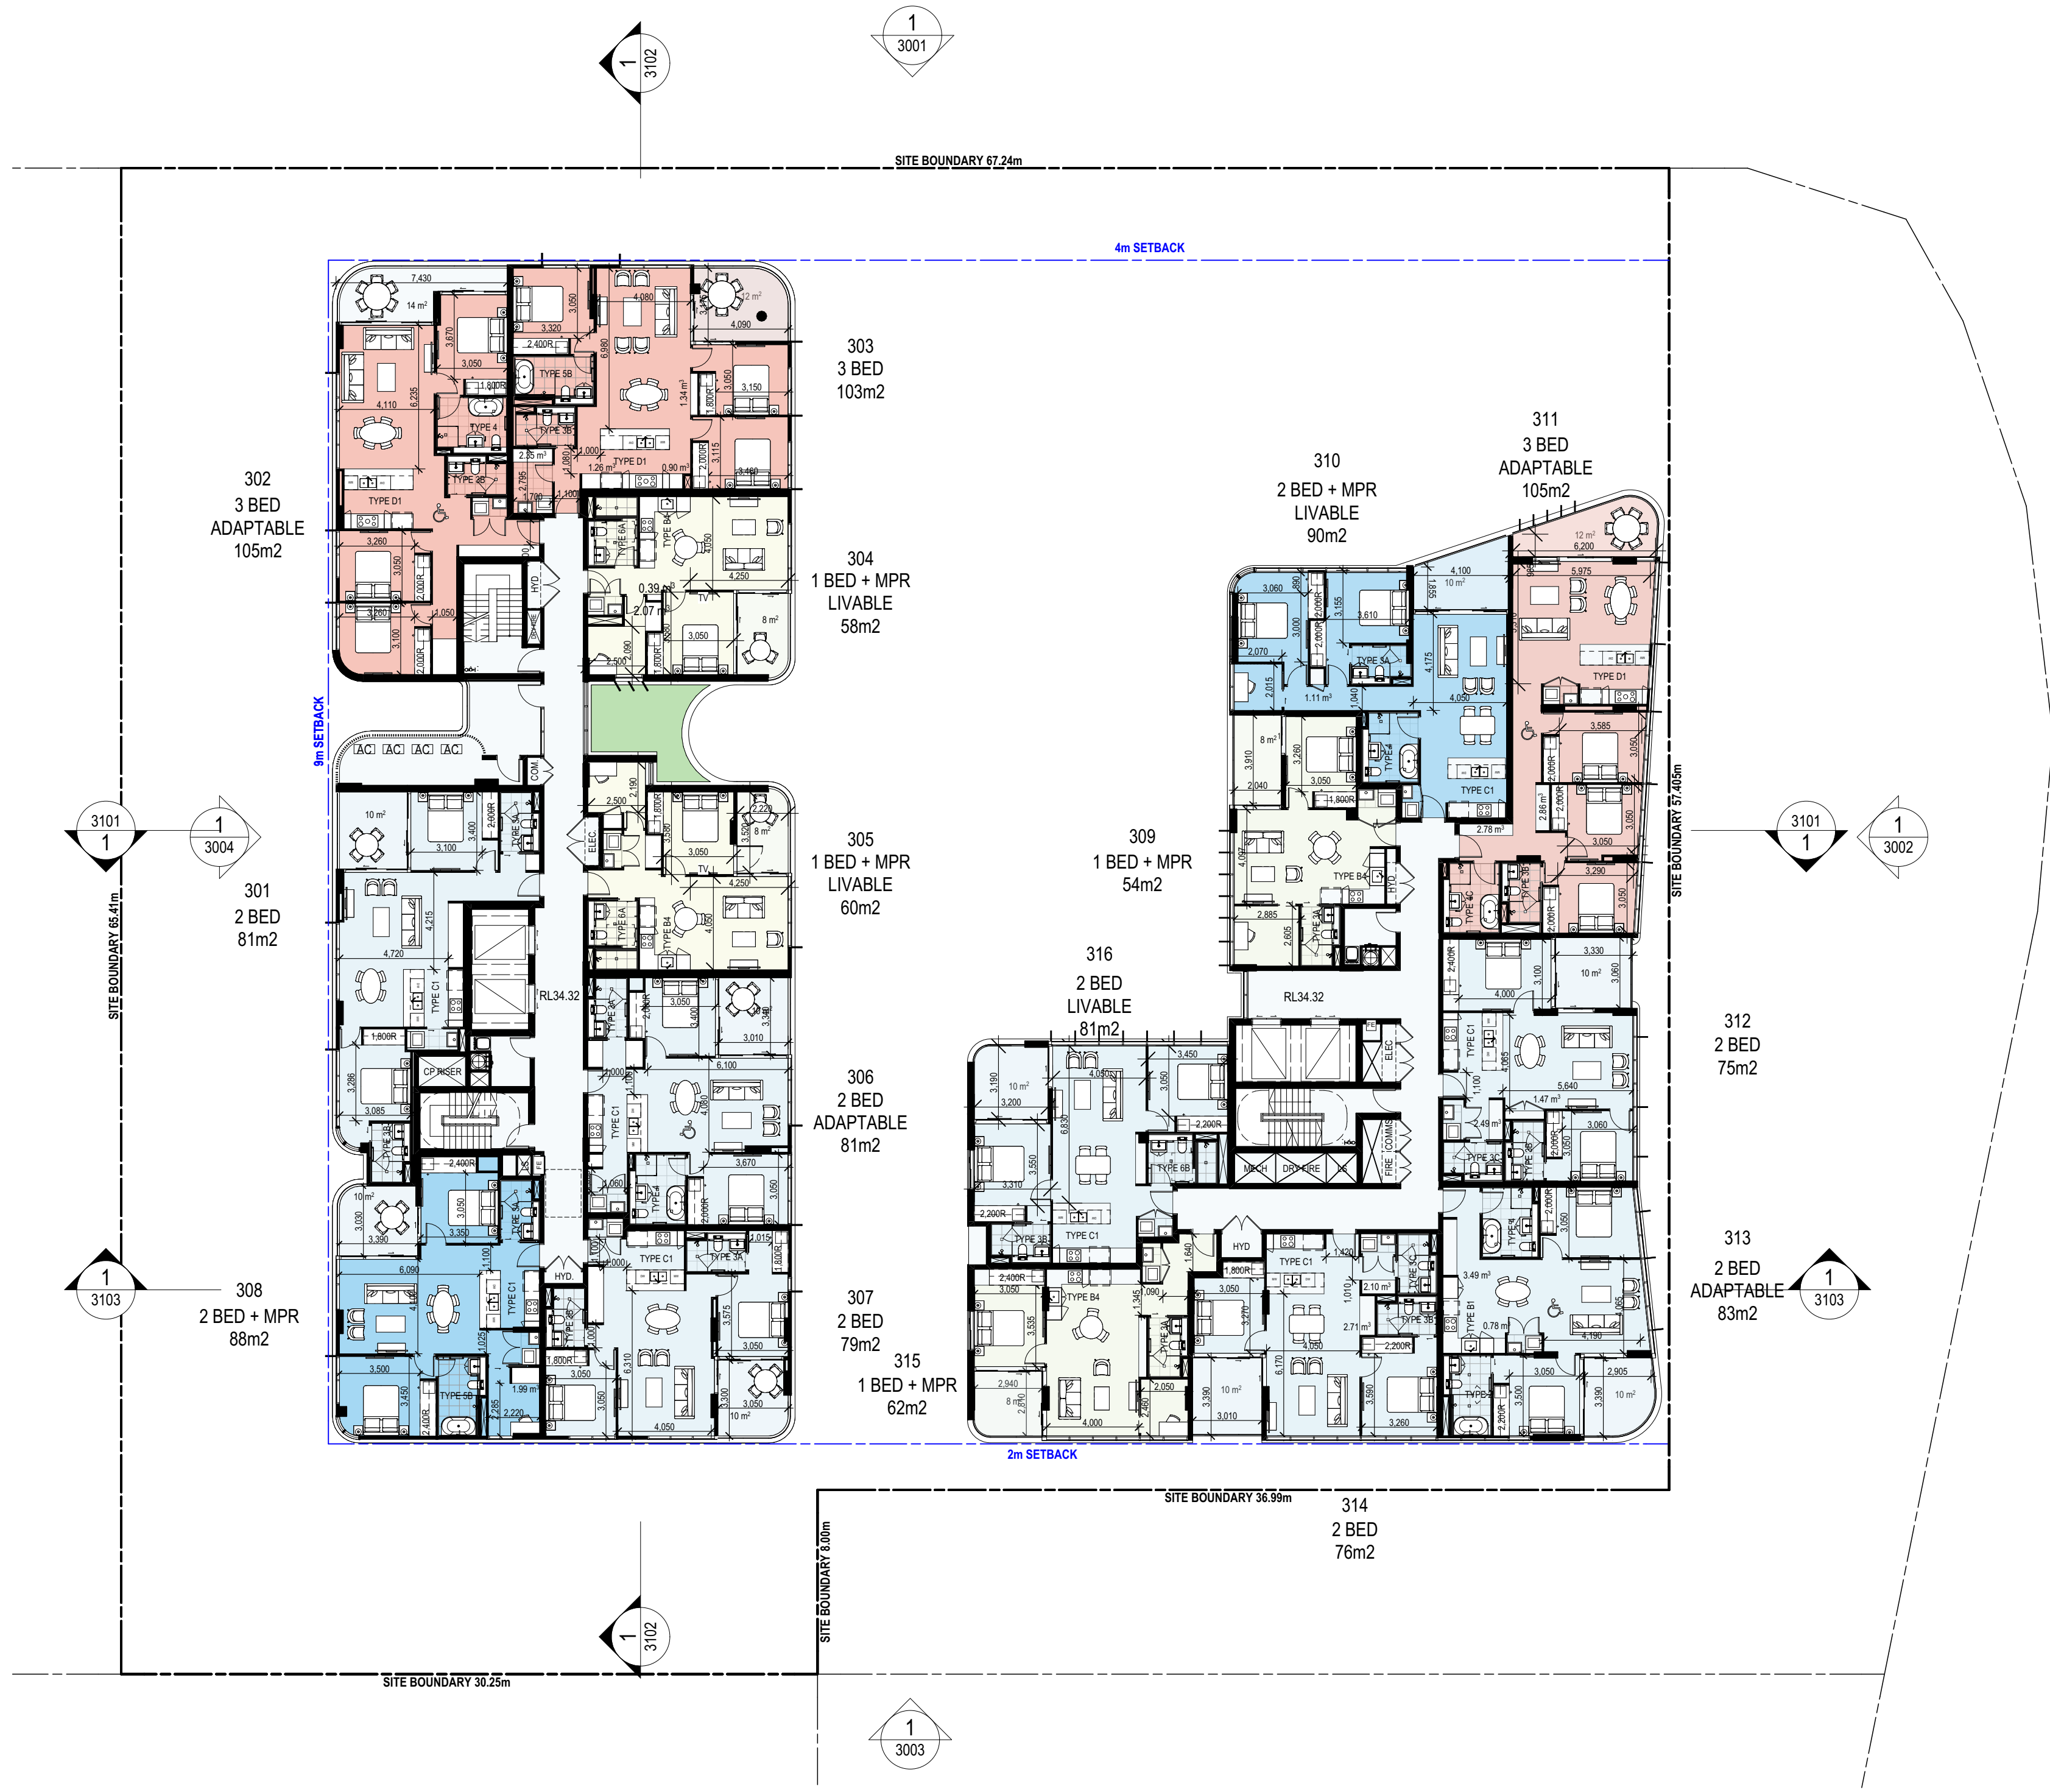

1 FLOOR PLAN - LEVEL 03
SCALE @ A1 1:200

COTTEEPARKER 

Sydney
T 61 2 9366 1133
COTTEEPARKER ARCHITECTS PTY LTD
ABN 77 010 924 106
COTTEEPARKER.COM.AU

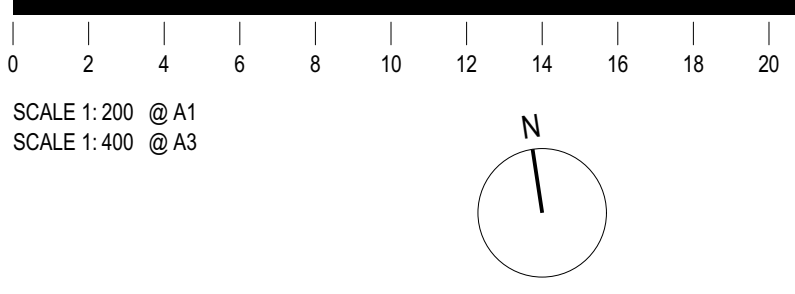

MINOR CHANGES TO FORM AND CONFIGURATION MAY BE REQUIRED WHEN DRAWINGS ARE SUBSEQUENTLY PREPARED FOR CONSTRUCTION PURPOSES AFTER THE GRANT OF DEVELOPMENT CONSENT.


J	RESPONSE TO DRP COMMENTS	04/03/2025	BN	TJM	ADM
I	RESPONSE TO DRP COMMENTS	28/02/2025	CA	TJM	TJM
H	RESPONSE TO COUNCIL RFI	30/01/2025	BN	TJM	ADM
G	PRELIMINARY ISSUE	23/01/2025	BN	TJM	ADM
F	PRELIMINARY ISSUE	22/01/2025	CPA	TM	ADM
E	PRELIMINARY ISSUE	17/01/2025	CPA	TM	ADM
D	PRELIMINARY ISSUE	20/12/2024	CPA	TM	ADM
C	FOR COORDINATION	25/06/2024	JH	TJM	ADM
B	ISSUE FOR DA	18/06/2024	LA	TJM	ADM
A	ISSUE FOR DA	06/06/2024	LA	TM	TM
ISSUE PURPOSE	DATE	D	C	A	

FOR INFORMATION

PAGEWOOD LOT J
8 HEFFRON ROAD, EASTGARDENS
CLIENT - Meriton
DRAWING TITLE
FLOOR PLAN - LEVEL 03
JOB No 6914
SD2107
J


LEGEND:

HYD = HYDRAULIC RISER
ELEC = ELECTRICAL RISER
COM = COMMUNICATIONS RISER
FE = FIRE EXTINGUISHER
LS = LOBBY SUPPLY
AC = AIR CONDITIONER CONDENSERS

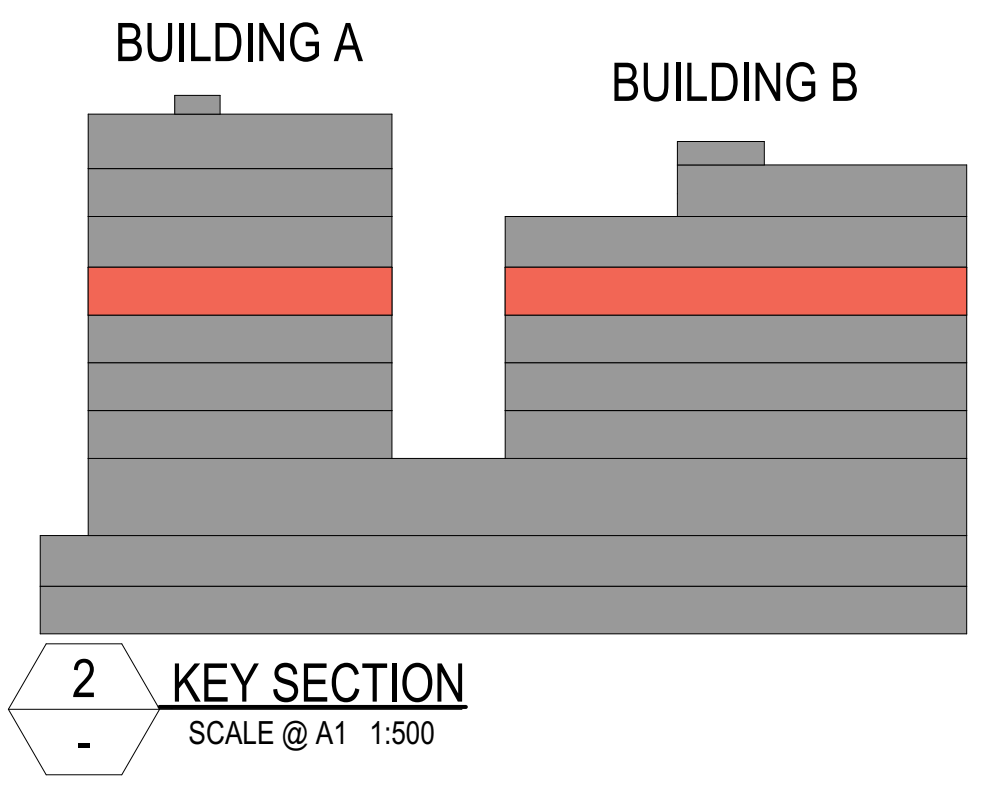


LEGEND:

HYD = HYDRAULIC RISER
ELEC = ELECTRICAL RISER
COM = COMMUNICATIONS RISER
FE = FIRE EXTINGUISHER
LS = LOBBY SUPPLY
AC = AIR CONDITIONER CONDENSERS

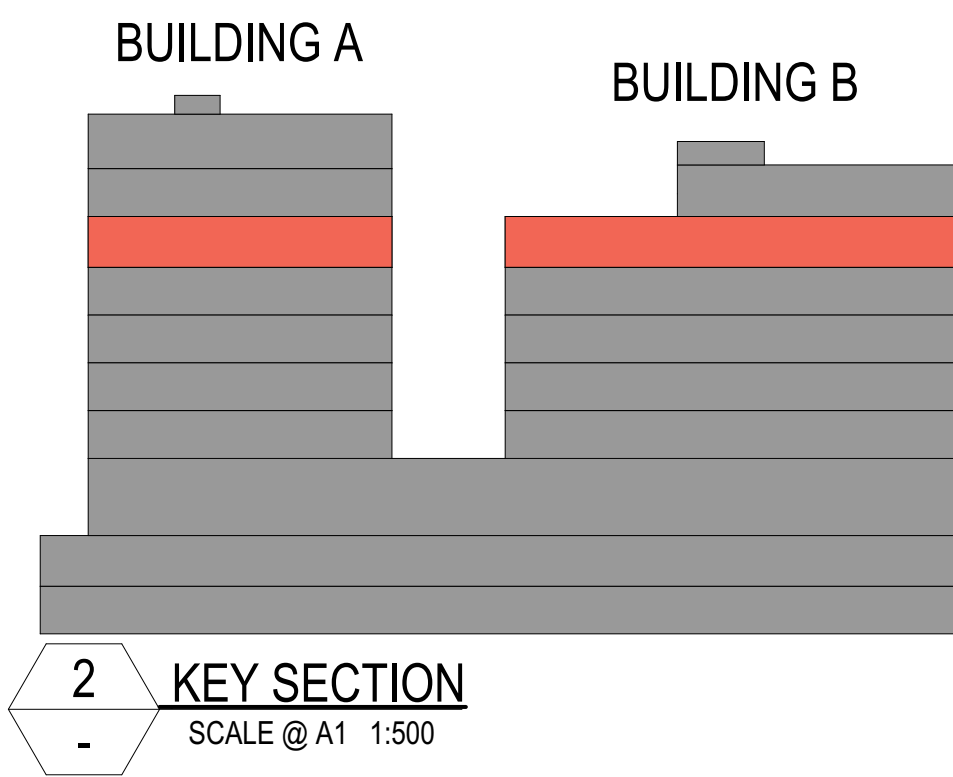


LEGEND:

HYD = HYDRAULIC RISER
ELEC = ELECTRICAL RISER
COM = COMMUNICATIONS RISER
FE = FIRE EXTINGUISHER
LS = LOBBY SUPPLY
AC = AIR CONDITIONER CONDENSERS

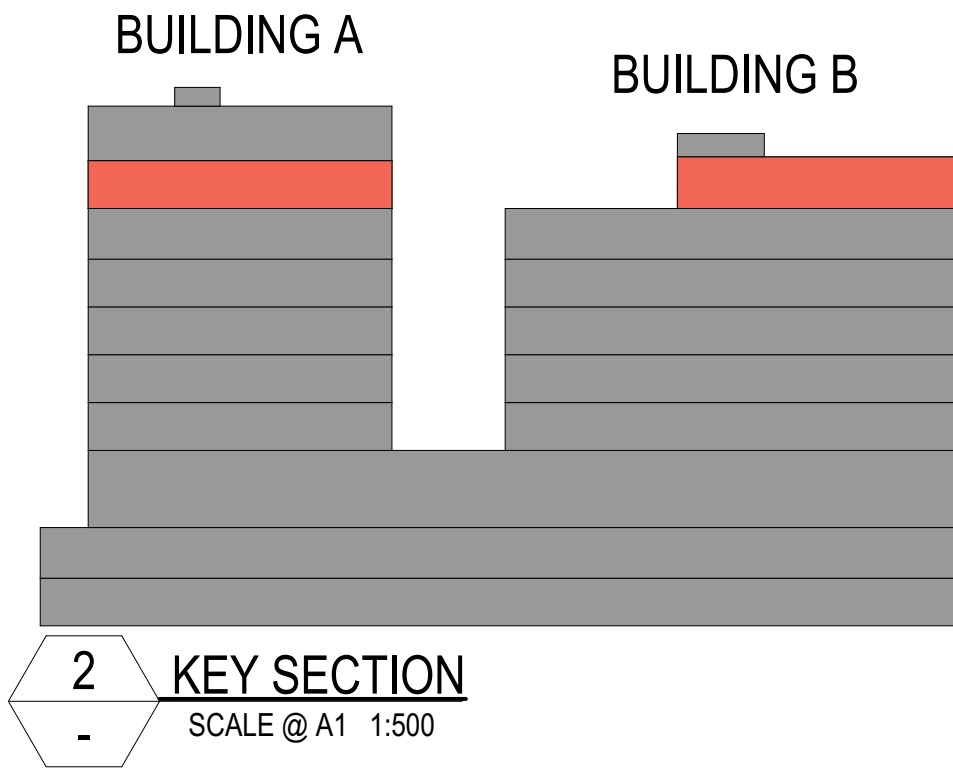

COTTEEPARKER

Sydney
T 61 2 9366 1133
COTTEE PARKER ARCHITECTS PTY LTD
ABN 77 010 924 106
COTTEEPARKER.COM.AU

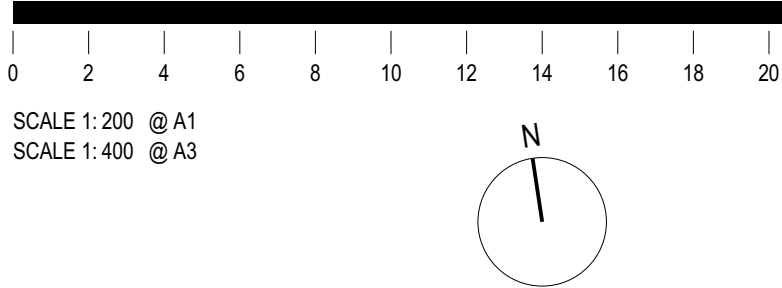

BIMcloud: CPACLBIMM01 - BIMcloud/2200/6914 Pagewood Lot H & J 128 Bunnerong Rd Eastgardens DA Master: 28/02/2025: 4:41 PM

MINOR CHANGES TO FORM AND CONFIGURATION MAY BE REQUIRED WHEN DRAWINGS ARE SUBSEQUENTLY PREPARED FOR CONSTRUCTION PURPOSES AFTER THE GRANT OF DEVELOPMENT CONSENT.

J	RESPONSE TO DRP COMMENTS	28/02/2025	CA	TJM	TJM
I	FOR COORDINATION	24/02/2025	CA	TJM	TJM
H	RESPONSE TO COUNCIL RFI	30/01/2025	BN	TJM	ADM
G	PRELIMINARY ISSUE	23/01/2025	BN	TJM	ADM
F	PRELIMINARY ISSUE	22/01/2025	CPA	TM	AD
E	PRELIMINARY ISSUE	17/01/2025	CPA	TM	AD
D	PRELIMINARY ISSUE	20/12/2024	CPA	TM	AD
C	FOR COORDINATION	25/06/2024	JH	TJM	ADM
B	ISSUE FOR DA	18/06/2024	LA	TJM	ADM
A	ISSUE FOR DA	06/06/2024	LA	TM	TM
DATE	D	C	A		

FOR INFORMATION

PAGEWOOD LOT J

8 HEFFRON ROAD, EASTGARDENS

CLIENT - Meriton

DRAWING TITLE

FLOOR PLAN - LEVEL 06

JOB No

6914

DRAWING No


SD2110

ISSUE


J

LEGEND:

HYD = HYDRAULIC RISER
ELEC = ELECTRICAL RISER
COM = COMMUNICATIONS RISER
FE = FIRE EXTINGUISHER
LS = LOBBY SUPPLY
AC = AIR CONDITIONER CONDENSERS

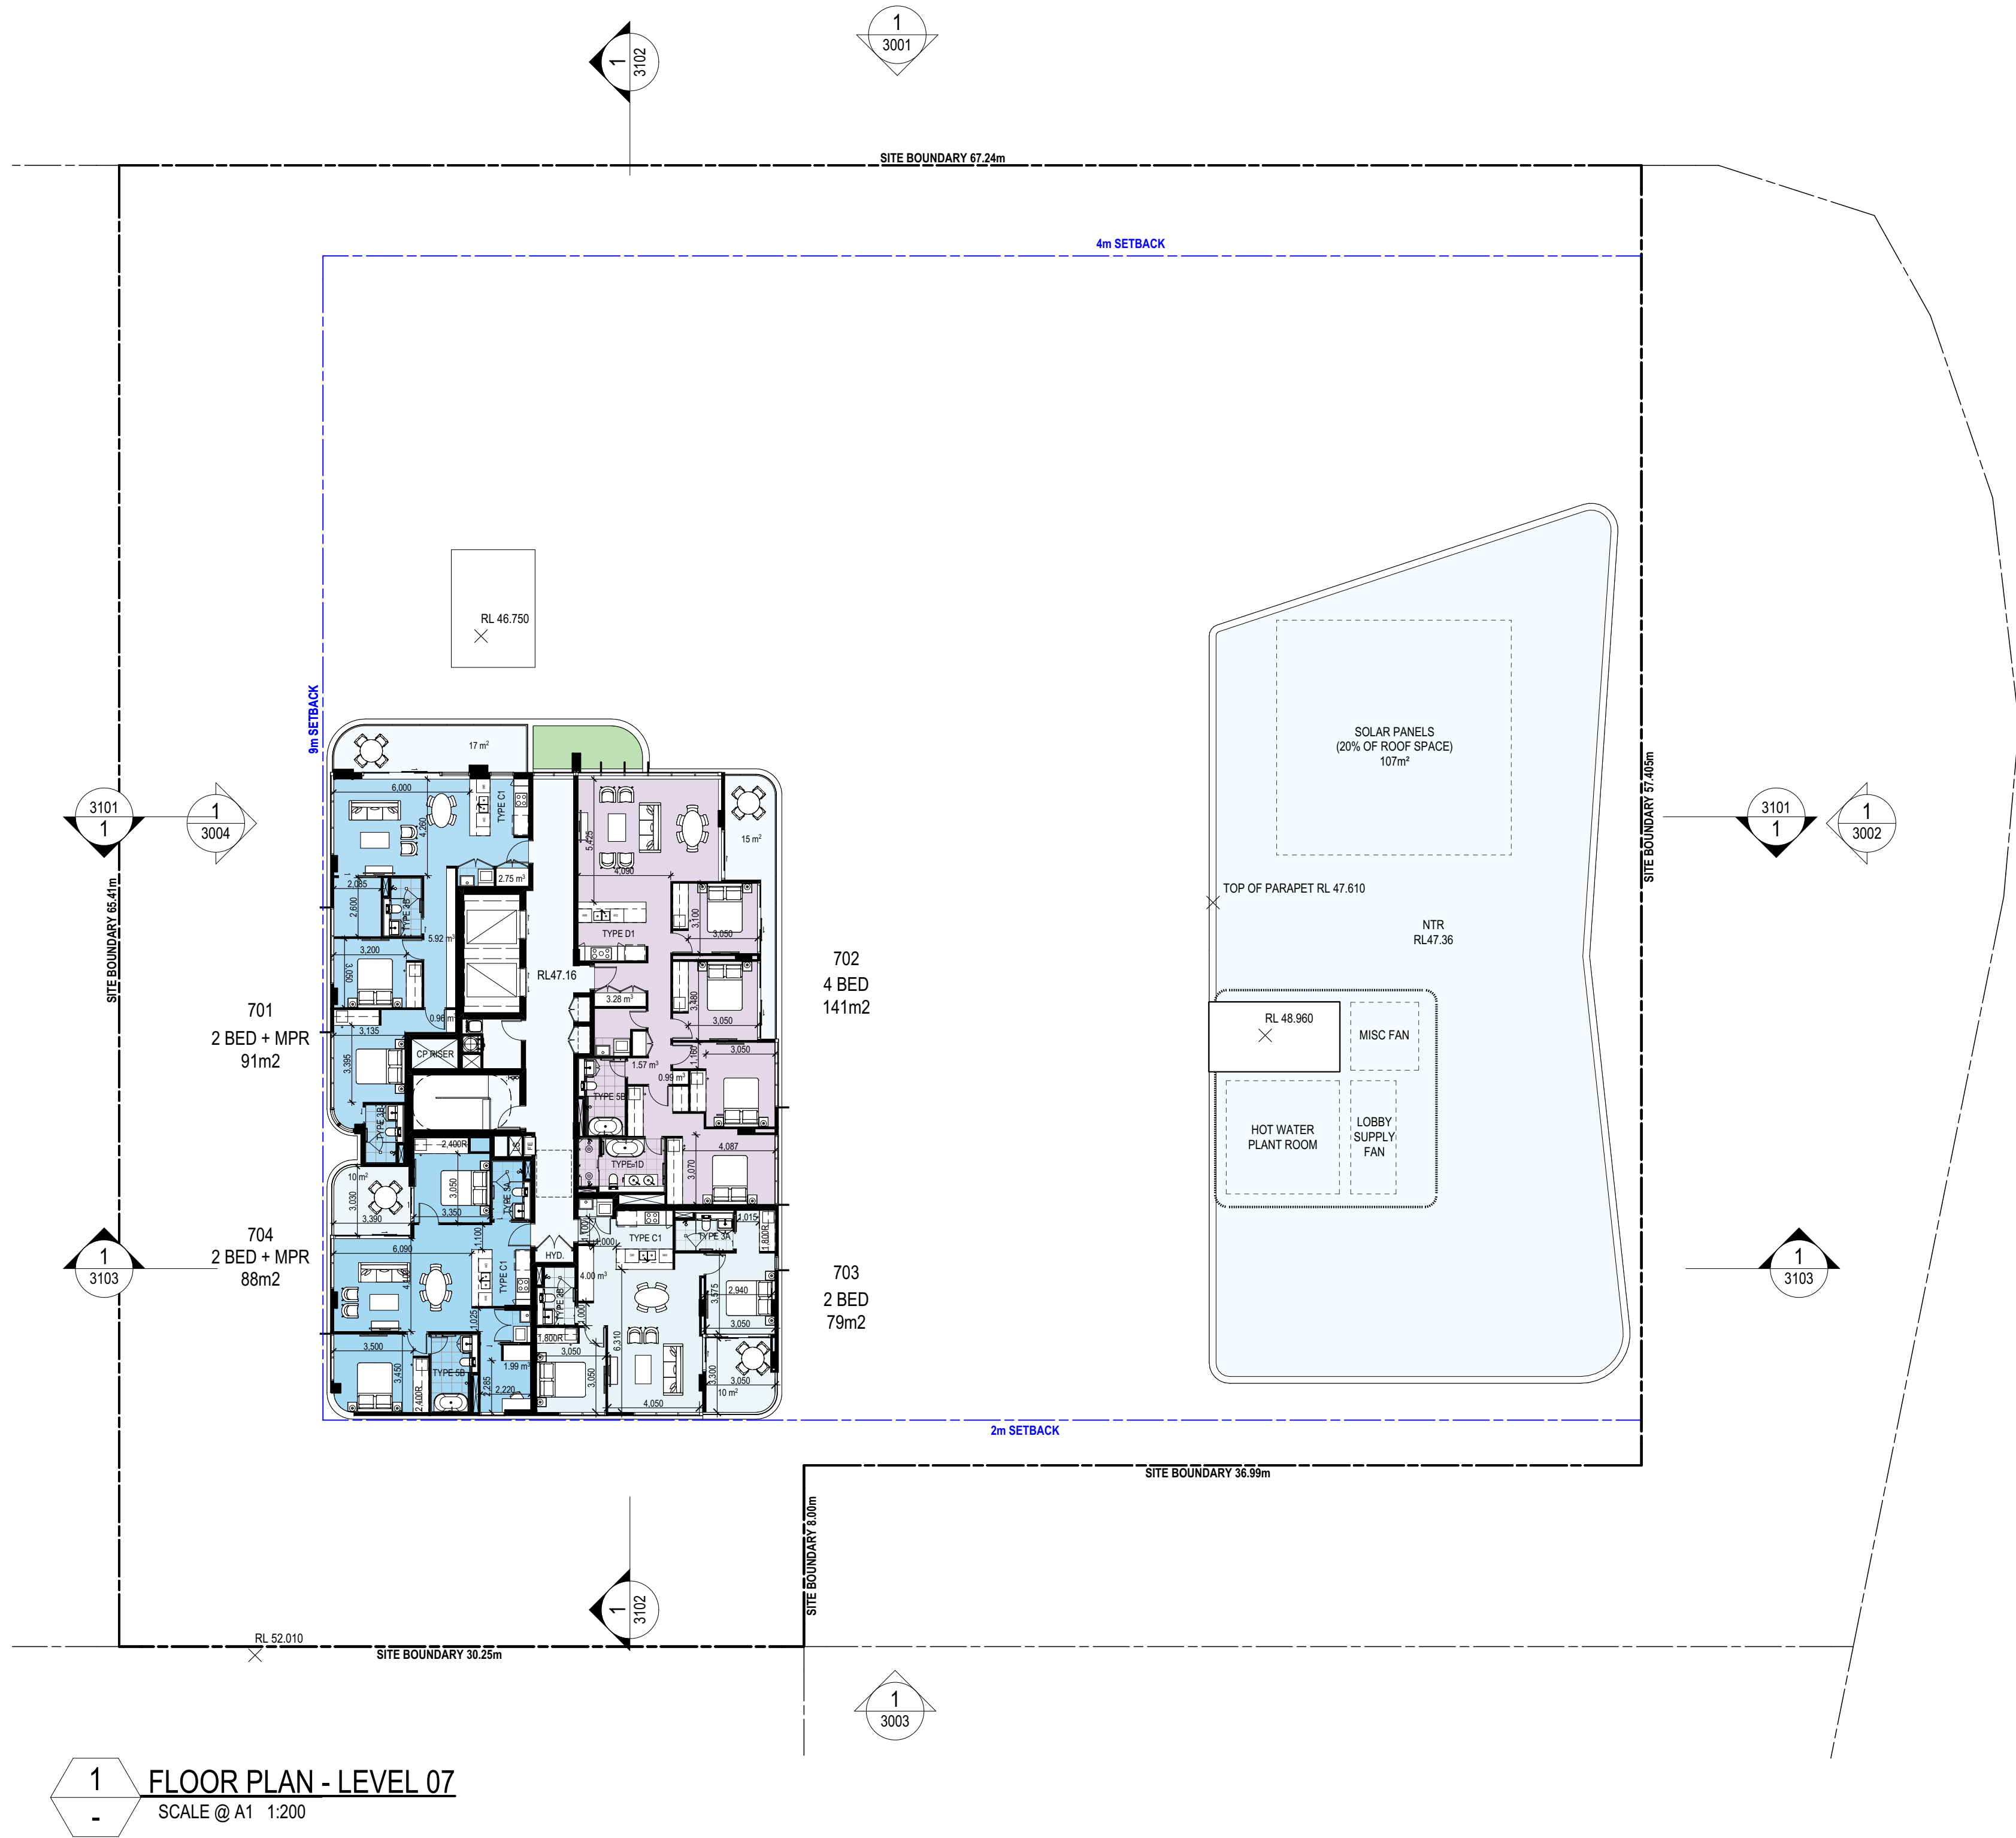


1 FLOOR PLAN - LEVEL 07
SCALE @ A1 1:200

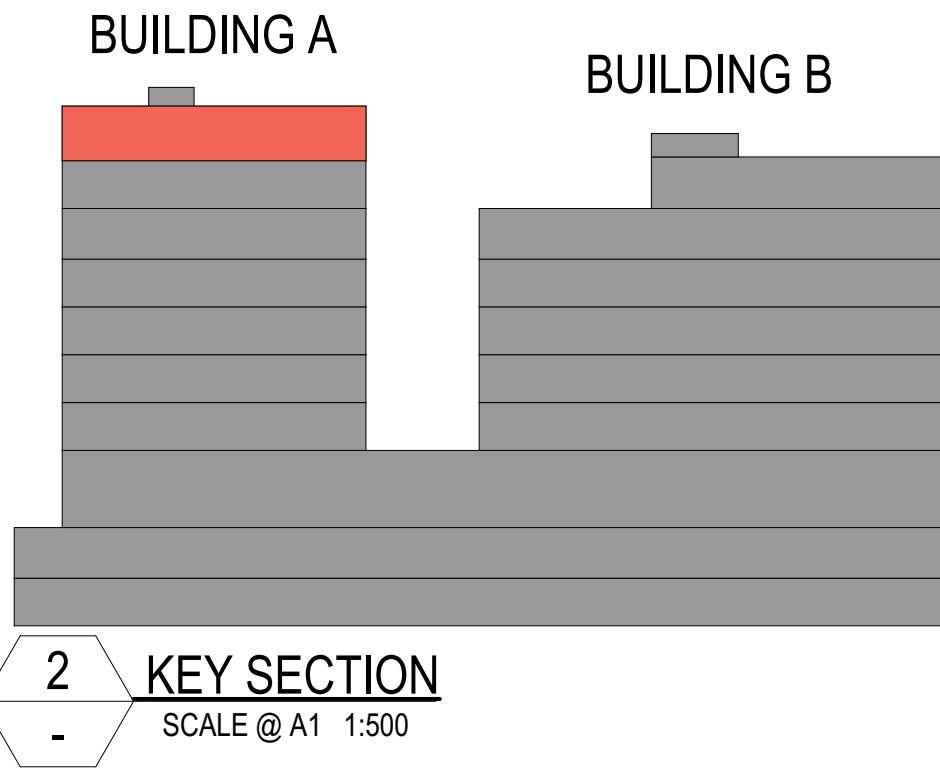


2 KEY SECTION
SCALE @ A1 1:500

LEGEND:


HYD = HYDRAULIC RISER
ELEC = ELECTRICAL RISER
COM = COMMUNICATIONS RISER
FE = FIRE EXTINGUISHER
LS = LOBBY SUPPLY
AC = AIR CONDITIONER CONDENSERS

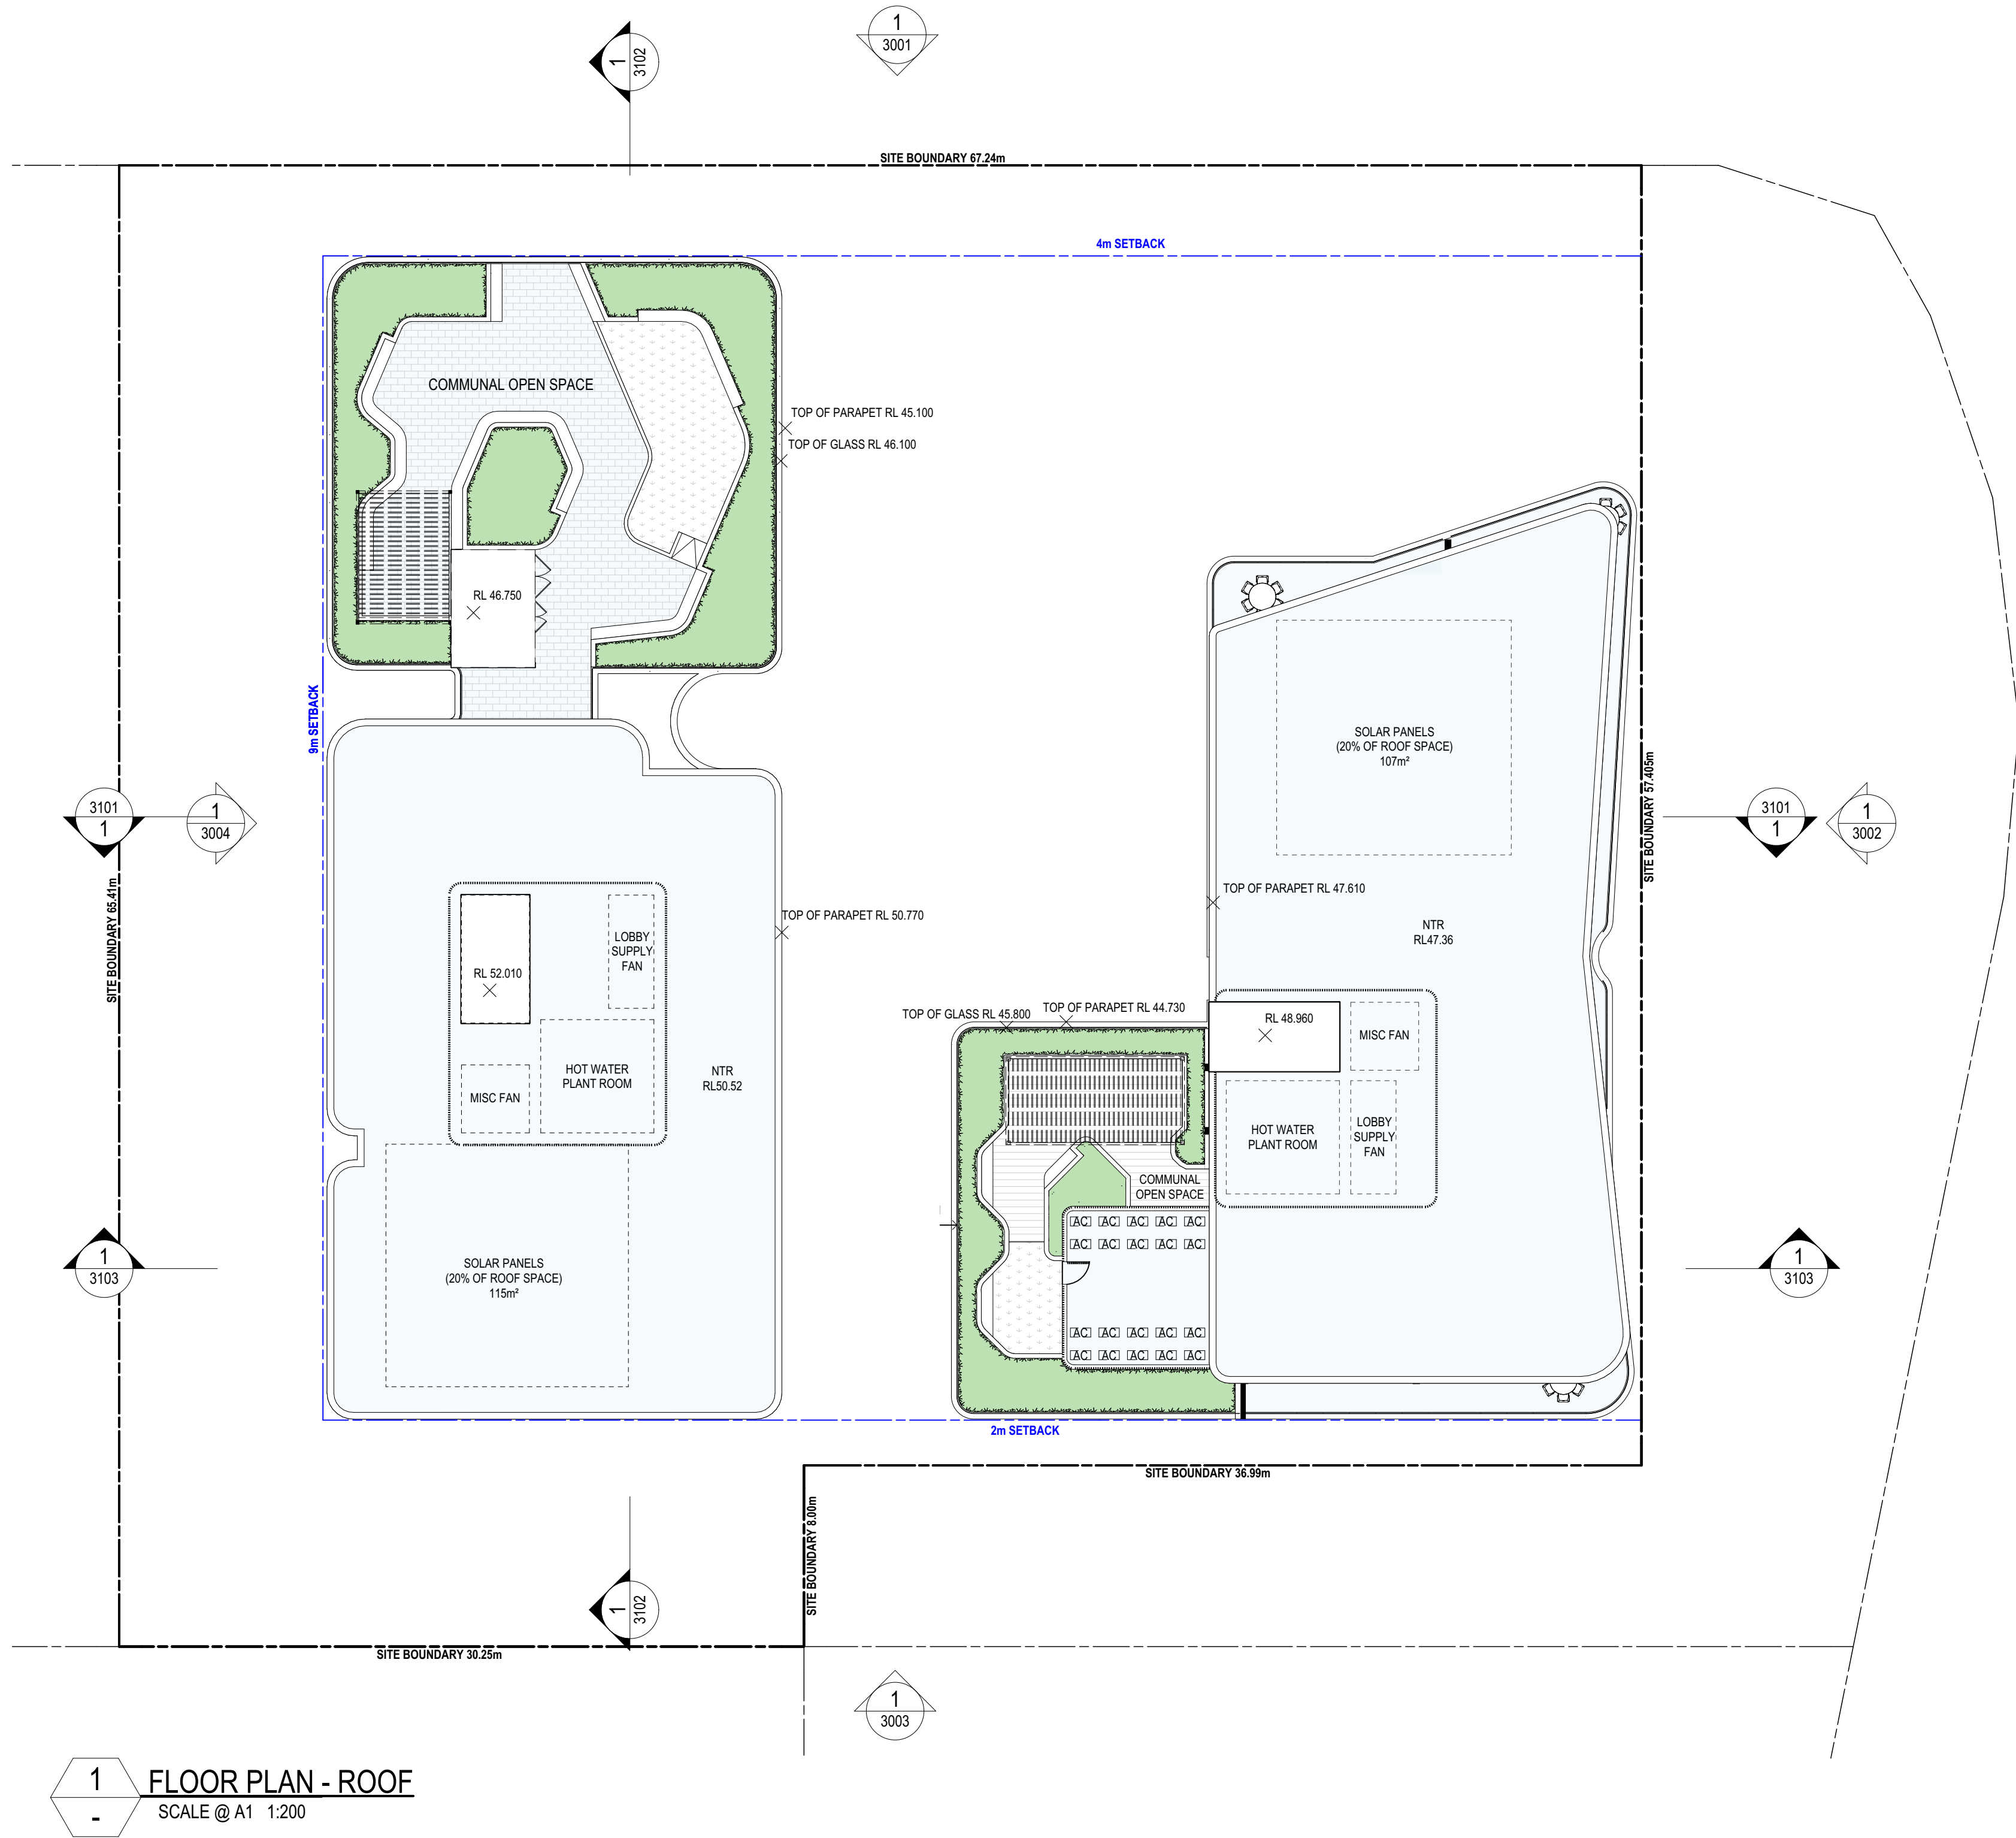

1 FLOOR PLAN - ROOF
SCALE @ A1 1:200

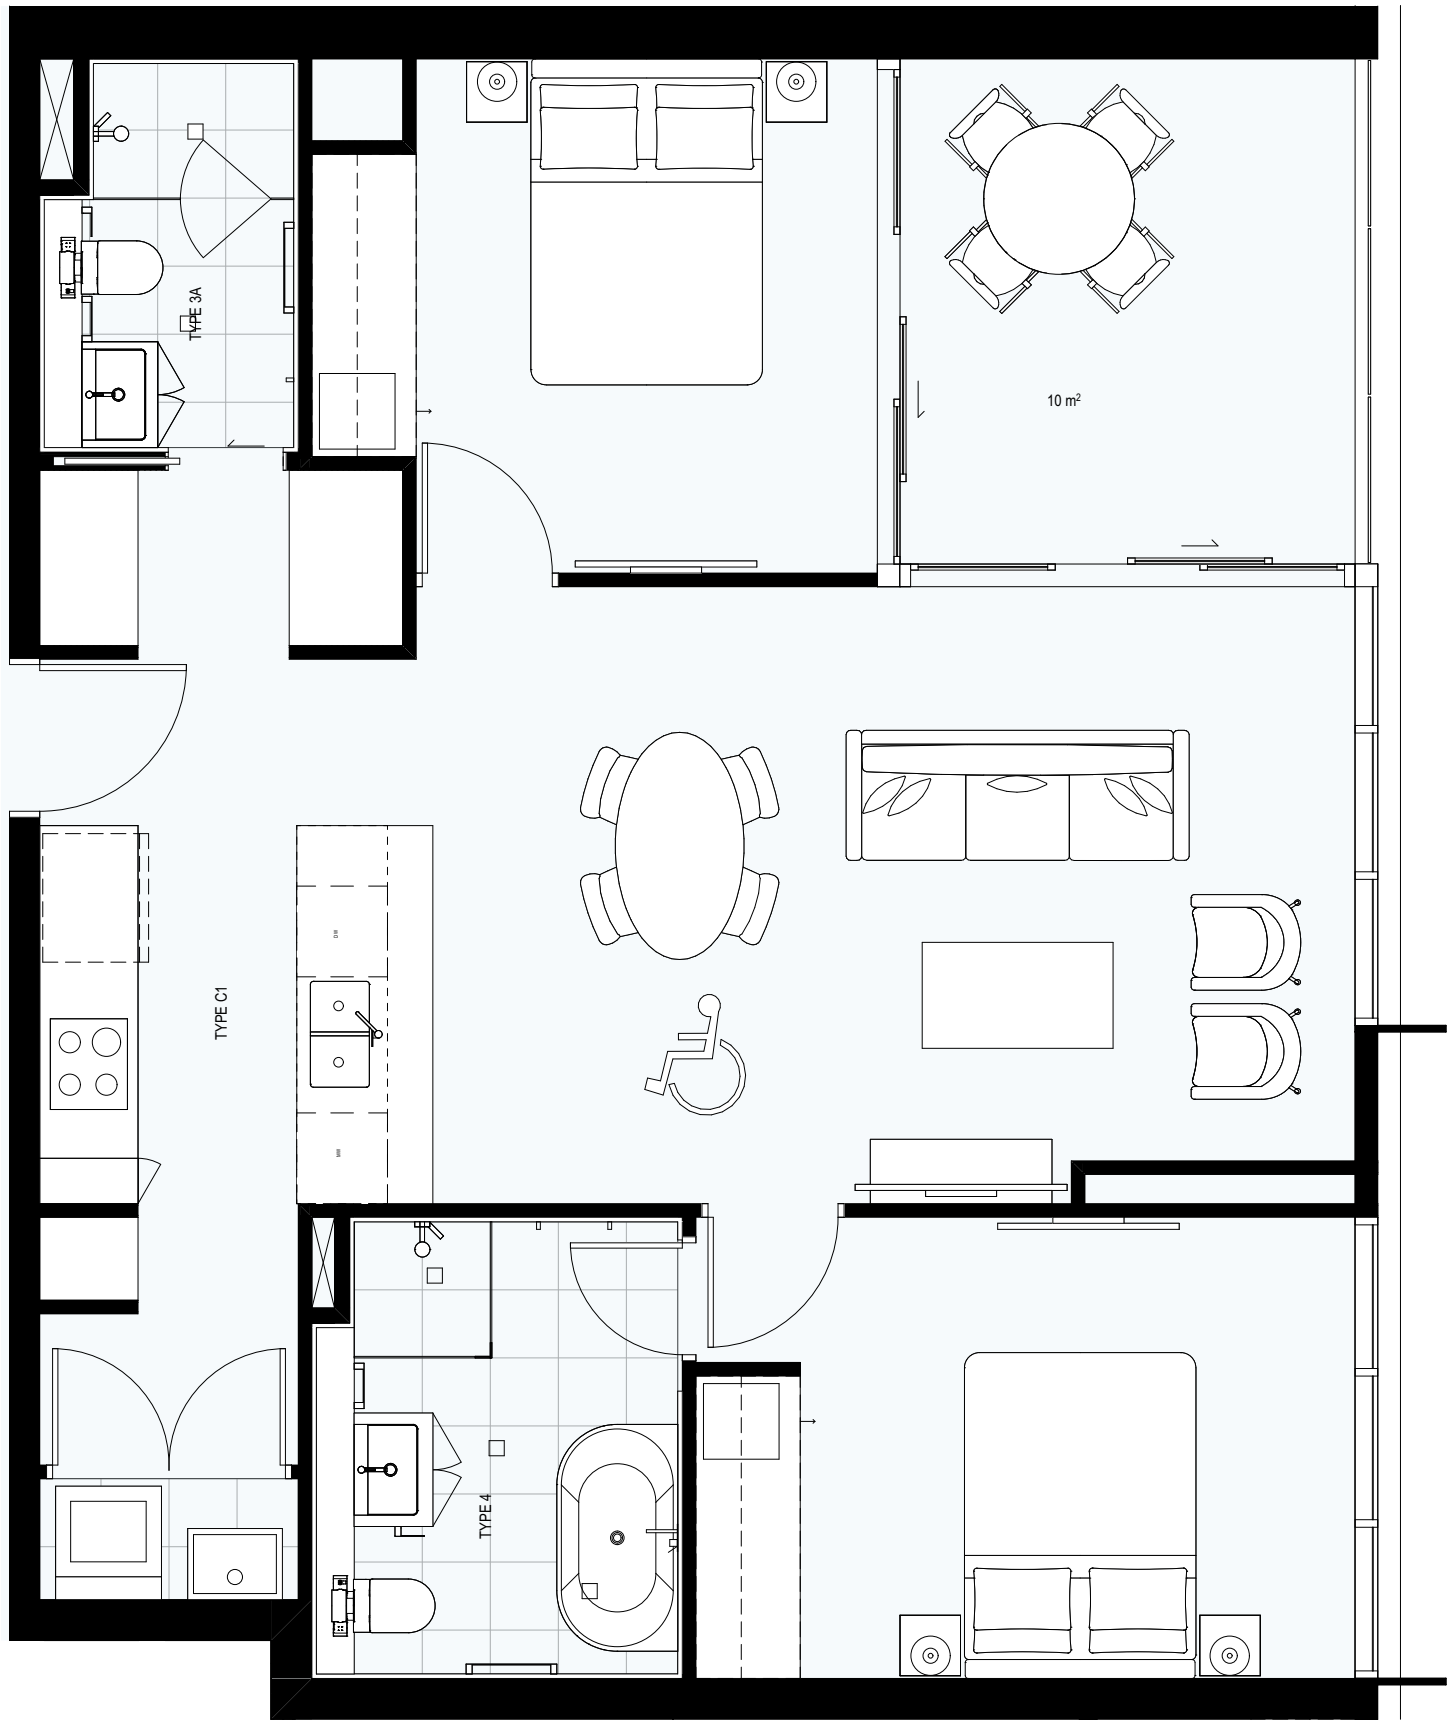


1
- TWO BEDROOM UNIT - PRE ADAPTATION
SCALE 1:50 @ A1
SCALE 1:100 @ A3

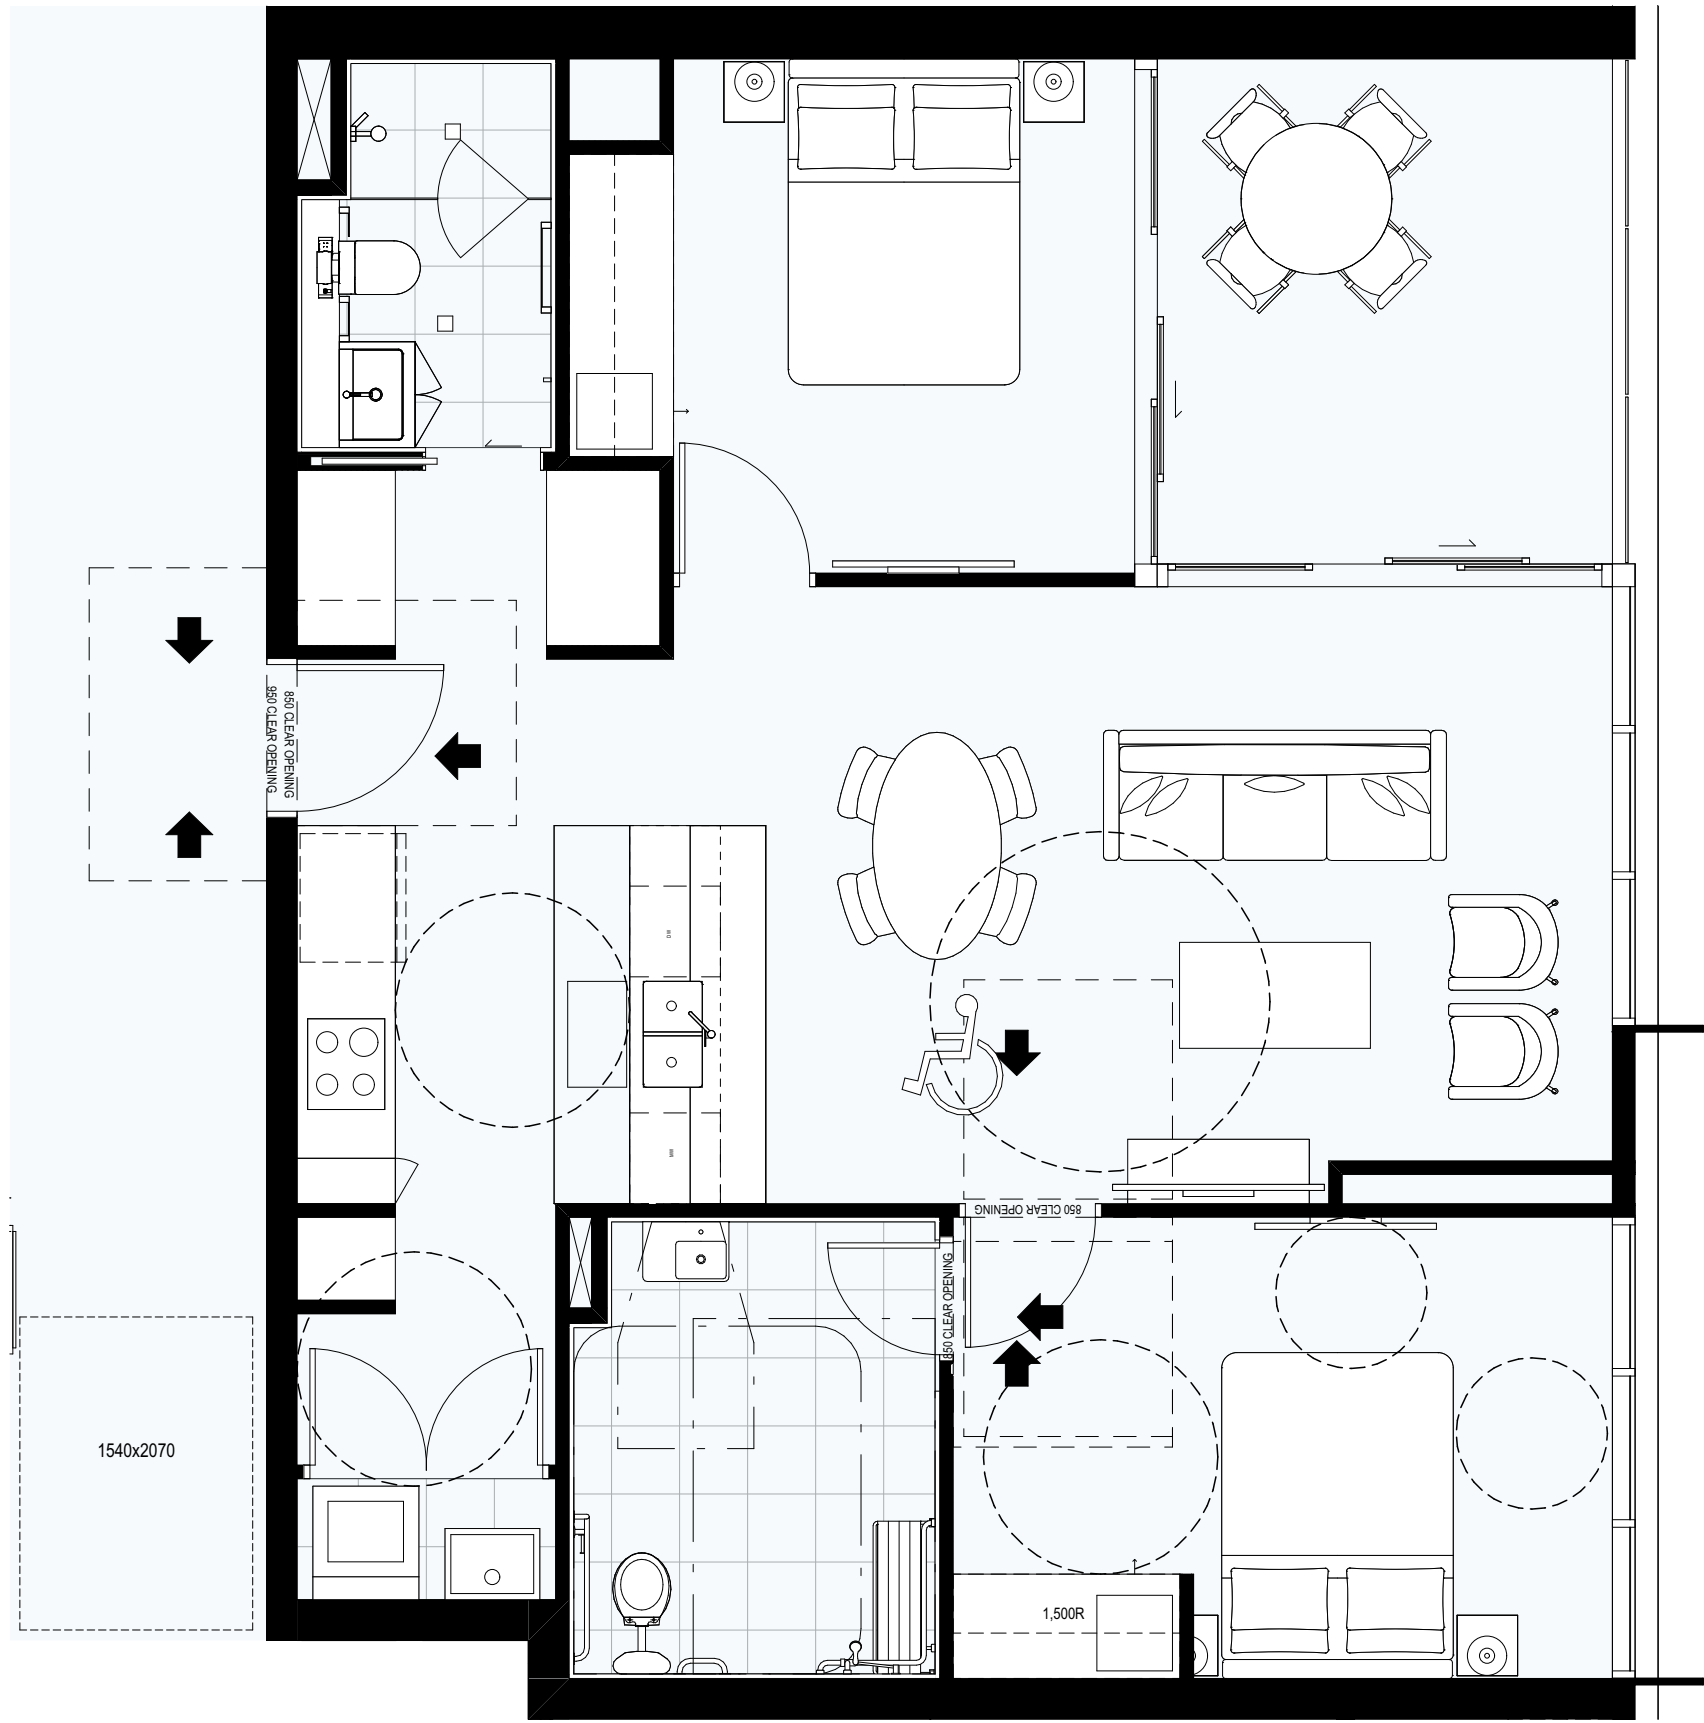


2
- TWO BEDROOM UNIT - POST ADAPTATION
SCALE 1:50 @ A1
SCALE 1:100 @ A3

UNITS:
106, 206, 306, 406, 506, 603

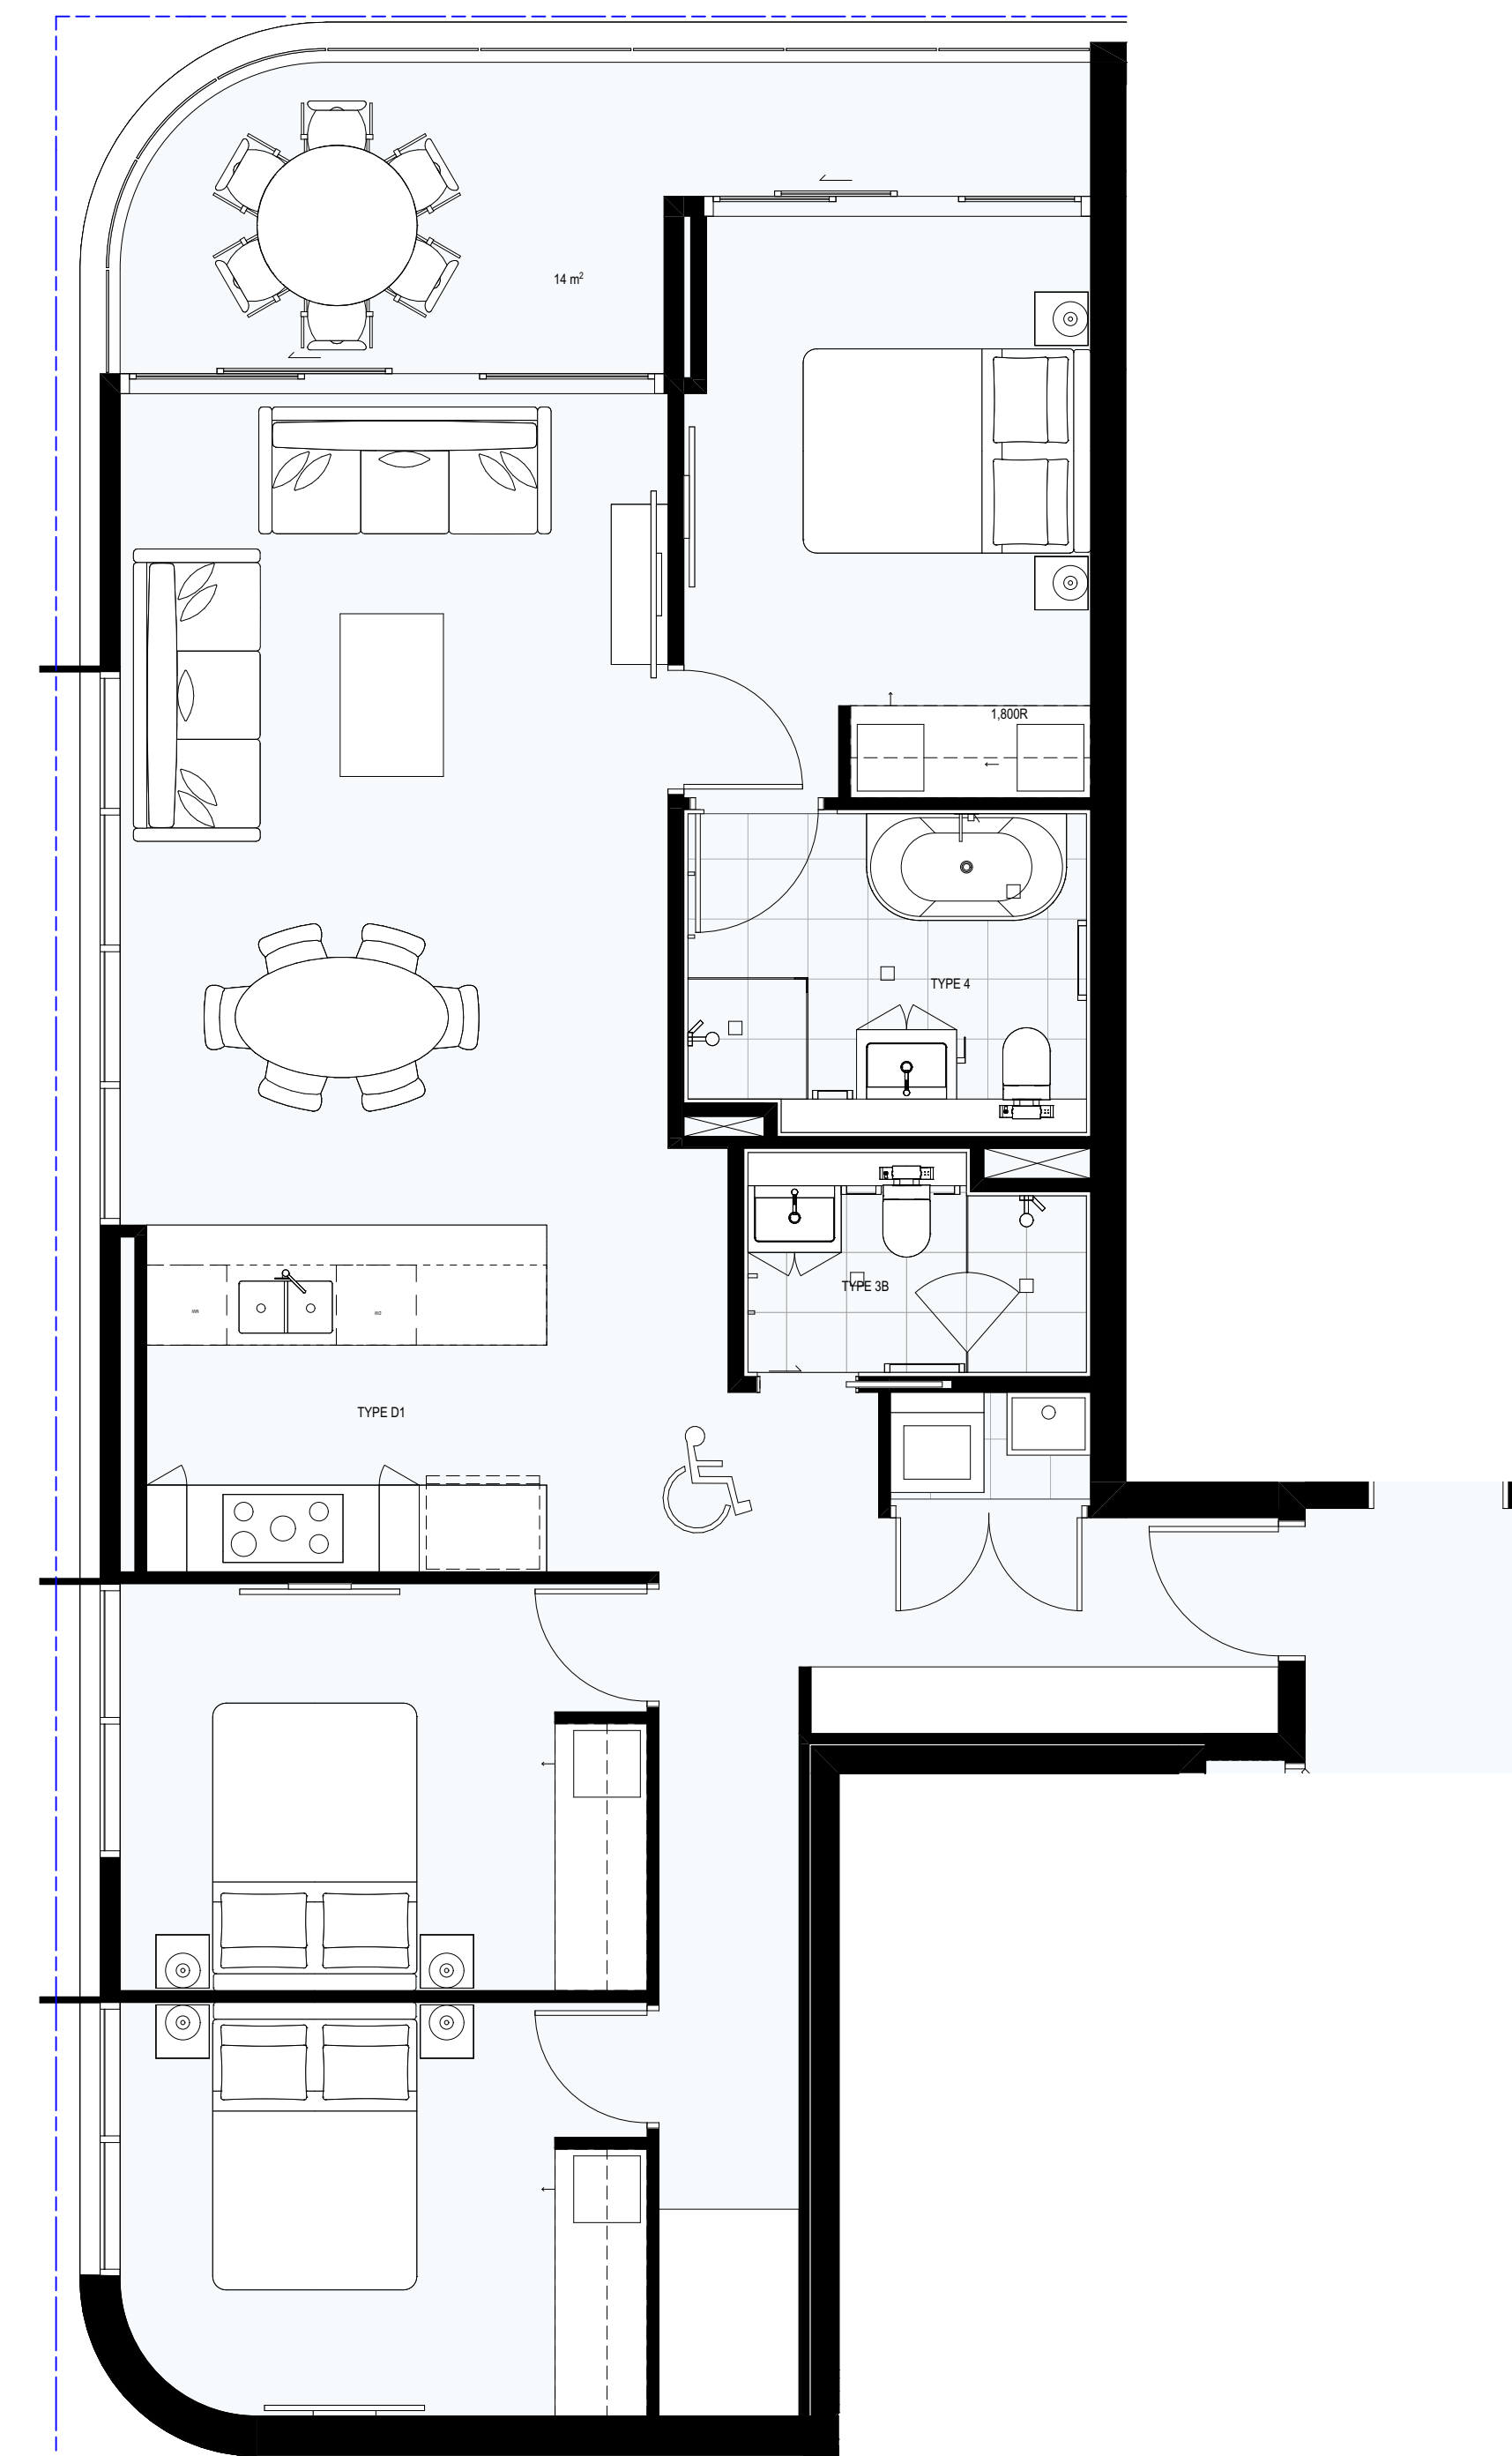

1 THREE BEDROOM UNIT - PRE ADAPTATION
SCALE 1:50 @ A1
SCALE 1:100 @ A3

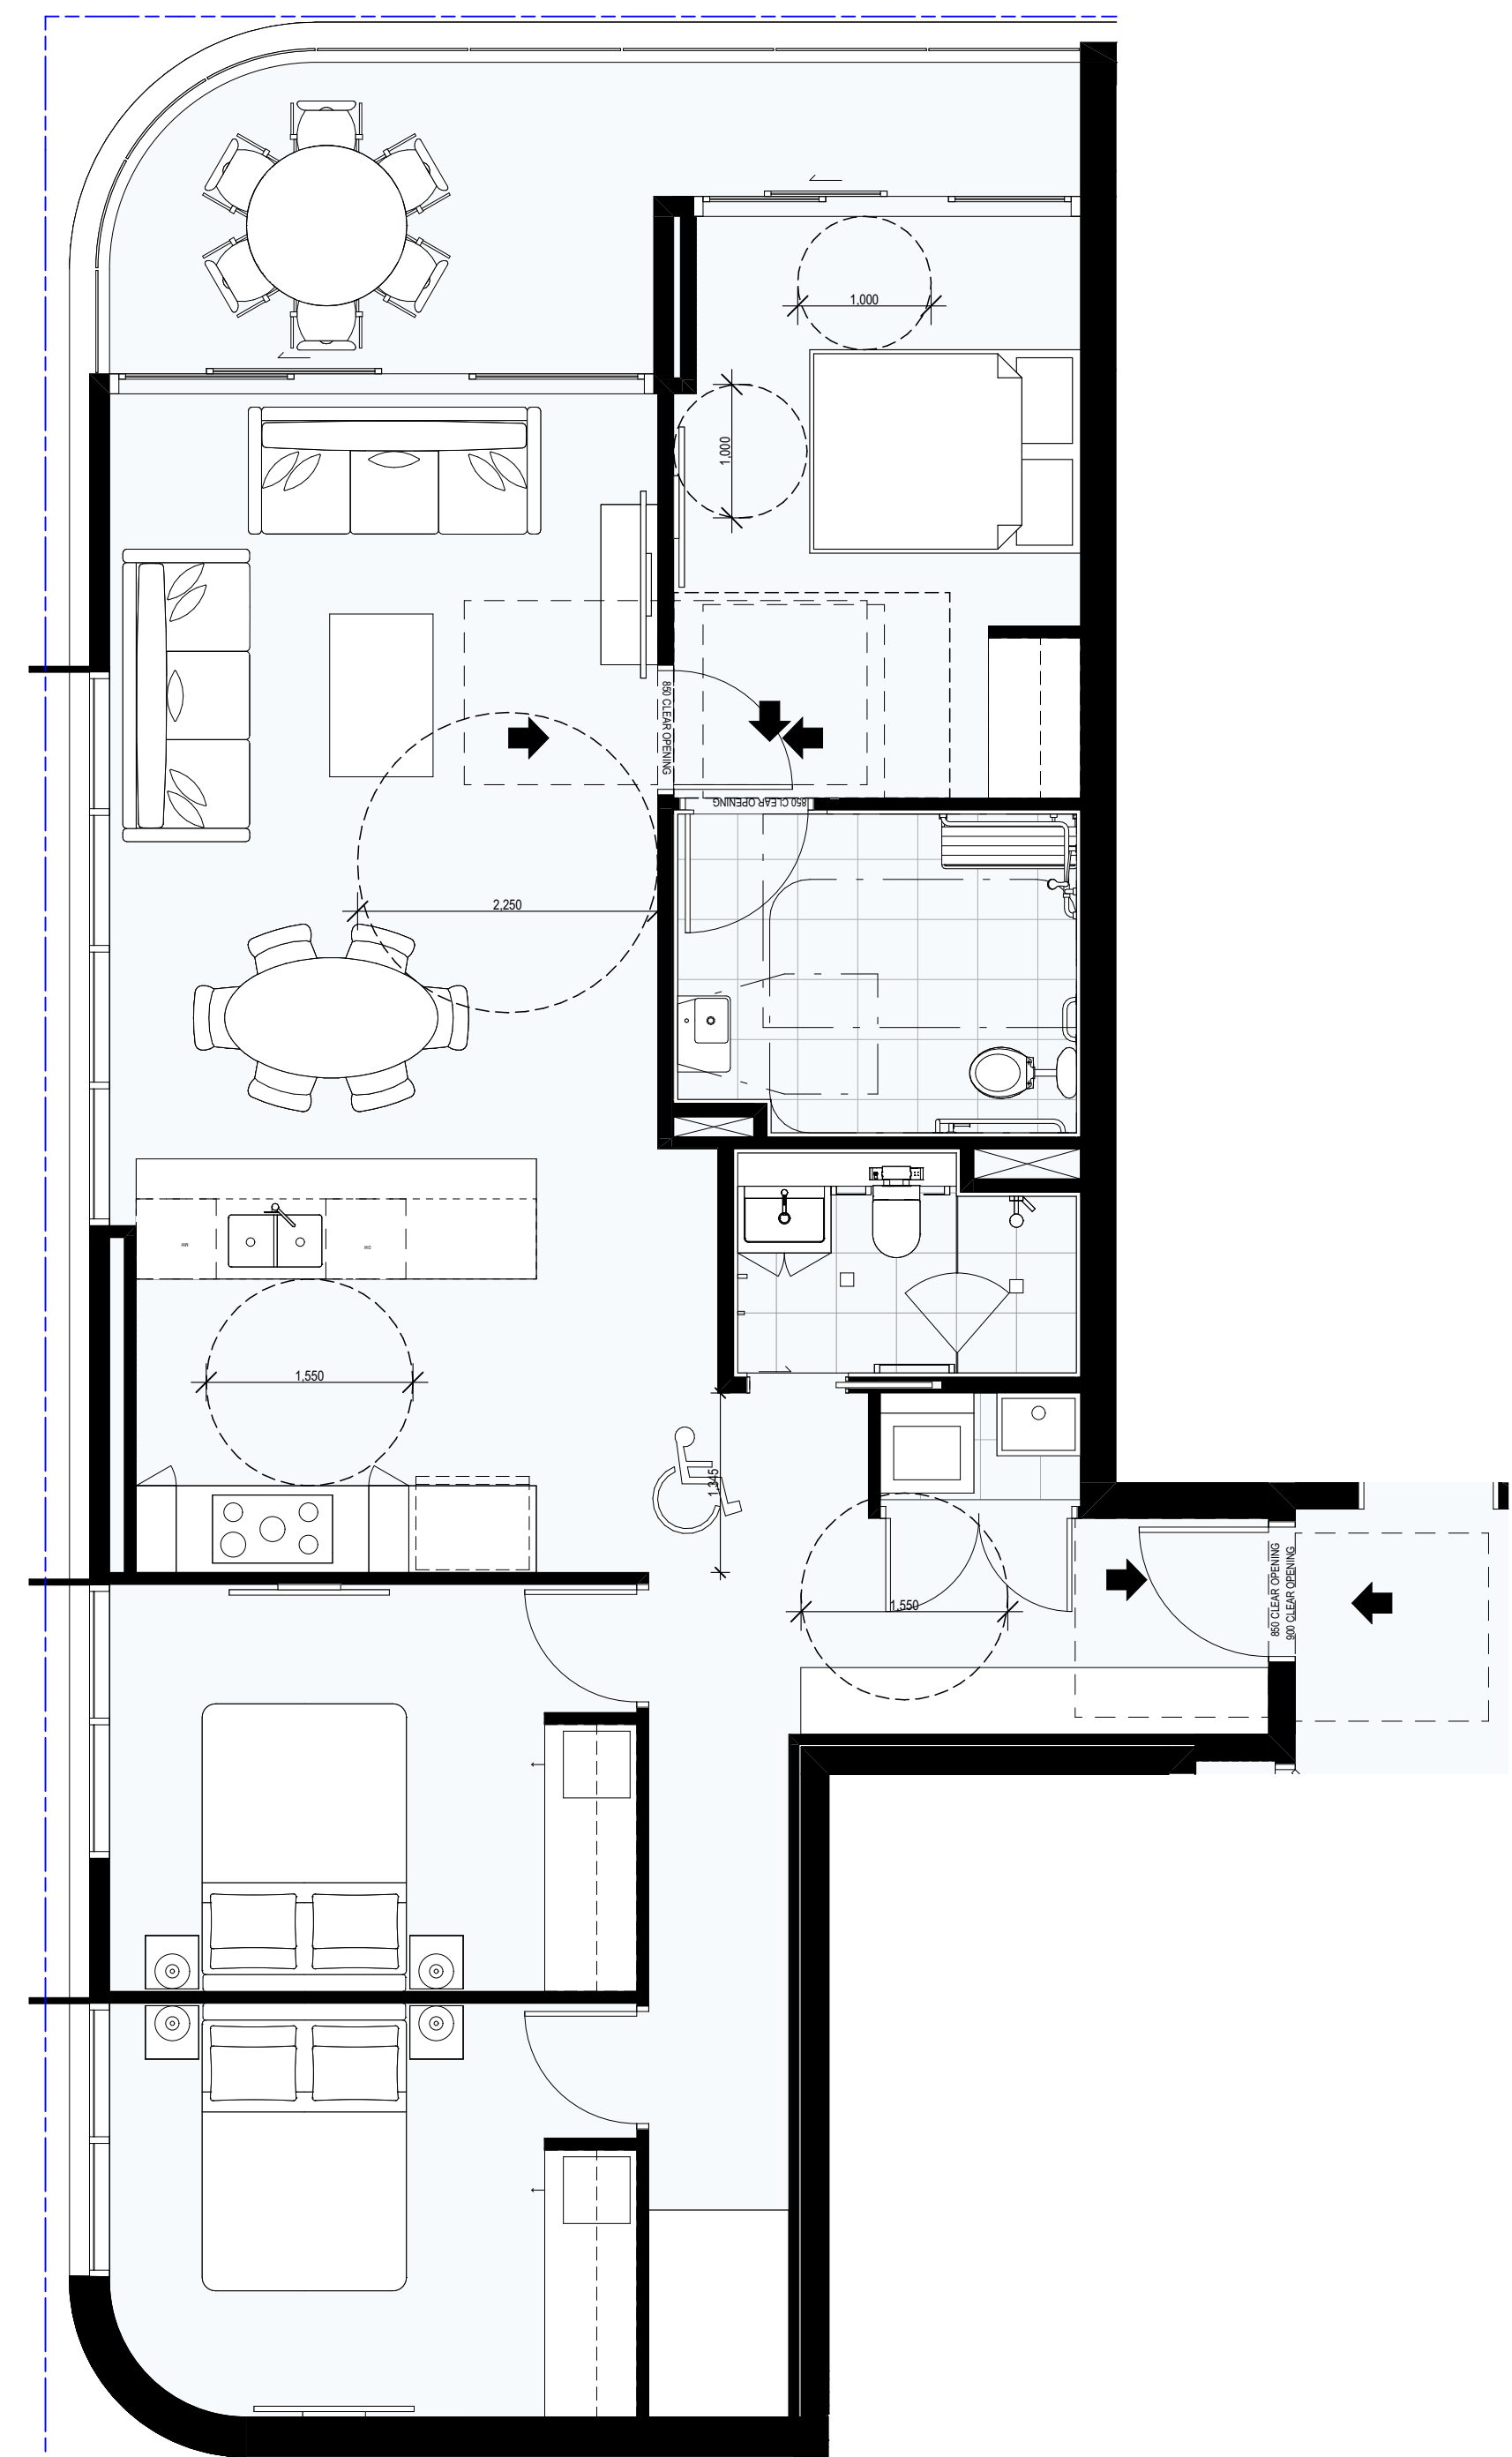


2 THREE BEDROOM UNIT - POST ADAPTATION
SCALE 1:50 @ A1
SCALE 1:100 @ A3

UNITS:
102, 202, 302, 402, 502

COTTEEPARKER Φ

Sydney
T 61 2 9366 1133
COTTEE PARKER ARCHITECTS PTY LTD
ABN 77 010 924 106
COTTEEPARKER.COM.AU

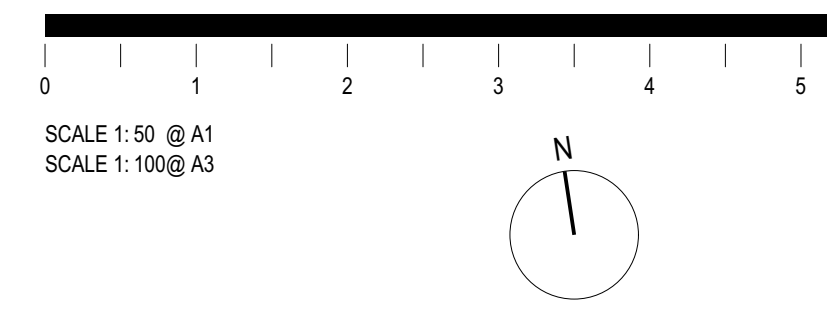


BIMcloud: CPACLBIM01 - BIMcloud/2200/6914 Pagewood Lot H & J 128 Bunnerong Rd Eastgardens DA Master: 22/01/2025: 5:56 PM


MINOR CHANGES TO FORM AND CONFIGURATION MAY BE REQUIRED WHEN DRAWINGS ARE SUBSEQUENTLY PREPARED FOR CONSTRUCTION PURPOSES AFTER THE GRANT OF DEVELOPMENT CONSENT.

B PRELIMINARY ISSUE
A ISSUE FOR DA
DATE 22/01/2025
CPA TM AD
06/06/2024
LA TM TM
DATE D C A
FOR INFORMATION

PAGEWOOD LOT J
8 HEFFRON ROAD, EASTGARDENS
CLIENT - Meriton
DRAWING TITLE
FLOOR PLAN - ADAPTABLE APARTMENT
JOB No 6914
DRAWING No SD2152
ISSUE B

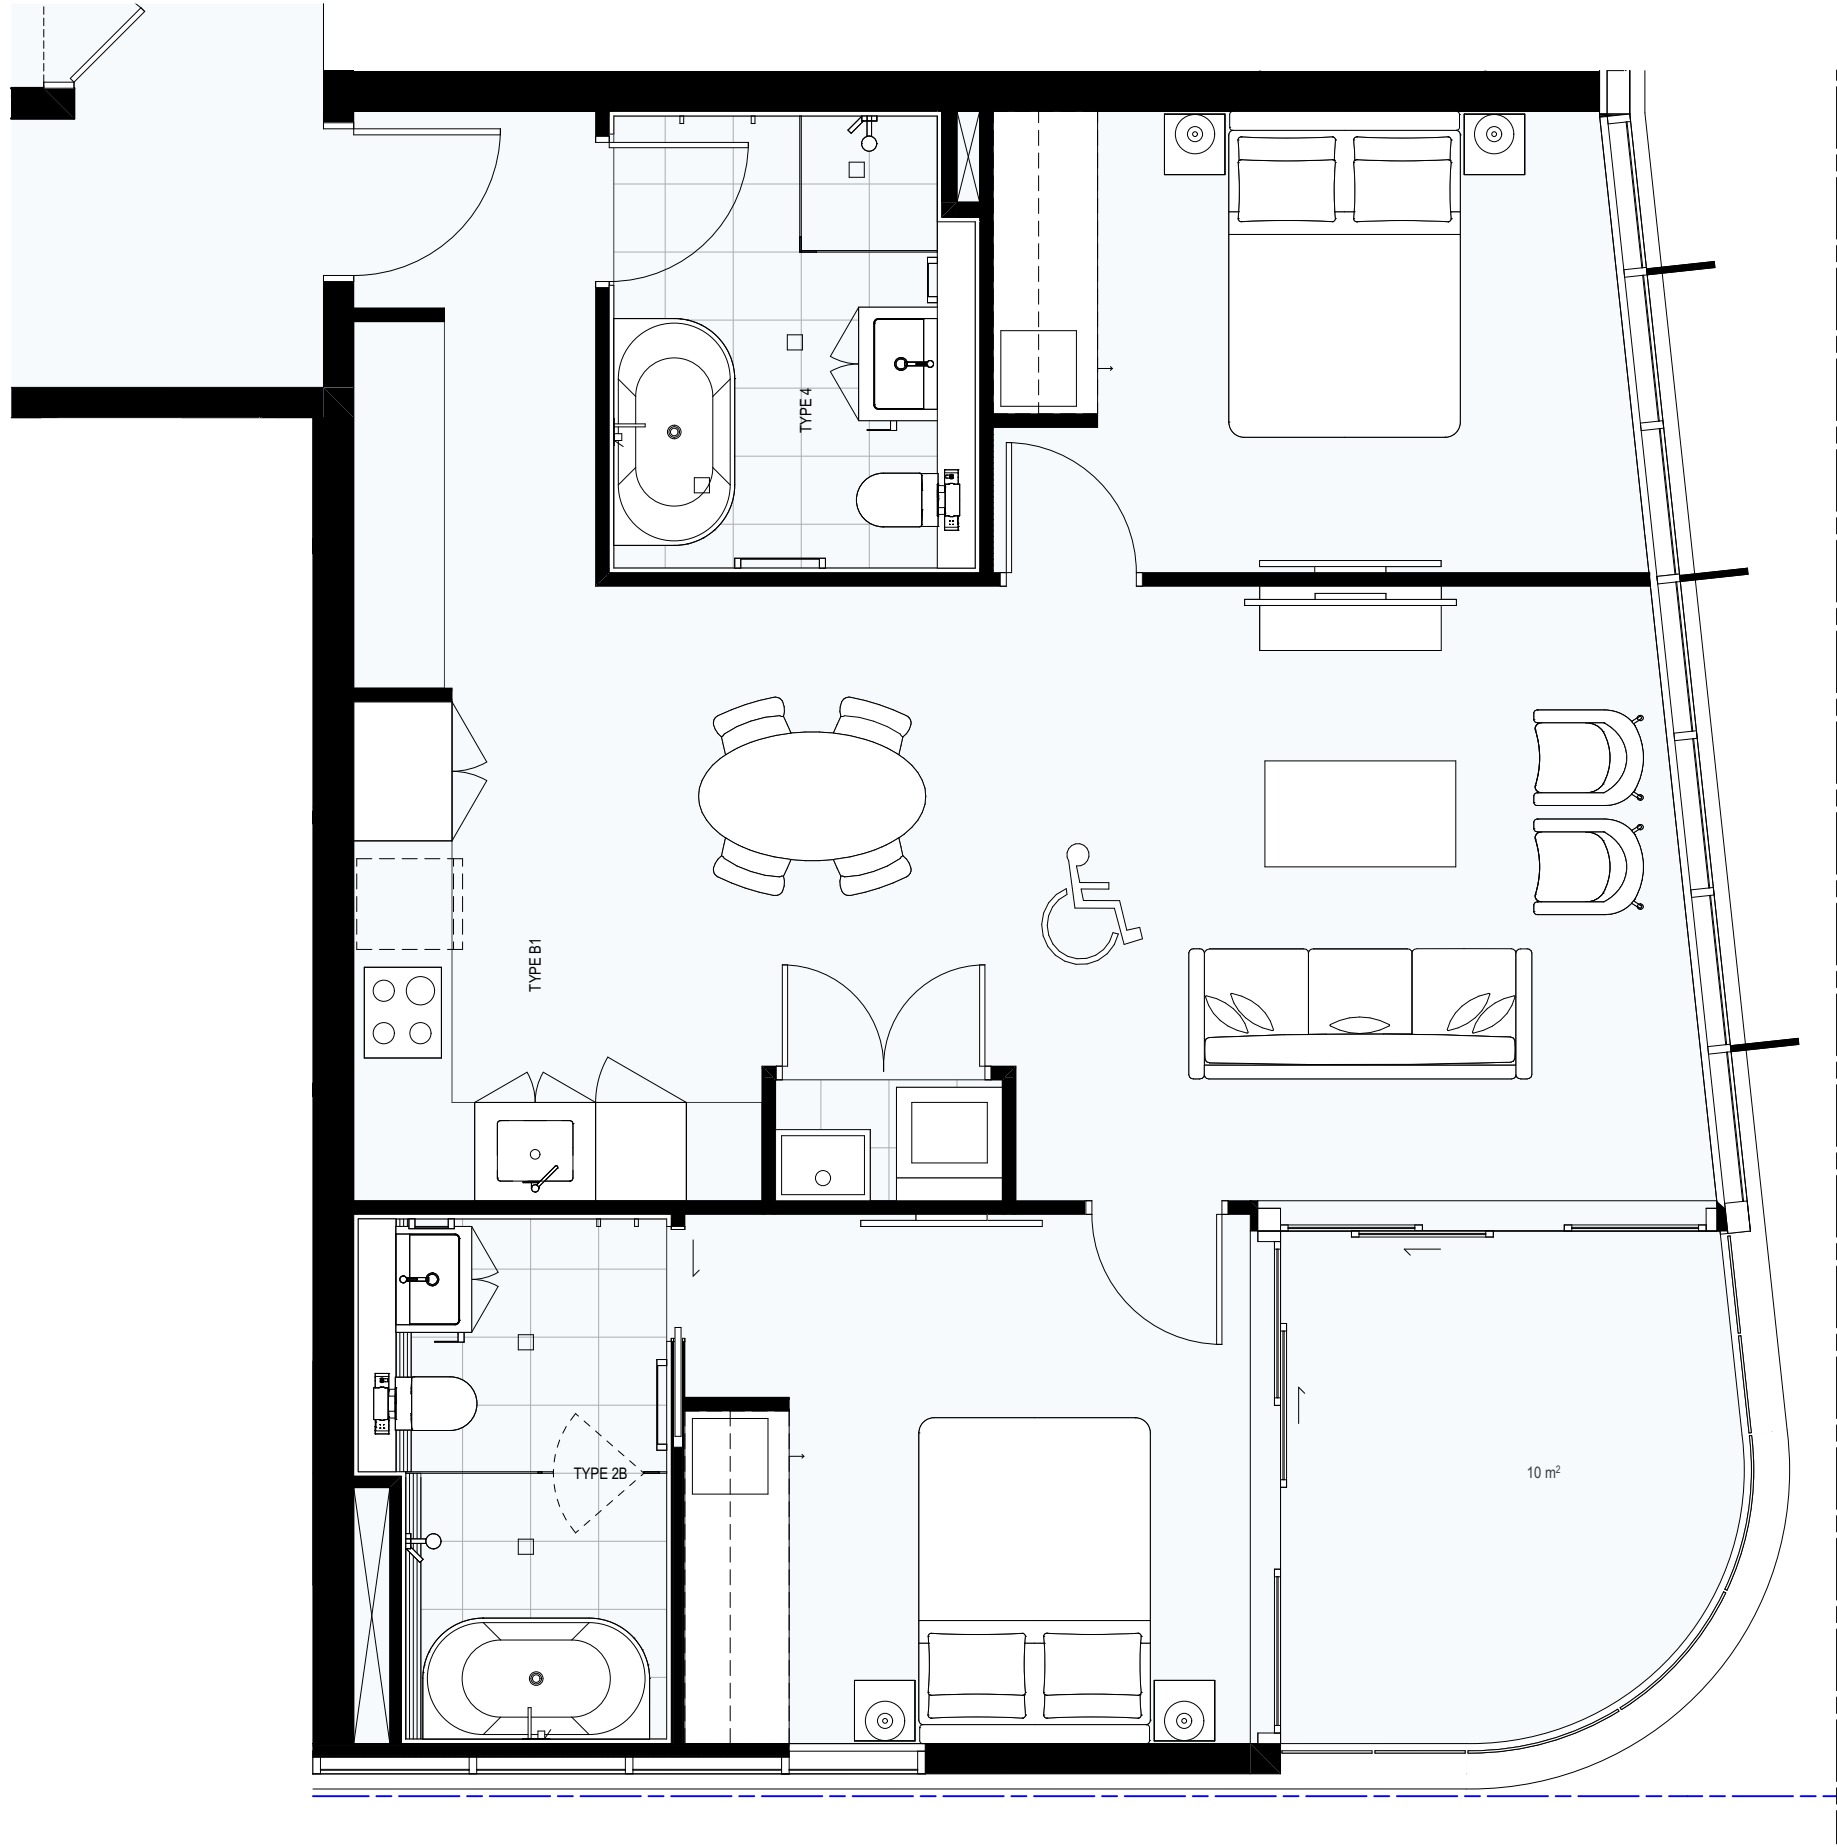

1 TWO BEDROOM UNIT - PRE ADAPTATION
SCALE 1:50 @ A1
SCALE 1:100 @ A3

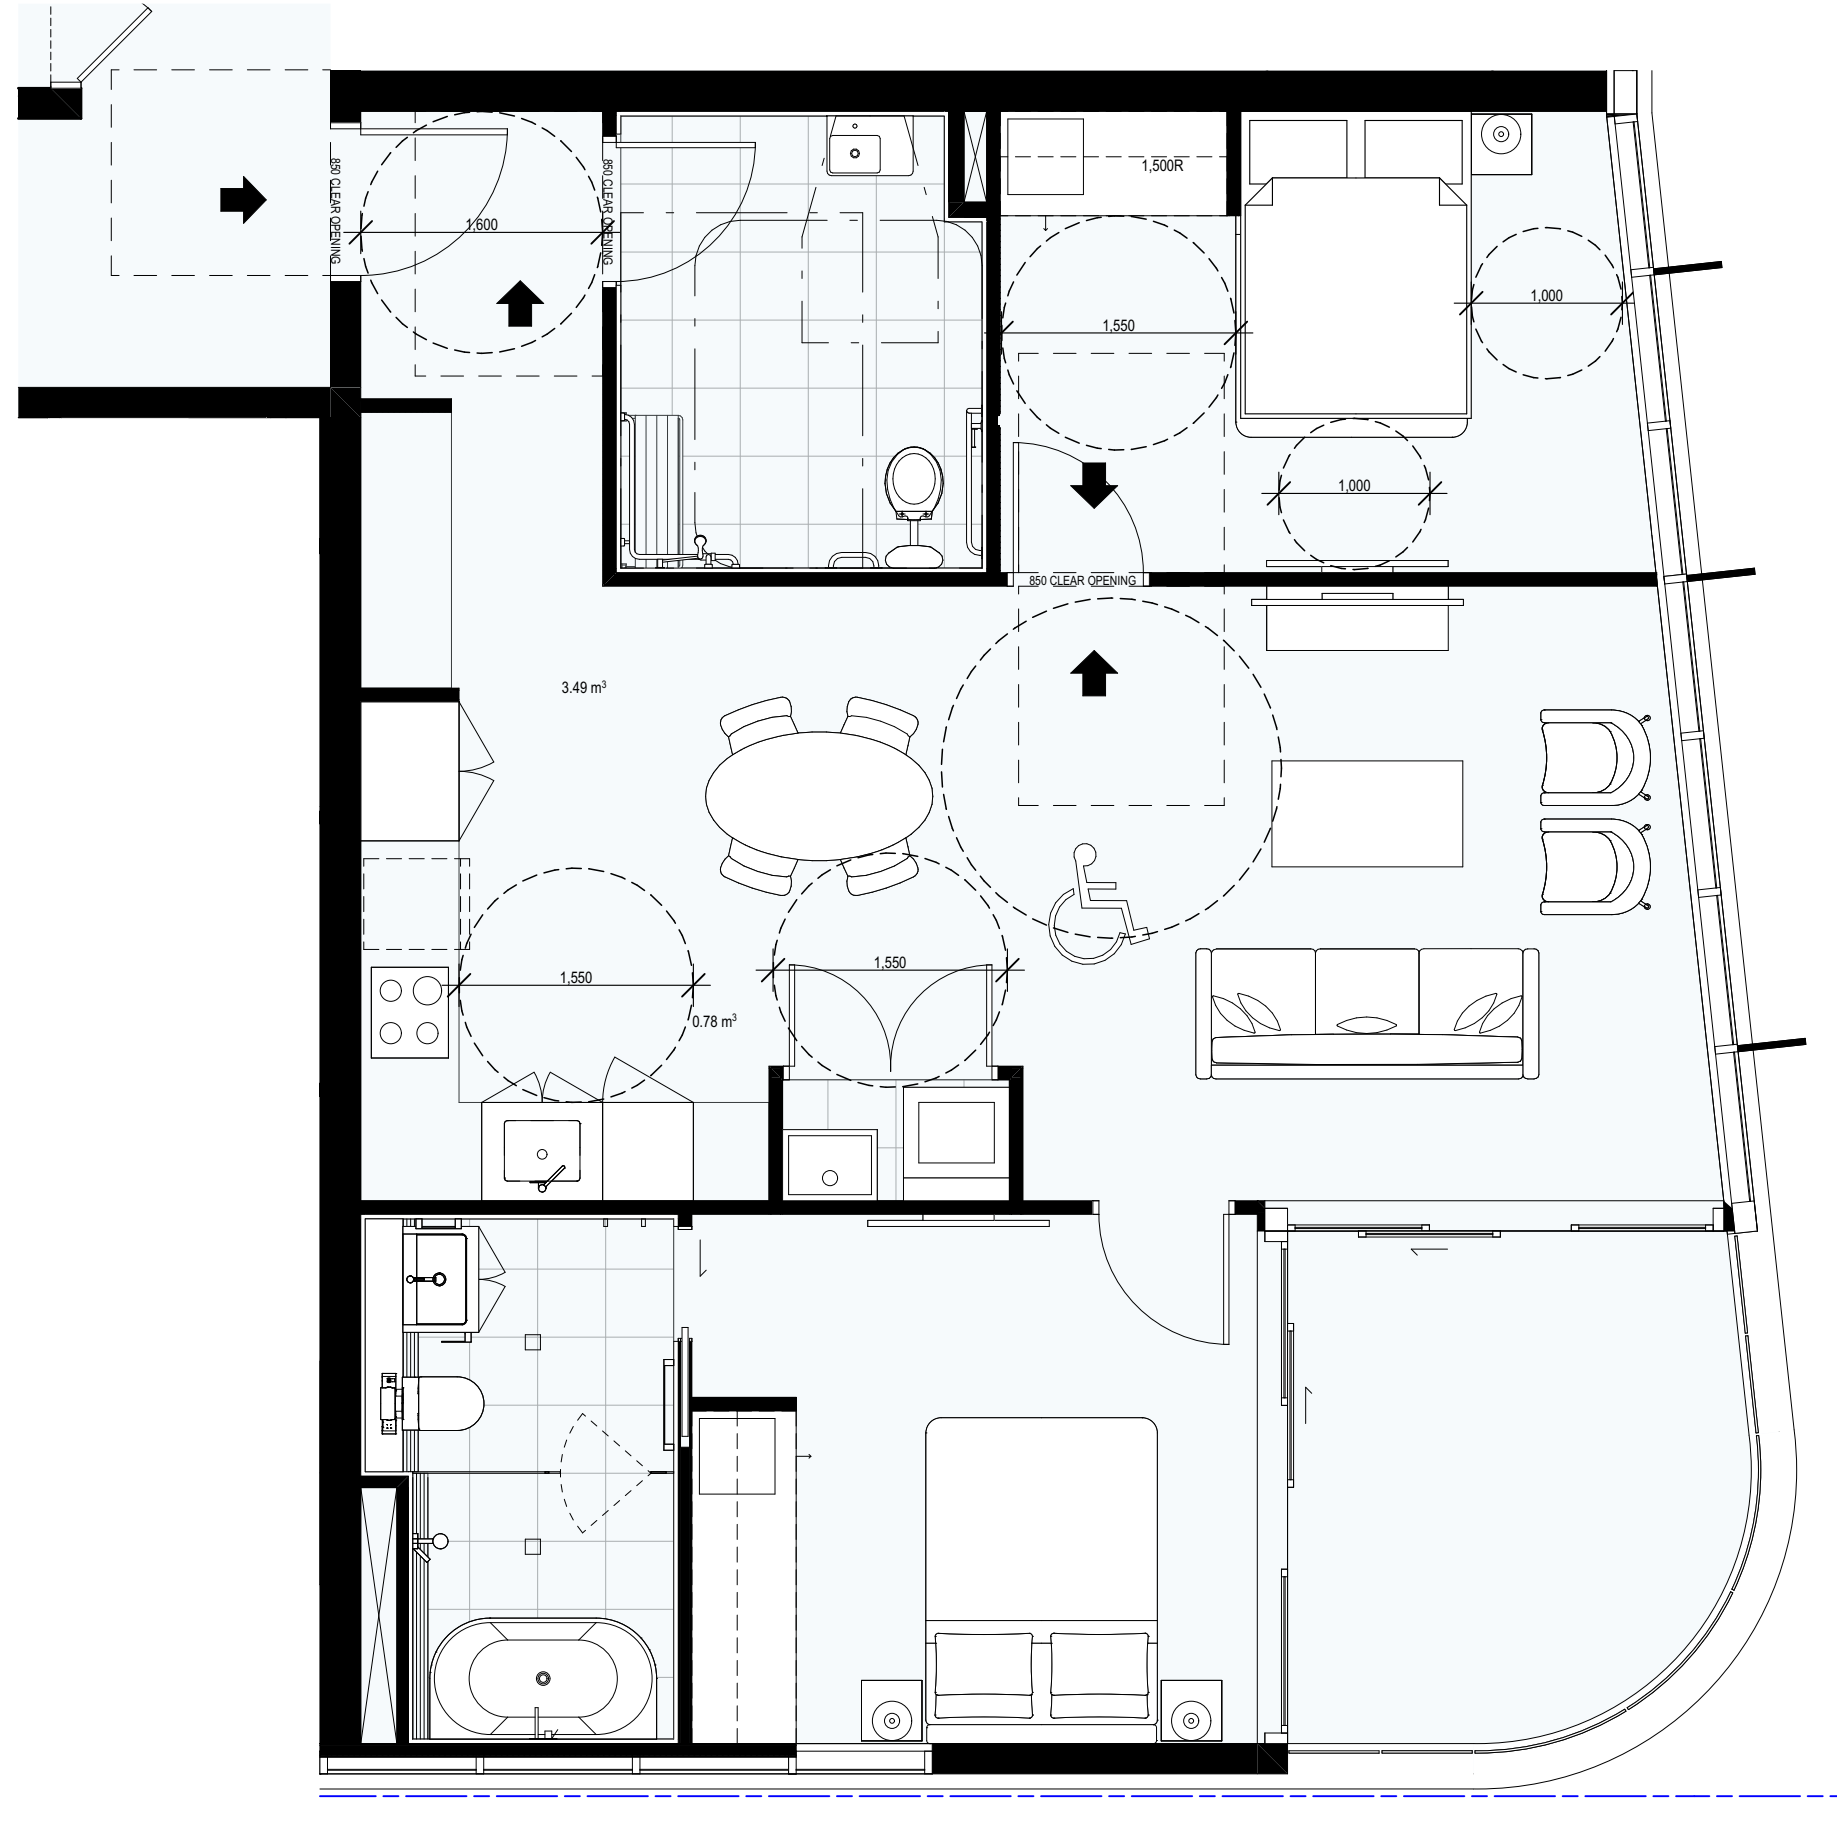


2 TWO BEDROOM UNIT - POST ADAPTATION
SCALE 1:50 @ A1
SCALE 1:100 @ A3

UNITS:
213, 313, 413, 513

COTTEEPARKER 

Sydney
T 61 2 9366 1133
COTTEEPARKER ARCHITECTS PTY LTD
ABN 77 010 924 106
COTTEEPARKER.COM.AU

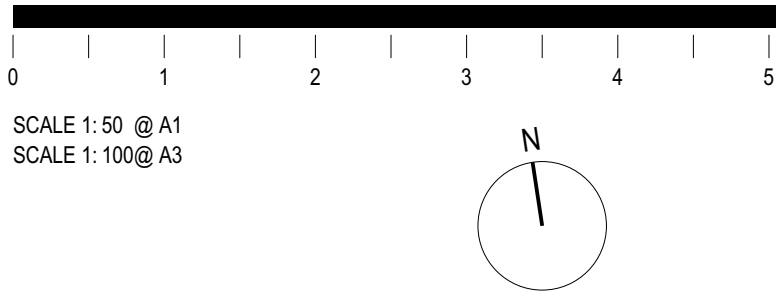

SCALE 1:50 @ A1
SCALE 1:100 @ A3


BIMcloud: CPACLBIM01 - BIMcloud/2200/6914 Pagewood Lot H & J 128 Bunnerong Rd Eastgardens DA Master: 22/01/2025: 5:56 PM

MINOR CHANGES TO FORM AND CONFIGURATION MAY BE REQUIRED WHEN DRAWINGS ARE SUBSEQUENTLY PREPARED FOR CONSTRUCTION PURPOSES AFTER THE GRANT OF DEVELOPMENT CONSENT.


— A — PRELIMINARY ISSUE
ISSUE PURPOSE
DATE D C A
FOR INFORMATION

22/01/2025 CPA TM AD

PAGWOOD LOT J
8 HEFFRON ROAD, EASTGARDENS
CLIENT - Meriton
DRAWING TITLE
FLOOR PLAN - ADAPTABLE APARTMENT
JOB No 6914
DRAWING No SD2153
ISSUE A

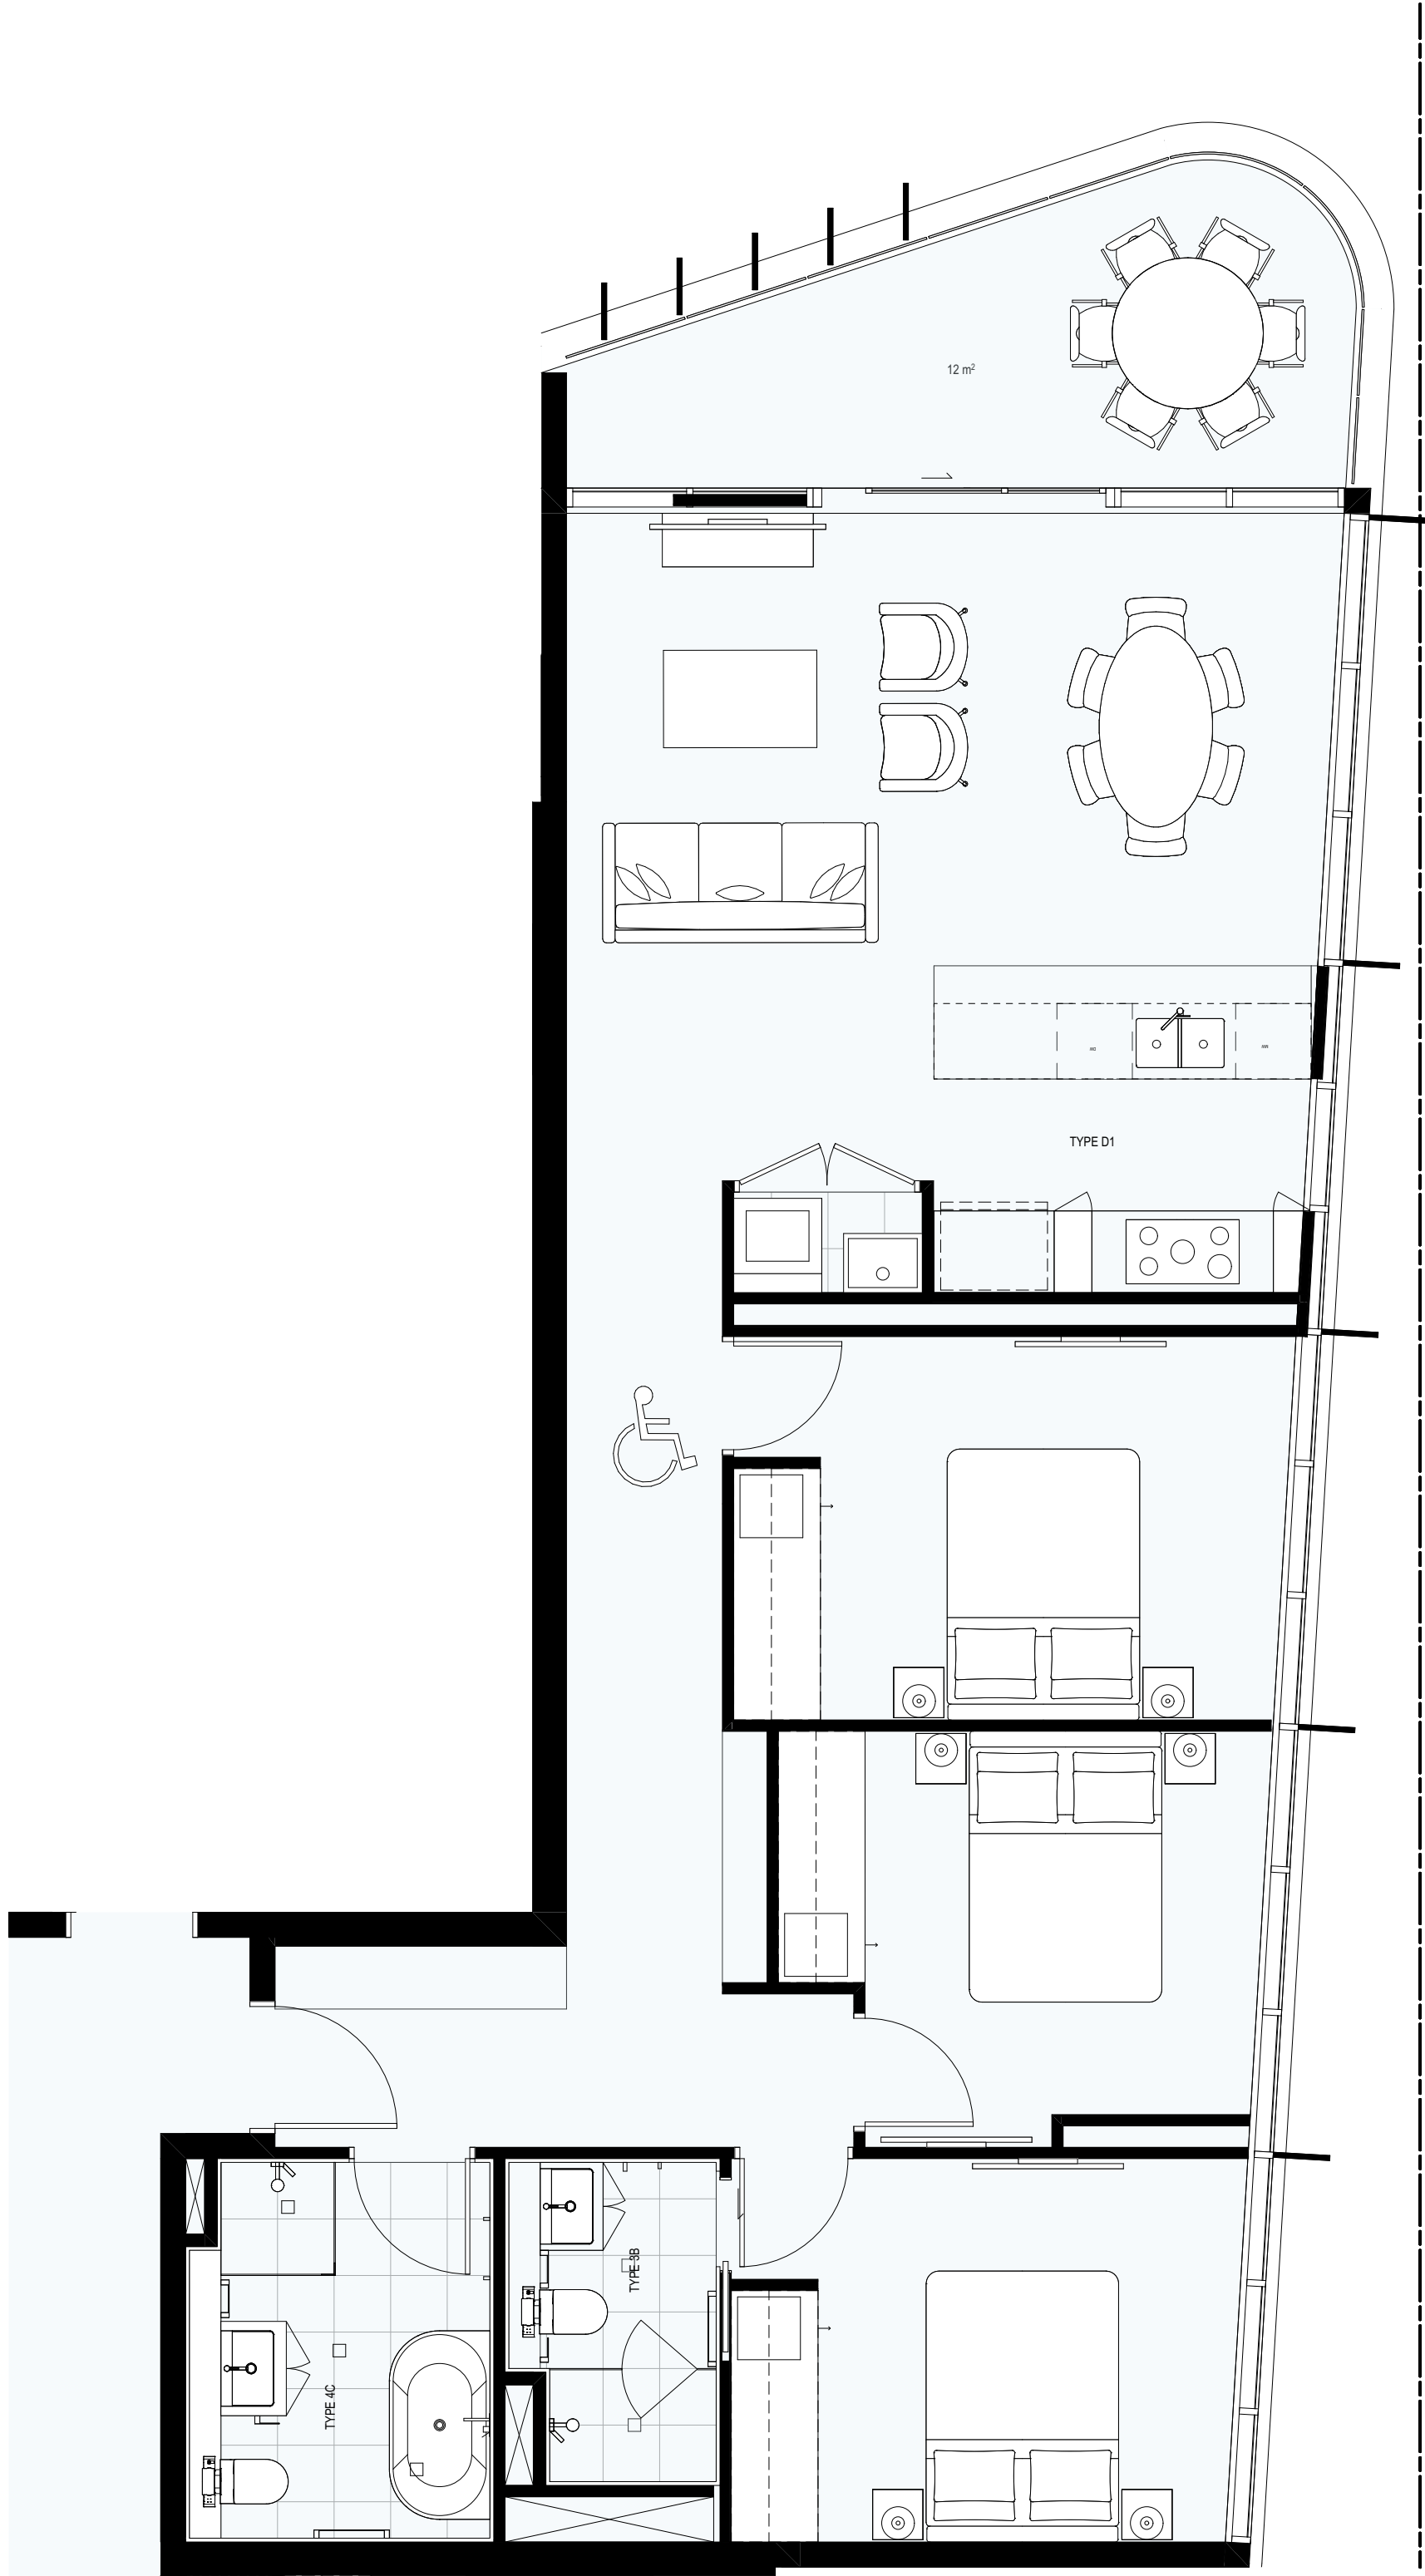

1 THREE BEDROOM UNIT - PRE ADAPTATION
SCALE 1:50 @ A1
SCALE 1:100 @ A3

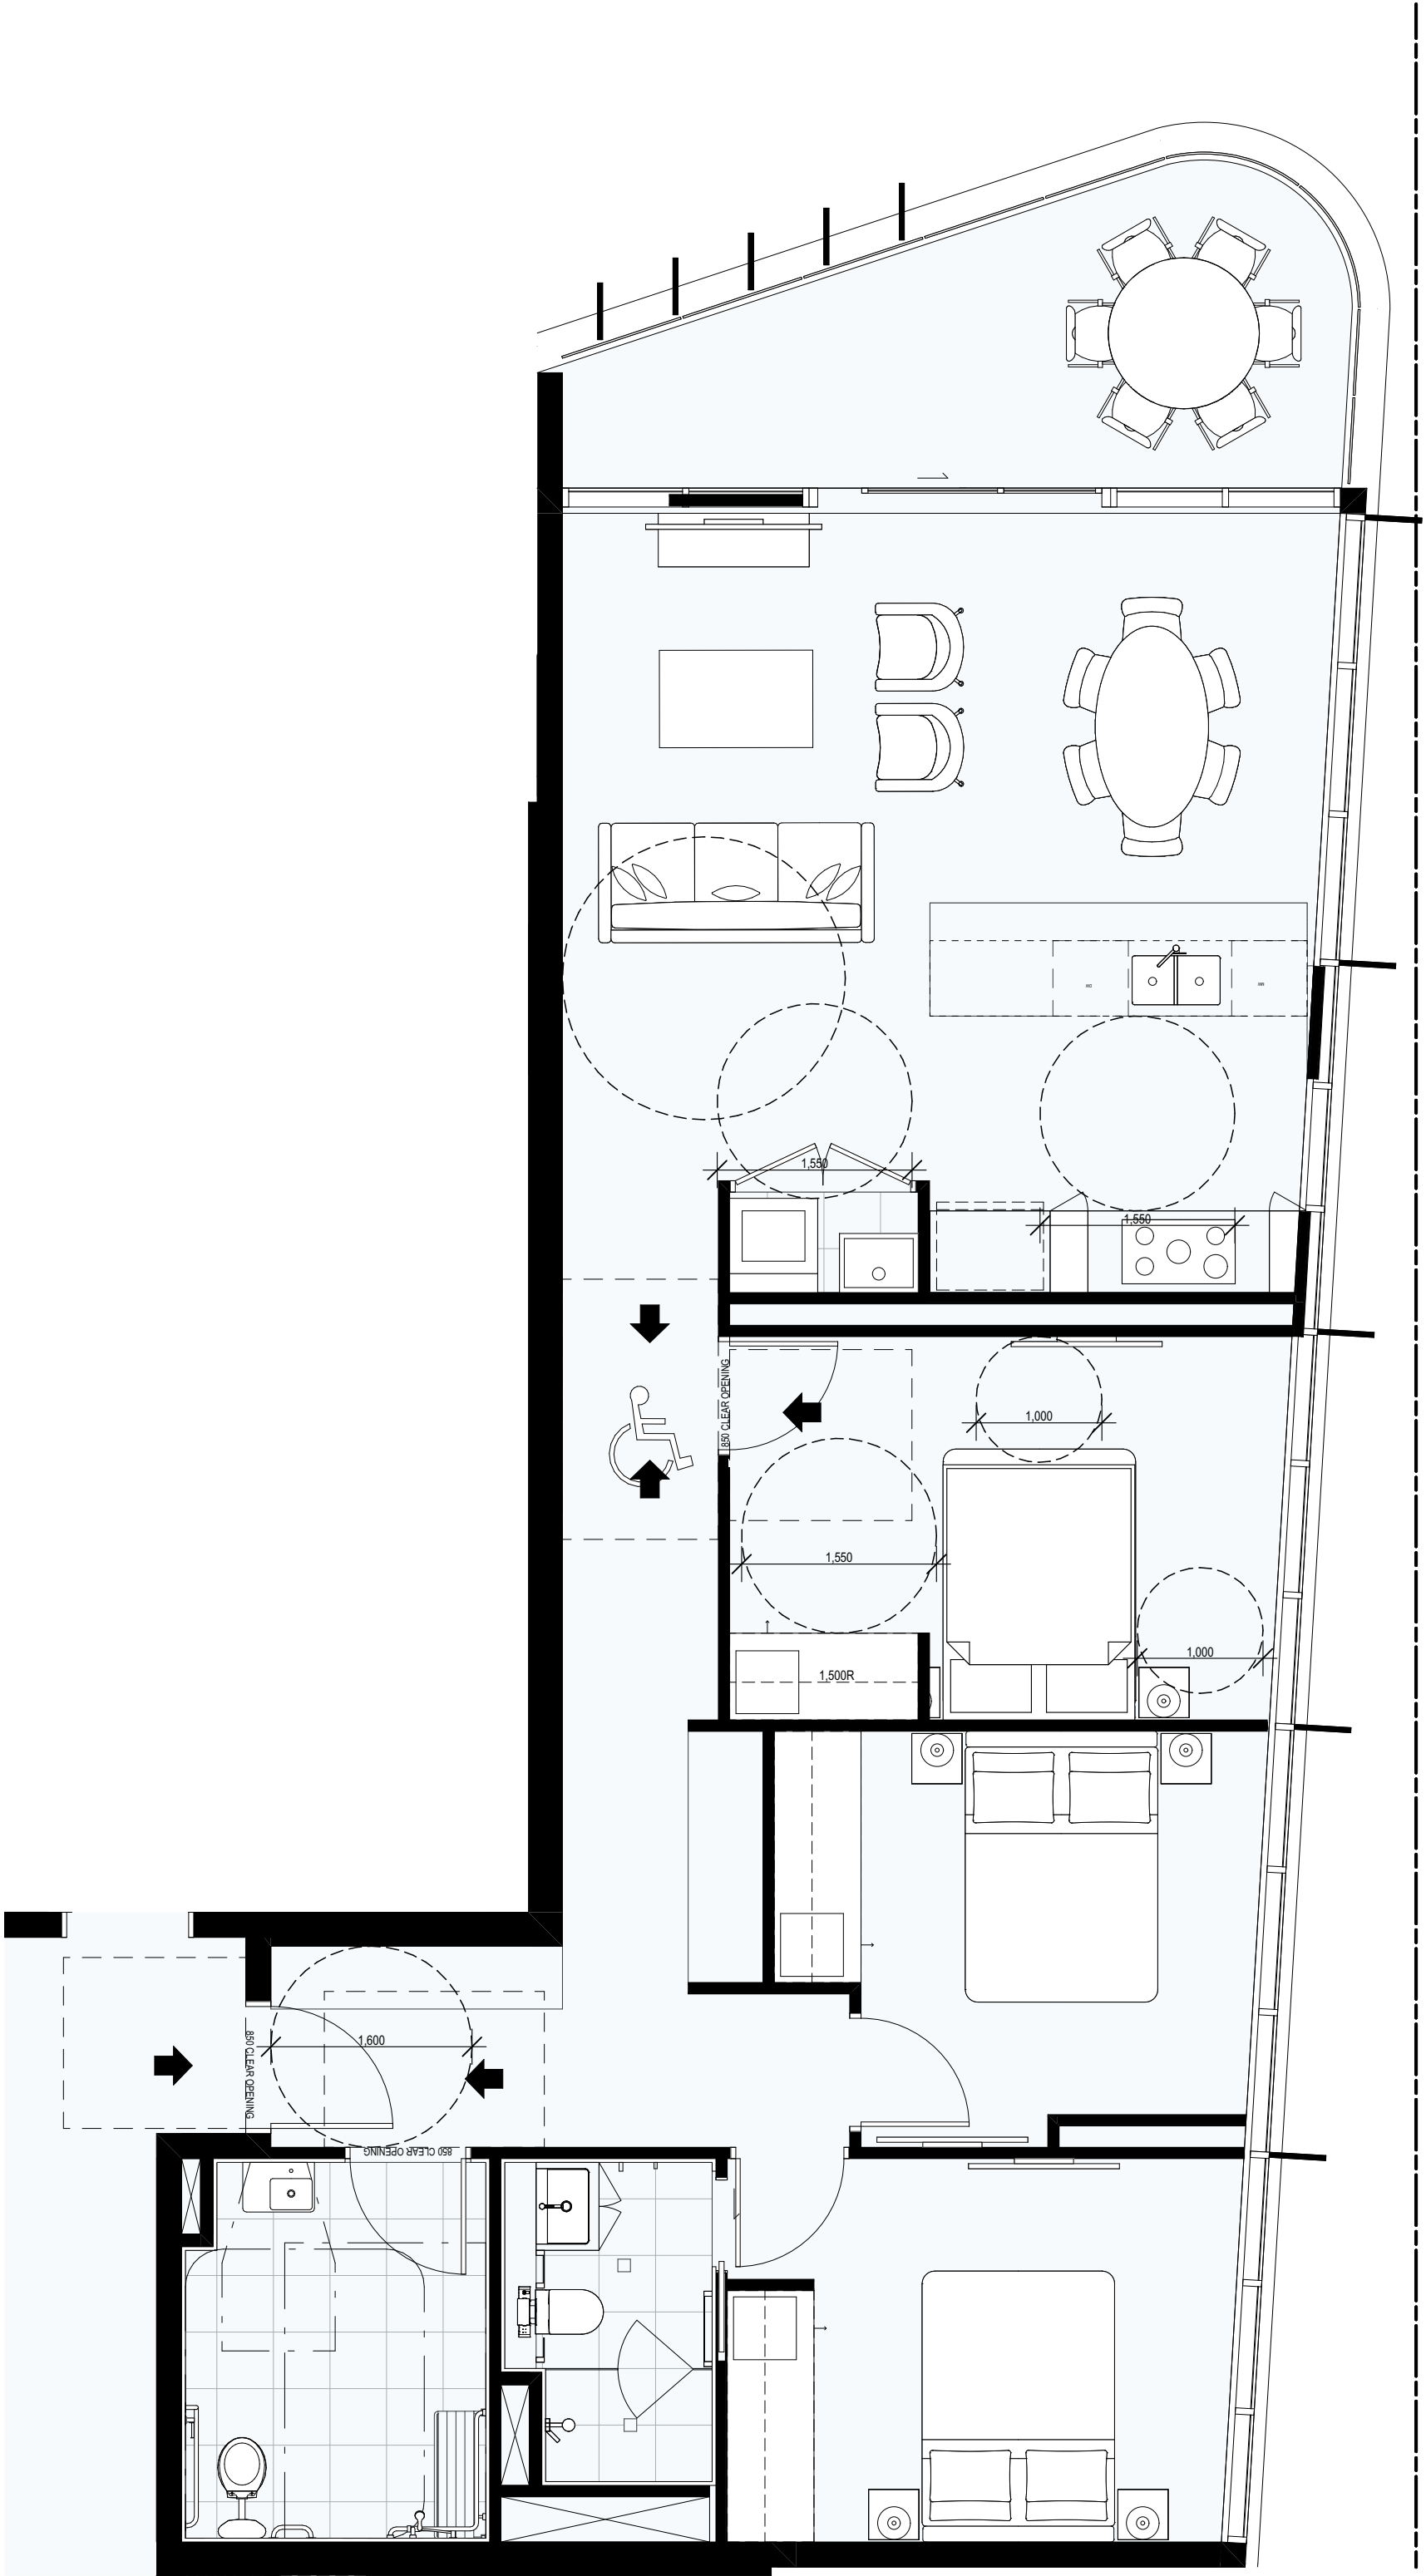

2 THREE BEDROOM UNIT - PRE ADAPTATION
SCALE 1:50 @ A1
SCALE 1:100 @ A3

UNITS:
211, 311, 411, 511

PAINT FINISHES

XP01: APPLIED PAINT FINISH - WHITE

XP02: APPLIED PAINT FINISH - BRONZE

XPC01: POWDERCOATED METAL FINISH - BRONZE

XPC02: POWDERCOATED METAL FINISH - PEWTER PEARL

WALL CLADDING

WC01: TIMBER LOOK CLADDING

XCL01: TINTED CONCRETE STAIN

XCL02: RIBBED CONCRETE

FENCE

XG05: GREY FROSTED GLASS

PC01: DARK GREY METAL SLATS

PC02: ACOUSTIC PERFORATED METAL PANELS

GLAZING

XG01: GREY GLASS

XG02: CLEAR GLASS

XG03: GREY COLOURBACK GLASS

XG04: TINTED FROSTED GLASS

1

NORTH ELEVATION

SCALE 1:100 @ A1

SCALE 1:200 @ A3

COTTEEPARKER

Darlinghurst

T 61 2 9366 1133

COTTEE PARKER ARCHITECTS PTY LTD

ABN 77 010 924 106

COTTEEPARKER.COM.AU

M

MERITON

0 1 2 3 4 5 6 7 8 9 10

SCALE 1:100 @ A1

SCALE 1:200 @ A3

MINOR CHANGES TO FORM AND CONFIGURATION MAY BE REQUIRED WHEN DRAWINGS ARE SUBSEQUENTLY PREPARED FOR CONSTRUCTION PURPOSES AFTER THE GRANT OF DEVELOPMENT CONSENT.

G	RESPONSE TO DRP COMMENTS	28/02/2025	CA	TJM	TJM
F	PRELIMINARY ISSUE	22/01/2025	CPA	TM	AD
E	PRELIMINARY ISSUE	17/01/2025	CPA	TM	AD
D	PRELIMINARY ISSUE	20.12.2024	CPA	TM	AD
C	RESPONSE TO COUNCIL RF1	03/09/2024	WZ	TJM	TJM
B	ISSUE FOR DA	18/06/2024	LA	TJM	ADM
A	ISSUE FOR DA	06/06/2024	LA	TM	TM
ISSUE PURPOSE	DATE	D	C	A	

FOR INFORMATION

PAGEWOOD LOT J

8 HEFFRON ROAD, EASTGARDENS

CLIENT - Meriton

DRAWING TITLE

ELEVATIONS - SHEET 01

JOB No 6914

DATE 28/02/2025

SD3001

G

PAINT FINISHES

XP01: APPLIED PAINT FINISH - WHITE

XP02: APPLIED PAINT FINISH - BRONZE

XPC01: POWDERCOATED METAL FINISH - BRONZE

XPC02: POWDERCOATED METAL FINISH - PEWTER PEARL

WALL CLADDING

WC01: TIMBER LOOK CLADDING

XCL01: TINTED CONCRETE STAIN

XCL02: RIBBED CONCRETE

FENCE

XG05: GREY FROSTED GLASS

PC01: DARK GREY METAL SLATS

PC02: ACOUSTIC PERFORATED METAL PANELS

GLAZING

XG01: GREY GLASS

XG02: CLEAR GLASS

XG03: GREY COLOURBACK GLASS

XG04: TINTED FROSTED GLASS

1

EAST ELEVATION

SCALE 1:100 @ A1

SCALE 1:200 @ A3

BUILDING B

COTTEEPARKER

Darlinghurst
T 61 2 9366 1133
COTTEE PARKER ARCHITECTS PTY LTD
ABN 77 010 924 106
COTTEEPARKER.COM.AU

0 1 2 3 4 5 6 7 8 9 10
SCALE 1:100 @ A1
SCALE 1:200 @ A3

MINOR CHANGES TO FORM AND CONFIGURATION MAY BE REQUIRED WHEN DRAWINGS ARE SUBSEQUENTLY PREPARED FOR CONSTRUCTION PURPOSES AFTER THE GRANT OF DEVELOPMENT CONSENT.

G	RESPONSE TO DRP COMMENTS	28/02/2025	CA	TJM	TJM
F	PRELIMINARY ISSUE	22/01/2025	CPA	TM	AD
E	PRELIMINARY ISSUE	17/01/2025	CPA	TM	AD
D	PRELIMINARY ISSUE	20.12.2024	CPA	TM	AD
C	RESPONSE TO COUNCIL RF1	03/09/2024	VIZ	TJM	TJM
B	ISSUE FOR DA	18/06/2024	LA	TJM	ADM
A	ISSUE FOR DA	06/06/2024	LA	TM	TM
ISSUE PURPOSE	DATE	D	C	A	

FOR INFORMATION

PAGEWOOD LOT J

8 HEFFRON ROAD, EASTGARDENS

CLIENT - Meriton

DRAWING TITLE

ELEVATIONS - SHEET 02

JOB No

6914

DRAWING No

SD3002

ISSUE

G

PAINT FINISHES

- XP01: APPLIED PAINT FINISH - WHITE
- XP02: APPLIED PAINT FINISH - BRONZE
- XPC01: POWDERCOATED METAL FINISH - BRONZE
- XPC02: POWDERCOATED METAL FINISH - PEWTER PEARL

WALL CLADDING

- WC01: TIMBER LOOK CLADDING
- XCL01: TINTED CONCRETE STAIN
- XCL02: RIBBED CONCRETE

FENCE

- XG05: GREY FROSTED GLASS
- PC01: DARK GREY METAL SLATS
- PC02: ACOUSTIC PERFORATED METAL PANELS

GLAZING

- XG01: GREY GLASS
- XG02: CLEAR GLASS
- XG03: GREY COLOURBACK GLASS
- XG04: TINTED FROSTED GLASS



COTTEEPARKER

Darlinghurst
T 61 2 9366 1133
COTTEE PARKER ARCHITECTS PTY LTD
ABN 77 010 924 106
COTTEEPARKER.COM.AU



0 1 2 3 4 5 6 7 8 9 10
SCALE 1:100 @ A1
SCALE 1:200 @ A3

MINOR CHANGES TO FORM AND CONFIGURATION MAY BE REQUIRED WHEN DRAWINGS ARE SUBSEQUENTLY PREPARED FOR CONSTRUCTION PURPOSES AFTER THE GRANT OF DEVELOPMENT CONSENT.

G	RESPONSE TO DRP COMMENTS	28/02/2025	CA	TJM	TJM
F	PRELIMINARY ISSUE	22/01/2025	CPA	TM	AD
E	PRELIMINARY ISSUE	17/01/2025	CPA	TM	AD
D	PRELIMINARY ISSUE	20.12.2024	CPA	TM	AD
C	RESPONSE TO COUNCIL RF1	03/09/2024	VIZ	TJM	TJM
B	ISSUE FOR DA	18/06/2024	LA	TJM	ADM
A	ISSUE FOR DA	06/06/2024	LA	TM	TM
ISSUE PURPOSE	DATE	D	C	A	

FOR INFORMATION

PAGEWOOD LOT J

8 HEFFRON ROAD, EASTGARDENS

CLIENT - Meriton

DRAWING TITLE

ELEVATIONS - SHEET 03

ISSUE

JOB No
6914

DRAWING No
SD3003

G

PAINT FINISHES

XP01: APPLIED PAINT FINISH - WHITE

XP02: APPLIED PAINT FINISH - BRONZE

XPC01: POWDERCOATED METAL FINISH - BRONZE

XPC02: POWDERCOATED METAL FINISH - PEWTER PEARL

WALL CLADDING

WC01: TIMBER LOOK CLADDING

XCL01: TINTED CONCRETE STAIN

XCL02: RIBBED CONCRETE

FENCE

XG05: GREY FROSTED GLASS

PC01: DARK GREY METAL SLATS

PC02: ACOUSTIC PERFORATED METAL PANELS

GLAZING

XG01: GREY GLASS

XG02: CLEAR GLASS

XG03: GREY COLOURBACK GLASS

XG04: TINTED FROSTED GLASS

COTTEEPARKER

Darlinghurst
T 61 2 9366 1133
COTTEE PARKER ARCHITECTS PTY LTD
ABN 77 010 924 106
COTTEEPARKER.COM.AU

0 1 2 3 4 5 6 7 8 9 10
SCALE 1:100 @ A1
SCALE 1:200 @ A3

MINOR CHANGES TO FORM AND CONFIGURATION MAY BE REQUIRED WHEN DRAWINGS ARE SUBSEQUENTLY PREPARED FOR CONSTRUCTION PURPOSES AFTER THE GRANT OF DEVELOPMENT CONSENT.

G	RESPONSE TO DRP COMMENTS	28/02/2025	CA	TJM	TJM
F	PRELIMINARY ISSUE	22/01/2025	CPA	TM	AD
E	PRELIMINARY ISSUE	17/01/2025	CPA	TM	AD
D	PRELIMINARY ISSUE	20.12.2024	CPA	TM	AD
C	RESPONSE TO COUNCIL RF1	03/09/2024	VZ	TJM	TJM
B	ISSUE FOR DA	18/06/2024	LA	TJM	ADM
A	ISSUE FOR DA	06/06/2024	LA	TM	TM
ISSUE PURPOSE	DATE	D	C	A	

FOR INFORMATION

PAGEWOOD LOT J

8 HEFFRON ROAD, EASTGARDENS
CLIENT - Meriton

DRAWING TITLE
ELEVATIONS - SHEET 04

JOB No
6914

DRAWING No
SD3004

ISSUE
G

PAINT FINISHES

XP01: APPLIED PAINT FINISH - WHITE

XP02: APPLIED PAINT FINISH - BRONZE

XPC01: POWDERCOATED METAL FINISH - BRONZE

XPC02: POWDERCOATED METAL FINISH - PEWTER PEARL

WALL CLADDING

WC01: TIMBER LOOK CLADDING

XCL01: TINTED CONCRETE STAIN

XCL02: RIBBED CONCRETE

FENCE

XG05: GREY FROSTED GLASS

PC01: DARK GREY METAL SLATS

PC02: ACOUSTIC PERFORATED METAL PANELS

GLAZING

XG01: GREY GLASS

XG02: CLEAR GLASS

XG03: GREY COLOURBACK GLASS

XG04: TINTED FROSTED GLASS

COTTEEPARKER

Darlinghurst
T 61 2 9366 1133
COTTEE PARKER ARCHITECTS PTY LTD
ABN 77 010 924 106
COTTEEPARKER.COM.AU

0 1 2 3 4 5 6 7 8 9 10
SCALE 1:100 @ A1
SCALE 1:200 @ A3

BIMcloud: CPACLD8IMM01 - BIMcloud/2200/6914 Pagewood Lot H & J 128 Bunnerong Rd Eastgardens DA Master: 28/02/2025: 4:41 PM

MINOR CHANGES TO FORM AND CONFIGURATION MAY BE REQUIRED WHEN DRAWINGS ARE SUBSEQUENTLY PREPARED FOR CONSTRUCTION PURPOSES AFTER THE GRANT OF DEVELOPMENT CONSENT.

G	RESPONSE TO DRP COMMENTS	28/02/2025	CA	TJM	TJM
F	PRELIMINARY ISSUE	22/01/2025	CPA	TM	AD
E	PRELIMINARY ISSUE	17/01/2025	CPA	TM	AD
D	PRELIMINARY ISSUE	20/12/2024	CPA	TM	AD
C	RESPONSE TO COUNCIL RF1	03/09/2024	VZ	TJM	TJM
B	ISSUE FOR DA	18/06/2024	LA	TJM	ADM
A	ISSUE FOR DA	06/06/2024	LA	TM	TM
ISSUE PURPOSE	DATE	D	C	A	

FOR INFORMATION

PAGEWOOD LOT J

8 HEFFRON ROAD, EASTGARDENS

CLIENT - Meriton

DRAWING TITLE

ELEVATIONS - SHEET 05

ISSUE

JOB No
6914

DRAWING No
SD3005

G

PAINT FINISHES

XP01: APPLIED PAINT FINISH - WHITE

XP02: APPLIED PAINT FINISH - BRONZE

XPC01: POWDERCOATED METAL FINISH - BRONZE

XPC02: POWDERCOATED METAL FINISH - PEWTER PEARL

WALL CLADDING

WC01: TIMBER LOOK CLADDING

XCL01: TINTED CONCRETE STAIN

XCL02: RIBBED CONCRETE

FENCE

XG05: GREY FROSTED GLASS

PC01: DARK GREY METAL SLATS

PC02: ACOUSTIC PERFORATED METAL PANELS

GLAZING

XG01: GREY GLASS

XG02: CLEAR GLASS

XG03: GREY COLOURBACK GLASS

XG04: TINTED FROSTED GLASS

COTTEEPARKER

Darlinghurst
T 61 2 9366 1133
COTTEE PARKER ARCHITECTS PTY LTD
ABN 77 010 924 106
COTTEEPARKER.COM.AU

0 1 2 3 4 5 6 7 8 9 10
SCALE 1:100 @ A1
SCALE 1:200 @ A3

MINOR CHANGES TO FORM AND CONFIGURATION MAY BE REQUIRED WHEN DRAWINGS ARE SUBSEQUENTLY PREPARED FOR CONSTRUCTION PURPOSES AFTER THE GRANT OF DEVELOPMENT CONSENT.

G	RESPONSE TO DRP COMMENTS	28/02/2025	CA	TJM	TJM
F	PRELIMINARY ISSUE	22/01/2025	CPA	TM	AD
E	PRELIMINARY ISSUE	17/01/2025	CPA	TM	AD
D	PRELIMINARY ISSUE	20/12/2024	CPA	TM	AD
C	RESPONSE TO COUNCIL RF1	03/09/2024	WZ	TJM	TJM
B	ISSUE FOR DA	18/06/2024	LA	TJM	ADM
A	ISSUE FOR DA	06/06/2024	LA	TM	TM
ISSUE PURPOSE	DATE	D	C	A	

FOR INFORMATION

PAGEWOOD LOT J

8 HEFFRON ROAD, EASTGARDENS

CLIENT - Meriton

DRAWING TITLE


ELEVATIONS - SHEET 06

ISSUE

JOB No
6914

DRAWING No
SD3006

G

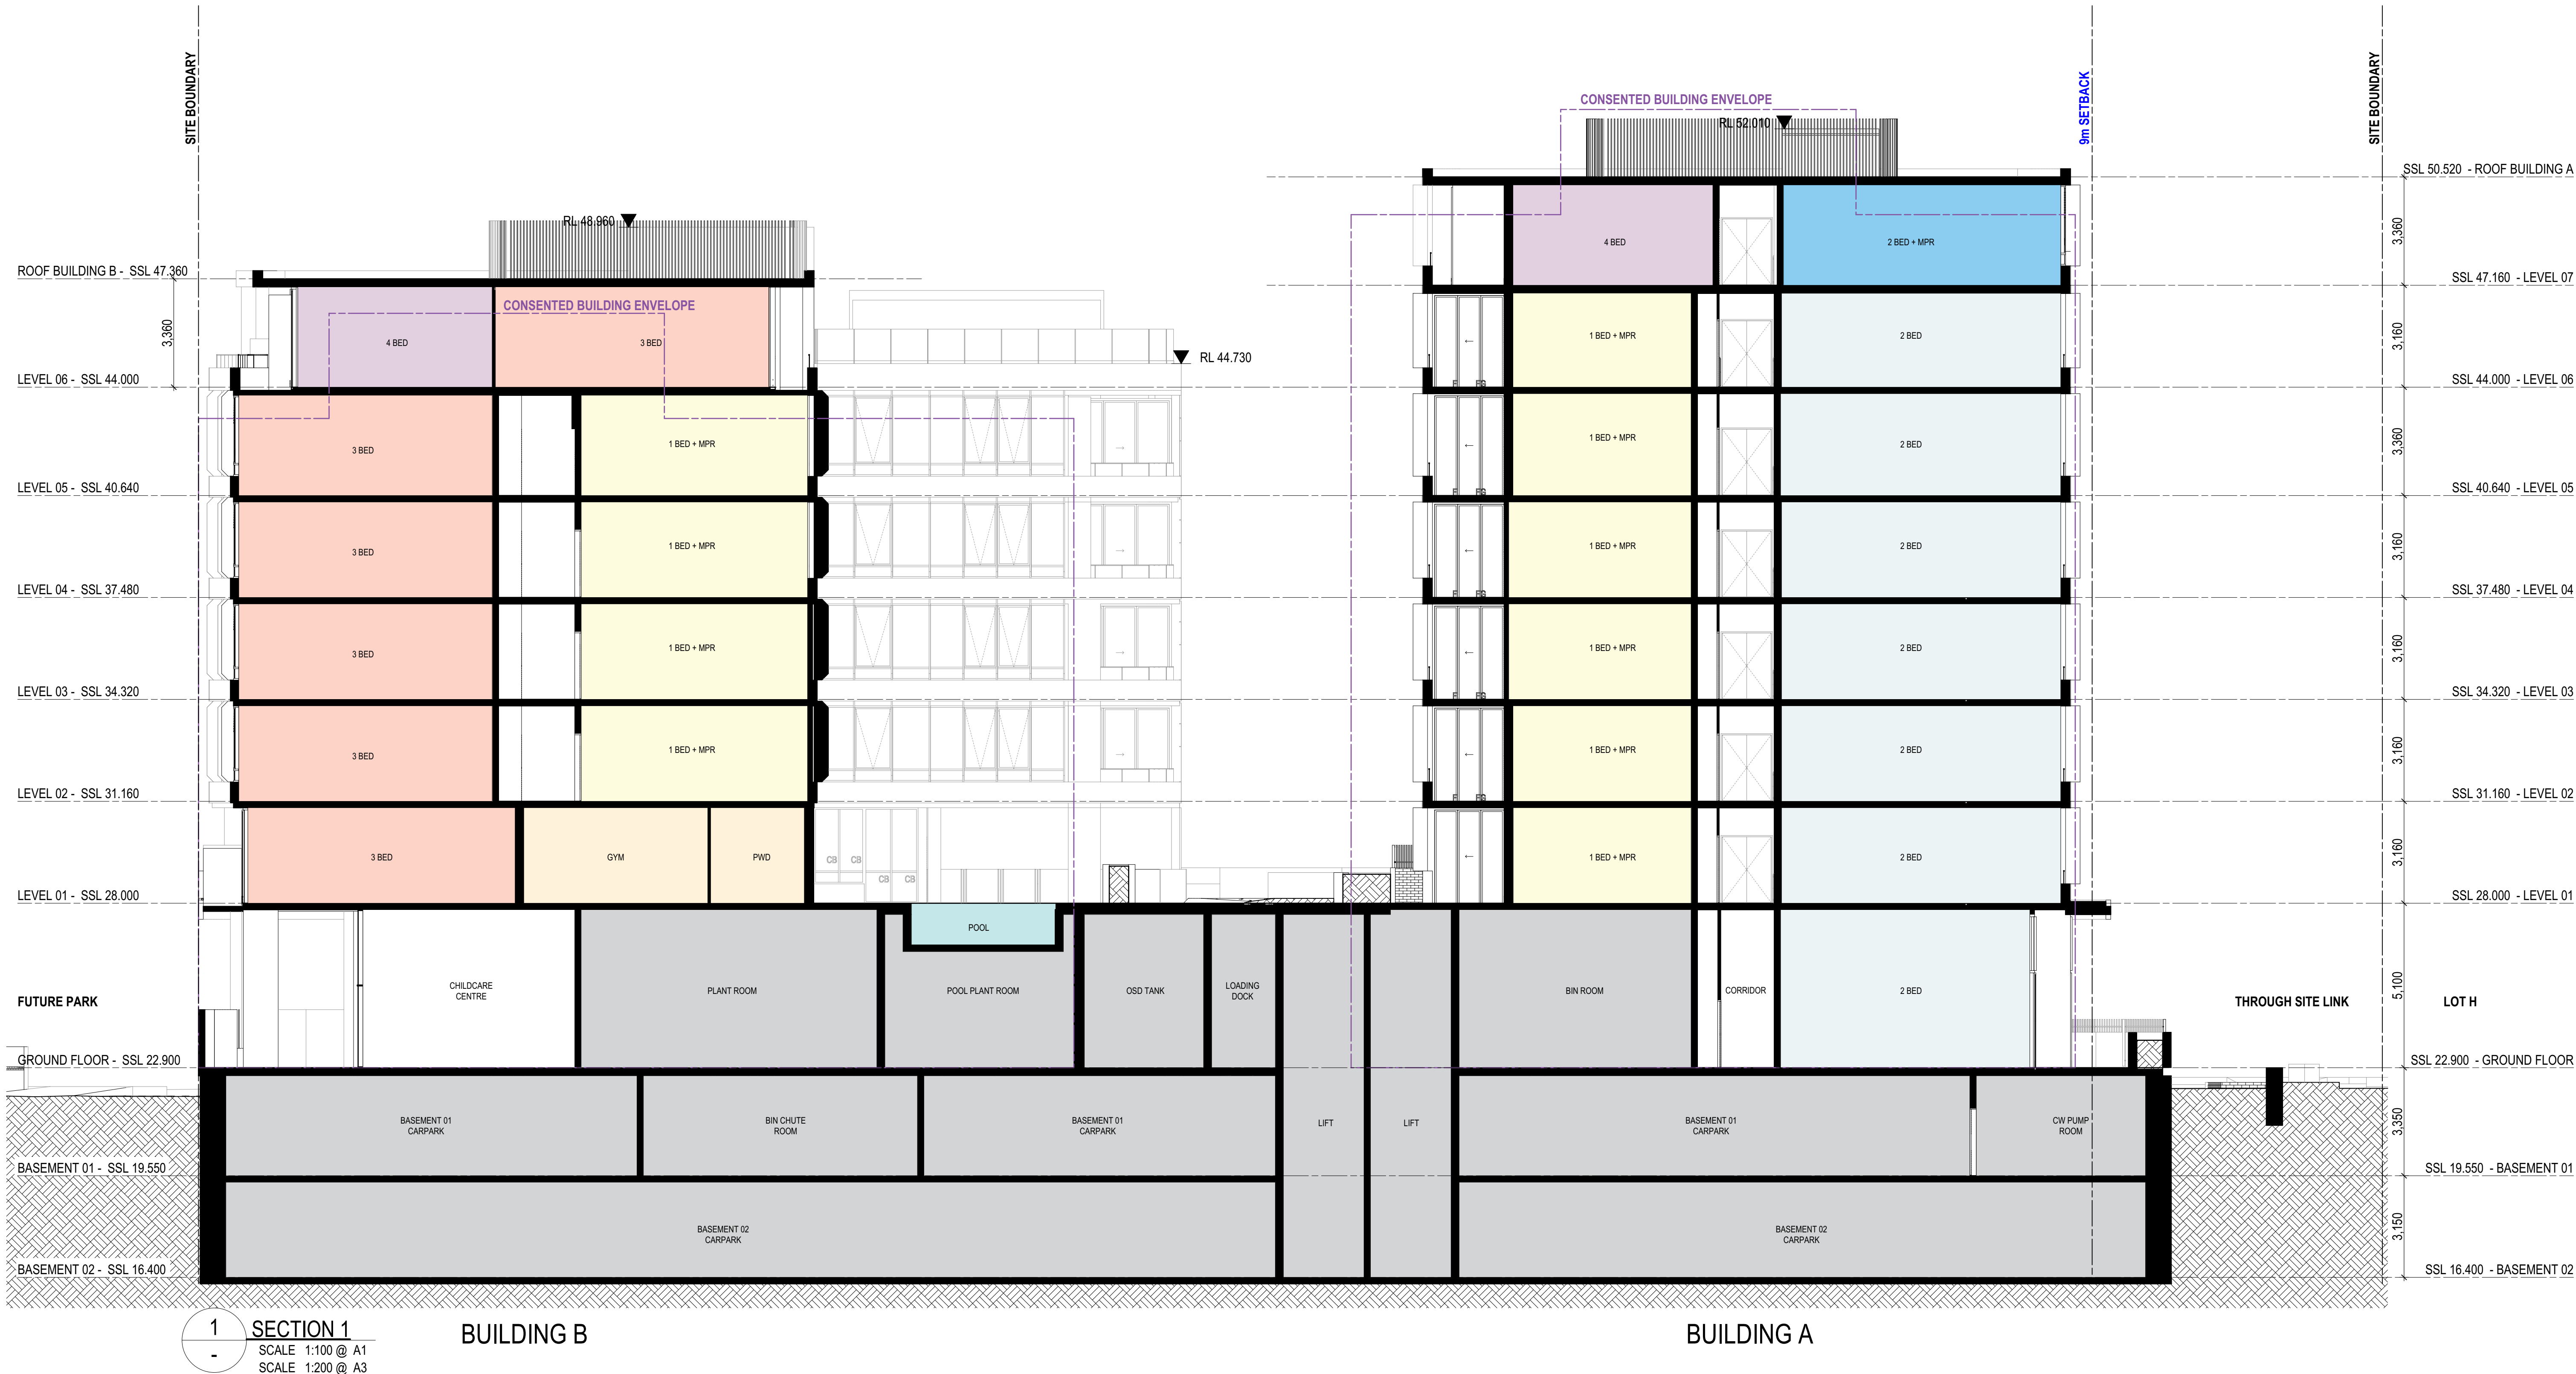

COTTEEPARKER

Darlinghurst
T 61 2 9366 1133
COTTEE PARKER ARCHITECTS PTY LTD
ABN 77 010 924 106
COTTEEPARKER.COM.AU



0 1 2 3 4 5 6 7 8 9 10
SCALE 1:100 @ A1
SCALE 1:200 @ A3

BIMcloud: CPACLBIM01 - BIMcloud/2200/6914 Pagewood Lot H & J 128 Bunnerong Rd Eastgardens DA Master: 22/01/2025: 4:59 PM

MINOR CHANGES TO FORM AND CONFIGURATION MAY BE REQUIRED WHEN DRAWINGS ARE SUBSEQUENTLY PREPARED FOR CONSTRUCTION PURPOSES AFTER THE GRANT OF DEVELOPMENT CONSENT.

D PRELIMINARY ISSUE
C PRELIMINARY ISSUE
B ISSUE FOR DA
A ISSUE FOR DA
ISSUE PURPOSE
DATE D C A

FOR INFORMATION

22/01/2025 CPA TM AD
20/12/2024 CPA TM AD
18/06/2024 LA TJM ADM
06/06/2024 LA TM TM


JOB No
6914

PAGEWOOD LOT J

8 HEFFRON ROAD, EASTGARDENS
CLIENT - Meriton

DRAWING TITLE
SECTIONS - SHEET 01

DRAWING No
SD3101
ISSUE
D

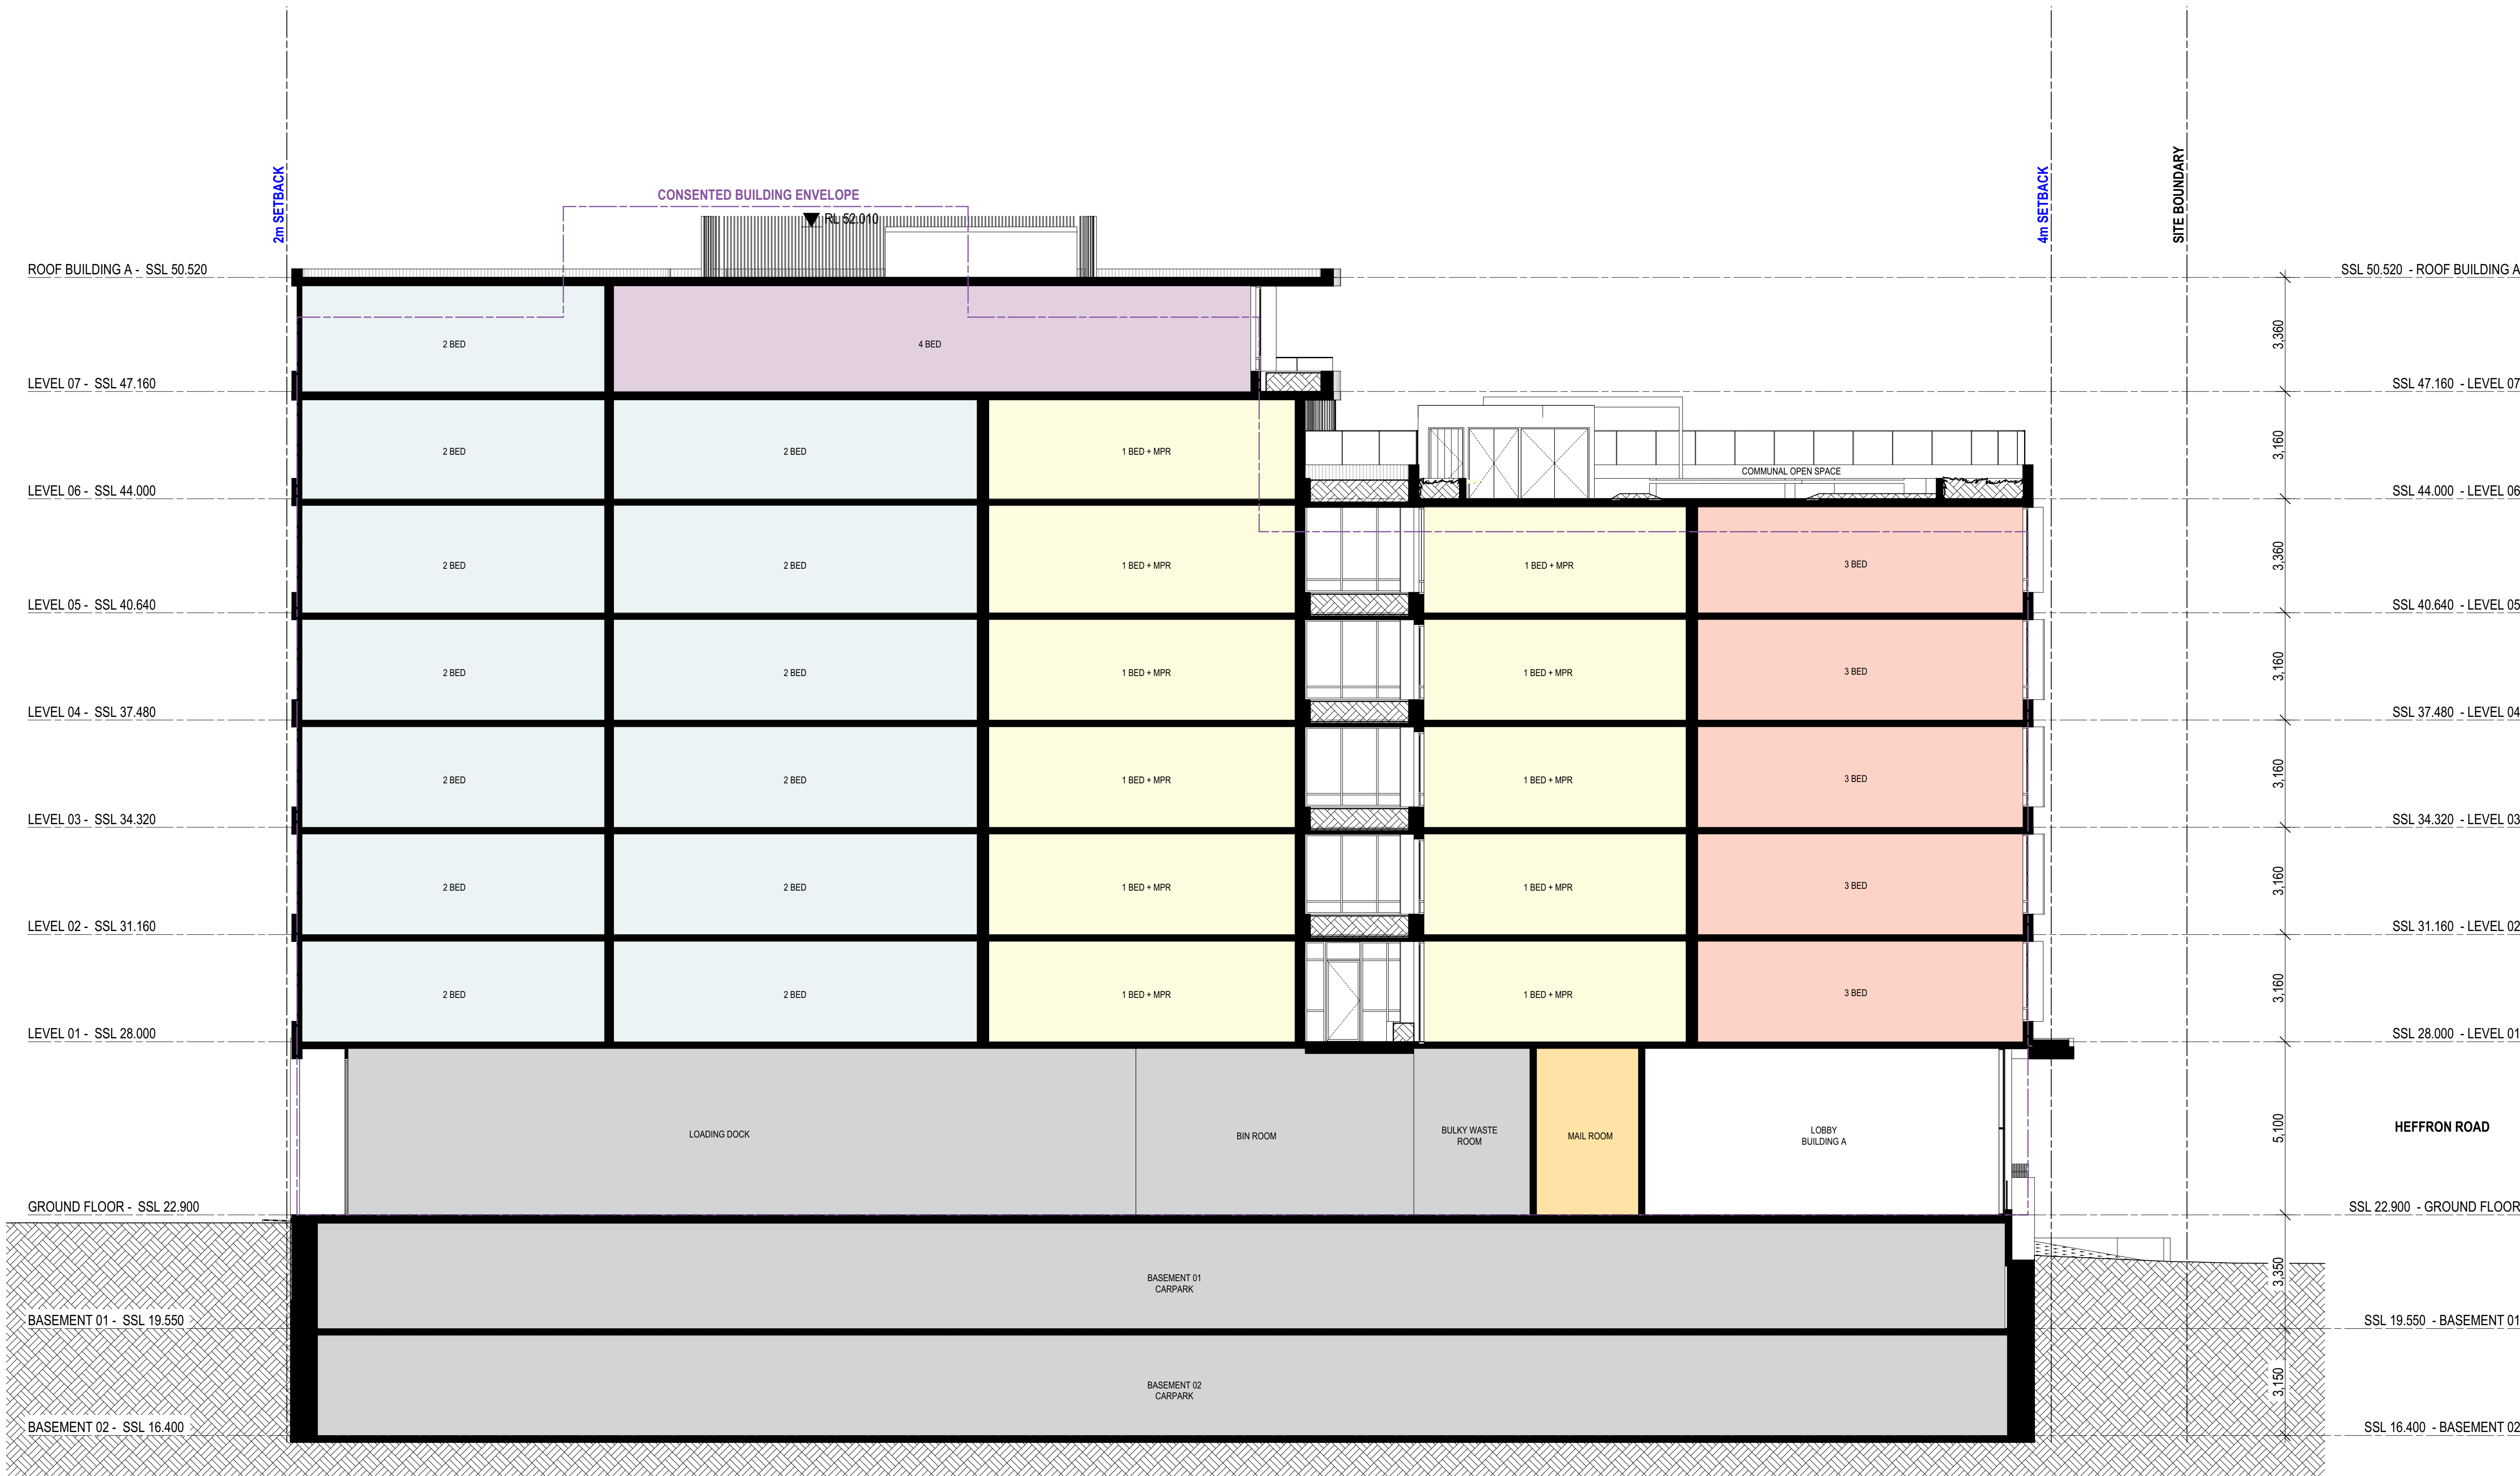

BUILDING A

1 SECTION 2
SCALE 1:100 @ A1
SCALE 1:200 @ A3

COTTEEPARKER

Darlinghurst
T 61 2 9366 1133
COTTEE PARKER ARCHITECTS PTY LTD
ABN 77 010 924 106
COTTEEPARKER.COM.AU



0 1 2 3 4 5 6 7 8 9 10
SCALE 1:100 @ A1
SCALE 1:200 @ A3

BIMcloud: CPACLDIMM01 - BIMcloud/2200/6914 Pagewood Lot H & J 128 Bunnerong Rd Eastgardens DA Master: 22/01/2025: 4:45 PM

MINOR CHANGES TO FORM AND CONFIGURATION MAY BE REQUIRED WHEN DRAWINGS ARE SUBSEQUENTLY PREPARED FOR CONSTRUCTION PURPOSES AFTER THE GRANT OF DEVELOPMENT CONSENT.

D PRELIMINARY ISSUE
C PRELIMINARY ISSUE
B ISSUE FOR DA
A ISSUE FOR DA
ISSUE PURPOSE
DATE D C A

22/01/2025 CPA TM AD
20/12/2024 CPA TM AD
18/06/2024 LA TJM ADM
06/06/2024 LA TM TM

FOR INFORMATION

JOB No

6914

PAGWOOD LOT J

8 HEFFRON ROAD, EASTGARDENS

CLIENT - Meriton

DRAWING TITLE

SECTIONS - SHEET 02

DRAWING No

SD3102

ISSUE

D

PAINT FINISHES

XP01: APPLIED PAINT FINISH - WHITE

XP02: APPLIED PAINT FINISH - BRONZE

XPC01: POWDERCOATED METAL FINISH - BRONZE

XPC02: POWDERCOATED METAL FINISH - PEWTER PEARL

WALL CLADDING

WC01: TIMBER LOOK CLADDING

XCLO1: TINTED CONCRETE STAIN

XCLO2: RIBBED CONCRETE

FENCE

XG05: GREY FROSTED GLASS

PC01: DARK GREY METAL SLATS

PC02: ACOUSTIC PERFORATED METAL PANELS

GLAZING

XG01: GREY GLASS

XG02: CLEAR GLASS

XG03: GREY COLOURBACK GLASS

XG04: TINTED FROSTED GLASS

COTTEEPARKER 

Darlinghurst
T 61 2 9366 1133
COTTEE PARKER ARCHITECTS PTY LTD
ABN 77 010 924 106
COTTEEPARKER.COM.AU



BIMcloud: CPACLBIMM01 - BIMcloud/2200/6914 Pagewood Lot H & J 128 Bunnerong Rd Eastgardens DA Master: 28/02/2025: 4:41 PM

MINOR CHANGES TO FORM AND CONFIGURATION MAY BE REQUIRED WHEN DRAWINGS ARE SUBSEQUENTLY PREPARED FOR CONSTRUCTION PURPOSES AFTER THE GRANT OF DEVELOPMENT CONSENT.

E	RESPONSE TO DRP COMMENTS	28/02/2025	CA	TJM	TJM
D	PRELIMINARY ISSUE	22/01/2025	CPA	TM	AD
C	RESPONSE TO COUNCIL RF1	03/09/2024	VZ	TJM	TJM
B	ISSUE FOR DA	18/06/2024	LA	TJM	ADM
A	ISSUE FOR DA	06/06/2024	LA	TM	TM
ISSUE PURPOSE	DATE	D	C	A	

FOR INFORMATION

JOB No
6914

PAGEWOOD LOT J
8 HEFFRON ROAD, EASTGARDENS

CLIENT - Meriton

DRAWING TITLE
EXTERIOR FINISHES

DRAWING No
SD6500

ISSUE
E