


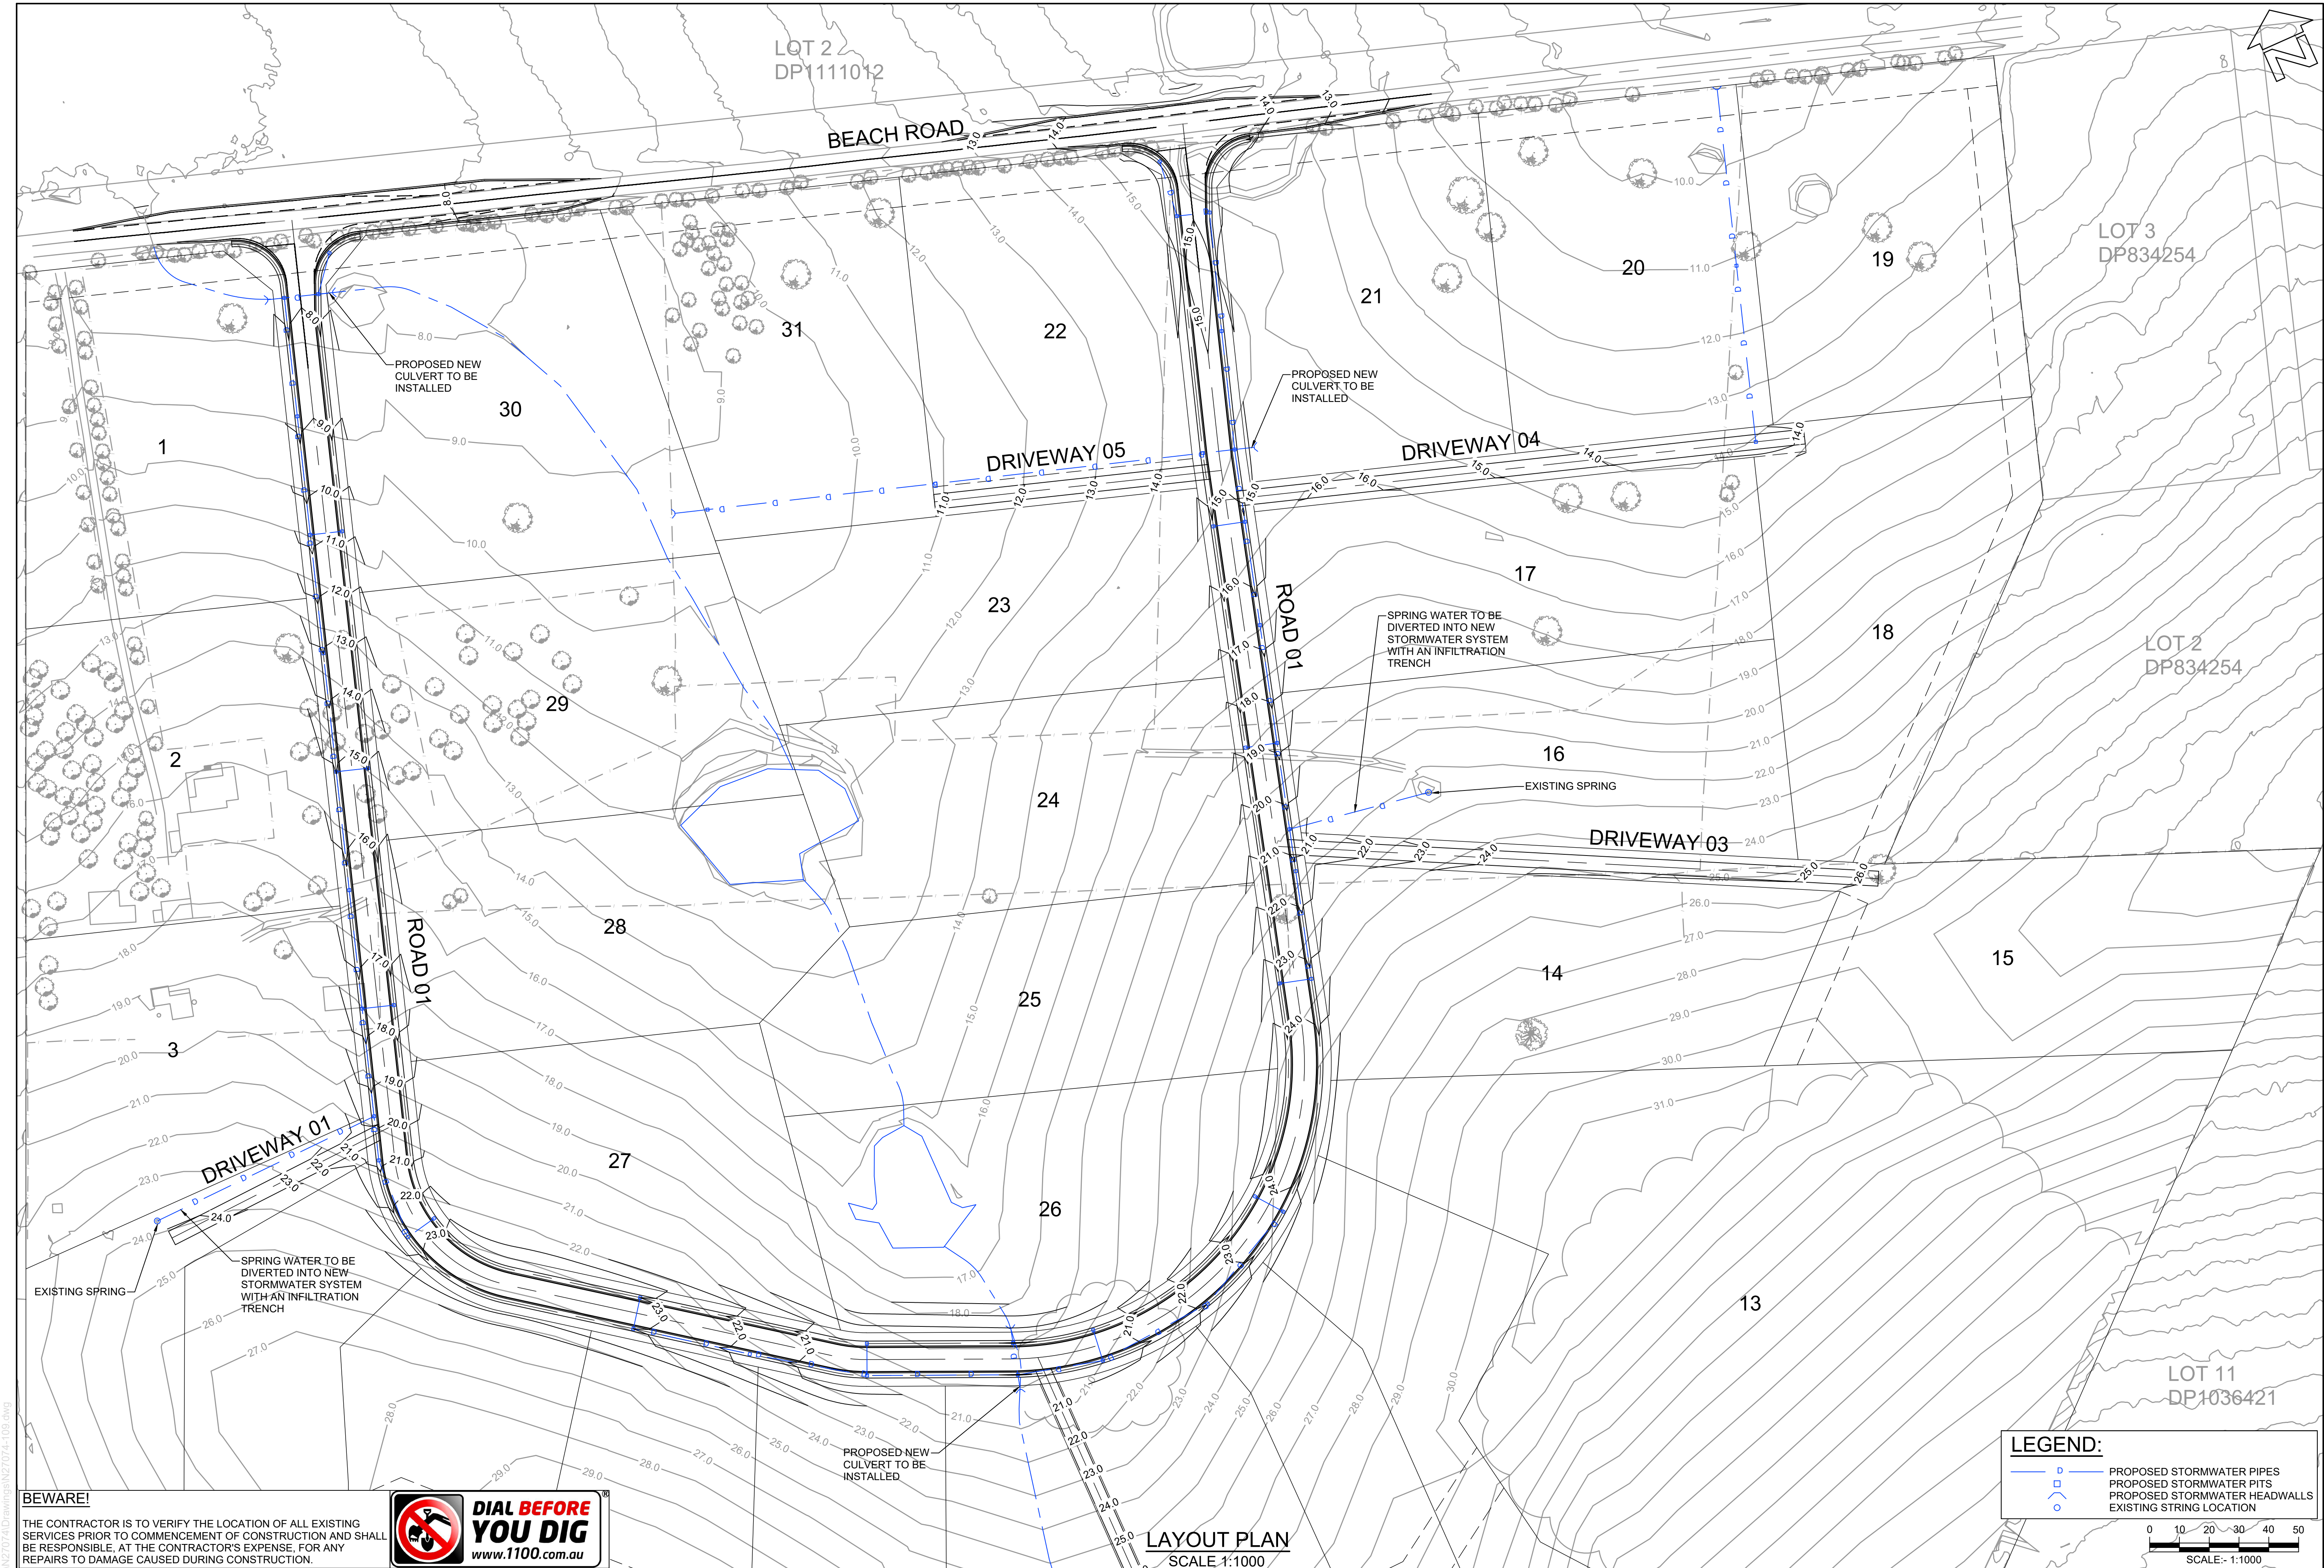

BEWARE!
THE CONTRACTOR IS TO VERIFY THE LOCATION OF ALL EXISTING SERVICES PRIOR TO COMMENCEMENT OF CONSTRUCTION AND SHALL BE RESPONSIBLE, AT THE CONTRACTOR'S EXPENSE, FOR ANY REPAIRS TO DAMAGE CAUSED DURING CONSTRUCTION.

DIAL BEFORE YOU DIG
www.1100.com.au

LAYOUT PLAN
SCALE 1:1000

LEGEND:
— PROPOSED STORMWATER PIPES
□ PROPOSED STORMWATER PITS
— PROPOSED STORMWATER HEADWALLS
○ EXISTING STRING LOCATION

0 10 20 30 40 50
SCALE:- 1:1000

RATIO: 1:1000 (AT A1 ORIGINAL)		DATUM: AUSTRALIAN HEIGHT DATUM ORIGIN: SSM RL DATE OF PLAN: FEBRUARY 2020	SURVEY DESIGN C/JG DRAWN C/JG CHECK'D MP	APS C/JG MP	REV =	DESCRIPTION	BY	DATE	allen price & scarratts pty ltd land and development consultants Nowra Office: 75 Plunkett Street, Nowra NSW 2541 Kiama Office: 1/28 Bong Bong Street, Kiama NSW 2533 phone: (02) 4421 6544 consultants@allenprice.com.au www.allenprice.com.au		STORMWATER DRAINAGE LAYOUT PLAN SHEET 01 PROPOSED RESIDENTIAL SUBDIVISION OVER LOT 4 DP 834254 AT 510 BEACH ROAD, BERRY FOR ENID HALL (RICHARD HALL AND ROBYN BATES)		DRAWING STATUS PRELIMINARY NOT TO BE USED FOR CONSTRUCTION PURPOSES	DRAWING NUMBER N27074-109	SHEET OF 17	REVISION P0
--	--	---	---	-------------------	----------	-------------	----	------	---	--	--	--	--	-------------------------------------	-----------------------	-----------------------