


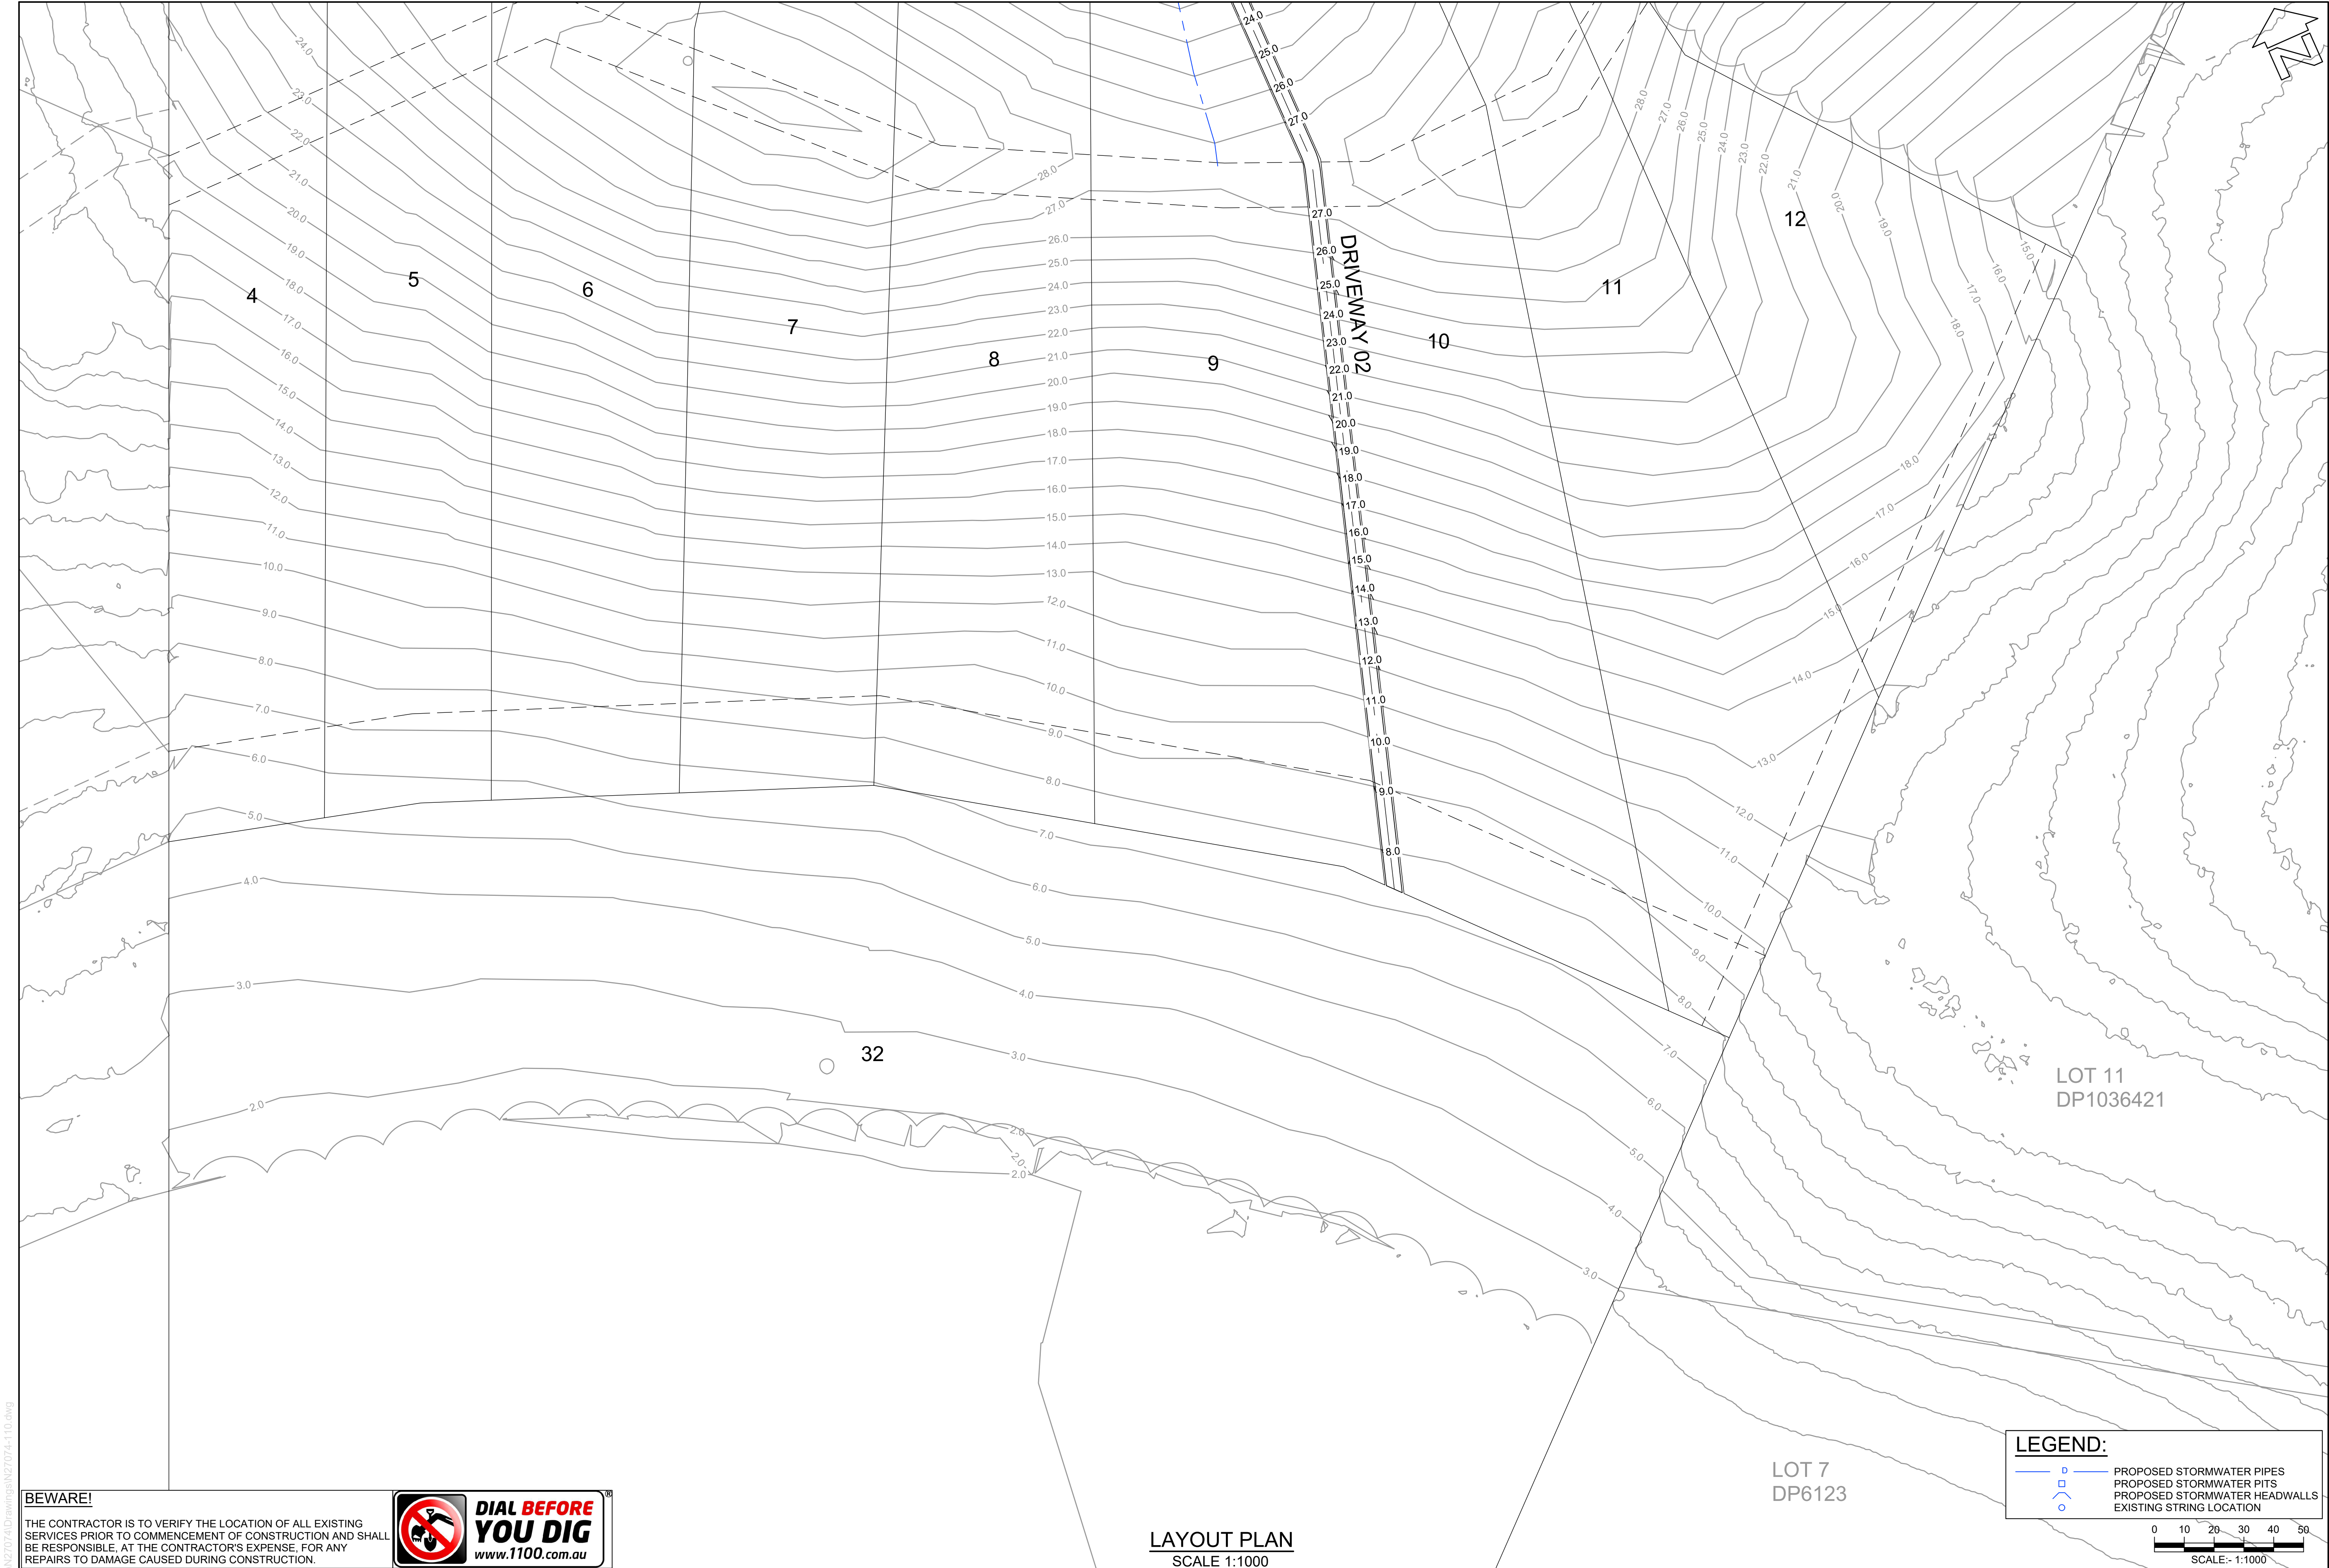

BEWARE!
THE CONTRACTOR IS TO VERIFY THE LOCATION OF ALL EXISTING SERVICES PRIOR TO COMMENCEMENT OF CONSTRUCTION AND SHALL BE RESPONSIBLE, AT THE CONTRACTOR'S EXPENSE, FOR ANY REPAIRS TO DAMAGE CAUSED DURING CONSTRUCTION.

**DIAL BEFORE YOU DIG**
www.1100.com.au

LAYOUT PLAN
SCALE 1:1000

RATIO: 1:1000 (AT A1 ORIGINAL)	DATUM: AUSTRALIAN HEIGHT DATUM	SURVEY	APS	REV	DESCRIPTION	BY	DATE	 allen price & scarratts pty ltd land and development consultants Nowra Office: 75 Plunkett Street, Nowra NSW 2541 Kiama Office: 1/28 Bong Bong Street, Kiama NSW 2533 phone: (02) 4421 6544 consultants@allenprice.com.au www.allenprice.com.au	STORMWATER DRAINAGE LAYOUT PLAN SHEET 02 PROPOSED RESIDENTIAL SUBDIVISION OVER LOT 4 DP 834254 AT 510 BEACH ROAD, BERRY FOR ENID HALL (RICHARD HALL AND ROBYN BATES)	DRAWING STATUS PRELIMINARY NOT TO BE USED FOR CONSTRUCTION PURPOSES		
	ORIGIN: SSM RL	DESIGN	CJG	=						DRAWING NUMBER N27074-110	SHEET 10 OF 17	REVISION P0
		DRAWN	CJG									
	CHECK'D	MP										
	DATE OF PLAN: FEBRUARY 2020											