
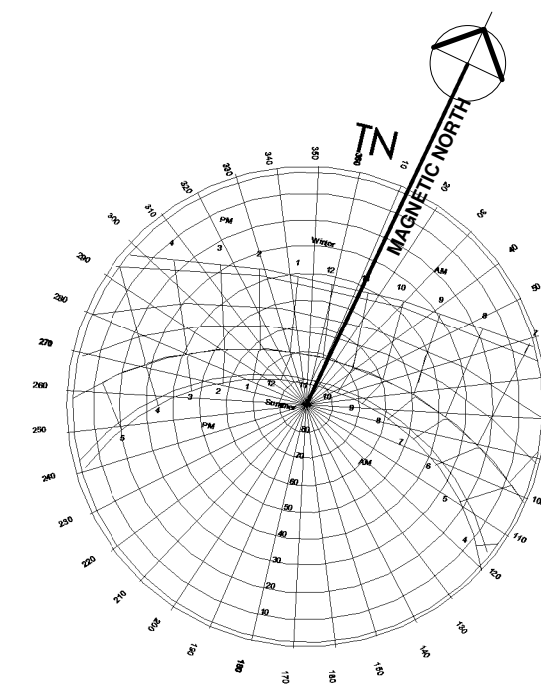


CONTRACTORS MUST VERIFY ALL DIMENSIONS ON SITE BEFORE COMMENCING ANY WORK OR PREPARING SHOP DRAWINGS


All Architectural drawing sheets to be cross-referenced with other relevant disciplines.

Rev	Description	Date
-----	-------------	------

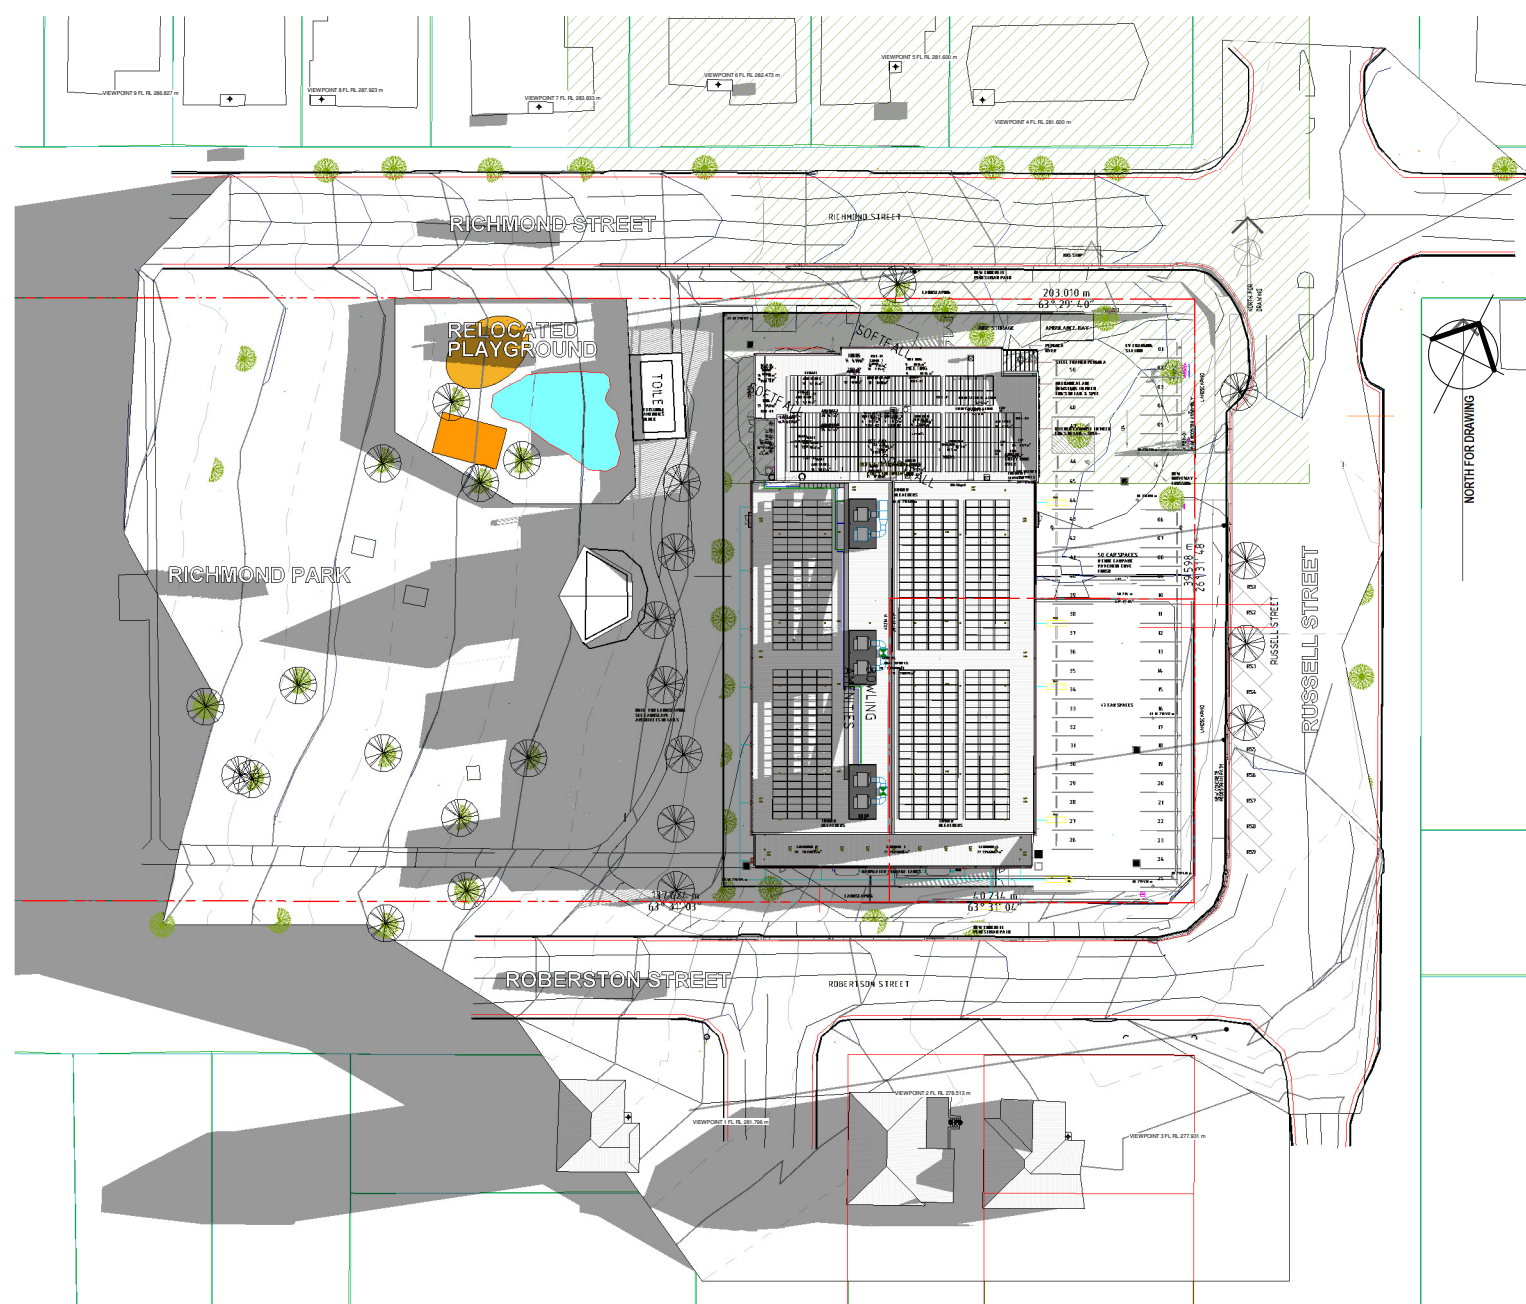

1 SITE PLAN Solar Study WINTER SOLSTICE 2025 9.00am
1:500

 NOTE: SCALE IS 1:1000 @ A3



CONSULTANT 4: **WEBB AUSTRALIA GROUP (NSW) PTY LTD**
 LEVEL 2 17 BOLTON STREET
 NEWCASTLE NSW 2300 AUSTRALIA
 T 41 2 4929 5225 F 41 41 478 412 035
 MECHANICAL ENGINEERING

CONSULTANT 3: **GLENN HAIG & PARTNERS** Coffs Harbour
 P. 62 4658 2444 P. 62 9310 3552
 PO Box 302 PO Box 689
 SAWTELL, NSW, 2452 SURRY HILLS, NSW, 2018
HYDRAULIC + FIRE CONSULTANTS office@glennhaig.com.au

CONSULTANT 2: **SPECTRUM** 1 Davis Place
 Glenhaven NSW 2156
 ENGINEERING SOLUTIONS Phone: (02) 8850 6802
 Mobile: 0419 294 533
 Email: nash@spectrumgsolutions.com.au

CONSULTANT 1: **PM DESIGN GROUP**
 50 Gheringhap Street
 Geelong, Victoria, Australia 3320
 PH: 03 5249 4800
 e: pdg@pmdesign.com.au
 STRUCTURAL + CIVIL ENGINEERING

DESIGN ARCHITECT: **FACILITY DESIGN GROUP** NSW Reg. No. 7148
 ABN: 75 583 999 424
 info@fdg.com.au
 www.fdg.com.au
 PO Box 62, Camberwata NSW 2540
 AQUATIC ■ SPORTS ■ LEISURE ■ CIVIC ■ PROJECT MANAGEMENT

CLIENT: **Snowy Valleys Council**

PROJECT NAME:
MULTIPURPOSE + EVACUATION CENTRE

FOR DA

PROJECT ADDRESS:
 RICHMOND PARK, TUMUT NSW
 Lot 1 Section 81 DP 759004 and
 Lot 701 DP 1059193.

DRAWING TITLE:
SHADOW DIAGRAMS - 9.00am

A1 PRINT SIZE

SHEET ISSUE DATE: 28.02.2025	DRAWING NO.	REV.
REVISION DATE:	@ A1	A.053.A
SCALE: 1:500	JOB NO.:	W366

DRAWN BY: AT CHECKED BY: S. JOHANSSON



COPYRIGHT FACILITY DESIGN GROUP PTY. LIMITED. ALL RIGHTS RESERVED. DO NOT SCALE OFF DRAWINGS. WORK TO FIGURED DIMENSIONS ONLY. VERIFY DIMENSIONS ON SITE PRIOR TO COMMENCING WORK.

NOMINATED ARCHITECT: STEPHEN JOHANSSON - NSW REG No. 7148
 20/06/2025 12:03:44 PM

CONTRACTORS MUST VERIFY ALL DIMENSIONS ON SITE BEFORE COMMENCING ANY WORK OR PREPARING SHOP DRAWINGS

All Architectural drawing sheets to be cross-referenced with other relevant disciplines.

Rev	Description	Date
-----	-------------	------

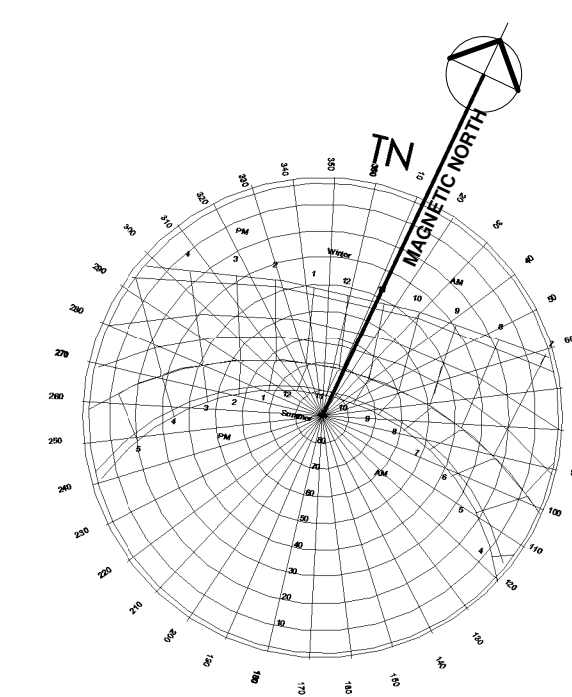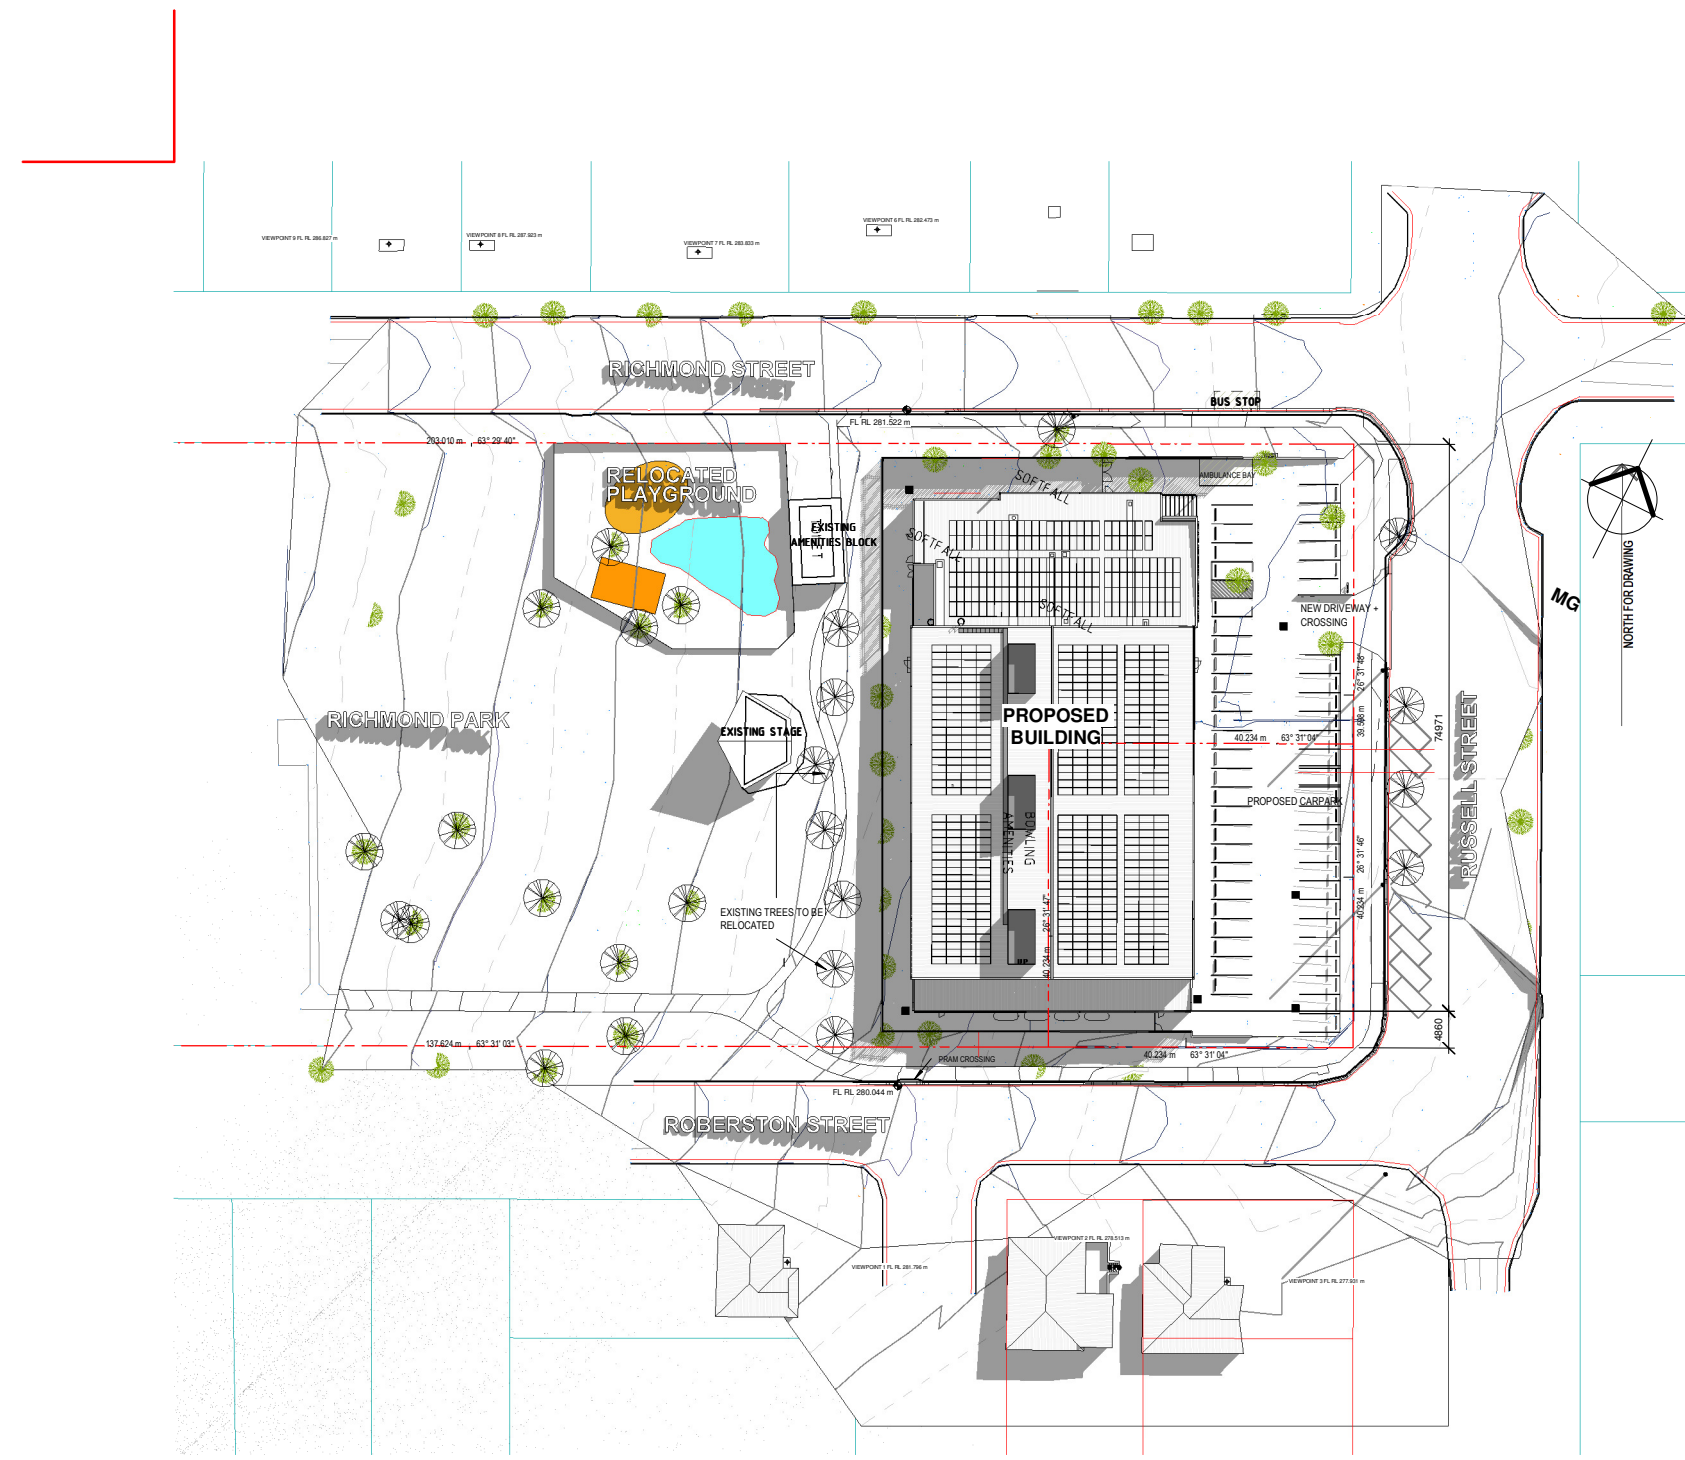

1 SITE PLAN Solar Study WINTER SOLSTICE 2025 12.00pm
1:500

CONSULTANT 4:
WEBB AUSTRALIA GROUP (NSW) PTY LTD
LEVEL 2 17 BOLTON STREET
NEWCASTLE NSW 2300 AUSTRALIA
T 41 2 409 5225 F 41 428 412 035
MECHANICAL ENGINEERING

CONSULTANT 3:
GLENN HAIG & PARTNERS
Coffs Harbour
P 62 4658 2444 P 62 9310 3552
PO Box 302 PO Box 689
SARTELL, NSW, 2452 SURRY HILLS, NSW, 2018
HYDRAULIC + FIRE CONSULTANTS office@glennhaig.com.au

CONSULTANT 2:
SPECTRUM ENGINEERING SOLUTIONS
1 Davis Place
Glenhaven NSW 2156
Phone: (02) 8850 4802
Mobile: 0419 294 533
Email: info@spectrumengineering.com.au

CONSULTANT 1:
PM DESIGN GROUP
50 Gheringhap Street
Geelong, Victoria, Australia 3320
PH: 03 5249 4800
e: gpm@pmdesign.com.au
STRUCTURAL + CIVIL ENGINEERING

DESIGN ARCHITECT:
FACILITY DESIGN GROUP
NSW Reg. No. 7148
ABN: 75 033 999 424
info@fdg.com.au
www.fdg.com.au
P: 02 4444 0777
PO Box 62,
Camden NSW 2540
AQUATIC ■ SPORTS ■ LEISURE ■ CIVIC ■ PROJECT MANAGEMENT

CLIENT:
Snowy Valleys Council

PROJECT NAME:
MULTIPURPOSE + EVACUATION CENTRE

FOR DA

PROJECT ADDRESS:
RICHMOND PARK, TUMUT NSW
Lot 1 Section 81 DP 759004 and
Lot 701 DP 1059193.

DRAWING TITLE:
SHADOW DIAGRAM -12.00pm


A1 PRINT SIZE

SHEET ISSUE DATE: 06/20/25	DRAWING NO.	REV.
REVISION DATE:		
SCALE: 1:500 @ A1	A.053.B	
JOB NO.: W366		

DRAWN BY: Author CHECKED BY: S. JOHANSSON

COPYRIGHT FACILITY DESIGN GROUP PTY. LIMITED. ALL RIGHTS RESERVED. DO NOT SCALE OFF DRAWINGS. WORK TO FIGURED DIMENSIONS ONLY. VERIFY DIMENSIONS ON SITE PRIOR TO COMMENCING WORK.


 
NOMINATED ARCHITECT: STEPHEN ARCHITECT - NSW REG No. 7148
20/06/2025 12:03:50 PM



CONTRACTORS MUST VERIFY ALL DIMENSIONS ON SITE BEFORE COMMENCING ANY WORK OR PREPARING SHOP DRAWINGS

All Architectural drawing sheets to be cross-referenced with other relevant disciplines.

Rev	Description	Date
-----	-------------	------

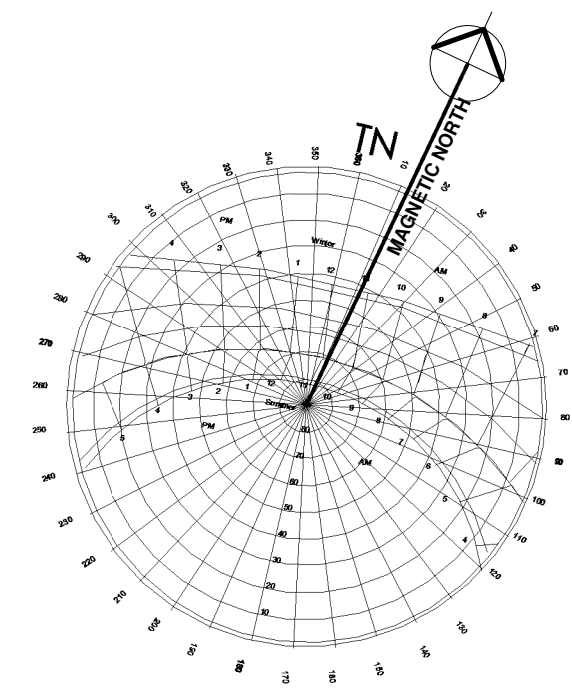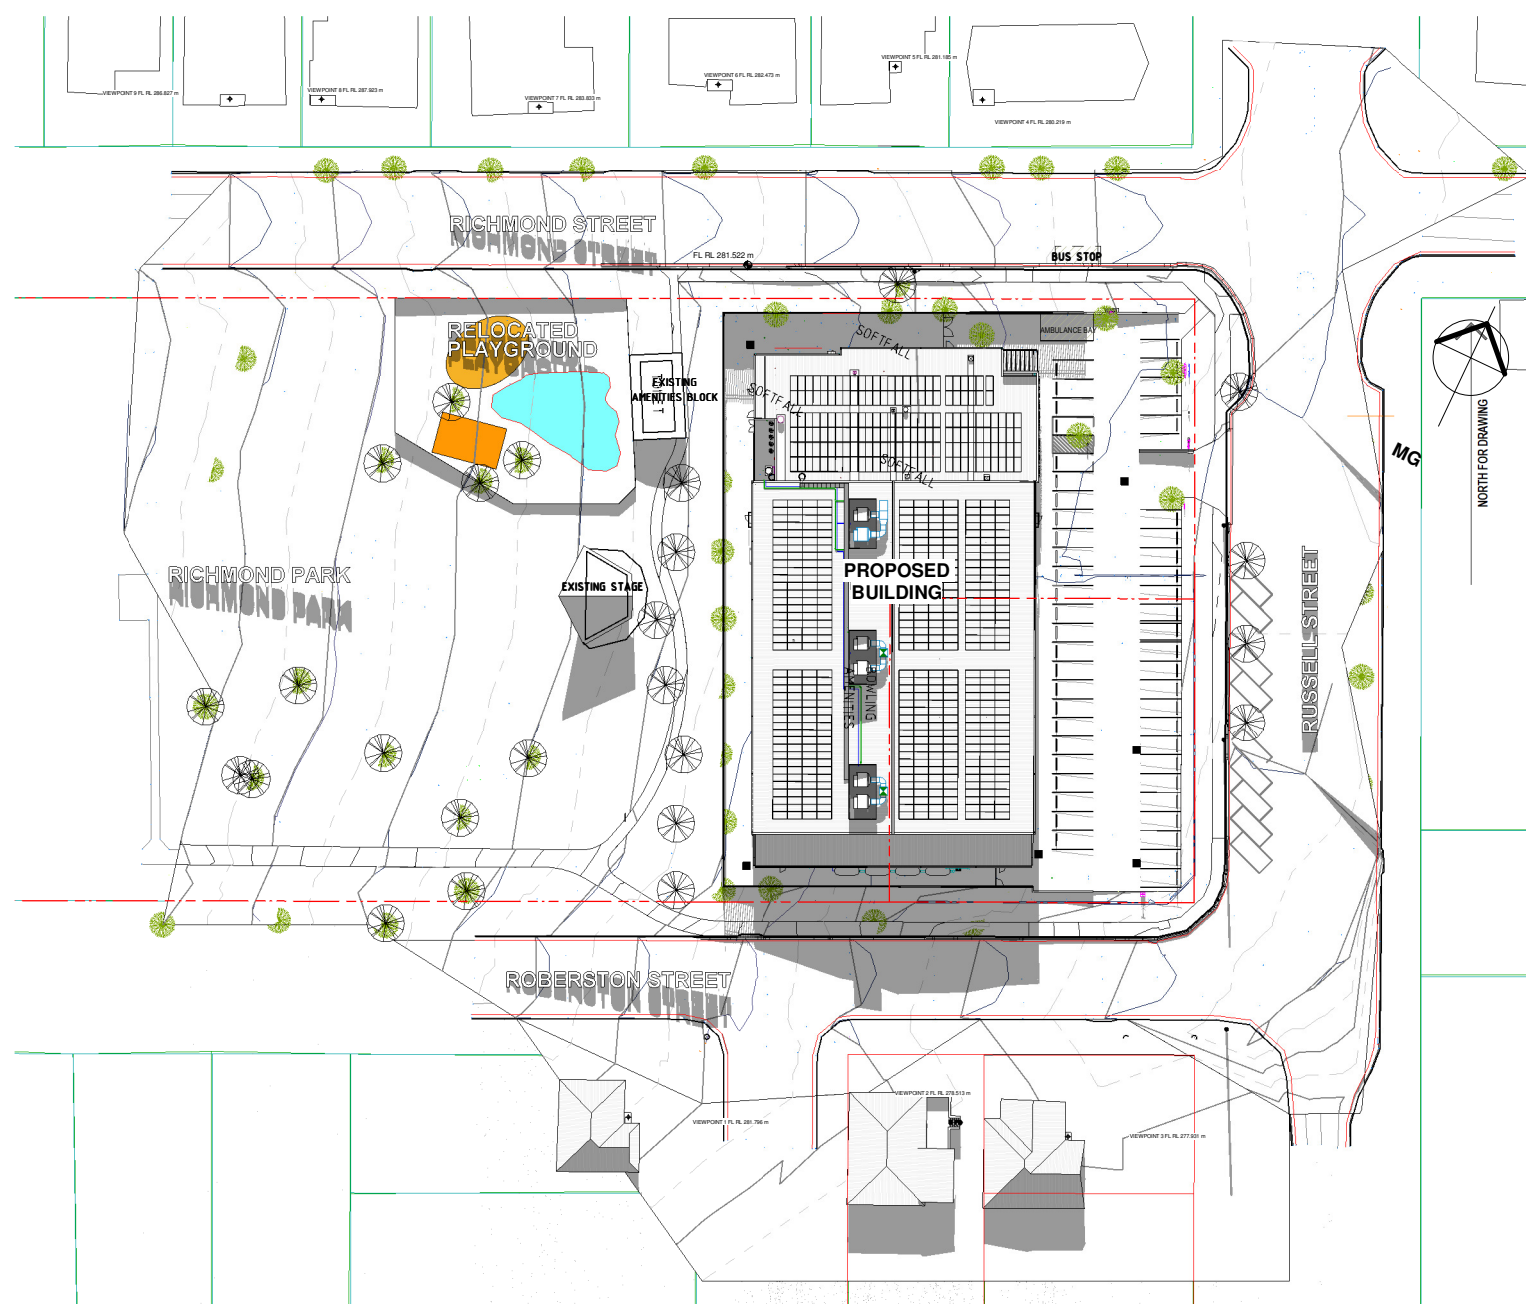

1 SITE PLAN Solar Study WINTER SOLSTICE 2025 3.00pm
1:500

NOTE: SCALE IS 1:1000 @ A3

CONSULTANT 4: **WEBB AUSTRALIA GROUP (NSW) PTY LTD**
 LEVEL 2 17 BOLTON STREET
 NEWCASTLE NSW 2300 AUSTRALIA
 T +61 2 4929 5225 F +61 428 412 035
 MECHANICAL ENGINEERING

CONSULTANT 3: **GLENN HAIG & PARTNERS** **Coffs Harbour**
 P. 62 4658 2444 P. 62 9310 3552
 PO Box 302 PO Box 689
 SAWTELL, NSW, 2452 SIRRIL HILLS, NSW, 2018
HYDRAULIC + FIRE CONSULTANTS office@glennhaig.com.au

CONSULTANT 2: **SPECTRUM**
 1 Davis Place
 Glenhaven NSW 2156
ENGINEERING SOLUTIONS Phone: (02) 8850 6802
 Mobile: 0419 294 533
 Email: nash@spectrumgolf.com.au

CONSULTANT 1: **PM DESIGN GROUP**
 50 Gheringhap Street
 Geelong, Victoria, Australia 3320
 PH: 03 5249 4800
 e: pdm@pmdesign.com.au
STRUCTURAL + CIVIL ENGINEERING

DESIGN ARCHITECT: **FACILITY DESIGN GROUP**
 NSW Reg. No. 7148
 ABN: 75 583 999 424
 info@fdg.com.au
 www.fdg.com.au
 PO Box 62, Camberwong NSW 2540
 AQUATIC ■ SPORTS ■ LEISURE ■ CIVIC ■ PROJECT MANAGEMENT

CLIENT: **Snowy Valleys Council**

PROJECT NAME:
MULTIPURPOSE + EVACUATION CENTRE

FOR DA

PROJECT ADDRESS:
 RICHMOND PARK, TUMUT NSW
 Lot 1 Section 81 DP 759004 and
 Lot 701 DP 1059193.

DRAWING TITLE:
SHADOW DIAGRAM - 3.00pm

PROJECT INFORMATION:

SHEET ISSUE DATE: 06/20/25	DRAWING NO.	REV.
REVISION DATE:	@ A1	A.053.C
SCALE: 1:500	JOB NO.:	W366

DRAWN BY: Author **CHECKED BY:** S. JOHANSSON

COPYRIGHT FACILITY DESIGN GROUP PTY. LIMITED. ALL RIGHTS RESERVED. DO NOT SCALE OFF DRAWINGS. WORK TO FIGURED DIMENSIONS ONLY. VERIFY DIMENSIONS ON SITE PRIOR TO COMMENCING WORK.

NOMINATED ARCHITECT: STEPHEN ARCHANSON - NSW REG No. 7148
 20/06/2025 12:03:56 PM