


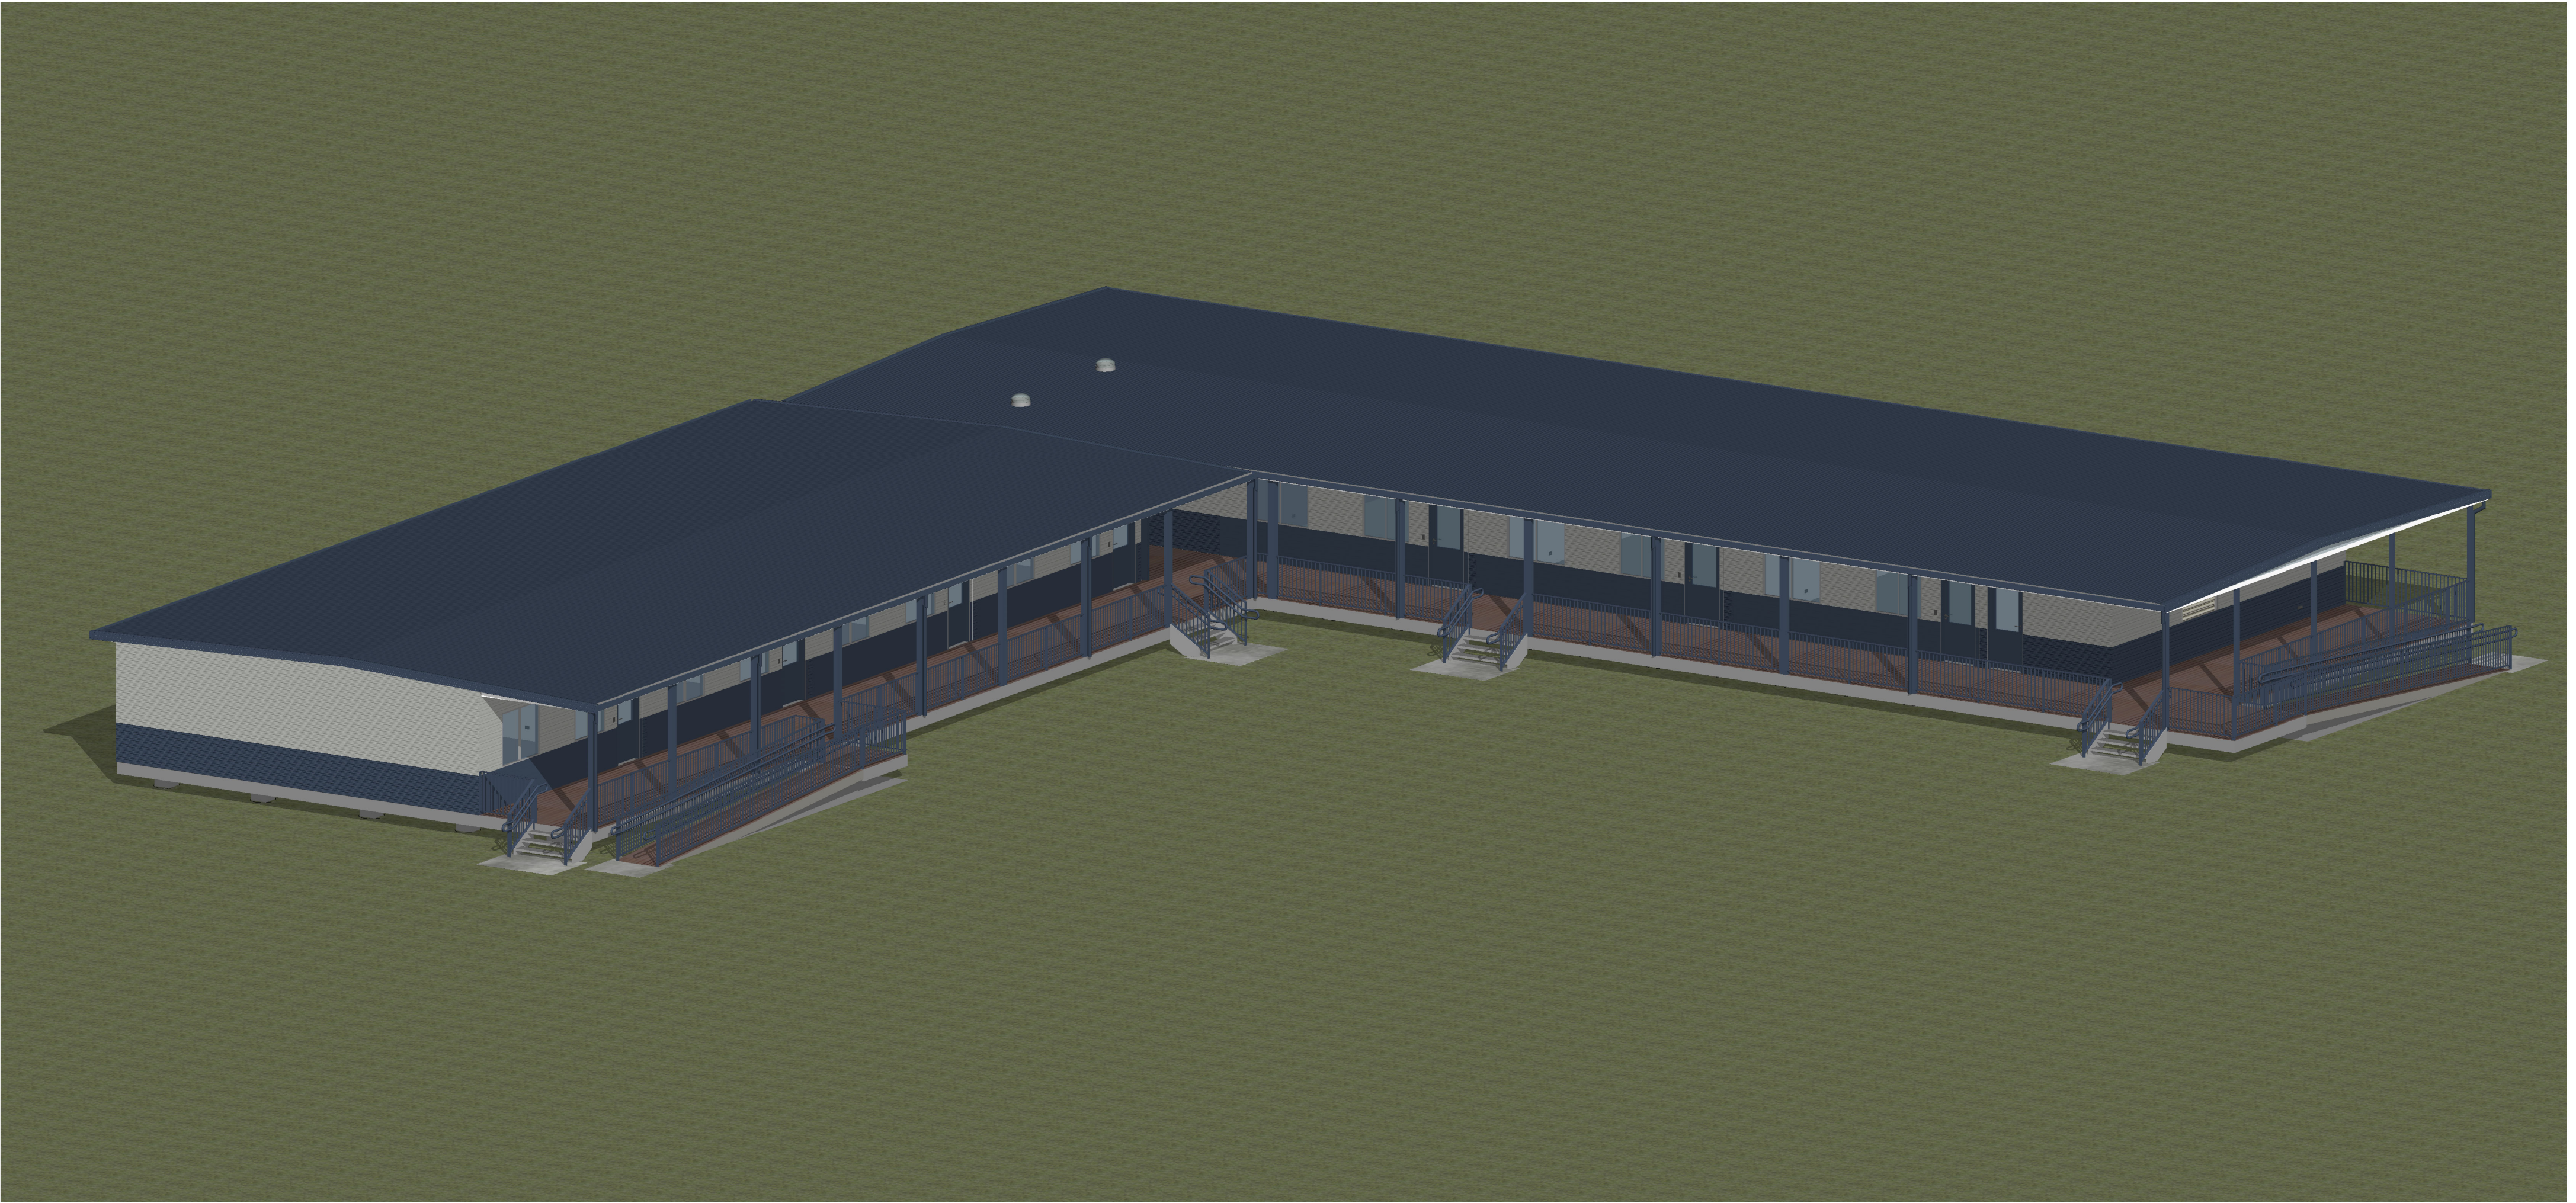

MBS
132 WARREN RD, SMITHFIELD
TEL: 1800 217 131
FAX: (02) 8718 2599

**modular
building
systems**
NSW 2164
D: (02) 8718 2500
www.MBS.com.au

CLIENT APPROVAL

SIGNATURE

NAME

DATE

PROJECT

MPG - Arrahman College
Nine Classrooms

© COPYRIGHT THE INFORMATION IDEAS AND CONCEPTS CONTAINED IN THIS DOCUMENT ARE: CONFIDENTIAL.
THE RECIPIENT(S) OF THIS DOCUMENT IS/ARE PROHIBITED FROM DISCLOSING SUCH INFORMATION: IDEAS AND
CONCEPTS TO ANY PERSON WITHOUT THE PRIOR WRITTEN CONSENT OF MODULAR BUILDING SYSTEMS Pty Ltd

I:\2. BID & CONTRACTS\Bld Team\TENDERS ACTIVE\200597- MPG - Arrahman College\1. Tender folder\3. Drawings & Design\2. Revit\200597- MPG - Arrahman College - Nine Classrooms - B3\ 20200324 - B.rvt

DATE 02.08.019

DRAWN BY TT

CHECKED BY DT

SCALE:

TITLE

COVER SHEET

DRAWING NUMBER MS-200597- B1- 001


BUILDING NUMBER B1

QUOTATION NUMBER 200597

REV C

SHEET A2

PRELIMINARY DRAWING			
C	ADDED ELECTRIC PLAN, WC DETAILS	TT	27.03.2020
B	REVISED DESIGN	TT	13.01.2020
A	PRELIMINARY DRAWING	TT	17.07.2019
ISSUE	AMENDMENT	BY	DATE

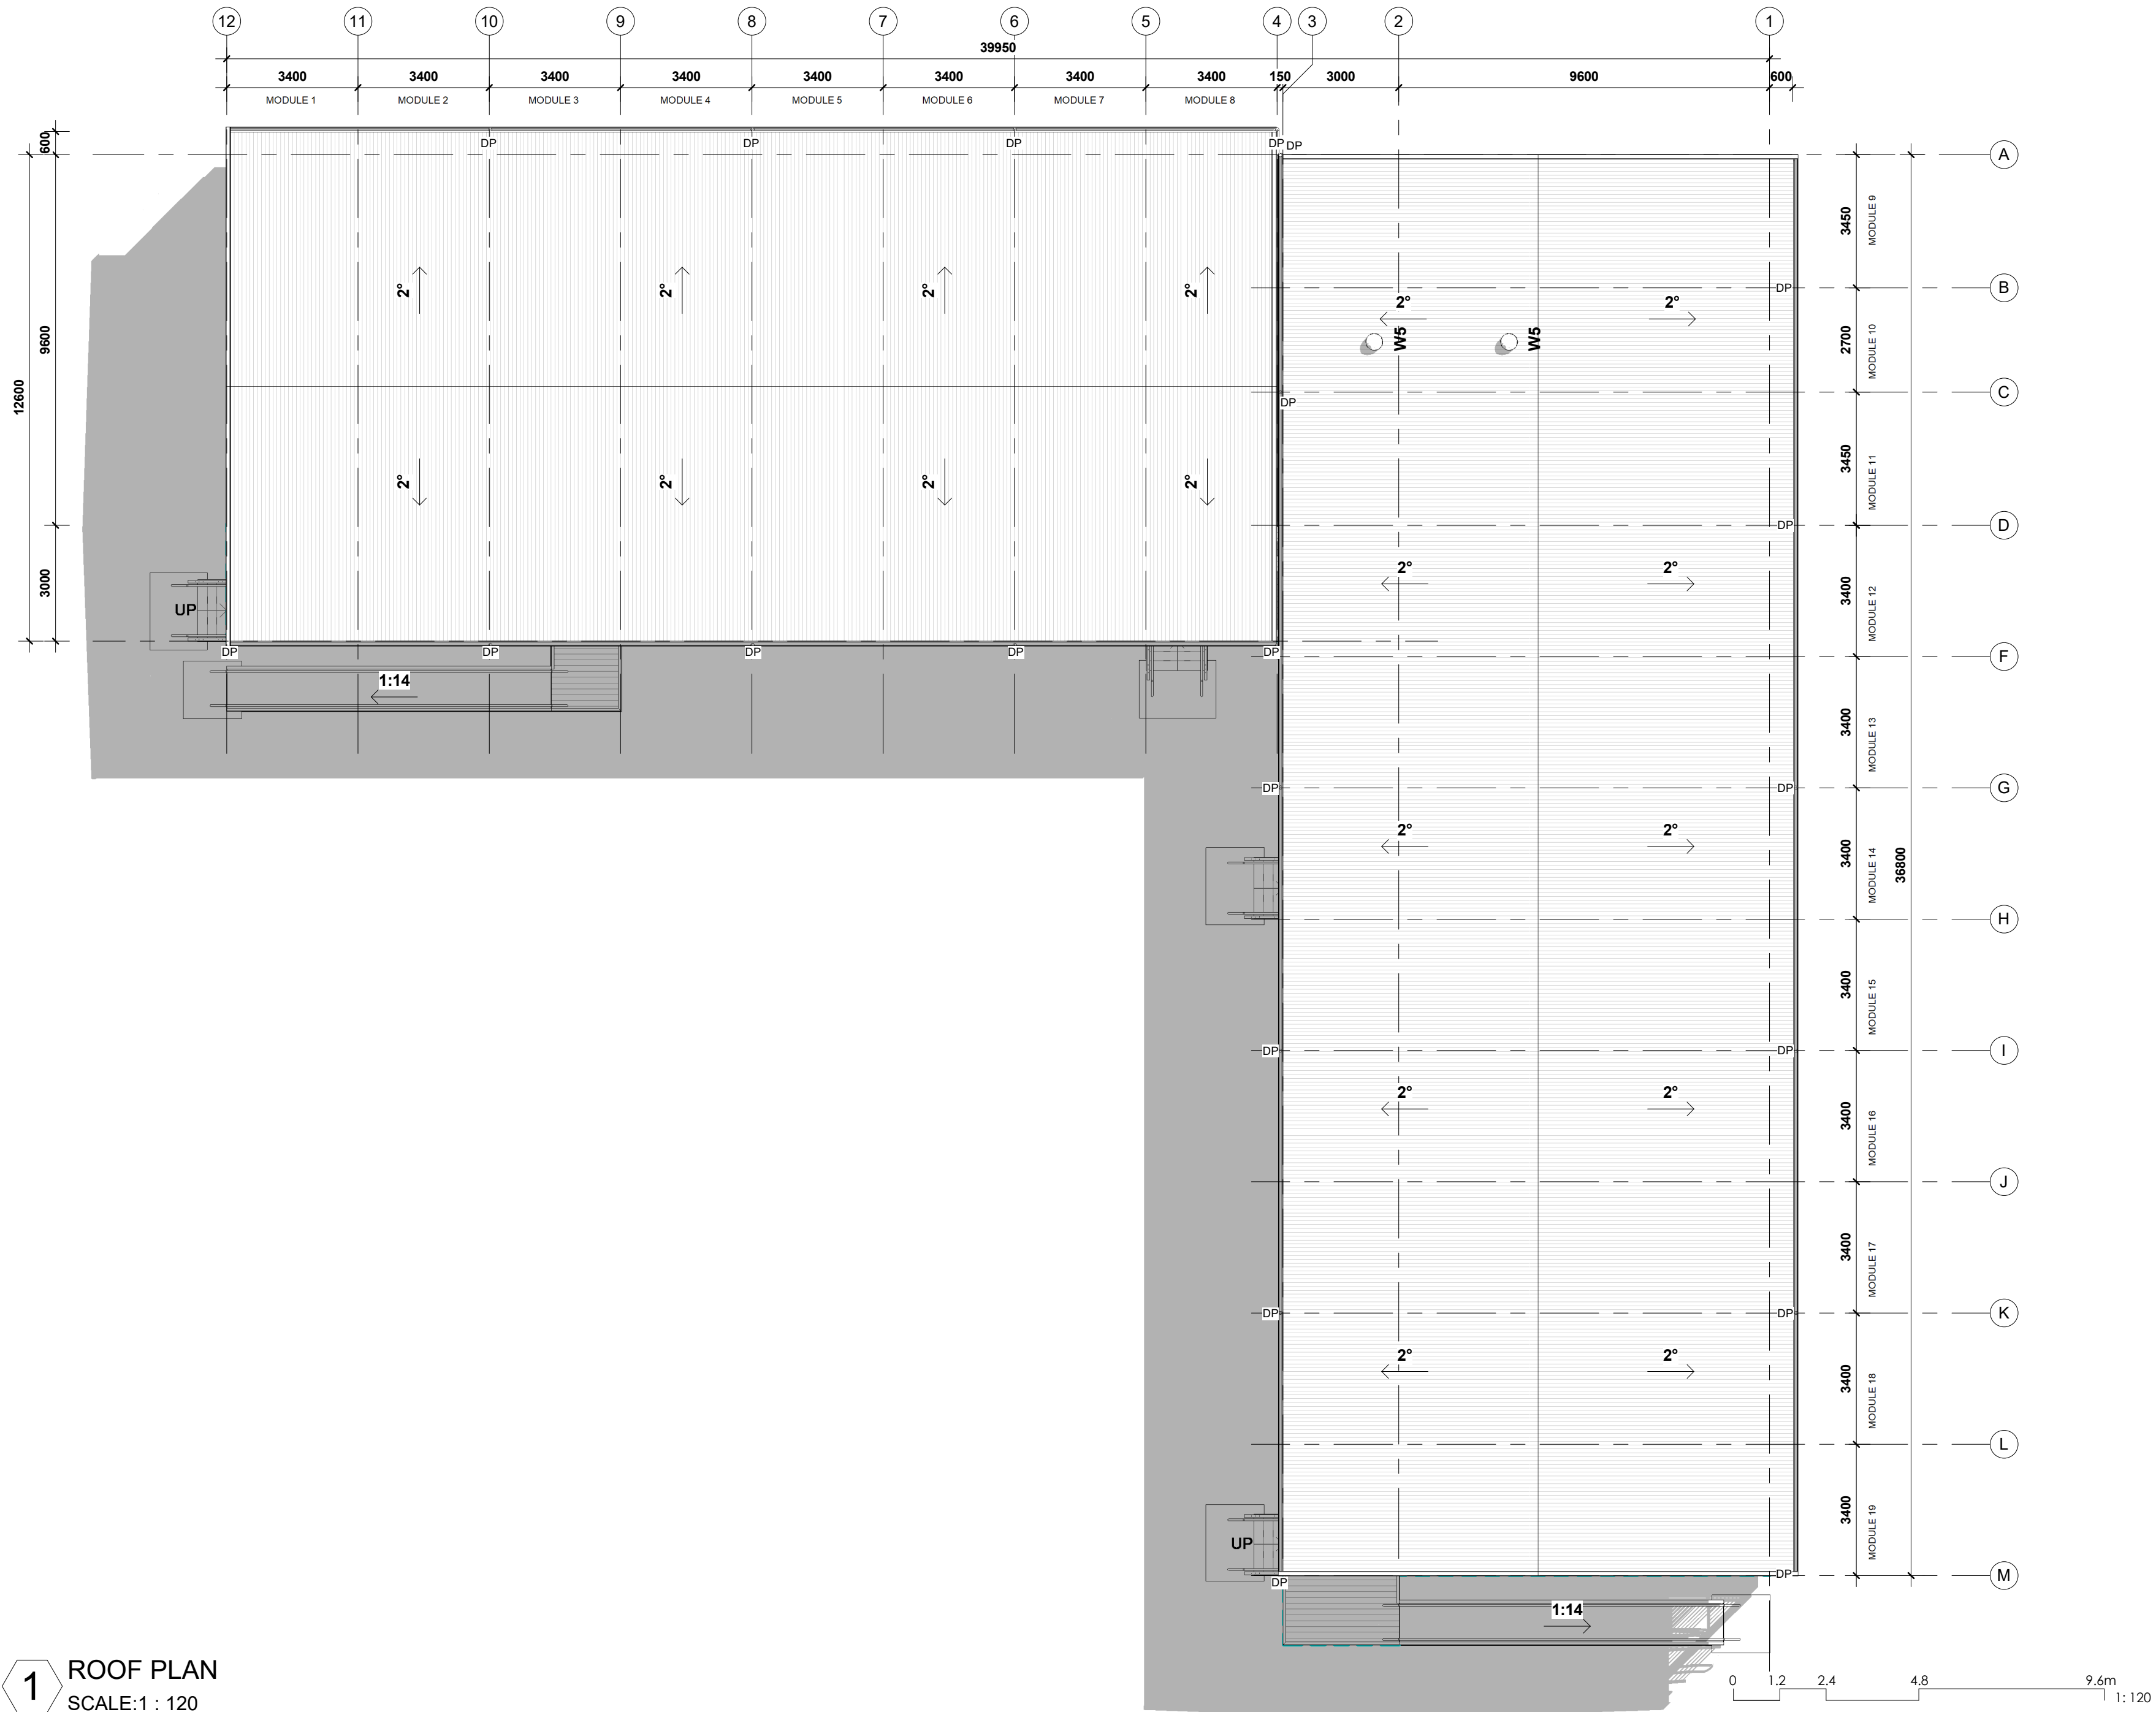

1 ROOF PLAN
SCALE:1 : 120

MBS
132 WARREN RD, SMITHFIELD
TEL: 1800 217 131
FAX: (02) 8718 2599

**modular
building
systems**
NSW 2164
D: (02) 8718 2500
www.MBS.com.au

CLIENT APPROVAL

SIGNATURE

NAME

DATE

PROJECT

MPG - Arrahman College
Nine Classrooms

© COPYRIGHT THE INFORMATION IDEAS AND CONCEPTS CONTAINED IN THIS DOCUMENT ARE: CONFIDENTIAL.
THE RECIPIENT(S) OF THIS DOCUMENT IS/ARE PROHIBITED FROM DISCLOSING SUCH INFORMATION, IDEAS AND
CONCEPTS TO ANY PERSON WITHOUT THE PRIOR WRITTEN CONSENT OF MODULAR BUILDING SYSTEMS PTY. LTD

1:2 BID & CONTRACTS\Bld Team\TENDERS ACTIVE\200597- MPG - Arrahman College\1. Tender folder\3. Drawings & Design\2. Revit\200597- MPG - Arrahman College - Nine Classrooms - B3\20200324 - B.rvt

DATE
02.08.019

DRAWN BY
Author

CHECKED BY
Checker

SCALE: 1 : 120

TITLE
ROOF PLAN

DRAWING NUMBER
MS-200597- B1- 100


BUILDING NUMBER
B1

QUOTATION NUMBER
200597


REV B

SHEET A2

PRELIMINARY DRAWING			
B	ADDED ELECTRIC PLAN, WC DETAILS	TT	27.03.2020
A	REVISED DESIGN	TT	13.01.2020
ISSUE	AMENDMENT	BY	DATE

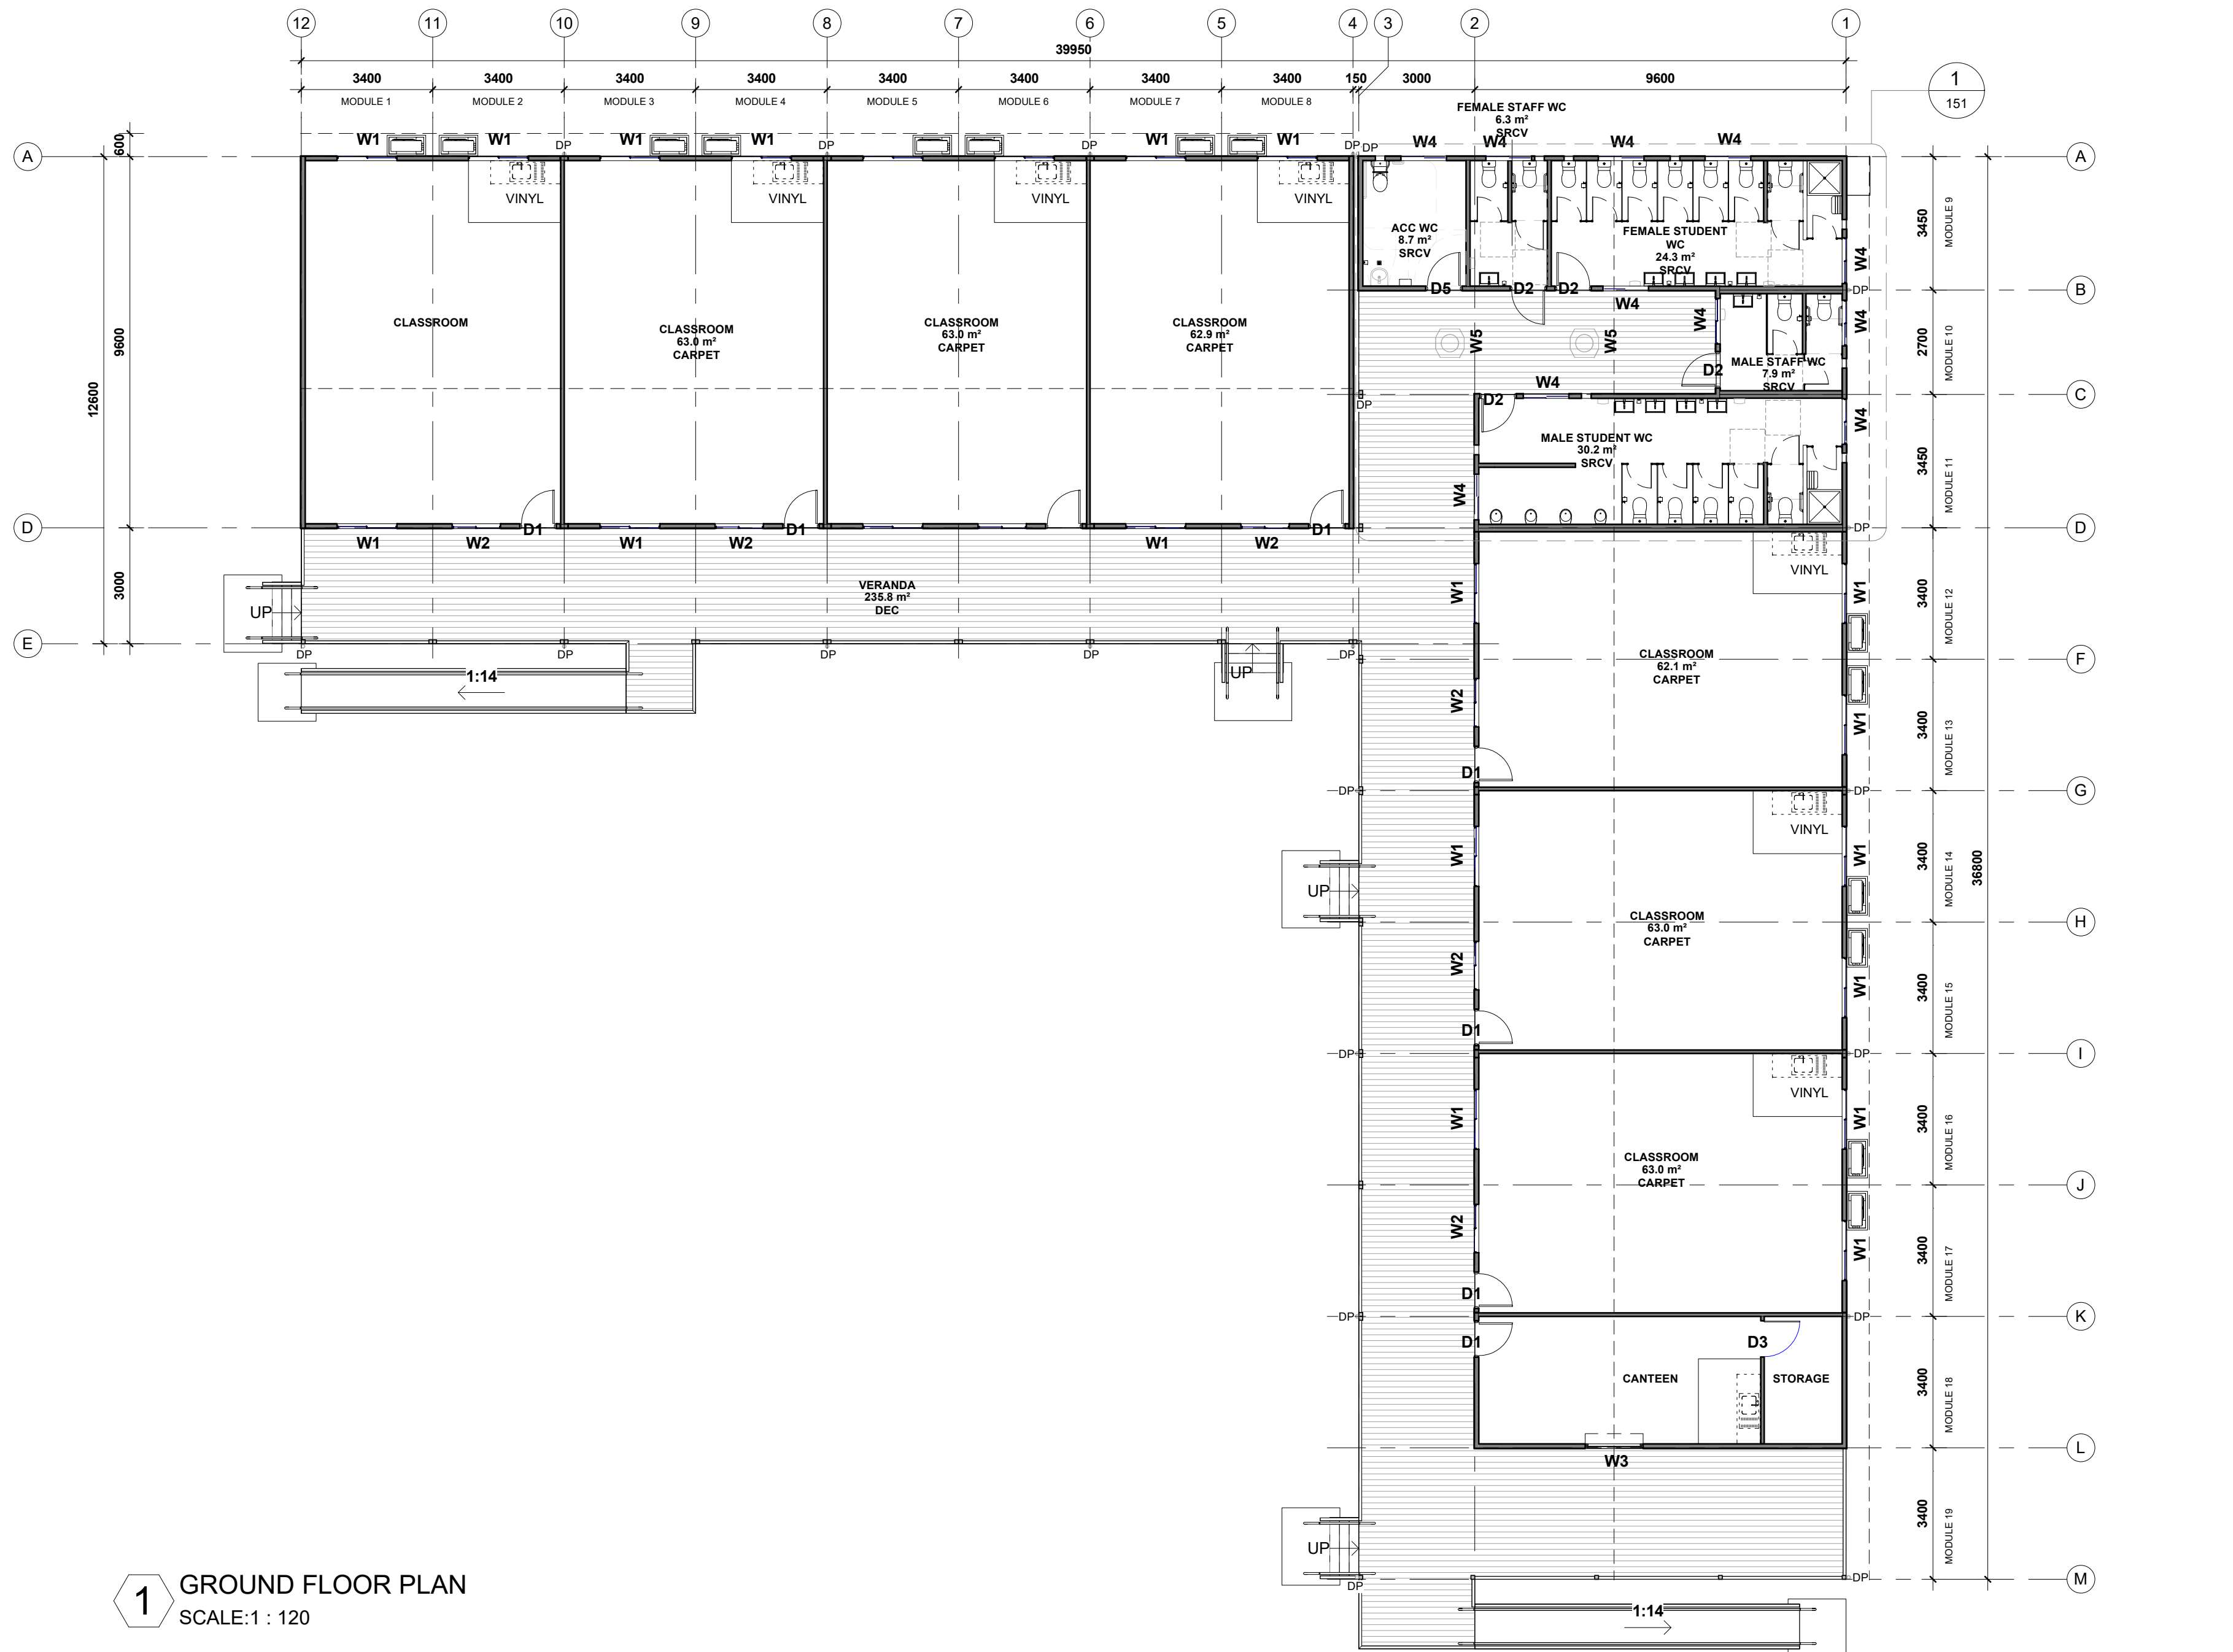

1 GROUND FLOOR PLAN
SCALE:1 : 120

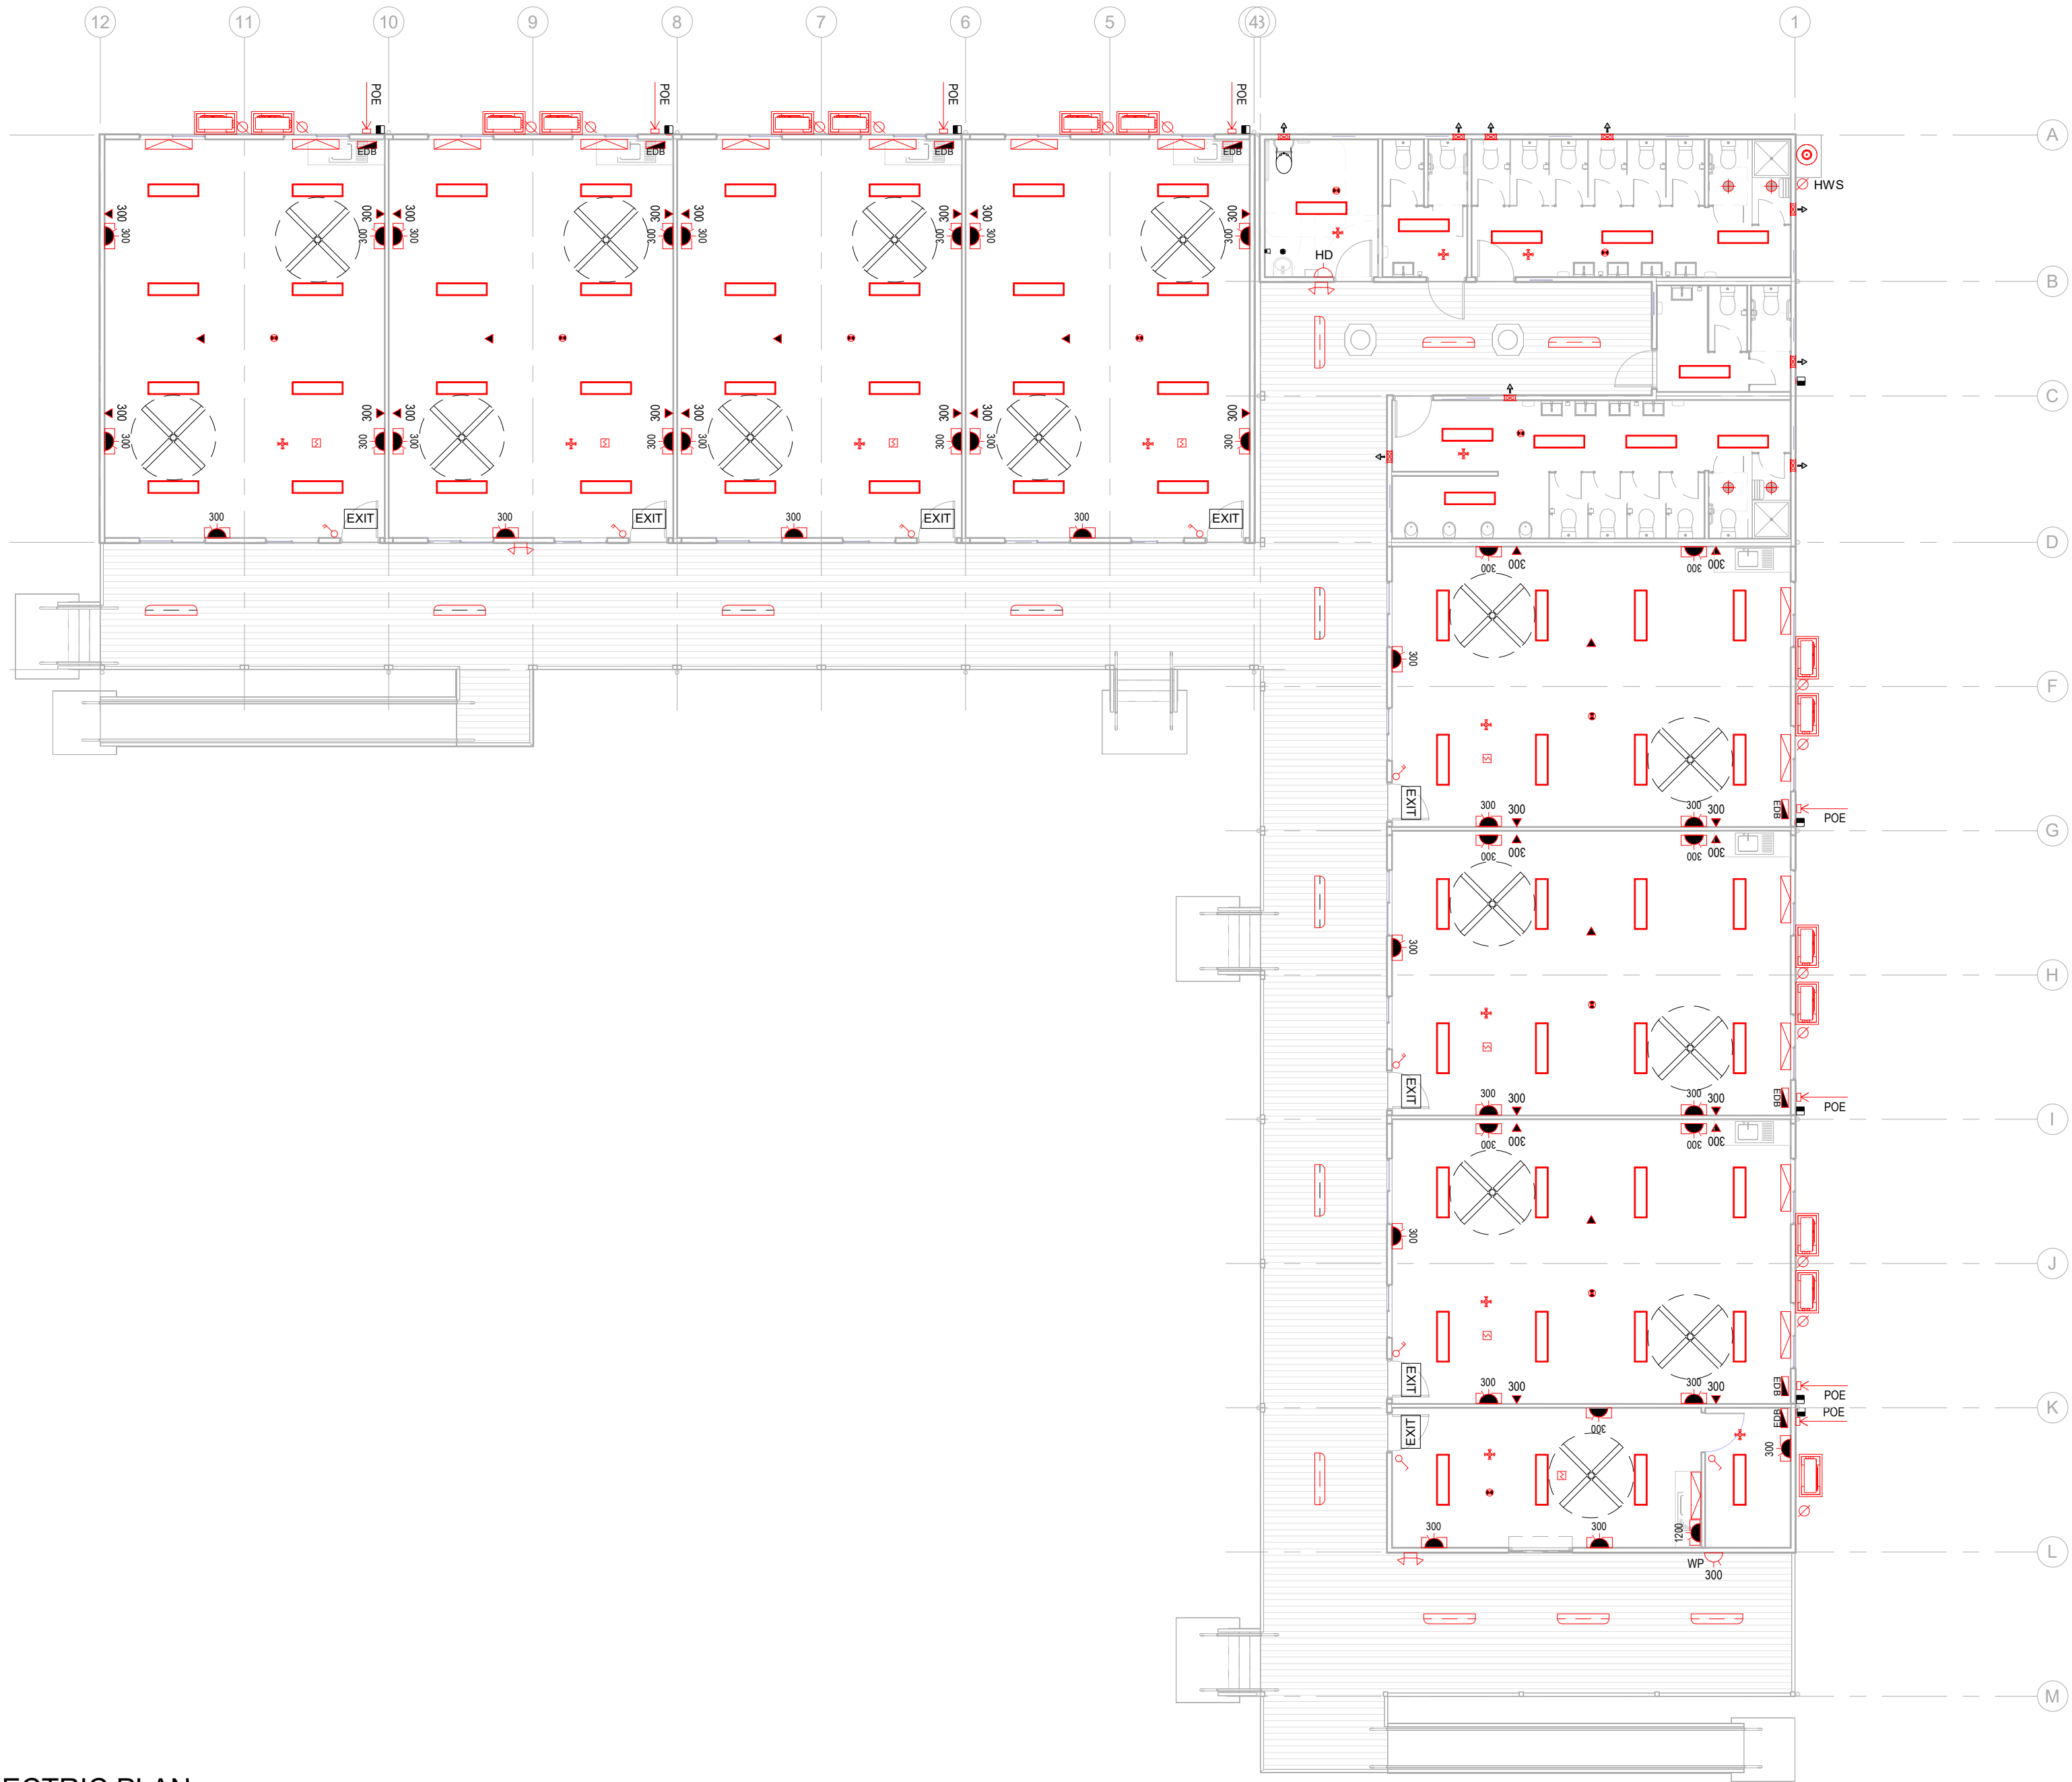

ELECTRICS SCHEDULE			
ITEM	DESCRIPTION	HEIGHT	QTY
360 DEGREE MOTION SENSOR		C/MNTD	13
A/C CONDENSER UNIT			15
A/C SPLIT UNIT		2200 AFFL	15
CEILING FAN - 4 BLADE - 1400mm DIAMETER		C/MNTD	14
DATA (DRAW WIRE ONLY)		300 AFFL	28
DATA AT CEILING (DRAW WIRE ONLY)		C/MNTD	7
DOWNLIGHT - RECESSED, LED		C/MNTD	4
ELECTRICAL DISTRIBUTION BOARD		1800 AFFL	8
ELECTRICAL SUPPLY POINT OF ENTRY		UFFL	8
EMERGENCY FLOODLIGHT			3
EXHAUST FAN			4
EXIT LIGHT		C/MNTD	8
GPO DOUBLE -10 AMP		300 AFFL	39
GPO DOUBLE -10 AMP		1200 AFFL	1
GPO DOUBLE -10 AMP		2600 AFFL	7
GPO DOUBLE - WEATHERPROOF		300 AFFL	1
GPO SINGLE - HD		1200 AFFL	1
HWS ISOLATOR		300 AFFL	1
ISOLATOR		300 AFFL	15
LED LIGHTING WITH DIFFUSER		C/MNTD	71
LED SPITFIRE		C/MNTD	11
LED W/PROOF		C/MNTD	14
LIGHT SWITCH - DOUBLE 1WAY		1100 AFFL	7
LIGHT SWITCH - SINGLE 1 WAY		1100 AFFL	2
PHOTO ELECTRIC IP66 (SUNSET SWITCH 3WIRE)		2100 AFFL	9
SMOKE DETECTOR		C/MNTD	7

1 ELECTRIC PLAN
SCALE:1 : 120



132 WARREN RD, SMITHFIELD
TEL: 1800 217 131
FAX: (02) 8718 2599

NSW 2164
D: (02) 8718 2500
www.MBS.com.au

CLIENT APPROVAL

SIGNATURE

NAME

DATE

PROJECT

MPG - Arrahman College
Nine Classrooms

© COPYRIGHT THE INFORMATION IDEAS AND CONCEPTS CONTAINED IN THIS DOCUMENT ARE CONFIDENTIAL. THE RECIPIENT(S) OF THIS DOCUMENT IS/ARE PROHIBITED FROM DISCLOSING SUCH INFORMATION, IDEAS AND CONCEPTS TO ANY PERSON WITHOUT THE PRIOR WRITTEN CONSENT OF MODULAR BUILDING SYSTEMS PTY LTD

132 BID & CONTRACTS\Bld Team\TENDERS ACTIVE\200597- MPG - Arrahman College\1. Tender folder\3. Drawings & Design\2.Rev\200597- MPG - Arrahman College - Nine Classrooms - E3 2020\0324 - B.rvt

DATE

02.08.019

DRAWN BY

Author

CHECKED BY

Checker

SCALE:

1 : 120

TITLE

ELECTRIC PLAN

DRAWING NUMBER

MS-200597- 104

BUILDING NUMBER

QUOTATION NUMBER

200597

REV


A

SHEET


A2

PRELIMINARY DRAWING


A	ADDED ELECTRIC PLAN, WC DETAILS	TT	27.03.2020
ISSUE	AMENDMENT	BY	DATE

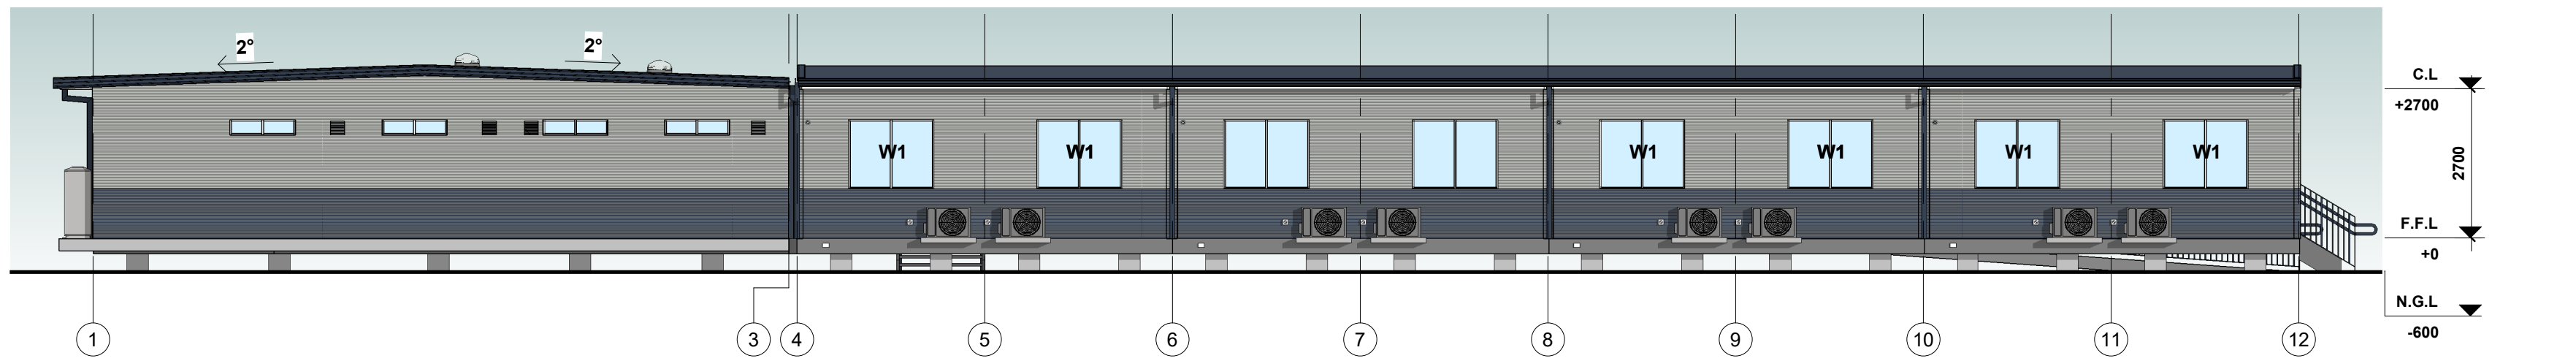


1 REAR ELEVATION
SCALE: 1 : 100

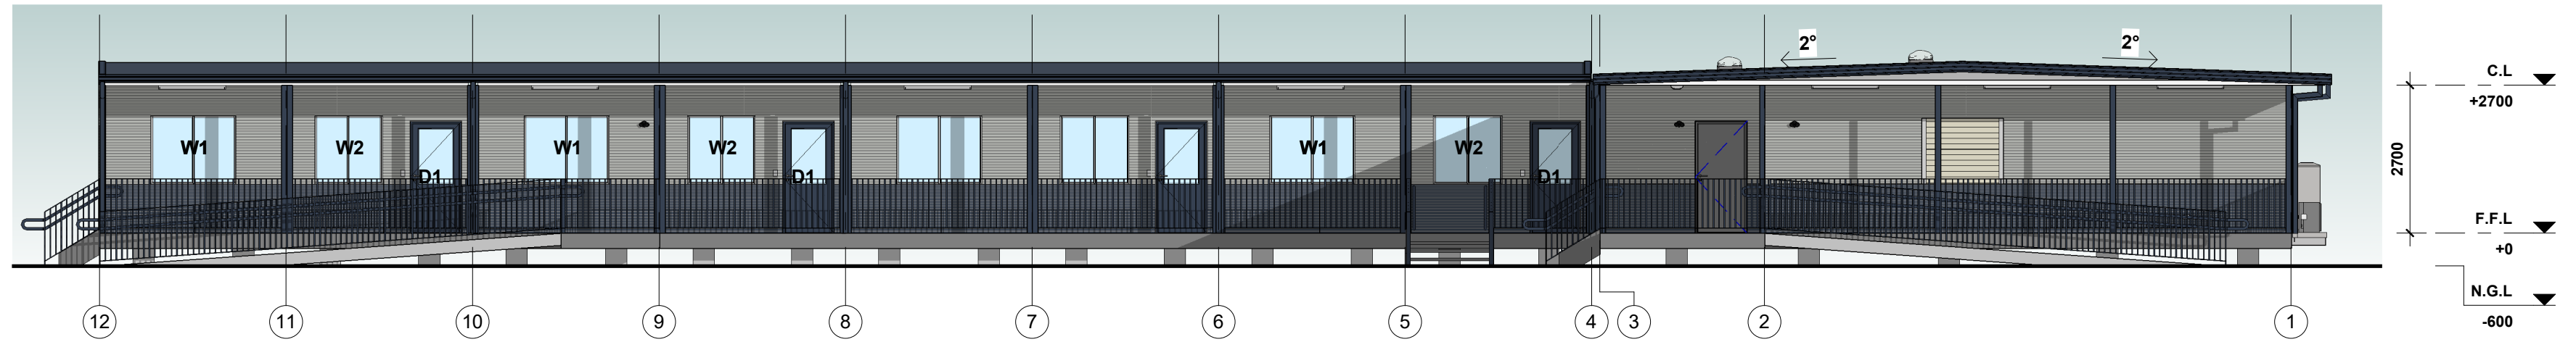

2 FRONT ELEVATION
SCALE: 1 : 100

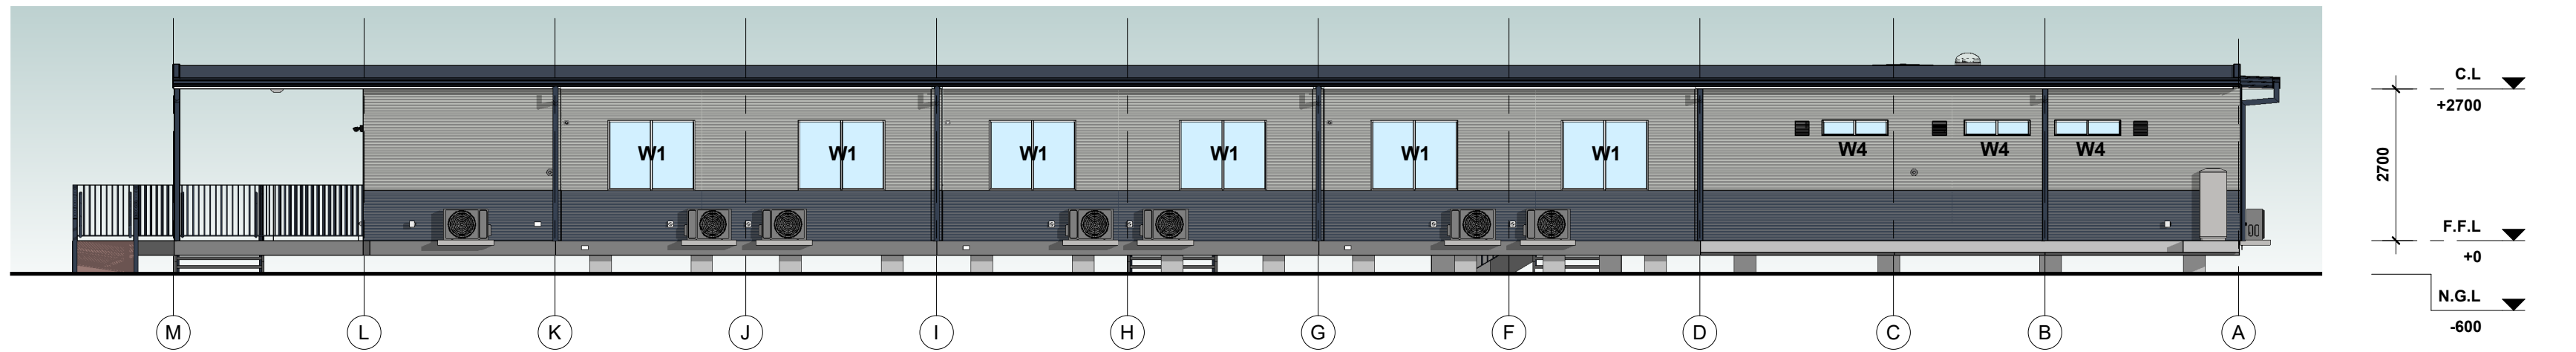

3 RIGHT SIDE ELEVATION
SCALE: 1 : 100

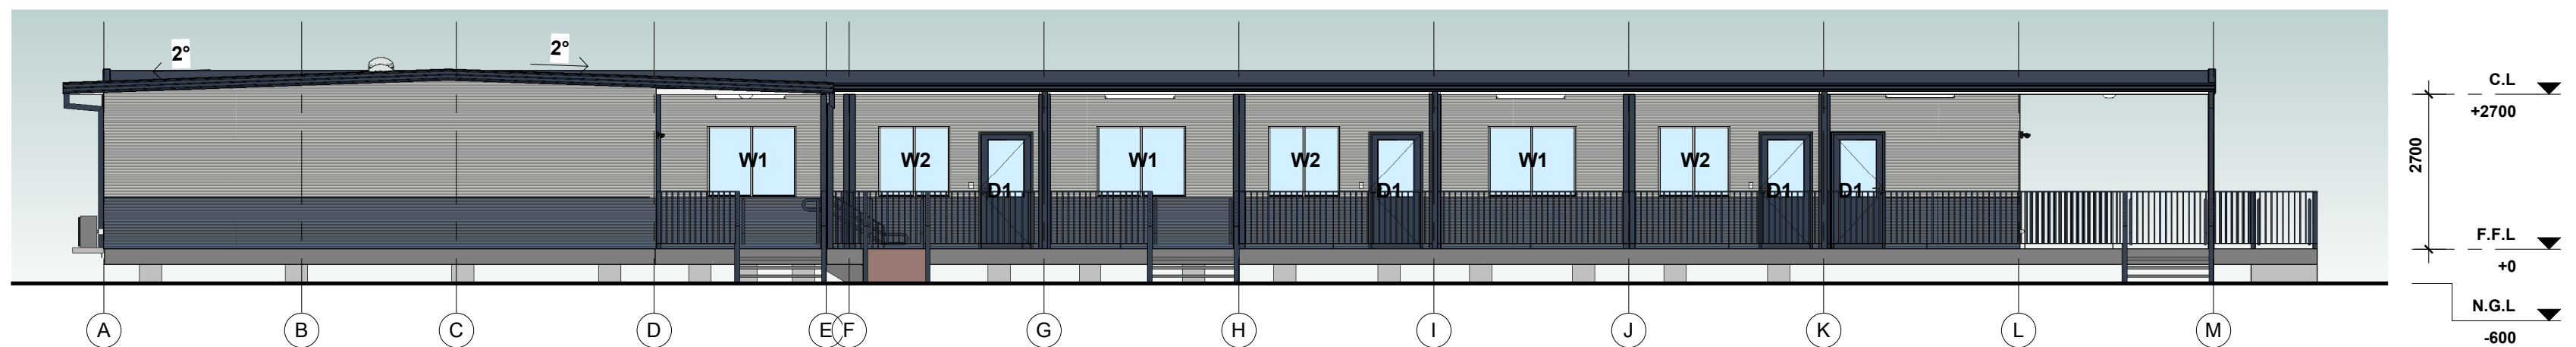

4 LEFT SIDE ELEVATION
SCALE: 1 : 100

MBS modular building systems
132 WARREN RD, SMITHFIELD NSW 2164
TEL: 1800 217 131 D: (02) 8718 2500
FAX: (02) 8718 2599 www.mbs.com.au

CLIENT APPROVAL

SIGNATURE
NAME
DATE

PROJECT
MPG - Arrahman College
Nine Classrooms


© COPYRIGHT THE INFORMATION IDEAS AND CONCEPTS CONTAINED IN THIS DOCUMENT ARE CONFIDENTIAL. THE RECIPIENT(S) OF THIS DOCUMENT IS/ARE PROHIBITED FROM DISCLOSING SUCH INFORMATION, IDEAS AND CONCEPTS TO ANY PERSON WITHOUT THE PRIOR WRITTEN CONSENT OF MODULAR BUILDING SYSTEMS PTY LTD
132 BID & CONTRACTS/BM Team/TENDERS ACTIVE/200597- MPG - Arrahman College/1 Tender folder/3 Drawings & Design/2 Revit/200597- MPG - Arrahman College - Nine Classrooms - B1/ 2020/03/24 - B1/1

DATE
02.08.019
DRAWN BY
TT
CHECKED BY
DT
SCALE:
1 : 100


TITLE
EXTERIOR ELEVATIONS
DRAWING NUMBER
MS-200597- B1- 120
BUILDING NUMBER
B1
QUOTATION NUMBER
200597
REV
D
SHEET
A2

PRELIMINARY DRAWING

ISSUE	AMENDMENT	BY	DATE
D	ADDED ELECTRIC PLAN, WC DETAILS	TT	27.03.2020
C	ADDED JOINERY & RELOCATED W3	TT	27.02.2020
B	REVISED DESIGN	TT	13.01.2020
A	PRELIMINARY DRAWING	TT	17.07.2019

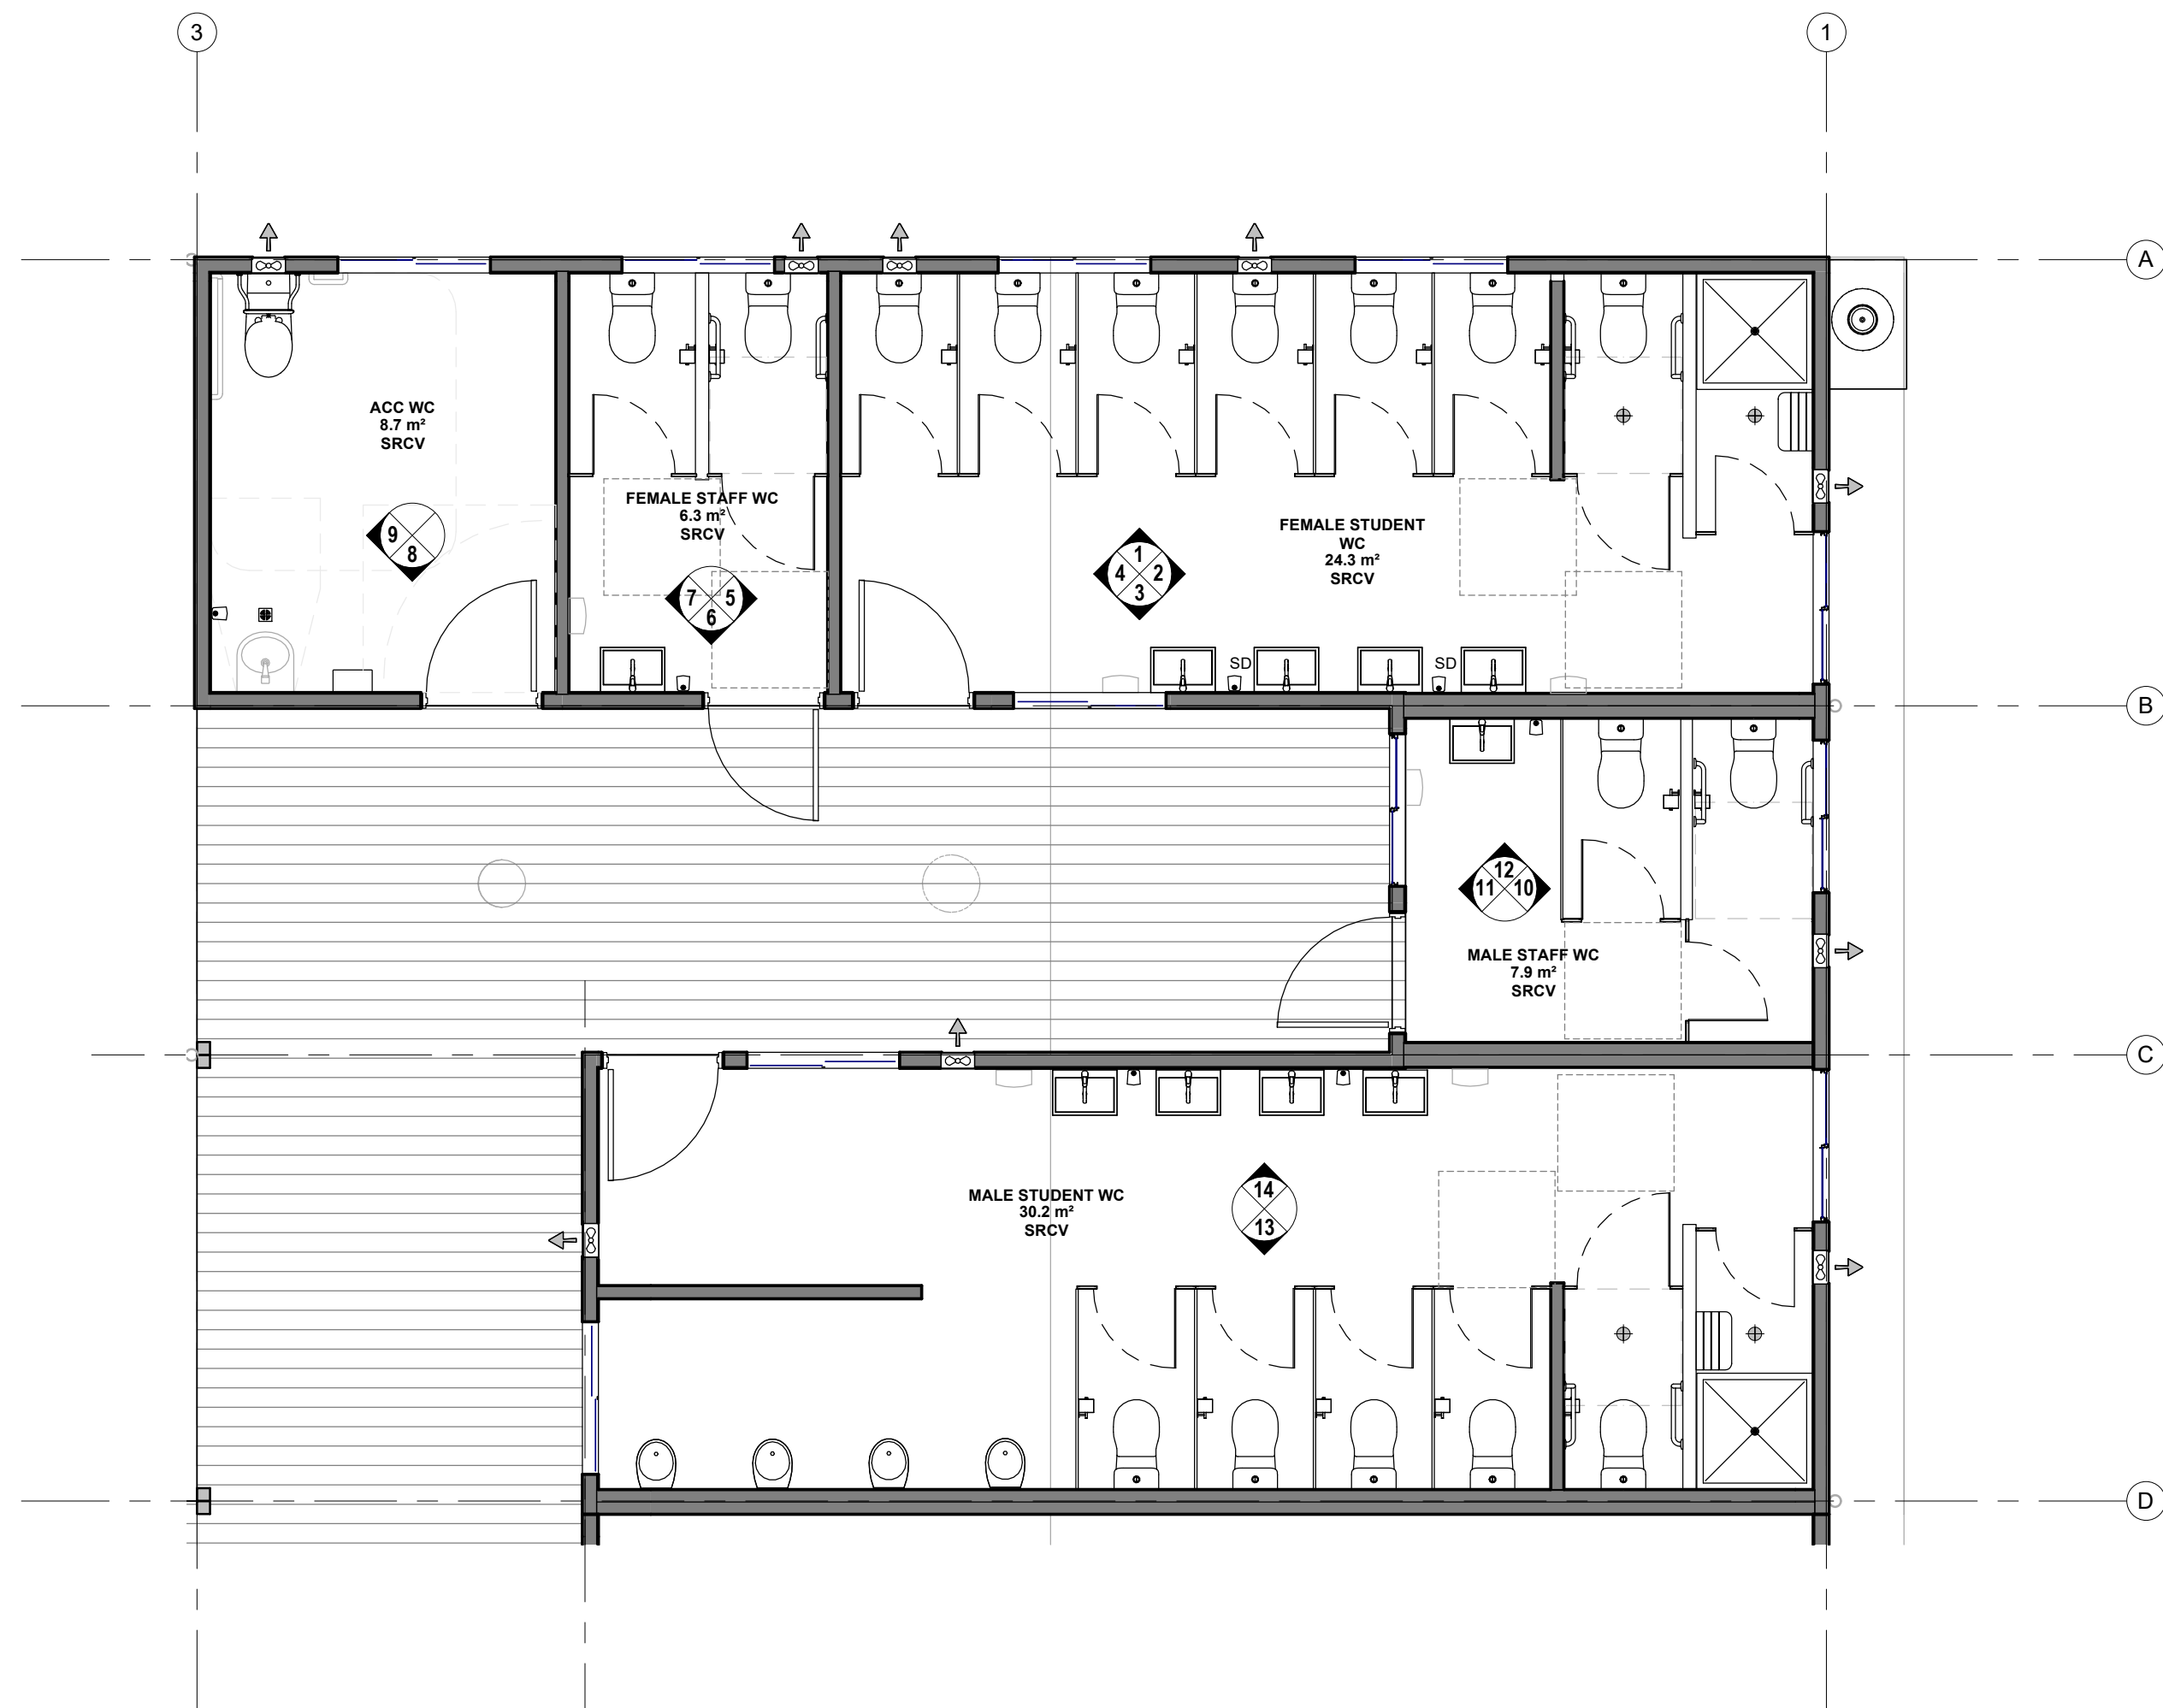

1 TOILET FLOOR PLAN
SCALE: 1 : 50

 

MBS modular building systems

132 WARREN RD, SMITHFIELD
TEL: 1800 217 131
FAX: (02) 8718 2599

NSW 2164
D: (02) 8718 2500
www.MBS.com.au

CLIENT APPROVAL

SIGNATURE

NAME

DATE

PROJECT

MPG - Arrahman College
Nine Classrooms

© COPYRIGHT THE INFORMATION IDEAS AND CONCEPTS CONTAINED IN THIS DOCUMENT ARE: CONFIDENTIAL. THE RECIPIENT(S) OF THIS DOCUMENT IS/ARE PROHIBITED FROM DISCLOSING SUCH INFORMATION, IDEAS AND CONCEPTS TO ANY PERSON WITHOUT THE PRIOR WRITTEN CONSENT OF MODULAR BUILDING SYSTEMS Pty. Ltd

112 BID & CONTRACTS\Bld Team\TENDERS ACTIVE\200597- MPG - Arrahman College\11 Tender folder\3 Drawings & Design\2 Revit\200597- MPG - Arrahman College - Nine Classrooms - EJ 20200324 - B.rvt

DATE 02.08.019

DRAWN BY Author

CHECKED BY

Checker

SCALE: 1 : 50

TITLE

TOILET DETAIL

DRAWING NUMBER MS-200597- 151

BUILDING NUMBER


QUOTATION NUMBER 200597

REV A


SHEET A2

PRELIMINARY DRAWING


A	ADDED ELECTRIC PLAN, WC DETAILS	TT	27.03.2020		
ISSUE	AMENDMENT	BY	DATE		

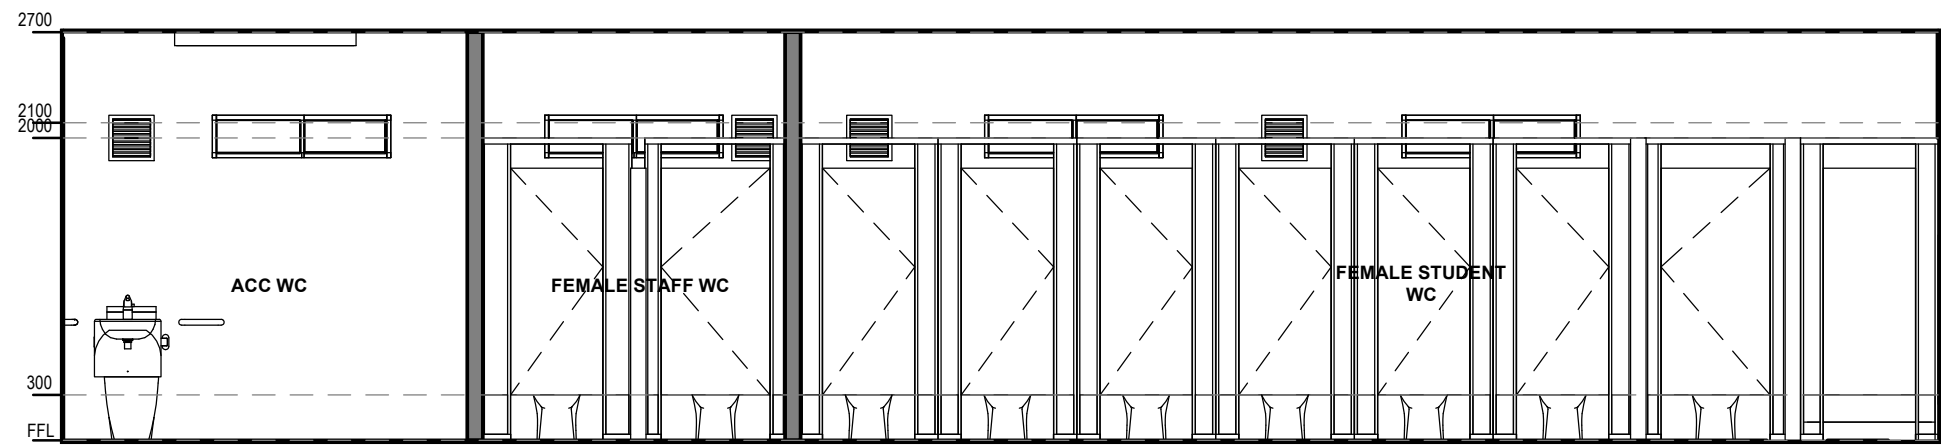


1 ACC WC, FEMALE STAFF & ST WC ELEVATION
SCALE: 1 : 50

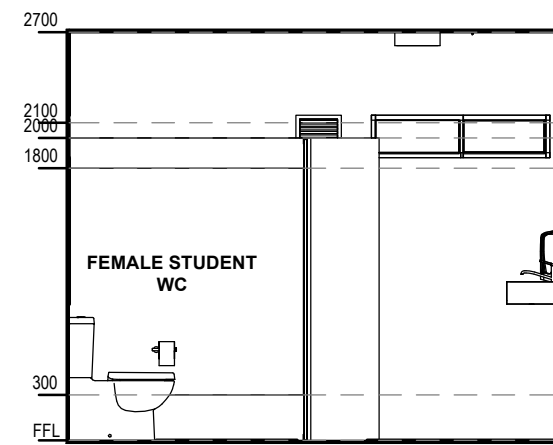


2 FEMALE ST WC - ELE 2
SCALE: 1 : 50

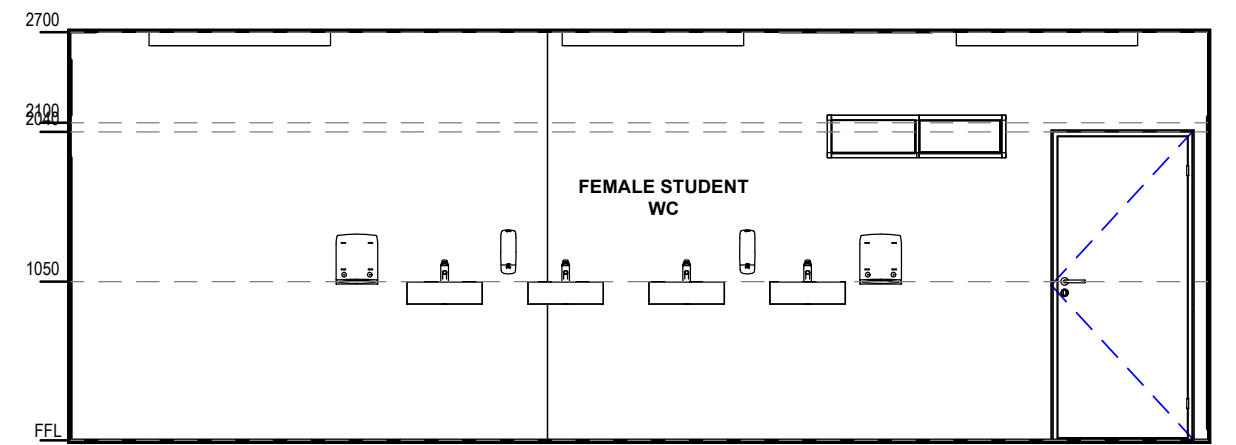


3 FEMALE ST WC - ELE 3
SCALE: 1 : 50

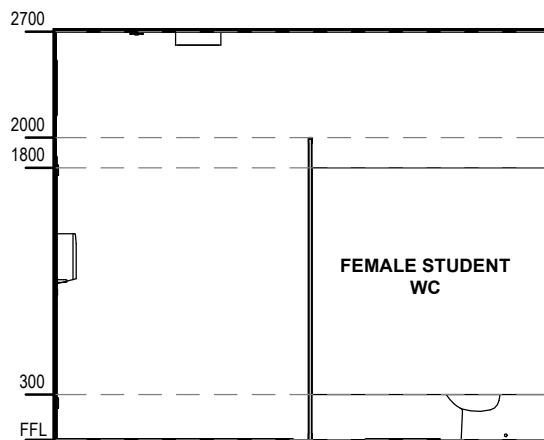


4 FEMALE ST WC - ELE 4
SCALE: 1 : 50

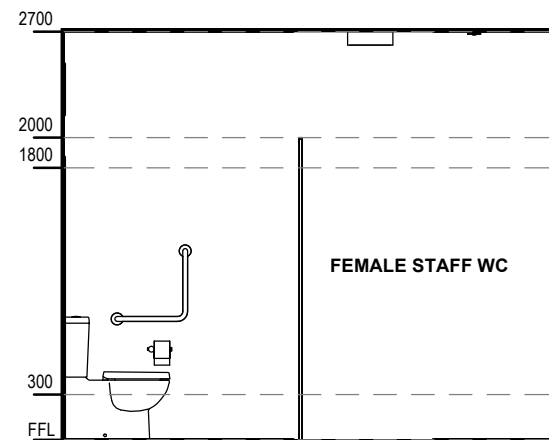


5 FEMALE STAFF WC - ELE 5
SCALE: 1 : 50

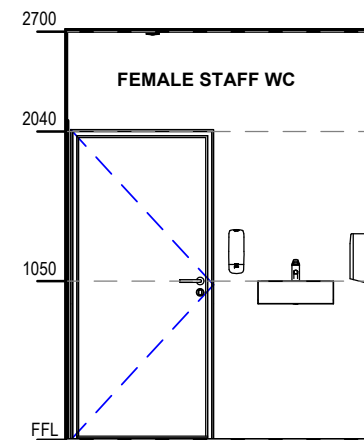


6 FEMALE STAFF WC - ELE 6
SCALE: 1 : 50

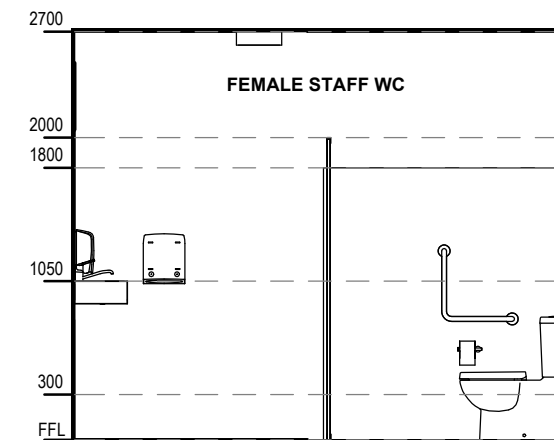


7 FEMALE STAFF WC ELE 7
SCALE: 1 : 50

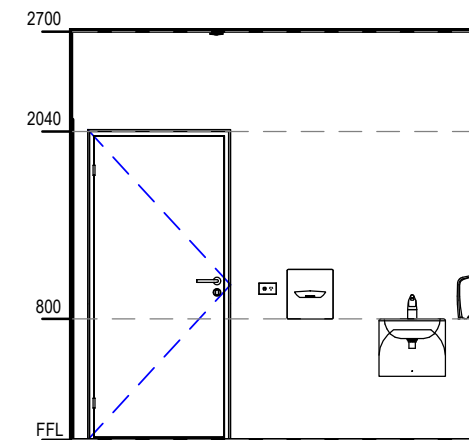


8 ACC WC ELE 8
SCALE: 1 : 50

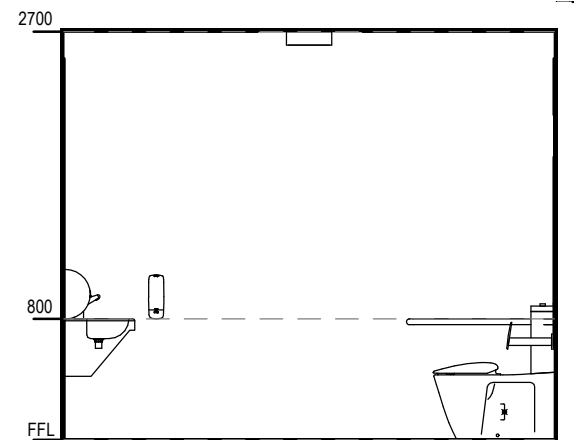


9 ACC WC ELE 9
SCALE: 1 : 50

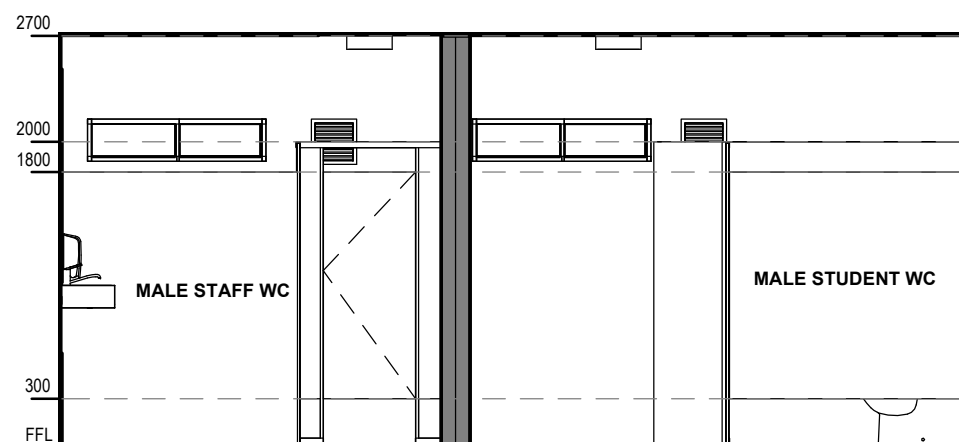


10 MALE STAFF & MALE ST WC ELE 10
SCALE: 1 : 50

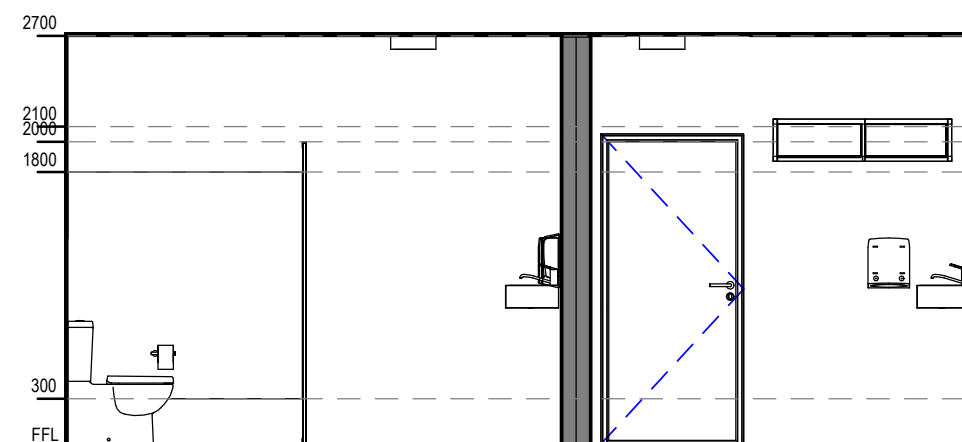


11 MALE STAFF & MALE ST WC ELE 11
SCALE: 1 : 50

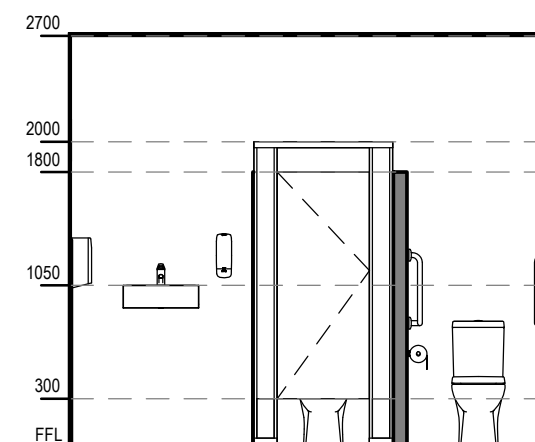

12 MALE STAFF WC ELE 12
SCALE: 1 : 50

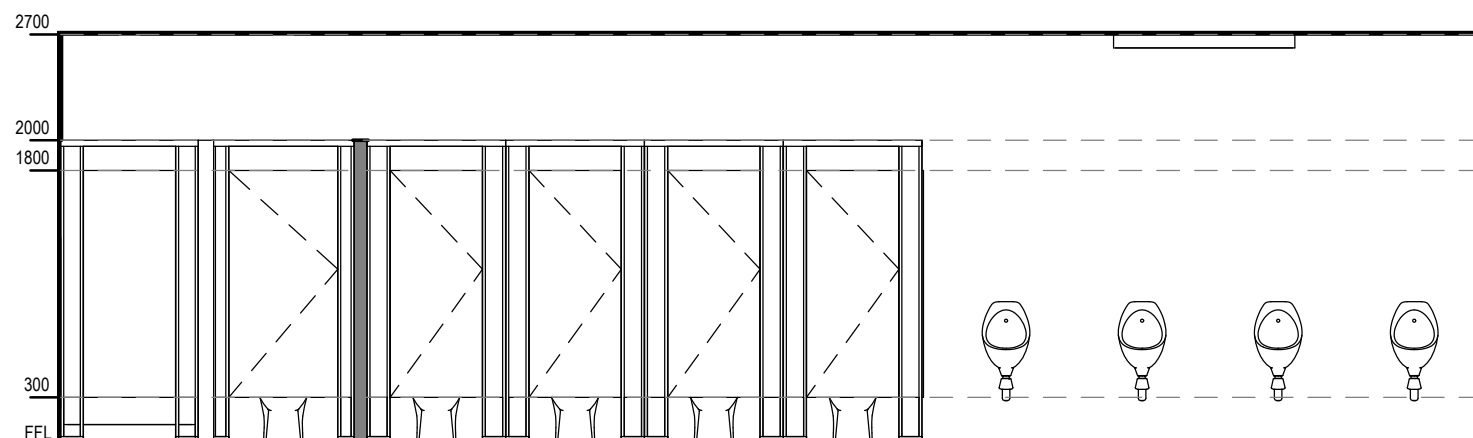

13 MALE STUDENT WC ELE 13
SCALE: 1 : 50

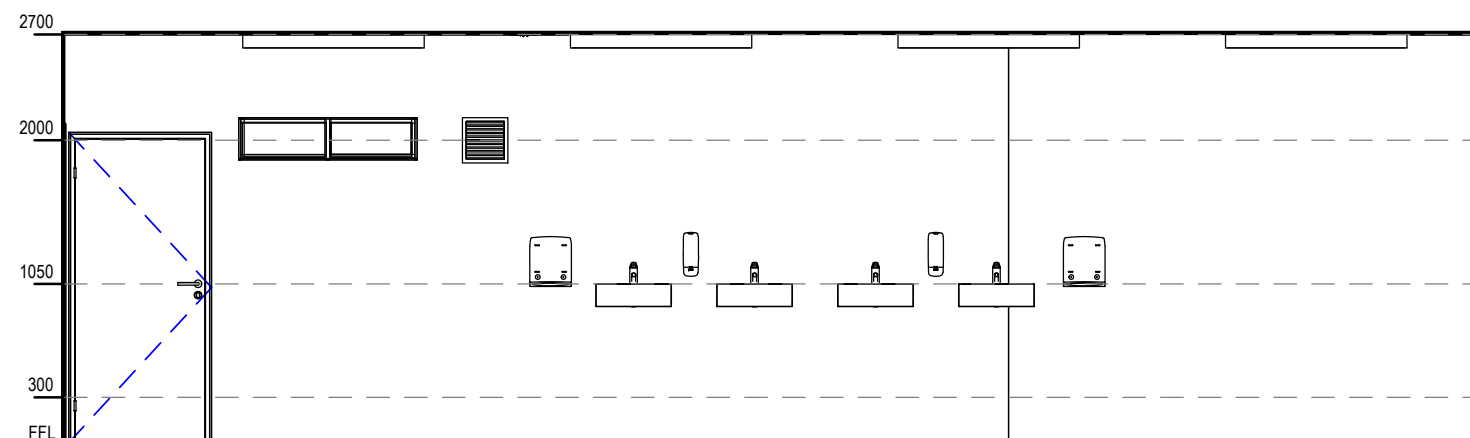

14 MALE STUDENT WC ELE 14
SCALE: 1 : 50

0 0.5 1 2 4m 1:50