


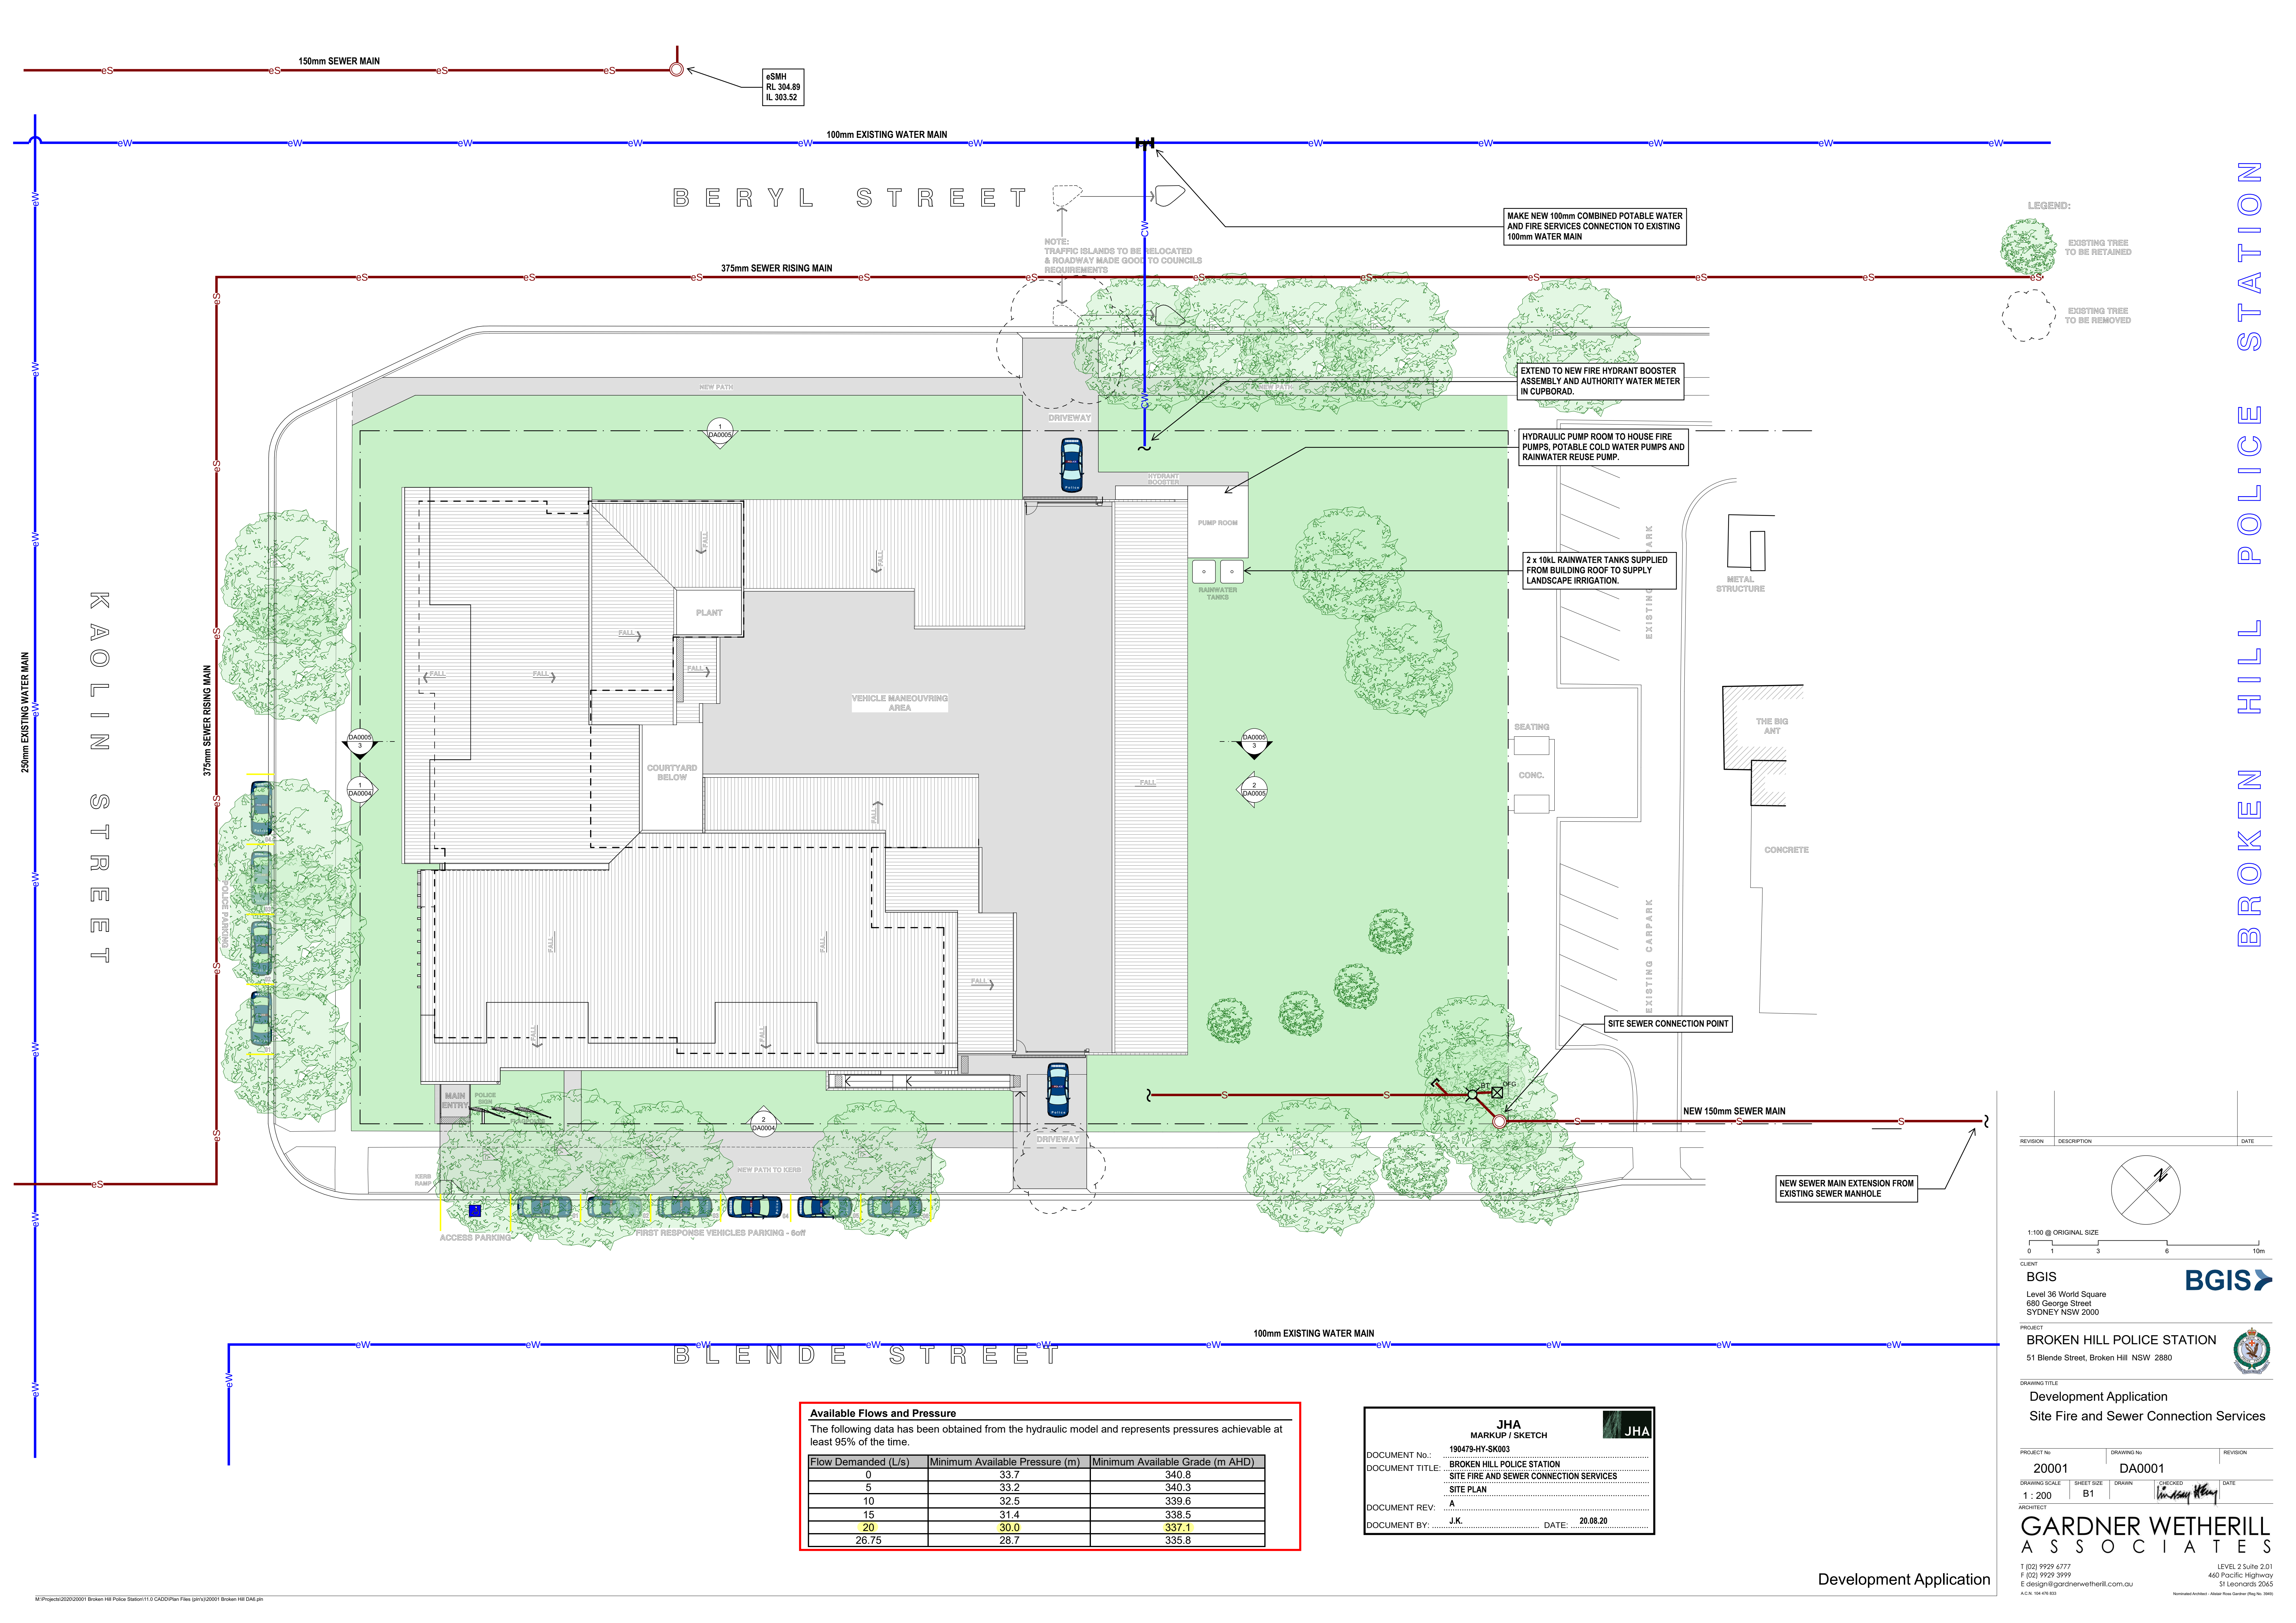

Available Flows and Pressure		
The following data has been obtained from the hydraulic model and represents pressures achievable at least 95% of the time.		
Flow Demanded (L/s)	Minimum Available Pressure (m)	Minimum Available Grade (m AHD)
0	33.7	340.8
5	33.2	340.3
10	32.5	339.6
15	31.4	338.5
20	30.0	337.1
26.75	28.7	335.8

JHA
MARKUP / SKETCH

JHA

DOCUMENT NO.: 190473-HY-SK003

DOCUMENT TITLE: BROKEN HILL POLICE STATION
SITE FIRE AND SEWER CONNECTION SERVICES
SITE PLAN

DOCUMENT REV: A

DOCUMENT BY: J.K. DATE: 20.08.20

REVISION	DESCRIPTION	DATE

1:100 @ ORIGINAL SIZE
0 1 3 6 10m

CLIENT
BGIS
Level 36 World Square
680 George Street
SYDNEY NSW 2000

PROJECT
BROKEN HILL POLICE STATION
51 Blende Street, Broken Hill NSW 2880

DRAWING TITLE
Development Application
Site Fire and Sewer Connection Services

PROJECT NO. 20001	DRAWING NO. DA0001	REVISION
----------------------	-----------------------	----------

DRAWING SCALE 1 : 200	SHEET SIZE B1	DRAWN 	CHECKED 	DATE
--------------------------	------------------	-----------	-------------	------

ARCHITECT
GARDNER WETHERILL
ASSOCIATES
T (02) 9929 6777
F (02) 9929 9999
E design@gardnerwetherill.com.au
A.C.N. 104 478 833

LEVEL 2 Suite 2.01
460 Pacific Highway
St Leonards 2065
Normalised Architect - Allstar Rise Garden (Reg No. 3946)

I:\Projects\2020\20001 Broken Hill Police Station\110 CAD\Plan Files\g419\20001 Broken Hill DA6.dwg